

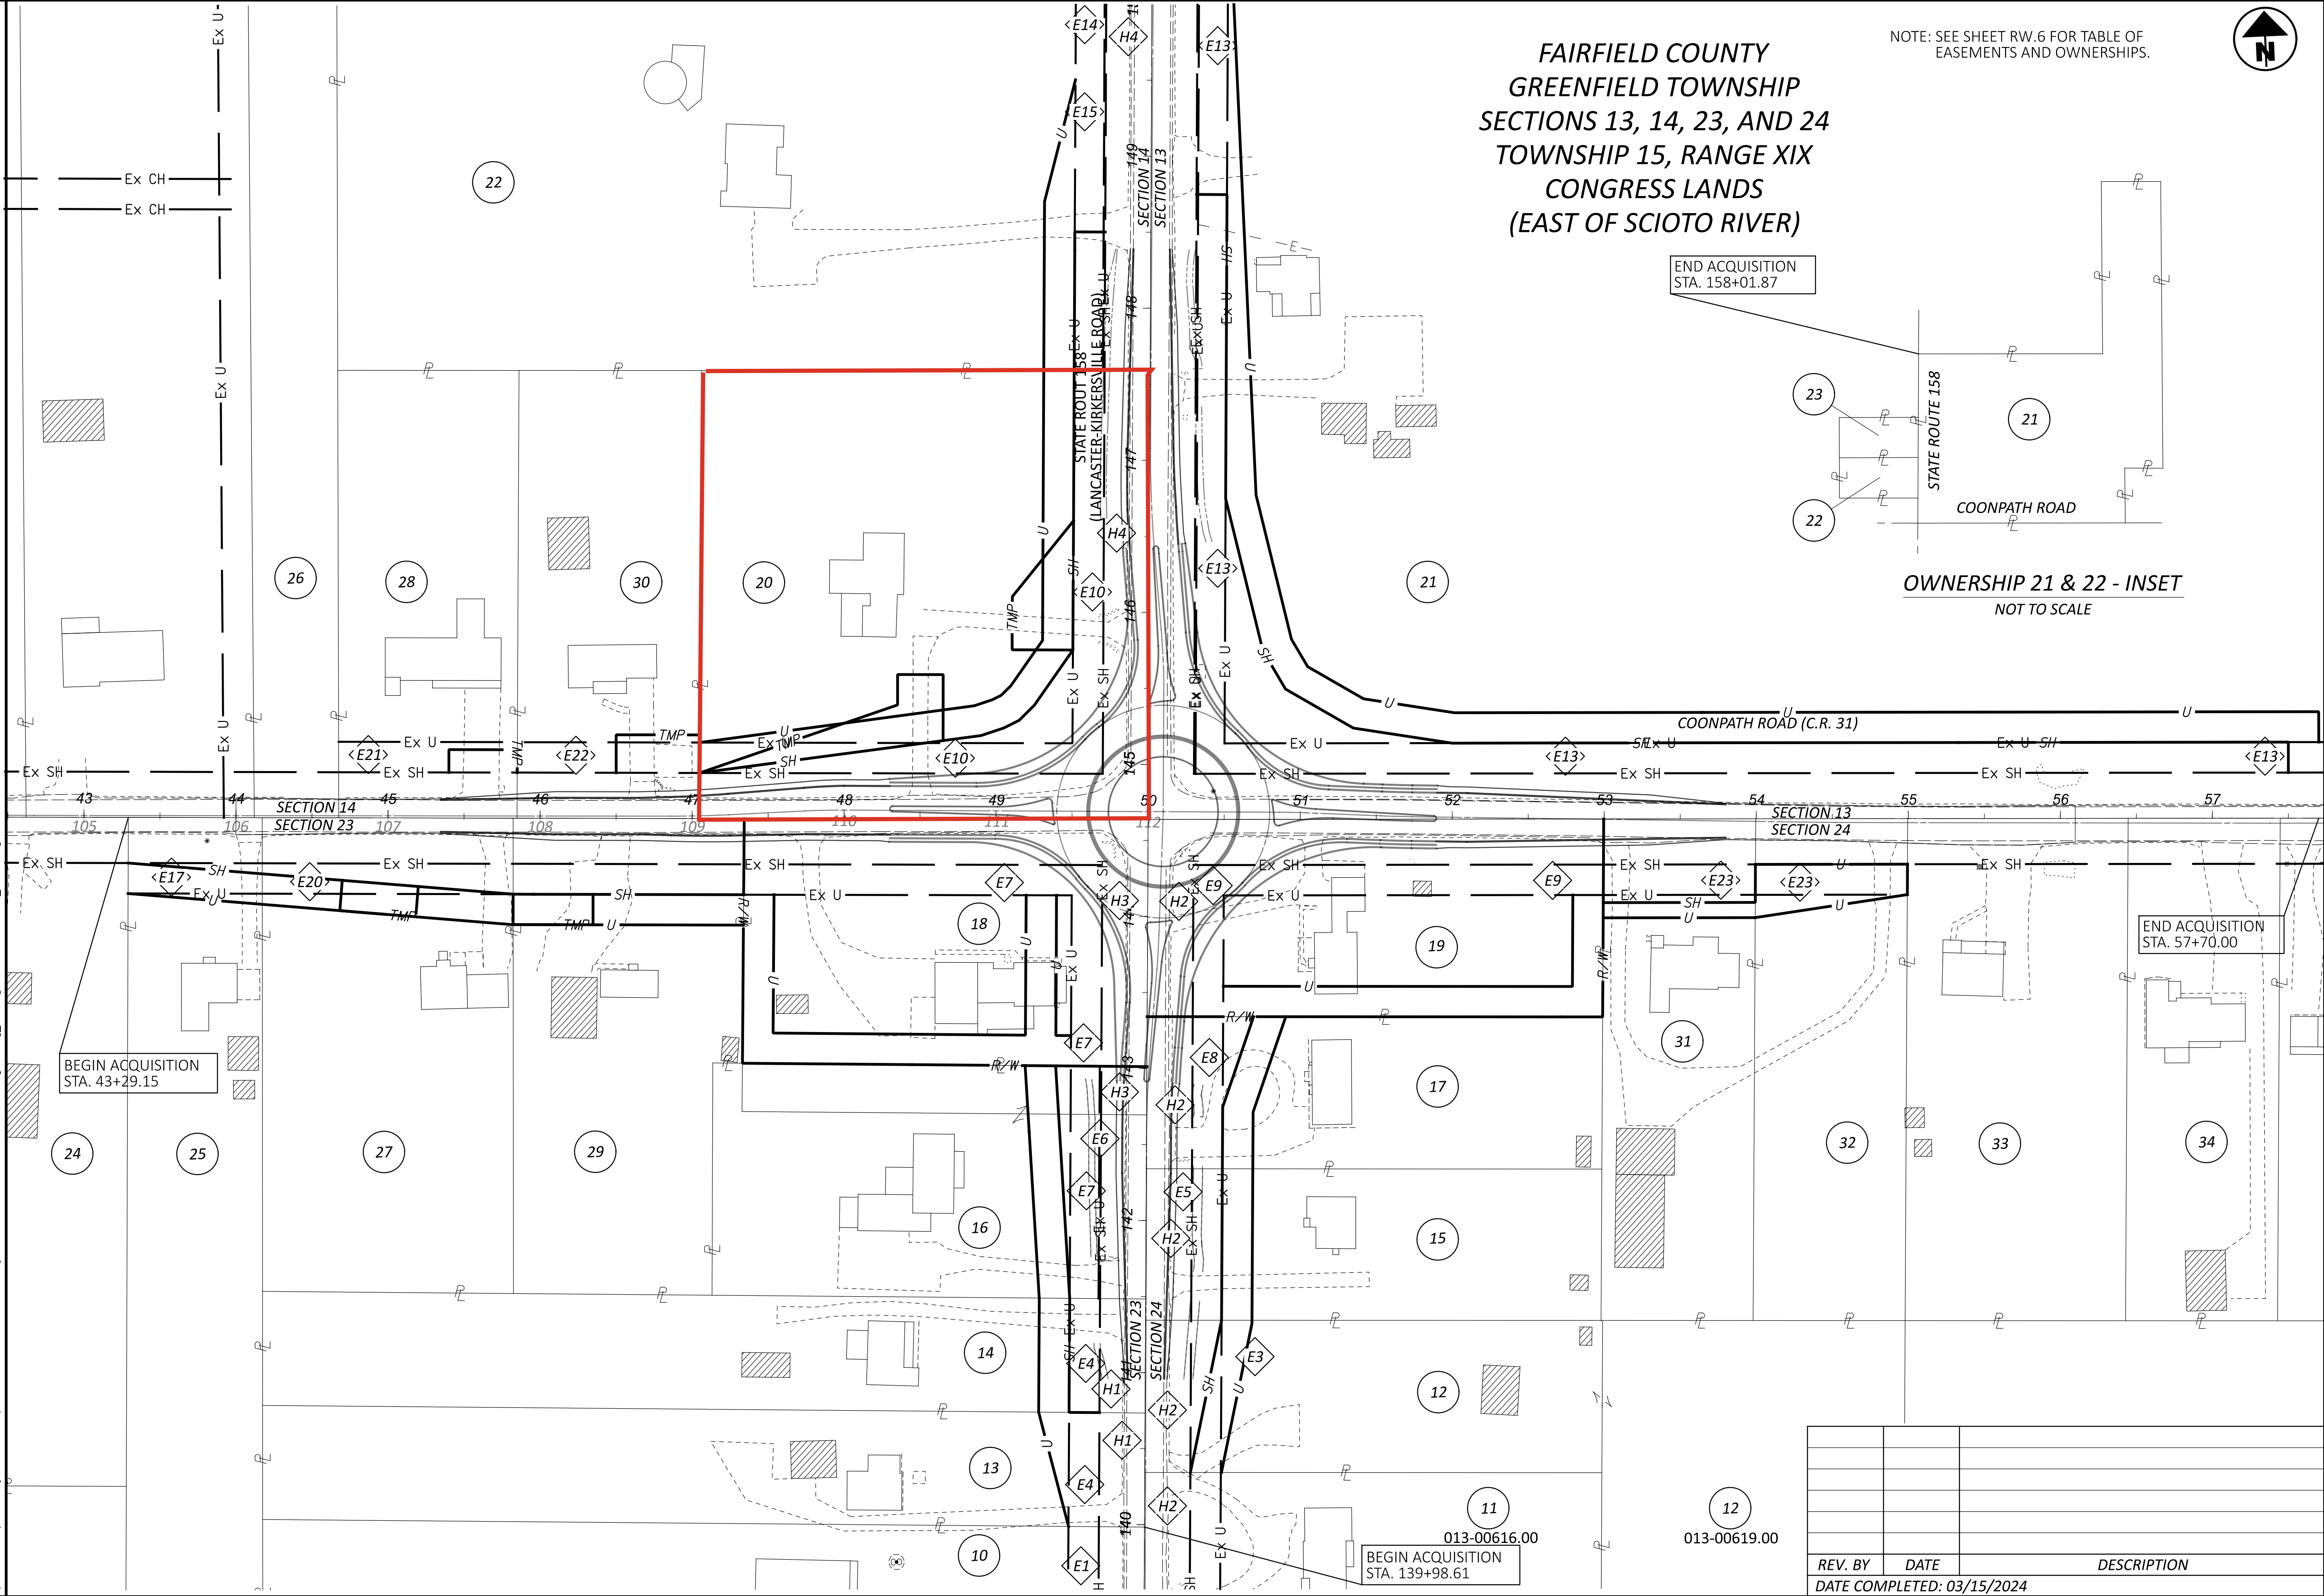


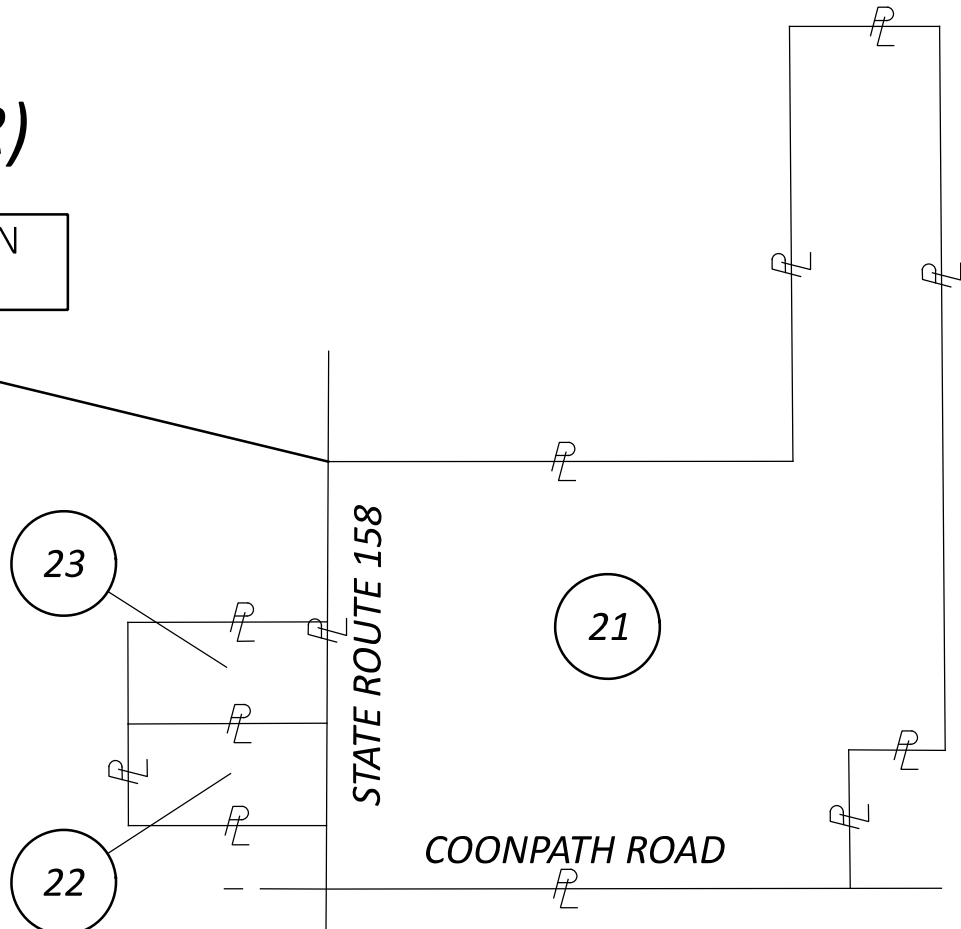

FAIRFIELD COUNTY
GREENFIELD TOWNSHIP
SECTIONS 13, 14, 23, AND 24
TOWNSHIP 15, RANGE XIX
CONGRESS LANDS
(EAST OF SCIOTO RIVER)

NOTE: SEE SHEET RW.6 FOR TABLE OF
EASEMENTS AND OWNERSHIPS.

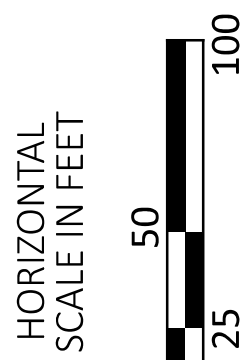

PROPERTY MAP

REV. BY	DATE	DESCRIPTION
DATE COMPLETED: 03/15/2024		

DESIGN AGENCY



DESIGNER

JPS

REVIEWER

FDS 03/15/24

PROJECT ID

111621

SUBSET TOTAL

RW.5 18

MODEL: Sheet PAPER: 34x22 (in.) DATE: 4/4/2024 TIME: 9:21:08 AM USER: jslfka
pw:\ohiodot-pw.bentley.com\ohiodot-pw-02\Documents\01 Active Projects\District 05\Fairfield\111621\401-Engineering_FokEng\RW\Sheets\111621_RS001.dgn

TOTAL NUMBER OF : 18 OWNERSHIPS 2 TOTAL TAKES 36 PARCELS 2 OWNERSHIPS W/ STRUCTURES INVOLVED NET TAKE = GROSS TAKE - PRO IN TAKE NET RESIDUE = RECORD AREA - TOTAL PRO - NET TAKE ALL AREAS IN ACRES GRANTEE: ALL RIGHT OF WAY ACQUIRED IN THE NAME OF THE STATE OF OHIO DEPARTMENT OF TRANSPORTATION. ANY RIGHT OF WAY ACQUIRED IN THE NAME OF ANOTHER AGENCY WILL CONTAIN THE "V" PARCEL IDENTIFIER AND THE NAME OF THAT AGENCY IS SHOWN IN THE REMARKS COLUMN.																	
PARCEL NO.	OWNER	SHEET NO.	OWNERS RECORD		AUDITOR'S PARCEL	RECORD AREA	TOTAL P.R.O.	GROSS TAKE	P.R.O. IN TAKE	NET TAKE	STRUC-TURE	NET RESIDUE		TYPE FUND	REMARKS	AS ACQUIRED	
			BOOK	PAGE								LEFT	RIGHT			BOOK	PAGE
1-9	NOT USED																
10	JENNIFER BROWNING	9-10	OR 1825	1233	013-00593.00	1.000	0.520								NO ADDITIONAL RIGHT OF WAY REQUIRED		
11	SOLUTIONS ONE PROFESSIONAL SERVICES, LLC, AN OHIO LIMITED LIABILITY COMPANY	9-10	202400001565		013-00616.00	0.690	0.069								NO ADDITIONAL RIGHT OF WAY REQUIRED		
12-SH	JORDAN REMODELING LLC, AN OHIO LIMITED LIABILITY COMPANY	9-10	202400001580		013-00615.00 013-00619.00	0.690 1.380	0.069 -	0.092 0.047	0.069 0.000	0.023 0.047			0.598		PARCEL ONE PARCEL TWO P.R.O. EASEMENT TO STATE OF OHIO IN BOOK HE-1, PAGE 157; N.E.O.		
12-UV																	
13-UV	JARROD T. DODDS	9-10	202100008243		013-00594.00	1.000	0.052	0.017	0.000	0.017					N.E.O.		
14-SH	JOSHUA E. ECK AND JENNIFER N. ECK	9-10	OR 1400	3046	013-00595.00	1.000	0.052	0.086	0.052	0.034		0.914			P.R.O. EASEMENT TO STATE OF OHIO IN BOOK HE-1, PAGE 163		
14-UV								0.034	0.000	0.034					N.E.O.		
15-SH	CHAD GUISINGER AND STACEY GUISINGER	9-12	202200001545		013-00617.00	0.690	0.069	0.114	0.069	0.045			0.576		TAKE (1) SHRUB P.R.O. EASEMENT TO STATE OF OHIO IN BOOK HE-1, PAGE 157		
15-UV								0.046	0.000	0.046					N.E.O.		
16-SH	ROBERT E. LAESSLE AND LORETTA K. LAESSLE	9-12	OR 1382	140	013-00590.00	1.000	0.105	0.193	0.105	0.088		0.807			TRACT ONE AND TRACT TWO, TAKE (4) SHRUBS, (1) TREE, (1) EVERGREEN, PLOW, 21.5 LIN. FT. OF 3 FT SPLIT RAIL FENCE, *(6) ROCKS, P.R.O. EASEMENT TO STATE OF OHIO IN BOOK HE-1, PAGE 163 & PAGE 167		
16-UV								0.070	0.000	0.070					N.E.O.		
17-SH	ROBERT H. KEMMERER AND JANIS A. KEMMERER	11-12, 17-18	DV 561	698	013-00631.00	0.690	0.069	0.128	0.069	0.059			0.562		TAKE (1) TREE, WAGON & STEEL WHEEL, *FLOWER BED P.R.O. EASEMENT TO STATE OF OHIO IN BOOK HE-1, PAGE 157		
17-UV								0.048	0.000	0.048					N.E.O.		
18-WD	ZACHARY J. YOUNG AND ANDREA M. FRY	11-12, 15-16	OR 1705	4441	013-00590.10	1.000	0.274	0.987	0.274	0.713	Y				TOTAL TAKE		
18-UV								0.183	0.000	0.183					P.R.O. EASEMENT TO STATE OF OHIO IN BOOK HE-1, PAGE 167		
19-WD	RODNEY C. HORN	11-12, 17-18	202100020940 OR 1818	4522	013-00632.00	0.860	0.275	0.894	0.275	0.619	Y				½ INTEREST; TOTAL TAKE ½ INTEREST P.R.O. EASEMENT TO STATE OF OHIO IN BOOK HE-1, PAGE 157		
19-UV								0.142	0.000	0.142							
20-SH	JEFFREY J. GRESSICK AND DENISE M. GRESSICK	11-16	OR 654	128	013-00376.00	2.000	0.386	0.623	0.386	0.237		1.377			TAKE (4) TREES, (8) EVERGREENS, *(3) TREES, *(4) EVERGREENS, *SHRUB/MAILBOX/PAPERBOX		
20-T-1								0.055	0.000	0.055					TO CONSTRUCT DRIVEWAY		
20-T-2								0.072	0.000	0.072					TO CONSTRUCT DRIVEWAY		
20-UV								0.202	0.000	0.202					N.E.O. & S.C.P. P.R.O. EASEMENT TO STATE OF OHIO IN BOOK HE-1, PAGE 171		
21-SH	MAJORS FARMS, LLC	11-14, 17-18	OR 1655	1399	013-00344.00	71.480	2.031	2.638	2.031	0.607			68.842		P.R.O. EASEMENT TO STATE OF OHIO IN BOOK HE-1, PAGE 169 WARRANTY DEED OR 1655, PG 1396		
21-UV								0.462	0.000	0.462					N.E.O. & S.C.P.		

TYPES OF TITLE LEGEND:
WD = WARRANTY DEED
SH = STANDARD HIGHWAY EASEMENT
T = TEMPORARY EASEMENT
U= UTILITY EASEMENT

NOTE: ALL TEMPORARY PARCELS TO
BE OF 24 MONTH DURATION.

NOTE: UNDER NO CIRCUMSTANCES ARE TEMPORARY
EASEMENTS TO BE USED FOR STORAGE OF
MATERIAL OR EQUIPMENT BY THE CONTRACTOR
UNLESS NOTED OTHERWISE.


NOTE: NAME OF AGENCY THAT -UV EASEMENTS ARE
TO BE ACQUIRED IN THE NAME OF:
N.E.O. = NORTHEAST OHIO NATURAL GAS CORP.
S.C.P. = SOUTH CENTRAL POWER COMPANY,
AN OHIO CORPORATION.
FOR RELOCATION OF UTILITIES.

* DENOTES RIGHT OF WAY ENCROACHMENT

			DESIGN AGENCY
			TF ASSOCIATES
			DESIGNER
			JPS
			REVIEWER
			FDS 03/15/24
			PROJECT ID
			111621
REV. BY	DATE	DESCRIPTION	SUBSET TOTAL
FIELD REVIEW BY: FDS	DATE: 03/13/2024	OWNERSHIP VERIFIED BY: FDS	RW.7 18
DATE COMPLETED: 03/15/2024			

SUMMARY OF ADDITIONAL RIGHT OF WAY
(PARCEL 1 - 21)

RESIDENTIAL
18
ZACHARY J. YOUNG AND
ANDREA M. FRY
013-00590.10
OR 1705, PG.4441

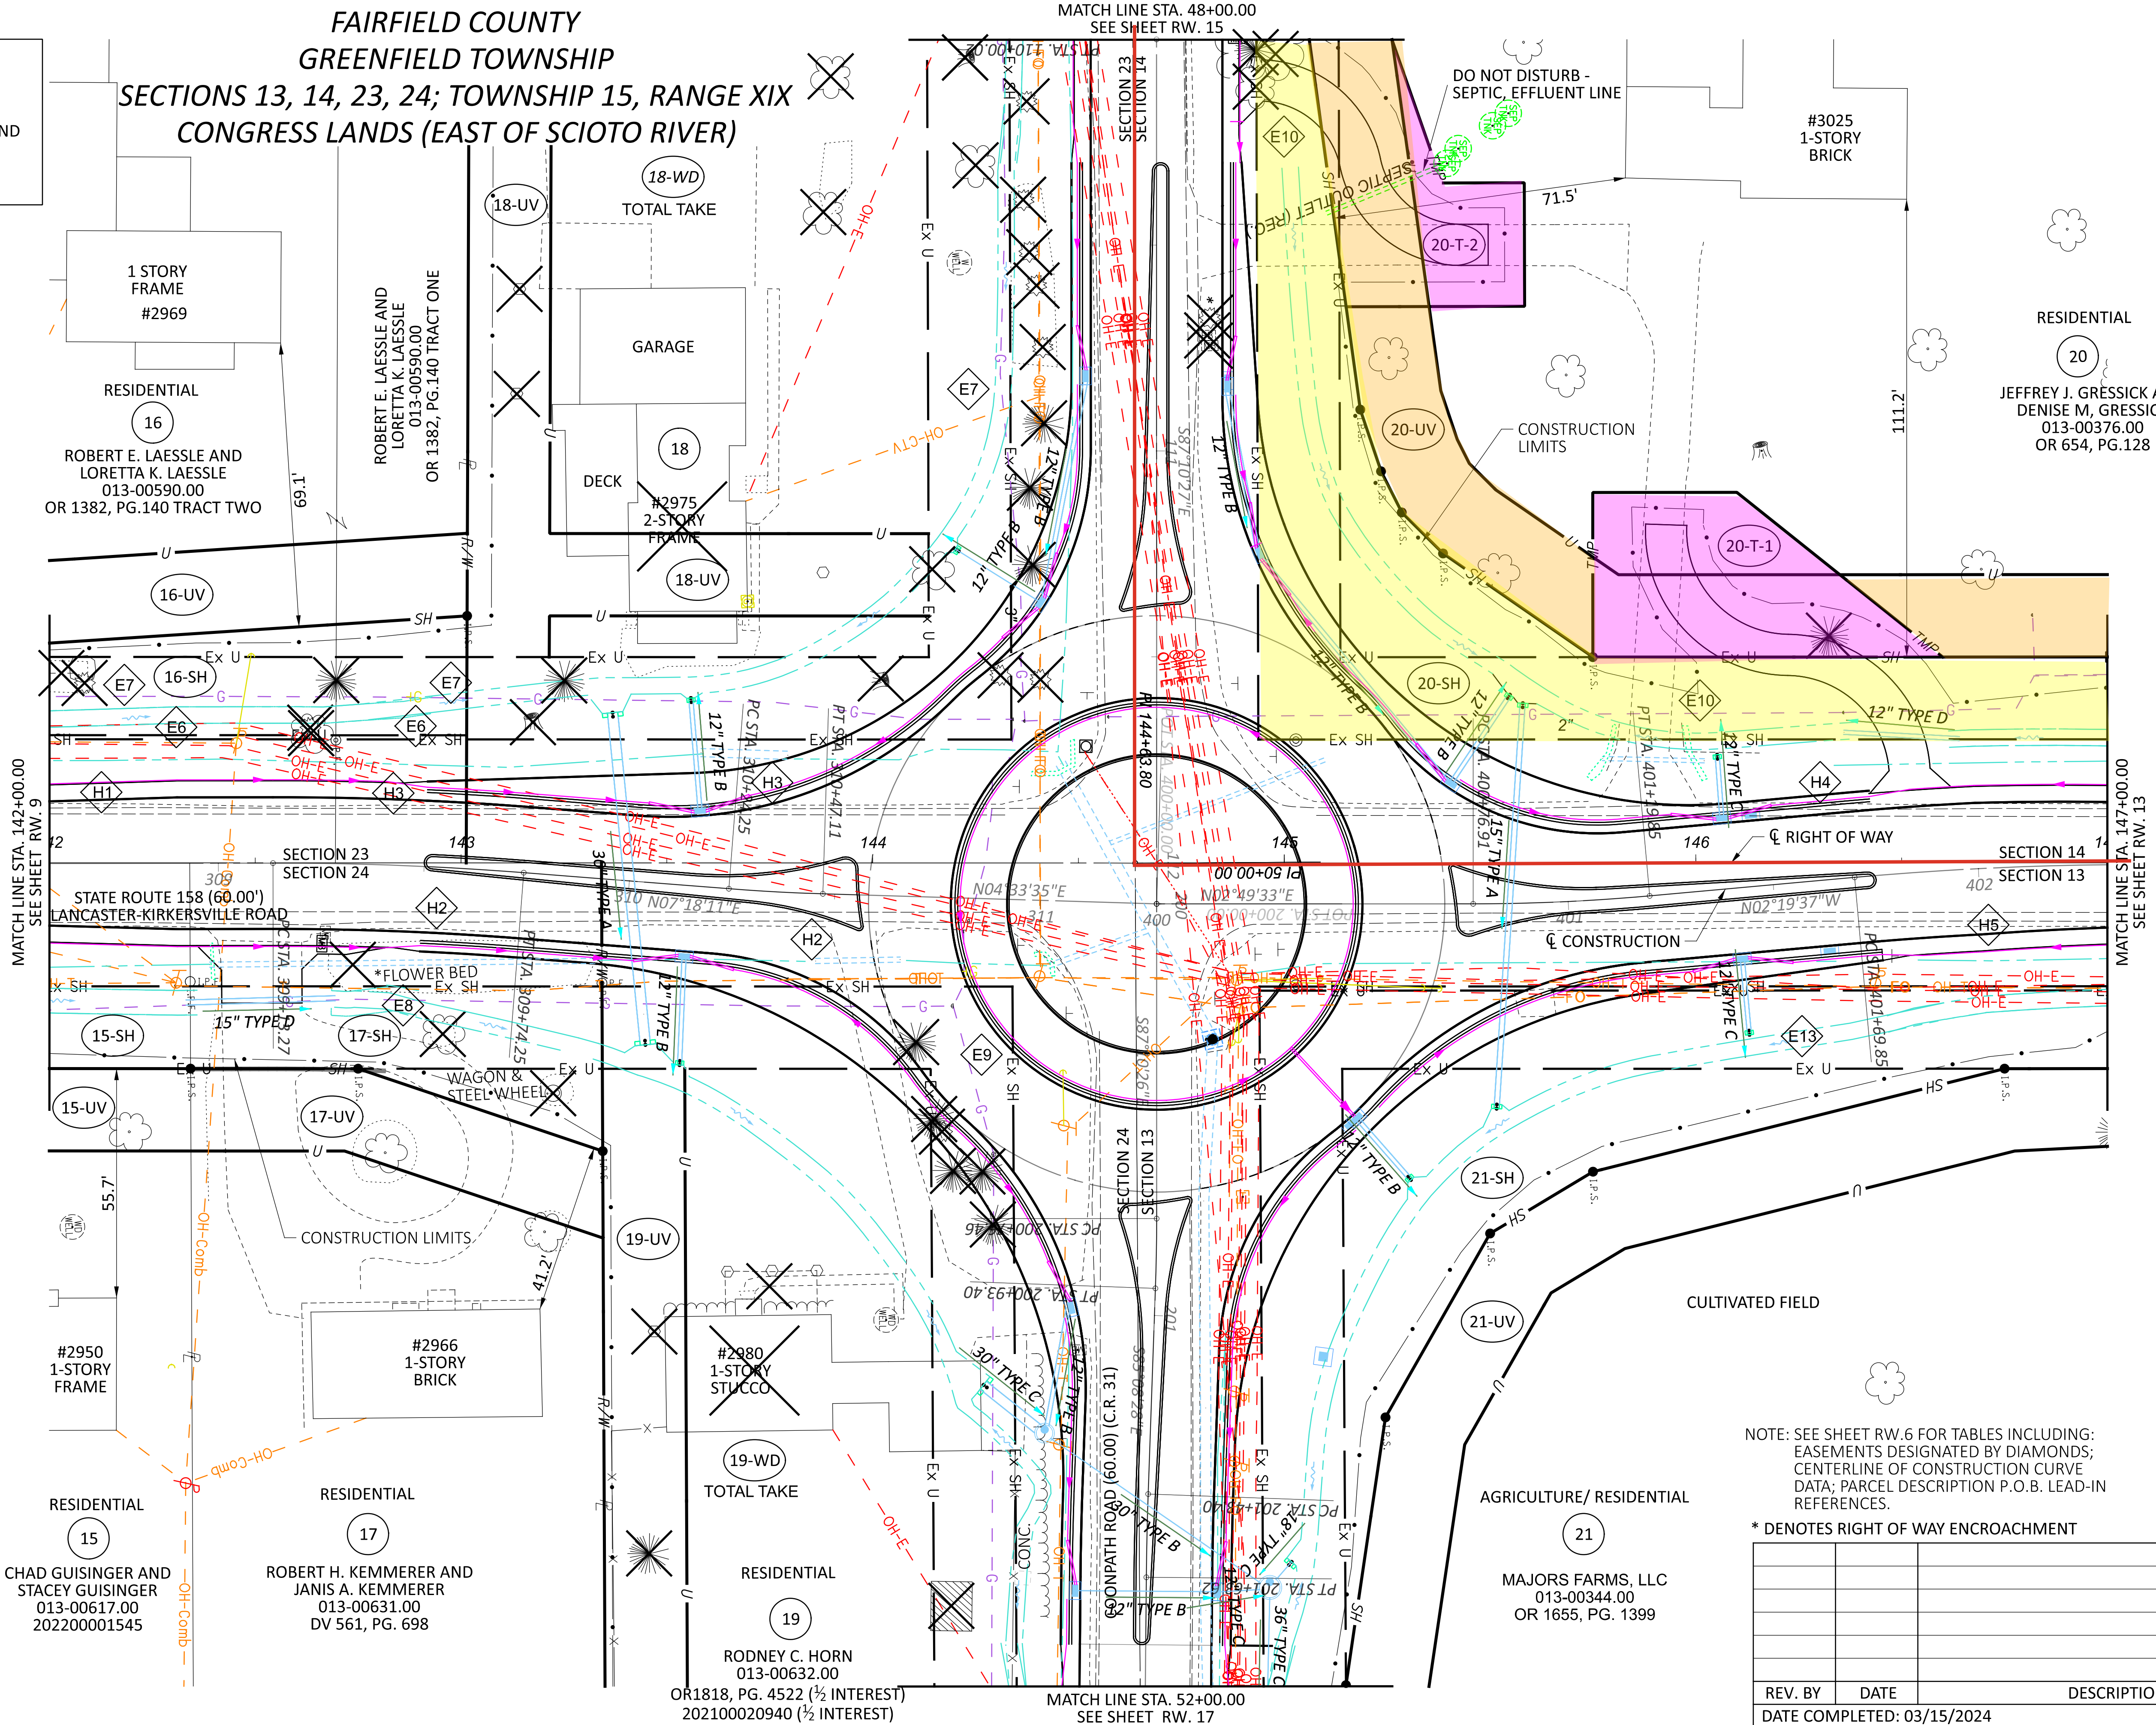

DESIGN AGENCY	
TF ASSOCIATES	
DESIGNER	
JPS	
REVIEWER	
FDS 03/15/24	
PROJECT ID	
111621	
SUBSET	
RW.11	
TOTAL	
18	

NOTE: SEE SHEET RW.6 FOR TABLES INCLUDING:
EASEMENTS DESIGNATED BY DIAMONDS;
CENTERLINE OF CONSTRUCTION CURVE
DATA; PARCEL DESCRIPTION P.O.B. LEAD-IN
REFERENCES.

* DENOTES RIGHT OF WAY ENCROACHMENT


REV. BY	DATE	DESCRIPTION
DATE COMPLETED: 03/15/2024		

RIGHT OF WAY TOPO SHEET
STA. 142+00.00 TO STA. 147+00.00

HORIZONTAL
SCALE IN FEET
0 20 40

FAI-158-4.20

MODEL: 111621_RB002 PAPERSIZE: 34x22 (in.) DATE: 4/4/2024 TIME: 9:22:06 AM USER: jslifka
pw: \\ohiodot-pw.bentley.com:ohiodot-pw-02\Documents\01 Active Projects\District 05\Fairfield\

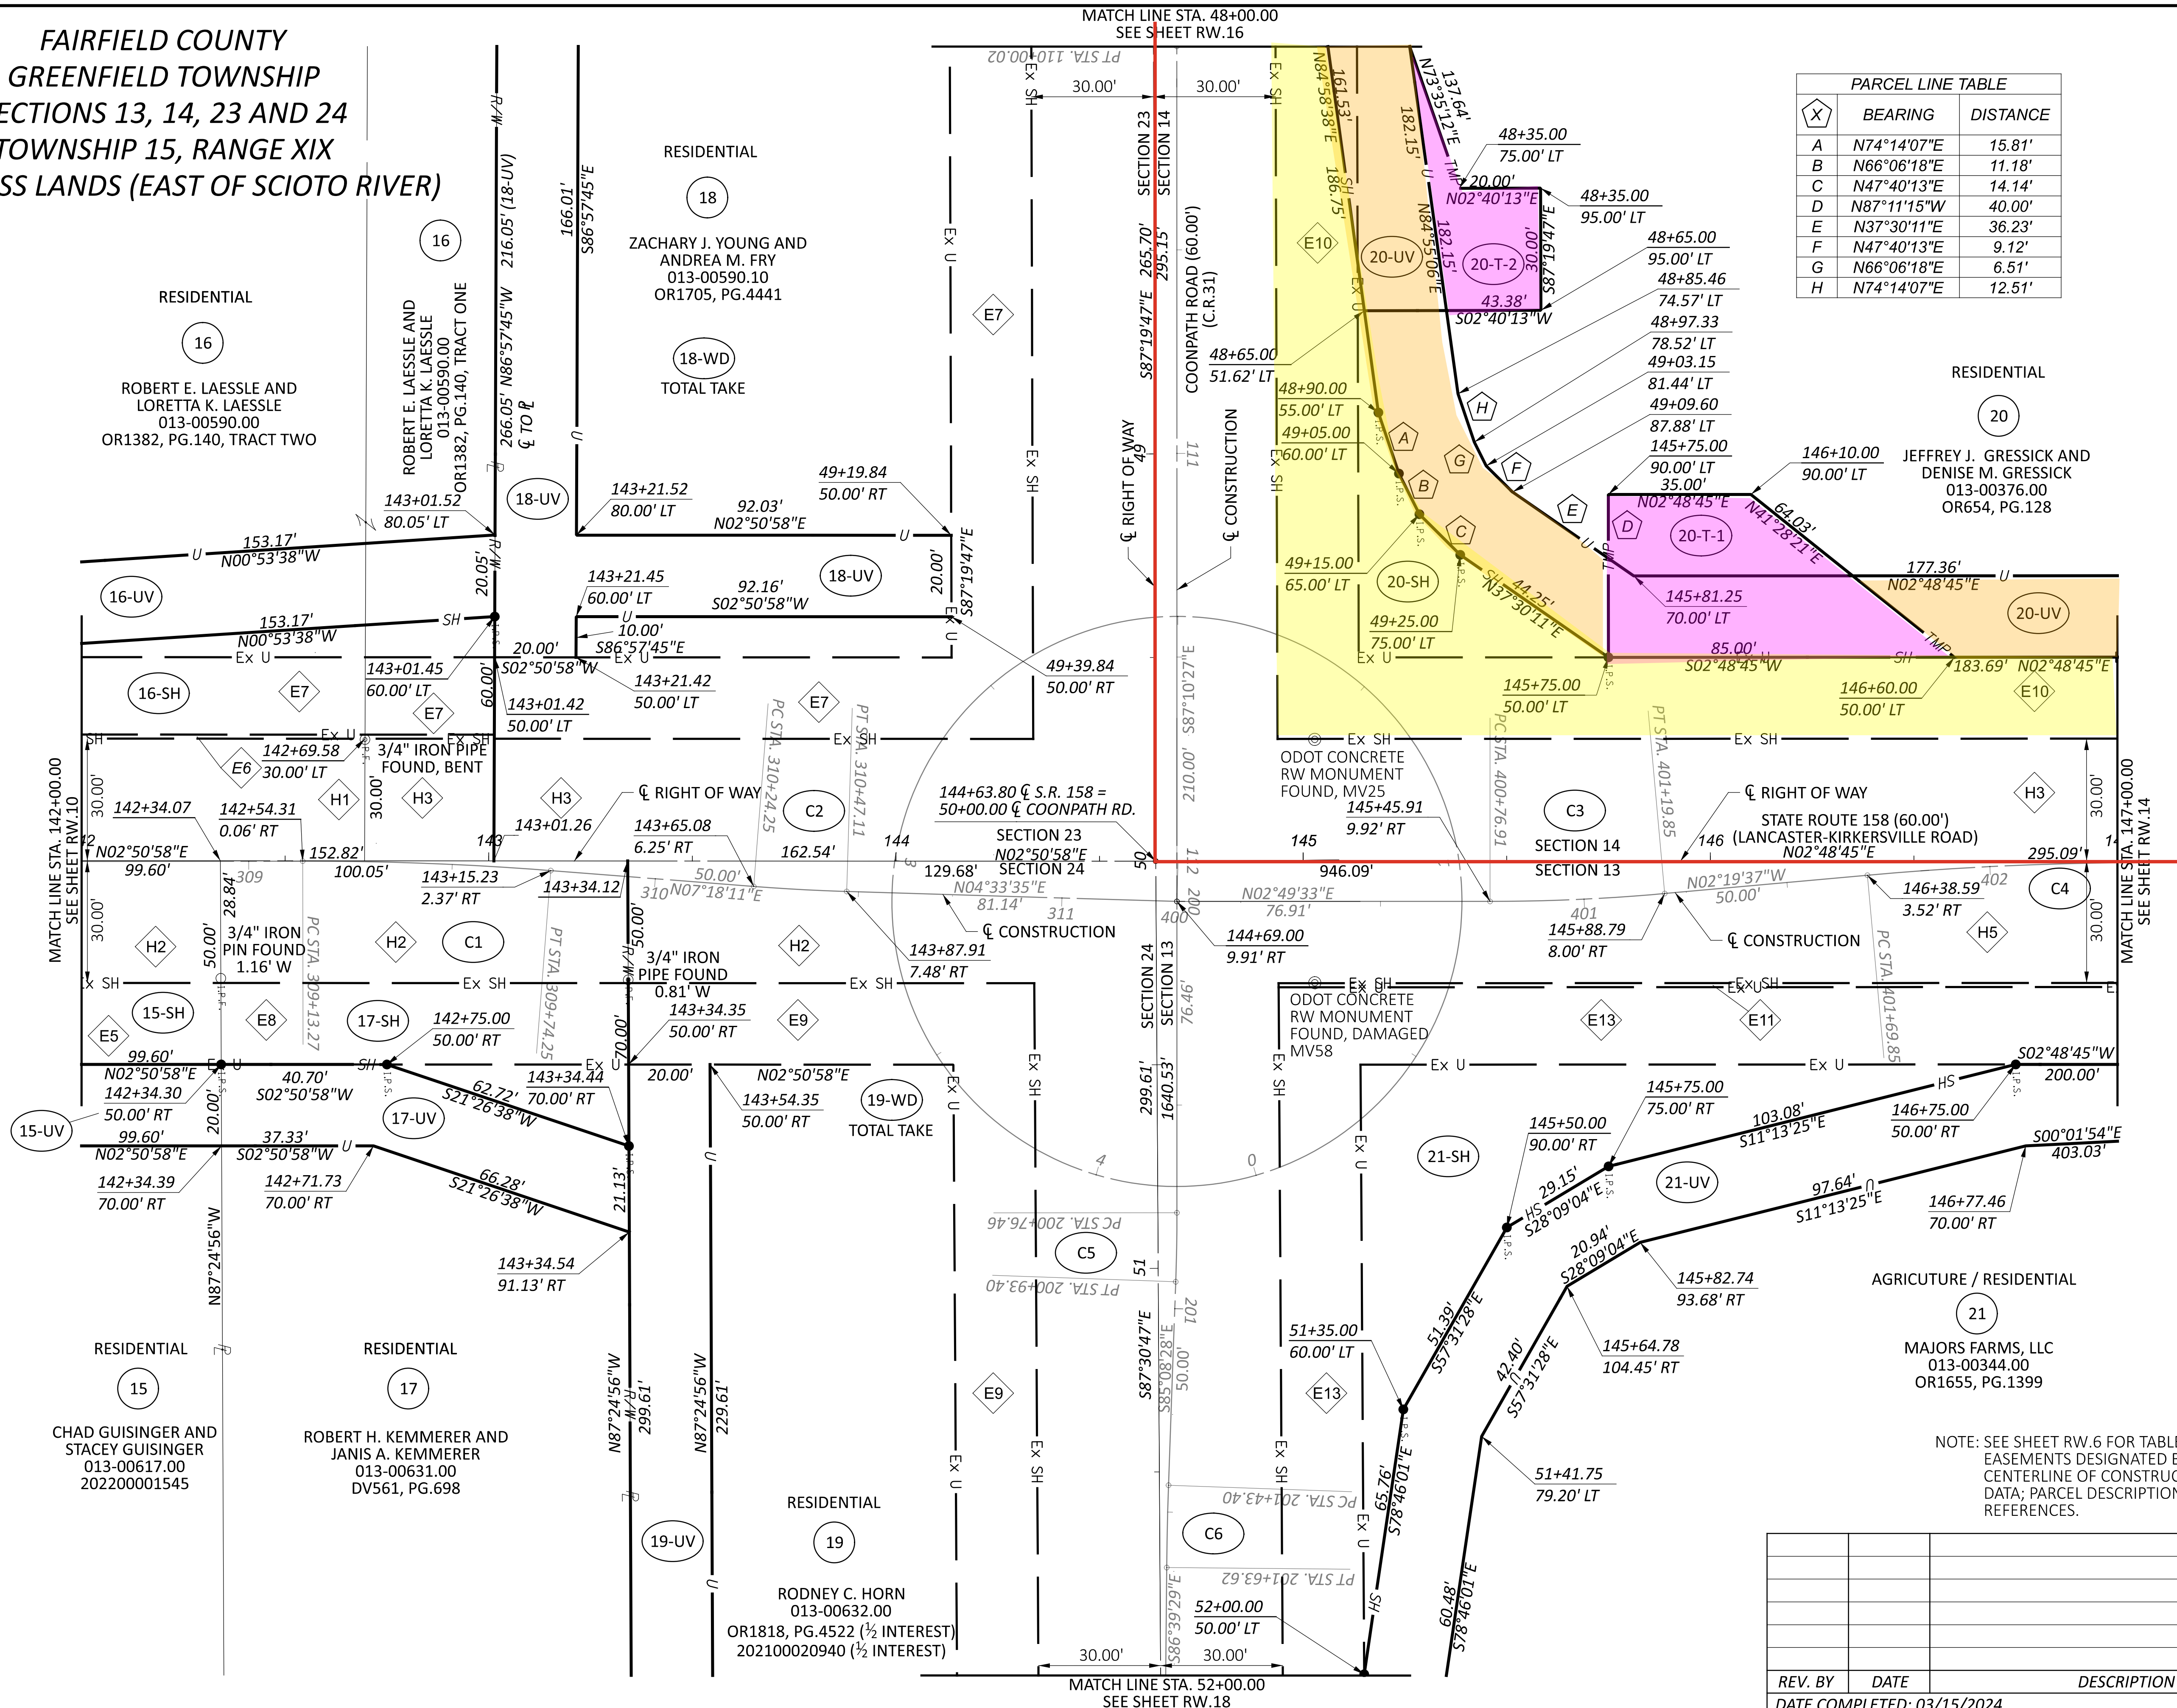

PARCEL LINE TABLE		
	BEARING	DISTANCE
A	N74°14'07"E	15.81'
B	N66°06'18"E	11.18'
C	N47°40'13"E	14.14'
D	N87°11'15"W	40.00'
E	N37°30'11"E	36.23'
F	N47°40'13"E	9.12'
G	N66°06'18"E	6.51'
H	N74°14'07"E	12.51'

NOTE: SEE SHEET RW.6 FOR TABLES INCLUDING:
EASEMENTS DESIGNATED BY DIAMONDS;
CENTERLINE OF CONSTRUCTION CURVE
DATA; PARCEL DESCRIPTION P.O.B. LEAD-IN
REFERENCES.

REV. BY	DATE	DESCRIPTION
DATE COMPLETED: 03/15/2024		

RIGHT OF WAY BOUNDARY SHEET
STA. 142+00.00 TO STA. 147+00.00



DESIGN AGENCY

TF
ASSOCIATES

DESIGNER




JPS

FDS 03/15/24

PROJECT ID

111621

SUBSET	TOTAL
RW.12	18

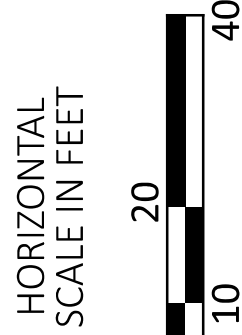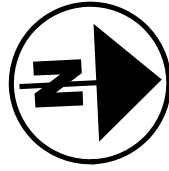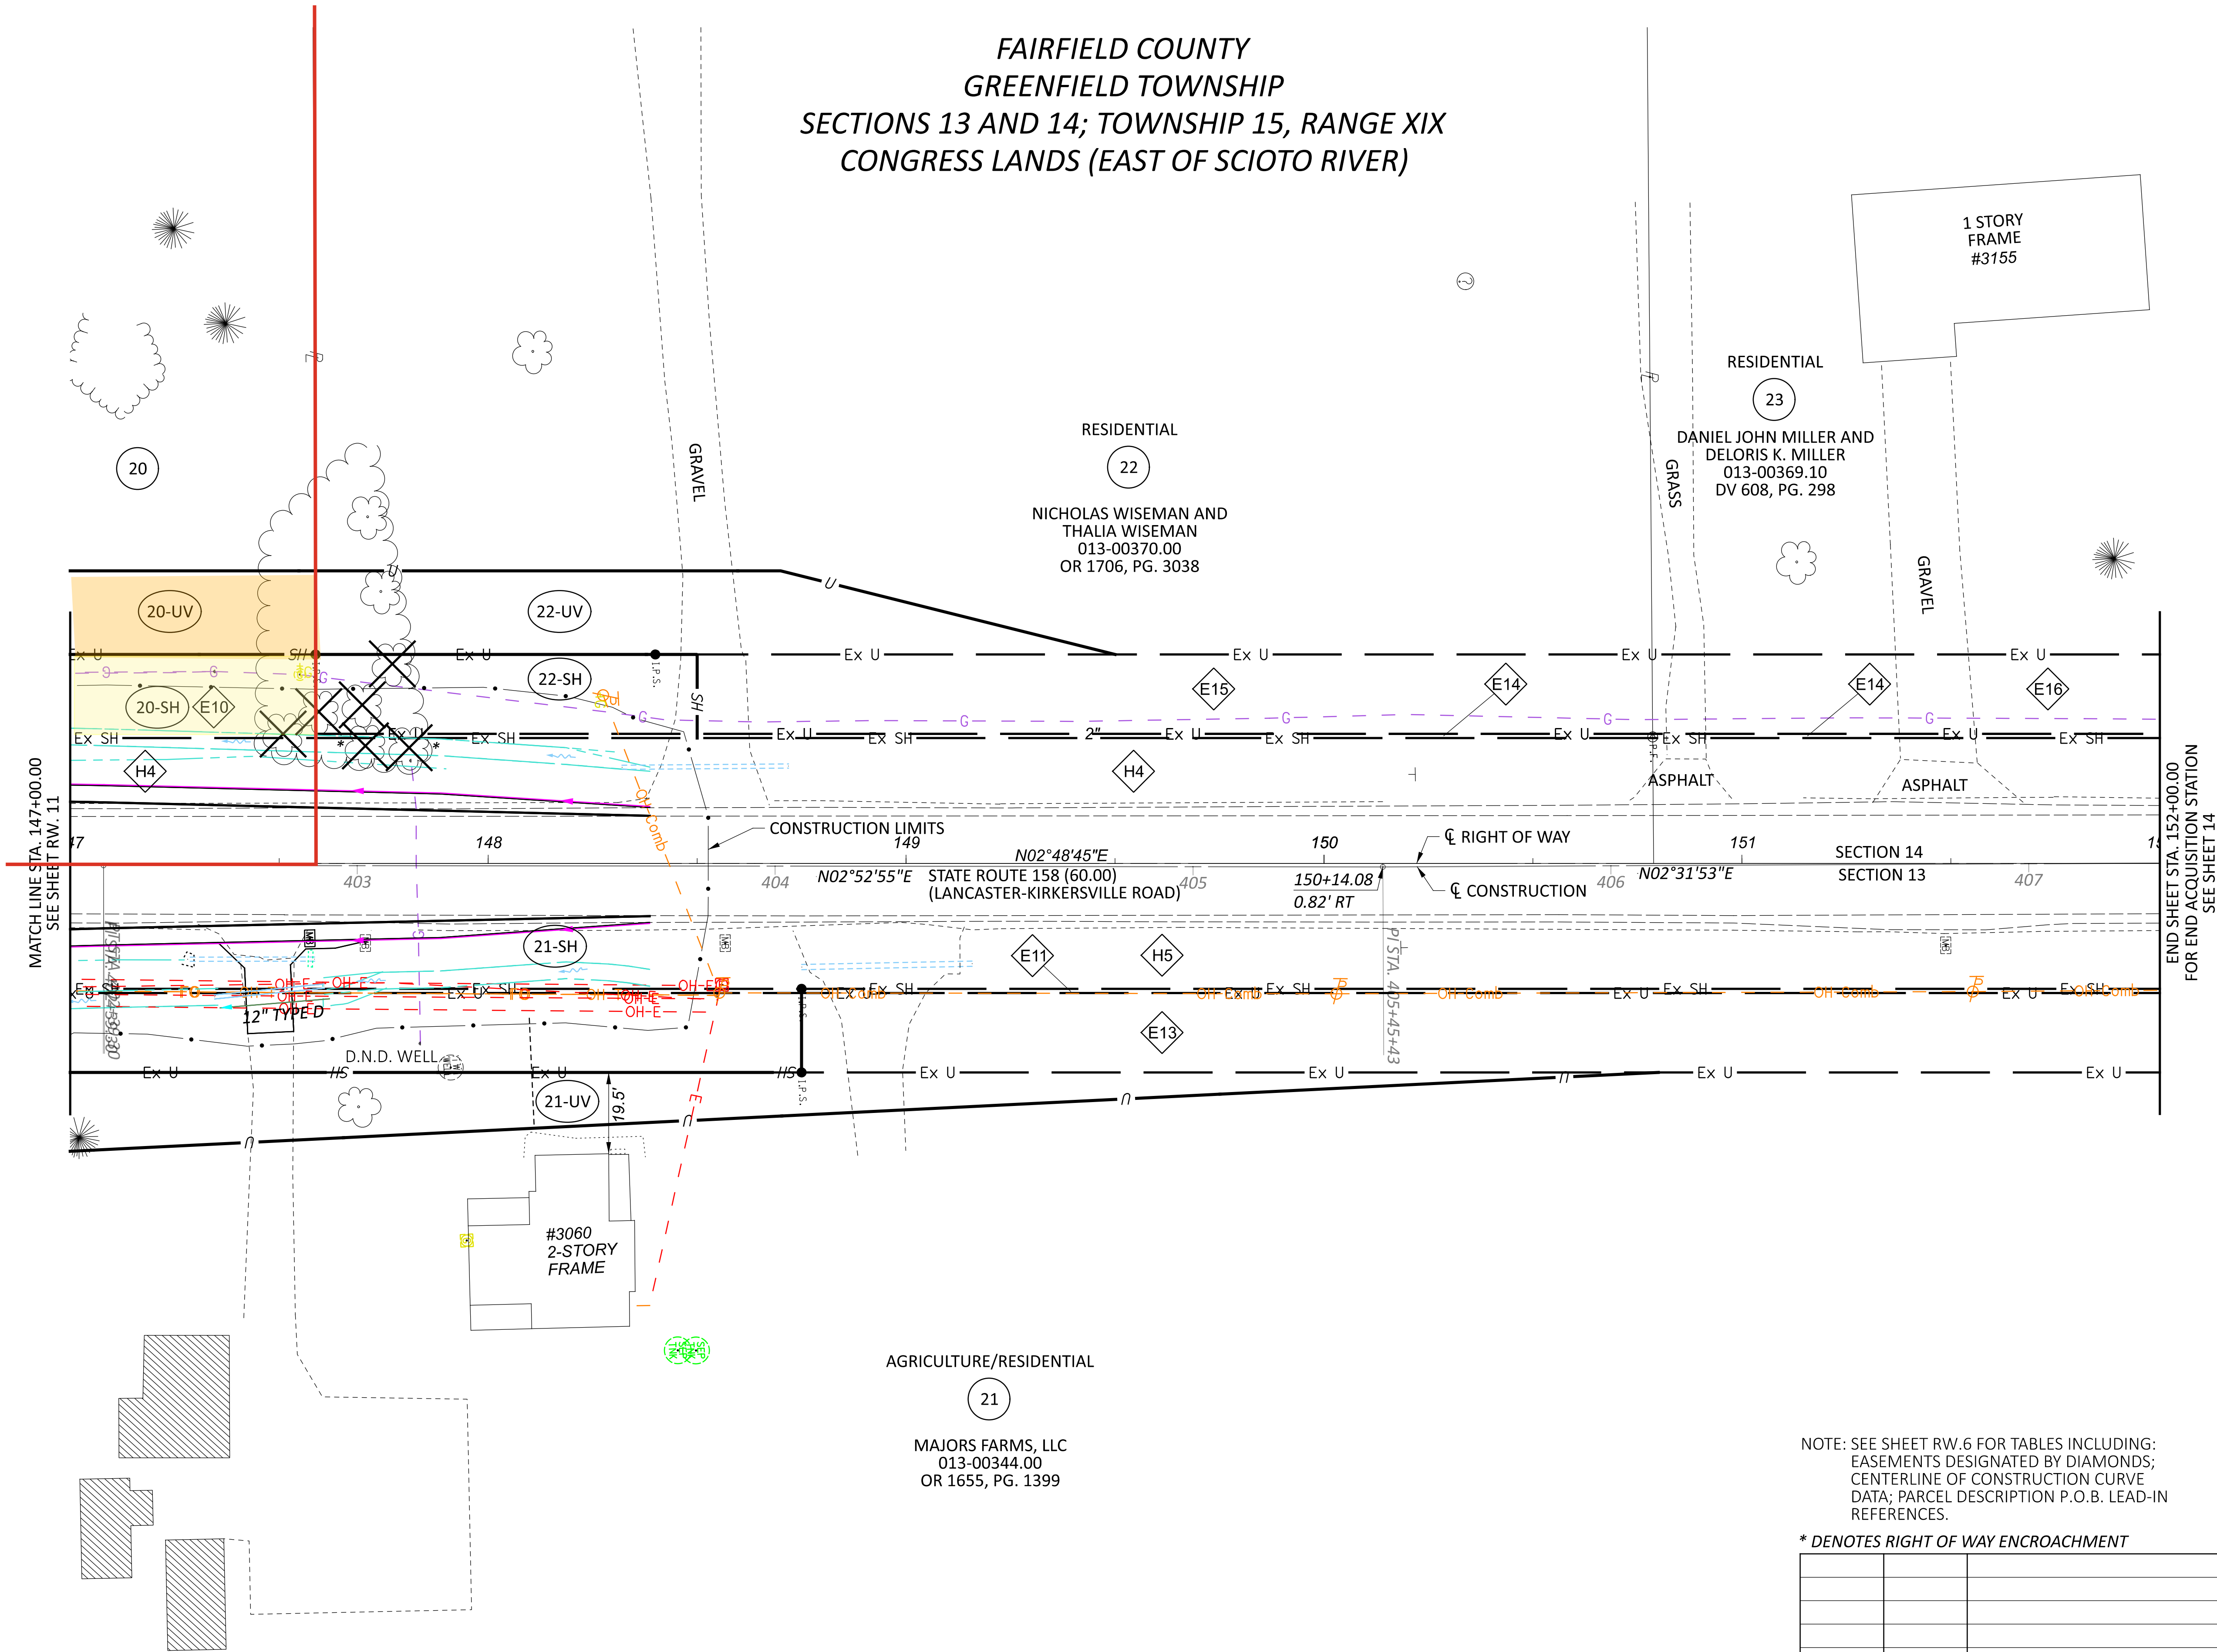

RIGHT OF WAY TOPO SHEET
STA. 147+00.00 TO STA. 152+00.00

NOTE: SEE SHEET RW.6 FOR TABLES INCLUDING:
EASEMENTS DESIGNATED BY DIAMONDS;
CENTERLINE OF CONSTRUCTION CURVE
DATA; PARCEL DESCRIPTION P.O.B. LEAD-IN
REFERENCES.

* DENOTES RIGHT OF WAY ENCROACHMENT

REV. BY	DATE	DESCRIPTION
DATE COMPLETED: 03/15/2024		

DESIGN AGENCY



DESIGNER

JPS

REVIEWER

FDS 03/15/24

PROJECT ID



111621

SUBSET

RW.13

TOTAL

18

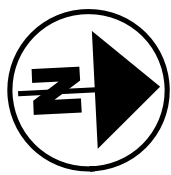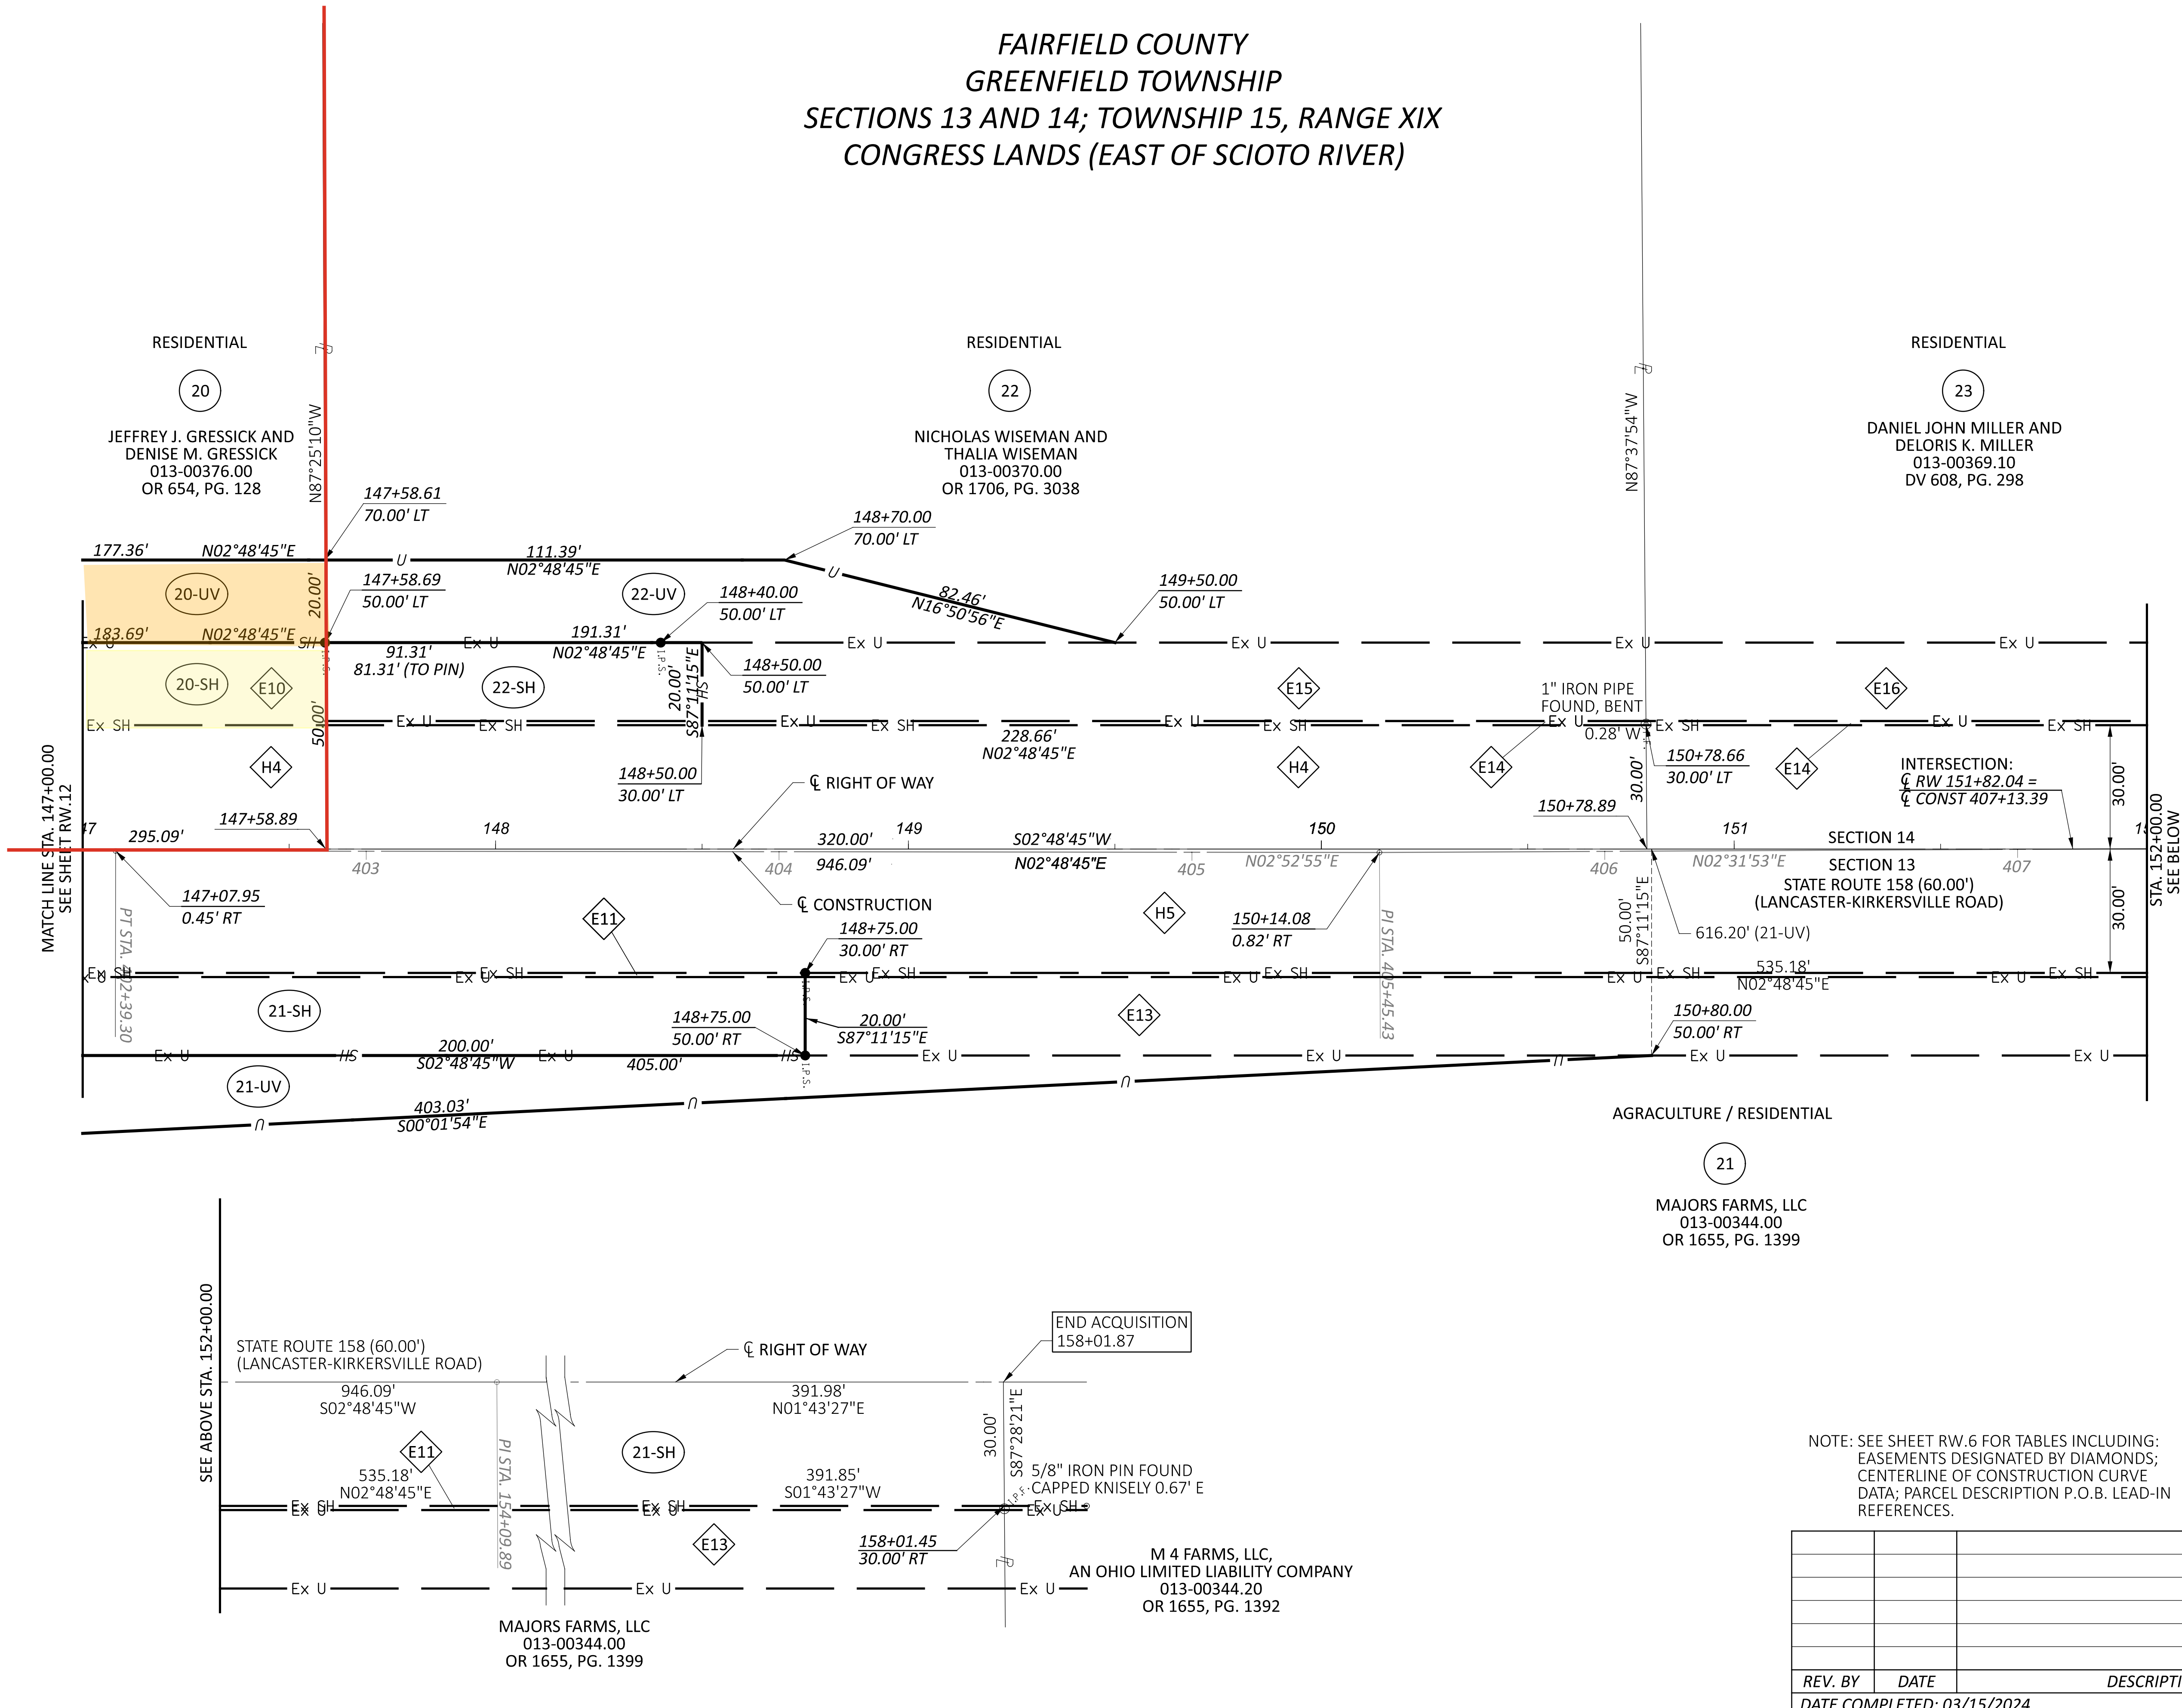

RIGHT OF WAY BOUNDARY SHEET
STA. 147+00.00 TO STA. 152+00.00

DESIGN AGENCY



DESIGNER

JPS

REVIEWER

FDS 03/15/24

PROJECT ID

111621

SUBSET

RW.14 TOTAL 18

JONATHAN G. MILLER
013-00364.40
OR 1239, PG.850 (1/2 INT)
OR 1826, PG.563 (1/2 INT)

1 STORY
FRAME
#1120

BEGIN ACQUISITION
STA. 43+29.15

BEGIN SHEET STA. 43+00.00

RESIDENTIAL
24

THOMAS M. ROCKHOLD AND
BRENDA F. ROCKHOLD
013-00603.10
DV 494, PG. 168

#1105
1 STORY
FRAME

RESIDENTIAL
25

738 NORTH BROAD STREET, LLC,
AN OHIO LIMITED LIABILITY COMPANY
013-00601.00
OR1630, PG. 1726, PARCEL #2

RESIDENTIAL
26

LEROY H. SAVAGE AND
DEBORAH M. SAVAGE
013-00364.80
OR 653, PG.880

RESIDENTIAL
28

ALMA C. KIGER
013-00374.00
202100032507

1 STORY
FRAME
#1080

RESIDENTIAL
30

BONNIE L. WEAVER
013-00375.00
OR1796, PG.2747 1/2INT.
DV 445, PG.637 1/2INT.

1 STORY
FRAME
#1060

D.N.D. GRAVEL 4"
CONC. BORDER
TURN-A-ROUND

D.N.D. BASKETBALL
POST & HOOP

RESIDENTIAL
20

JEFFREY J. GRESSICK AND
DENISE M. GRESSICK
013-00376.00
OR 654, PG.128

#3025

20-UV

20-T-2

20-SH


RESIDENTIAL
18

ZACHARY J. YOUNG AND
ANDREA M. FRY
013-00590.10
OR 1705, PG.4441

18-WD
TOTAL TAKE

18-UV

FAIRFIELD COUNTY
GREENFIELD TOWNSHIP
SECTIONS 14 AND 23; TOWNSHIP 15, RANGE XIX
CONGRESS LANDS (EAST OF SCIOTO RIVER)

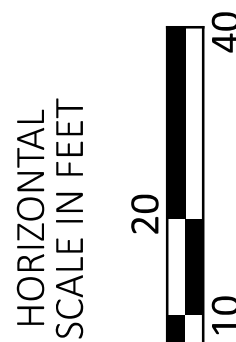

RIGHT OF WAY TOPO SHEET
STA. 43+00.00 TO STA. 48+00.00

DESIGN AGENCY

TF
ASSOCIATES

DESIGNER

JPS

REVIEWER

FDS 03/15/24

PROJECT ID

111621

SUBSET

RW.15

TOTAL

18

NOTE: SEE SHEET RW.6 FOR TABLES INCLUDING:
EASEMENTS DESIGNATED BY DIAMONDS;
CENTERLINE OF CONSTRUCTION CURVE
DATA; PARCEL DESCRIPTION P.O.B. LEAD-IN
REFERENCES.

* DENOTES RIGHT OF WAY ENCROACHMENT

REV. BY	DATE	DESCRIPTION
---------	------	-------------


DATE COMPLETED: 03/15/2024

HORIZONTAL
SCALE IN FEET



A horizontal scale bar with alternating black and white segments. It is marked with the numbers 0, 10, 20, and 40.

RIGHT OF WAY BOUNDARY SHEET
STA. 43+00.00 TO STA. 48+00.00

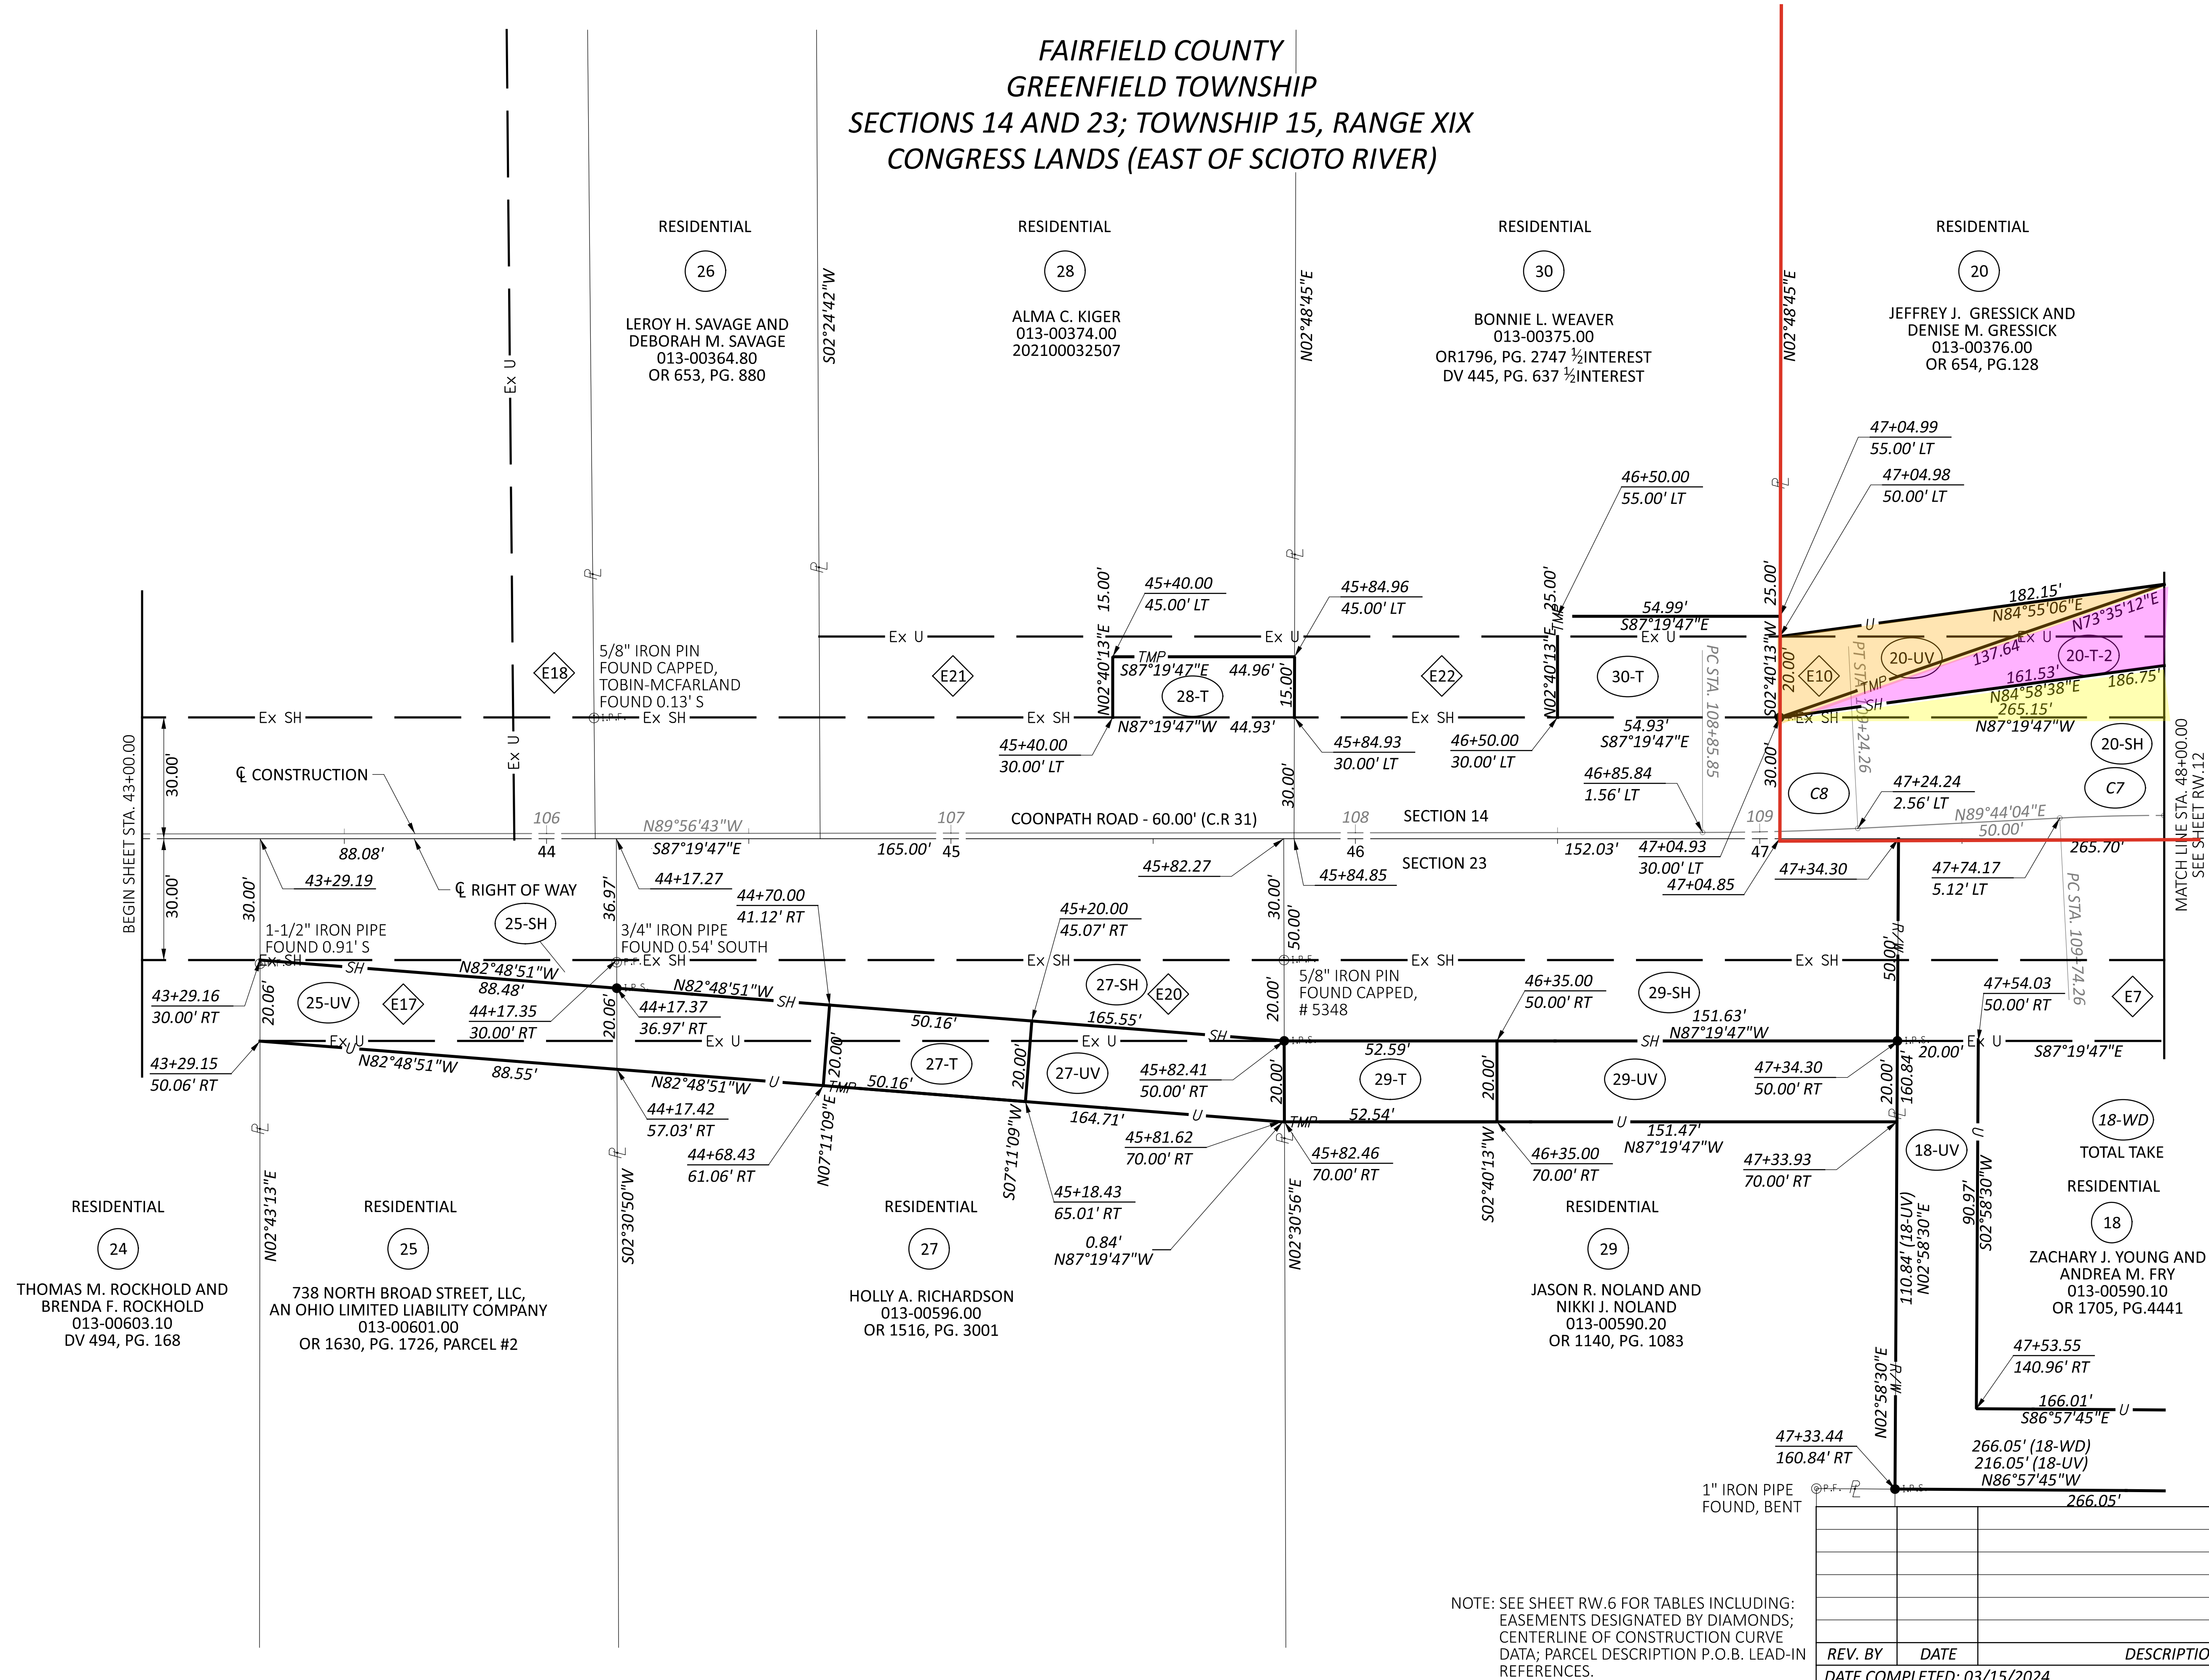

DESIGN AGENCY

TF
ASSOCIATES

DESIGNER

JPS

REVIEWER

FDS 03/15/24

PROJECT ID:

111621

SUBSET	TOTAL
1	1
2	2
3	3
100	100

RW.16 | 1



REV. BY	DATE	DESCRIPTION
DATE COMPLETED: 03/15/2024		


EXISTING LEGEND

- (A) EX. ASPHALT CONCRETE
- (B) EX. BRICK BASE
- (C) EX. AGGREGATE BASE

PROPOSED LEGEND

- (1) ITEM 441 - 1.25" ASPHALT CONCRETE SURFACE COURSE, TYPE 1, (449) PG70-22M
- (2) ITEM 441 - 1.75" ASPHALT CONCRETE INTERMEDIATE COURSE, TYPE 2, (449)
- (3) ITEM 301 - 6" ASPHALT CONCRETE BASE, PG64-22, (449)
- (4) ITEM 304 - 6" AGGREGATE BASE
- (5) ITEM 407 - NON-TRACKING TACK COAT
- (6) ITEM 609 - CURB, TYPE 6
- (7) ITEM 609 - COMBINATION CURB AND GUTTER, TYPE 9, AS PER PLAN - 1, (SEE DETAIL "A" ON SHEET P.6)
- (8) ITEM 609 - COMBINATION CURB AND GUTTER, TYPE 9, AS PER PLAN - 2, (SEE DETAIL "B" ON SHEET P.6)
- (9) ITEM 452 - 9" NON-REINFORCED CONCRETE PAVEMENT, CLASS QC1P, AS PER PLAN, (SEE DETAIL "D" AND DETAIL "E" ON SHEET P.6)
- (10) ITEM 204 - SUBGRADE COMPACTION
- (11) ITEM 659 - SEEDING AND MULCHING, CLASS 1
- (12) ITEM 605 - 6" BASE PIPE UNDERDRAIN
- (13) ITEM 609 - 6" CONCRETE TRAFFIC ISLAND, AS PER PLAN, CLASS QC1P, (SEE DETAIL "C" ON SHEET P.6)
- (14) ITEM 204 - EXCAVATION OF SUBGRADE, 14" DEPTH
- (15) ITEM 206 - CEMENT STABILIZED SUBGRADE, 14" DEPTH
- (16) ITEM 254 - PAVEMENT PLANING, ASPHALT CONCRETE, 3.0"

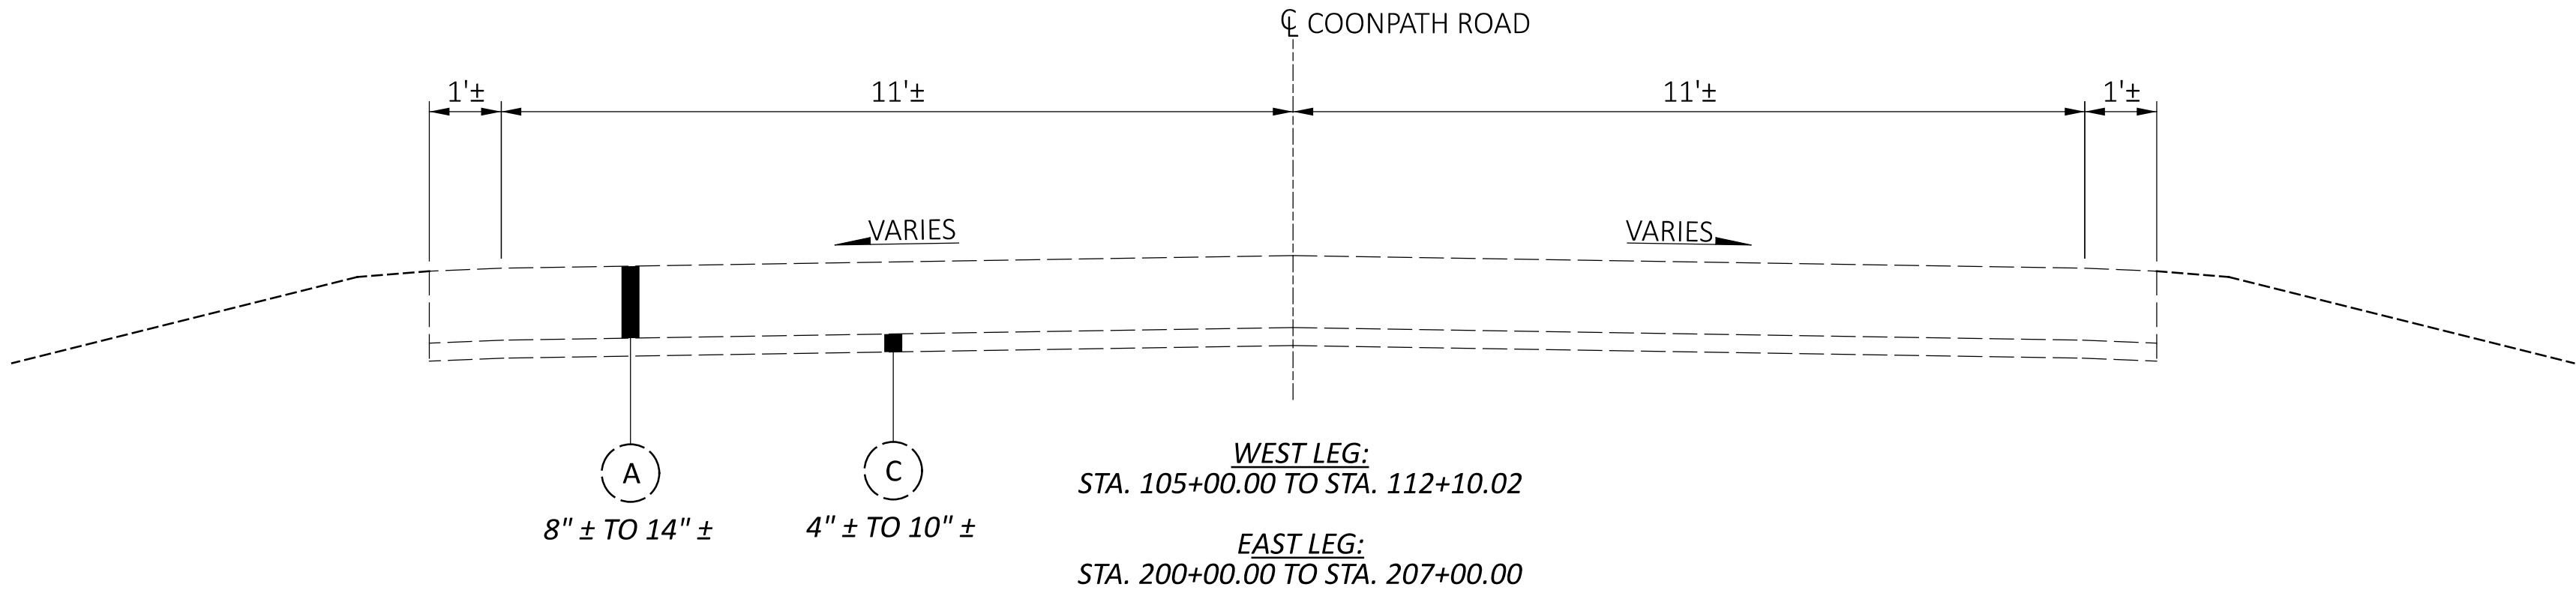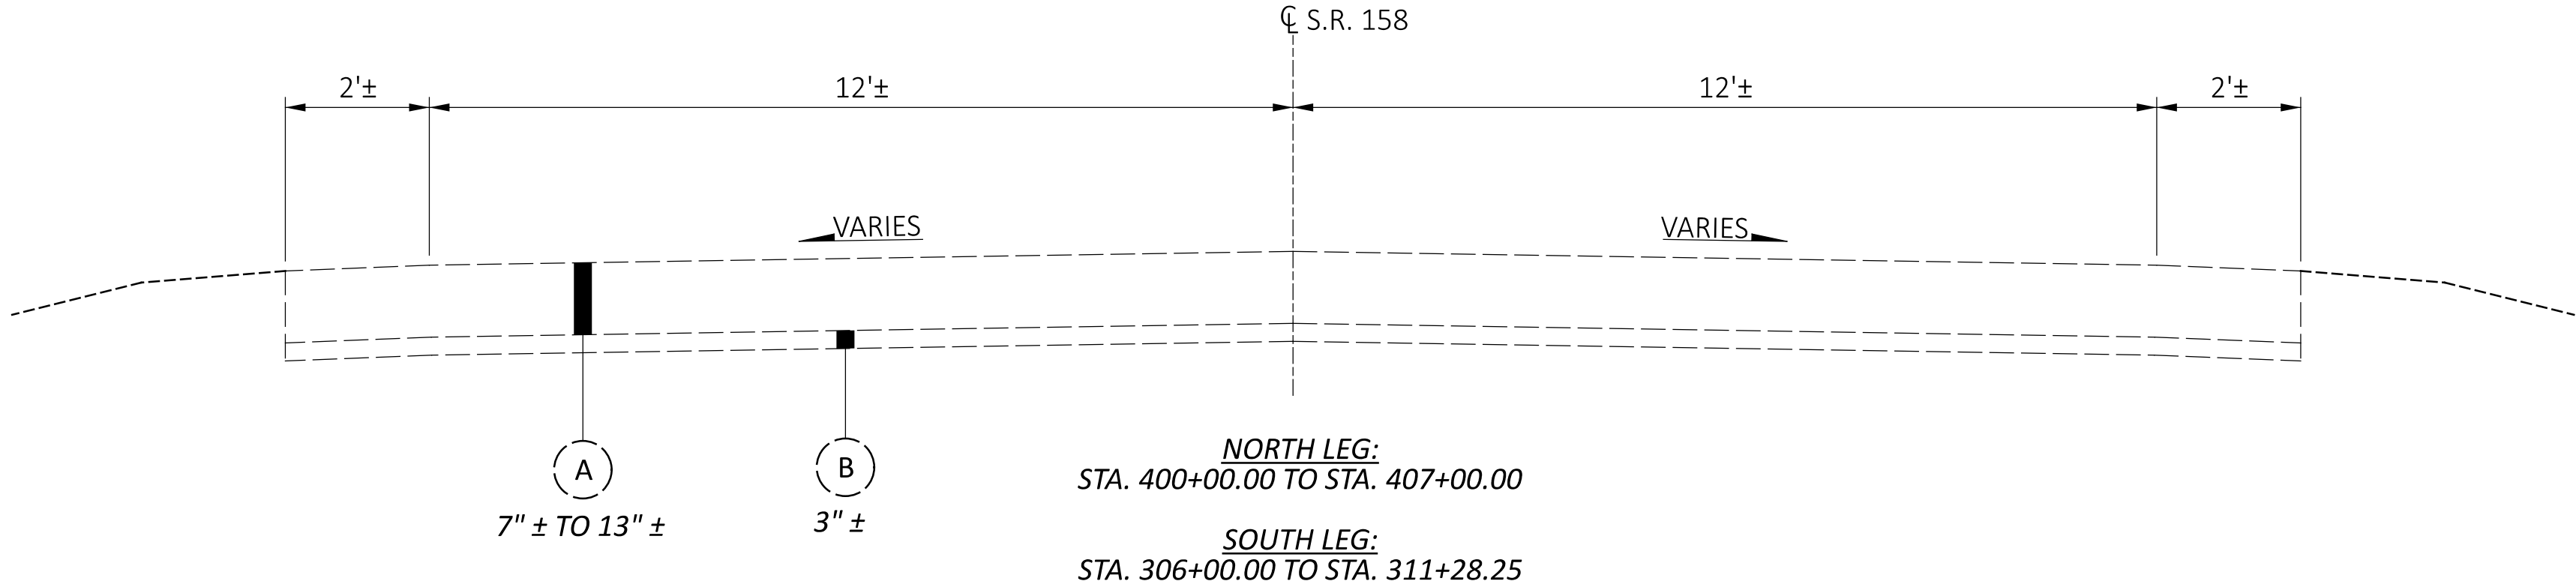

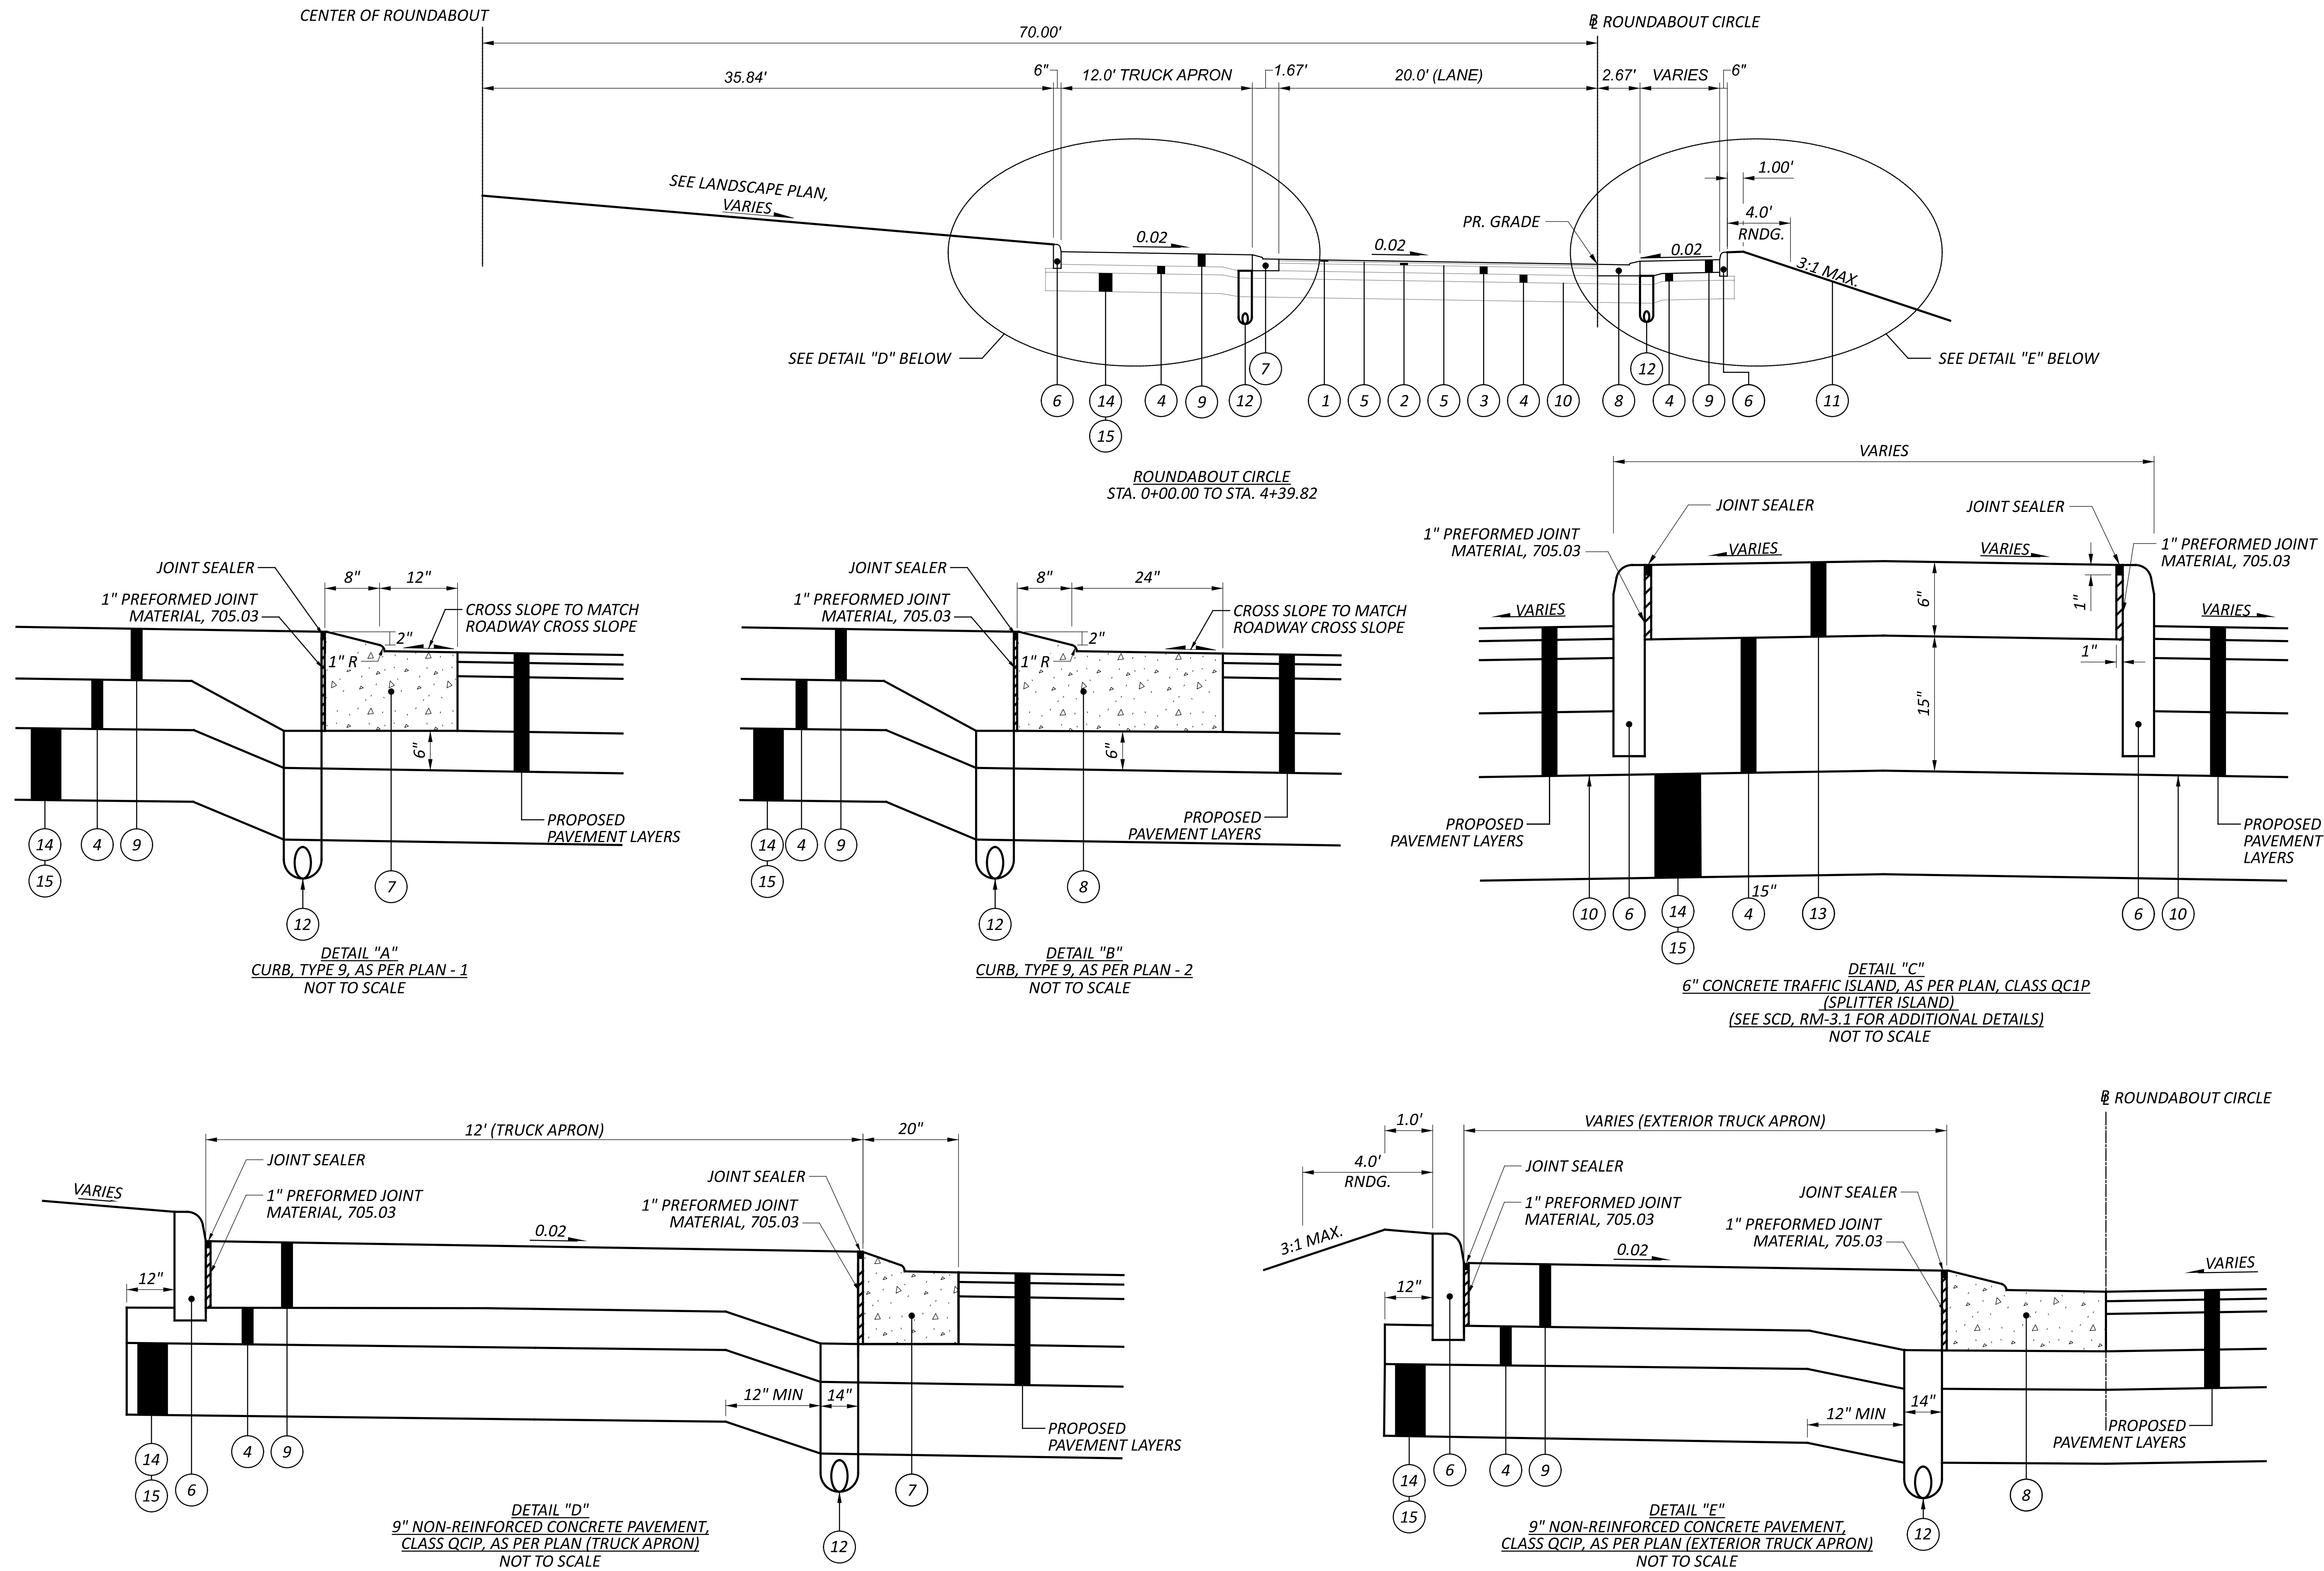

- A

NORTH LEG:
16.00' FROM STA. 401+75.00 TO STA. 402+00.00
TAPERS FROM 16.00' @ STA. 402+00.00 TO 12.00' @ STA. 403+70.00

SOUTH LEG:
TAPERS FROM 12.00' @ STA. 307+55.00 TO 16.00' @ STA. 308+90.00
16.00' FROM STA. 308+90.00 TO STA. 309+50.00
- B

NORTH LEG:
4.00' FROM STA. 401+75.00 TO STA. 403+20.00
TAPERS FROM 4.00' @ STA. 403+20.00 TO 2.00' @ STA. 403+70.00

SOUTH LEG:
TAPERS FROM 2.00' @ STA. 307+55.00 TO 4.00' @ STA. 308+05.00
4.00' FROM STA. 308+05.00 TO STA. 309+50.00
- C

NORTH LEG:
4.00' FROM STA. 401+75.00 TO STA. 403+20.00
TAPERS FROM 4.00' @ STA. 403+20.00 TO 1.50' @ STA. 403+70.00

SOUTH LEG:
TAPERS FROM 2.00' @ STA. 307+55.00 TO 4.00' @ STA. 308+05.00
4.00' FROM STA. 308+05.00 TO STA. 309+50.00
- D

NORTH LEG:
VARIES FROM 28.78' @ STA. 400+70.00 TO 16.00' @ STA. 401+14.28
16.00' FROM STA. 401+14.28 TO STA. 401+65.00

SOUTH LEG:
16.00' FROM STA. 309+60.00 TO STA. 310+01.26
VARIES FROM 16.00' @ STA. 310+01.26 TO 32.35' @ STA. 310+58.25
- E

NORTH LEG:
VARIES FROM 31.37' @ STA. 400+70.00 TO 16.00' @ STA. 401+16.65
16.00' FROM STA. 401+16.65 TO STA. 401+65.00

SOUTH LEG:
16.00' FROM STA. 309+60.00 TO STA. 310+21.27
VARIES FROM 16.00' @ STA. 310+21.27 TO 28.53' @ STA. 310+58.25
- F

NORTH LEG:
VARIES FROM 10.27' @ STA. 400+70.00 TO 2.00' @ STA. 401+75.00

SOUTH LEG:
VARIES FROM 2.00' @ STA. 309+50.00 TO 6.56' @ STA. 310+58.25
- G

NORTH LEG:
VARIES FROM 5.56' @ STA. 400+70.00 TO 2.00' @ STA. 401+75.00



SOUTH LEG:
VARIES FROM 2.00' @ STA. 309+50.00 TO 10.36' @ STA. 310+58.25
- H

NORTH LEG:
VARIES FROM 8.69' @ STA. 400+70.98 TO 0.00' @ STA. 401+75.00

SOUTH LEG:
VARIES FROM 0.00' @ STA. 309+50.00 TO 6.12' @ STA. 310+55.50
- I

NORTH LEG:
VARIES FROM 4.86' @ STA. 400+72.85 TO 0.00' @ STA. 401+75.00

SOUTH LEG:
VARIES FROM 0.00' @ STA. 309+50.00 TO 7.69' @ STA. 310+57.16

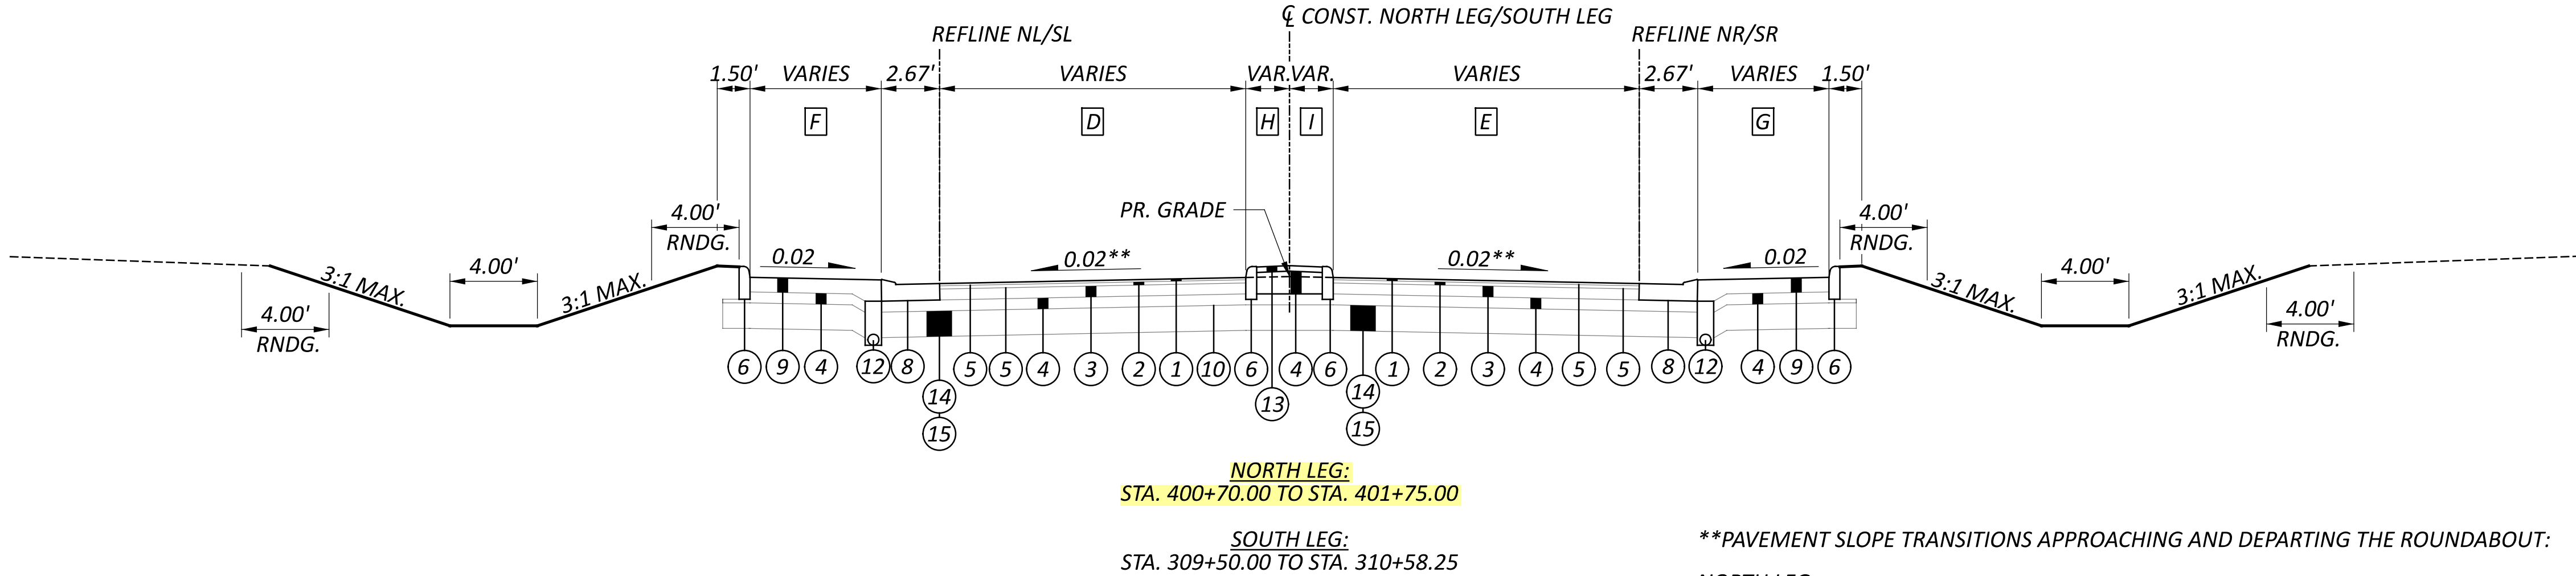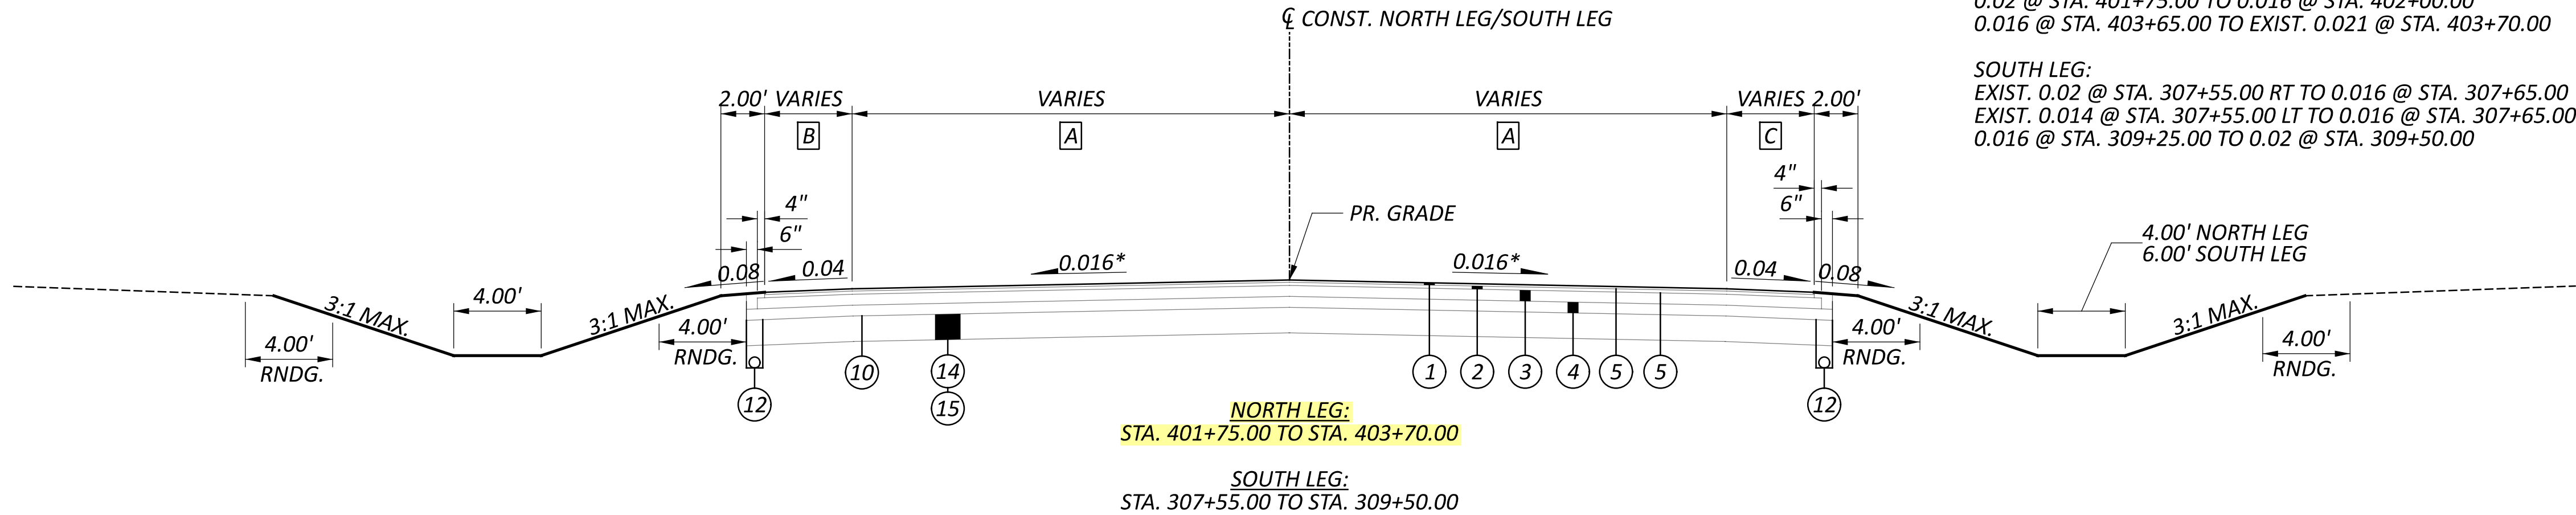

H

EAST LEG:
VARIES FROM 6.14' @ STA. 200+72.75 TO 0.00' @ STA. 201+80.00

WEST LEG:
VARIES FROM 0.00' @ STA. 110+30.00 TO 7.93' @ STA. 111+38.96



DRIVE 5 CURVE DATA
P.I. = STA. 5+45.39
 $\Delta = 78^\circ 23' 25''$ RT
Dc = 229'10'59"
R = 25.00'
T = 20.39'
L = 34.2'
E = 7.26'

DRIVE 11 CURVE DATA
P.I. = STA. 11+52.61
 $\Delta = 85^\circ 14' 32''$ LT
Dc = 190'59'09"
R = 30.00'
T = 27.61'
L = 44.63'
E = 10.77'

DRIVE 5 CURVE DATA
P.I. = STA. 5+79.62
 $\Delta = 78^\circ 27' 46''$ LT
Dc = 229'10'59"
R = 25.00'
T = 20.41'
L = 34.24'
E = 7.27'

DRIVE 11 CURVE DATA
P.I. = STA. 12+00.28
 $\Delta = 91^\circ 13' 15''$ RT
Dc = 190'59'09"
R = 30.00'
T = 30.65'
L = 47.76'
E = 12.89'

CURVE DATA
P.I. = STA. 0+00.00
 $\Delta = 360^\circ 00' 00''$ LT
Dc = 81'51'04"
R = 70.00'
T = 0.00'
L = 439.82'
E = 0.00'
Emax = N.C.

CURVE DATA
P.I. = STA. 200+84.93
 $\Delta = 02^\circ 01' 58''$ RT
Dc = 12'00'00"
R = 477.47'
T = 8.47'
L = 16.94'
E = 0.08'
Emax = N.C.

CURVE DATA
P.I. = STA. 201+53.51
 $\Delta = 01^\circ 31' 01''$ LT
Dc = 07'30'00"
R = 763.94'
T = 10.11'
L = 20.22'
E = 0.07'
Emax = N.C.

CURVE DATA
P.I. = STA. 400+98.40
 $\Delta = 05^\circ 09' 11''$ LT
Dc = 12'00'00"
R = 477.47'
T = 21.49'
L = 42.94'
E = 0.48'
Emax = N.C.

CURVE DATA
P.I. = STA. 310+35.69
 $\Delta = 02^\circ 44' 36''$ LT
Dc = 12'00'00"
R = 477.47'
T = 11.43'
L = 22.86'
E = 0.14'
Emax = N.C.

ROUNDABOUT PLAN
STA. 0+00 TO STA. 4+25

DESIGN AGENCY

AECOM

DESIGNER

VHP

REVIEWER

NSP 07/10/23

PROJECT ID

111621

SHEET


P.38


TOTAL

102

HORIZONTAL
SCALE IN FEET

0 20 40

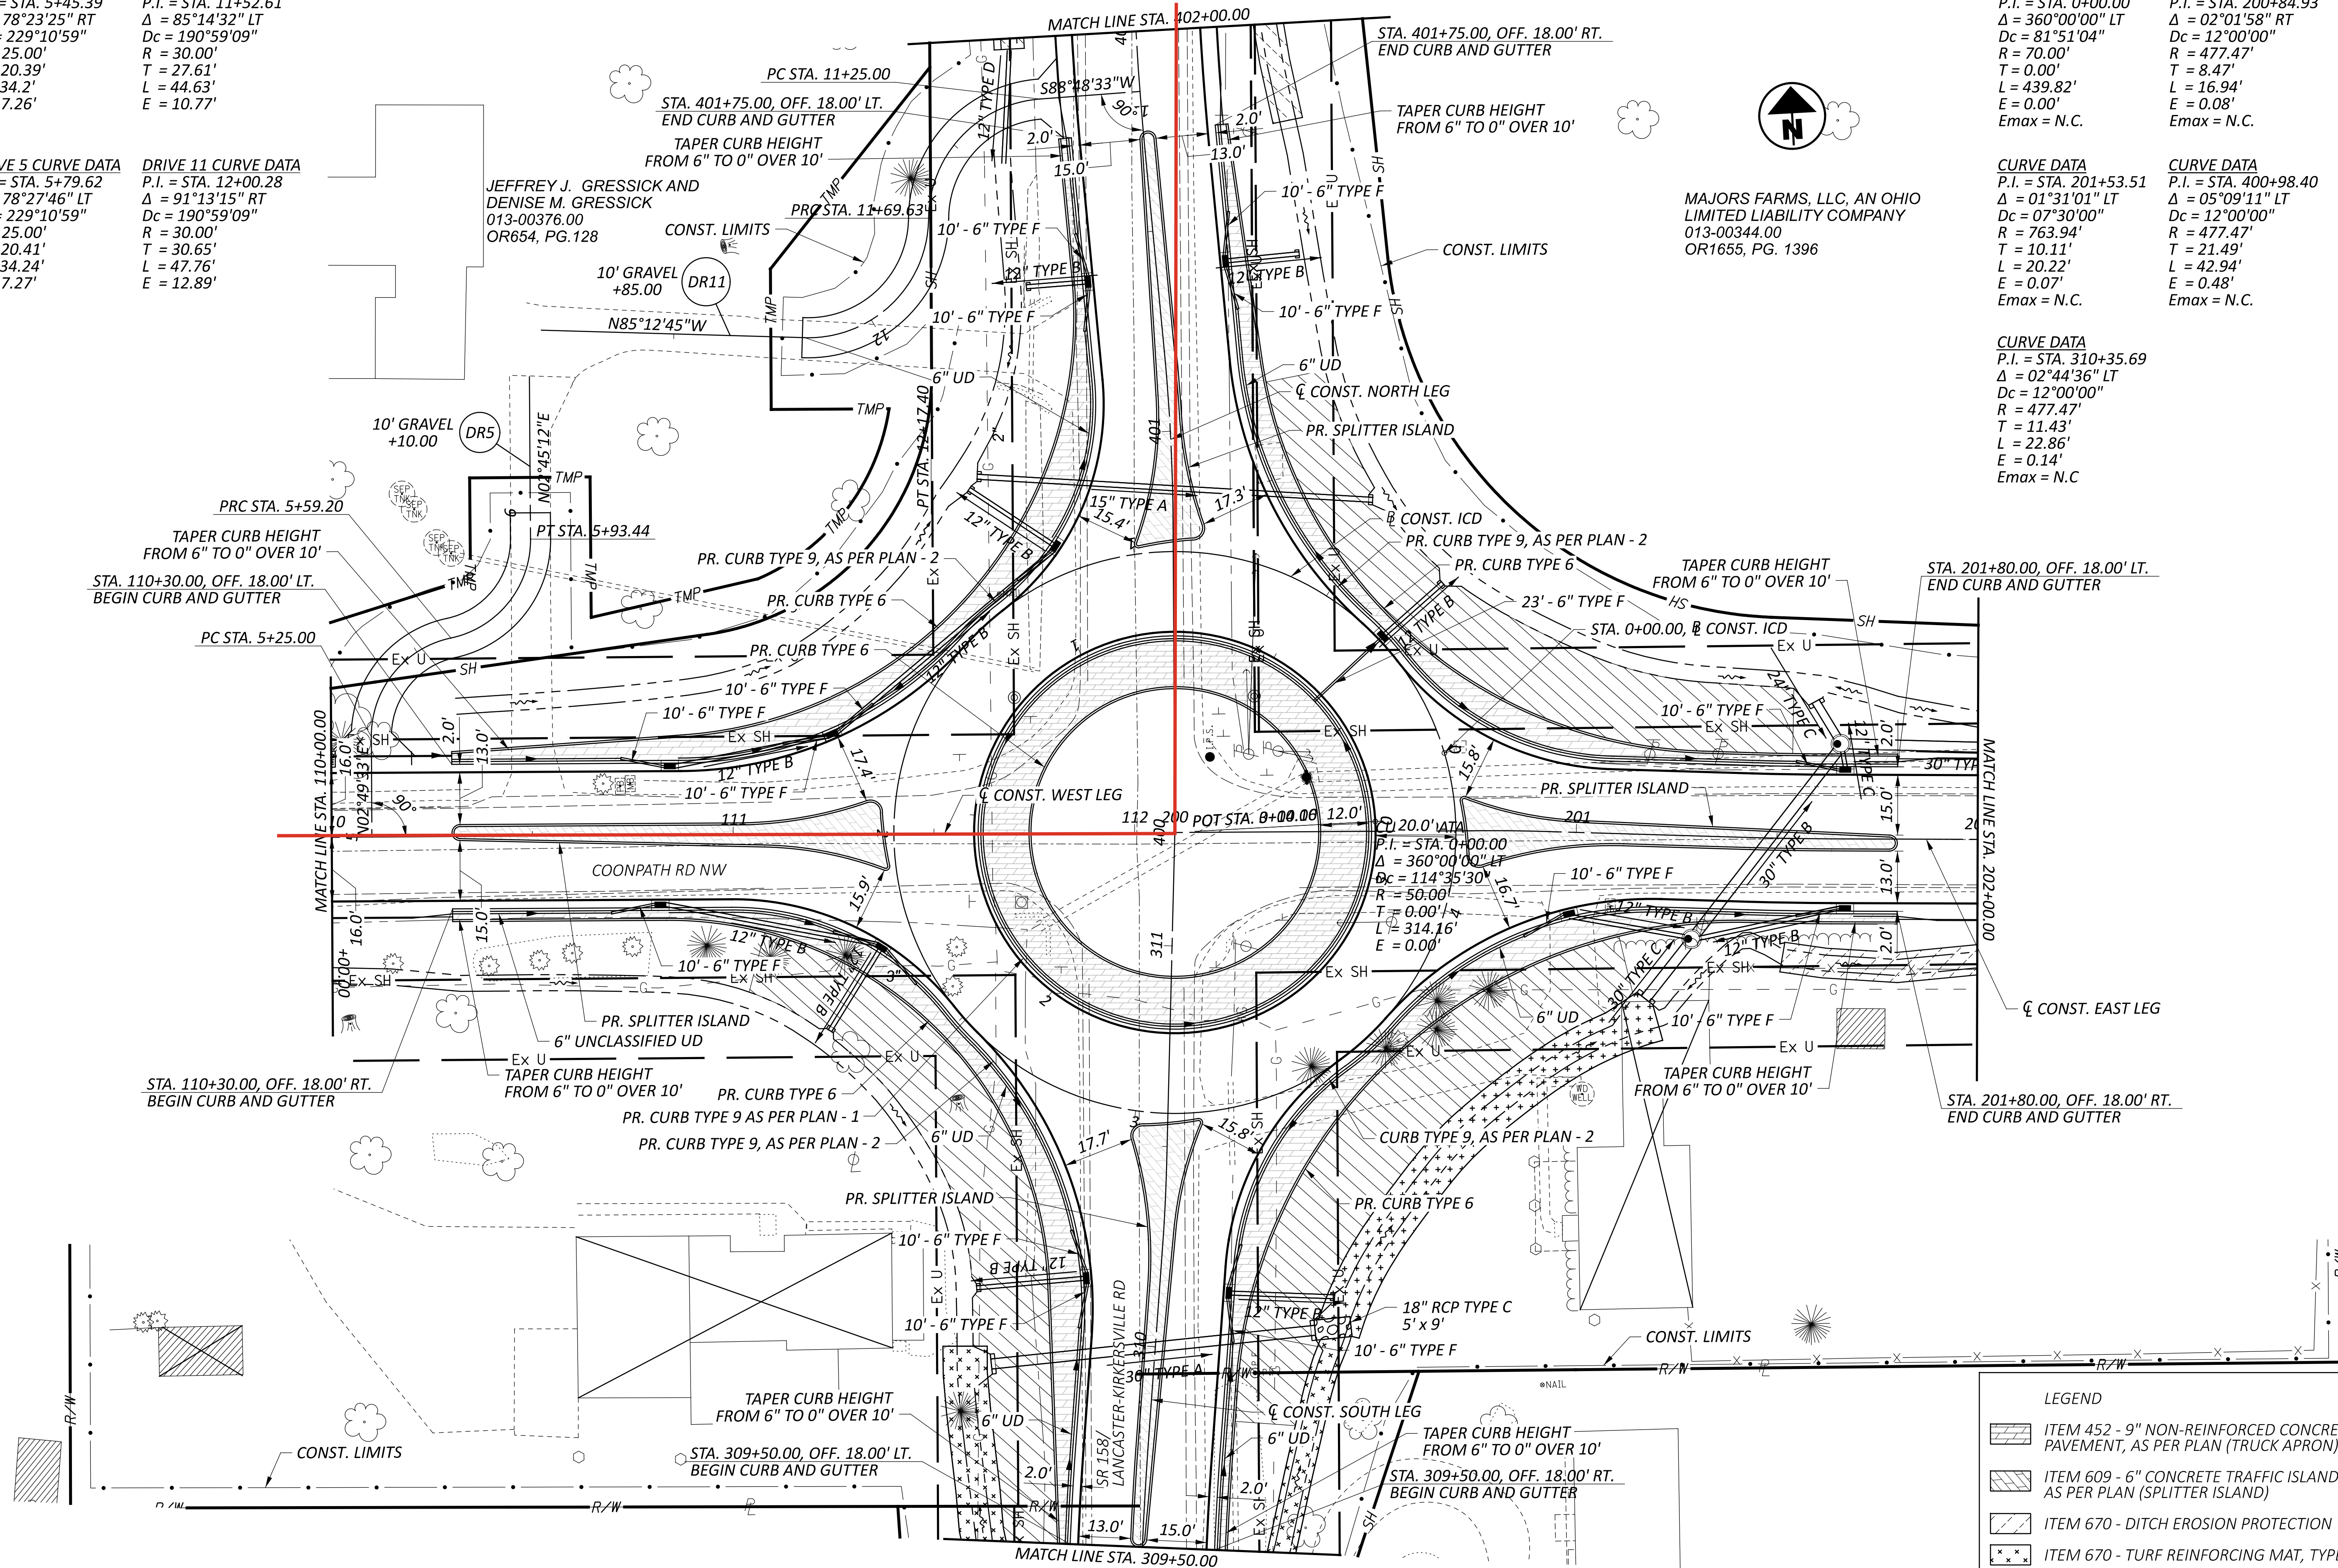

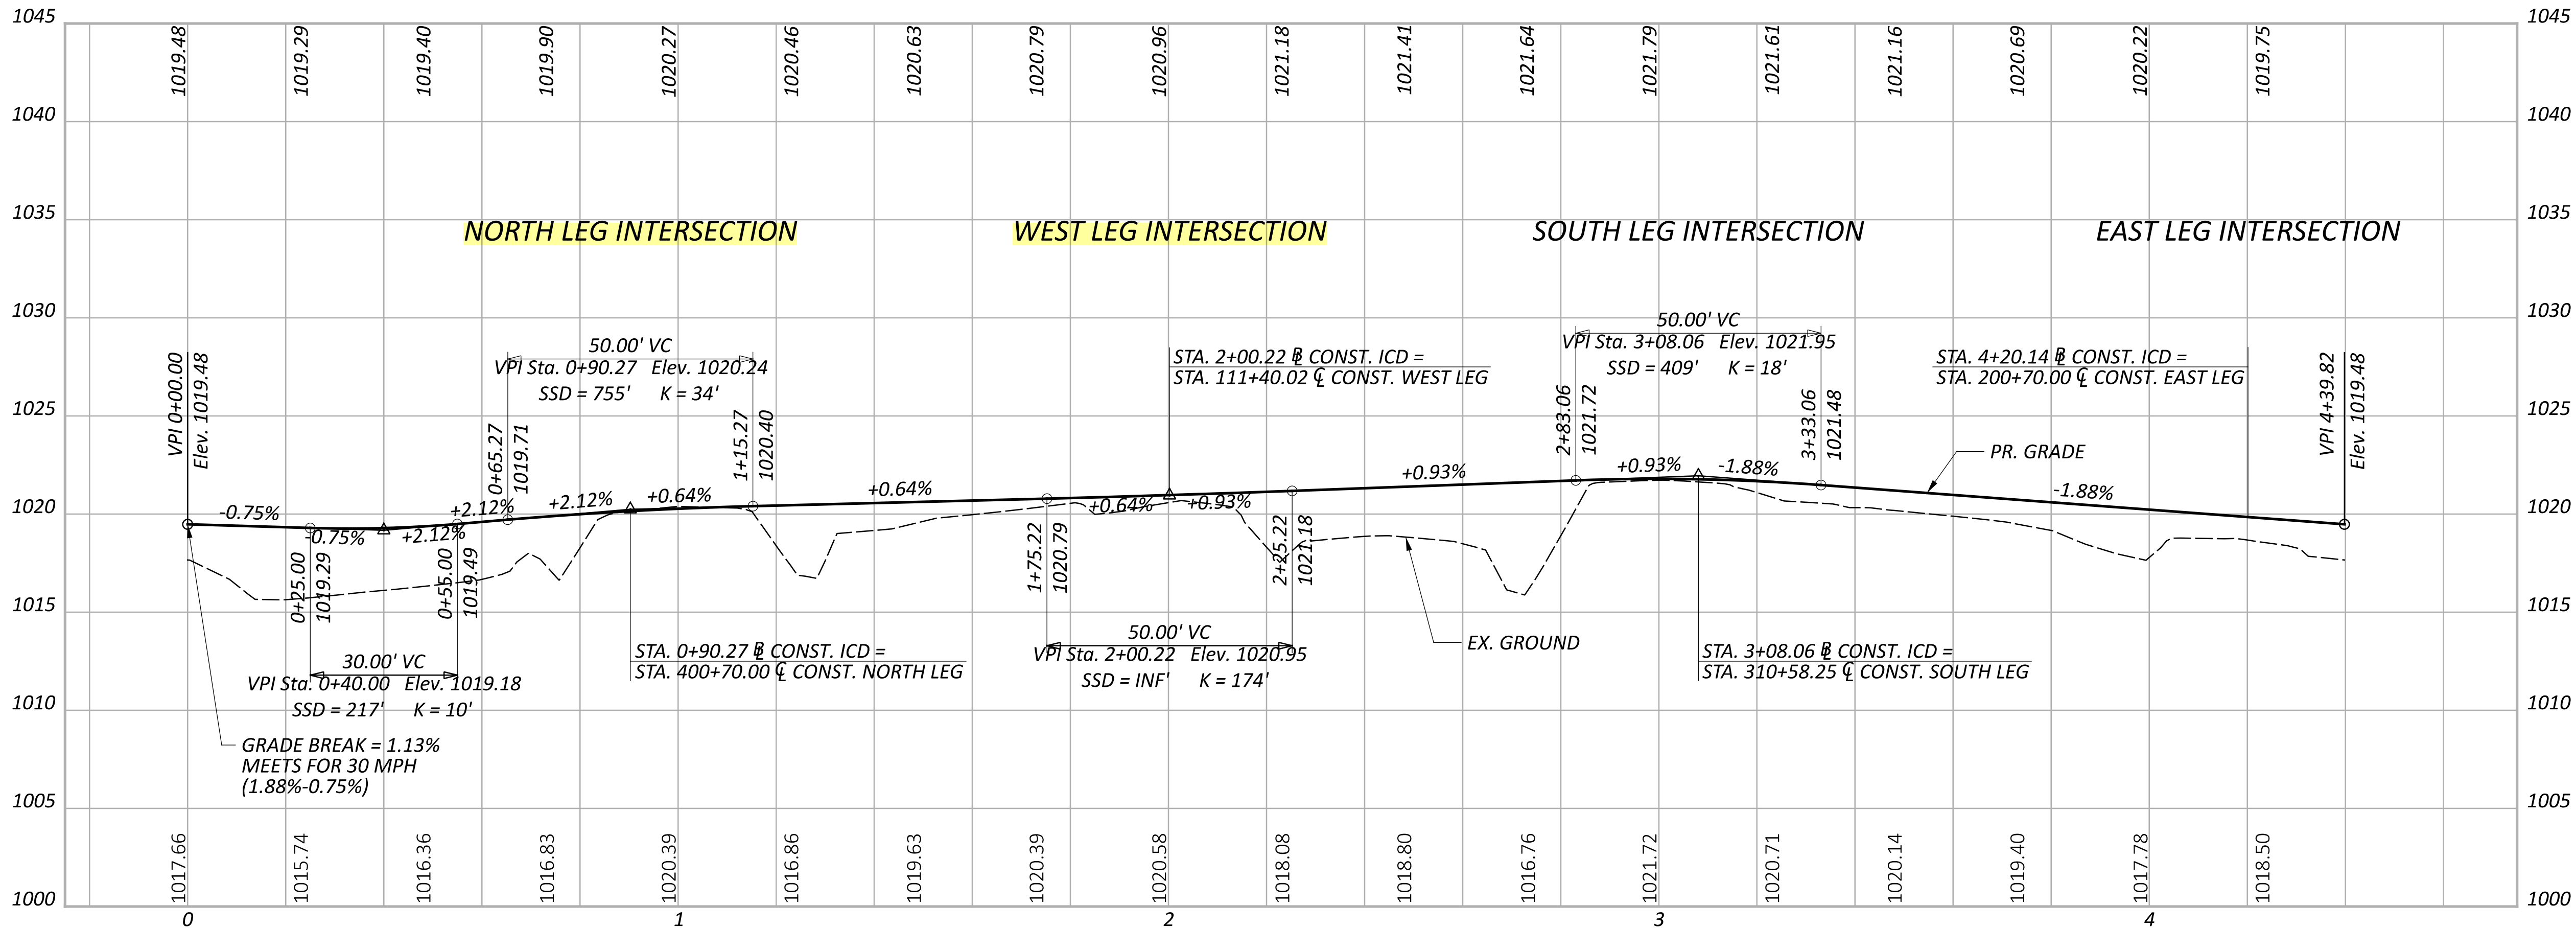

ROUNDABOUT PROFILE
STA. 0+00 TO STA. 4+25

DESIGN AGENCY

AECOM

DESIGNER

VHP

REVIEWER

NSP 07/10/23

PROJECT ID

111621

 
SHEET


P.39

TOTAL


102

HORIZONTAL
SCALE IN FEET



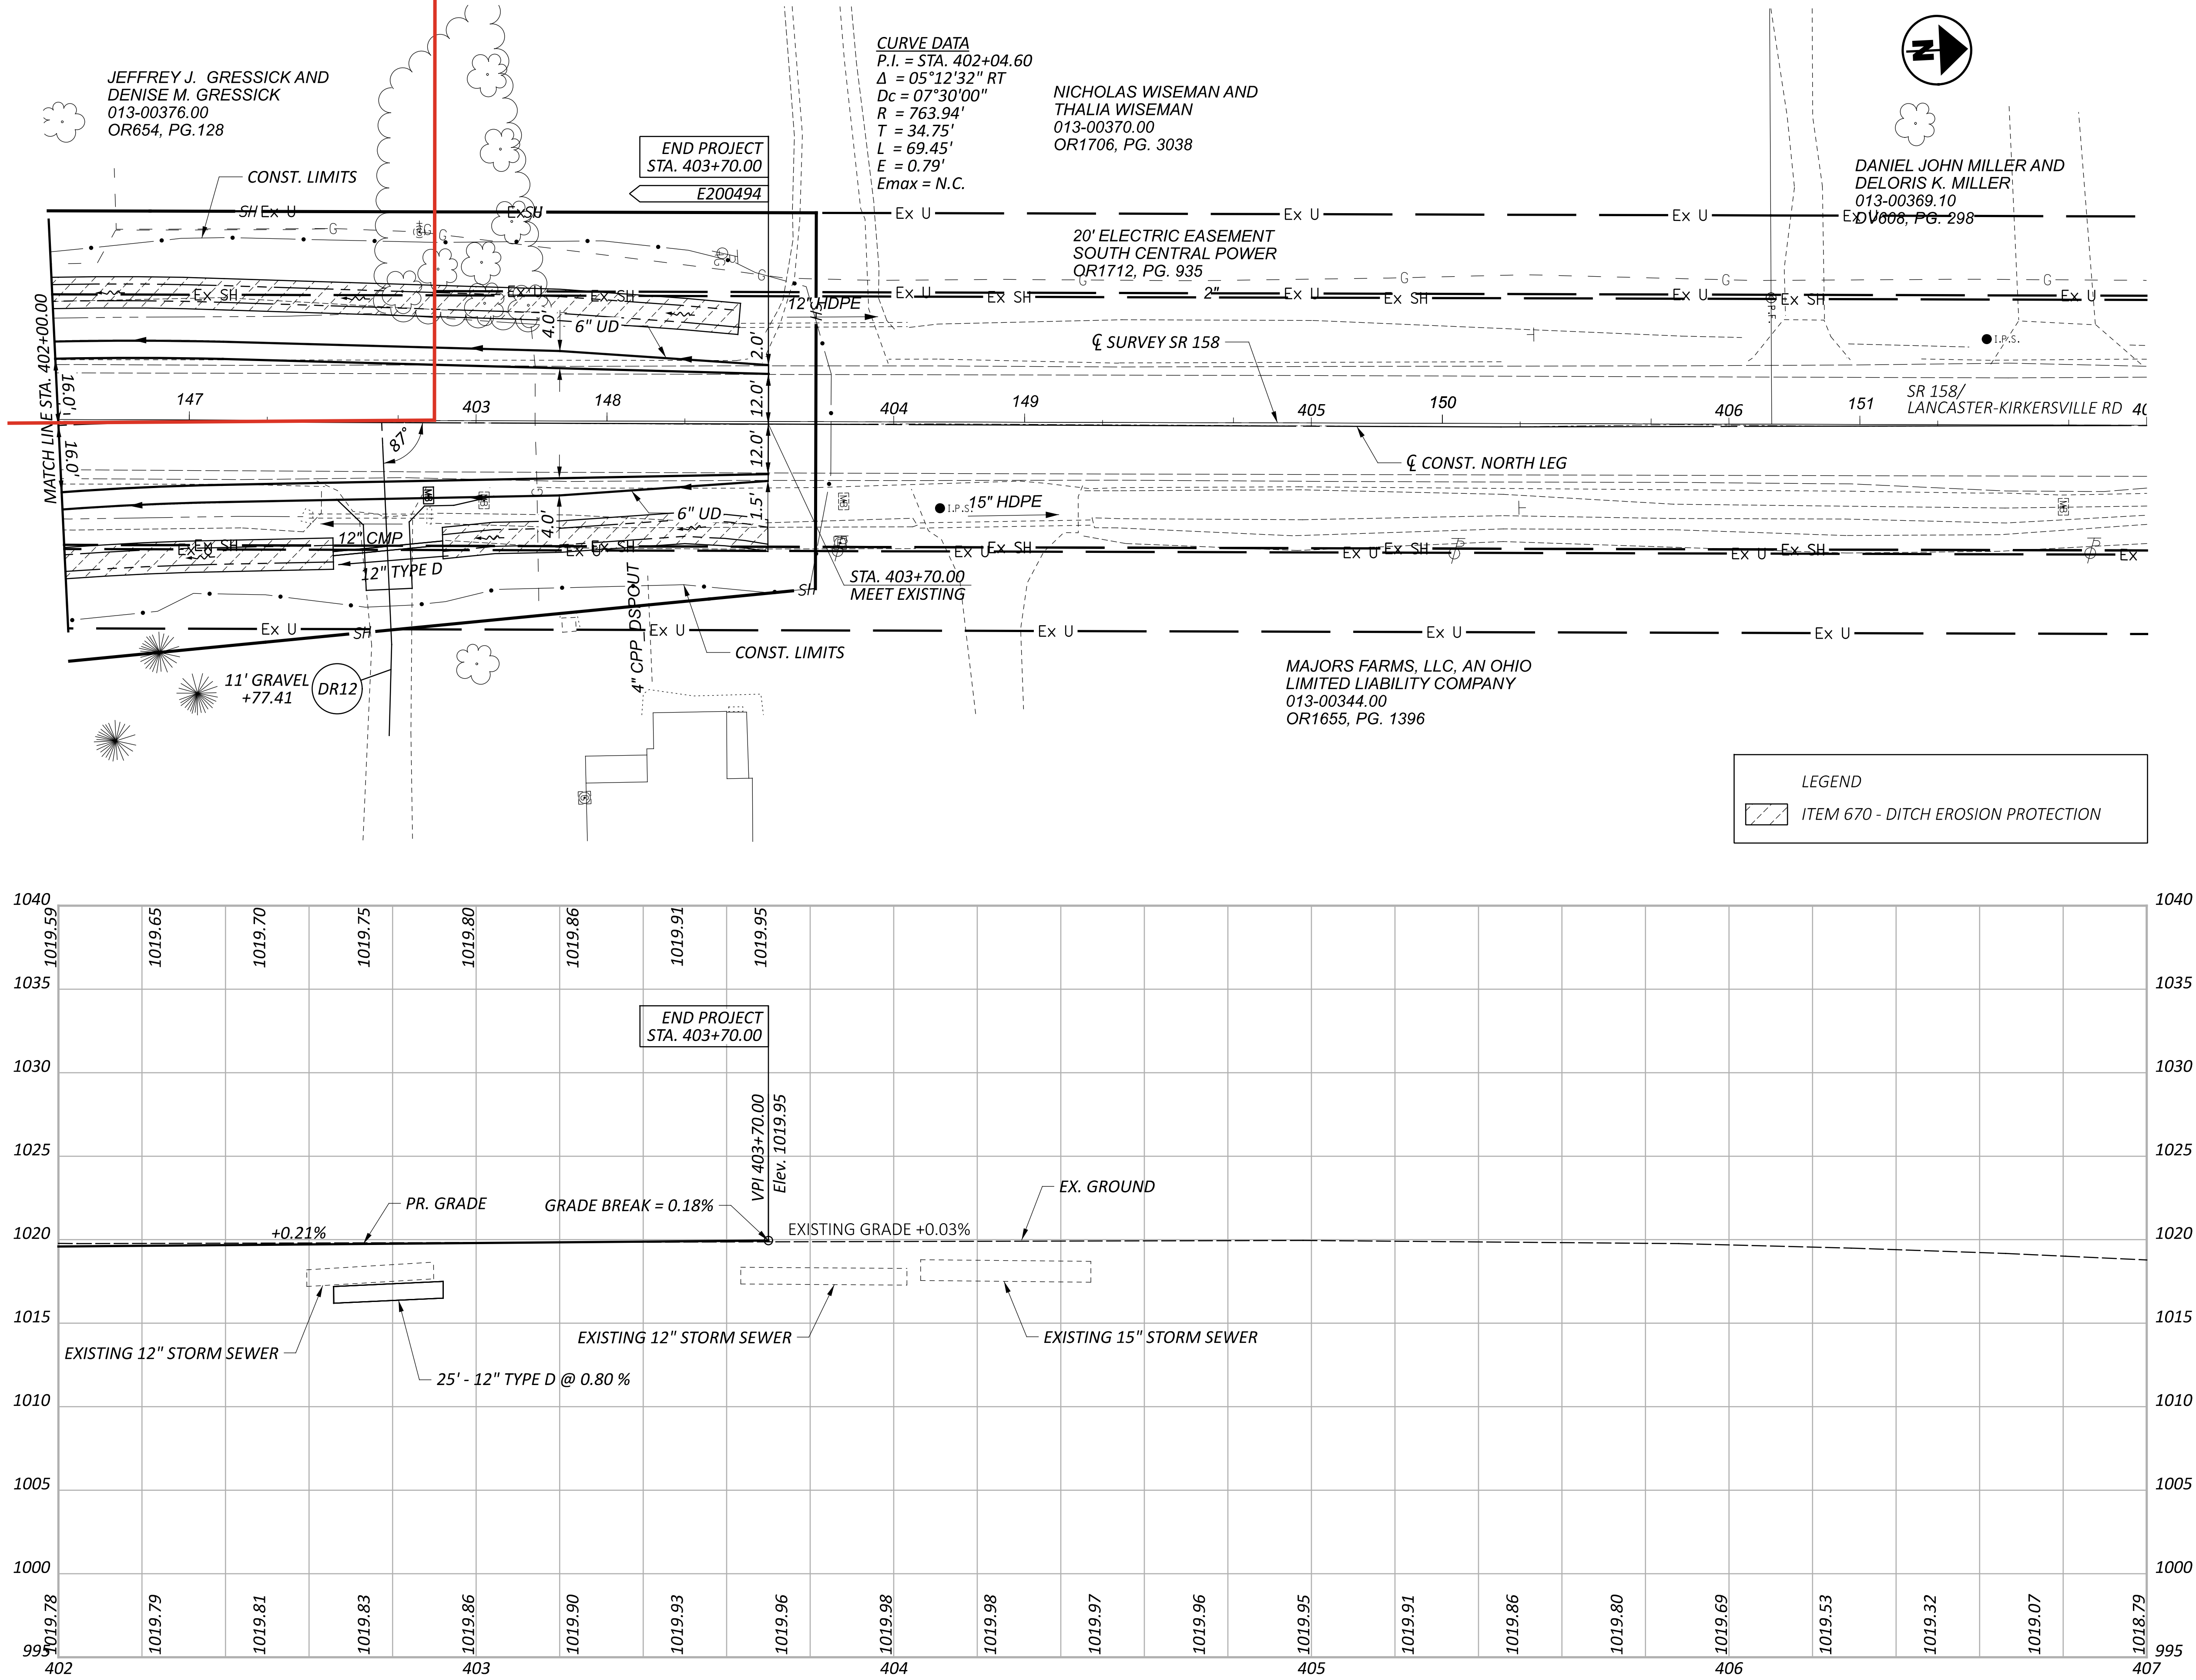

NORTH LEG PLAN AND PROFILE
STA. 402+00 TO END

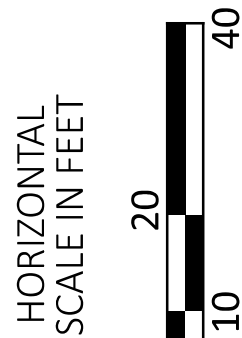

DESIGN AGENCY

AECOM

DESIGNER

VHP

REVIEWER

NSP 07/10/23

PROJECT ID


111621

SHEET

P.41

TOTAL

102

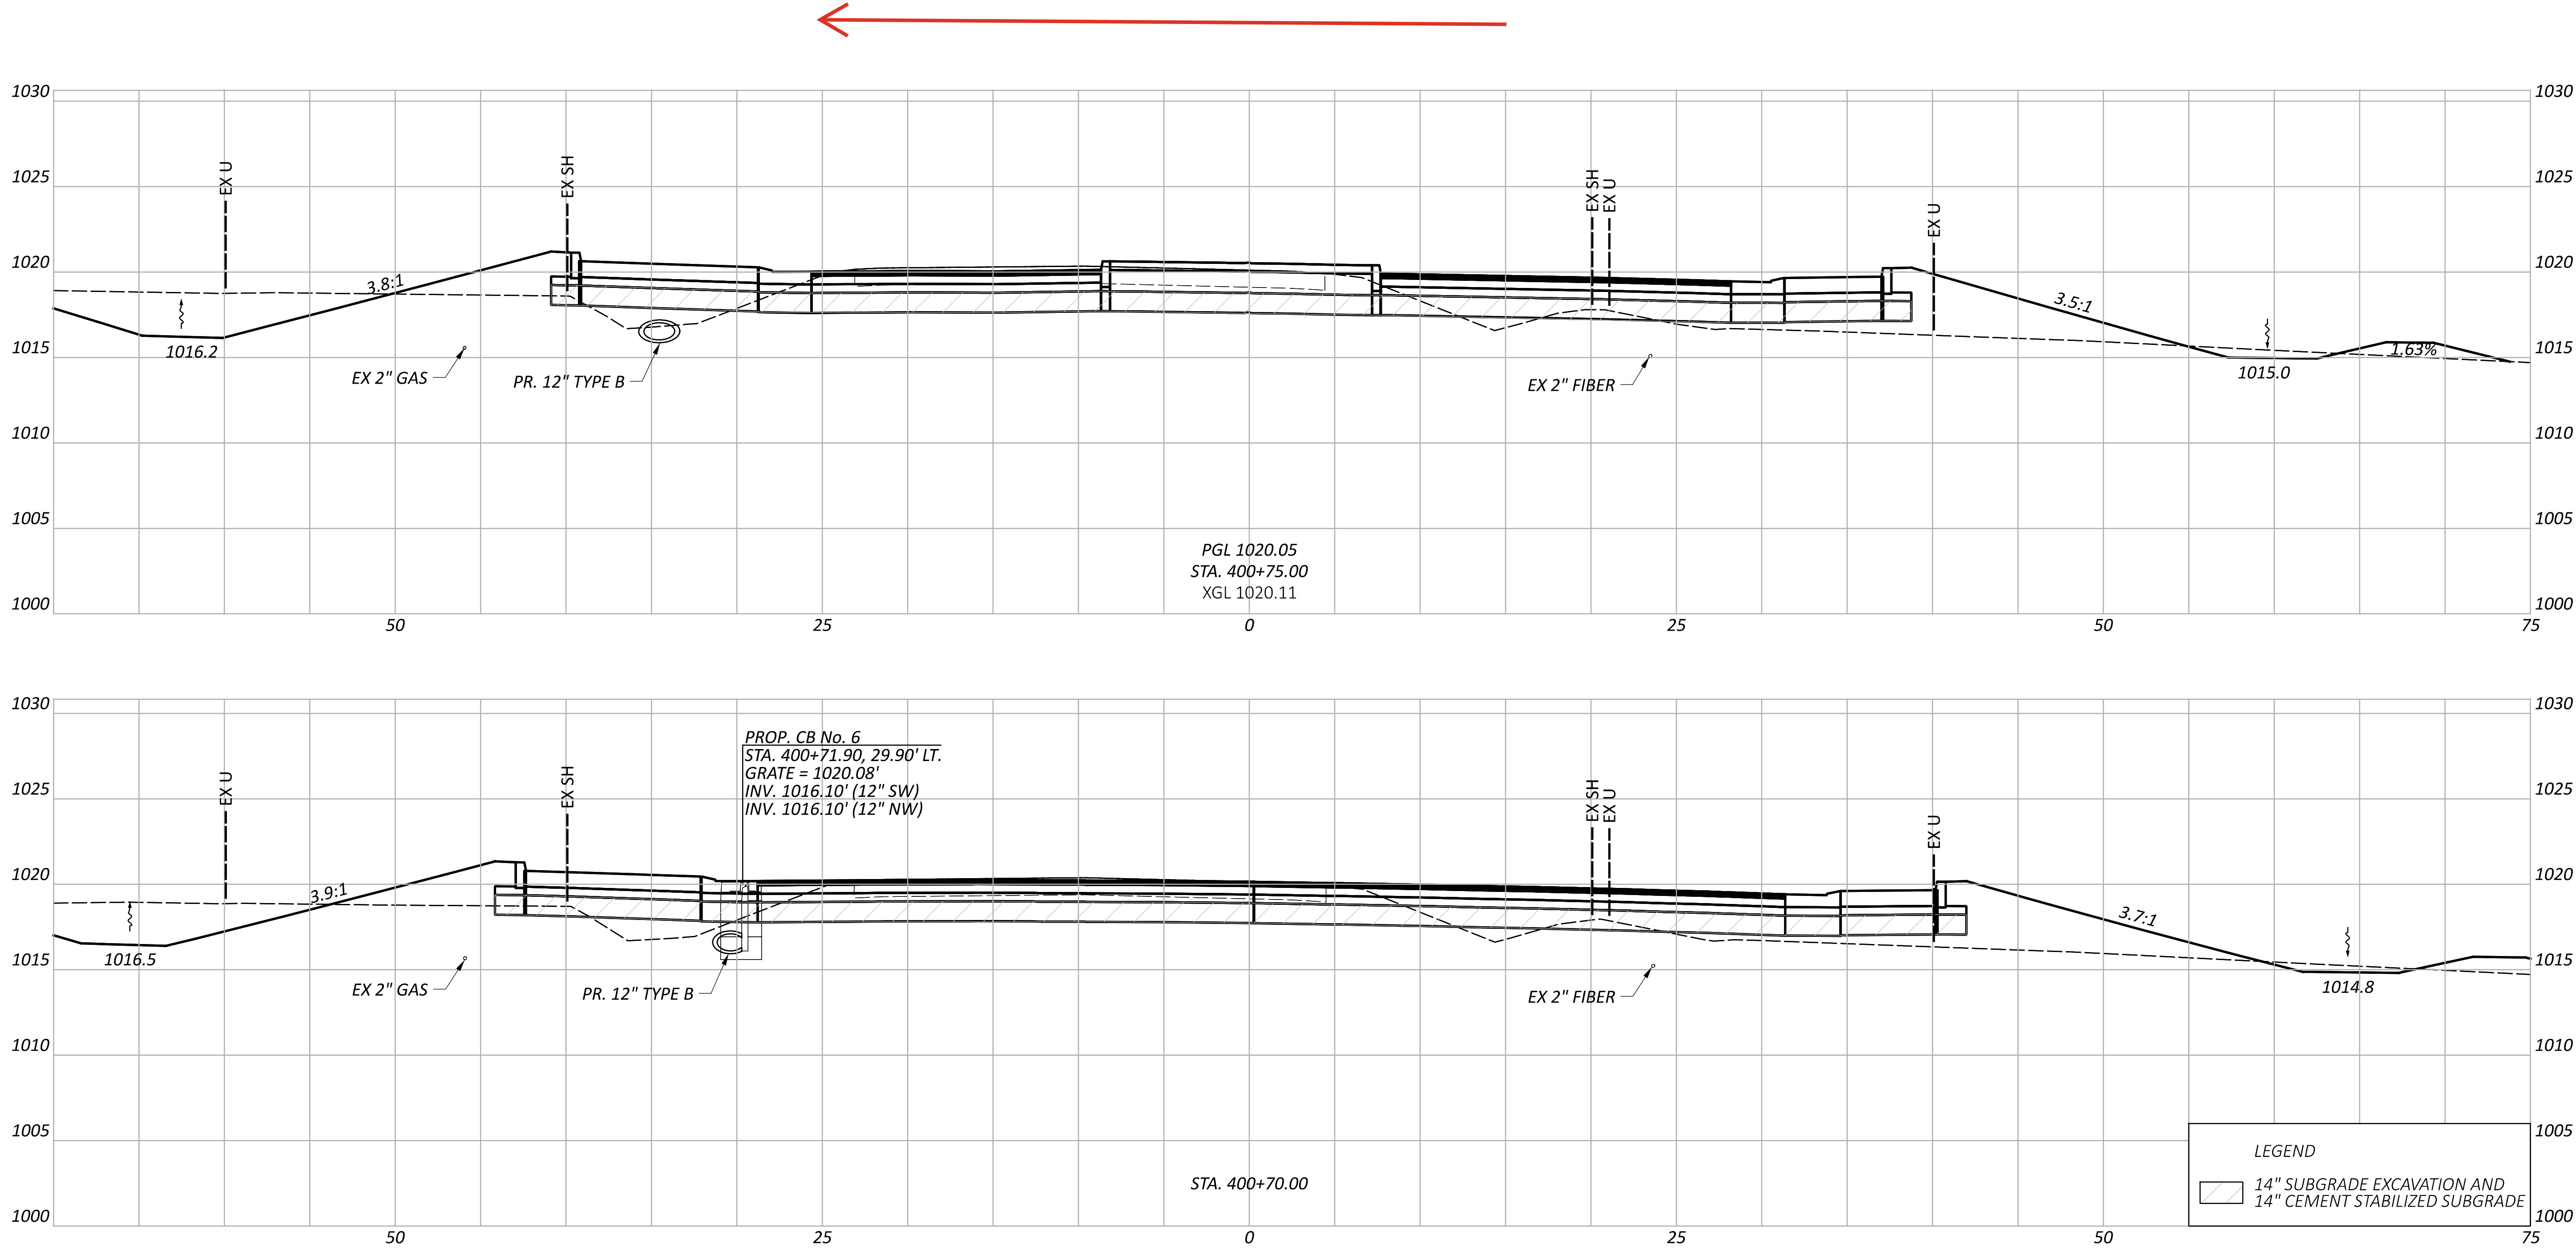

CROSS SECTIONS - NORTH LEG
STA. 400+70 - 400+75

DESIGN AGENCY

AECOM

DESIGNER

VHP

REVIEWER

NSP 07/10/23

PROJECT ID

111621

Sheet Totals

Seeding Cut Fill


. . .

SHEET

P.58

TOTAL

102

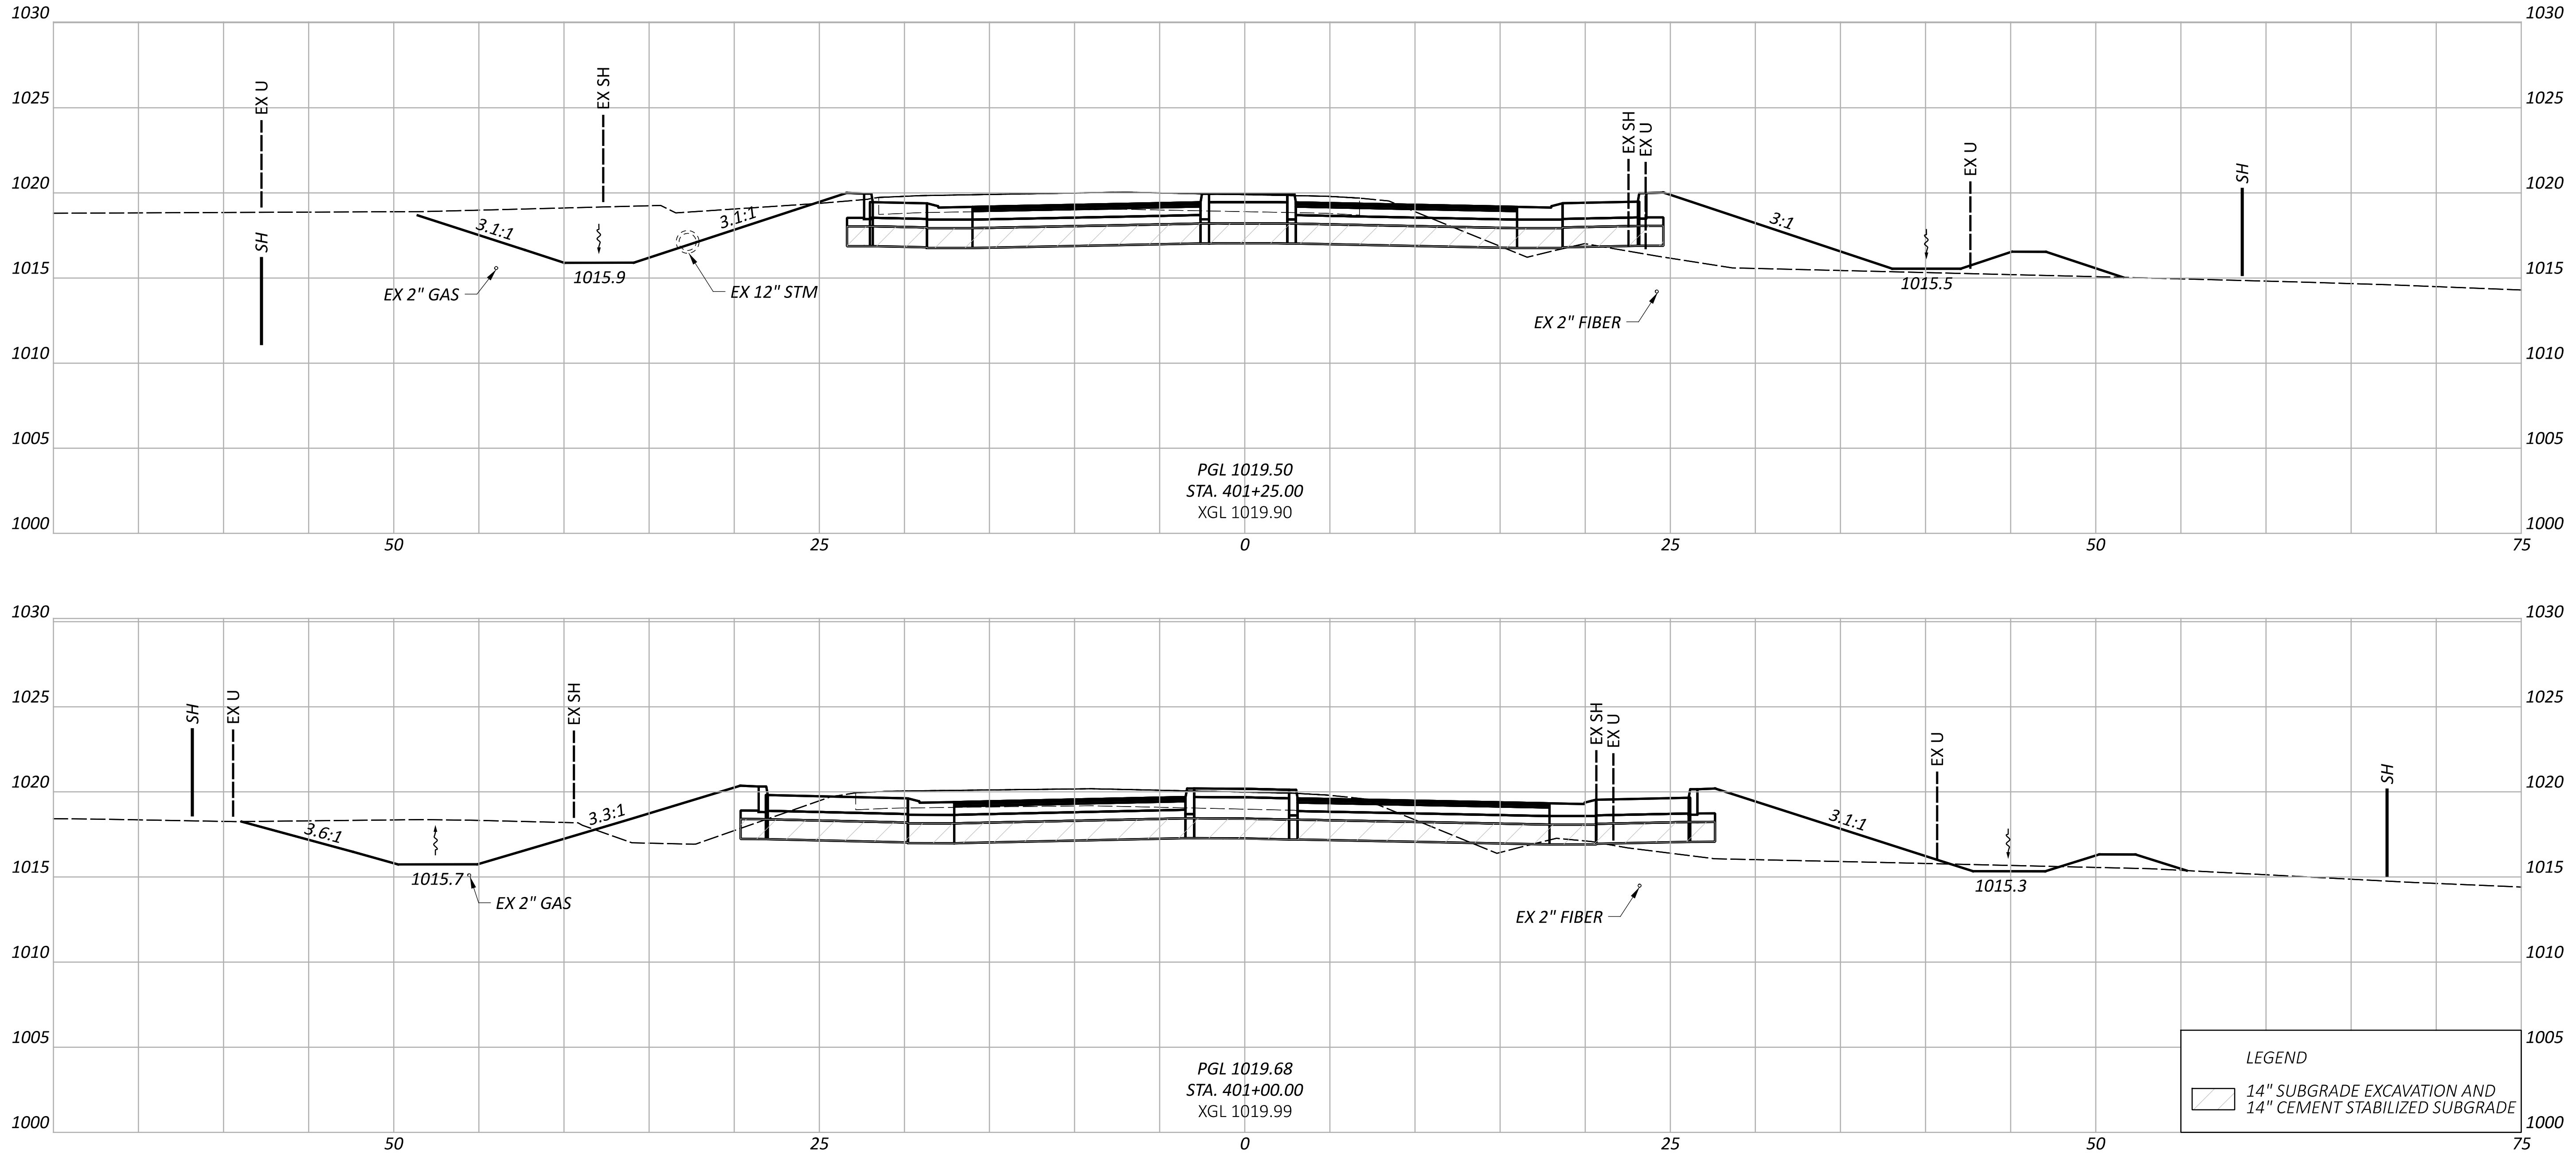

CROSS SECTIONS - NORTH LEG
STA. 401+00 - 401+25

DESIGN AGENCY


AECOM

DESIGNER
VHP

REVIEWER
NSP 07/10/23

PROJECT ID
111621

Sheet Totals			SHEET	TOTAL
Seeding	Cut	Fill		
.	.	.	P.59	102

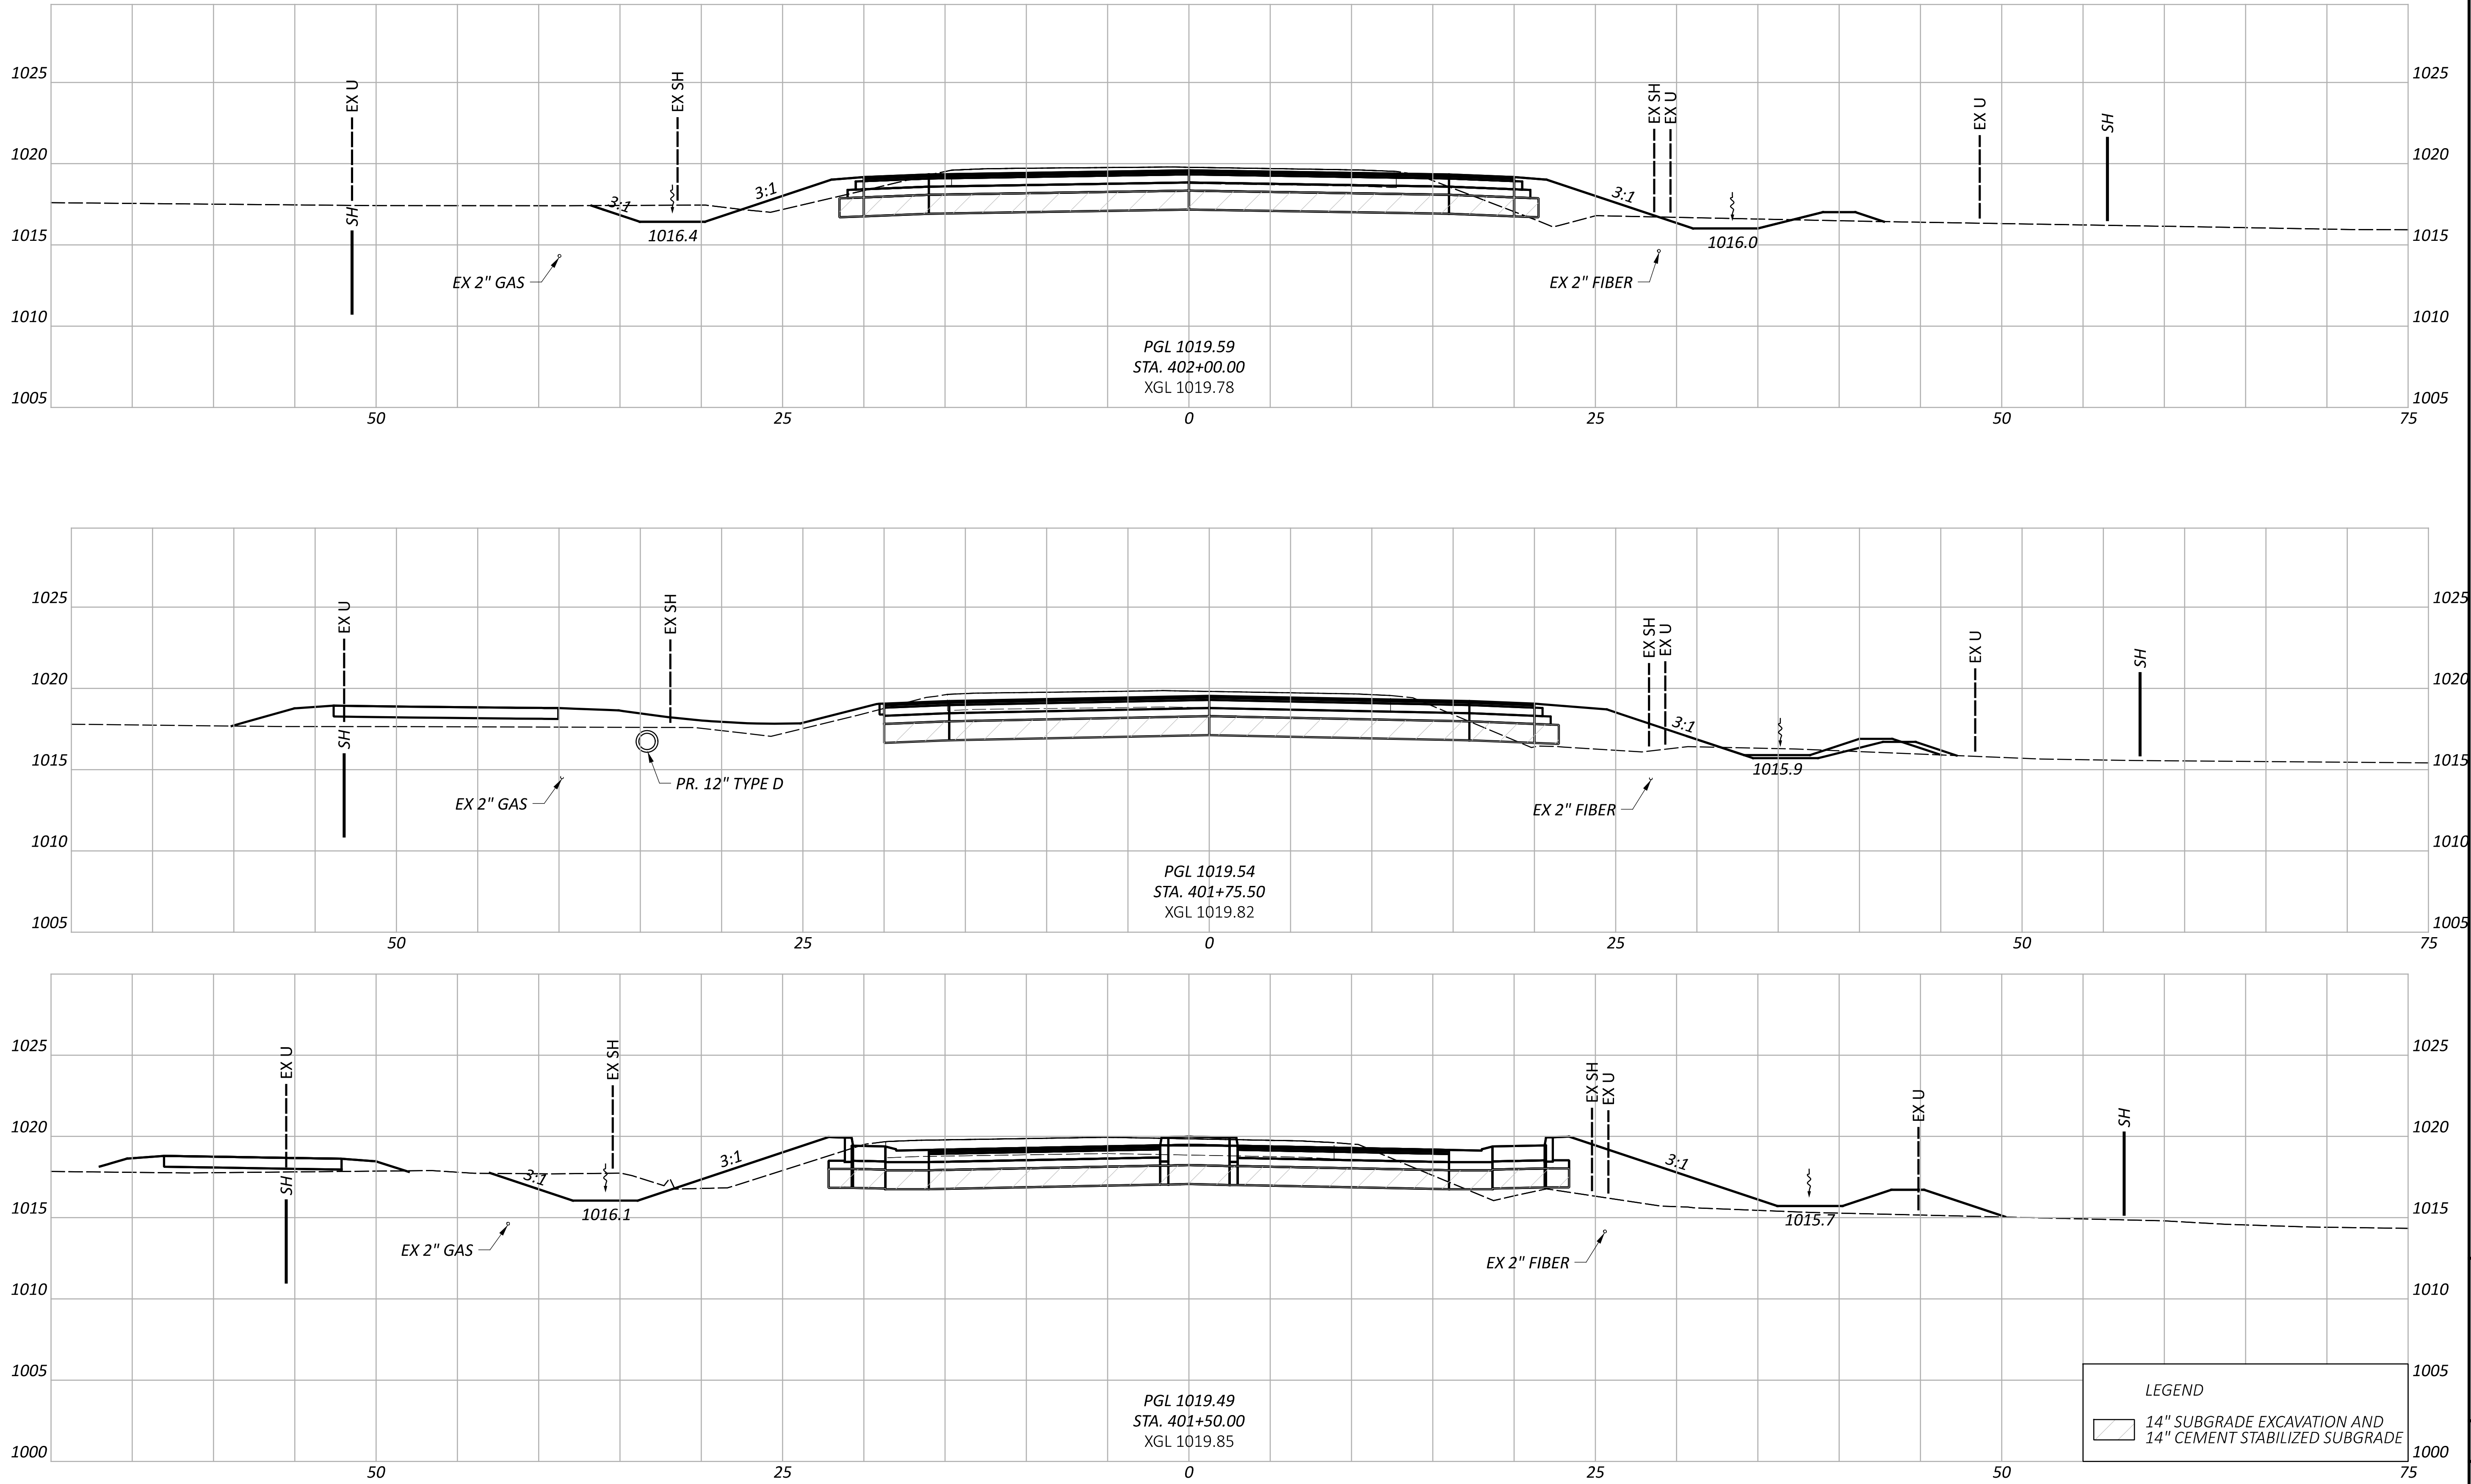

CROSS SECTIONS - NORTH LEG
STA. 401+50 - 402+00

DESIGN AGENCY


AECOM

DESIGNER
VHP

REVIEWER
NSP 07/10/23

PROJECT ID
111621

Sheet Totals			SHEET	TOTAL
Seeding	Cut	Fill		
.	.	.	P.60	102

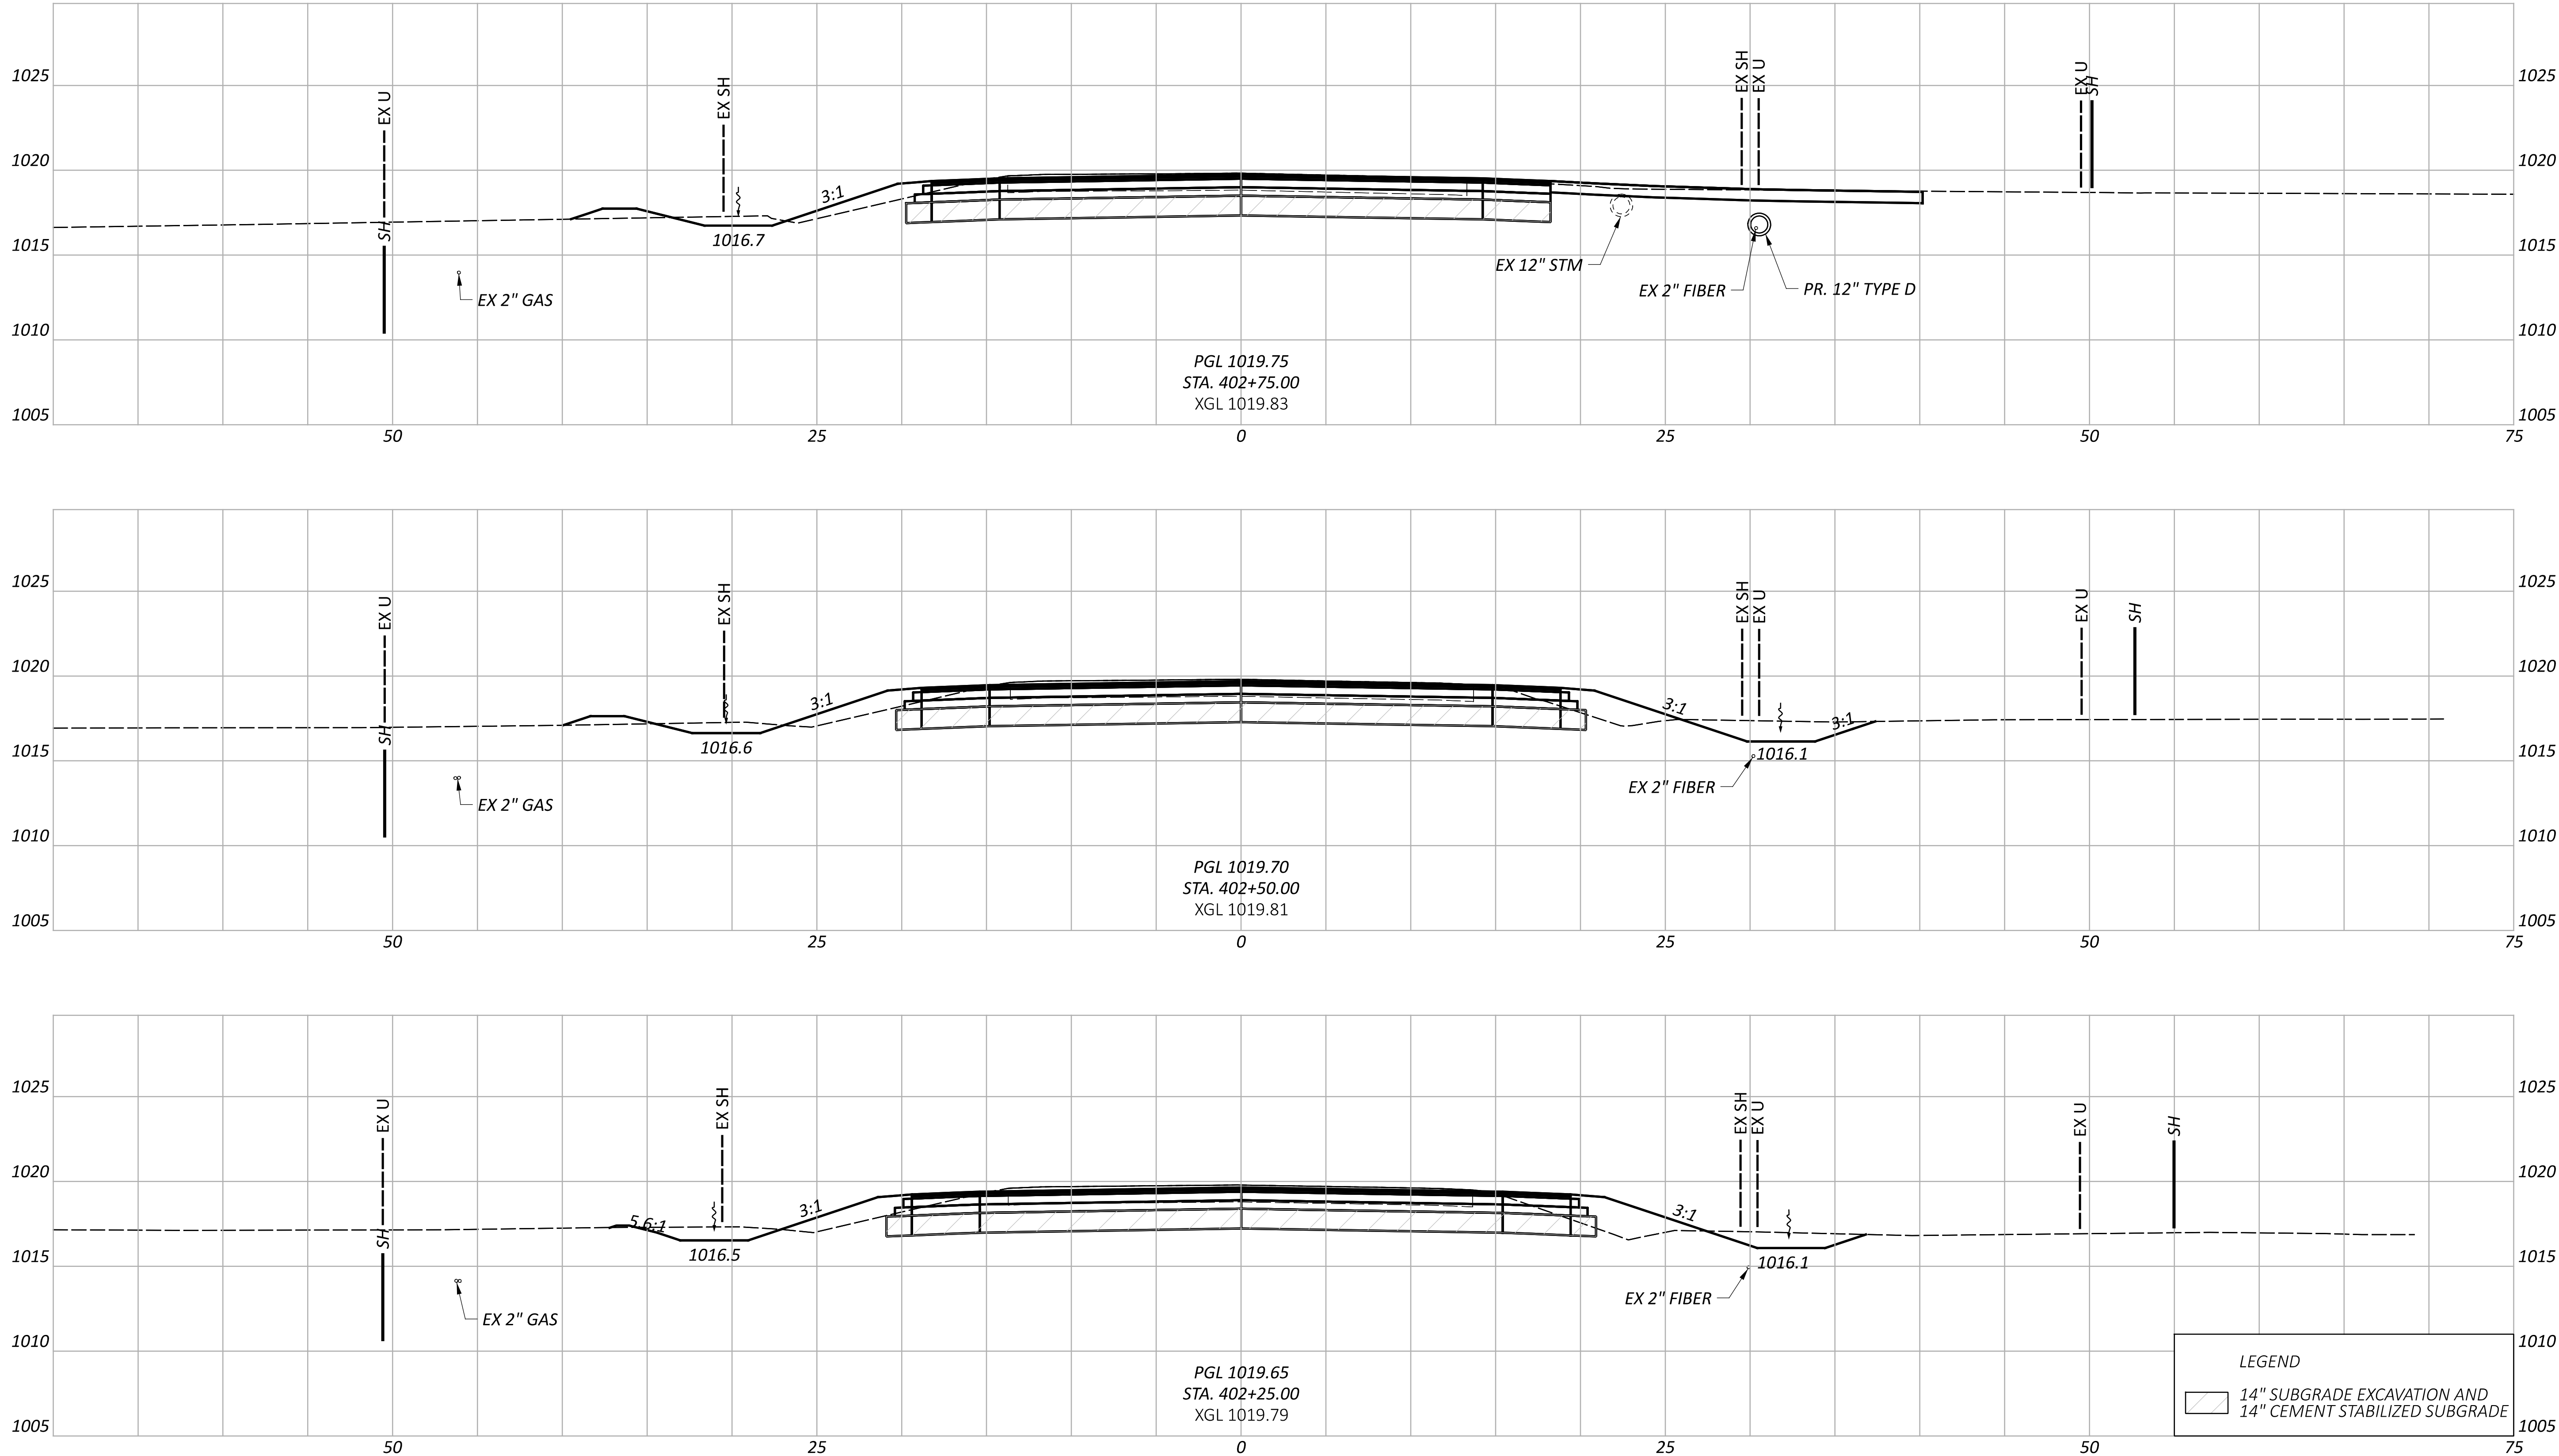

CROSS SECTIONS - NORTH LEG
STA. 402+25 - 402+75

DESIGN AGENCY

AECOM

DESIGNER

VHP

REVIEWER

NSP 07/10/23

PROJECT ID

111621

Sheet Totals

Seeding Cut Fill


. . .

SHEET

P.61


TOTAL


102

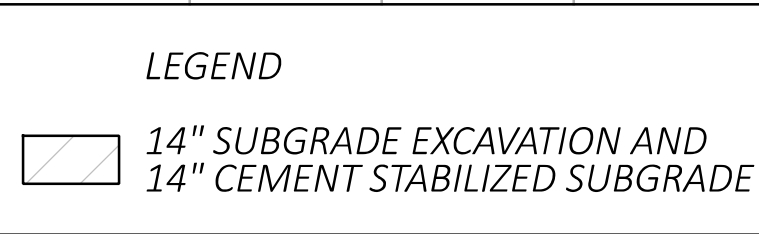

Sheet Totals			111621	
Seeding	Cut	Fill	SHEET	TOTAL
.	.	.	P.62	102

CROSS SECTIONS - NORTH LEG
STA. 403+00 - 403+50

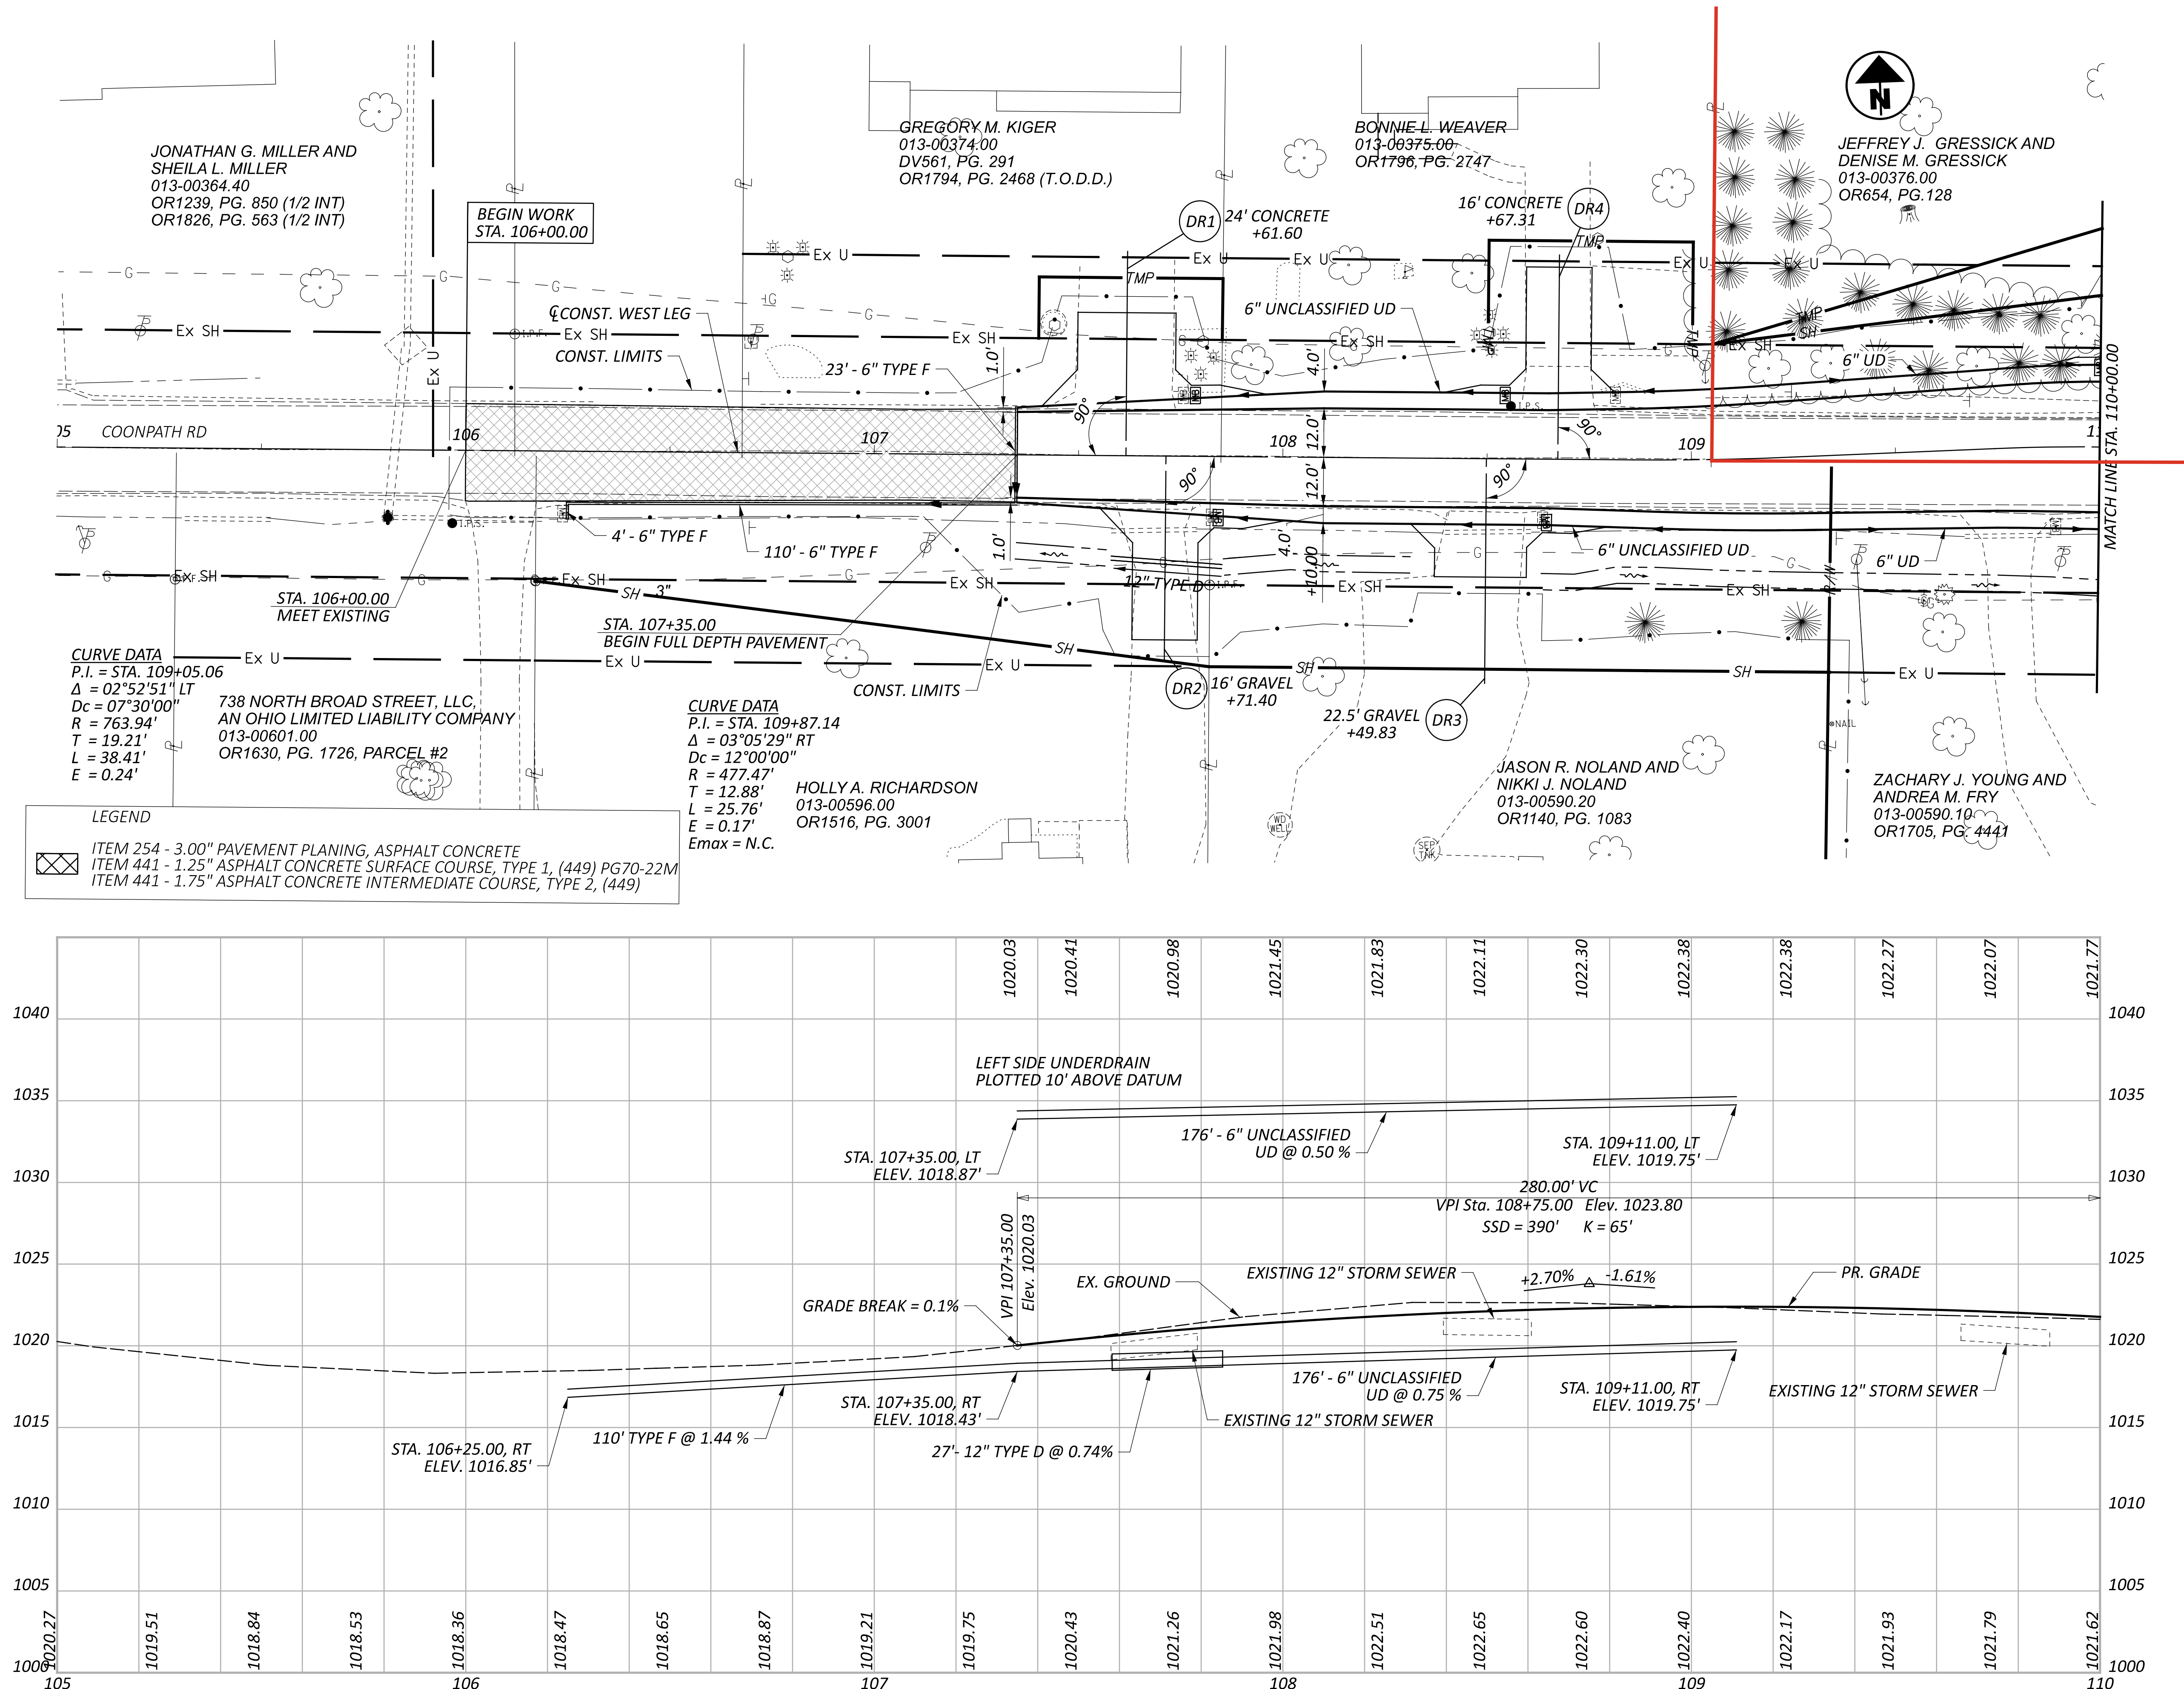

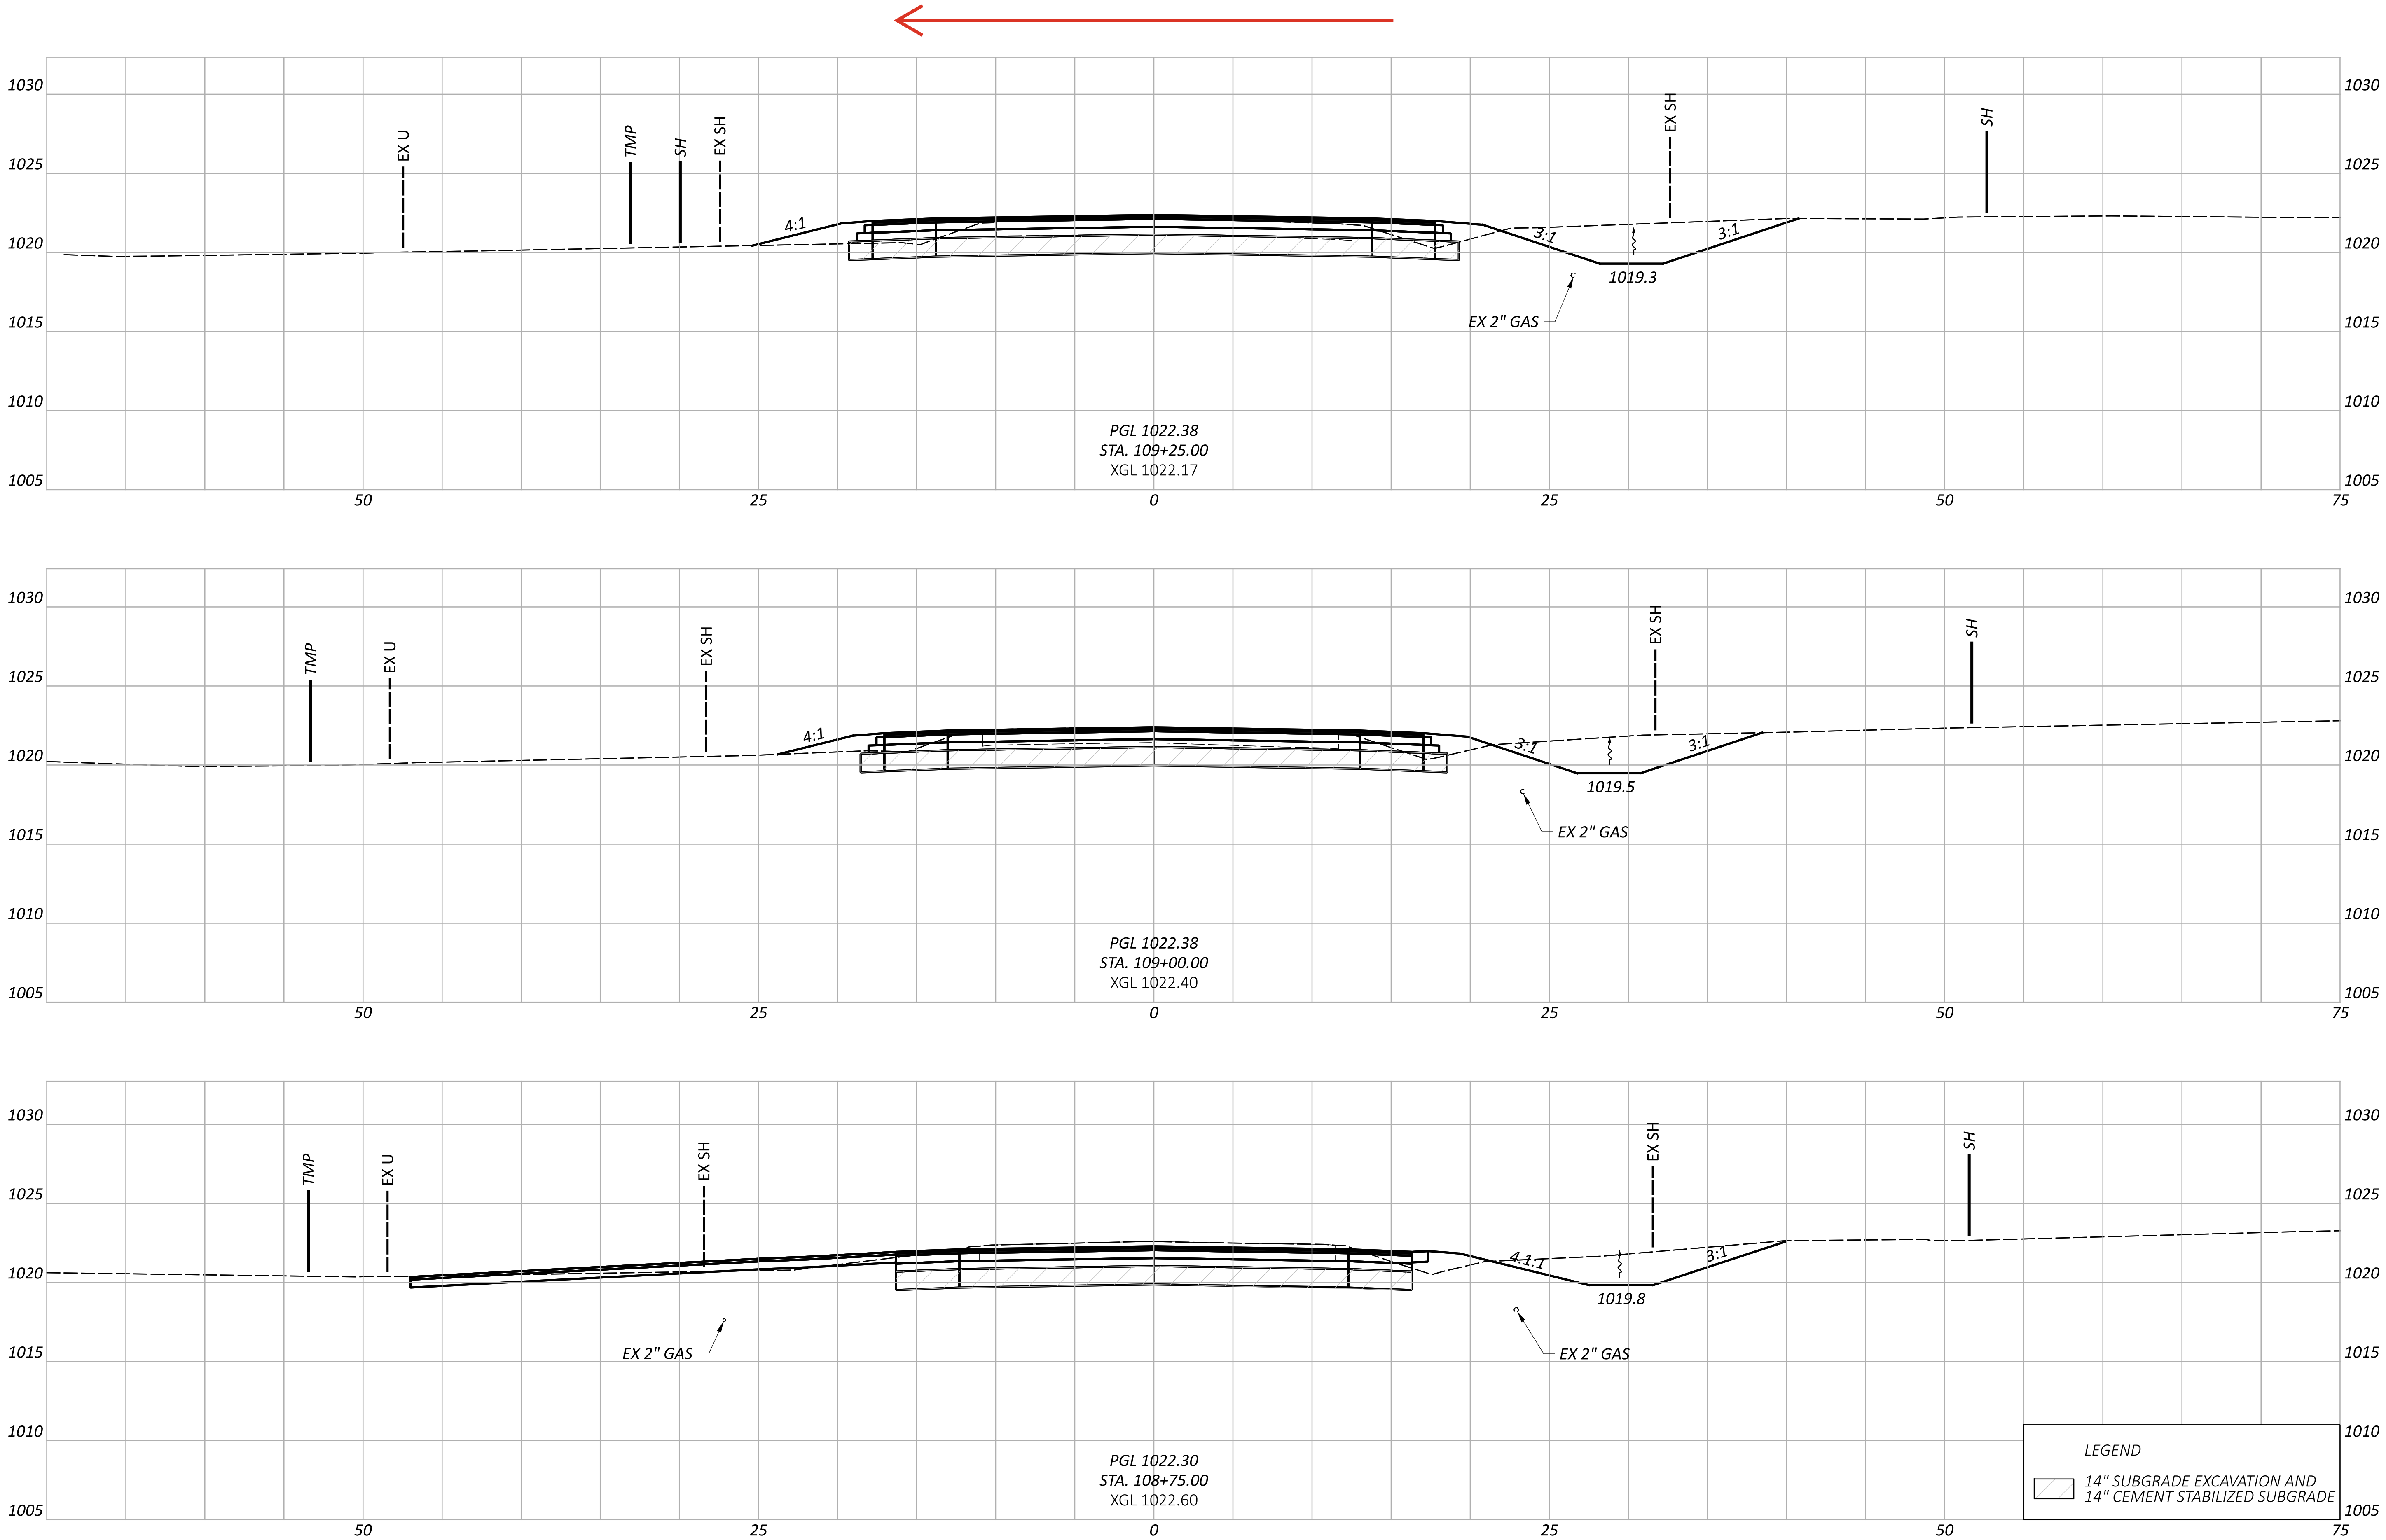

CROSS SECTIONS - WEST LEG
STA. 108+75 - 109+25

DESIGN AGENCY

AECOM

DESIGNER

VHP

REVIEWER

NSP 07/10/23

PROJECT ID

111621




Sheet Totals

Seeding Cut Fill

. . .

SHEET TOTAL

P.67 102

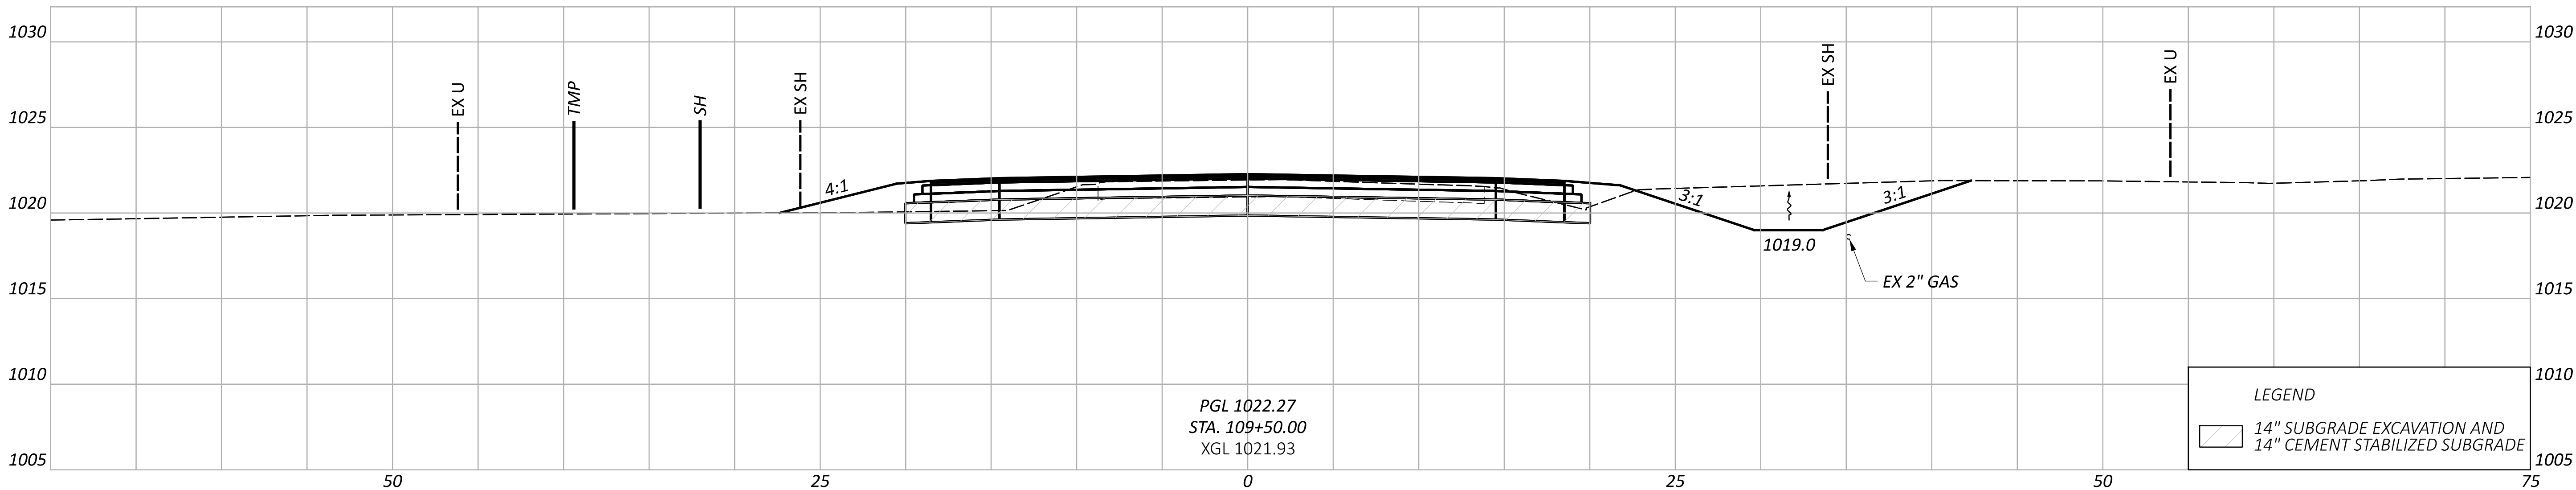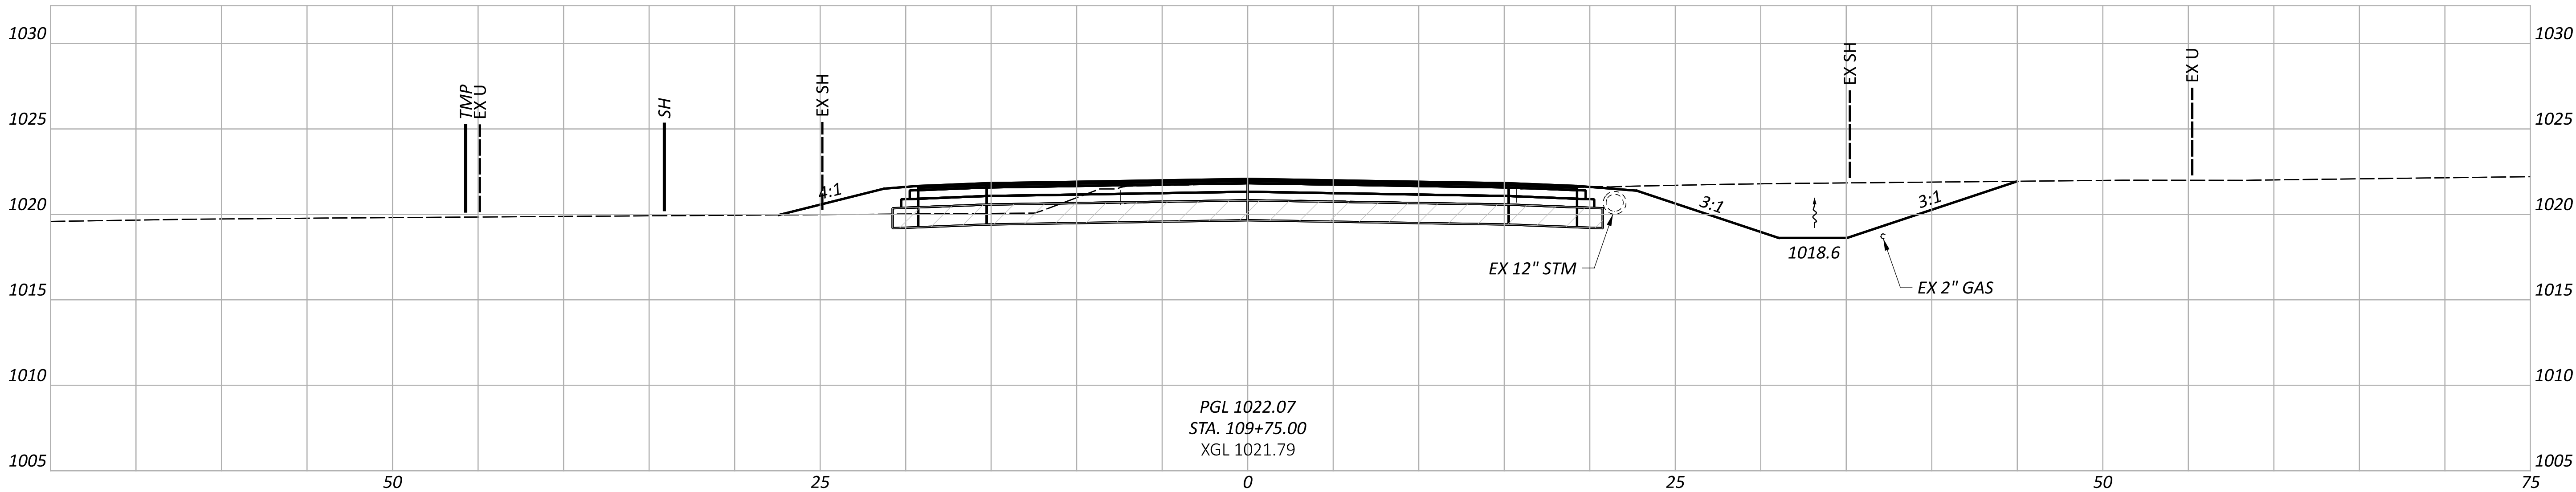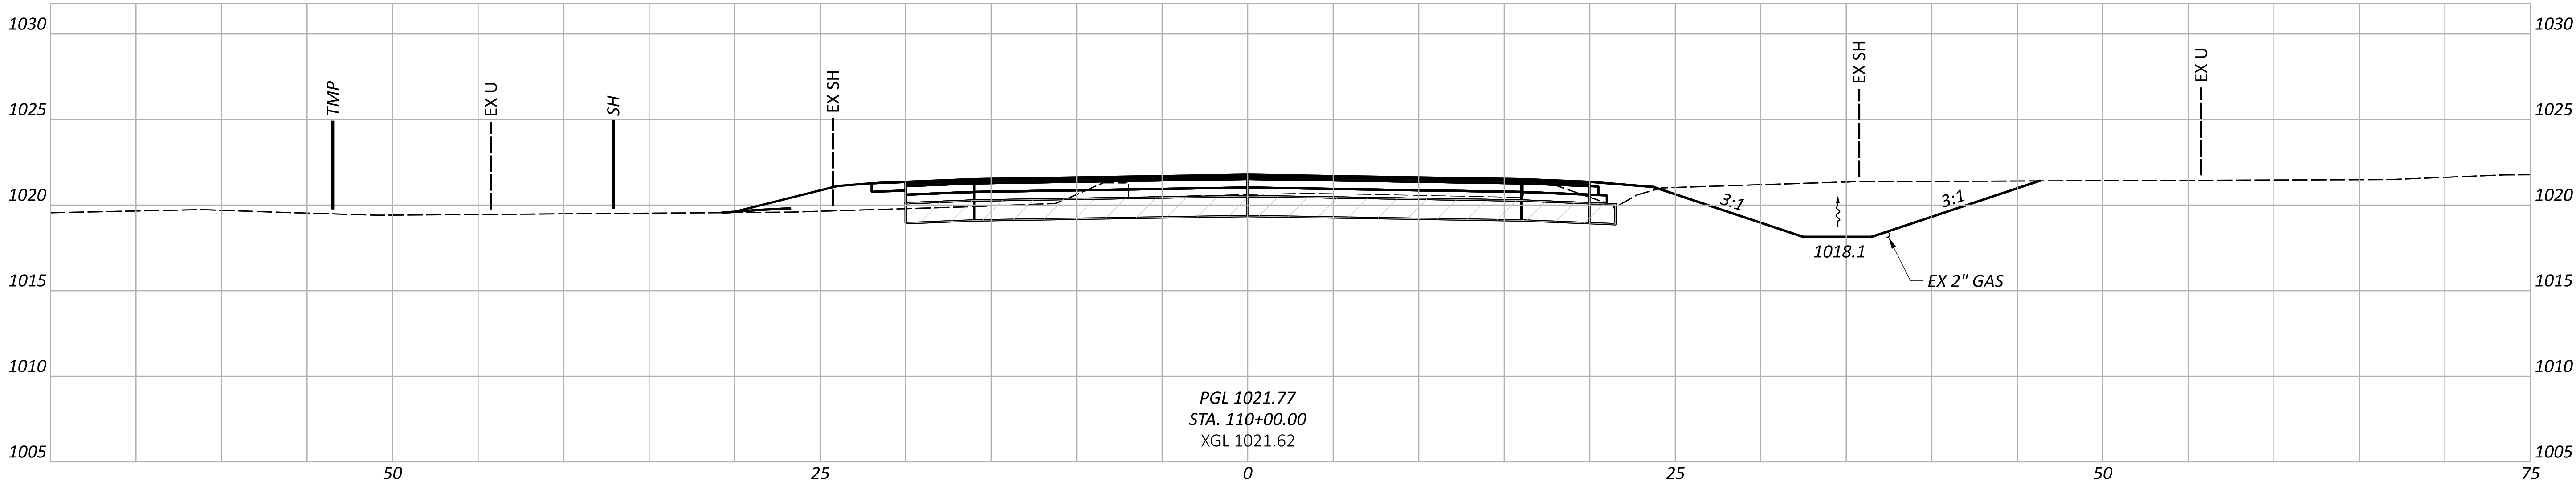

LEGEND

14" SUBGRADE EXCAVATION AND
14" CEMENT STABILIZED SUBGRADE

Sheet Totals			SHEET	TOTAL
Seeding	Cut	Fill		
.	.	.	P.68	102

CROSS SECTIONS - WEST LEG
STA. 109+50 - 110+00

DESIGN AGENCY

AECOM

DESIGNER


VHP

REVIEWER

NSP 07/10/23

PROJECT ID

111621

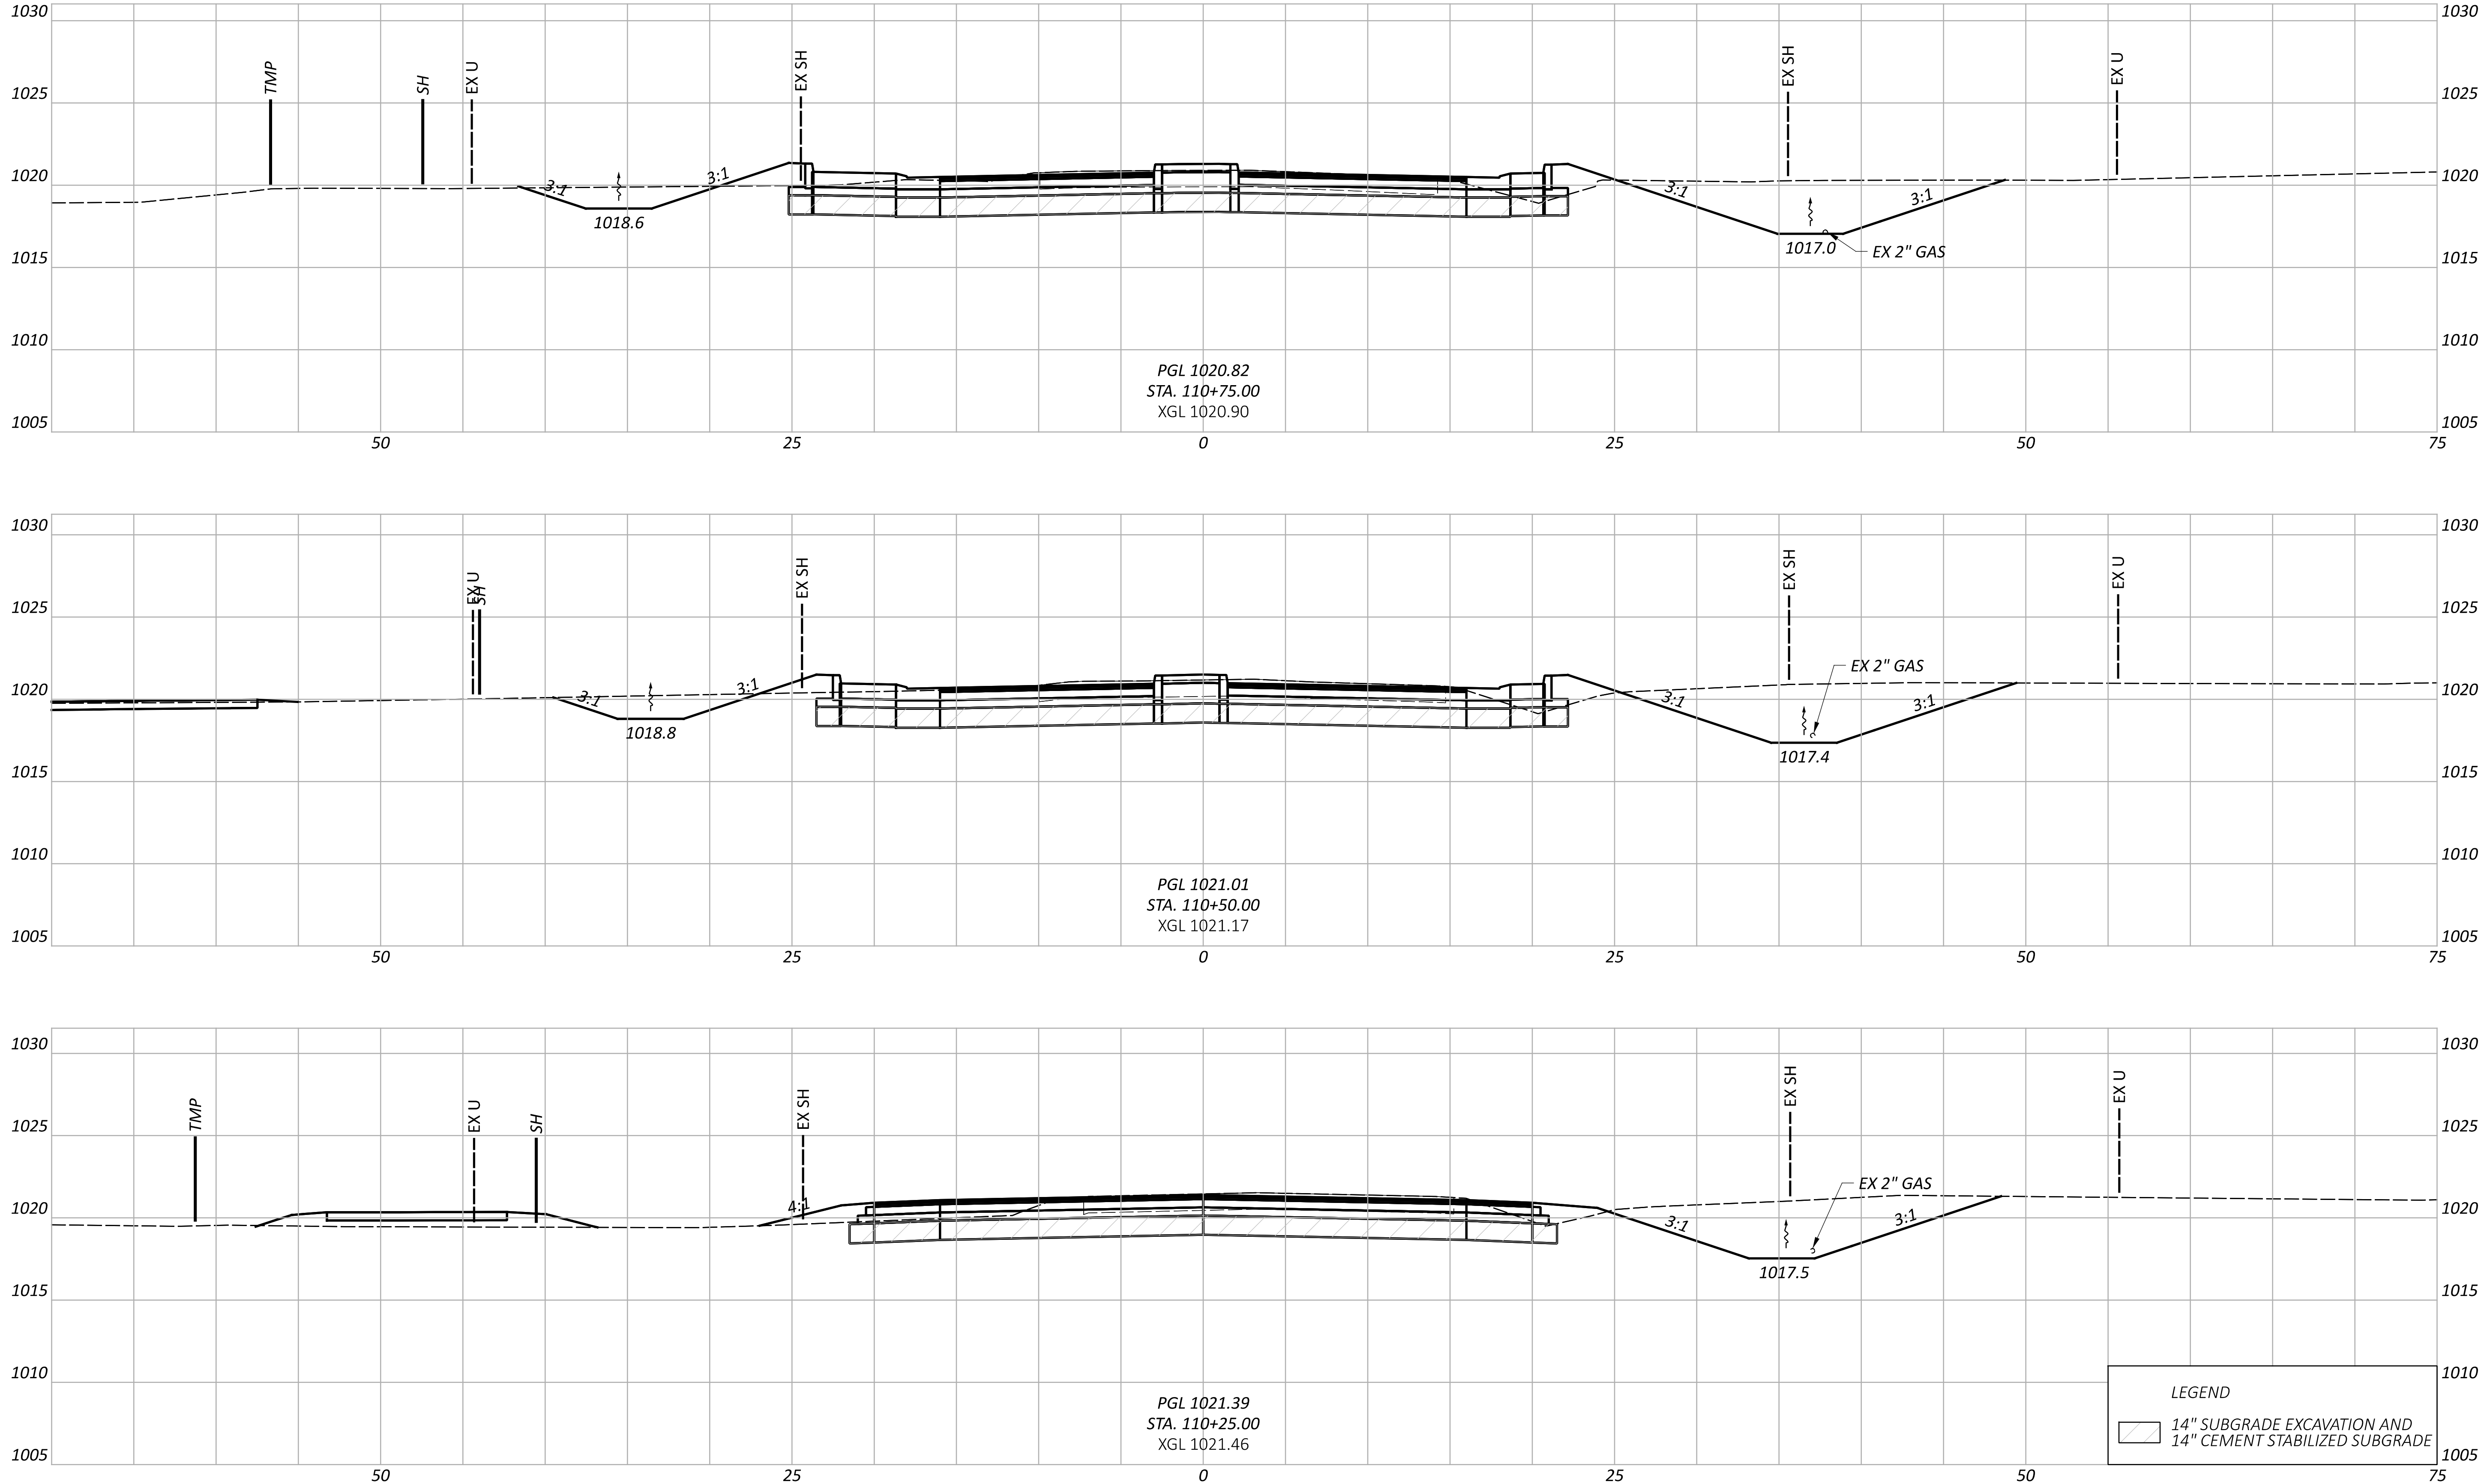


LEGEND

14" SUBGRADE EXCAVATION AND 14" CEMENT STABILIZED SUBGRADE

Sheet Totals			SHEET	TOTAL
Seeding	Cut	Fill		
.	.	.	P.69	102



CROSS SECTIONS - WEST LEG
STA. 110+25 - 110+75

DESIGN AGENCY
AECOM
DESIGNER
VHP
REVIEWER
NSP 07/10/23
PROJECT ID
111621

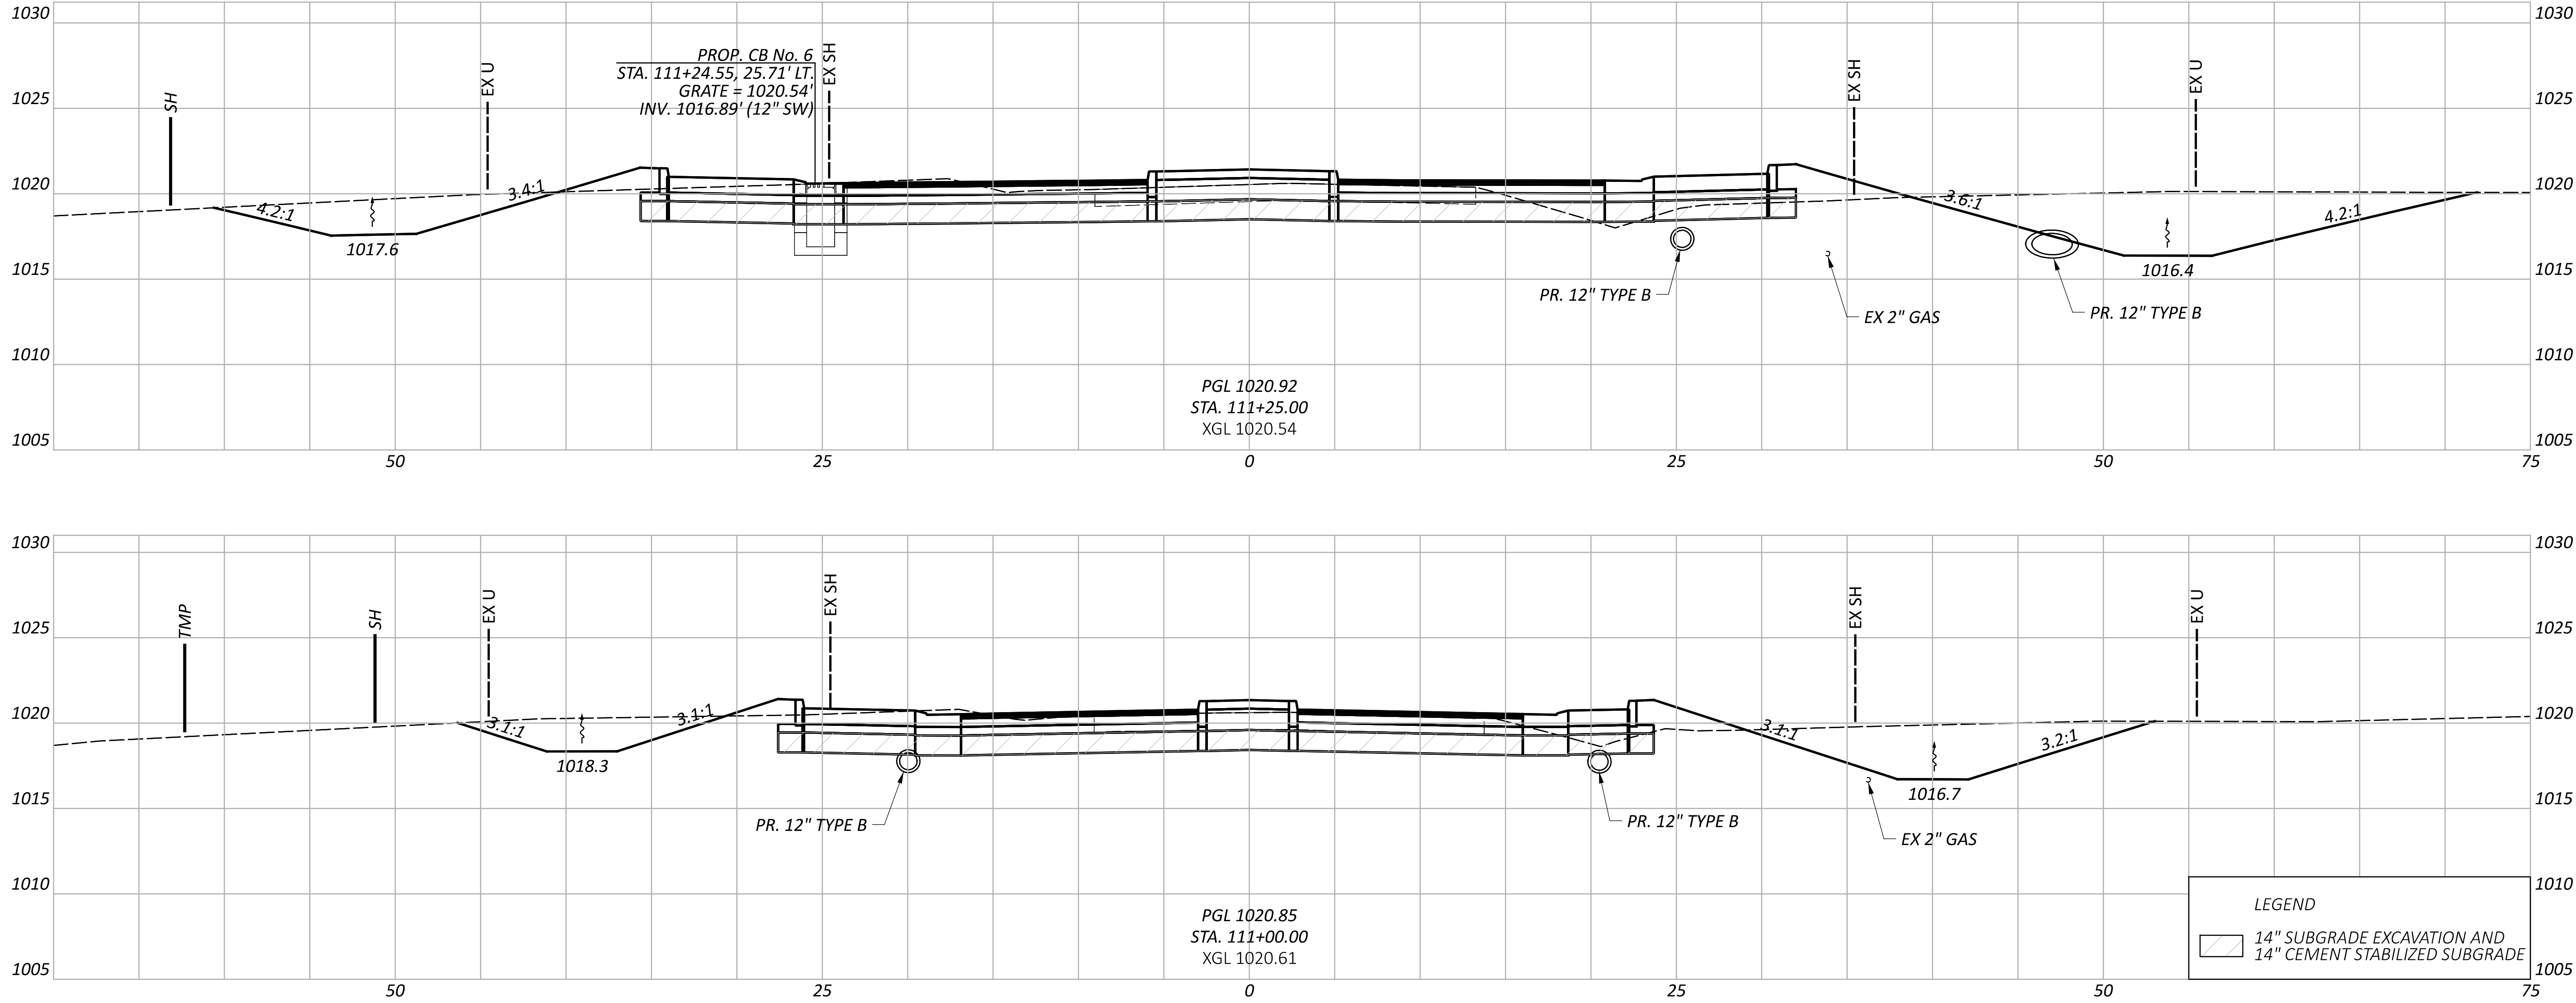

CROSS SECTIONS - WEST LEG
STA. 111+00 - 111+25

DESIGN AGENCY	
AECOM	
DESIGNER	
VHP	
REVIEWER	
NSP 07/10/23	
PROJECT ID	
111621	
SHEET	TOTAL
P.70	102

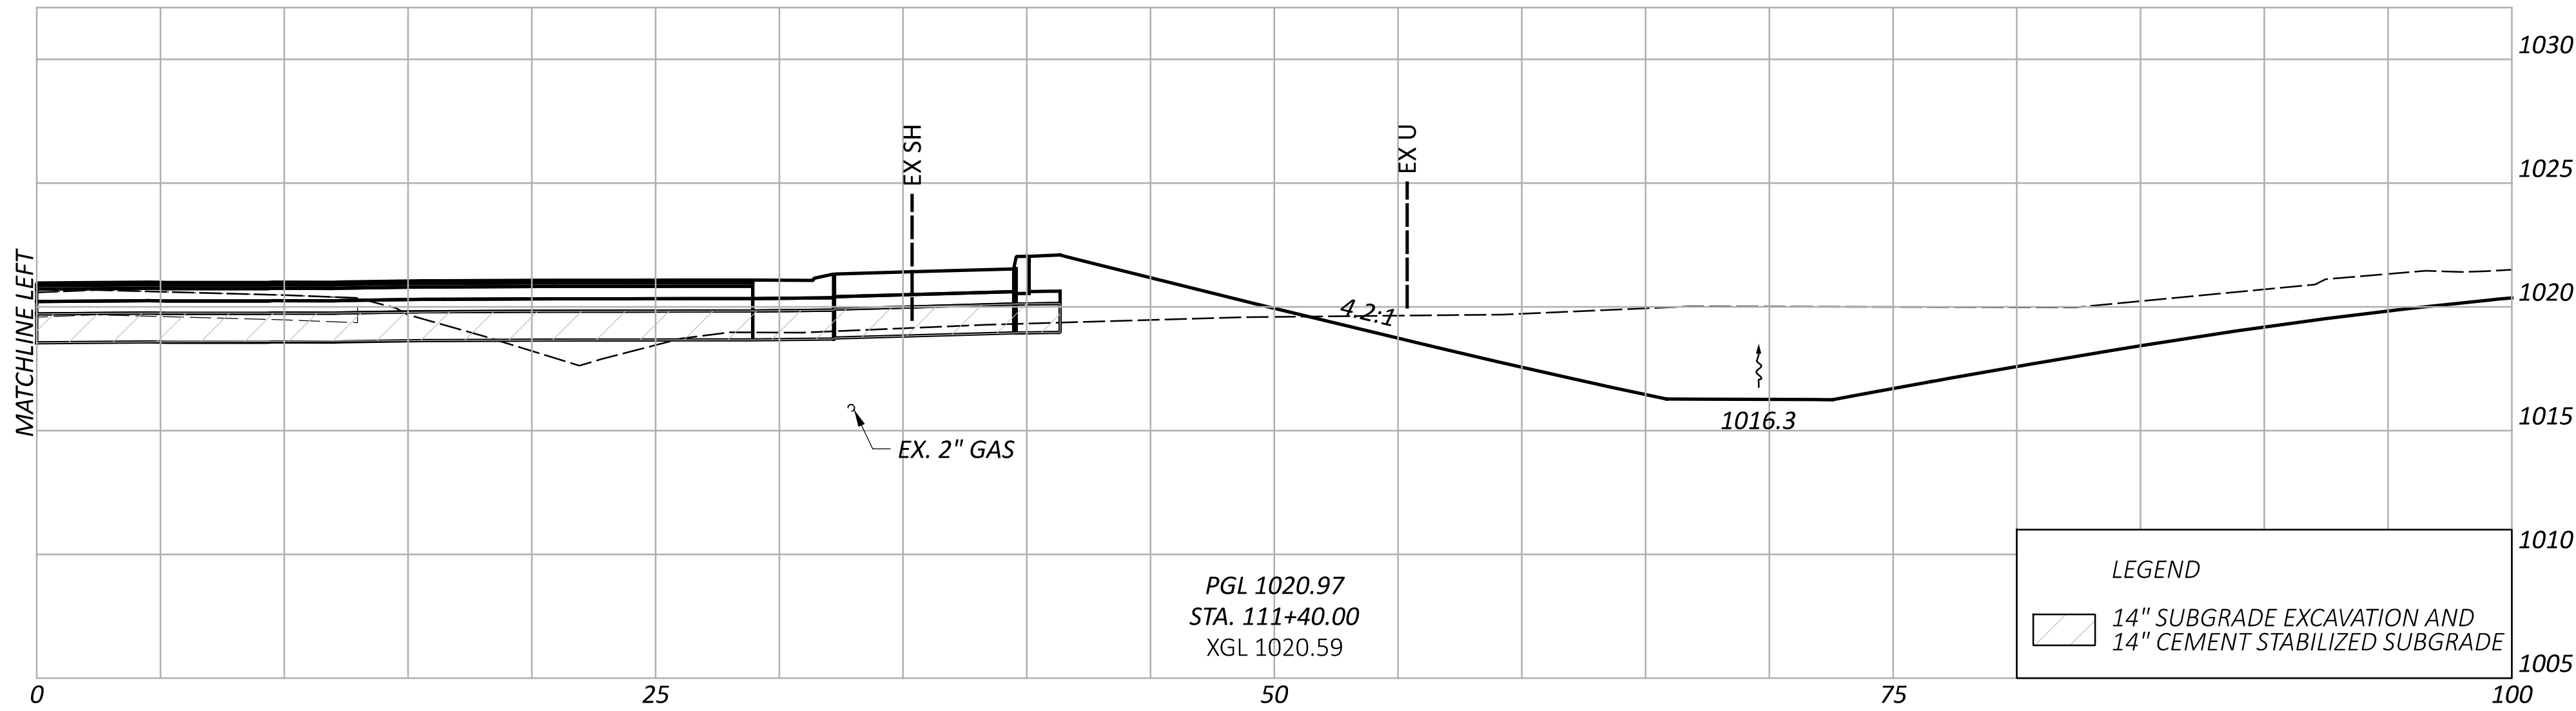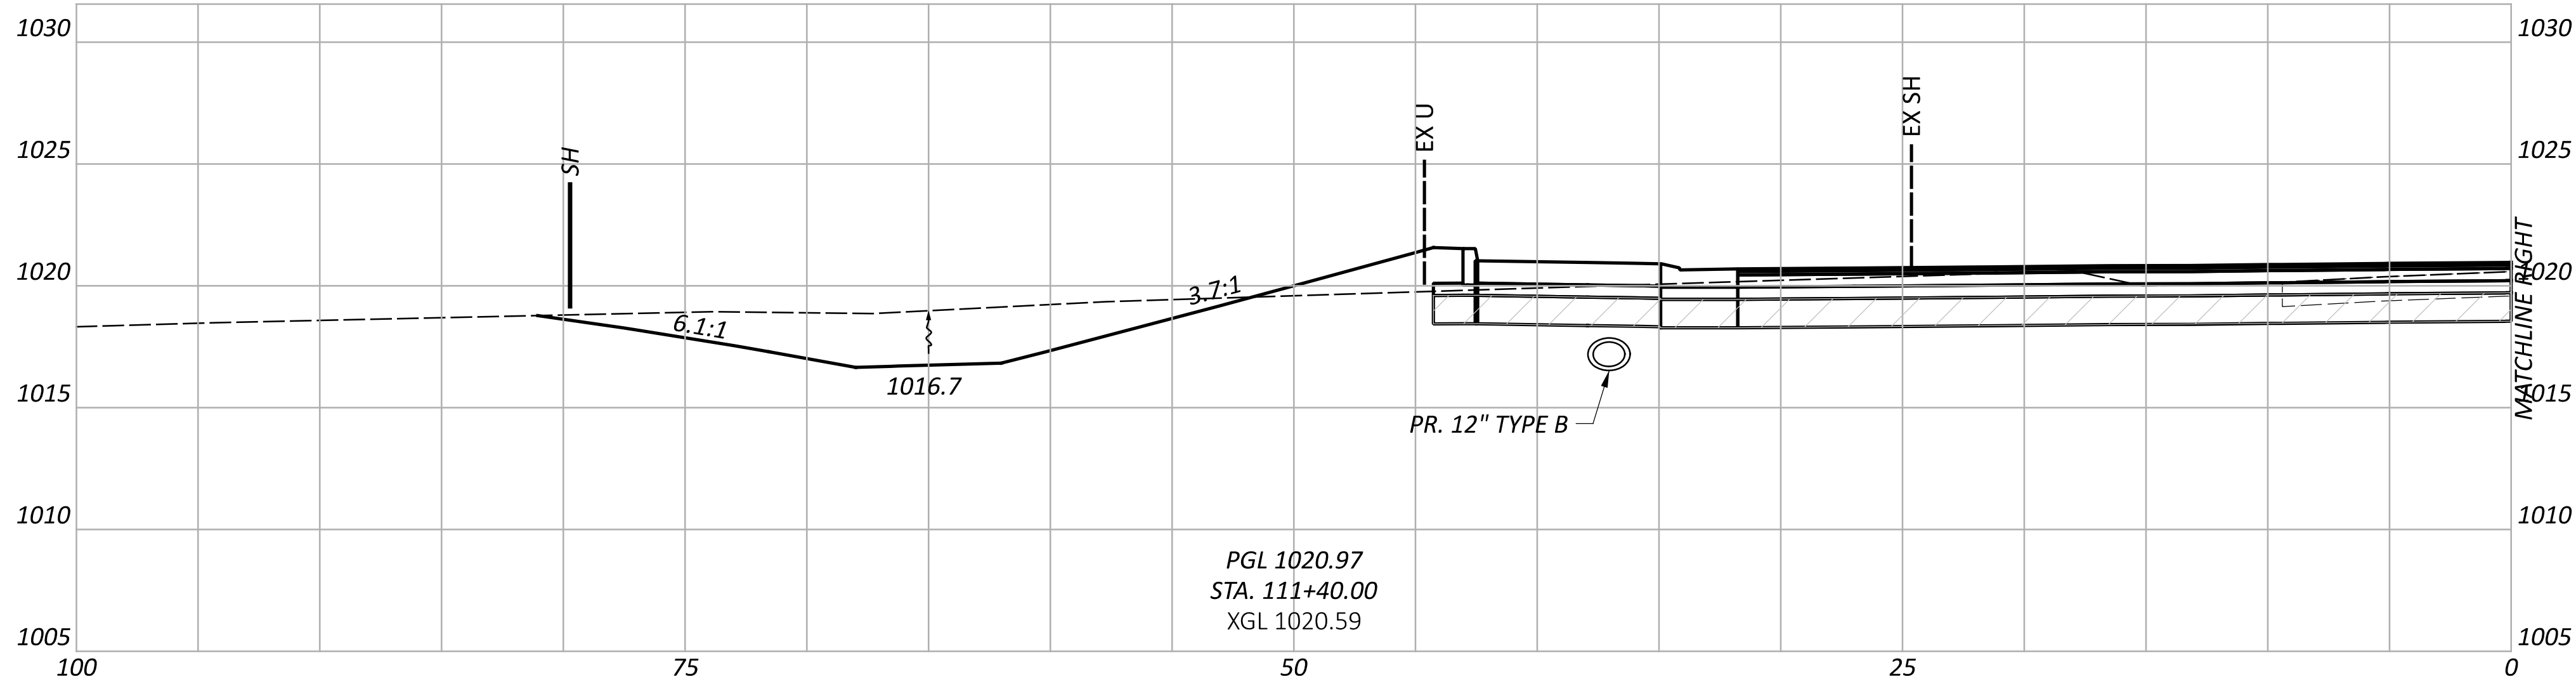

LEGEND


14" SUBGRADE EXCAVATION AND
14" CEMENT STABILIZED SUBGRADE

CROSS SECTIONS - WEST LEG
STA. 111+40


DESIGN AGENCY	
AECOM	
DESIGNER	
VHP	
REVIEWER	
NSP 07/10/23	
PROJECT ID	
111621	
SHEET TOTAL	
P.71	102

Sheet Totals		
Seeding	Cut	Fill


- LEGEND**
- 1 ITEM 204 - SUBGRADE COMPACTION
 - 2 ITEM 304 - AGGREGATE BASE [T=8" GRAVEL DRIVE, 6" ASPHALT DRIVE]
 - 3 ITEM 441 - ASPHALT CONCRETE SURFACE COURSE, TYPE 1, (449), (DRIVEWAYS) [T=2"]
 - 4 ITEM 452 - 6" NON-REINFORCED CONCRETE PAVEMENT, CLASS QC1P

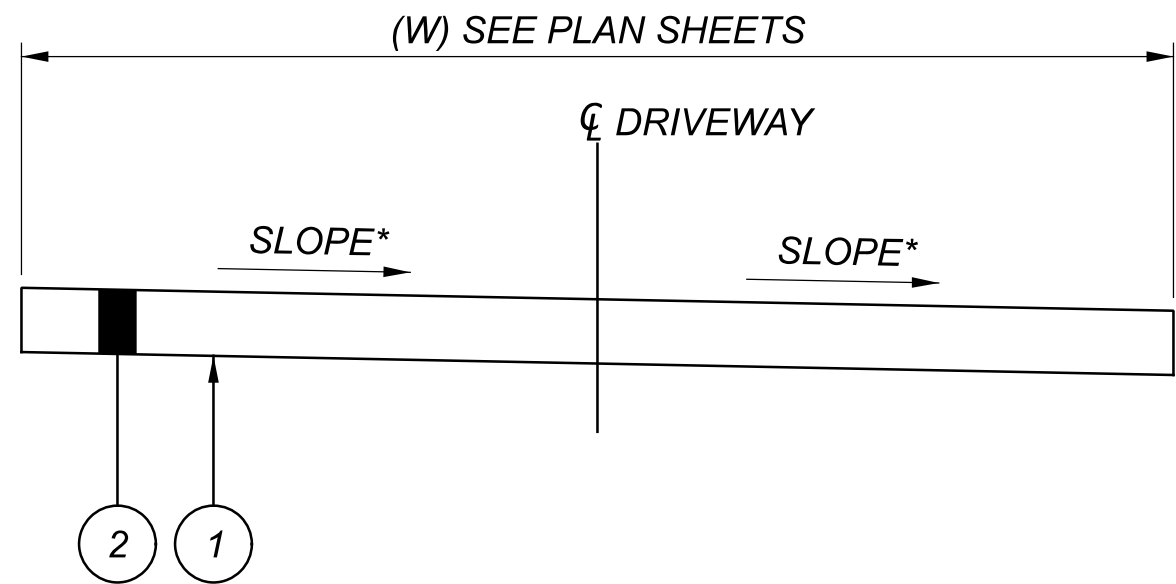

RESIDENTIAL AGGRREGATE DRIVE

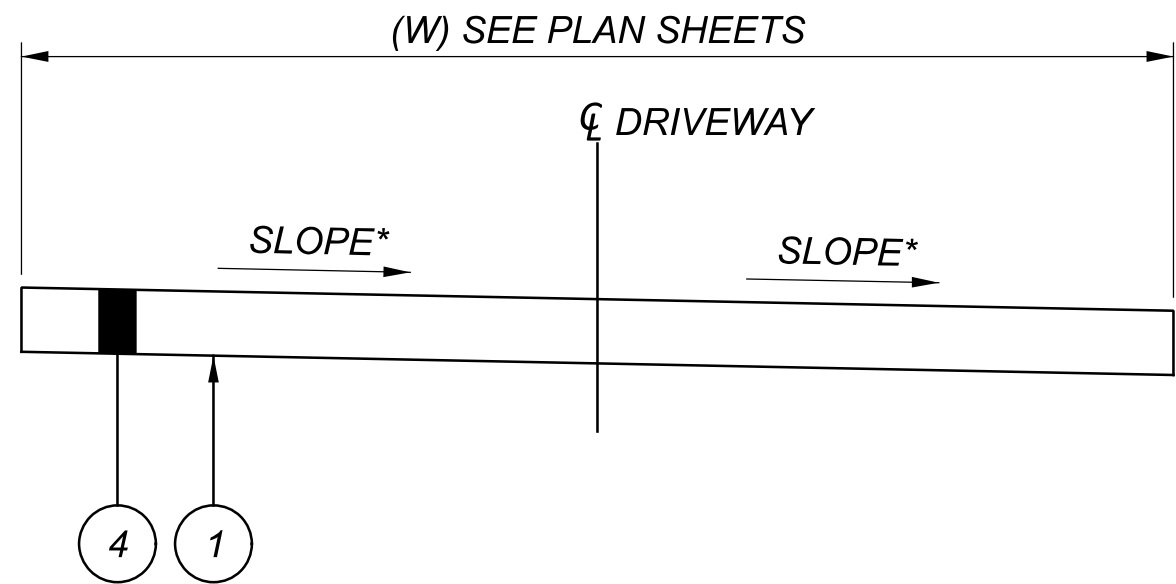


RESIDENTIAL CONCRETE DRIVE

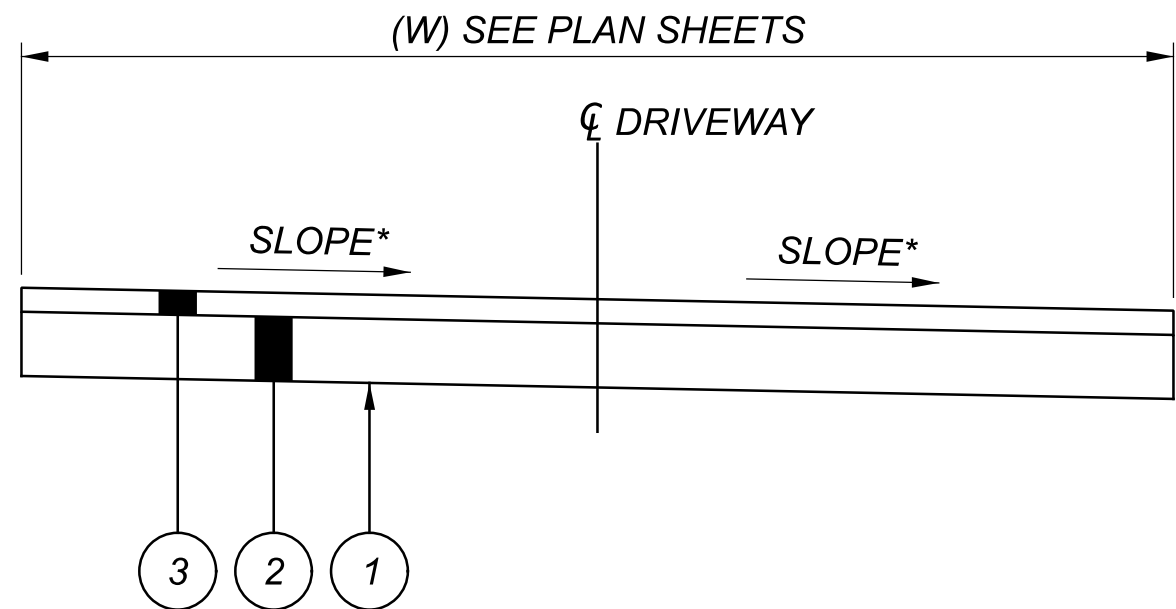


RESIDENTIAL ASPHALT DRIVE


* SLOPE TO MATCH EXISTING OR SLOPED TO THE LOW SIDE AT 0.5% MIN. (PAVED) OR 2% MIN. (AGGREGATE)

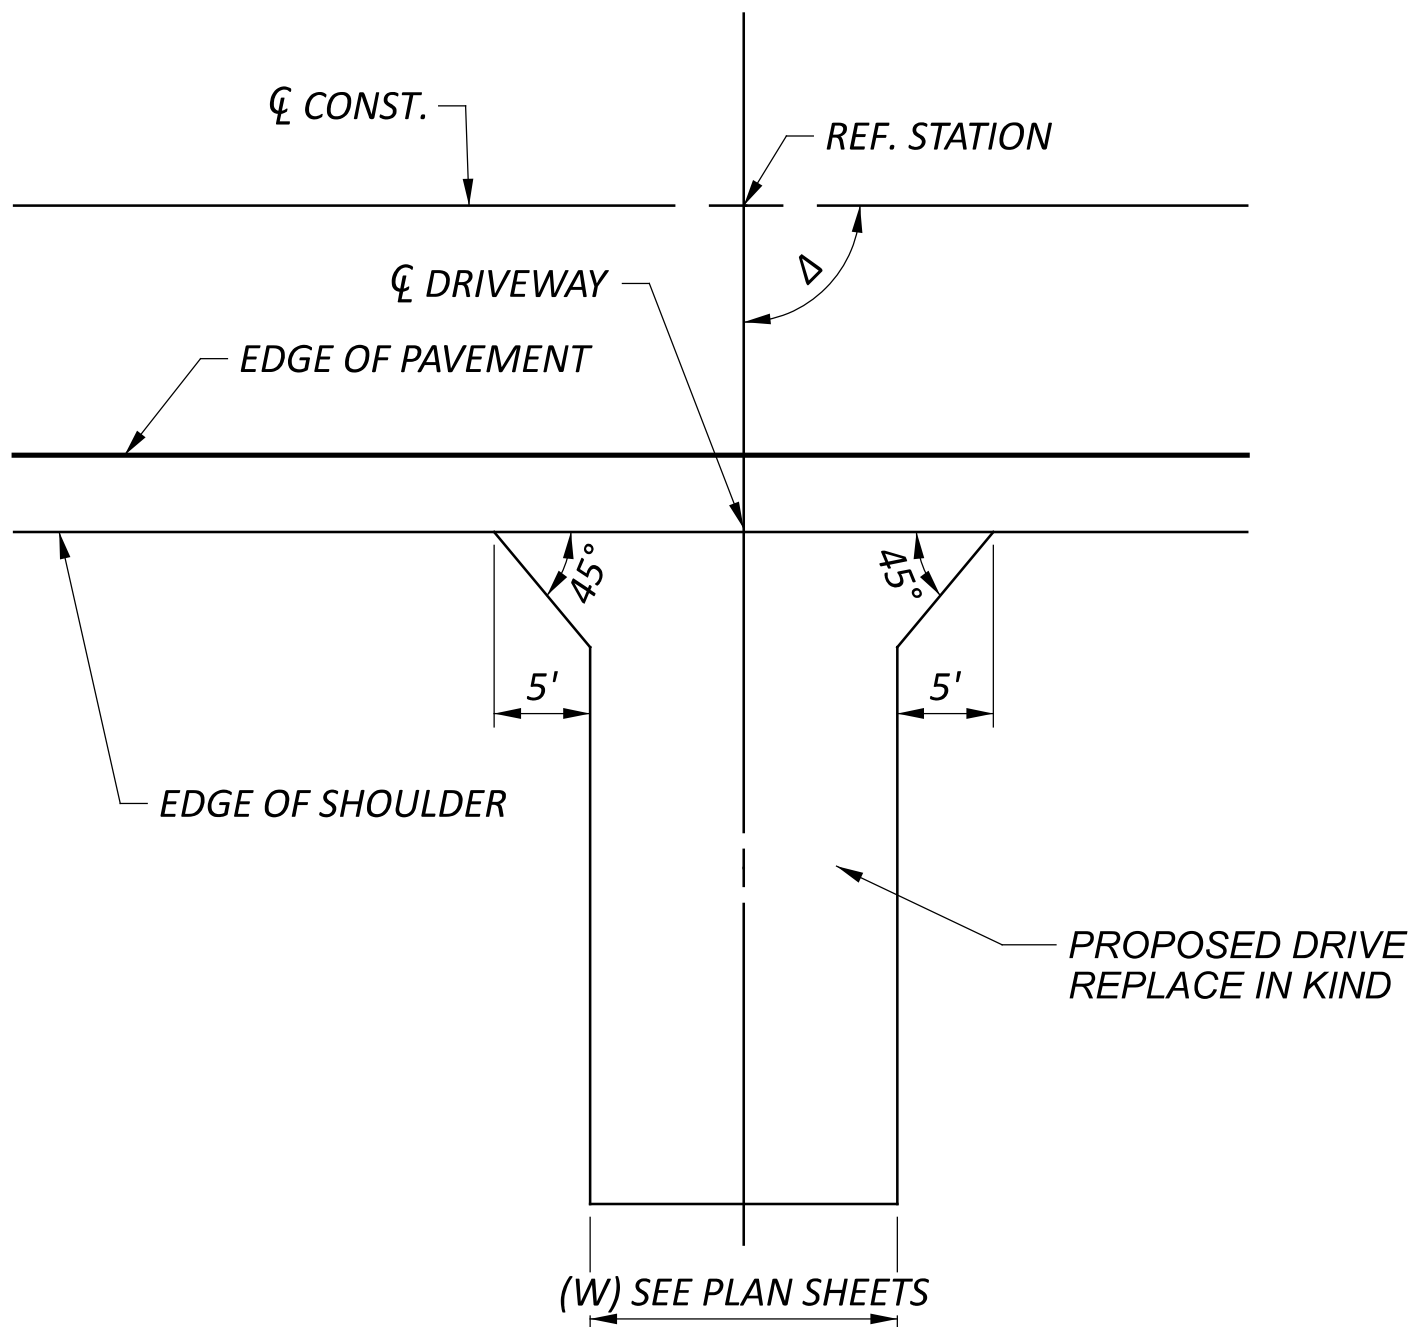







**UNCURBED DRIVEWAY ALONG UNCURBED ROADWAY
NOT TO SCALE**

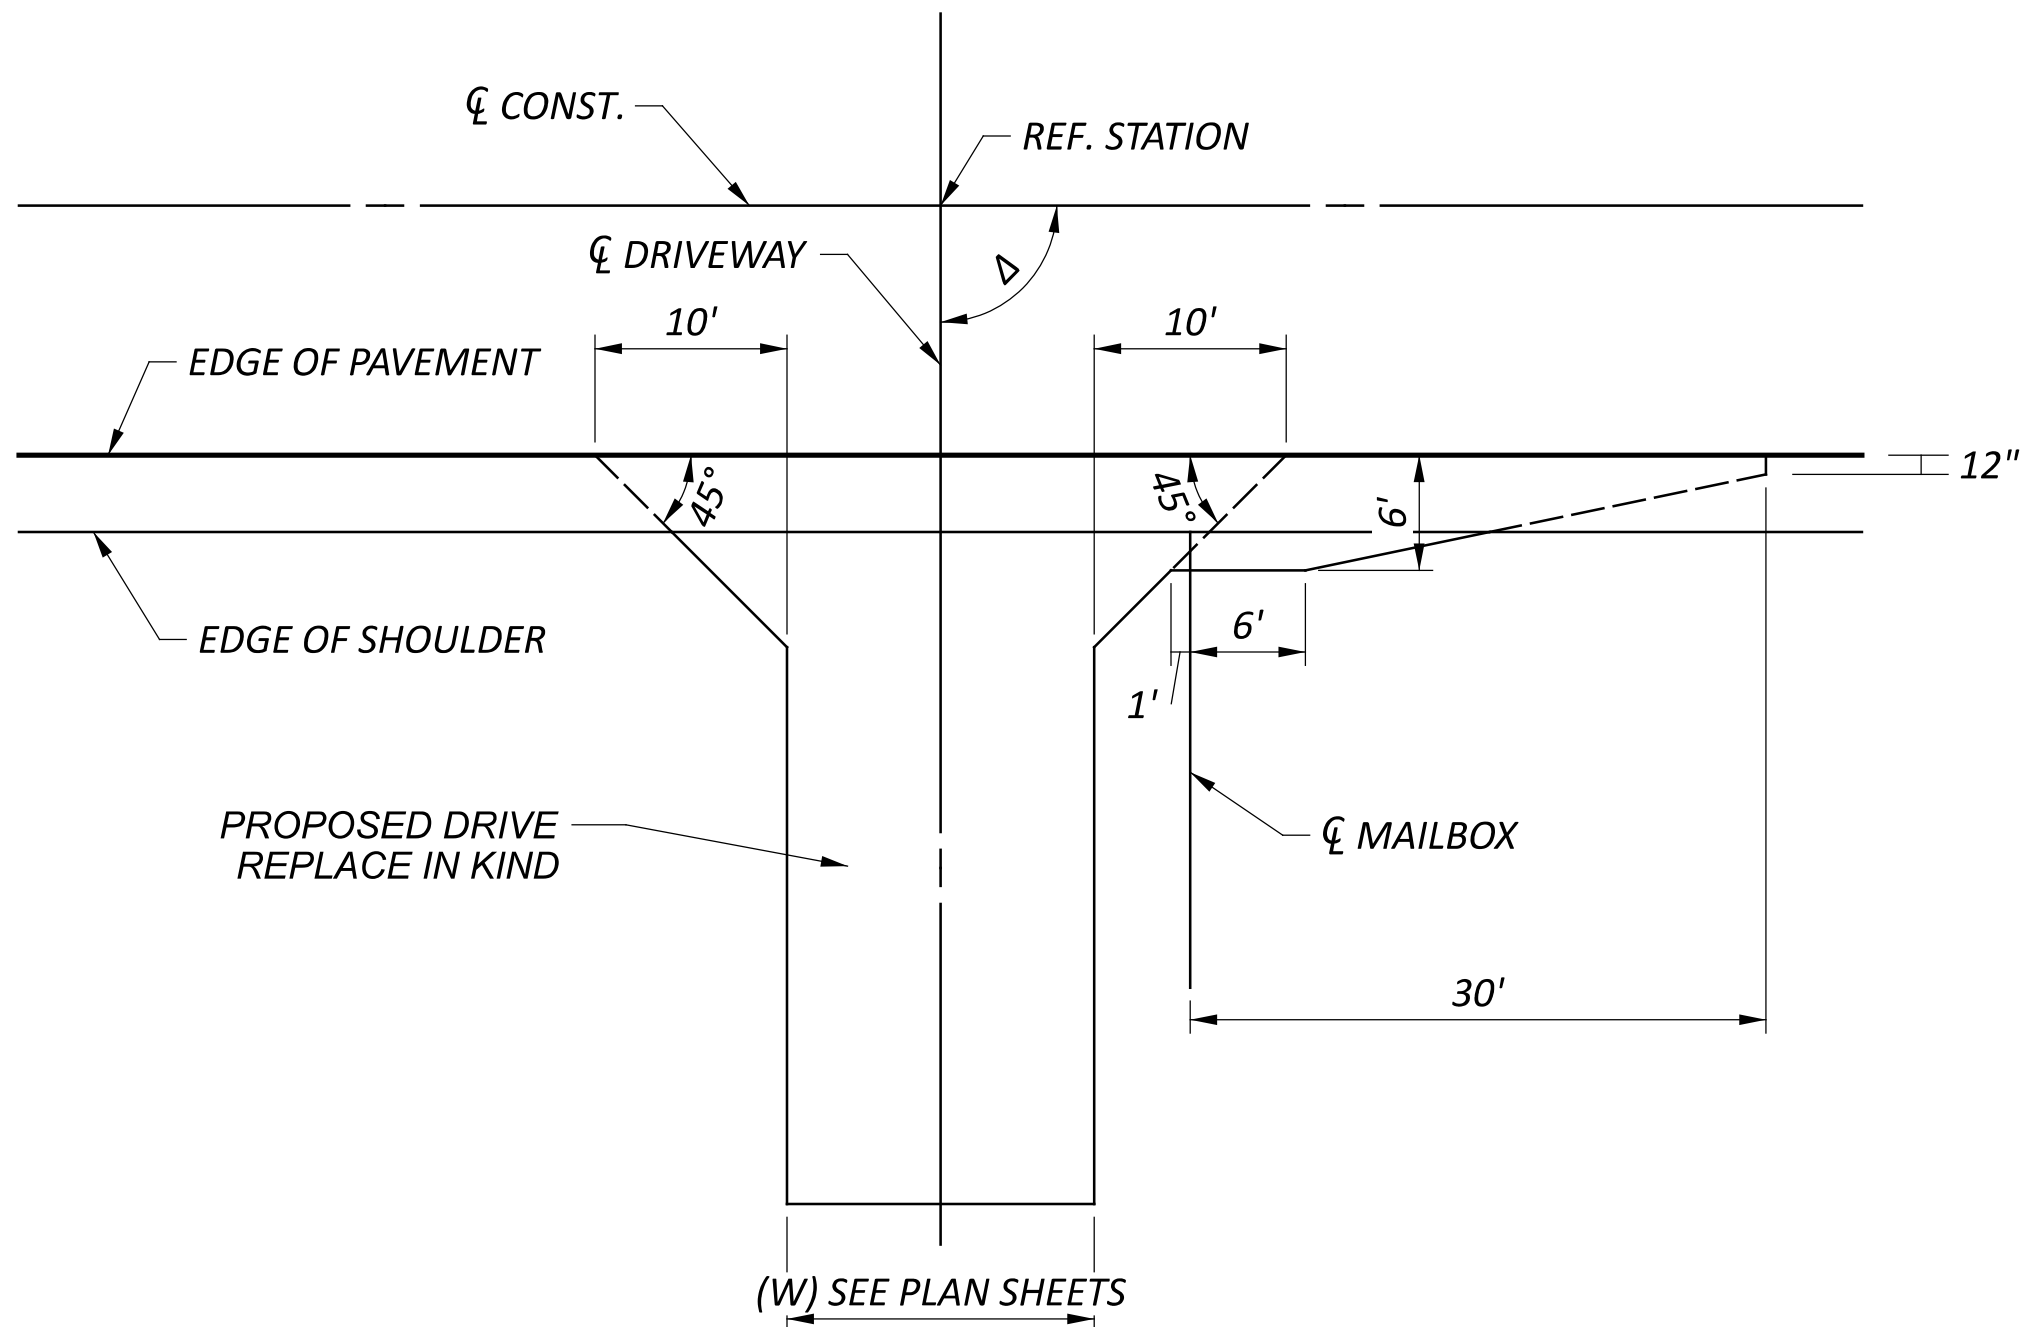

**UNCURBED DRIVEWAY ALONG UNCURBED ROADWAY
WITH MAILBOX APPROACH
NOT TO SCALE**

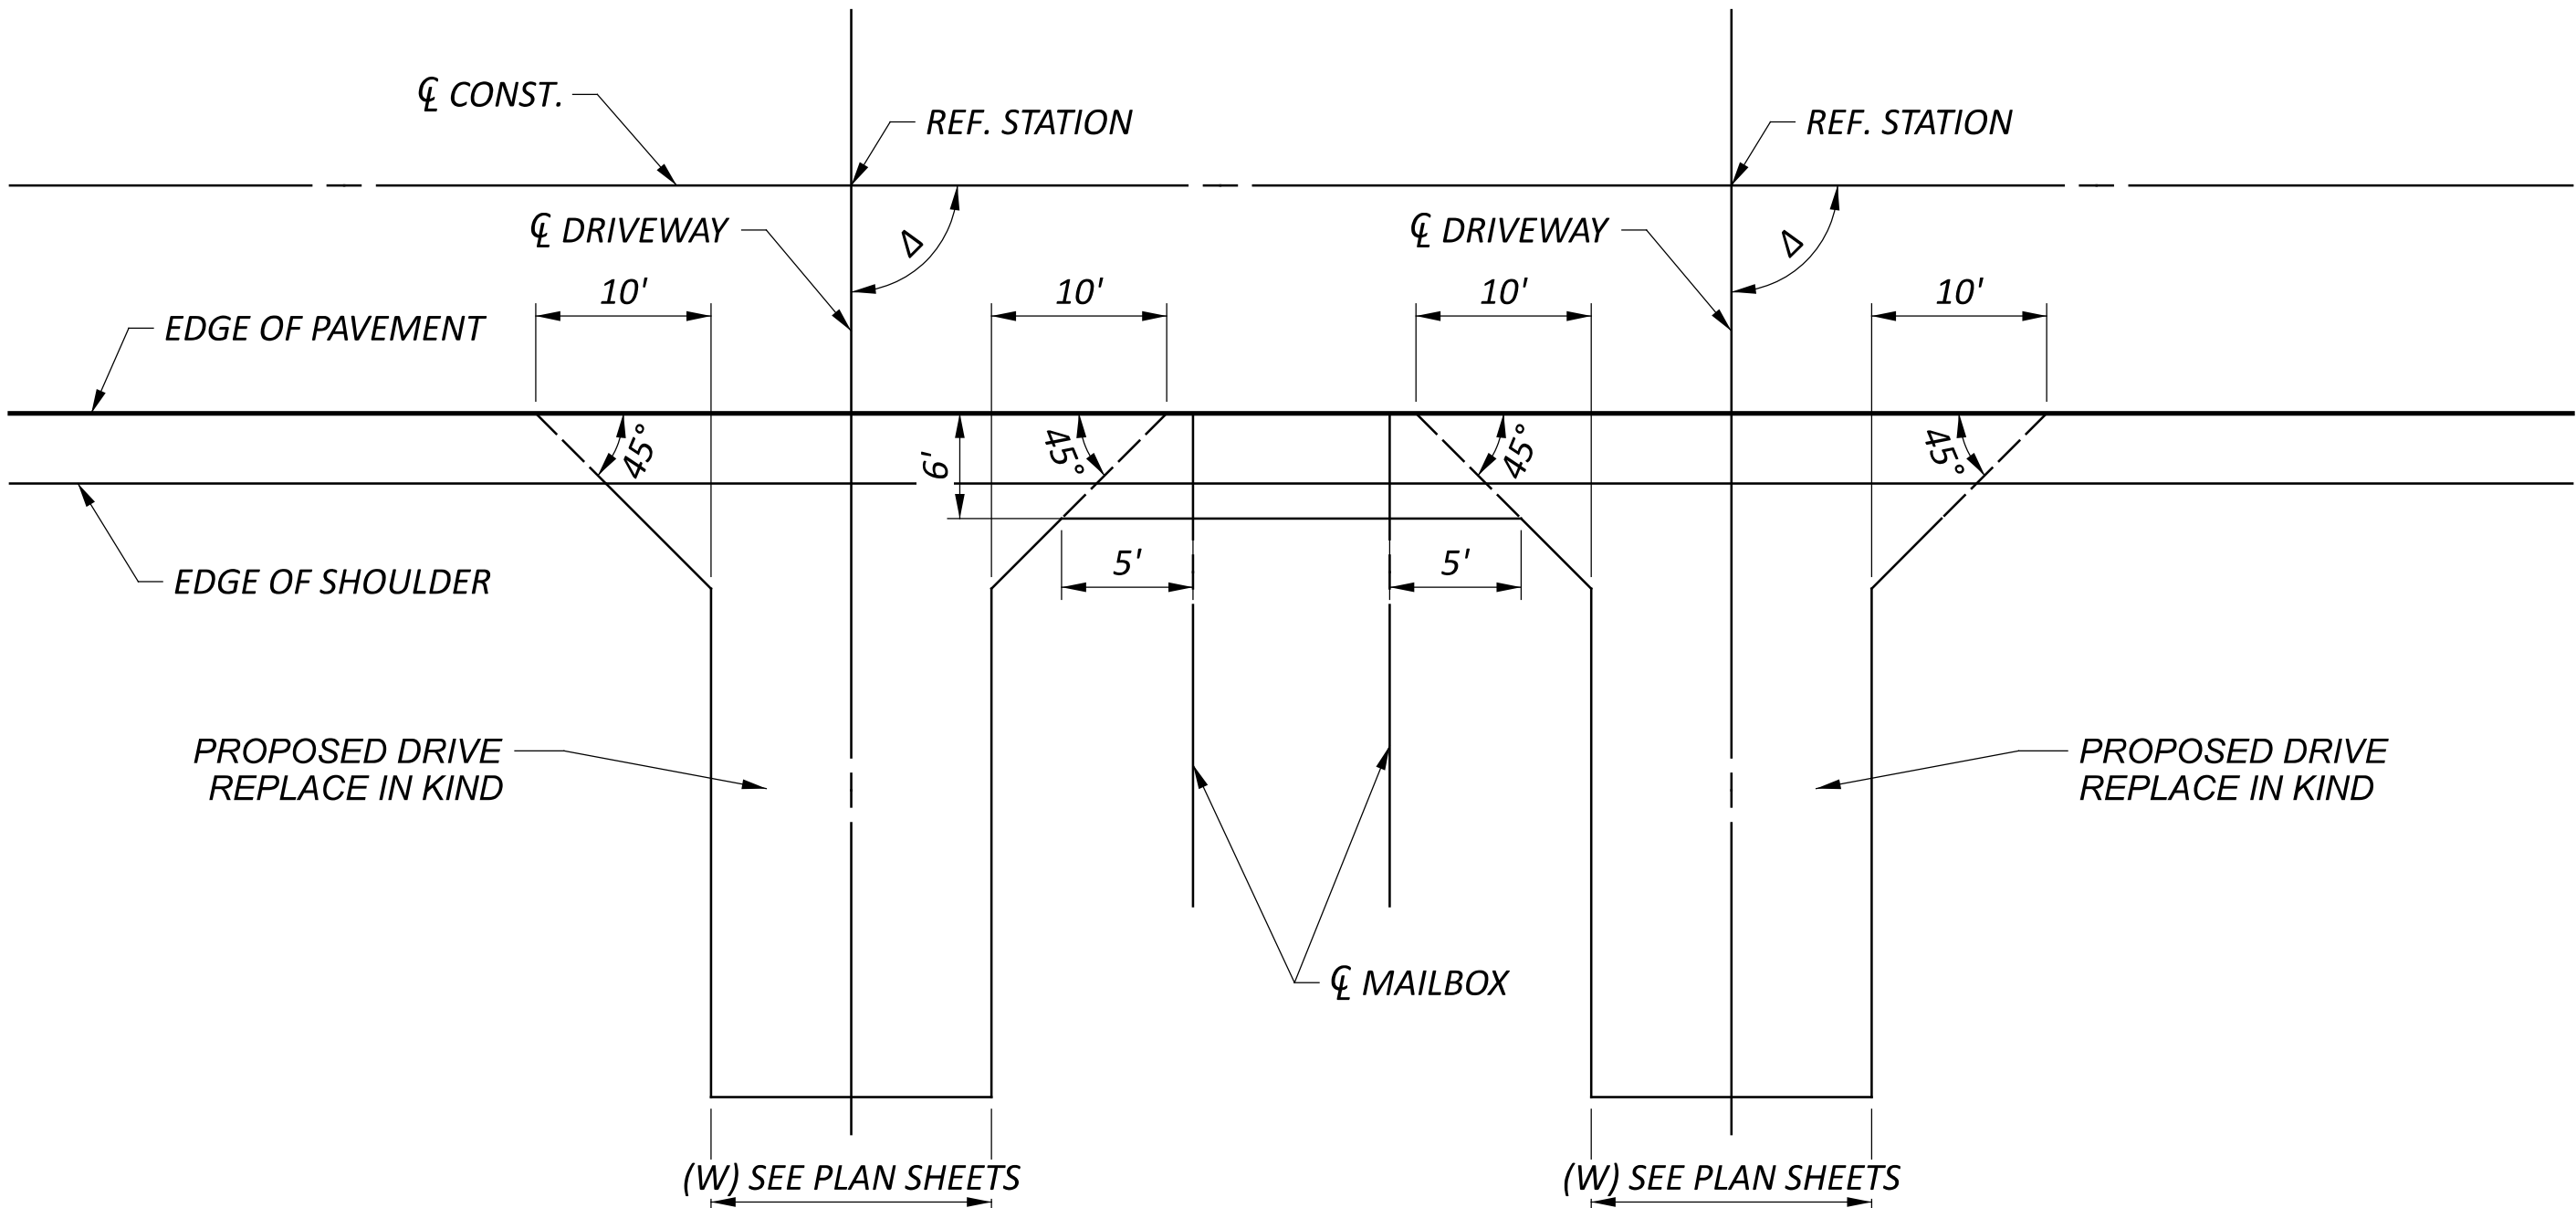

**UNCURBED DRIVEWAY ALONG UNCURBED ROADWAY
WITH DOUBLE MAILBOX APPROACH
NOT TO SCALE**

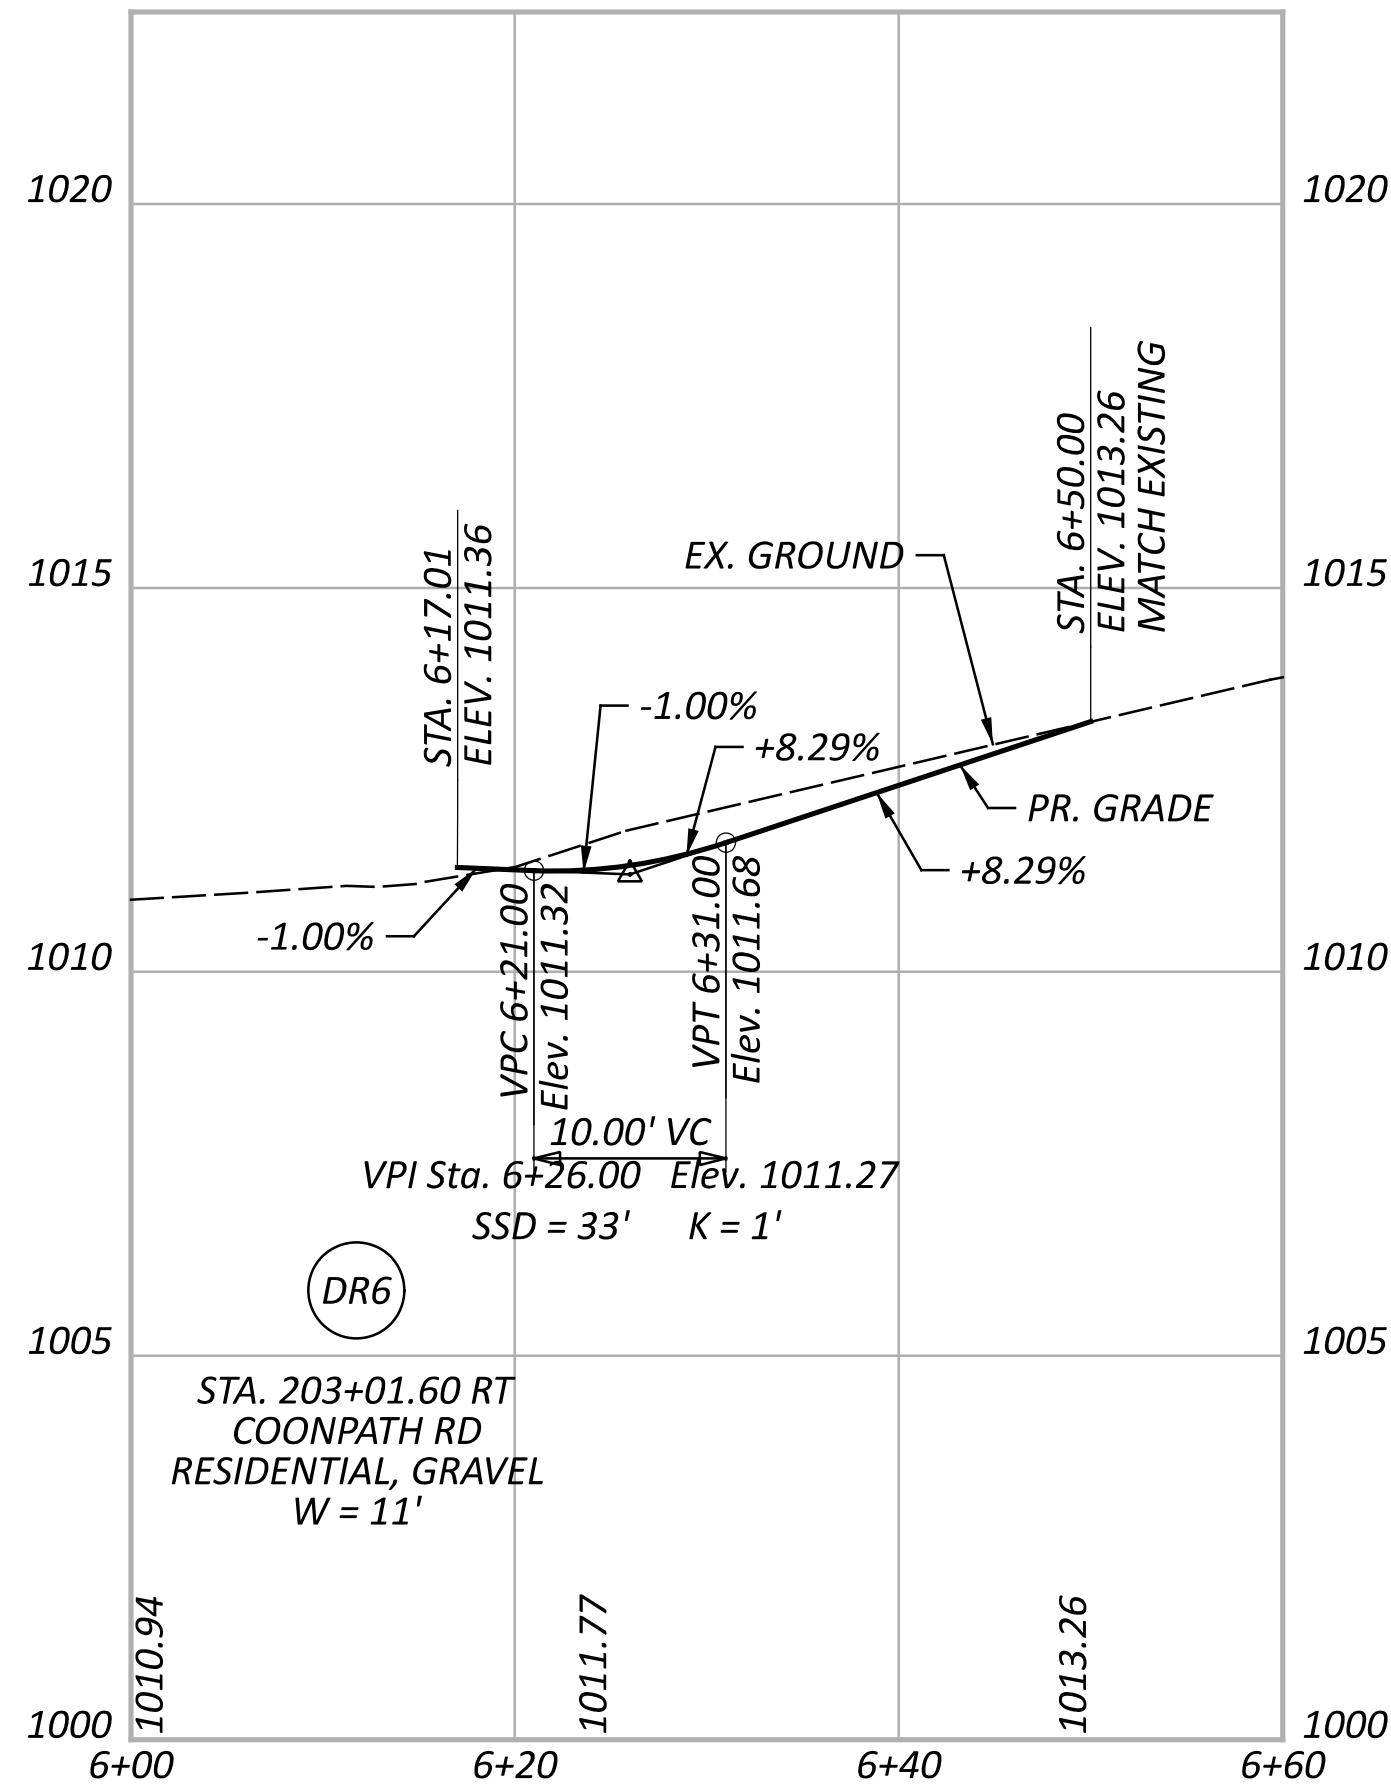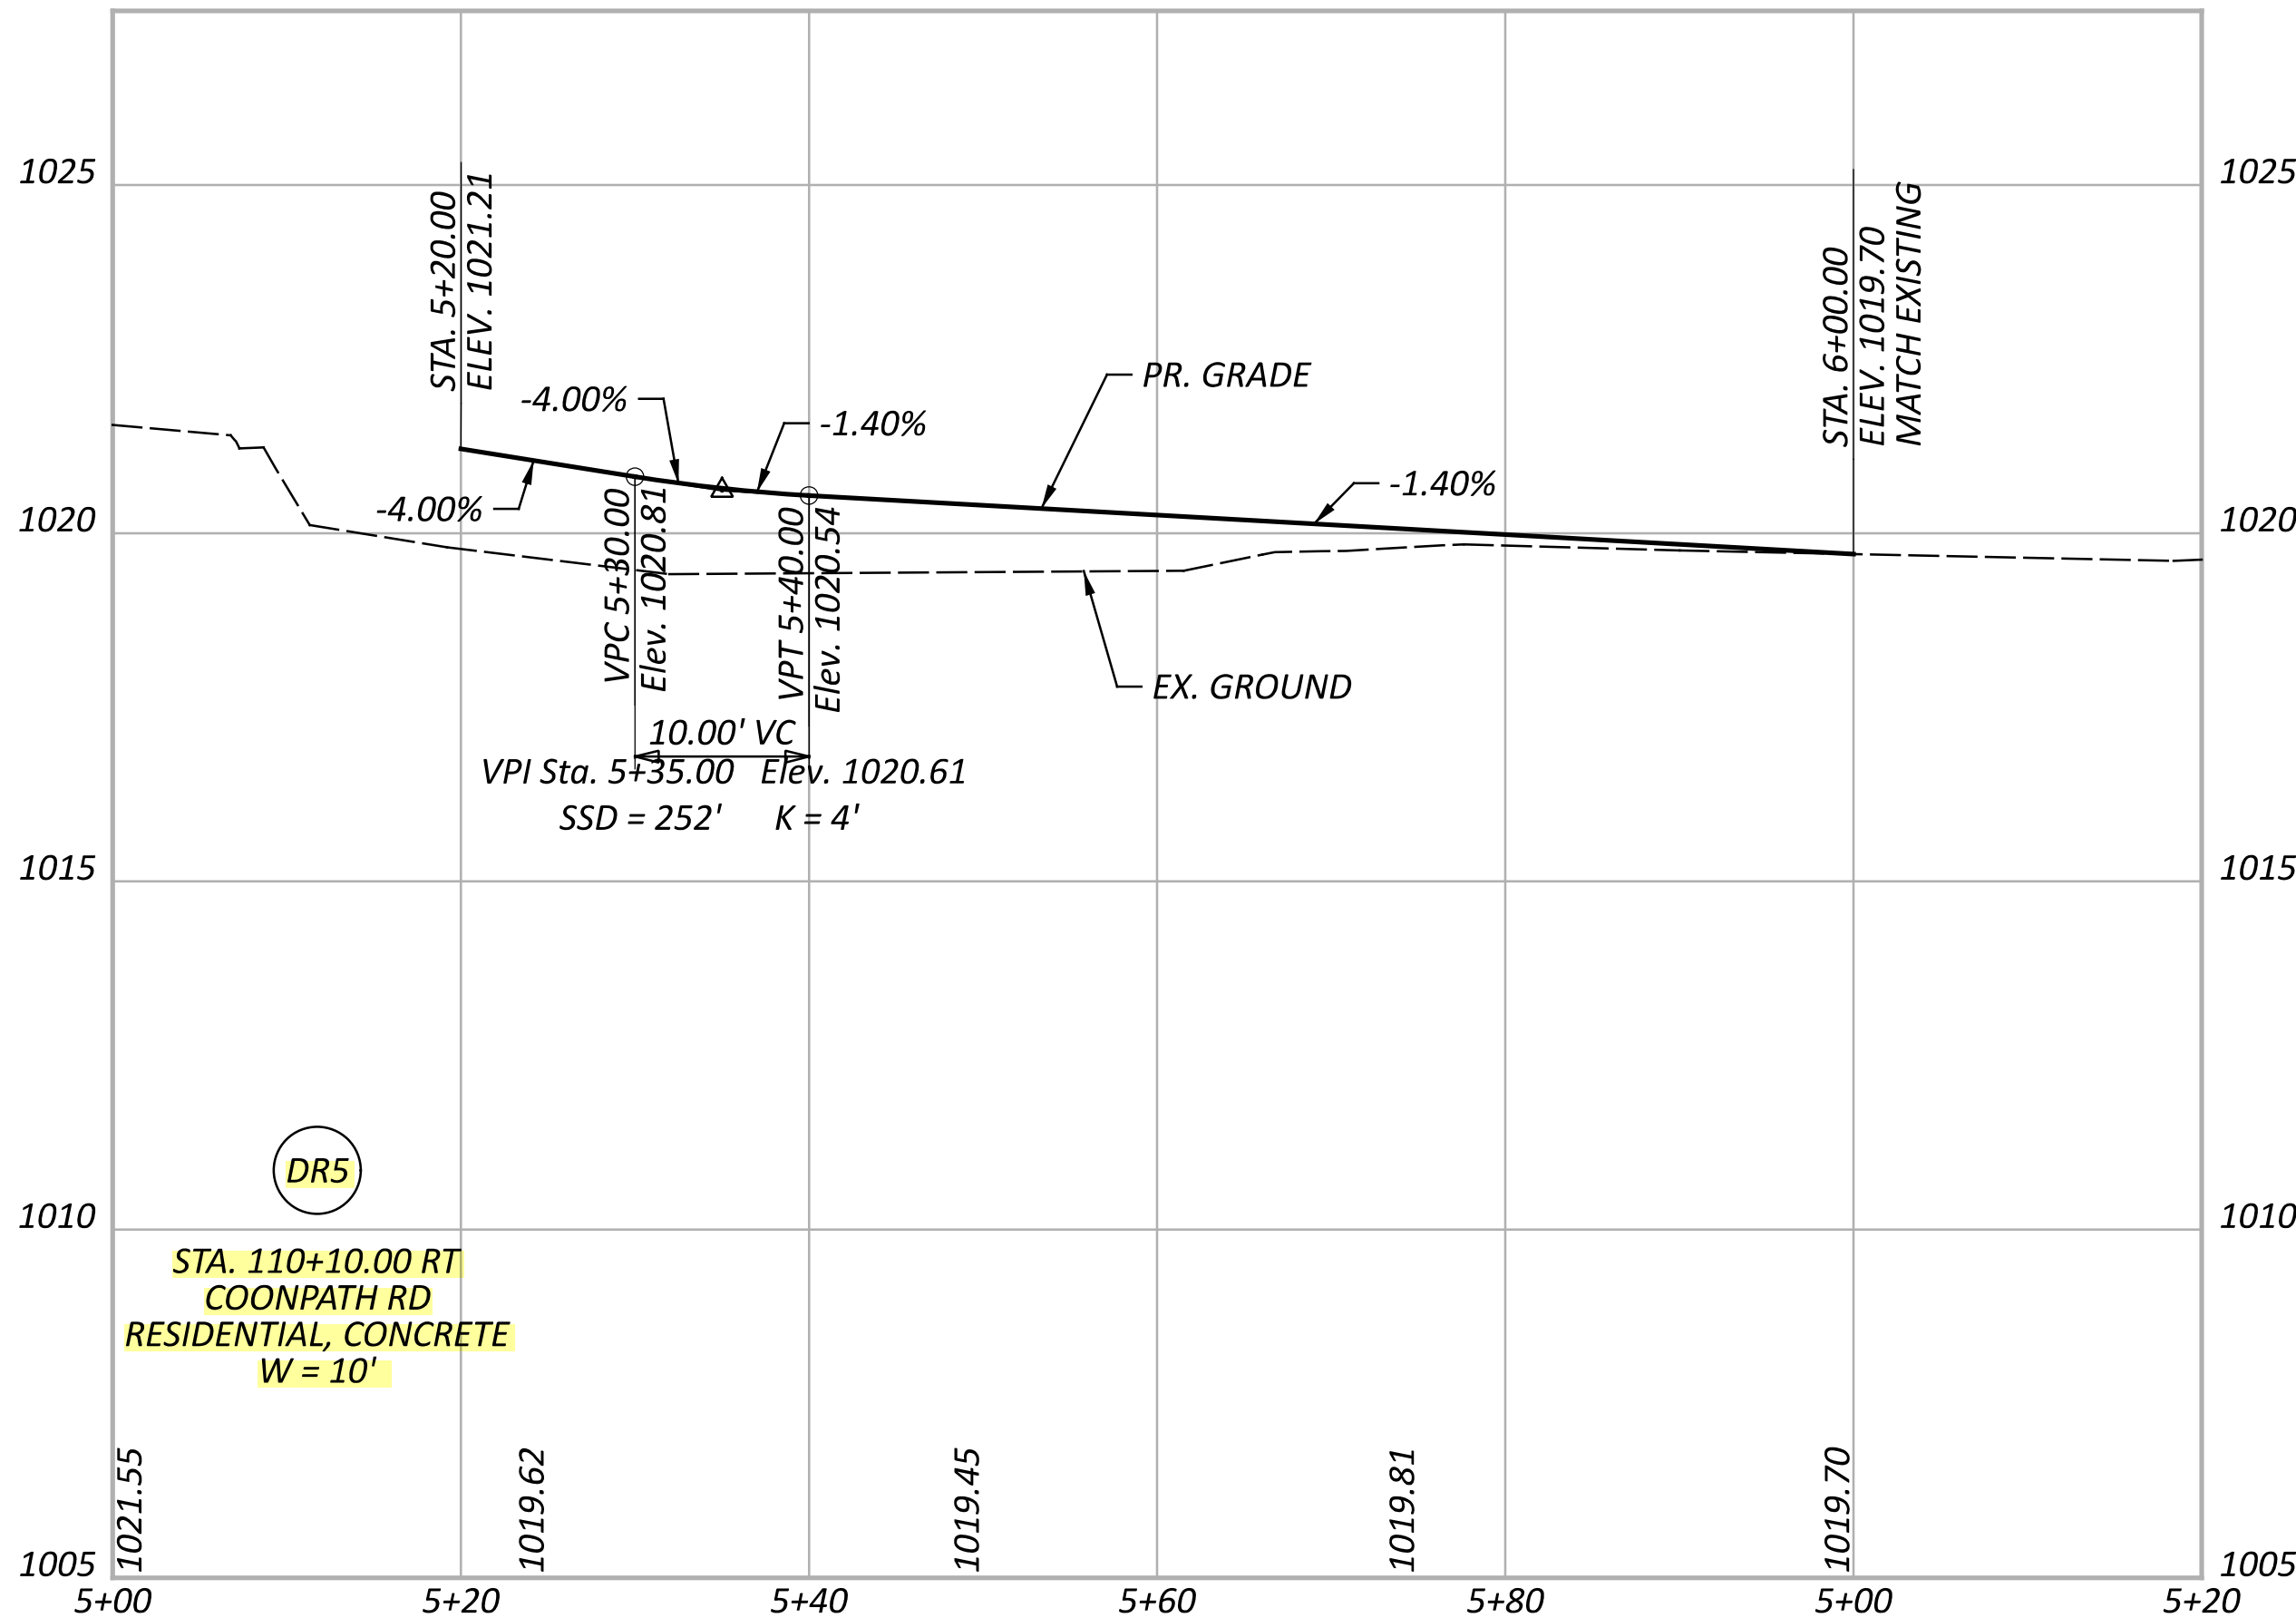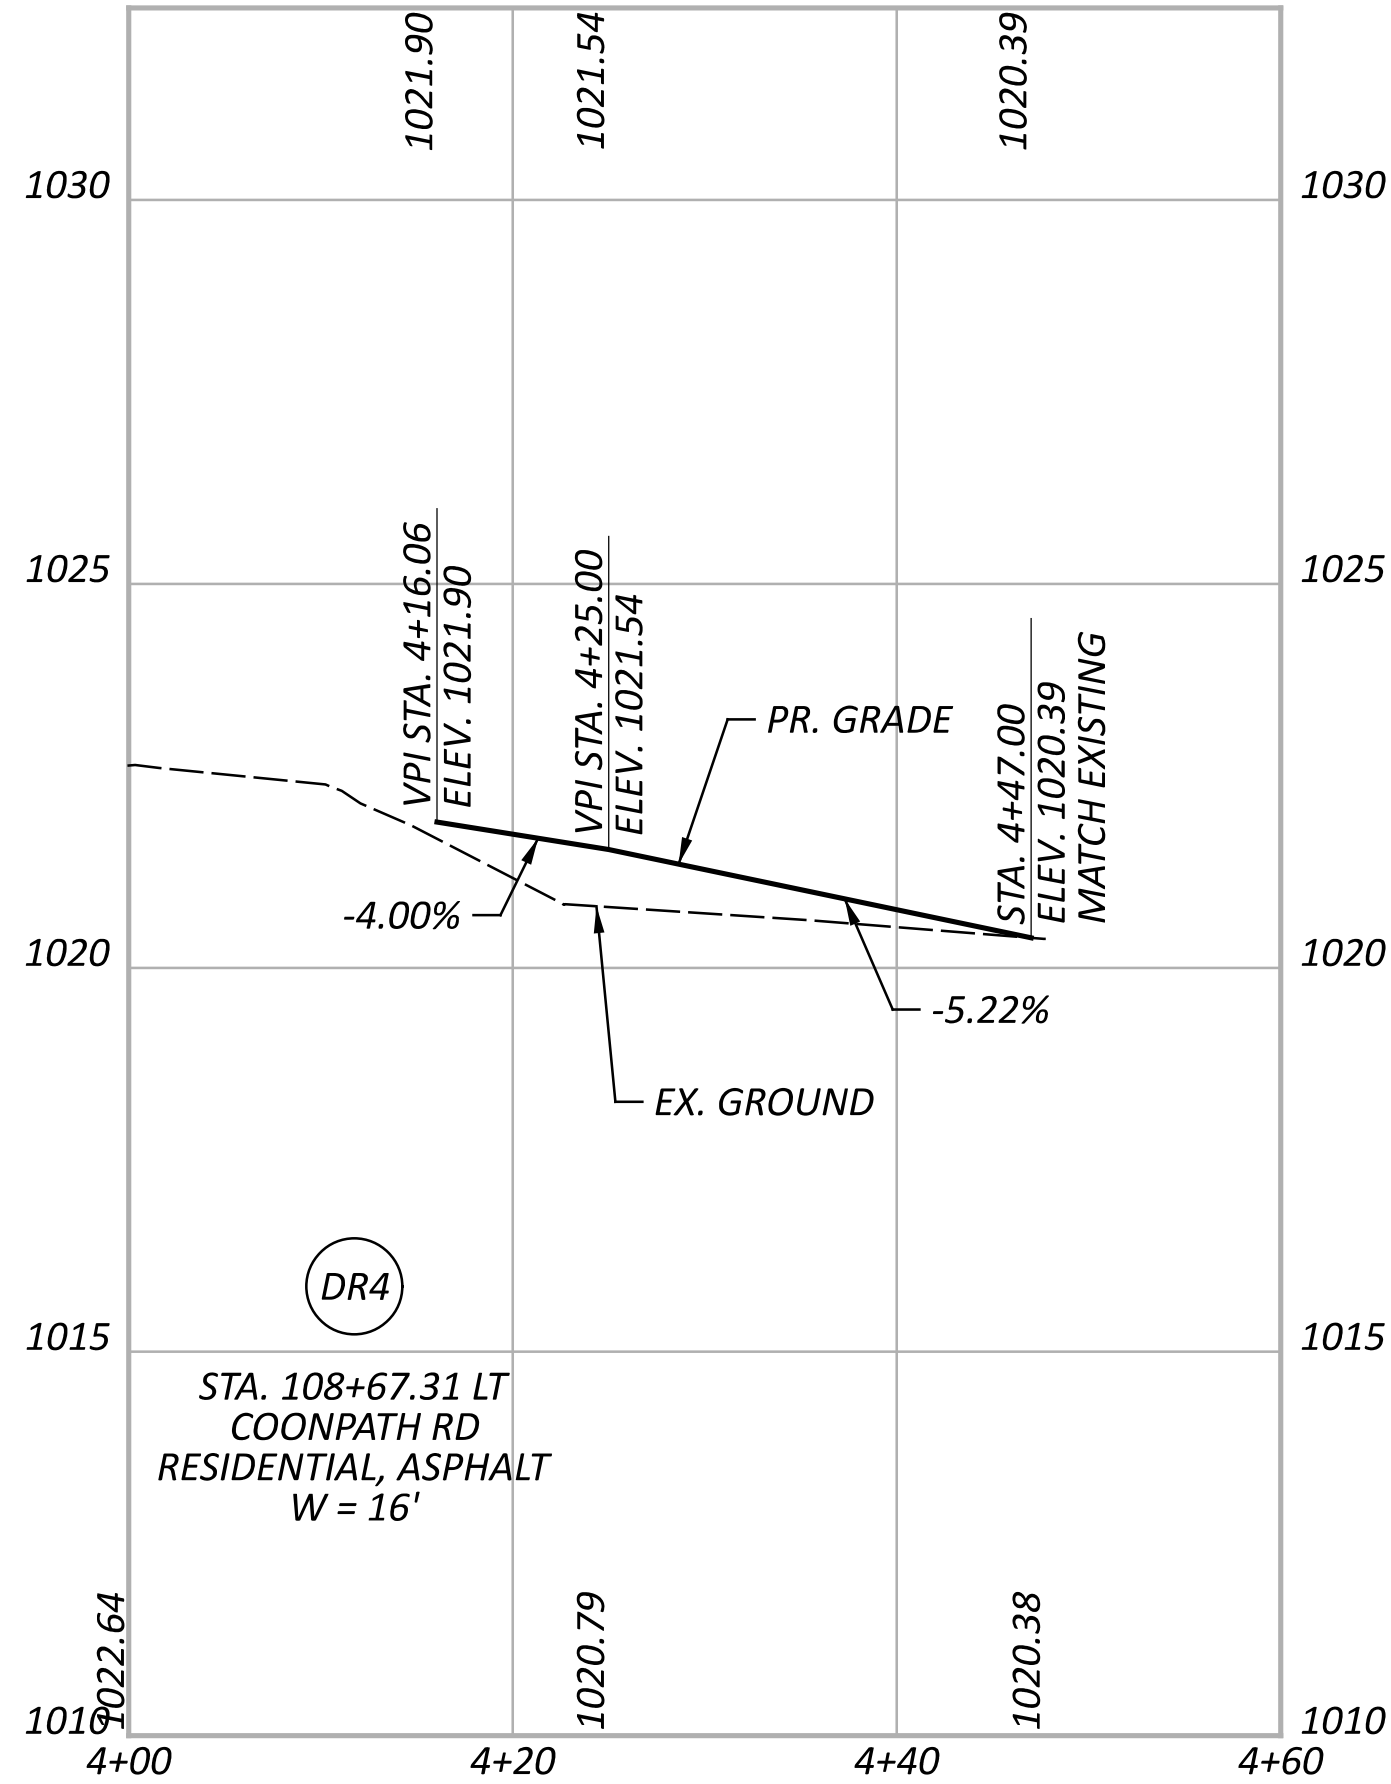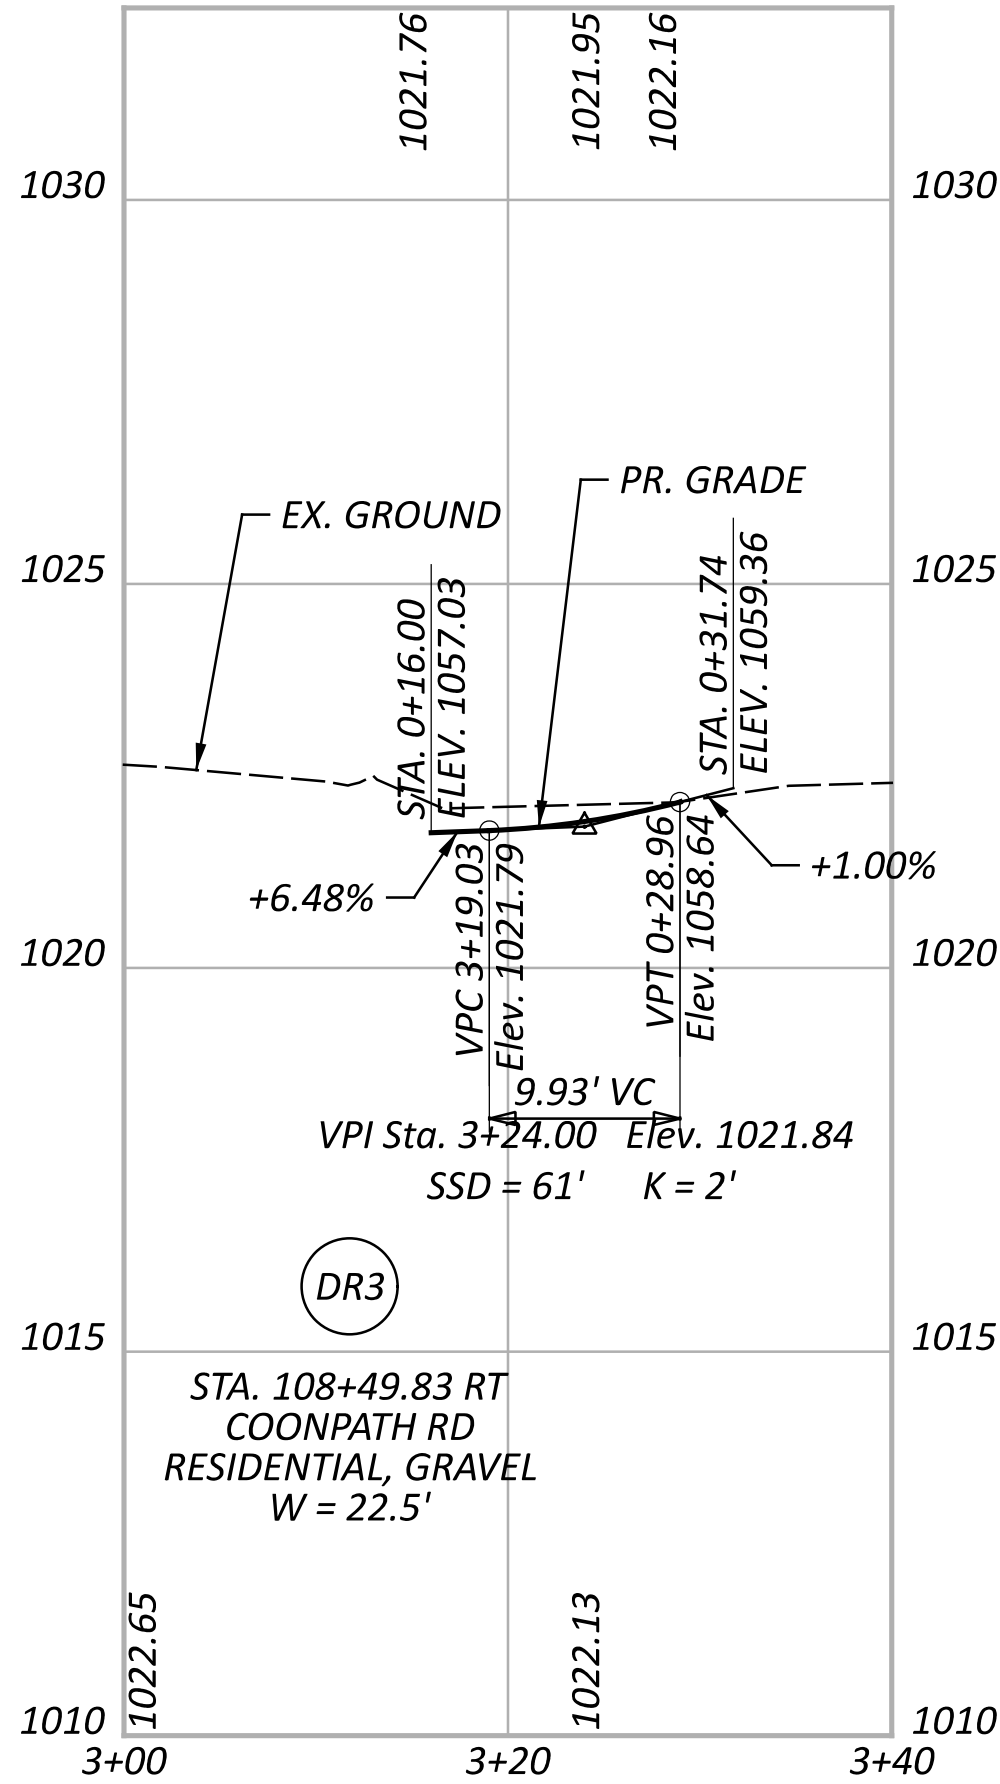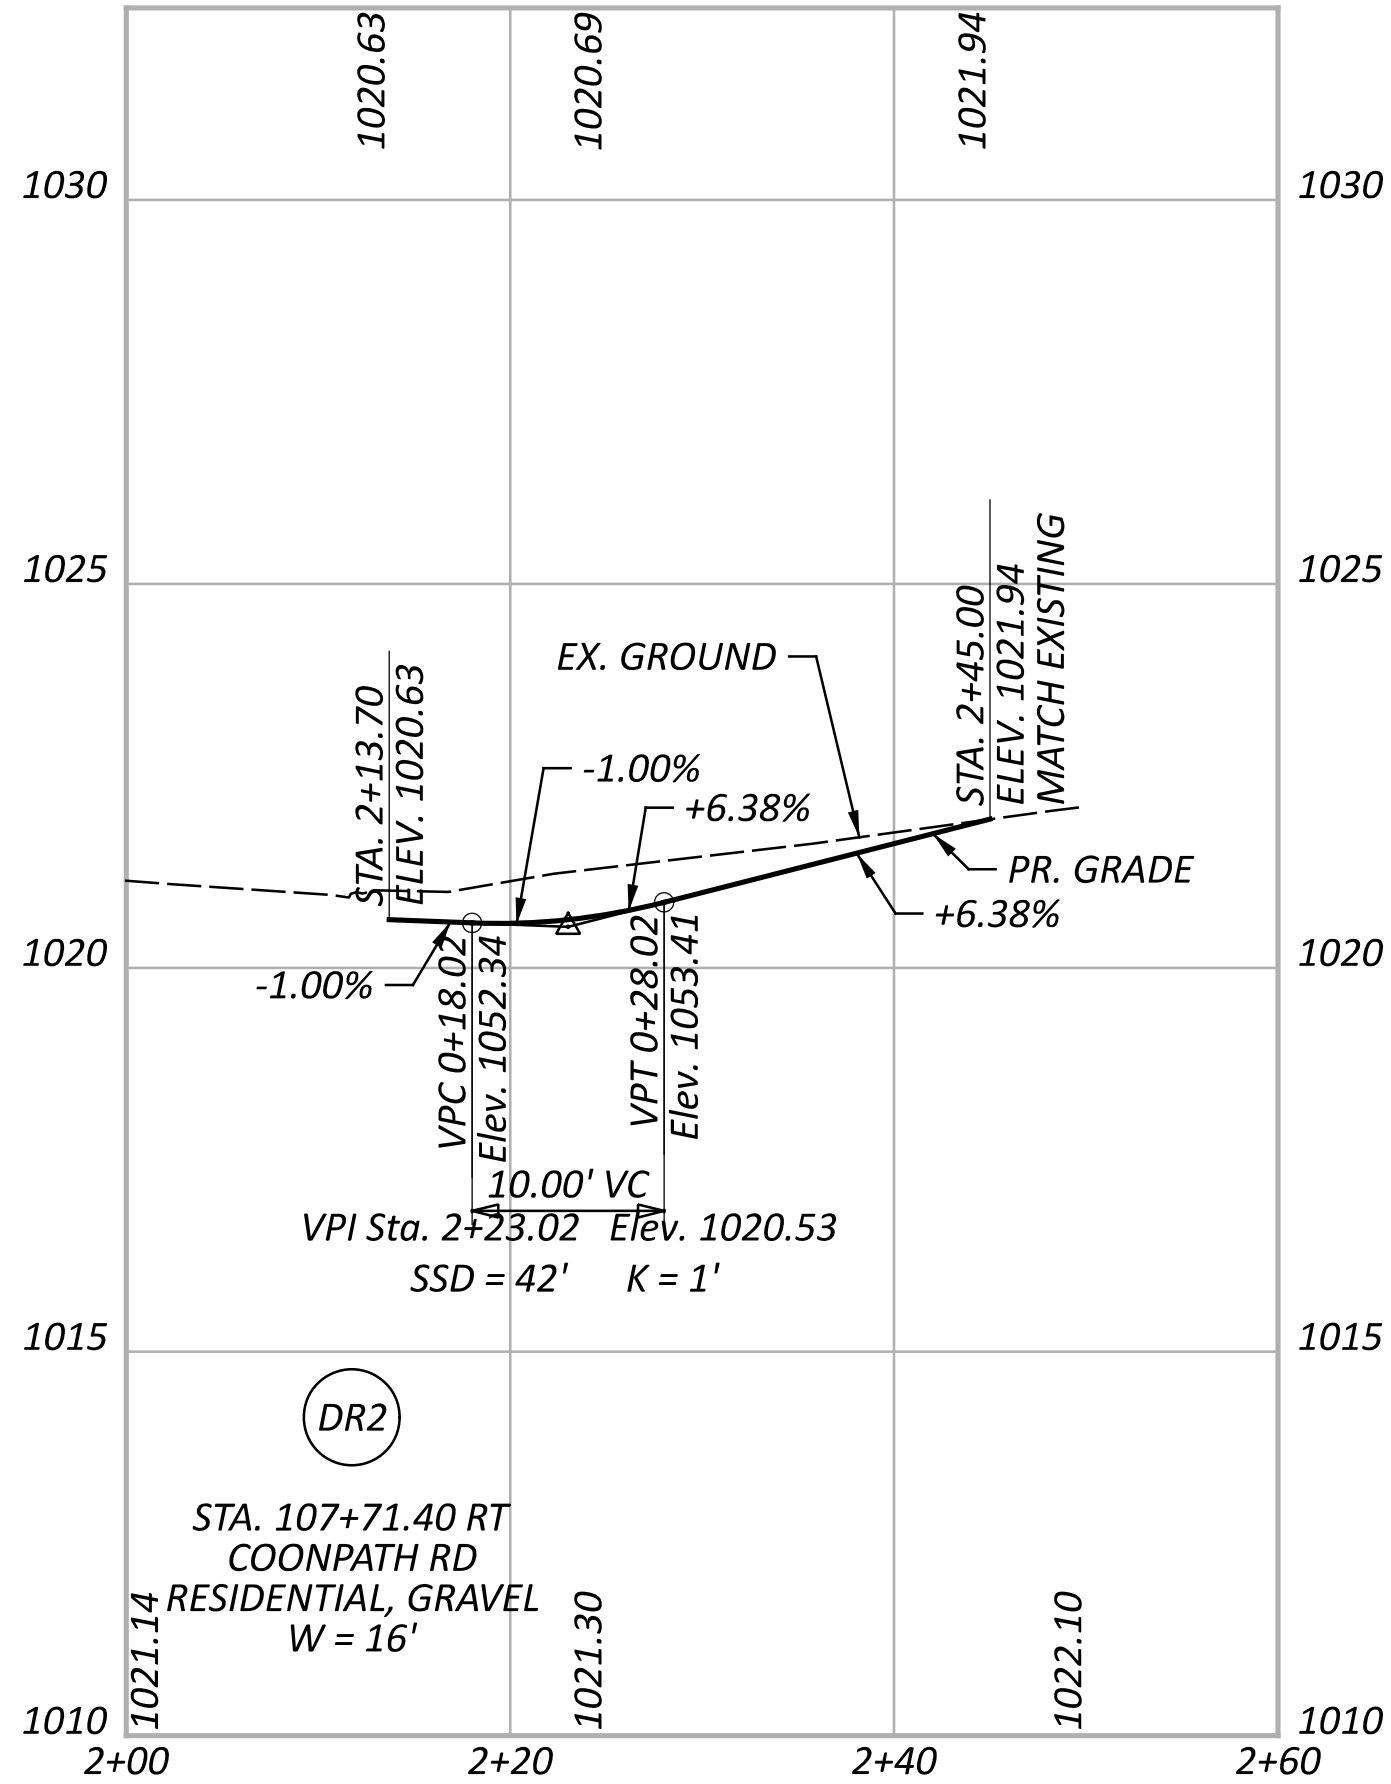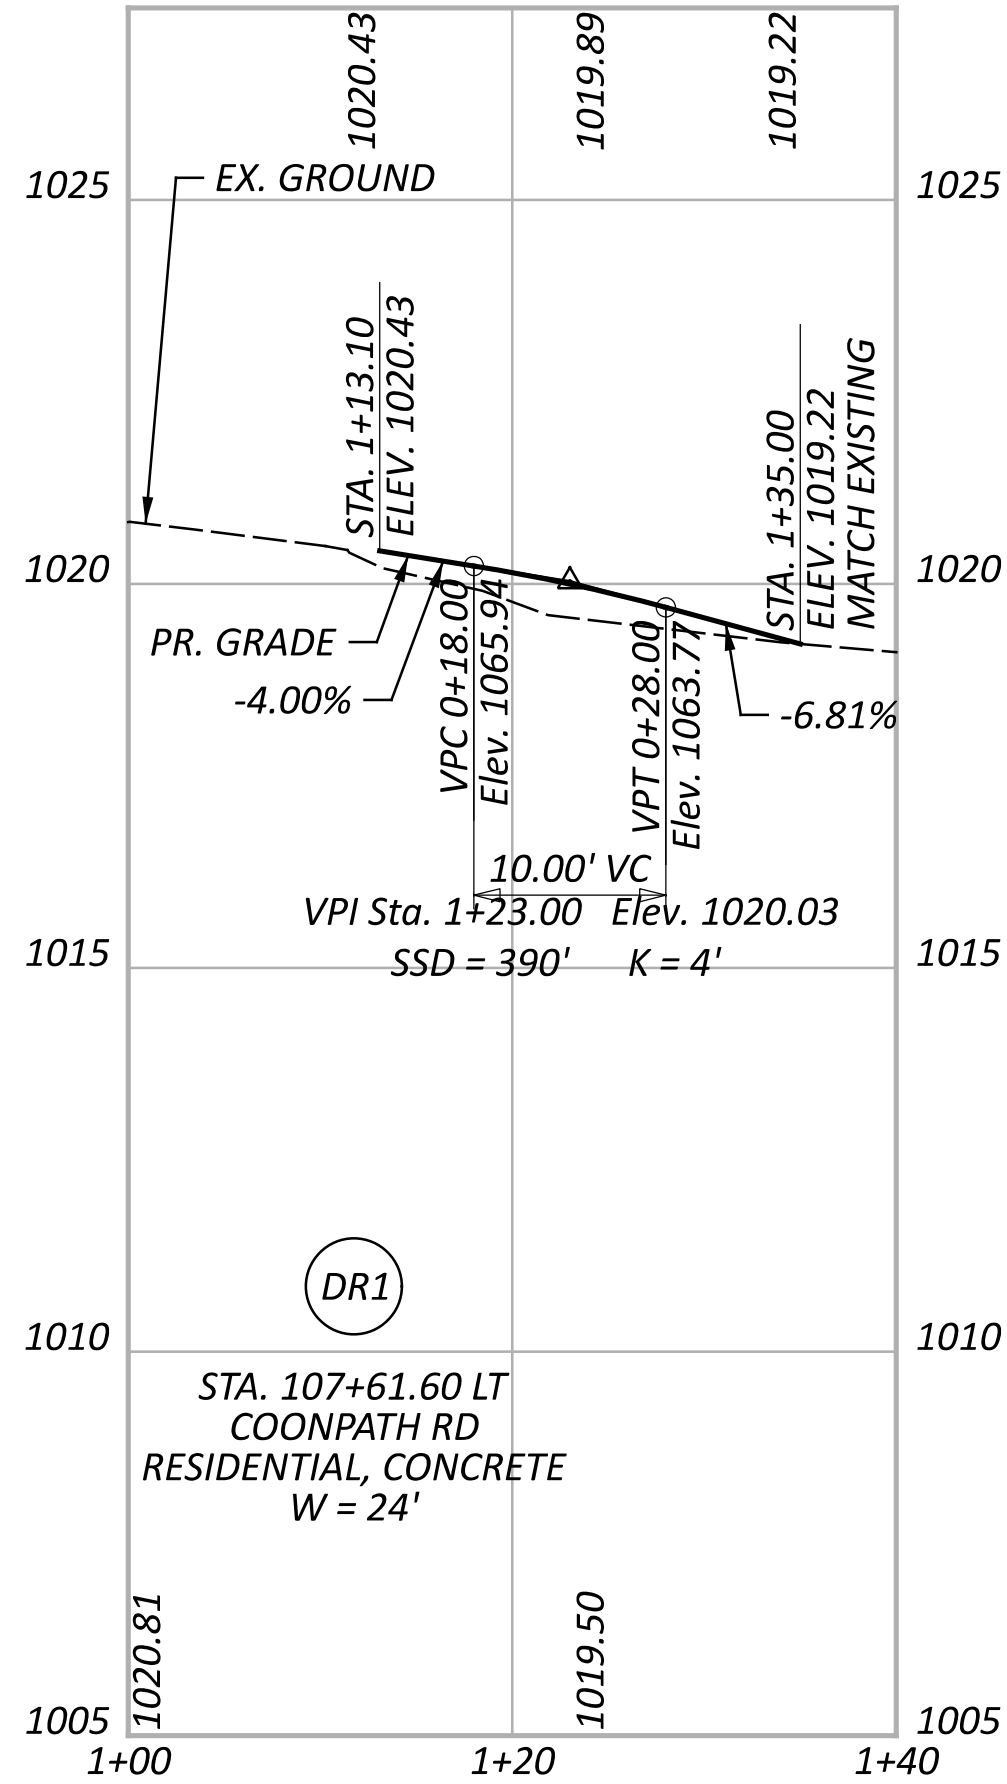

DRIVE PROFILES
DRIVE 1 TO DRIVE 6

DESIGN AGENCY

AECOM

DESIGNER

KB

REVIEWER

NSP 07/10/23

PROJECT ID







111621

SHEET

P.89

TOTAL

102

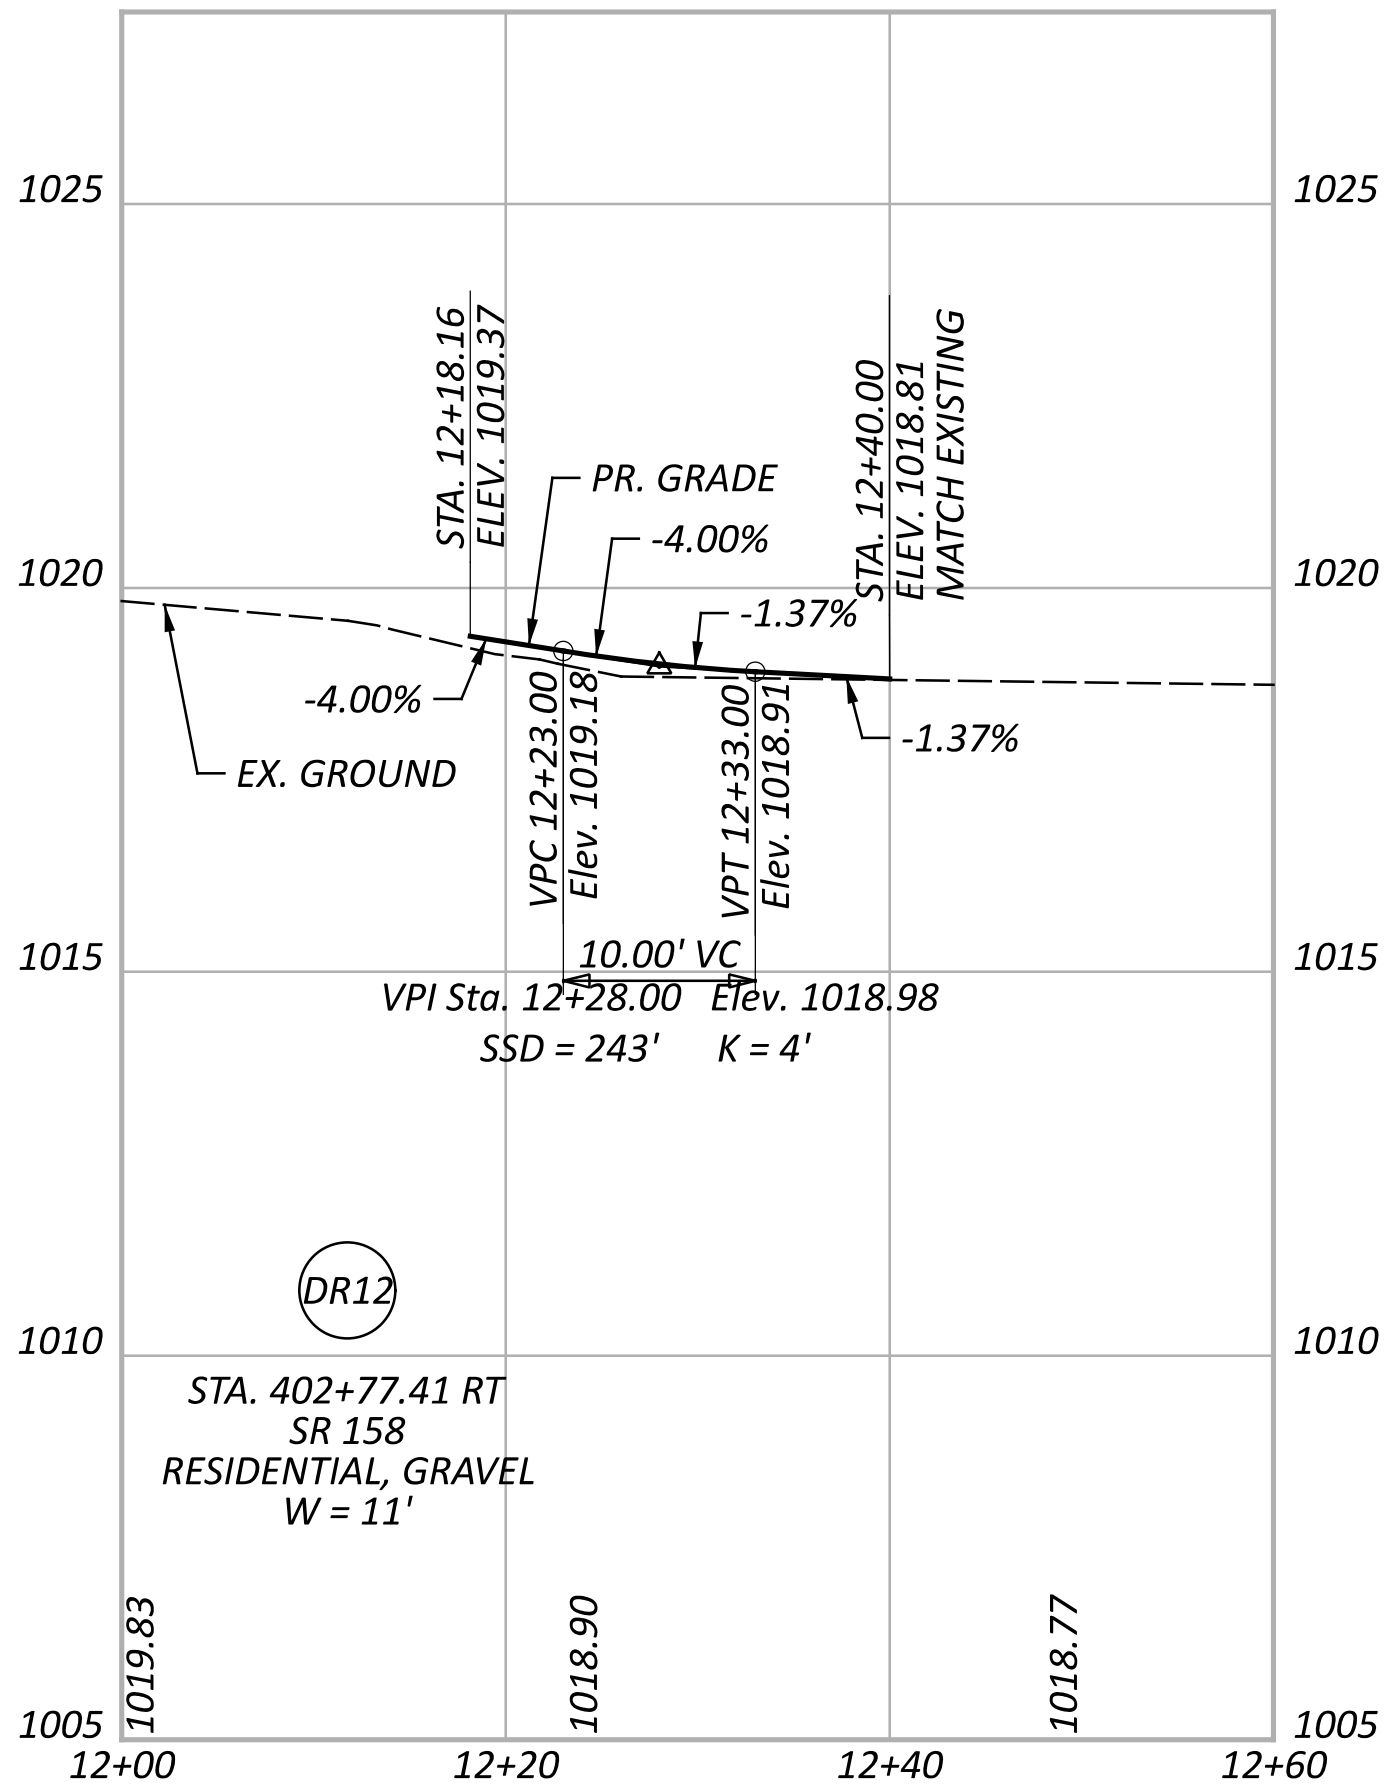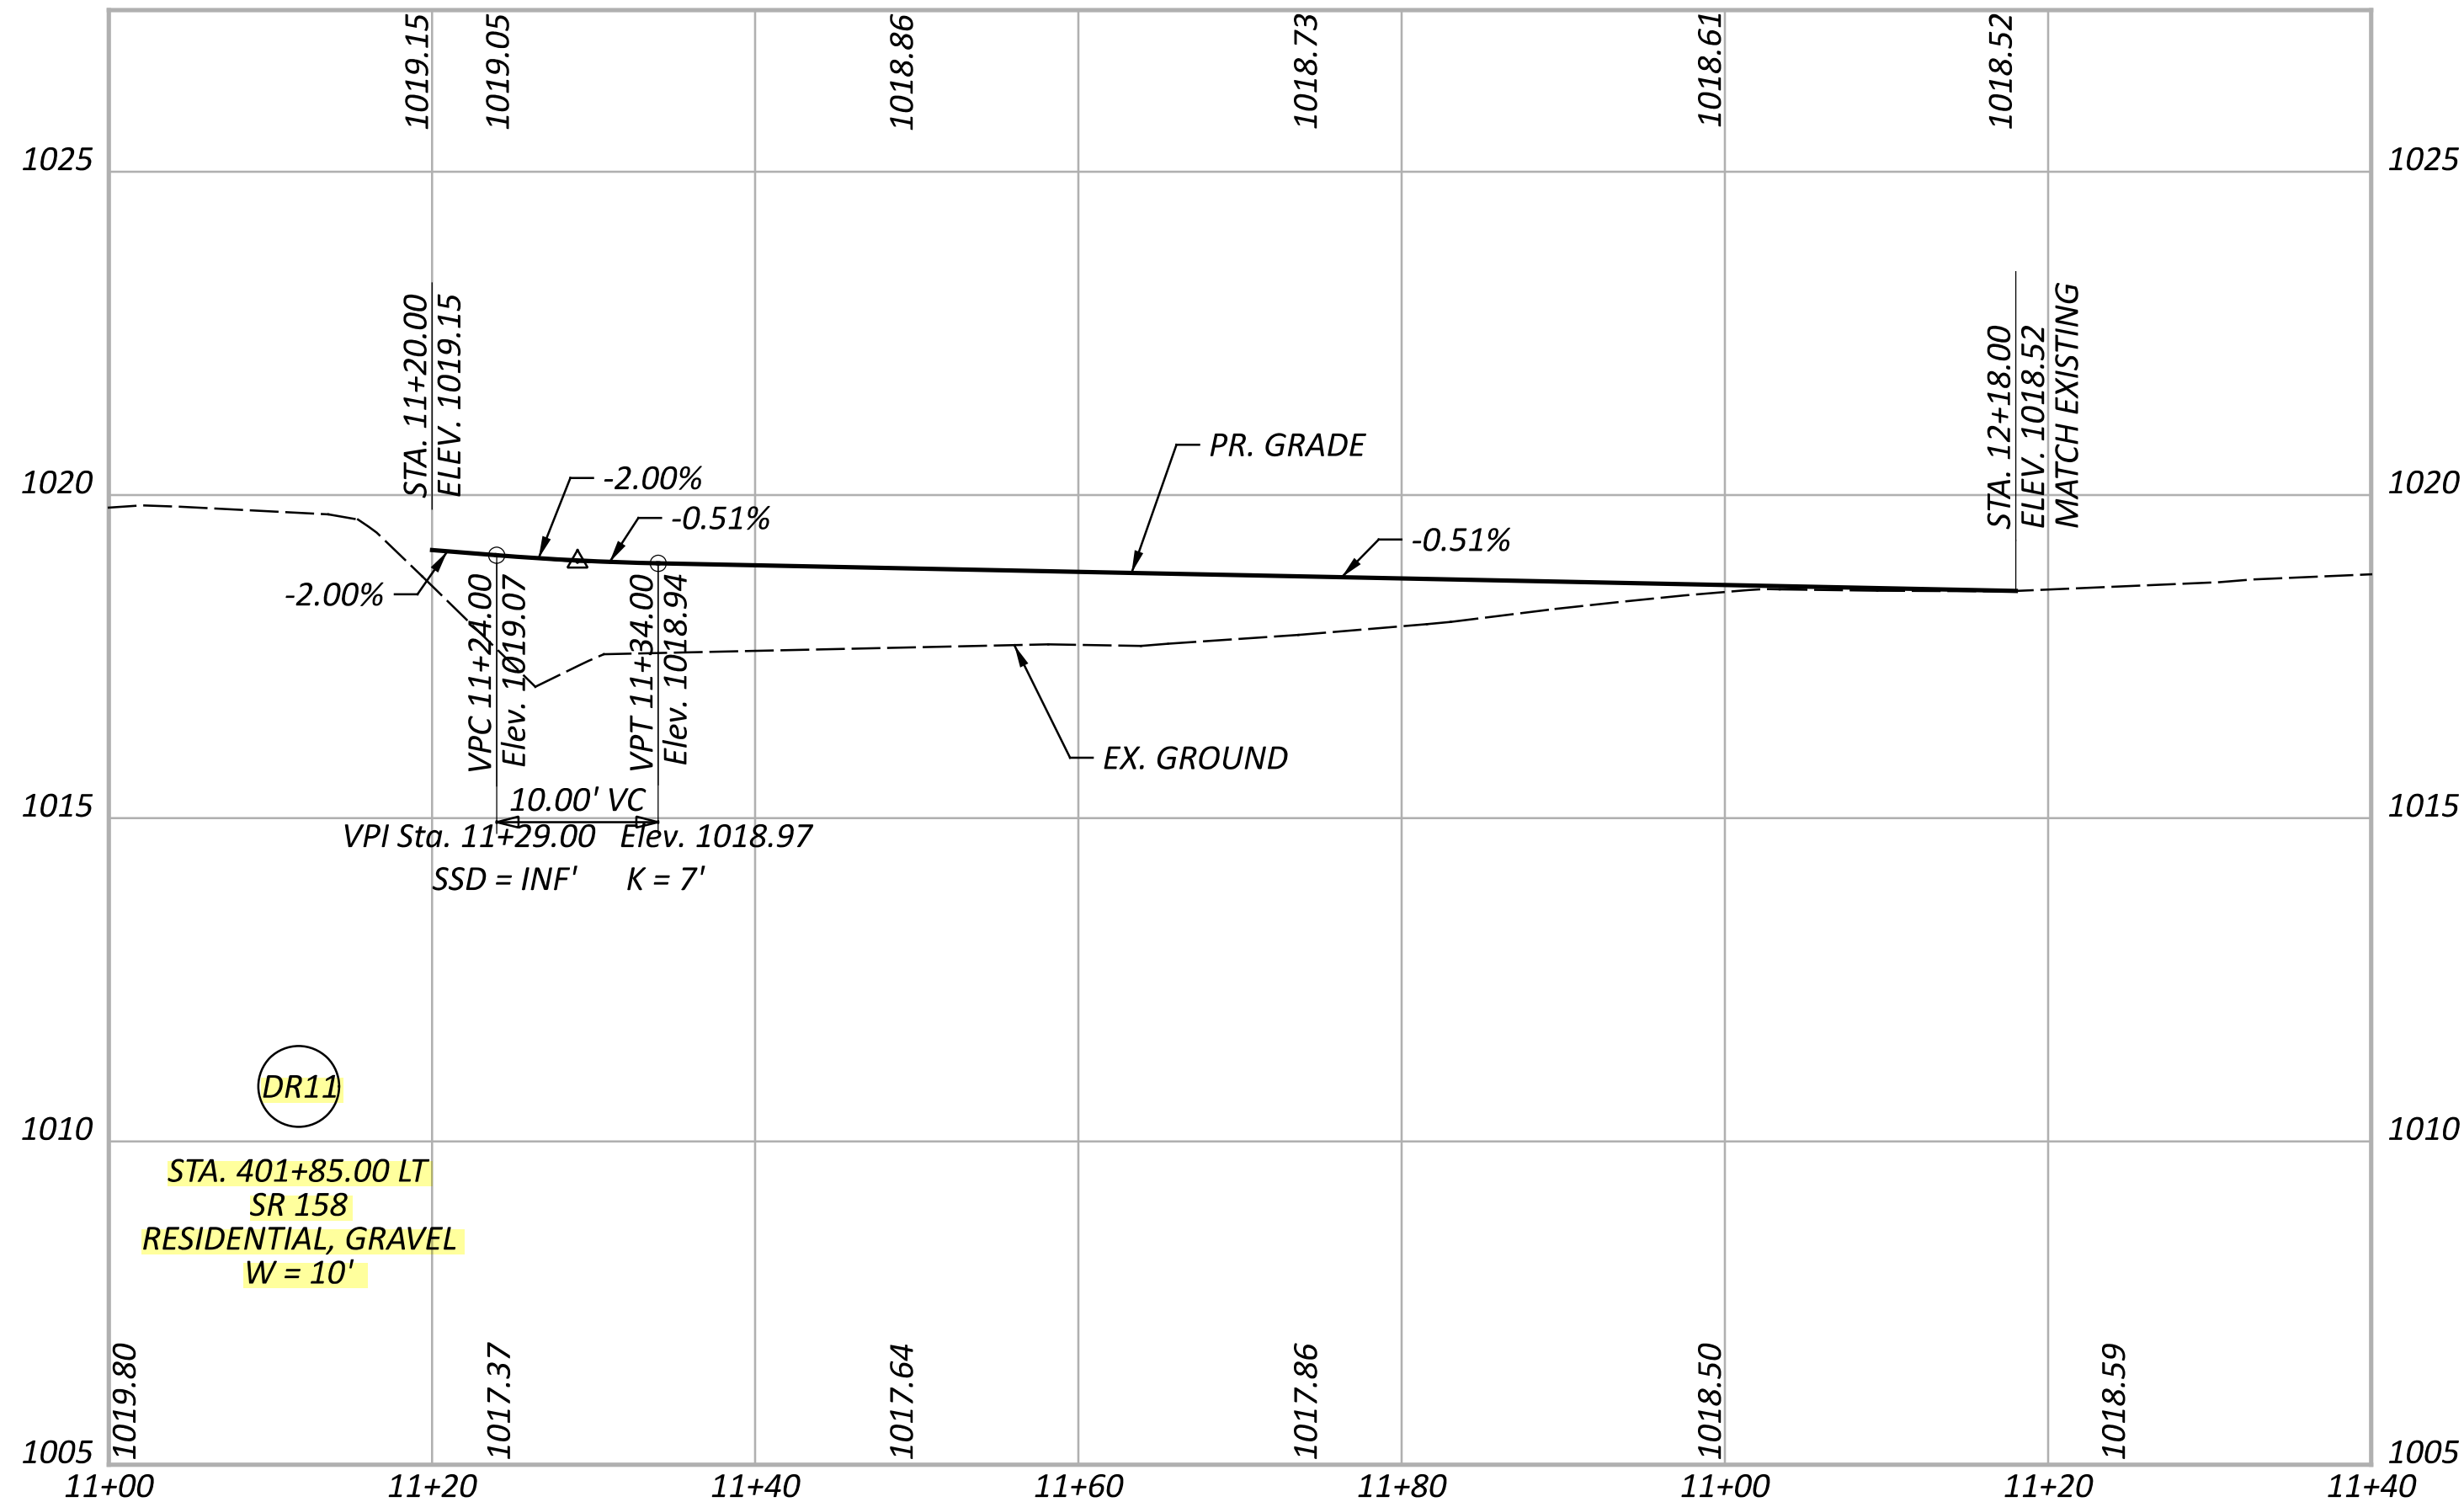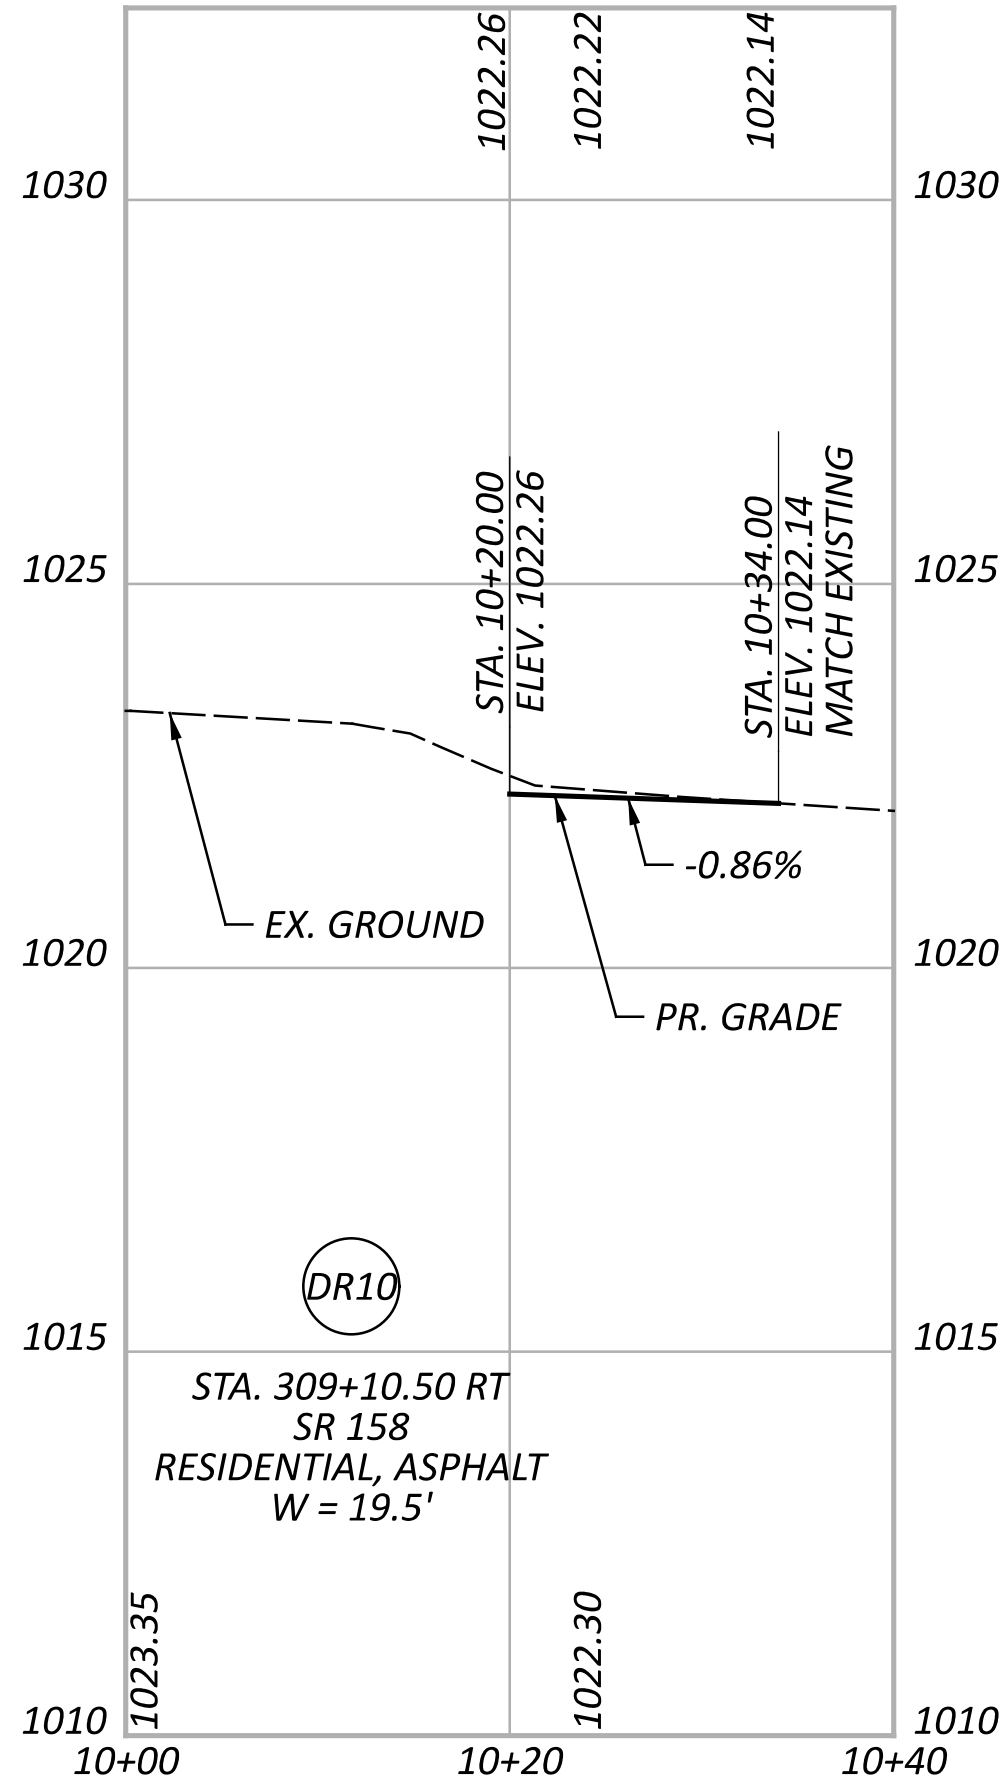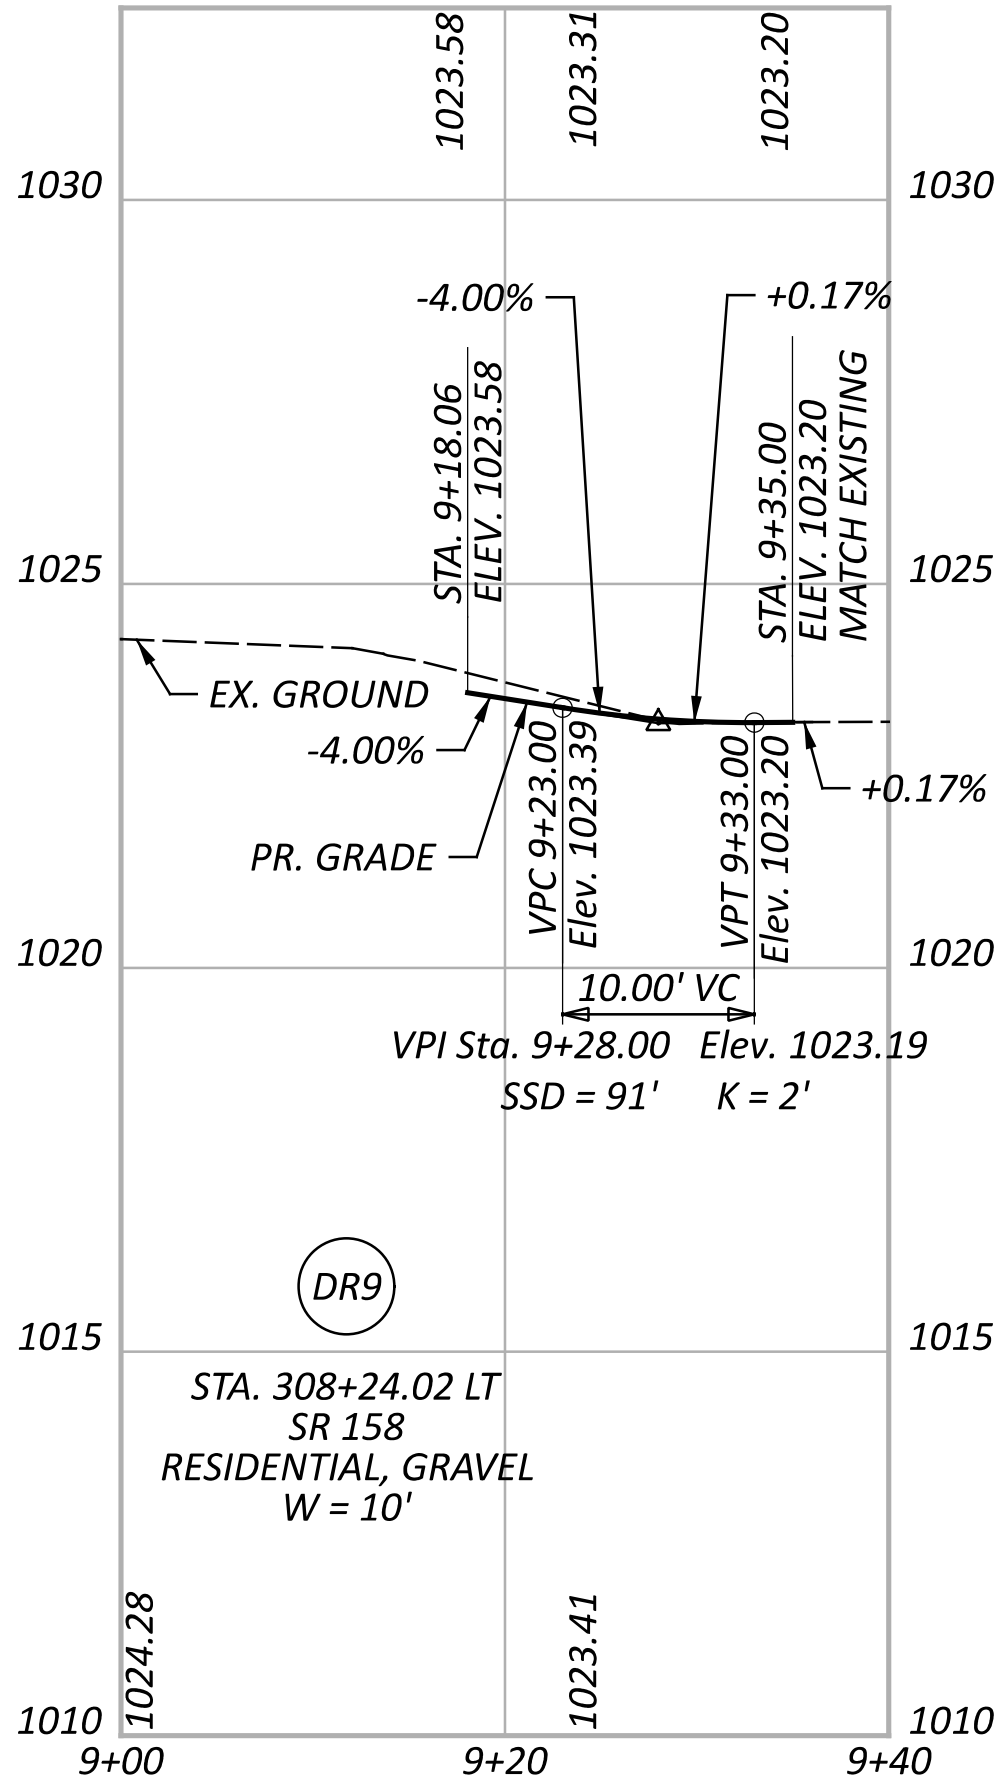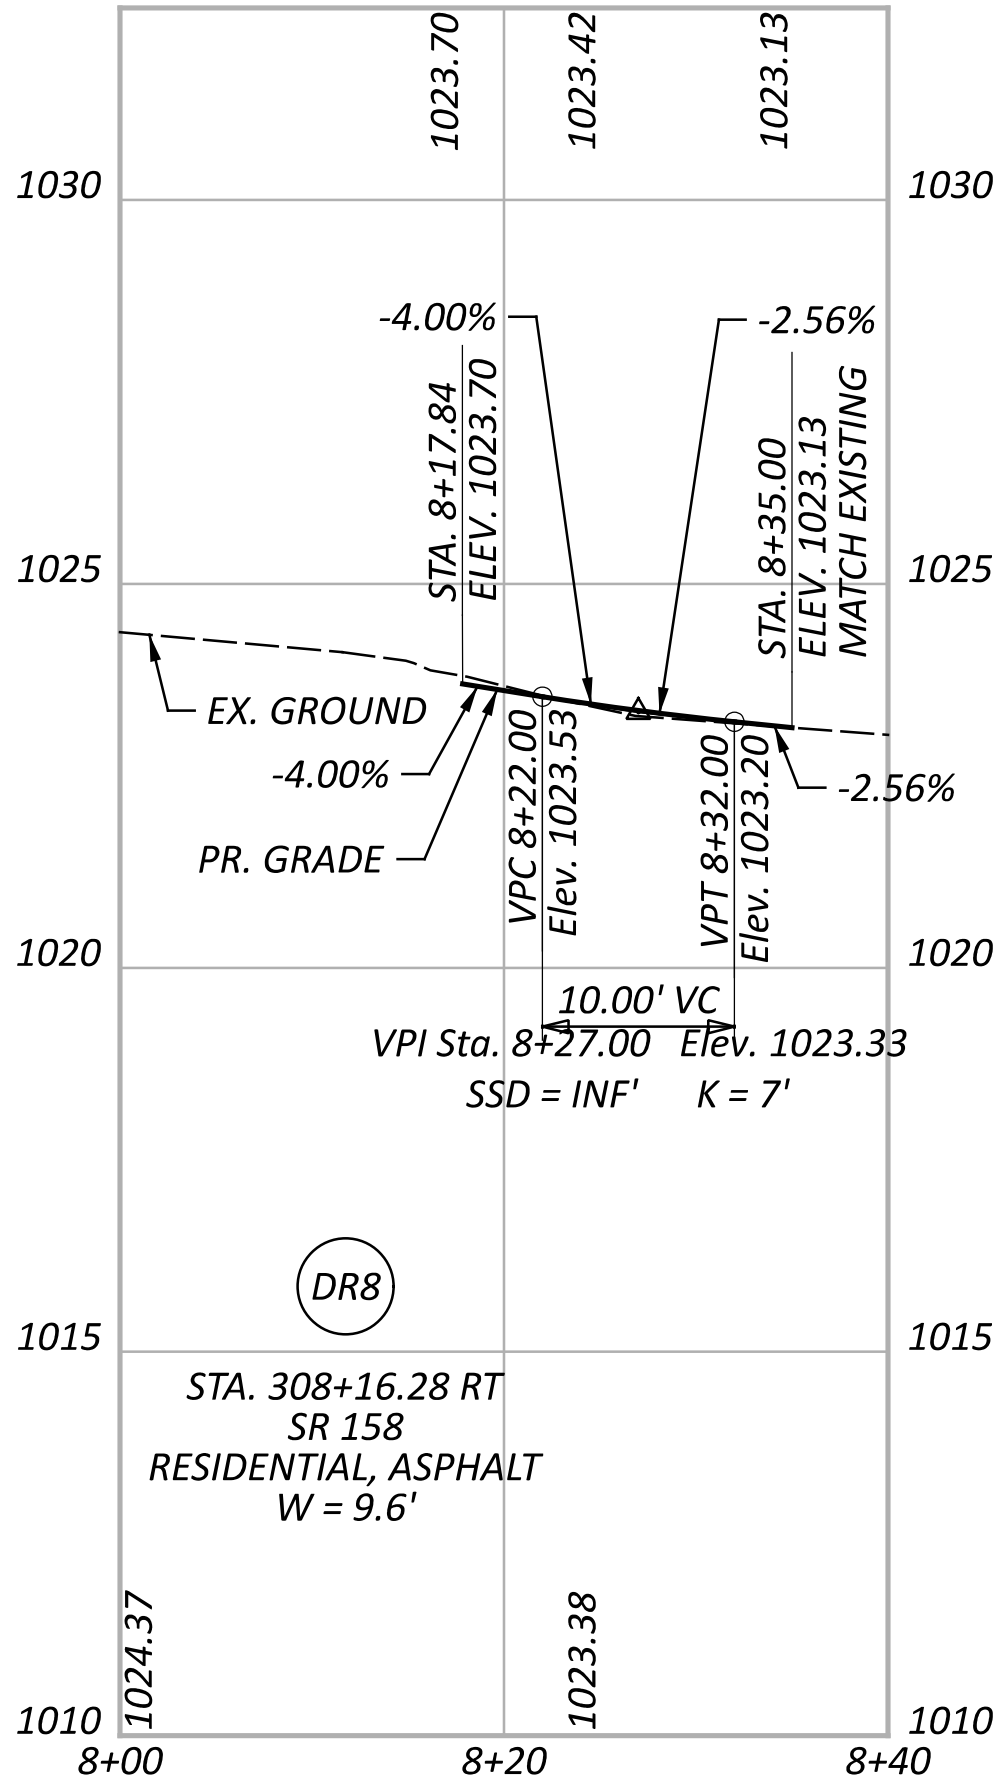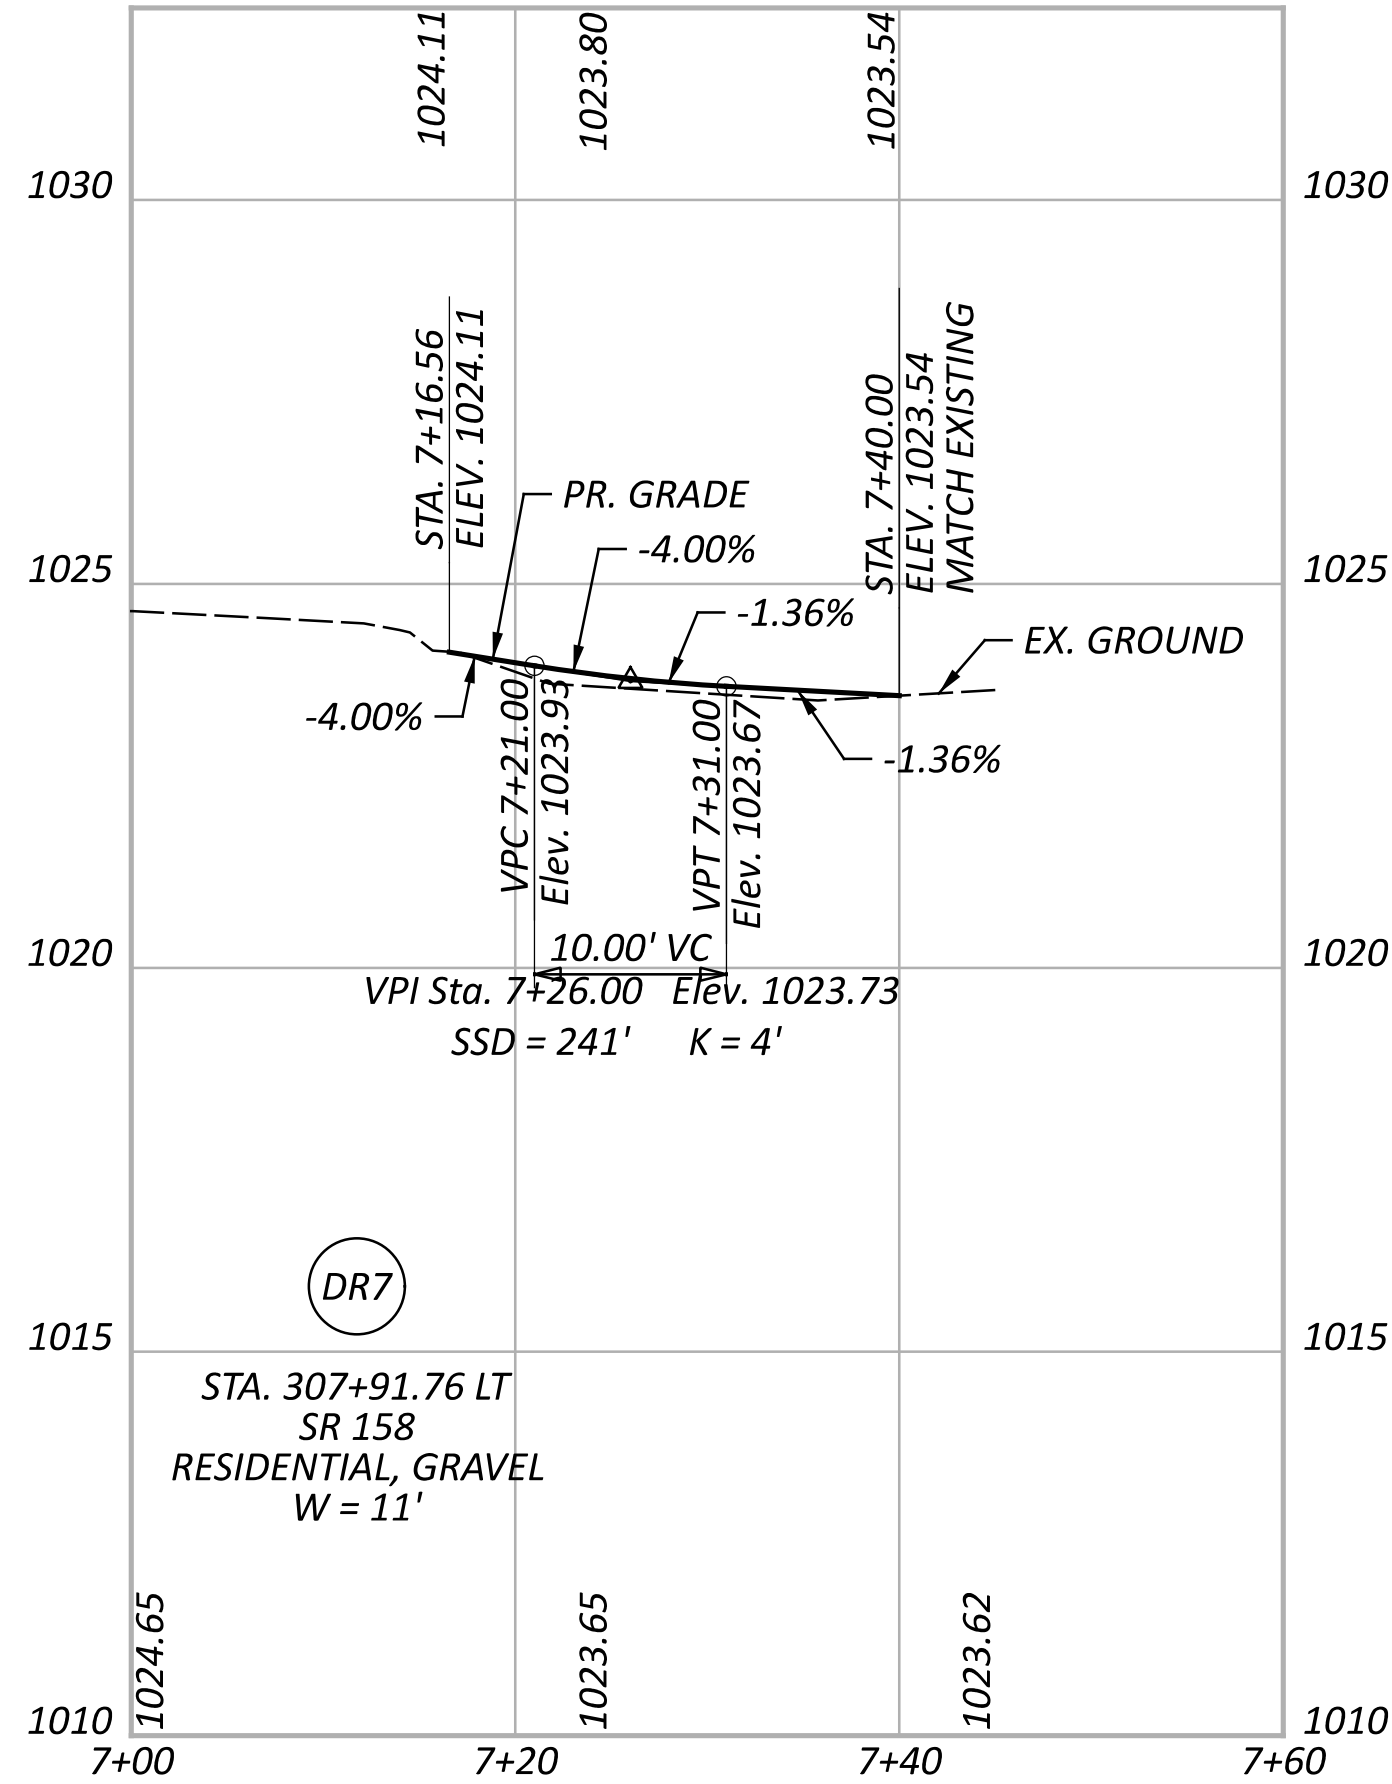

DRIVE PROFILES
DRIVE 7 TO DRIVE 12

DESIGN AGENCY

AECOM

DESIGNER

KB

REVIEWER

NSP 07/10/23

PROJECT ID

111621


SHEET

P.90

TOTAL

102

- A ITEM 644, 4" CENTERLINE, DOUBLE YELLOW
- B ITEM 644, 4" EDGE LINE, YELLOW
- C ITEM 644, 4" EDGE LINE, WHITE
- D ITEM 644, YIELD LINE (24" BASE SHARKS TEETH)
- E ITEM 644, 8" DOTTED LINE, WHITE

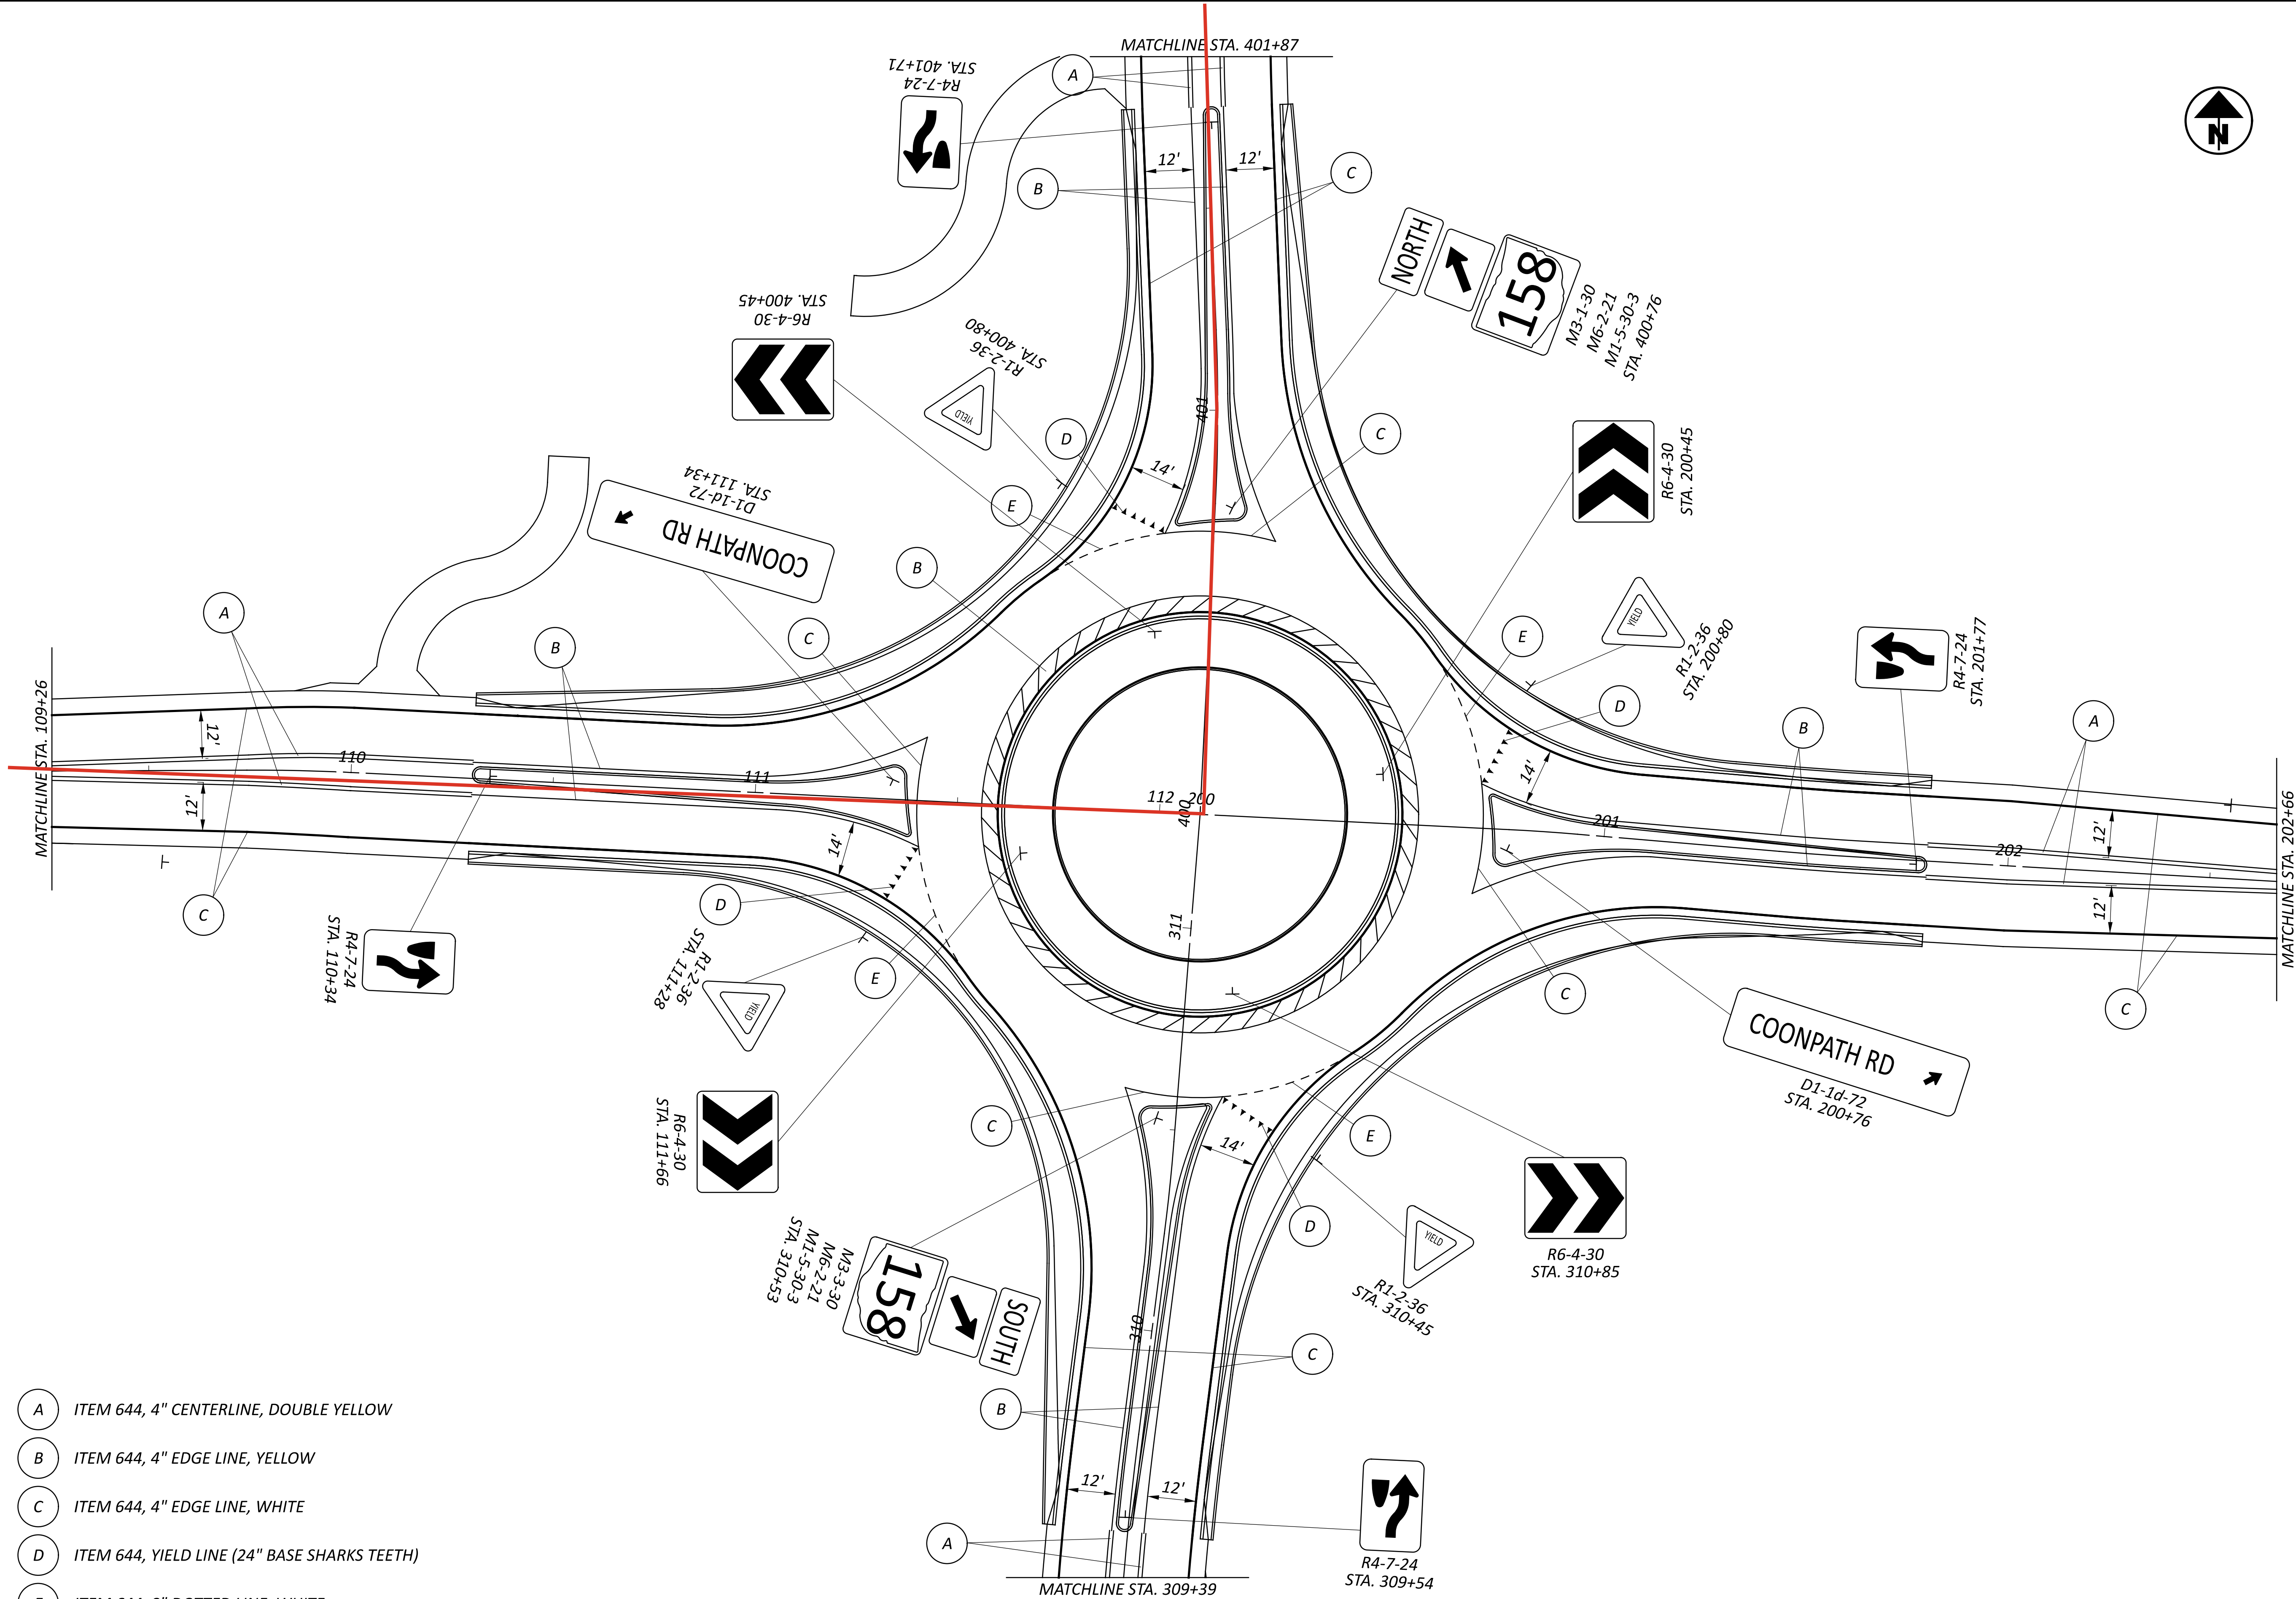

TRAFFIC CONTROL PLAN
SR 158 AND COONPATH RD

DESIGN AGENCY

AECOM

DESIGNER

SJK

REVIEWER

NSP 07/10/23

PROJECT ID

111621


SHEET

P.97

TOTAL

102

MODEL: Sheet PAPER: 34x22 (in.) DATE: 8/3/2023 TIME: 11:56:58 AM USER: PatelV2
pw:\ohiodot-pw.bentley.com\ohiodot-pw-02\Documents\01 Active Projects\District 05\Fairfield\111621\402-Engineering_AECOM\Traffic\Sheets\111621_TP002.dgn

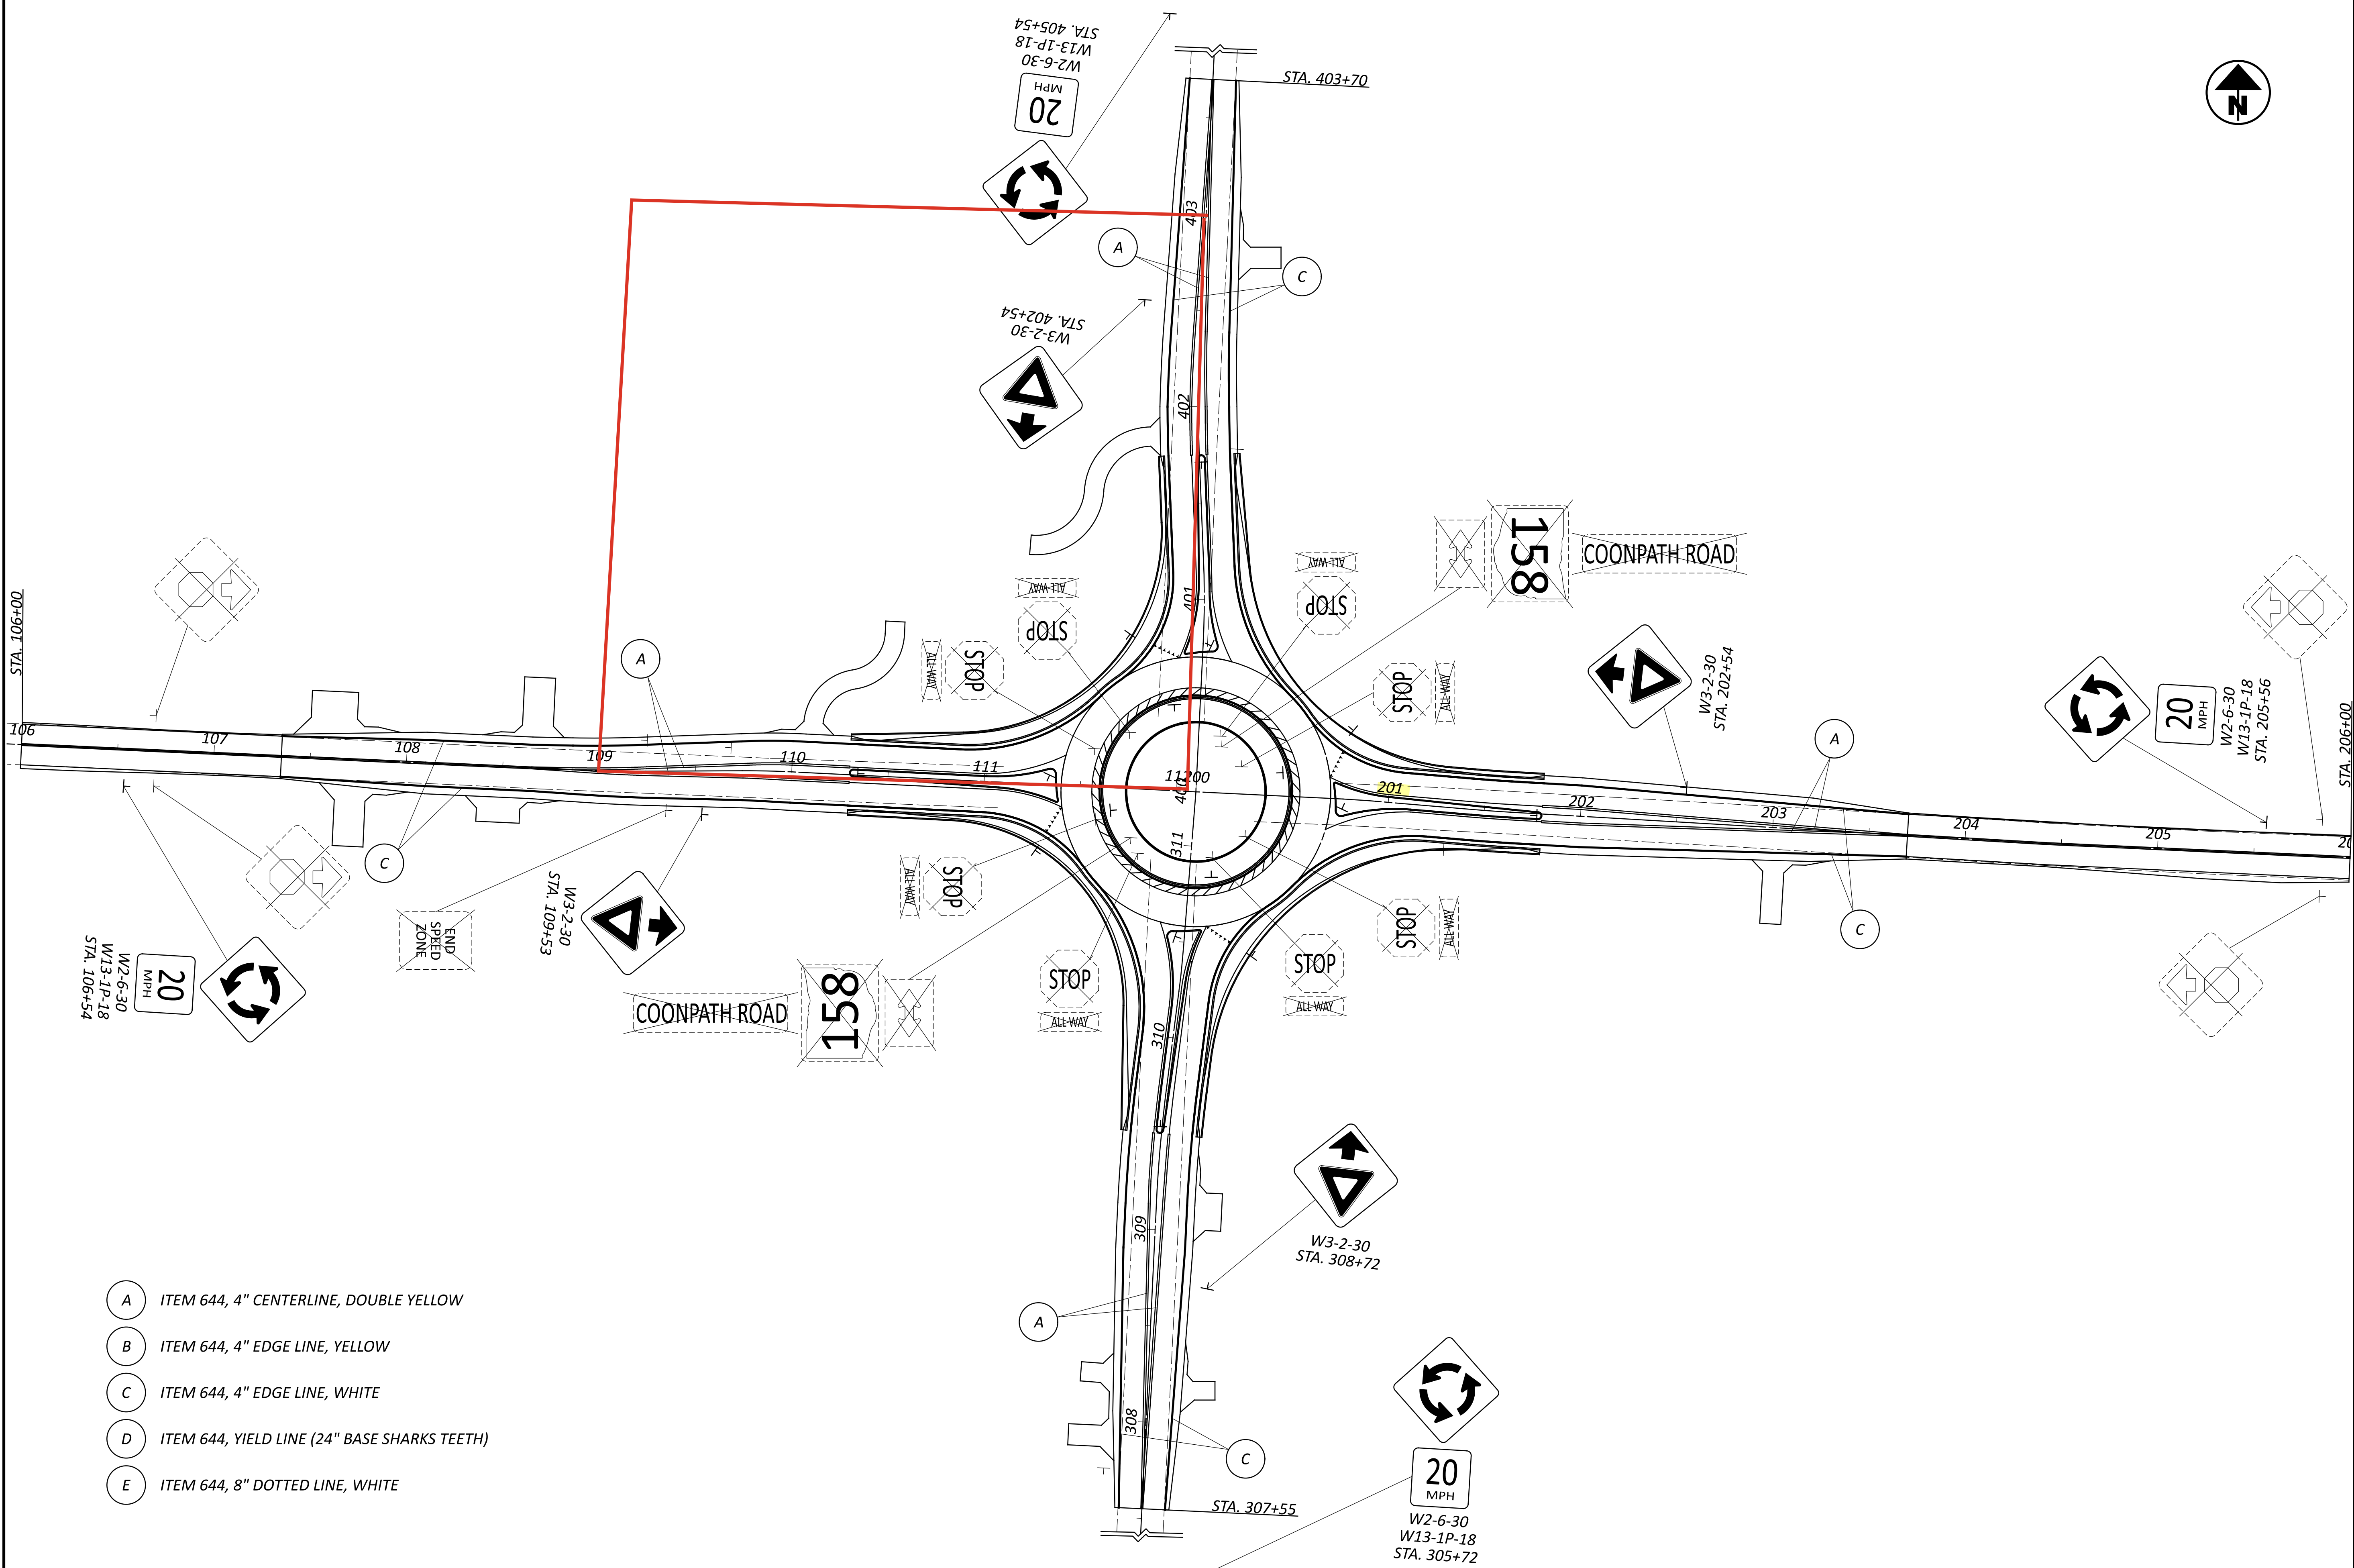

TRAFFIC CONTROL PLAN
SR 158 AND COONPATH RD

DESIGN AGENCY



DESIGNER
SJK

REVIEWER
NSP 07/10/23


PROJECT ID
111621

SHEET	TOTAL
P.98	102

HORIZONTAL
SCALE IN FEET

A horizontal scale bar with alternating black and white segments. The segments are labeled 0, 20, 40, and 80. The bar is oriented vertically in the image.

- LEGEND:**
- 35' LIGHT POLE WITH TYPE II LED LUMINAIRE
 - 1-1/2" DUCT CABLE WITH THREE NO. 6 AWG 2400 VOLT CABLES, (TYPICAL, UNLESS NOTED)
 - 3" CONDUIT, 725.04 WITH 3 WIRE NO. 6 AWG 2400 VOLT CABLES, 2 CONDUCTORS, 120/240 VOLT, WITH GROUND
 - STUB AND CAP CONDUIT ELL
 - POWER SERVICE/LCC SINGLE PHASE, 3-WIRE (2 CONDUCTORS, 120/240V, WITH GROUND)
 - PULL BOX

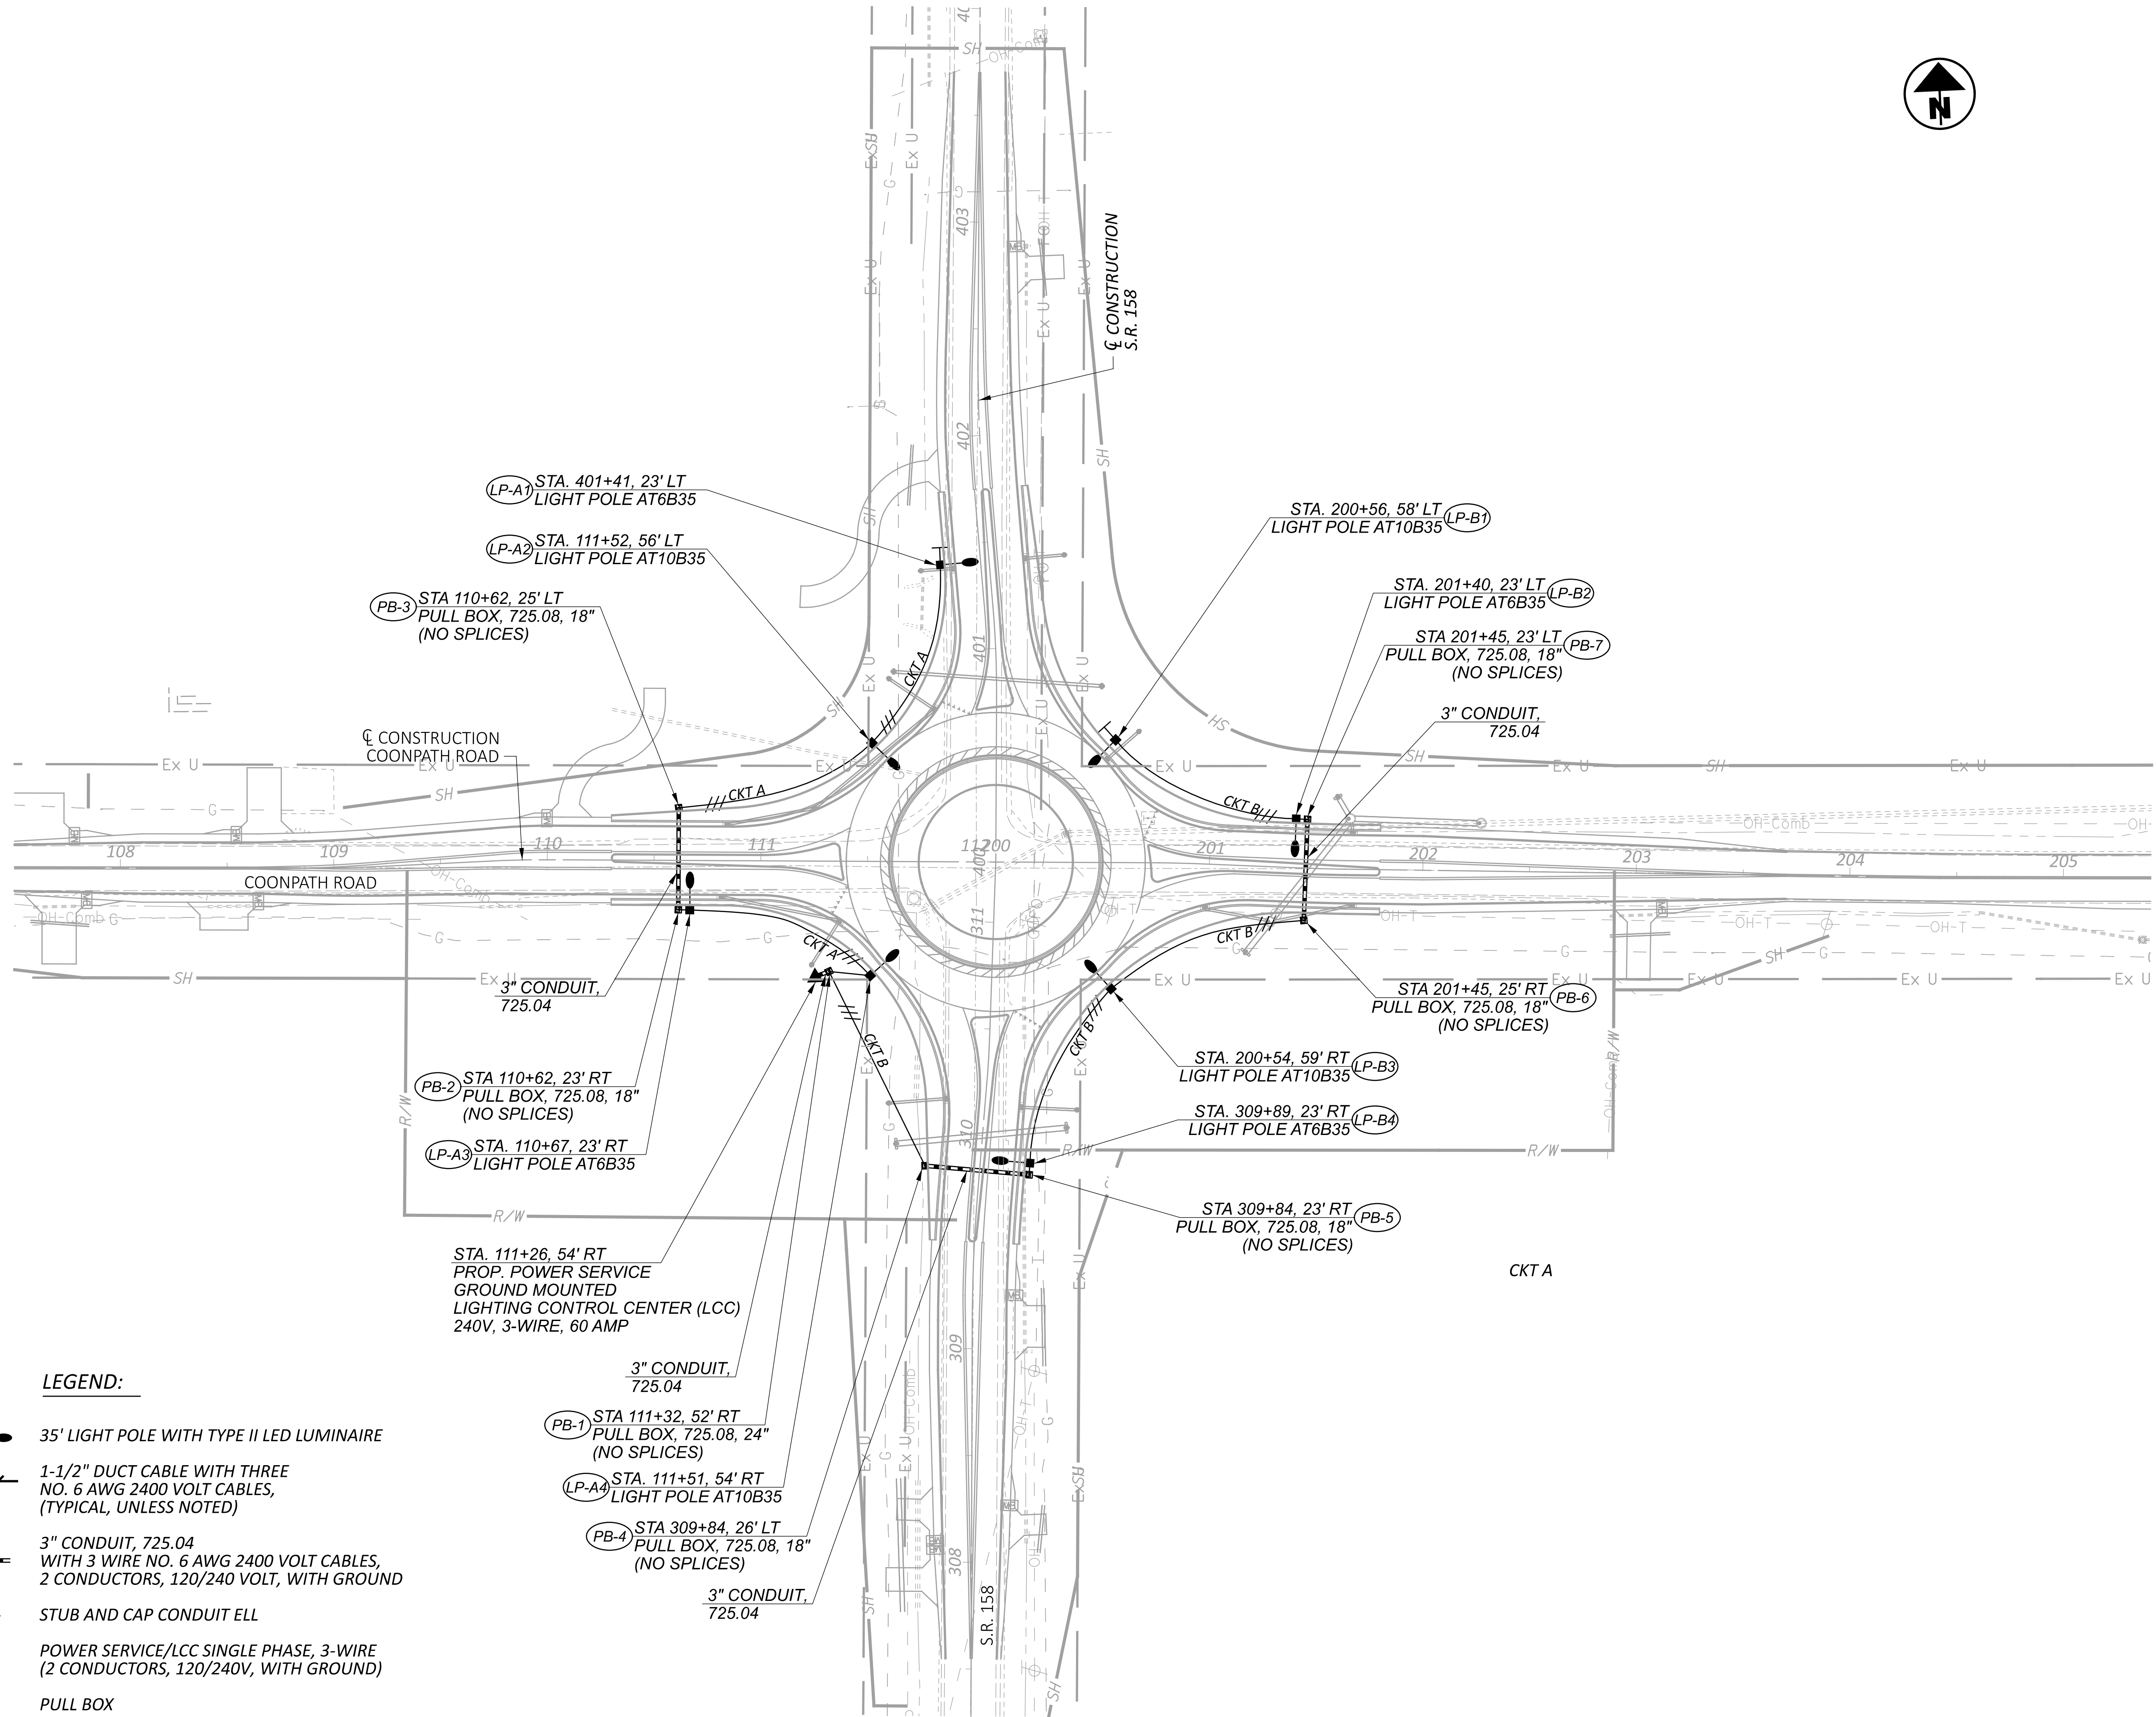

LIGHTING PLAN

DESIGN AGENCY

AECOM

DESIGNER

CX

REVIEWER

TS 07-23-23

PROJECT ID


111621

SHEET

P.100

TOTAL

102

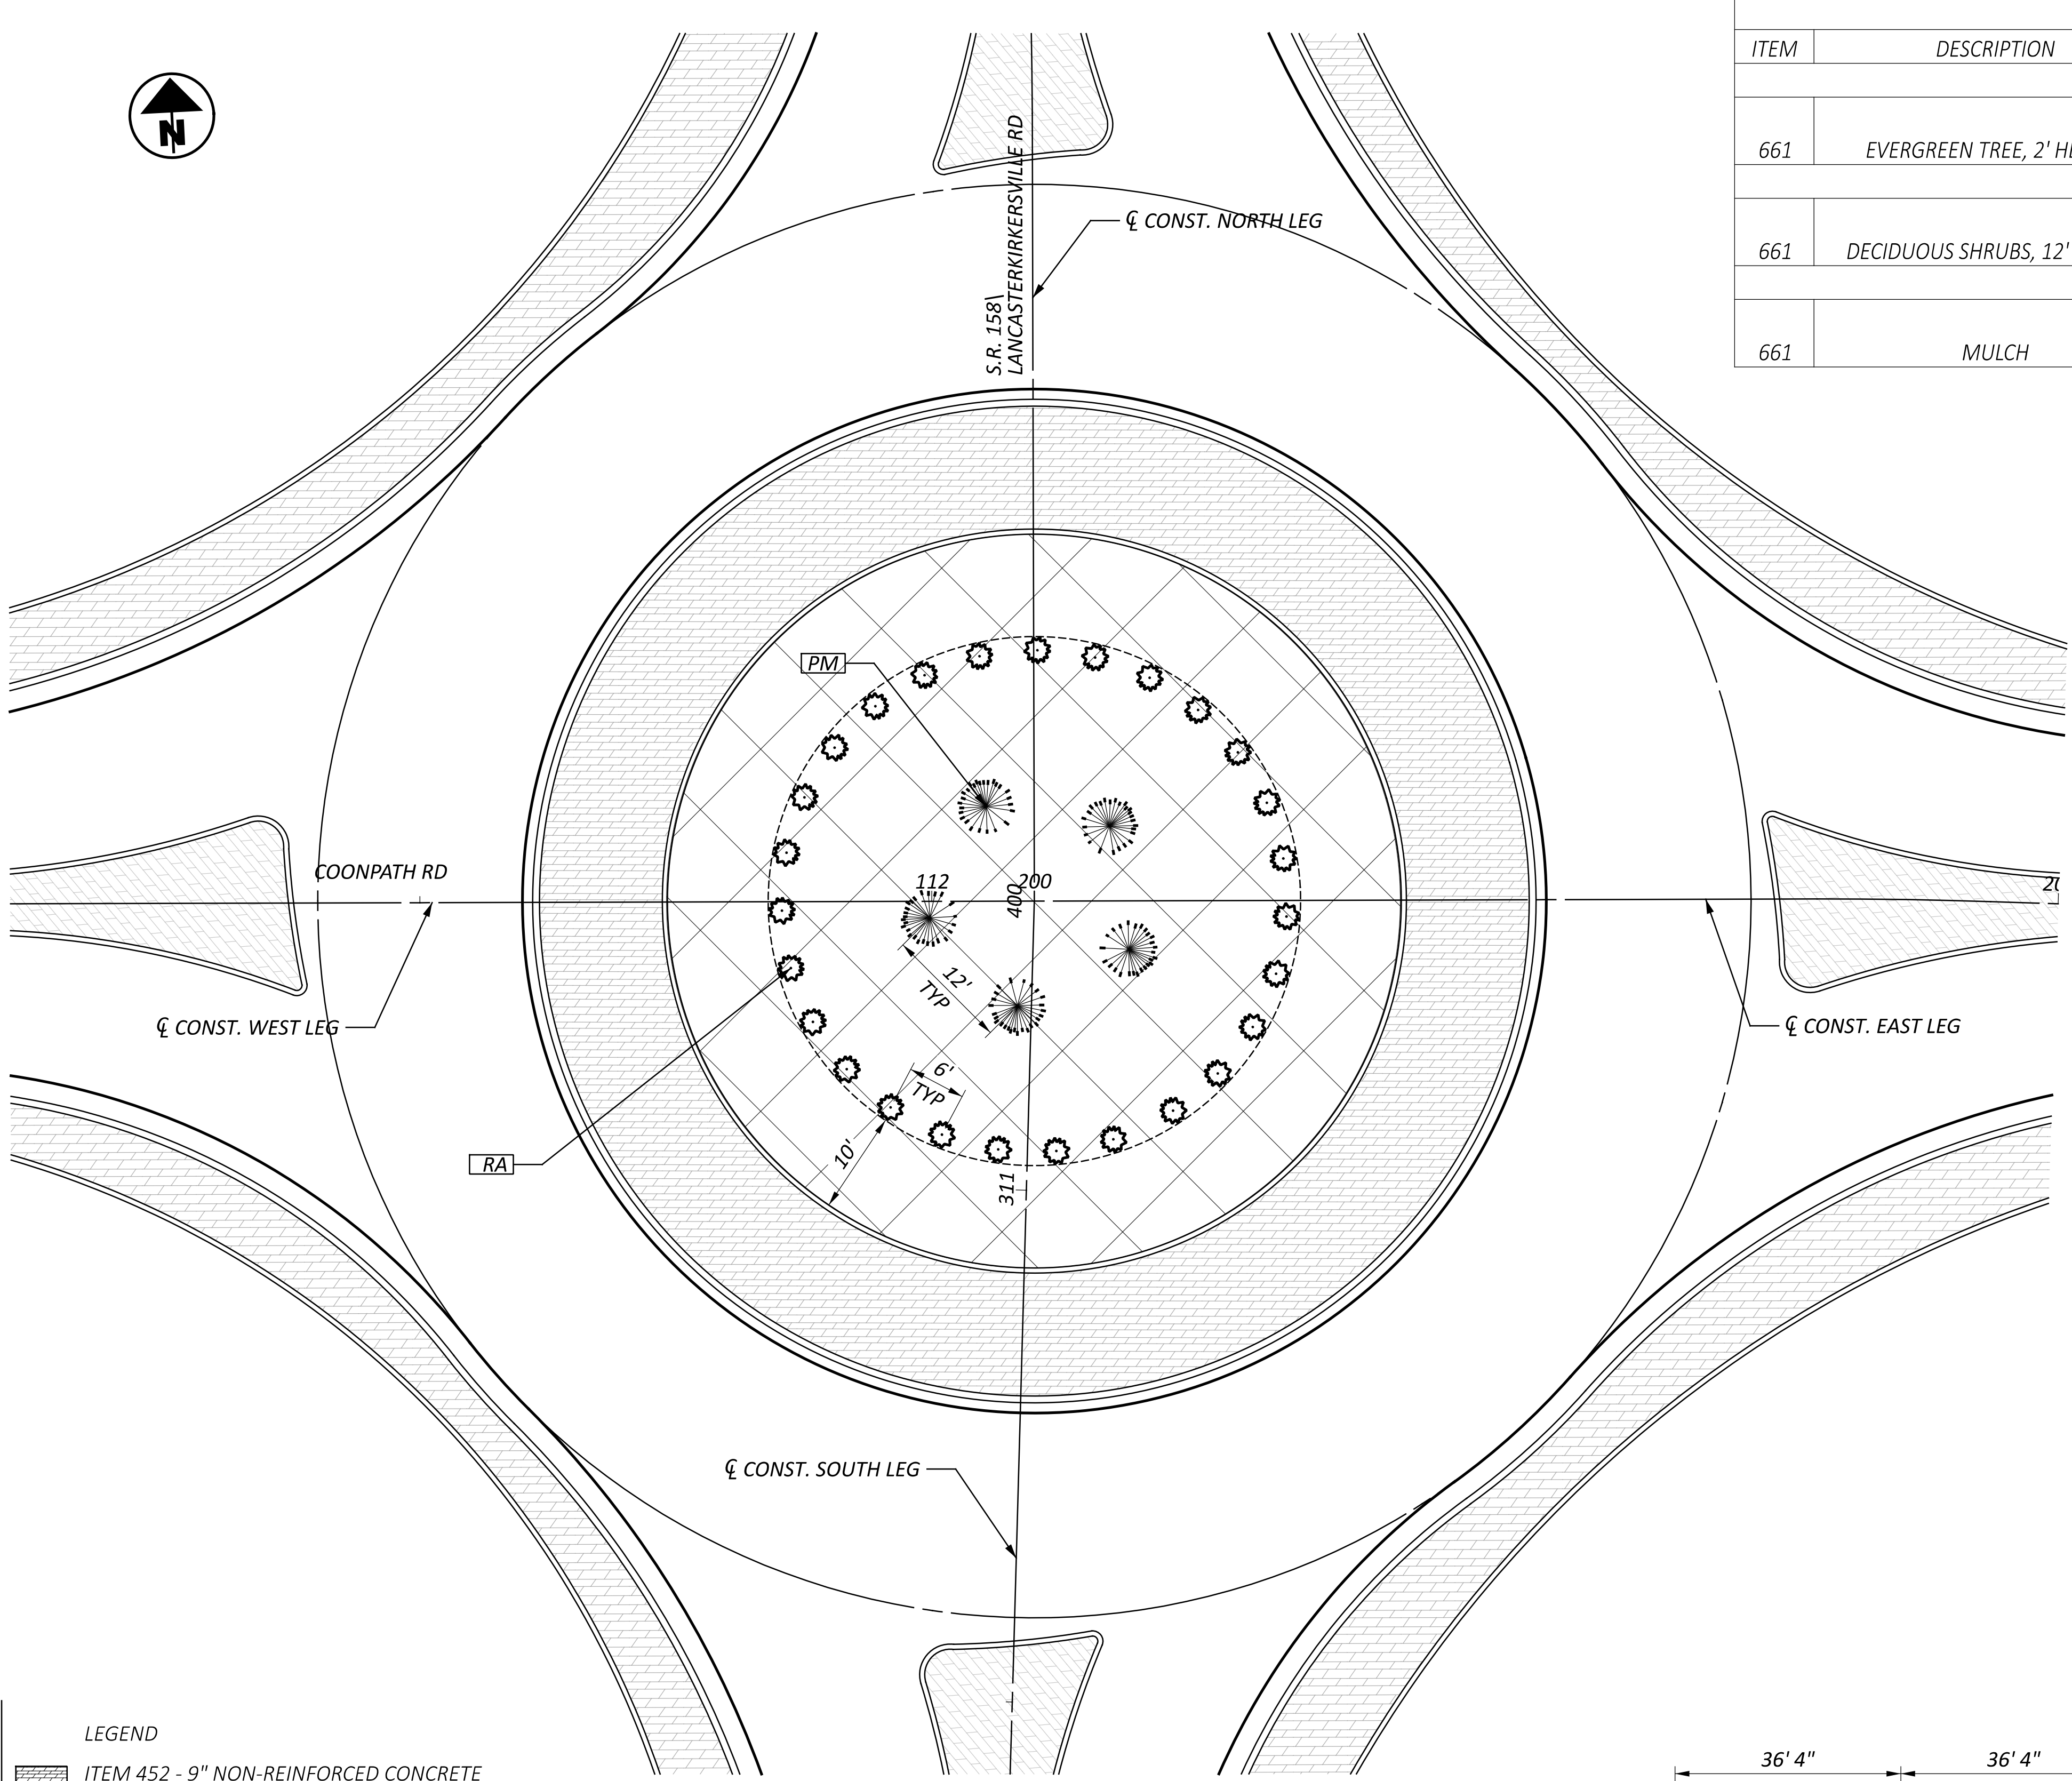

LEGEND

ITEM 452 - 9" NON-REINFORCED CONCRETE PAVEMENT, AS PER PLAN (TRUCK APRON)

ITEM 609 - 6" CONCRETE TRAFFIC ISLAND, AS PER PLAN (SPLITTER ISLAND)

ITEM 657 - RIPRAP FOR TREE PROTECTION AS PER PLAN, ITEM 204 - GEOTEXTILE FABRIC

ITEM 661 - DECIDUOUS SHRUB, 12" HEIGHT

ITEM 661 - EVERGREEN TREE, 2' HEIGHT

NOTE: FOR ALIGNMENT DATA, SEE SCHEMATIC PLAN

PLANTING SCHEDULE						
ITEM	DESCRIPTION	KEY	QTY	BOTNICAL NAME	COMMON NAME	PLANTING SIZE
TREES						
661	EVERGREEN TREE, 2' HEIGHT	PM	X	PINUS MUGO	MUGO PINE	X GAL
SHRUBS						
661	DECIDUOUS SHRUBS, 12' HEIGHT	RA	X	RHUS AROMATICA	FRAGRANT SUMAC	X GAL
MULCH						
661	MULCH		XX CY	SHREDDED HARDWOOD BARK MULCH	MULCH	

HORIZONTAL SCALE IN FEET

0

5

10

20

LANDSCAPE PLAN
ROUNDBOUT

DESIGN AGENCY

AECOM

DESIGNER
VHP

REVIEWER
NSP 07/10/23

PROJECT ID
111621

SHEET
P.102

TOTAL
102