
 


ROADWAY LIGHTING FIXTURE SCHEDULE							
SYMBOL	DESCRIPTION	QUANTITY	LLF	COLOR	MOUNTING	CONFIG.	CATALOG NO. & NOTES
	1882 LIGHTING LED SARATOGA HISTORIC POST TOP LUMINAIRE, TYPE III DISTRIBUTION, 37 WATT 14'-0" MOUNTING HEIGHT	15	0.90	4000K	12'-10" 1882 LIGHTING DLP 193 DECORATIVE ALUMINUM POLE, BLACK WITH GFCI OUTLET, 2 BANNER ARMS AND FLAG HOLDER	1 FIXTURE	FIXTURE: SRT3-3-5-QF-1X37-U-4K-B POLE:DLP-193-4-14'-F-125-T300-GFCI-(FH-BO)-FPH-BK

LEGEND


- E
- PROPOSED STREET LIGHTING CABLE AND CONDUIT (SEE CABLE AND CONDUIT LEGEND)


JBGFCI

MAIN STREET.A.1 STREET NAME. LIGHT POLE CIRCUIT NO

(C-1) OUTLET CIRCUIT - OUTLET NO

CABLE AND CONDUIT LEGEND

- A
- UNIT DUCT, 600V, 2-1C NO.4, 3-1C NO.4 AND 1/C NO. 4 GROUND, (XLP-TYPE-USE), 2" DIA, POLYETHYLENE

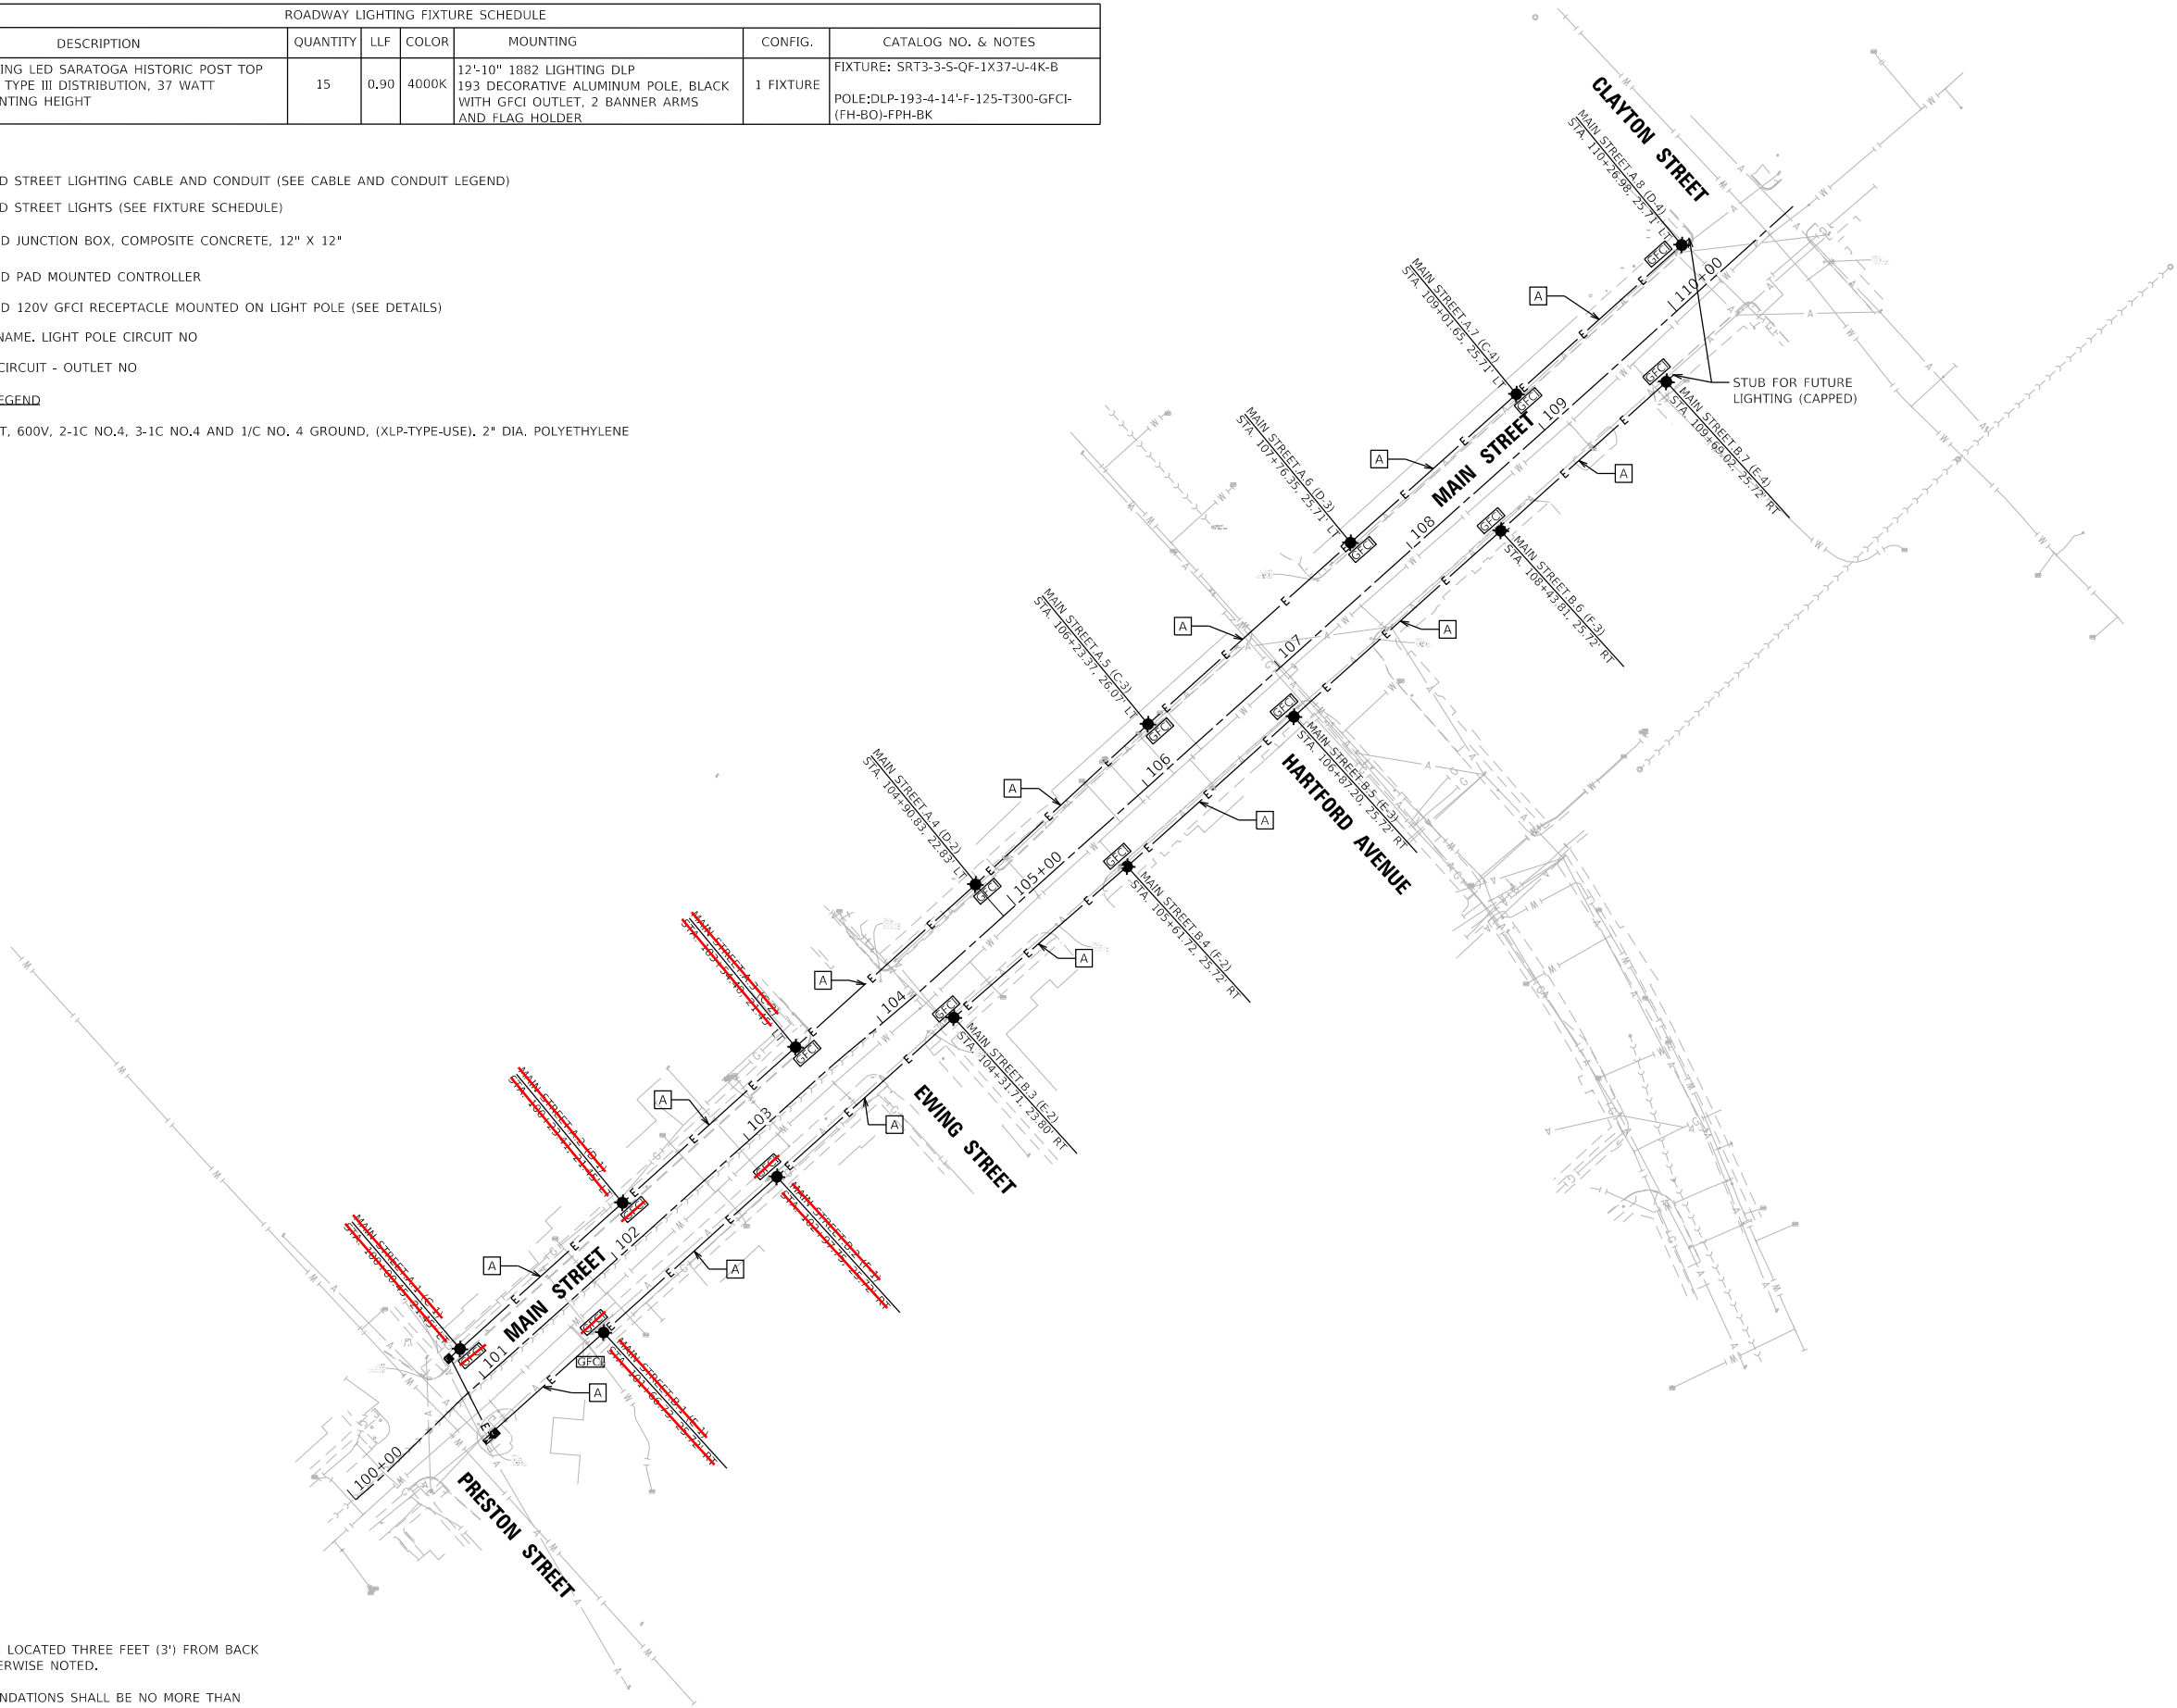

NOTES:

1. LIGHT POLES SHALL BE LOCATED THREE FEET (3') FROM BACK OF CURB UNLESS OTHERWISE NOTED.
2. THE TOP OF POLE FOUNDATIONS SHALL BE NO MORE THAN THREE INCHES (3") ABOVE FINISHED GRADE.

MODEL: Default  
FILE NAME: N:\2024\240188\Drawings\Main\CADD\_Sheets\240188-sh-lighting01.dgn



V3 Companies  
7325 Janes Avenue  
Woodridge, IL 60517  
630.724.9200 phone  
630.724.9202 fax  
www.v3co.com

USER NAME	= amuro
PLOT SCALE	= 100'
PLOT DATE	= 1/13/2025

DESIGNED	-
DRAWN	-
CHECKED	-
DATE	-

REVISED	-
REVISED	-
REVISED	-
REVISED	-

REVISED	-
REVISED	-
REVISED	-
REVISED	-

MAIN STREET LIGHTING IMPROVEMENTS

CENTERBURG

OHIO

STREET LIGHTING AND ELECTRICAL PLAN

SCALE: 1"=50'

SHEET 1 OF 1 SHEETS STA. TO STA.

COUNTY	TOTAL SHEETS	SHEET NO.
KNOX	9	6

PROJECT NO. 240188