


# STATE OF OHIO DEPARTMENT OF TRANSPORTATION

## GRE-68-12.65


XENIA TOWNSHIP  
GREENE COUNTY

### BUILDABLE UNIT #3 AND #4

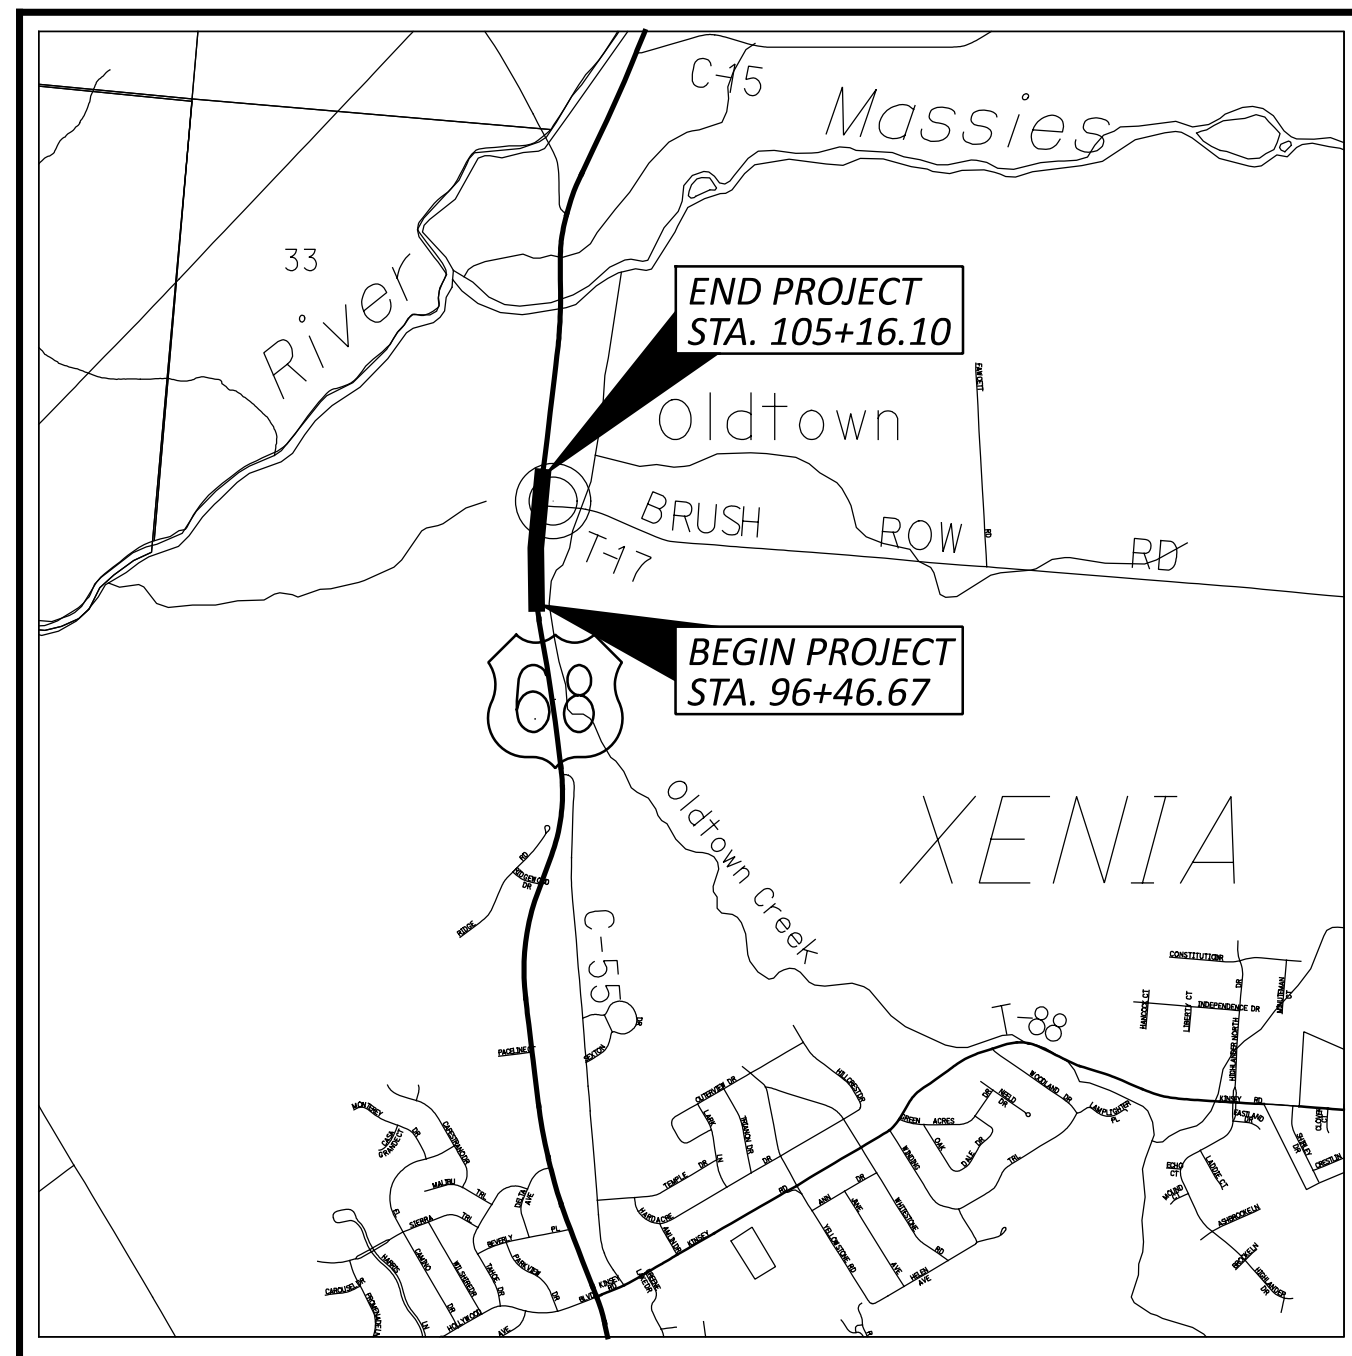

LOCATION MAP

LATITUDE: 39 °43'46" LONGITUDE: 83 °56'12"

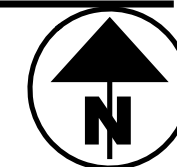

PORTION TO BE IMPROVED	=====
INTERSTATE HIGHWAY	=====
FEDERAL ROUTES	=====
STATE ROUTES	=====
COUNTY & TOWNSHIP ROADS	=====
OTHER ROADS	=====

#### DESIGN DESIGNATION

CURRENT ADT (2024)	8600
DESIGN YEAR ADT (2044)	8800
DESIGN HOURLY VOLUME (2044)	1200
DIRECTIONAL DISTRIBUTION	50%
TRUCKS (24 HOUR B&C)	7%
DESIGN SPEED	45 MPH
LEGAL SPEED	45 MPH
DESIGN FUNCTIONAL CLASSIFICATION: PRINCIPAL ARTERIAL URBAN	
NHS PROJECT	YES

#### DESIGN EXCEPTIONS

NONE

#### ADA DESIGN WAIVERS

NONE

**UNDERGROUND UTILITIES**  
Contact Two Working Days  
Before You Dig

  
**OHIO811.org**  
Before You Dig

**OHIO811. 8-1-1. or 1-800-362-2764**  
(Non members must be called directly)

PLAN PREPARED BY:



#### INDEX OF SHEETS:

TITLE SHEET	1
TYPICAL SECTIONS	2-4
GENERAL NOTES	5-6
MOT PLANS AND DETOUR ROUTES	7-14
PLAN AND PROFILE - U.S. 68	15-17
CROSS SECTIONS - U.S. 68	18-25
PLAN AND PROFILE - LITTLE MIAMI SCENIC TRAIL	26
CROSS SECTIONS - LITTLE MIAMI SCENIC TRAIL	27-29
PLAN AND PROFILE - RAMP	30
HANDRAIL DETAIL	31
INTERSECTION DETAIL - U.S. 68 AND BRUSH ROW ROAD	32
INTERSECTION DETAIL - SHARED USE PATH AND LMST	33
CURB RAMP DETAILS	34
GRADING DETAIL	35
DRIVEWAY DETAILS	36-42
STORM SEWER PROFILES	43-44
TRENCH DRAIN DETAIL	45
FIRE HYDRANT SETTING DETAILS	46
BRIDGE DETAILS	47-73
WALL DETAILS	74-85
TRAFFIC CONTROL PLAN	86-89
LIGHTING PLANS	90-92
GEOTECHNICAL PLAN	93-107

**FINAL SUBMITTAL  
DATE: 03/31/2025**

ENGINEER'S SEAL:		STANDARD CONSTRUCTION DRAWINGS								SUPPLEMENTAL SPECIFICATIONS		SPECIAL PROVISIONS		
ROADWAY		BP-4.1	07/19/13	TC-41.20	10/18/13	MT-101.60	01/17/25	CB-2-2B	07/19/24	EXJ-6-17	01/19/24	800	07/19/24	WATERWAY PERMITS CONDITIONS
		BP-5.1	01/17/25	TC-41.30	04/21/23	MT-110.10	07/19/13	CB-3	07/19/24			813	07/21/23	02/25/25
		BP-7.1	01/17/25	TC-42.20	10/18/13	MT-102.20	07/21/23	CB-3A	07/19/24	PSID-1-13	07/19/24	825	10/20/23	
ENGINEER'S SEAL:				TC-52.10	10/18/13	MT-105.10	01/17/23			GSD-1-19	07/19/24	832	07/19/24	
	STRUCTURE			RM-2.1	07/19/13	TC-52.20	01/15/21	MT-97.10	04/19/19	MH-3	07/19/24	839	07/16/21	
					RM-5.2	07/21/23	TC-65.10	01/17/14	MT-101.90	07/17/20			913	04/16/21
				TC-65.11	01/17/25			HW-2.1	07/15/22			939	01/17/20	
				HL-30.11	07/21/23	TC-71.10	04/21/23			HW-2.2	07/20/18			
				HL-30.22	01/17/25	TC-74.10	07/21/23							
				HL-30.31	01/17/25	TC-83.20	07/19/24			DM-4.3	01/17/25			
				HL-40.20	01/17/25	TC-87.10	01/17/25			DM-4.3	04/15/16			
				HL-50.21	07/15/22					DM-4.4	04/15/16			
				HL-60.31	07/19/24									

#### PROJECT DESCRIPTION

PROPOSED IMPROVEMENTS SHALL FOCUS ON THE CONSTRUCTION OF A GRADE SEPARATED CROSSING, CONNECTING THE LITTLE MIAMI SCENIC TRAIL WITH THE NEW SHAWNEE INTERPRETIVE CENTER. ADDITIONAL AT-GRADE CROSSING IMPROVEMENTS ARE TO BE INSTALLED AT THE US 68 AND BRUSH ROW INTERSECTION, LOCATED APPROXIMATELY 400 FEET NORTH OF THE SHAWNEE INTERPRETIVE CENTER. THE PEDESTRIAN FACILITIES, WITHIN THE DEFINED PROJECT LIMITS OF THE US 68 ROADWAY CORRIDOR WILL ALSO BE UPGRADED.

#### EARTH DISTURBED AREAS

PROJECT EARTH DISTURBED AREA:	2.08 ACRES
ESTIMATED CONTRACTOR EARTH DISTURBED AREA:	0.50 ACRES
NOTICE OF INTENT EARTH DISTURBED AREA:	2.58 ACRES

#### 2023 SPECIFICATIONS

THE STANDARD SPECIFICATIONS OF THE STATE OF OHIO, DEPARTMENT OF TRANSPORTATION, INCLUDING SUPPLEMENTAL SPECIFICATIONS LISTED IN THE PLANS, CHANGES LISTED IN THE PROPOSAL, AND THE SUPPLEMENTAL SPECIFICATION 800 VERSION INDICATED ON THE PROPOSAL SHALL GOVERN THIS IMPROVEMENT.

I HEREBY APPROVE THESE PLANS AND DECLARE THAT THE MAKING OF THIS IMPROVEMENT WILL REQUIRE THE CLOSING TO TRAFFIC OF THE HIGHWAY AND THAT DETOURS WILL BE PROVIDED AS INDICATED ON SHEET P.13 .

TITLE SHEET

GRE-68-12.65

MODEL: Sheet\_SurvFl\_PAPER SIZE: 34x42 (in.) DATE: 3/31/2025 TIME: 4:25:46 PM USER: wshannon P:\DBP\EG003\_GRE-68-12.65\15388\00-Engineering\Roadway\Sheets\15388\_GT001.dgn

DESIGN AGENCY



DESIGNER

CEF

REVIEWER

BAA 03/28/25

PROJECT ID


115388

SHEET TOTAL


P.01 P.107

**LEGEND**



- ① ITEM 204 - PROOF ROLLING
  - ② ITEM 204 - SUBGRADE COMPACTION
  - ③ ITEM 254 - 1/2" PAVEMENT PLANING
  - ④ ITEM 301 - 10" A.C. BASE, PG64-22, (449)
  - ⑤ ITEM 304 - 4" AGGREGATE BASE
  - ⑥ ITEM 304 - 6" AGGREGATE BASE
  - ⑦ ITEM 407 - NON-TRACKING TACK COAT
  - ⑧ ITEM 441 - 1/2" A.C. SURFACE COURSE, TYPE 1 (448), PG64-22
  - ⑨ ITEM 441 - 2" A.C. INTERMEDIATE COURSE, TYPE 2 (448)
  - ⑩ ITEM 530 - RETAINING WALL
  - ⑪ ITEM 605 - 6" BASE PIPE UNDERDRAIN
  - ⑫ ITEM 608 - 4" CONCRETE WALK
  - ⑬ ITEM 608 - 6" CONCRETE WALK
  - ⑭ ITEM 609 - 6" CURB, TYPE 6
  - ⑮ ITEM 659 - SEEDING AND MULCHING
  - ⑯ ITEM 517 - PEDESTIAN AND BICYCLE RAILING
  - ⑰ ITEM 204 - PROOF ROLLING
- (A) EXISTING COMPOSITE PAVEMENT
  - (B) EXISTING CONCRETE WALK
  - (C) EXISTING CURB
  - (D) EXISTING ALPHALT SHARED-USE PATH

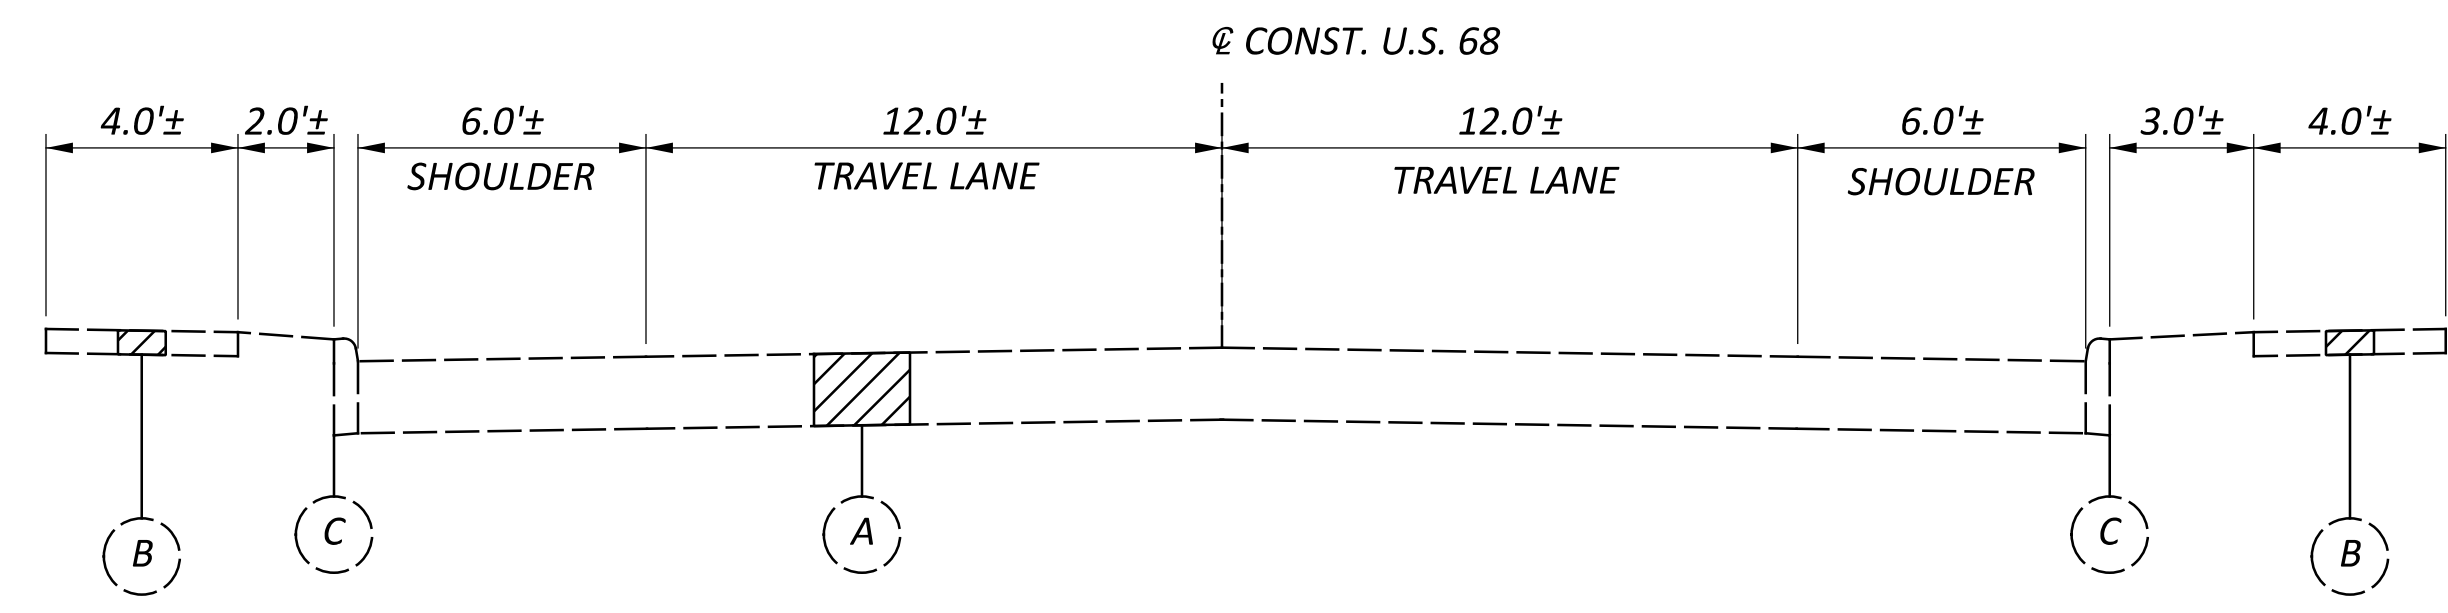


**EXISTING SECTION - U.S. 68**

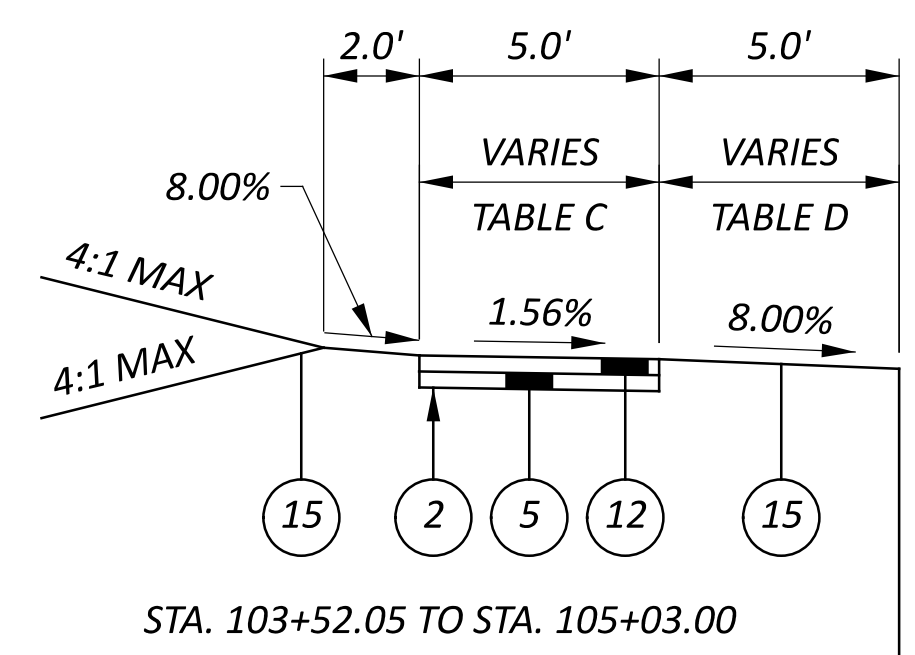

STA. 96+46.67 TO STA. 96+57.88

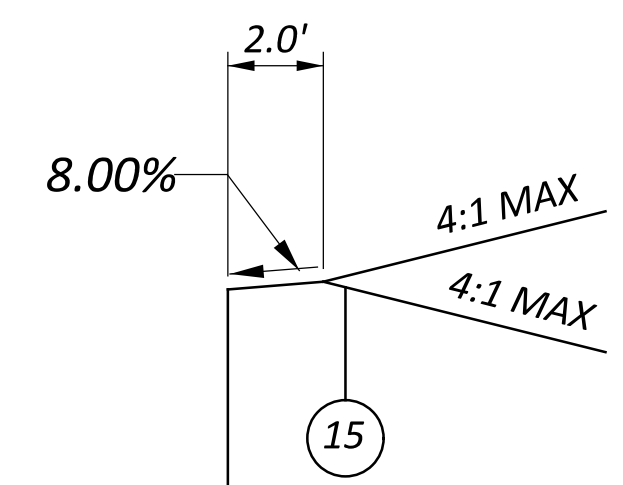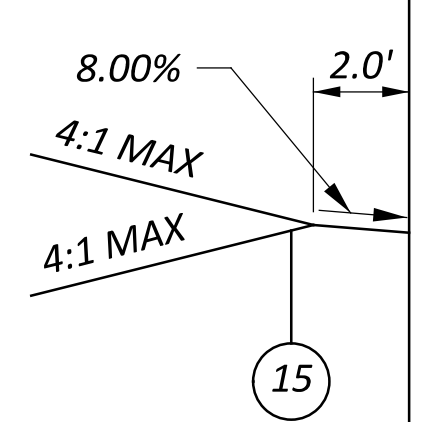

STA. 96+57.88 TO STA. 97+77.65

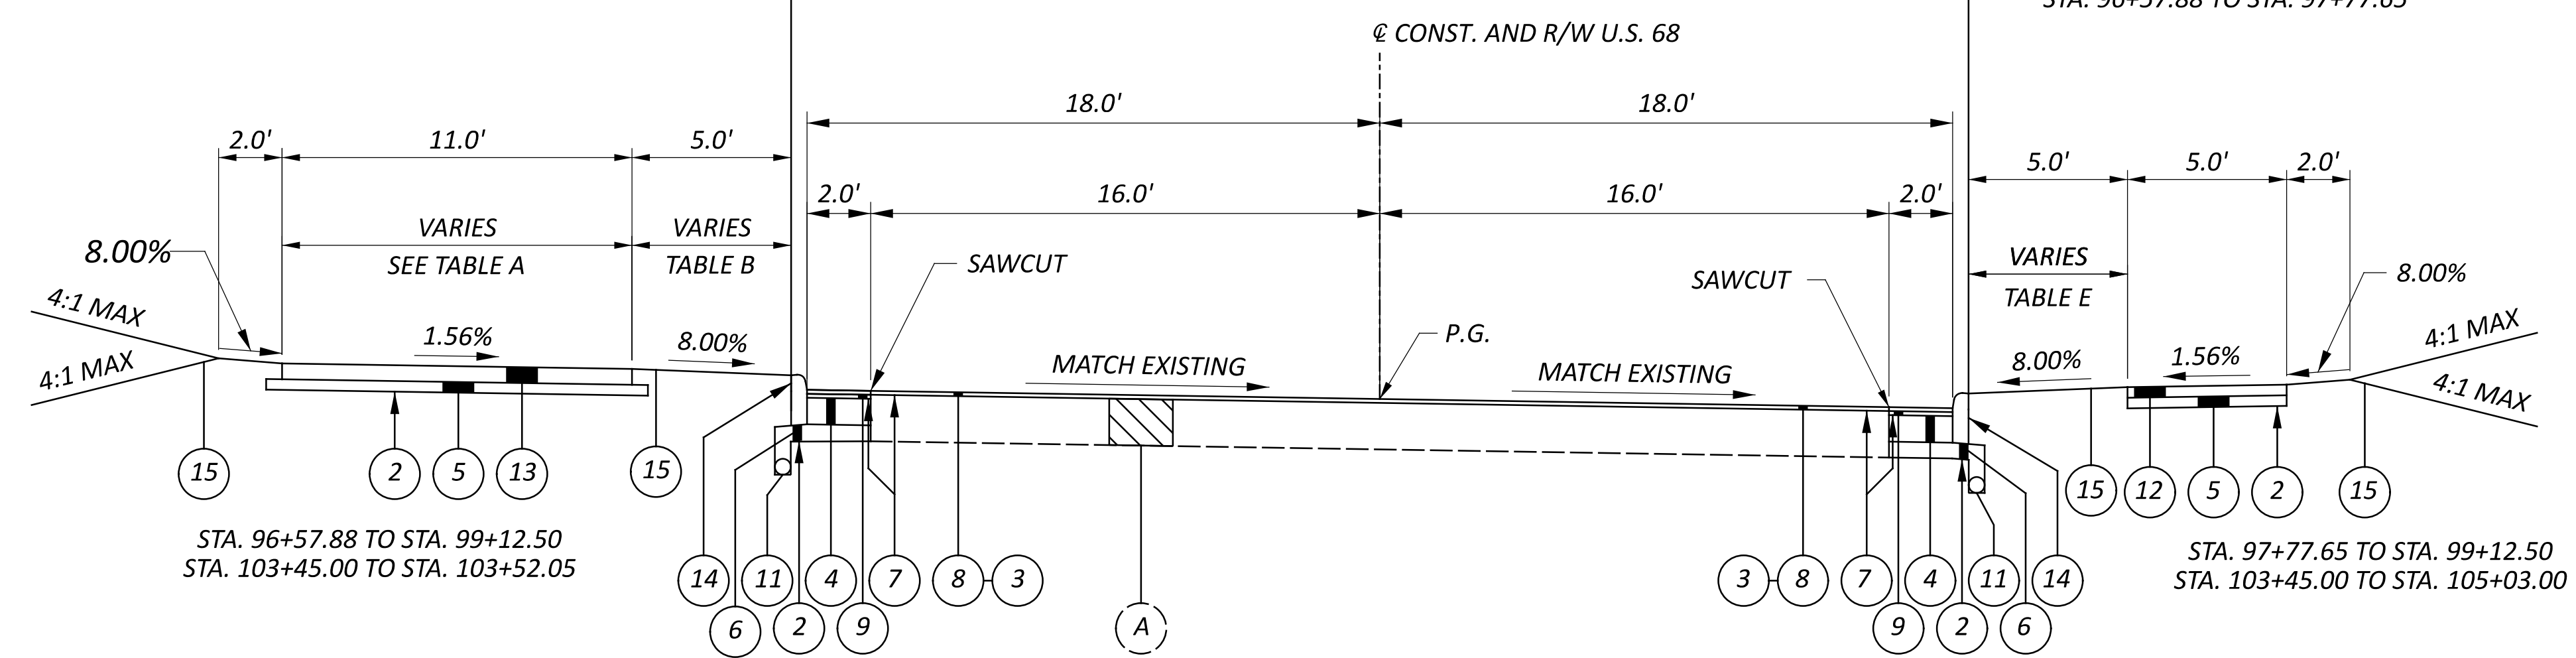

STA. 96+57.88 TO STA. 99+12.50  
 STA. 103+45.00 TO STA. 105+03.00


TABLE A	
STATION	PATH WIDTH
96+57.88 TO 99+00.80	10.0'
99+00.50 TO 99+22.00	10.0' TO 11.0'

TABLE B	
STATION	BUFFER WIDTH
96+57.88 TO 99+00.80	11.5'
99+00.80 TO 99+22.00	11.5' TO 8.8'
100+31.76 TO 100+93.00	8.8' TO 3.0'
100+93.00 TO 102+28.93	3.0'
102+28.93 TO 102+48.93	3.0' TO 5.0'

TABLE C	
STATION	WALK WIDTH
105+11.10 TO 105+16.10	5.0' TO 3.9'


TABLE D	
STATION	BUFFER WIDTH
104+66.10 TO 105+16.10	5.0' TO 2.6'

TABLE E	
STATION	BUFFER WIDTH
104+66.10 TO 105+16.10	5.0' TO 2.6'

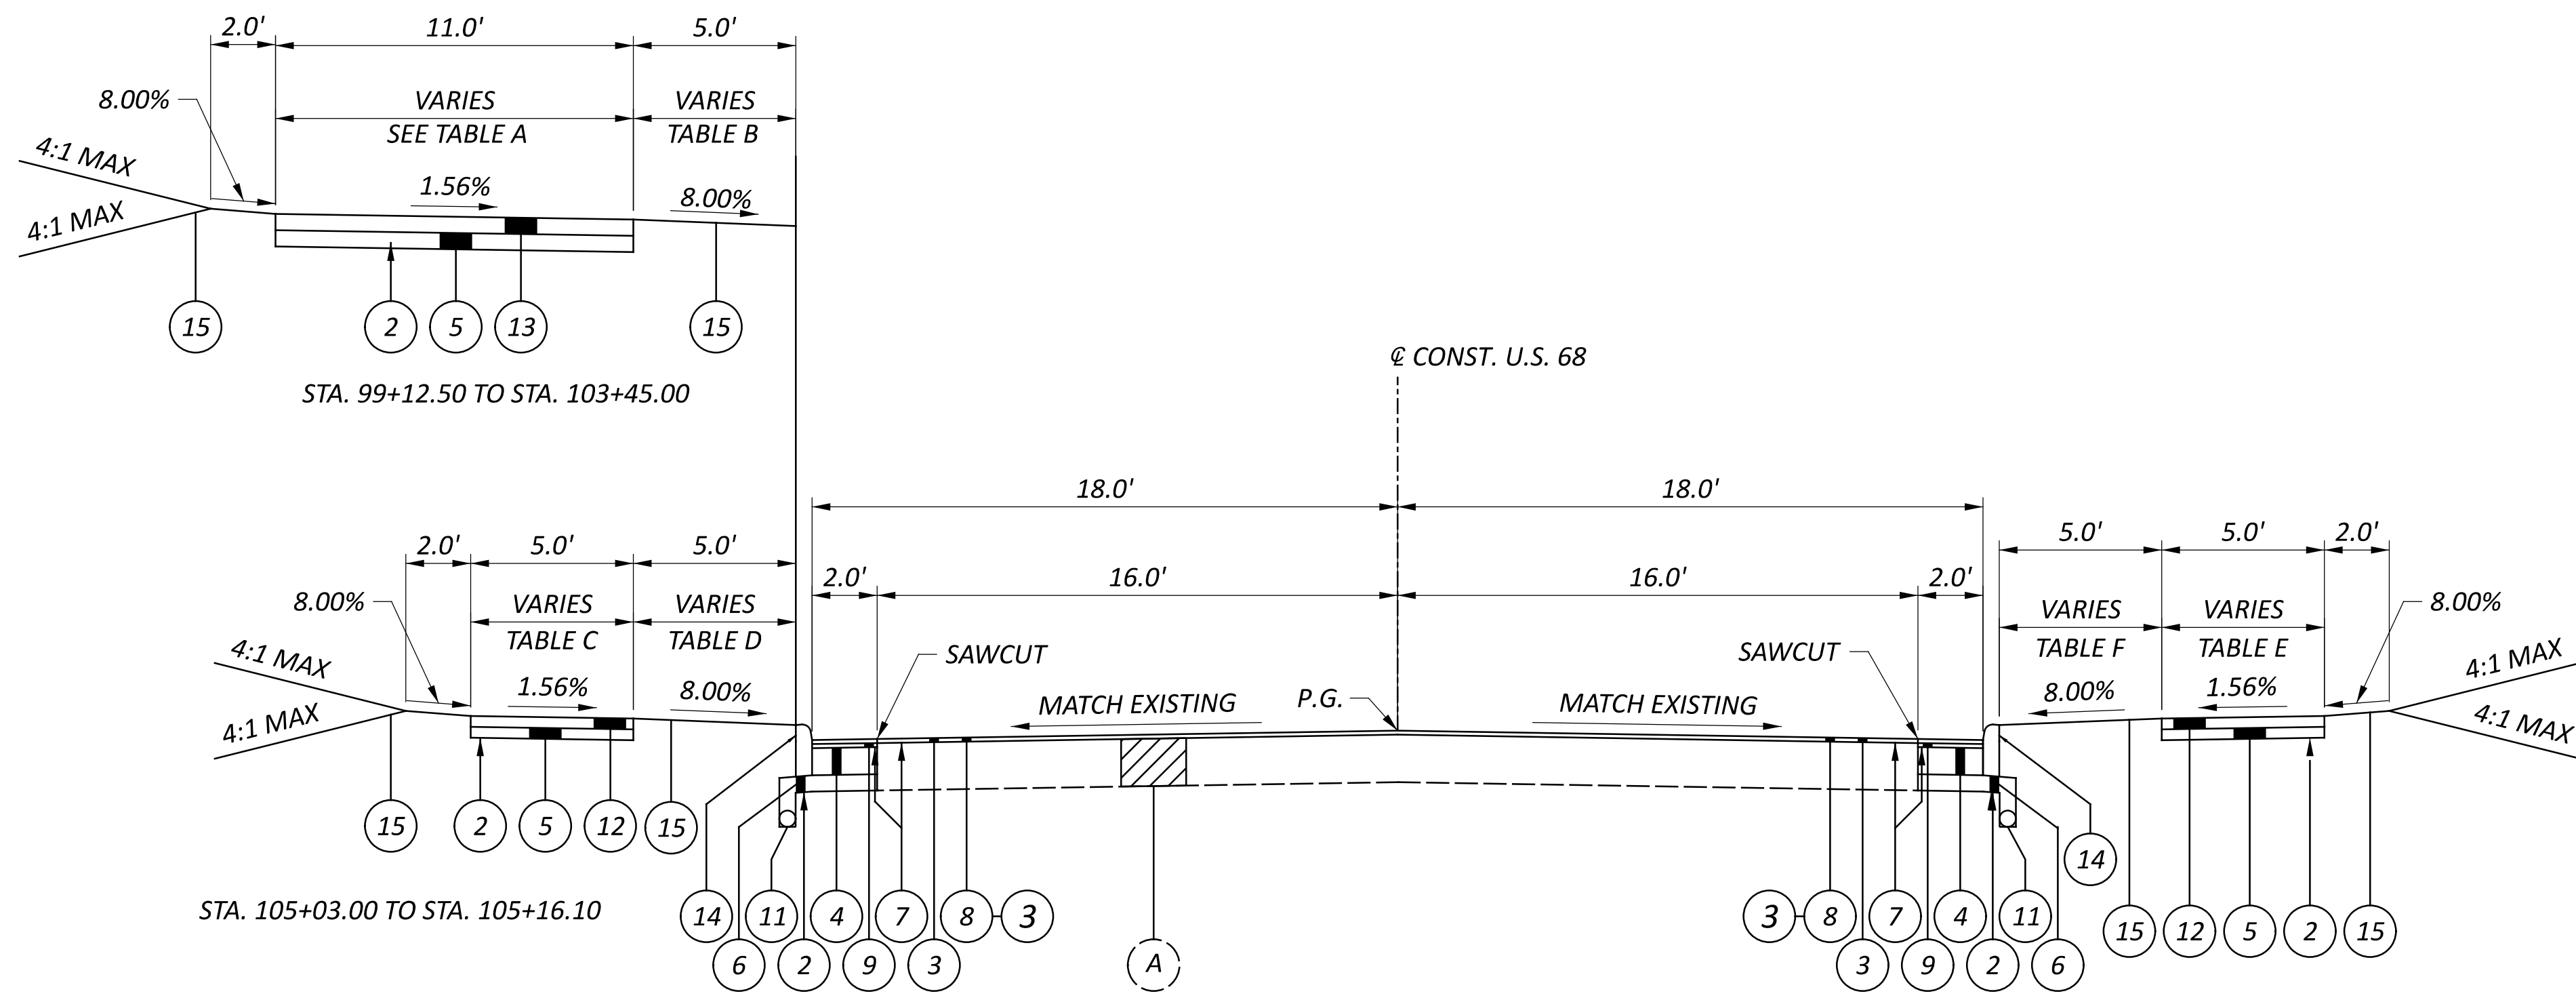


**NORMAL SECTION - U.S. 68**

STA. 99+12.50 TO STA. 103+45.00  
 STA. 105+03.00 TO STA. 105+16.10

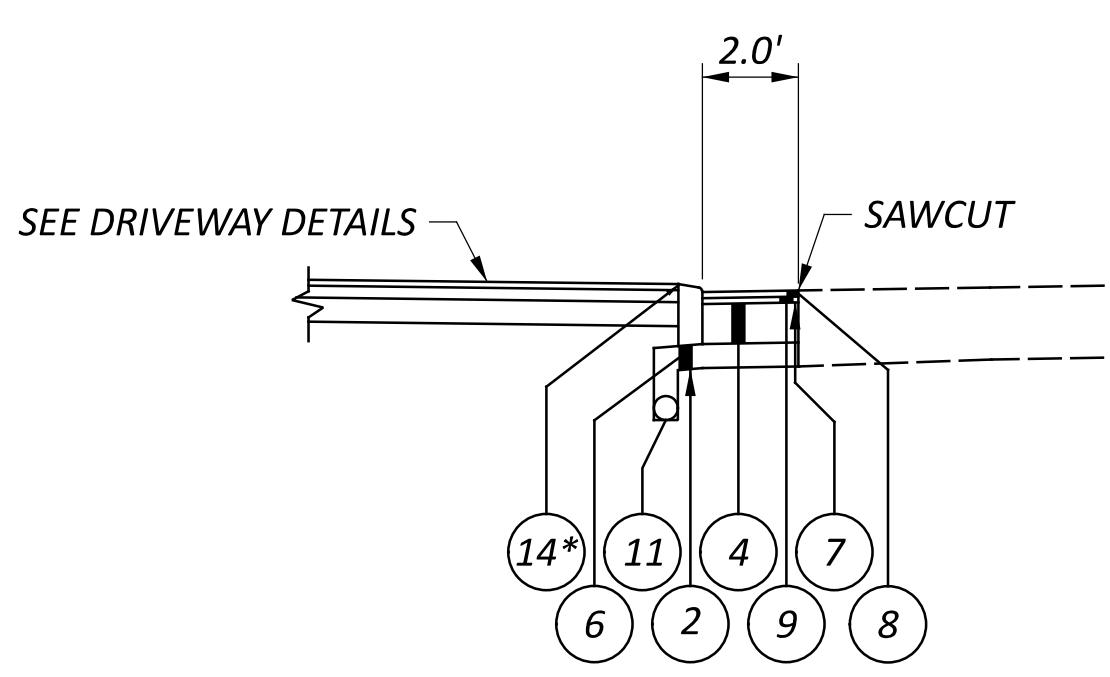


**CURB DETAIL - U.S. 68**

STA. 96+08.30 TO STA. 96+46.67  
 STA. 105+16.10 TO STA. 105+83.28

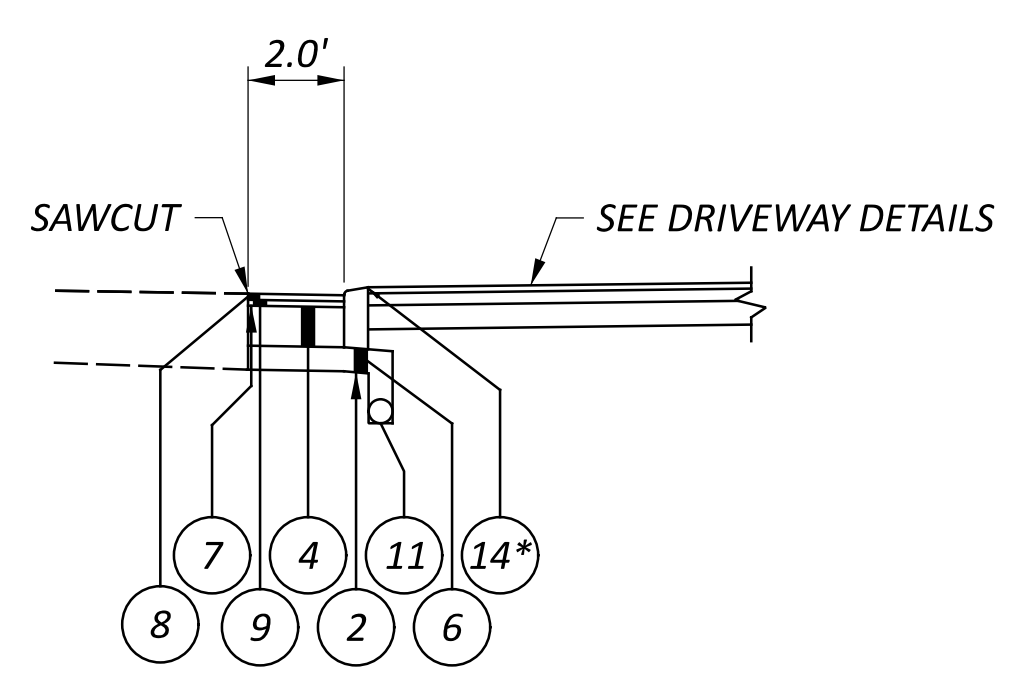


**CURB DETAIL - U.S. 68**

STA. 96+32.41 TO STA. 96+46.67

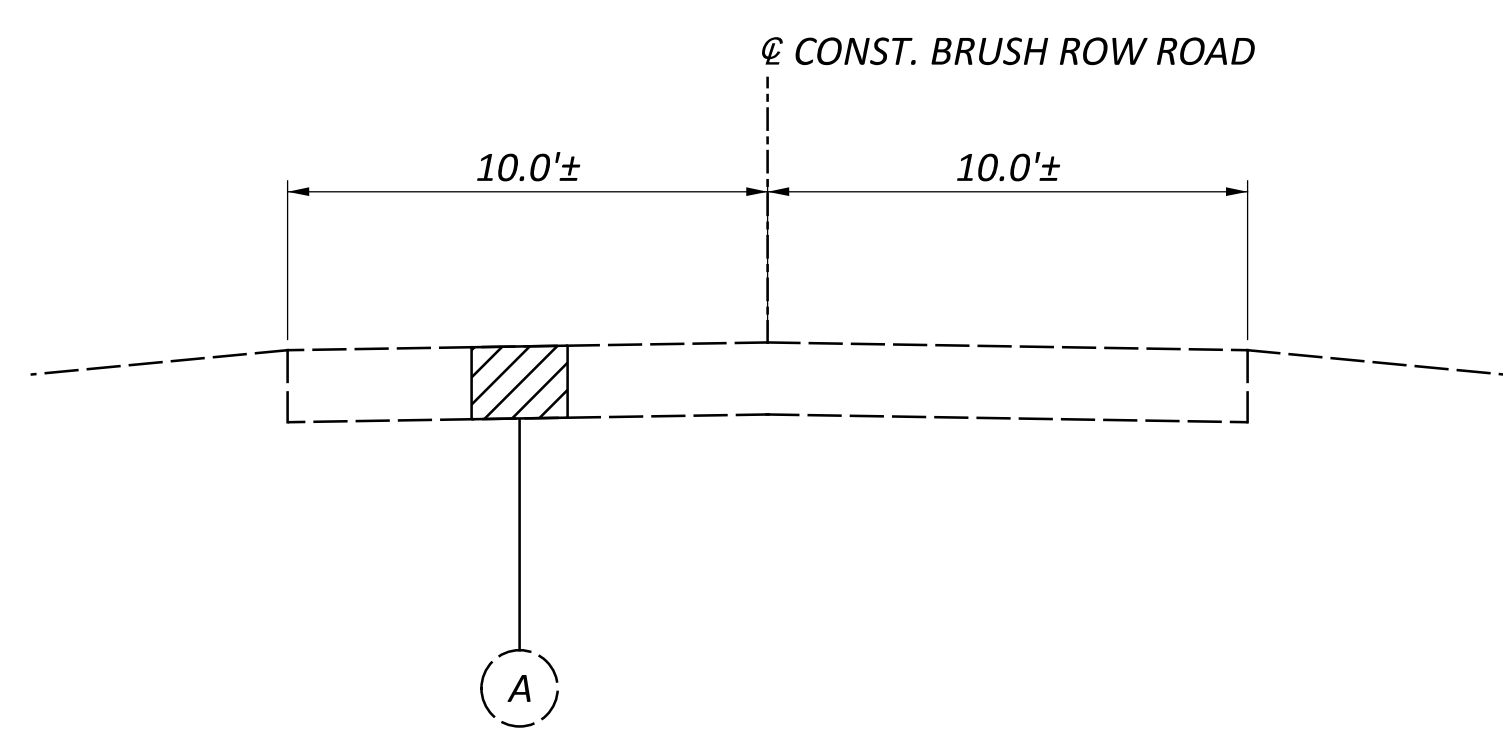

**EXISTING SECTION - BRUSH ROW ROAD**

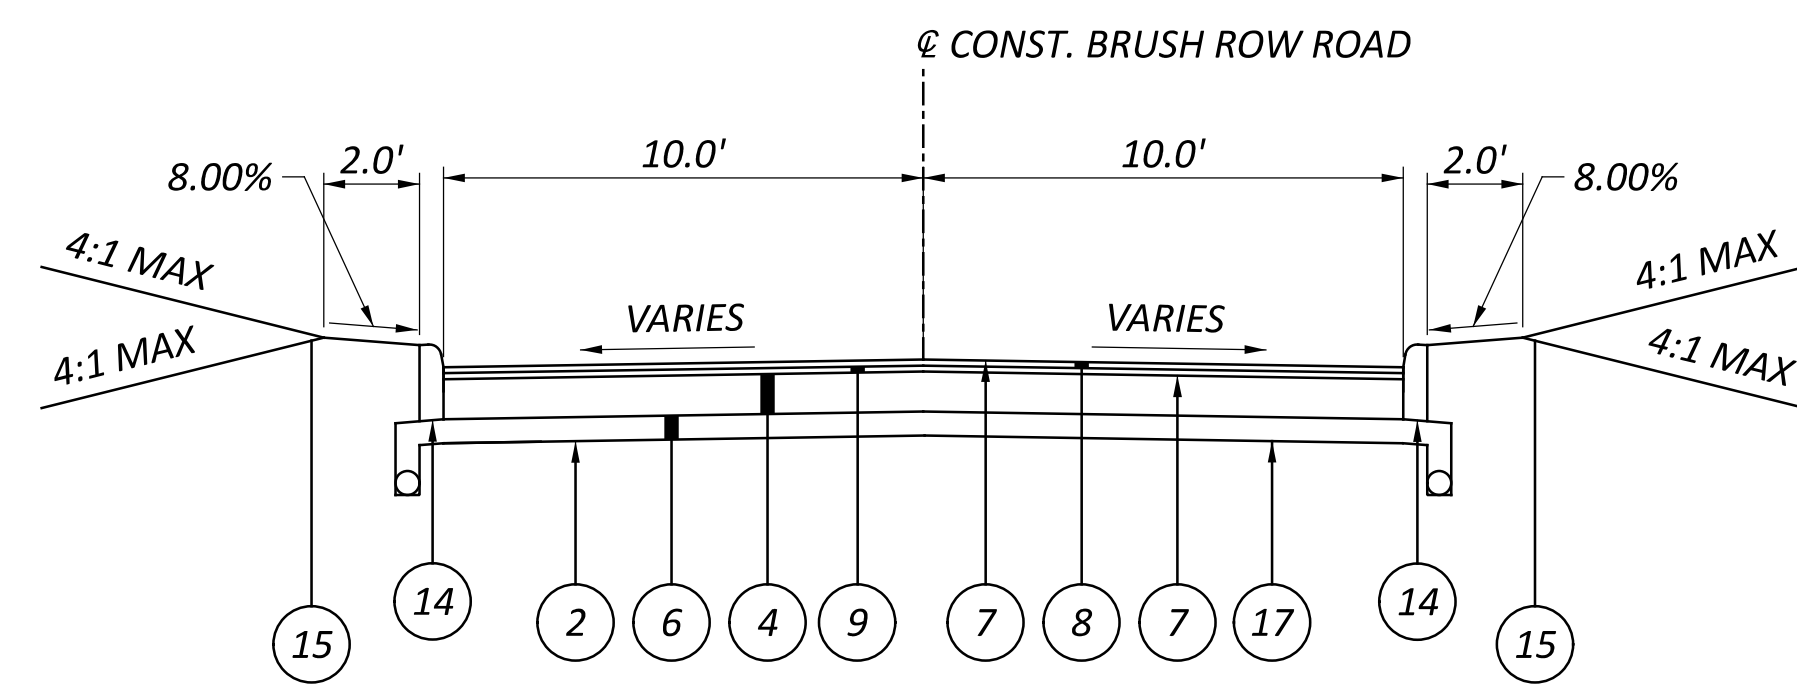

**TYPICAL SECTION - BRUSH ROW ROAD**

STA. 10+00.00 TO STA. 10+78.00

**NOTE:**  
 SEE SHEET P.02 FOR TYPICAL SECTION LEGEND.  
 \* = DROP CURB PER ODOT SCD BP-4.1


TABLE A	
STATION	PATH WIDTH
96+57.88 TO 99+00.80	10.0'
99+00.50 TO 99+22.00	10.0' TO 11.0'

TABLE B	
STATION	BUFFER WIDTH
96+57.88 TO 99+00.80	11.5'
99+00.80 TO 99+22.00	11.5' TO 8.8'
100+31.76 TO 100+93.00	8.8' TO 3.0'
100+93.00 TO 102+28.93	3.0'
102+28.93 TO 102+48.93	3.0' TO 5.0'


TABLE C	
STATION	WALK WIDTH
105+11.10 TO 105+16.10	5.0' TO 3.9'

TABLE D	
STATION	BUFFER WIDTH
104+66.10 TO 105+16.10	5.0' TO 2.6'

TABLE E	
STATION	BUFFER WIDTH
104+66.10 TO 105+16.10	5.0' TO 2.6'

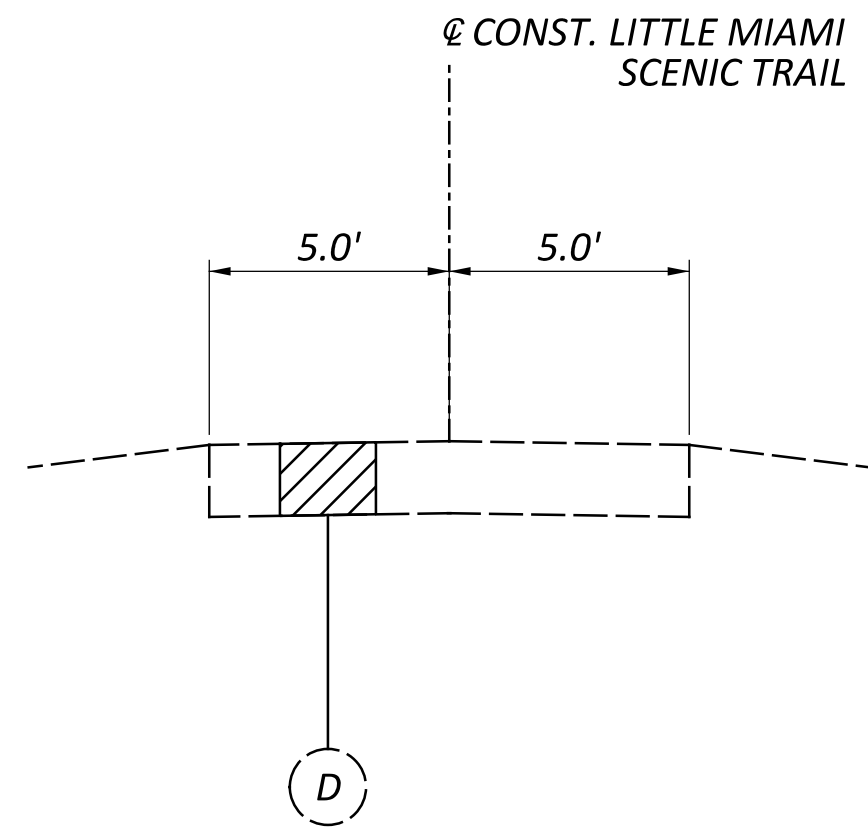


**EXISTING SECTION - LITTLE MIAMI SCENIC TRAIL**

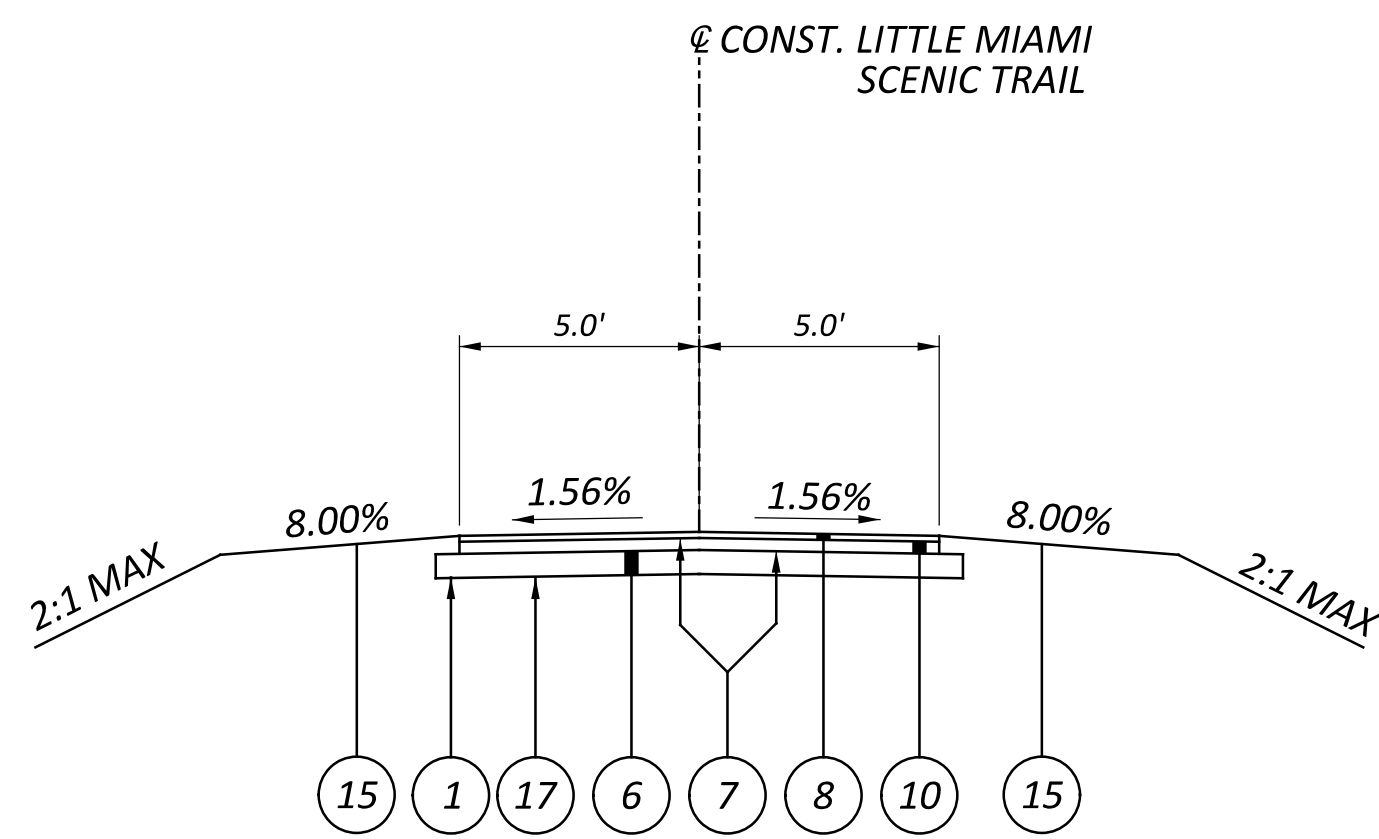


**TYPICAL SECTION - LITTLE MIAMI SCENIC TRAIL**

STA. 200+03.52 TO STA. 203+37.21

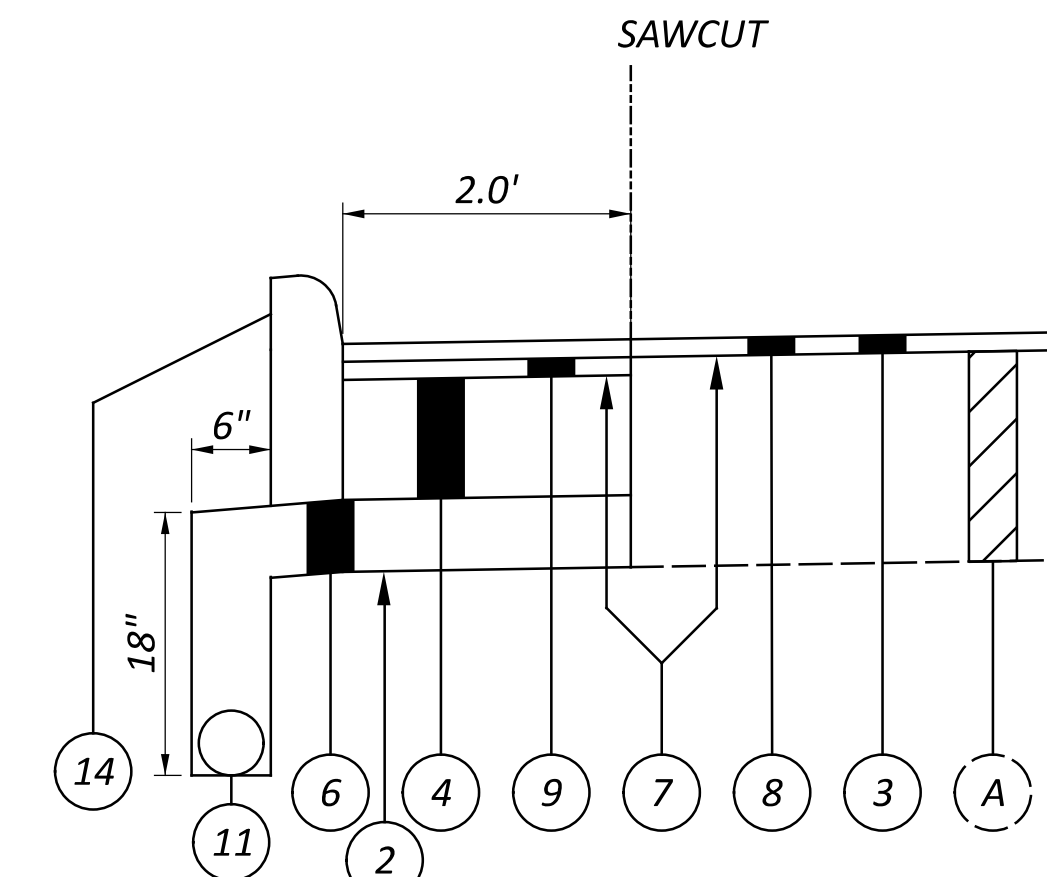


**FULL DEPTH PAVEMENT BUILDUP**

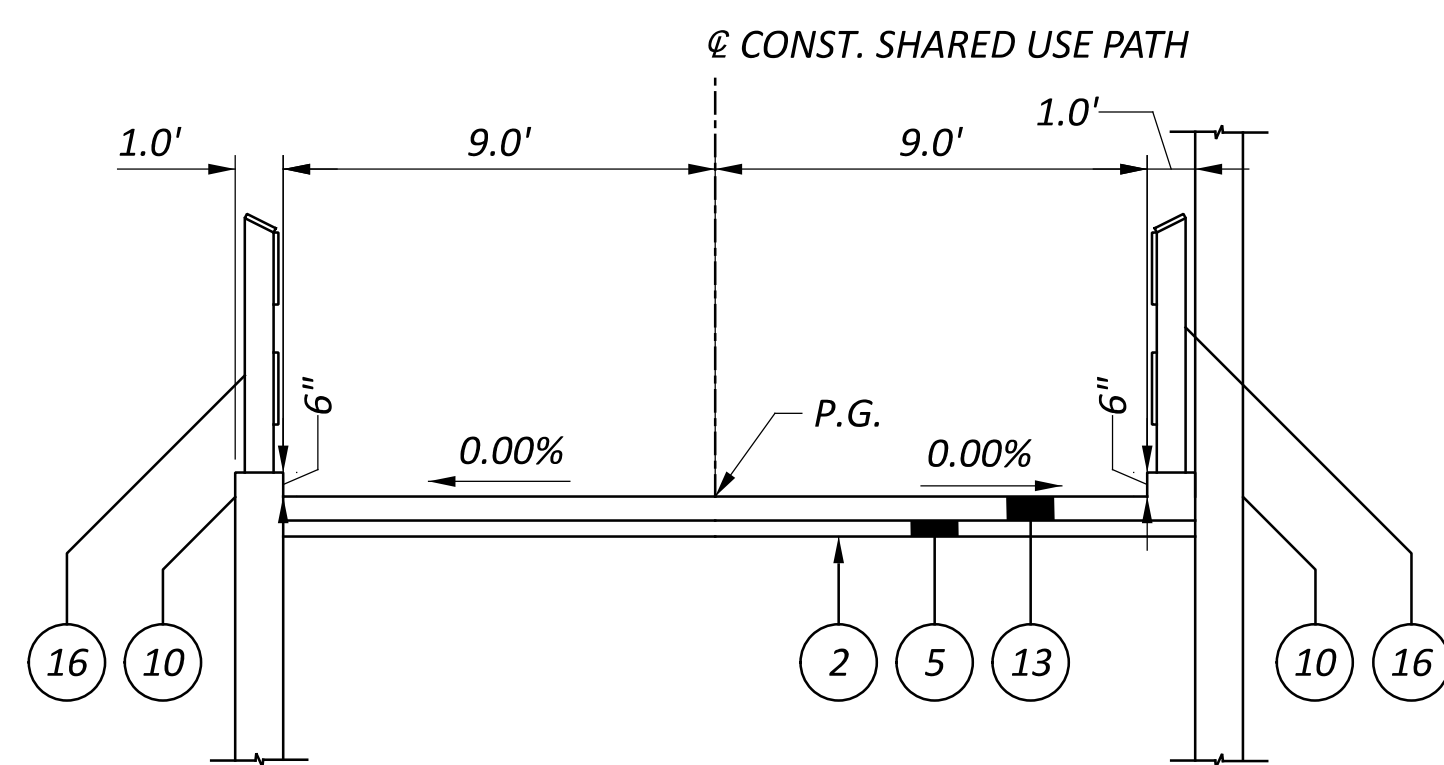


**TYPICAL SECTION - SHARED USE PATH**

STA. 1+62.62 TO STA. 2+72.53

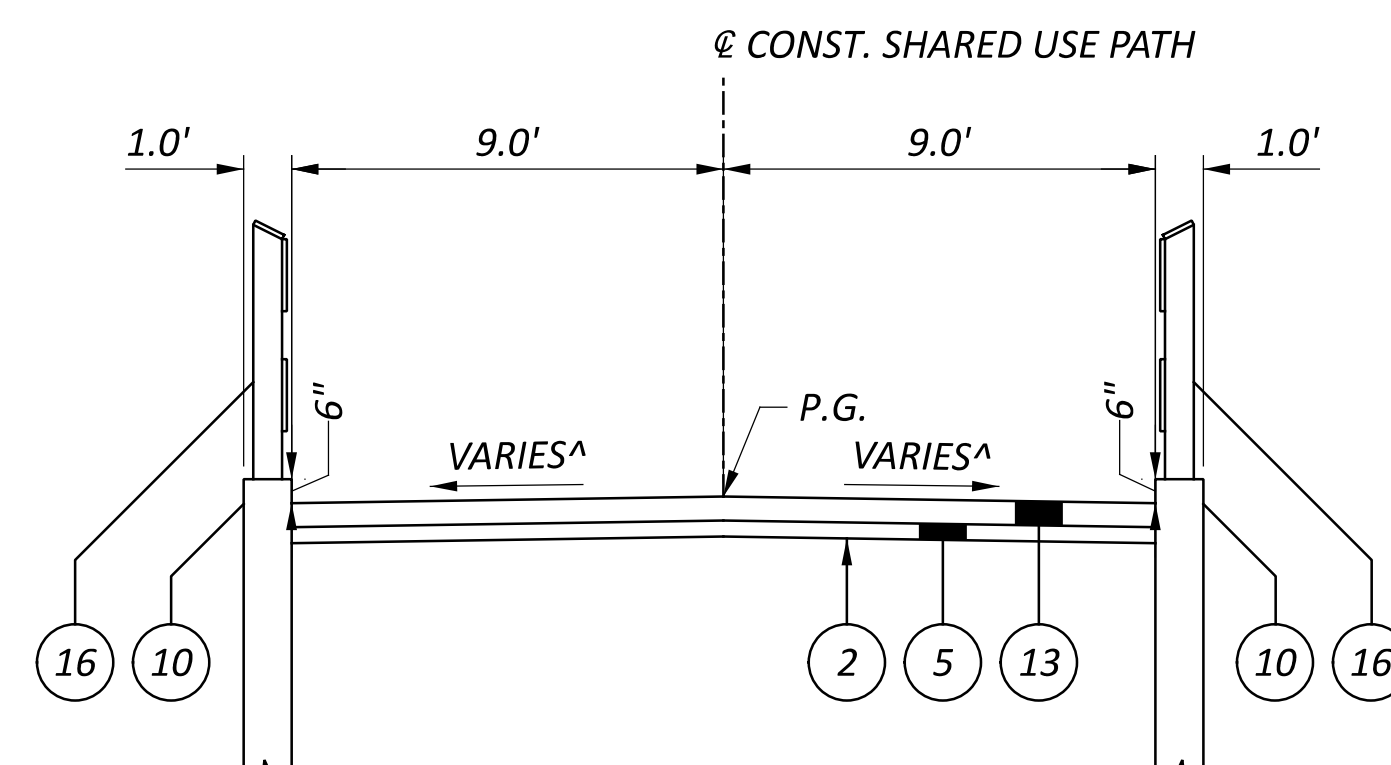


**TYPICAL SECTION - SHARED USE PATH**

STA. 2+72.53 TO STA. 4+95.94

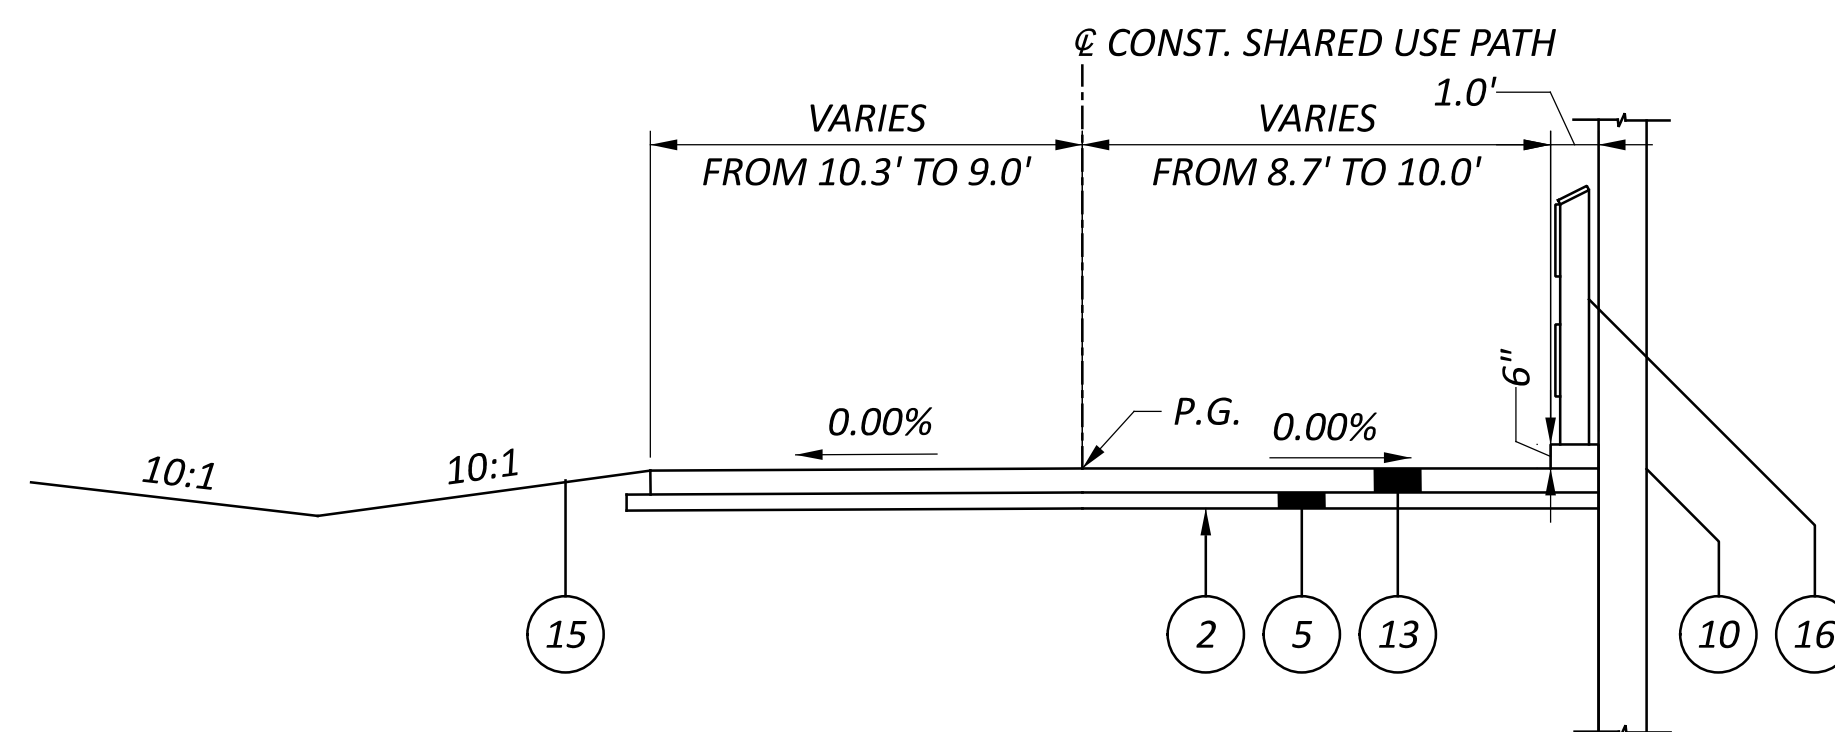

**TYPICAL SECTION - SHARED USE PATH**

STA. 0+34.51 TO STA. 1+62.62

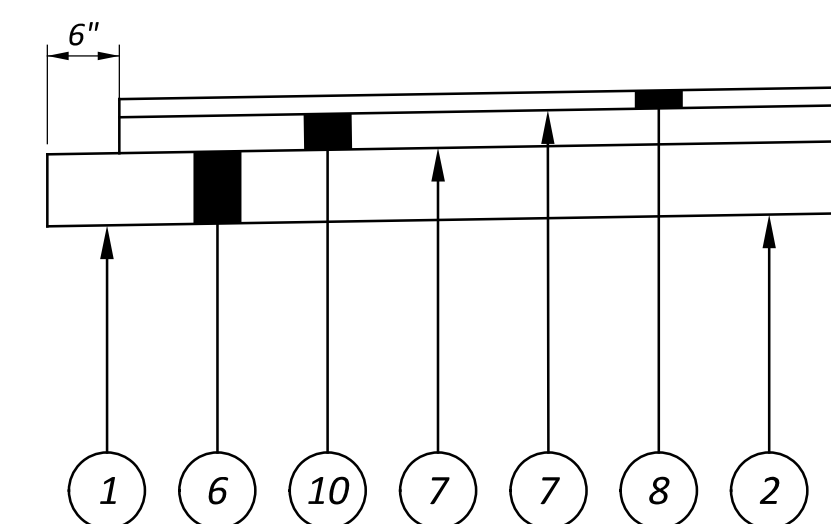

**SHARED USE PATH STEP DETAIL**

- NOTES
- SEE SHEET P.02 FOR TYPICAL SECTION LEGEND
  - SEE SHEETS P.74 - P.84 FOR WALL DETAIL SHEETS
- ^ VARIES FROM 1.00% TO 0.00% FROM STA. 4+50.00 TO STA. 4+95.94

**UTILITIES**

LISTED BELOW ARE ALL UTILITIES LOCATED WITHIN THE PROJECT CONSTRUCTION LIMITS TOGETHER WITH THEIR RESPECTIVE OWNERS:

AES OHIO  
1900 DRYDEN RD.  
DAYTON, OH 45439  
ATTN: WILLIAM WARD  
PHONE: 937-554-9063  
WILLIAM.WARD@AES.COM

CHARTER COMMUNICATIONS  
3691 TURNER ROAD  
DAYTON, OH 45415  
JEFF GAMMON  
937-396-7290  
JEFFERY.GAMMON@CHARTER.COM

AT&T OHIO  
7201 FAR HILLS AVE.  
DAYTON, OH 45439  
ATTN: ALAN STUTES  
PHONE: 937-708-1026  
AS1634@ATT.COM

ALTA FIBER  
221 E. 4TH ST.  
CINCINNATI, OH 45201  
ATTN: GARY MCCARTNEY  
PHONE: 937-271-8730  
GARY.MCCARTNEY@ALTA FIBER.COM

CITY OF XENIA  
11 N. DETROIT ST.  
XENIA, OHIO 45385  
ATTN: CHRIS BERGER  
PHONE: 937-376-7265  
CBERGER@CI.XENIA.OH.US

MIAMI VALLEY LIGHTING  
ATTN: ROBYN LIVESAY  
ROBYN.LIVESAY@AES.COM

**SPECIFICATIONS**

THE STATE OF OHIO DEPARTMENT OF TRANSPORTATION 2023 CONSTRUCTION AND MATERIAL SPECIFICATIONS, CURRENT EDITION, SHALL GOVERN THIS IMPROVEMENT.

**CONSTRUCTION NOISE**

ACTIVITIES AND LAND USE ADJACENT TO THIS PROJECT MAY BE AFFECTED BY CONSTRUCTION NOISE. IN ORDER TO MINIMIZE ANY ADVERSE CONSTRUCTION NOISE IMPACTS, DO NOT OPERATE POWER-OPERATED CONSTRUCTION-TYPE DEVICES BETWEEN THE HOURS OF 10 PM AND 7 AM. IN ADDITION, DO NOT OPERATE AT ANY TIME ANY DEVICE IN SUCH A MANNER THAT THE NOISE CREATED SUBSTANTIALLY EXCEEDS THE NOISE CUSTOMARILY AND NECESSARILY ATTENDANT TO THE REASONABLE AND EFFICIENT PERFORMANCE OF SUCH EQUIPMENT.

**OVERHEAD UTILITIES**

THE CONTRACTOR SHALL EXERCISE EXTREME CAUTION WHEN WORKING UNDER OR AROUND OVERHEAD UTILITY LINES.

**WORK LIMITS**

THE WORK LIMITS SHOWN ON THESE PLANS ARE FOR PHYSICAL CONSTRUCTION ONLY. PROVIDE THE INSTALLATION AND OPERATION OF ALL WORK ZONE TRAFFIC CONTROL AND WORK ZONE TRAFFIC CONTROL DEVICES REQUIRED BY THESE PLANS WHETHER INSIDE OR OUTSIDE THESE WORK LIMITS.

**ENDANGERED BAT HABITAT REMOVAL**

THIS PROJECT IS LOCATED WITHIN THE KNOWN HABITAT RANGES OF THE FEDERALLY LISTED AND PROTECTED INDIANA BAT, AND NORTHERN LONG-EARED BAT. NO TREES SHALL BE REMOVED UNDER THIS PROJECT FROM APRIL 1 THROUGH SEPTEMBER 30. ALL NECESSARY TREE REMOVAL SHALL OCCUR FROM OCTOBER 1 THROUGH MARCH 31. THIS REQUIREMENT IS NECESSARY TO AVOID AND MINIMIZE IMPACTS TO THESE SPECIES AS REQUIRED BY THE ENDANGERED SPECIES ACT (ESA). FOR THE PURPOSES OF THIS NOTE, A TREE IS DEFINED AS: A LIVE, DYING, OR DEAD WOODY PLANT, WITH A TRUNK 3 INCHES OR GREATER IN DIAMETER AT A HEIGHT OF 4.5 FEET ABOVE THE GROUND SURFACE, AND WITH A MINIMUM HEIGHT OF 13 FEET.

ANY PARTY FINDING A DEAD, INJURED, OR SICK BAT SPECIMEN MUST PROMPTLY NOTIFY THE USFWS OHIO FIELD OFFICE AT (614) 416-8993. THE CONTRACTOR SHALL CONTACT ODOT WHO WILL IN TURN CONTACT USFWS ABOUT ANY BATS FOUND WITHIN THE PROJECT.

**SURVEYING PARAMETERS - OHIO STATE PLANE (SOUTH)**

PRIMARY PROJECT CONTROL MONUMENTS GOVERN ALL POSITIONING ON ODOT PROJECTS. SEE THIS SHEET FOR A TABLE CONTAINING PROJECT CONTROL INFORMATION.

USE THE FOLLOWING PROJECT CONTROL, VERTICAL POSITIONING, AND HORIZONTAL POSITIONING PARAMETERS FOR ALL SURVEYING:

PROJECT CONTROL  
POSITIONING METHOD: ODOT VRS  
MONUMENT TYPE: 5/8" IRON PIN TRAVERSE POINT WITH RED CARPENTER MARTY TRANSPORTATION CAP

VERTICAL POSITIONING  
ORTHOMETRIC HEIGHT DATUM: NAVD 88  
GEOID: GEOID 18

HORIZONTAL POSITIONING  
REFERENCE FRAME: NAD 83 (2011)  
ELLIPSOID: GRS80  
COORDINATE SYSTEM: LAMBERT CONFORMAL CONIC  
MAP PROJECTION: OHIO STATE PLANE, SOUTH OHIO  
PROJECT ADJUSTMENT FACTOR: 1.0000000000 (PRJ. IS IN GRID COORD.)  
ORIGIN OF COORDINATE SYSTEM: 0,0

USE THE POSITIONING METHODS AND MONUMENT TYPE USED IN THE ORIGINAL SURVEY TO RESTORE ALL MONUMENTS RELATED TO PRIMARY PROJECT CONTROL THAT ARE DAMAGED OR DESTROYED BY CONSTRUCTION ACTIVITIES. RESTORE THE DAMAGED OR DESTROYED MONUMENTS IN ACCORDANCE WITH CMS 623.

UNITS ARE IN U.S. SURVEY FEET.

**SEEDING AND MULCHING**

THE FOLLOWING QUANTITIES ARE PROVIDED TO PROMOTE GROWTH AND CARE OF PERMANENT SEEDED AREAS:

659, TOPSOIL 641 CY  
659, SEEDING AND MULCHING 5766 SY  
659, REPAIR SEEDING AND MULCHING 288 SY  
659, INTER-SEEDING 288 SY  
659, COMMERCIAL FERTILIZER 0.78 TON  
659, LIME 1.20 ACRES  
659, WATER 15600 GAL

SEEDING AND MULCHING SHALL BE APPLIED TO ALL AREAS OF EXPOSED SOIL BETWEEN THE RIGHT-OF-WAY LINES, AND WITHIN THE CONSTRUCTION LIMITS FOR AREAS OUTSIDE THE RIGHT-OF-WAY LINES COVERED BY WORK AGREEMENT OR SLOPE EASEMENT. QUANTITY CALCULATIONS FOR SEEDING AND MULCHING ARE BASED ON THESE LIMITS.

**IN-STREAM WORK RESTRICTIONS**

THE CONTRACTOR SHALL NOT WORK BELOW THE ORDINARY HIGH-WATER MARK OF OLDTOWN CREEK, OR INSTALL, MODIFY, OR REMOVE ANY EXISTING IN-STREAM FILLS DURING THE ODNR INSTREAM WORK RESTRICTION PERIOD OF APRIL 15TH AND JUNE 30TH.

**ITEM 204 - PROOF ROLLING**

THE FOLLOWING QUANTITY IS PROVIDED IN THE GENERAL SUMMARY TO ADDRESS LOCATIONS REQUIRING PROOF ROLLING. SEE PLAN SHEET NO. 2 FOR ADDITIONAL INFORMATION.

ITEM 204 – PROOF ROLLING 2 HOUR.

**ODNR NOTIFICATION**

THE ODNR DIVISION OF PARKS AND WATERCRAFT'S GREAT COUNCIL STATE PARK MANAGER, TIM PRITCHARD, SHALL BE INFORMED OF ANY PARK RELATED INTERESTS (I.E. SCHEDULING, ROAD CLOSURES, ETC.) AS THE PROJECT PROGRESSES. MR. PRITCHARD CAN BE REACHED AT TIMOTHY.PRITCHARD@DNR.OHIO.GOV OR 937-629-1740.

CL OF CONSTRUCTION PROPOSED SEWER			PROJECT GROUND COORDINATES		ELEVATION	DESCRIPTION
POINT NUMBER	STATION	OFFSET	NORTH (Y) U.S. FT.	EAST (X) U.S. FT.		
CP01	93+69.19	21.53 LT	632483.62	1564386.75	833.71	IRON PIN
BM01	95+30.07	41.84 LT	632644.71	1564356.84	833.23	FH BOLT (BENCHMARK)
CP02	95+98.17	46.38 LT	632713.73	1564351.23	831.80	IRON PIN
CP03	96+73.50	146.38 RT	632787.14	1564543.33	833.71	IRON PIN
CP04	97+86.00	96.87 RT	632896.57	1564497.72	835.37	MAG NAIL
T2	97+91.42	21.63 RT	632906.33	1564422.92	834.79	CONCRETE MONUMENT (BENCHMARK)
CP05	98+06.23	23.91 RT	632920.64	1564426.05	835.76	MAG NAIL
CP06	99+16.17	25.68 RT	633029.55	1564436.40	843.32	MAG NAIL
CP07	99+71.31	29.95 LT	633089.22	1564385.67	835.66	IRON PIN
CP08	100+31.42	163.51 LT	633160.48	1564257.70	840.84	PIPE FOUND
T104	100+88.75	24.39 LT	633205.76	1564401.20	835.68	MAG NAIL (BENCHMARK)
CP09	100+91.43	160.17 LT	633219.98	1564266.14	841.12	IRON PIN
CP10	100+93.88	154.24 LT	633221.93	1564272.26	840.80	MAG NAIL
CP11	100+94.64	40.00 RT	633206.15	1564465.86	835.18	IRON PIN
CP12	101+36.27	123.47 LT	633261.54	1564306.52	840.36	MAG NAIL
CP13	101+50.51	97.12 RT	633256.96	1564527.52	835.69	MAG NAIL
CP14	102+87.83	13.92 LT	633402.82	1564420.92	834.97	MAG NAIL

CENTERLINE REFERENCES AND KEY SURVEY POINTS PROPOSED US 68 - GROUND COORDINATES						
STATION	OFFSET (FT)	SIDE	NORTHING	EASTING	ELEVATION	DESCRIPTION
85+42.87	0	CL	631669.86	1564538.15	---	P.O.T.
91+43.61	0	CL	632261.92	1564437.28	---	P.C.
98+71.09	0	CL	632986.82	1564406.98	---	P.T.
103+23.10	0	CL	633437.19	1564445.44	---	P.C.
105+13.09	0	CL	633626.18	1564464.74	---	P.T.
109+00.00	0	CL	634010.40	1564510.43	---	P.O.T.

LITTLE MIAMI SCENIC TRAIL PROJECT CONTROL						
CL OF CONSTRUCTION PROPOSED SEWER			PROJECT GROUND COORDINATES		ELEVATION	DESCRIPTION
POINT NUMBER	STATION	OFFSET	NORTH (Y) U.S. FT.	EAST (X) U.S. FT.		
CP15	200+92.80	27.47 LT	633126.36	1564856.57	827.97	IRON PIN
CP16	201+18.85	8.39 LT	633149.09	1564879.51	831.87	IRON PIN
CP17	201+44.60	26.74 LT	633177.41	1564865.42	828.19	IRON PIN

**DAYTON AQUIFER AND DRINKING WATER PROTECTION**

THIS PROJECT IS LOCATED WITHIN THE GREAT MIAMI SOLE SOURCE AQUIFER AND A DRINKING WATER PROTECTION AREA. IN ORDER TO MINIMIZE THE POTENTIAL FOR CONTAMINATION, THE CONTRACTOR SHALL UTILIZE PROPER CONTAINMENT AND DIKING IN REFUELING AREAS. FUELS, TOXIC/HAZARDOUS MATERIALS, AND CHEMICALS SHALL NOT BE STORED NEAR DRAINAGE WAYS, DITCHES, OR STREAMS. A SPILL KIT IS TO BE MAINTAINED ON-SITE THROUGHOUT CONSTRUCTION ACTIVITIES. THE CONTRACTOR SHALL IMMEDIATELY TAKE STEPS TO MITIGATE ANY EVENT, SUCH AS SPILL OF FUELS, OILS, OR CHEMICALS THAT COULD THREATEN TO CONTAMINATE THE DRINKING WATER SUPPLY. ANY SUCH SPILL OR EVENT SHALL BE REPORTED IMMEDIATELY TO THE XENIA CITY PWS (OH2902812) COMMUNITY SYSTEM (937) 376-7269. IF THE SPILL IS A REPORTABLE AMOUNT (PER OHIO EPA'S RELEASE REPORTING REQUIREMENTS), THE CONTRACTOR SHALL CONTACT XENIA TOWNSHIP FIRE DEPARTMENT (937) 372-7857 OR THE OHIO EPA'S SPILLS HOTLINE 1-800-282-9378 FOR CLEAN-UP OF THE SPILL.

**POST CONSTRUCTION STORM WATER TREATMENT**

THIS PLAN UTILIZES STRUCTURAL BEST MANAGEMENT PRACTICES (BMP'S) FOR POST CONSTRUCTION STORM WATER TREATMENT.

THIS PLAN UTILIZES MANUFACTURED WATER QUALITY STRUCTURES FOR WATER QUALITY TREATMENT. AREAS HAVE BEEN SHOWN IN THE PLANS FOR PLACEMENT OF AN IN-LINE SYSTEM. PAYMENT FOR THESE DEVICES SHALL BE MADE AT THE CONTRACT UNIT PRICE FOR ITEM 895, MANUFACTURED WATER QUALITY STRUCTURE, TYPE 2.



**ITEM SPECIAL - MAILBOX SUPPORT**

THIS WORK SHALL CONSIST OF FURNISHING AND ERECTING MAILBOX SUPPORTS AND ANY ASSOCIATED MOUNTING HARDWARE IN ACCORDANCE WITH PLAN DETAILS, AND ATTACHING OWNER-SUPPLIED MAILBOX AT LOCATIONS SPECIFIED IN THE PLANS, OR OTHERWISE ESTABLISHED BY THE ENGINEER.

WOOD POSTS SHALL BE NOMINAL 4 INCHES BY 4 INCHES SQUARE OR 4.5 INCHES DIAMETER ROUND, AND CONFORM TO 710.14.

STEEL POSTS SHALL BE NOMINAL PIPE SIZE 2 INCHES I.D., AND CONFORM TO AASHTO M 181.

ALL HARDWARE INCLUDING BUT NOT LIMITED TO PLATES, SCREWS, BOLTS, AND ETC. SHALL BE COMMERCIAL-GRADE GALVANIZED STEEL.

POSTS SHALL BE SET PER THE FIRST PARAGRAPH OF 606.03, AND SHALL IN NO INSTANCE BE EMCASED IN CONCRETE.

SUPPORT HARDWARE SHALL ACCOMMODATE EITHER A SINGLE OR A DOUBLE MAILBOX INSTALLATION, AND NO MORE THAN TWO BOXES MAY BE MOUNTED ON A SINGLE POST.

THE MAILBOX SHALL BE SECURELY AND NEATLY ATTACHED BY THE CONTRACTOR TO THE NEW SUPPORT. THE CONTRACTOR SHALL FURNISH ALL NECESSARY ATTACHMENT HARDWARE (STRAPS, BOLTS, PLATES, SPACERS, AND WASHERS) AS NECESSARY TO ACCOMMODATE THE COMPLETE INSTALLATION.

IN THE ABSENCE OF A NEW BOX SUPPLIED BY THE OWNER, THE CONTRACTOR SHALL SALVAGE THE EXISTING BOX AND PLACE IT ON THE NEW SUPPORT. DUE CARE SHALL BE EXERCISED IN SUCH AN OPERATION, AND THE CONTRACTOR SHALL BE RESPONSIBLE FOR REPAIRING OR REPLACING ANY BOX DAMAGED BY IMPROPER HANDLING ON HIS PART, AS JUDGED AND DIRECTED BY THE ENGINEER.

THE CONTRACTOR SHALL BE RESPONSIBLE FOR COORDINATING WITH THE LOCAL POST MASTER REGARDING THE TIMING OF THE MOVEMENT OF ANY MAILBOX TO A NEW LOCATION.

NEW POSTED TIMES THAT ITEM SHALL BE LIMITED TO FINAL PERMANENT INSTALLATIONS. TEMPORARY INSTALLATIONS SHALL BE IN ACCORDANCE WITH ITEM 730.10. HOWEVER, THE REQUIREMENTS FOR POST DIMENSIONS AS SPECIFIED IN THIS INSTALLATION SHALL APPLY.

MAILBOX SUPPORTS, COMPLETE IN PLACE, WILL BE PAID FOR AT THE CONTRACT UNIT PRICE PER EACH, FOR ITEM REFERENCED IN THE SUPPORTING SPECIFICATION (I.E. 606.80).

**CROSSINGS AND CONNECTIONS TO EXISTING PIPES AND UTILITIES**

WHERE PLANS PROVIDE FOR A PROPOSED CONDUIT TO BE CONNECTED TO, OR CROSS OVER OR UNDER AN EXISTING SEWER OR UNDERGROUND UTILITY, LOCATE THE EXISTING PIPES OR UTILITIES BOTH AS TO LINE AND GRADE BEFORE STARTING TO LAY THE PROPOSED CONDUIT.

IF IT IS DETERMINED THAT THE ELEVATION OF THE EXISTING CONDUIT, OR EXISTING APPURTENANCE TO BE CONNECTED, DIFFERS FROM THE PLAN ELEVATION OR RESULTS IN A CHANGE IN THE PLAN CONDUIT SLOPE, NOTIFY THE ENGINEER BEFORE STARTING CONSTRUCTION OF ANY PORTION OF THE PROPOSED CONDUIT WHICH WILL BE AFFECTED BY THE VARIANCE IN THE EXISTING ELEVATIONS.

IF IT IS DETERMINED THAT THE PROPOSED CONDUIT WILL INTERSECT AN EXISTING SEWER OR UNDERGROUND UTILITY IF CONSTRUCTED AS SHOWN ON THE PLAN, NOTIFY THE ENGINEER BEFORE STARTING CONSTRUCTION OF ANY PORTION OF THE PROPOSED CONDUIT WHICH WOULD BE AFFECTED BY THE INTERFERENCE WITH AN EXISTING FACILITY.

PAYMENT FOR ALL THE OPERATIONS DESCRIBED ABOVE IS INCLUDED IN THE CONTRACT PRICE FOR THE PERTINENT 611 CONDUIT ITEM.

**REVIEW OF DRAINAGE FACILITIES**

PRIOR TO THE START OF WORK AND AGAIN BEFORE FINAL ACCEPTANCE, PERFORM AN INSPECTION WITH REPRESENTATIVES OF THE DEPARTMENT, CONTRACTOR AND LOCALS OF ALL EXISTING DRAINAGE FACILITIES THAT ARE TO REMAIN IN SERVICE WHICH MAY BE AFFECTED BY THE WORK. THE CONDITION OF THE EXISTING CONDUITS AND THEIR APPURTENANCES IS DETERMINED FROM FIELD OBSERVATIONS. RECORDS OF THE INSPECTION ARE MAINTAINED BY THE DEPARTMENT.

CONFIRM ALL EXISTING SEWERS INSPECTED INITIALLY BY THE ABOVE-MENTIONED PARTIES ARE MAINTAINED AND LEFT IN A CONDITION COMPARABLE TO THAT DETERMINED BY THE ORIGINAL INSPECTION. THE CONTRACTOR IS RESPONSIBLE TO CORRECT ANY CHANGE IN THE CONDITION RESULTING FROM THEIR OPERATIONS AS DIRECTED AND APPROVED BY THE ENGINEER.

**LITTLE MIAMI SCENIC TRAIL**

ACCESS TO THE LITTLE MIAMI SCENIC TRAIL WILL BE RESTRICTED FOR THE DURATION OF CONSTRUCTION ACTIVITIES DUE TO SAFETY CONCERNS AND LACK OF A FEASIBLE AND SAFE DETOUR FOR PEDESTRIANS. THERE WILL BE ASSIGNED DETOUR ROUTE FOR BICYCLISTS.

TEMPORARY CONSTRUCTION FENCING SHALL BE INSTALLED ALONG PROPOSED CONSTRUCTION LIMITS PRIOR TO THE START OF CONSTRUCTION ACTIVITIES TO PROTECT THE EXISTING SECTION 4(F) PROPERTY AND THE PUBLIC.

APPROPRIATE SIGNAGE SHALL BE INSTALLED TO ALERT USERS OF THE LITTLE MIAMI SCENIC TRAIL OF CONSTRUCTION ACTIVITIES, ACCESS RESTRICTIONS OR CLOSURES, AND TO DIRECT USERS TO SECONDARY ACCESS POINTS.

THE CONTRACTOR SHALL BE REQUIRED TO CLOSELY COORDINATE THE CONSTRUCTION SCHEDULE WITH ODOT, ODNr, AND GREENE COUNTY PARKS & TRAILS PRIOR TO THE START OF CONSTRUCTION ACTIVITIES.

**ITEM SPEC - CONCRETE QUALITY CONTROL**

ALL CONCRETE SHALL BE TESTED. CONCRETE TESTING FOR QC/QA ITEMS (SWITCHBACK RAMP WALLS & FOOTERS, BRIDGE ABUTMENTS, BRIDGE PIERS, BRIDGE STAIRS, BRIDGE DECK) SHALL BE TESTED AS PER CMS ITEM 455. CONCRETE INSPECTION AND TESTING FOR NON-QC/QA ITEMS SHALL BE COVERED AND TESTED BY ODOT (SIDEWALKS, CURBS, BRIDGE PILES, DRIVEWAYS).

**ITEM 630 - SIGNING, MISC.: SOLAR-POWERED RECTANGULAR RAPID FLASHING BEACON (RRFB) SIGN ASSEMBLY, TWO-SIDED**

THIS WORK SHALL CONSIST OF FURNISHING AND INSTALLING A SOLAR POWERED RECTANGULAR RAPID FLASHING BEACON (RRFB) SIGN ASSEMBLY. THE FLASHING UNIT SHALL BE SOLAR POWERED, PEDESTRIAN ACTIVATED, AND 2-SIDED WITH TWO LED ARRAY BASED YELLOW INDICATIONS ON EACH SIDE. MULTIPLE UNITS SHALL BE WIRELESSLY CONTROLLED AND SYNCHRONIZED. THE UNIT SHALL BE COMPLIANT WITH THE MOST CURRENT OHIO MANUAL OF UNIFORM TRAFFIC CONTROL DEVICES (OMUTCD) AND FHWA INTERIM APPROVAL FOR RRFBs (IA-21).

**GENERAL REQUIREMENTS –**

1. EACH RRFB SHALL CONSIST OF TWO RAPIDLY FLASHED RECTANGULAR-SHAPED YELLOW INDICATIONS HAVING LED ARRAY BASED LIGHT SOURCE.
2. EACH RRFB SHALL BE A COMPLETE ASSEMBLY, CONSISTING OF BUT NOT LIMITED TO, SIGNAGE, SIGN MOUNTING HARDWARE, INDICATIONS AND ELECTRICAL COMPONENTS (WIRING, SOLID-STATE CIRCUIT BOARDS, ETC.).
3. EACH RRFB SHALL CONTAIN A PEDESTRIAN INDICATION LIGHT VISIBLE BY THE PEDESTRIAN IN THE DIRECTION OF TRAVEL.

**FUNCTIONAL REQUIREMENTS –**

1. EACH RRFB SHALL UTILIZE SOLAR POWER.
2. EACH RRFB SHALL BE ACTIVATED BY ADA COMPLIANT PUSHBUTTONS.
3. THE RRFB SHALL BE NORMALLY DARK, SHALL INITIATE OPERATION ONLY UPON PEDESTRIAN ACTUATION, AND SHALL CEASE OPERATION AFTER A PREDETERMINED TIME LIMIT (BASED ON OMUTCD PROCEDURES).
4. EACH REMOTE RRFB SHALL BE WIRELESSLY ACTIVATED.
5. ALL RRFB LIGHT INDICATIONS SHALL BE WIRELESSLY SYNCHRONIZED (ALL LIGHTS WILL TURN ON WITHIN 120 MSEC AND REMAIN SYNCHRONIZED THROUGHOUT THE DURATION OF THE FLASHING CYCLE).
6. THE UNIT SHALL BE CAPABLE OF RUNNING 14 DAYS WITHOUT SUNLIGHT.

MATERIALS – FURNISH A COMPLETE ASSEMBLY, CONSISTING OF BUT NOT LIMITED TO, SIGNAGE, SIGN MOUNTING HARDWARE, INDICATIONS, AND ELECTRICAL COMPONENTS (WIRING, SOLID-STATE CIRCUIT BOARDS, ETC.). THE RRFB ASSEMBLY INCLUDES THE FOLLOWING ITEMS:

1. RRFB INDICATIONS
  - A. EACH RRFB INDICATION LENS SHALL BE A MINIMUM SIZE OF APPROXIMATELY 5" WIDE X 2" HIGH.
  - B. THE RRFB INDICATIONS SHALL BE ALIGNED HORIZONTALLY, WITH THE LONGER DIMENSION OF THE INDICATION HORIZONTAL. THERE SHALL BE TWO INDICATIONS ON THE FRONT AND TWO INDICATIONS ON THE BACK.
  - C. EACH RRFB SHALL BE SUPPLIED WITH ALL REQUIRED HARDWARE TO INSTALL ASSEMBLY. ALL EXPOSED HARDWARE SHALL BE ANTI-VANDAL.
  - D. EACH RRFB SHALL BE LOCATED BETWEEN THE BOTTOM OF THE CROSSING WARNING SIGN AND THE TOP OF THE SUPPLEMENTAL DOWNWARD DIAGONAL ARROW PLAQUE.
  - E. THE LIGHT INTENSITY OF THE YELLOW INDICATIONS SHALL MEET THE MINIMUM CLASS 1 SPECIFICATIONS OF SOCIETY OF AUTOMOTIVE ENGINEERS (SAE) STANDARD J595 (DIRECTIONAL FLASHING OPTICAL WARNING DEVICES FOR AUTHORIZED EMERGENCY, MAINTENANCE, AND SERVICE VEHICLES) DATED JANUARY, 2005.
  - F. TO MINIMIZE EXCESSIVE GLARE DURING NIGHTTIME CONDITIONS, AN AUTOMATIC SIGNAL DIMMING DEVICE SHALL BE USED TO REDUCE THE BRILLIANCE OF THE RRFB INDICATIONS.
  - G. AN LED PEDESTRIAN CONFIRMATION LIGHT DIRECTED AT AND VISIBLE TO PEDESTRIANS IN THE CROSSWALK SHALL BE INSTALLED INTEGRAL TO THE RRFB OR PUSHBUTTON TO GIVE CONFIRMATION THAT THE RRFB IS IN OPERATION.
  - H. THE PEDESTRIAN CONFIRMATION LIGHT SHALL HAVE A MINIMUM AREA OF 0.5 SQUARE INCHES AND BE CONSPICUOUS TO PEDESTRIANS AT ALL DISTANCES FROM THE BEGINNING OF THE CONTROLLED CROSSWALK TO A POINT 10 FEET FROM THE END OF THE CONTROLLED CROSSWALK DURING BOTH DAY AND NIGHT.

**2. SIGNS**

- A. ALL SIGN ASSEMBLIES SHALL USE ANTI-VANDAL FASTENERS TO MOUNT COMPONENTS TO SIGN AND SIGN TO FIXTURE.
- B. PEDESTRIAN PUSHBUTTONS SIGNS SHALL BE PROVIDED AND INCLUDE THE LEGEND "PUSH BUTTON TO TURN ON WARNING LIGHTS". SIGNS SHOULD BE MOUNTED ADJACENT TO OR INTEGRAL WITH EACH PEDESTRIAN PUSHBUTTON.
- C. TWO SETS OF SIGNS SHALL BE REQUIRED PER UNIT FOR VIEW FROM EACH APPROACH.
- D. ASSURE SIGN MEETS THE REQUIREMENTS OF C&MS 630.

**3. CONTROL CIRCUIT**

- A. THE CONTROL CIRCUIT SHALL HAVE THE CAPABILITY OF INDEPENDENTLY FLASHING UP TO TWO INDEPENDENT OUTPUTS. THE LED LIGHT OUTPUTS AND FLASH PATTERN SHALL BE COMPLETELY PROGRAMMABLE.
- B. THE CONTROL CIRCUIT SHALL BE SEALED WATERTIGHT TO ELIMINATE DIRT CONTAMINATION AND ALLOW FOR SAFE HANDLING IN ALL WEATHER CONDITIONS.
- C. THE LEDS SHALL BE SEALED AGAINST DUST AND MOISTURE INTRUSION AS PER THE REQUIREMENTS OF NEMA STANDARD 250-1991 FOR TYPE 4 ENCLOSURE AND TO PROTECT ALL INTERNAL LED AND ELECTRICAL COMPONENTS.

**4. BATTERY AND SOLAR PANELS**

- A. BATTERY UNIT SHALL BE A 12VDC, 35 AHR MINIMUM, SEALED GEL OR AGM LEAD ACID BATTERY. BATTERIES SHALL HAVE A WRITTEN TWO YEAR FULL REPLACEMENT WARRANTY.
- B. THE SOLAR PANEL SHALL PROVIDE A MINIMUM OF 40 WATTS PEAK TOTAL OUTPUT.
- C. THE SOLAR PANEL SHALL BE MOUNTED TO AN ALUMINUM PLATE AND BRACKET AT AN ANGLE OF 45 DEGREES- 60 DEGREES TO PROVIDE MAXIMUM OUTPUT.
- D. ALL FASTENERS USED SHALL BE ANTI-VANDAL.

**5. WIRELESS RADIO**

- A. RADIO CONTROL SHALL OPERATE ON A 900 MHZ FREQUENCY HOPPING SPREAD SPECTRUM NETWORK, WI-FI OR APPROVED EQUAL.
- B. RADIO SHALL INTEGRATE COMMUNICATION OF RRFB CONTROL CIRCUIT TO ACTIVATE SIGN FROM PUSHBUTTON INPUT.
- C. THE RADIO SHALL BE SYNCHRONIZED SO ALL OF THE REMOTE RRFB LIGHT INDICATIONS WILL TURN ON WITHIN 120 MSEC OF EACH OTHER AND REMAIN SYNCHRONIZED THROUGH-OUT THE DURATION OF THE FLASHING CYCLE.

**6. PUSHBUTTON**

- A. THE PUSHBUTTON SHALL BE CAPABLE OF CONTINUOUS OPERATION OVER A TEMPERATURE RANGE OF -30 DEGREES F TO +165 DEGREES F.
- B. PUSHBUTTON SHALL BE ADA COMPLIANT.

7. PEDESTAL SHAFT AND BASE - MOUNT ON A STANDARD 4.5-INCH OD ALUMINUM PEDESTAL POLE WITH BREAKAWAY BASE. A 14 FOOT POLE SHALL BE PROVIDED AND FIELD ADJUSTED AND CAPPED TO MAINTAIN THE PROPER SIGN MOUNTING HEIGHTS, UNLESS SPECIFIED OTHERWISE IN THE PLANS. POLE AND BASE MANUFACTURER SHALL BE LISTED ON ODOT'S QUALIFIED PRODUCTS LIST.

CONSTRUCTION – THE RRFB SHALL BE ASSEMBLED AND CONSTRUCTED BY THE CONTRACTOR AS SHOWN AND SPECIFIED ON THE PLANS.

WARRANTY – WARRANTY SHALL BE TWO YEARS FROM THE DATE OF FINAL ACCEPTANCE.

MEASUREMENT – THE DEPARTMENT WILL MEASURE THE ITEM COMPLETE IN PLACE, INCLUDING ALL MATERIALS, TESTING, LABOR AND SOFTWARE FOR A FULLY FUNCTIONAL UNIT.

DESIGN AGENCY



DESIGNER  
CEF

REVIEWER  
BAA 03/28/25

PROJECT ID  
115388

SHEET TOTAL  
P.06 | P.107

**ITEM 614, MAINTAINING TRAFFIC**

A MINIMUM OF ONE LANE OF TRAFFIC IN EACH DIRECTION SHALL BE MAINTAINED AT ALL TIMES, EXCEPT FOR A PERIOD NOT TO EXCEED 3 CONSECUTIVE CALENDAR DAYS, WHEN THROUGH TRAFFIC MAY BE DETOURED AS SHOWN ON SHEET P.13. A DISINCENTIVE SHALL BE ASSESSED IN THE AMOUNT OF \$ 2500 PER DAY FOR EACH CALENDAR DAY THE ROADWAY REMAINS CLOSED TO TRAFFIC BEYOND THE SPECIFIED LIMIT.

NO WORK SHALL BE PERFORMED AND ALL EXISTING LANES SHALL BE OPEN TO TRAFFIC DURING THE FOLLOWING DESIGNATED HOLIDAYS OR SPECIAL EVENTS:

NEW YEAR'S (OBSERVED)	GENERAL/REGULAR ELECTION DAY ((NOV)
THANKSGIVING	DAYTON HAMVENTION
MEMORIAL DAY	CHRISTMAS (OBSERVED)
FOURTH OF JULY (OBSERVED)	GREENE COUNTY FAIR
LABOR DAY	INTERPRETIVE CENTER EVENTS

THE PERIOD OF TIME THAT THE LANES ARE TO BE OPEN DEPENDS ON THE DAY OF THE WEEK ON WHICH THE HOLIDAY OR SPECIAL EVENT FALLS. THE FOLLOWING SCHEDULE SHALL BE USED TO DETERMINE THIS PERIOD:

DAY OF HOLIDAY OR SPECIAL EVENT	TIME ALL LANES MUST BE OPEN TO TRAFFIC
SUNDAY	12:00N FRIDAY THROUGH 6:00 AM MONDAY
MONDAY	12:00N FRIDAY THROUGH 6:00 AM TUESDAY
TUESDAY	12:00N MONDAY THROUGH 6:00 AM WEDNESDAY
TUESDAY (GEN./REG. ELECTION)	5:00 AM TUESDAY THROUGH 12:00 AM WEDNESDAY
WEDNESDAY	12:00N TUESDAY THROUGH 6:00 AM THURSDAY
THURSDAY	12:00N WEDNESDAY THROUGH 6:00 AM FRIDAY
THURSDAY (THANKSGIVING ONLY)	6:00 AM WEDNESDAY THROUGH 6:00 AM MONDAY
FRIDAY	12:00N THURSDAY THROUGH 6:00 AM MONDAY
SATURDAY	12:00N FRIDAY THROUGH 6:00 AM MONDAY

DURING THE SAME PERIODS, MAINTAIN PEDESTRAIN ACCESS IF PEDESTRIAN ACCESS WAS PRESENT PRIOR TO CONSTRUCTION.

SHOULD THE CONTRACTOR FAIL TO MEET ANY OF THESE REQUIREMENTS, THE CONTRACTOR SHALL BE ASSESSED A DISINCENTIVE PER THE LANE VALUE CONTRACT (PN 127).

DESCRIPTION OF CRITICAL LANE/RAMP TO BE MAINTAINED	RESTRICTED TIME PERIOD	TIME UNIT	DISINCENTIVE PER TIME UNIT
U.S. 68 ALL LANES	PER PLCS	DAY	\$2500

NOTICE OF CLOSURE SIGNS (W20-H13) SHALL BE ERECTED BY THE CONTRACTOR PRIOR TO THE SCHEDULED ROAD OR RAMP CLOSURE IN ACCORDANCE WITH THE NOTICE OF CLOSURE TIME TABLE BELOW. [AT THE APPROVAL OF THE ENGINEER, PORTABLE CHANGEABLE MESSAGE SIGNS MAY BE USED IN LIEU OF THE STANDARD FLATSHEET SIGN FOR CLOSURE DURATIONS OF LESS THAN 1 WEEK.]

THE SIGNS SHALL BE ERECTED ON THE RIGHT-HAND SIDE OF THE ROAD/RAMP FACING TRAFFIC. THEY SHALL BE PLACED SO AS NOT TO INTERFERE WITH THE VISIBILITY OF ANY OTHER TRAFFIC CONTROL SIGNS. ON ROADWAYS, THEY SHOULD BE ERECTED AT OR NEAR THE POINT OF CLOSURE. THE SIGNS MAY BE ERECTED ANYWHERE ON RAMPS AS LONG AS THEY ARE VISIBLE TO THE MOTORISTS USING THE RAMP. ON ENTRANCE RAMPS, THE SIGN SHALL BE ERECTED WELL IN ADVANCE OF THE MERGE AREA TO AVOID DISTRACTING MOTORISTS.

**ITEM 614, MAINTAINING TRAFFIC (CONT.)**

NOTIFICATION OF TRAFFIC RESTRICTIONS TIME TABLE		
ITEM	DURATION OF CLOSURE	SIGN DISPLAYED TO PUBLIC
	>= 2 WEEKS	14 CALENDAR DAYS PRIOR TO CLOSURE
RAMP & ROAD CLOSURES	> 12 HOURS & < 2 WEEKS	7 CALENDAR DAYS PRIOR TO CLOSURE
	<= 12 HOURS	2 CALENDAR DAYS PRIOR TO CLOSURE

THE SIGN SHALL DISPLAY THE DATE OF THE CLOSURE IN MMM-DD FORMAT AND THE NUMBER OF DAYS OF THE CLOSURE. THE LAST LINE OF THE W20-H13 SIGN LISTS A PHONE NUMBER WHICH A MOTORIST MAY CALL FOR ADDITIONAL INFORMATION. THIS IS TO BE A SPECIFIC OFFICE WITHIN THE DISTRICT RATHER THAN THE GENERAL SWITCHBOARD NUMBER

THE FOLLOWING QUANTITIES HAVE BEEN INCLUDED IN THE FOR USE AS DETERMINED BY THE ENGINEER FOR THE MAINTENANCE OF TRAFFIC.

ITEM 410, TRAFFIC COMPACTED SURFACE, TYPE A OR B	40 CY
ITEM 614, ASPHALT CONCRETE FOR MAINTAINING TRAFFIC	40 CY

THE CONTRACTOR SHALL PROVIDE, ERECT AND MAINTAIN SIGNS AND SIGN SUPPORTS, AS DETAILED IN THE OHIO MANUAL OF UNIFORM TRAFFIC CONTROL DEVICES, AND TYPE III BARRICADES OF AS SHOWN IN THE MAINTENANCE OF TRAFFIC PLANS.

THE CONTRACTOR SHALL PROVIDE, ERECT AND MAINTAIN STANDARD 48 X 30 INCH ROAD CLOSED SIGNS, SIGN SUPPORTS, BARRICADES AND LIGHTS, AS DETAILED IN TRAFFIC SCD MT-101.60 AT THE FOLLOWING LOCATIONS DURING PERIODS IN WHICH THE AFFECTED ROADS ARE CLOSED TO TRAFFIC.

THROUGHOUT THE DURATION OF THE PROJECT, THE CONTRACTOR SHALL NOTIFY THE PROJECT ENGINEER IN WRITING OF ALL TRAFFIC RESTRICTIONS AND UPCOMING MAINTENANCE OF TRAFFIC CHANGES. THE CONTRACTOR SHALL ENSURE THE WRITTEN NOTIFICATION IS SUBMITTED IN A TIMELY MANNER TO ALLOW THE PROJECT ENGINEER TO MEET THE REQUIRED TIME FRAMES SET FORTH IN THE TABLE BELOW TO INFORM THE SPECIAL HAULING PERMITS SECTION (HAULING.PERMITS@DOT.OHIO.GOV) AND THE DISTRICT PUBLIC INFORMATION OFFICE (PIO). THIS NOTIFICATION SHALL BE RECEIVED BY THE PROJECT ENGINEER PRIOR TO THE PHYSICAL SETUP OF ANY APPLICABLE SIGNS OR MESSAGE BOARDS.

INFORMATION SHOULD INCLUDE, BUT IS NOT LIMITED TO, ALL CONSTRUCTION ACTIVITIES THAT IMPACT OR INTERFERE WITH TRAFFIC AND SHALL LIST THE SPECIFIC LOCATION, TYPE OF WORK, ROAD STATUS, DATE AND TIME OF RESTRICTION, DURATION OF RESTRICTION, NUMBER OF LANES MAINTAINED, NUMBER OF LANES CLOSED, MINIMUM VERTICAL CLEARANCE, MINIMUM WIDTH OF DRIVABLE PAVEMENT, DETOUR ROUTES, IF APPLICABLE, AND ANY OTHER INFORMATION REQUESTED BY THE PROJECT ENGINEER.

NOTIFICATION OF TRAFFIC RESTRICTIONS TIME TABLE		
ITEM	DURATION OF CLOSURE	SIGN DISPLAYED TO PUBLIC
	>= 2 WEEKS	21 CALENDAR DAYS PRIOR TO CLOSURE
RAMP & ROAD CLOSURES	> 12 HOURS & < 2 WEEKS	14 CALENDAR DAYS PRIOR TO CLOSURE
	<= 12 HOURS	4 BUSINESS DAYS PRIOR TO CLOSURE

NOTIFICATION OF TRAFFIC RESTRICTIONS TIME TABLE CONT.		
ITEM	DURATION OF CLOSURE	SIGN DISPLAYED TO PUBLIC
	>= 2 WEEKS	14 CALENDAR DAYS PRIOR TO CLOSURE
LANE CLOSURES & RESTRICTIONS	< 2 WEEKS	5 BUSINESS DAYS PRIOR TO CLOSURE
START OF CONSTRUCTION & TRAFFIC PATTERN CHANGES	N/A	14 CALENDAR DAYS PRIOR TO IMPLEMENTATION

ANY UNFORESEEN CONDITIONS NOT SPECIFIED IN THE PLANS REQUIRING TRAFFIC RESTRICTIONS SHALL ALSO BE REPORTED TO THE PROJECT ENGINEER USING THE NOTIFICATION TIME TABLE.

ALL WORK AND TRAFFIC CONTROL DEVICES SHALL BE IN ACCORDANCE WITH C&MS 614 AND OTHER APPLICABLE PORTIONS OF THE SPECIFICATIONS, AS WELL AS THE OHIO MANUAL OF UNIFORM TRAFFIC CONTROL DEVICES. PAYMENT FOR ALL LABOR, EQUIPMENT AND MATERIALS SHALL BE INCLUDED IN THE LUMP SUM CONTRACT PRICE FOR ITEM 614, MAINTAINING TRAFFIC, UNLESS SEPARATELY ITEMIZED IN THE PLAN.

**DESIGNATED LOCAL DETOUR ROUTE**

IN ADDITION TO THE OFFICIAL, SIGNED DETOUR ROUTE, A LOCAL ROUTE HAS BEEN DETERMINED TO BE THE SECONDARY, UNSIGNED DETOUR ROUTE OR "DESIGNATED LOCAL DETOUR ROUTE." THIS ROUTE IS SHOWN ON SHEET NO. P.13. DURING THE TIME THAT TRAFFIC IS DETOURED, THE CONTRACTOR SHALL MAINTAIN THIS ROUTE IN A CONDITION WHICH IS REASONABLY SMOOTH AND FREE FROM HOLES, RUTS, RIDGES, BUMPS, DUST AND STANDING WATER. ONCE THE DETOUR IS REMOVED AND TRAFFIC RETURNED TO ITS NORMAL PATTERN, THE DESIGNATED LOCAL DETOUR ROUTE SHALL BE RESTORED TO A CONDITION THAT IS EQUIVALENT TO THAT WHICH EXISTED PRIOR TO ITS USE FOR THIS PURPOSE. ALL SUCH WORK SHALL BE PERFORMED WHEN AND AS DETERMINED BY THE ENGINEER.

THE FOLLOWING ITEMS ARE PROVIDED FOR USE AS DETERMINED BY THE ENGINEER TO MAINTAIN AND SUBSEQUENTLY RESTORE THE DESIGNATED LOCAL DETOUR ROUTE:

ITEM 441, ASPHALT CONCRETE SURFACE COURSE, TYPE 1, (448) PG64-22	150 CY
ITEM 407, NON-TRACKING TACK COAT	50 GAL
ITEM 616, WATER	70 MGAL
ITEM 617, COMPACTED AGGREGATE, TYPE A	100 CY
ITEM 617, WATER	50 MGAL

**TRENCH FOR WIDENING**

TRENCH EXCAVATION FOR BASE WIDENING SHALL BE ONLY ON ONE SIDE OF THE PAVEMENT AT A TIME. THE OPEN TRENCH SHALL BE ADEQUATELY MAINTAINED AND PROTECTED WITH DRUMS OR BARRICADES AT ALL TIMES. PLACEMENT OF PROPOSED SUBBASE AND BASE MATERIAL SHALL FOLLOW AS CLOSELY AS POSSIBLE BEHIND EXCAVATION OPERATIONS. THE LENGTH OF WIDENING TRENCH WHICH IS OPEN AT ANY ONE TIME SHALL BE HELD TO A MINIMUM AND SHALL AT ALL TIMES BE SUBJECT TO APPROVAL OF THE ENGINEER.

**DUST CONTROL**

THE CONTRACTOR SHALL FURNISH AND APPLY WATER FOR DUST CONTROL AS DIRECTED BY THE ENGINEER.

**DRUM REQUIREMENTS**

IN ADDITION TO THE REQUIREMENTS OF THE PLANS, SPECIFICATION AND PROPOSAL, DRUMS FURNISHED BY THE CONTRACTOR SHALL BE NEW AND UNUSED AT THE TIME OF ARRIVAL ON THE PROJECT. ANY DRUMS BROUGHT ON THE PROJECT, WHICH HAVE PREVIOUSLY BEEN USED ELSEWHERE, WILL NOT BE ACCEPTED.

PAYMENT FOR DRUMS SHALL BE INCLUDED IN THE LUMP SUM PRICE BID FOR MAINTAINING TRAFFIC UNLESS SEPARATELY ITEMIZED.

**OVERNIGHT TRENCH CLOSING**

THE BASE WIDENING SHALL BE COMPLETED TO A DEPTH OF NO MORE THAN 3 INCHES BELOW THE EXISTING PAVEMENT BY THE END OF EACH WORK DAY. NO TRENCH SHALL BE LEFT OPEN OVERNIGHT EXCEPT FOR A SHORT LENGTH (25 FEET OR LESS) OF A WORK SECTION AT THE END OF THE TRENCH. IN CASE WORK MUST BE SUSPENDED BECAUSE OF INCLEMENT WEATHER OR OTHER REASONS, THE TRENCH FOR THE UNCOMPLETED BASE WIDENING SHALL BE BACKFILLED AT THE DIRECTION OF THE ENGINEER.

**FIRE STATION**

CONTINUOUS EMERGENCY VEHICLE ACCESS TO FIRE STATION #51 SHALL BE MAINTAINED AT ALL TIMES, INCLUDING DURING CLOSURES.

**DETOUR DURATION REQUIREMENTS**

US 68 MAY REQUIRE UP TO EIGHT (8) SHORT-TERM/INTERMEDIATE-TERM CLOSURES, FOR THE PURPOSES OF SUPERSTRUCTURE INSTALLATION AND STRUCTURE PAINTING. SHORT-TERM/INTERMEDIATE-TERM CLOSURES ARE ANY CLOSURES LASTING UP TO 3 CALENDAR DAYS. EACH SHORT-TERM/INTERMEDIATE-TERM CLOSURE IS REQUIRED TO HAVE A POSTED DETOUR. DETOUR SIGNING ALONG THE DETOUR ROUTE SHALL BE INSTALLED OR UNCOVERED NO MORE THAN 3 CALENDAR DAYS BEFORE THE CLOSURE AND SHALL BE REMOVED OR COVERED NO MORE THAN 3 CALENDAR DAYS AFTER THE CLOSURE; DETOUR SIGNING ALONG US 68 SHALL BE INSTALLED/REMOVED ON THE SAME DAY AS THE CLOSURE.

**LAW ENFORCEMENT OFFICER (WITH PATROL CAR) FOR ASSISTANCE DURING CONSTRUCTION OPERATIONS**

USE OF LAW ENFORCEMENT OFFICERS (LEOS) BY CONTRACTORS OTHER THAN THE USES SPECIFIED BELOW SHALL NOT BE PERMITTED AT PROJECT COST NOR TIME COMPENSATION. LEOS SHOULD NOT BE USED WHERE THE OMUTCD INTENDS THAT FLAGGERS BE USED.

IN ADDITION TO THE REQUIREMENTS OF C&MS 614 AND THE OMUTCD, A UNIFORMED LEO WITH AN OFFICIAL PATROL CAR (CAR WITH TOP-MOUNTED EMERGENCY FLASHING LIGHTS AND COMPLETE MARKINGS OF THE APPROPRIATE LAW ENFORCEMENT AGENCY) SHALL BE PROVIDED FOR THE FOLLOWING TRAFFIC CONTROL TASKS:

DURING THE ENTIRE ADVANCE PREPARATION AND CLOSURE SEQUENCE WHERE COMPLETE BLOCKAGE OF TRAFFIC IS REQUIRED. DURING A TRAFFIC SIGNAL INSTALLATION WHEN IMPACTING THE NORMAL FUNCTION OF THE SIGNAL OR THE FLOW OF TRAFFIC, OR WHEN TRAFFIC NEEDS TO BE DIRECTED THROUGH AN ENERGIZED TRAFFIC SIGNAL CONTRARY TO THE SIGNAL DISPLAY (E.G., DIRECTING MOTORISTS THROUGH A RED LIGHT).

IN GENERAL, LEOS SHOULD BE POSITIONED IN ADVANCE OF AND ON THE SAME SIDE AS THE LANE RESTRICTION (OR AT THE POINT OF ROAD CLOSURE), AND TO MANUALLY CONTROL TRAFFIC MOVEMENTS THROUGH SIGNALIZED INTERSECTIONS AND/OR IN CONTRARY TO OTHER TRAFFIC CONTROL DEVICES IN WORK ZONES.

LEOS SHOULD NOT FORGO THEIR TRAFFIC CONTROL RESPONSIBILITIES TO APPREHEND MOTORISTS FOR ROUTINE TRAFFIC VIOLATIONS. HOWEVER, IF A MOTORIST'S ACTIONS ARE CONSIDERED TO BE RECKLESS, THEN PURSUIT OF THE MOTORIST IS APPROPRIATE.

THE LEOS WORK AT THE DIRECTION OF THE CONTRACTOR. THE CONTRACTOR IS RESPONSIBLE FOR SECURING THE SERVICES OF THE LEOS WITH THE APPROPRIATE AGENCIES AND COMMUNICATING THE INTENTIONS OF THE PLANS WITH RESPECT TO DUTIES OF THE LEOS. THE ENGINEER SHALL HAVE FINAL CONTROL OVER THE LEOS' DUTIES AND PLACEMENT, AND WILL RESOLVE ANY ISSUES THAT MAY ARISE BETWEEN THE TWO PARTIES.

ENSURE PROVIDED LEOS HAVE BEEN TRAINED APPROPRIATE TO THE JOB DECISIONS THEY ARE REQUIRED TO MAKE WHILE ON THE PROJECT, IN ACCORDANCE WITH C&MS 614.03.

**LAW ENFORCEMENT OFFICER (WITH PATROL CAR) FOR ASSISTANCE DURING CONSTRUCTION OPERATIONS (CONT.)**

THE LEO SHALL REPORT IN TO THE CONTRACTOR PRIOR TO THE START OF THE SHIFT, IN ORDER TO RECEIVE INSTRUCTIONS REGARDING SPECIFIC WORK ASSIGNMENTS DURING HIS/HER SHIFT. THE SHIFT DURATION SHALL NOT BE LESS THAN THE LEO'S MINIMUM SHOW-UP TIME REQUIRED BY THEIR LAW ENFORCEMENT AGENCY. THE LEO IS EXPECTED TO STAY AT THE PROJECT SITE FOR THE ENTIRE DURATION OF HIS/HER SHIFT. THE LEO SHALL REPORT TO THE CONTRACTOR AT THE END OF HIS/HER SHIFT. SHOULD IT BE NECESSARY TO LEAVE THE PROJECT SITE, THE LEO SHALL NOTIFY THE ENGINEER. THE CONTRACTOR SHALL PROVIDE THE LEO WITH A TWO-WAY COMMUNICATION DEVICE THAT SHALL BE RETURNED TO THE CONTRACTOR AT THE END OF HIS/HER SHIFT.

LEOS (WITH PATROL CAR) REQUIRED BY THE TRAFFIC MAINTENANCE TASKS ABOVE SHALL BE PAID FOR ON A UNIT PRICE (HOURLY) BASIS UNDER ITEM 614, LAW ENFORCEMENT OFFICER (WITH PATROL CAR) FOR ASSISTANCE. THE FOLLOWING ESTIMATED QUANTITIES ARE TO BE USED AS DIRECTED BY THE ENGINEER.

ITEM 614, LAW ENFORCEMENT OFFICE WITH PATROL CAR FOR ASSISTANCE 80 HOURS

ANY ADDITIONAL COSTS (ADMINISTRATIVE OR OTHERWISE) INCURRED BY THE CONTRACTOR TO OBTAIN THE SERVICES OF AN LEO ARE INCLUDED WITH THE BID UNIT PRICE FOR ITEM 614, LAW ENFORCEMENT OFFICER WITH PATROL CAR FOR ASSISTANCE.

**DETOUR ROUTE**

THE FOLLOWING DETOUR ROUTE SHALL BE USED FOR SHORT-TERM/ INTERMEDIATE-TERM DETOURS IN CONJUNCTION WITH THE DETOUR PLAN

DETOUR ROUTE FOR U.S. 68 SOUTHBOUND TRAFFIC:  
 TRAVEL SOUTH ON U.S. 68.  
 TURN EAST ONTO STATE ROUTE 343.  
 TURN SOUTH ON STATE ROUTE 72.  
 TURN WEST ONTO U.S. 42.  
 TURN WEST ONTO U.S. 35.  
 TURN SOUTH ONTO U.S. 68.

DETOUR ROUTE FOR U.S. 68 NORTHBOUND TRAFFIC:  
 TRAVEL NORTH ON U.S. 68.  
 TURN EAST ONTO U.S. 35.  
 TURN NORTH ON U.S. 42.  
 TURN NORTH ONTO STATE ROUTE 72.  
 TURN WEST ON STATE ROUTE 343.  
 RECONNECT WITH NORTHBOUND U.S. 68.

**DETOUR DURATION REQUIREMENTS**

U.S. 68 MAY REQUIRE UP TO EIGHT (8) SHORT-TERM/INTERMEDIATE-TERM CLOSURES, FOR THE PURPOSES OF SUPERSTRUCTURE INSTALLATION AND STRUCTURE PAINTING. SHORT-TERM/INTERMEDIATE-TERM CLOSURES ARE AND CLOSURES LASTING UP TO 3 CALENDAR DAYS. EACH SHORT-TERM/ INTERMEDIATE-TERM CLOSURE IS REQUIRED TO HAVE A POSTED DETOUR. DETOUR SIGNING ALONG THE DETOUR ROUTE SHALL BE INSTALLED OR UNCOVERED NO MORE THAN 3 CALENDAR DAYS BEFORE THE CLOSURE AND SHALL BE REMOVED OR COVERED NO MORE THAN 3 CALENDAR DAYS AFTER THE CLOSURE; DETOUR SIGNING ALONG U.S. 68 SHALL BE INSTALLED/ REMOVED ON THE SAME DAY AS THE CLOSURE. THE SIGNING SHALL BE INSTALLED PER THE DETOUR PLAN.

**LITTLE MIAMI SCENIC TRAIL DETOUR**

THE FOLLOWING DETOUR ROUTE SHALL BE USED IN CONJUNCTION WITH THE LITTLE MIAMI SCENIC TRAIL DETOUR PLAN TO DETOUR PEDESTRIAN AND BICYCLE TRAFFIC ON THE LITTLE MIAMI SCENIC TRAIL.

DETOUR ROUTE FOR NORTHBOUND PEDESTRIANS/BICYCLES:  
 TRAVEL NORTH ON LITTLE MIAMI SCENIC TRAIL  
 TURN WEST AT OLD TOWN RESERVE PARK  
 TURN NORTH ON U.S. 68  
 TURN EAST ON BRUSH ROW ROAD  
 TURN NORTH ON LITTLE MIAMI SCENIC TRAIL

DETOUR ROUTE FOR SOUTHBOUND PEDESTRIANS/BICYCLES:  
 TRAVEL SOUTH ON LITTLE MIAMI SCENIC TRAIL  
 TURN WEST ON BRUSH ROW ROAD  
 TURN SOUTH ON U.S. 68  
 TURN EAST AT OLD TOWN RESERVE PARK  
 TURN SOUTH ON LITTLE MIAMI SCENIC TRAIL

DESIGN AGENCY



DESIGNER  
 WCS

REVIEWER  
 BAA 03/28/25

PROJECT ID  
 115388

SHEET TOTAL  
 P.08 | P.107



**SEQUENCE OF CONSTRUCTION**

**PHASE 1**

TRAFFIC SHALL BE SHIFTED TO THE EAST SIDE OF THE ROADWAY, UTILIZING THE EXISTING PAVEMENT TO MAINTAIN TRAFFIC WHILE WORKING ON THE WEST SIDE OF THE ROADWAY. TWO TRAVEL LANES, ONE NORTHBOUND AND ONE SOUTHBOUND SHALL BE PROVIDED DURING THIS PHASE. PEDESTRIAN ACCESS SHALL BE MAINTAINED BY UTILIZING THE EXISTING SIDEWALK ON THE EAST SIDE OF THE ROADWAY.

THE WORK ON THE EAST SIDE INCLUDES NEW CURB REPLACEMENT WITH A SAW CUT LINE 2' FROM THE EXISTING CURB, PAVEMENT PLANING AND SURFACE COURSE, A SHARED USE PATH, CURB RAMP RECONSTRUCTION, DRIVEWAY RECONSTRUCTION, AND THE REPLACEMENT OF THE RRFB.

**SEQUENCE OF CONSTRUCTION**

**PHASE 2**

 

TRAFFIC SHALL BE SHIFTED TO THE WEST SIDE OF THE ROADWAY, UTILIZING THE EXISTING PAVEMENT TO MAINTAIN TRAFFIC WHILE WORKING ON THE EAST SIDE OF THE ROADWAY. TWO TRAVEL LANES, ONE NORTHBOUND AND ONE SOUTHBOUND SHALL BE PROVIDED DURING THIS PHASE. PEDESTRIAN ACCESS SHALL BE MAINTAINED BY UTILIZING THE NEW SHARED USE PATH ON THE WEST SIDE OF THE ROADWAY.


THE WORK ON THE WEST SIDE INCLUDES NEW CURB REPLACEMENT WITH A SAW CUT LINE 2' FROM THE EXISTING CURB, PAVEMENT PLANING AND SURFACE COURSE, CONCRETE WALK, CURB RAMP RECONSTRUCTION, DRIVEWAY RECONSTRUCTION, AND THE REPLACEMENT OF THE RRFB. BRUSH ROW ROAD INTERSECTION WILL BE CONSTRUCTED WITH THIS PHASE.

**PLANING AND RESURFACING**

THE CONTRACTOR MAY PERFORM PLANING AND RESURFACING OPERATIONS OUTSIDE OF THE LISTED PHASES. THE CONTRACTOR SHALL UTILIZE FLAGGERS TO DIRECT TRAFFIC DURING THIS OPERATION. ALL WORK AND MAINTENANCE OF TRAFFIC SHALL MEET THE REQUIREMENTS OF THE OHIO CONSTRUCTION AND MATERIAL SPECIFICATIONS AND STANDARD DRAWINGS, CURRENT EDITIONS. ALL CONSTRUCTION SIGNAGE AND THE DEVICES EMPLOYED FOR MAINTENANCE OF TRAFFIC SHALL MEET THE STANDARDS ESTABLISHED IN THE OHIO MANUAL OF UNIFORM TRAFFIC CONTROL DEVICES (OMUTCD), CURRENT EDITION.


**LEGEND**

-  CONSTRUCTED IN PREVIOUS PHASE
-  CURRENT CONSTRUCTION PHASE

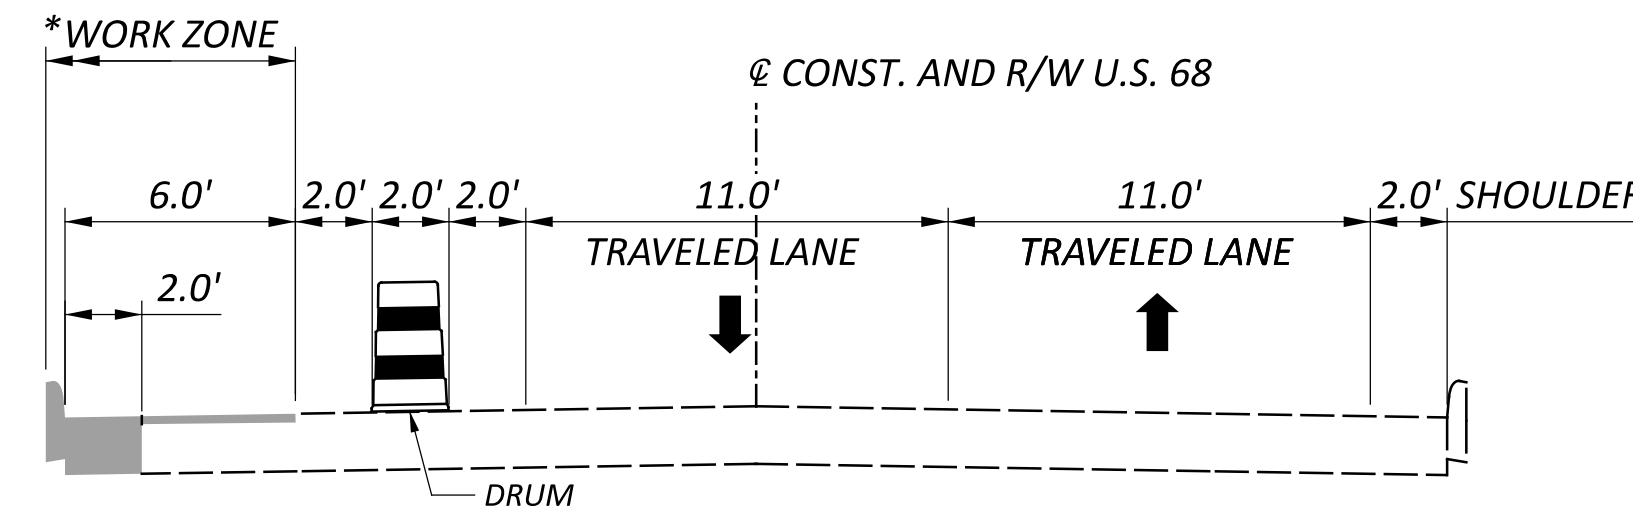

**MAINTENANCE OF TRAFFIC SECTION PHASE 1 - U.S. 68**


STA. 91+46.67 TO STA. 105+16.10

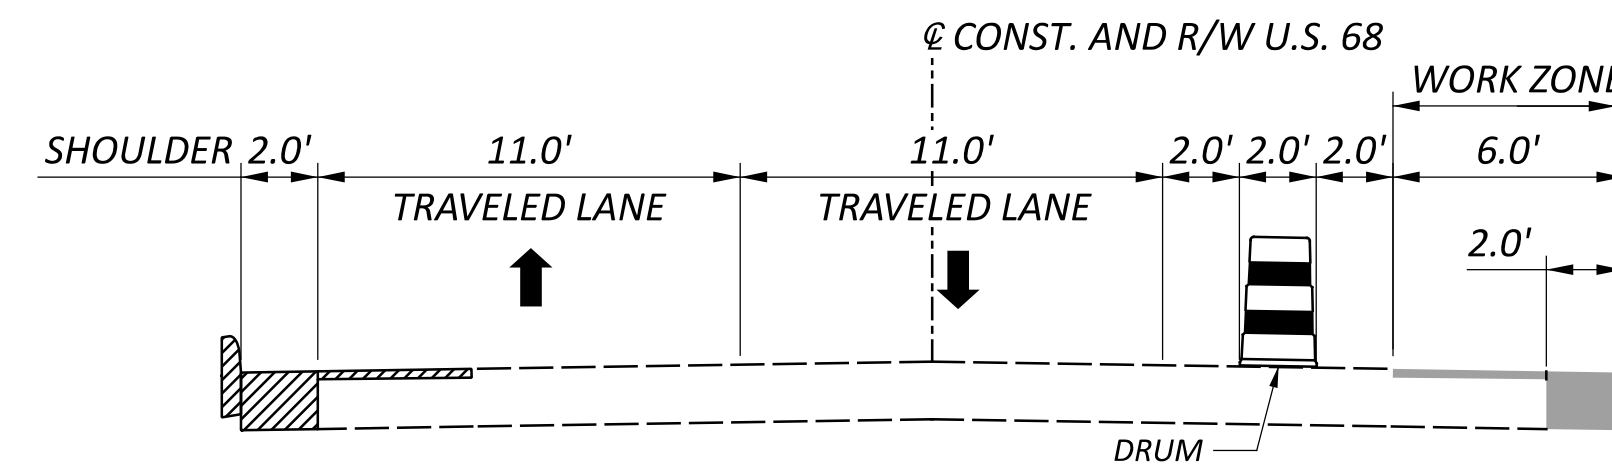

**MAINTENANCE OF TRAFFIC SECTION PHASE 2 - U.S. 68**


STA. 91+46.67 TO STA. 105+16.10

NOTE:  
\* WORK ZONE IS TO INCLUDE ALL WORK WITHIN THE CONSTRUCTION LIMITS THAT IS PAST THE CURB

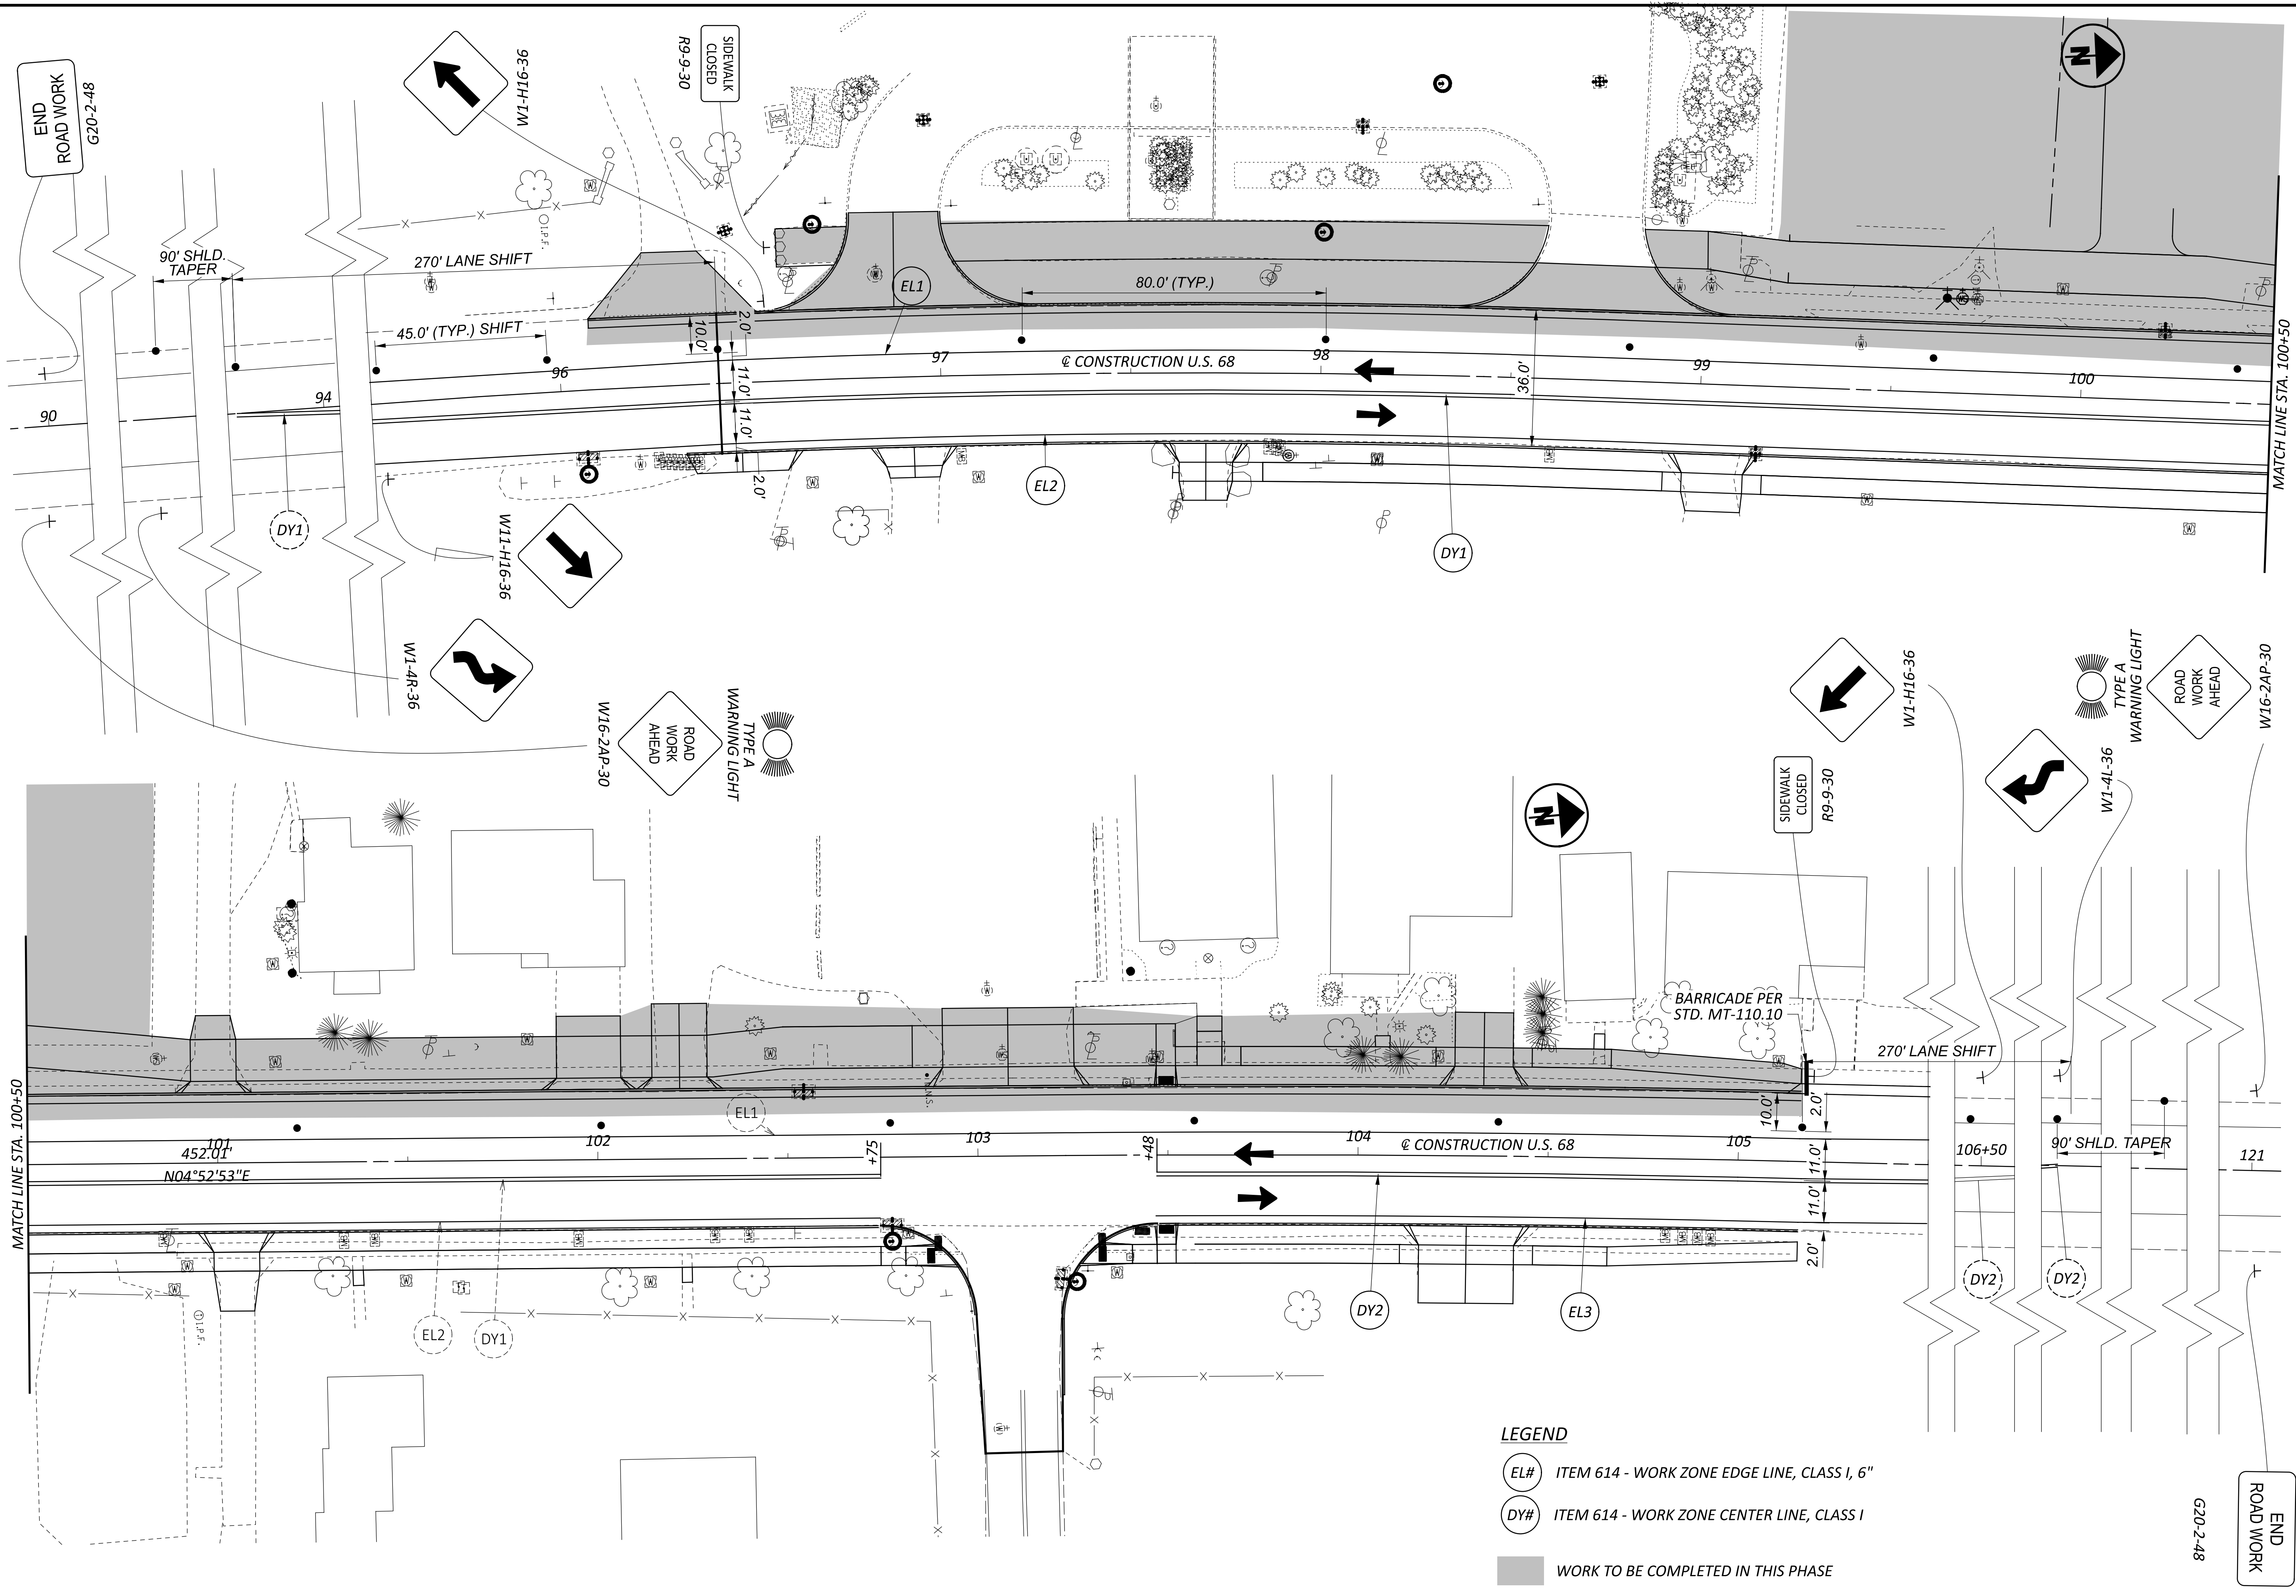

**LEGEND**

- EL# ITEM 614 - WORK ZONE EDGE LINE, CLASS I, 6"
- DY# ITEM 614 - WORK ZONE CENTER LINE, CLASS I
- WORK TO BE COMPLETED IN THIS PHASE

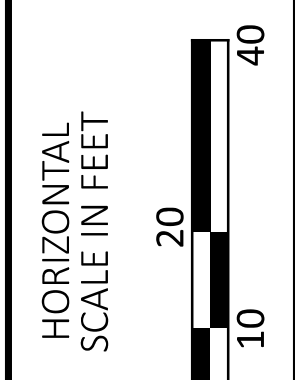

**MAINTENANCE OF TRAFFIC PLAN  
 PHASE 1**

DESIGN AGENCY	
<b>CARPENTER MARTY</b>	
DESIGNER	WCS
REVIEWER	BAA 03/28/25
PROJECT ID	115388
SHEET	TOTAL
P.10	P.107


END ROAD WORK

G20-2-48


MATCH LINE STA. 100+50

MATCH LINE STA. 100+50

END ROAD WORK  
G20-2-48










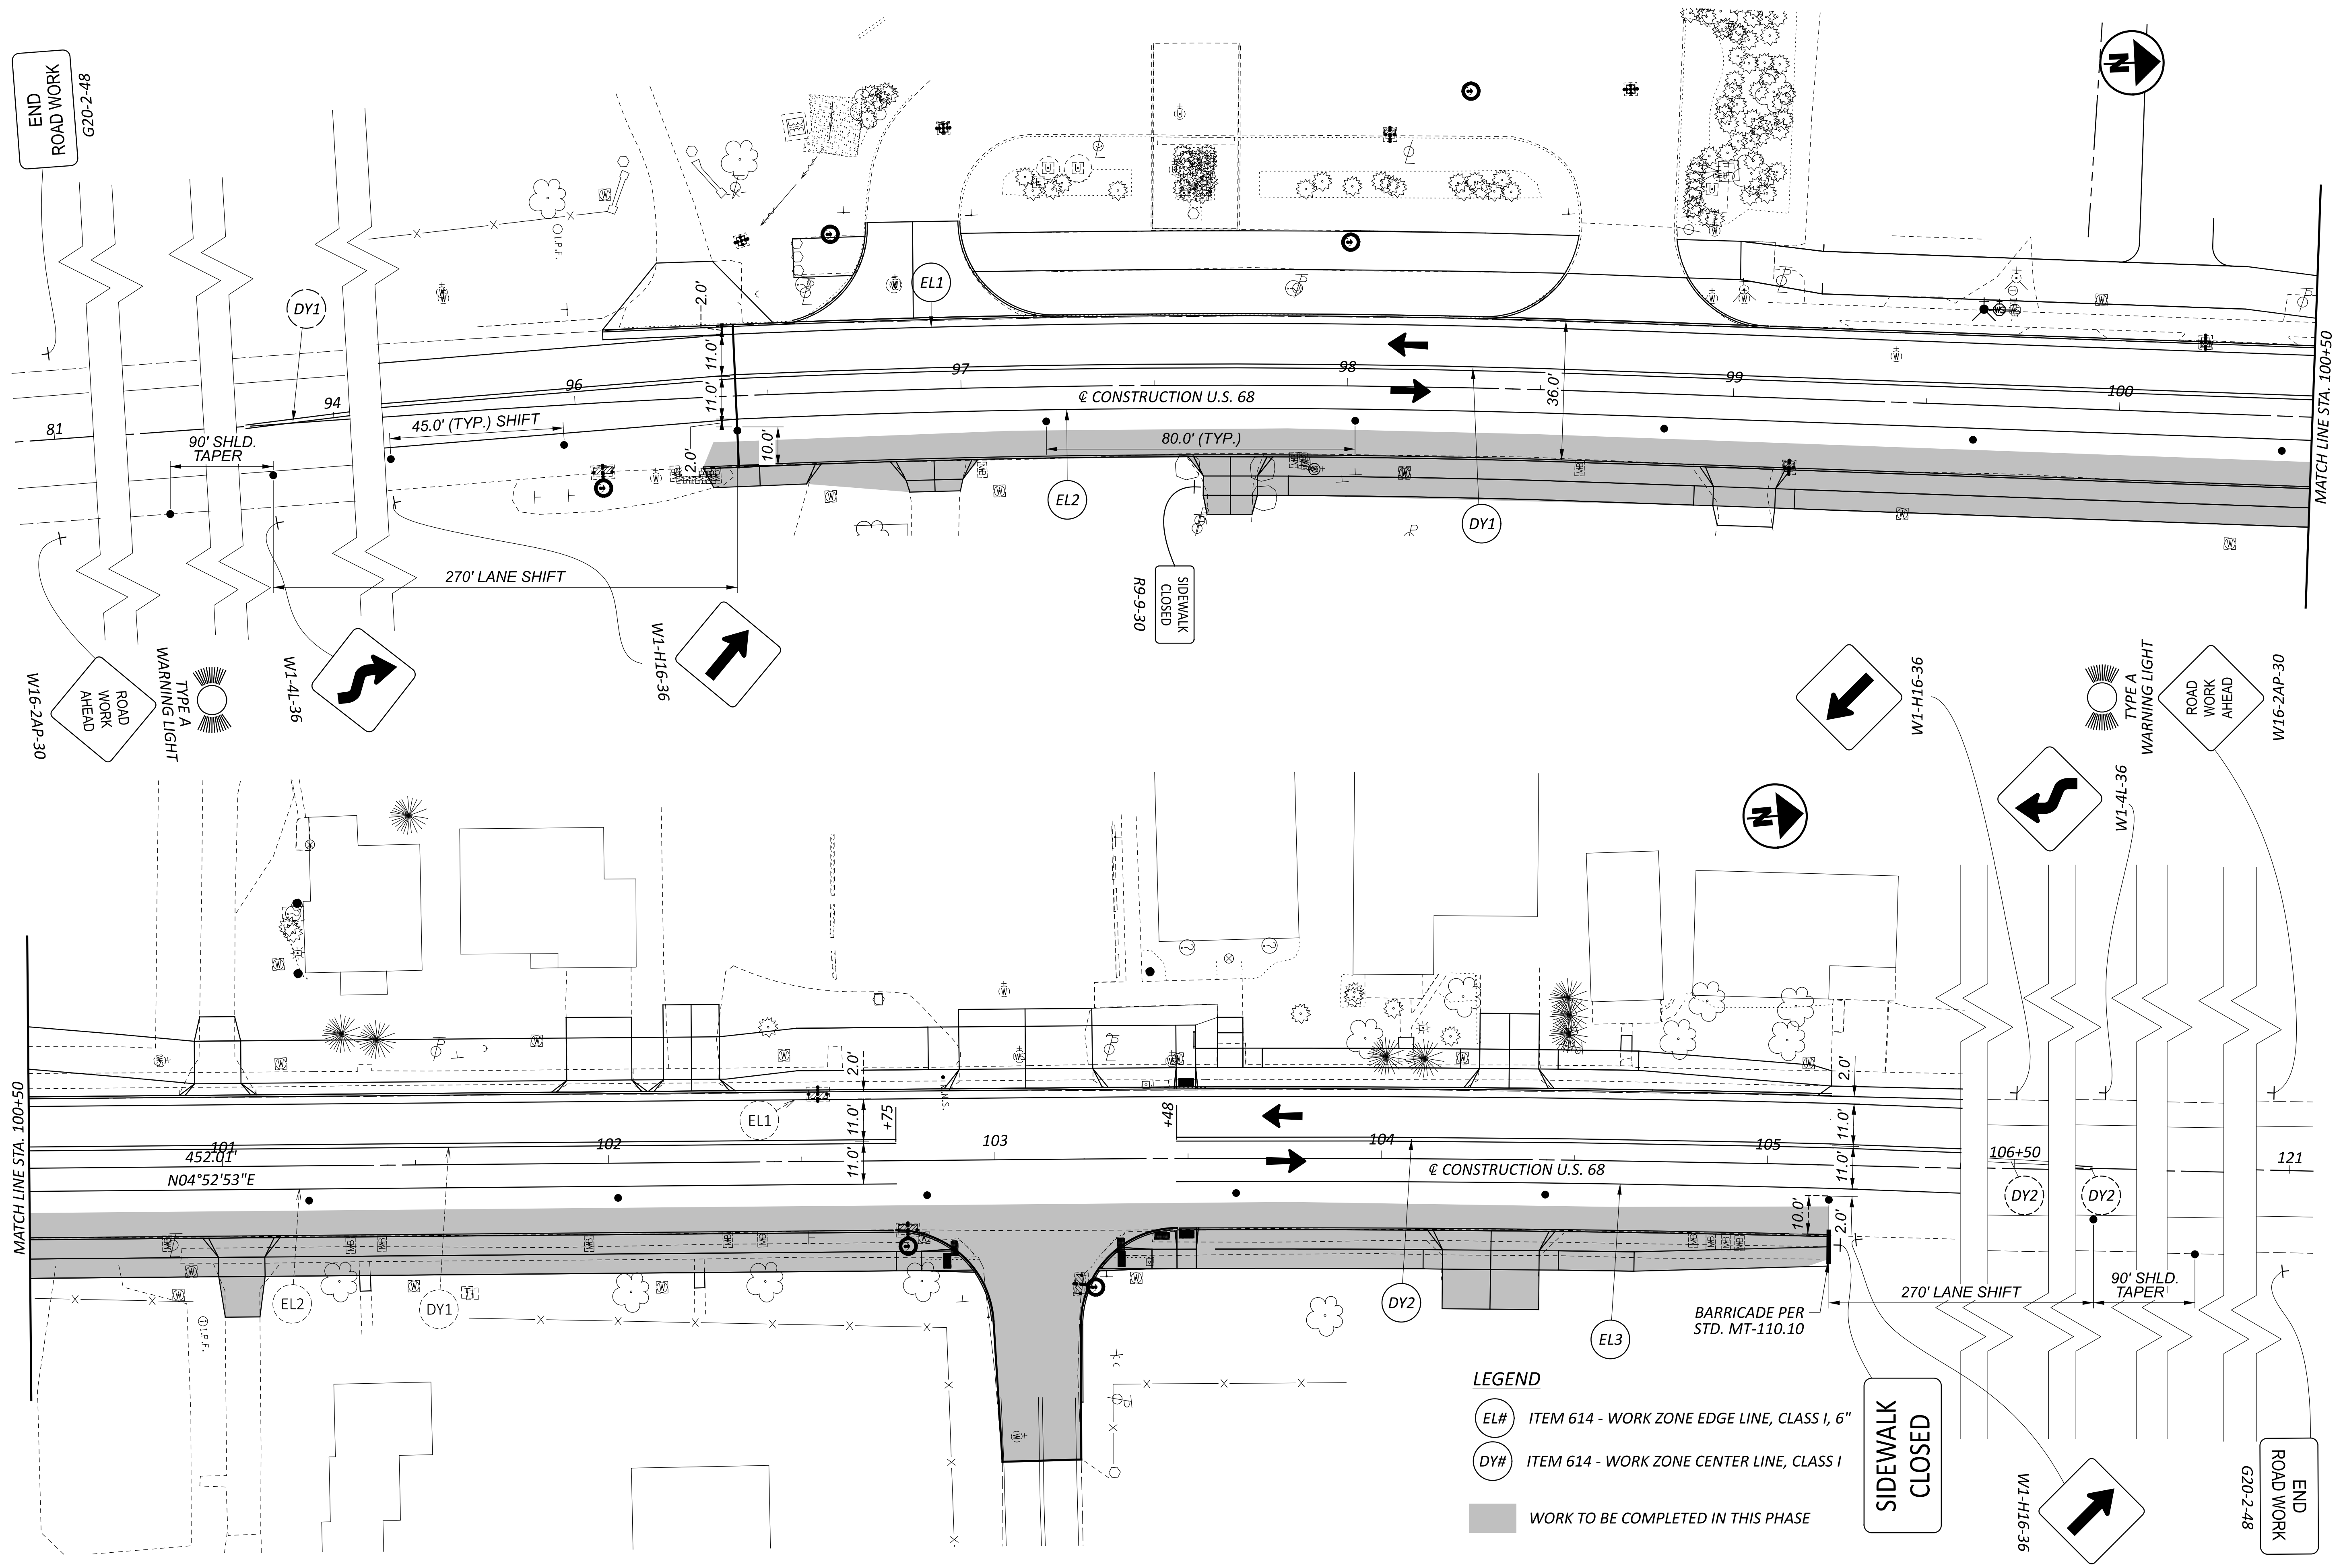


- LEGEND**
- EL# ITEM 614 - WORK ZONE EDGE LINE, CLASS 1, 6"
  - DY# ITEM 614 - WORK ZONE CENTER LINE, CLASS 1
  - WORK TO BE COMPLETED IN THIS PHASE

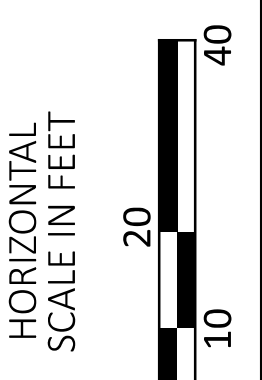

MAINTENANCE OF TRAFFIC PLAN  
 PHASE 2

DESIGN AGENCY	
CARPENTER MARTY	
DESIGNER	WCS
REVIEWER	BAA 03/28/25
PROJECT ID	115388
SHEET	TOTAL
P.11	P.107

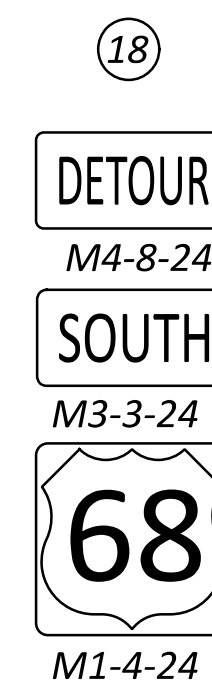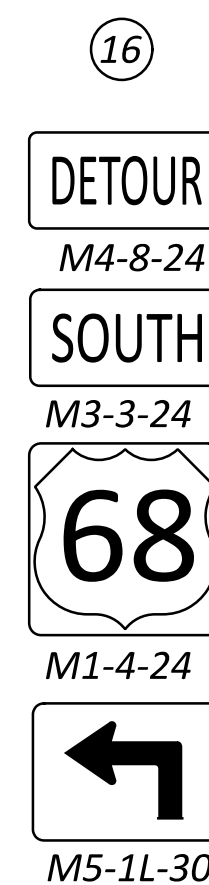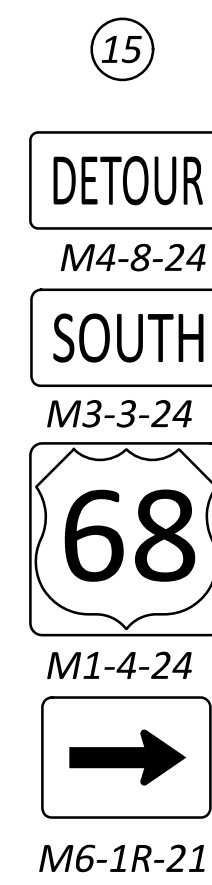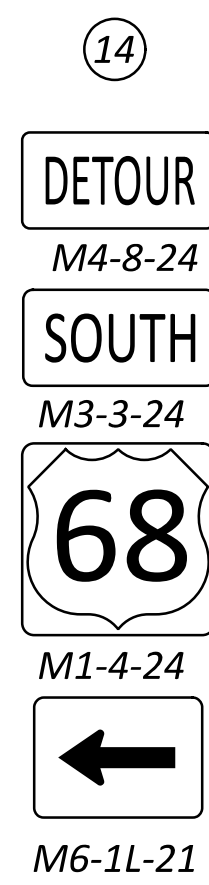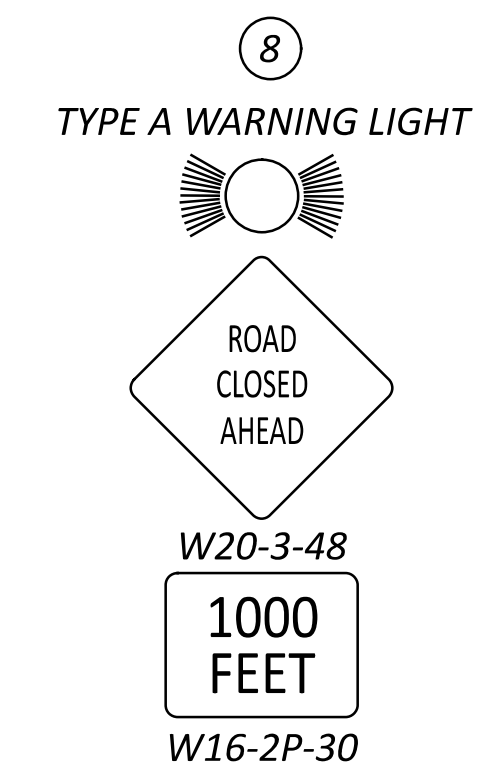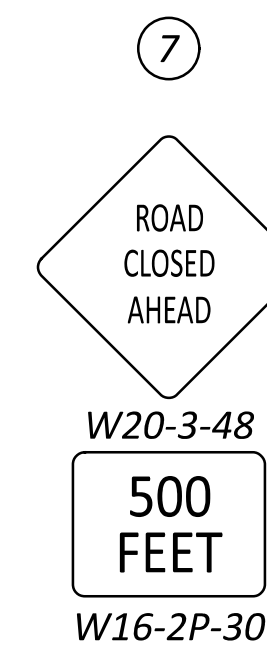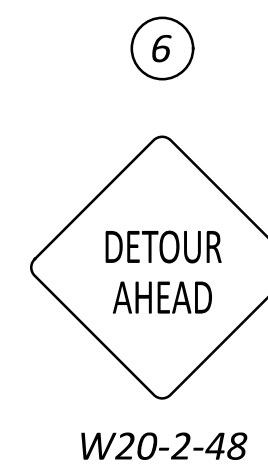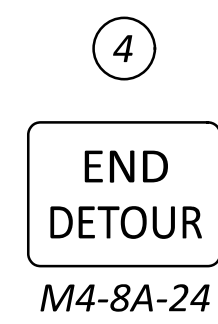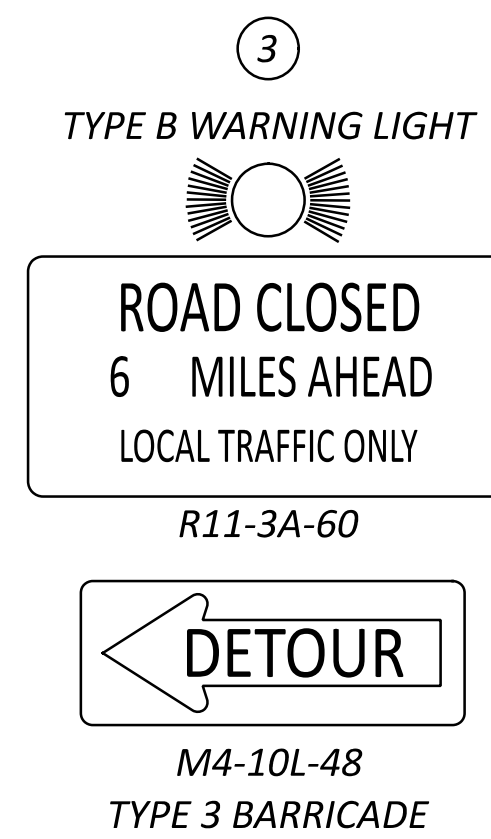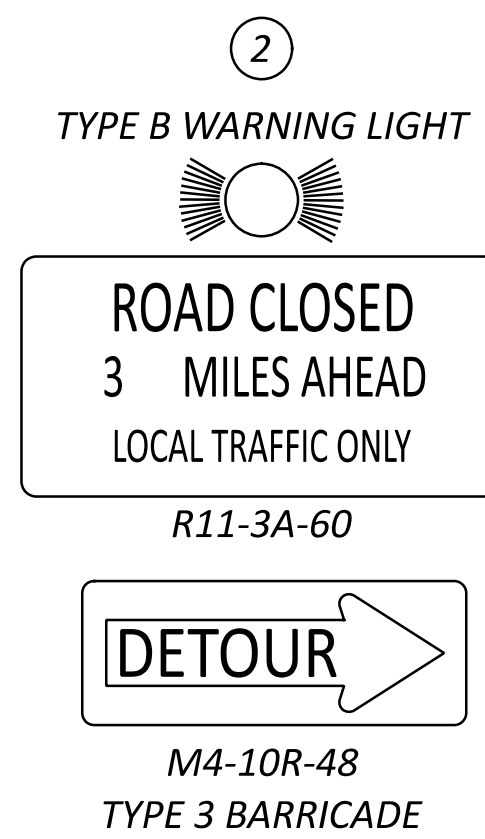




**NOTE**  
1. SEE SHEET P.13 FOR U.S. 68 DETOUR PLAN



ENLARGED PLAN






ENLARGED PLAN

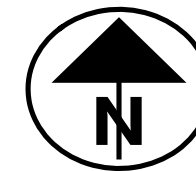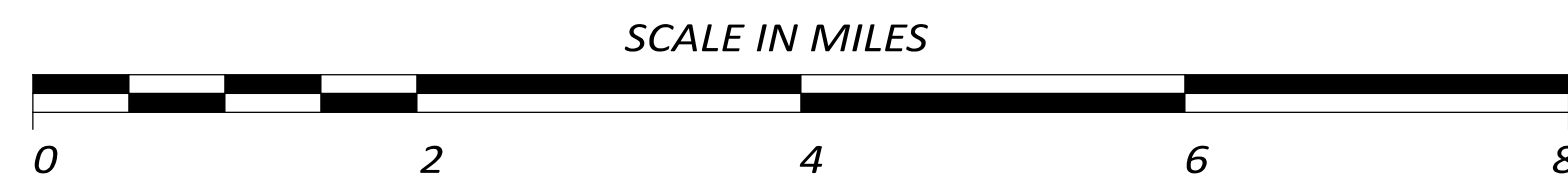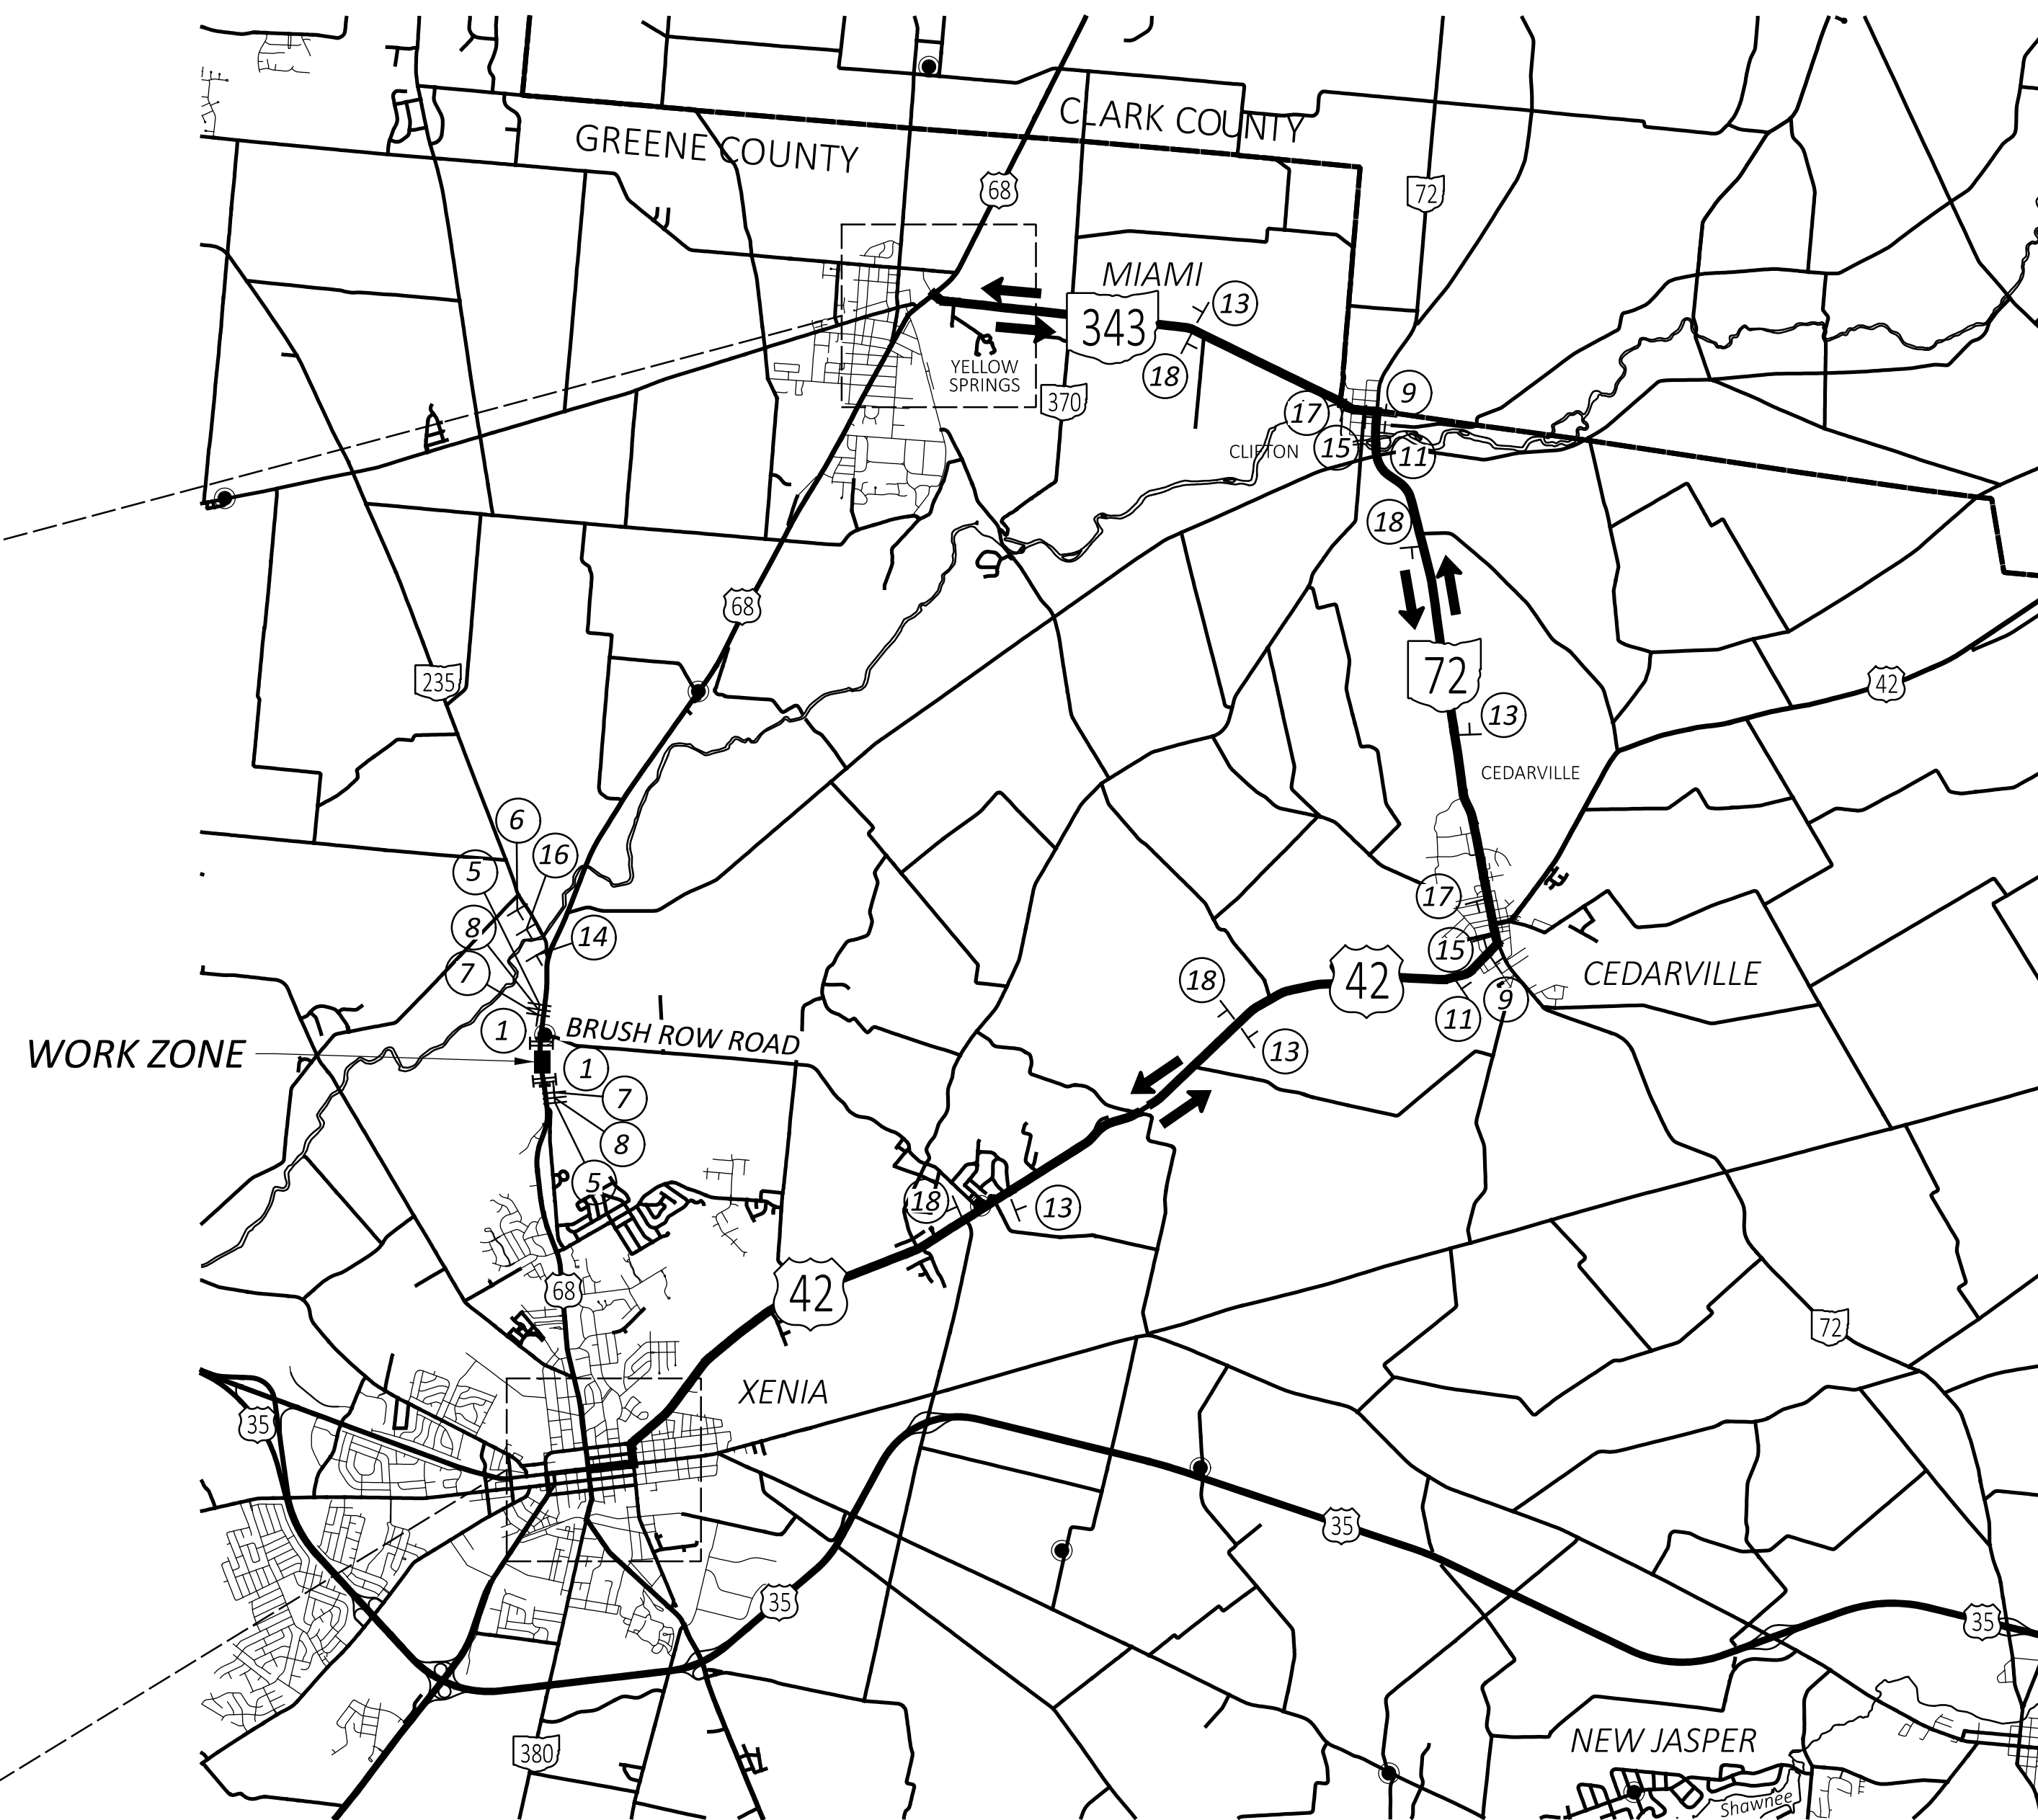

— DETOUR ROUTE

- NOTES:
1. DETOUR PLAN IS TO BE USED FOR SHORT-TERM/ INTERMEDIATE-TERM DETOURS ONLY SEE MOT NOTES FOR INFORMATION
  2. SEE SHEET P.12 FOR DETOUR SIGNS


DESIGN AGENCY	CARPENTER MARTY
DESIGNER	WCS
REVIEWER	BAA 03/28/25
PROJECT ID	115388
SHEET TOTAL	P.13 P.107

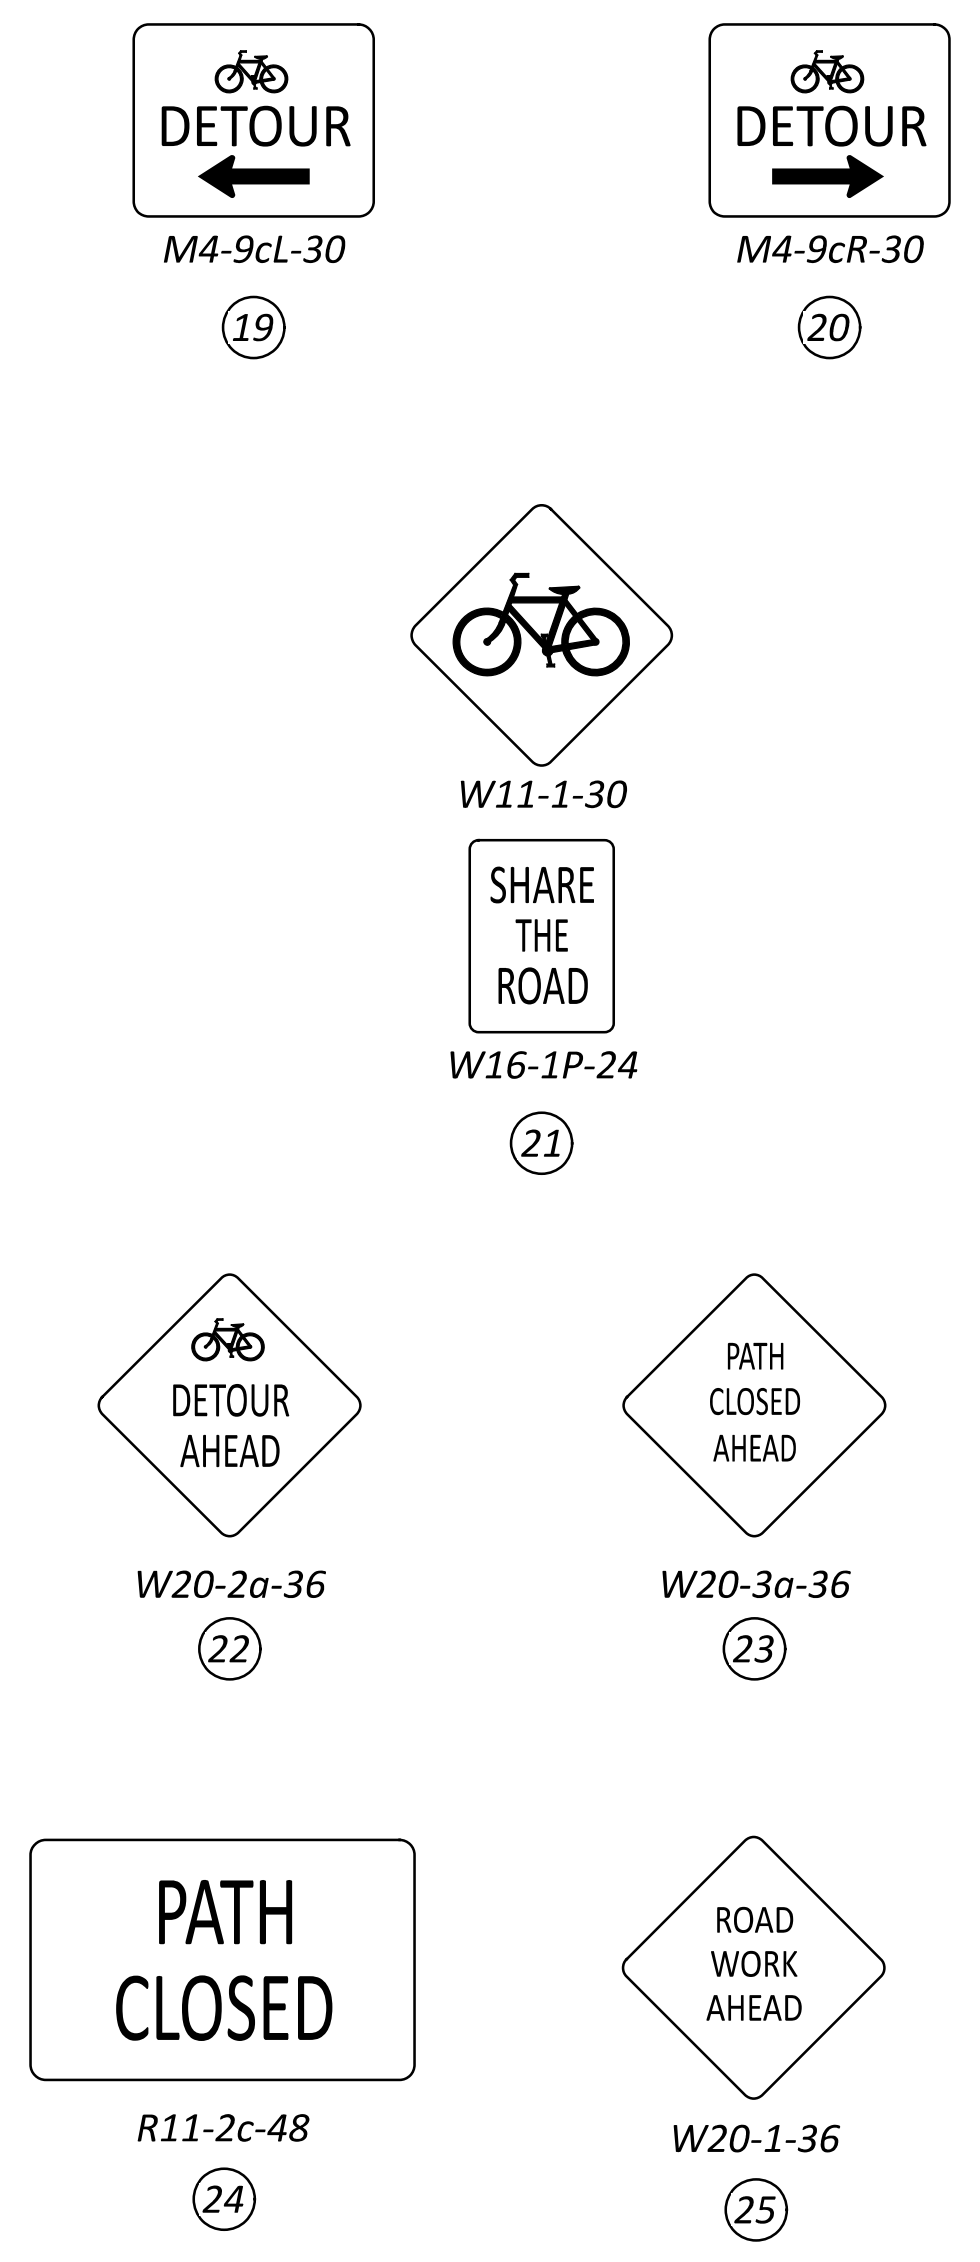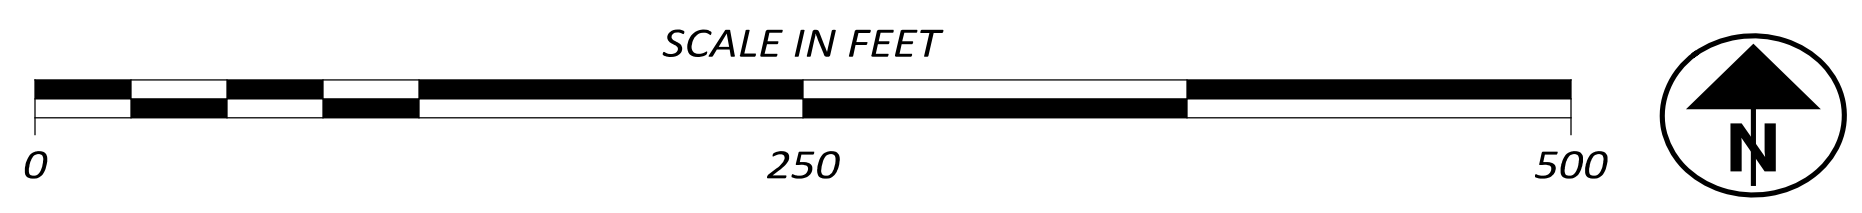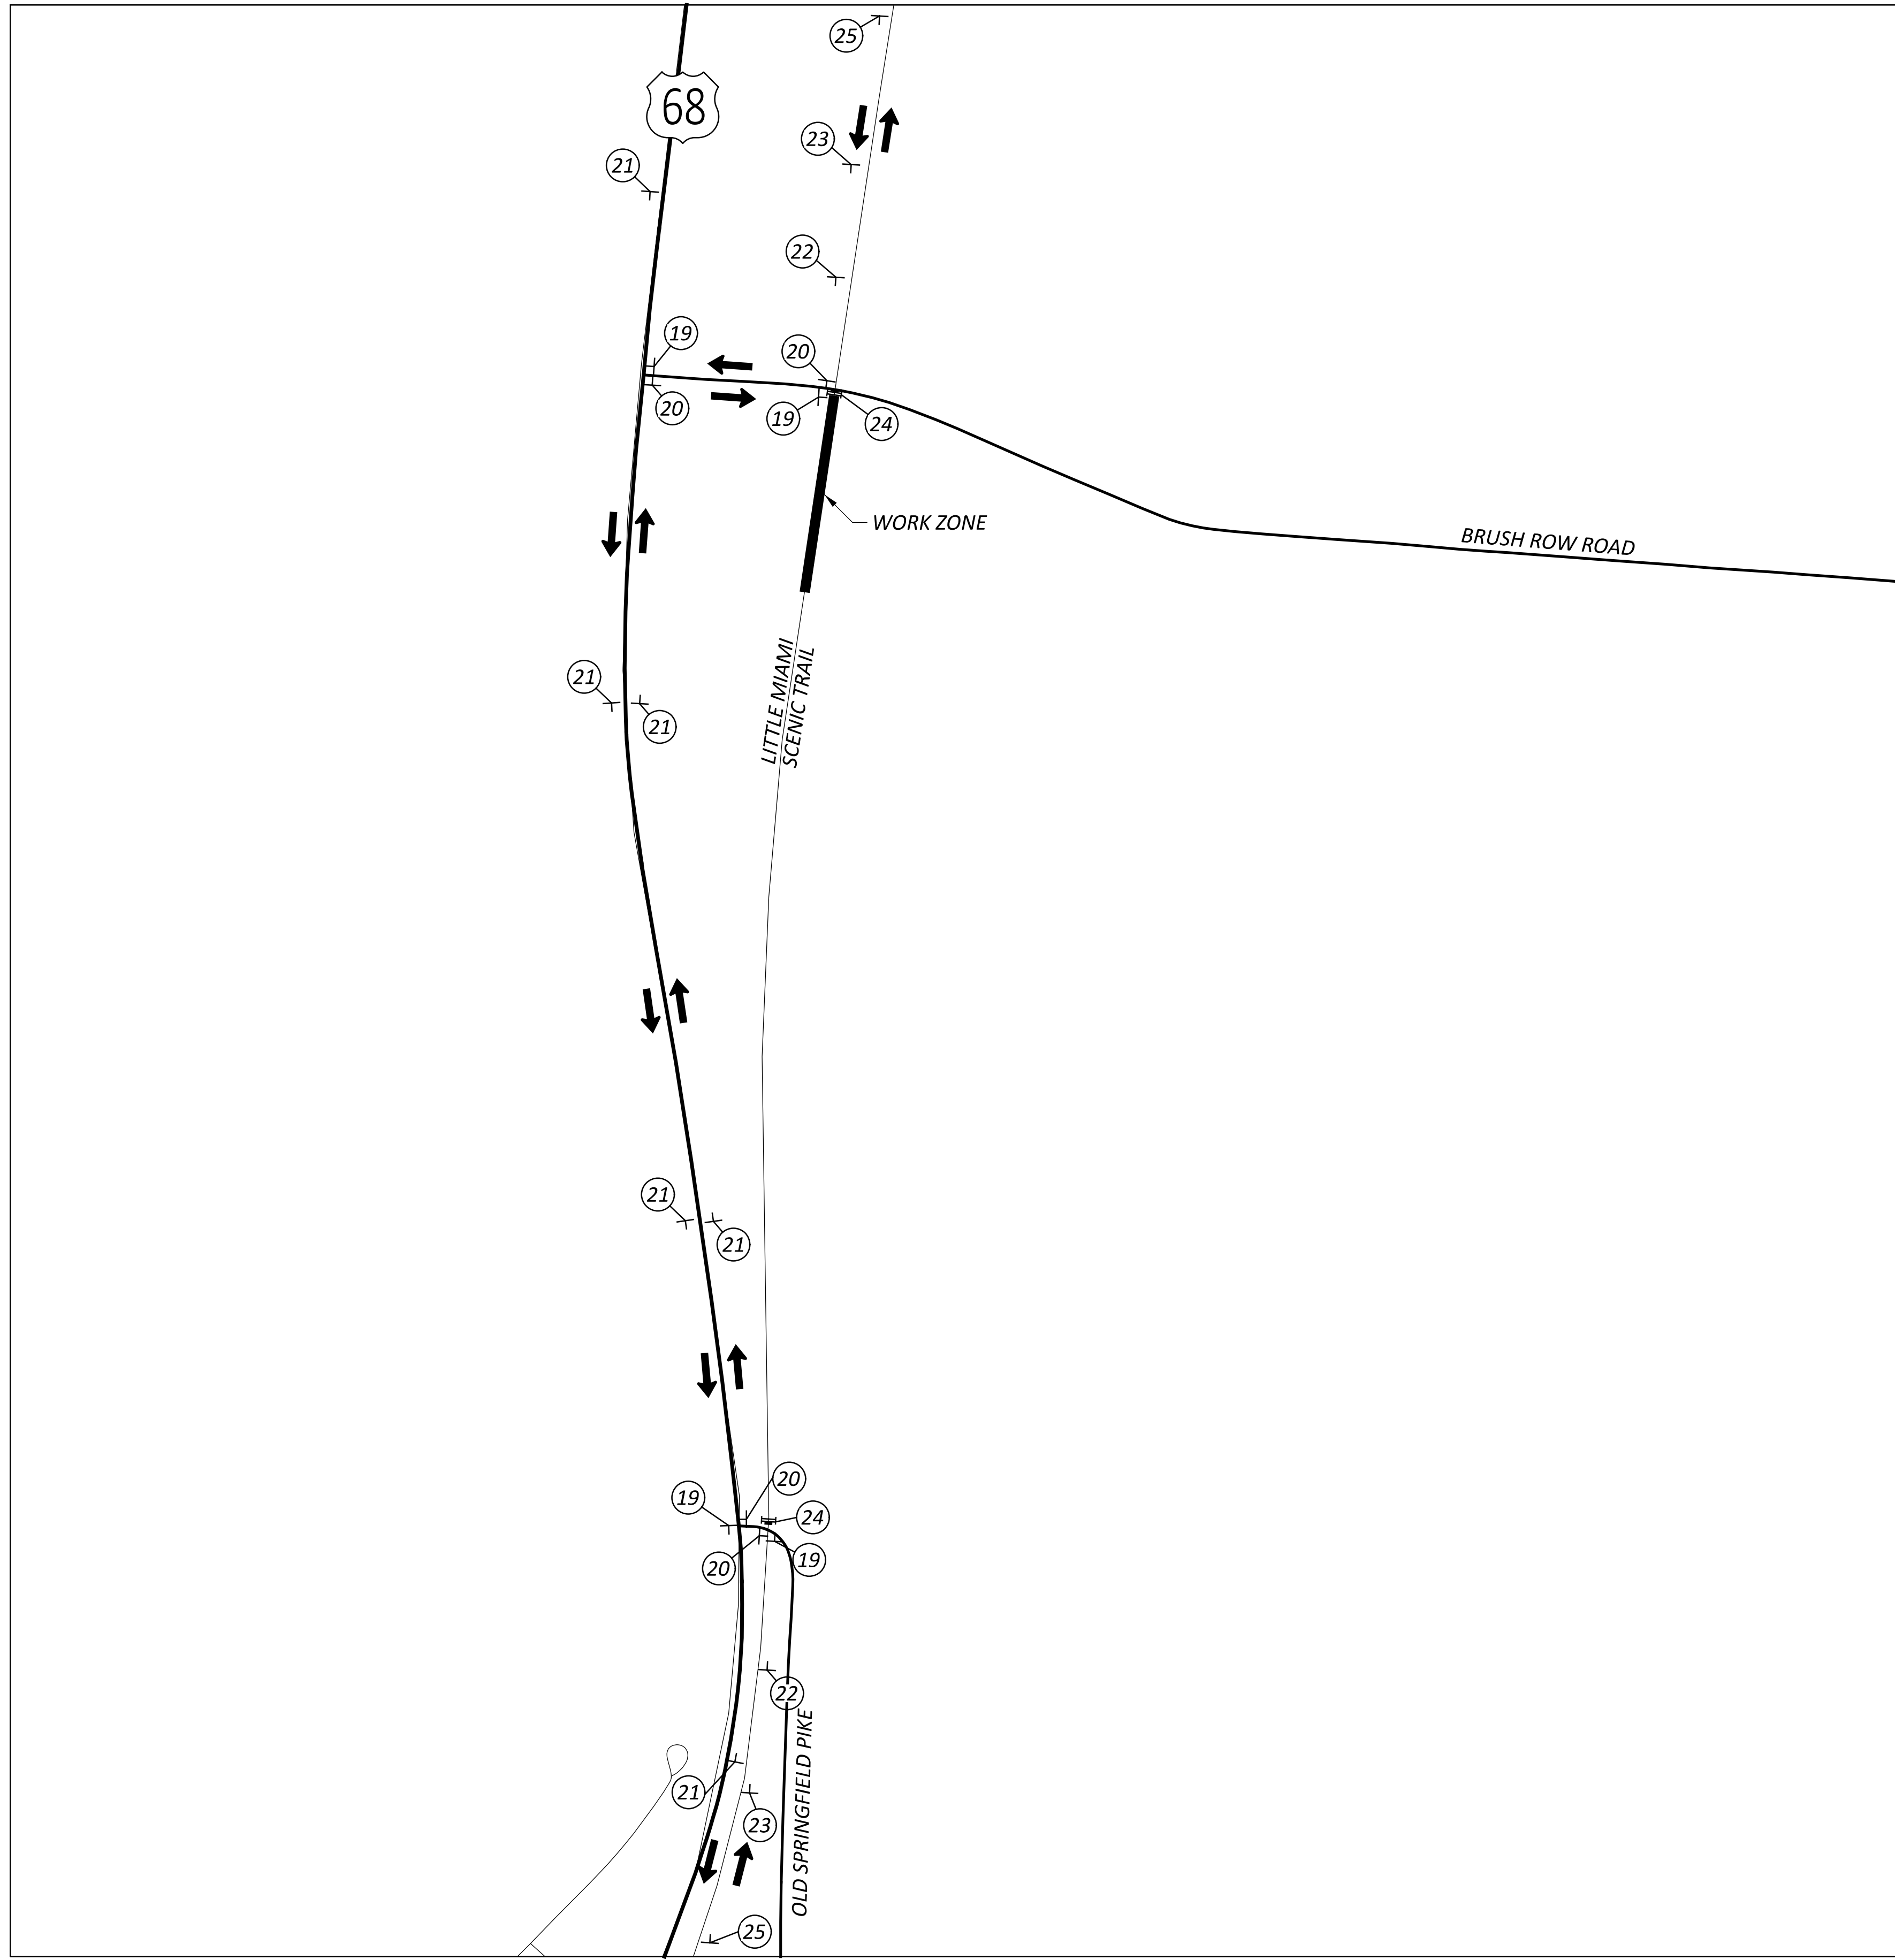

DETOUR PLAN  
 LITTLE MIAMI SCENIC TRAIL - BICYCLE

DESIGN AGENCY	
DESIGNER	
CEF	
REVIEWER	
BAA 03/28/25	
PROJECT ID	
115388	
SHEET	TOTAL
P.14	P.107



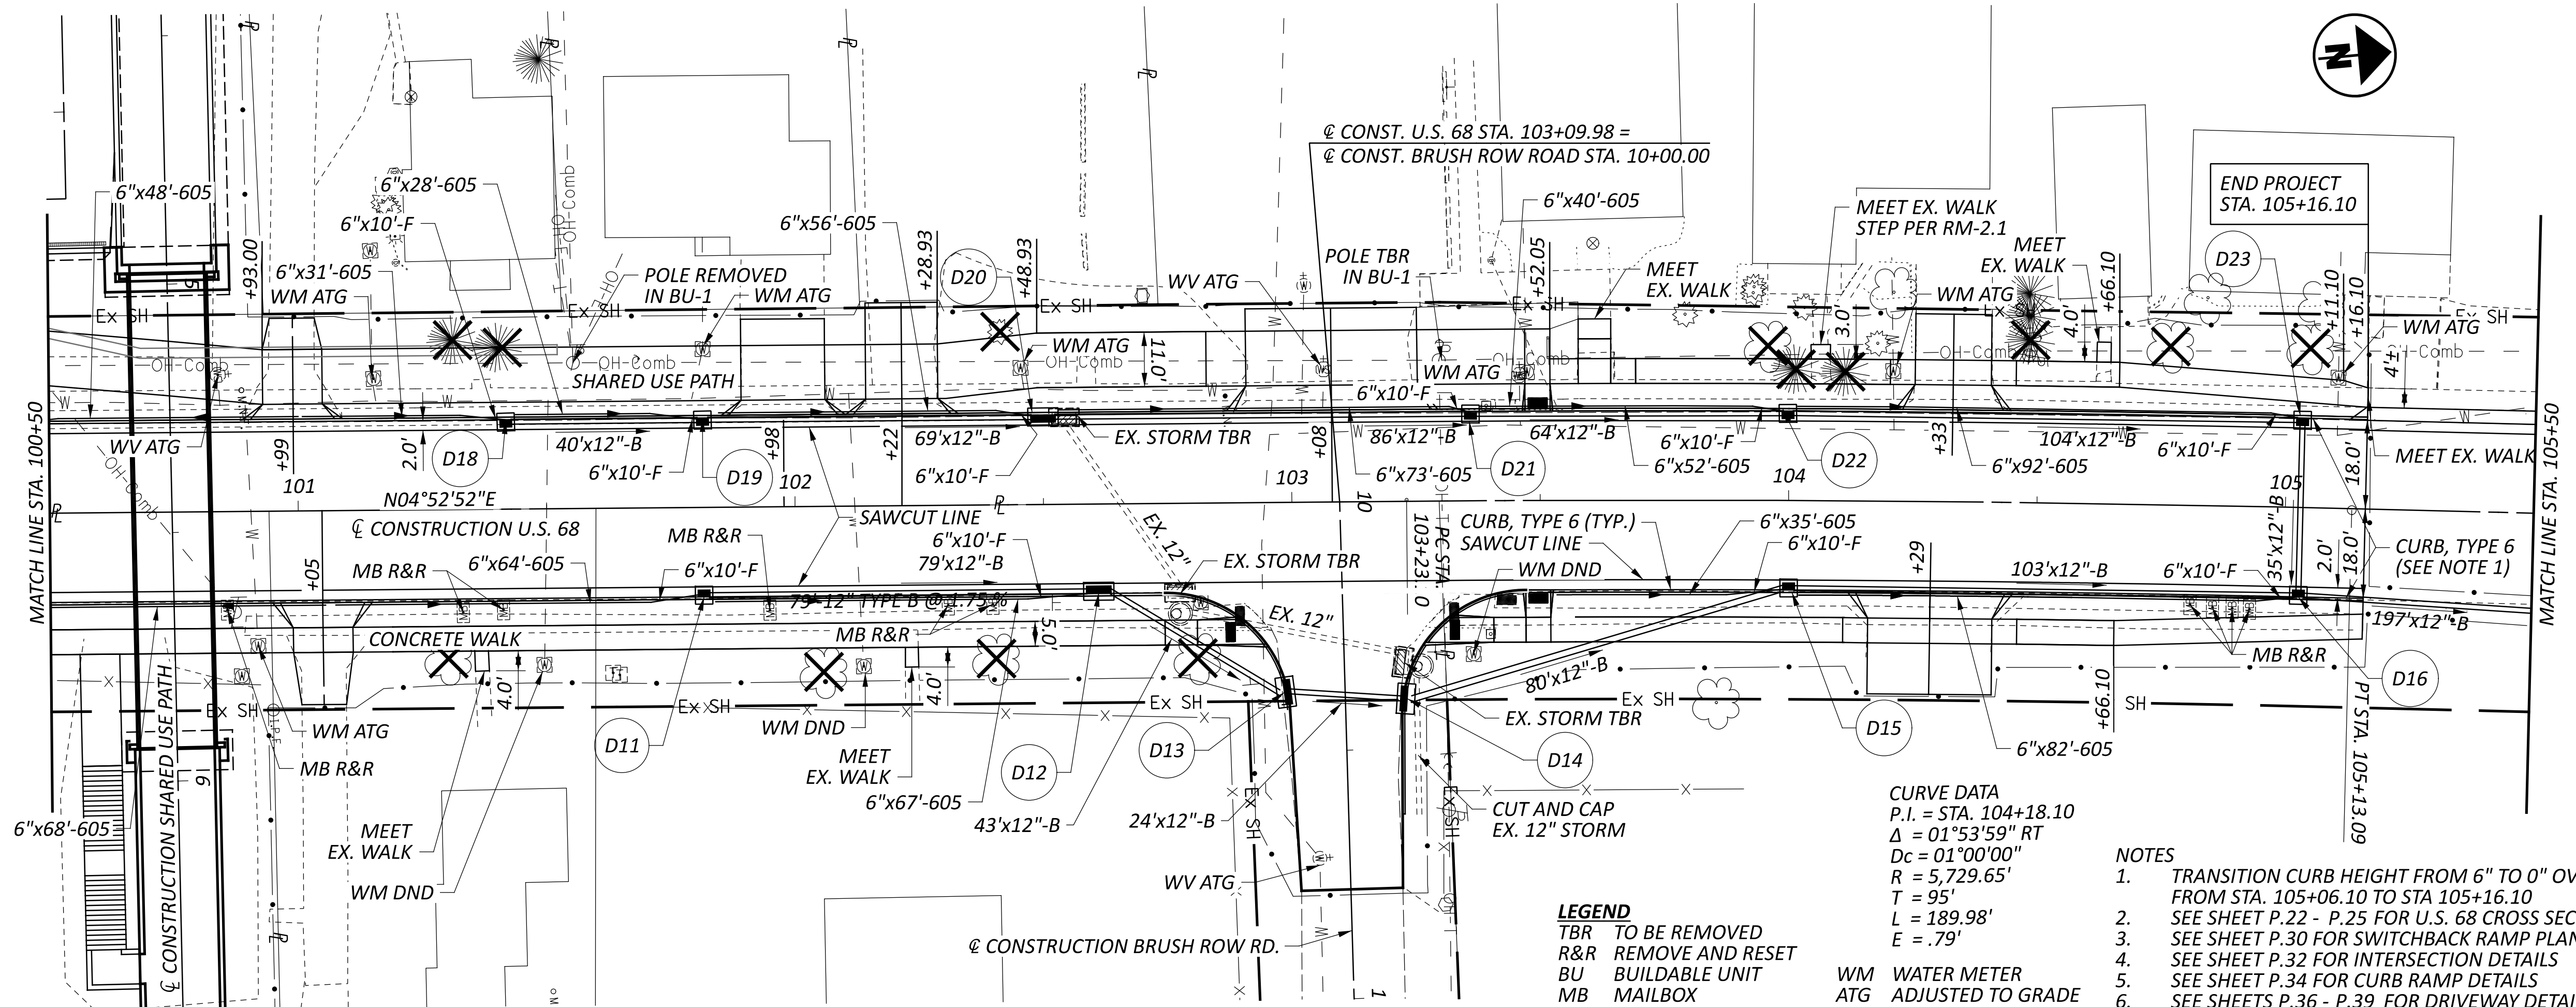



@ CONST. U.S. 68 STA. 103+09.98 =  
 @ CONST. BRUSH ROW ROAD STA. 10+00.00

END PROJECT  
 STA. 105+16.10

**CURVE DATA**  
 P.I. = STA. 104+18.10  
 $\Delta = 01^{\circ}53'59''$  RT  
 $D_c = 01^{\circ}00'00''$   
 $R = 5,729.65'$   
 $T = 95'$   
 $L = 189.98'$   
 $E = .79'$

**LEGEND**  
 TBR TO BE REMOVED  
 R&R REMOVE AND RESET  
 BU BUILDABLE UNIT  
 MB MAILBOX  
 EX EXISTING  
 J&B JACK AND BORED  
 WM WATER METER  
 ATG ADJUSTED TO GRADE  
 DND DO NOT DISTURB  
 WV WATER VALVE  
 X TREE REMOVED IN BU-2


- NOTES**
1. TRANSITION CURB HEIGHT FROM 6" TO 0" OVER 10' FROM STA. 105+06.10 TO STA 105+16.10
  2. SEE SHEET P.22 - P.25 FOR U.S. 68 CROSS SECTIONS
  3. SEE SHEET P.30 FOR SWITCHBACK RAMP PLAN
  4. SEE SHEET P.32 FOR INTERSECTION DETAILS
  5. SEE SHEET P.34 FOR CURB RAMP DETAILS
  6. SEE SHEETS P.36 - P.39 FOR DRIVEWAY DETAILS
  7. SEE SHEETS P.43 - P.44 FOR STORM SEWER PROFILES
  8. SEE SHEETS P.47 - P.71 FOR BRIDGE STRUCTURE PLANS
  9. SEE SHEET P.87 FOR TRAFFIC CONTROL PLAN

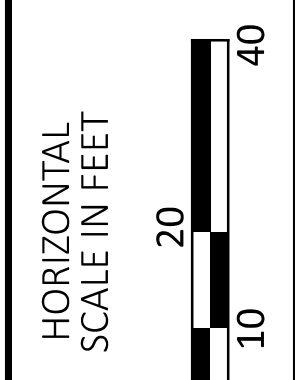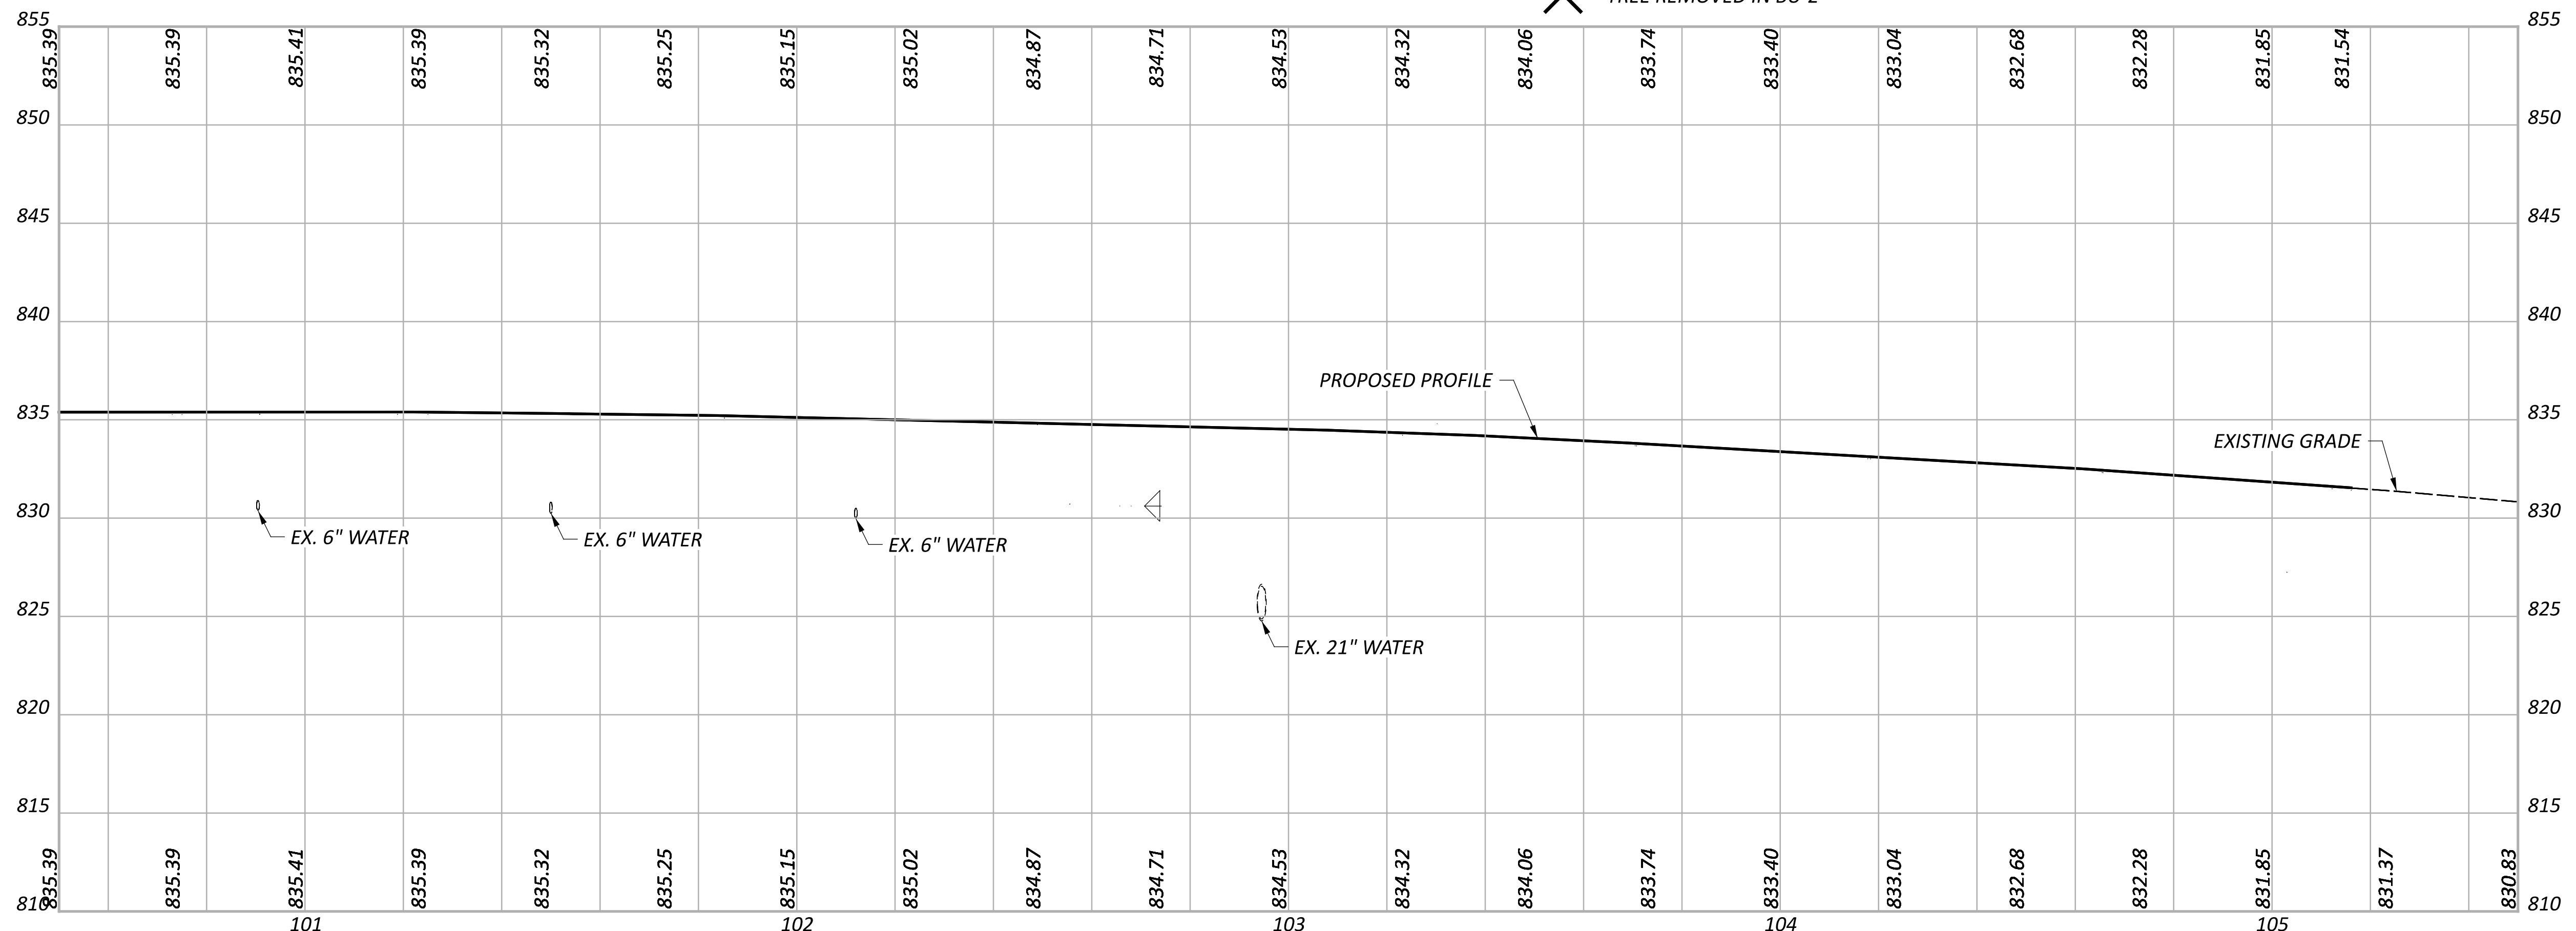

**PLAN AND PROFILE - U.S. 68**  
**STA. 100+50.00 TO STA. 105+50.00**


DESIGN AGENCY  
  
 DESIGNER  
 WCS  
 REVIEWER  
 BAA 03/28/25  
 PROJECT ID  
 115388  
 SHEET TOTAL  
 P.16 P.107



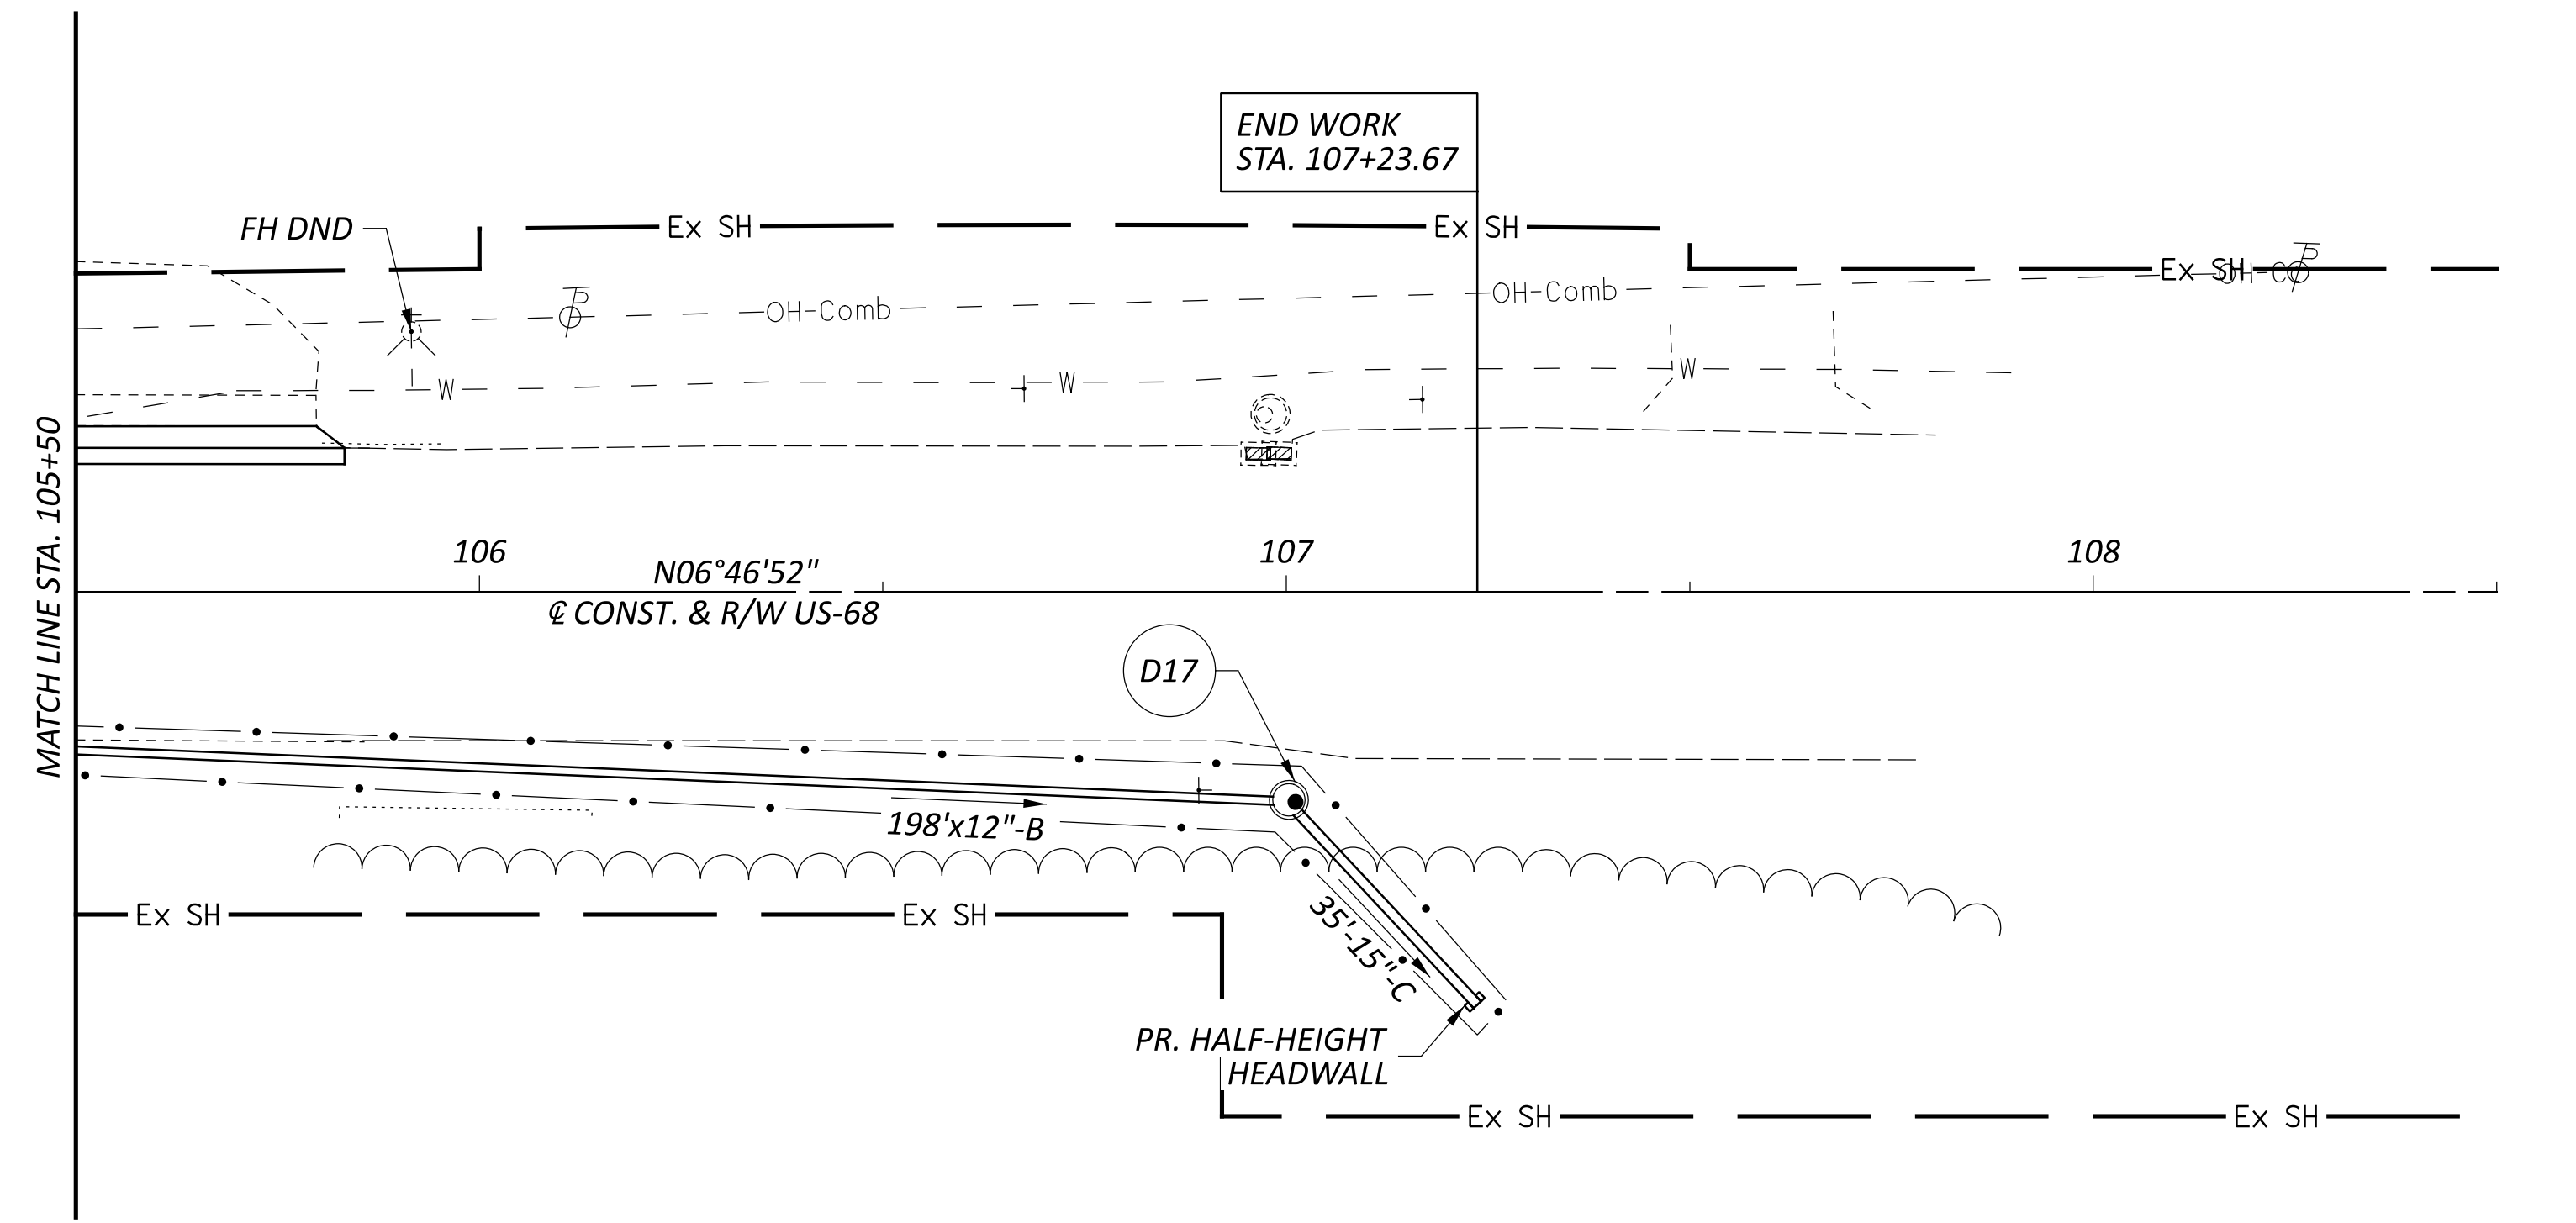

PLAN AND PROFILE - U.S. 68  
 STA. 105+50.00 TO STA. 108+50.00

DESIGN AGENCY

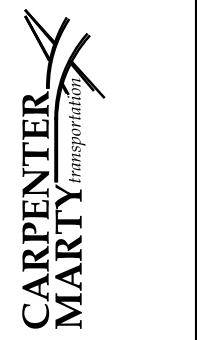

DESIGNER

WCS

REVIEWER




BAA 03/28/25

PROJECT ID

115388




SHEET TOTAL

P.17 P.107

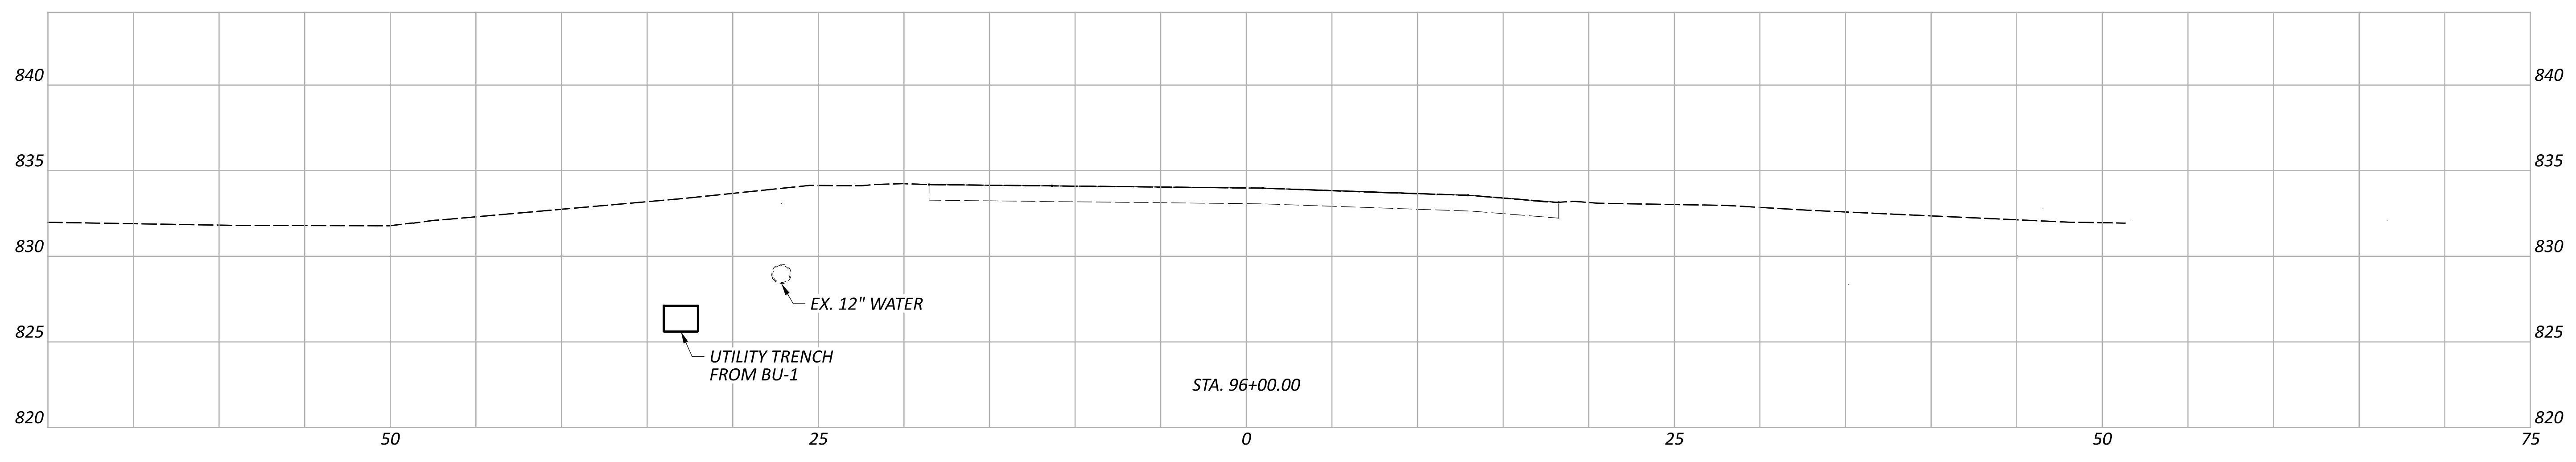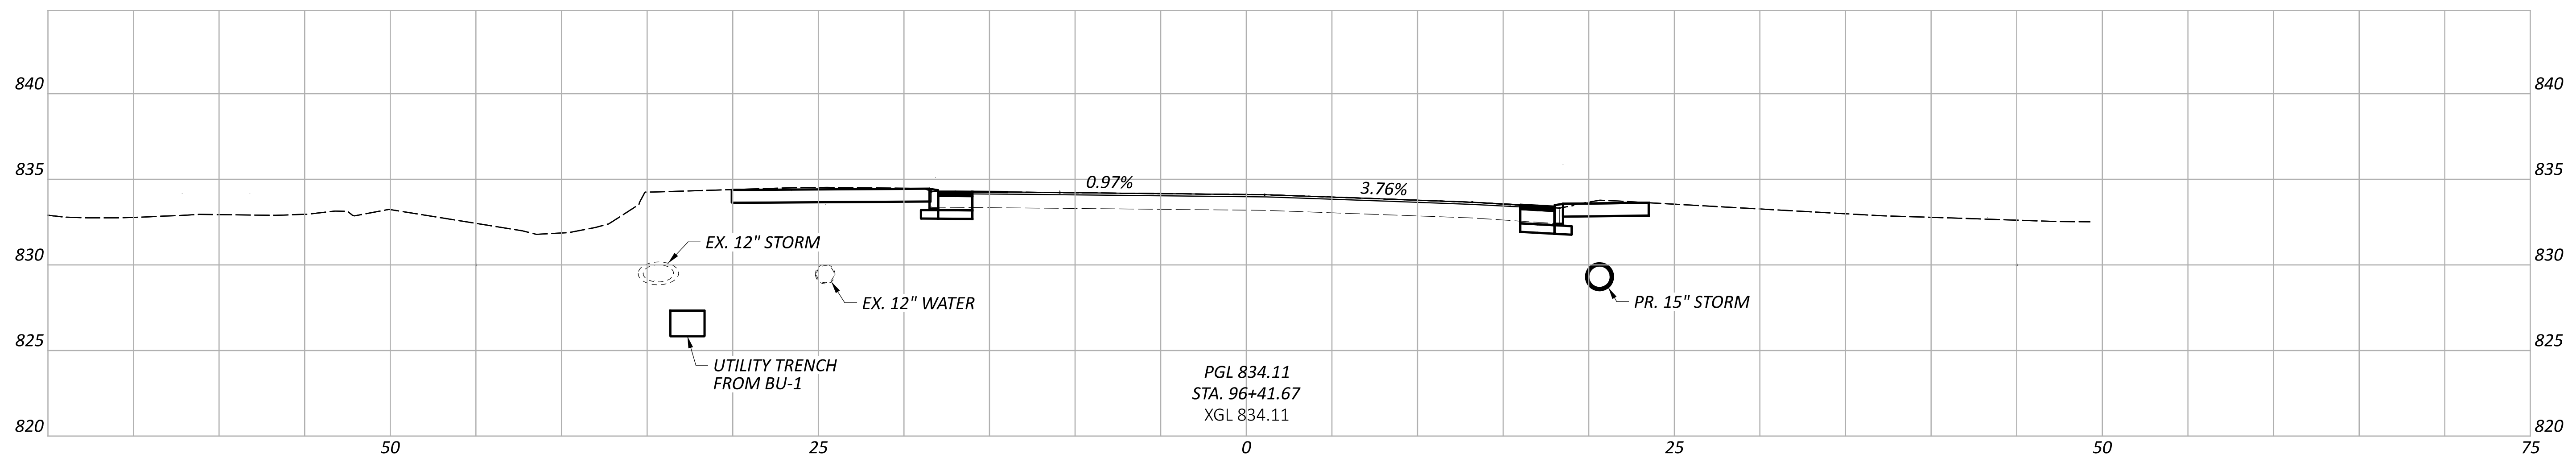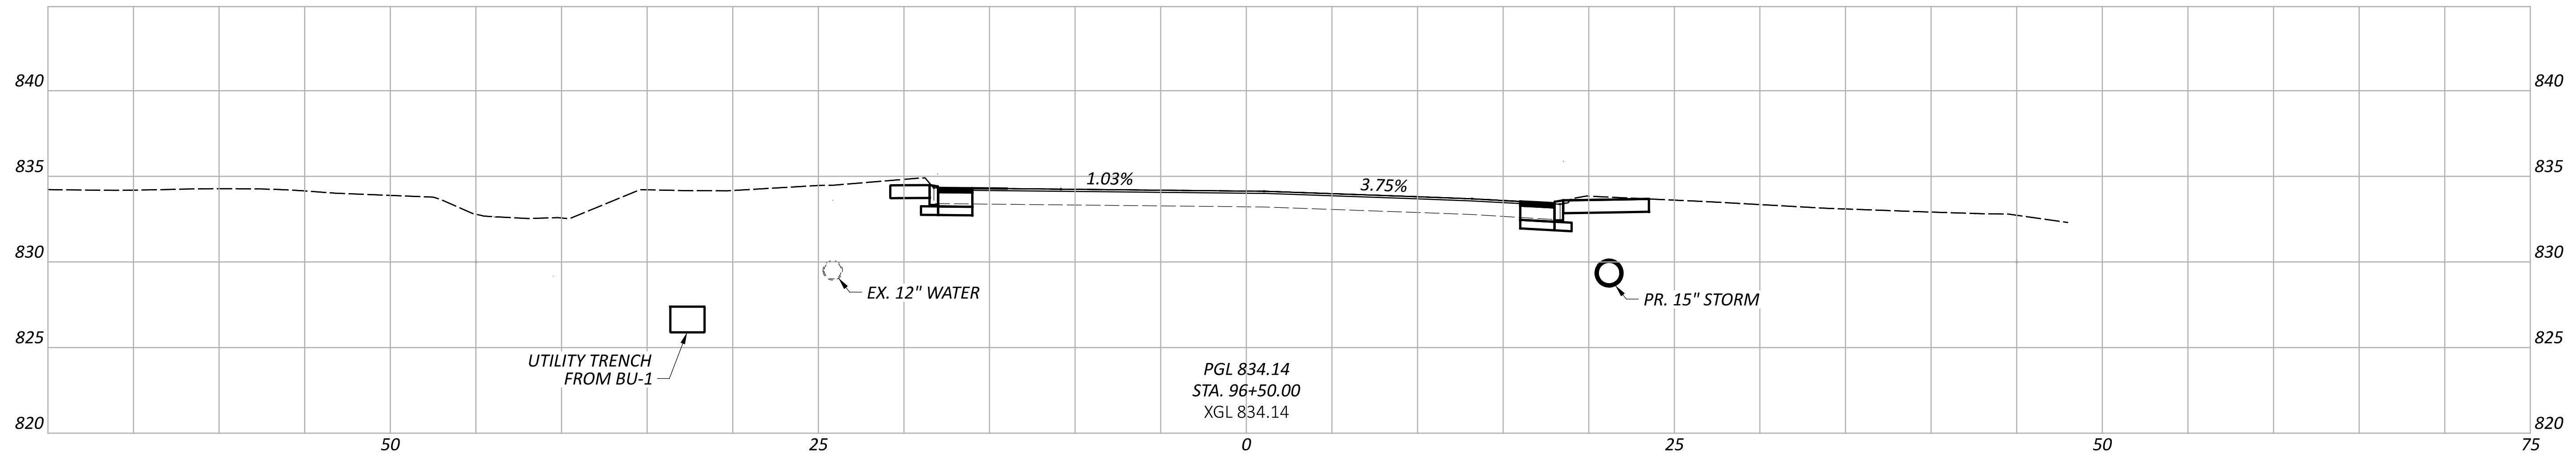




CROSS SECTIONS - U.S. 68  
STA. 96+00.00 TO STA. 96+50.00

DESIGN AGENCY
<b>CARPENTER MARTY</b>
DESIGNER
WCS
REVIEWER
BAA 03/28/25
PROJECT ID
115388
SHEET
P.18
TOTAL
P.107

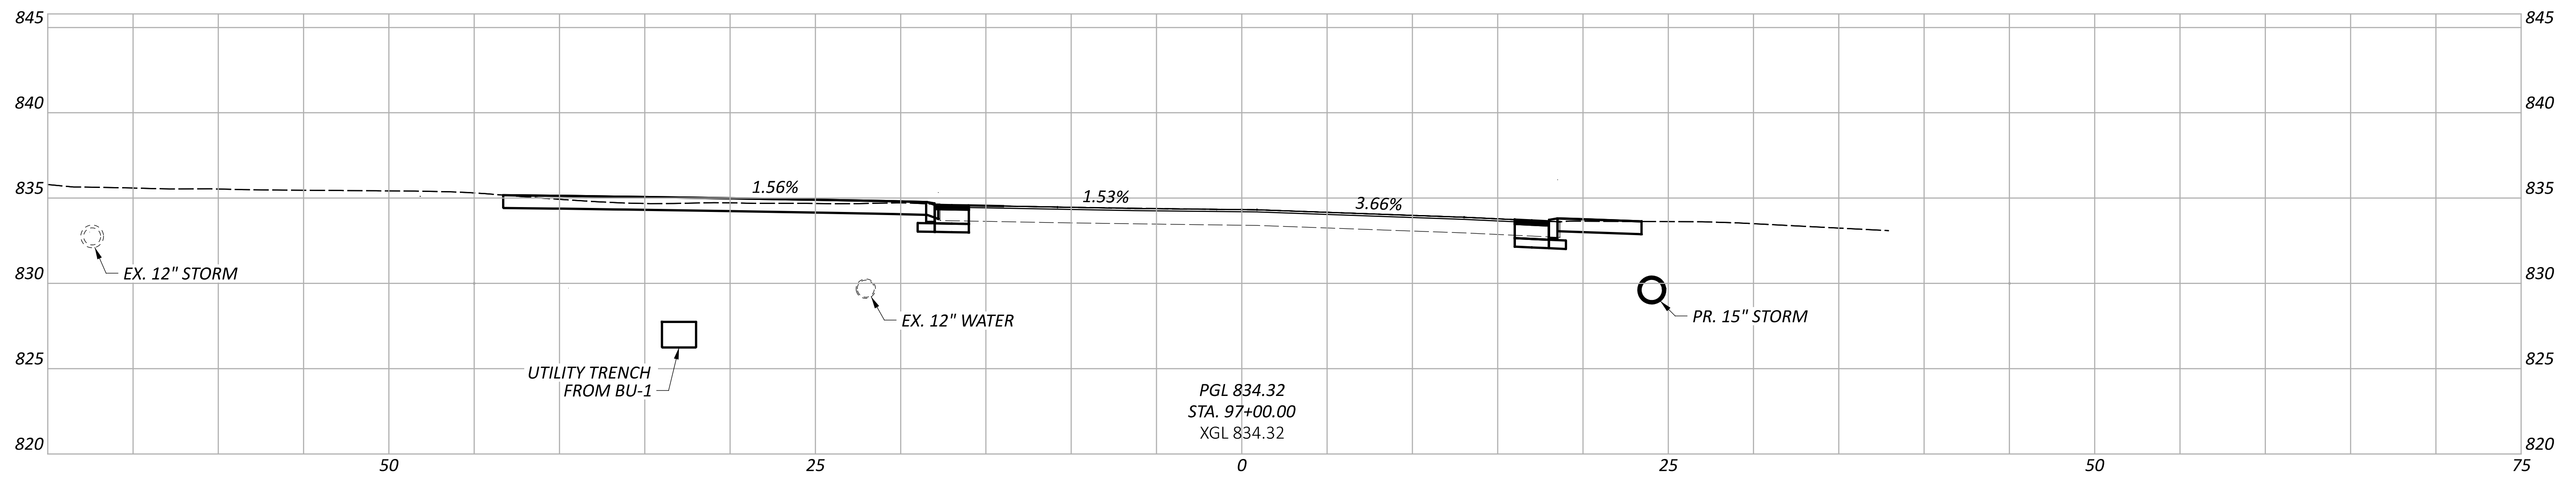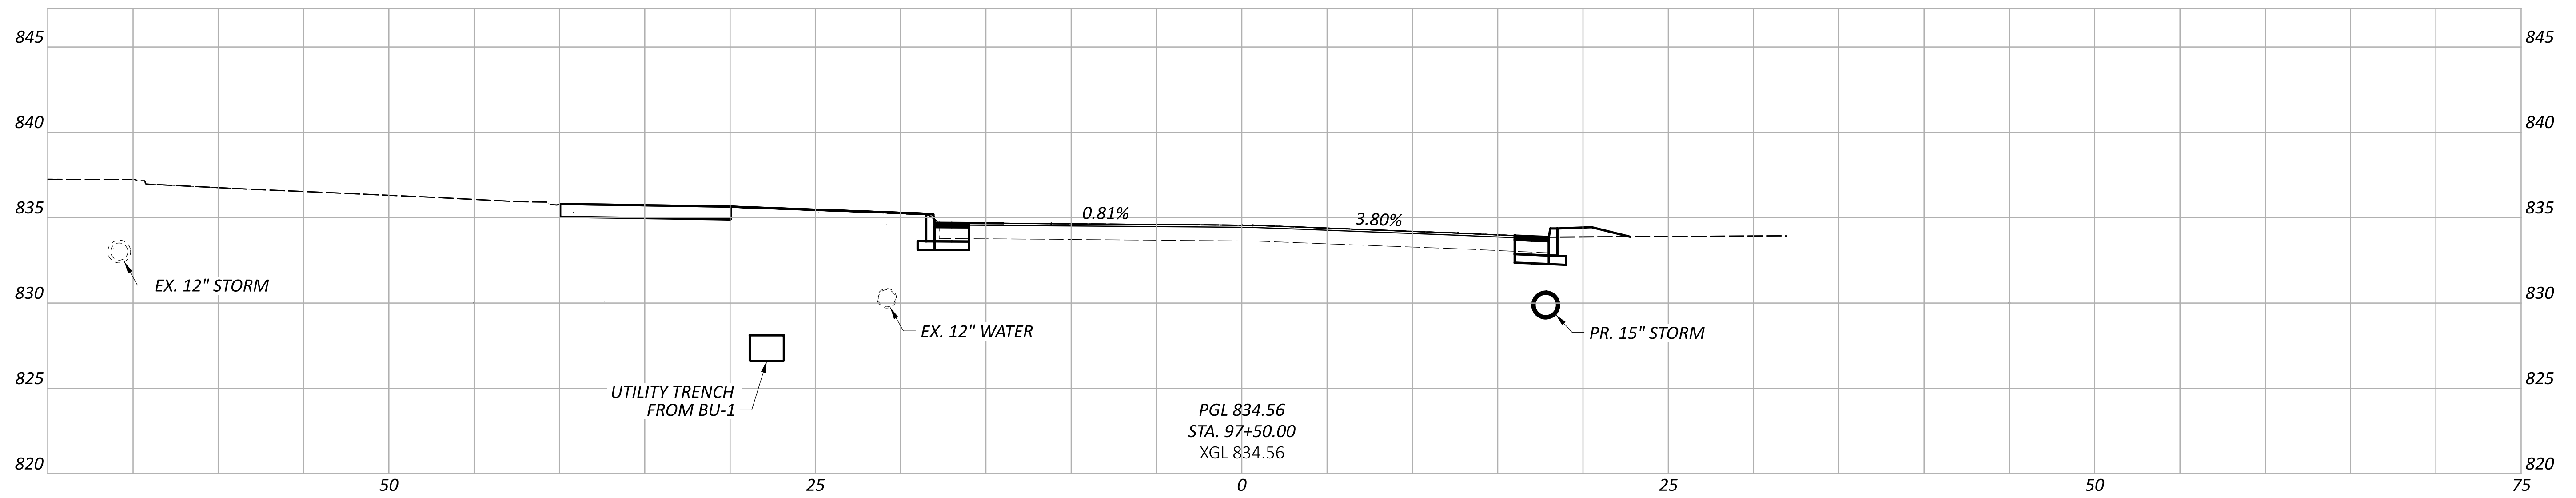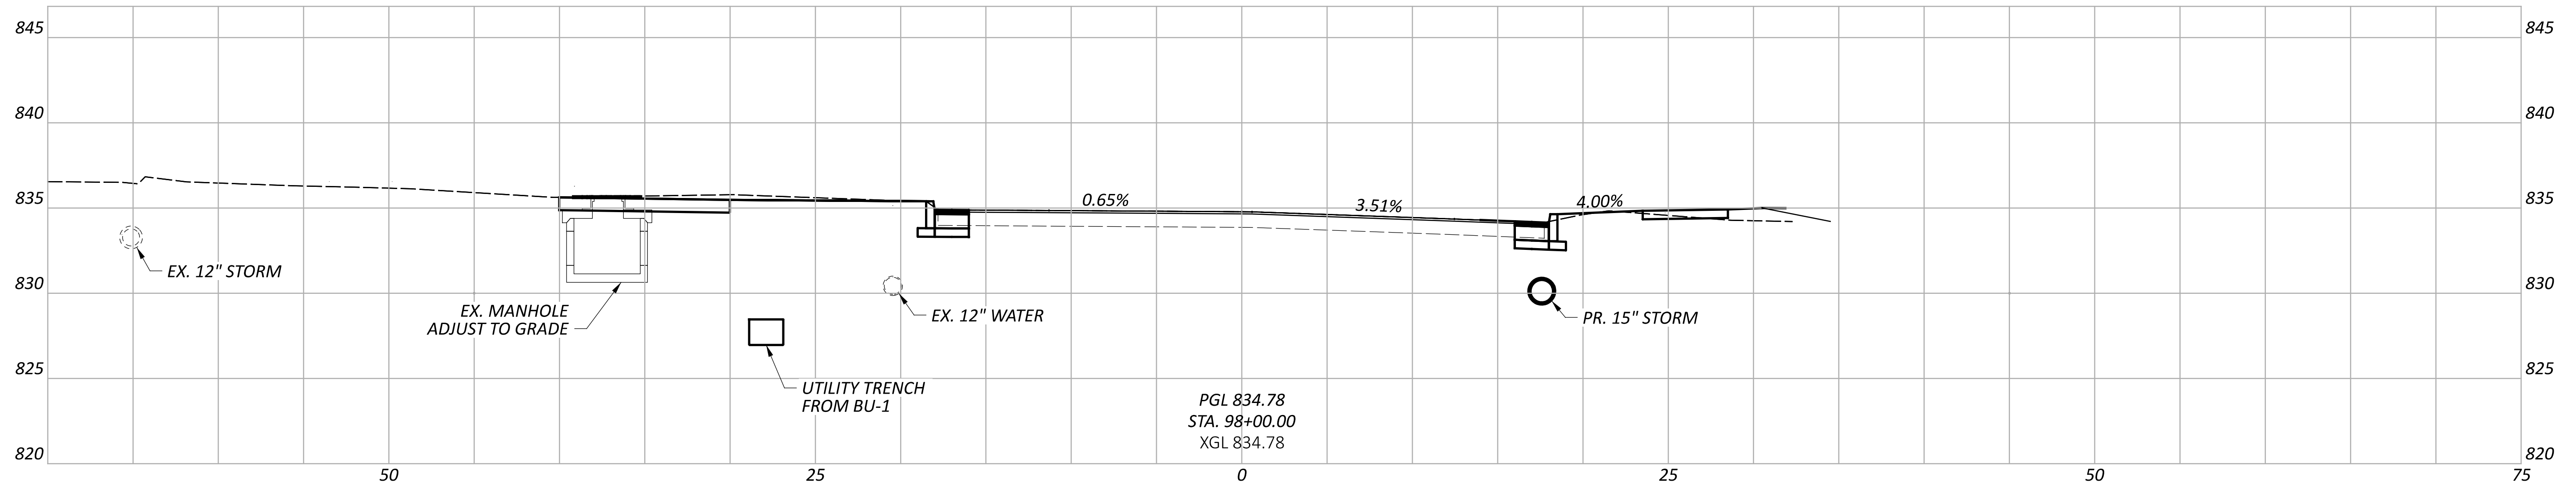

CROSS SECTIONS - U.S. 68  
STA. 97+00.00 TO STA. 98+00.00

DESIGN AGENCY	
CARPENTER MARTY	
DESIGNER	
WCS	
REVIEWER	
BAA 03/28/25	
PROJECT ID	
115388	
SHEET	TOTAL
P.19	P.107

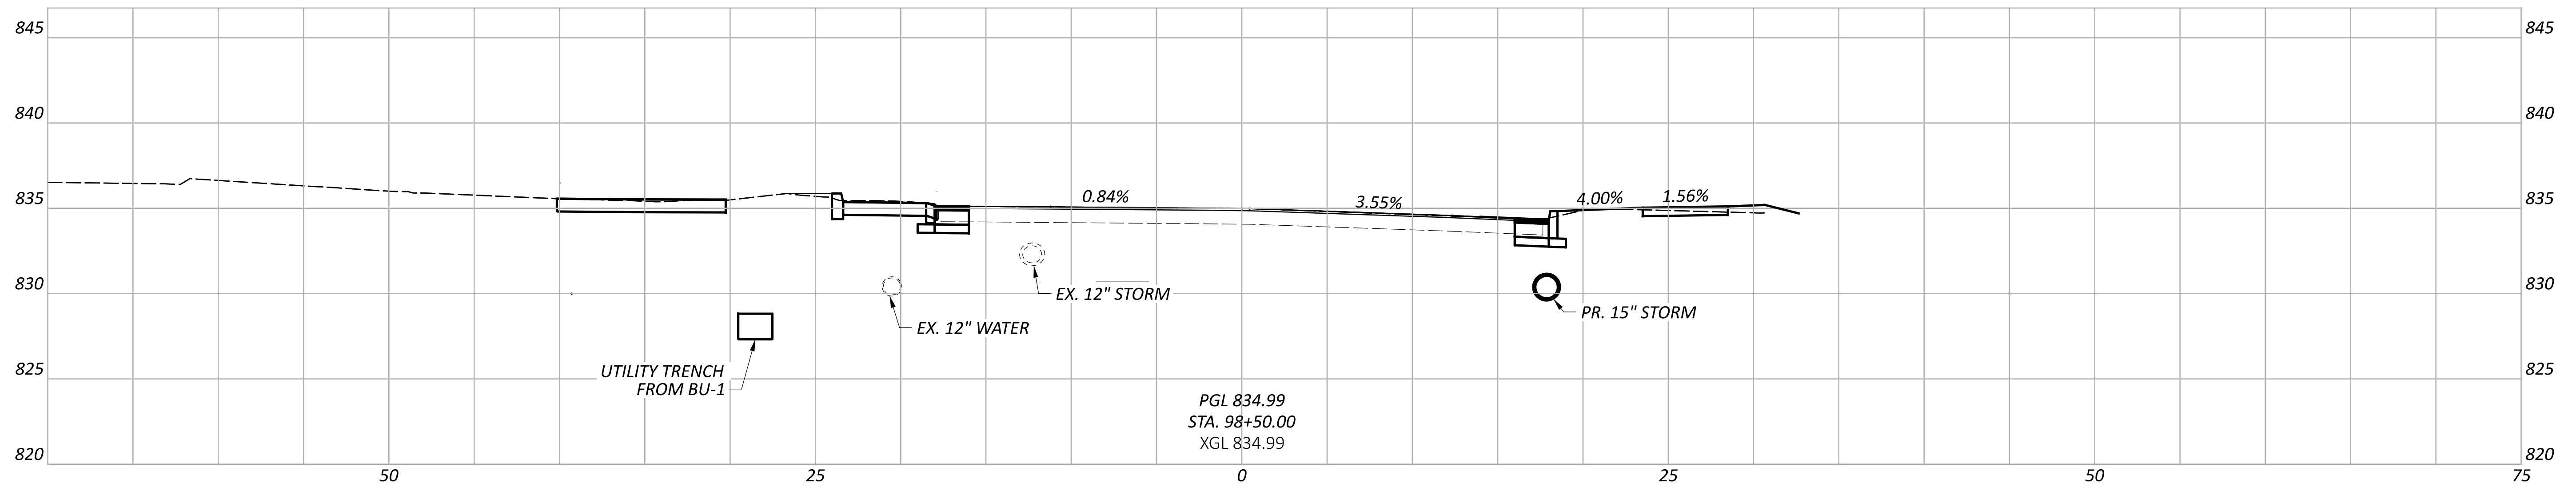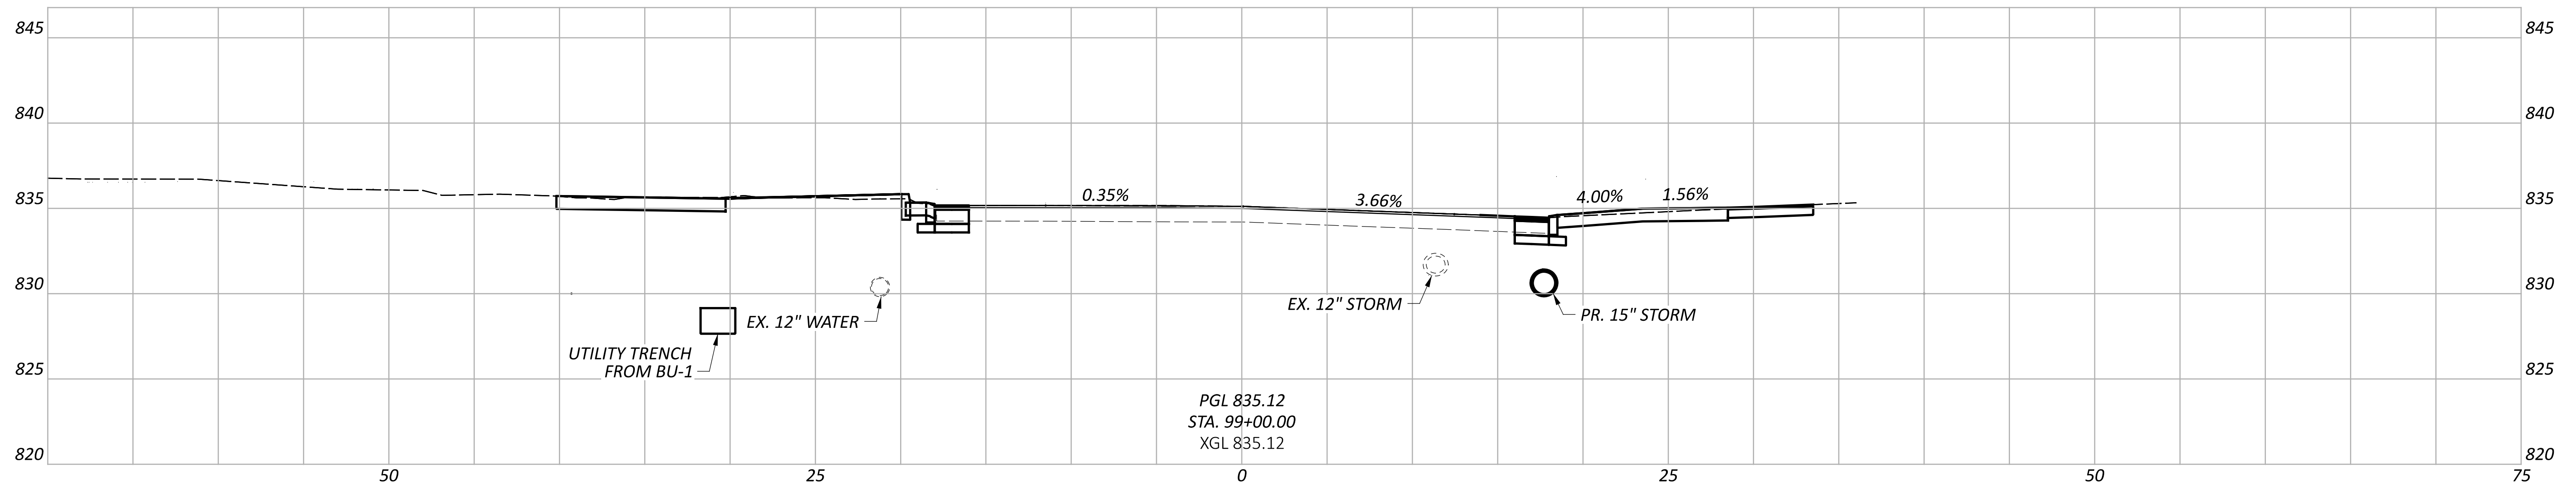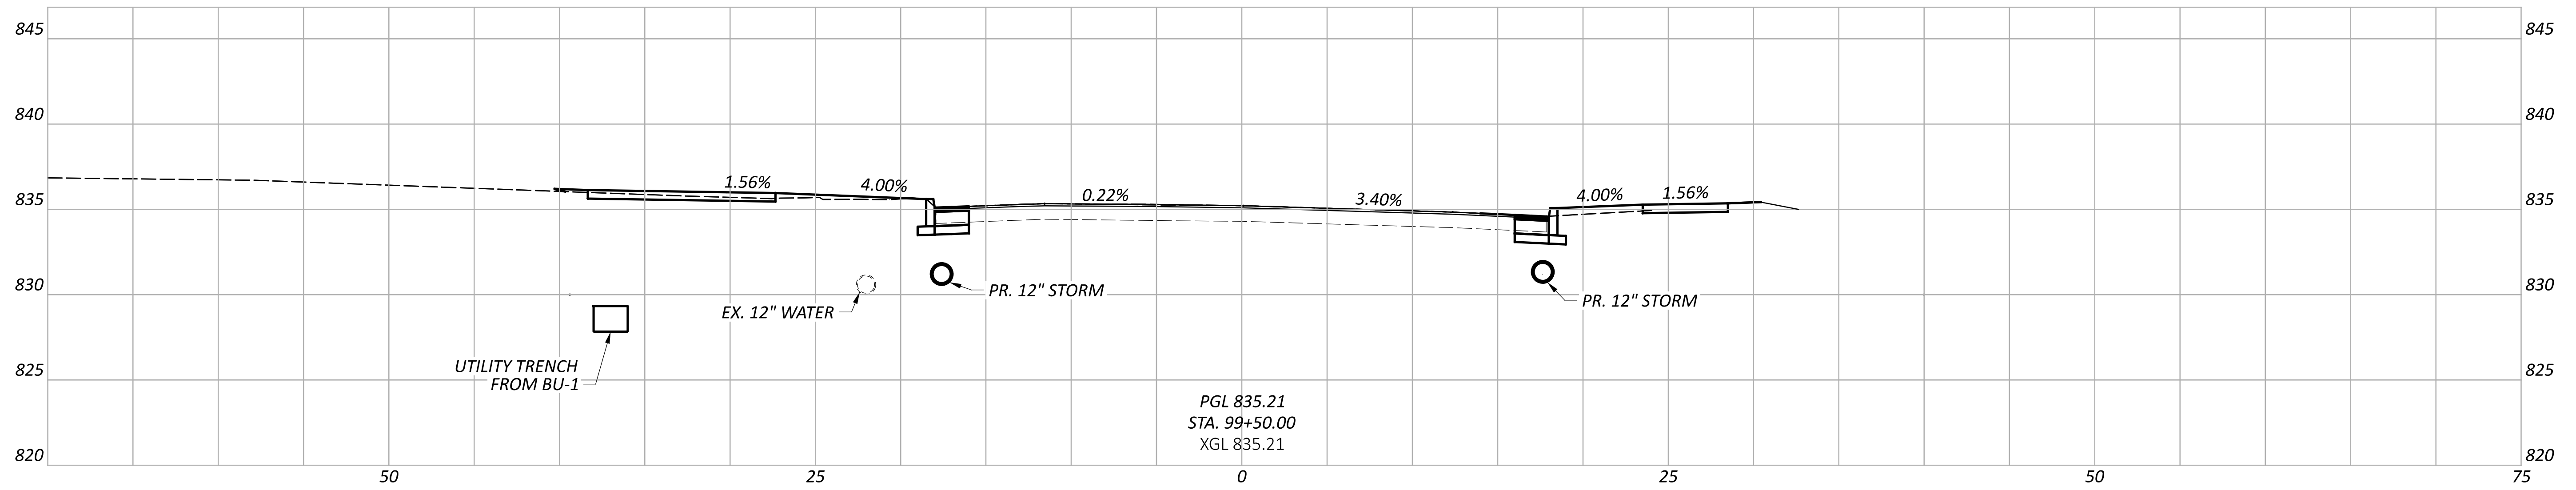

CROSS SECTIONS - U.S. 68  
STA. 98+50.00 TO STA. 99+50.00

DESIGN AGENCY



DESIGNER

WCS

REVIEWER



BAA 03/28/25

PROJECT ID

115388




SHEET TOTAL

P.20 P.107

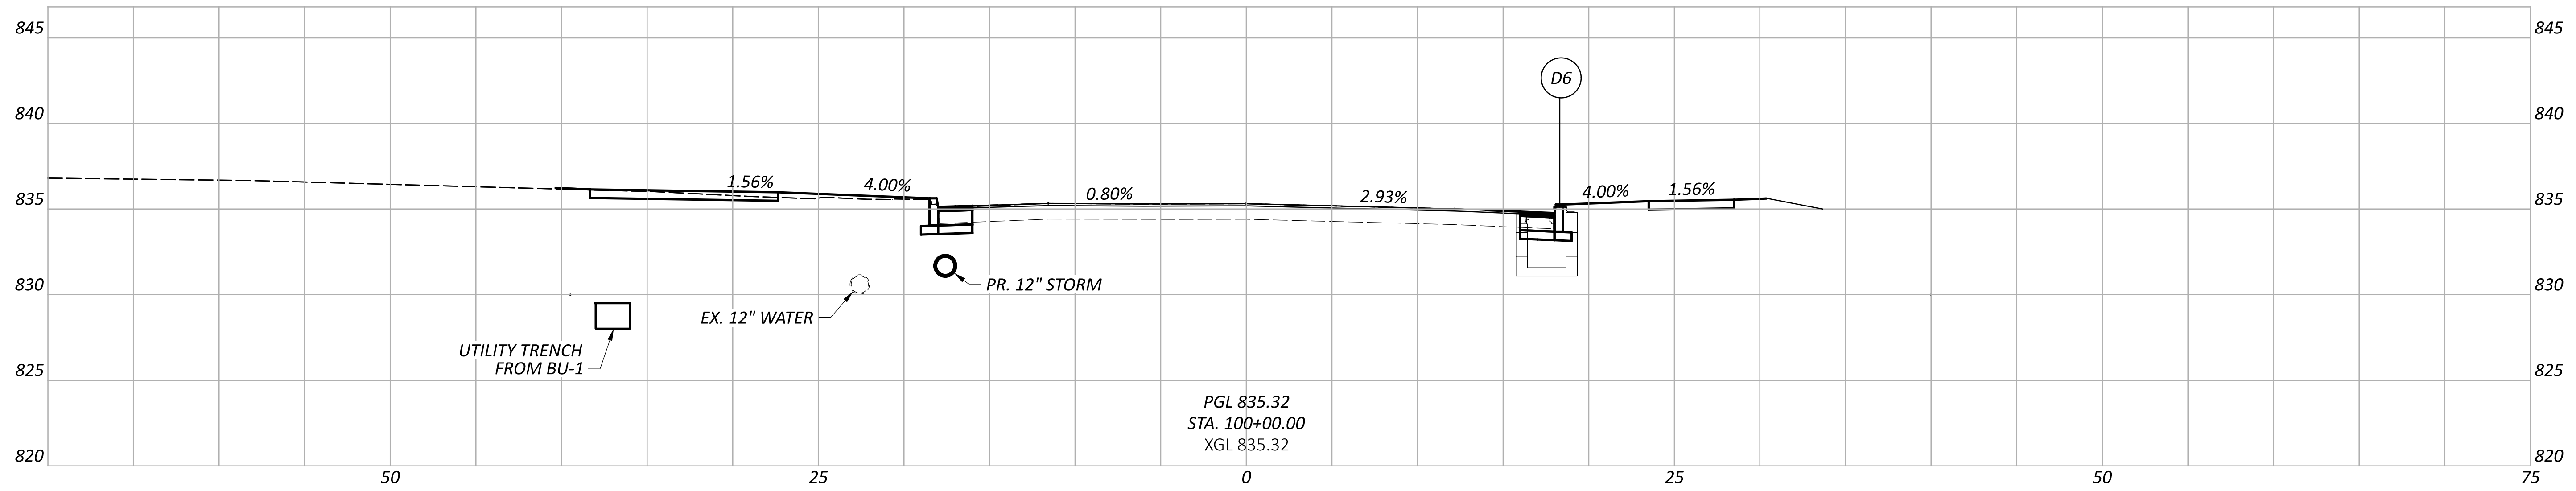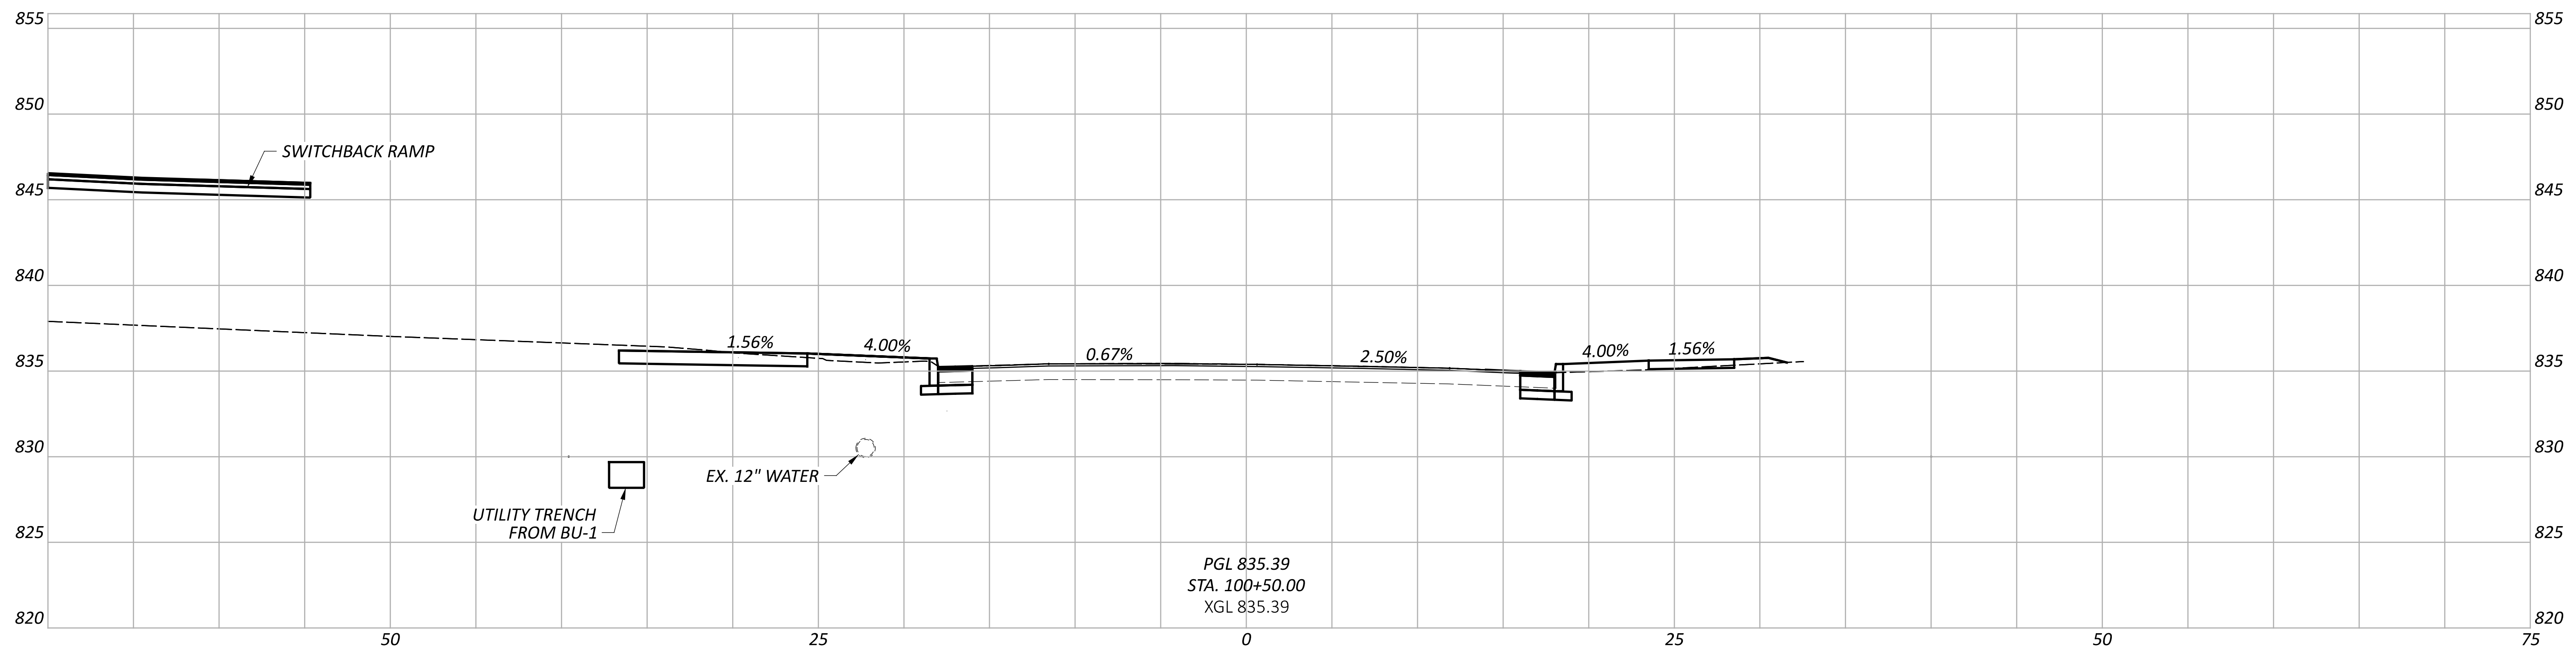


CROSS SECTIONS - U.S. 68  
STA. 100+00.00 TO STA. 100+50.00

DESIGN AGENCY
<b>CARPENTER</b> <b>MARTY</b>
DESIGNER
CEF
REVIEWER
BAA 03/28/25
PROJECT ID
115388
SHEET TOTAL
P.21 P.107

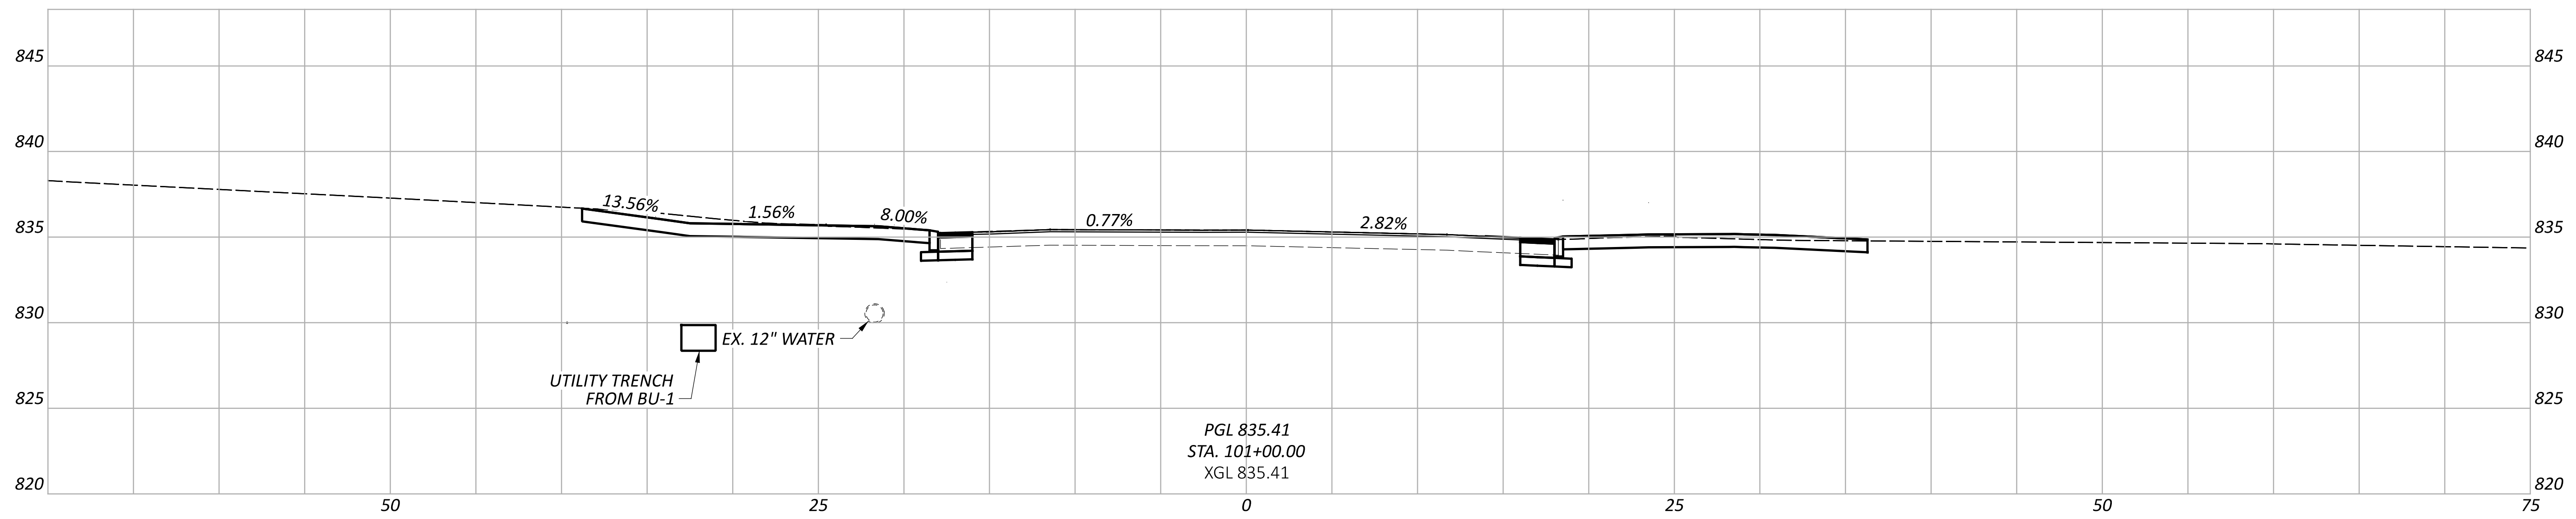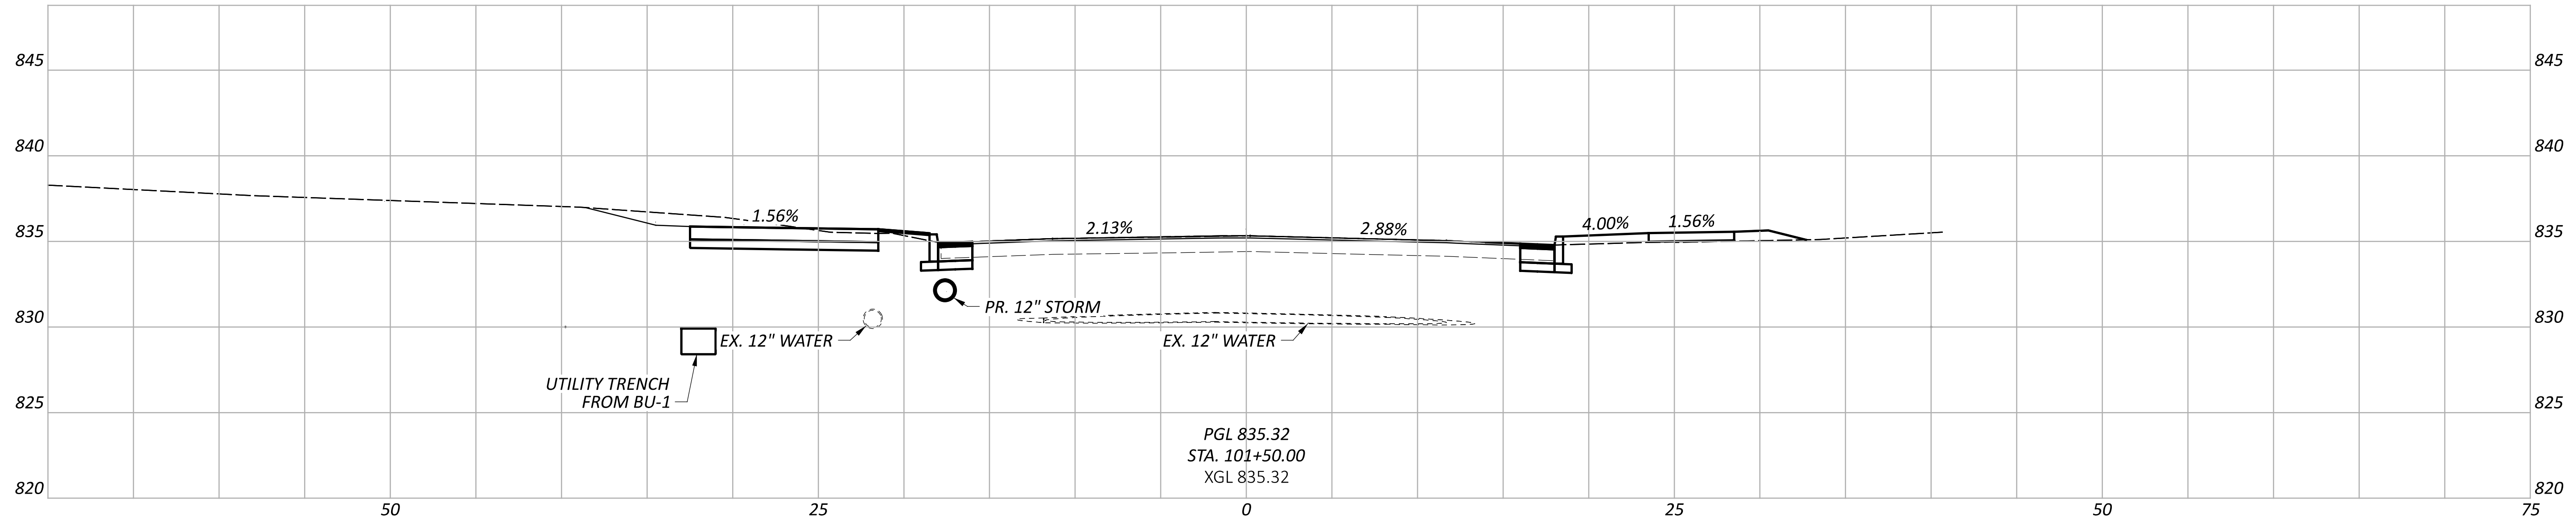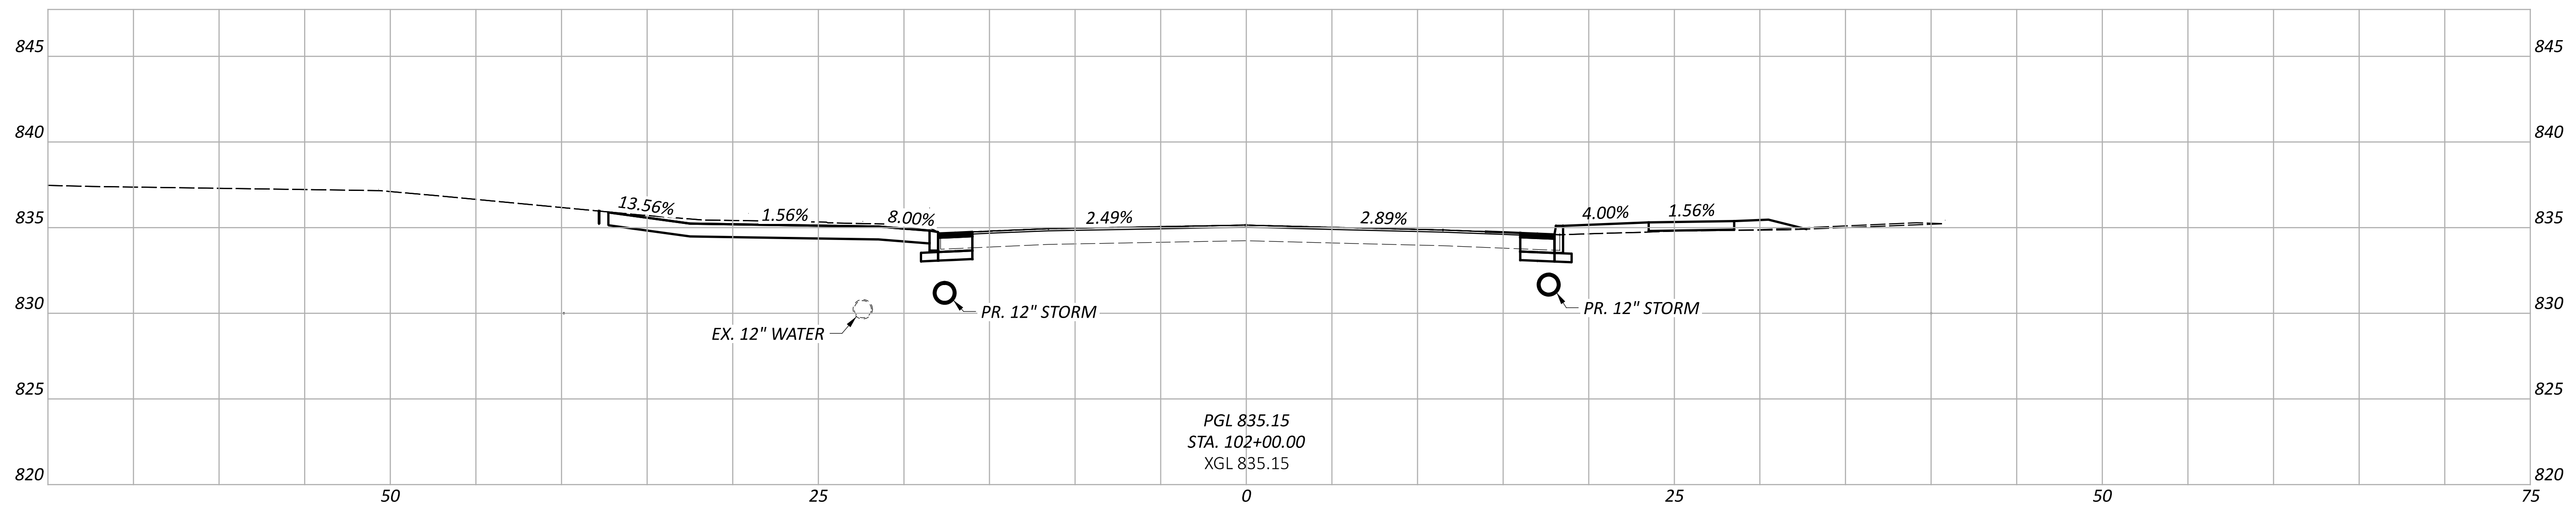


CROSS SECTIONS - U.S. 68  
STA. 101+00.00 TO STA. 102+00.00


DESIGN AGENCY
<b>CARPENTER MARTY</b>
DESIGNER
CEF
REVIEWER
BAA 03/28/25
PROJECT ID
115388
SHEET TOTAL
P.22 P.107

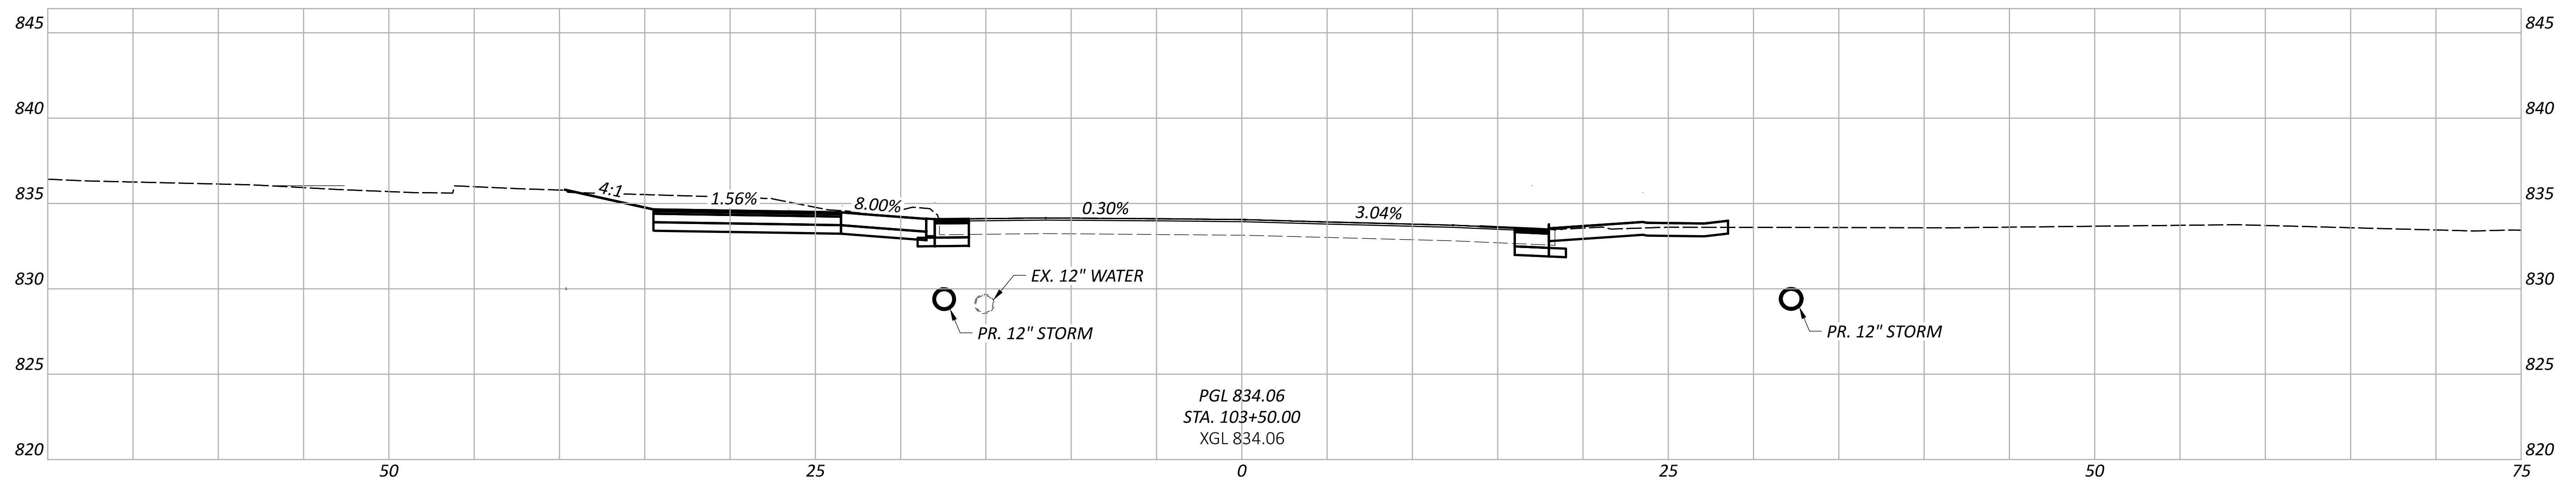

PGL 834.06  
 STA. 103+50.00  
 XGL 834.06

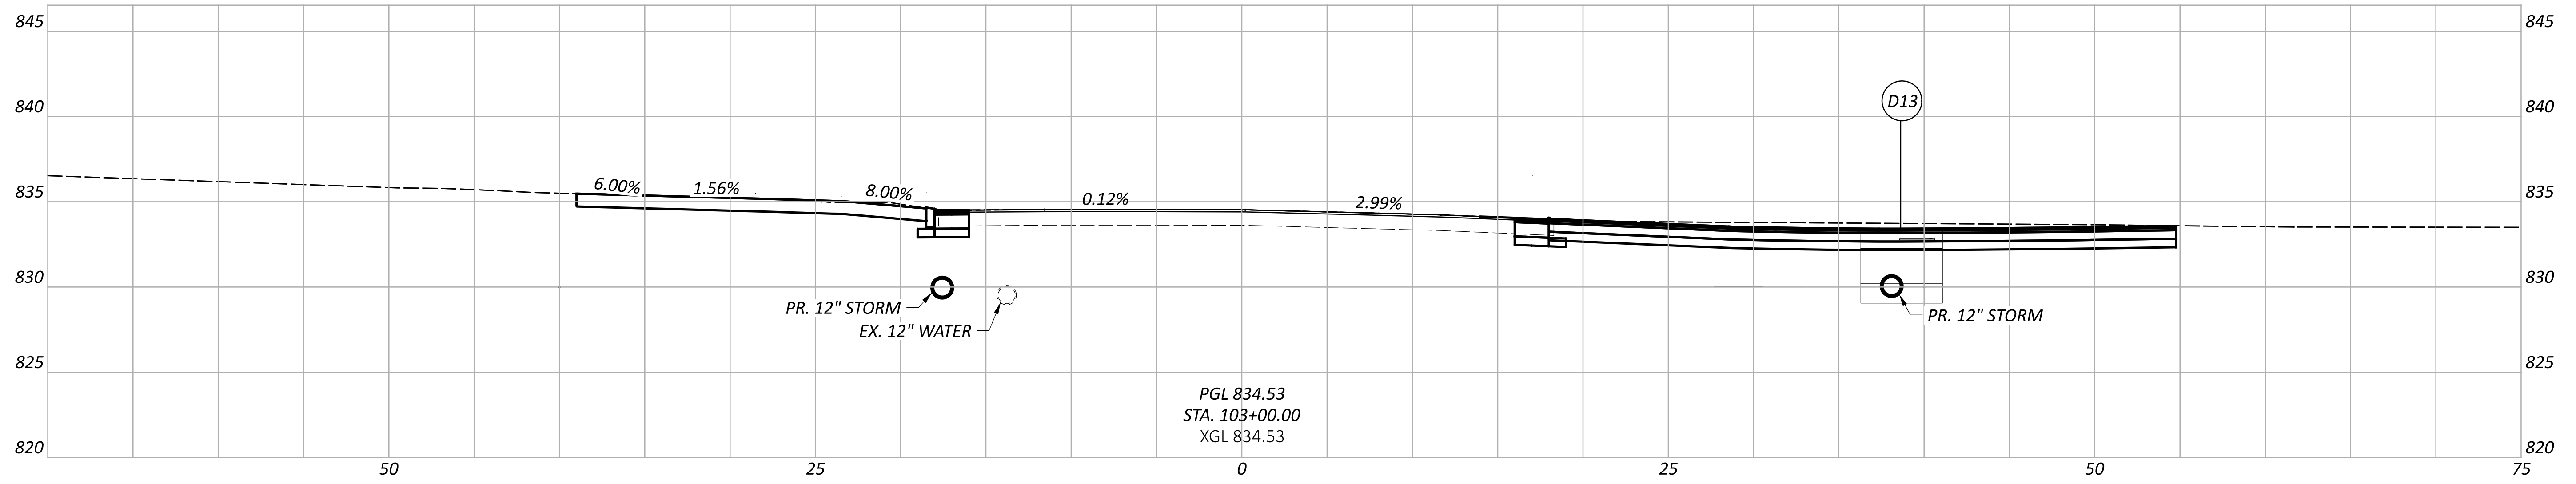

PGL 834.53  
 STA. 103+00.00  
 XGL 834.53

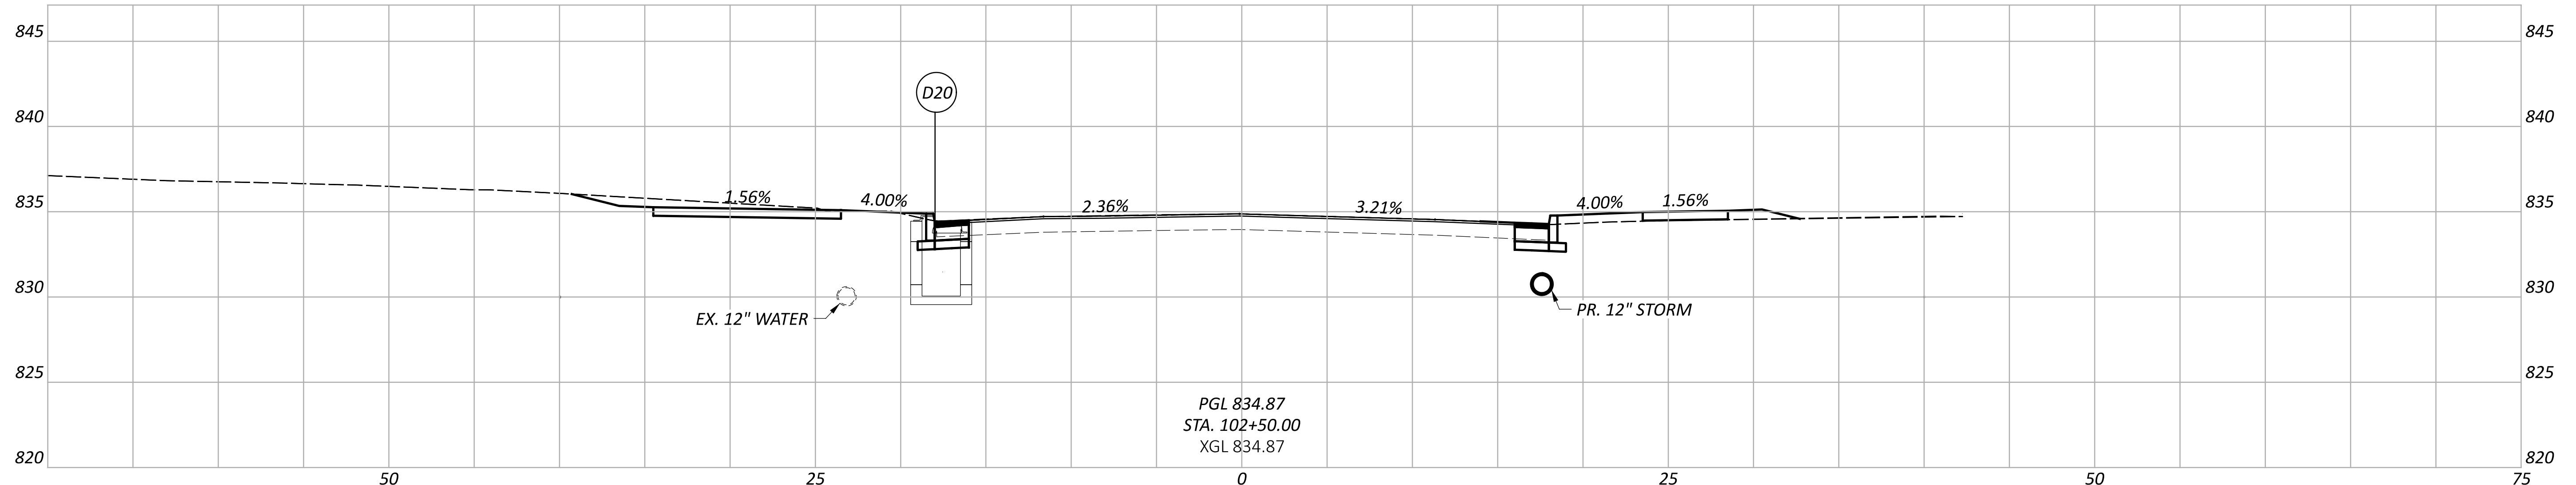

PGL 834.87  
 STA. 102+50.00  
 XGL 834.87

CROSS SECTIONS - U.S. 68  
 STA. 102+50.00 TO STA. 103+50.00

DESIGN AGENCY






DESIGNER  
 CEF

REVIEWER  
 BAA 03/28/25

PROJECT ID  
 115388



SHEET TOTAL  
 P.23 P.107

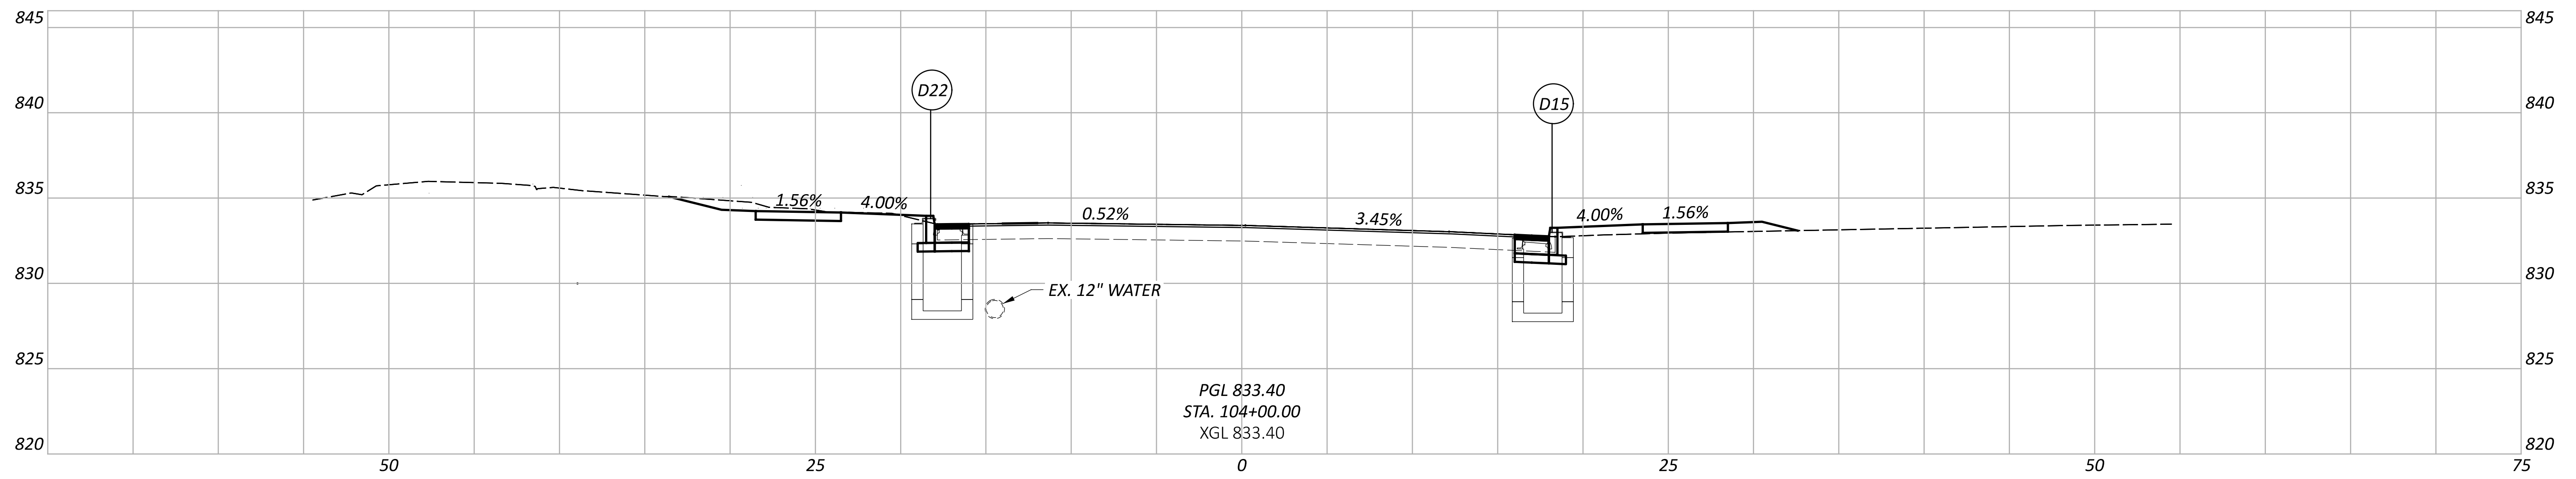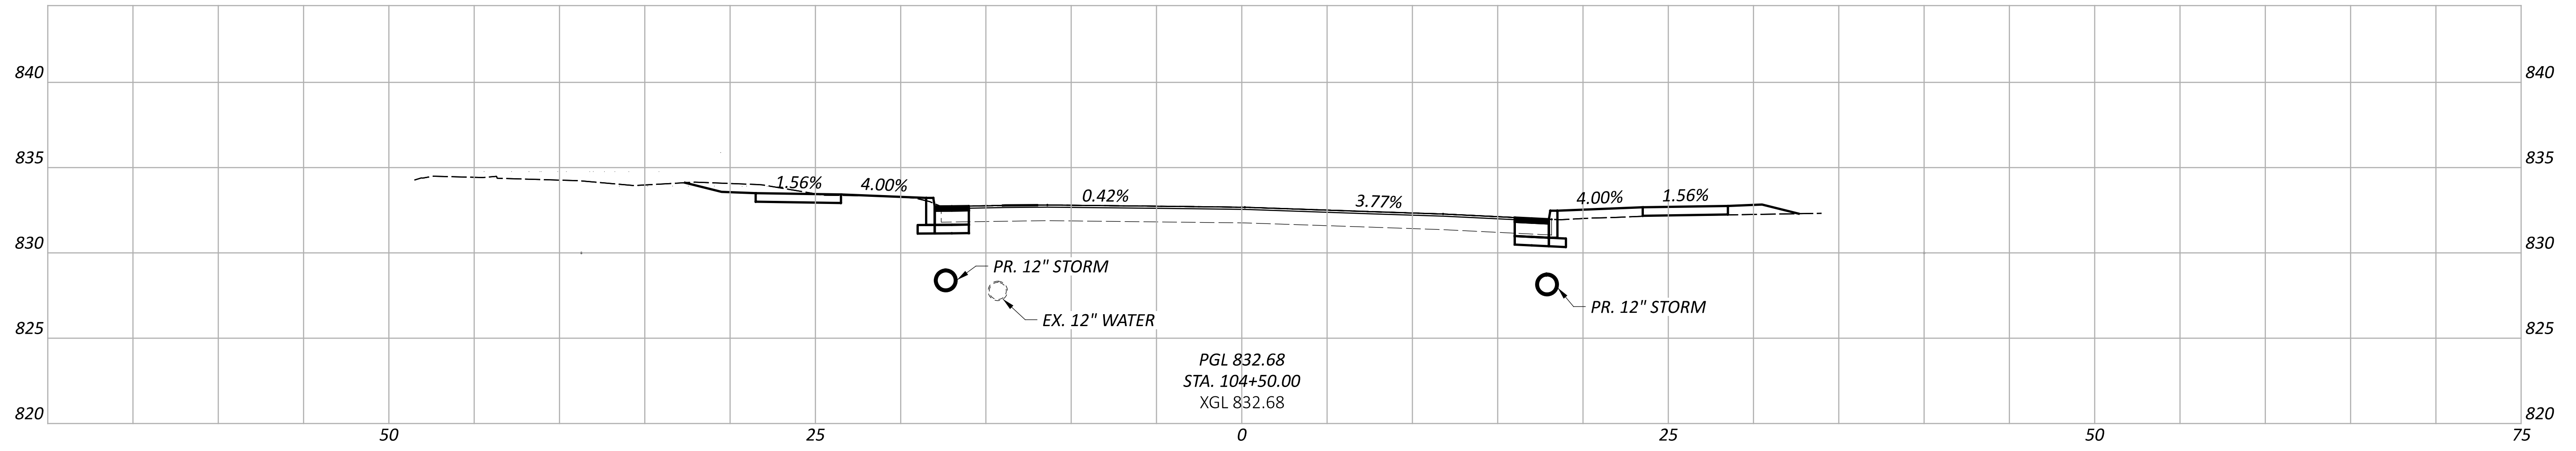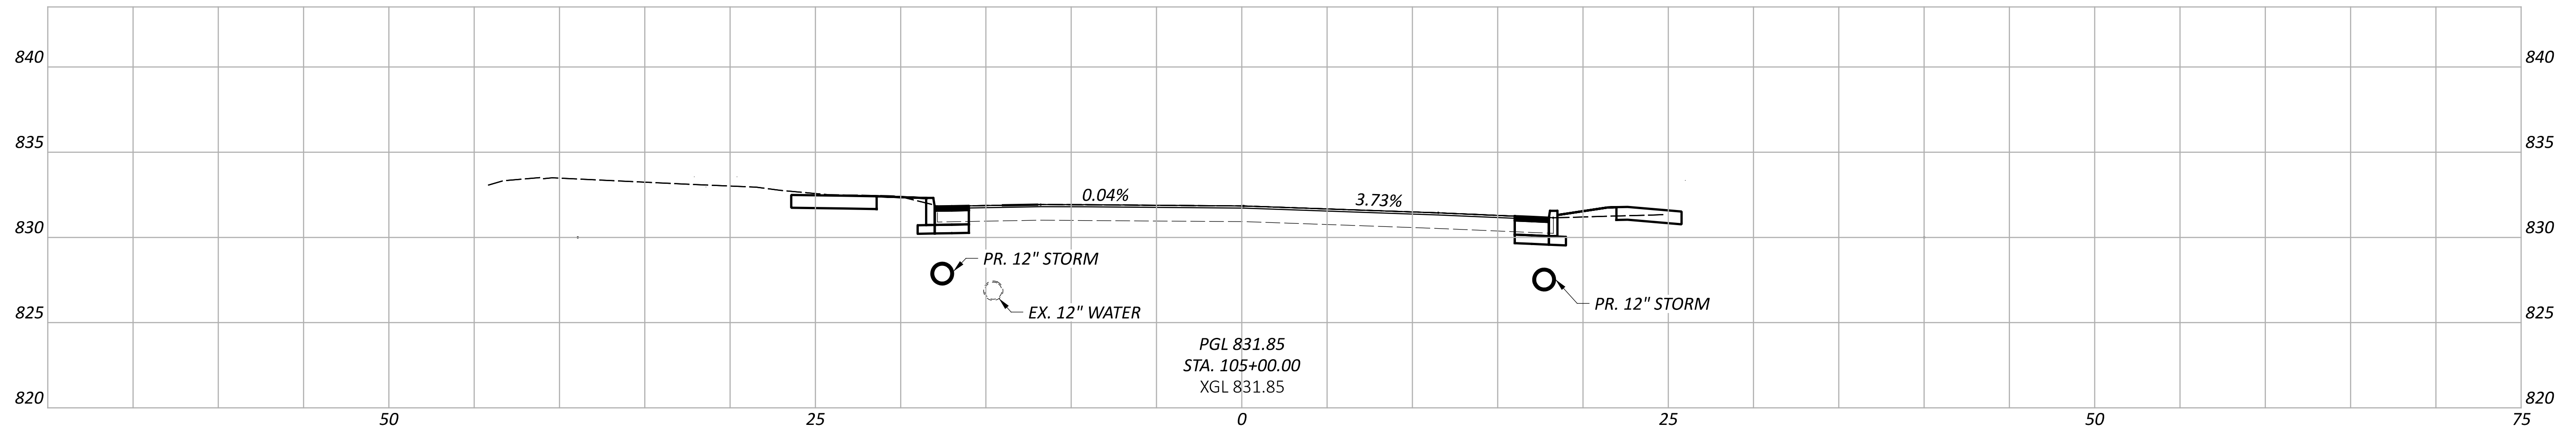

CROSS SECTIONS - U.S. 68  
STA. 104+00.00 TO STA. 105+00.00

DESIGN AGENCY
<b>CARPENTER MARTY</b>
DESIGNER
CEF
REVIEWER
BAA 03/28/25
PROJECT ID
115388
SHEET TOTAL
P.24 P.107




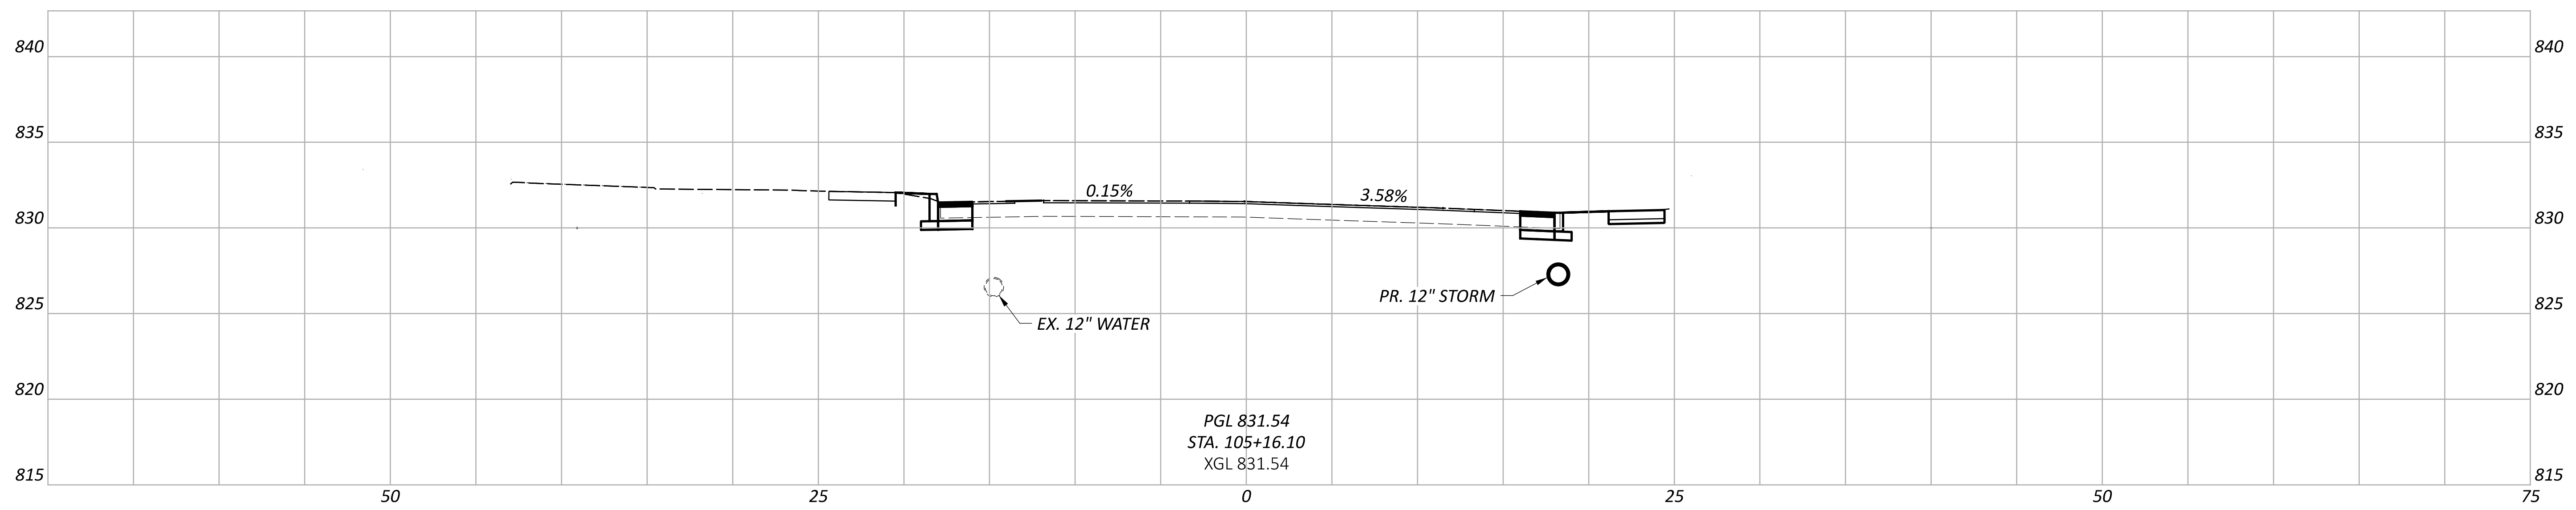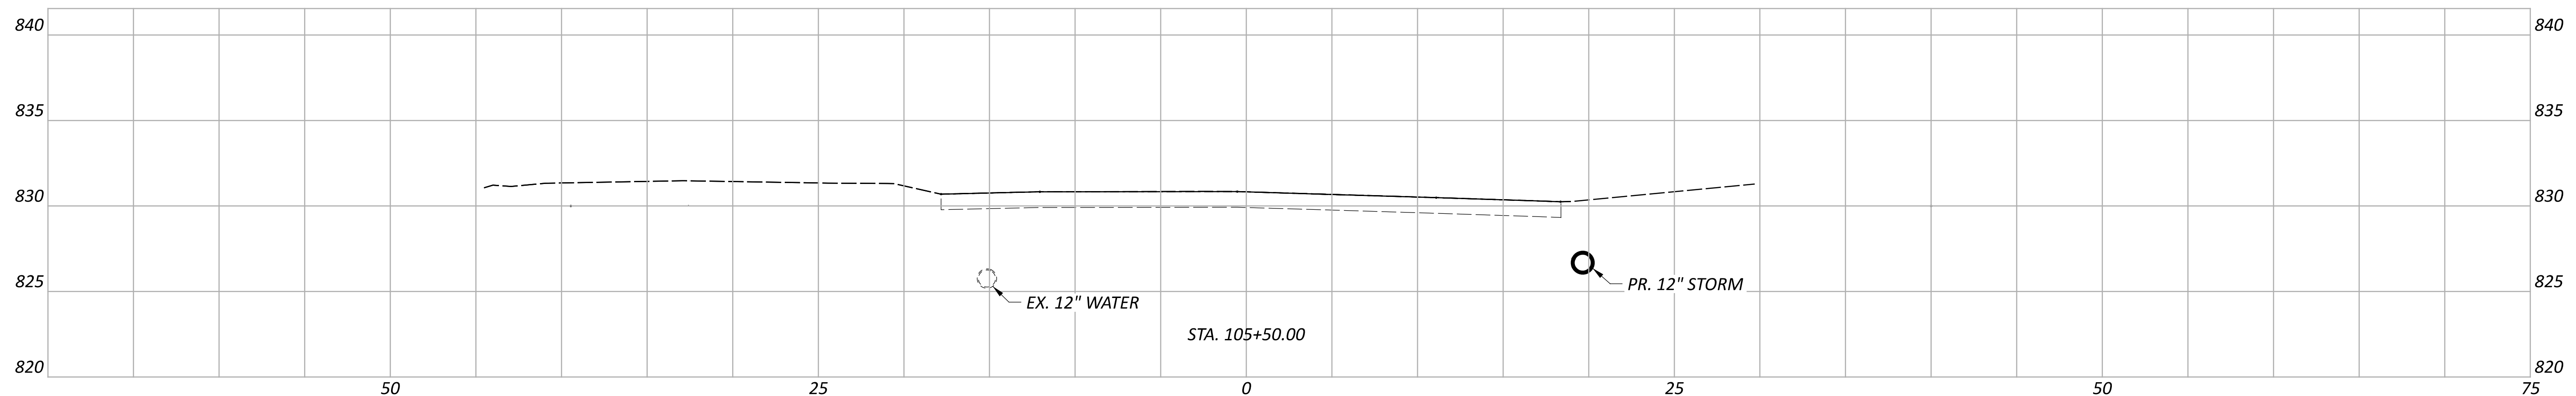

CROSS SECTIONS - U.S. 68  
STA. 105+16.00 TO STA. 105+50.00




DESIGN AGENCY

DESIGNER
CEF
REVIEWER
BAA 03/28/25
PROJECT ID
115388
SHEET TOTAL
P.25 P.107

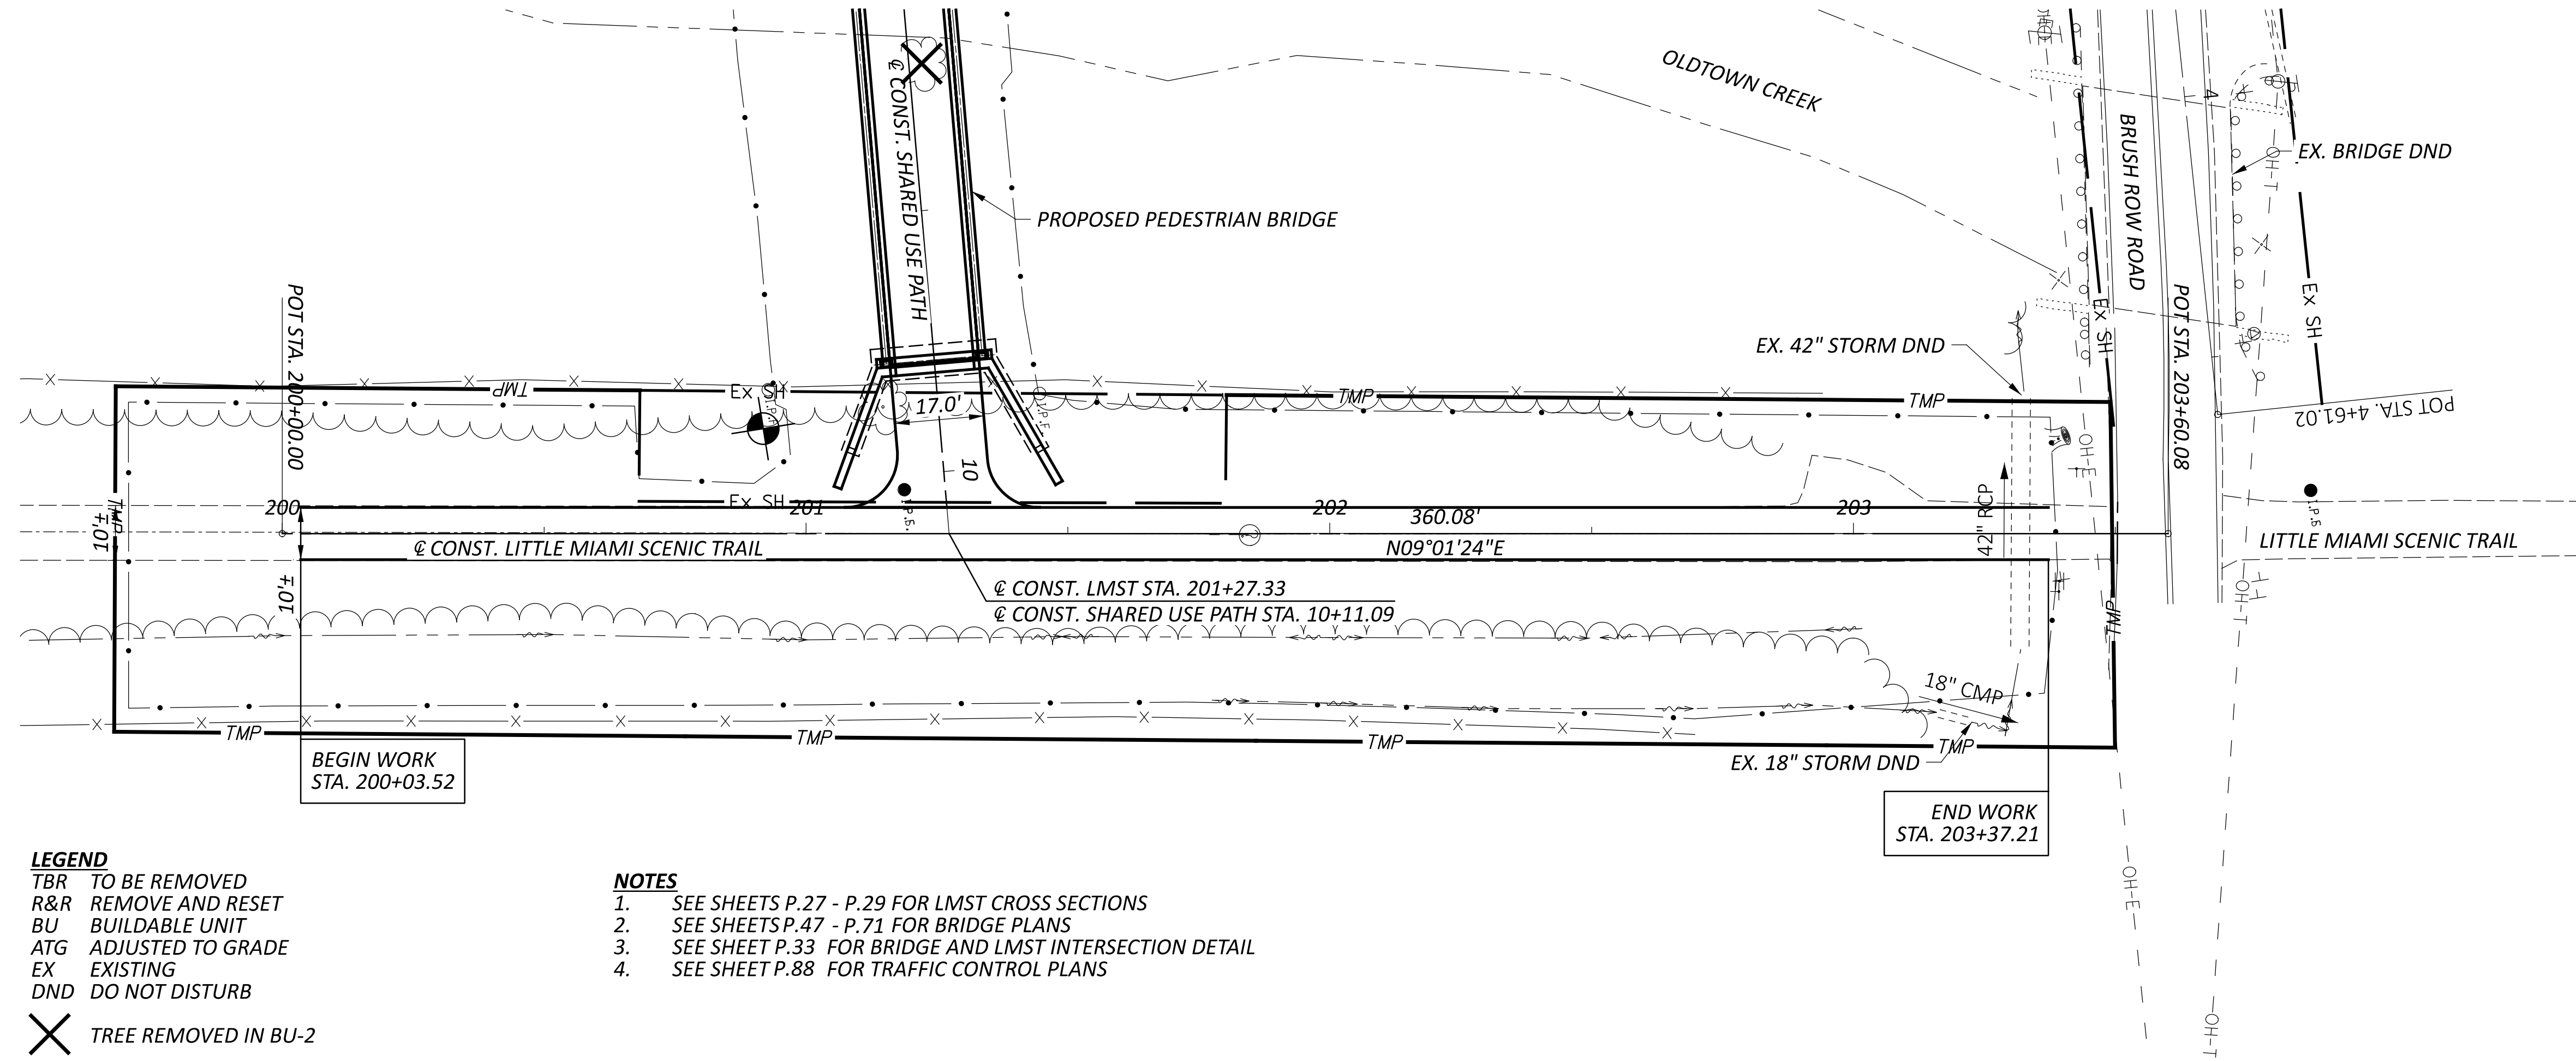




- LEGEND**
- TBR TO BE REMOVED
  - R&R REMOVE AND RESET
  - BU BUILDABLE UNIT
  - ATG ADJUSTED TO GRADE
  - EX EXISTING
  - DND DO NOT DISTURB
  - X TREE REMOVED IN BU-2

- NOTES**
1. SEE SHEETS P.27 - P.29 FOR LMST CROSS SECTIONS
  2. SEE SHEETS P.47 - P.71 FOR BRIDGE PLANS
  3. SEE SHEET P.33 FOR BRIDGE AND LMST INTERSECTION DETAIL
  4. SEE SHEET P.88 FOR TRAFFIC CONTROL PLANS

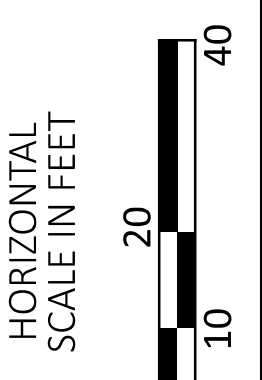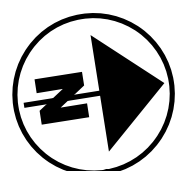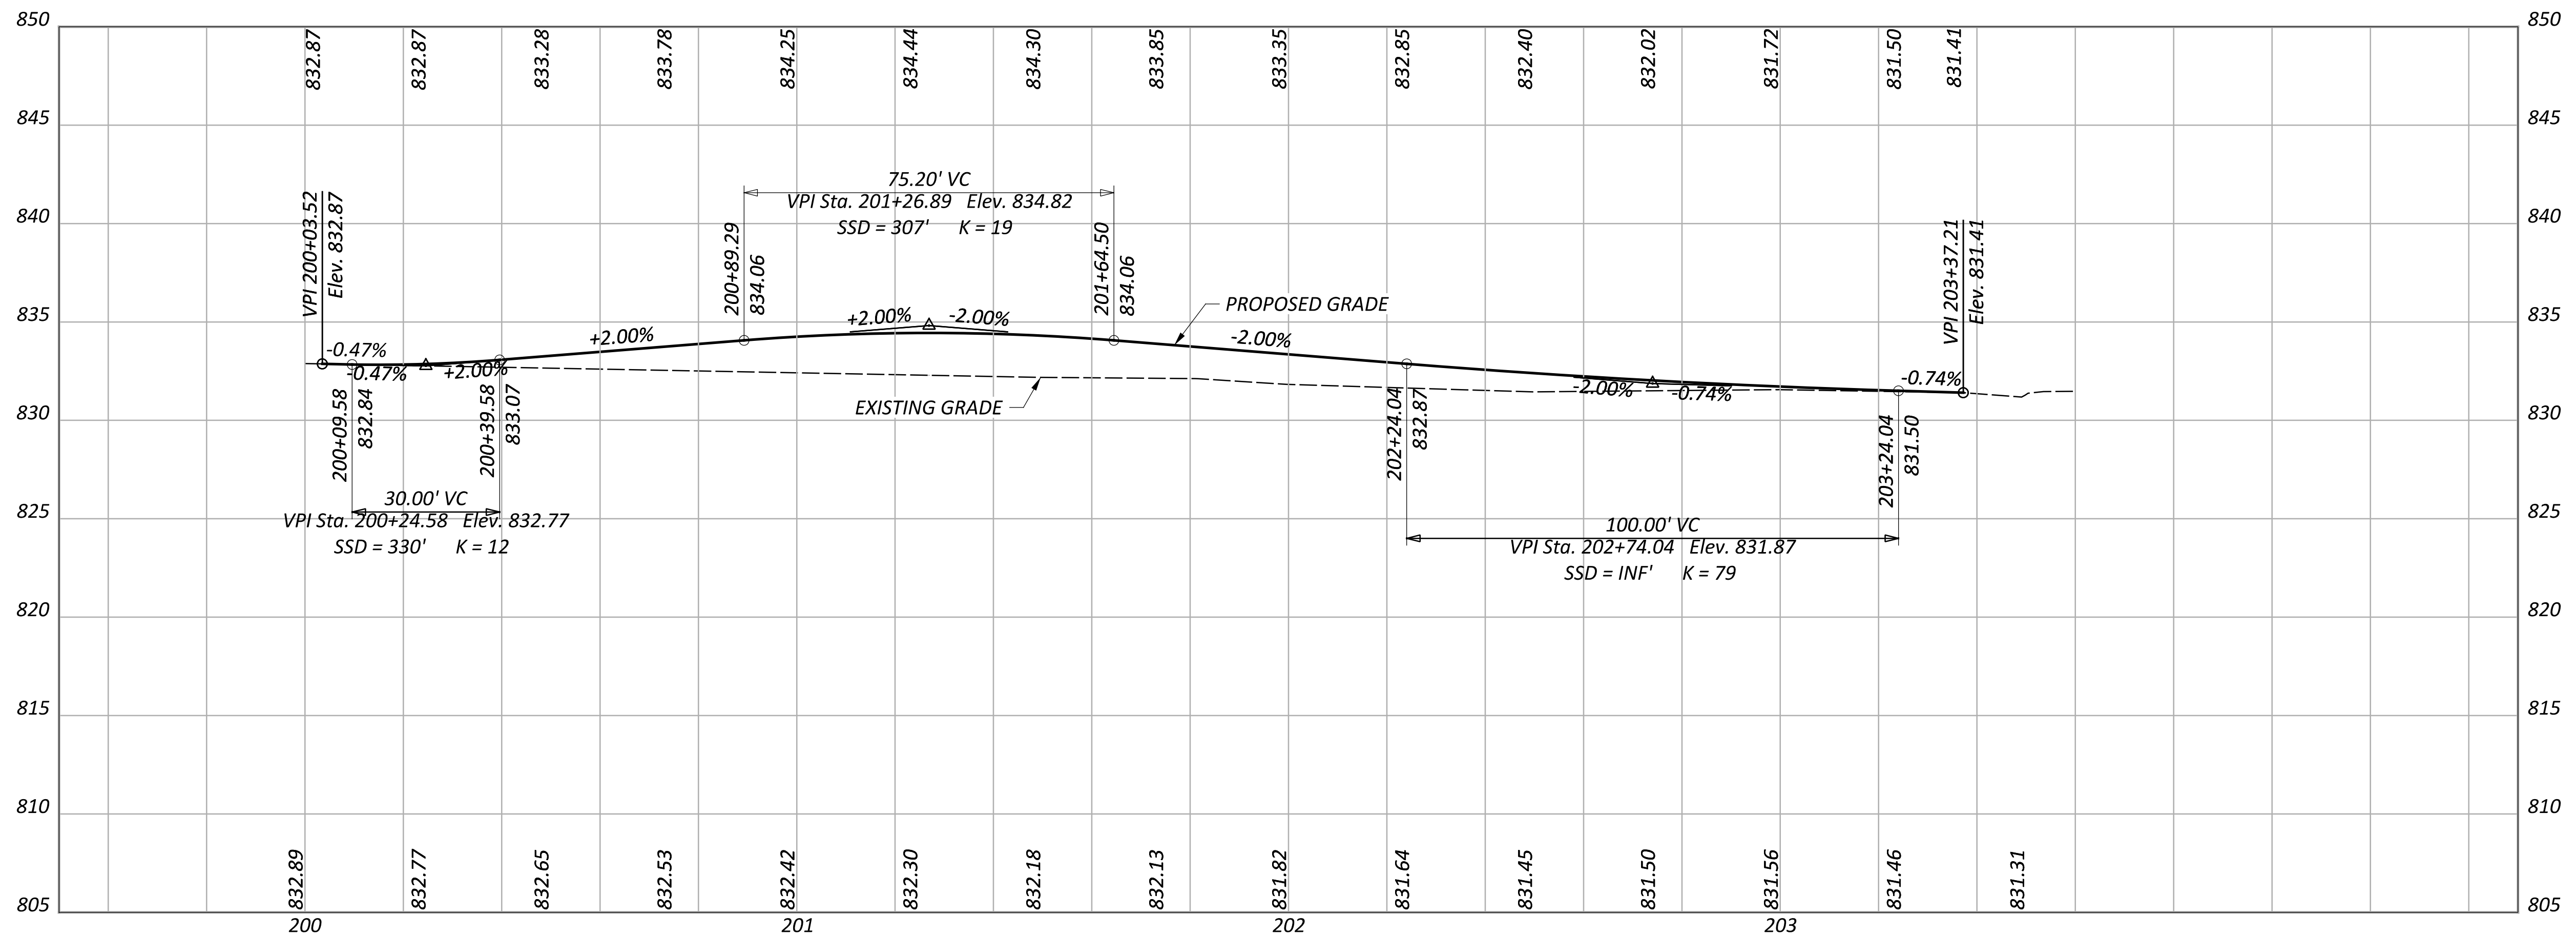




**PLAN AND PROFILE - LITTLE MIAMI SCENIC TRAIL**  
 STA. 200+00.00 TO STA. 203+60.08

DESIGN AGENCY	
<b>CARPENTER MARTY</b>	
DESIGNER	
CEF	
REVIEWER	
BAA 03/28/25	
PROJECT ID	
115388	
SHEET	TOTAL
P.26	P.107

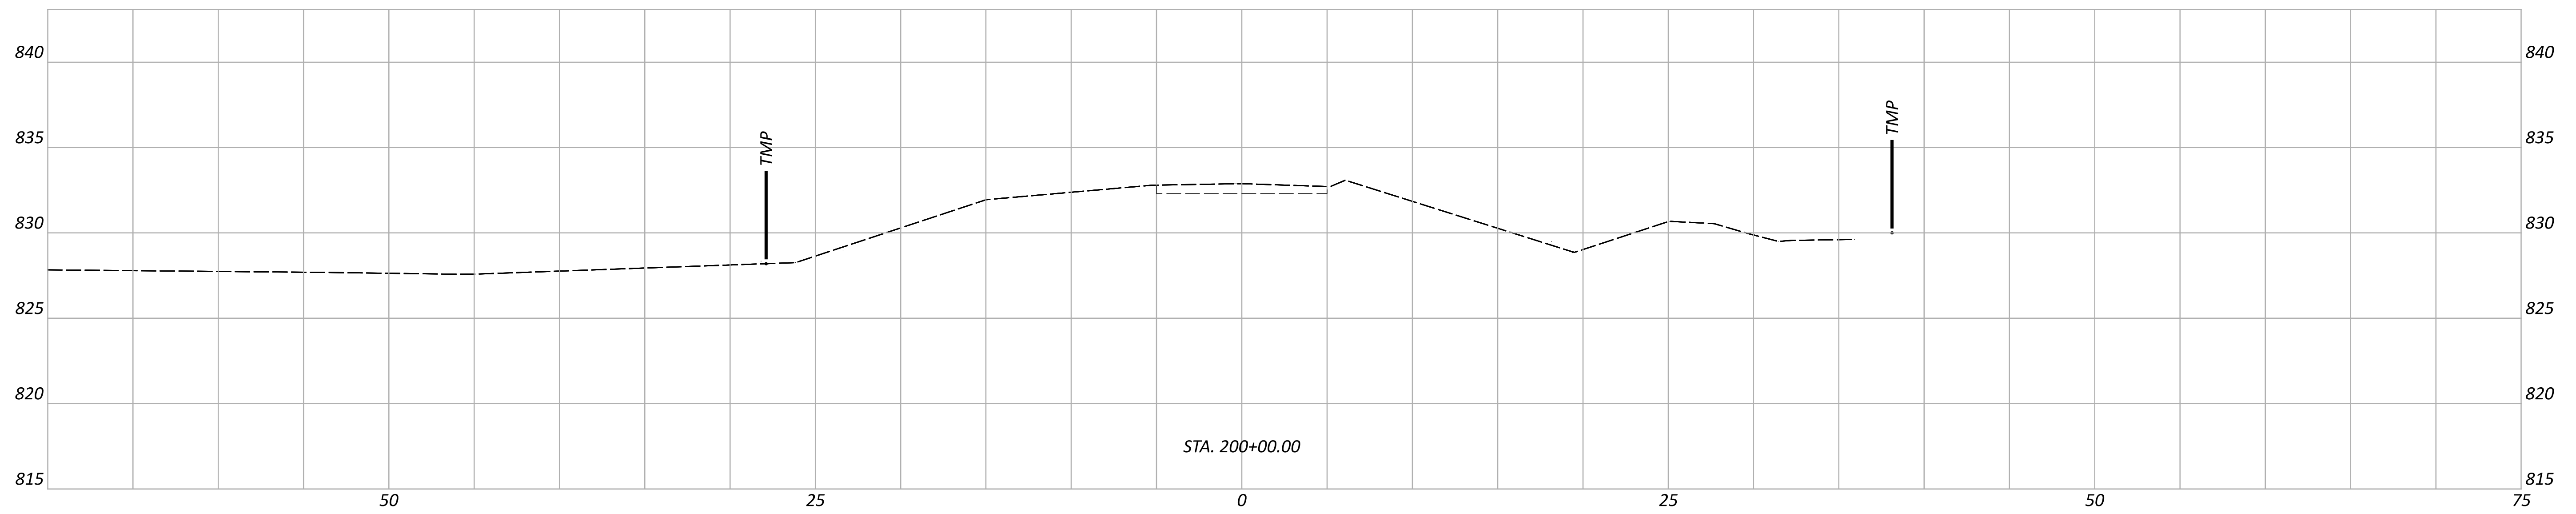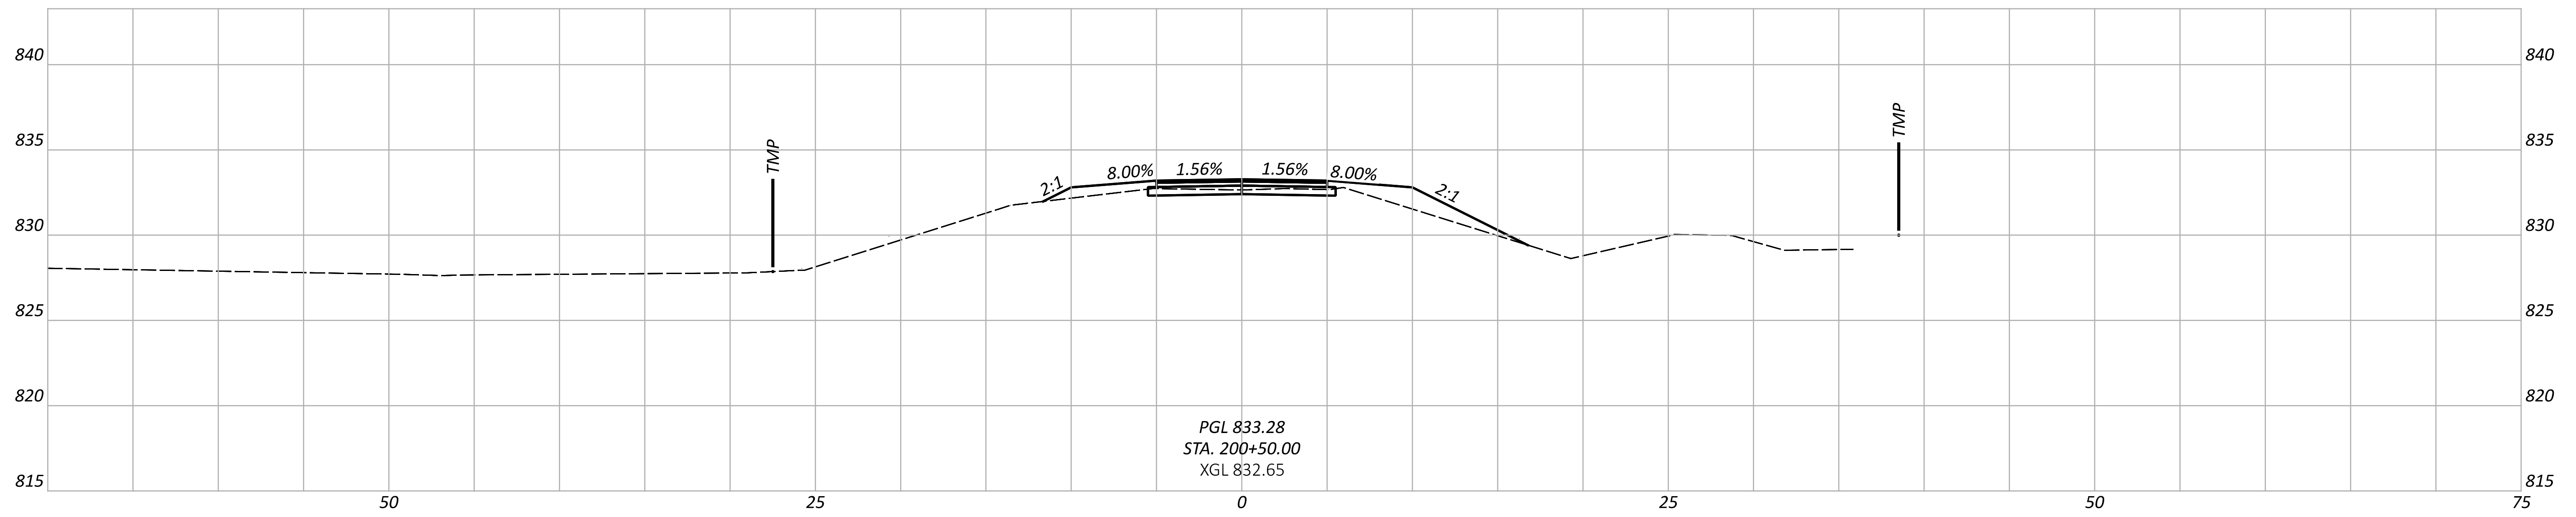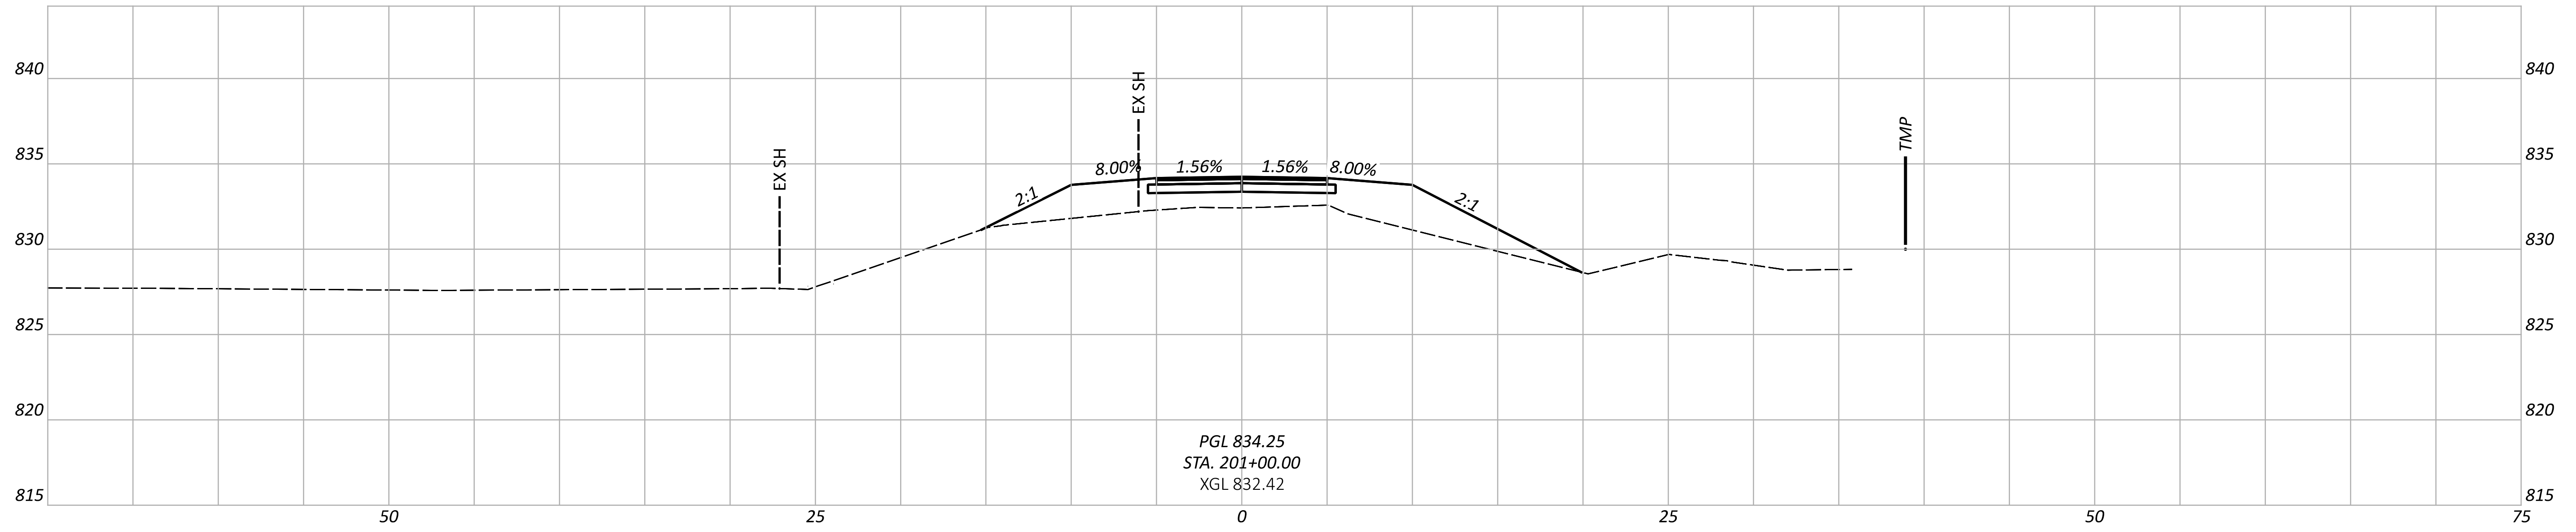



CROSS SECTIONS - LITTLE MIAMI SCENIC TRAIL  
 STA. 200+00.00 TO STA. 201+00.00

DESIGN AGENCY	
	
DESIGNER	
CEF	
REVIEWER	
BAA 03/28/25	
PROJECT ID	
115388	
SHEET	TOTAL
P.27	P.107

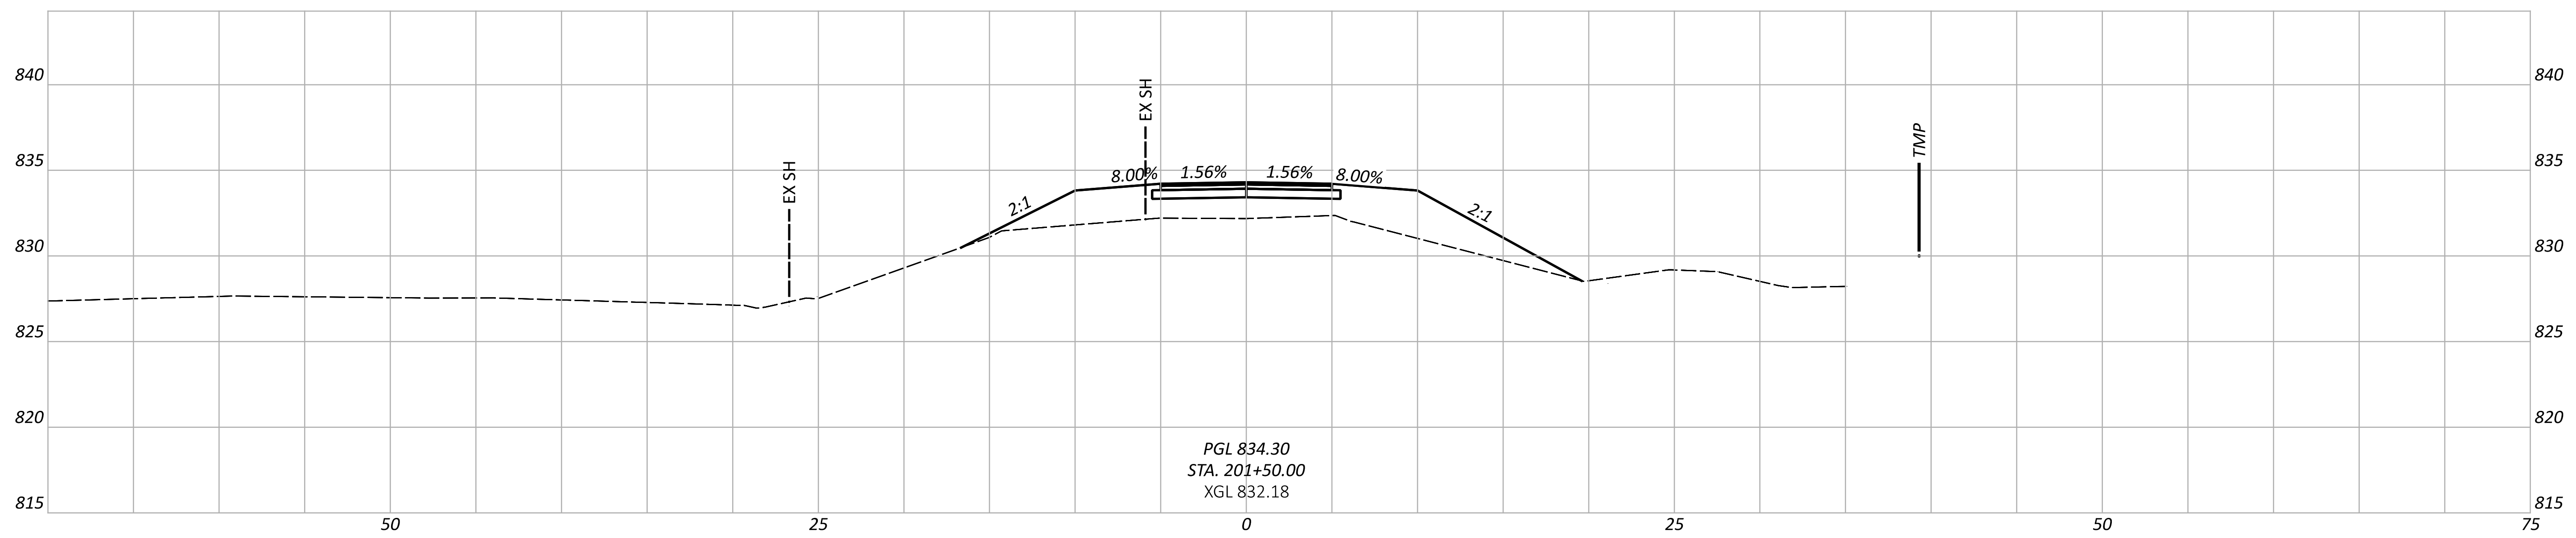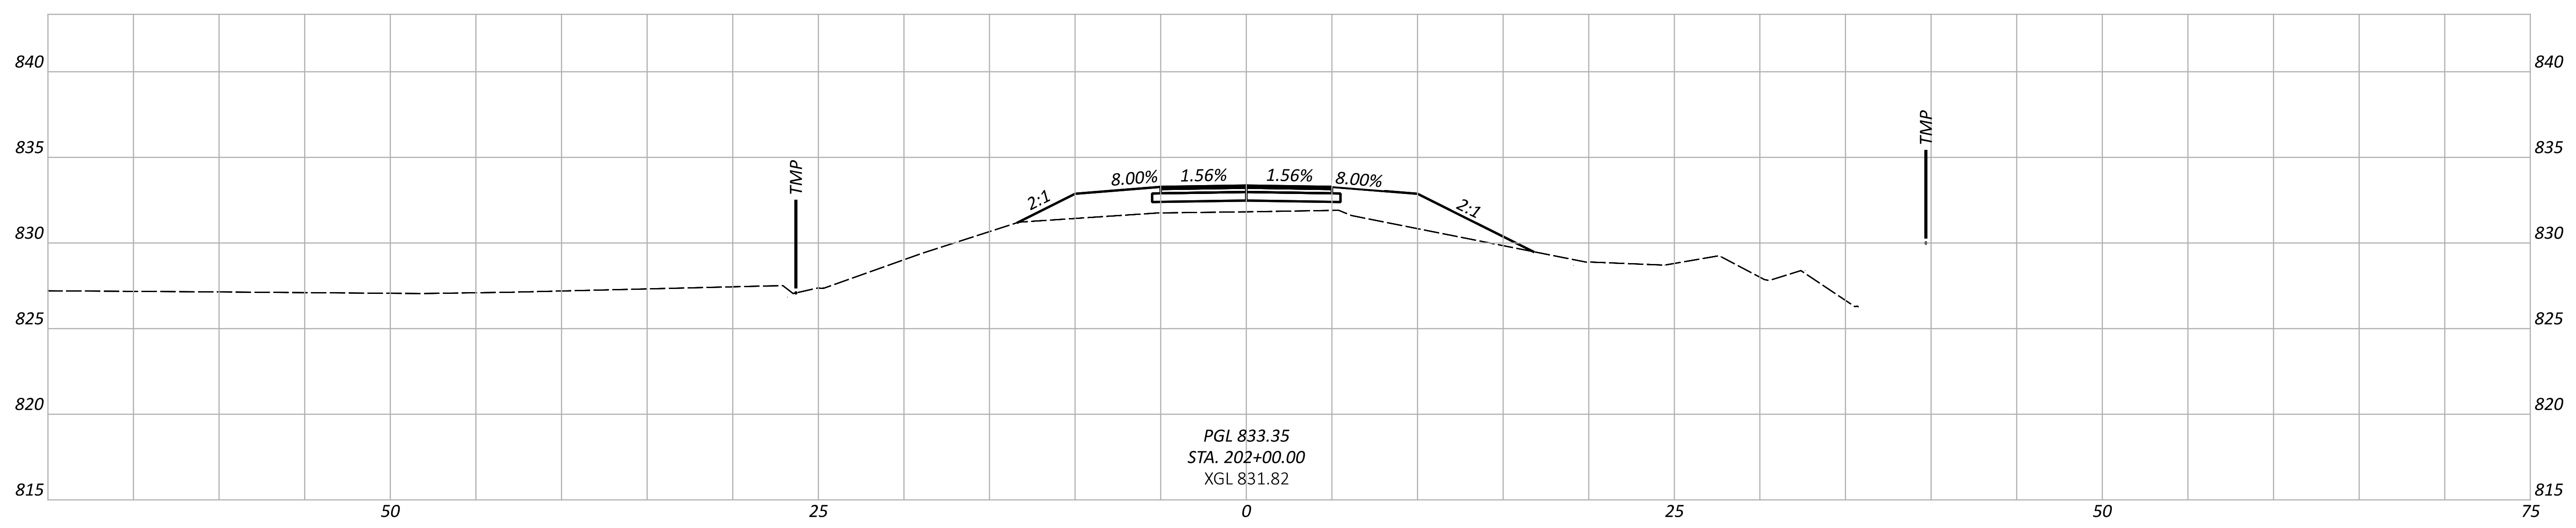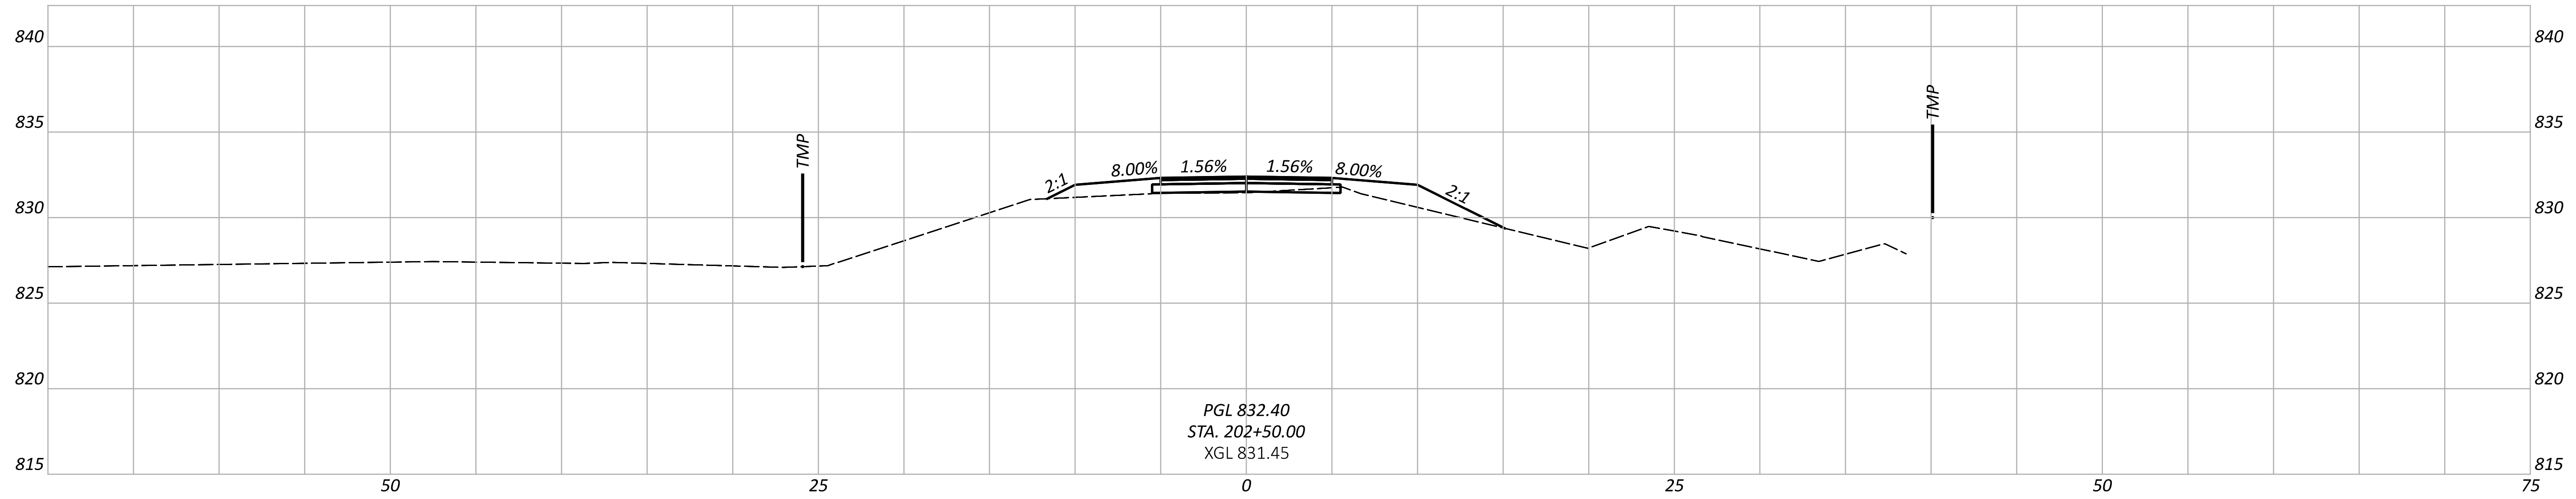

CROSS SECTIONS - LITTLE MIAMI SCENIC TRAIL  
STA. 201+50.00 TO STA. 202+50.00




DESIGN AGENCY	
CARPENTER MARTY	
DESIGNER	
CEF	
REVIEWER	
BAA 03/28/25	
PROJECT ID	
115388	
SHEET	TOTAL
P.28	P.107

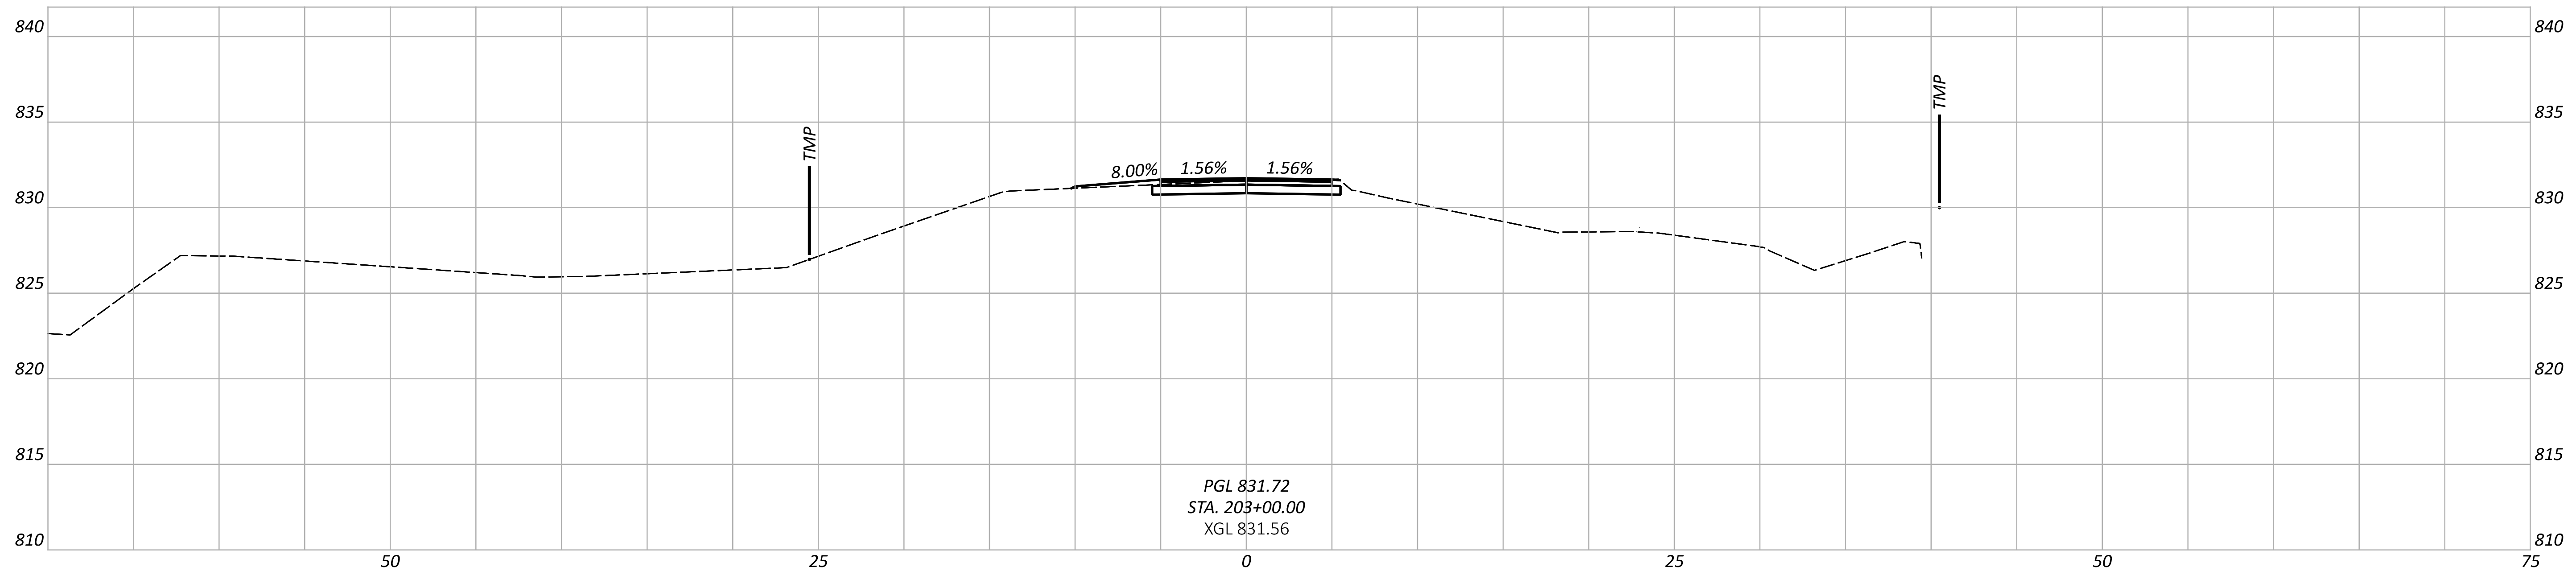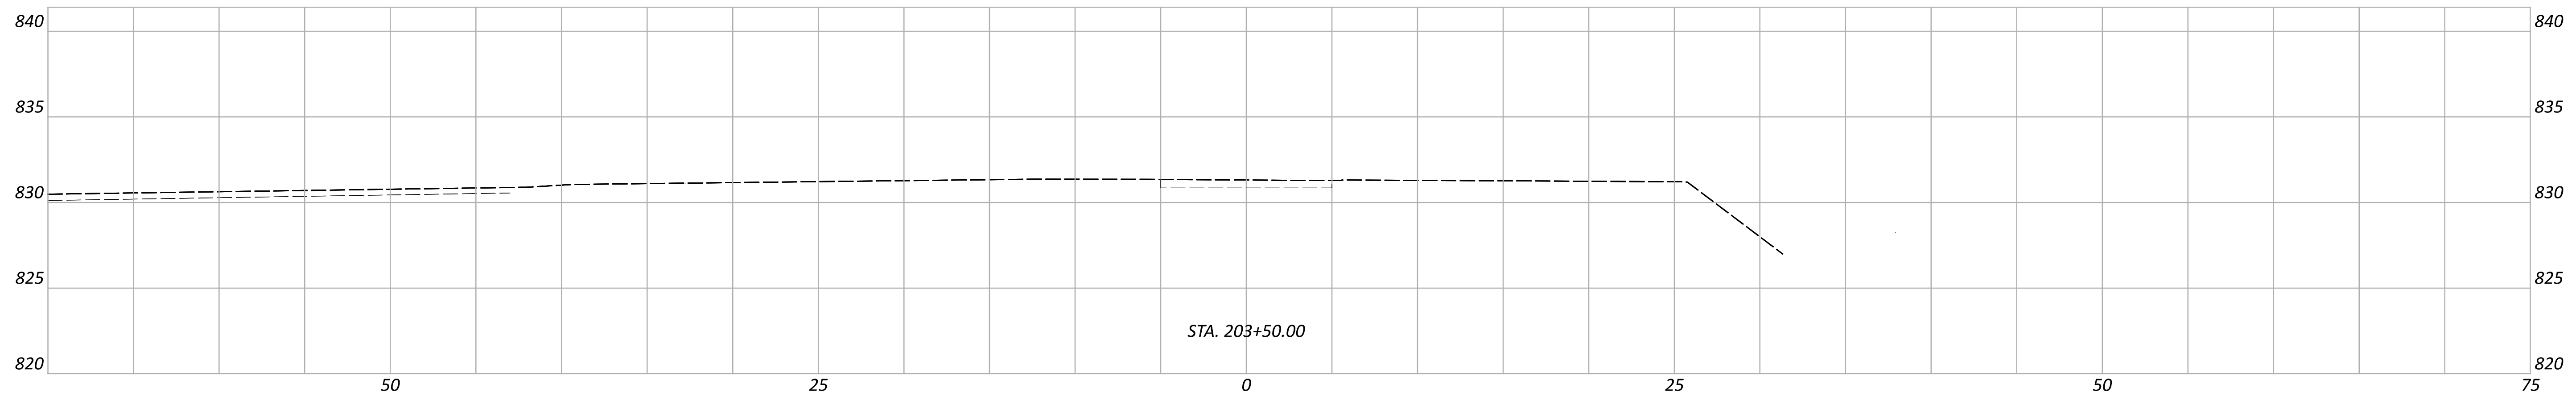



CROSS SECTIONS - LITTLE MIAMI SCENIC TRAIL  
STA. 203+00.00 TO STA. 203+50.00

DESIGN AGENCY	
CARPENTER MARTY	
DESIGNER	
CEF	
REVIEWER	
BAA 03/28/25	
PROJECT ID	
115388	
SHEET	TOTAL
P.29	P.107

SWITCHBACK RAMP CONTROL POINTS					
STATION	OFFSET	NORTHING	EASTING	DESCRIPTION	
A	0+00.00	0.00'	633129.80	1564419.19	P.O.T.
B	1+52.62	0.00'	633140.75	1564266.97	P.I.
C	1+72.62	0.00'	633160.70	1564268.40	P.I.
D	2+62.53	0.00'	633154.25	1564358.09	P.I.
E	2+82.53	0.00'	633174.20	1564359.53	P.I.
F	3+72.45	0.00'	633180.65	1564269.84	P.I.
G	3+92.45	0.00'	633200.60	1564271.27	P.I.

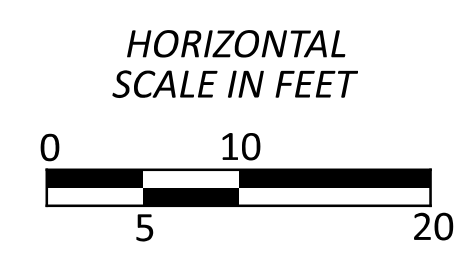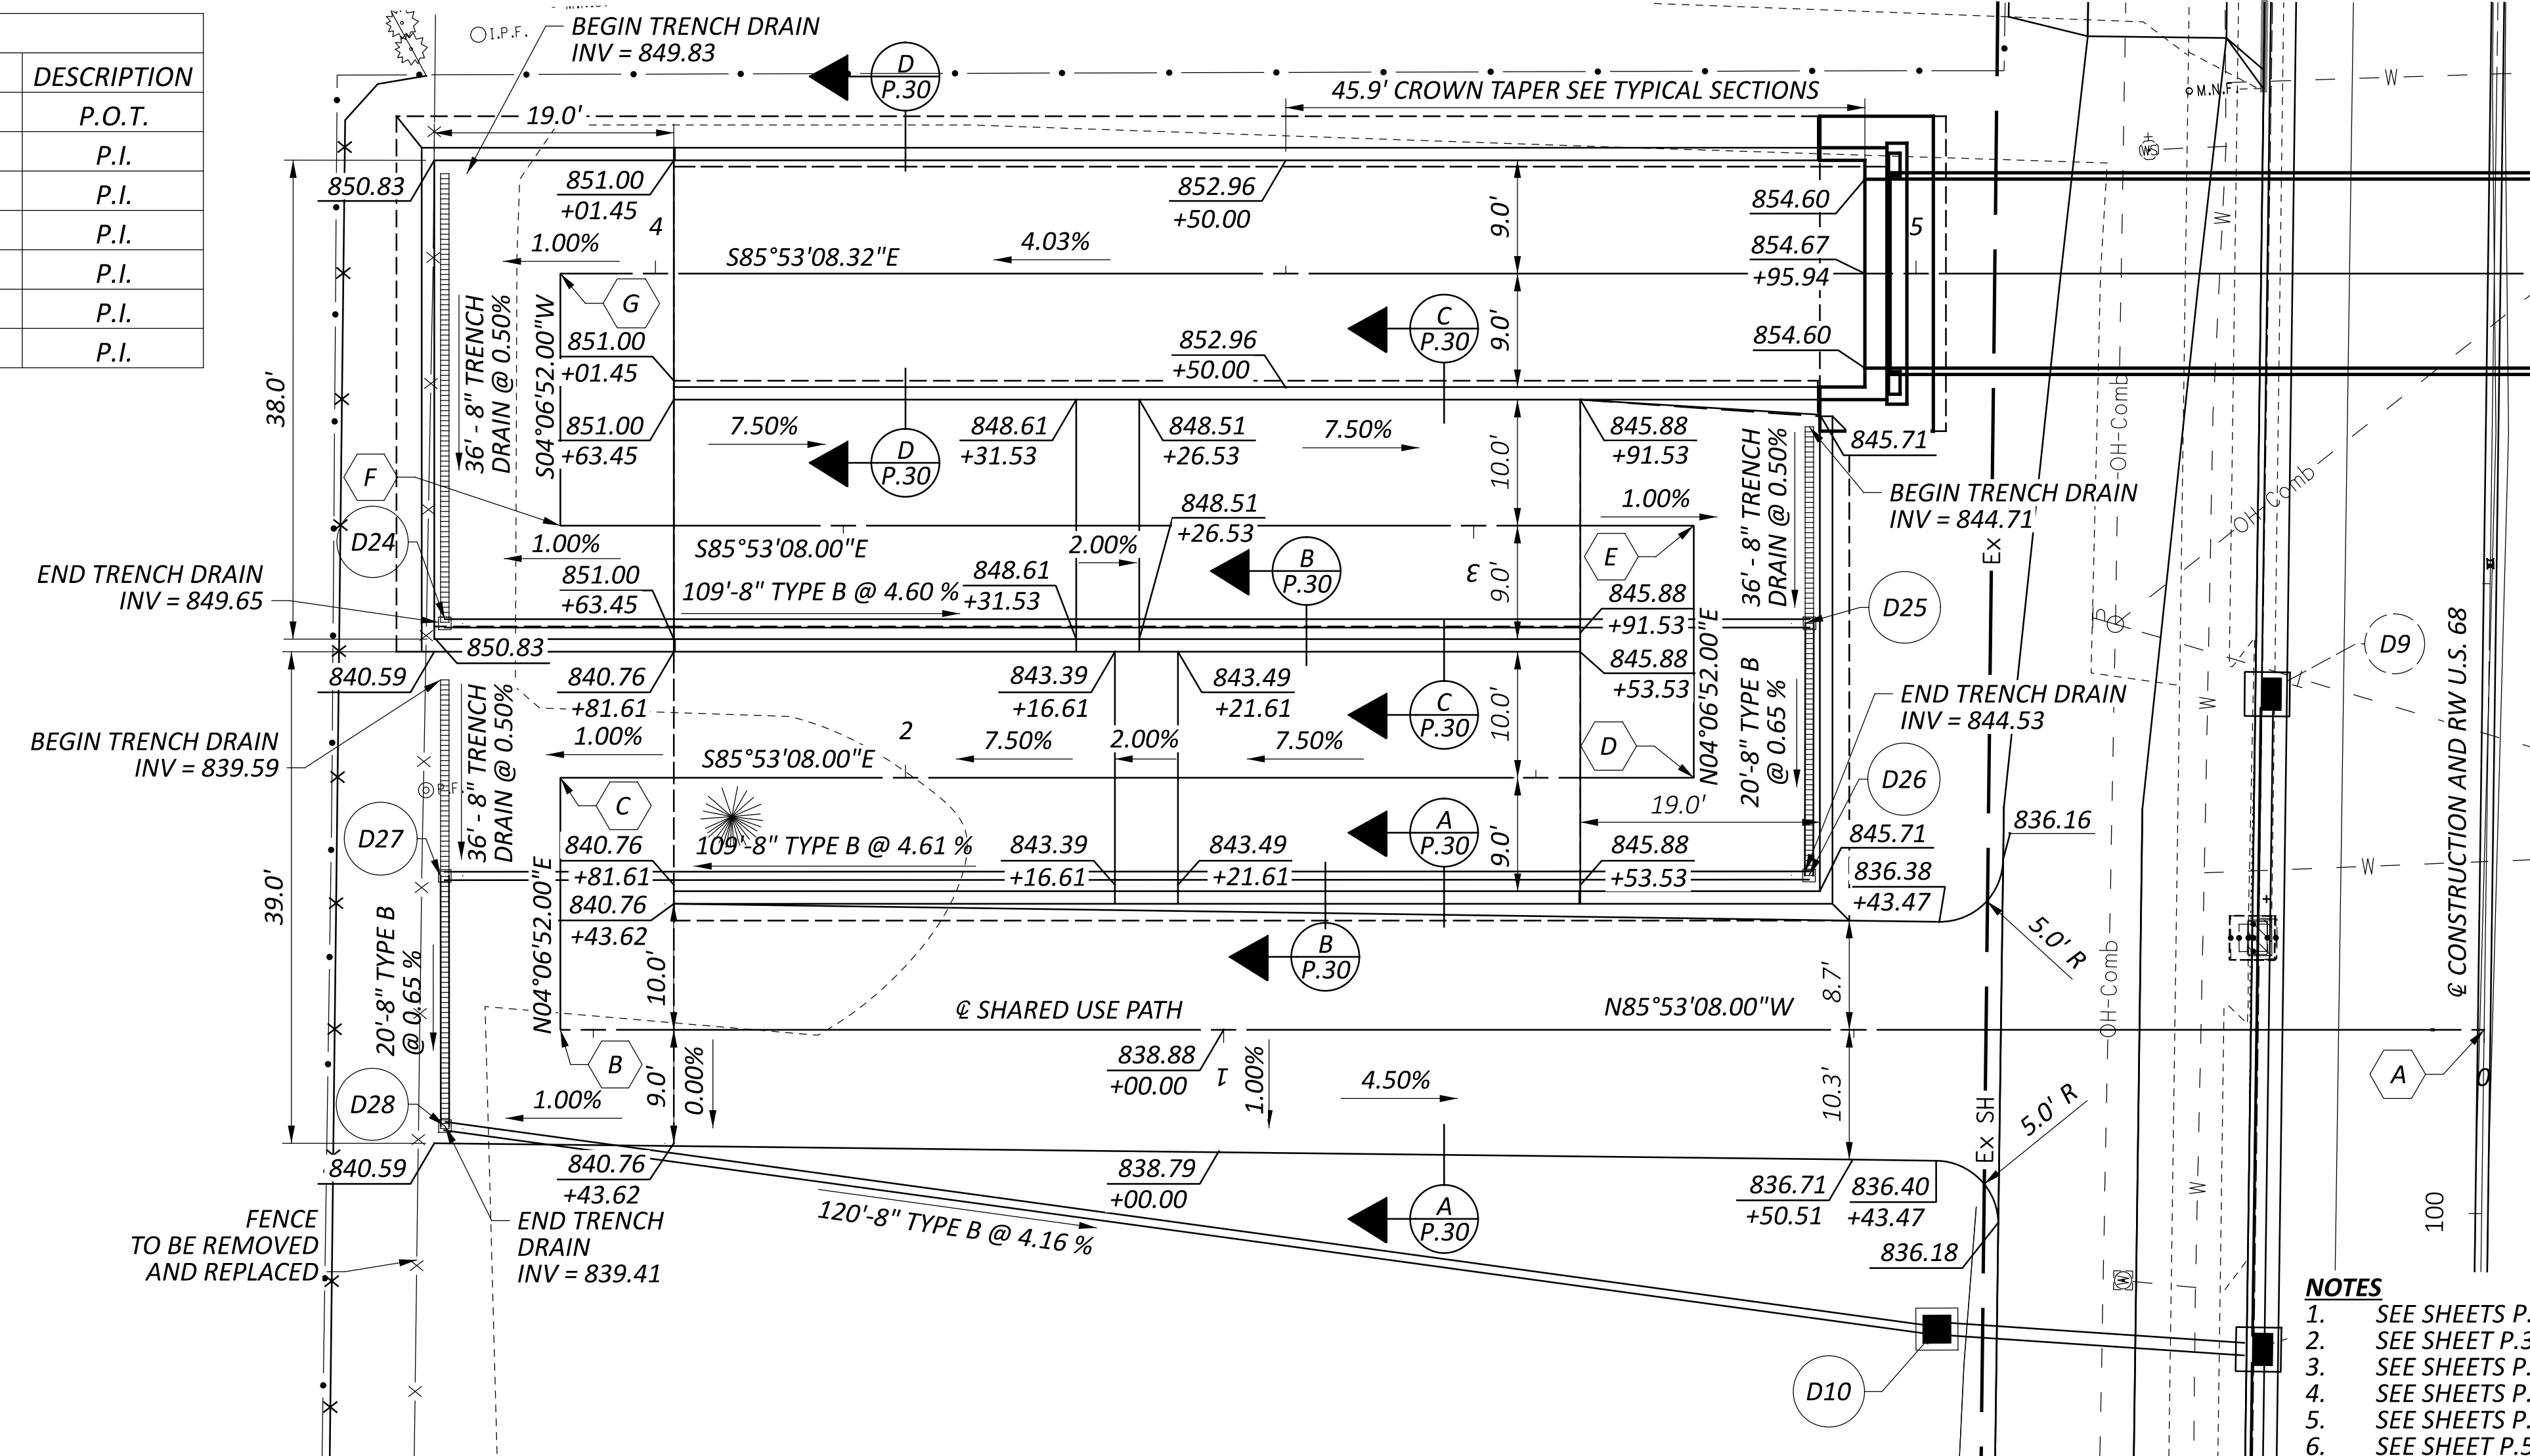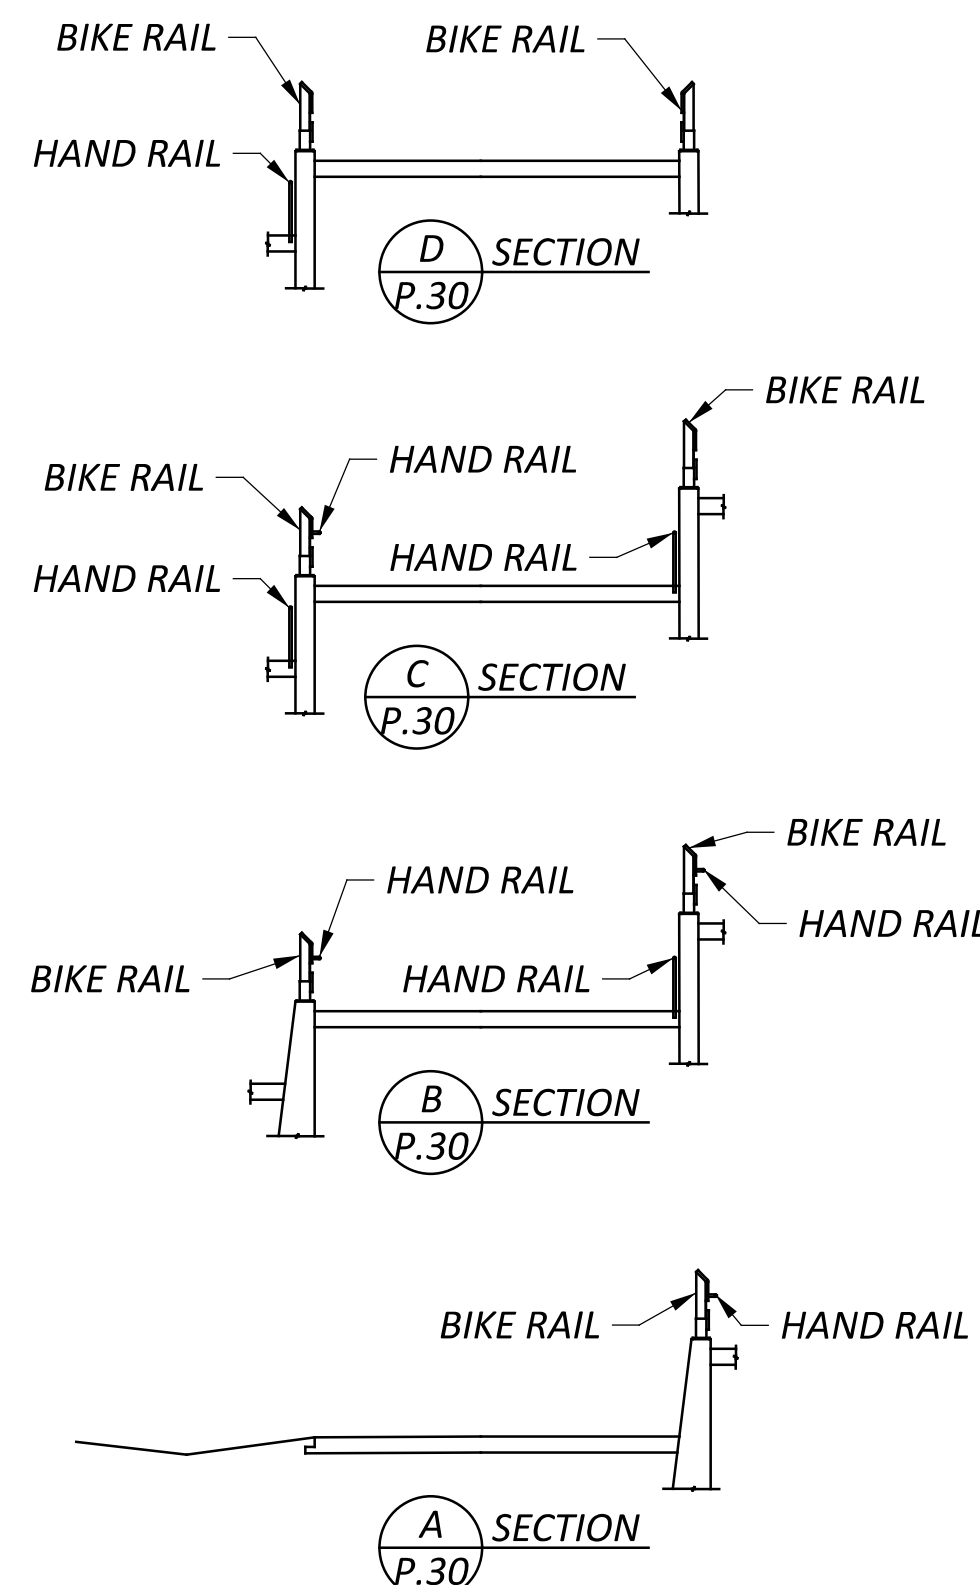


- NOTES**
- SEE SHEETS P.15 - P.17 FOR U.S. 68 PLAN AND PROFILE
  - SEE SHEET P.35 FOR PARKING LOT DETAILS
  - SEE SHEETS P.43 - P.44 FOR STORM SEWER PROFILES
  - SEE SHEETS P.47 - P.71 FOR BRIDGE STRUCTURE PLANS
  - SEE SHEETS P.75 - P.84 FOR WALL DETAILS
  - SEE SHEET P.50 FOR WALL/ABUTMENT ELEVATIONS

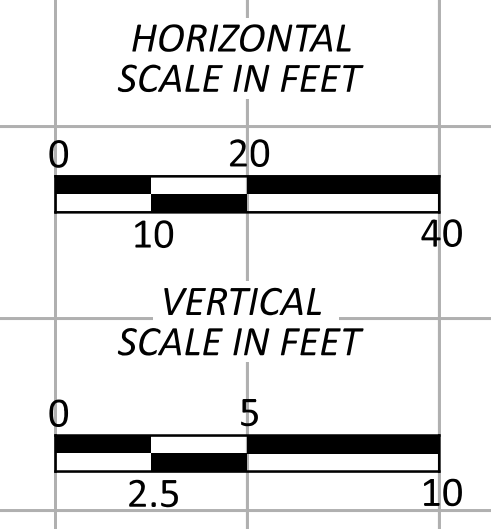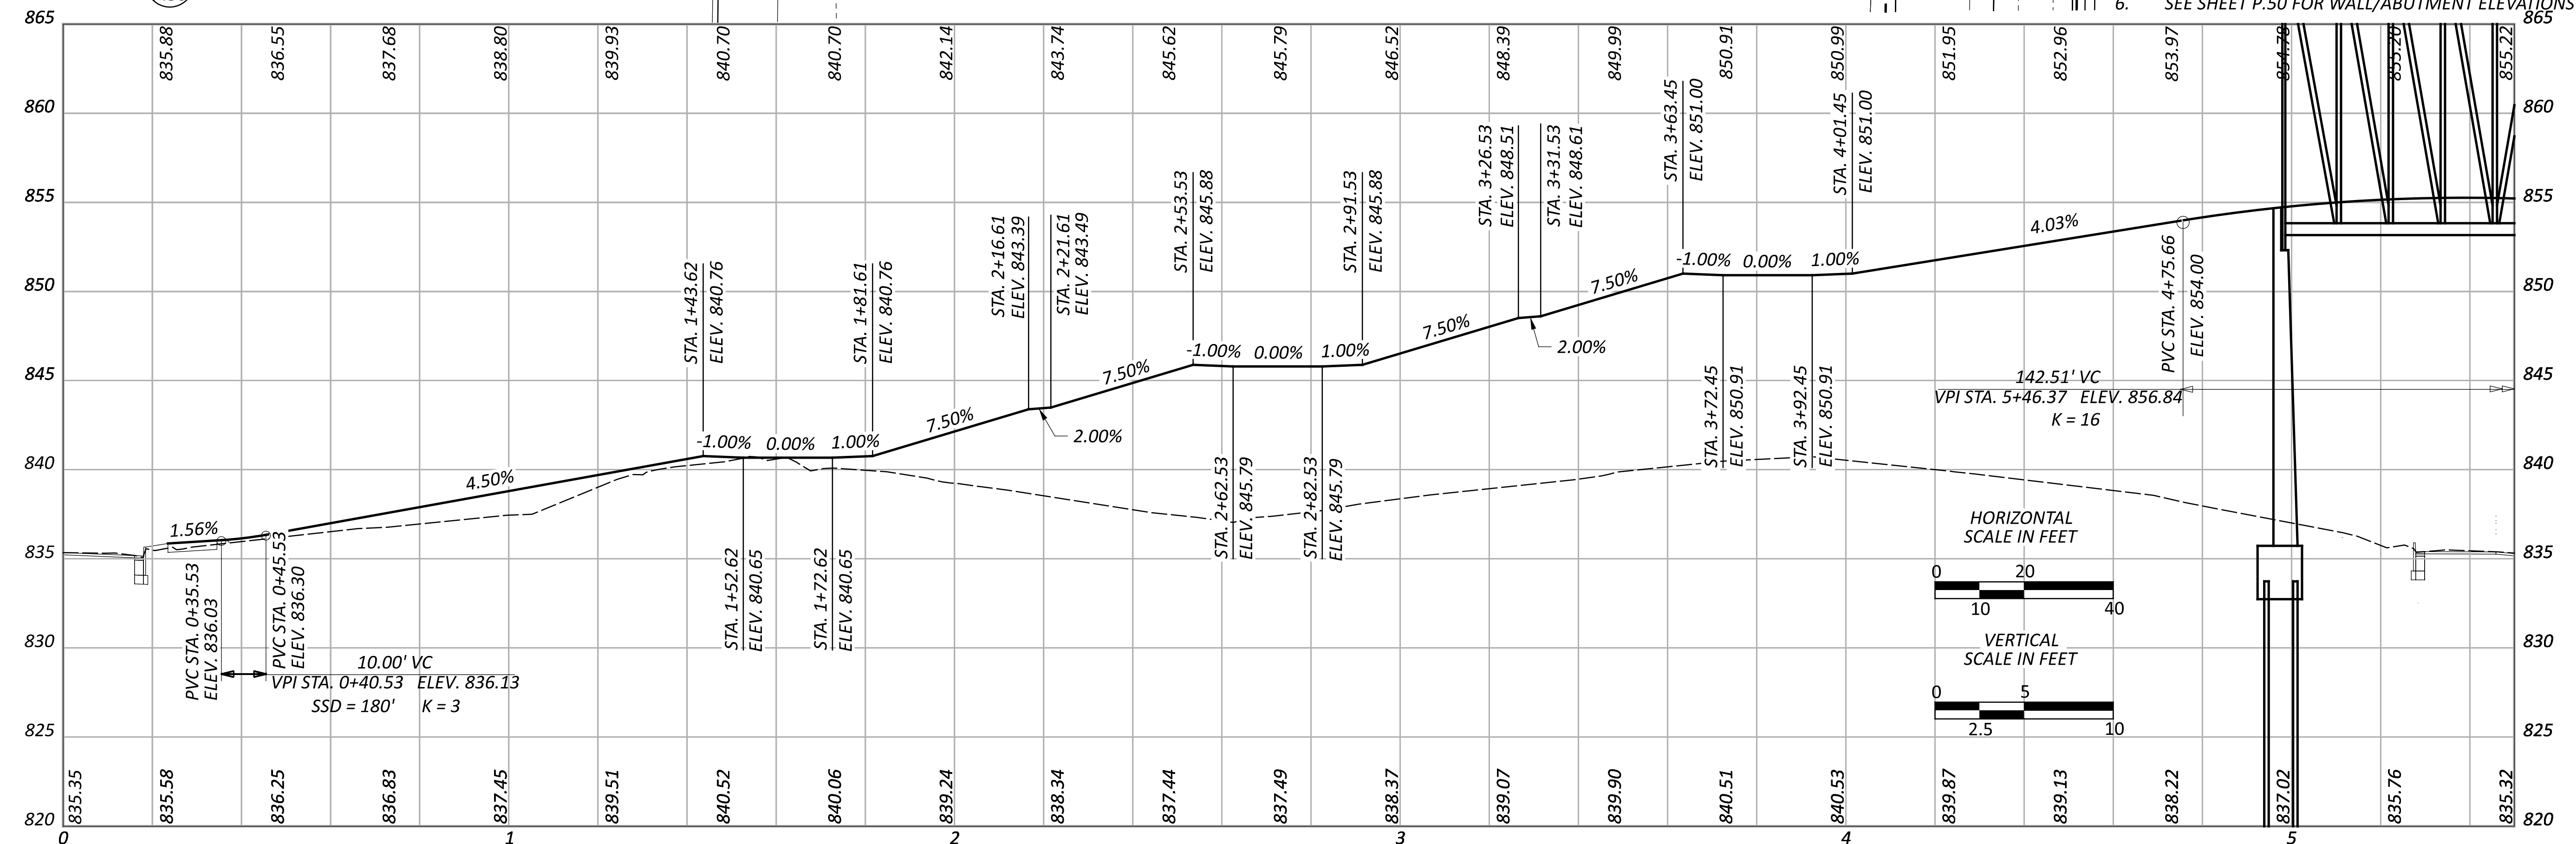

**PLAN AND PROFILE - RAMP**  
 STA. 0+00.00 TO STA. 5+50.00

DESIGN AGENCY	CARPENTER MARTY
DESIGNER	WCS
REVIEWER	BAA 03/28/25
PROJECT ID	115388
SHEET	P.30
TOTAL	P.107

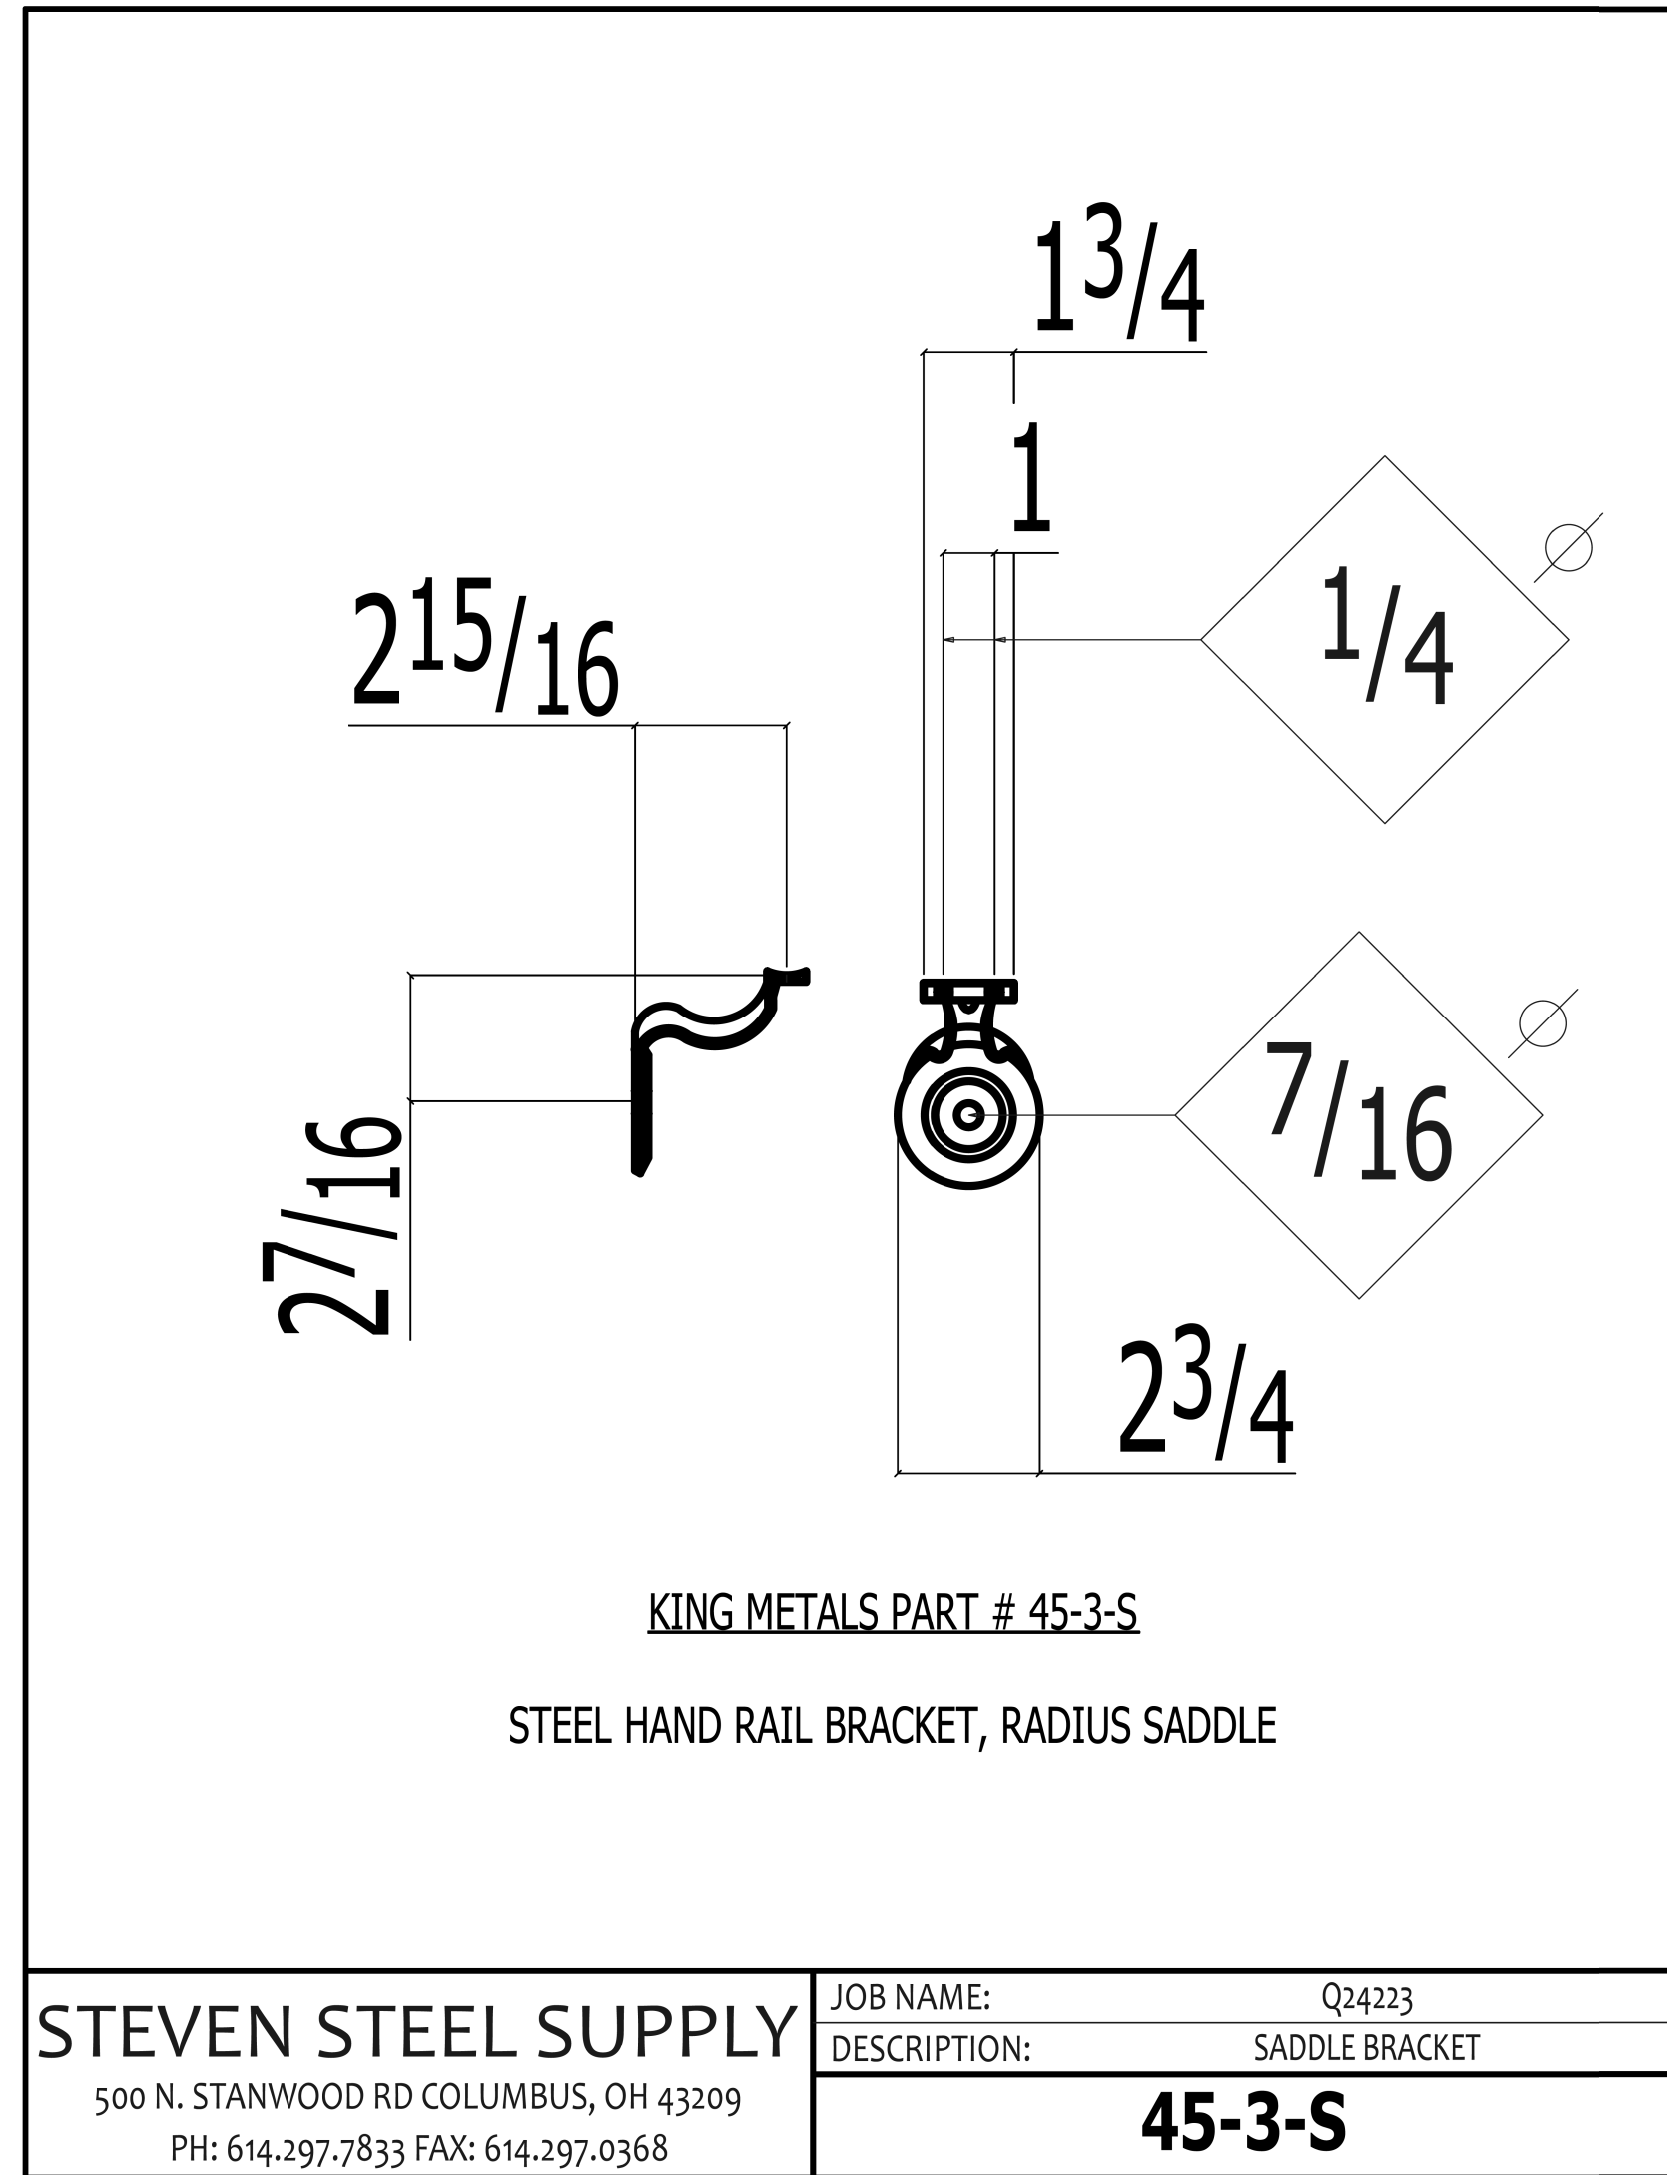

3D BRACKET VIEW

NOTE:  
 BRACKET IS TO BE MOUNTED TO BIKE RAIL WITH 3/8" BOLT  
 WITH NUT AND WASHER

DESIGN AGENCY



DESIGNER

WCS

REVIEWER

BAA 03/27/25

PROJECT ID



115388

SHEET

P.31

TOTAL

P.107

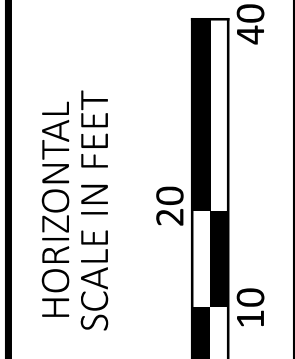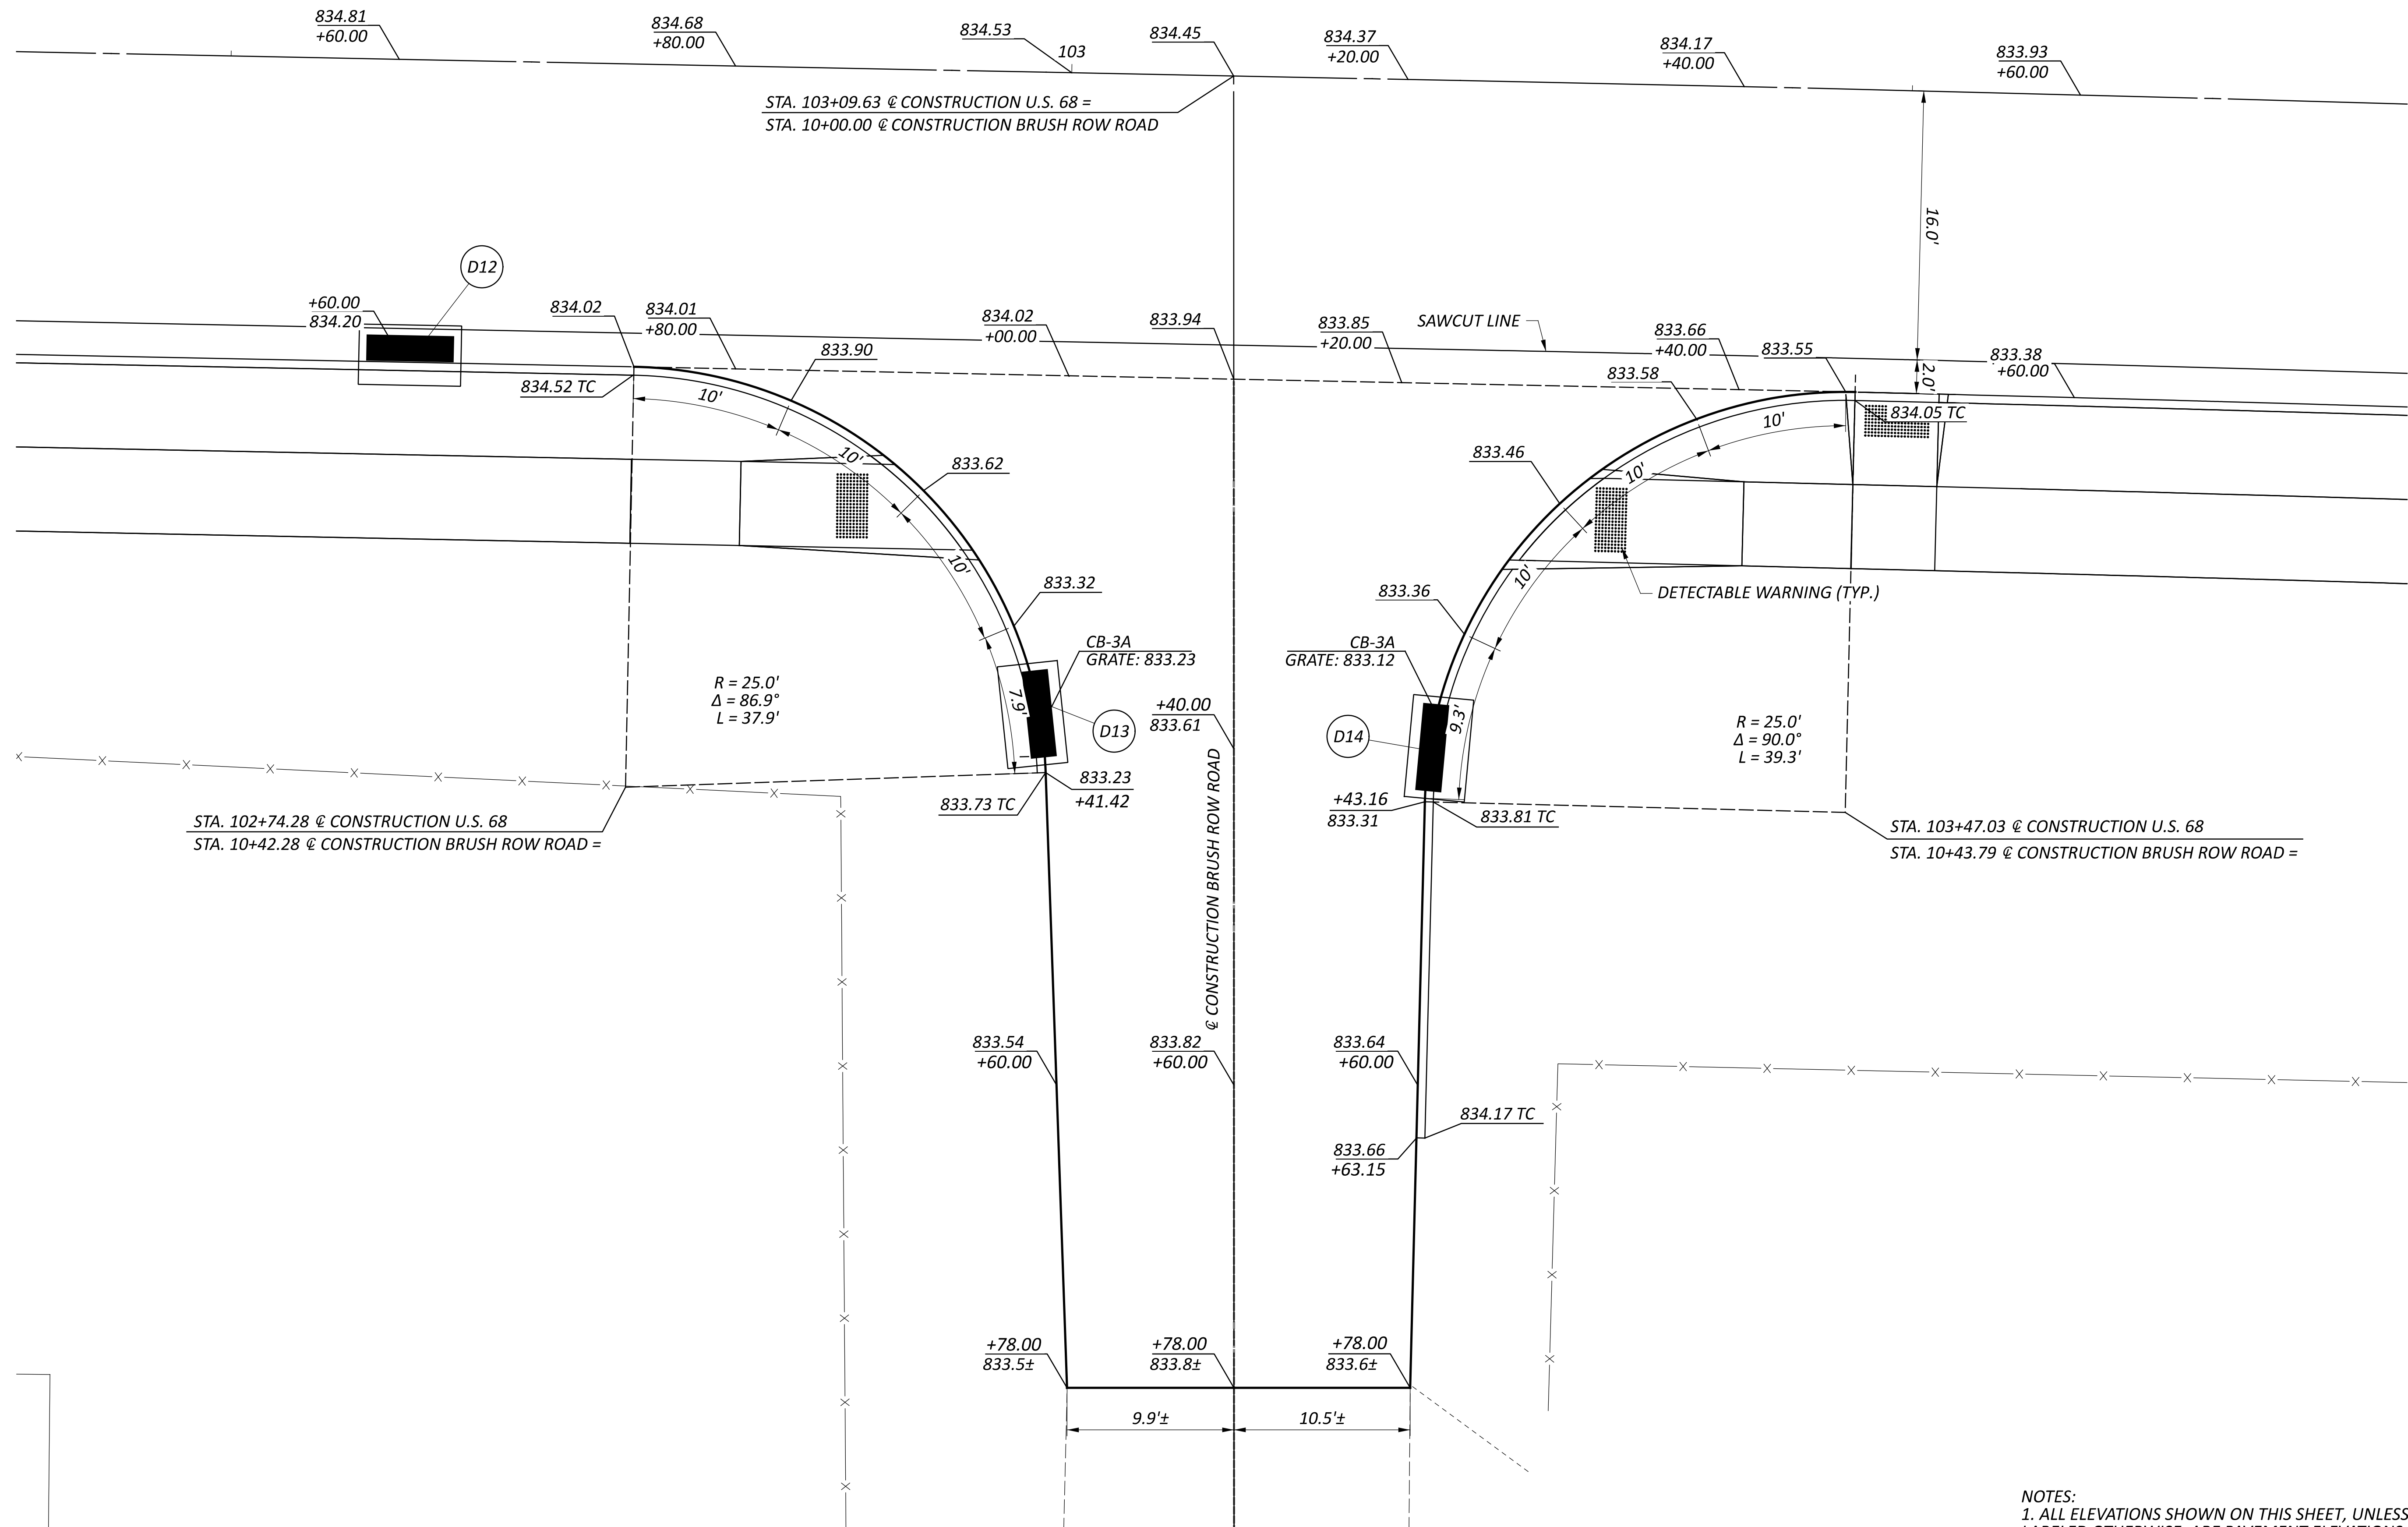


INTERSECTION DETAIL  
 U.S 68 AND BRUSH ROW ROAD


- NOTES:**
1. ALL ELEVATIONS SHOWN ON THIS SHEET, UNLESS LABELED OTHERWISE, ARE PAVEMENT ELEVATIONS
  2. SEE SHEET P.34 FOR CURB RAMP DETAILS

DESIGN AGENCY	
DESIGNER	WCS
REVIEWER	BAA
PROJECT ID	115388
SHEET	TOTAL
P.32	P.107



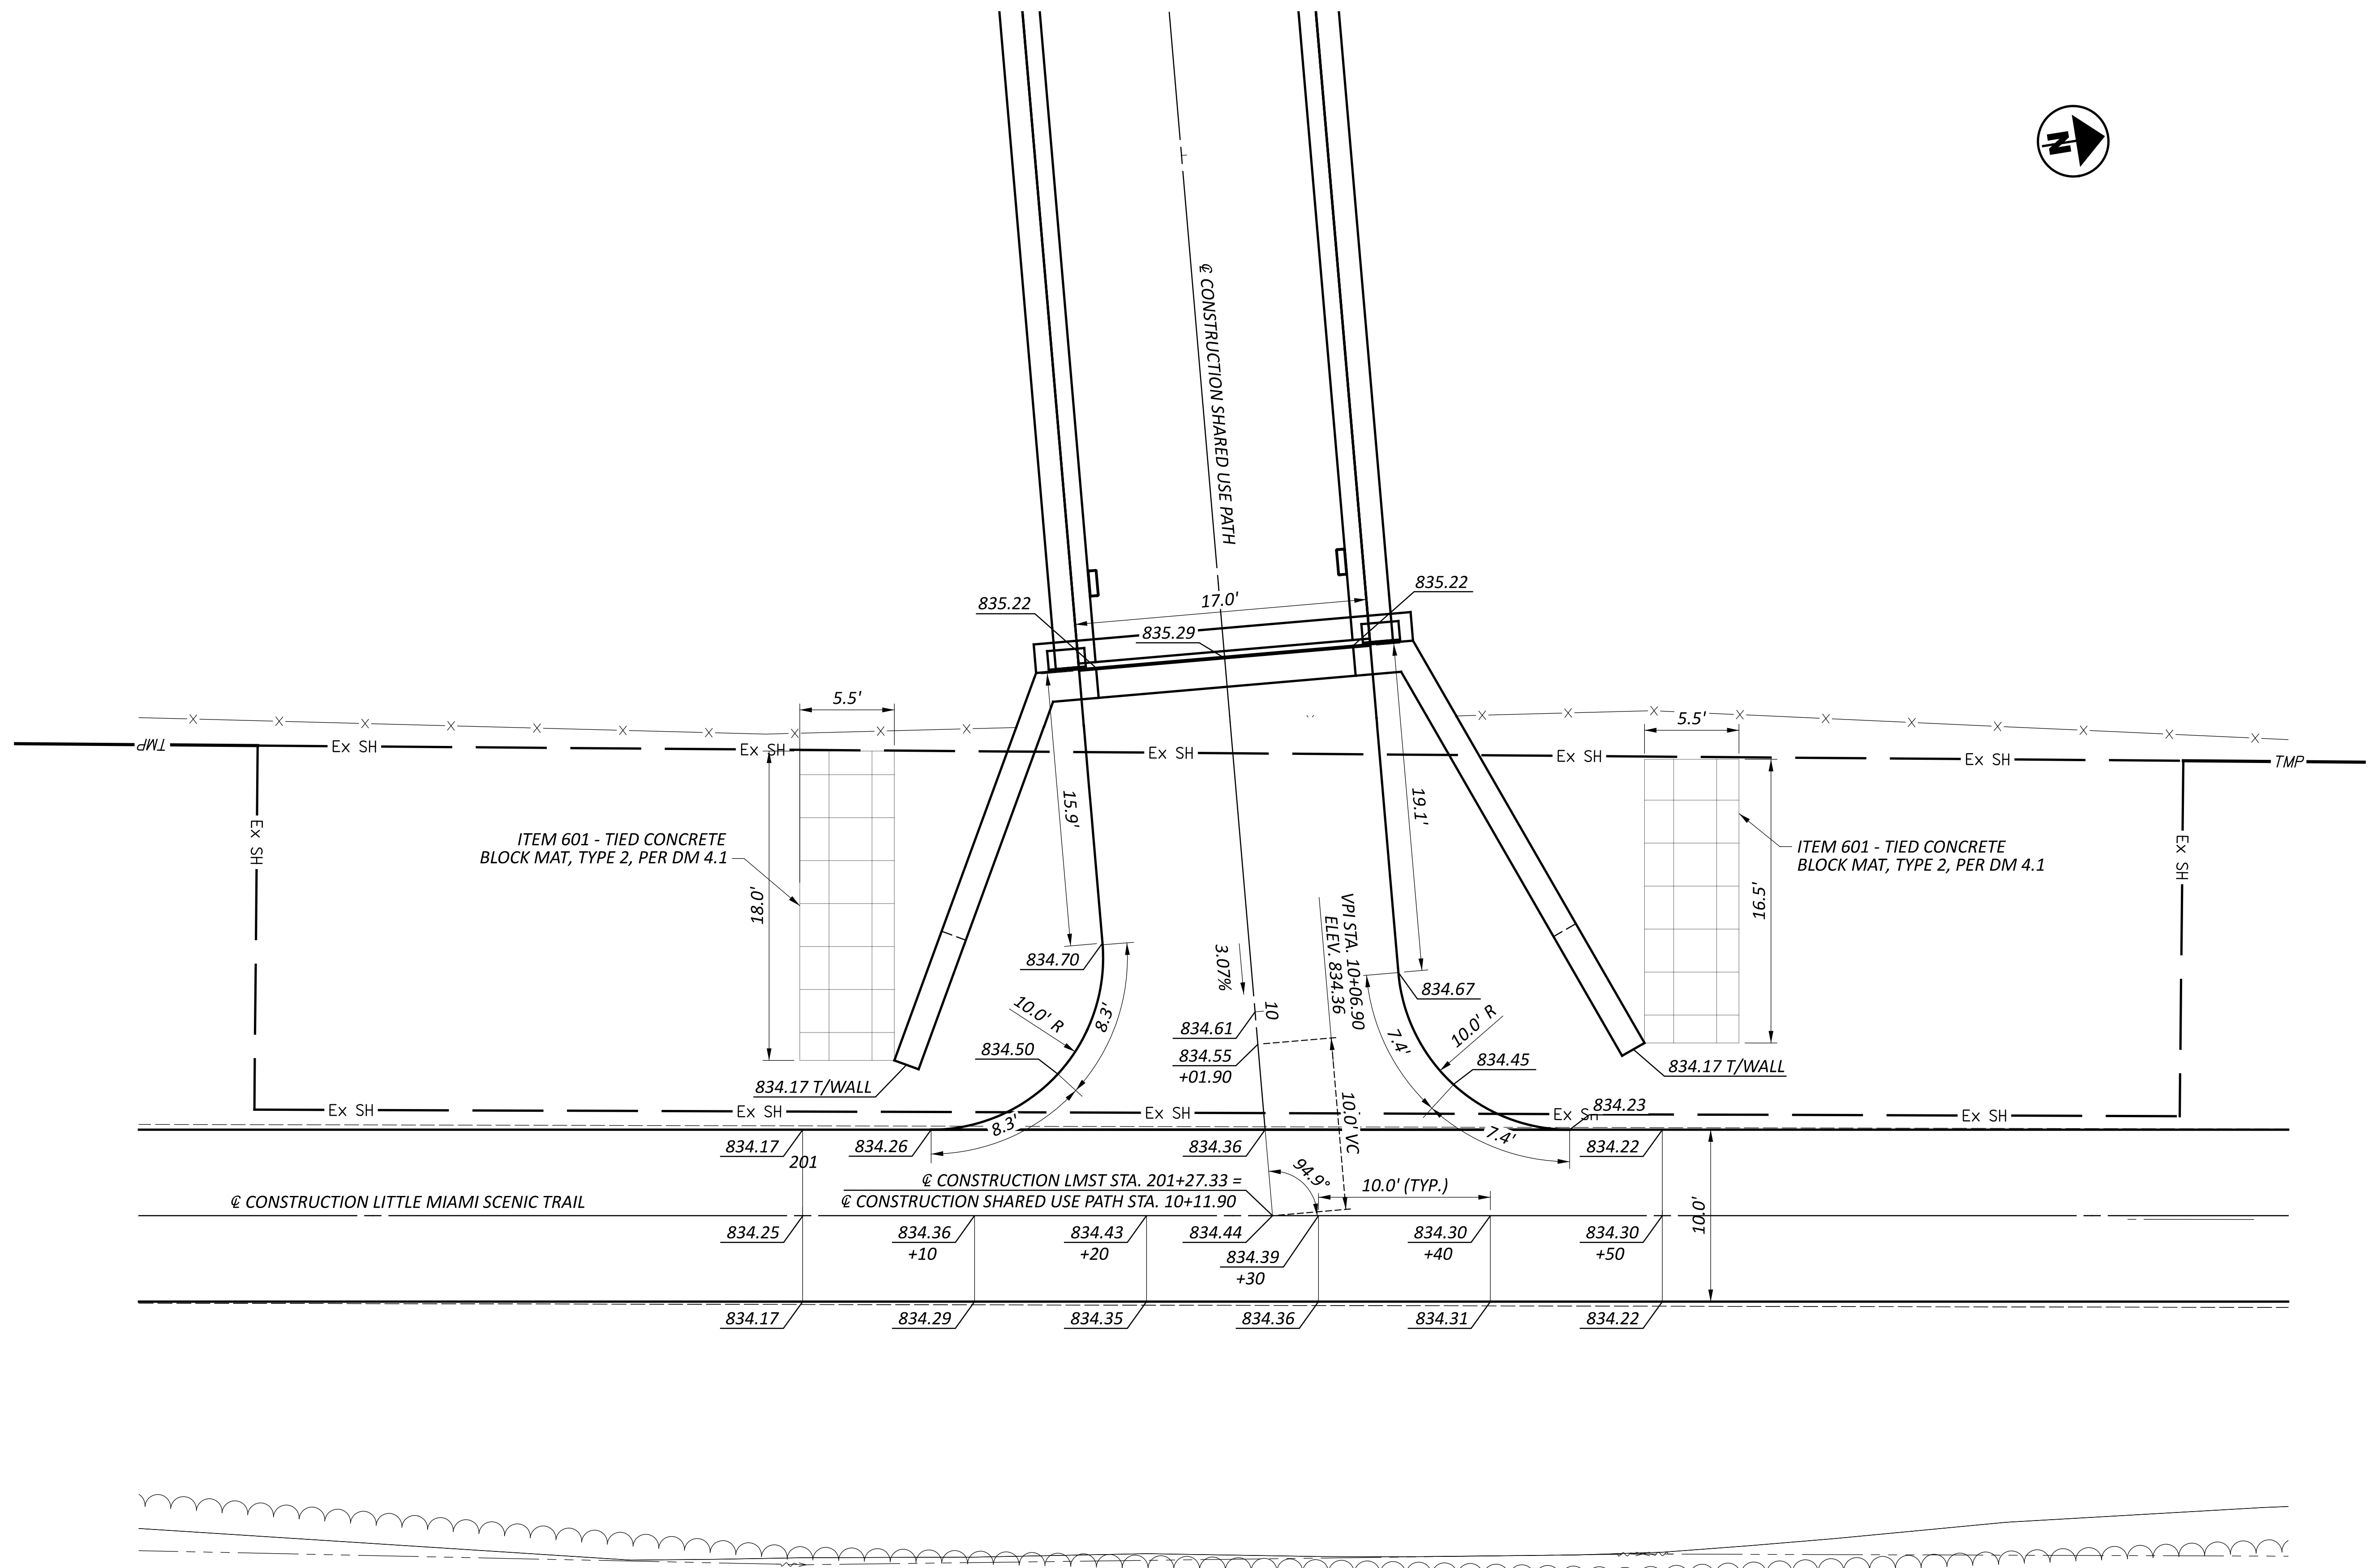

NOTES:  
 SEE SHEET P.53 FOR TOP OF WALL/ABUTMENT ELEVATIONS

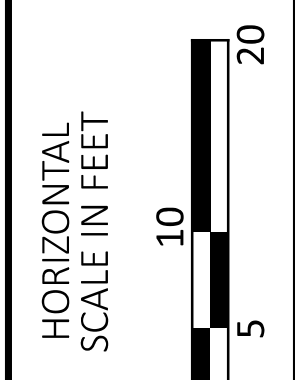

LITTLE MIAMI TRAIL  
 INTERSECTION DETAIL






DESIGN AGENCY	WCS
DESIGNER	WCS
REVIEWER	BAA 03/28/25
PROJECT ID	115388
SHEET	TOTAL
P.33	P.107



NOTES:

1. AREA IS TO BE DESIGNATED AS A FUTURE ODNR PARKING LOT. ALL REMOVED AGGREGATE IS TO BE KEPT CLEAN, FREE OF ADDITIONAL SOIL, AND STOCKPILED ONSITE. AGGREGATE THAT HAS BEEN REMOVED MAY BE USED ON THIS PROJECT PROVIDED IT IS KEPT CLEAN, AND FREE OF ADDITIONAL SOIL.

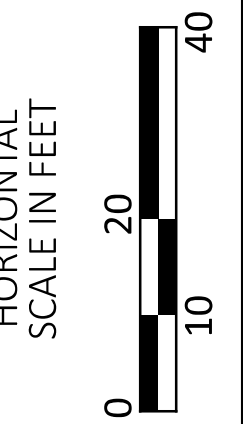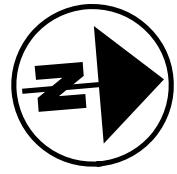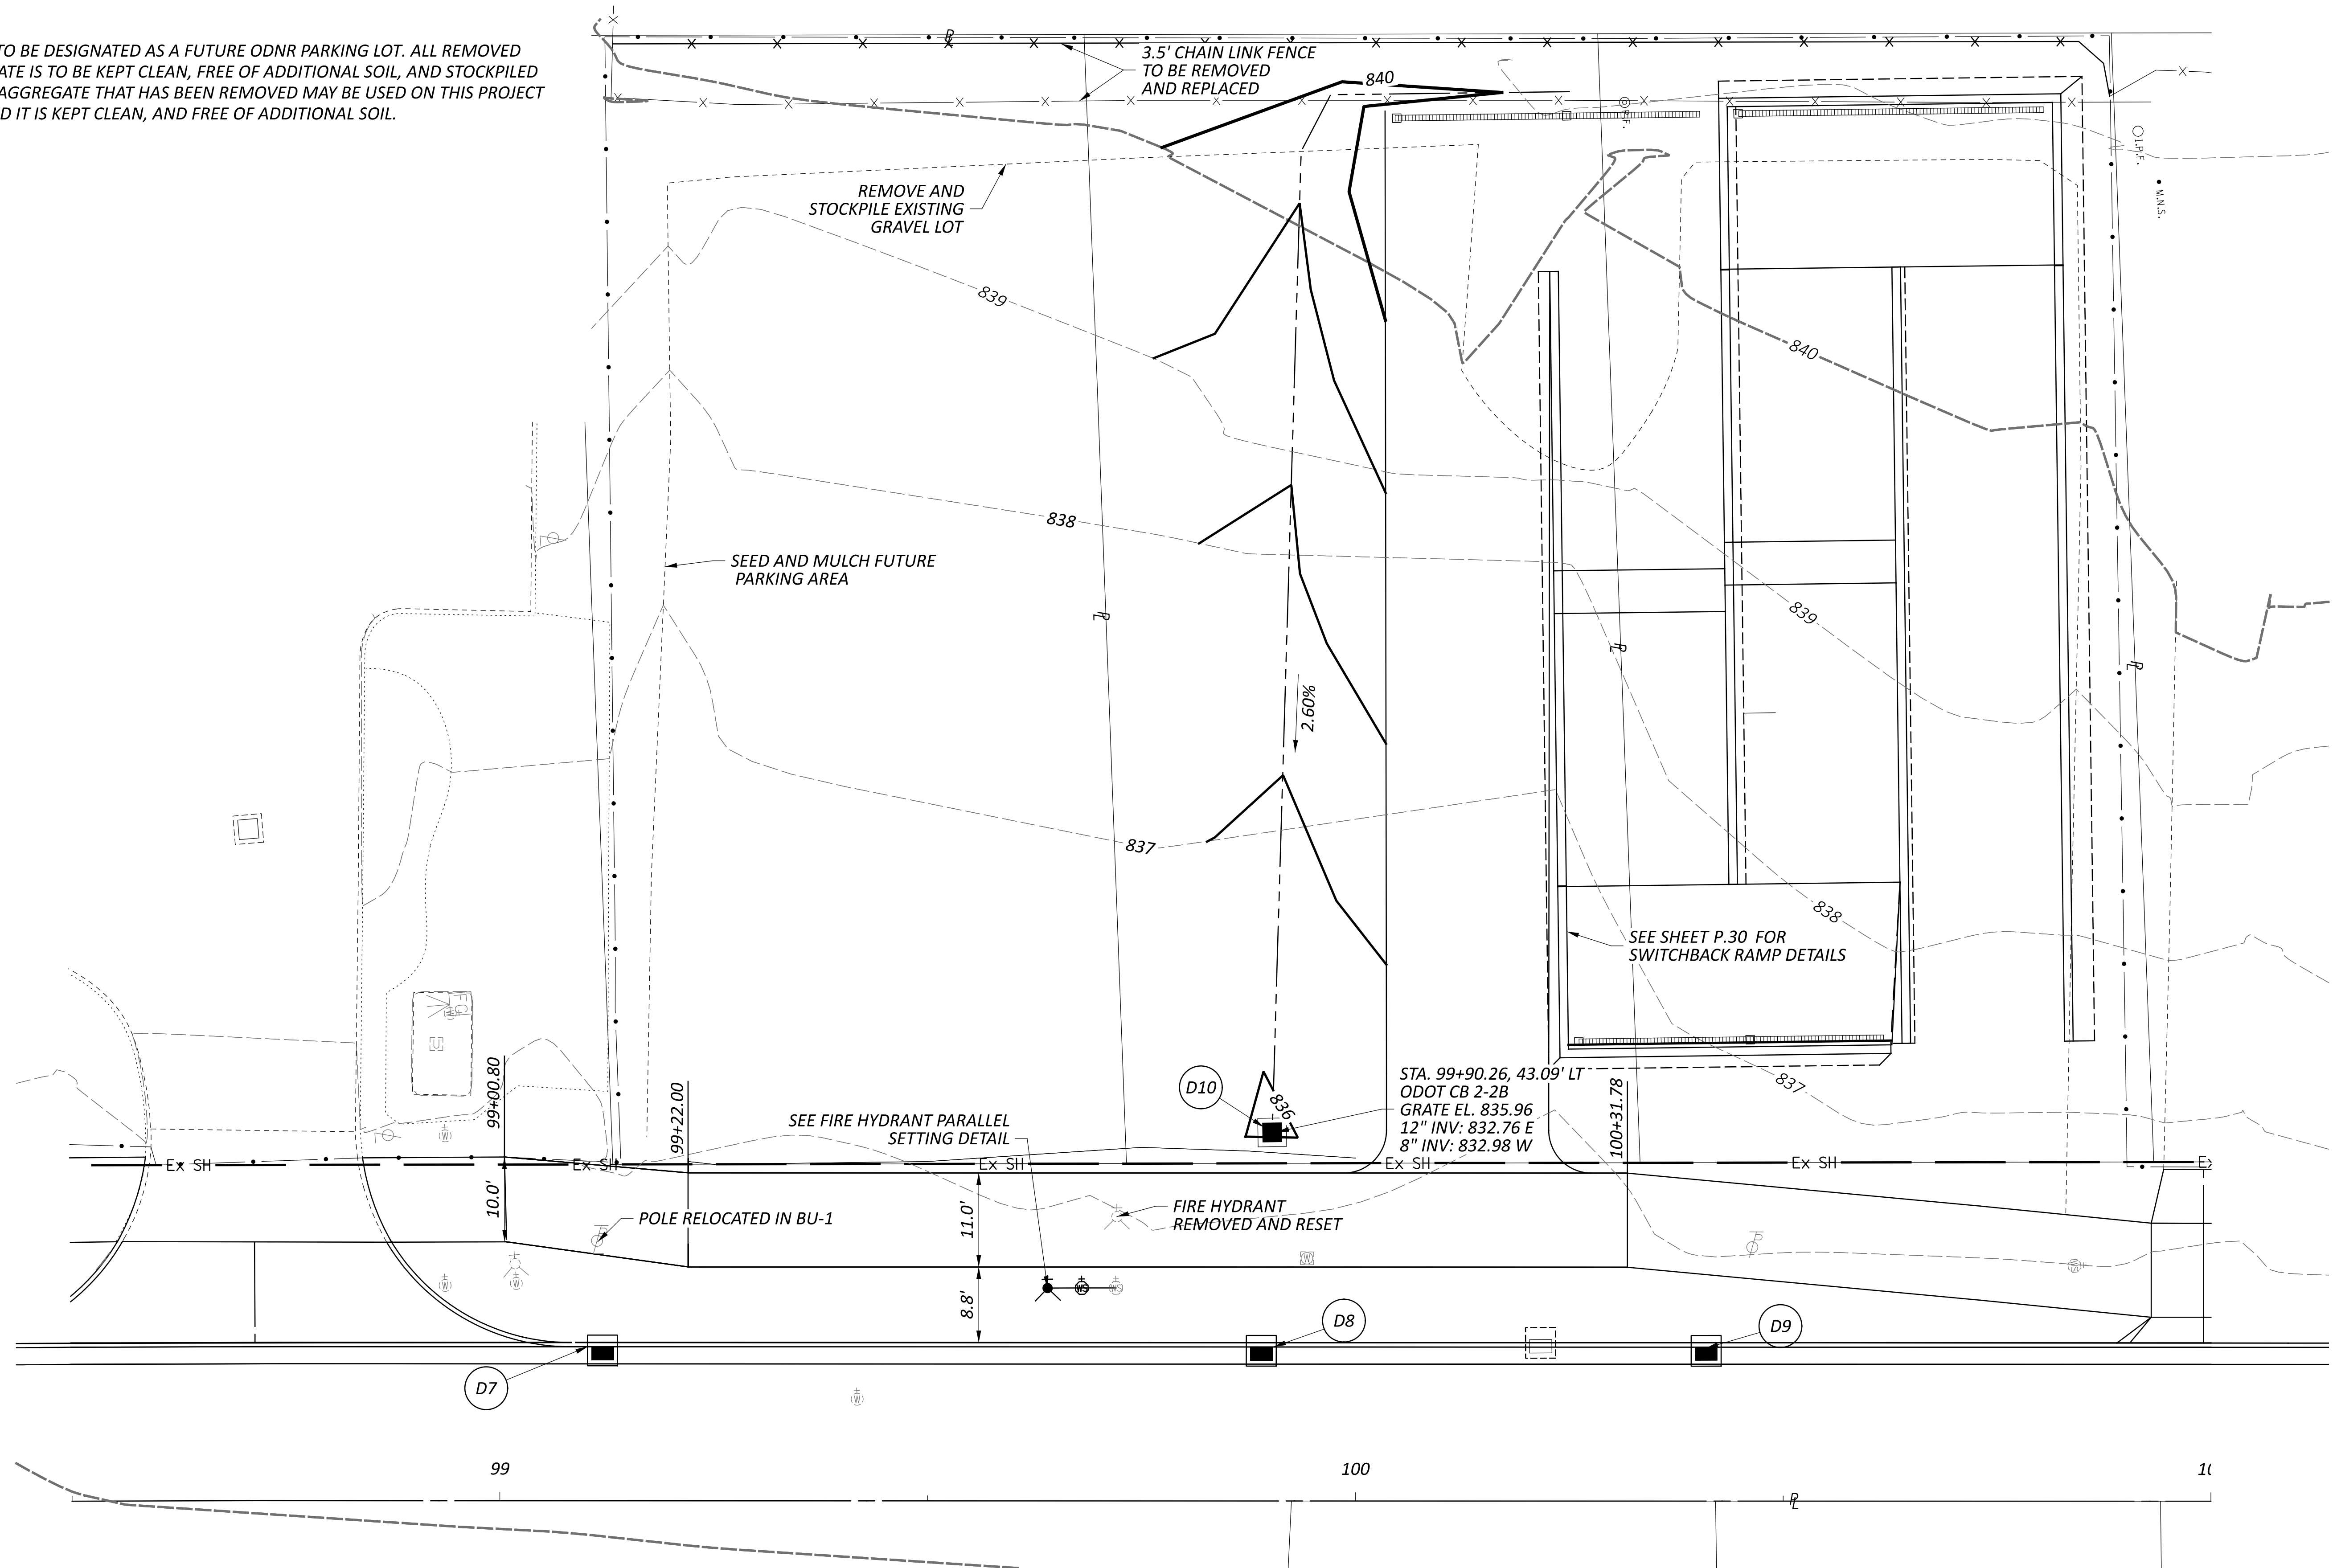

GRADING DETAILS


DESIGN AGENCY




DESIGNER	WCS
REVIEWER	BAA
PROJECT ID	115388
SHEET	TOTAL
P.35	P.107

**LEGEND - DRIVEWAY PAVEMENT BUILDUP**


- ① ITEM 452 - 6" NON-REINFORCED CONCRETE PAVEMENT
- ② ITEM 441 - 2" AC SURFACE COURSE, TYPE 1, 449, (DRIVEWAYS)  
ITEM 304 - 6" AGGREGATE BASE
- ③ ITEM 304 - 8" AGGREGATE BASE
- ④ ITEM 452 - 8" NON-REINFORCED CONCRETE PAVEMENT

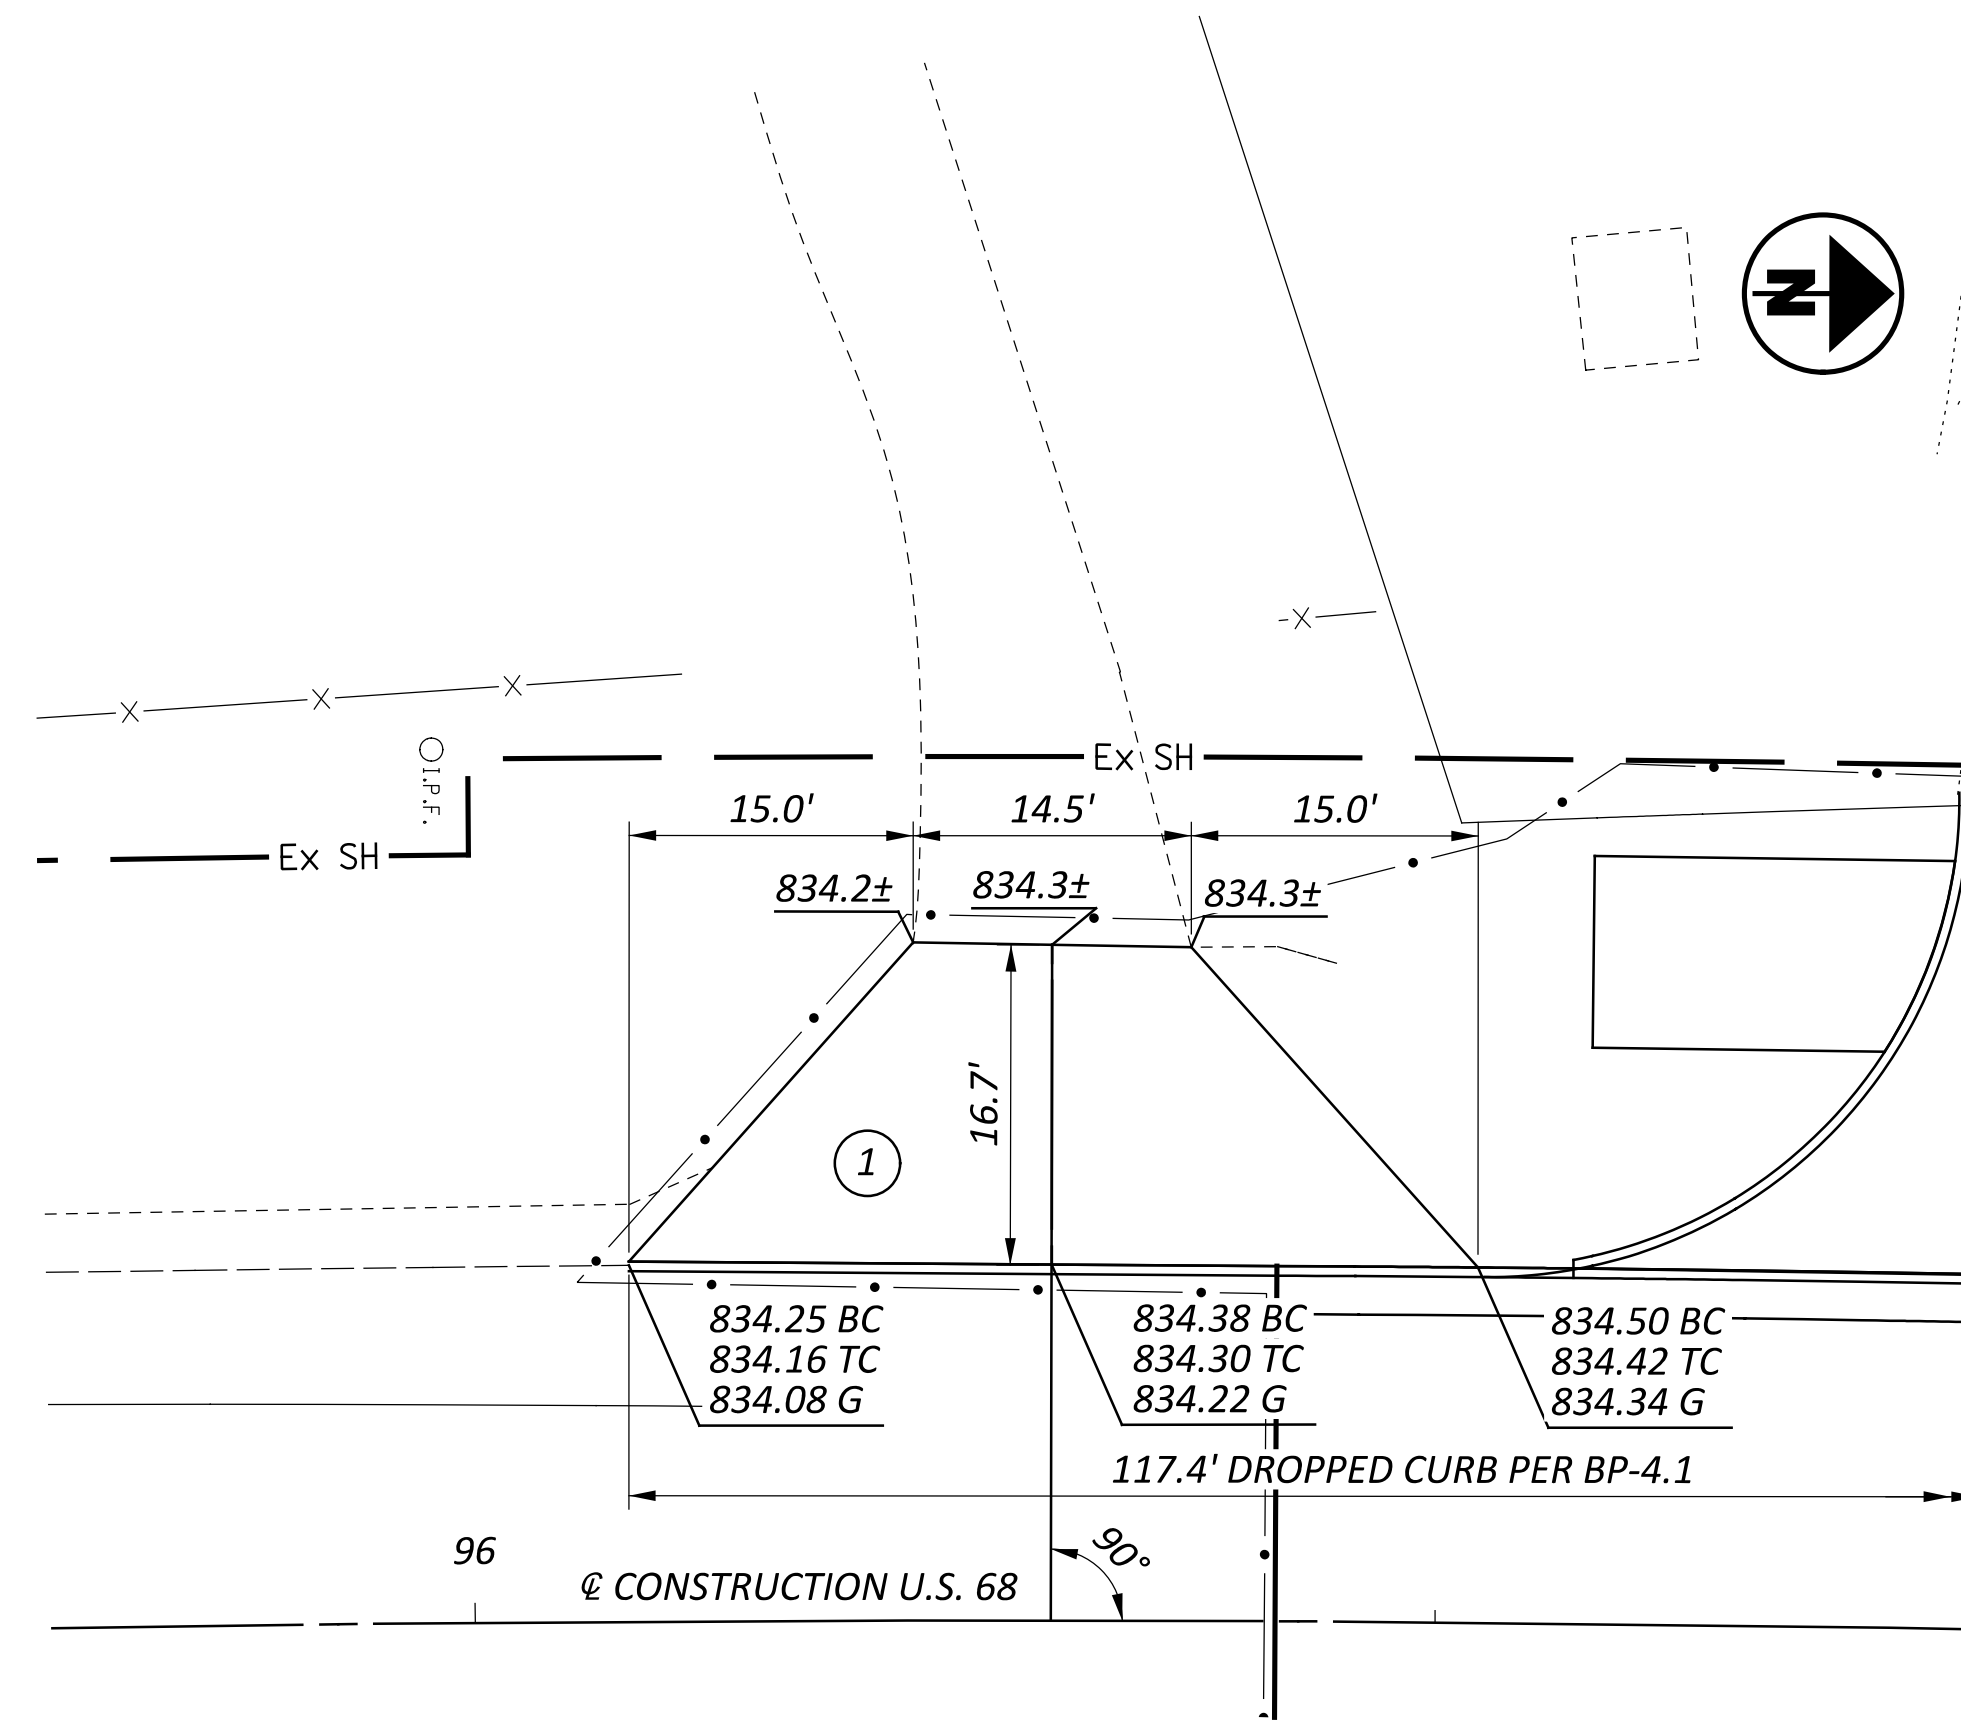

DRIVE STA. 96+29.88

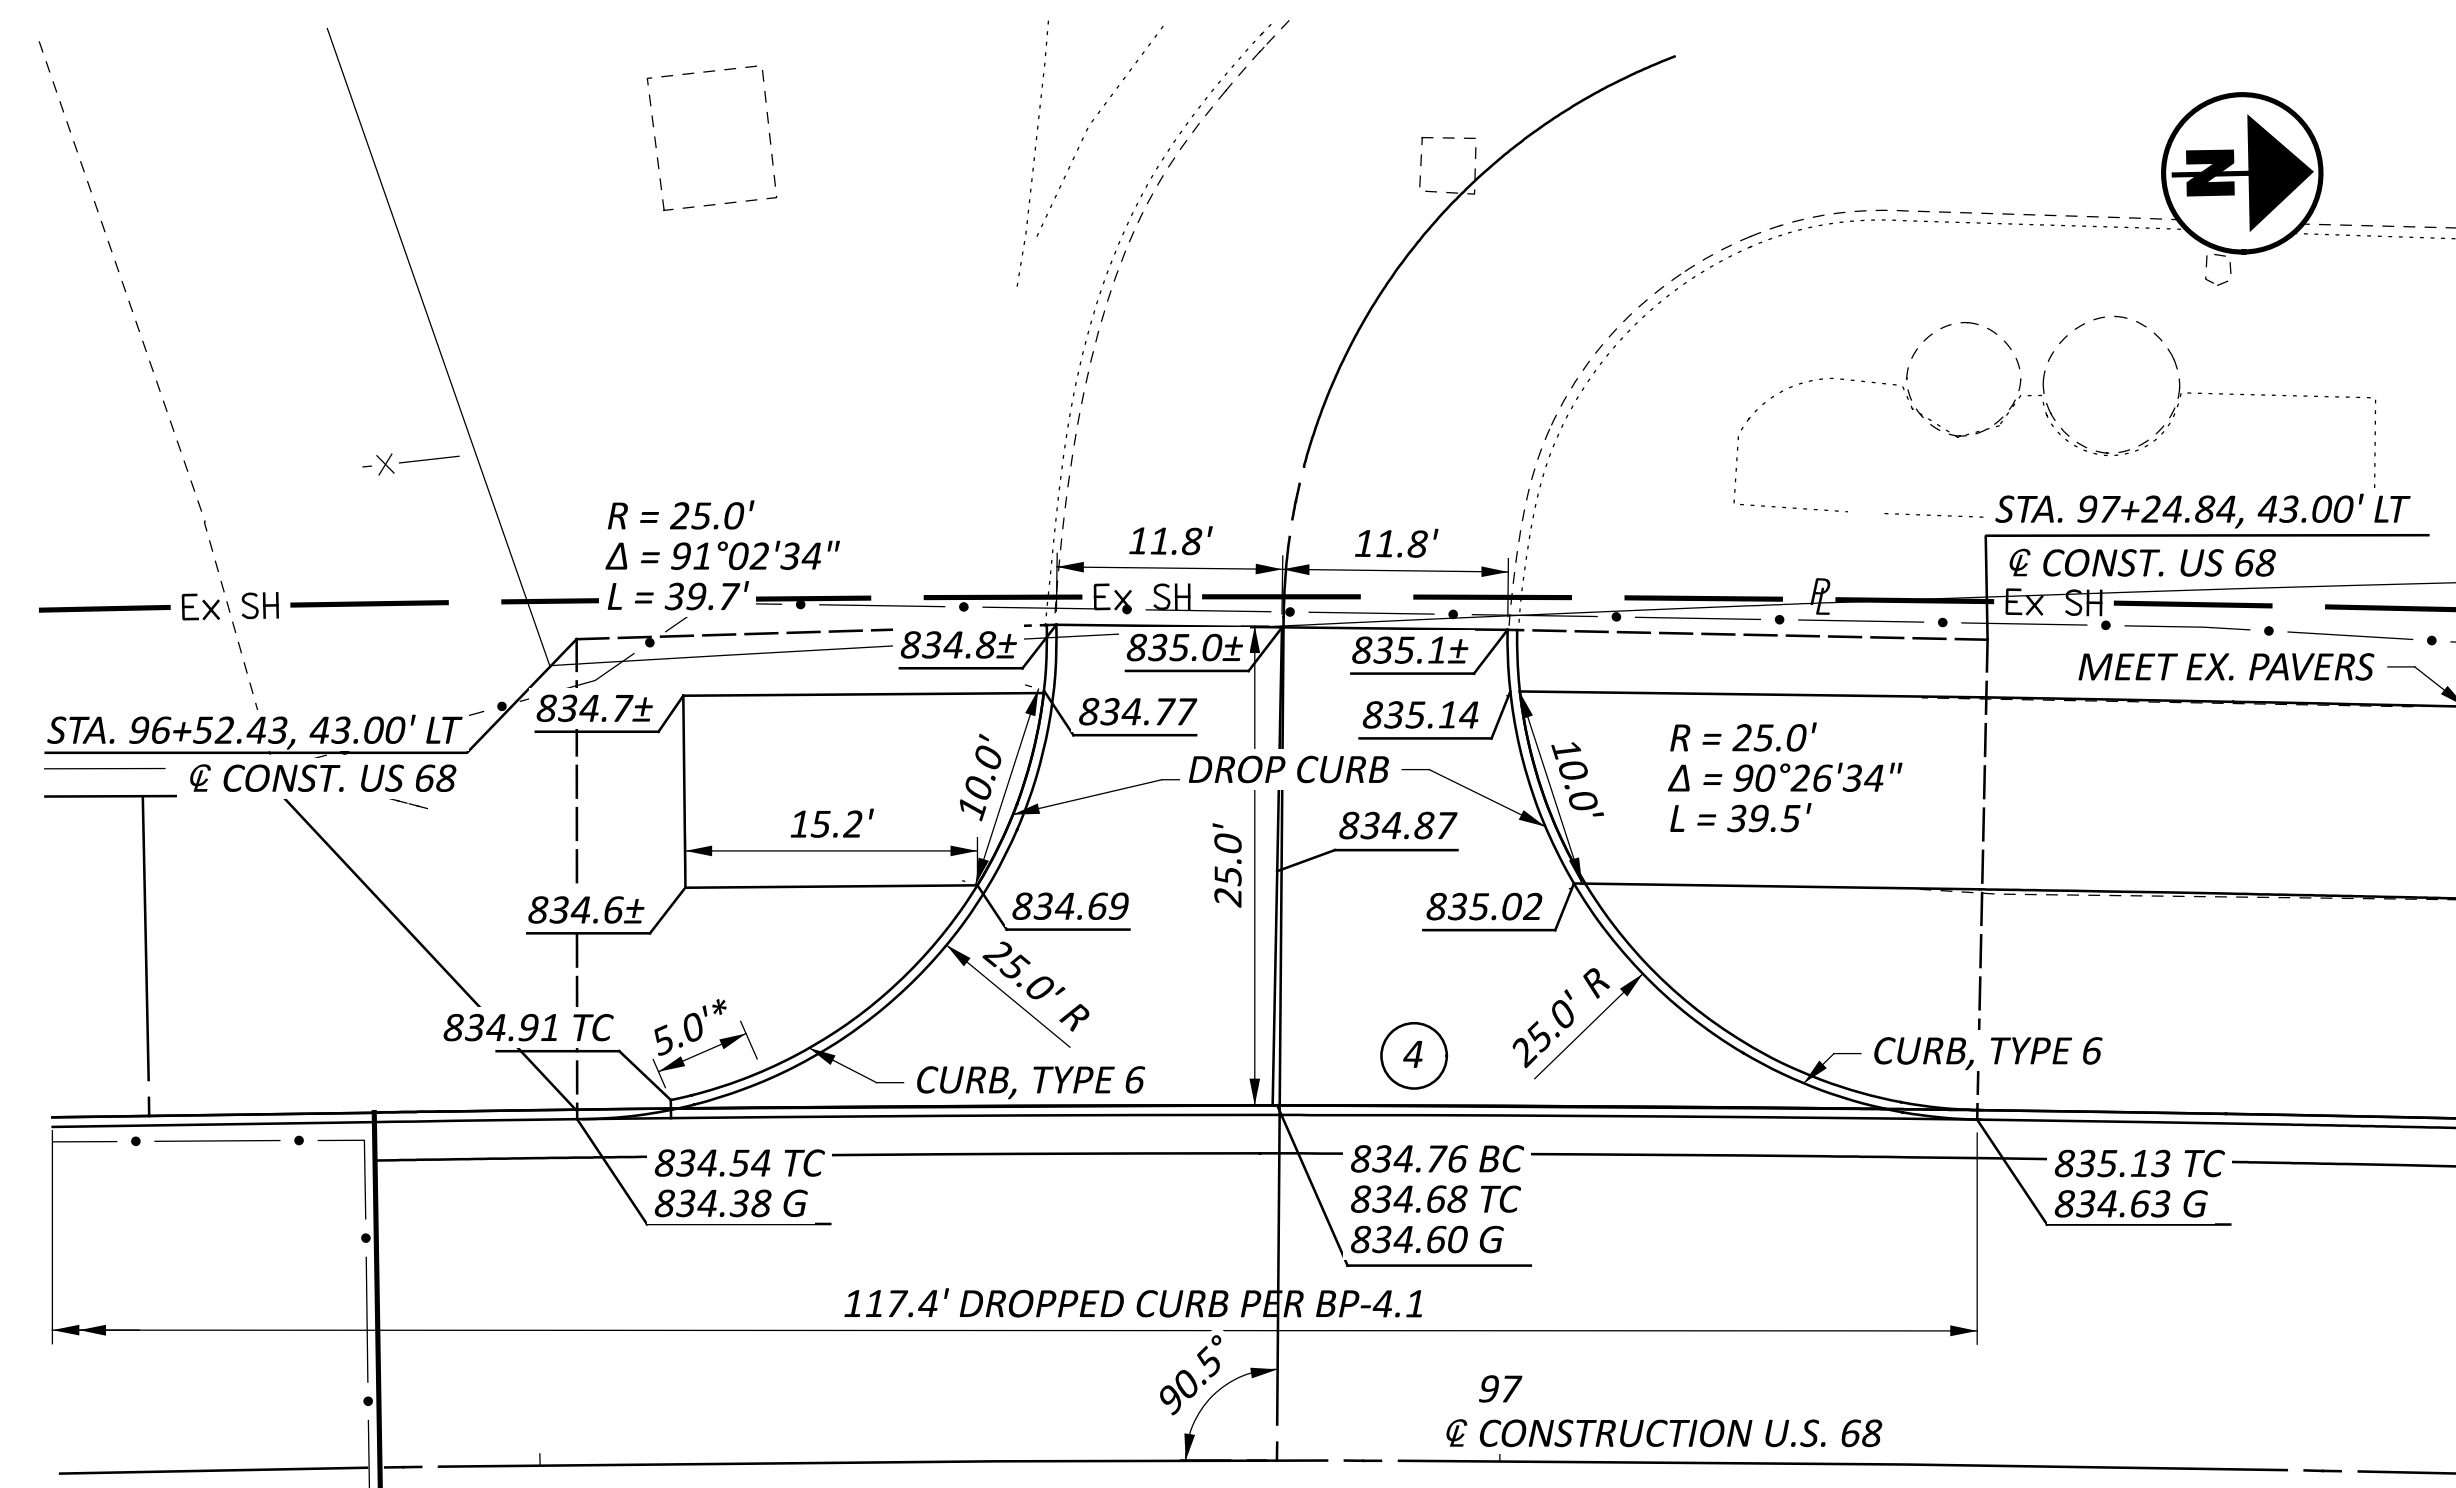

DRIVE STA. 96+88.39

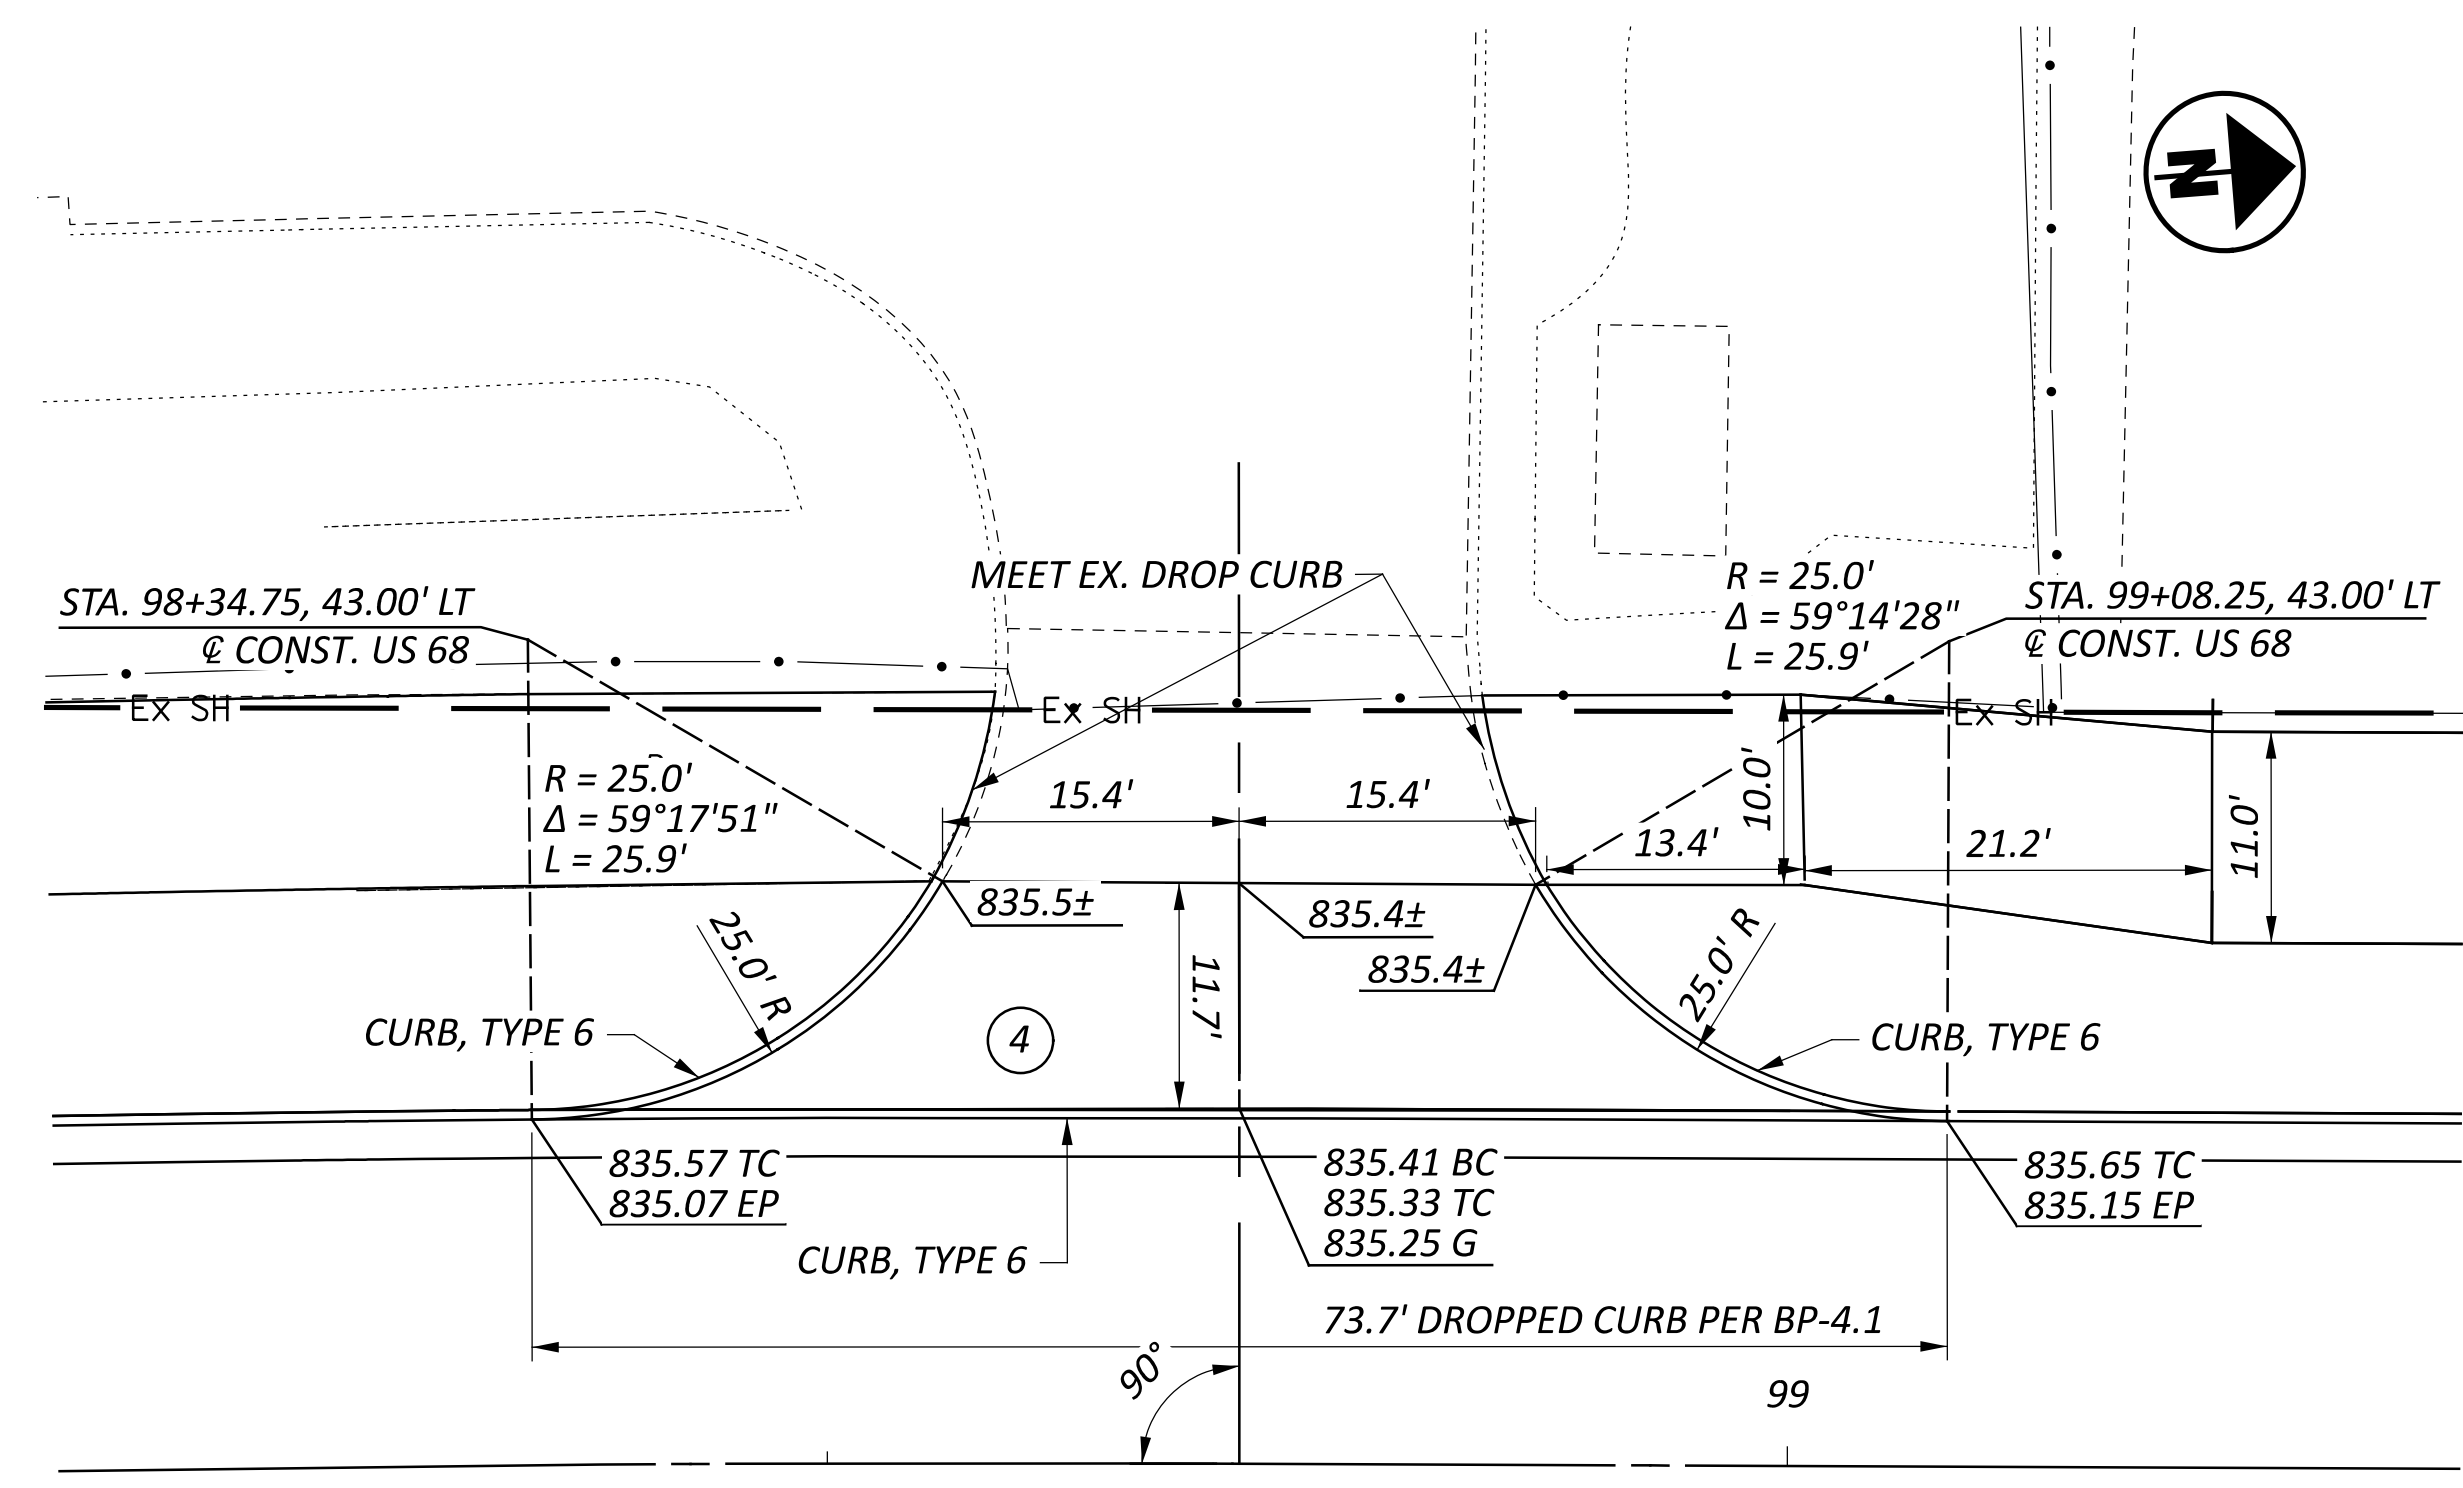


DRIVE STA. 98+71.46

DRIVEWAY DETAILS  
PLANS





GRE-68-12.65


MODEL: CLP\_US68 - Plan 1, PAPER SIZE: 34x42 (in.) DATE: 3/31/2025 TIME: 4:28:12 PM USER: wshannon  
P:\DBP\LAG\0003\_GRE-68-12.65\115388\400-Engineering\Roadway\Sheets\115388\_GD001.dgn

DESIGN AGENCY

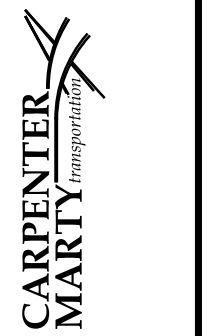


DESIGNER	WCS
REVIEWER	BAA
PROJECT ID	115388
SHEET TOTAL	P.36 P.107

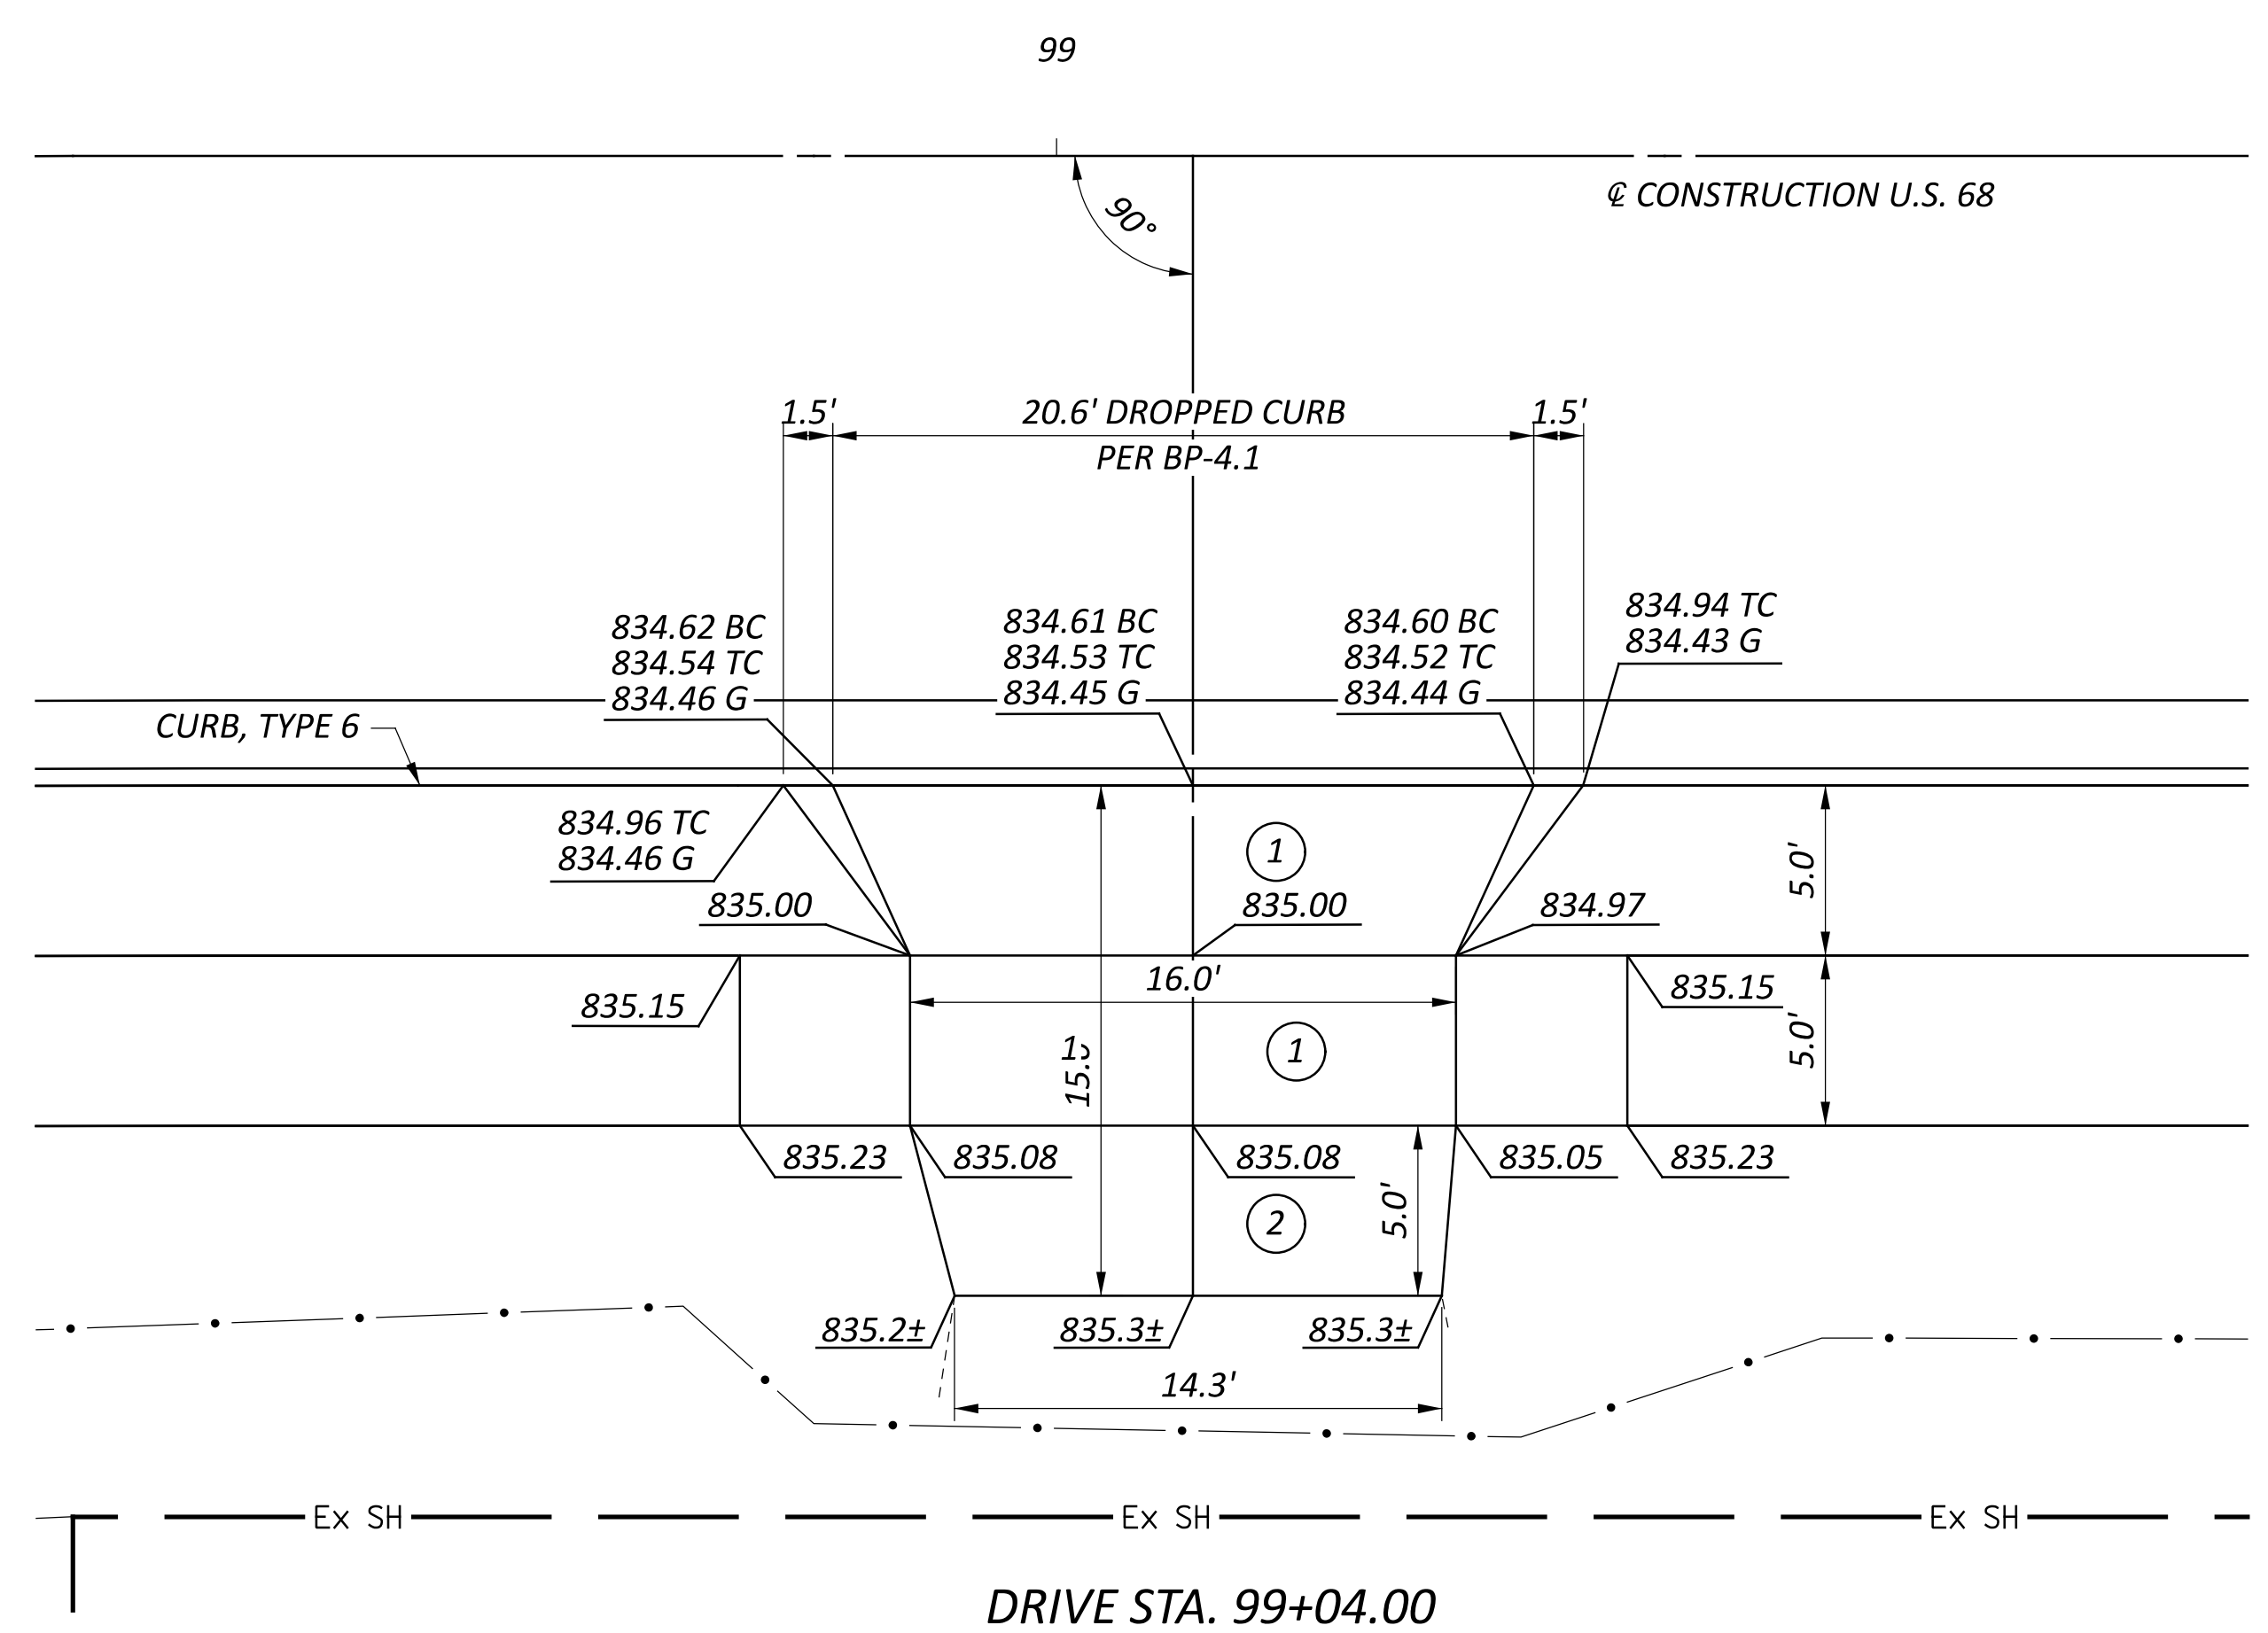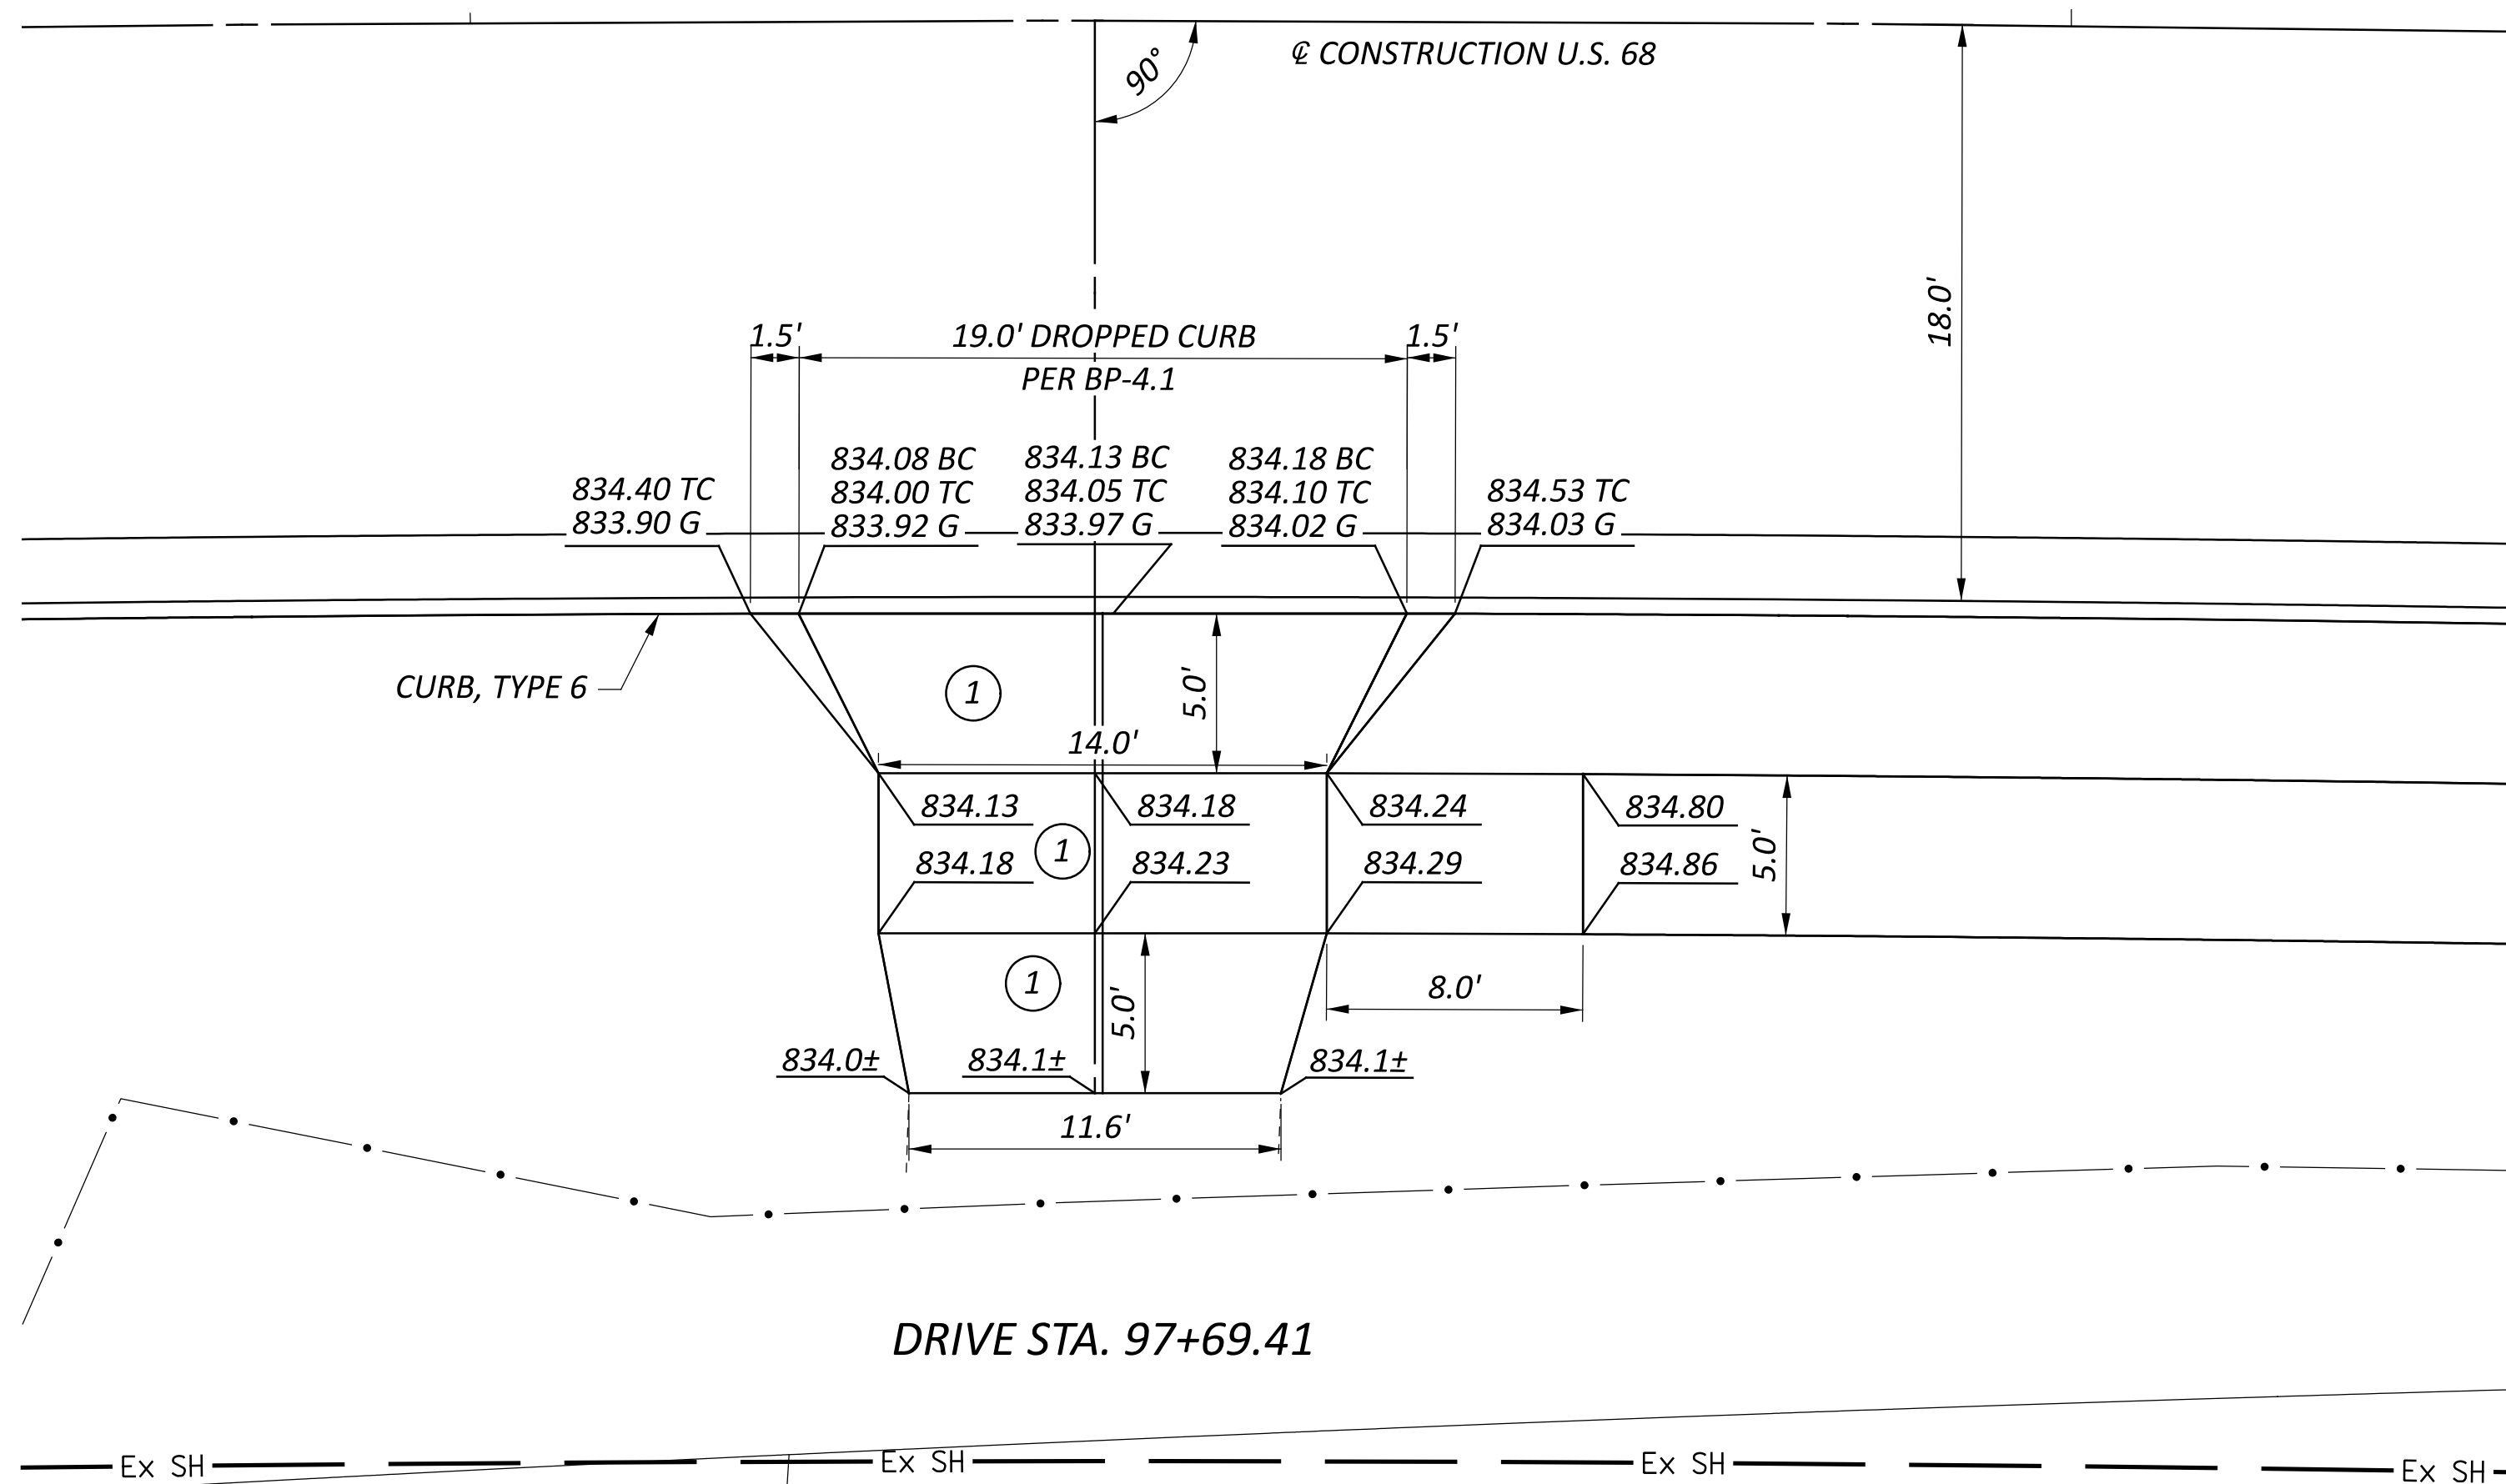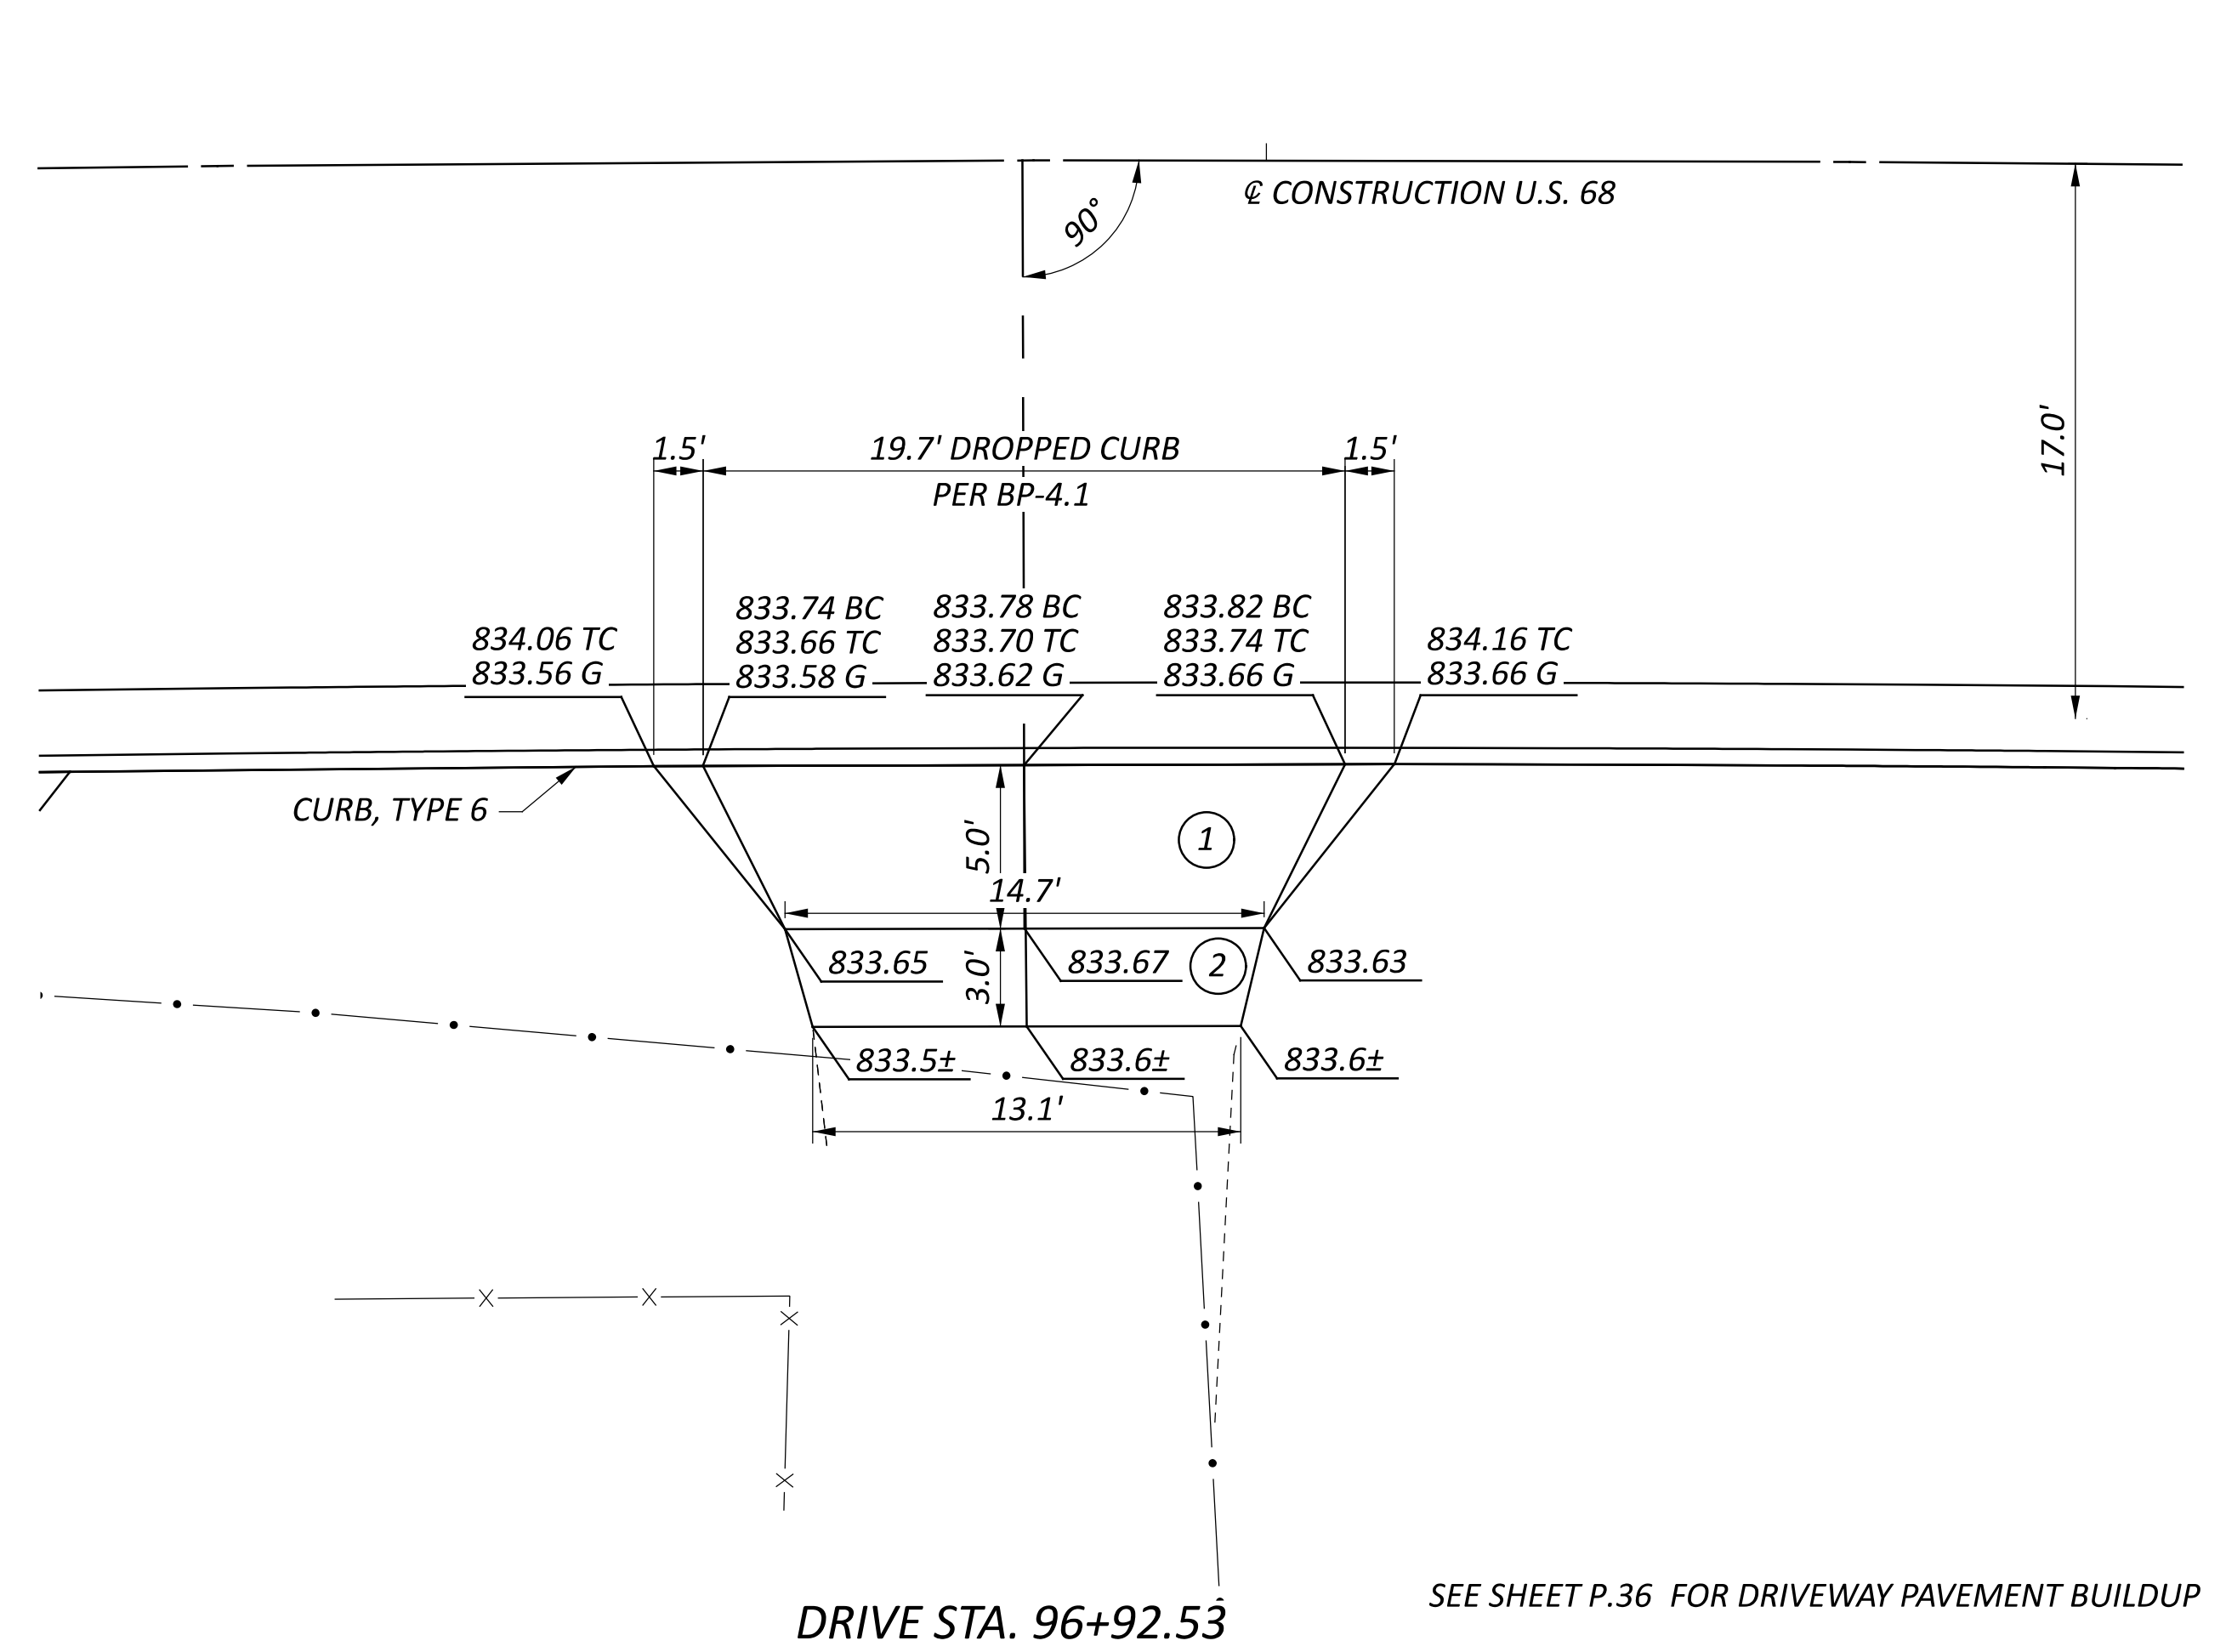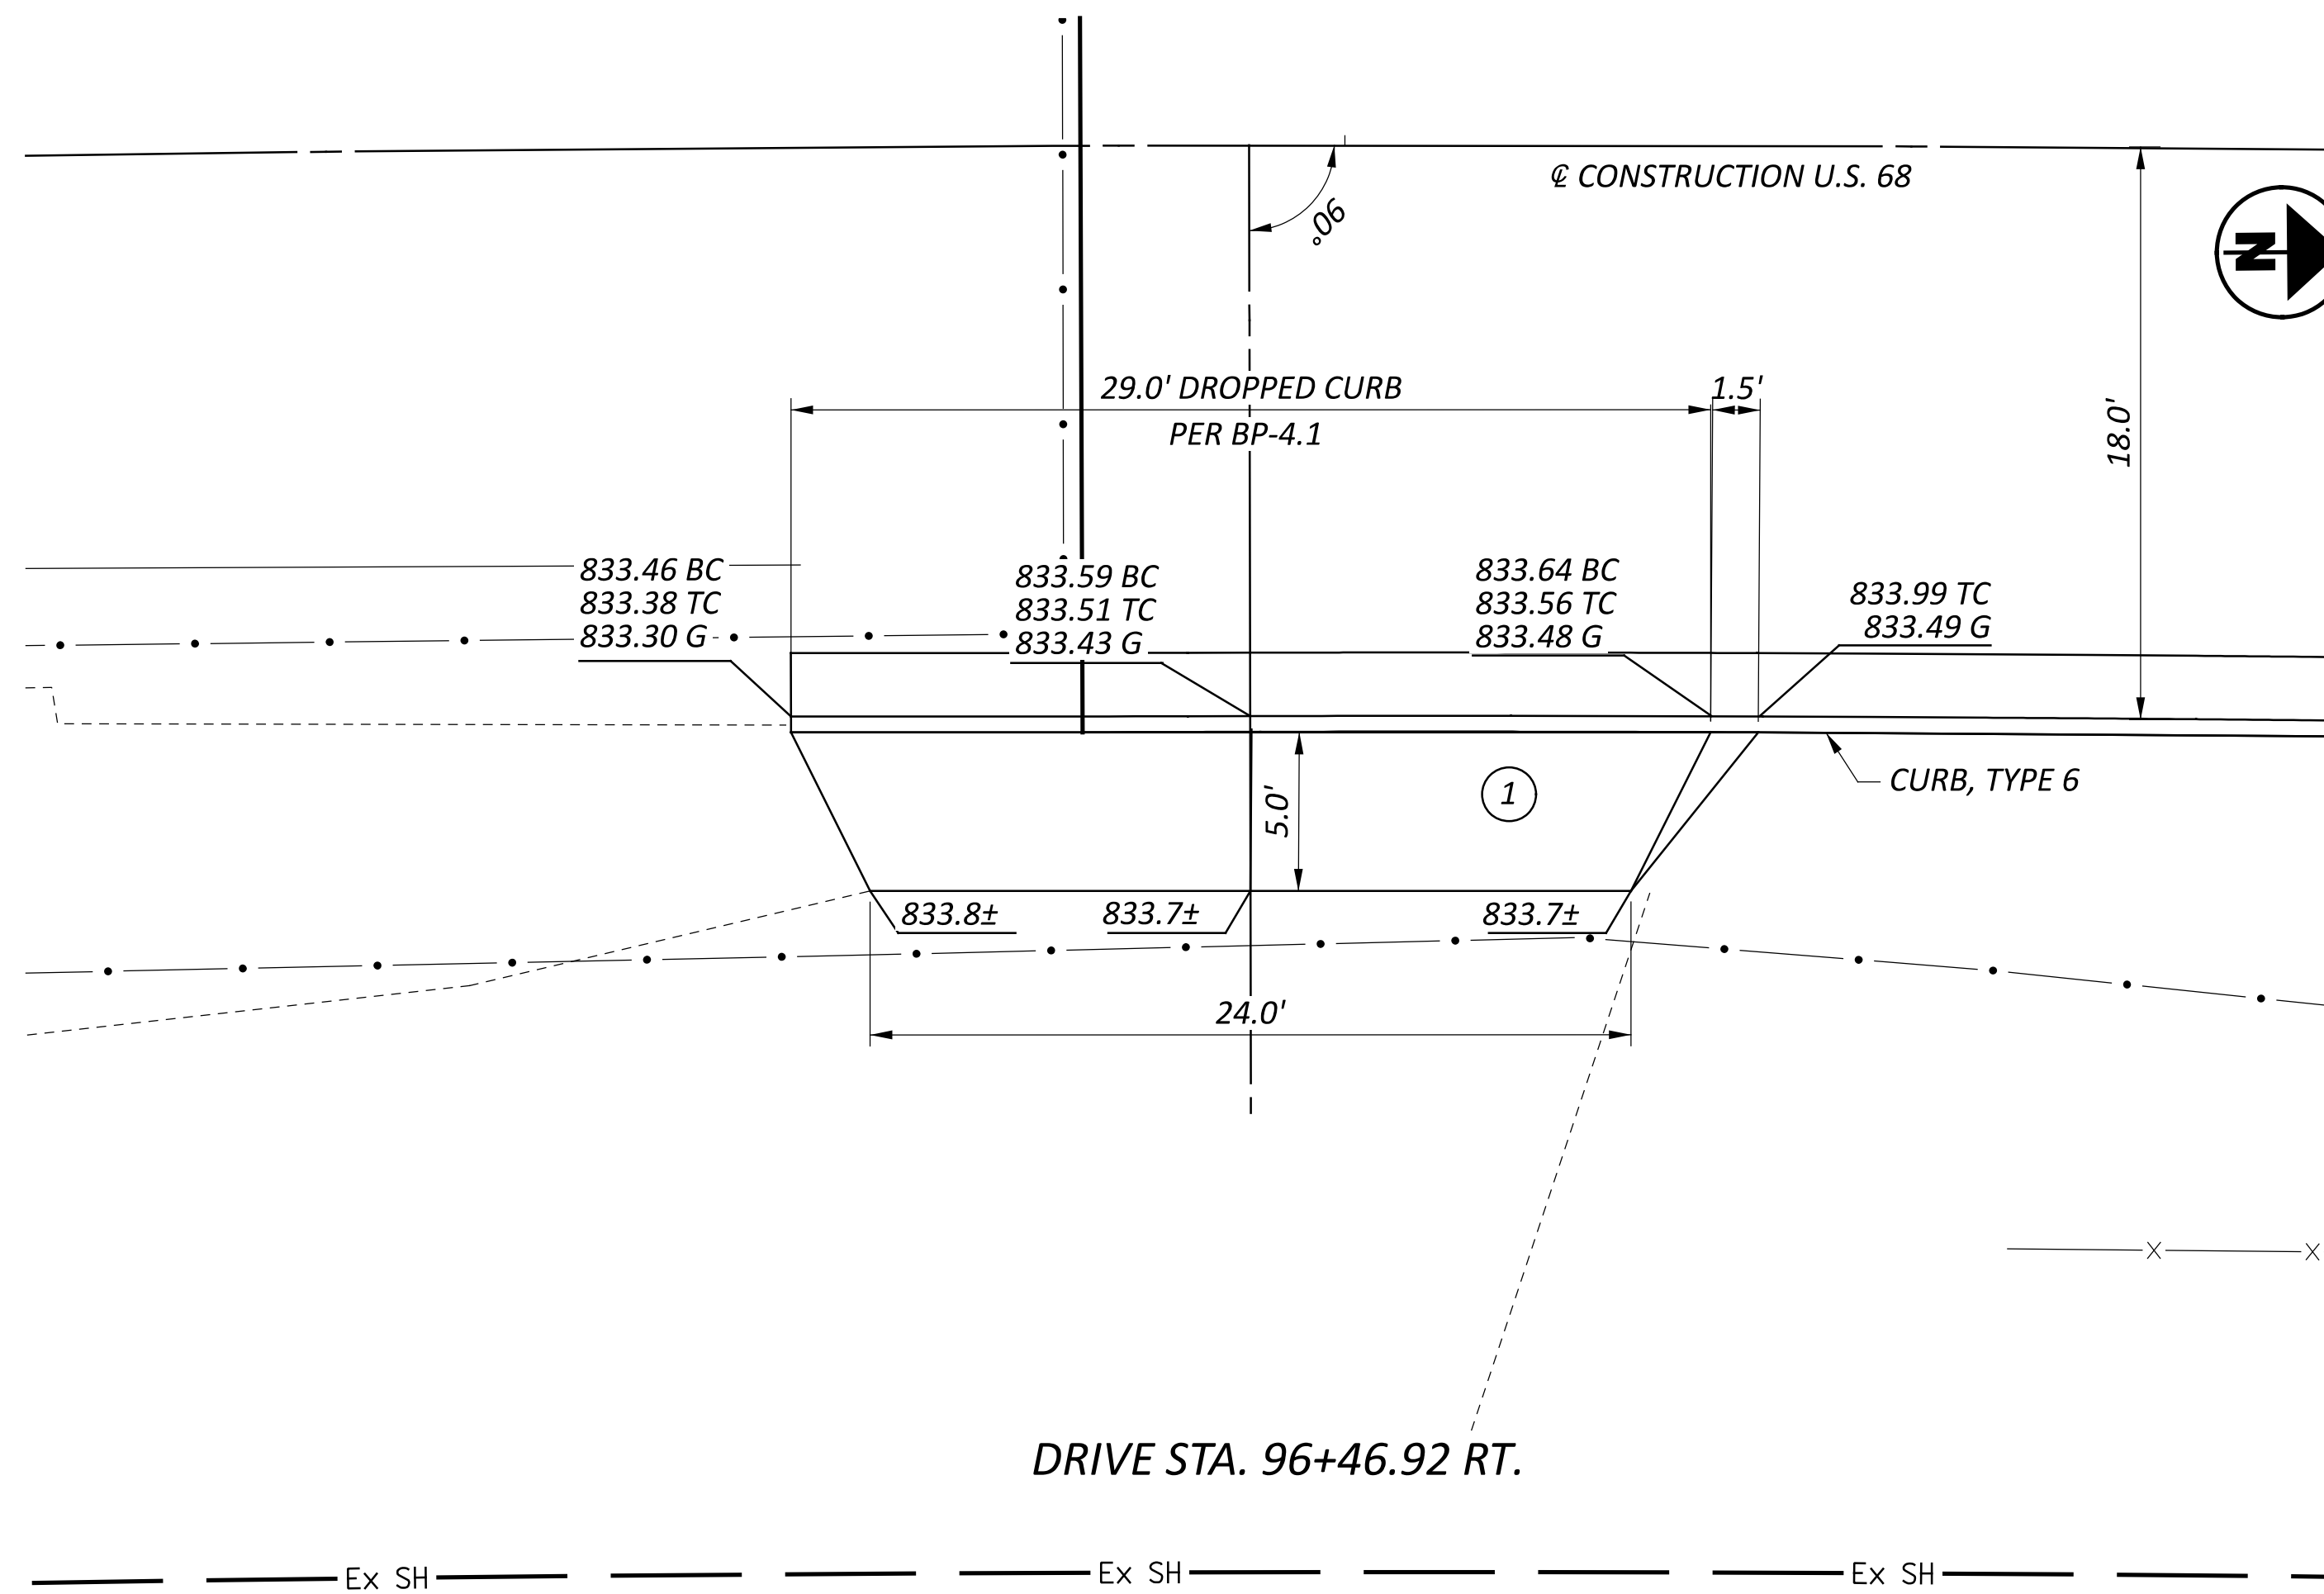


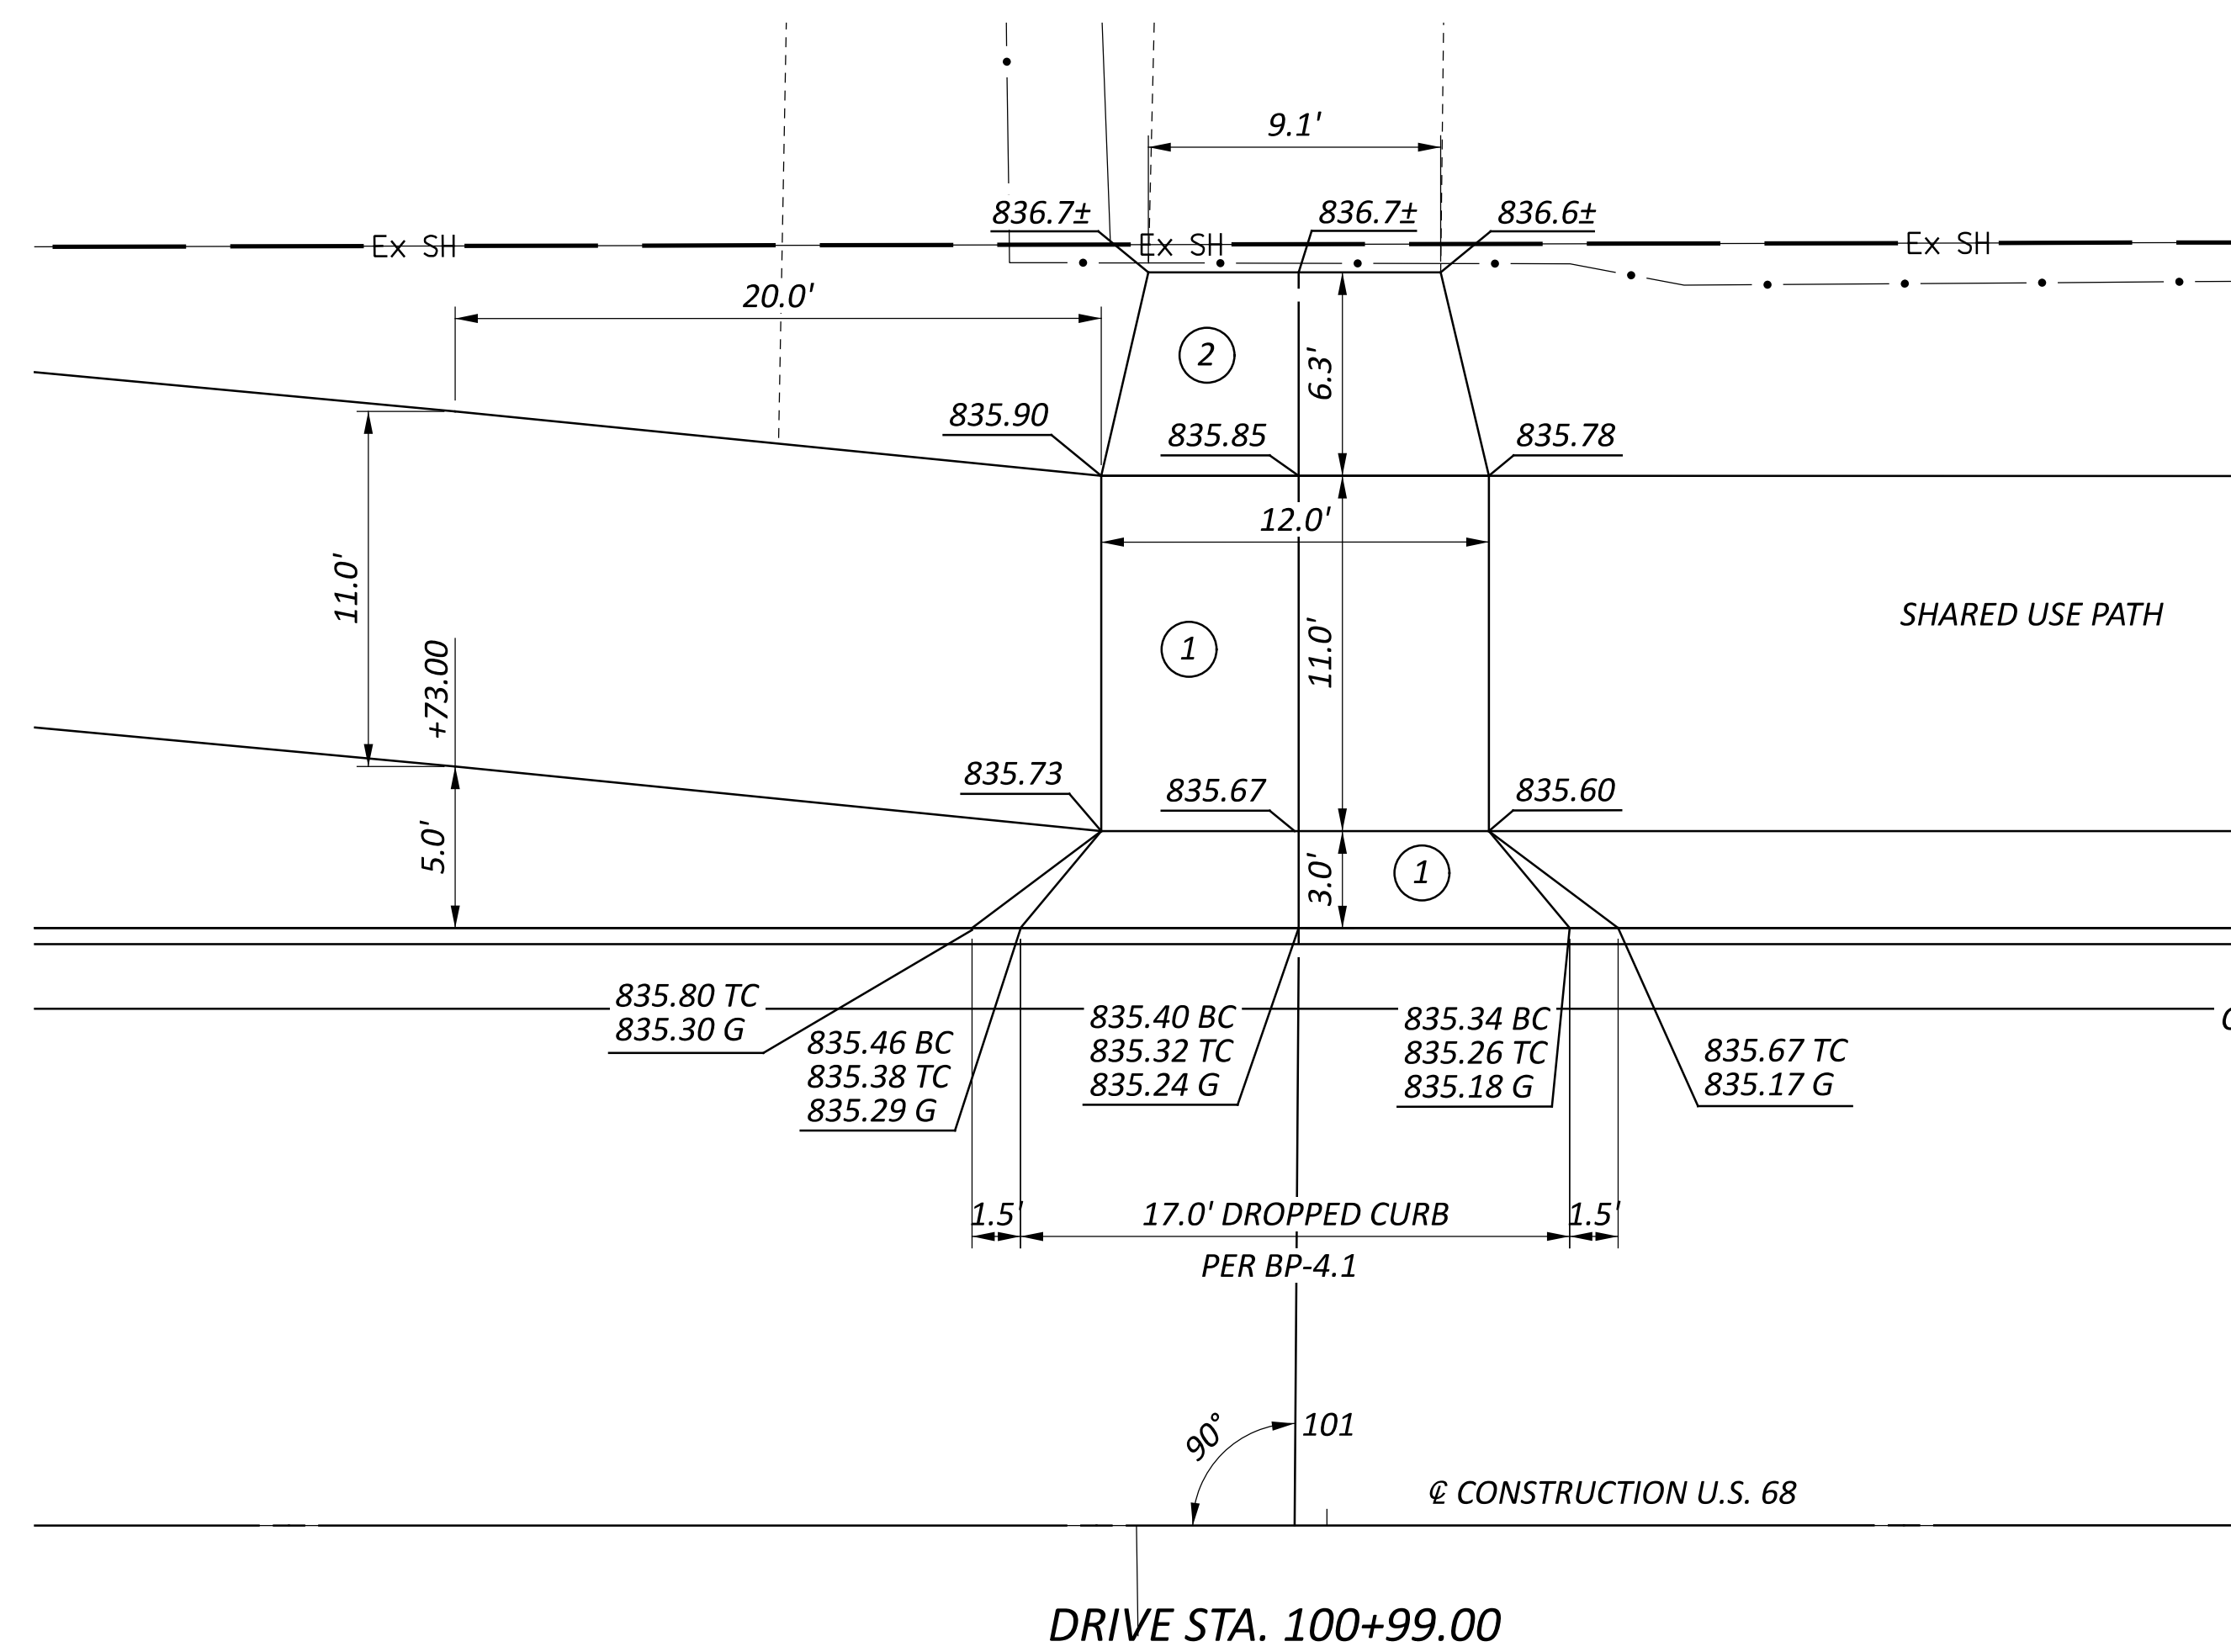


DRIVE STA. 100+99.00

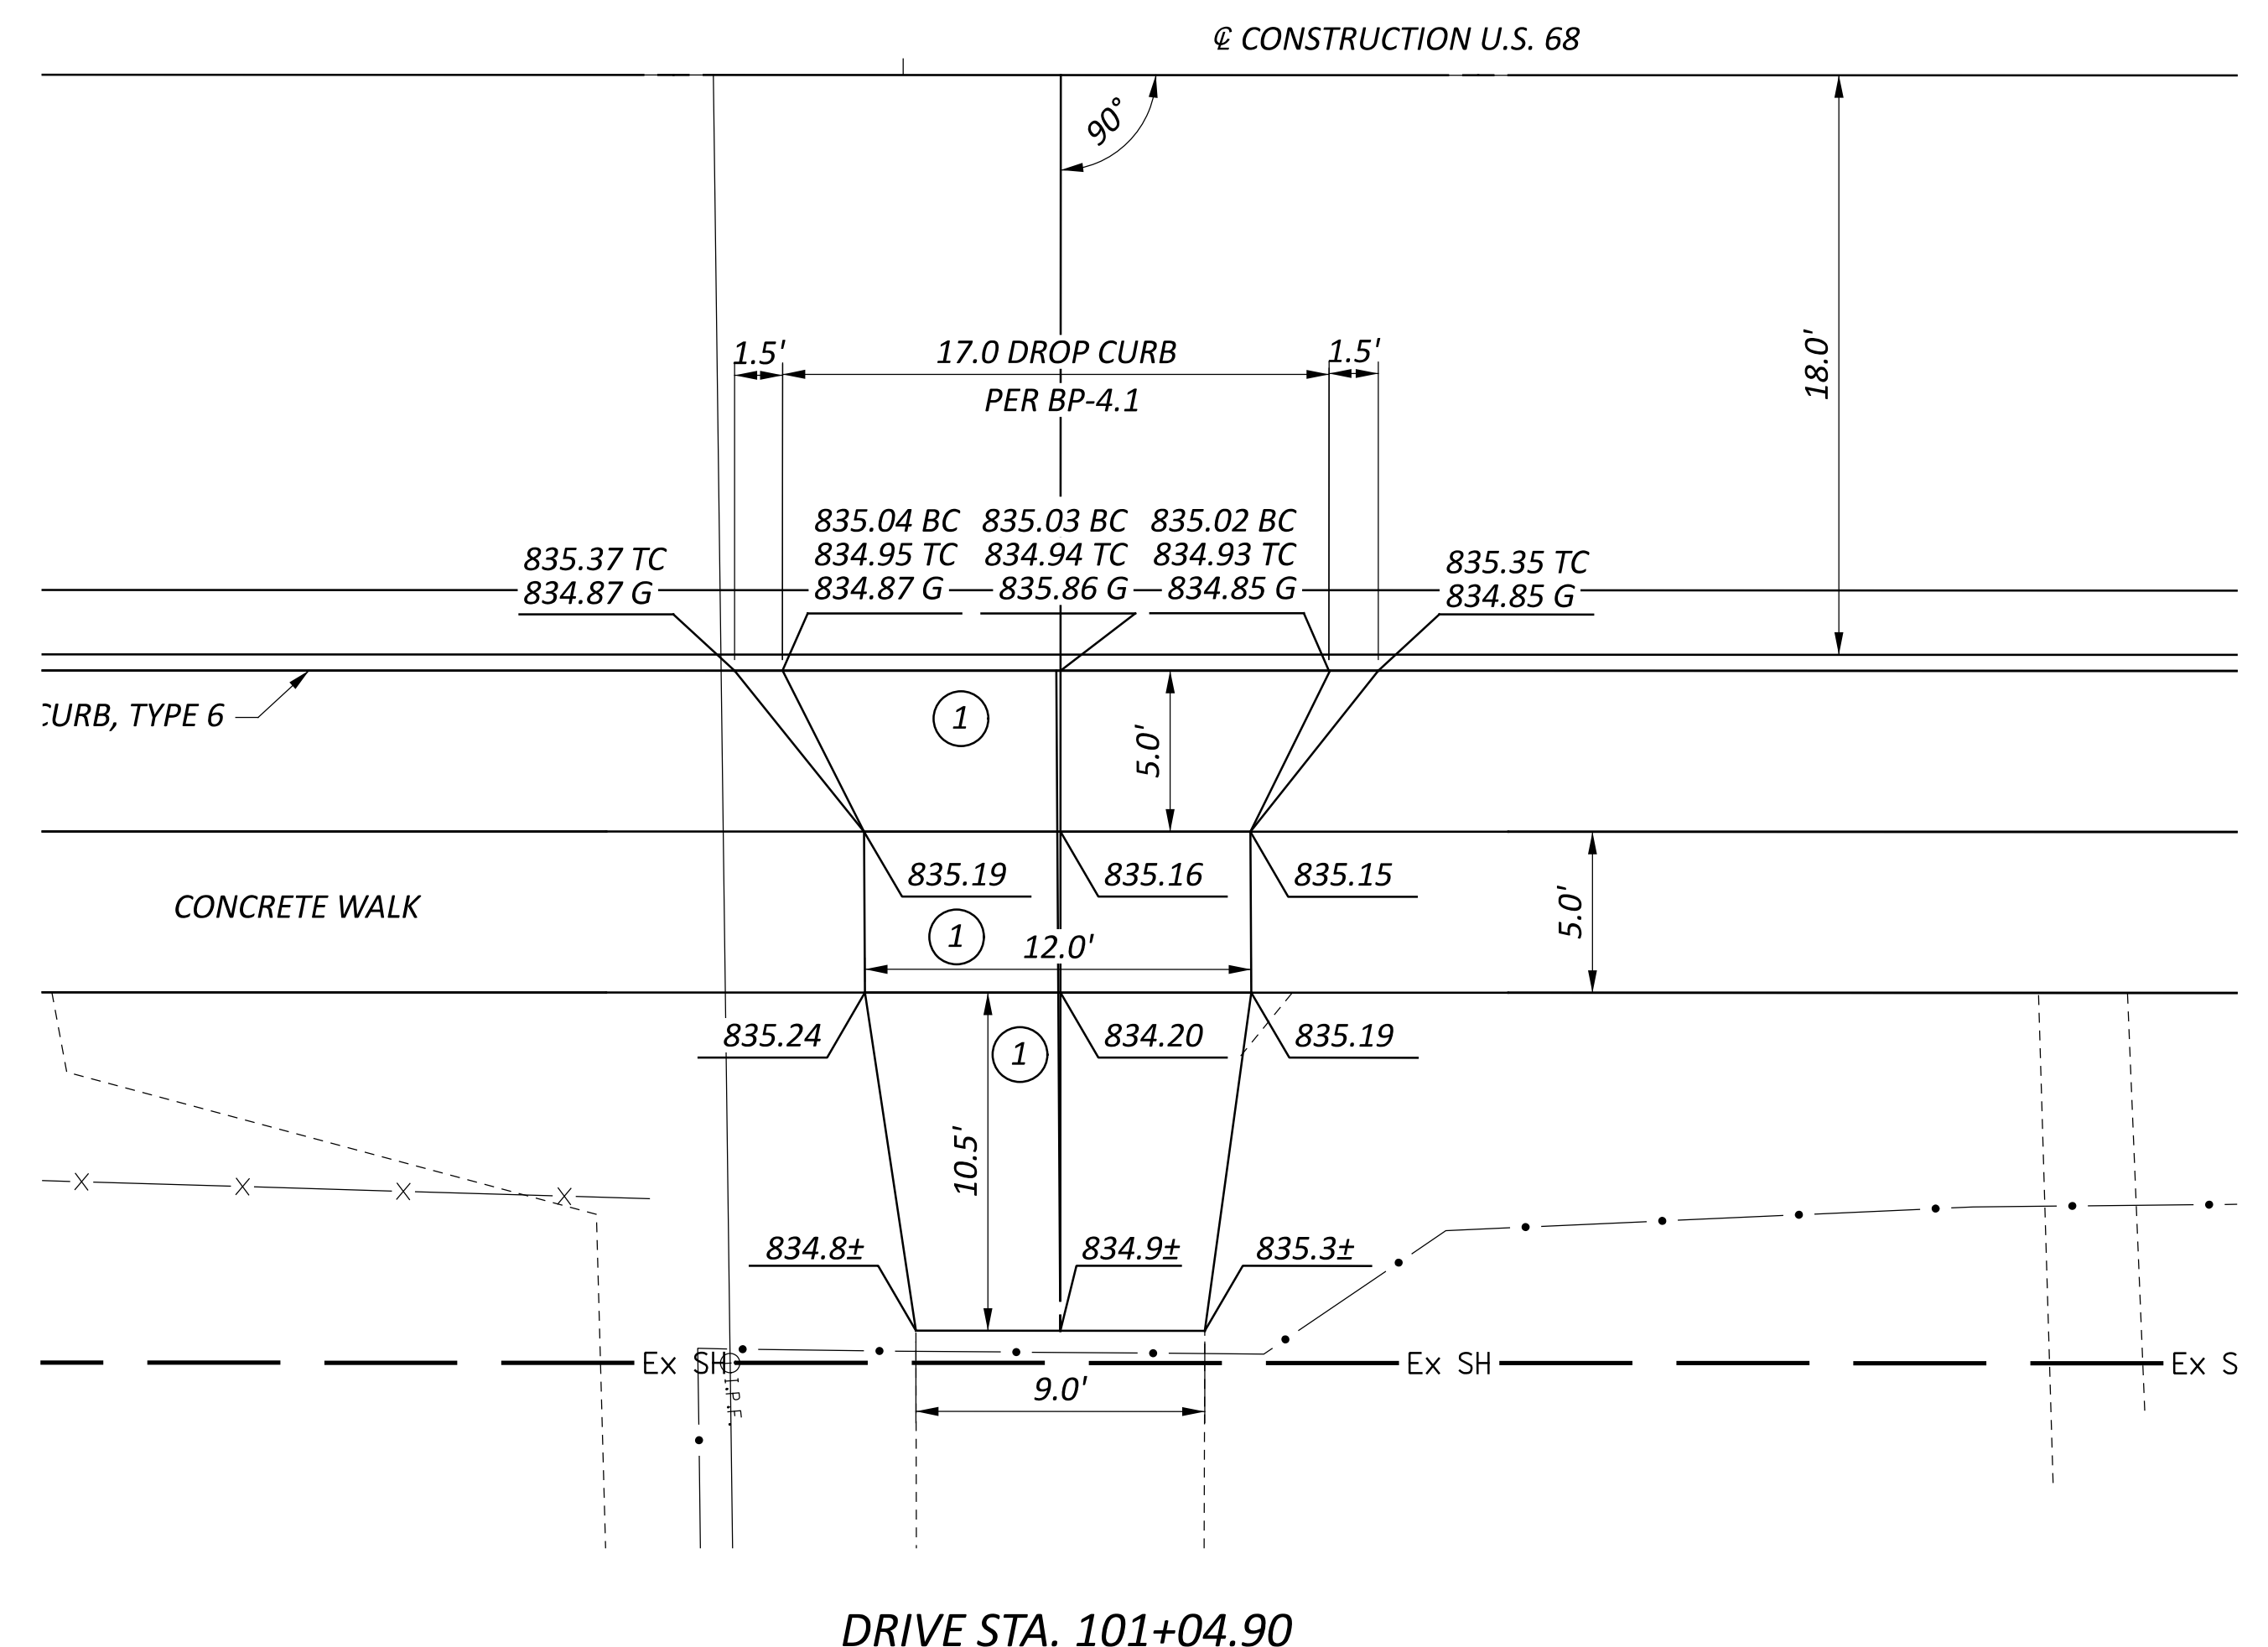

DRIVE STA. 101+04.90

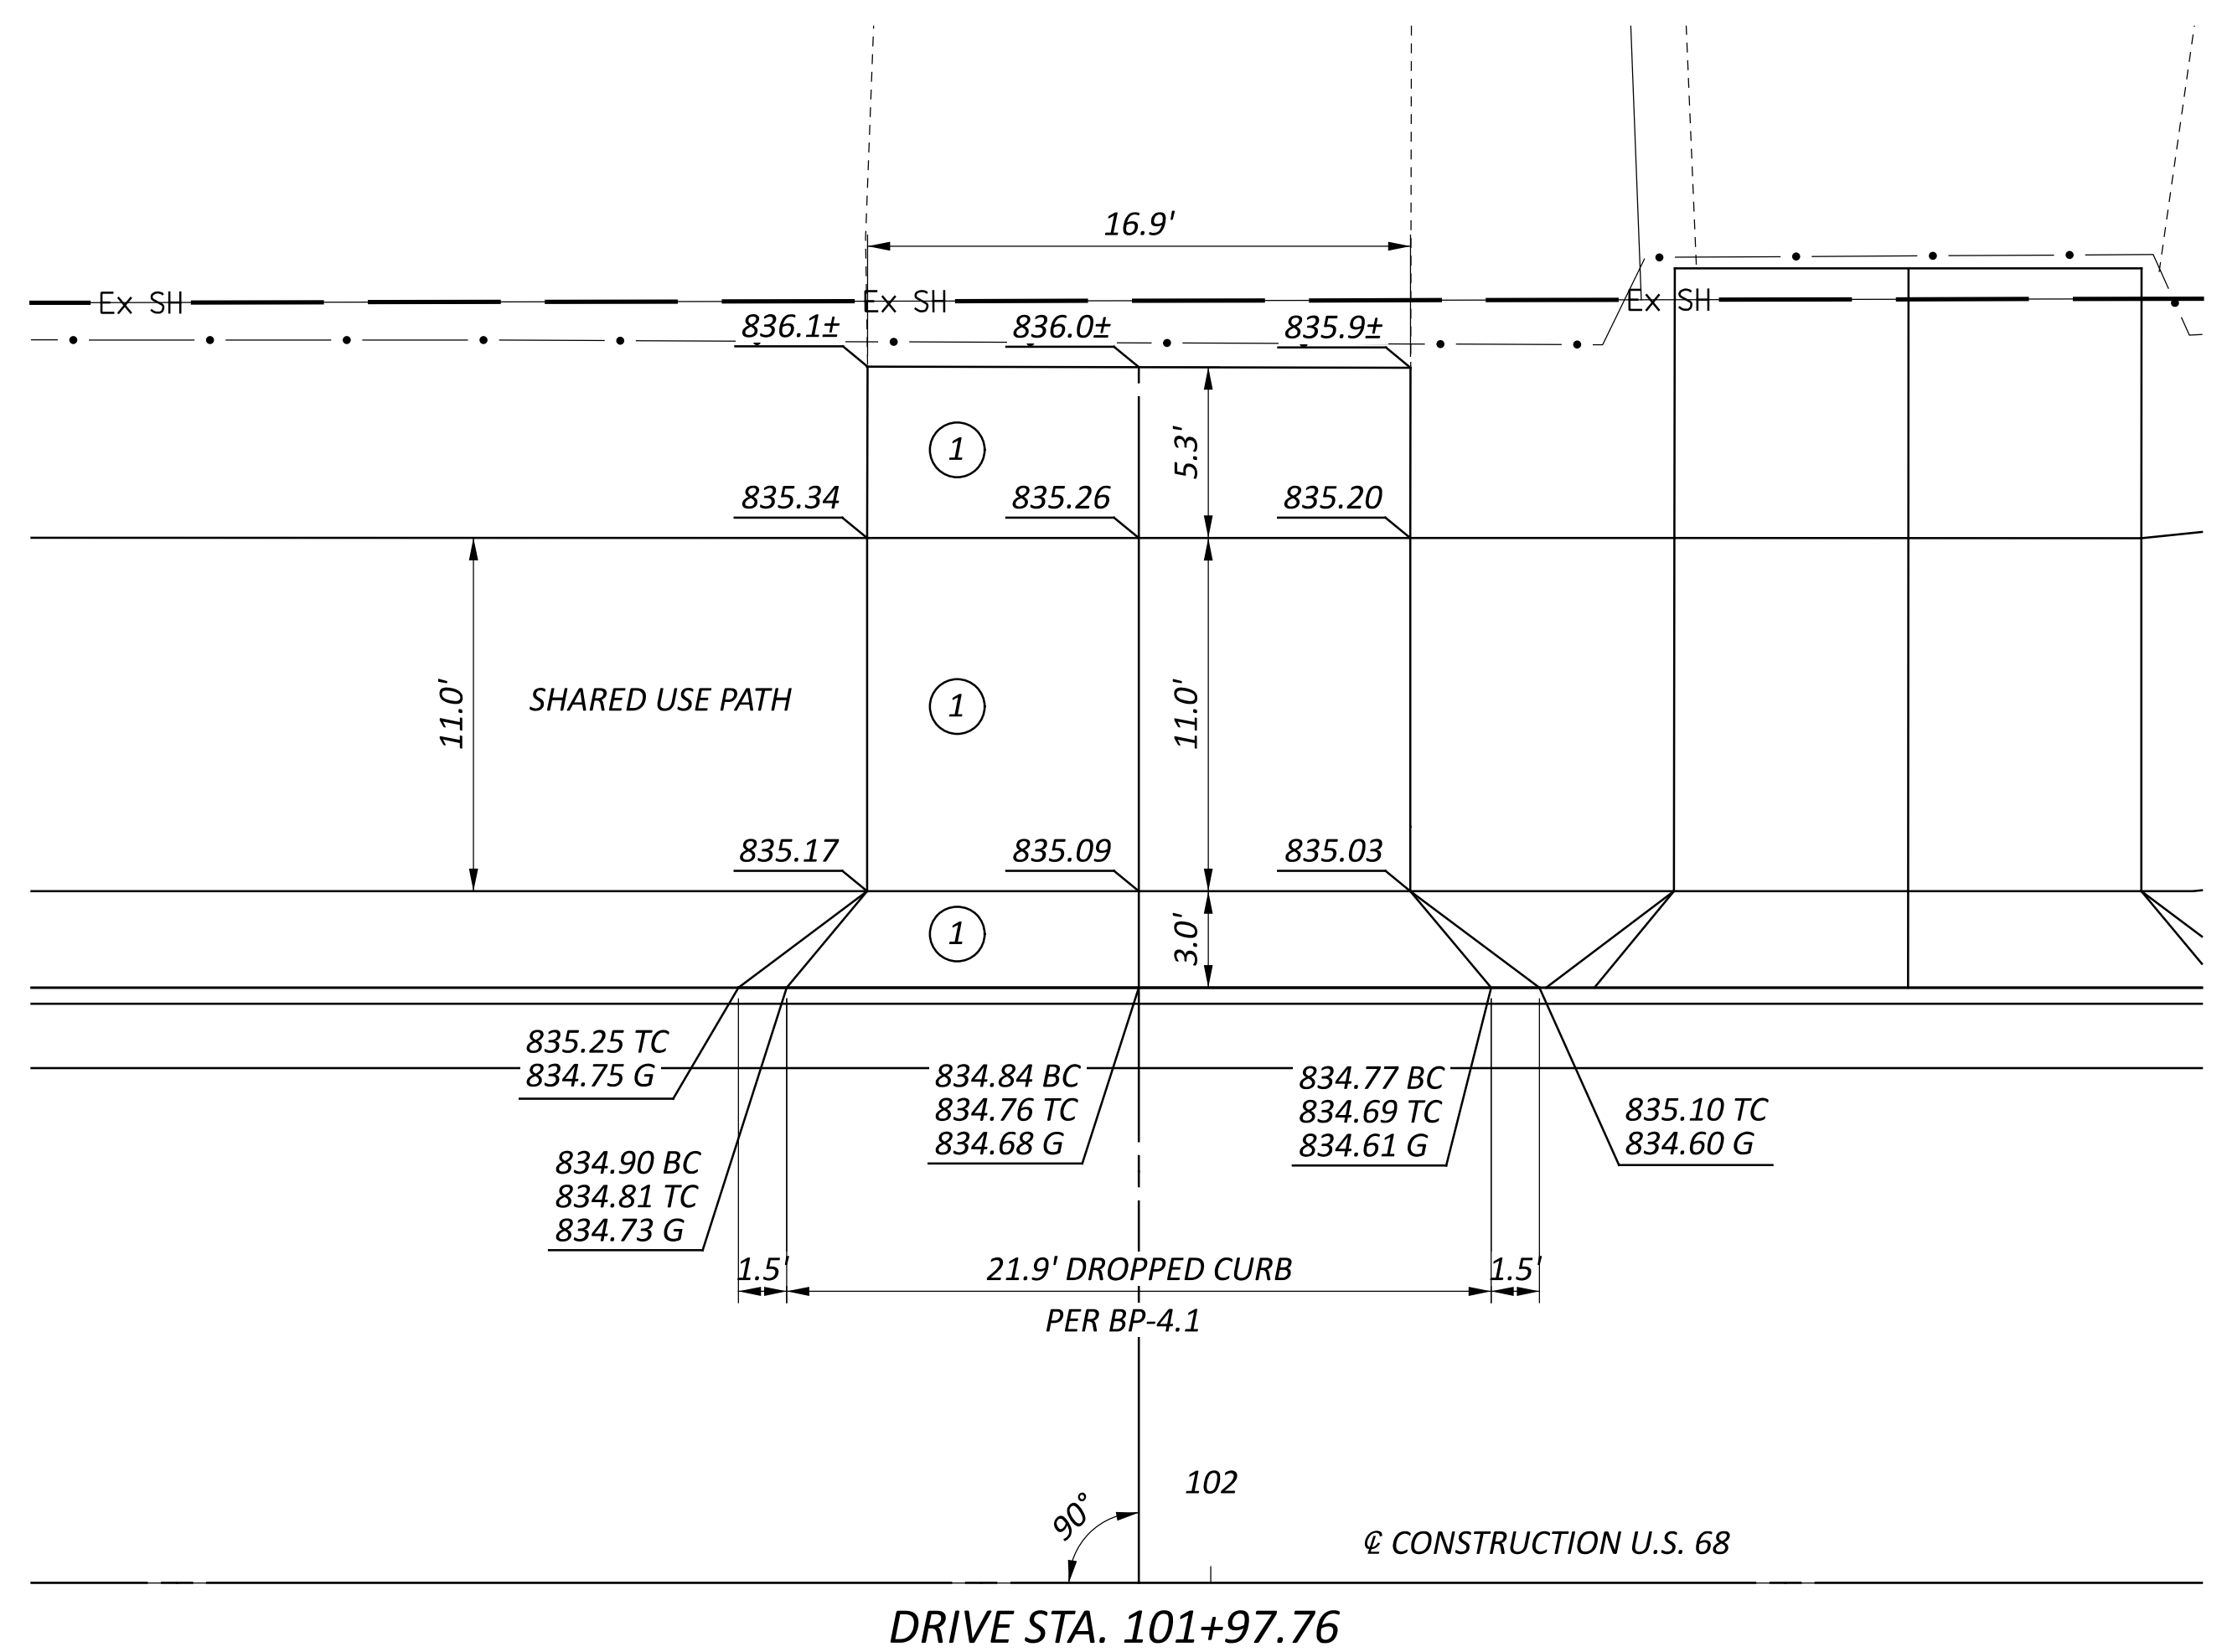

DRIVE STA. 101+97.76

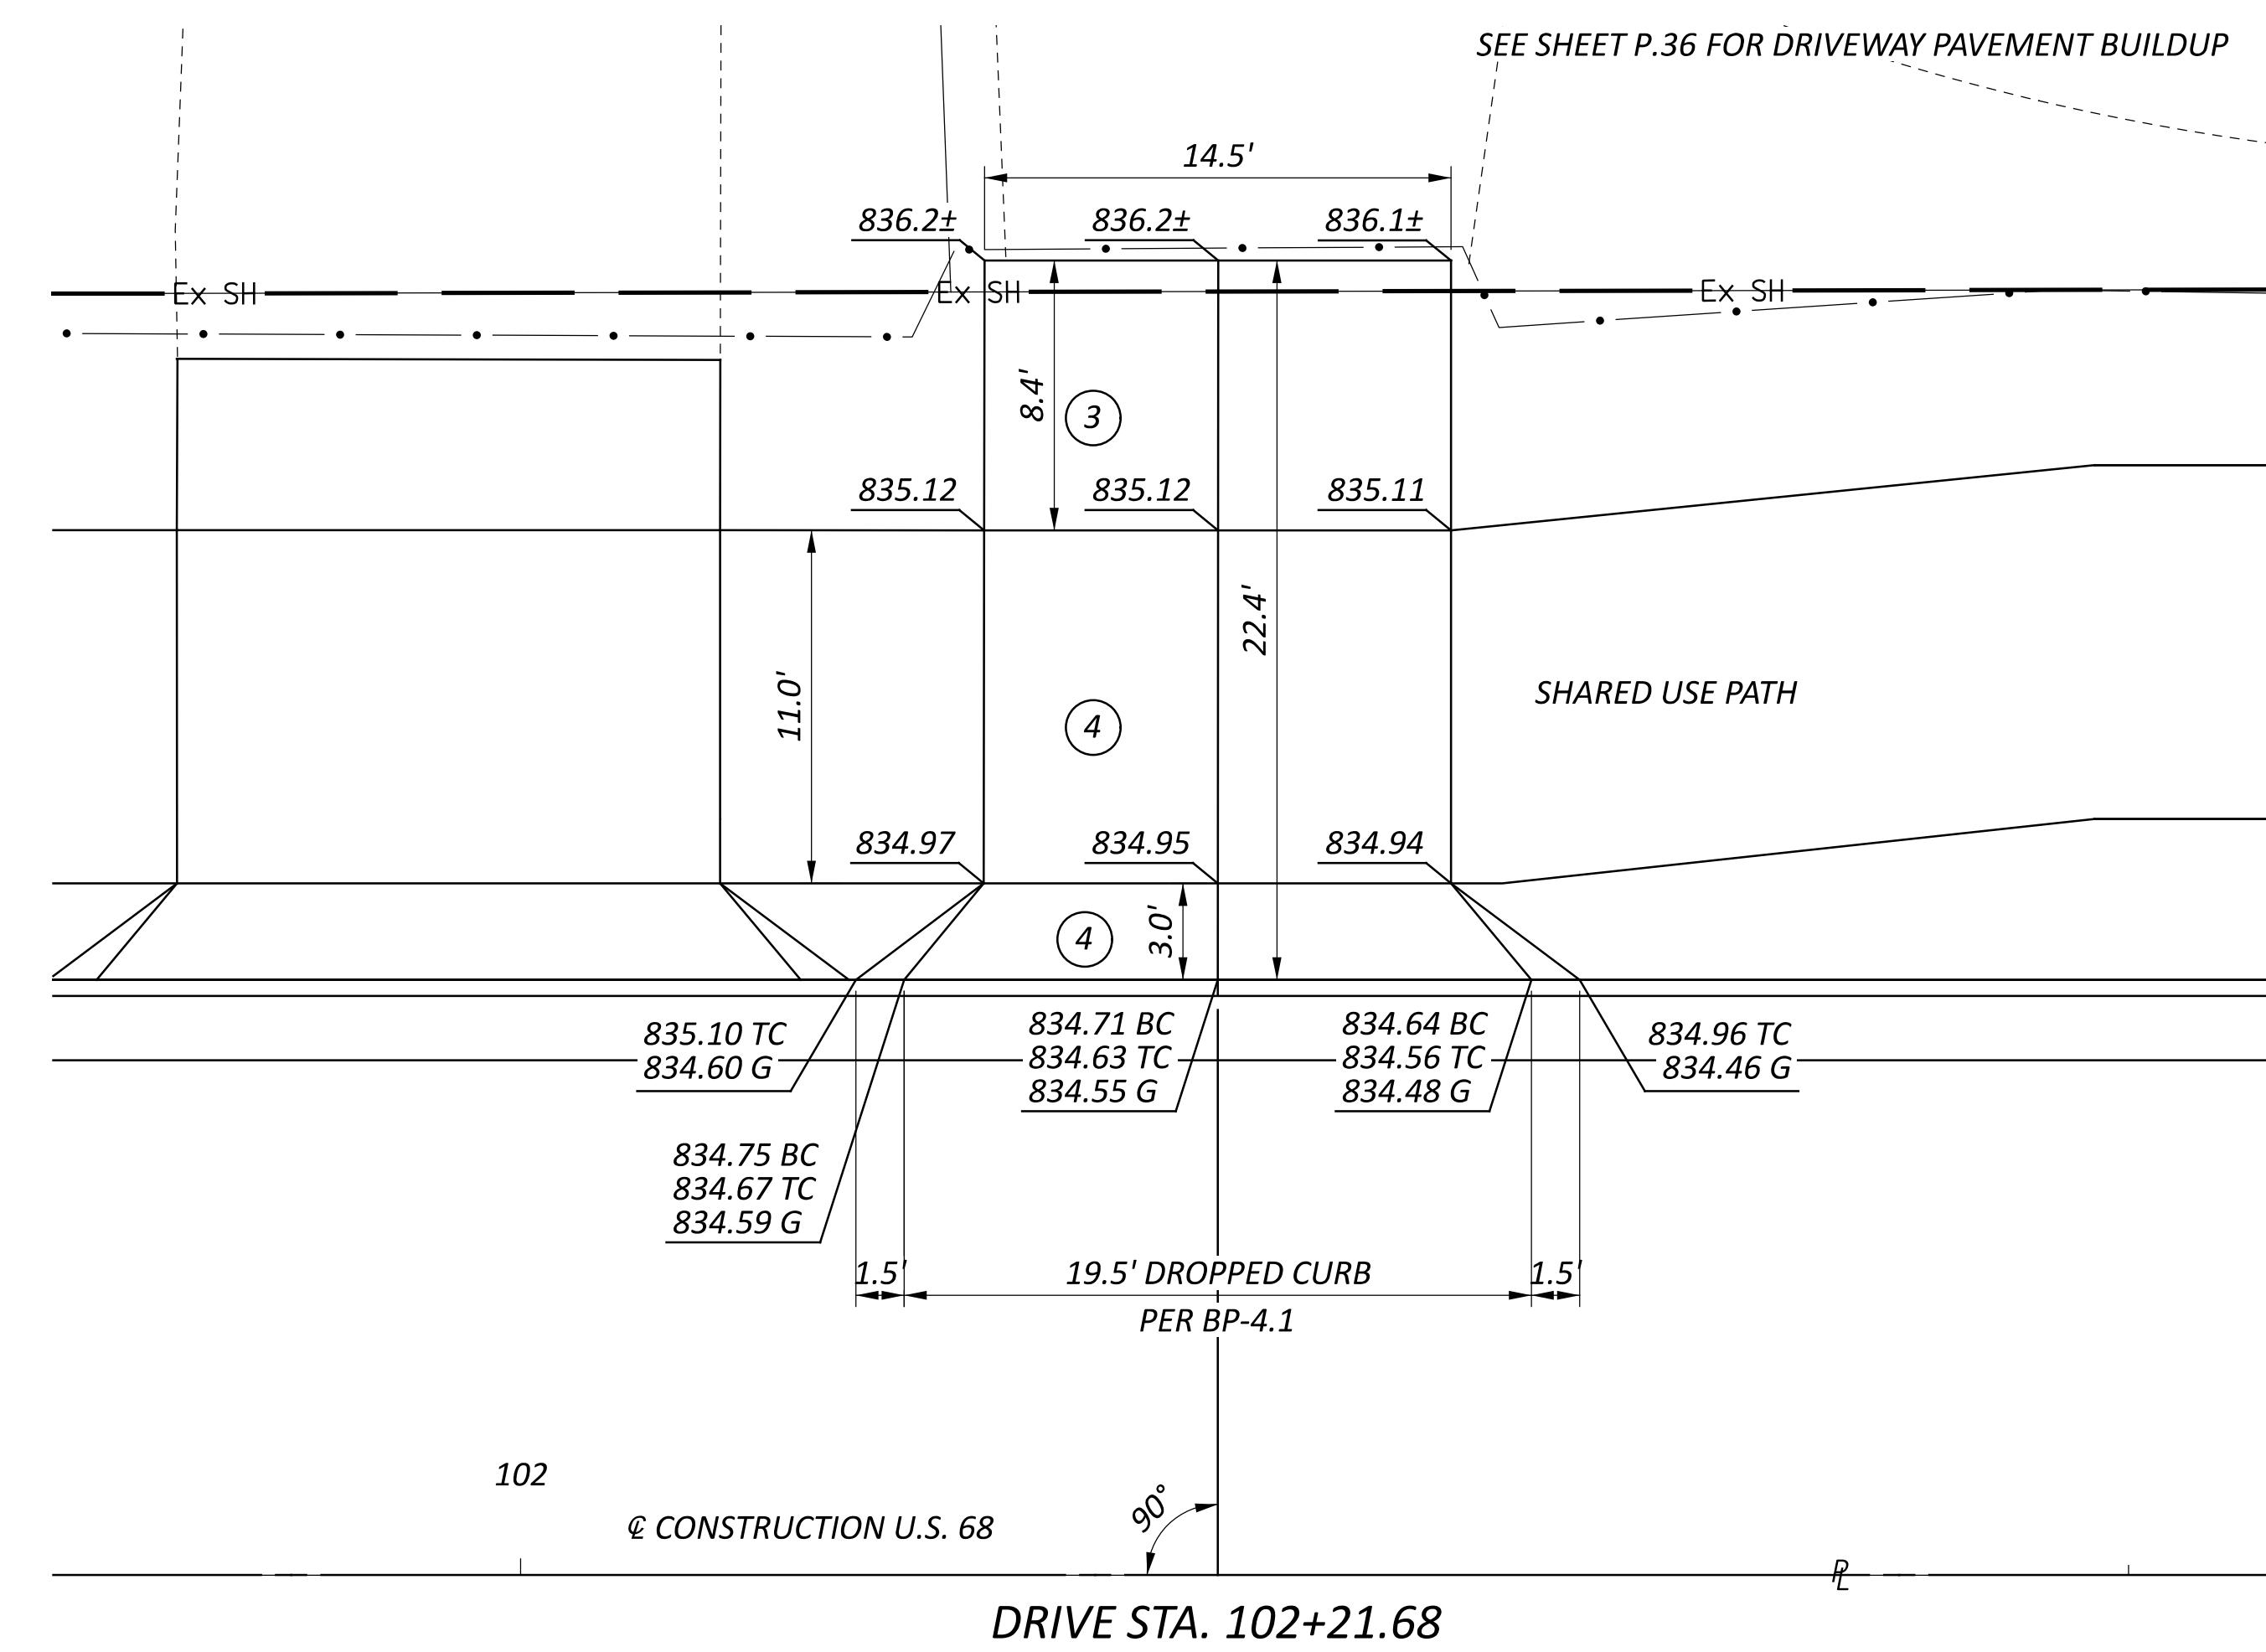

DRIVE STA. 102+21.68



DRIVEWAY DETAILS  
PLANS

DESIGN AGENCY



DESIGNER

WCS

REVIEWER


BAA 03/28/25

PROJECT ID


115388

SHEET TOTAL

P.38 P.107

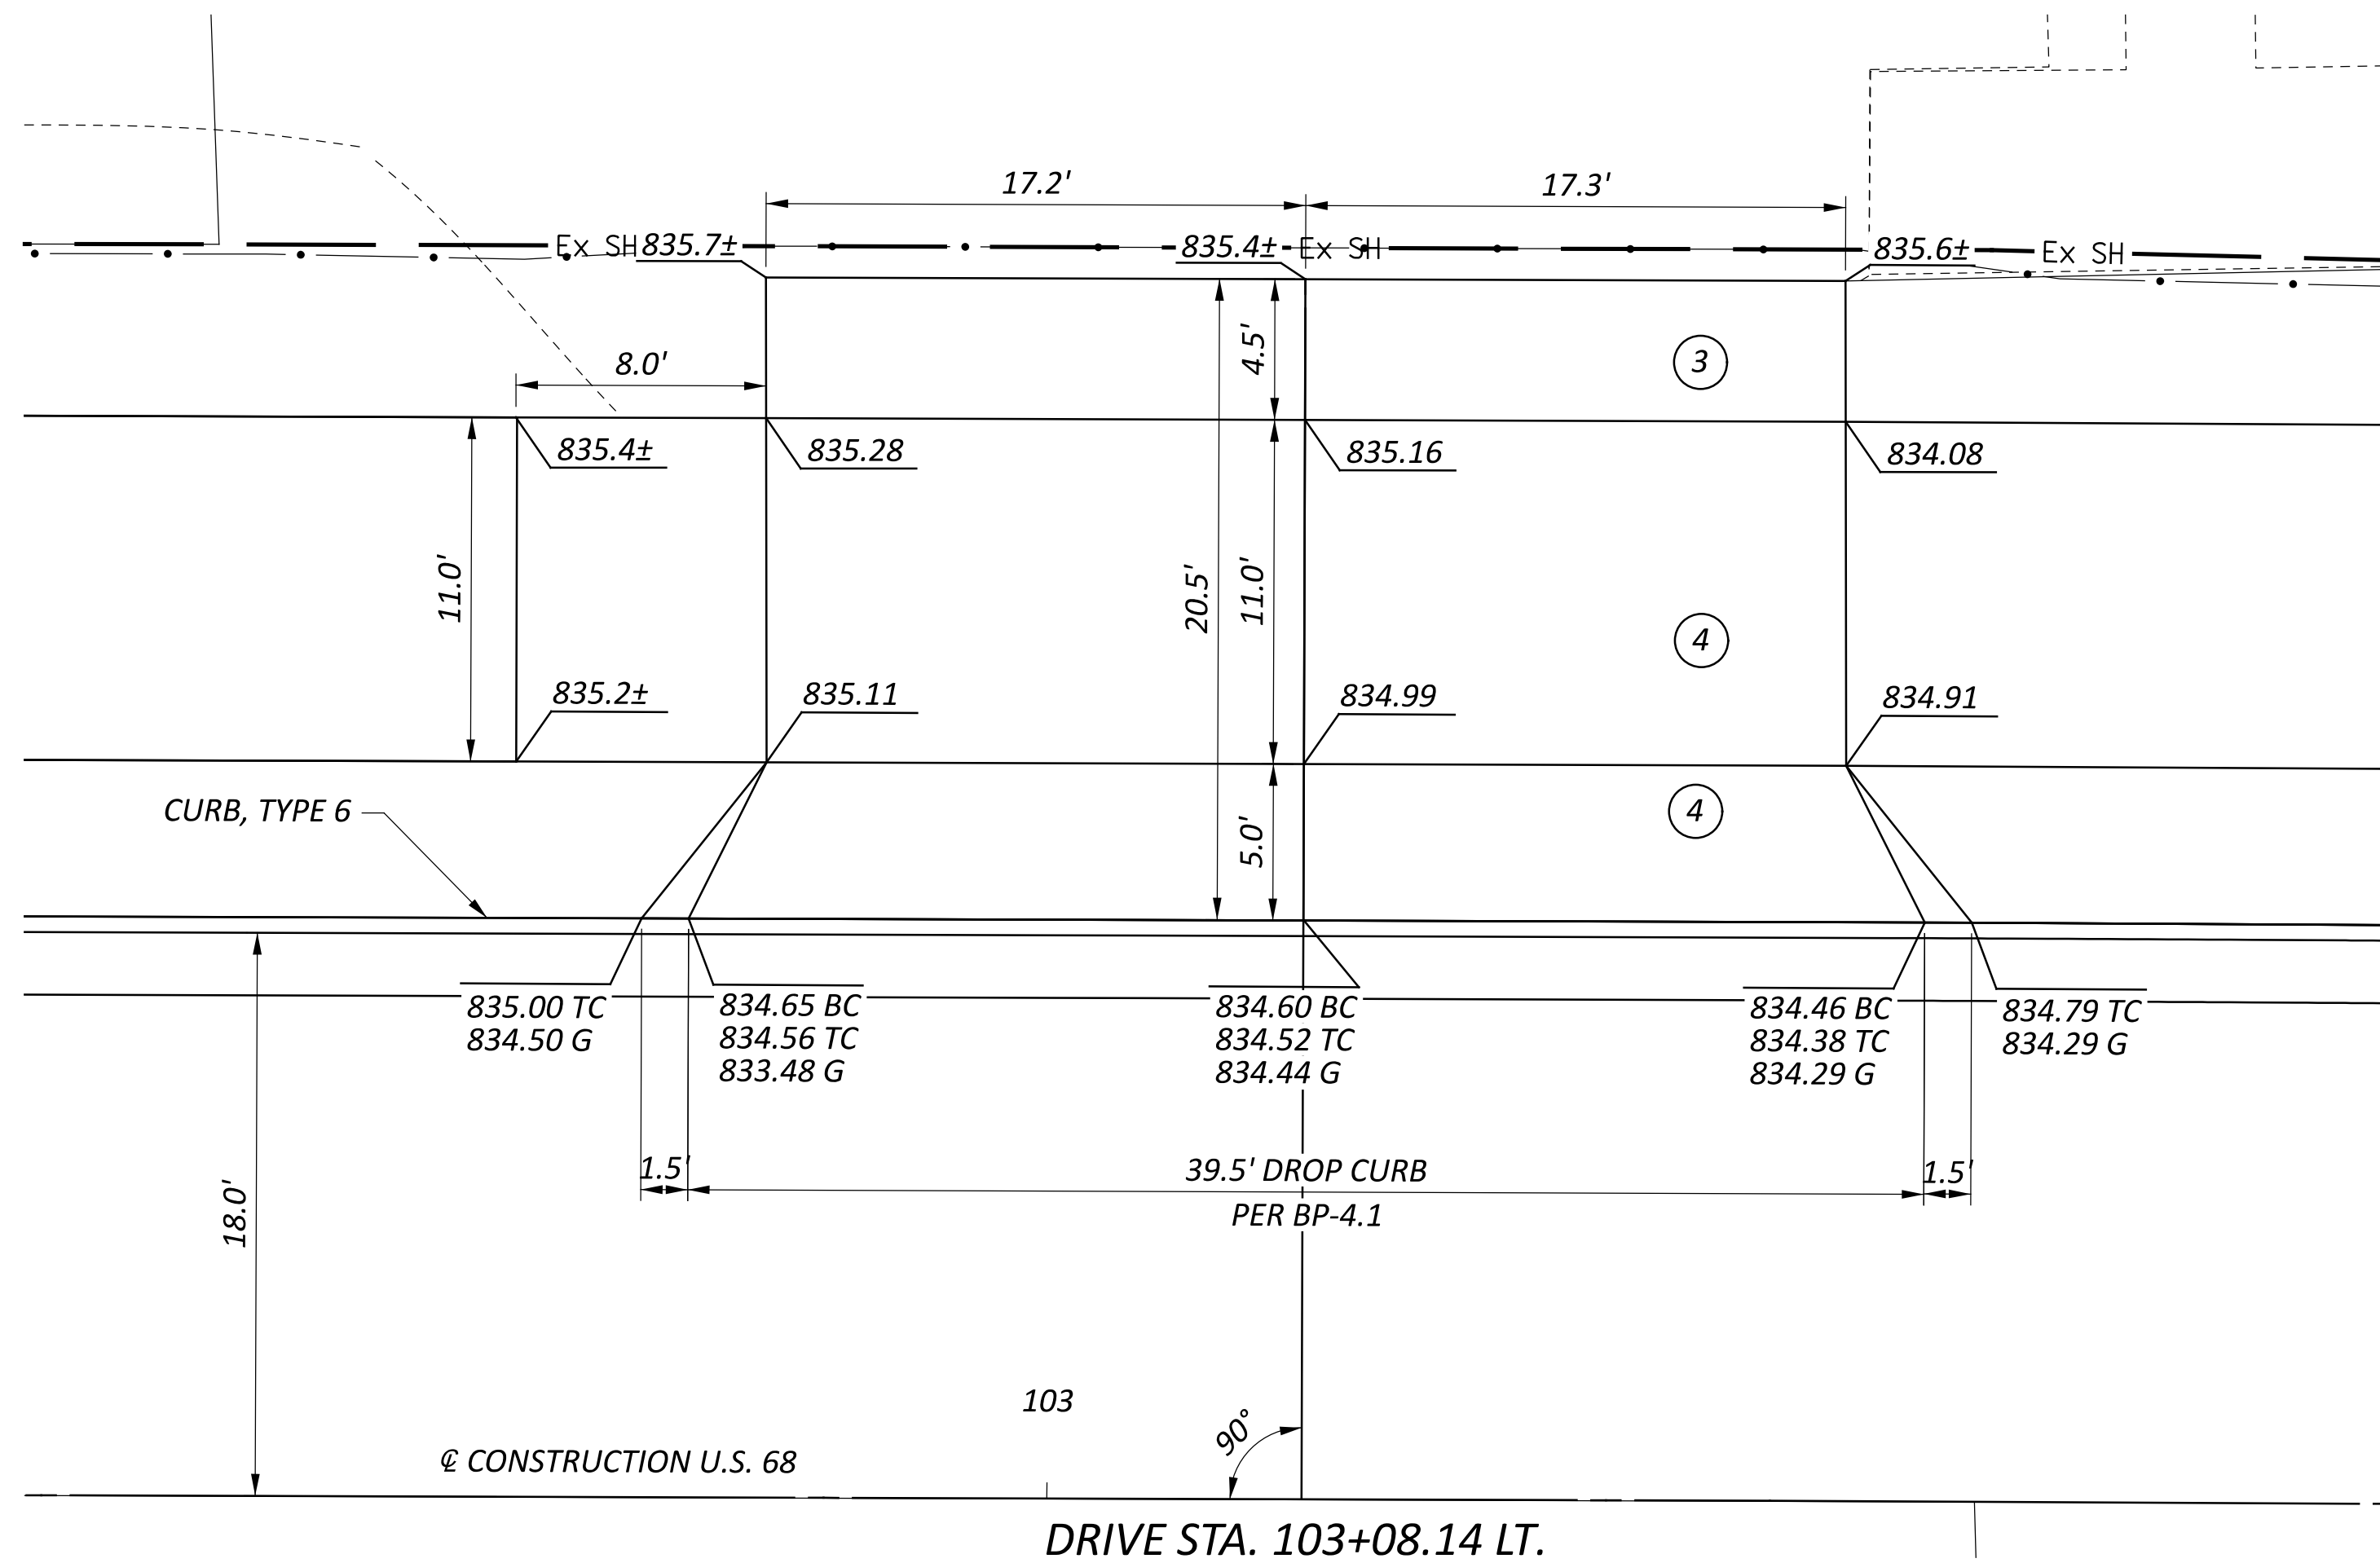


DRIVE STA. 103+08.14 LT.

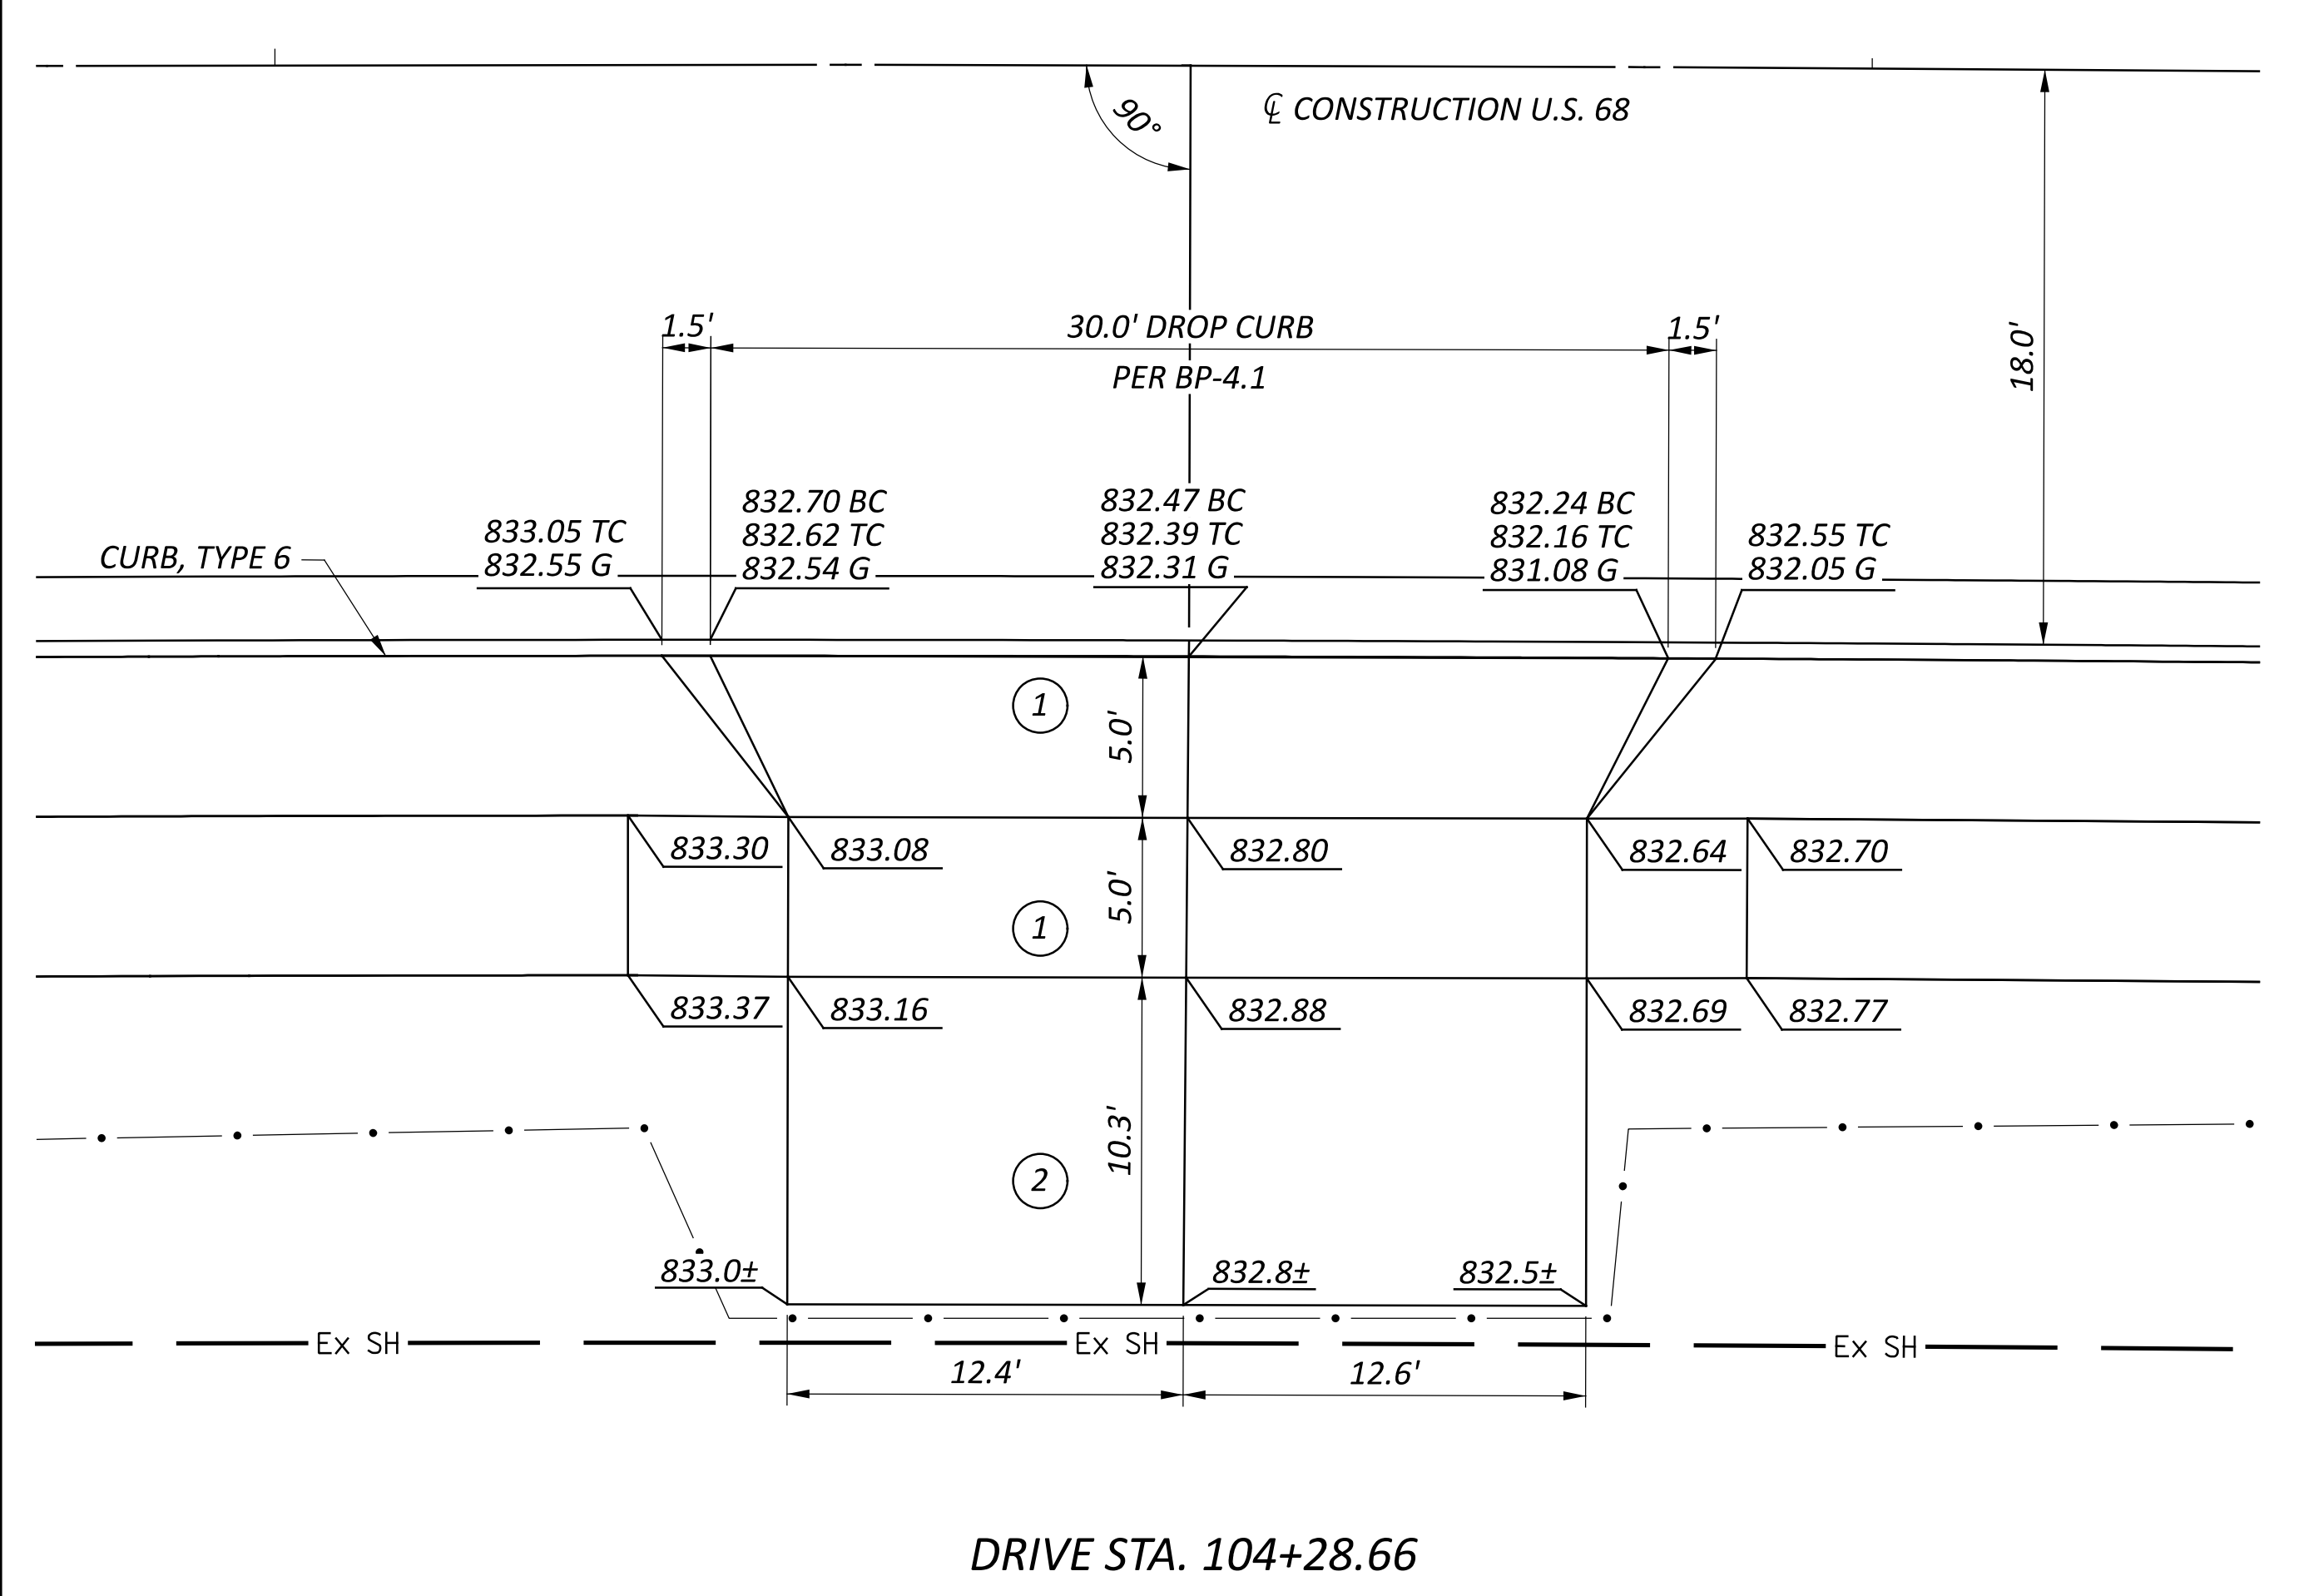


DRIVE STA. 104+28.66

SEE SHEET P.36 FOR DRIVEWAY PAVEMENT BUILDUP

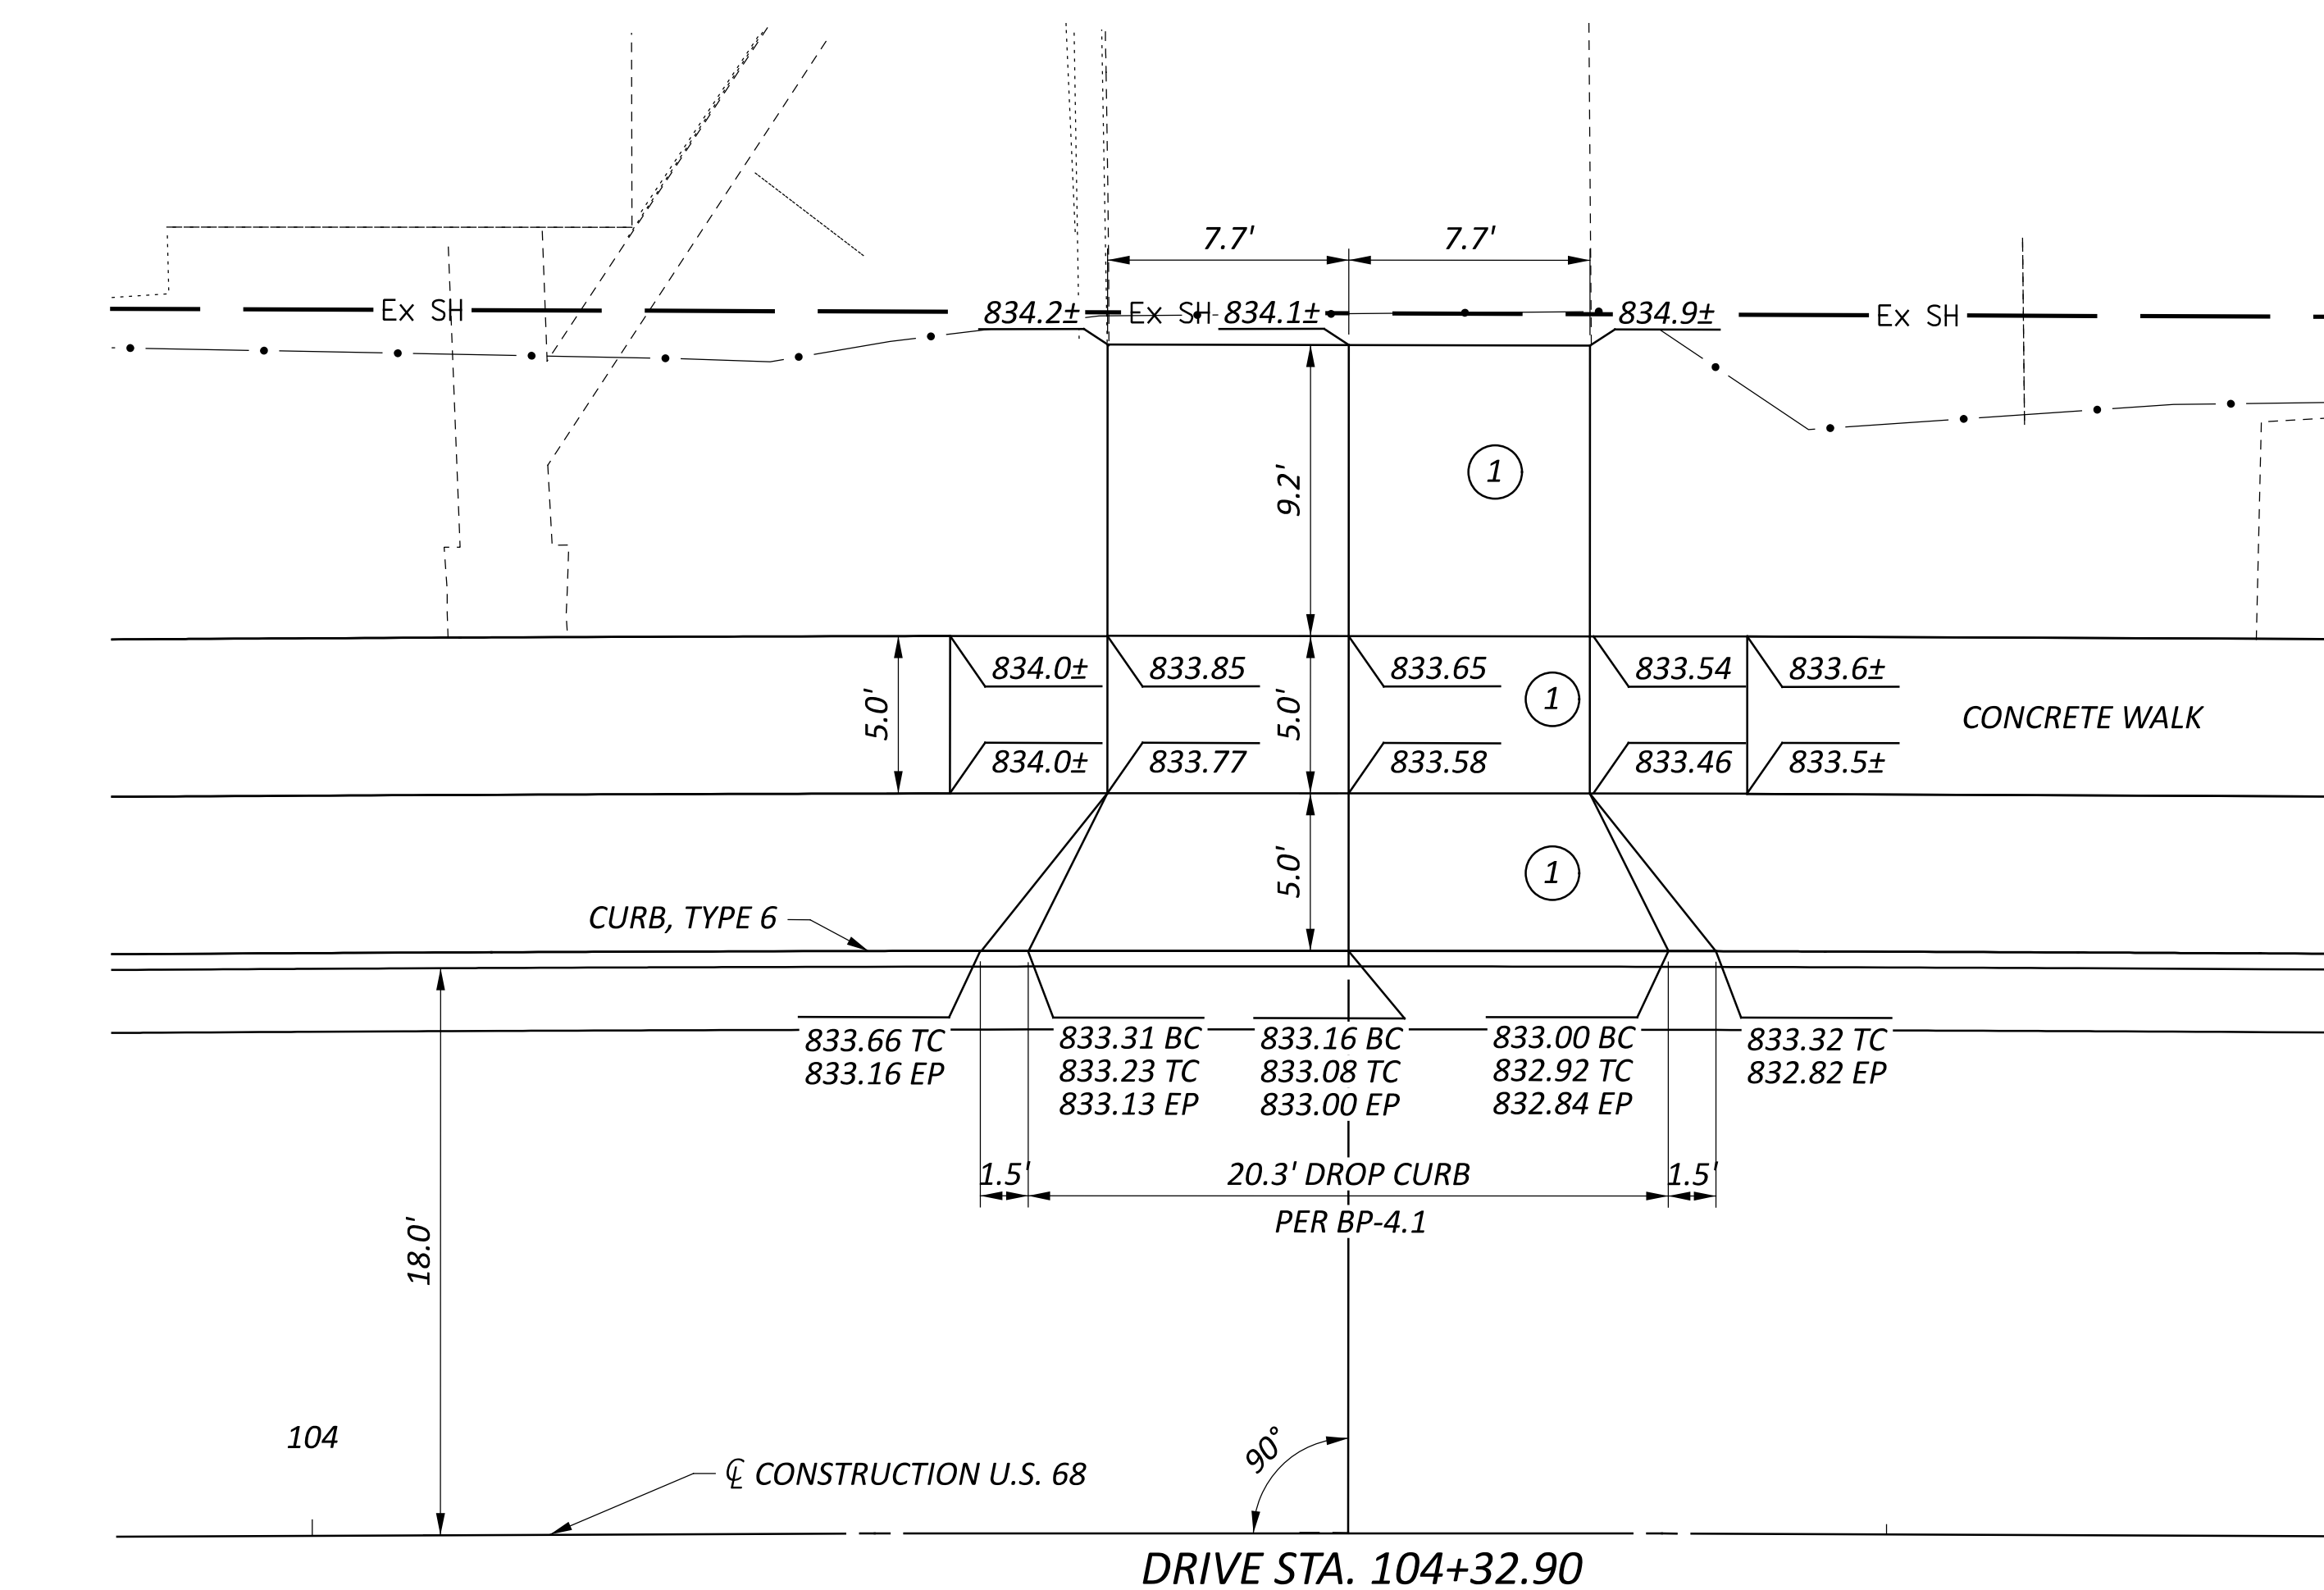

DRIVE STA. 104+32.90

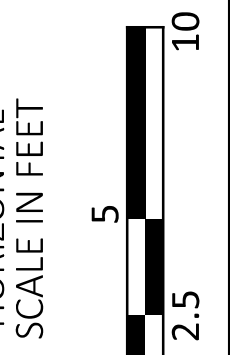

DRIVEWAY DETAILS  
PLANS

DESIGN AGENCY



DESIGNER

WCS

REVIEWER







BAA 03/28/25

PROJECT ID

115388





SHEET TOTAL

P.39 P.107

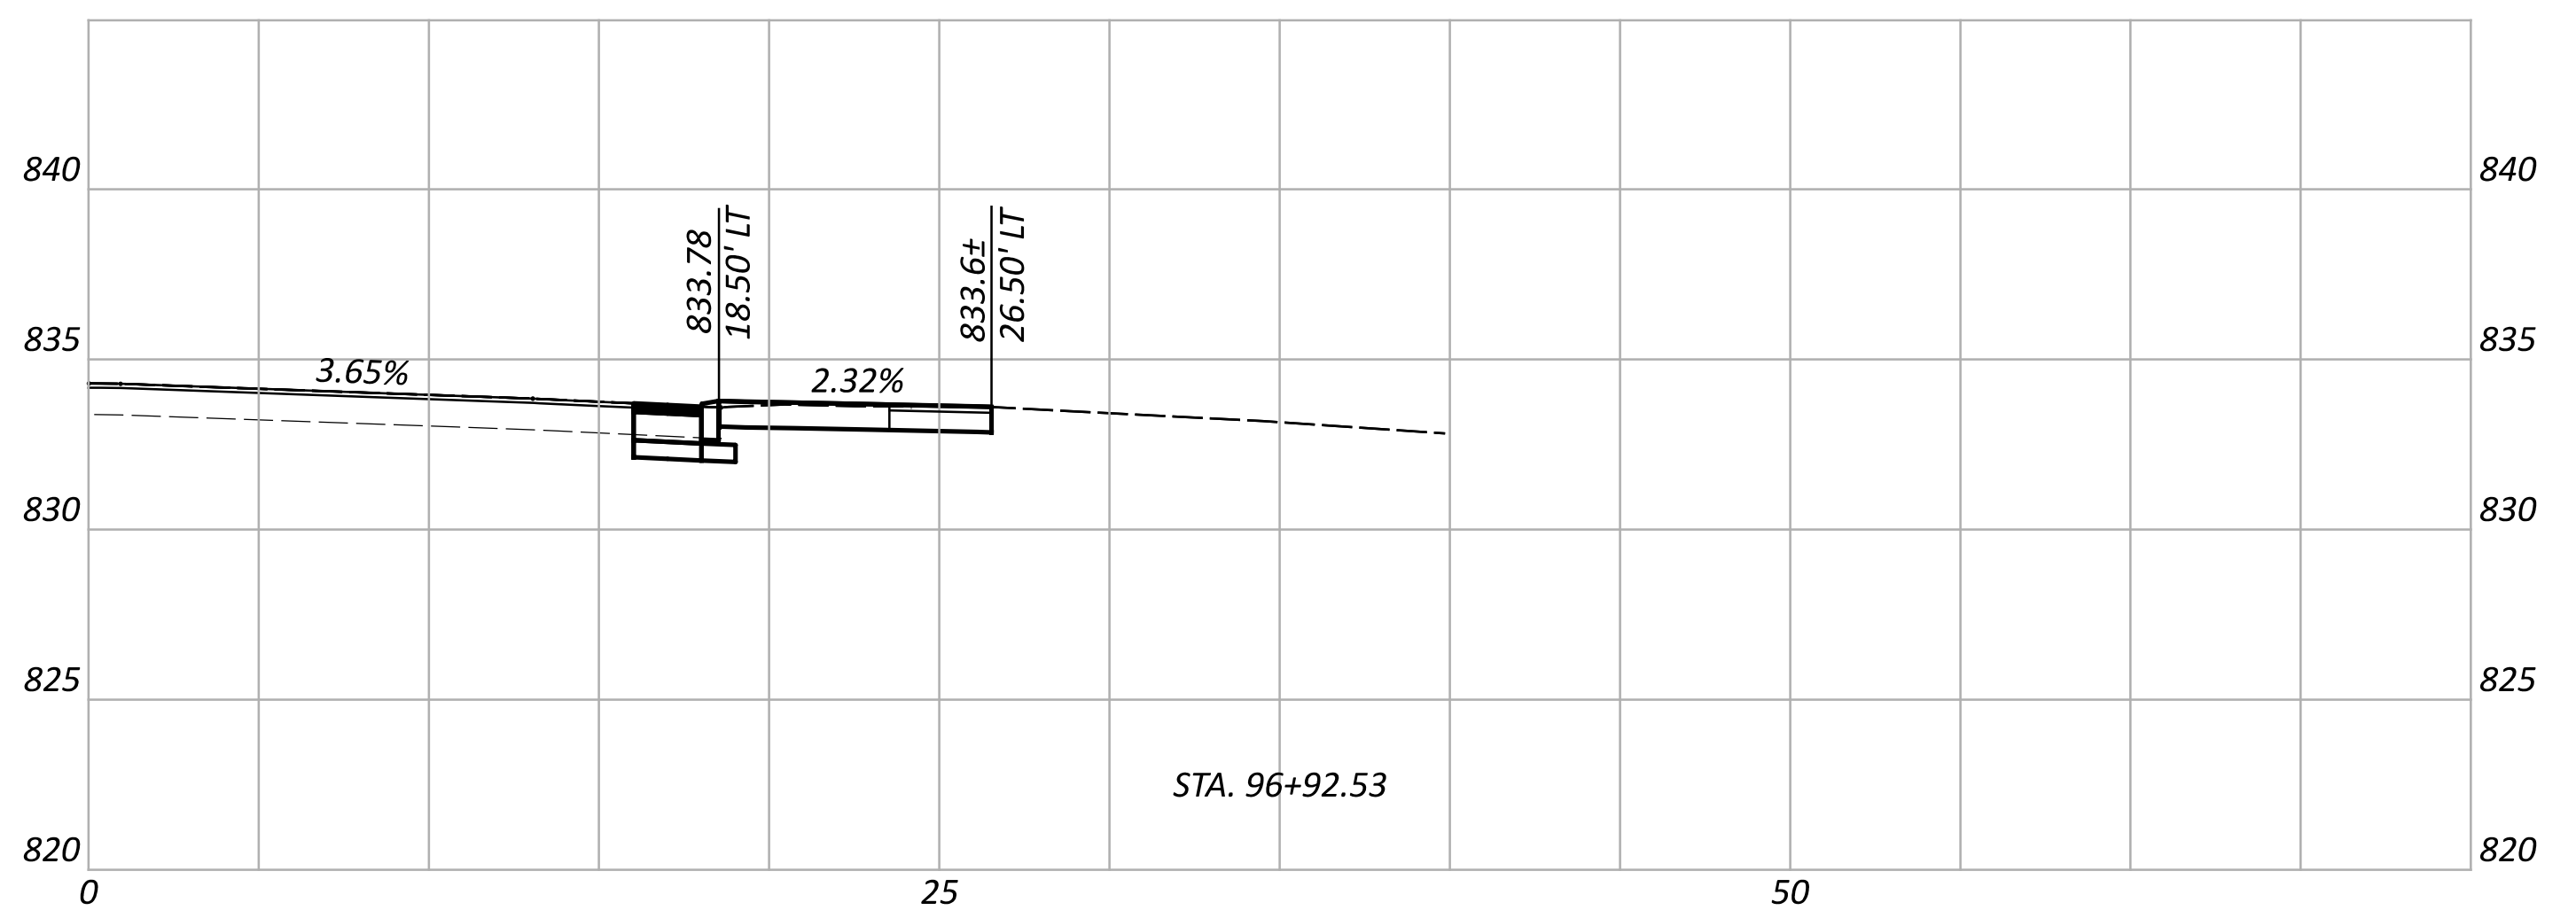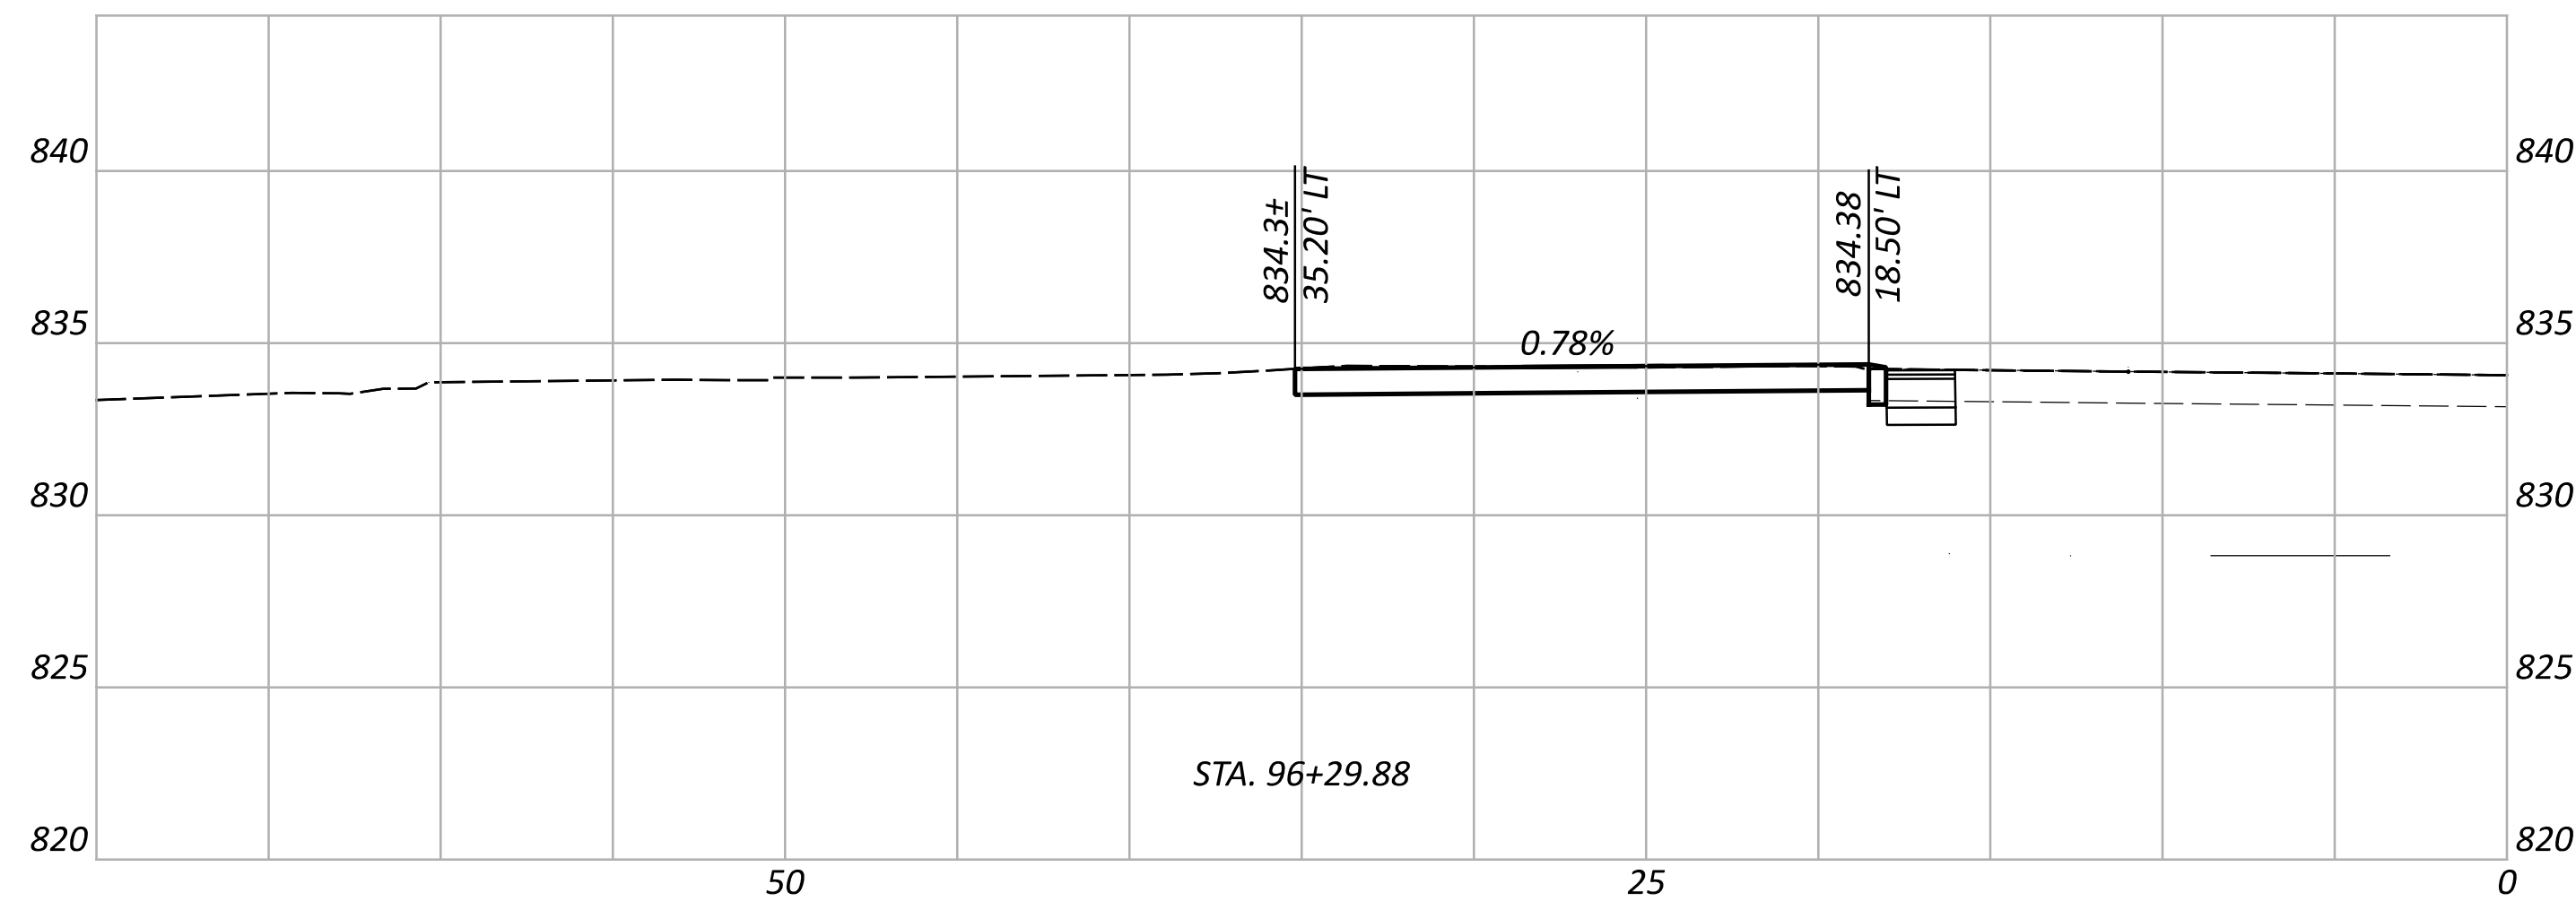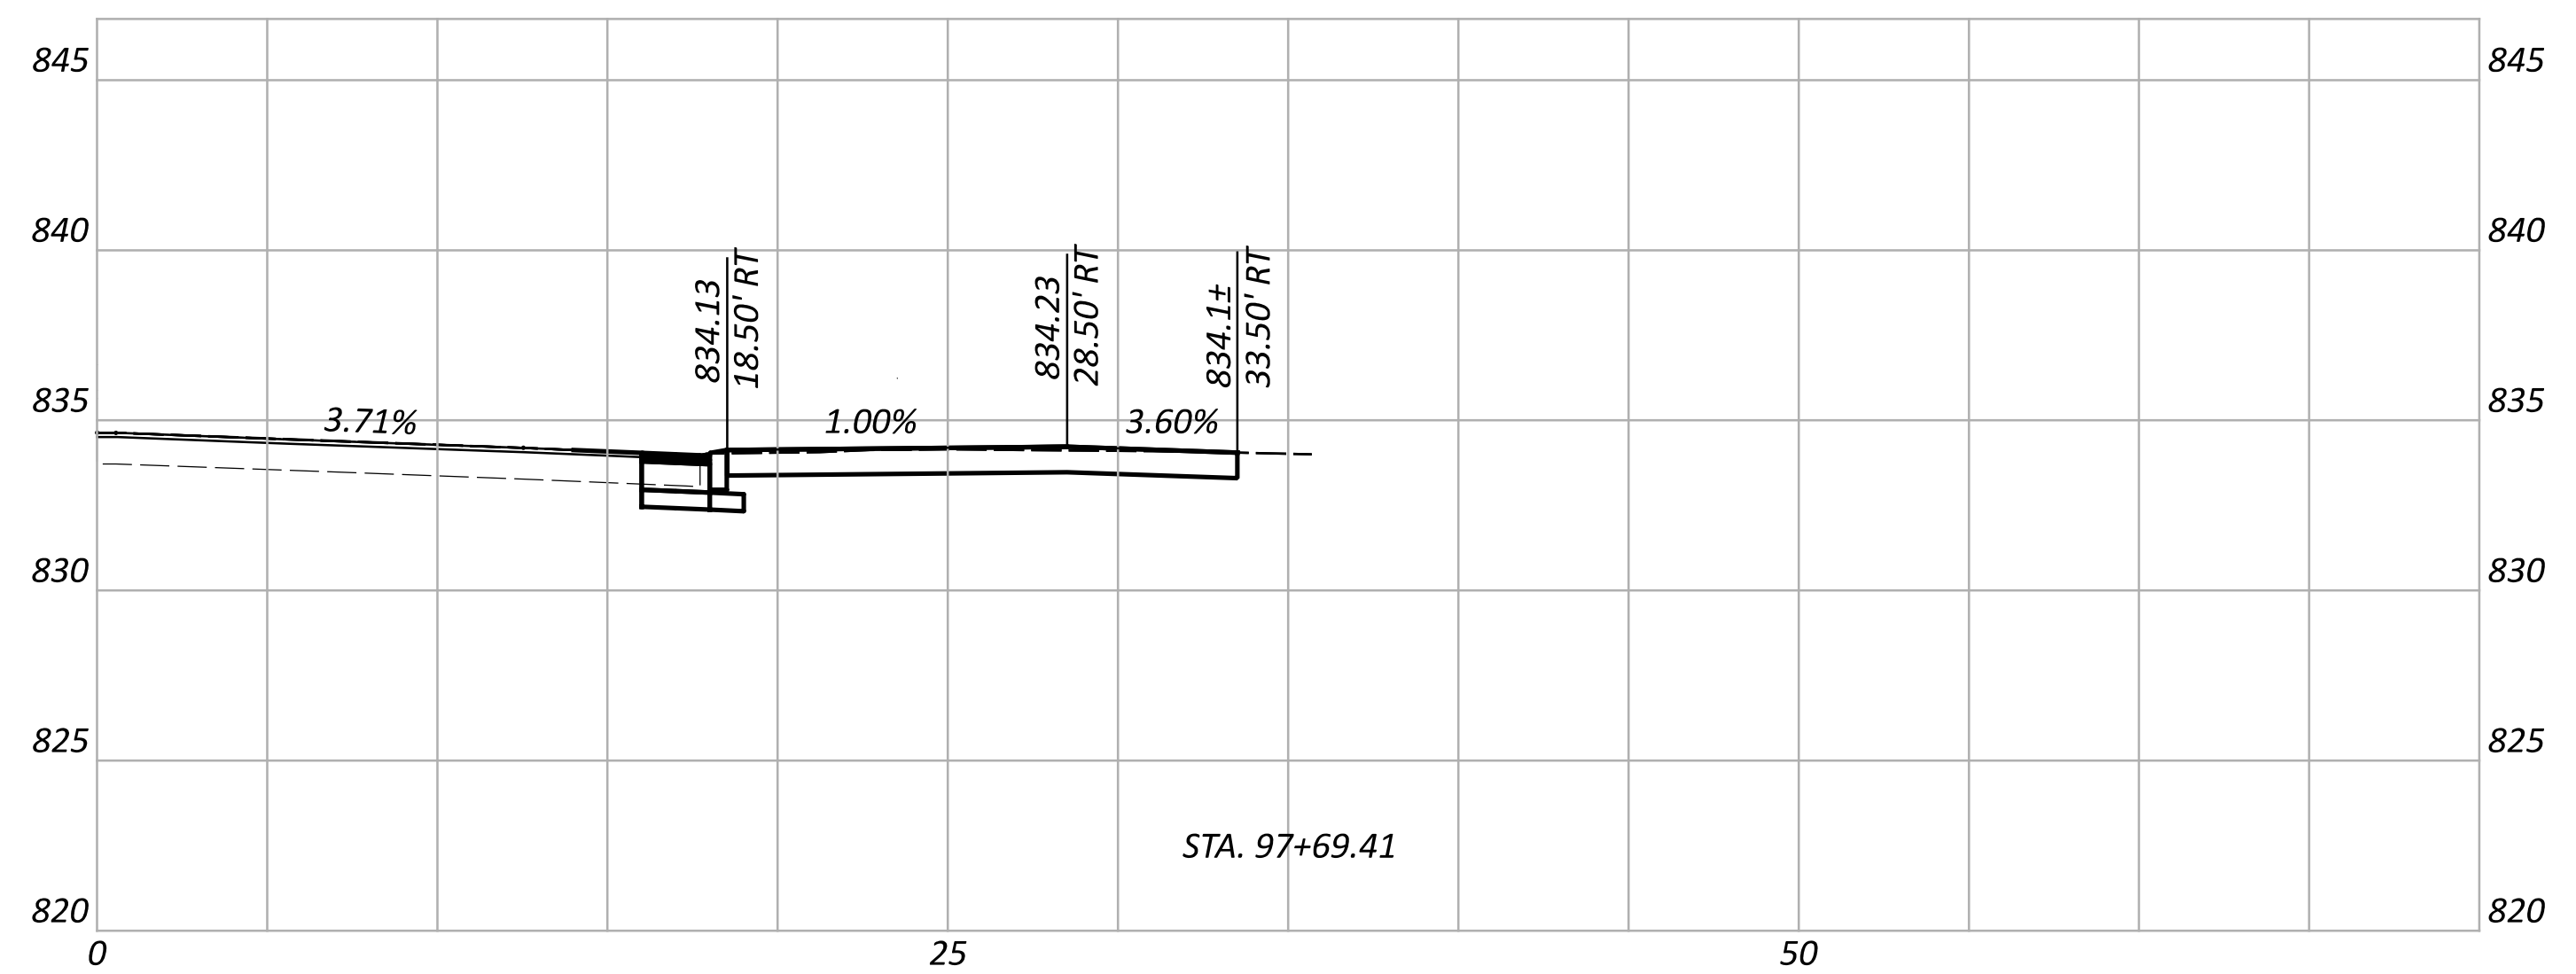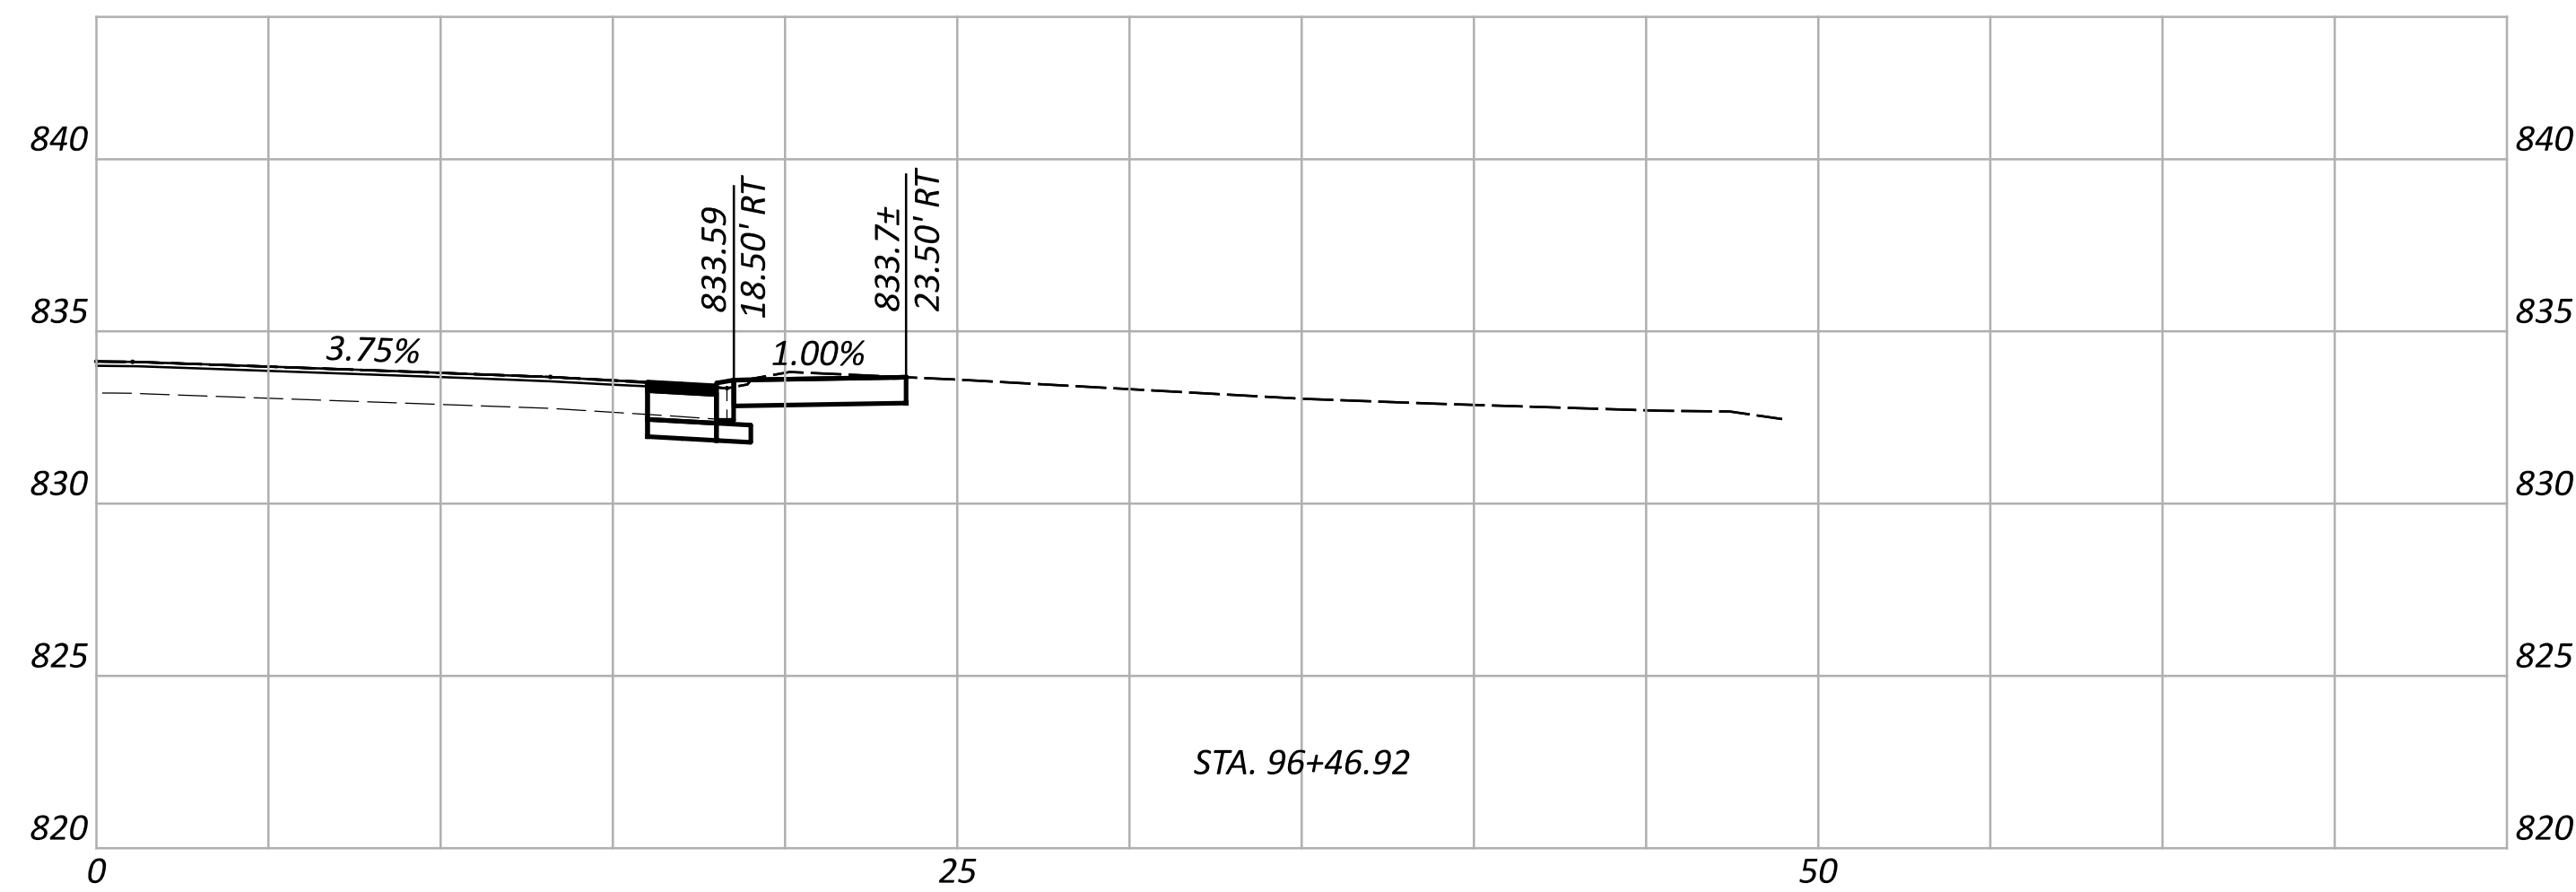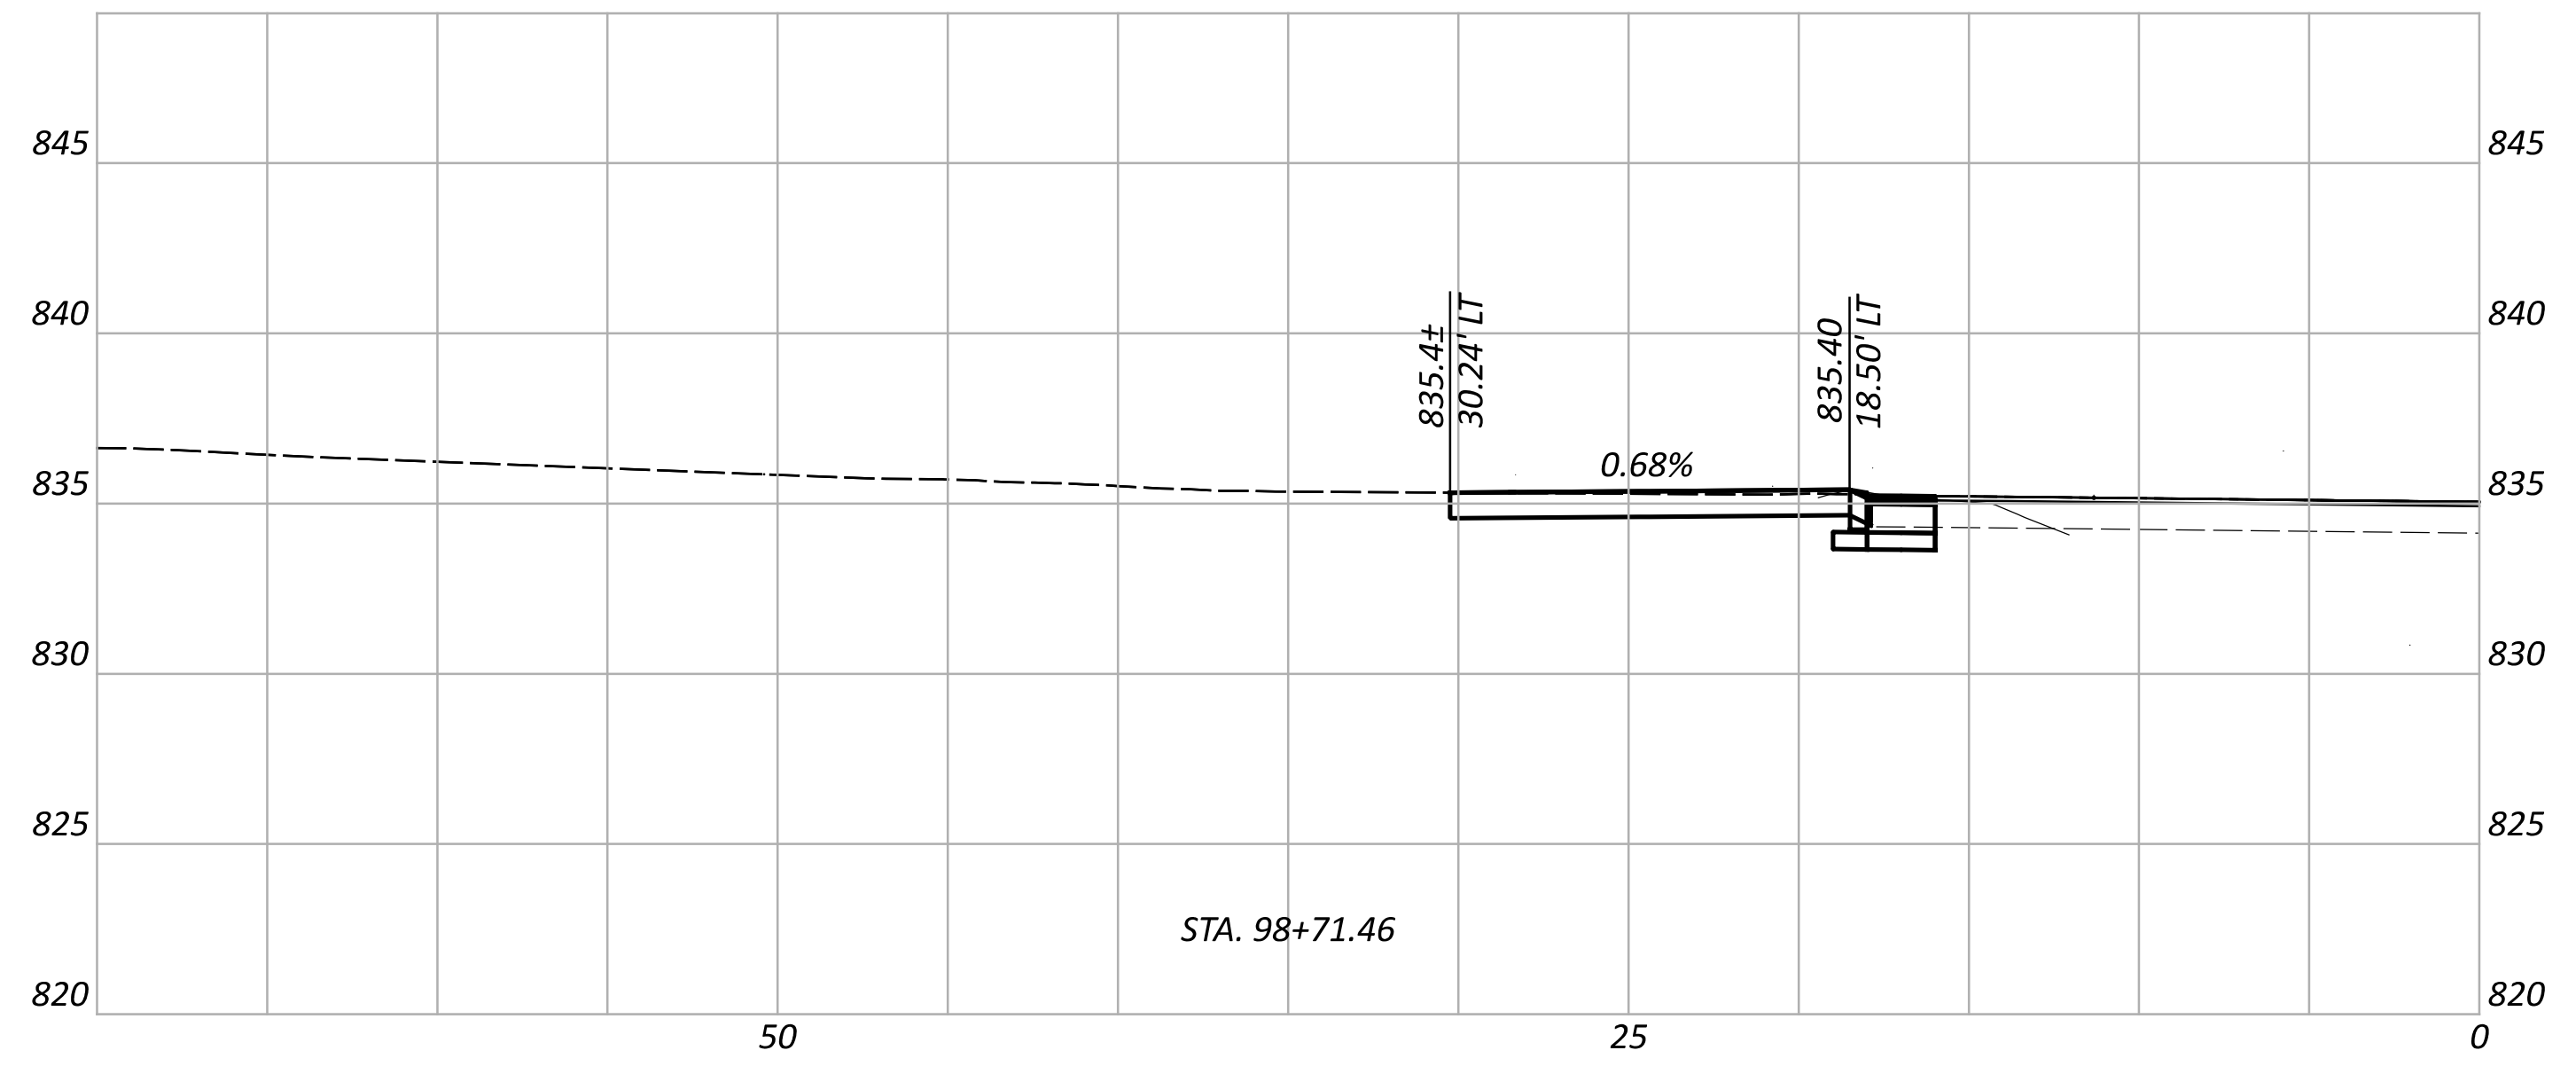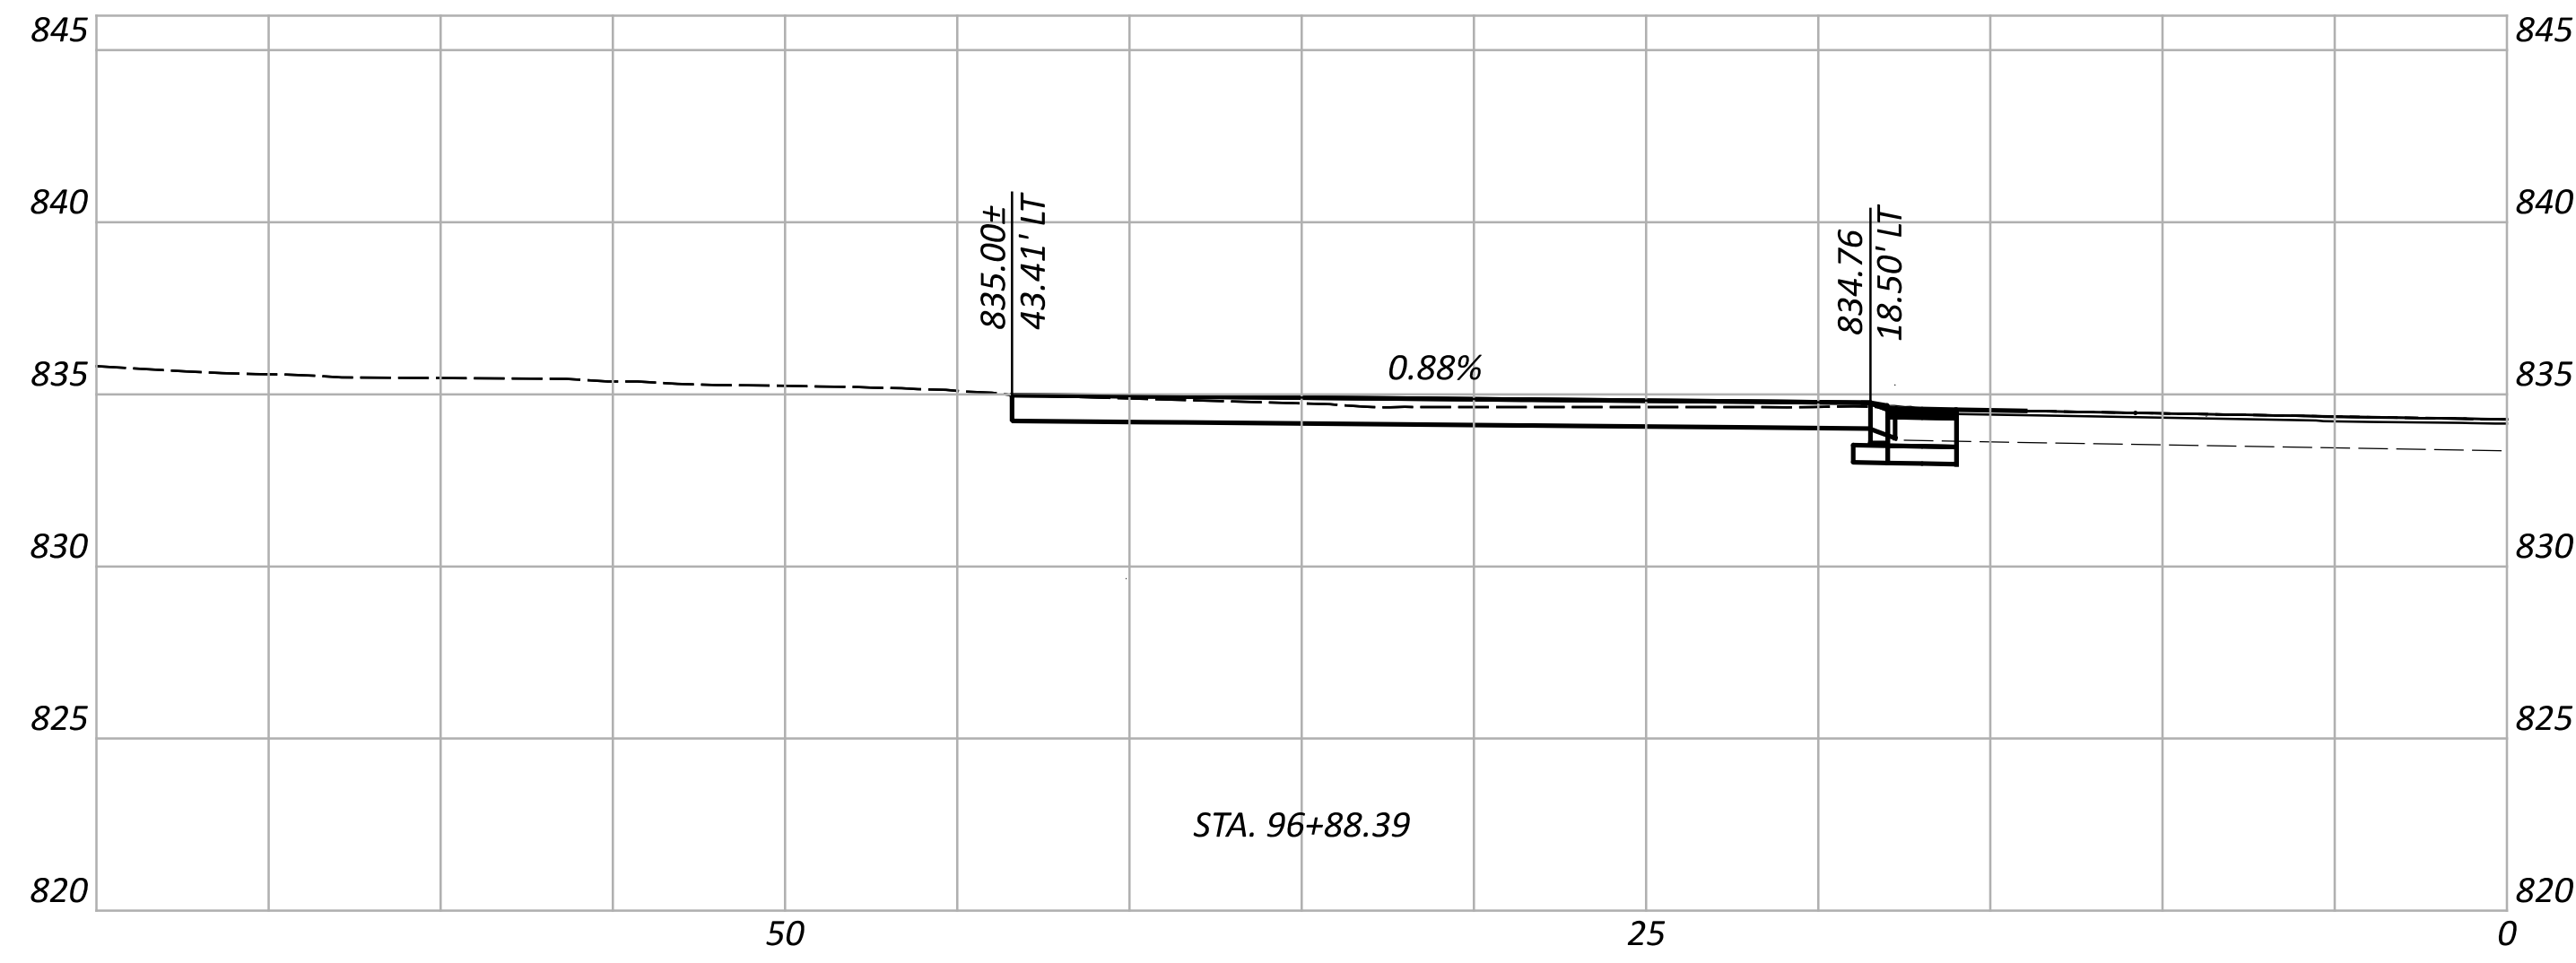

DRIVEWAY DETAILS  
 PROFILES



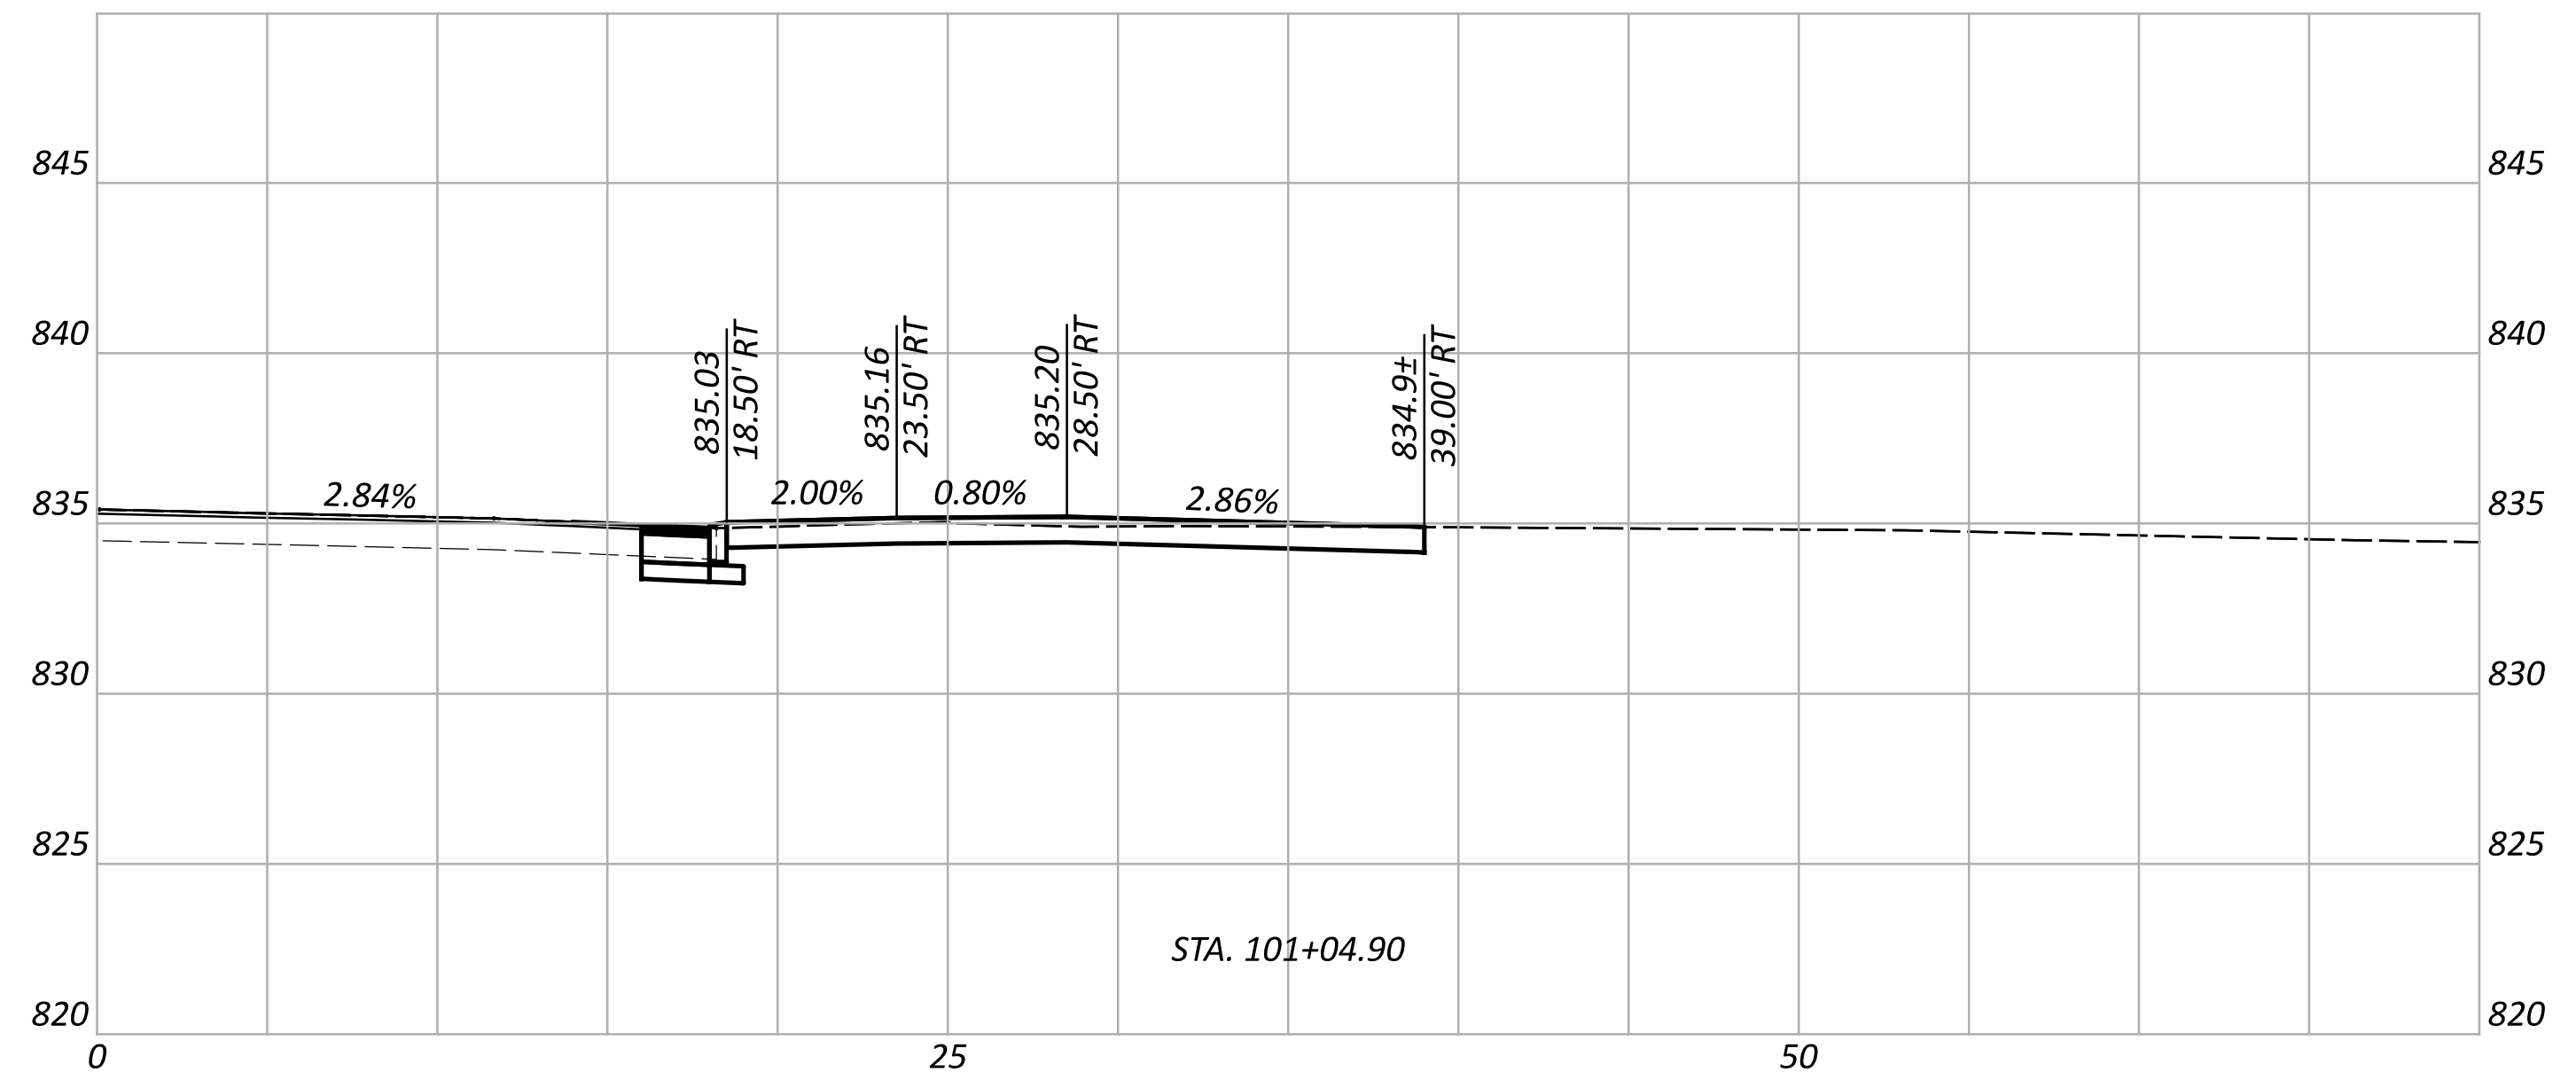
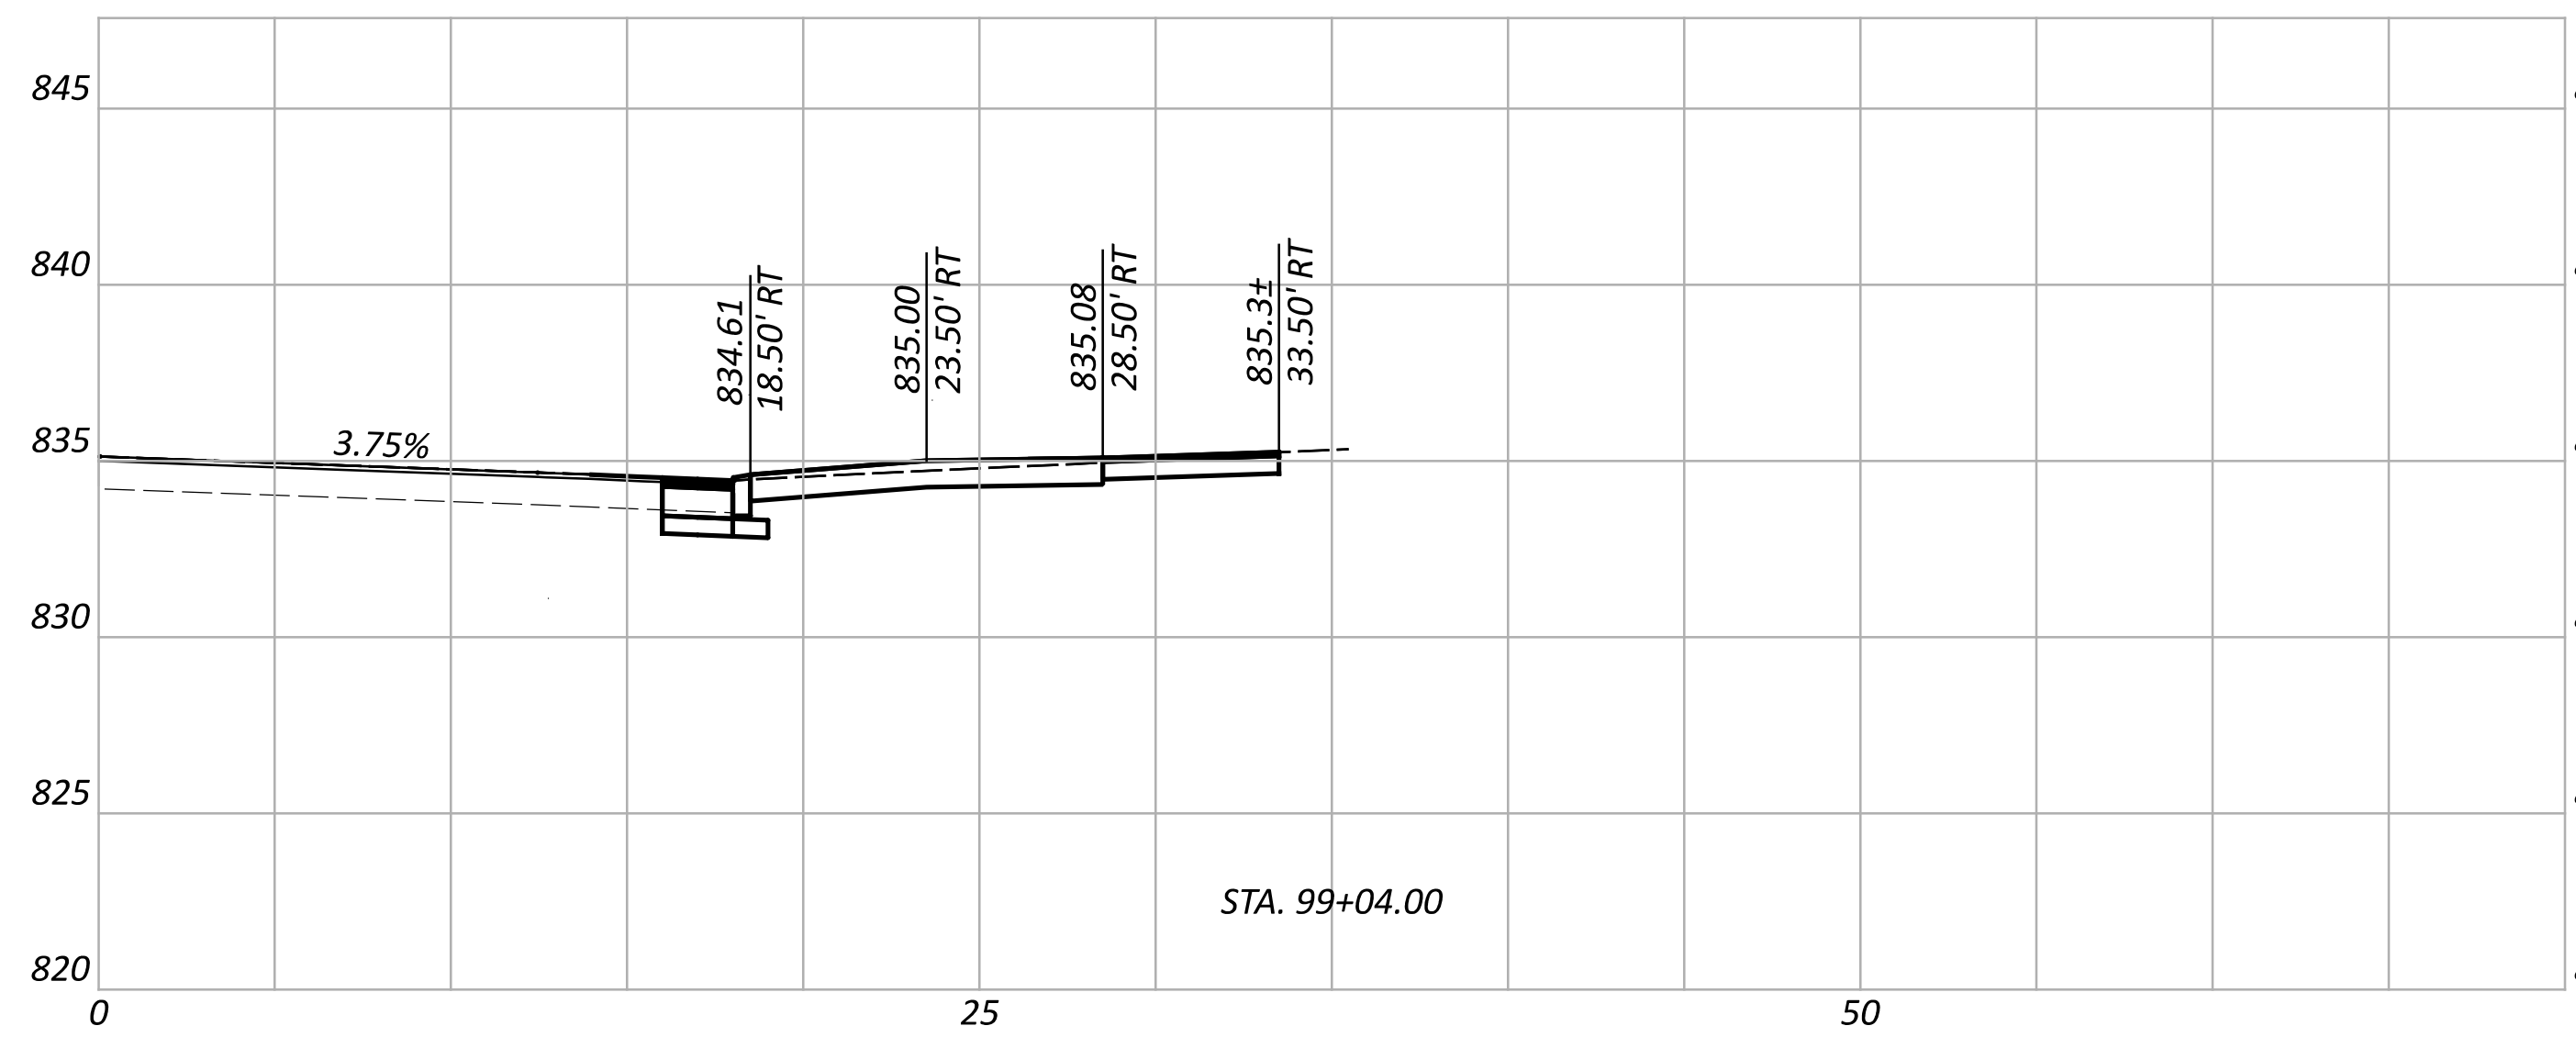
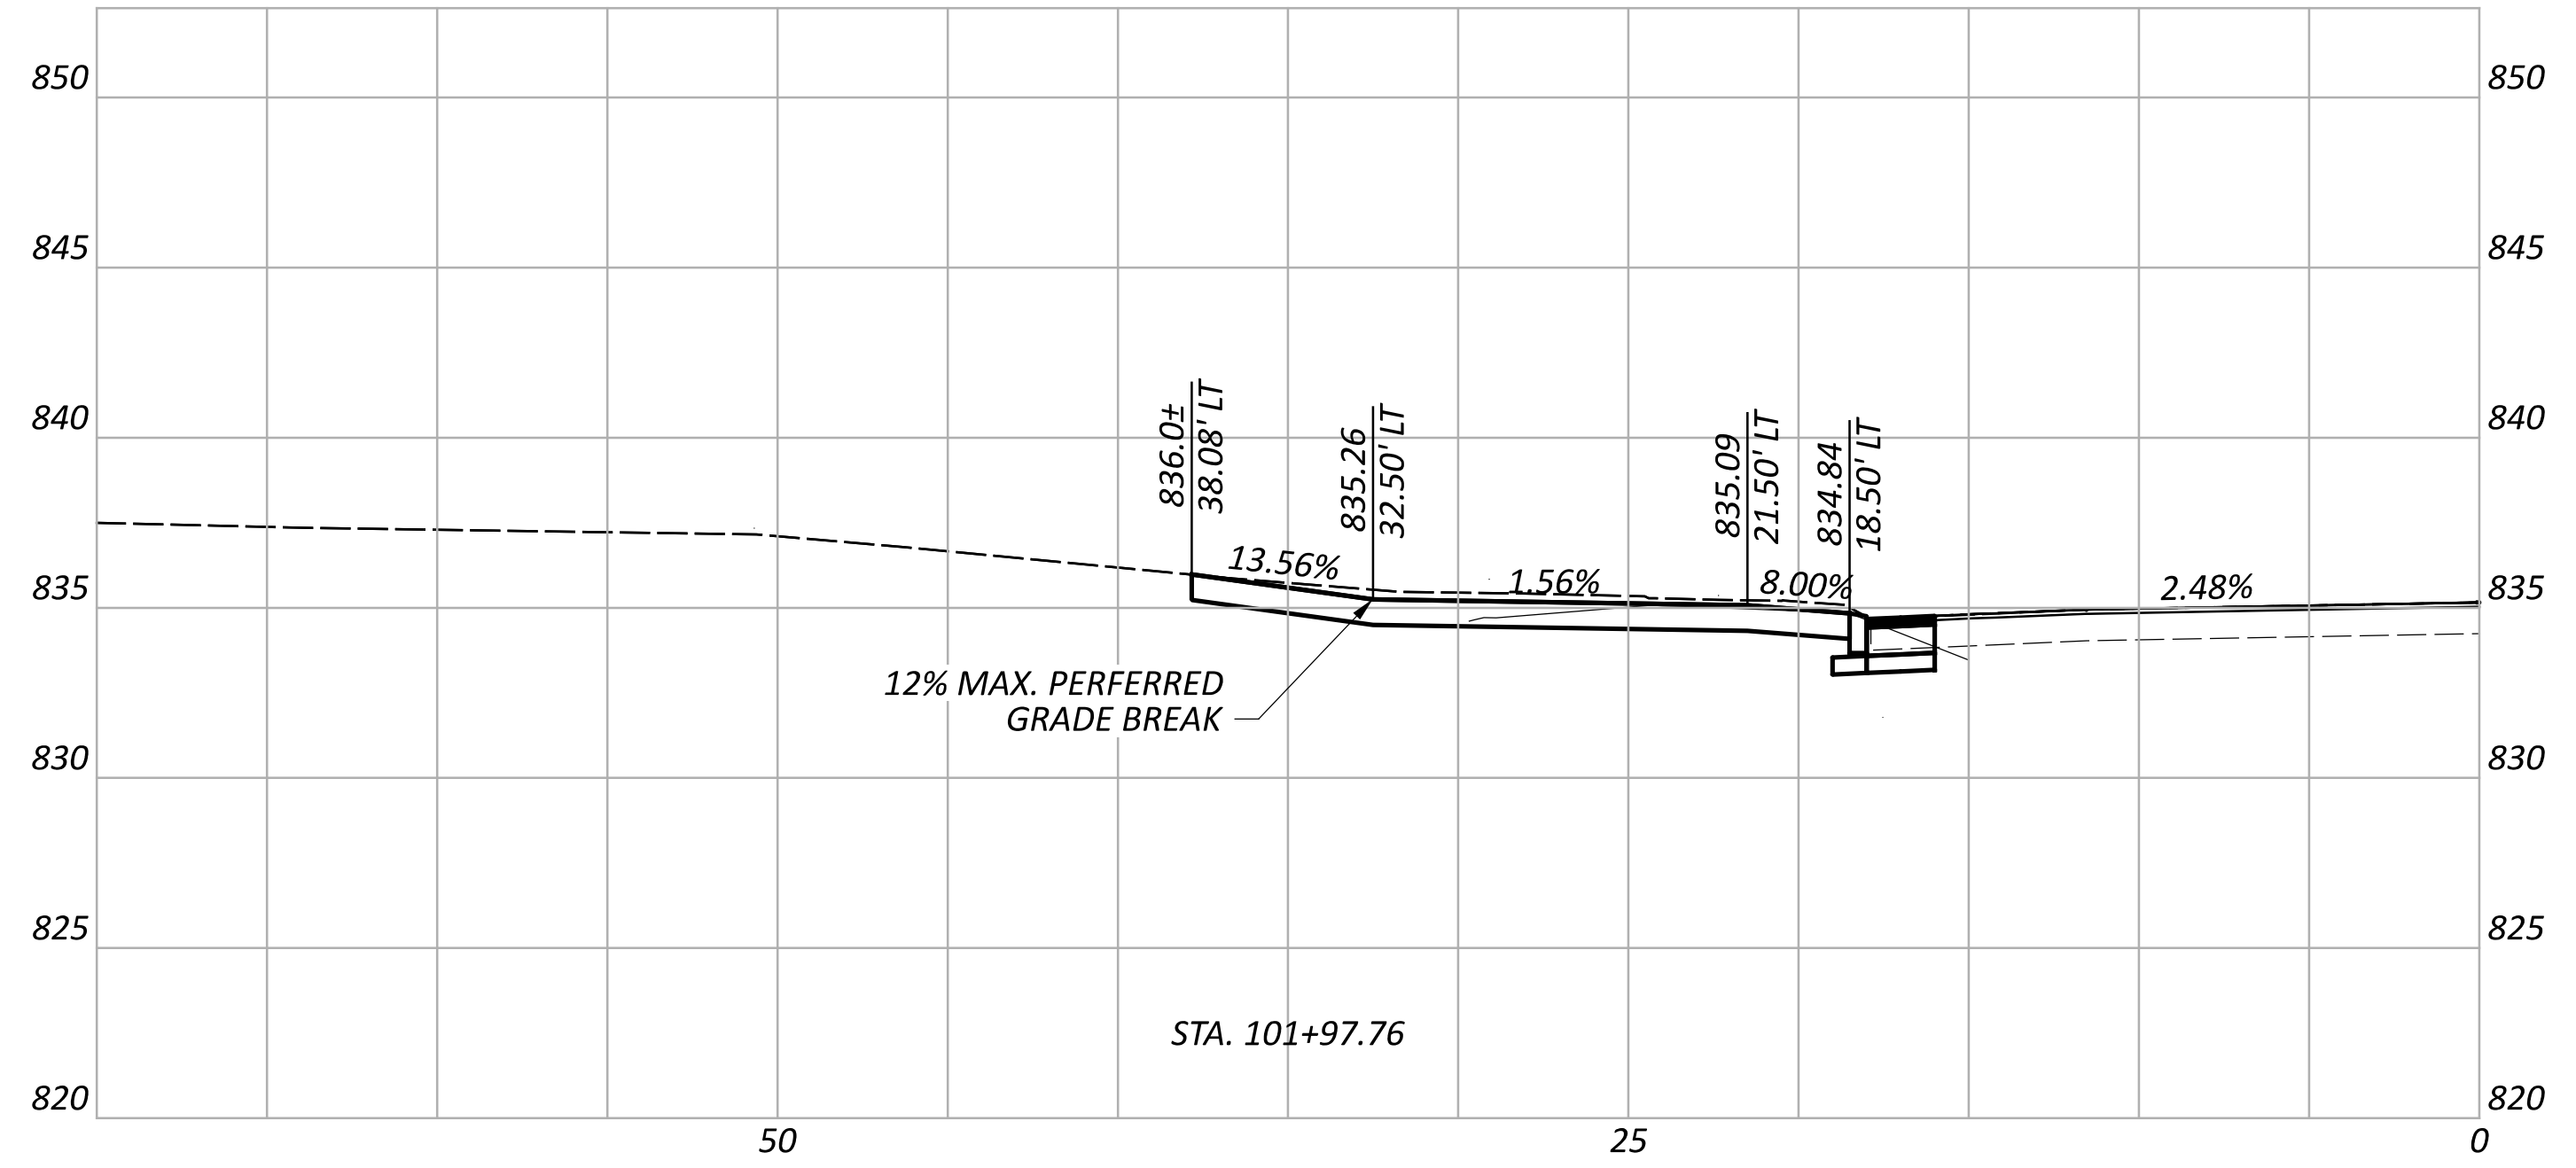
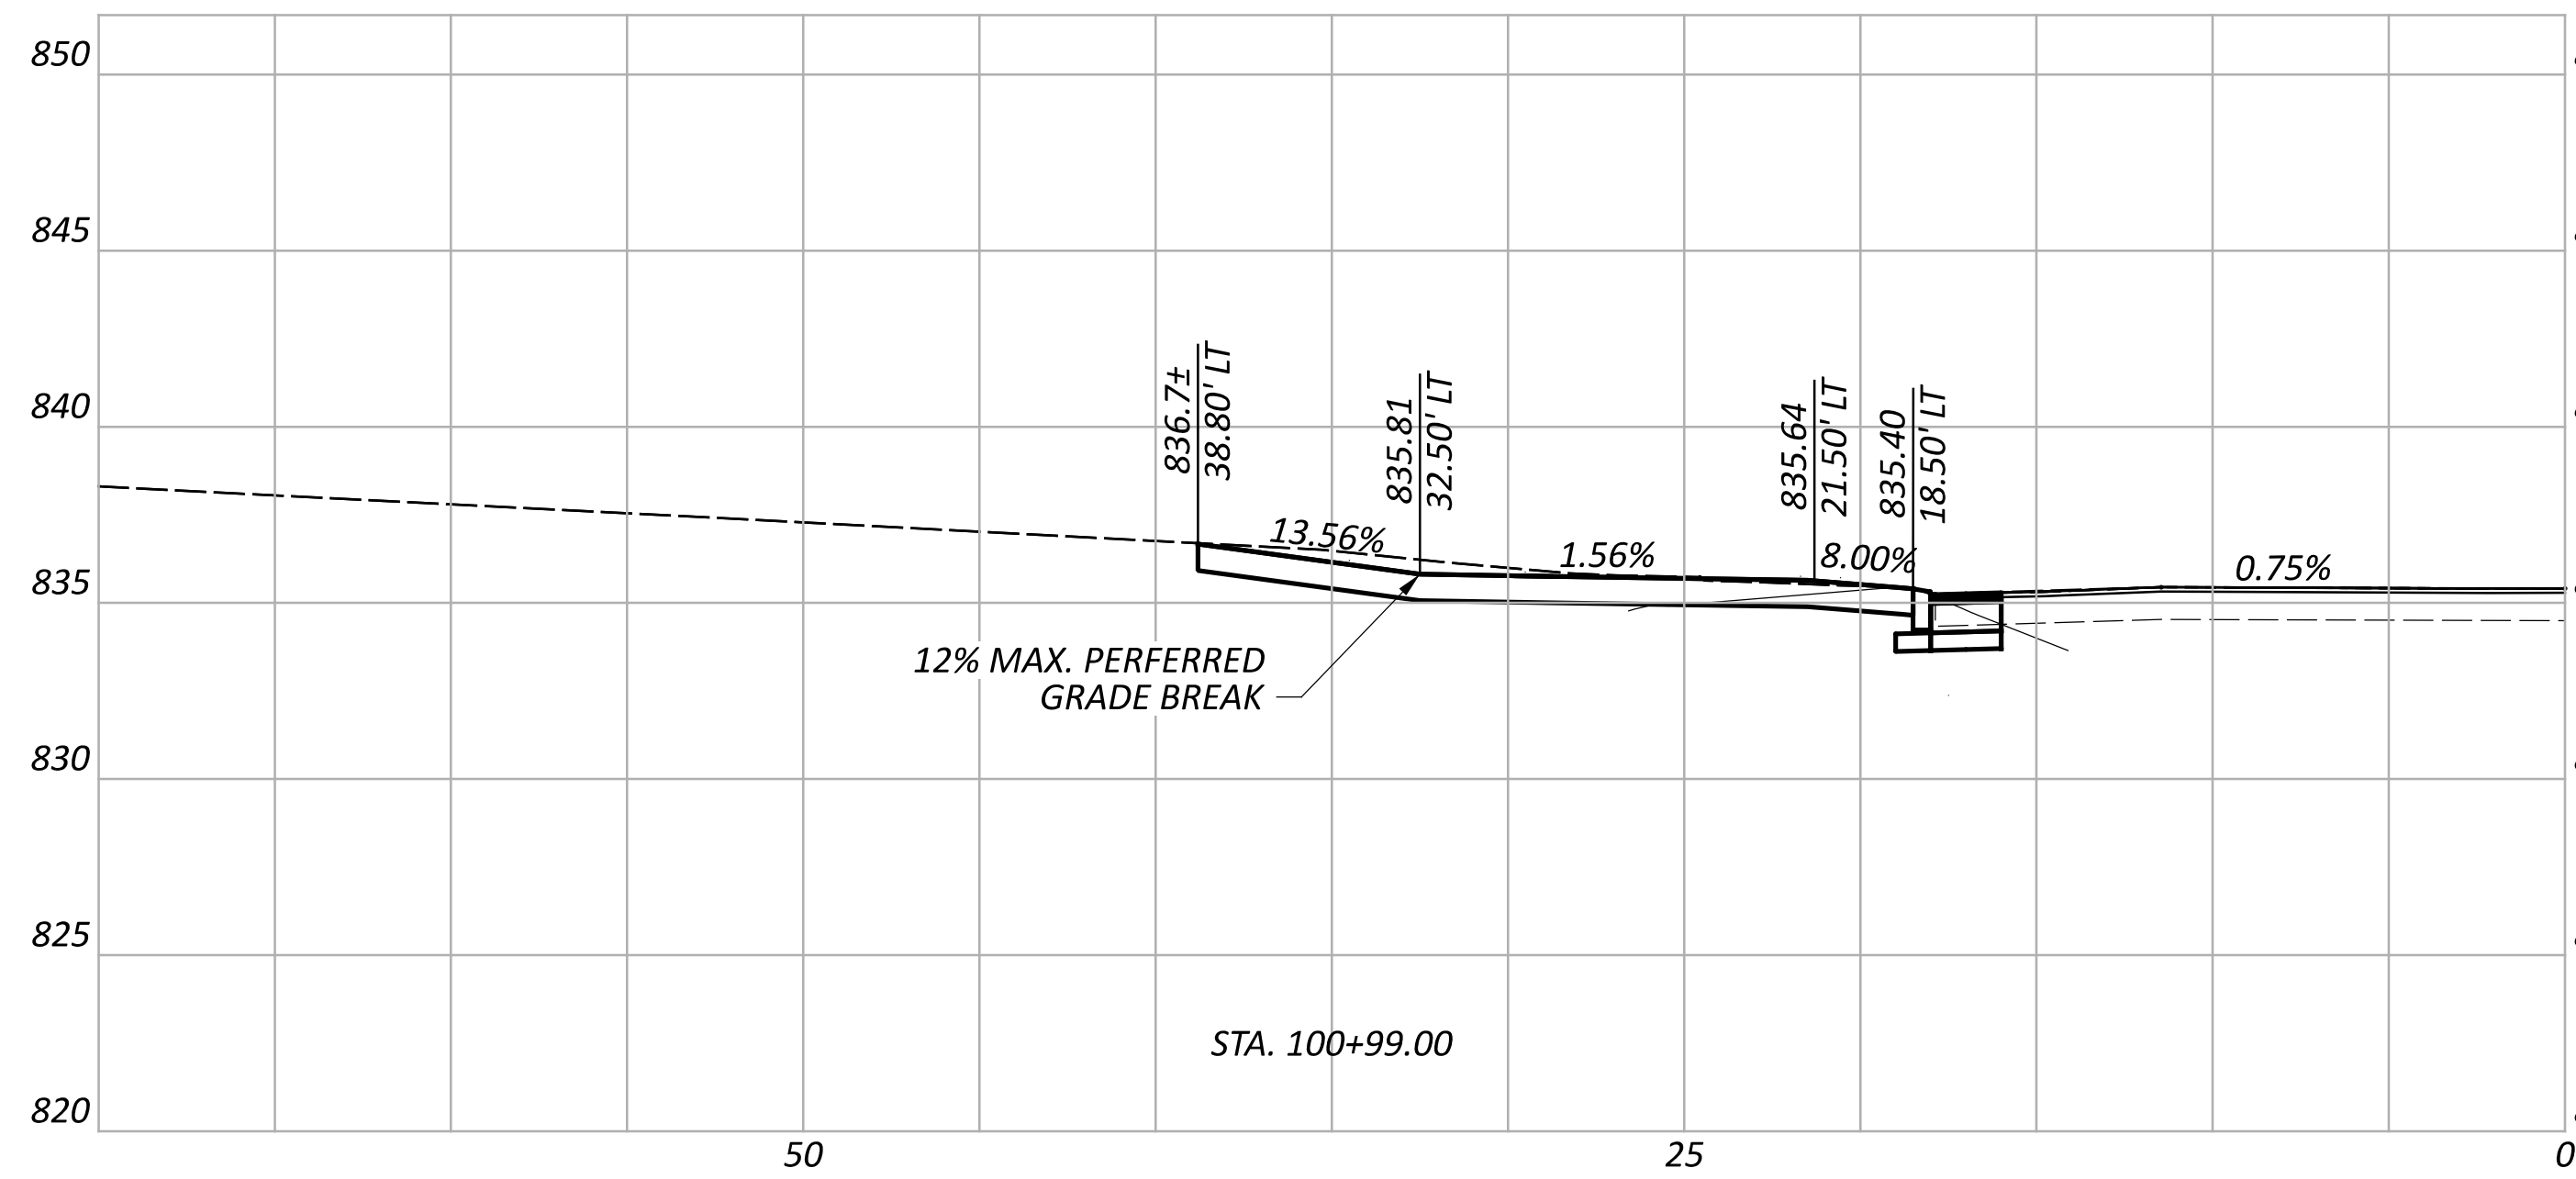


DRIVEWAY DETAILS  
PROFILES

DESIGN AGENCY



DESIGNER	WCS
REVIEWER	BAA 03/28/25
PROJECT ID	115388
SHEET	TOTAL
P.41	P.107

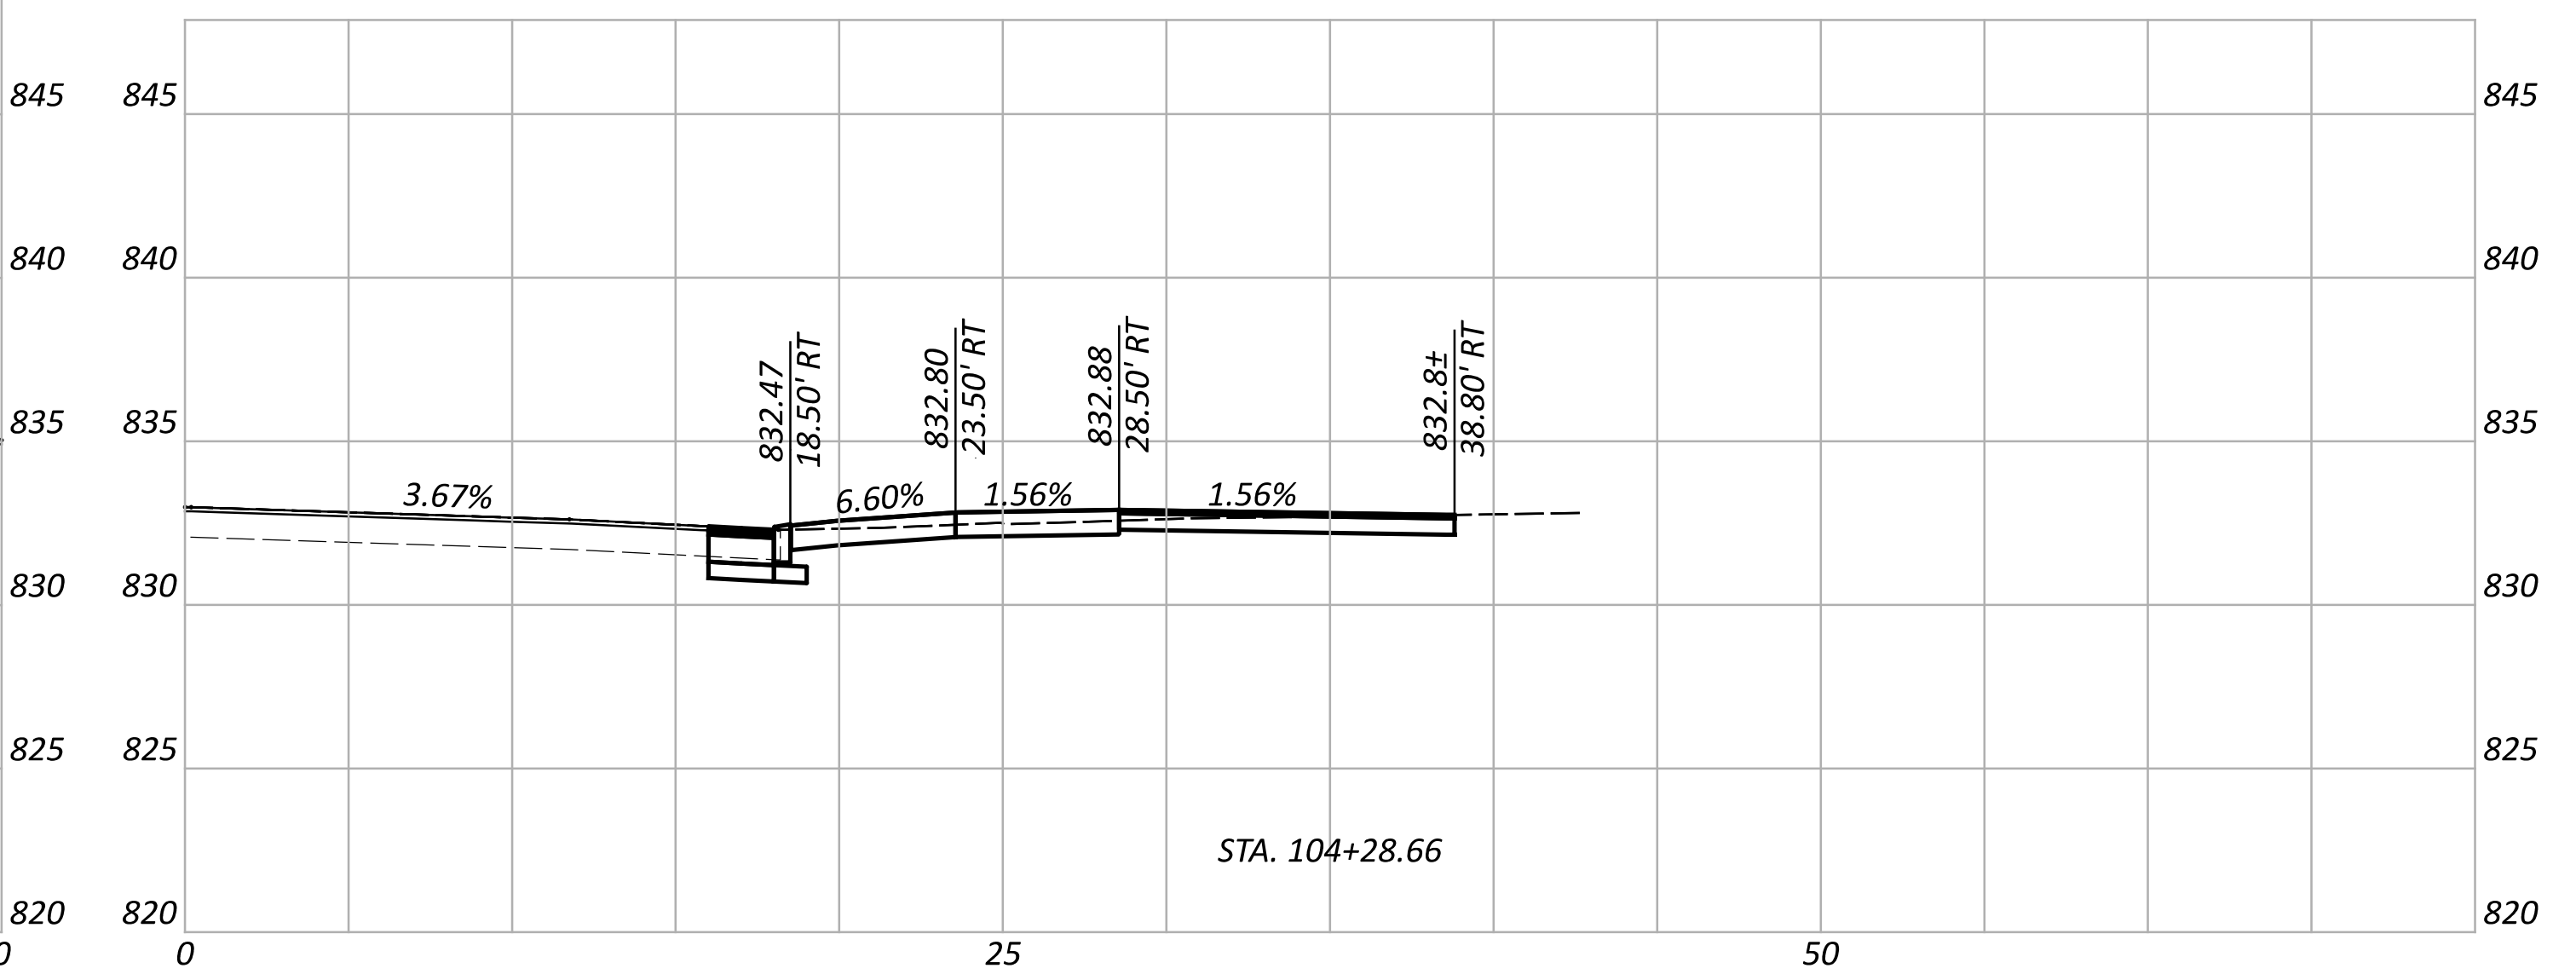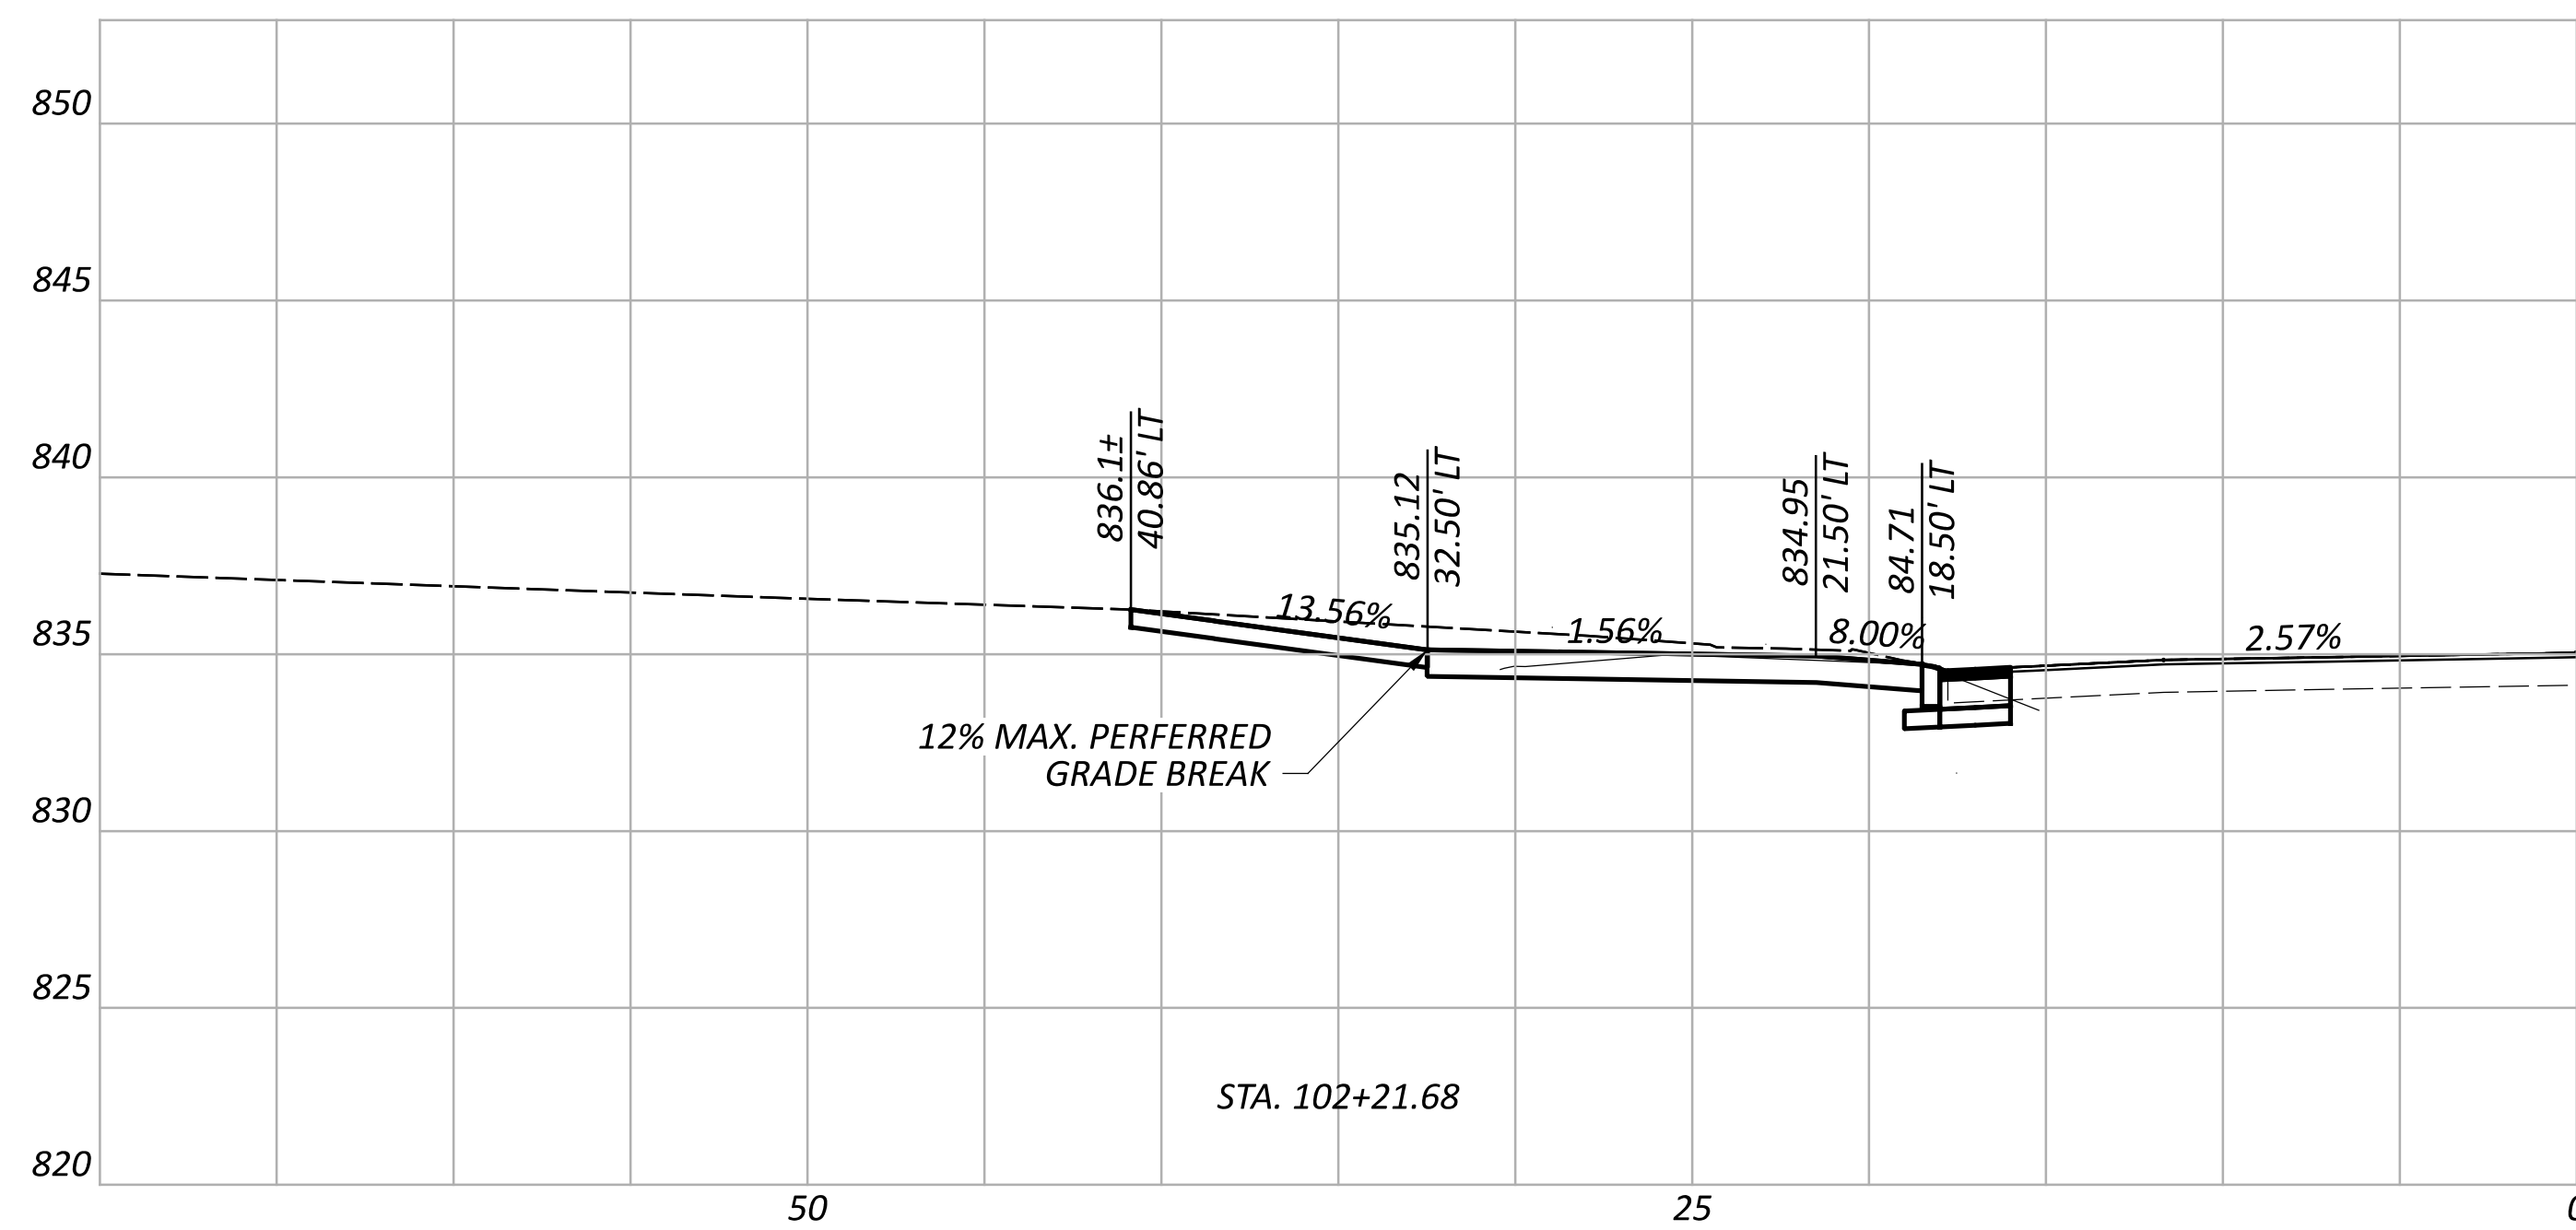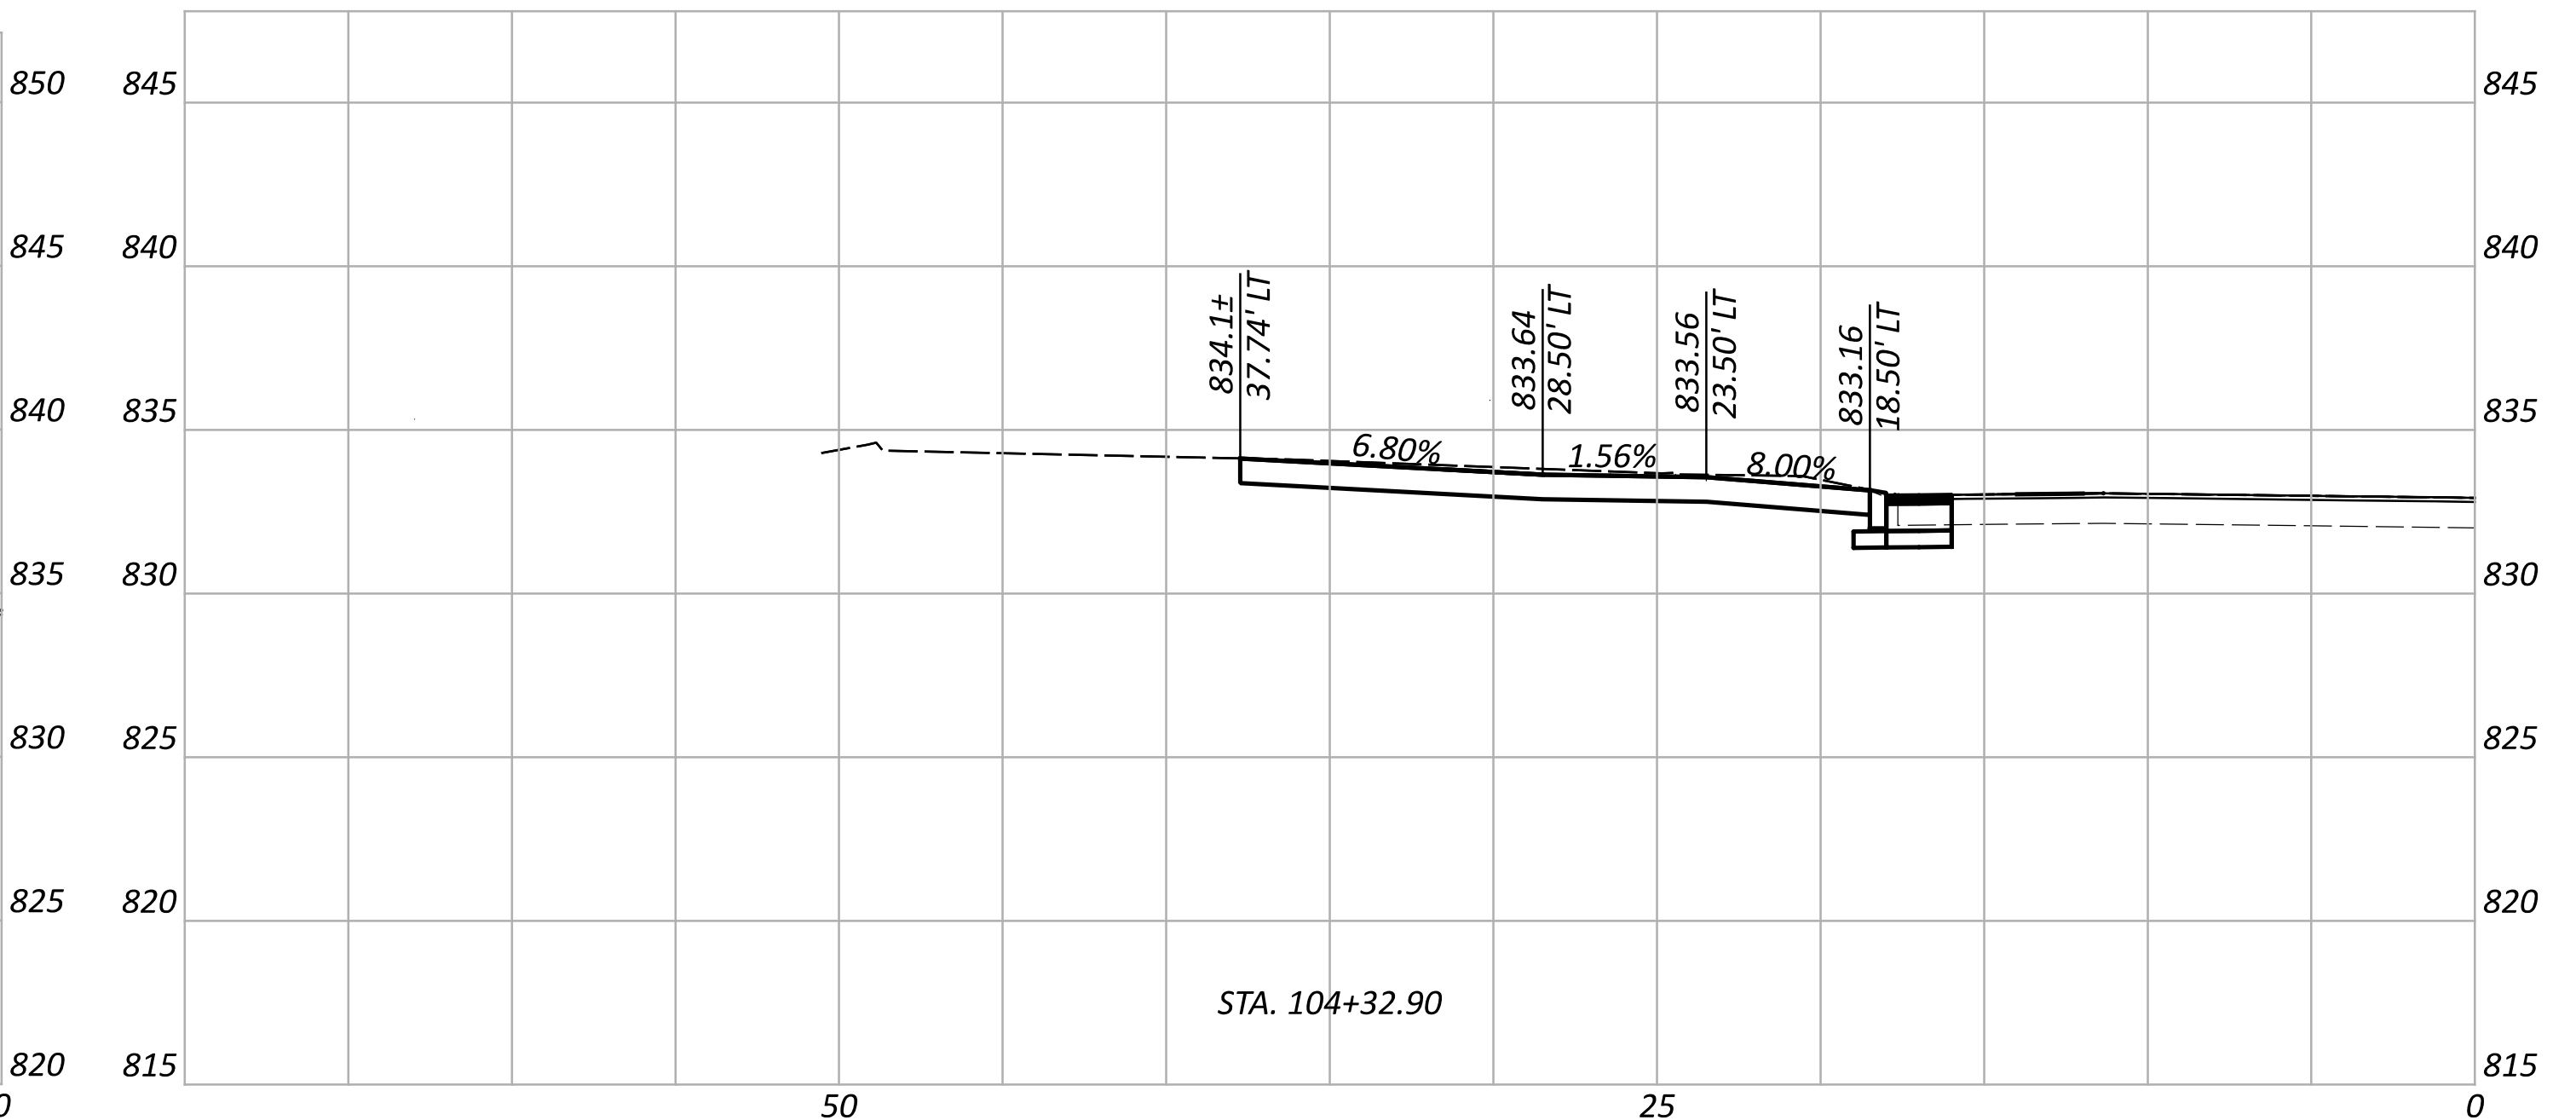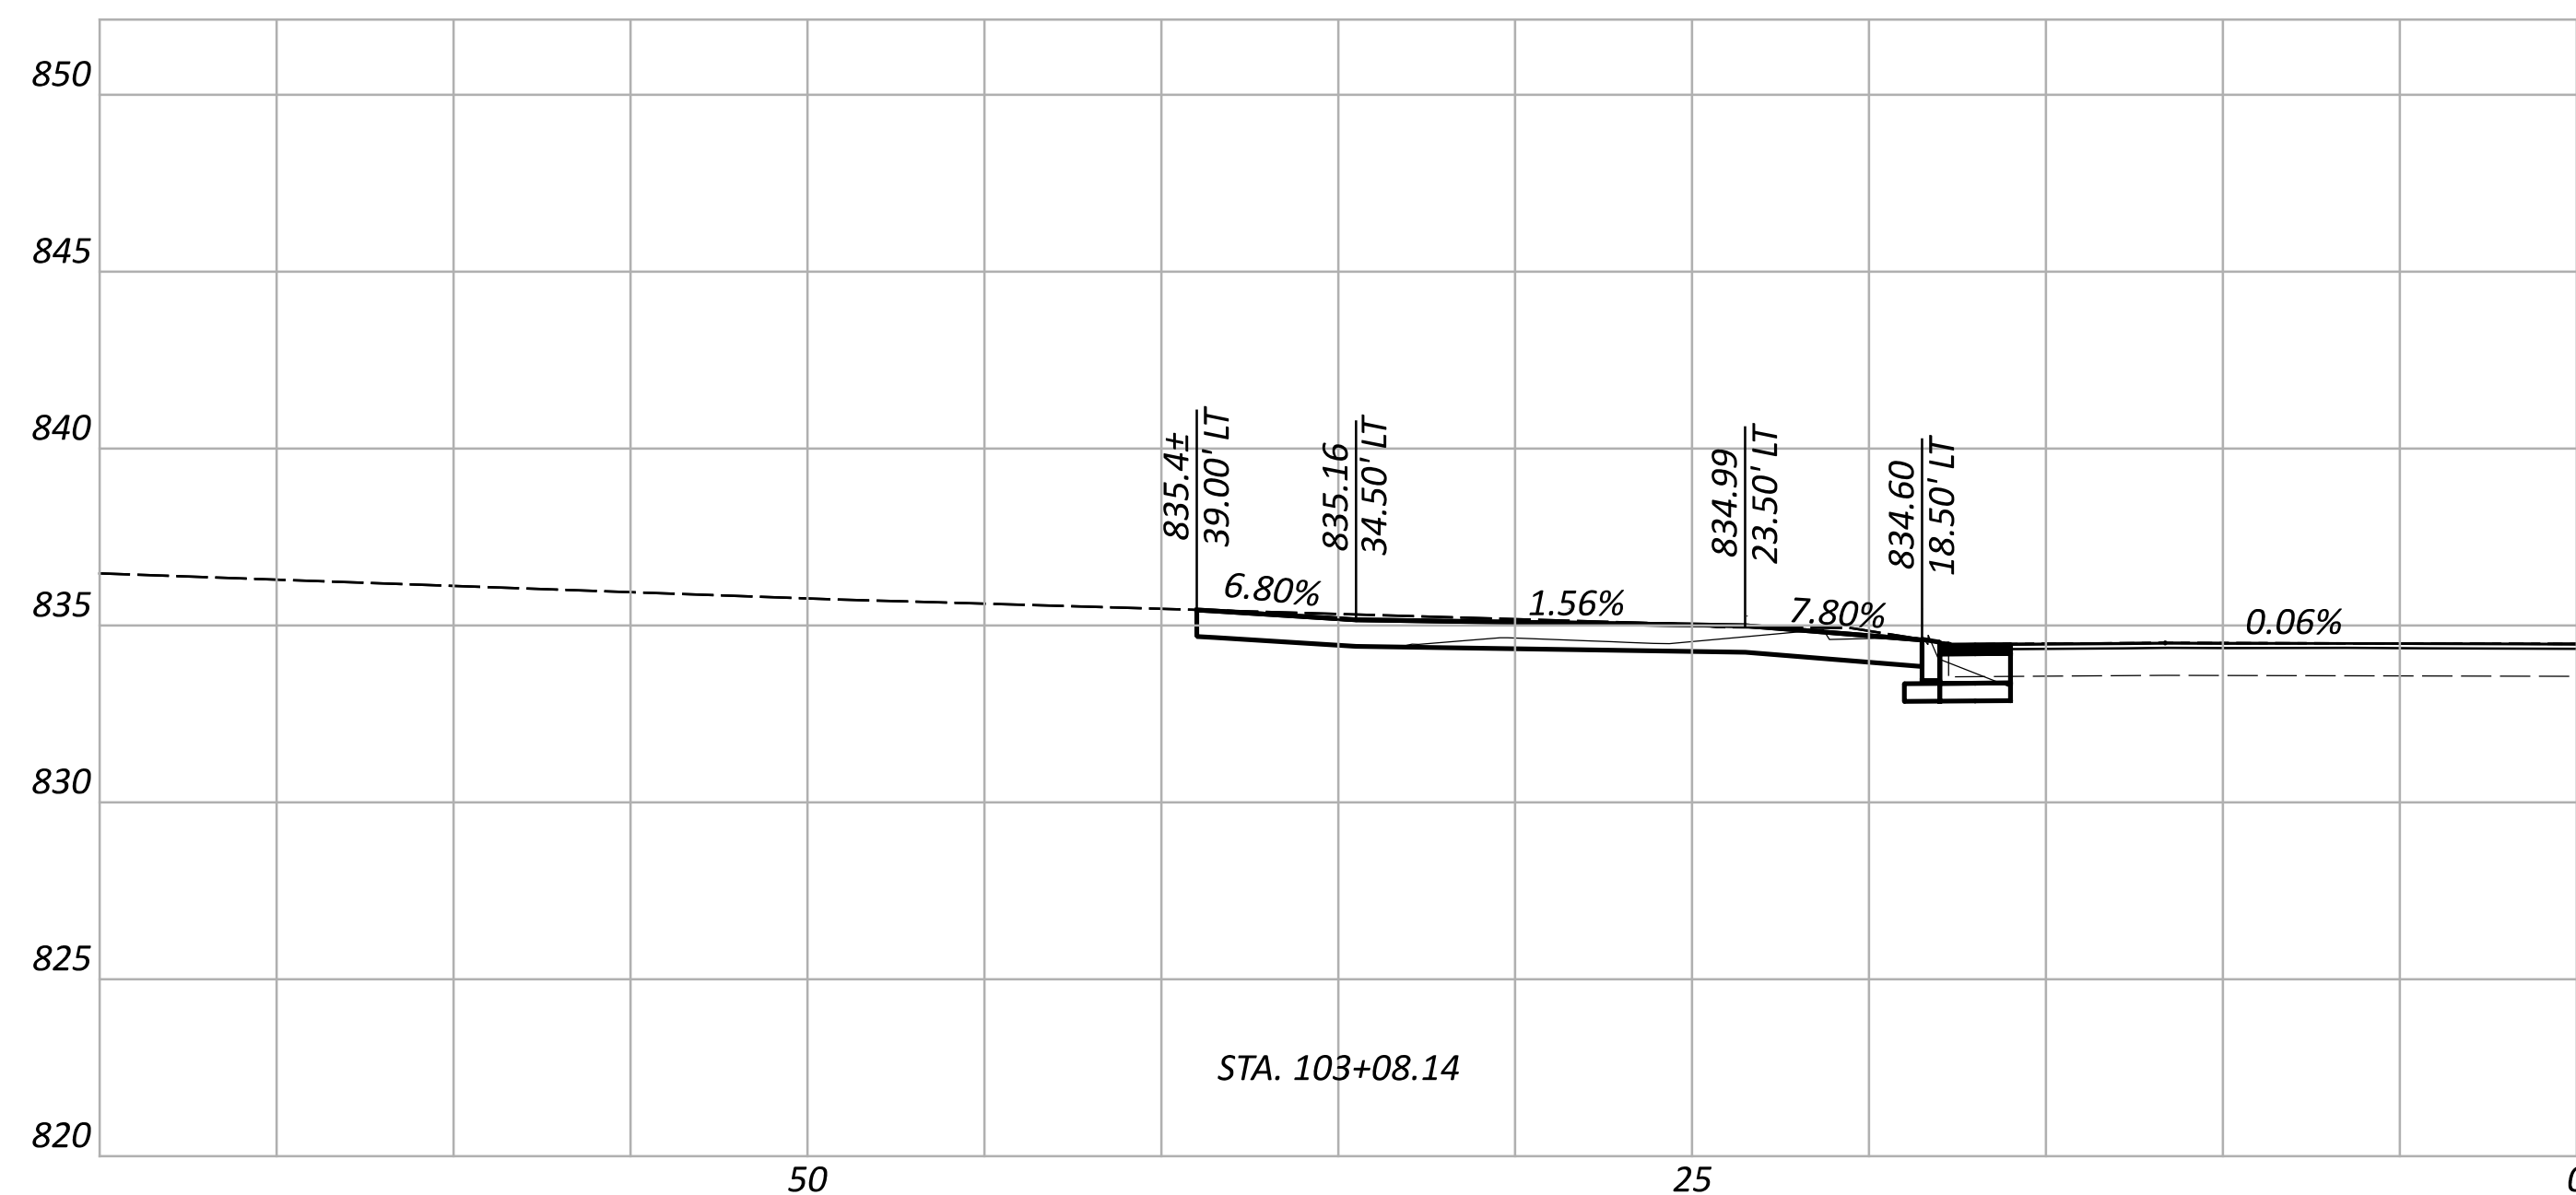

DRIVEWAY DETAILS  
 PROFILES

DESIGN AGENCY






DESIGNER  
 WCS

REVIEWER  
 BAA 03/28/25

PROJECT ID  
 115388

SHEET TOTAL  
 P.42 P.107

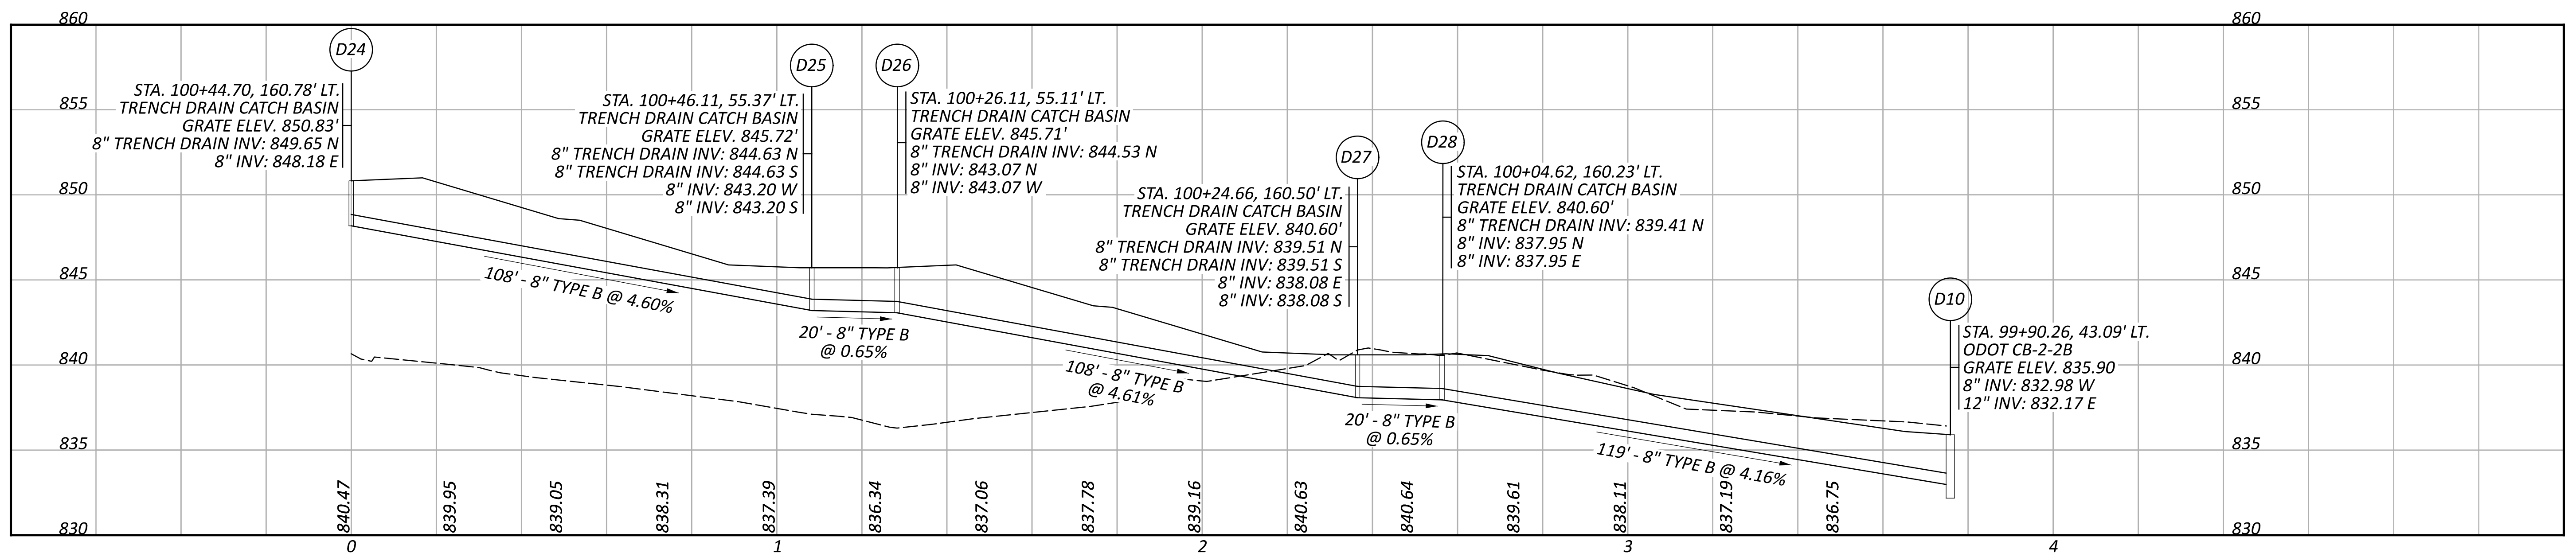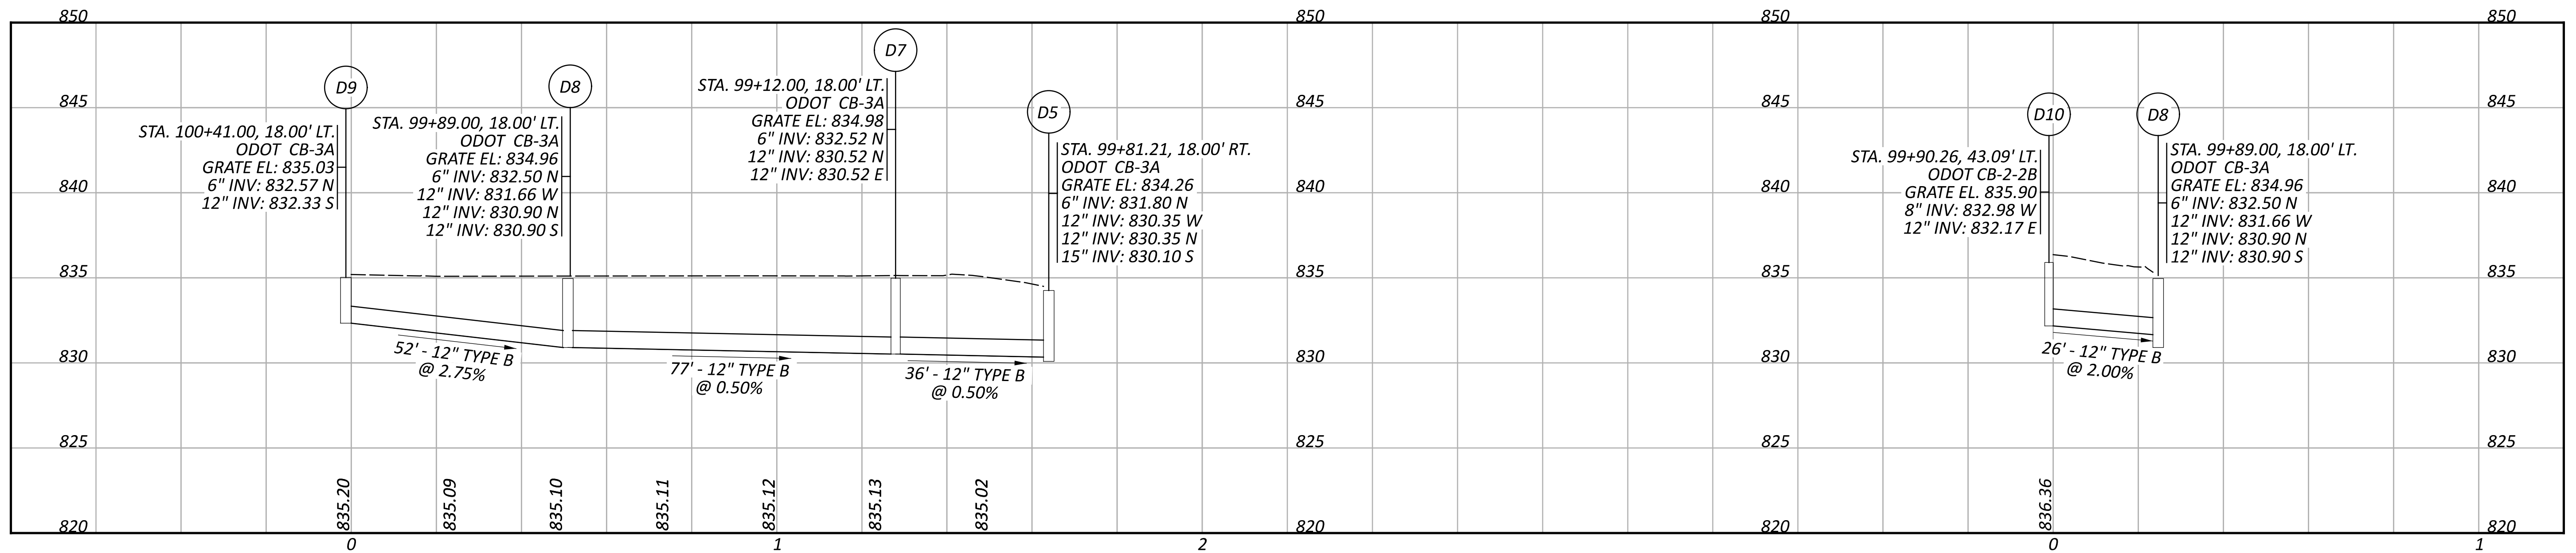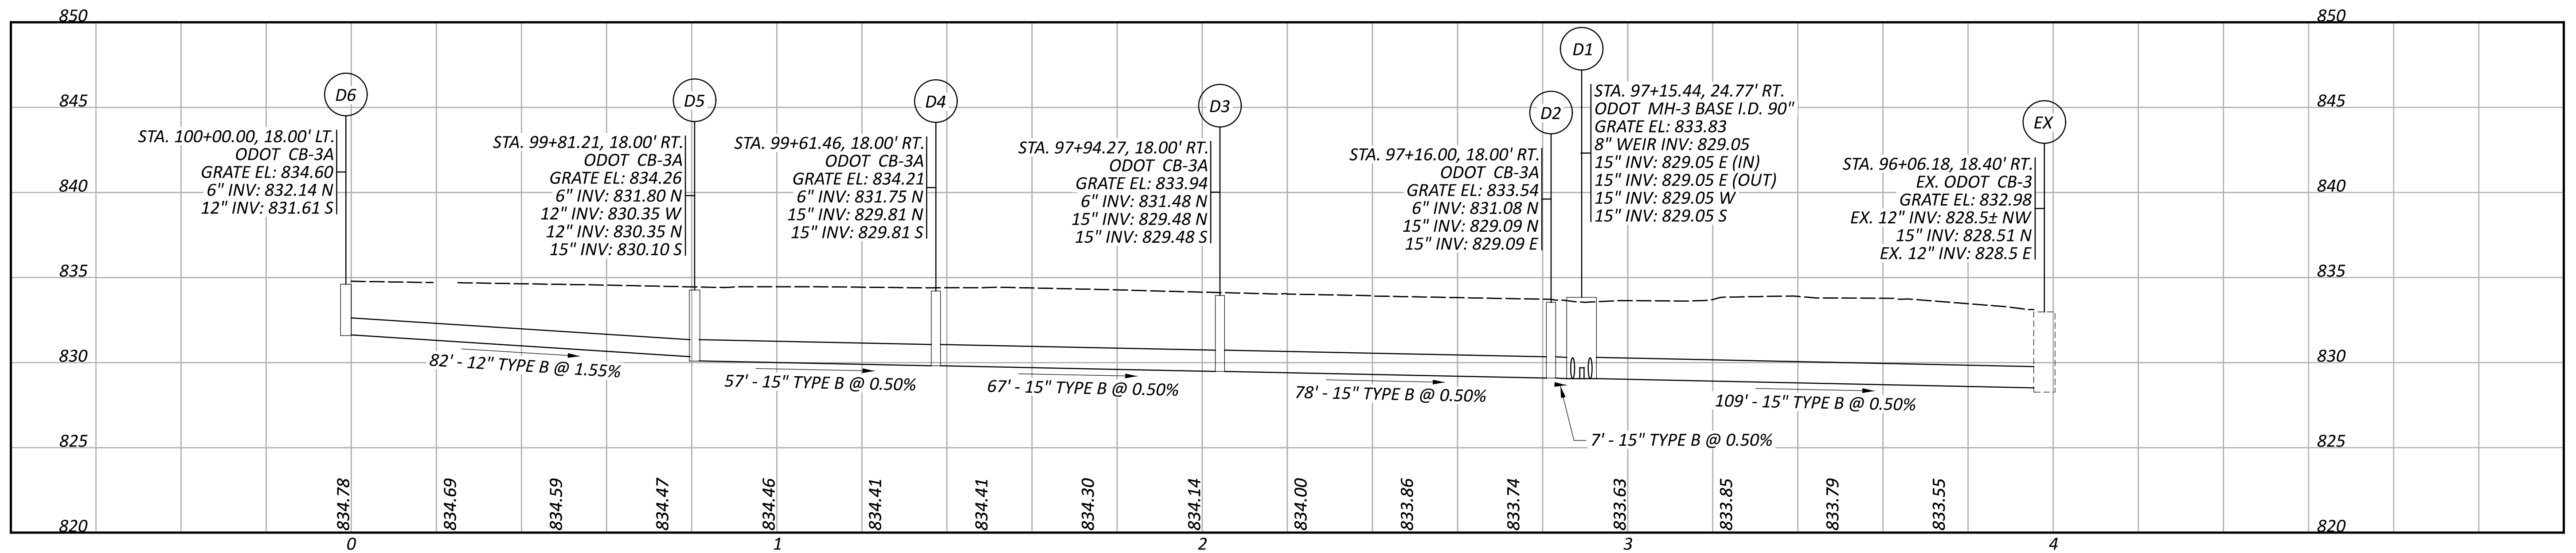

STORM SEWER  
PROFILES

DESIGN AGENCY



DESIGNER

CEF

REVIEWER




BAA 03/28/25

PROJECT ID

115388

SHEET TOTAL

P.43 P.107

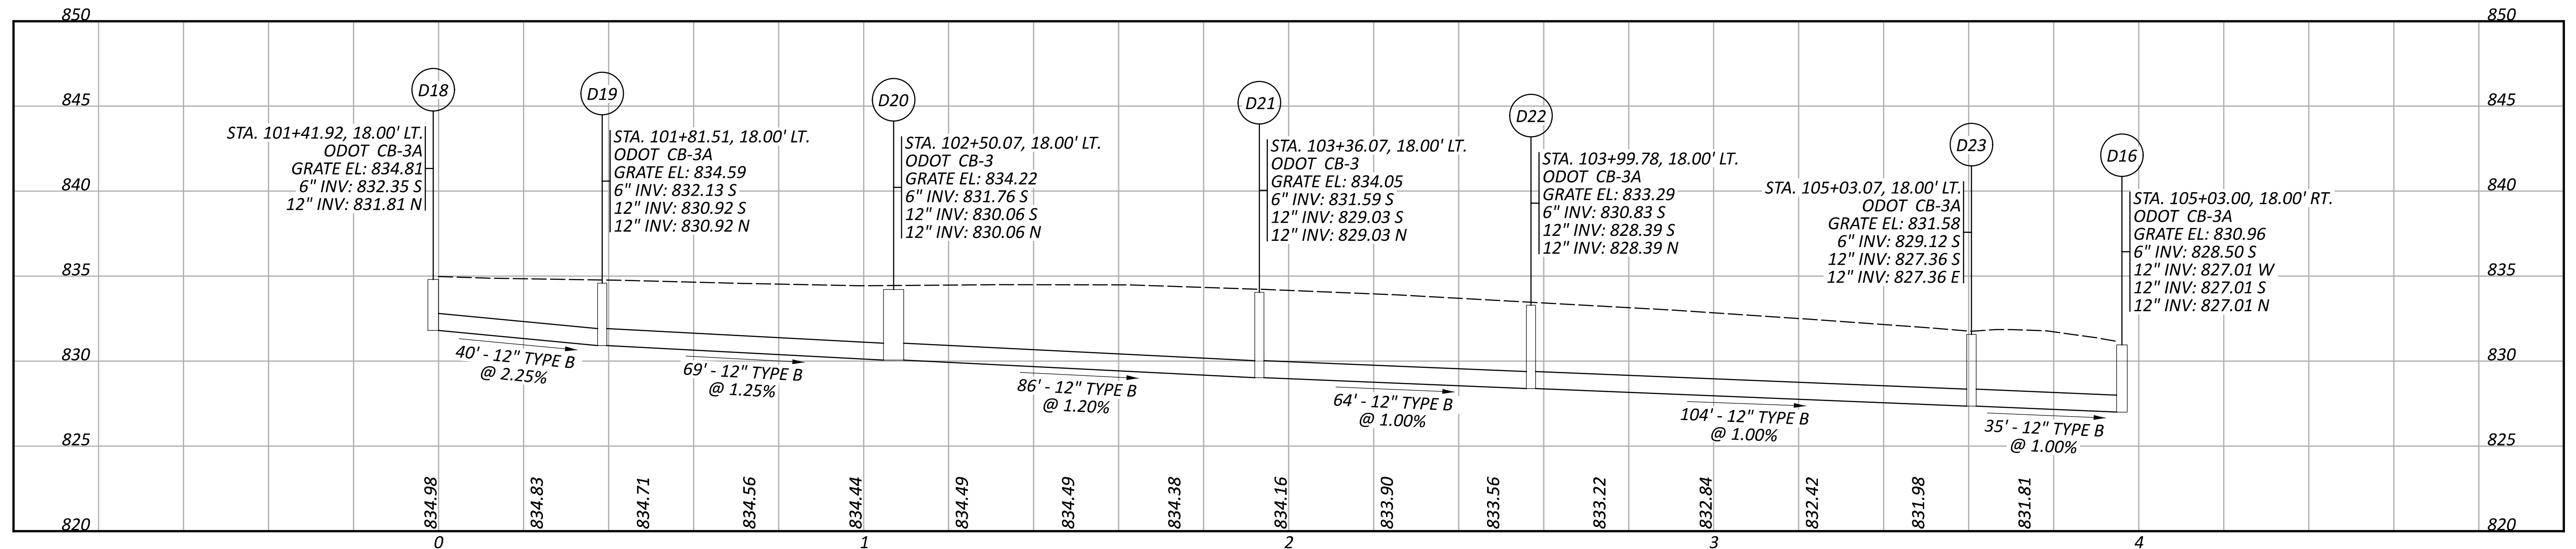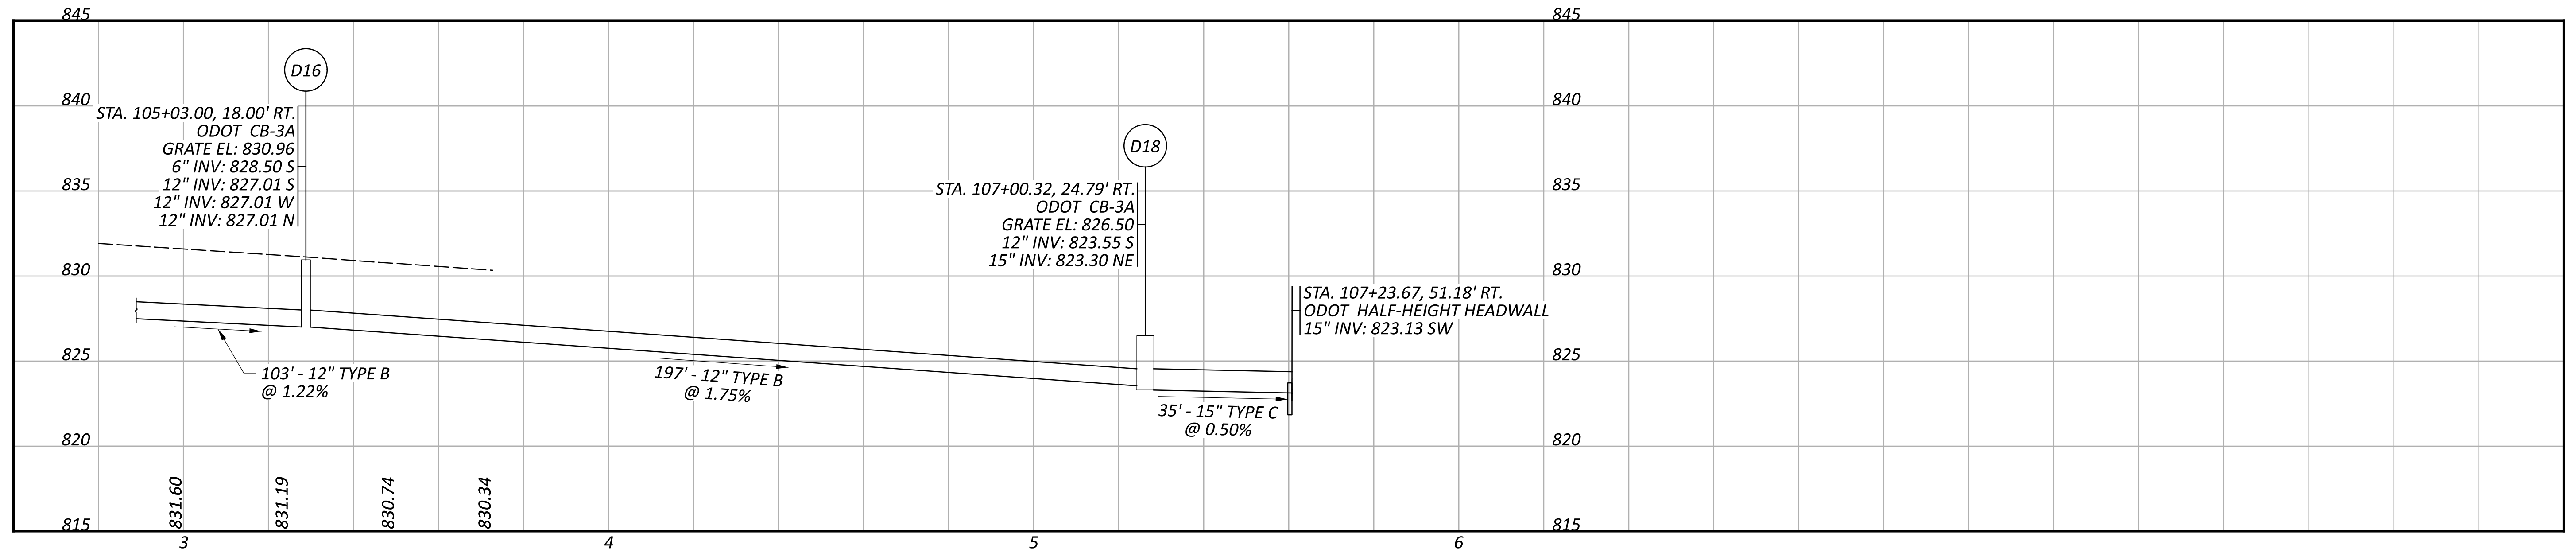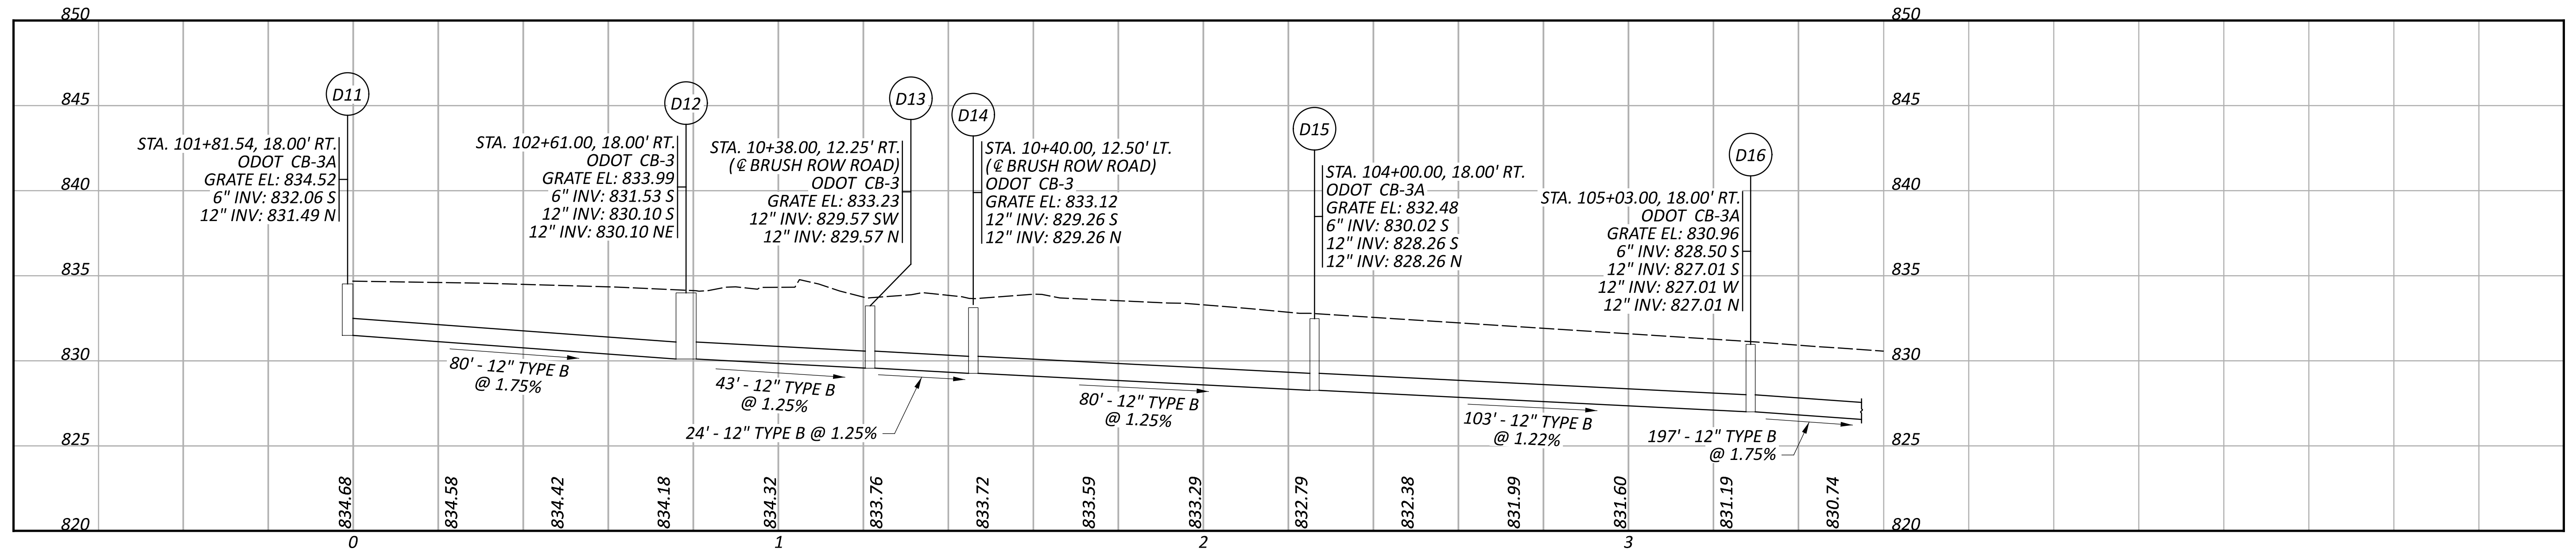

STORM SEWER  
 PROFILES

DESIGN AGENCY



DESIGNER

CEF

REVIEWER

BAA 03/28/25

PROJECT ID



115388

SHEET TOTAL

P.44 P.107

**ITEM 611 - DRAINAGE STRUCTURE, MISC.: POLYMER CONCRETE TRENCH DRAIN SYSTEM**

1. THIS WORK SHALL CONSIST OF FURNISHING AND CONSTRUCTING A TRENCH DRAIN SYSTEM FOR THE SWITCHBACK RAMP. THE WORK INCLUDES ALL NECESSARY EXCAVATION, FRAMES, GRATES, FITTINGS, COUPLING SYSTEMS, CONCRETE BACKFILL, AND ACCESSORIES.
2. ALL WORK SHALL BE PER ODOT SUPPLEMENTAL SPECIFICATION 839 AND 939.
3. THE MANUFACTURER MUST BE CERTIFIED PER ODOT SUPPLEMENT 1073.
4. THE GRATES SHALL BE TYPE B FOR INTERMITTENT, NON-INTENTIONAL TRAFFIC LOADING. THE GRATES SHALL BE ADA COMPLIANT PEDETRIAN SAFE. THE GRATES SHALL FIT INTO THE FRAMES WITHOUT ROCKING OR MOVEMENT AND EITHER BE REMOVABLE OR NON-REMOVABLE. PROVIDE AT LEAST ONE REMOVABLE GRATE WITH CORROSION RESISTANT LOCKING DEVICES EVERY 200-FOOT INTERVAL AT A MINIMUM.
5. THE CHANNEL SECTIONS SHALL BE 8" INSIDE WIDTH AND MINIMUM 12" DEEP, INTER-LOCKING, SLOPED-INVERT, POLYMER-CONCRETE MODULAR UNITS WITH END CAPS. THE CHANNEL SECTIONS SHALL INCLUDE ROUNDED BOTTOM WITH A BUILT-IN INVERT SLOPE OF 0.50 PERCENT MINIMUM. THE OUTLETS SHALL BE PLACED AS SPECIFIED ON THE PLANS. INCLUDE EXTENSION SECTIONS IF NECESSARY FOR THE REQUIRED DEPTH OF THE CATCH BASIN. THE CHANNEL SECTIONS SHALL BE JOINED AND FASTENED AS REQUIRED BY THE MANUFACTURER.
5. THE TRENCH DRAIN SHALL BE SURROUNDED BY A MINIMUM OF 4-INCHES ALONG THE BOTTOM AND 6-INCHES ON EITHER SIDE.
6. A 1-INCH PERFORATED EXPANSION JOINT FILLER (PEJF) SHALL BE PLACED BETWEEN THE CONCRETE PAVEMENT AND TRENCH DRAIN AS WELL AS THE RETAINING WALL AND TRENCH DRAIN AS SHOWN ON THE DETAIL ON THIS SHEET.

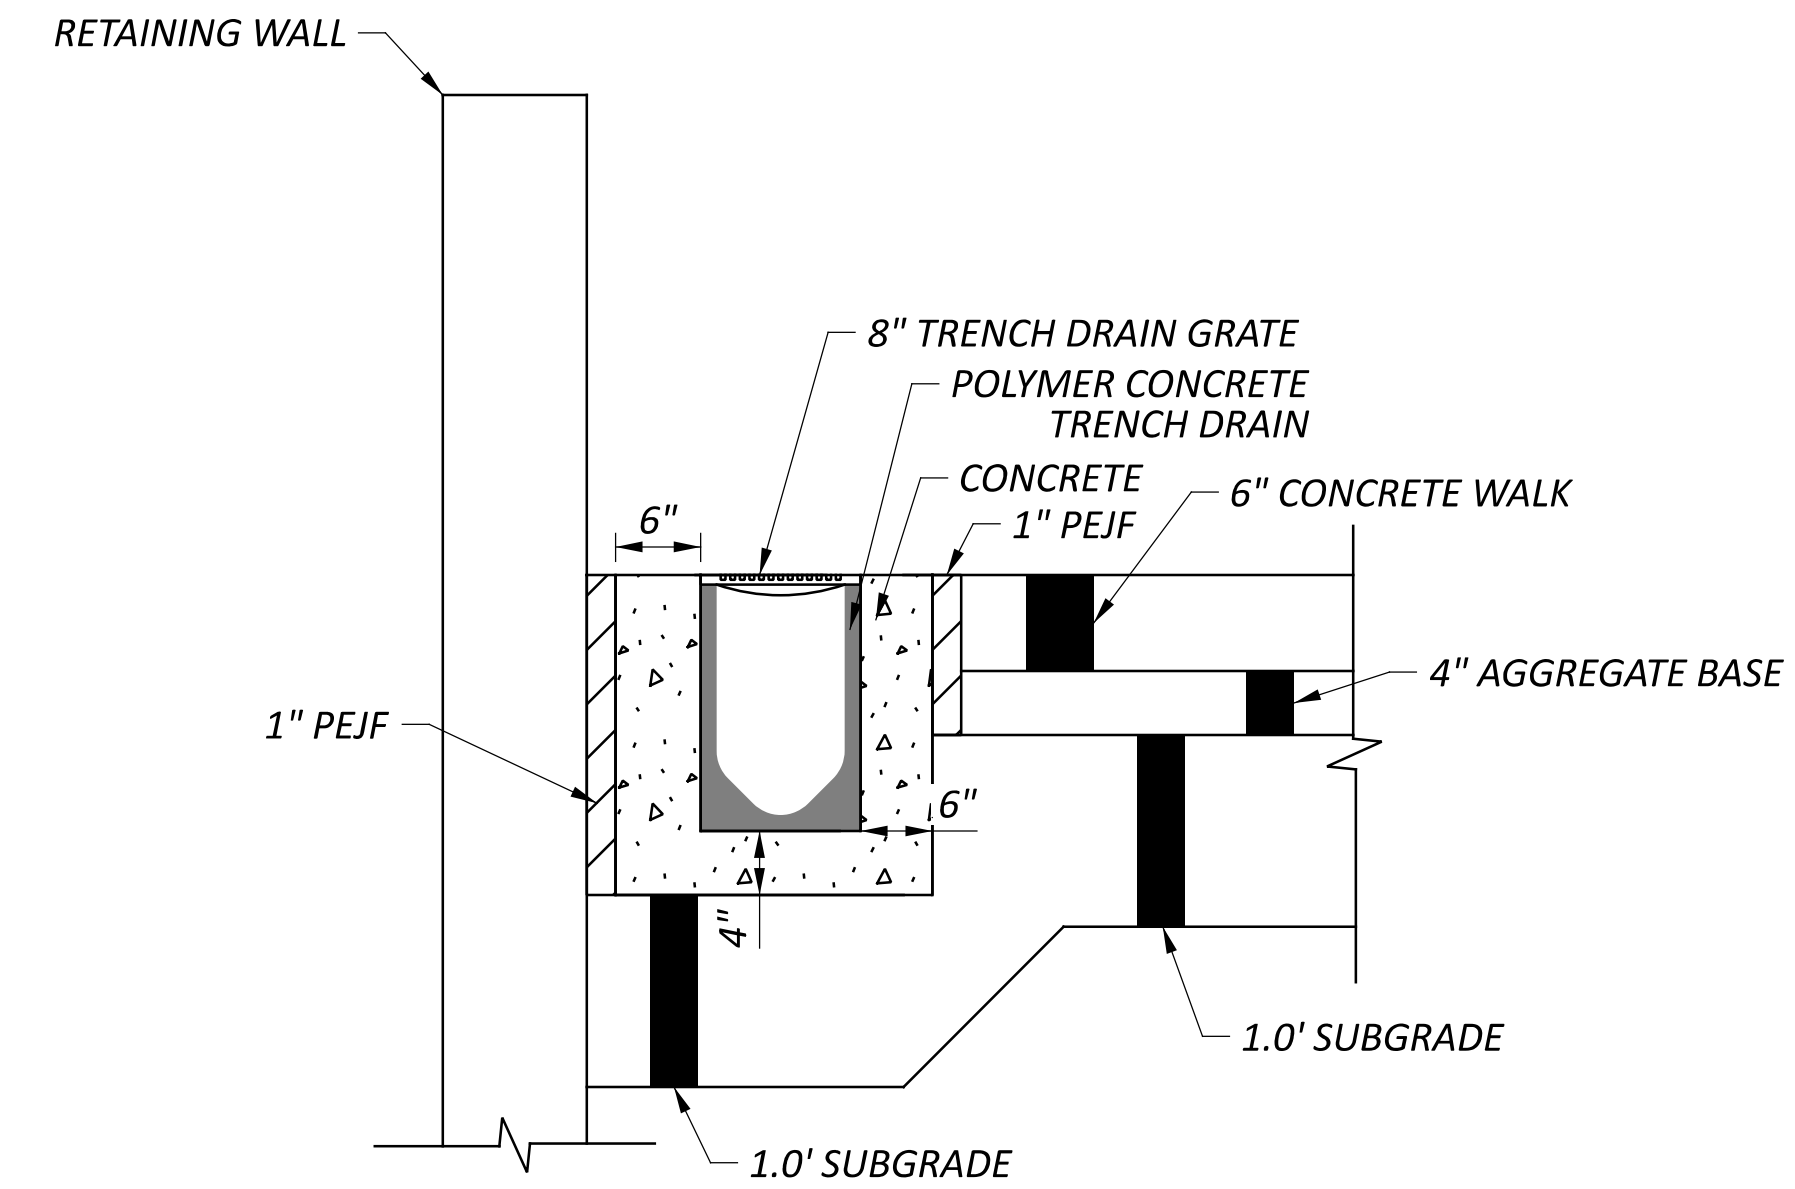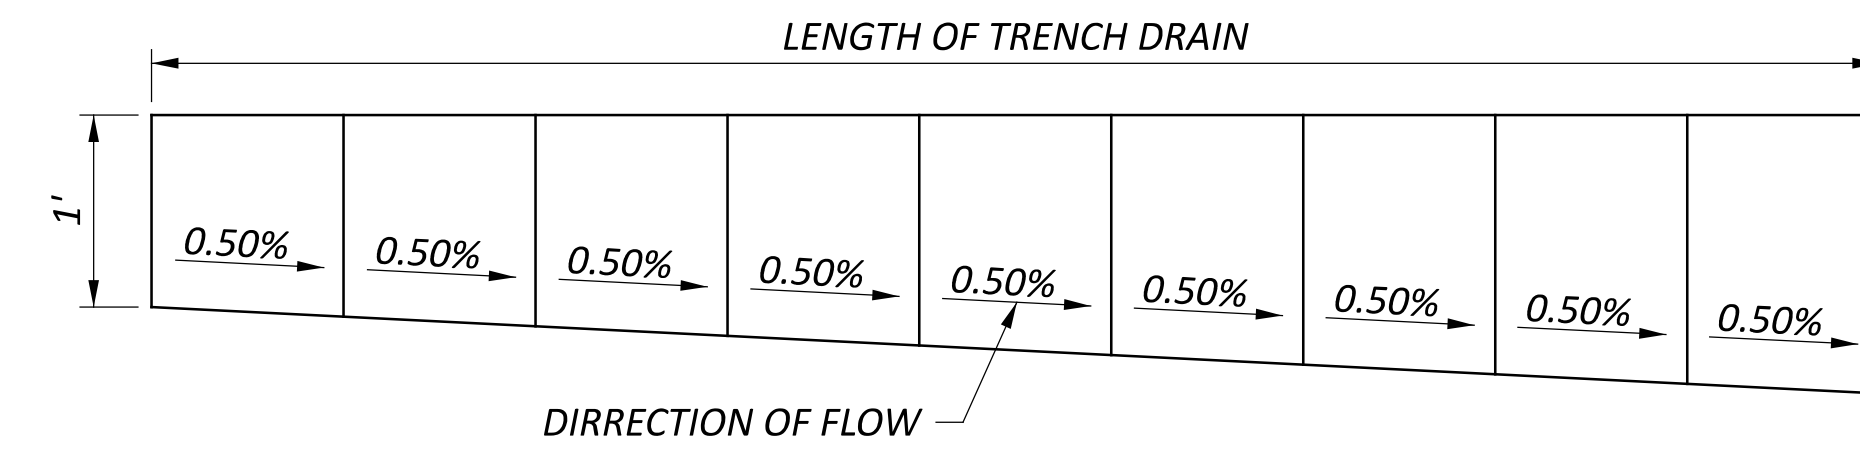


**TRENCH DRAIN SECTION DETAIL**

**MAKE OF HYDRANTS APPROVED IN XENIA**

1. MUELLER SUPER CENTURION A-423
2. CLOW MEDALLION
3. KENNEDY GUARDIAN K-81



**HYDRANT DATA**

- NOTE:
- 1) USE ANCHOR PIPE BETWEEN VALVE AND HYDRANT
  - 2) NO THRUST BLOCKING
  - 3) HYDRANTS SHALL BE YELLOW
1. ALL VALVES AND HYDRANTS "RIGHT TO OPEN"
  2. 5.25 VALVE OPENING
  3. 3 NOZZLES (2)2.5 & (1)5 STORZ
  4. ALL THREADS ARE NATIONAL STANDARD
  5. 1.5 INCH FIVE SIDED OPERATING NUT
  6. ALL HYDRANTS TO BE TRAFFIC MODEL
  7. HYDRANT TO BE YELLOW IN COLOR
  8. SELF DRAINING
  9. 5 1/2" LOWER BARRELL SECTION

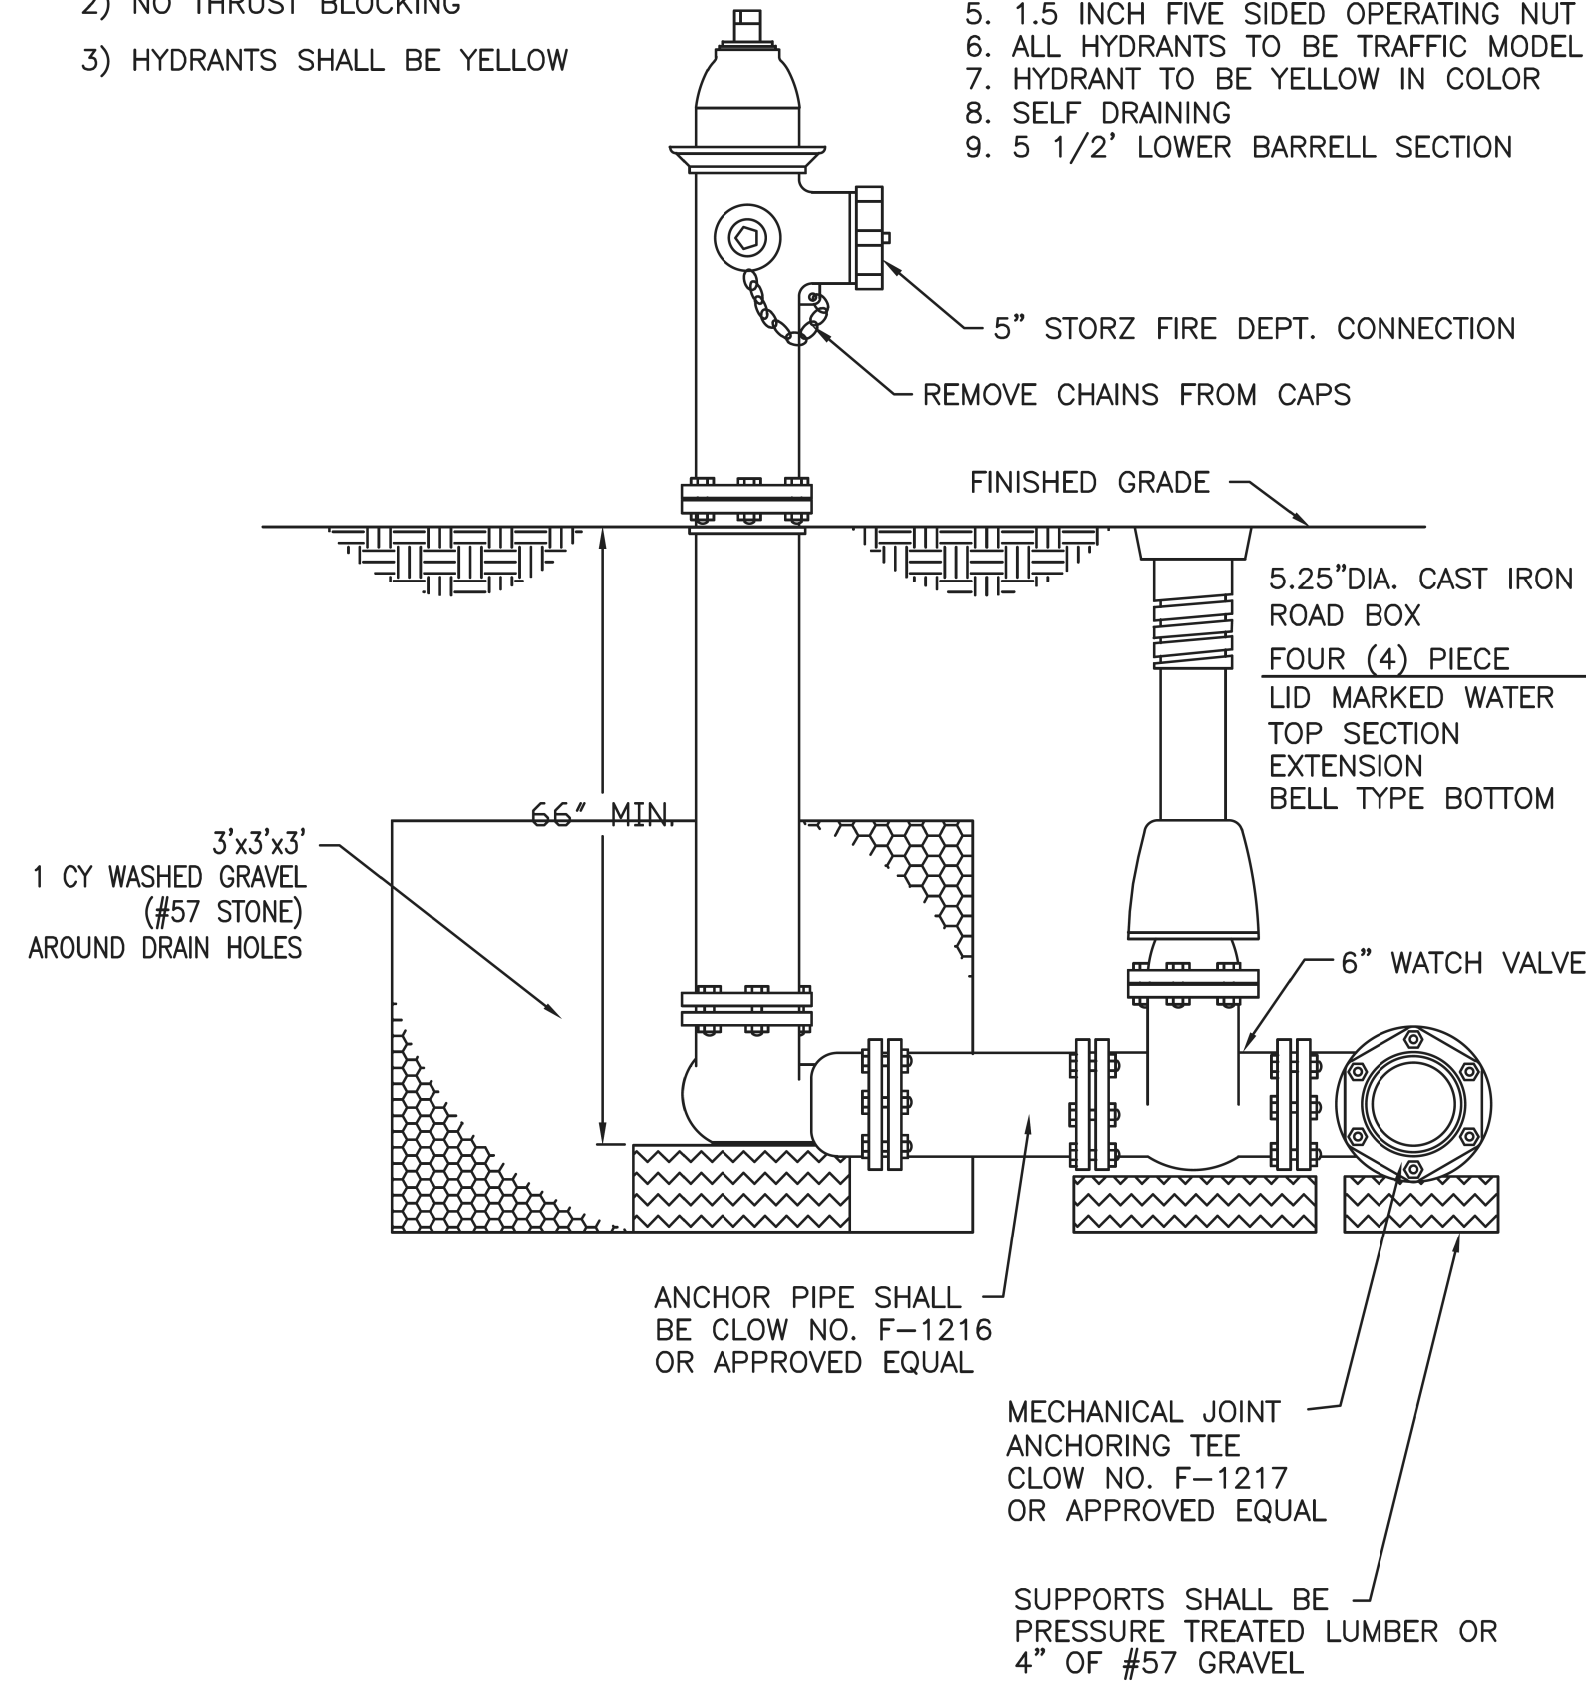

City of Xenia, Ohio  
 Standard Construction Drawings  
 Fire Hydrant Assembly

STANDARD  
**STD-103**  
 EDITION  
**2022**

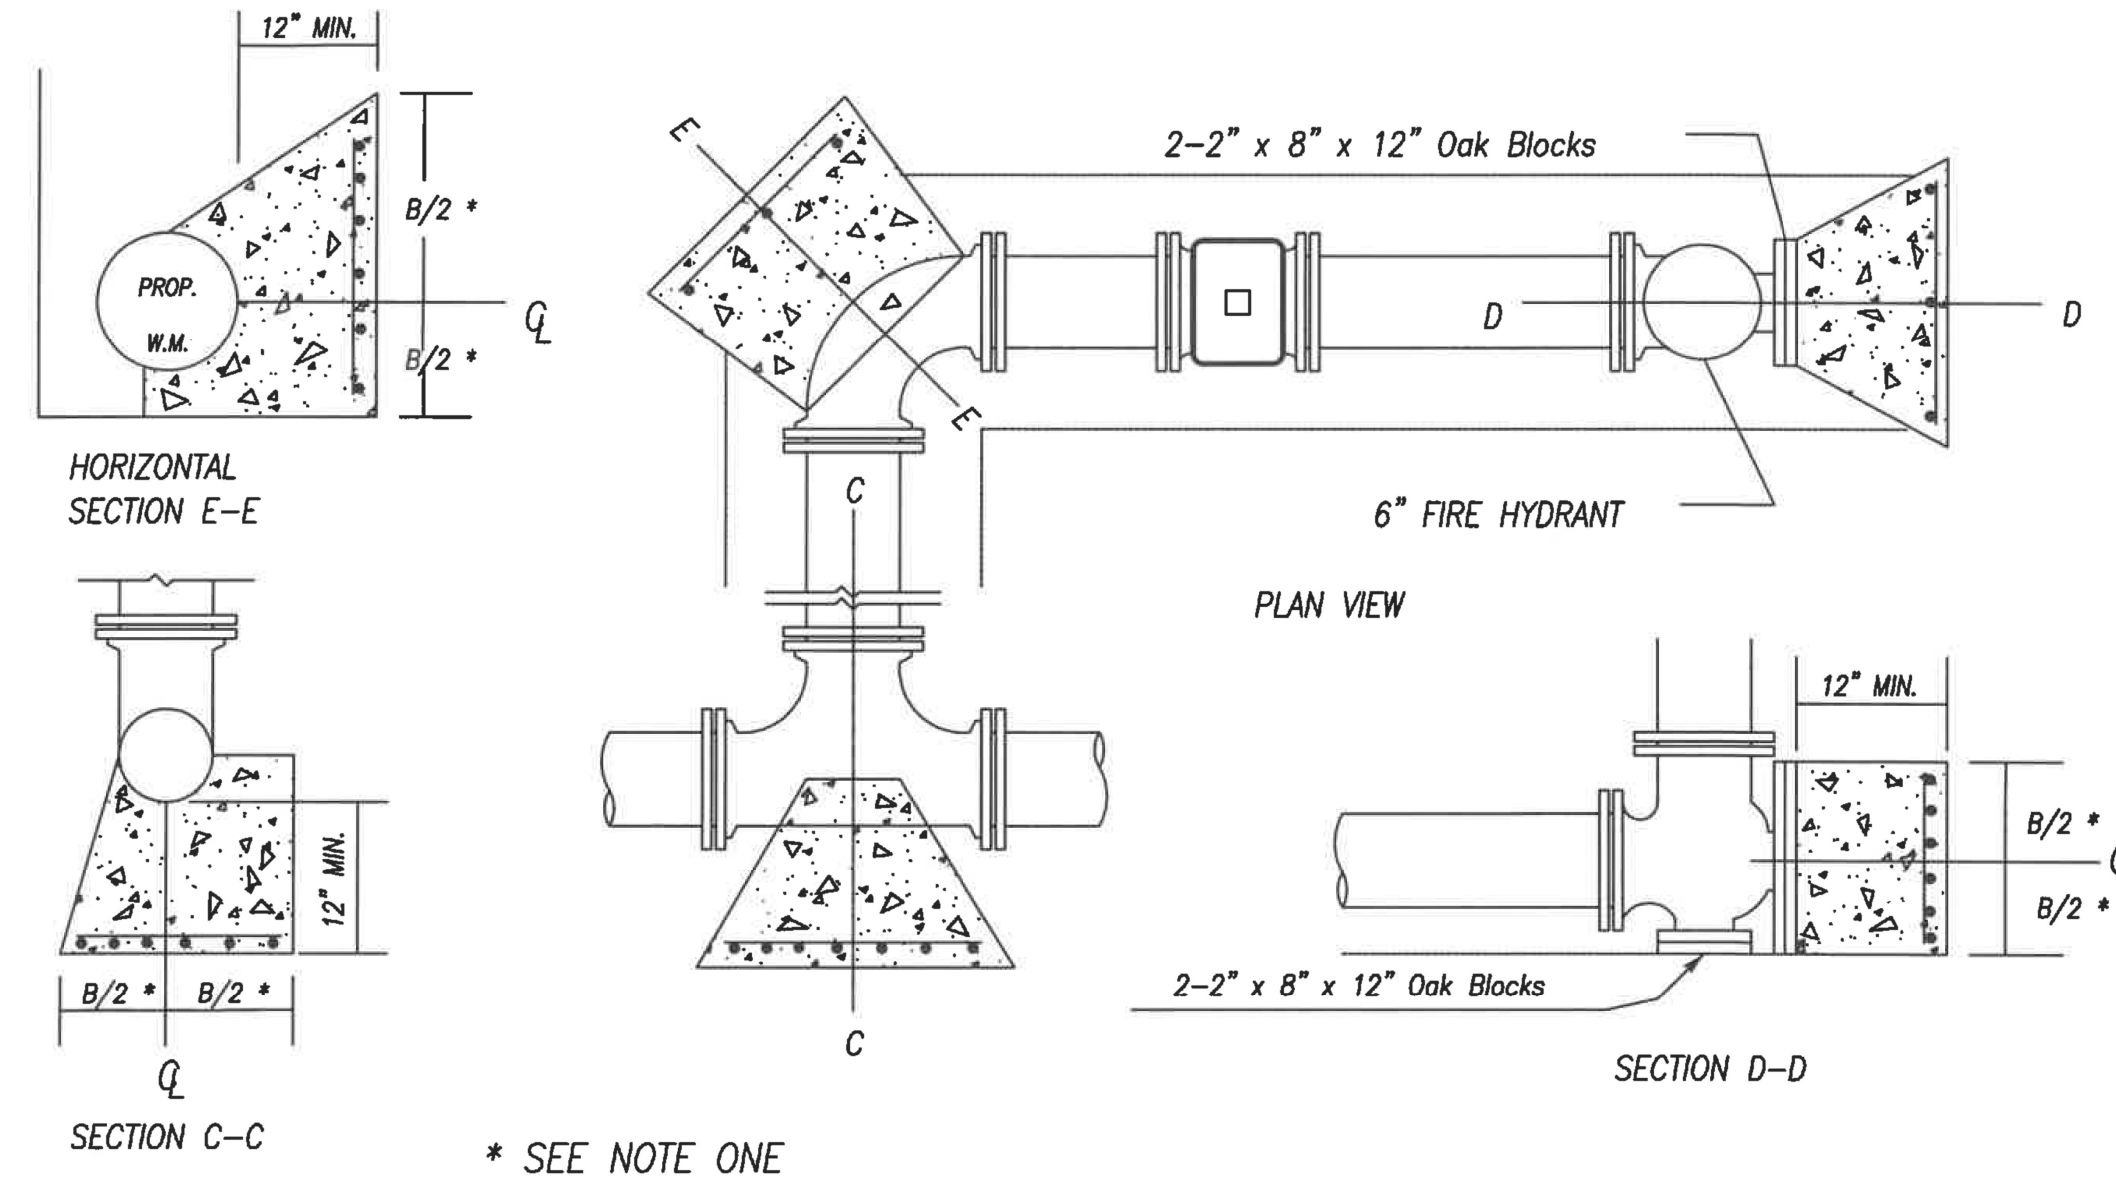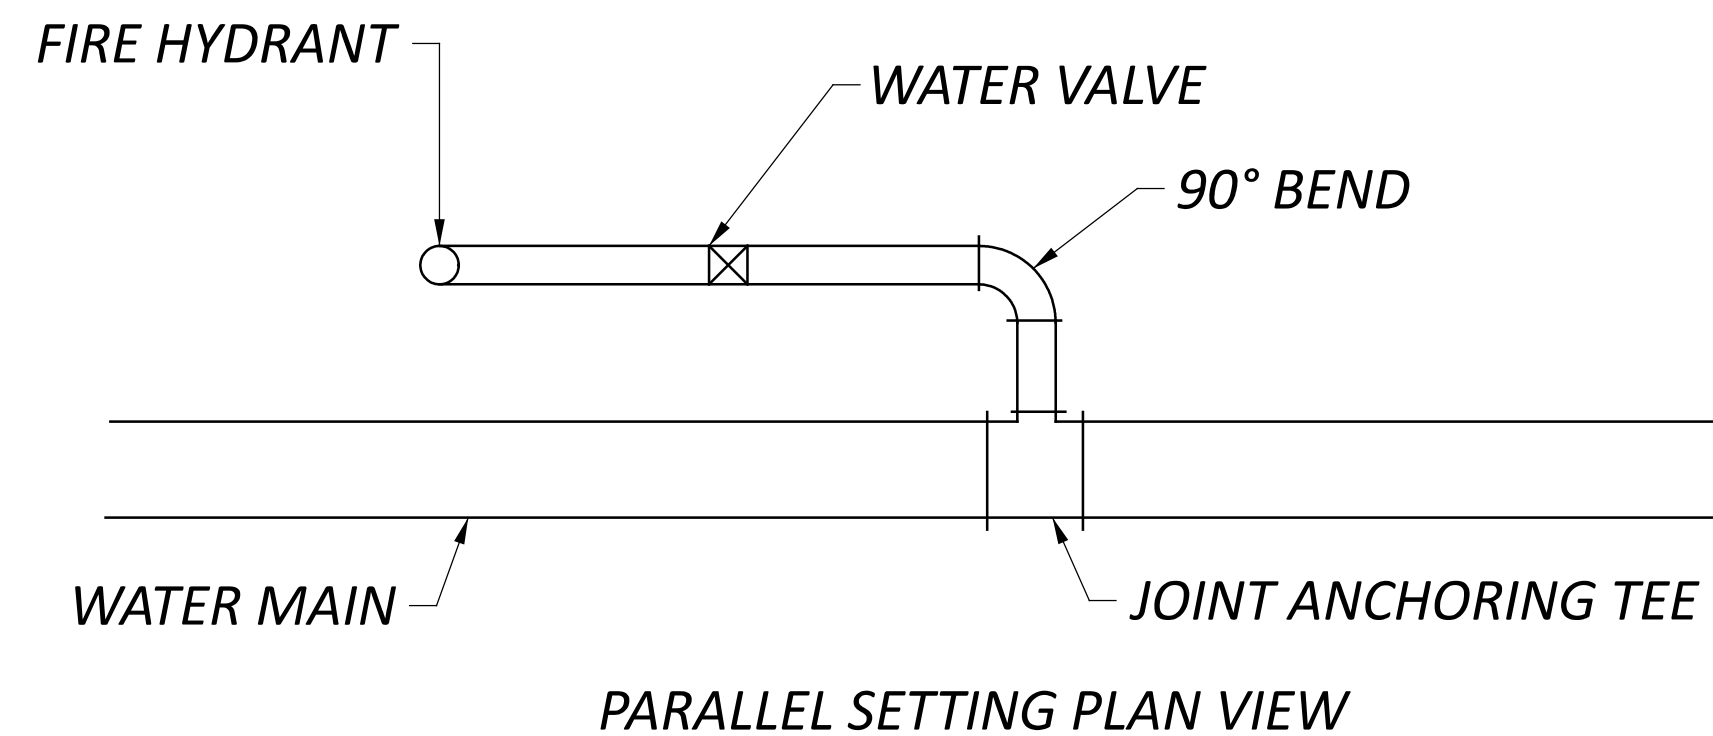


NOTE:


1. REFER TO STANDARD DRAWING NO. 101-5 FOR PLACEMENT OF REINFORCING STEEL AND BLOCKING DETAILS.
2. CONCRETE BLOCKING TO BE POURED AGAINST UNDISTURBED EARTH ON THE THRUST SIDE.
3. IN LIEU OF STEEL REINFORCING BARS, THE CONTRACTOR HAS THE OPTION TO USE WELDED WIRE FABRIC SHEETS (12 X 12 - W 5.8 X W 5.8) @ 42 LBS. PER 100 S.F.



CONCRETE BLOCKING FOR FITTINGS			
FIRE HYDRANT BLOCKING			
APPROVED	DATE	STANDARD DRAWING	
<i>[Signature]</i>	1/4/13	101-7	

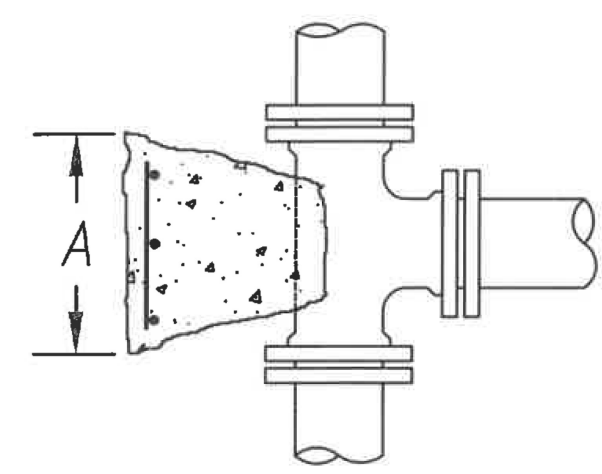

3/4" REINFORCING BARS TO BE PLACED ON THRUST SIDE 6" O.C.

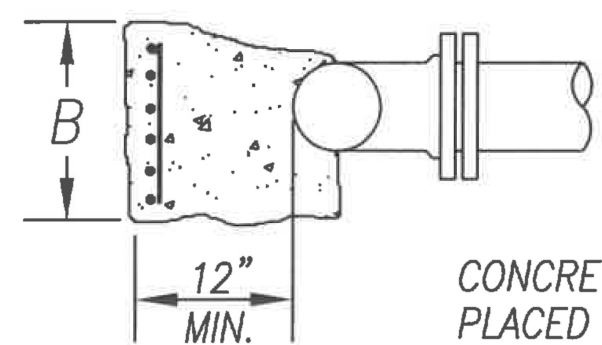

CONCRETE BLOCKING TO BE PLACED AGAINST UNDISTURBED EARTH.

NOTE:

THIS STD. DWG. SHALL BE UTILIZED FOR BLOCKING OF TEES, 90° BENDS, FIRE HYDRANTS, AND PLUGS

SIZE		75 P.S.I. & UNDER				75 P.S.I. TO 125 P.S.I.				125 P.S.I. TO 200 P.S.I.			
RUN	BRANCH	A	B	CU. YDS. CONC.	LBS. STEEL	A	B	CU. YDS. CONC.	LBS. STEEL	A	B	CU. YDS. CONC.	LBS. STEEL
6"	6"	1'9"	1'6"	0.1	17	2'6"	1'6"	0.1	23	2'6"	2'0"	0.2	30
8"	6"	1'6"	1'9"	0.1	17	2'0"	1'9"	0.1	23	2'6"	2'0"	0.2	30
12"	6"	1'6"	2'0"	0.2	18	2'0"	2'0"	0.2	24	2'6"	2'0"	0.2	30
16"	6"	1'6"	2'6"	0.2	23	1'6"	2'6"	0.2	23	2'0"	2'6"	0.2	30
20"	6"	1'6"	2'9"	0.2	26	1'6"	2'9"	0.2	26	1'9"	2'9"	0.2	33
8"	8"	2'0"	2'0"	0.2	24	2'6"	2'0"	0.2	28	3'0"	2'3"	0.2	32
10"	8"	2'0"	2'0"	0.2	24	2'6"	2'0"	0.2	28	3'0"	2'3"	0.2	32
12"	8"	2'0"	2'0"	0.2	24	2'6"	2'0"	0.2	28	3'0"	2'3"	0.2	32
16"	8"	2'0"	2'0"	0.2	24	2'6"	2'6"	0.3	35	3'0"	2'4"	0.3	32
20"	8"	2'0"	2'0"	0.2	24	2'6"	2'9"	0.4	35	3'0"	2'9"	0.4	39
12"	12"	3'0"	3'0"	0.5	54	4'0"	2'6"	0.4	55	4'6"	3'6"	0.7	95
16"	12"	3'0"	3'0"	0.5	54	4'0"	2'6"	0.4	55	4'6"	3'9"	0.7	98
20"	12"	3'0"	3'0"	0.5	54	4'0"	2'9"	0.6	60	4'6"	4'0"	1.0	108
20"	16"	4'0"	3'6"	0.8	84	4'6"	4'0"	1.0	108	6'0"	5'0"	1.5	180
20"	20"	4'6"	4'6"	1.1	122	5'6"	5'0"	1.4	165	7'0"	6'0"	2.0	252

NOTE: 1. PRESSURE RANGES AS SHOWN ARE OPERATING PRESSURES. CONCRETE AND STEEL QUANTITIES ARE CALCULATED USING OPERATING PRESSURE PLUS 50 P.S.I.

2. CONCRETE AND STEEL QUANTITIES ARE FOR ESTIMATING PURPOSES ONLY.

3. IN LIEU OF STEEL REINFORCING BARS, THE CONTRACTOR HAS THE OPTION TO USE WELDED WIRE FABRIC SHEETS (12 X 12 - W5.8 X W5.8) @ 42 LBS. PER 100 S.F.




CONCRETE BLOCKING FOR FITTINGS			
TEES			
APPROVED	DATE	STANDARD DRAWING	
<i>[Signature]</i>	1/4/13	101-5	


DESIGN AGENCY



DESIGNER  
 WCS  
 REVIEWER  
 BAA 03/27/25  
 PROJECT ID  
 115388  
 SHEET TOTAL  
 P.46 | P.107

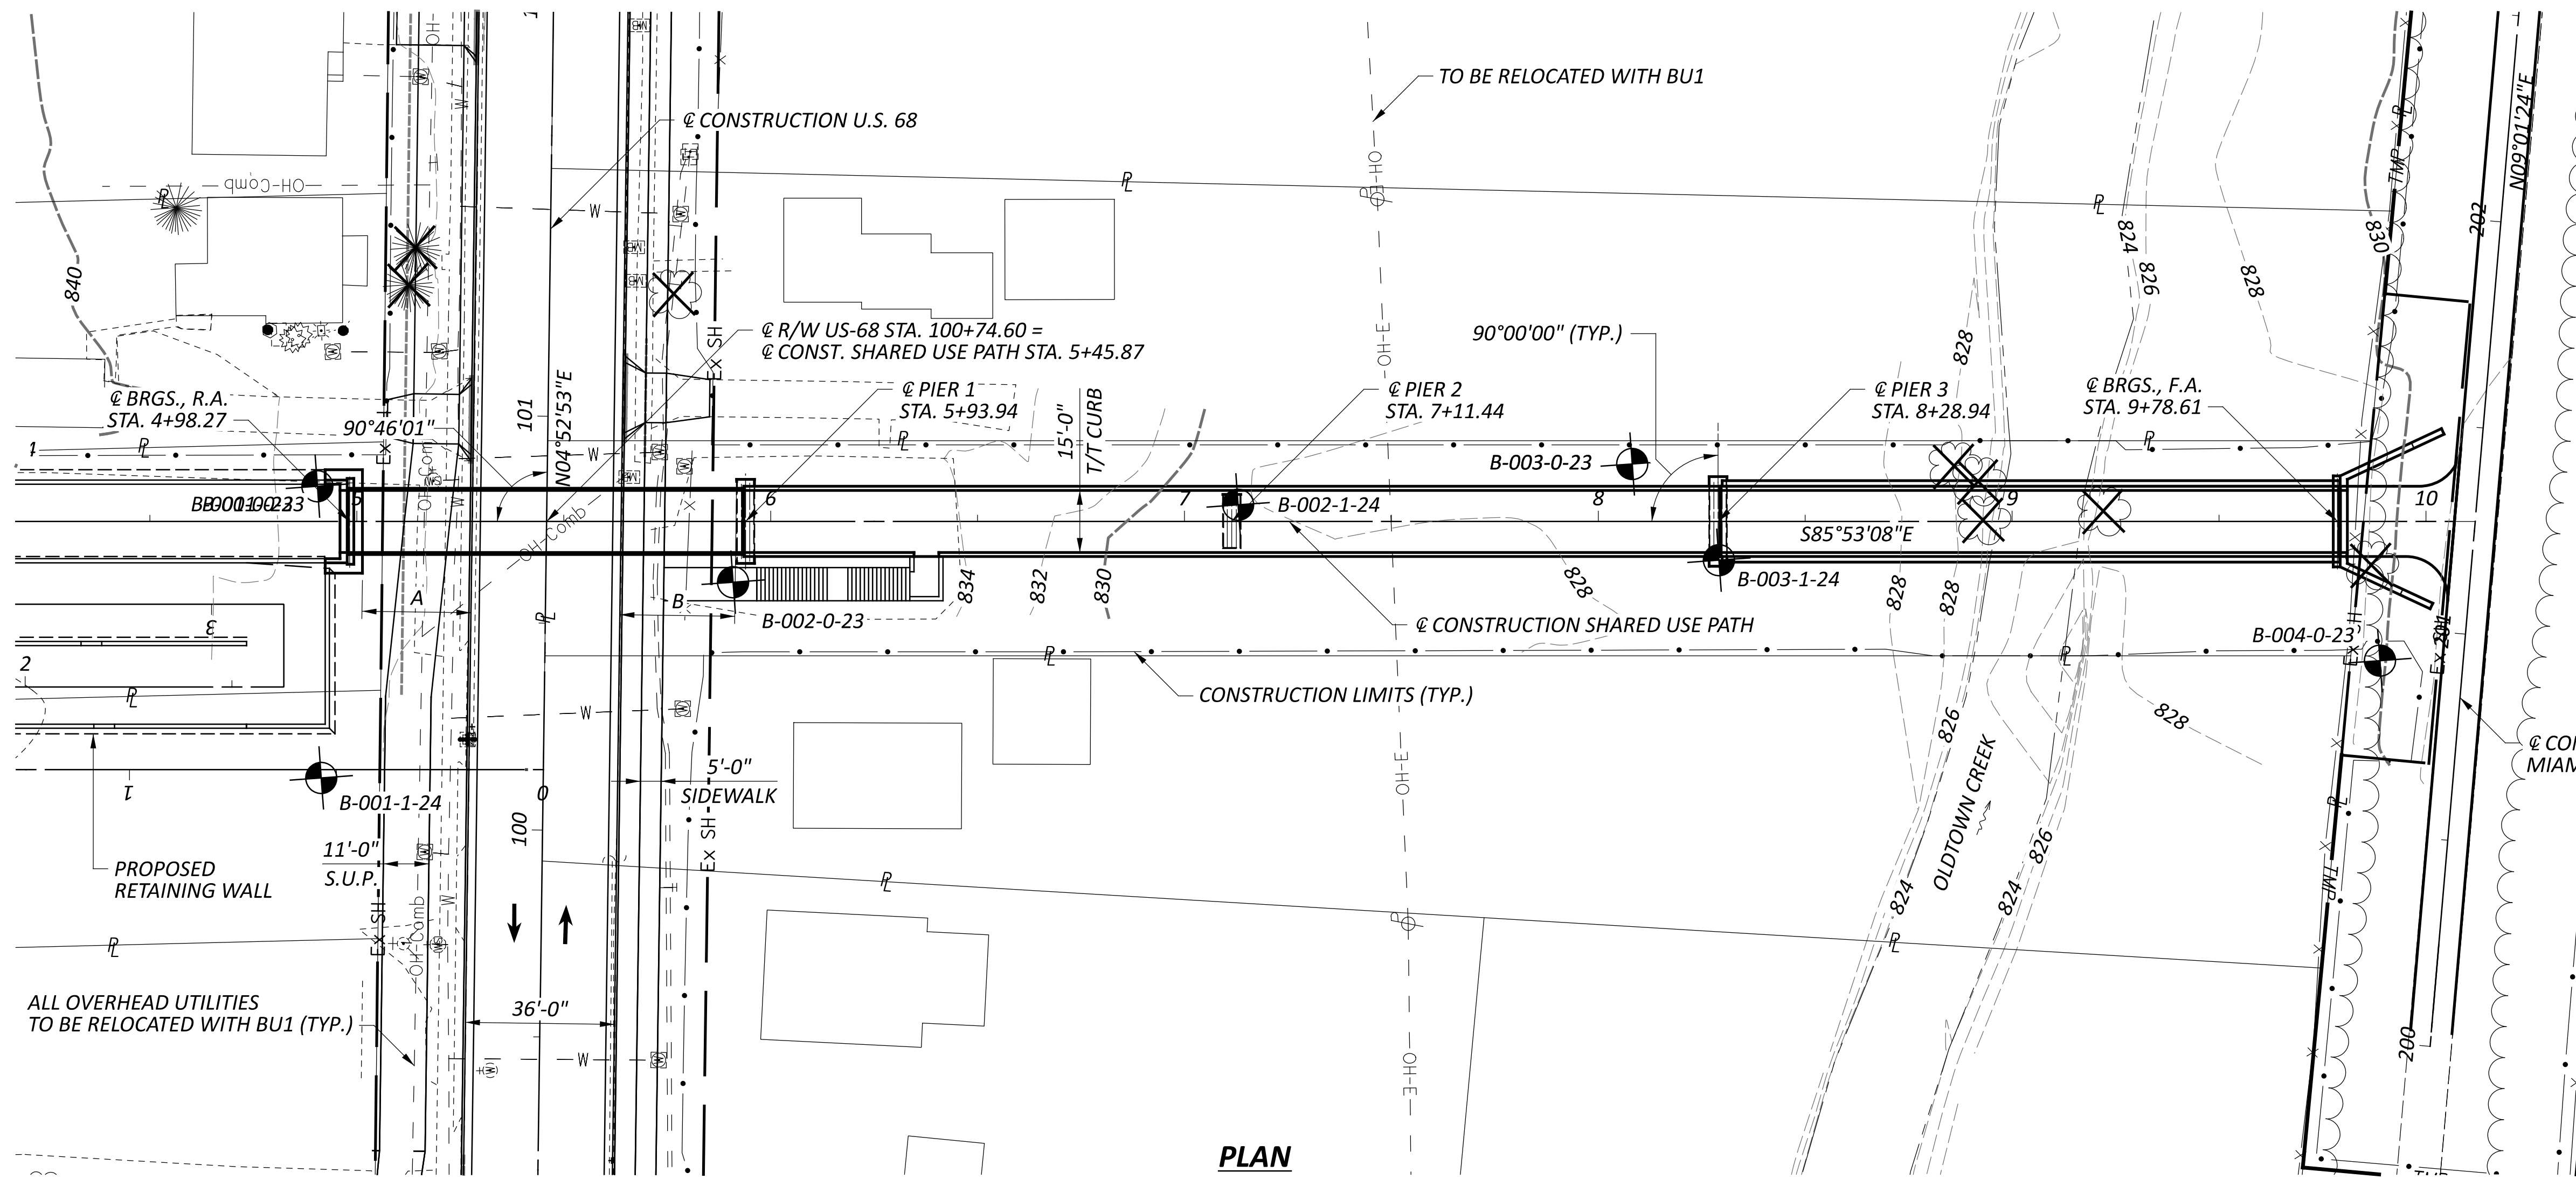

PLAN

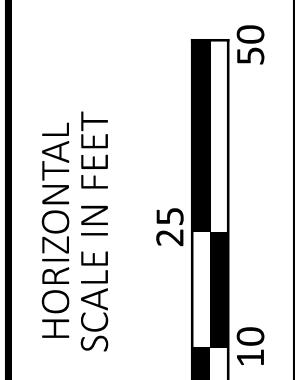

**BENCHMARK DATA**

BM01 STA. 95+30.07, EL. 833.23, OFFSET 41.84' LT.  
 T2 STA. 97+91.42, EL. 834.79, OFFSET 21.63' RT.  
 T104 STA. 100+88.75, EL. 835.68, OFFSET 24.39' LT.


FOR ADDITIONAL BENCHMARK INFORMATION SEE ROADWAY PLAN SHEET P.05/P.107.

**HYDRAULIC DATA**

DRAINAGE AREA = 9.62 SQ. MILES  
 Q (1%) = 2000 CFS V (1%) = 2.06 FT/S  
 Q (20%) = 763 CFS V (20%) = 1.63 FT/S  
 STRUCTURE CLEARS THE AEP DESIGN HW BY 1.5 FEET.

**LEGEND**

A - MINIMUM HORIZONTAL CLEARANCE = 26'-6"  
 B - MINIMUM HORIZONTAL CLEARANCE = 27'-9"  
 - PROJECT BORING LOCATION

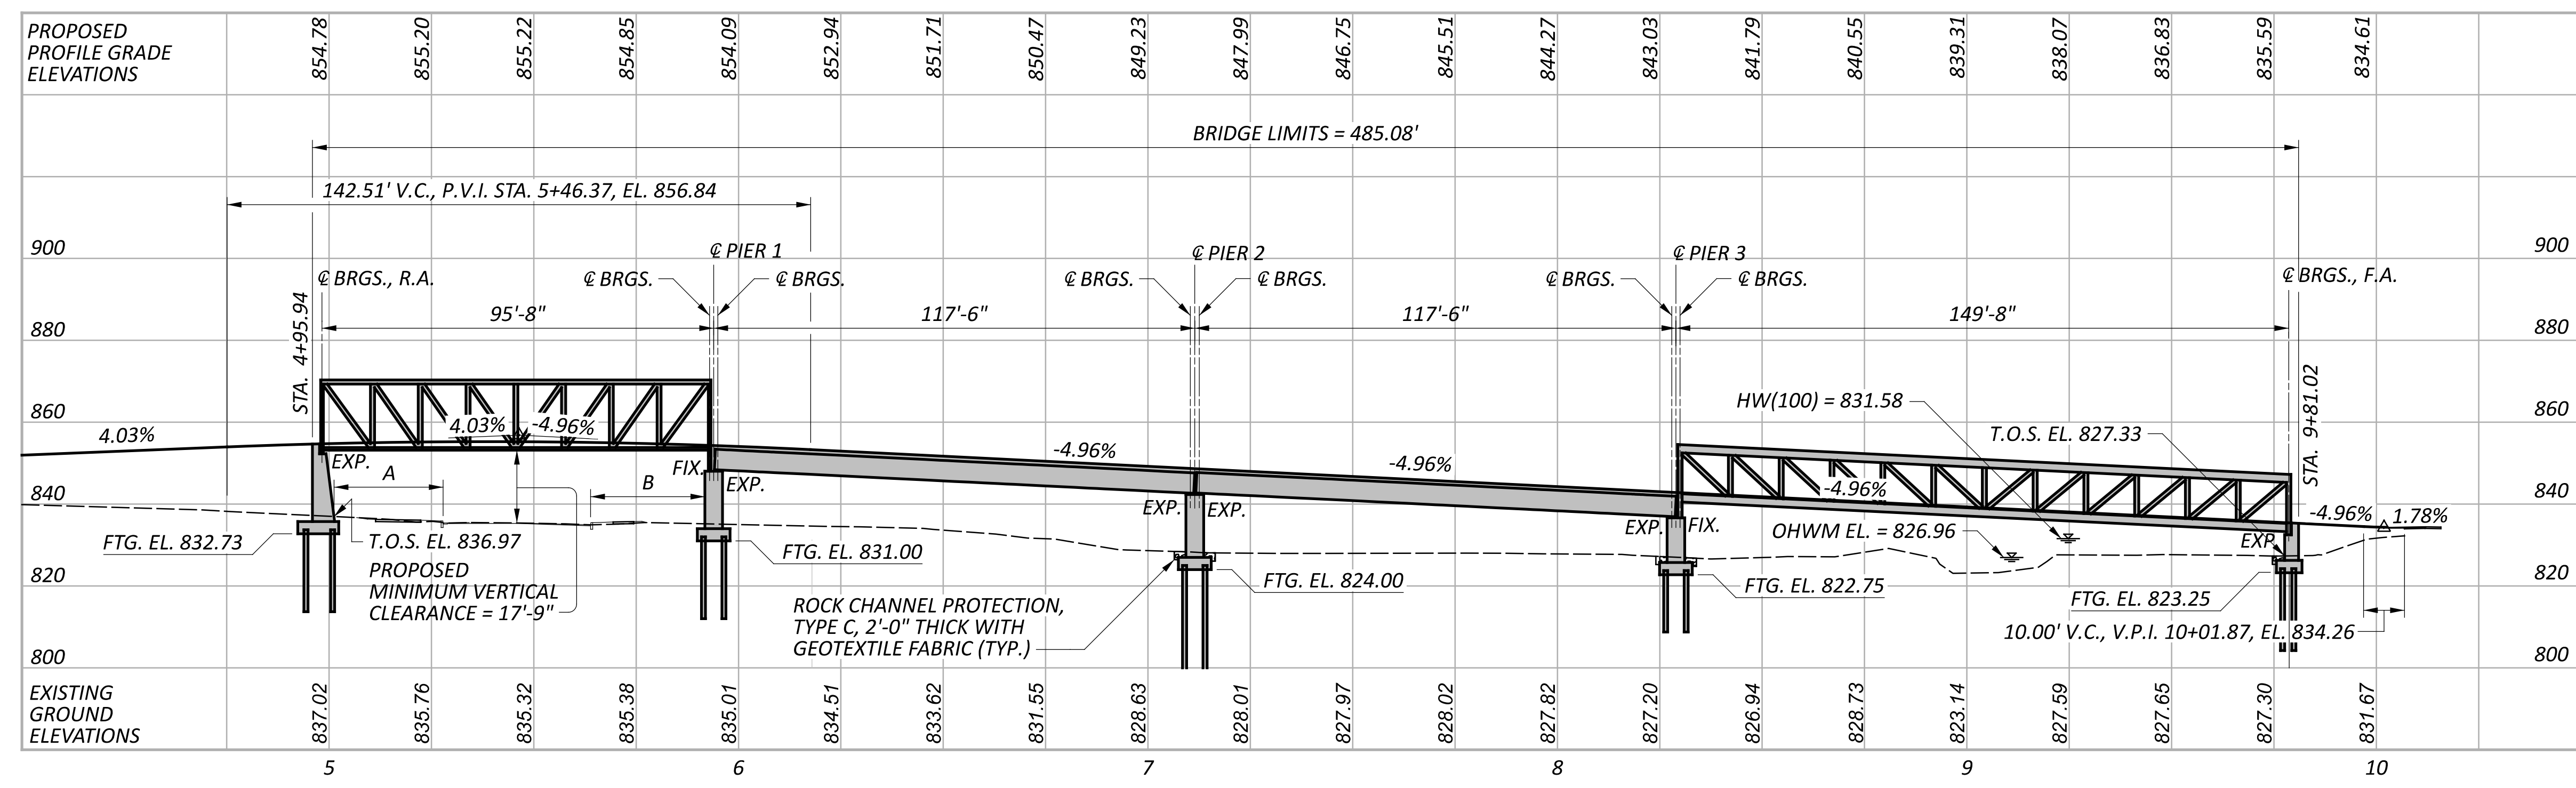

PROFILE ALONG @ CONSTRUCTION SHARED USE PATH

**PROPOSED STRUCTURE**

TYPE: FOUR SPAN PREFABRICATED PAINTED STEEL TRUSS AND WIDE FLANGE BEAM SUPERSTRUCTURE WITH REINFORCED CONCRETE DECK ON REINFORCED CONCRETE ABUTMENTS AND PIERS SUPPORTED ON CAST-IN-PLACE REINFORCED CONCRETE PILES

SPANS: 95'-8", 117'-6", 117'-6", 149'-8" MEASURED BETWEEN SUBSTRUCTURE UNITS

ROADWAY: 15'-0" TOE/TOE CURB

LOADING: 0.090 KSF PEDESTRIAN LOAD OR H15-44

SKEW: NONE

WEARING SURFACE: 1" MONOLITHIC CONCRETE

APPROACH SLABS: NONE

ALIGNMENT: TANGENT

CROWN: 0.01 FT/FT

DECK AREA: 8,257 SF

COORDINATES: LATITUDE N39°43'46.65"  
 LONGITUDE W83°56'12.36"

SITE PLAN  
 BRIDGE NO. GRE-BK80020-00.492  
 PEDESTRIAN BRIDGE OVER US 68 AND OLDTOWN CREEK

DESIGNER	CHECKER
SMH	AMR
REVIEWER	
PROJECT ID	
115388	
SUBSET	TOTAL
1	27
SHEET	TOTAL
P.47	P.107

REFER TO THE FOLLOWING STANDARD BRIDGE DRAWINGS:

EXJ-6-17	REVISED	1-19-2024
PSID-1-13	REVISED	7-19-2024
GSD-1-19	REVISED	7-19-2024
RM-5.2	REVISED	7-21-2023

**DESIGN SPECIFICATIONS**

THIS STRUCTURE CONFORMS TO THE 9th EDITION OF THE "LRFD BRIDGE DESIGN SPECIFICATIONS" ADOPTED BY THE AMERICAN ASSOCIATION OF STATE HIGHWAY AND TRANSPORTATION OFFICIALS, 2020, THE "LRFD GUIDE SPECIFICATIONS FOR THE DESIGN OF PEDESTRIAN BRIDGES" ADOPTED BY THE AMERICAN ASSOCIATION OF STATE HIGHWAY AND TRANSPORTATION OFFICIALS, 2009, AND THE ODOT BRIDGE DESIGN MANUAL, 2020.

**OPERATIONAL IMPORTANCE:**

A LOAD MODIFIER OF 1.0 HAS BEEN ASSUMED FOR THE DESIGN OF THIS STRUCTURE IN ACCORDANCE WITH THE AASHTO LRFD BRIDGE DESIGN SPECIFICATIONS, ARTICLE 1.3.5 AND THE ODOT BRIDGE DESIGN MANUAL.

**DESIGN LOADING**

VEHICULAR LIVE LOAD: H15-44 (NOT CONCURRENTLY WITH PEDESTRIAN LIVE LOAD)

PEDESTRIAN LIVE LOAD: 0.090 KIPS/FT<sup>2</sup>

**DESIGN DATA**

CONCRETE CLASS QC2 WITH QC/QA - COMPRESSIVE STRENGTH 4.5 KSI (SUPERSTRUCTURE)

CONCRETE CLASS QC1 WITH QC/QA - COMPRESSIVE STRENGTH 4.0 KSI (SUBSTRUCTURE)

CONCRETE REINFORCEMENT:

GALVANIZED STEEL REINFORCEMENT - MINIMUM YIELD STRENGTH 60 KSI (SUBSTRUCTURES, SUPERSTRUCTURES)

STRUCTURAL STEEL - ASTM A709 GRADE 50 - YIELD STRENGTH 50 KSI

STEEL CIP PILES - ASTM A252 GRADE 3 - YIELD STRENGTH 45 KSI

CONCRETE FOR PRESTRESSED BEAM: COMPRESSIVE STRENGTH (FINAL) - 7 KSI COMPRESSIVE STRENGTH (RELEASE) - 5 KSI

WELD WIRE REINFORCEMENT: YIELD STRENGTH - 70 KSI

PRESTRESSING STRAND: AREA = 0.217 SQ. IN. 0.6" Ø ULTIMATE STRENGTH = 270 KSI INITIAL STRESS = 202.5 KSI (LOW RELAXATION STRANDS) INITIAL TENSION LOAD = 43.95 KIP/STRAND

**MONOLITHIC WEARING SURFACE**

MONOLITHIC WEARING SURFACE IS ASSUMED, FOR DESIGN PURPOSES, TO BE 1 INCH THICK.

**DECK PROTECTION METHOD**

GALVANIZED REINFORCING STEEL 2½" CONCRETE COVER SEAL JOINT WITH HMWM RESIN

**SEALING OF CONCRETE SURFACES, AS PER PLAN, (PERMANENT GRAFFITI PROTECTION):**

APPLY A PERMANENT GRAFFITI COATING QUALIFIED ACCORDING TO S1083 THAT IS COMPATIBLE WITH THE CONCRETE SEALER OVER WHICH IT IS APPLIED. APPLY THE GRAFFITI COATING IN ACCORDANCE WITH THE MANUFACTURER'S PRINTED INSTRUCTIONS.

**SEALING OF CONCRETE SURFACES (EPOXY-URETHANE)**

SEALING OF ALL CONCRETE SURFACES WITH THE EXCEPTION OF THE REAR ABUTMENT AND PIERS SHALL BE LIGHT NEUTRAL FEDERAL COLOR FS-595C-17778.

**DECK PLACEMENT DESIGN ASSUMPTIONS**

THE FOLLOWING ASSUMPTIONS OF CONSTRUCTION MEANS AND METHODS WERE MADE FOR THE ANALYSIS AND DESIGN OF THE SUPERSTRUCTURE. THE CONTRACTOR IS RESPONSIBLE FOR THE DESIGN OF THE FALSEWORK SUPPORT SYSTEM WITHIN THESE PARAMETERS AND WILL ASSUME RESPONSIBILITY FOR SUPERSTRUCTURE ANALYSIS FOR DEVIATION FROM THESE DESIGN ASSUMPTIONS.

AN EIGHT WHEEL FINISHING MACHINE WITH A MAXIMUM WHEEL LOAD OF 2.2 KIPS.

A MINIMUM OUT-TO-OUT WHEEL SPACING AT EACH END OF THE MACHINE OF 103 INCHES.

A MAXIMUM SPACING OF OVERHANG FALSEWORK BRACKETS OF 48 INCHES.

A MAXIMUM DISTANCE FROM THE CENTERLINE OF THE FASCIA GIRDER TO THE FACE OF THE SAFETY HANDRAIL OF 65 INCHES.

**PILE DESIGN LOADS (ULTIMATE BEARING VALUE):**

THE ULTIMATE BEARING VALUE (UBV) IS 292.9 KIPS PER PILE FOR THE REAR AND 164.8 KIPS PER PILE FORWARD ABUTMENT PILES. THE UBV IS 226.6 KIPS PER PILE FOR THE PIER 1 PILES, 303.0 KIPS PER PILE FOR THE PIER 2 PILES, AND 259.6 KIPS PER PILE FOR THE PIER 3 PILES.

REAR ABUTMENT PILES:

14 INCH DIAMETER PILES 25 FEET LONG, ORDER LENGTH 1 DYNAMIC LOAD TESTING ITEMS

PIER 1 PILES:

12 INCH DIAMETER PILES 25 FEET LONG, ORDER LENGTH 1 DYNAMIC LOAD TESTING ITEMS

PIER 2 PILES:

14 INCH DIAMETER PILES 35 FEET LONG, ORDER LENGTH 1 DYNAMIC LOAD TESTING ITEMS

PIER 3 PILES:

14 INCH DIAMETER PILES 20 FEET LONG, ORDER LENGTH 1 DYNAMIC LOAD TESTING ITEMS

FORWARD ABUTMENT PILES:

14 INCH DIAMETER PILES 25 FEET LONG, ORDER LENGTH 1 DYNAMIC LOAD TESTING ITEMS

PROVIDE PLAIN CYLINDRICAL CASINGS WITH A MINIMUM PILE WALL THICKNESS PER TABLE 3/27 FOR THE CAST-IN-PLACE REINFORCED CONCRETE PILES.

**FOUNDATION BEARING RESISTANCE:**




STAIRWAY PIER FOOTINGS, AS DESIGNED, PRODUCE A MAXIMUM SERVICE LIMIT STATE BEARING PRESSURE OF 1.7 KIPS PER SQUARE FOOT AND A MAXIMUM STRENGTH LIMIT STATE BEARING PRESSURE OF 2.1 KIPS PER SQUARE FOOT. THE FACTORED BEARING RESISTANCE IS X.X KIPS PER SQUARE FOOT.

**AESTHETIC TREATMENT (CONCRETE FORMLINER)**


ONE FULL SCALE PATTERNED PRECONSTRUCTION TEST PANEL SHALL BE PROVIDED FOR APPROVAL BY THE DISTRICT 8 BRIDGE SECTION. IF THE TEST PANEL DOES NOT MEET THE APPROVAL OF THE DISTRICT 8 PROJECT MANAGER, THE RESULT WILL BE GROUNDS TO THE REJECT THE PROPOSED PANEL SURFACE CHOSEN. THE TEST PANEL WILL BE PROVIDED REPEATEDLY, AS NECESSARY, UNTIL APPROVAL IS GRANTED. THE MOCK-UP SHALL HAVE THE SAME ARCHITECTURAL RELIEF, THICKNESS, PATTERN INTENDED TO BE USED ON THE PROJECT. THE PANEL SHALL BE THE SAME CEMENT AND AGGREGATE SOURCE THAT WILL BE USED TO CONSTRUCT THE PROJECT. AFTER APPROVAL THE CONCRETE TEST PANEL SHALL BE REMOVED AND DISPOSED OF BY THE CONTRACTOR.

**STRUCTURE GROUNDING**

THE PROPOSED PEDESTRIAN BRIDGE OVER US-68 AND THE PROPOSED BRIDGE OVER OLDTOWN CREEK SHALL HAVE A STRUCTURE GROUNDING SYSTEM PROVIDED AS PER SCD HL-50.21.

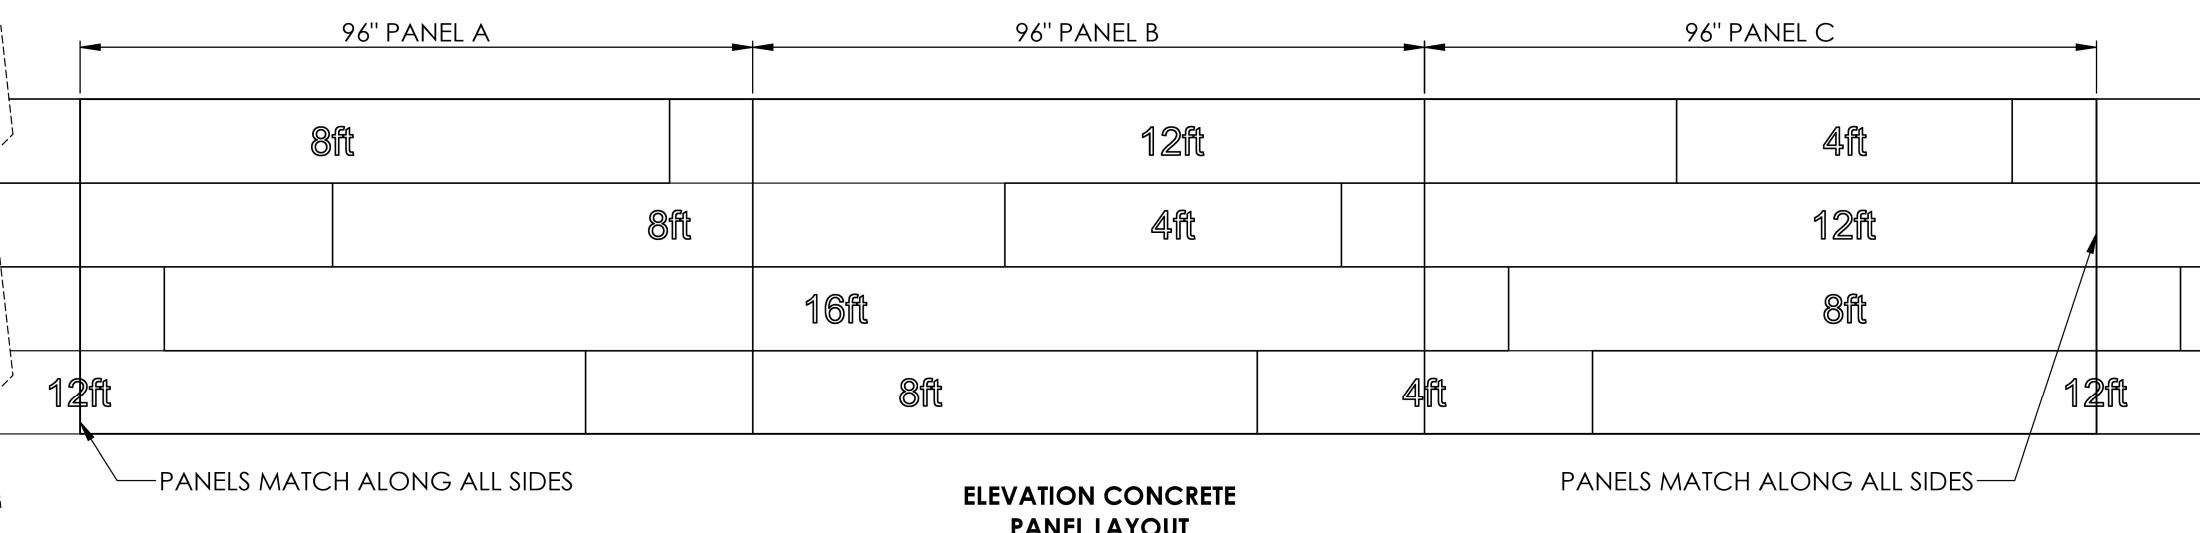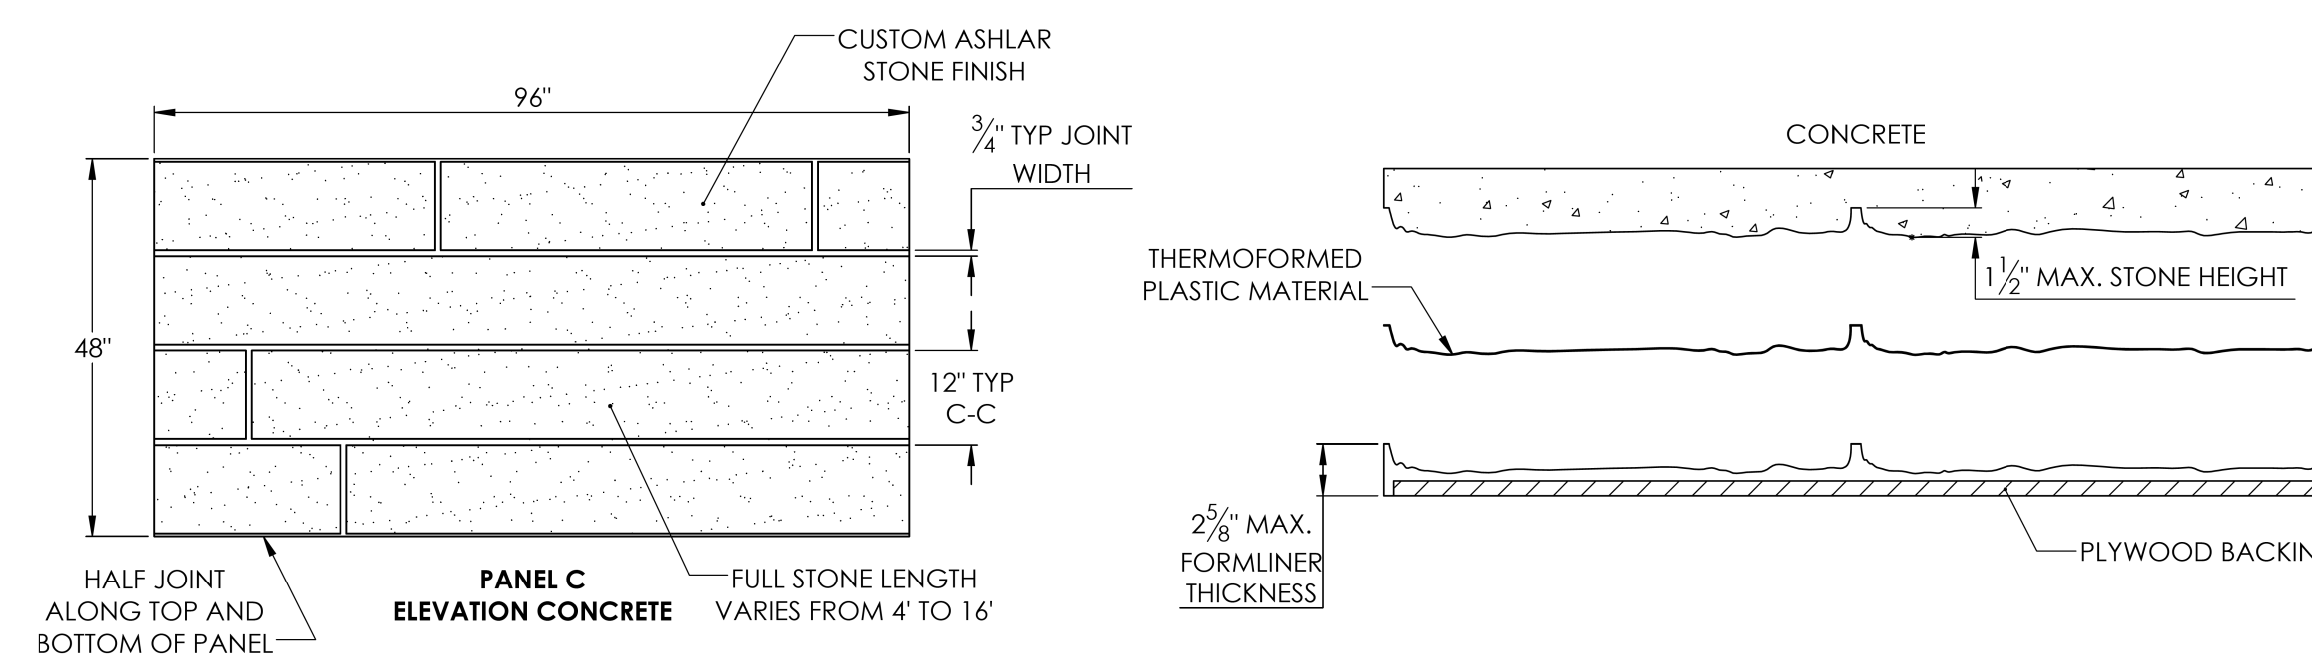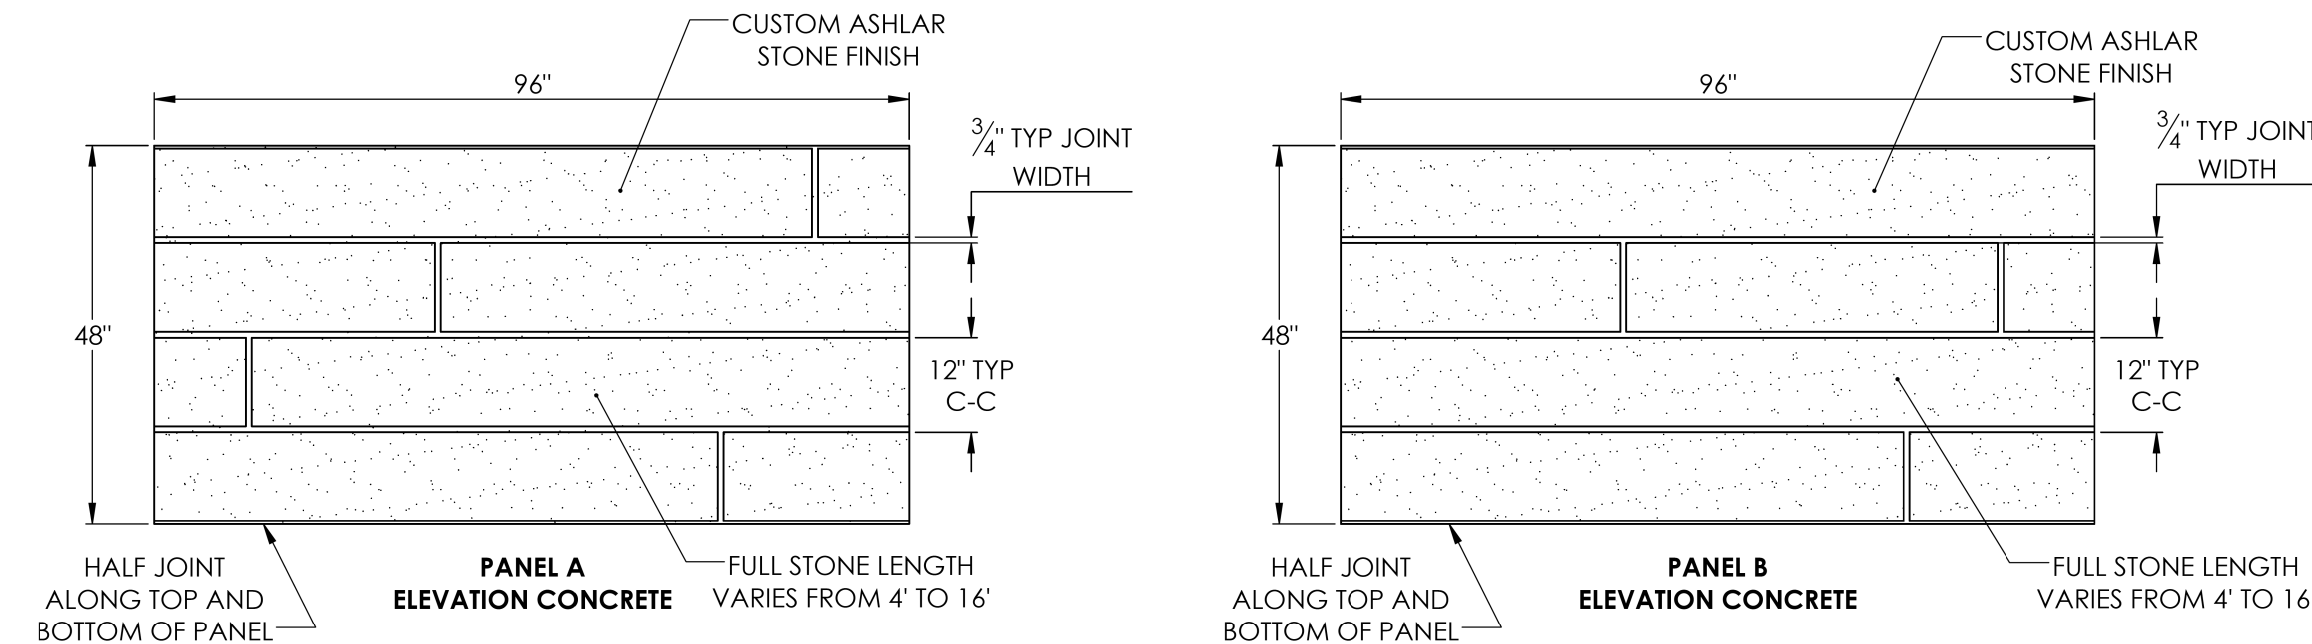

**CONCRETE FORMLINER DETAIL**

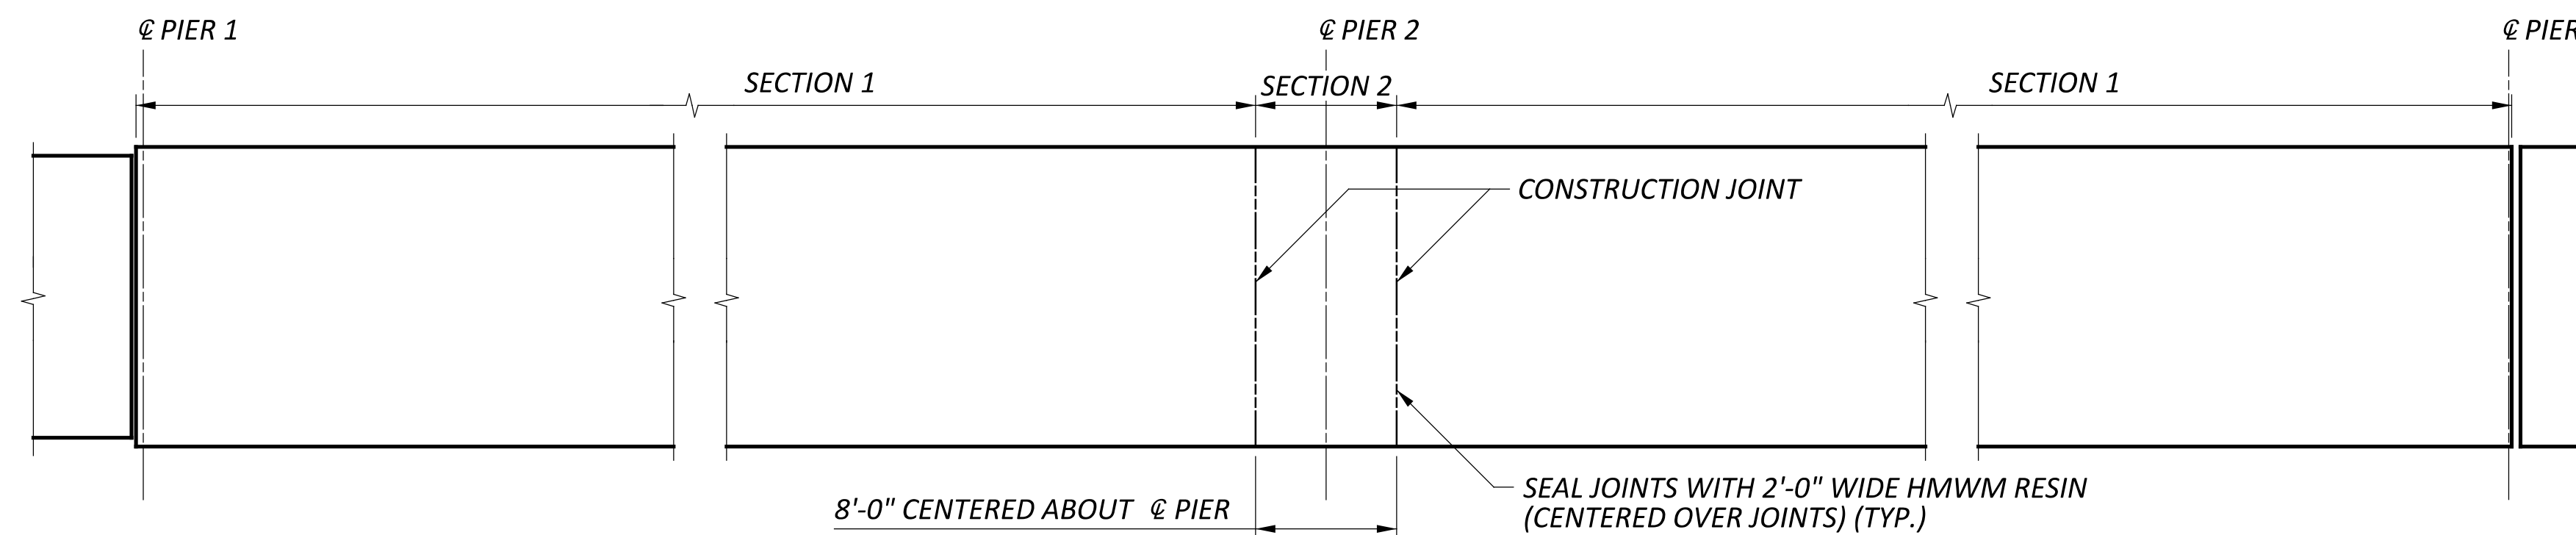

**DECK POURING SEQUENCE PLAN**


**NOTE**

SECTION 2 SHALL NOT BE POURED PRIOR TO SECTION 1 WITHOUT APPROVAL OF THE ENGINEER.

BRIDGE GENERAL NOTES  
BRIDGE NO. GRE-BK80020-00.492  
PEDESTRIAN BRIDGE OVER US 68 AND OLDTOWN CREEK

SFN	2926107
DESIGN AGENCY	CARPENTER MARTY
DESIGNER	CHECKER
JZ	AMR
REVIEWER	
GDJ	03/28/25
PROJECT ID	115388
SUBSET	TOTAL
2	27
SHEET	TOTAL
P.48	P.107




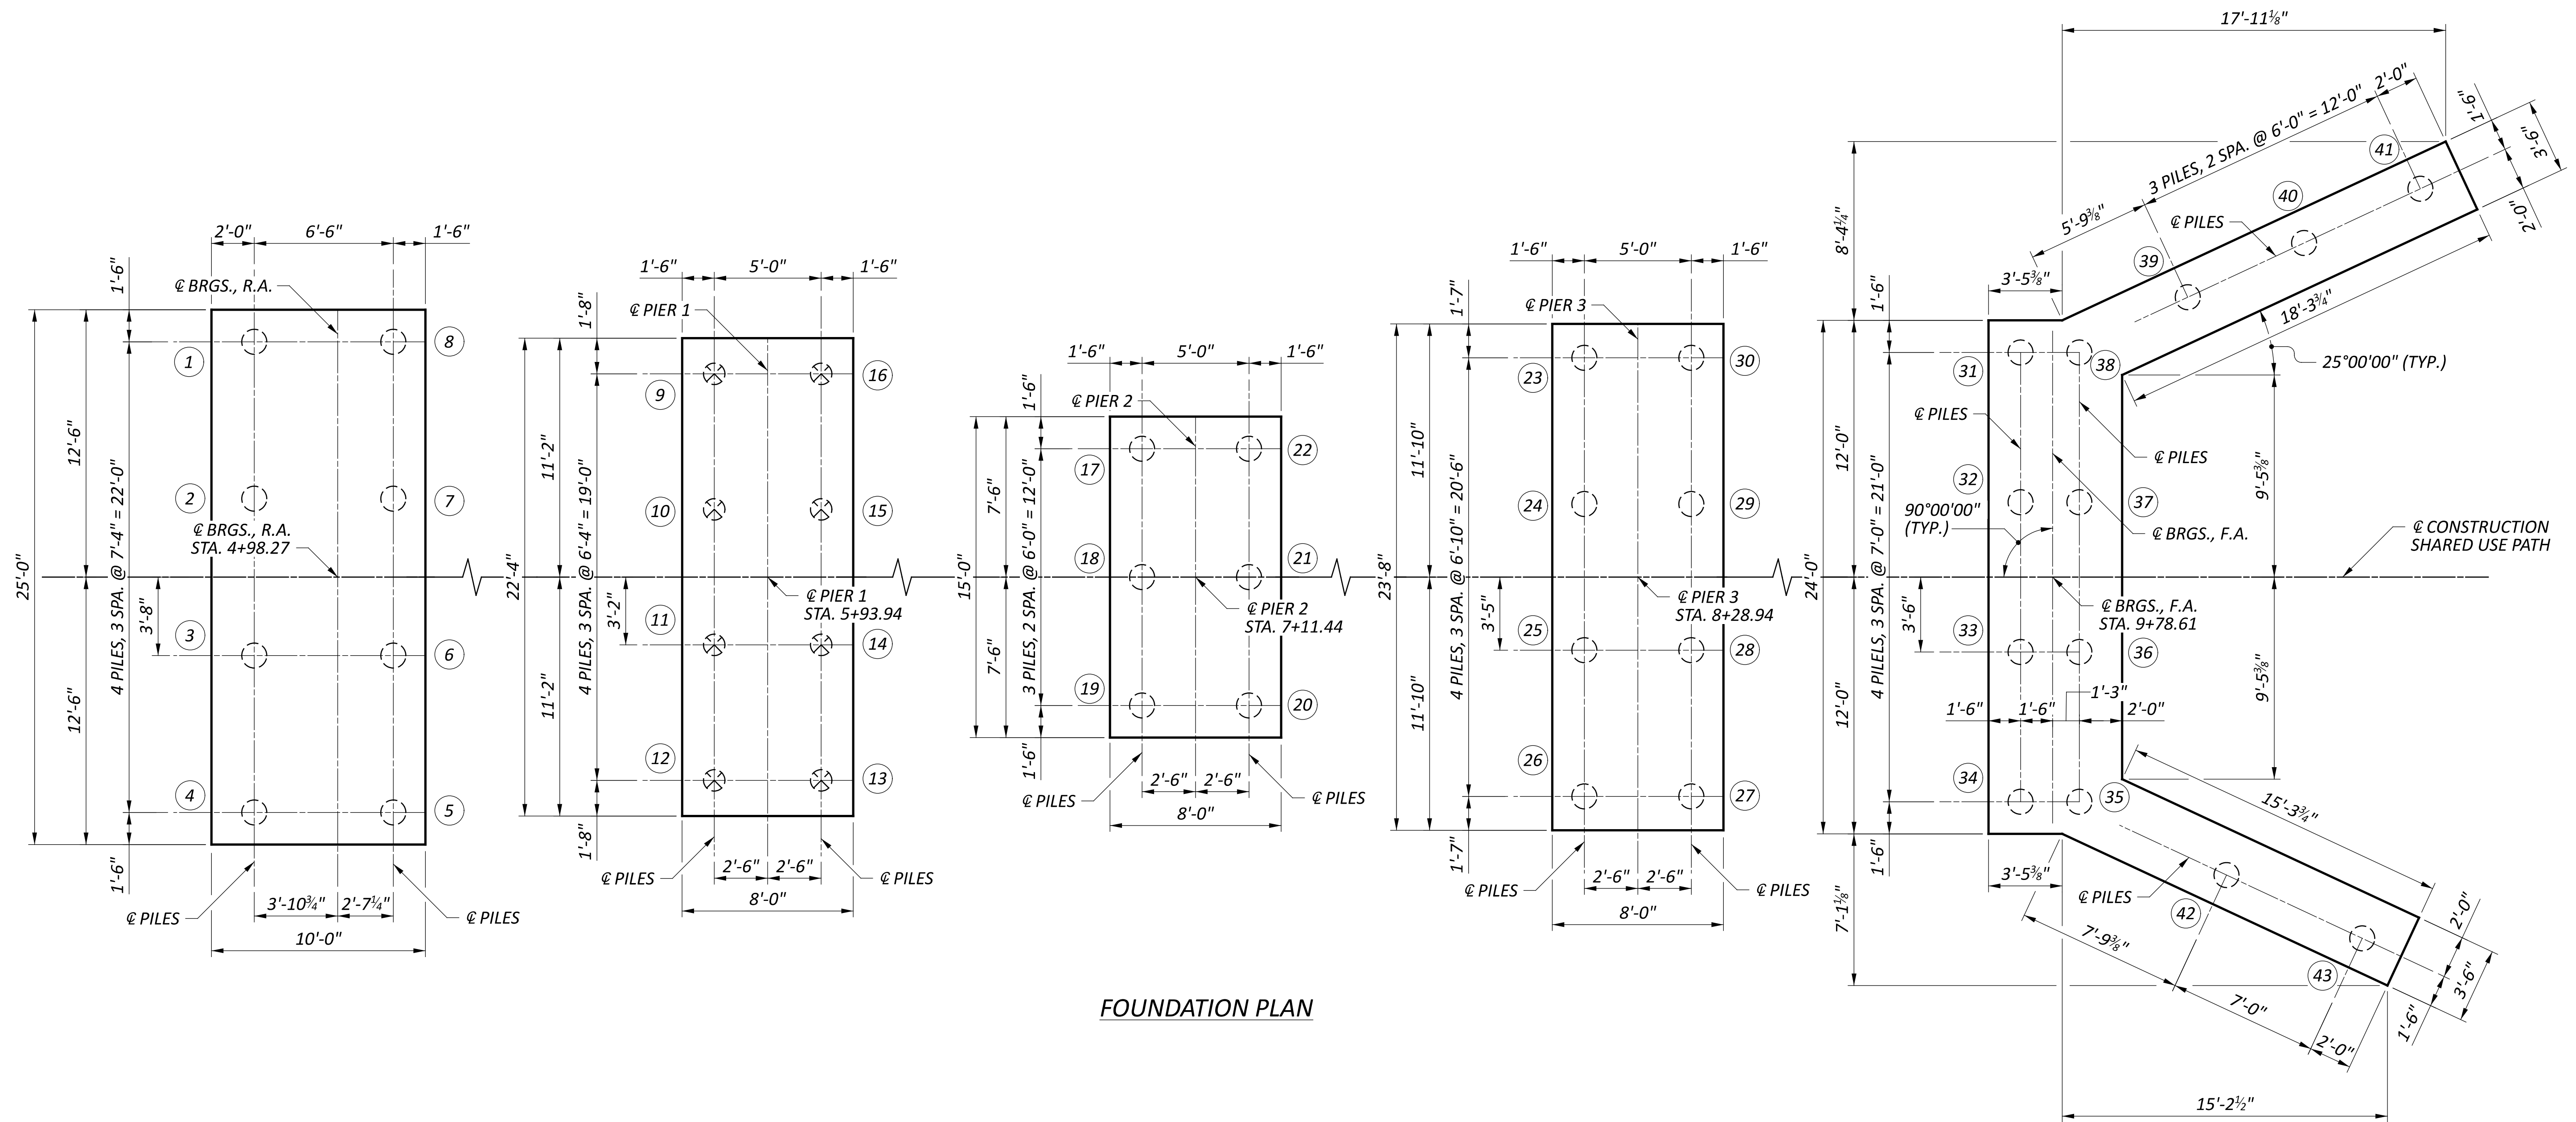


FOUNDATION PLAN


**LEGEND**

- ① - PILE NUMBER
- ⊗ - 12" C.I.P. REINFORCED CONCRETE PILE (PIER 1)
- ⊙ - 14" C.I.P. REINFORCED CONCRETE PILE (R.A., PIER 2, PIER 3 AND F.A.)

LOCATION	PILE TYPE ( ASTM A252)	PREBORE LENGTH FROM BOTTOM OF FOOTING (FT)	ESTIMATED PILE LENGTH (FT)	ORDER LENGTH (FT)	MINIMUM PILE WALL THICKNESS (INCHES)
R.A.	14-INCH C.I.P. (GRADE 3)	7.50	20	25	0.438
PIER 1	12-INCH C.I.P. (GRADE 3)	6.00	20	25	0.250
PIER 2	14-INCH C.I.P. (GRADE 3)	14.00	30	35	0.312
PIER 3	14-INCH C.I.P. (GRADE 3)	10.05	15	20	0.312
F.A.	14-INCH C.I.P. (GRADE 3)	10.05	15	20	0.250

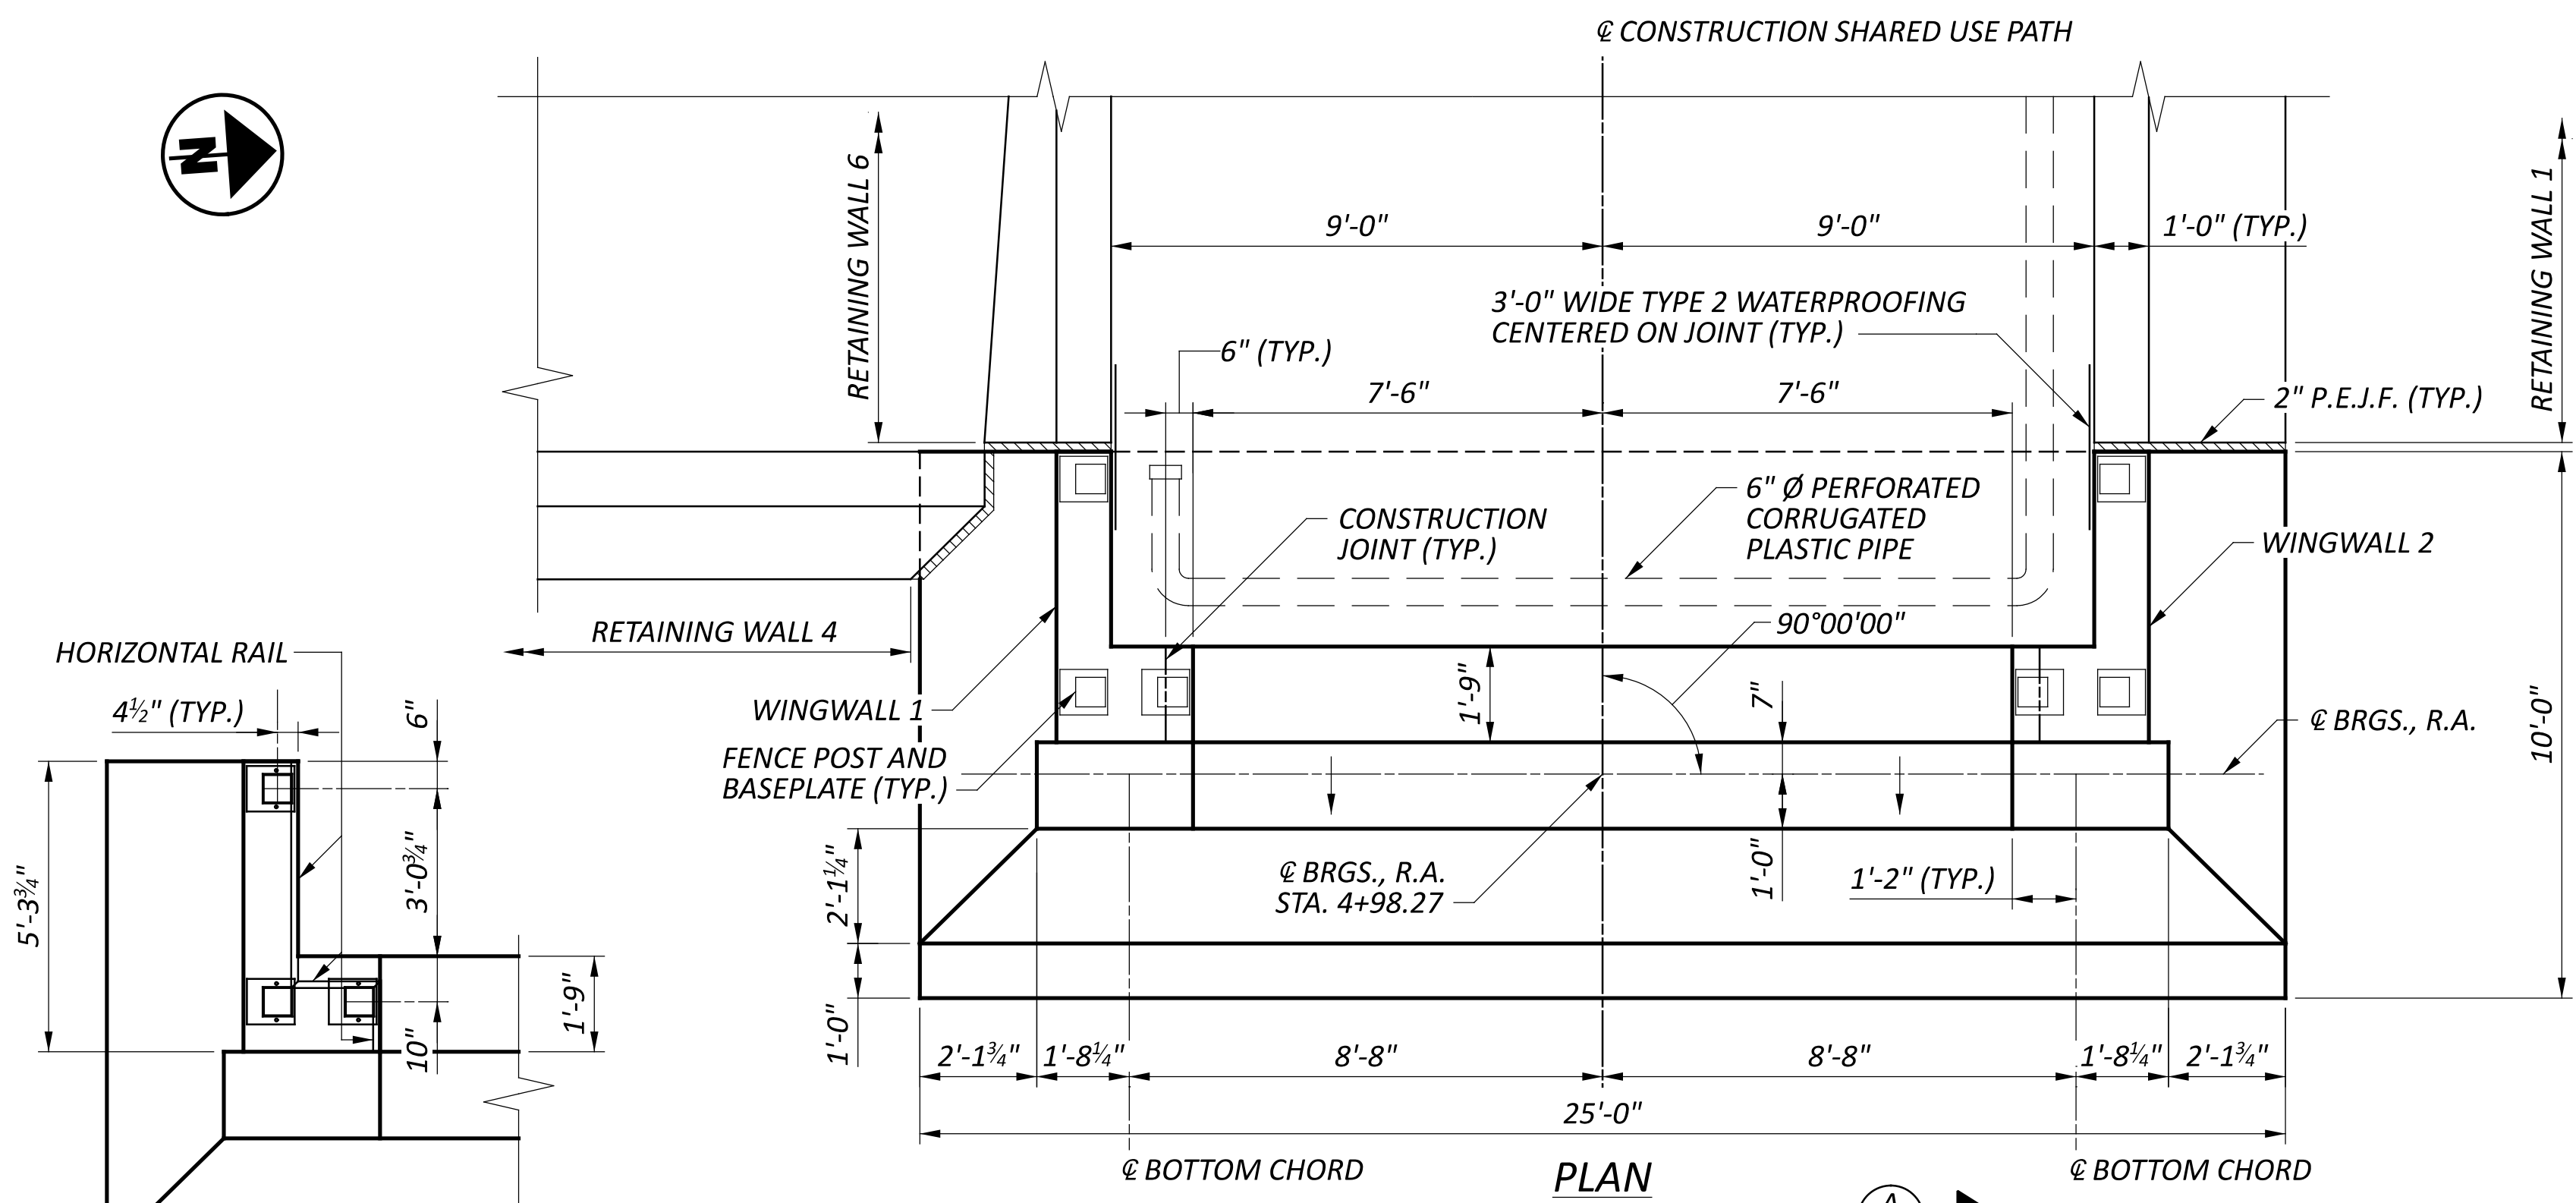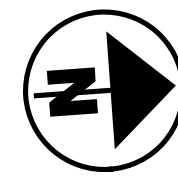


**FENCE POST PLACEMENT DETAIL**  
WINGWALL 1 SHOWN,  
WINGWALL 2 OPPOSITE

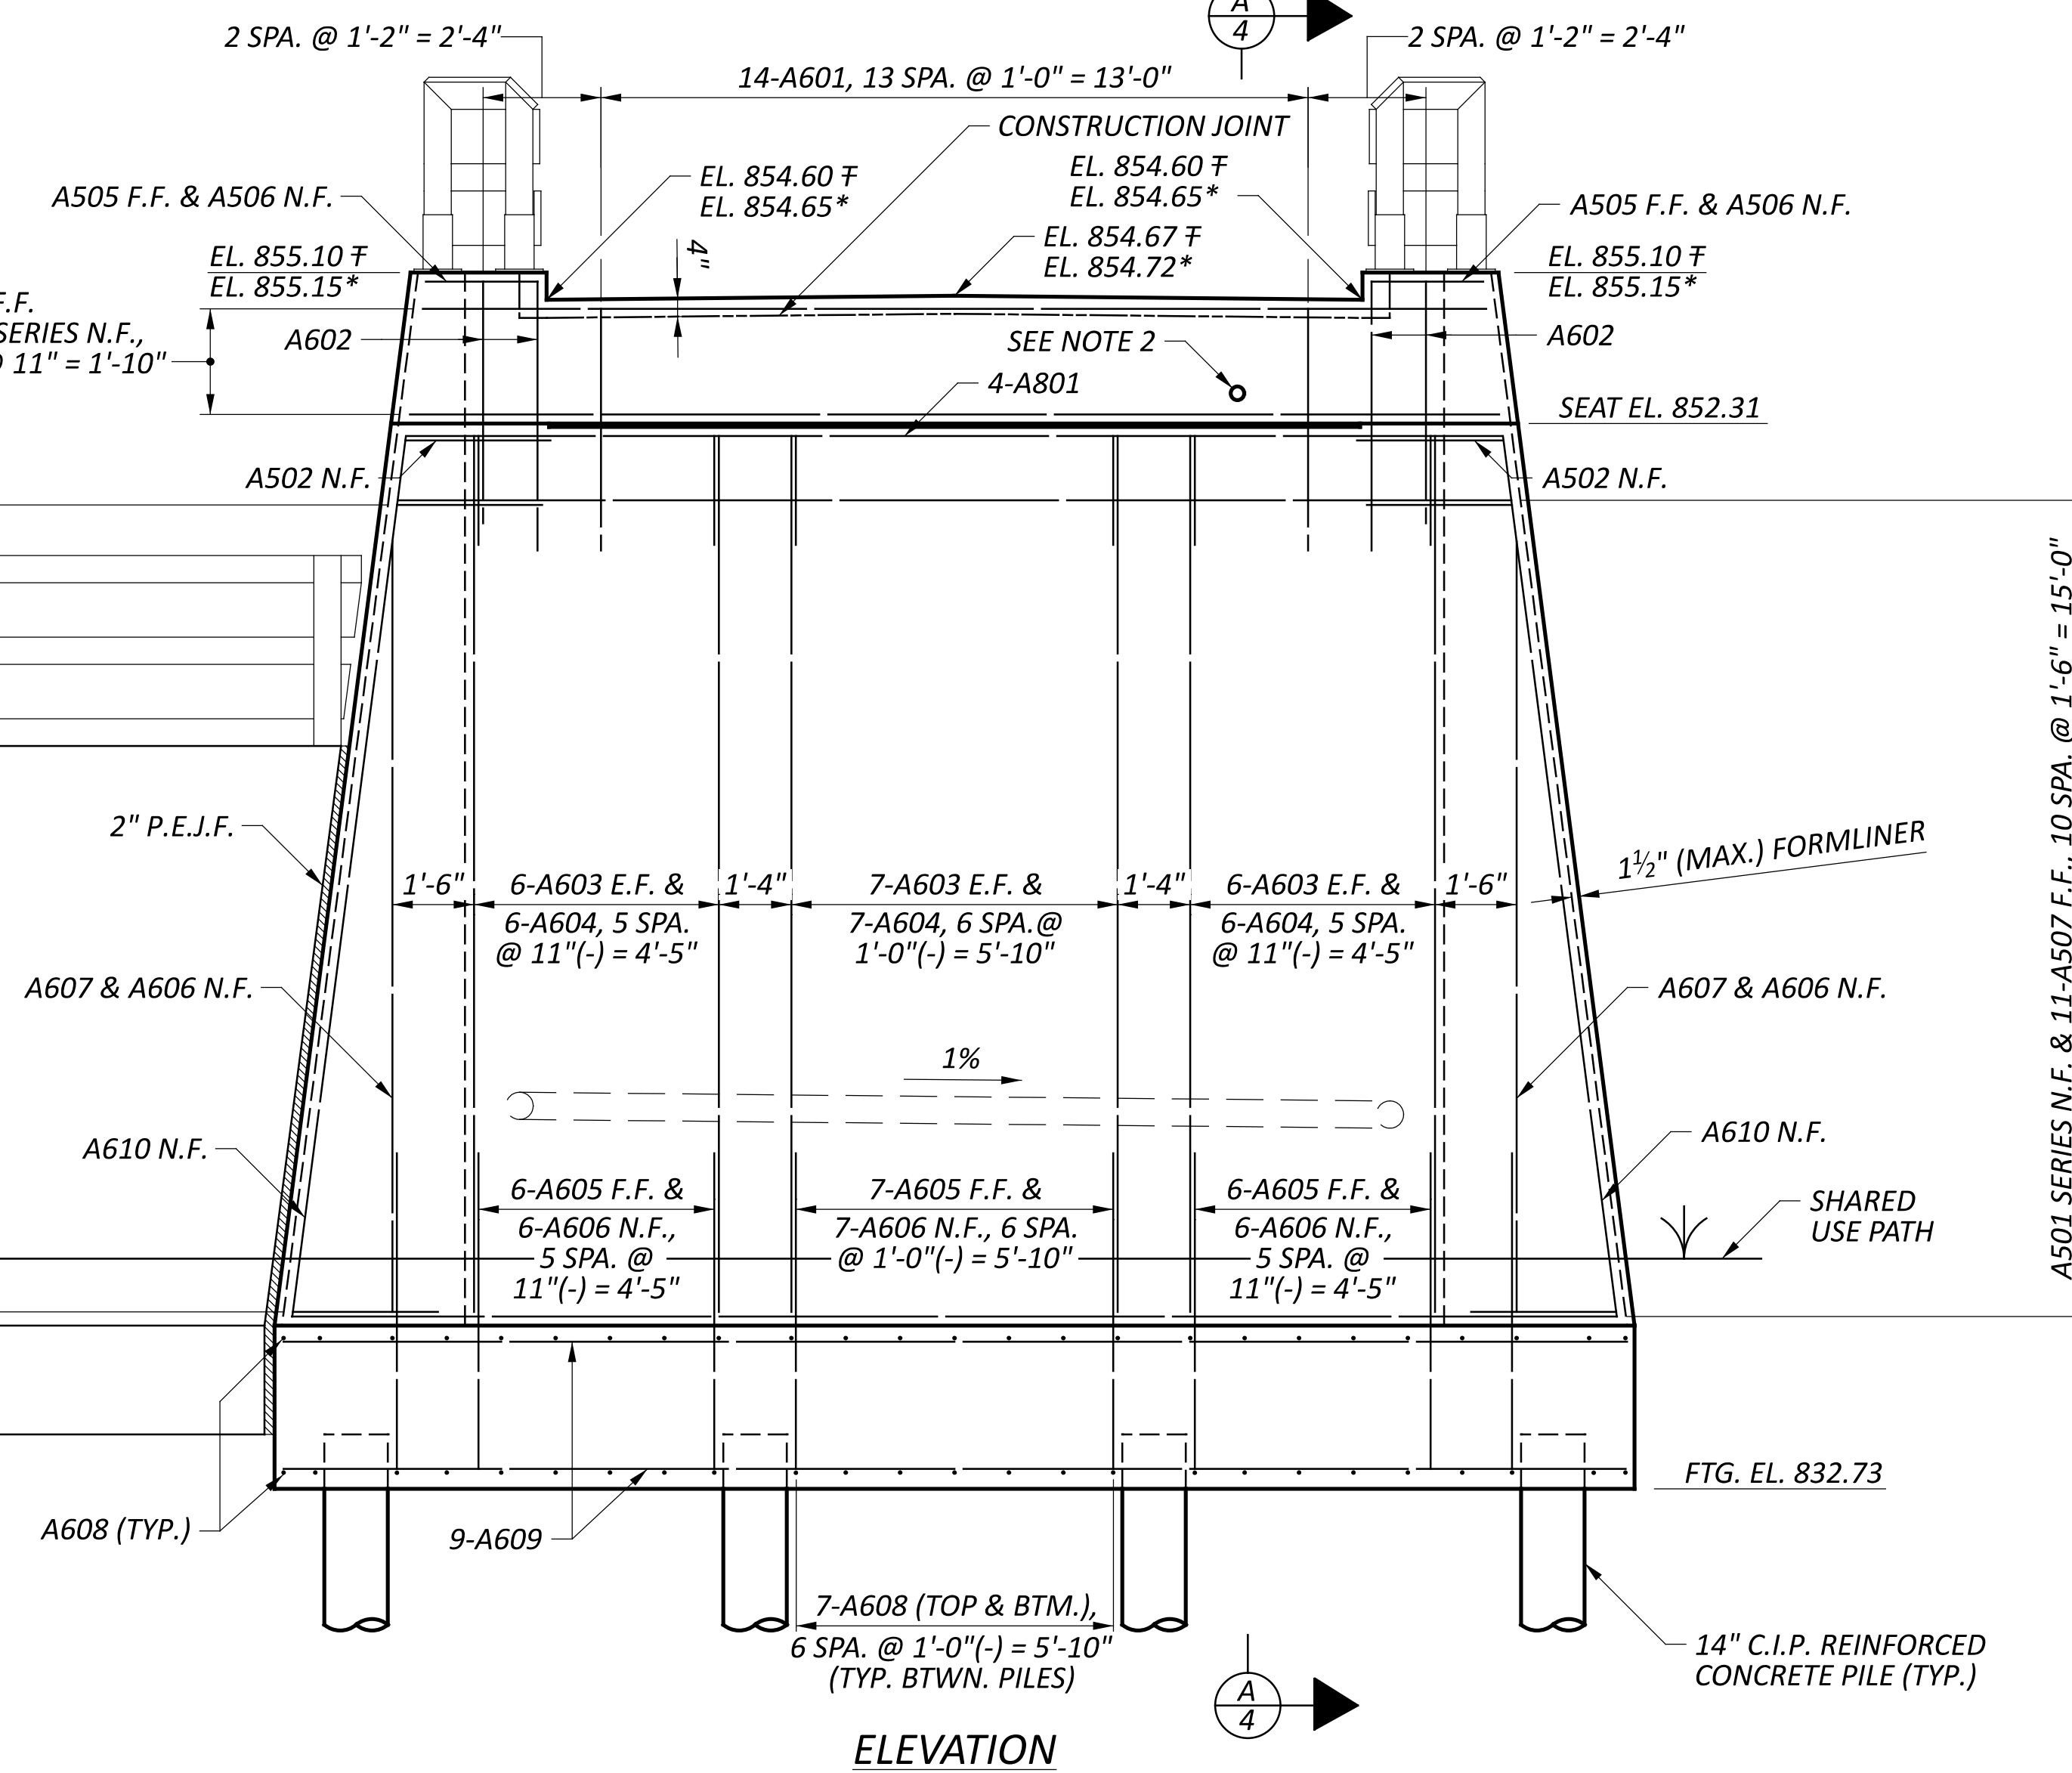

**ELEVATION**


- LEGEND**
- ∓ - ELEVATION TAKEN AT BRIDGE LIMITS
  - \* - ELEVATION TAKEN AT FACE
  - E.F. - EACH FACE
  - F.F. - FAR FACE
  - N.F. - NEAR FACE

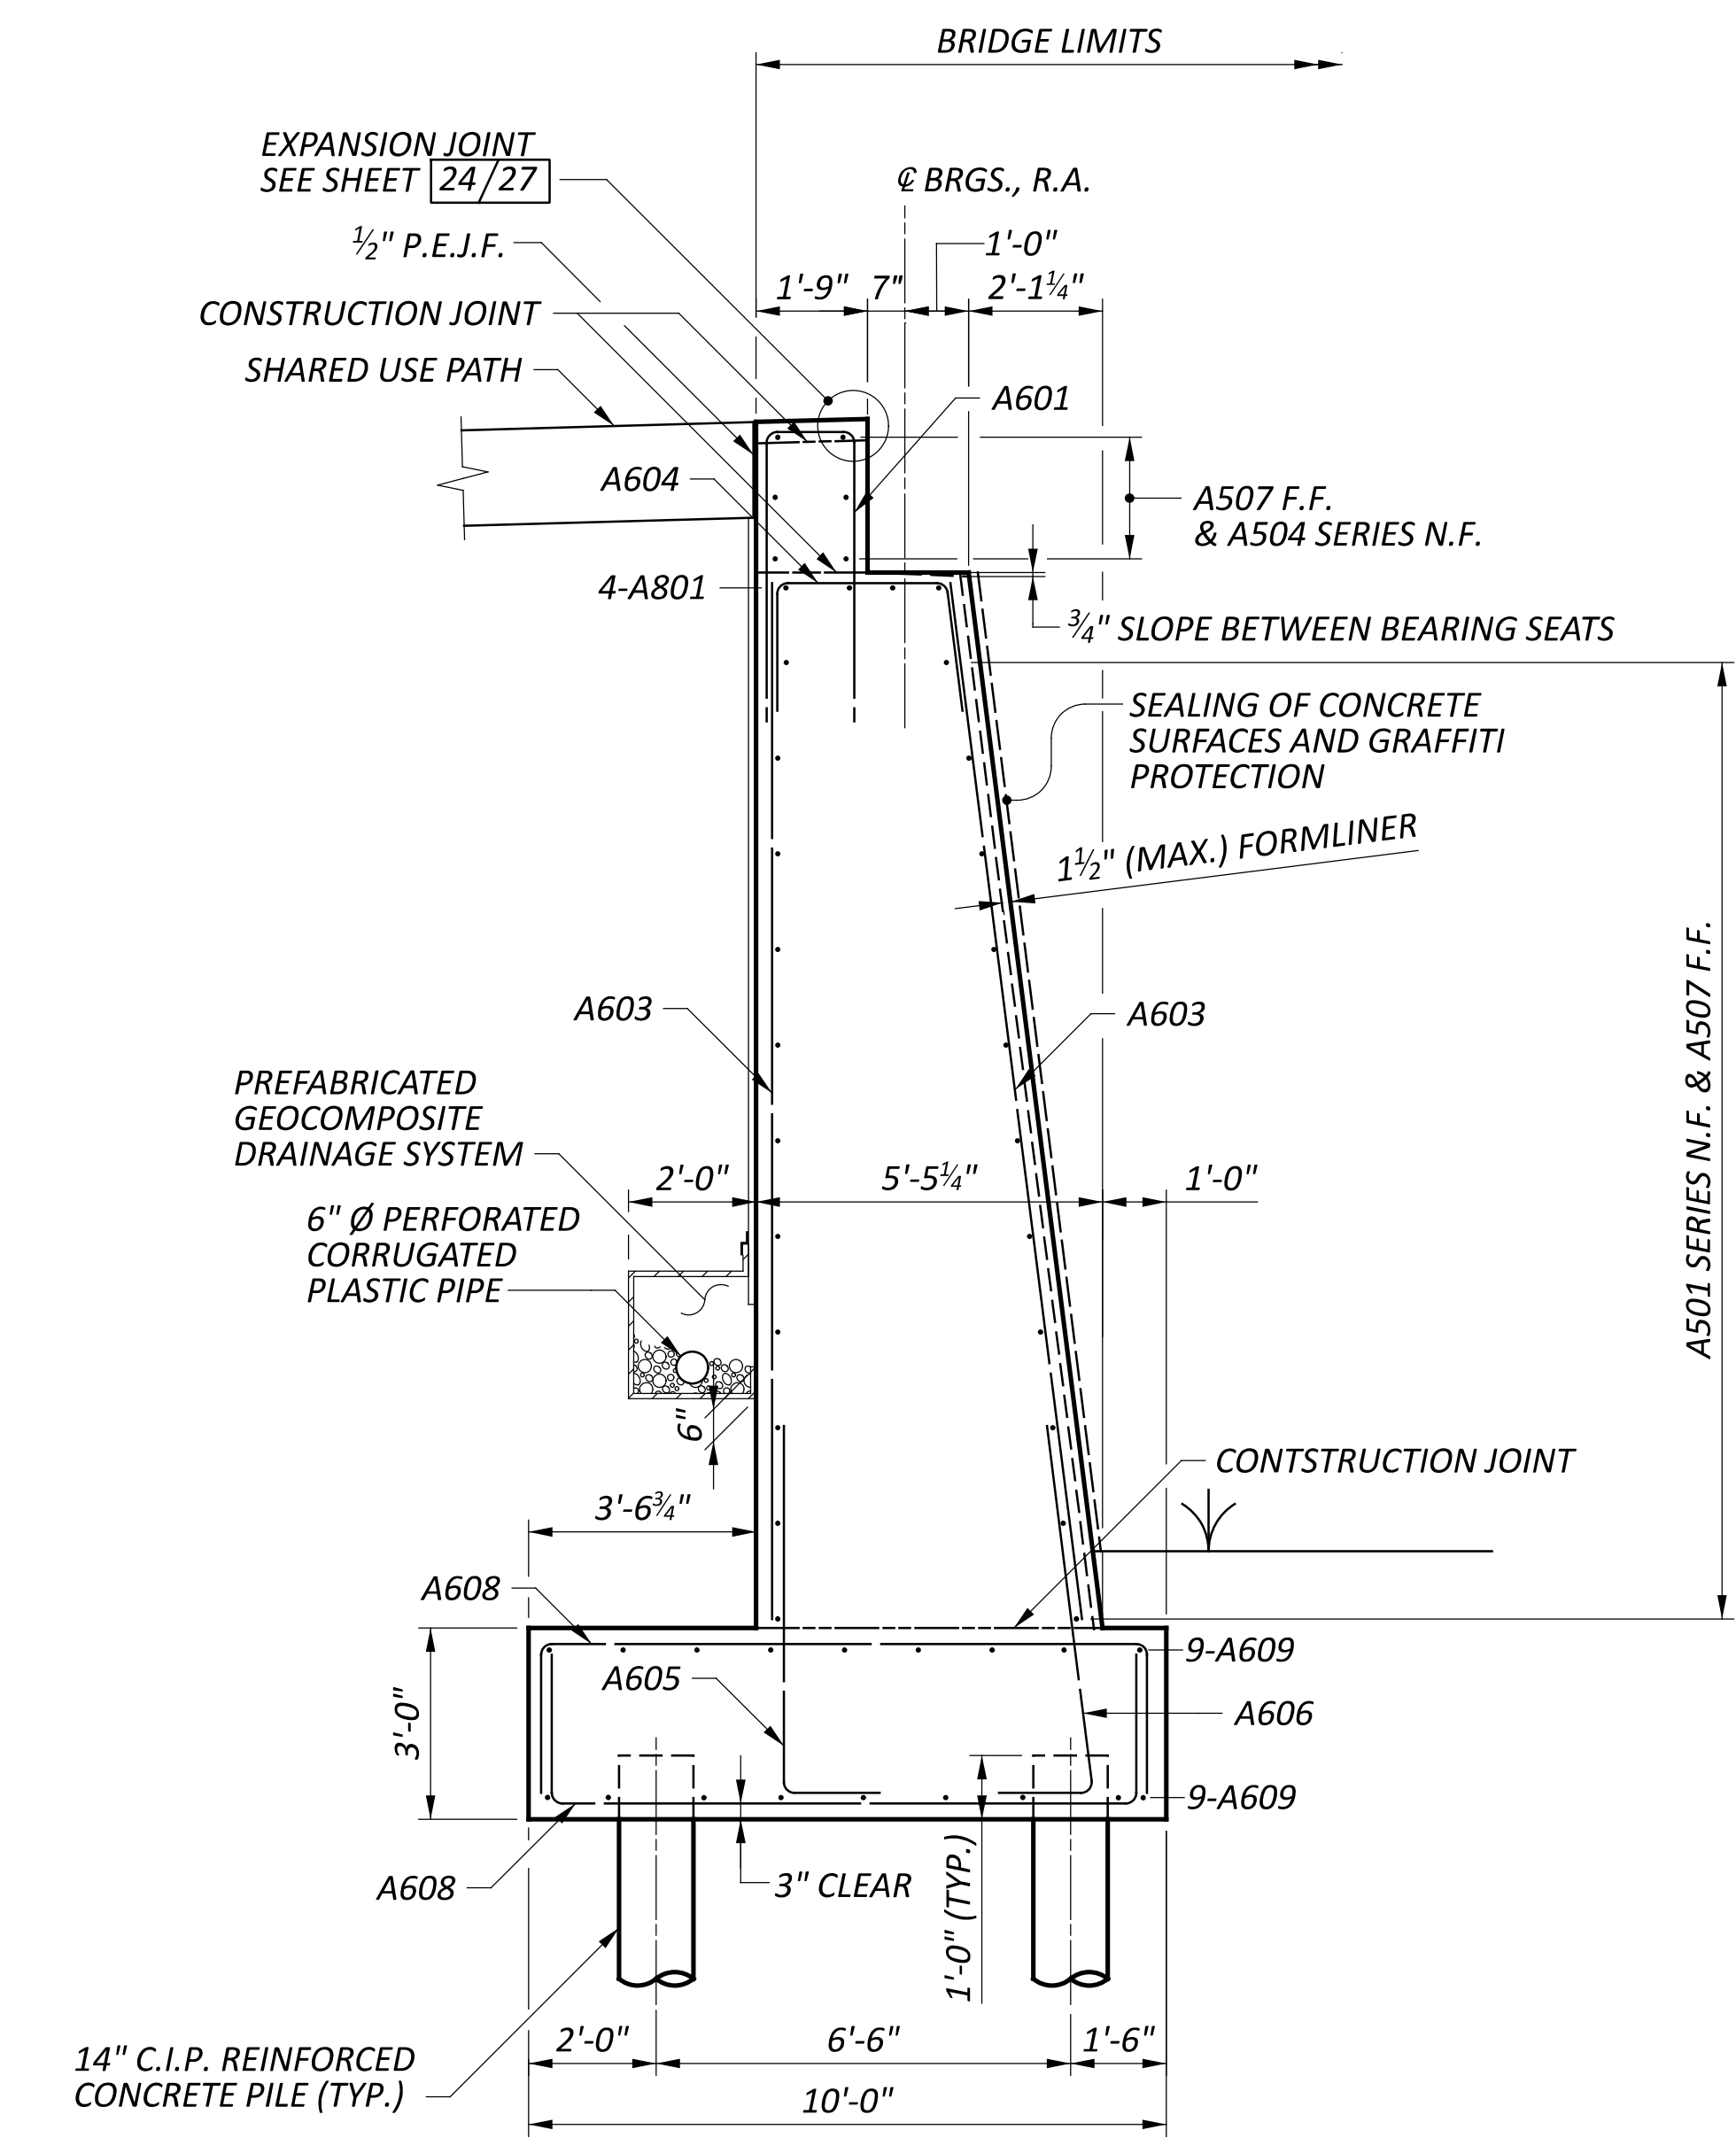


**A SECTION**

- NOTES**
1. MINIMUM LAP SPLICE LENGTH: #6 BAR = 36 INCHES
  2. 3" DIAMETER SLEEVE FOR THE 2" CONDUIT. THE GAP BETWEEN THE SLEEVE AND 2" CONDUIT SHALL BE FULLY SEALED BY CONTRACTOR.


SFN	2926107
DESIGN AGENCY	CARPENTER MARTY
DESIGNER	CHECKER
SMH	AMR
REVIEWER	
GDJ	03/28/25
PROJECT ID	115388
SUBSET	TOTAL
4	27
SHEET	TOTAL
P.50	P.107

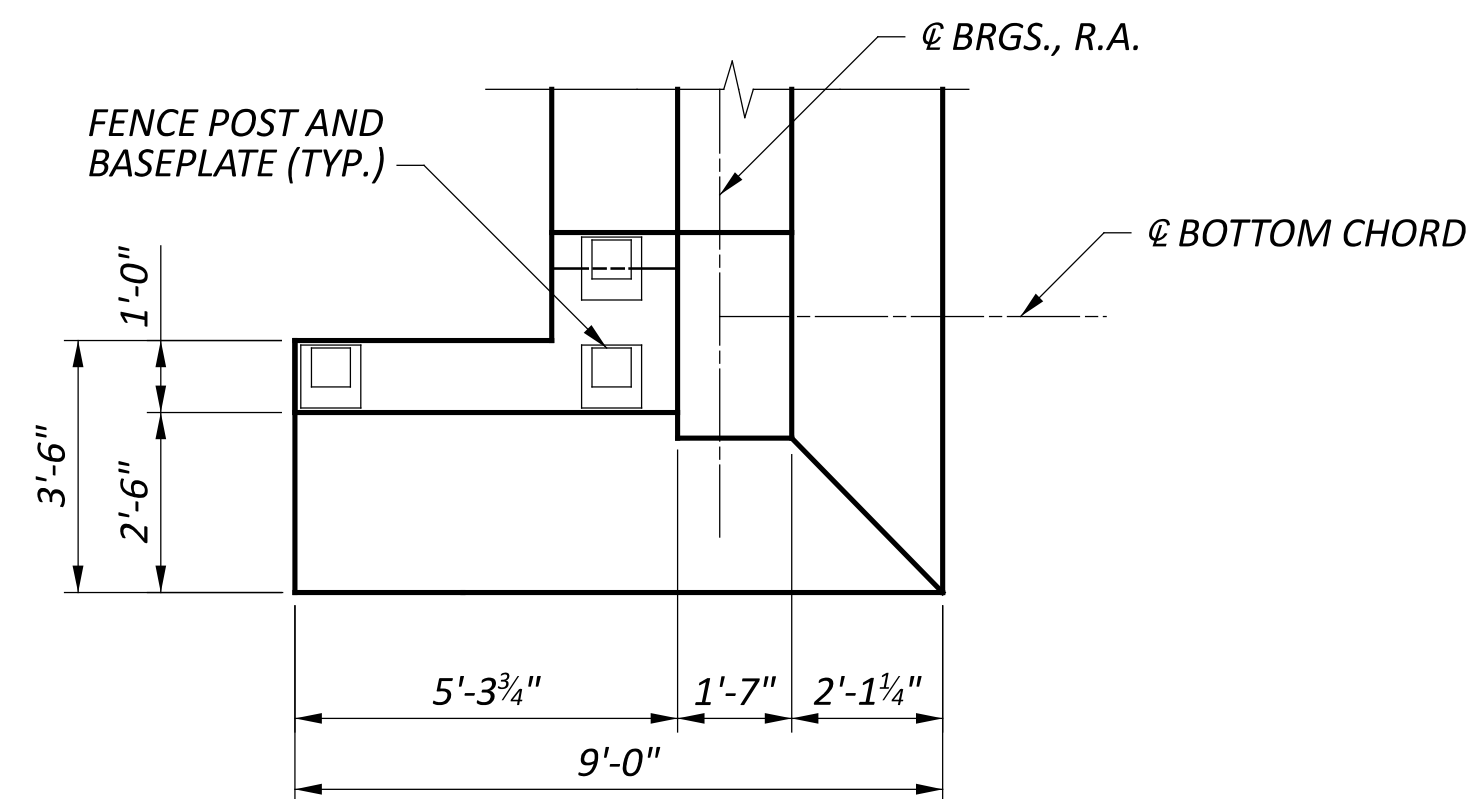

**WINGWALL 1 PLAN**  
 WINGWALL 2 OPPOSITE,  
 ADJACENT RETAINING WALLS NOT SHOWN

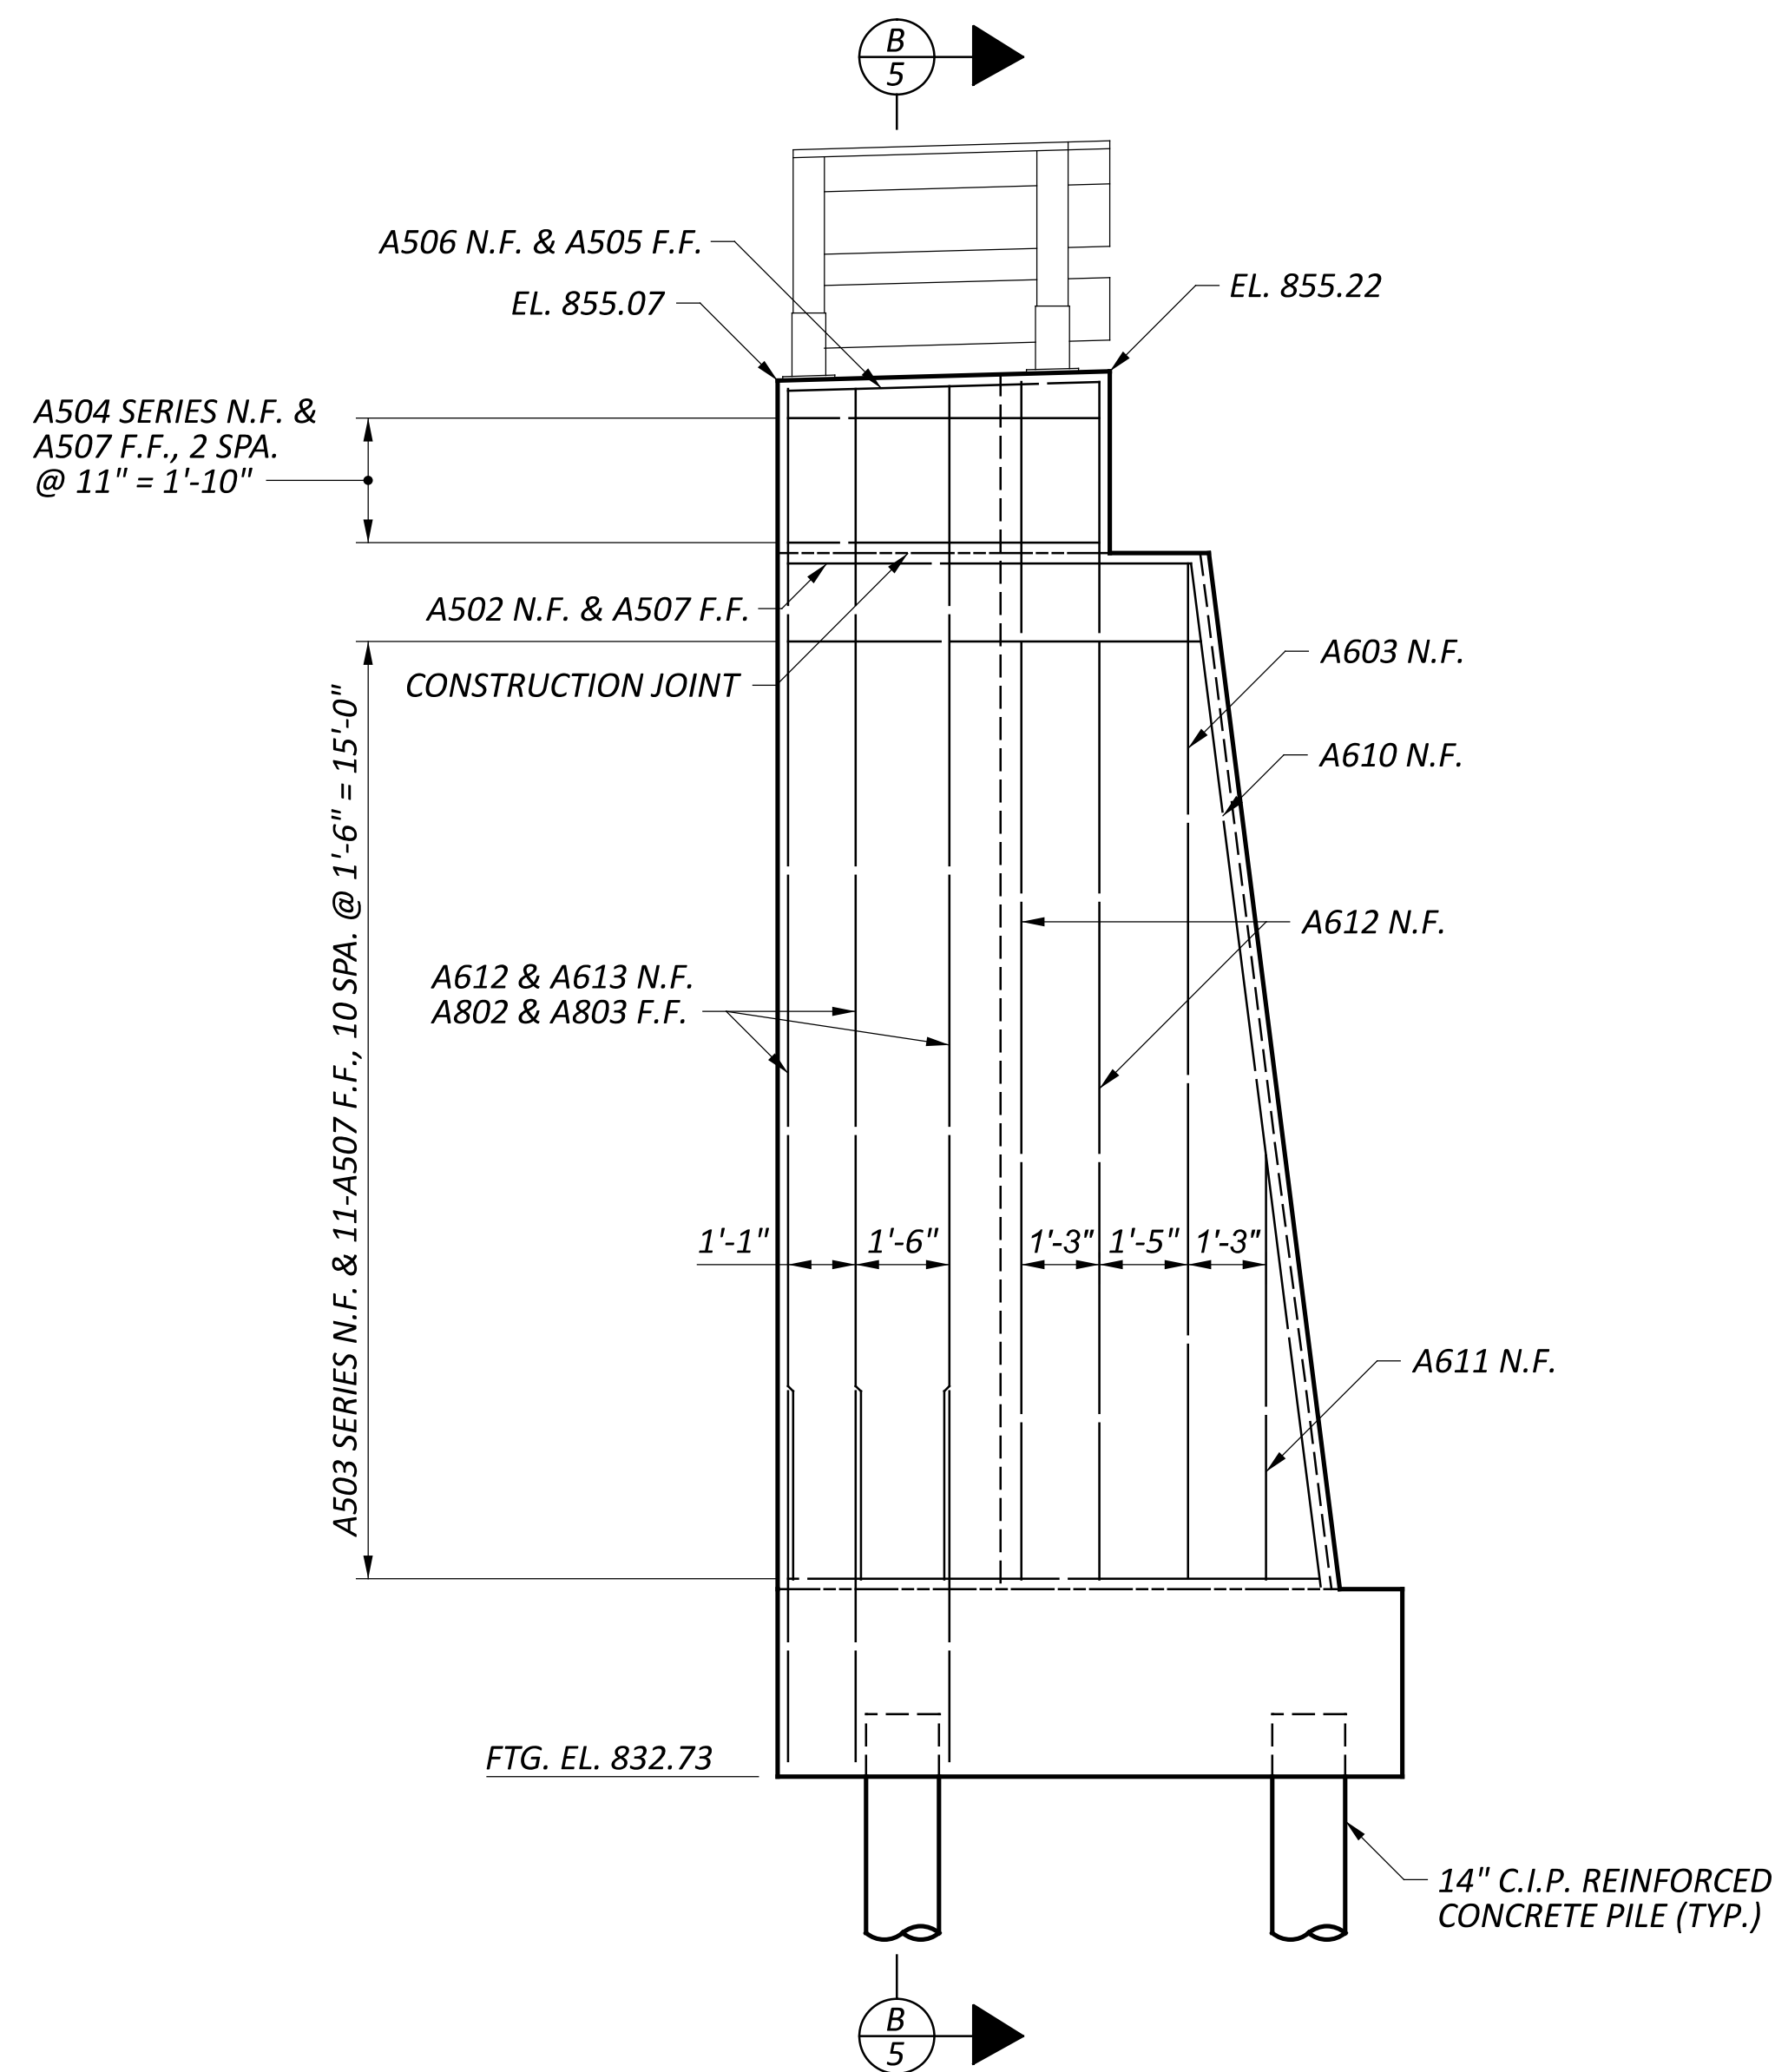

**WINGWALL 1 ELEVATION**  
 WINGWALL 2 OPPOSITE

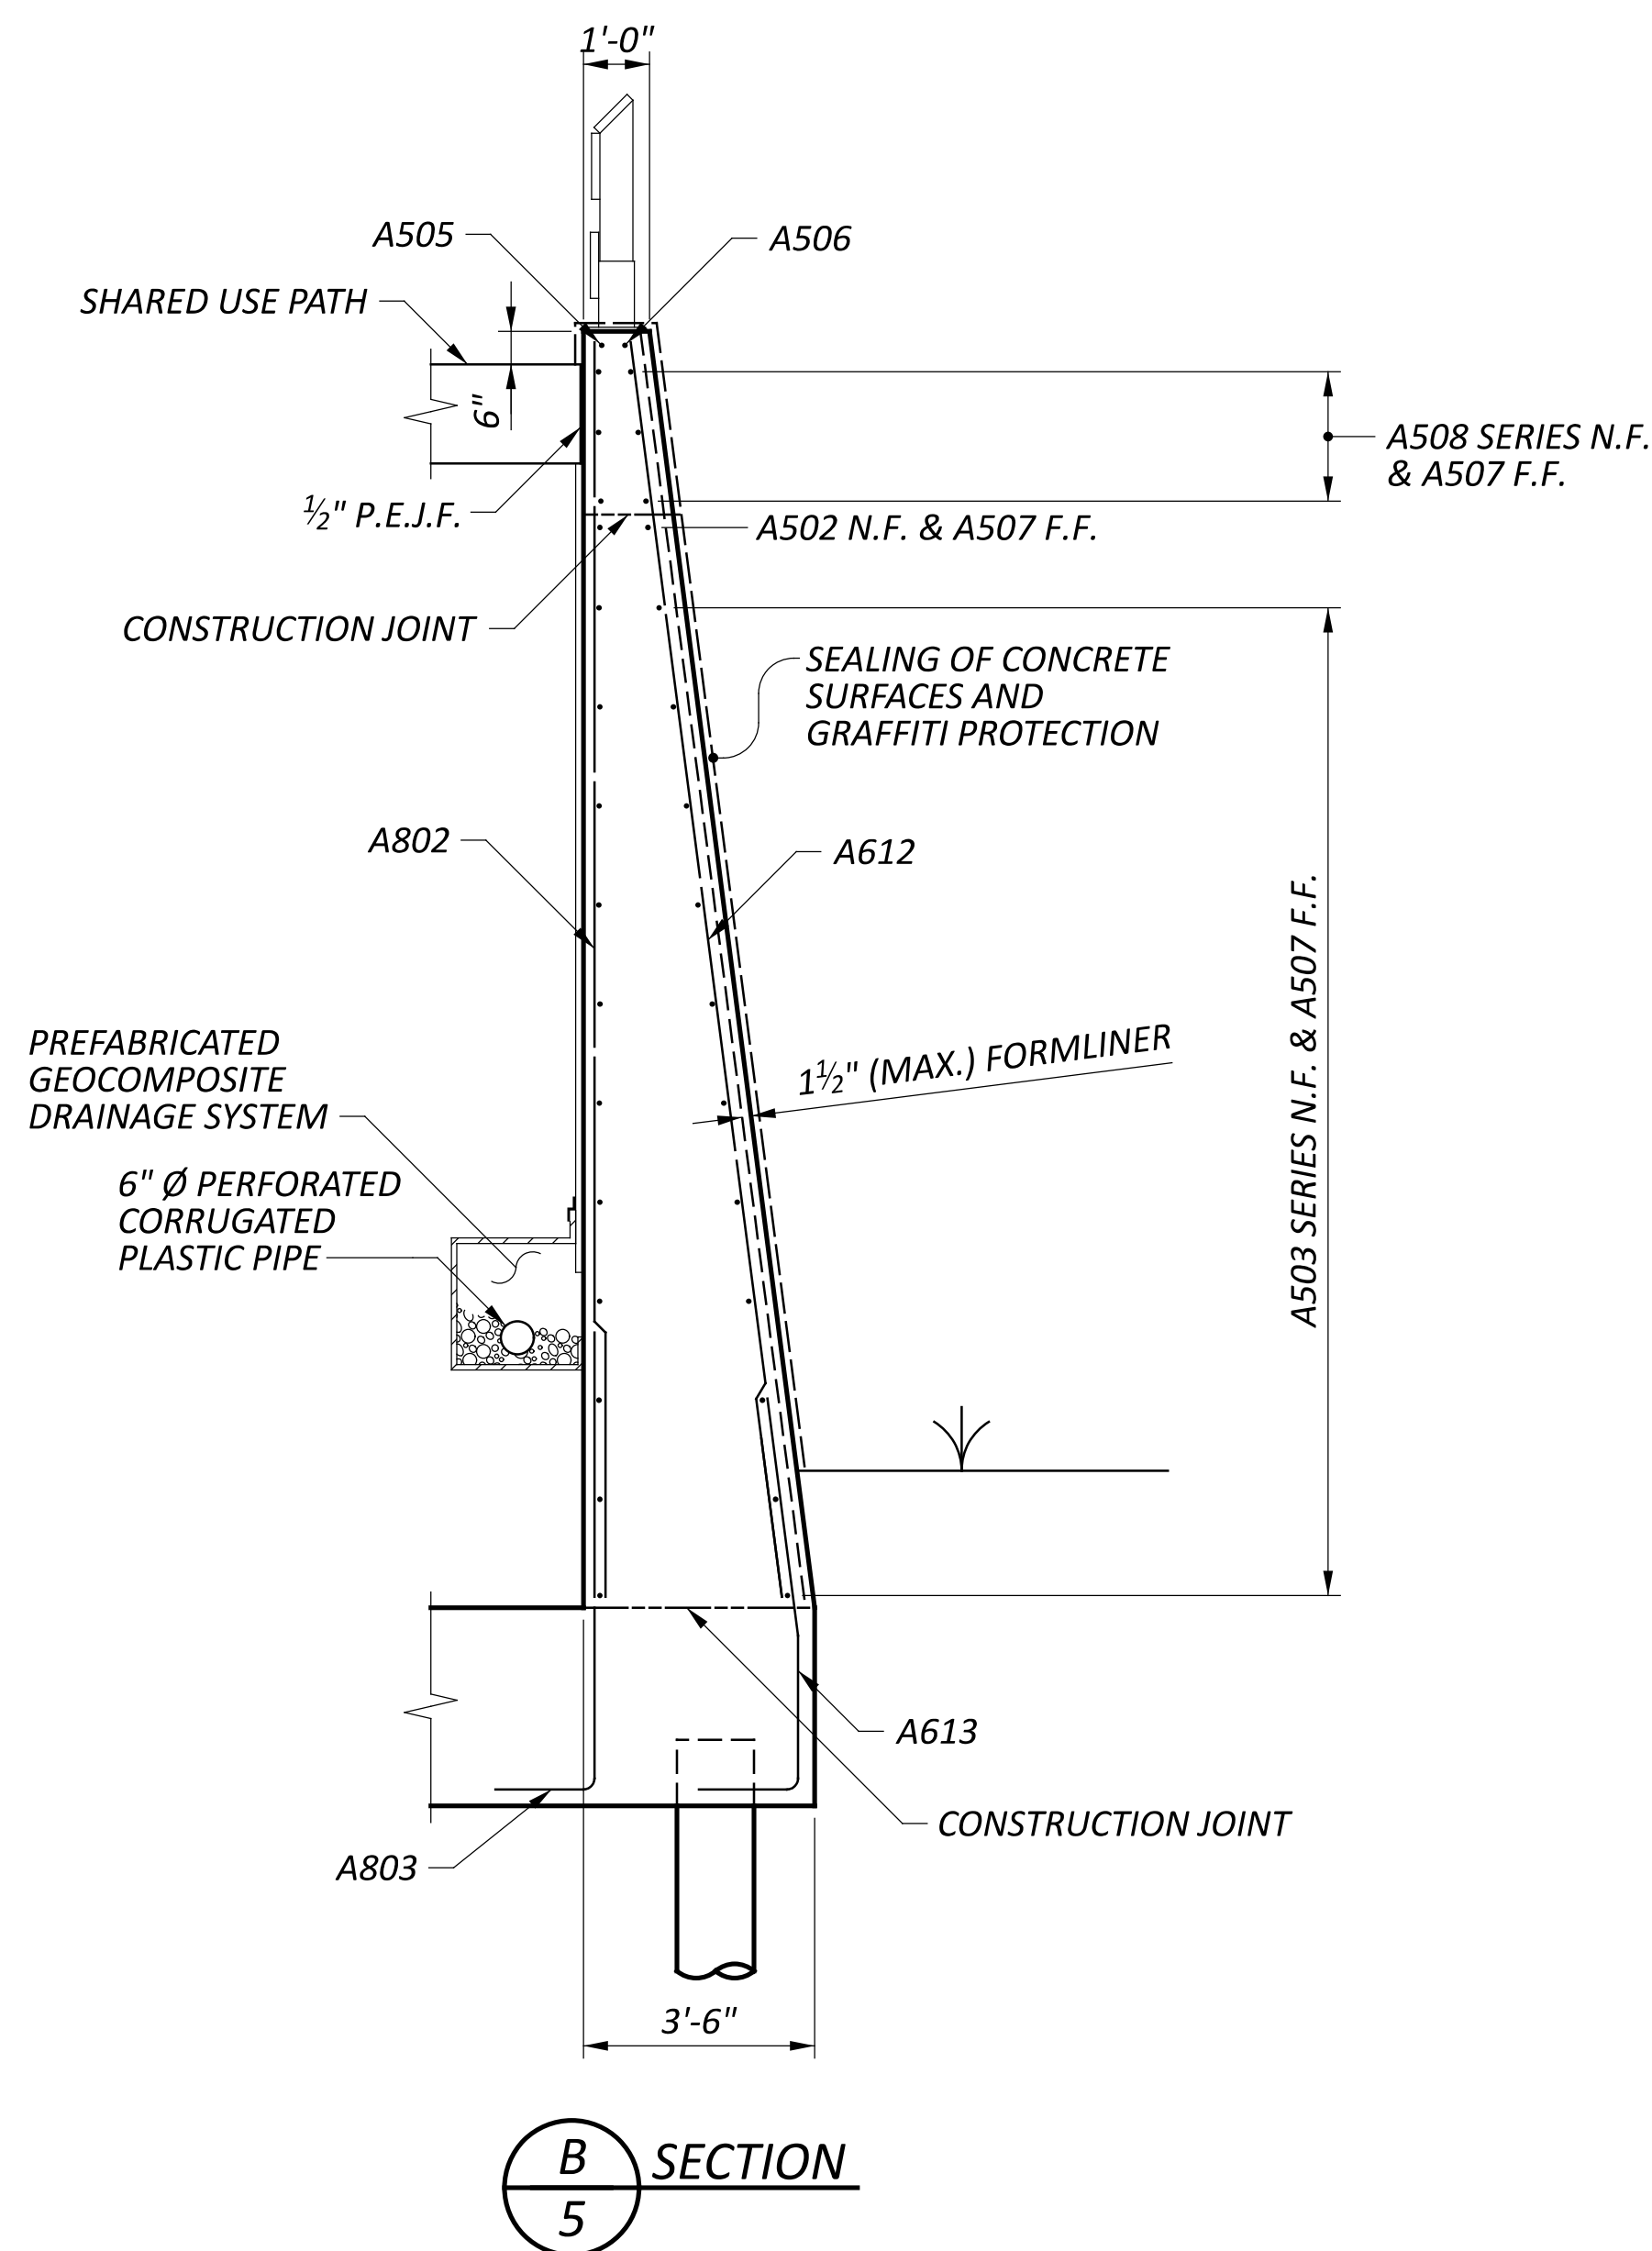

**SECTION B-5**

**NOTE**


MINIMUM LAP SPLICE LENGTH:  
 #6 BAR = 36 INCHES

**LEGEND**

- E.F. - EACH FACE
- F.F. - FAR FACE
- N.F. - NEAR FACE

SFN  
 2926107

DESIGN AGENCY

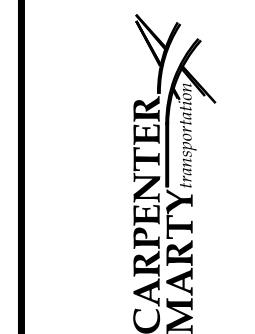

DESIGNER: SMH  
 CHECKER: AMR

REVIEWER

GDJ 03/28/25

PROJECT ID

1153888


SUBSET TOTAL

5 27


SHEET TOTAL

P.51 P.107


**NOTE**  
 MINIMUM LAP SPLICE LENGTH:  
 #8 BAR = 4'-6"

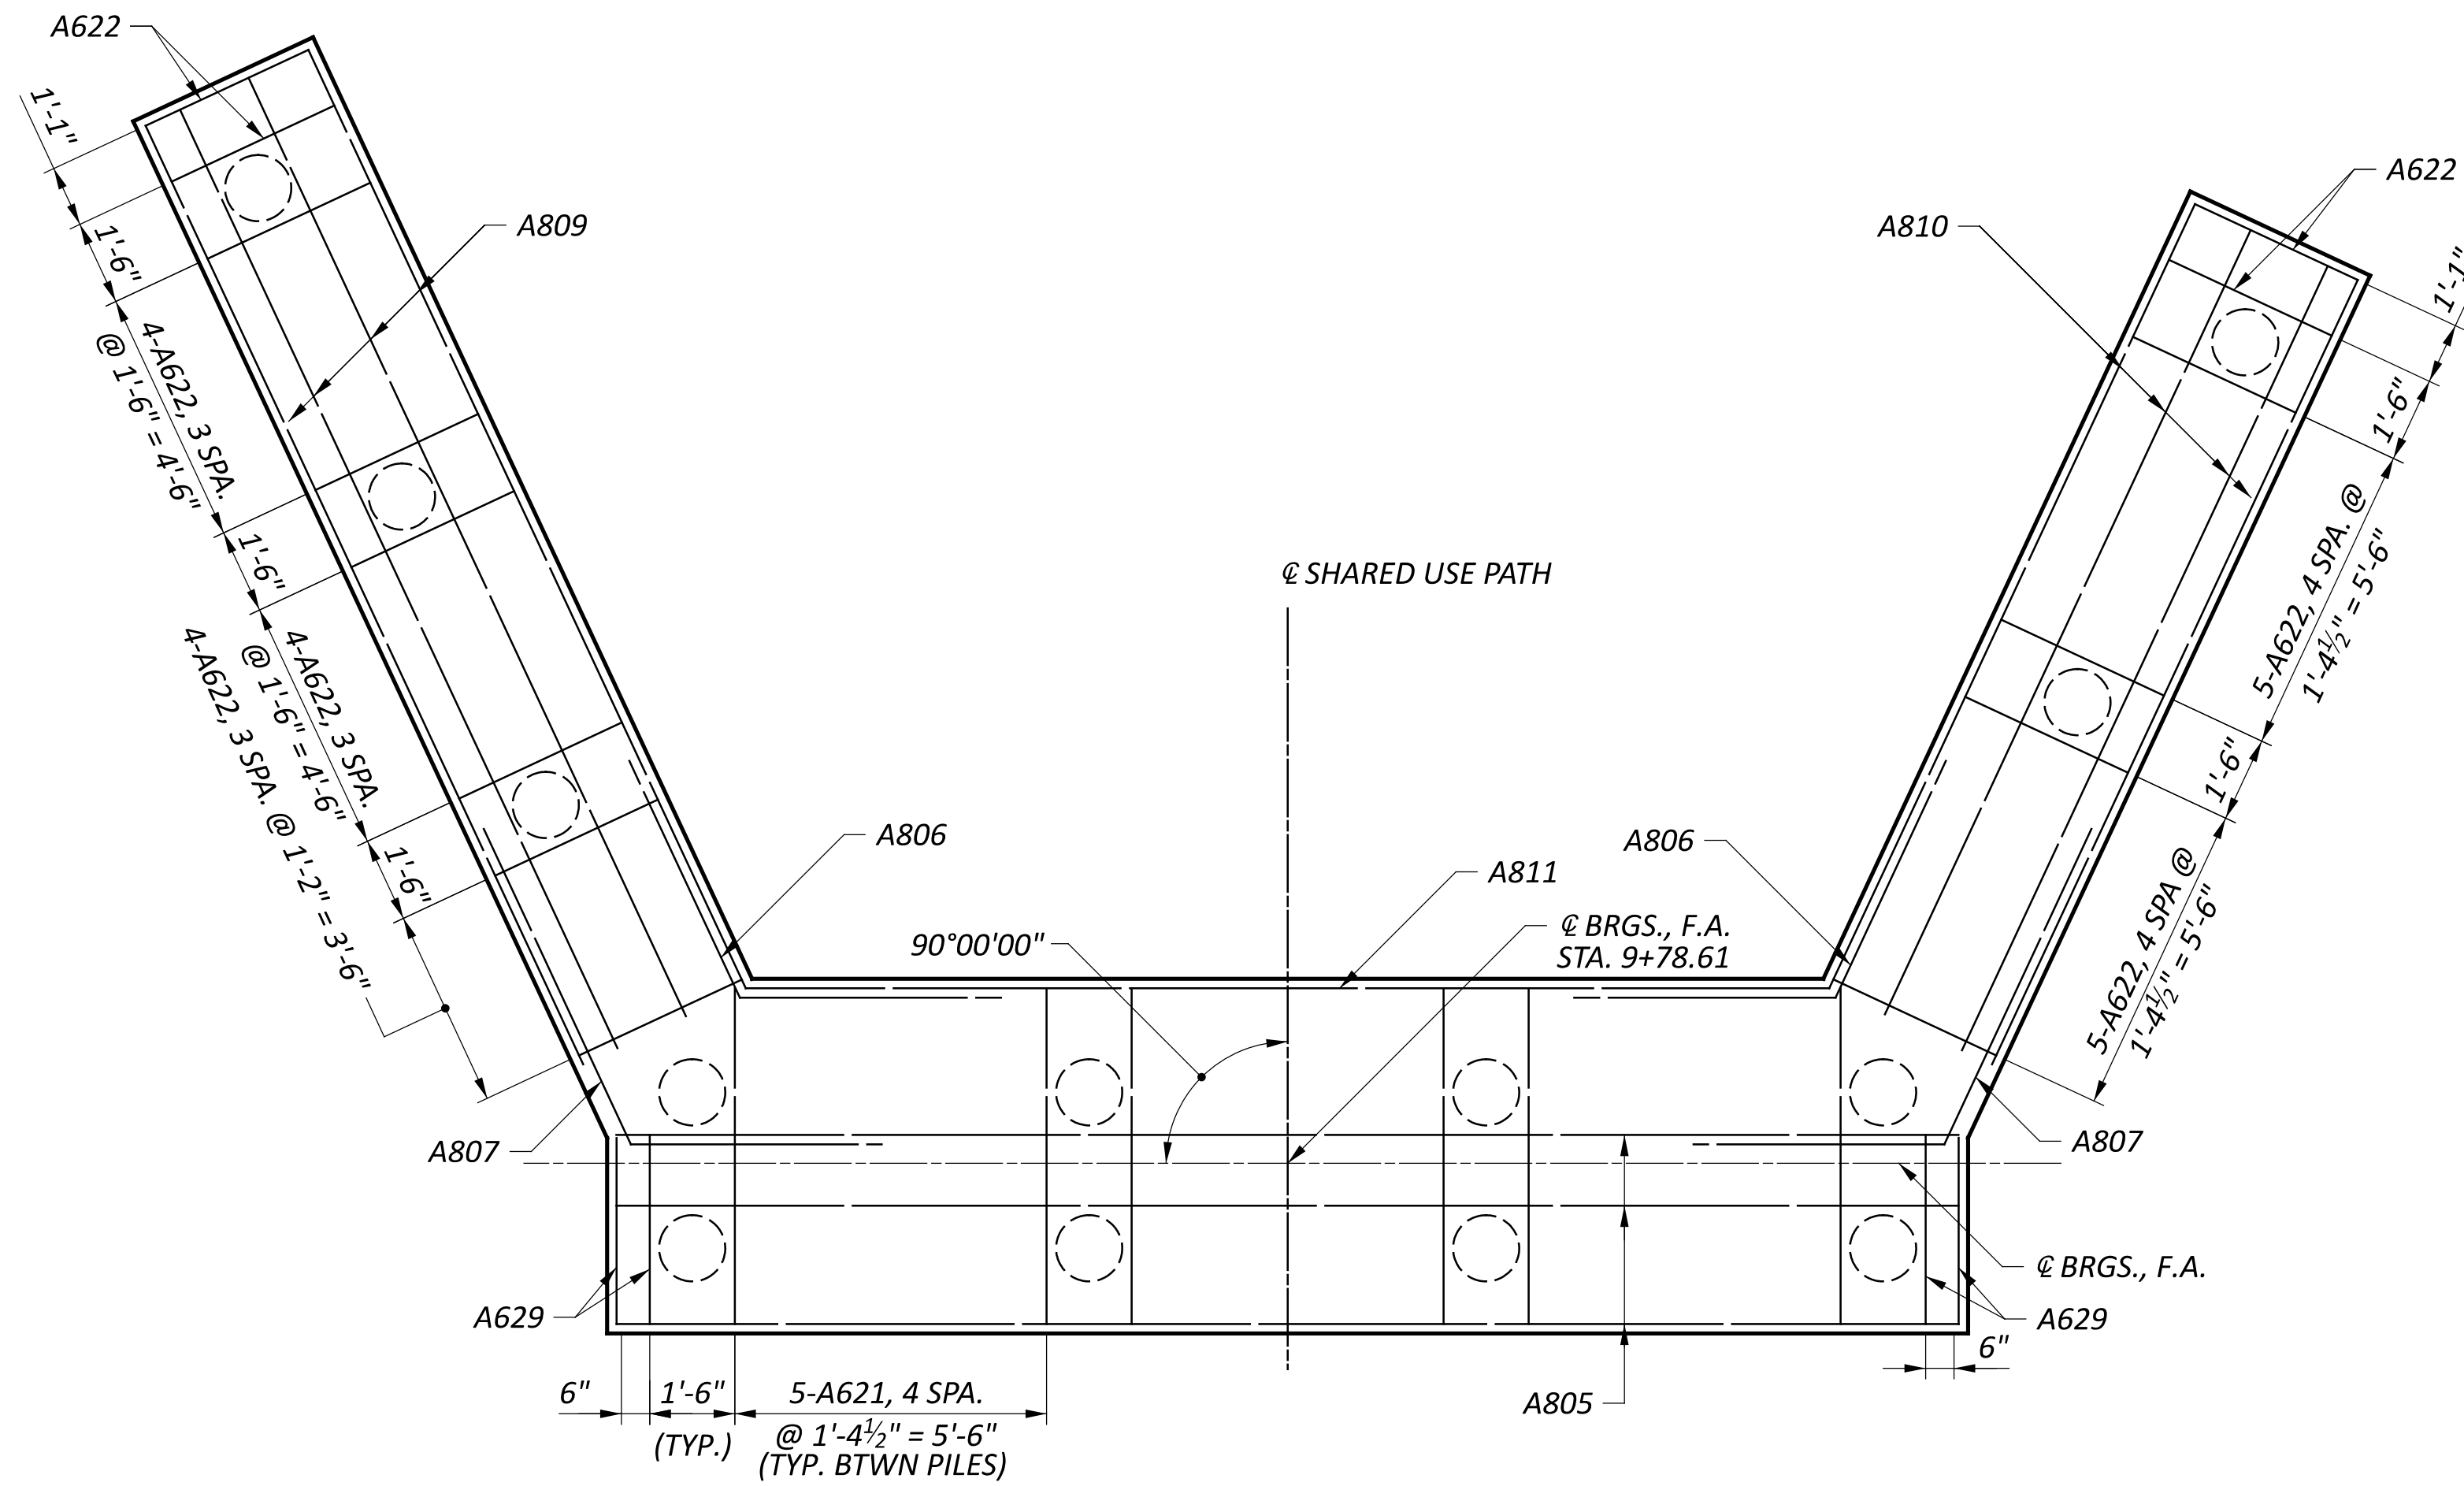


BOTTOM MAT REINFORCEMENT PLAN

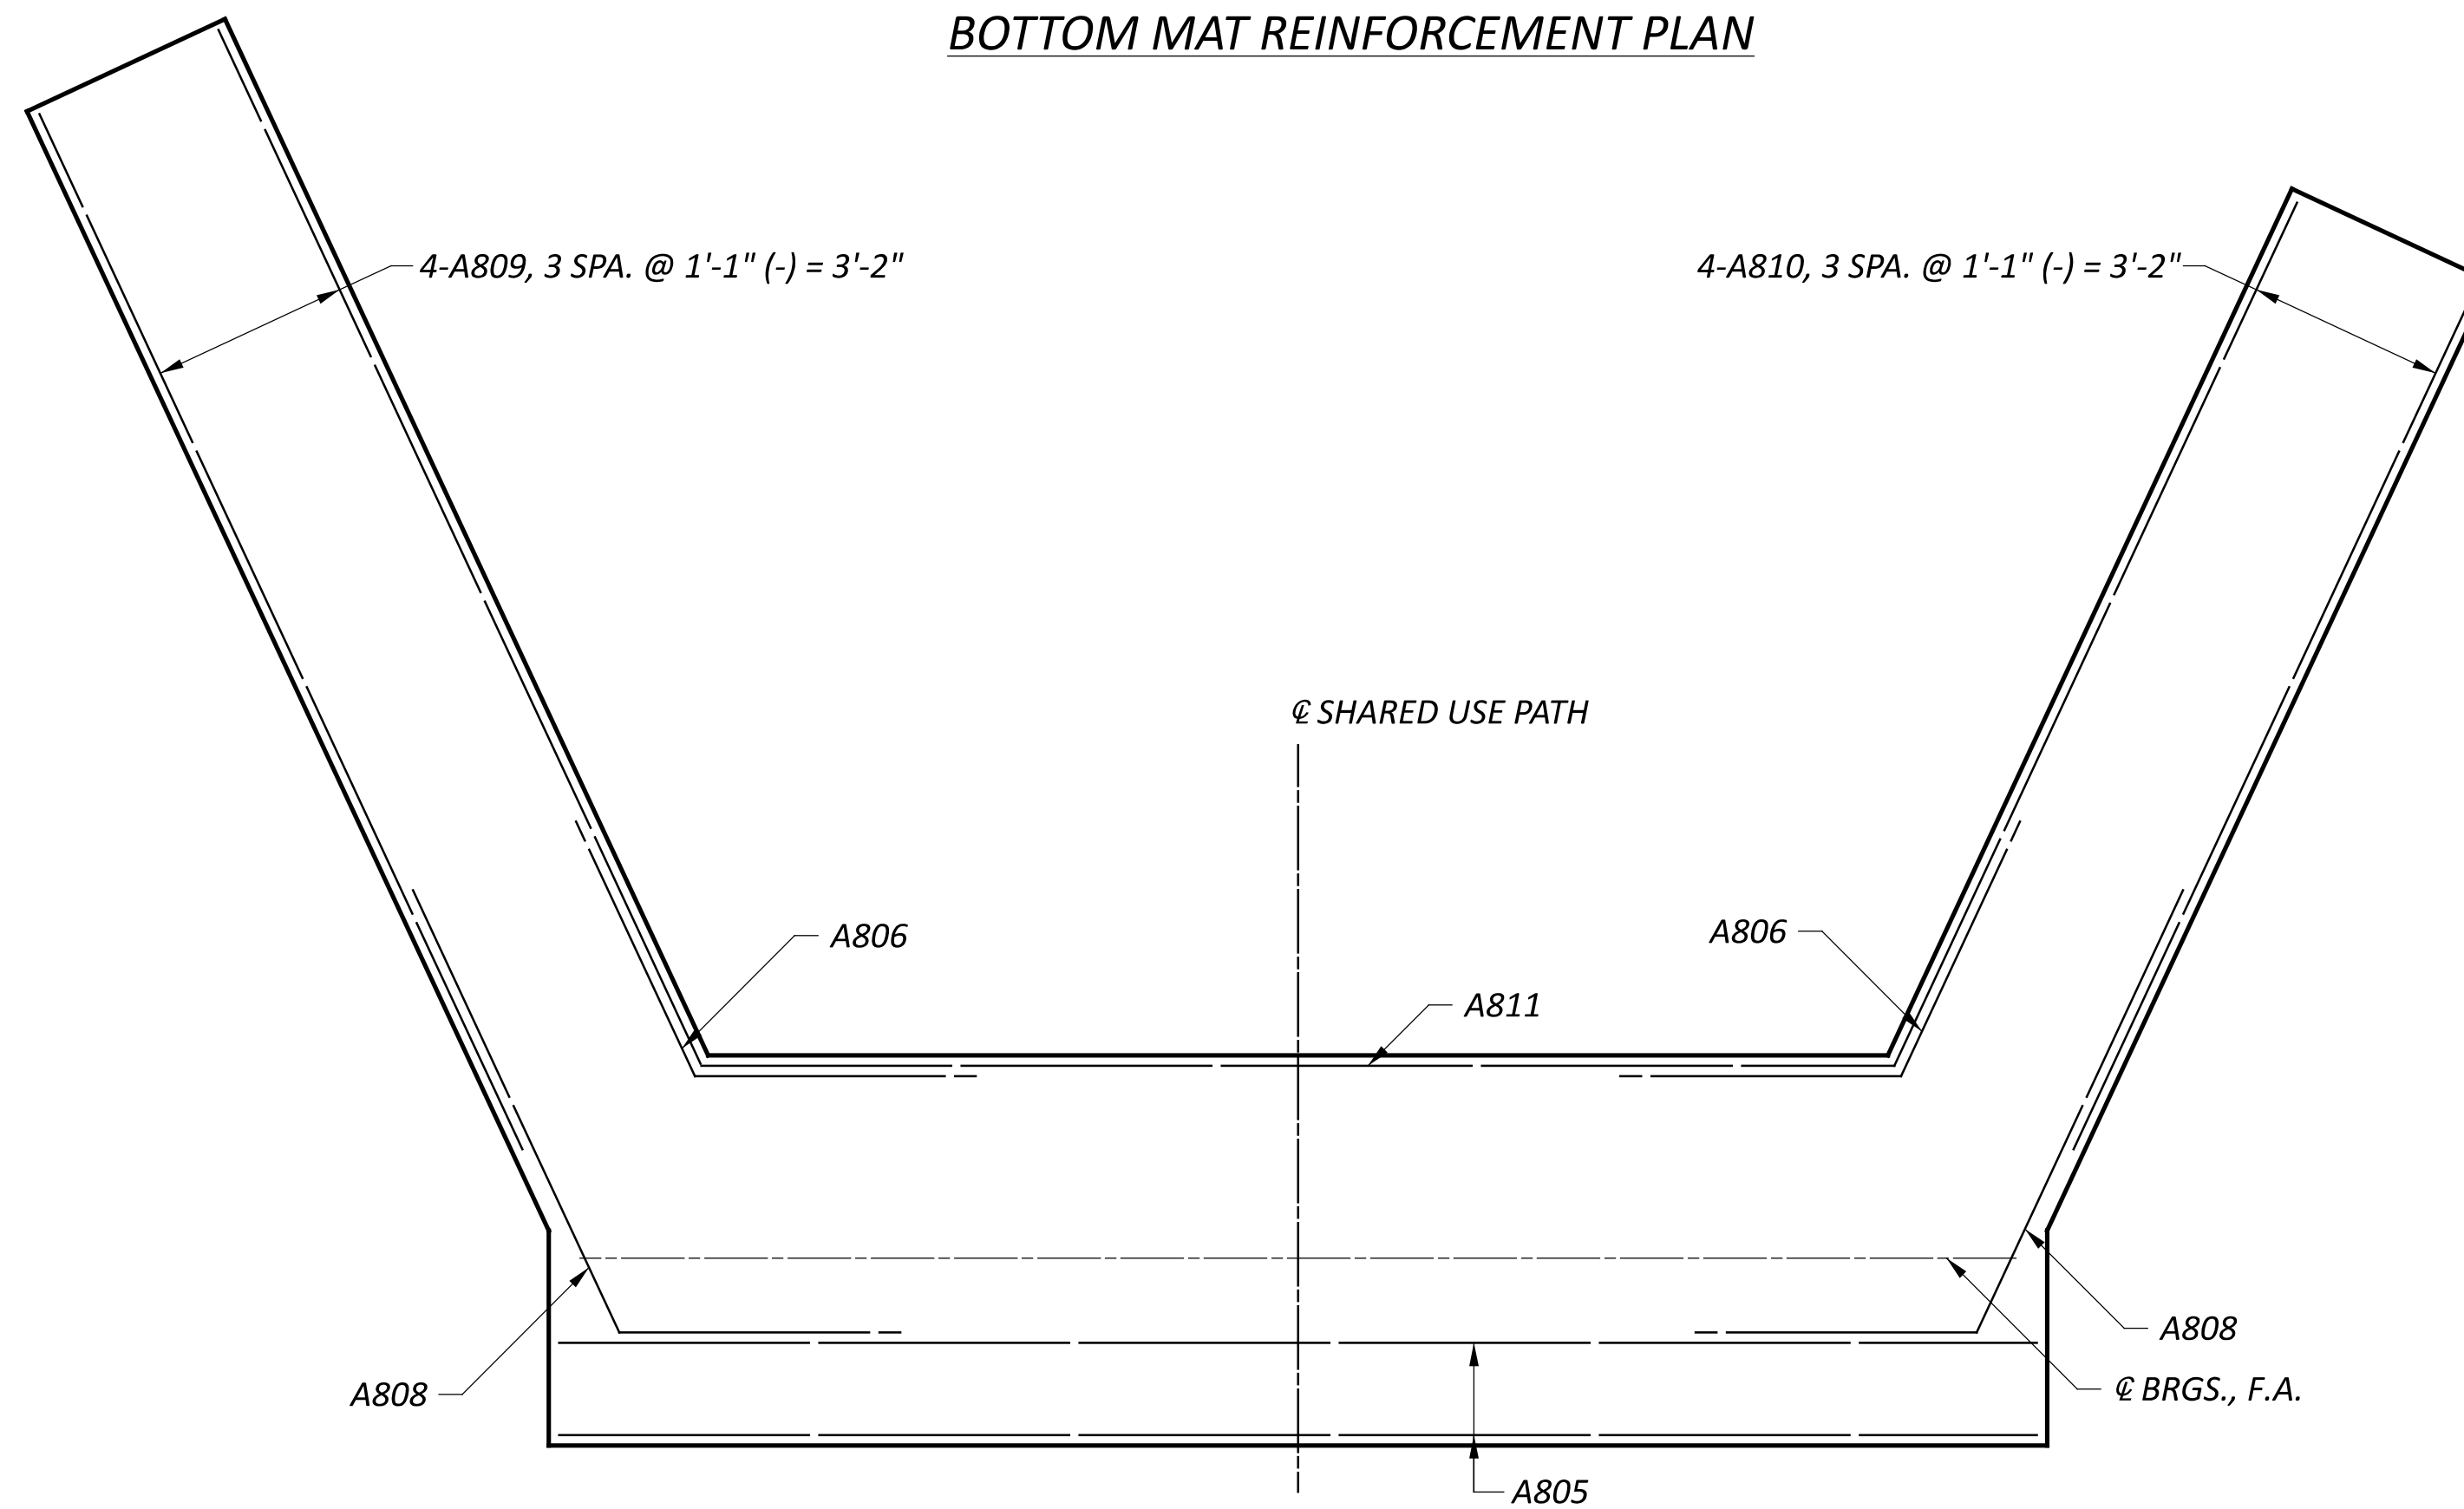

TOP MAT REINFORCEMENT PLAN

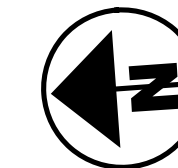

SFN	
2926107	
DESIGN AGENCY	
DESIGNER	CHECKER
SMH	AMR
REVIEWER	
GDJ 03/28/25	
PROJECT ID	
115388	
SUBSET	TOTAL
6	27
SHEET	TOTAL
P.52	P.107

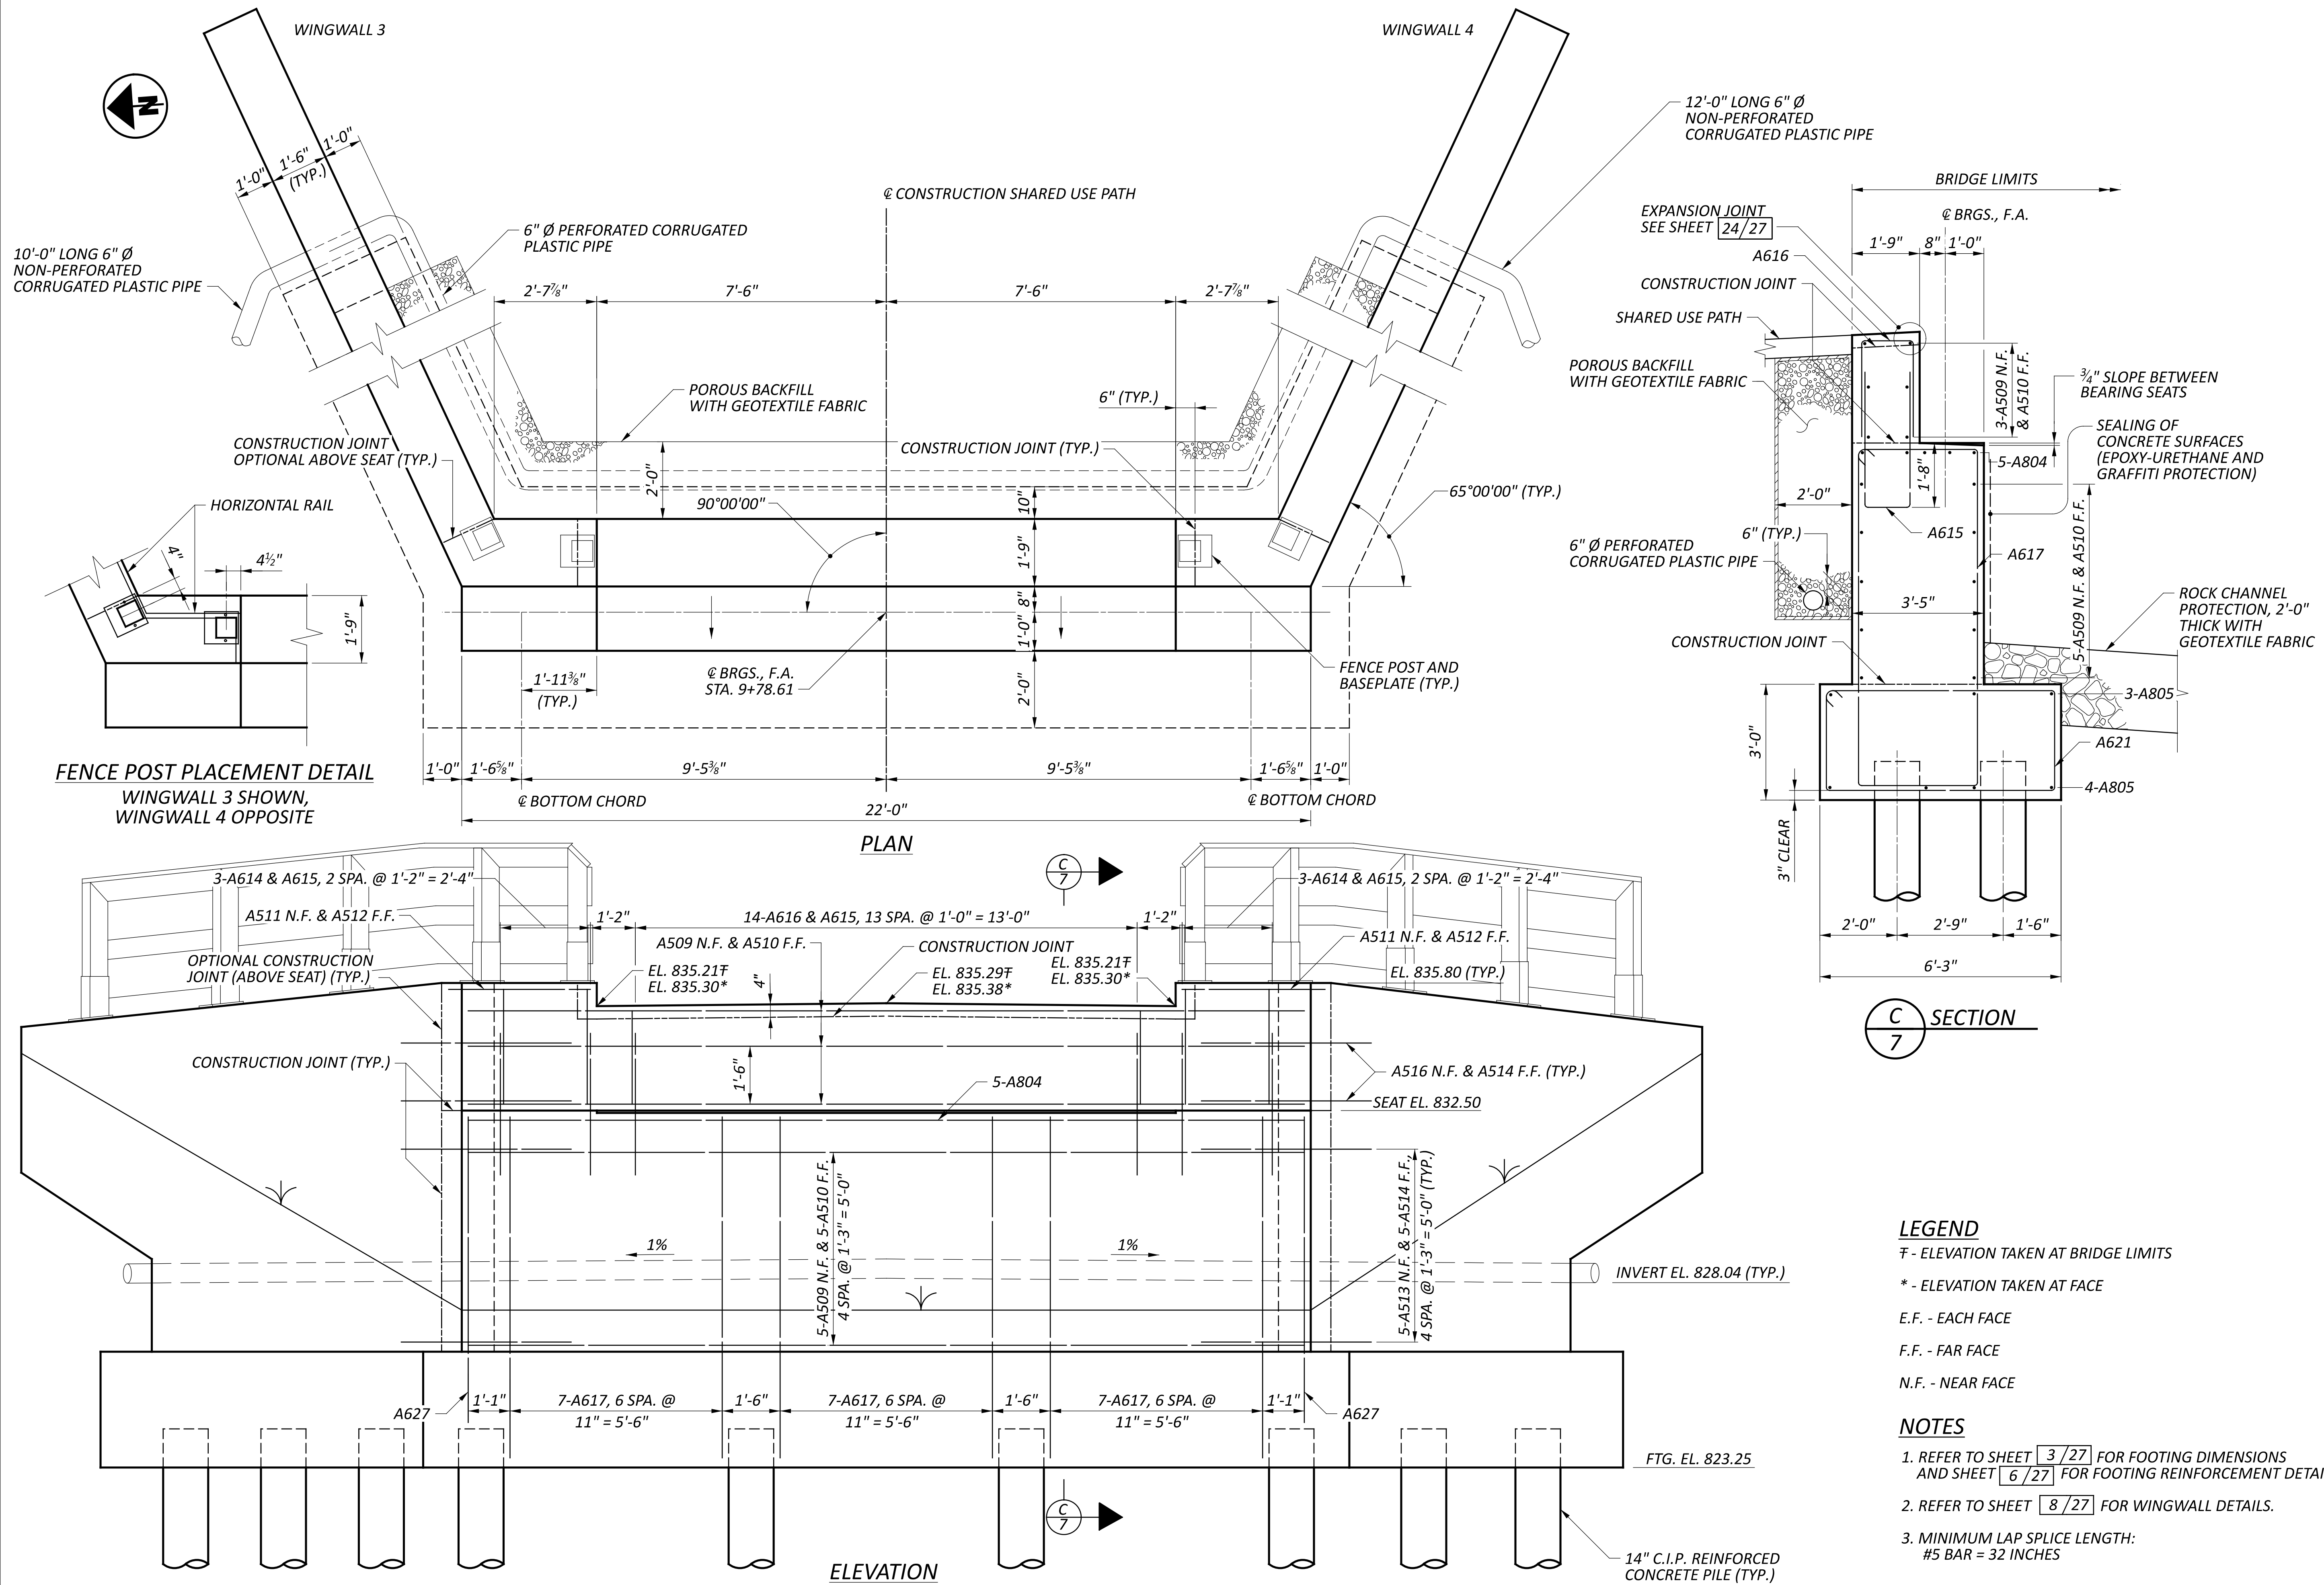

**LEGEND**


- ∇ - ELEVATION TAKEN AT BRIDGE LIMITS
- \* - ELEVATION TAKEN AT FACE
- E.F. - EACH FACE
- F.F. - FAR FACE
- N.F. - NEAR FACE

**NOTES**


1. REFER TO SHEET 3/27 FOR FOOTING DIMENSIONS AND SHEET 6/27 FOR FOOTING REINFORCEMENT DETAILS.
2. REFER TO SHEET 8/27 FOR WINGWALL DETAILS.
3. MINIMUM LAP SPLICE LENGTH: #5 BAR = 32 INCHES

FORWARD ABUTMENT DETAILS  
 BRIDGE NO. GRE-BK80020-00.492  
 PEDESTRIAN BRIDGE OVER US 68 AND OLDTOWN CREEK


SFN 2926107	
DESIGN AGENCY	
DESIGNER SMH	CHECKER AMR
REVIEWER GDJ 03/28/25	
PROJECT ID 115388	
SUBSET 7	TOTAL 27
SHEET P.53	TOTAL P.107

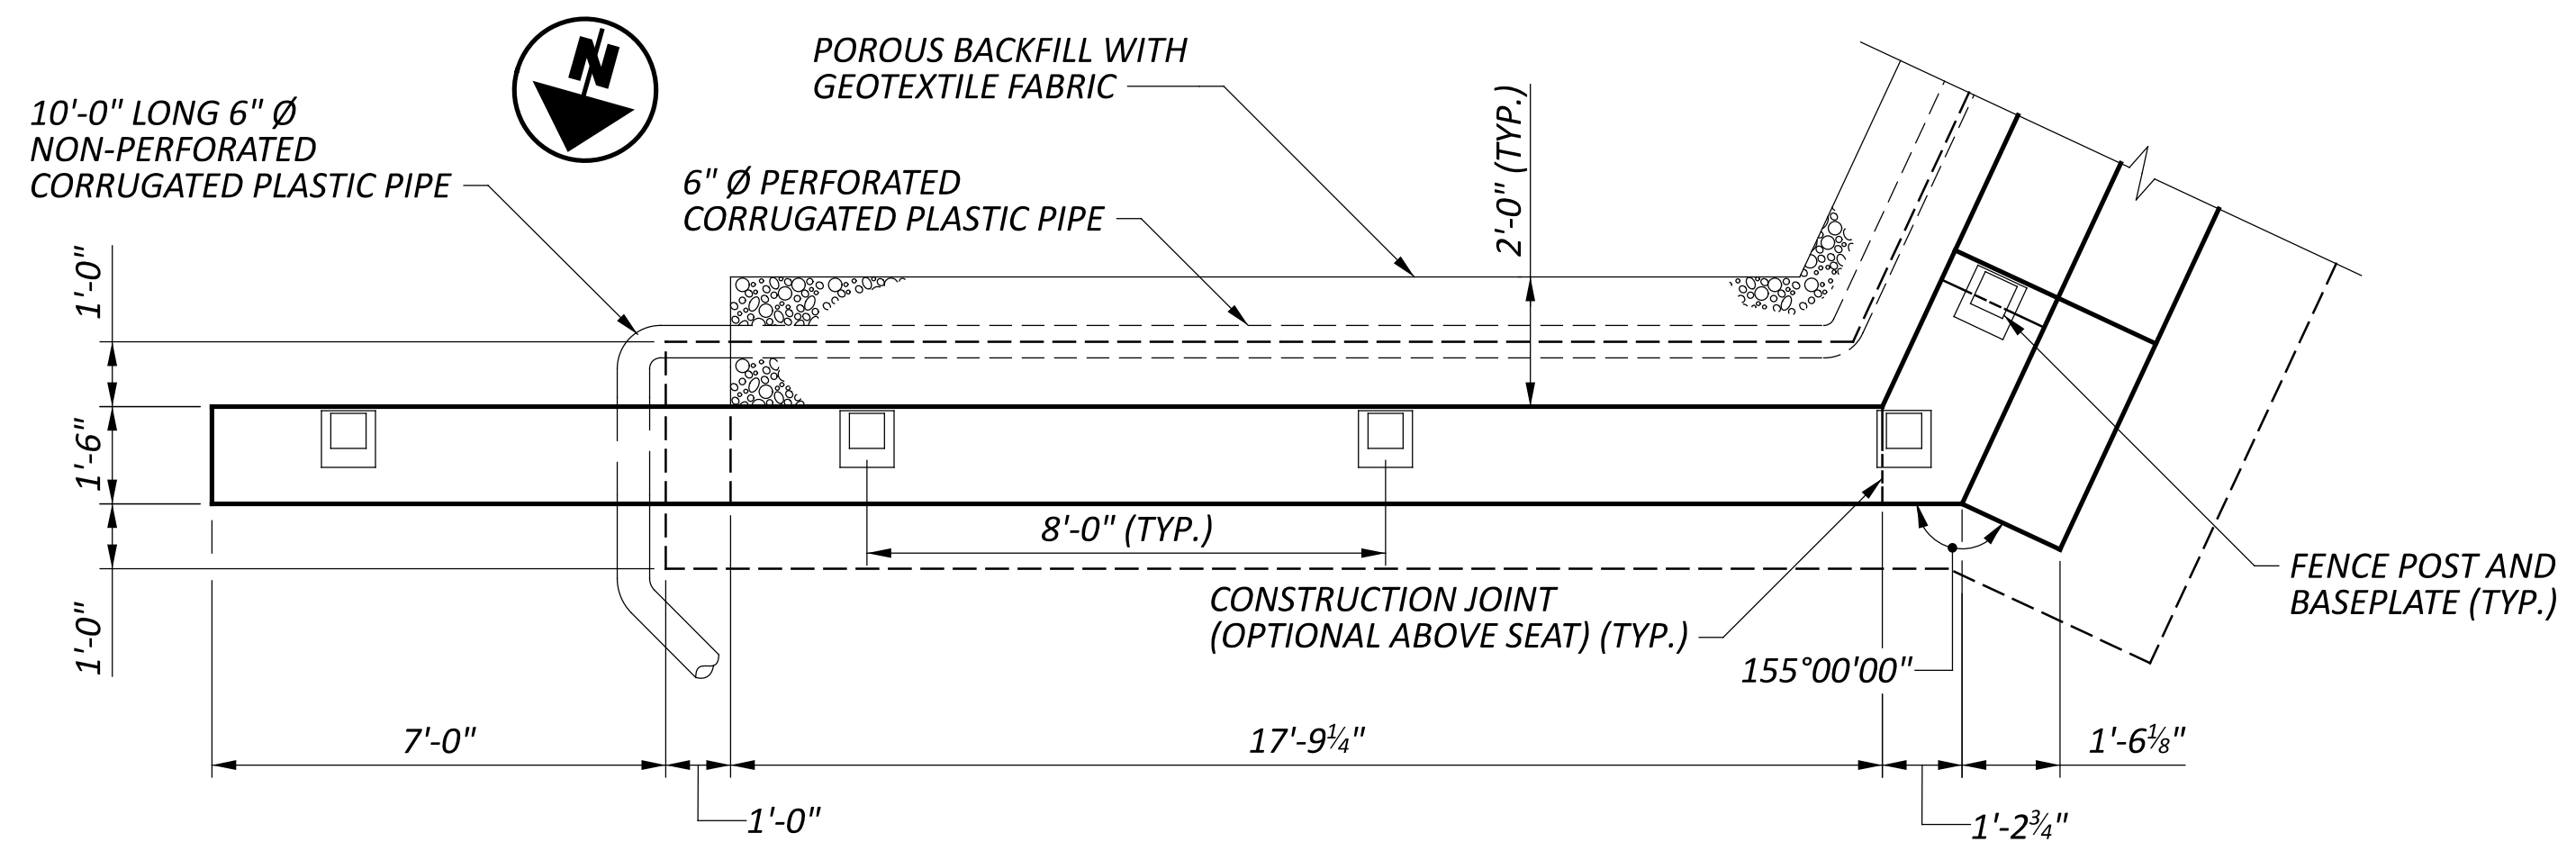


WINGWALL 3 PLAN

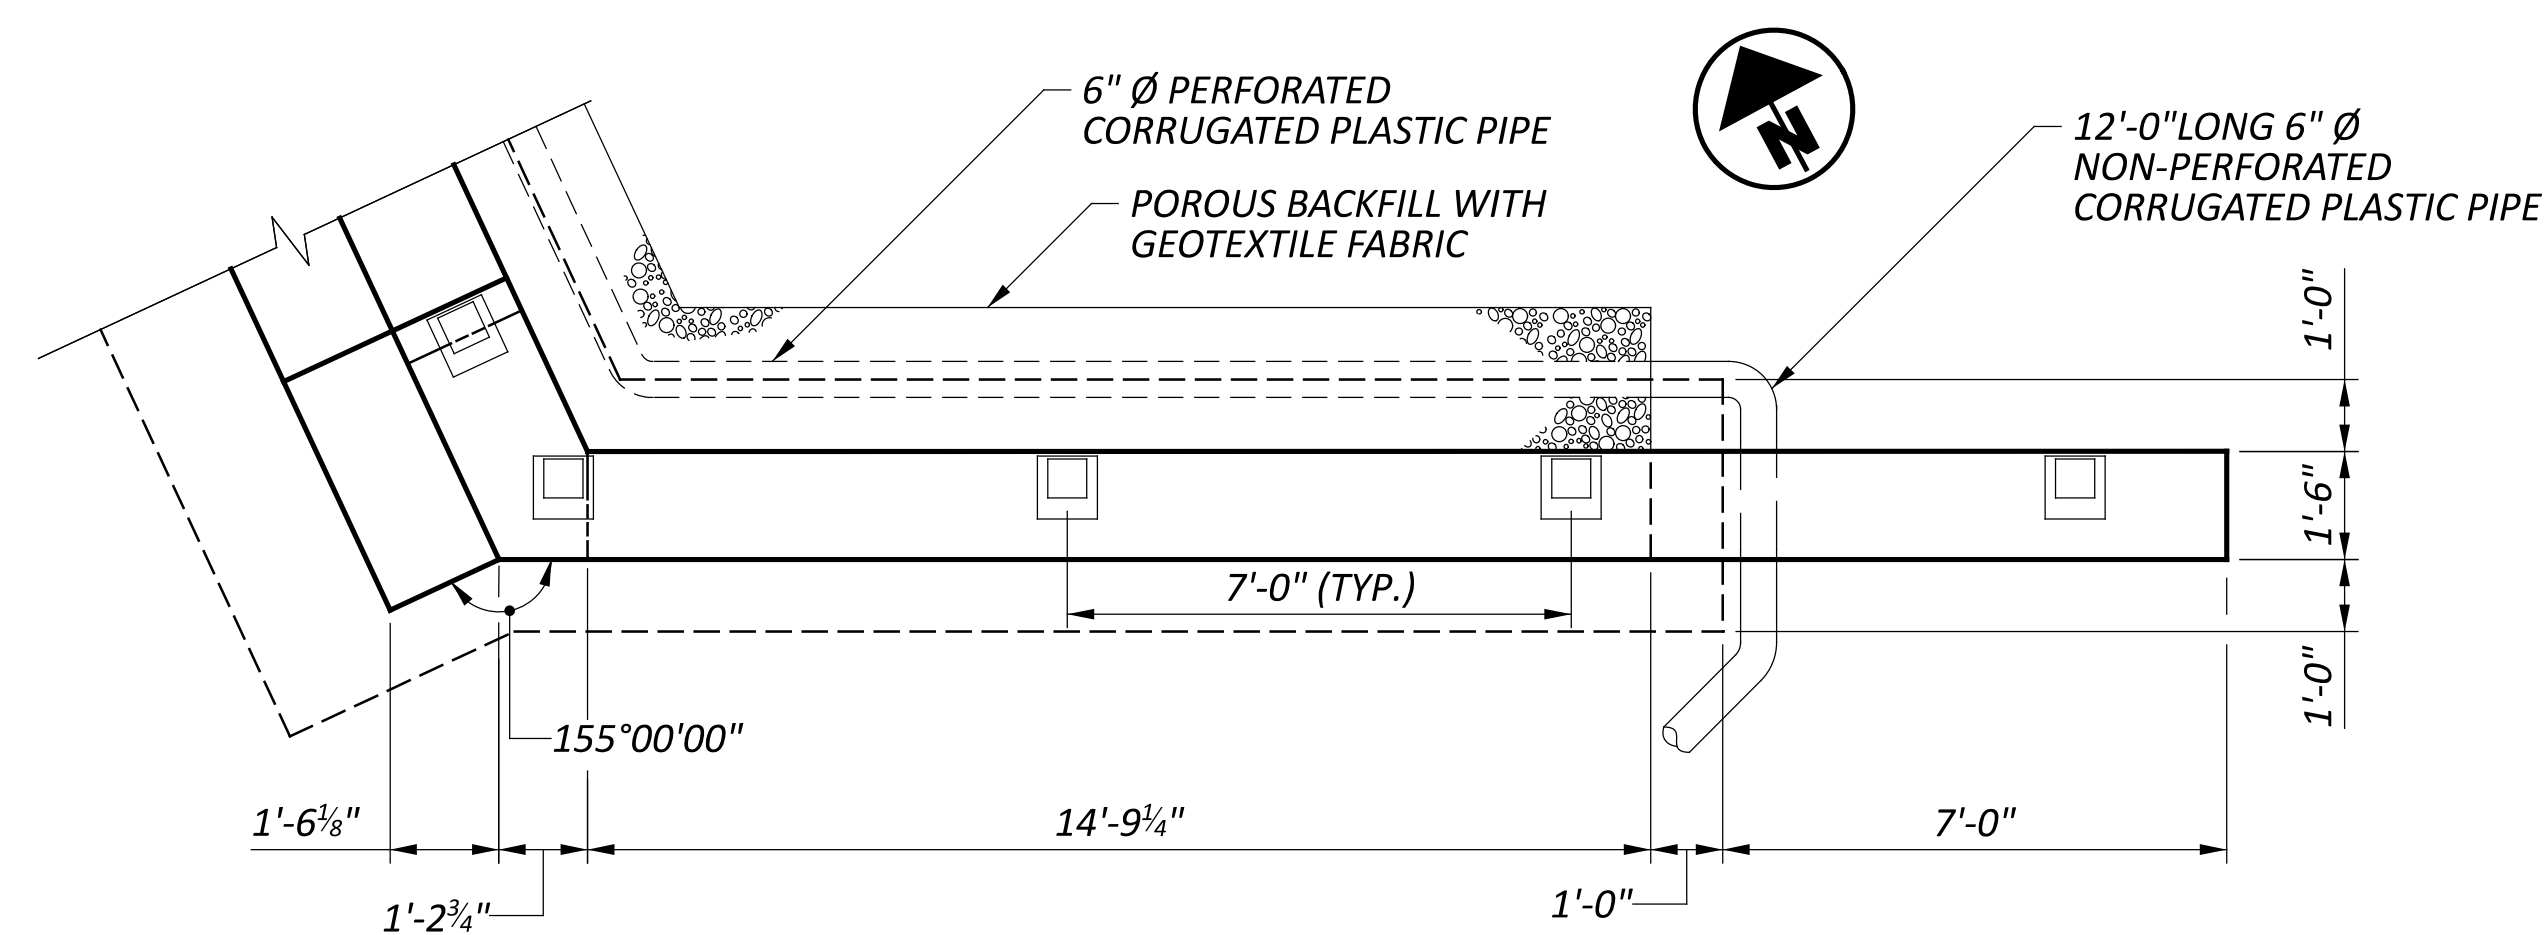


WINGWALL 4 PLAN

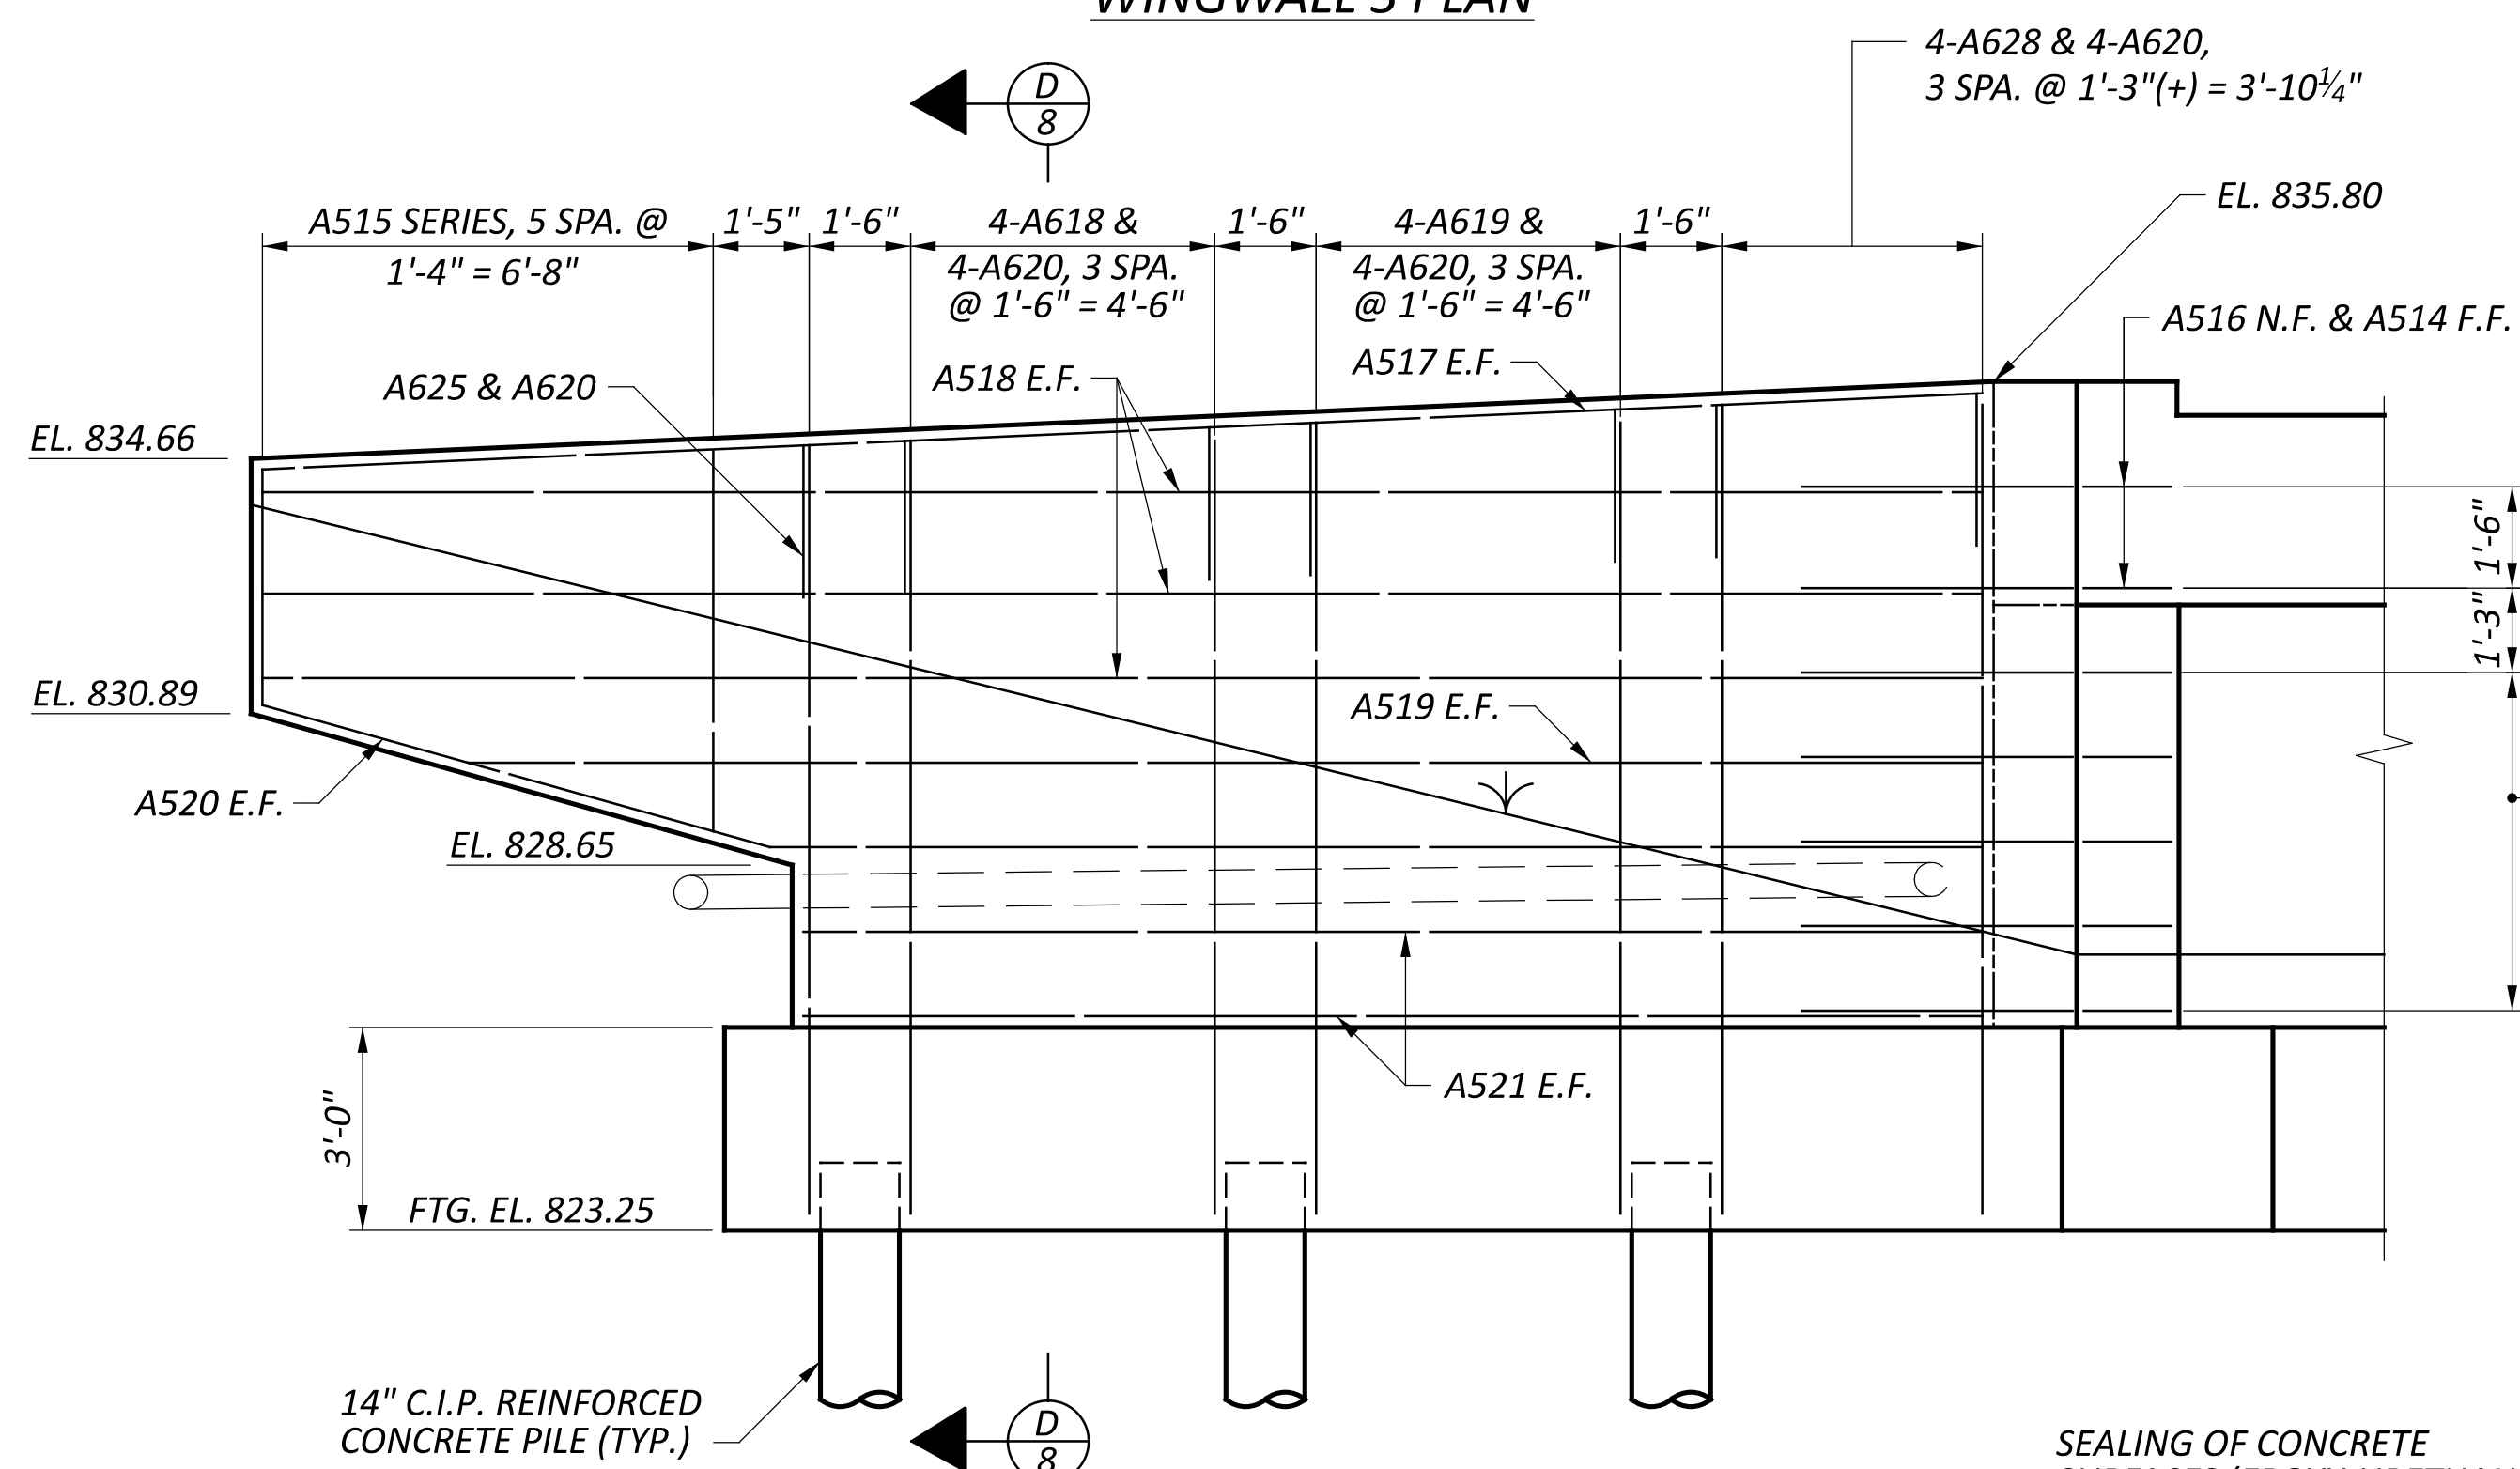

WINGWALL 3 ELEVATION  
 FENCE NOT SHOWN

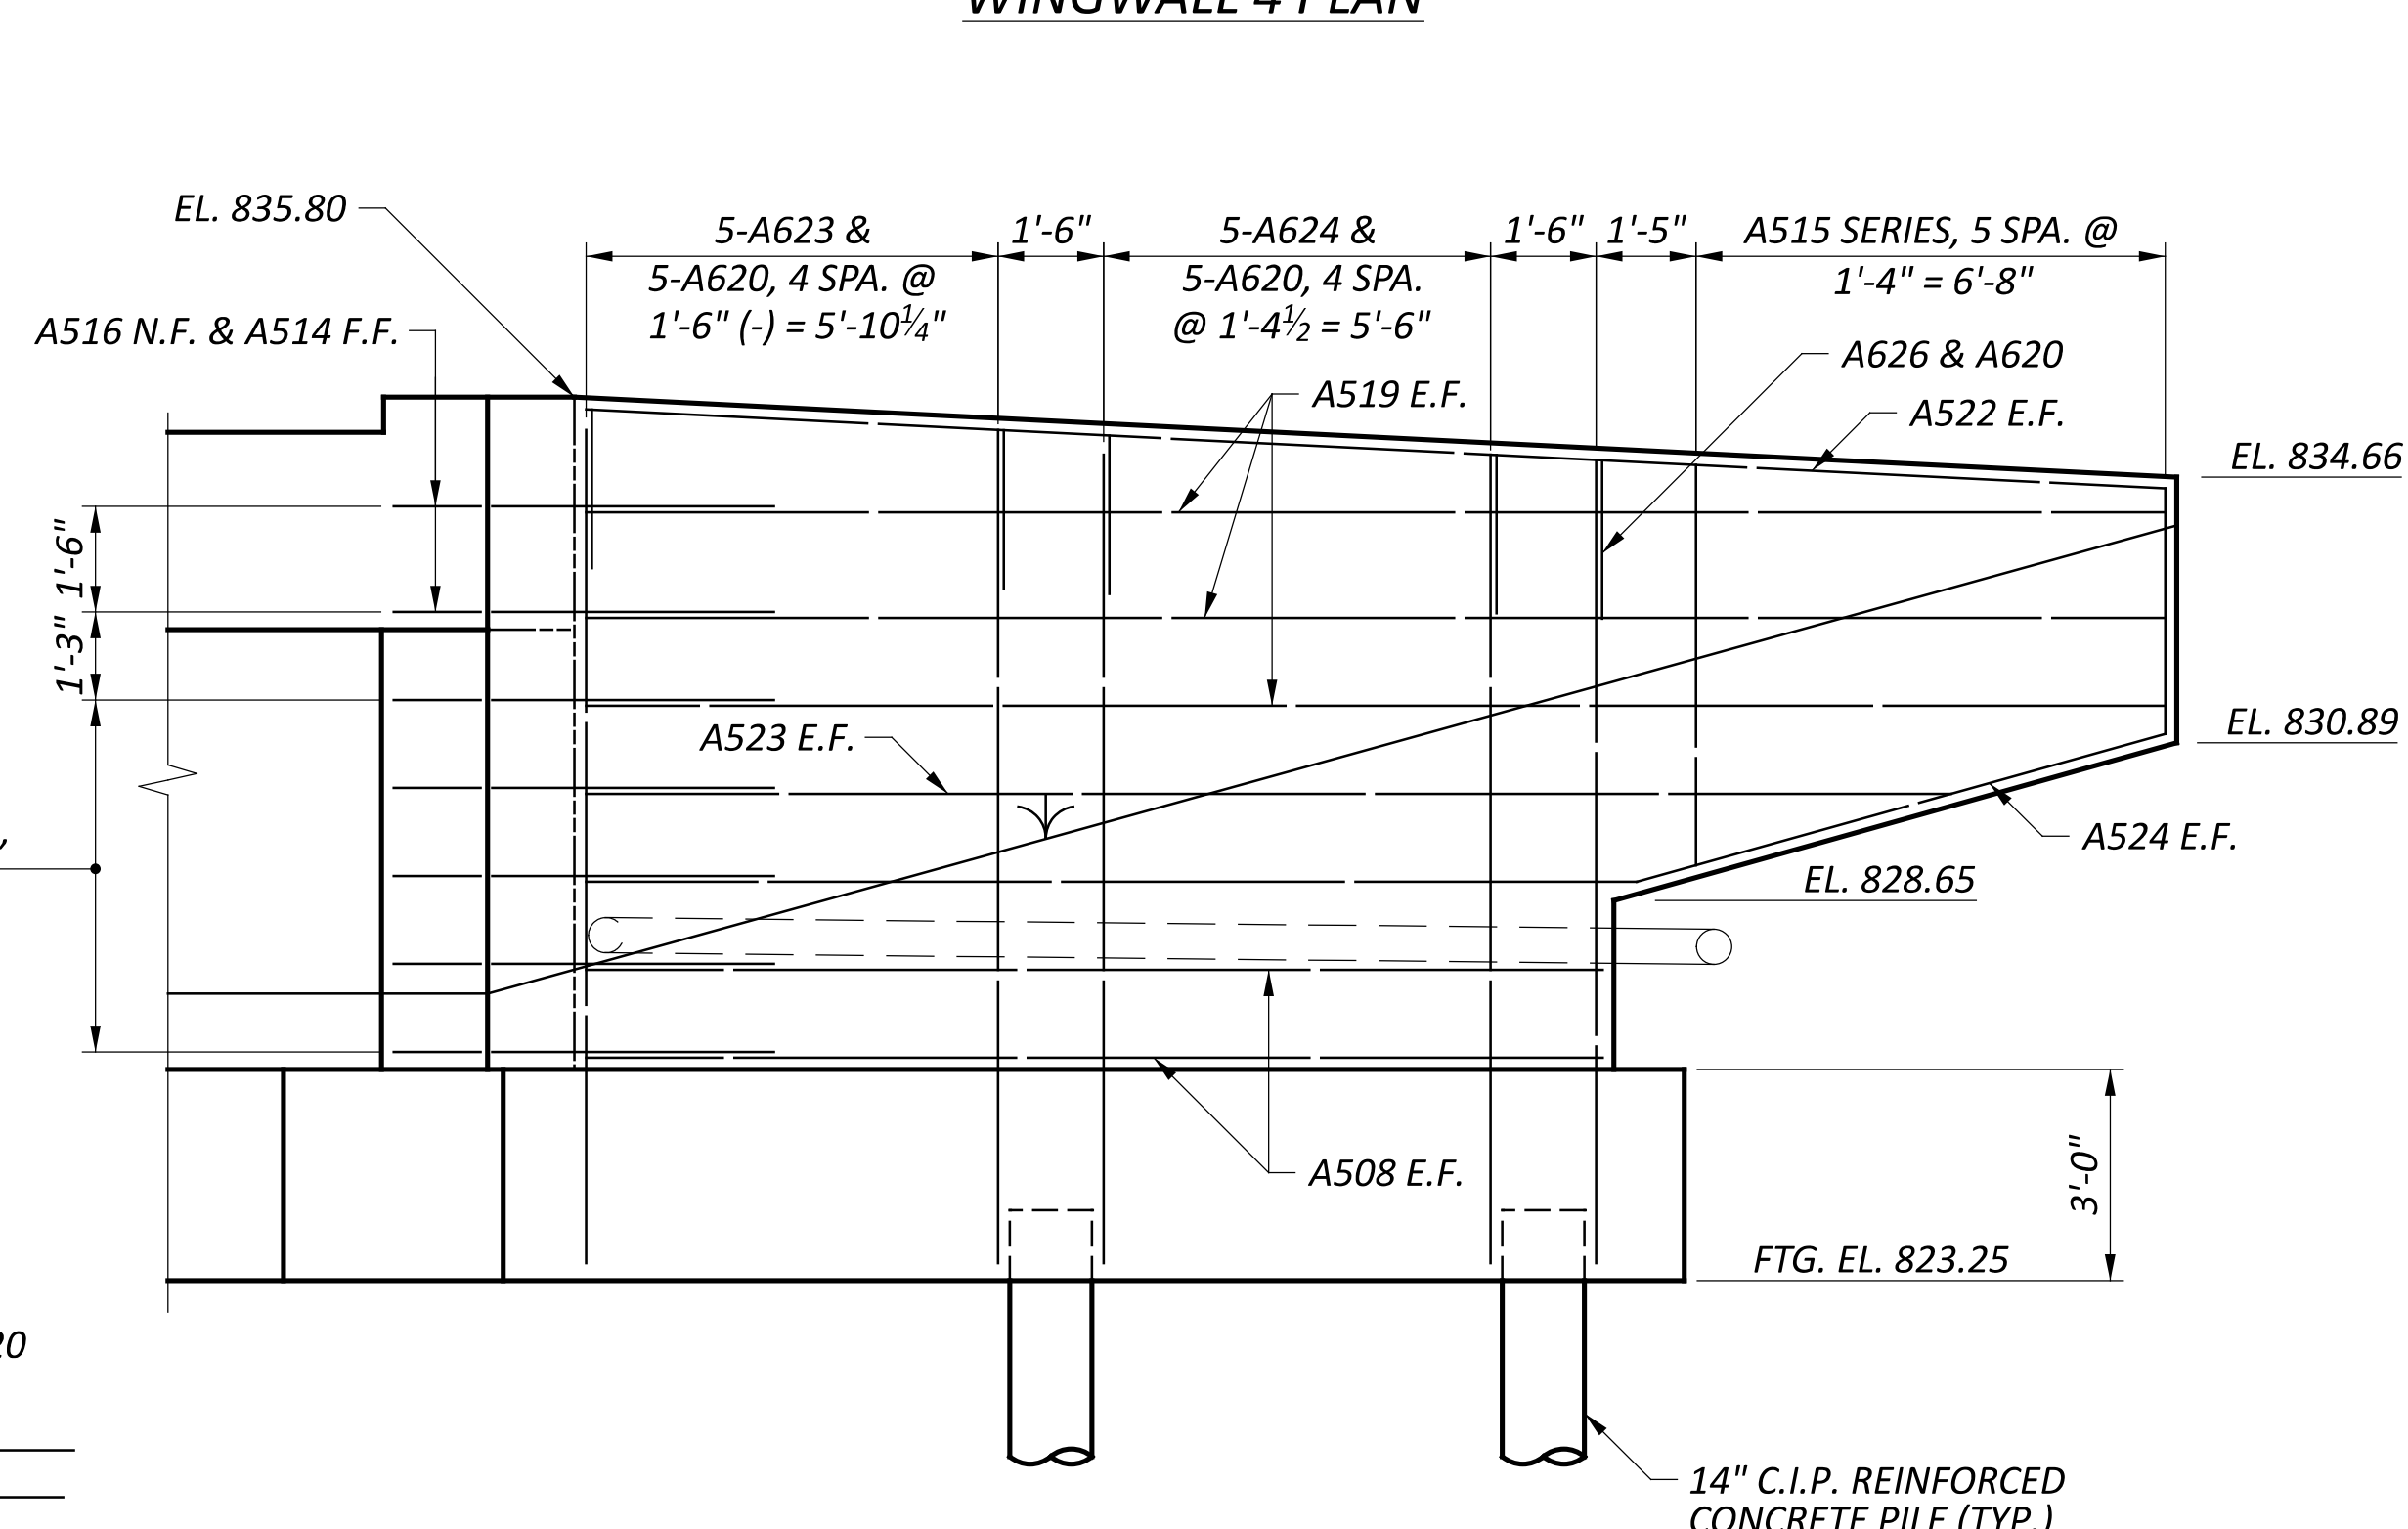

WINGWALL 4 ELEVATION  
 FENCE NOT SHOWN

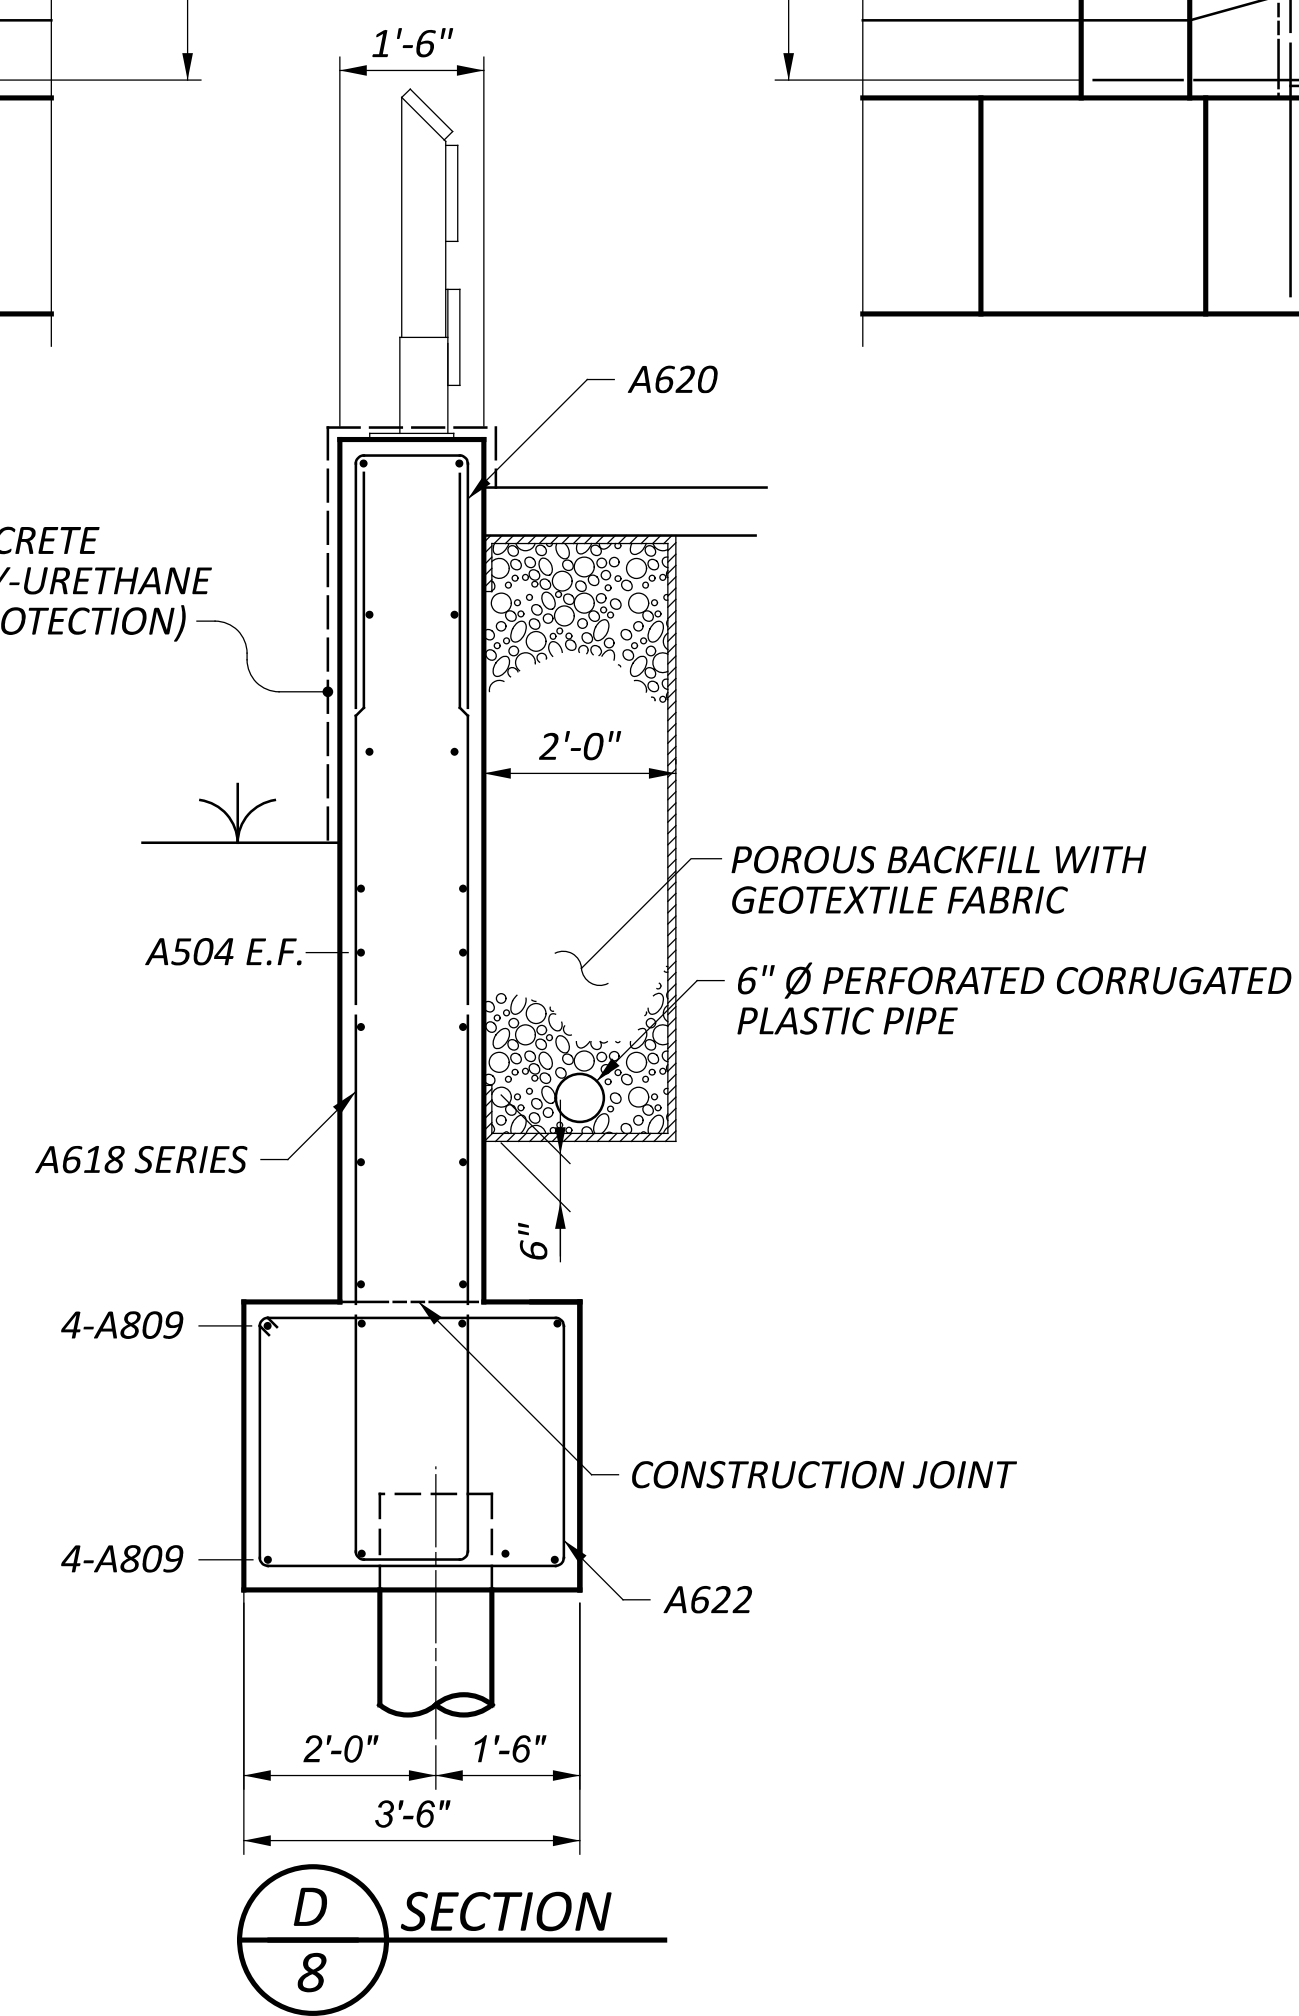

SECTION 8



LEGEND

- E.F. - EACH FACE
- F.F. - FAR FACE
- N.F. - NEAR FACE


NOTES

1. MINIMUM LAP SPLICE LENGTH:  
 #5 BAR = 32 INCHES  
 #6 BAR = 29 INCHES
2. REFER TO SHEET 3/27 FOR FOOTING DIMENSIONS AND SHEET 6/27 FOR FOOTING REINFORCEMENT DETAILS.


SFN	2926107
DESIGN AGENCY	CARPENTER MARTY
DESIGNER	CHECKER
SMH	AMR
REVIEWER	
GDJ	03/28/25
PROJECT ID	115388
SUBSET	TOTAL
8	27
SHEET	TOTAL
P.54	P.107

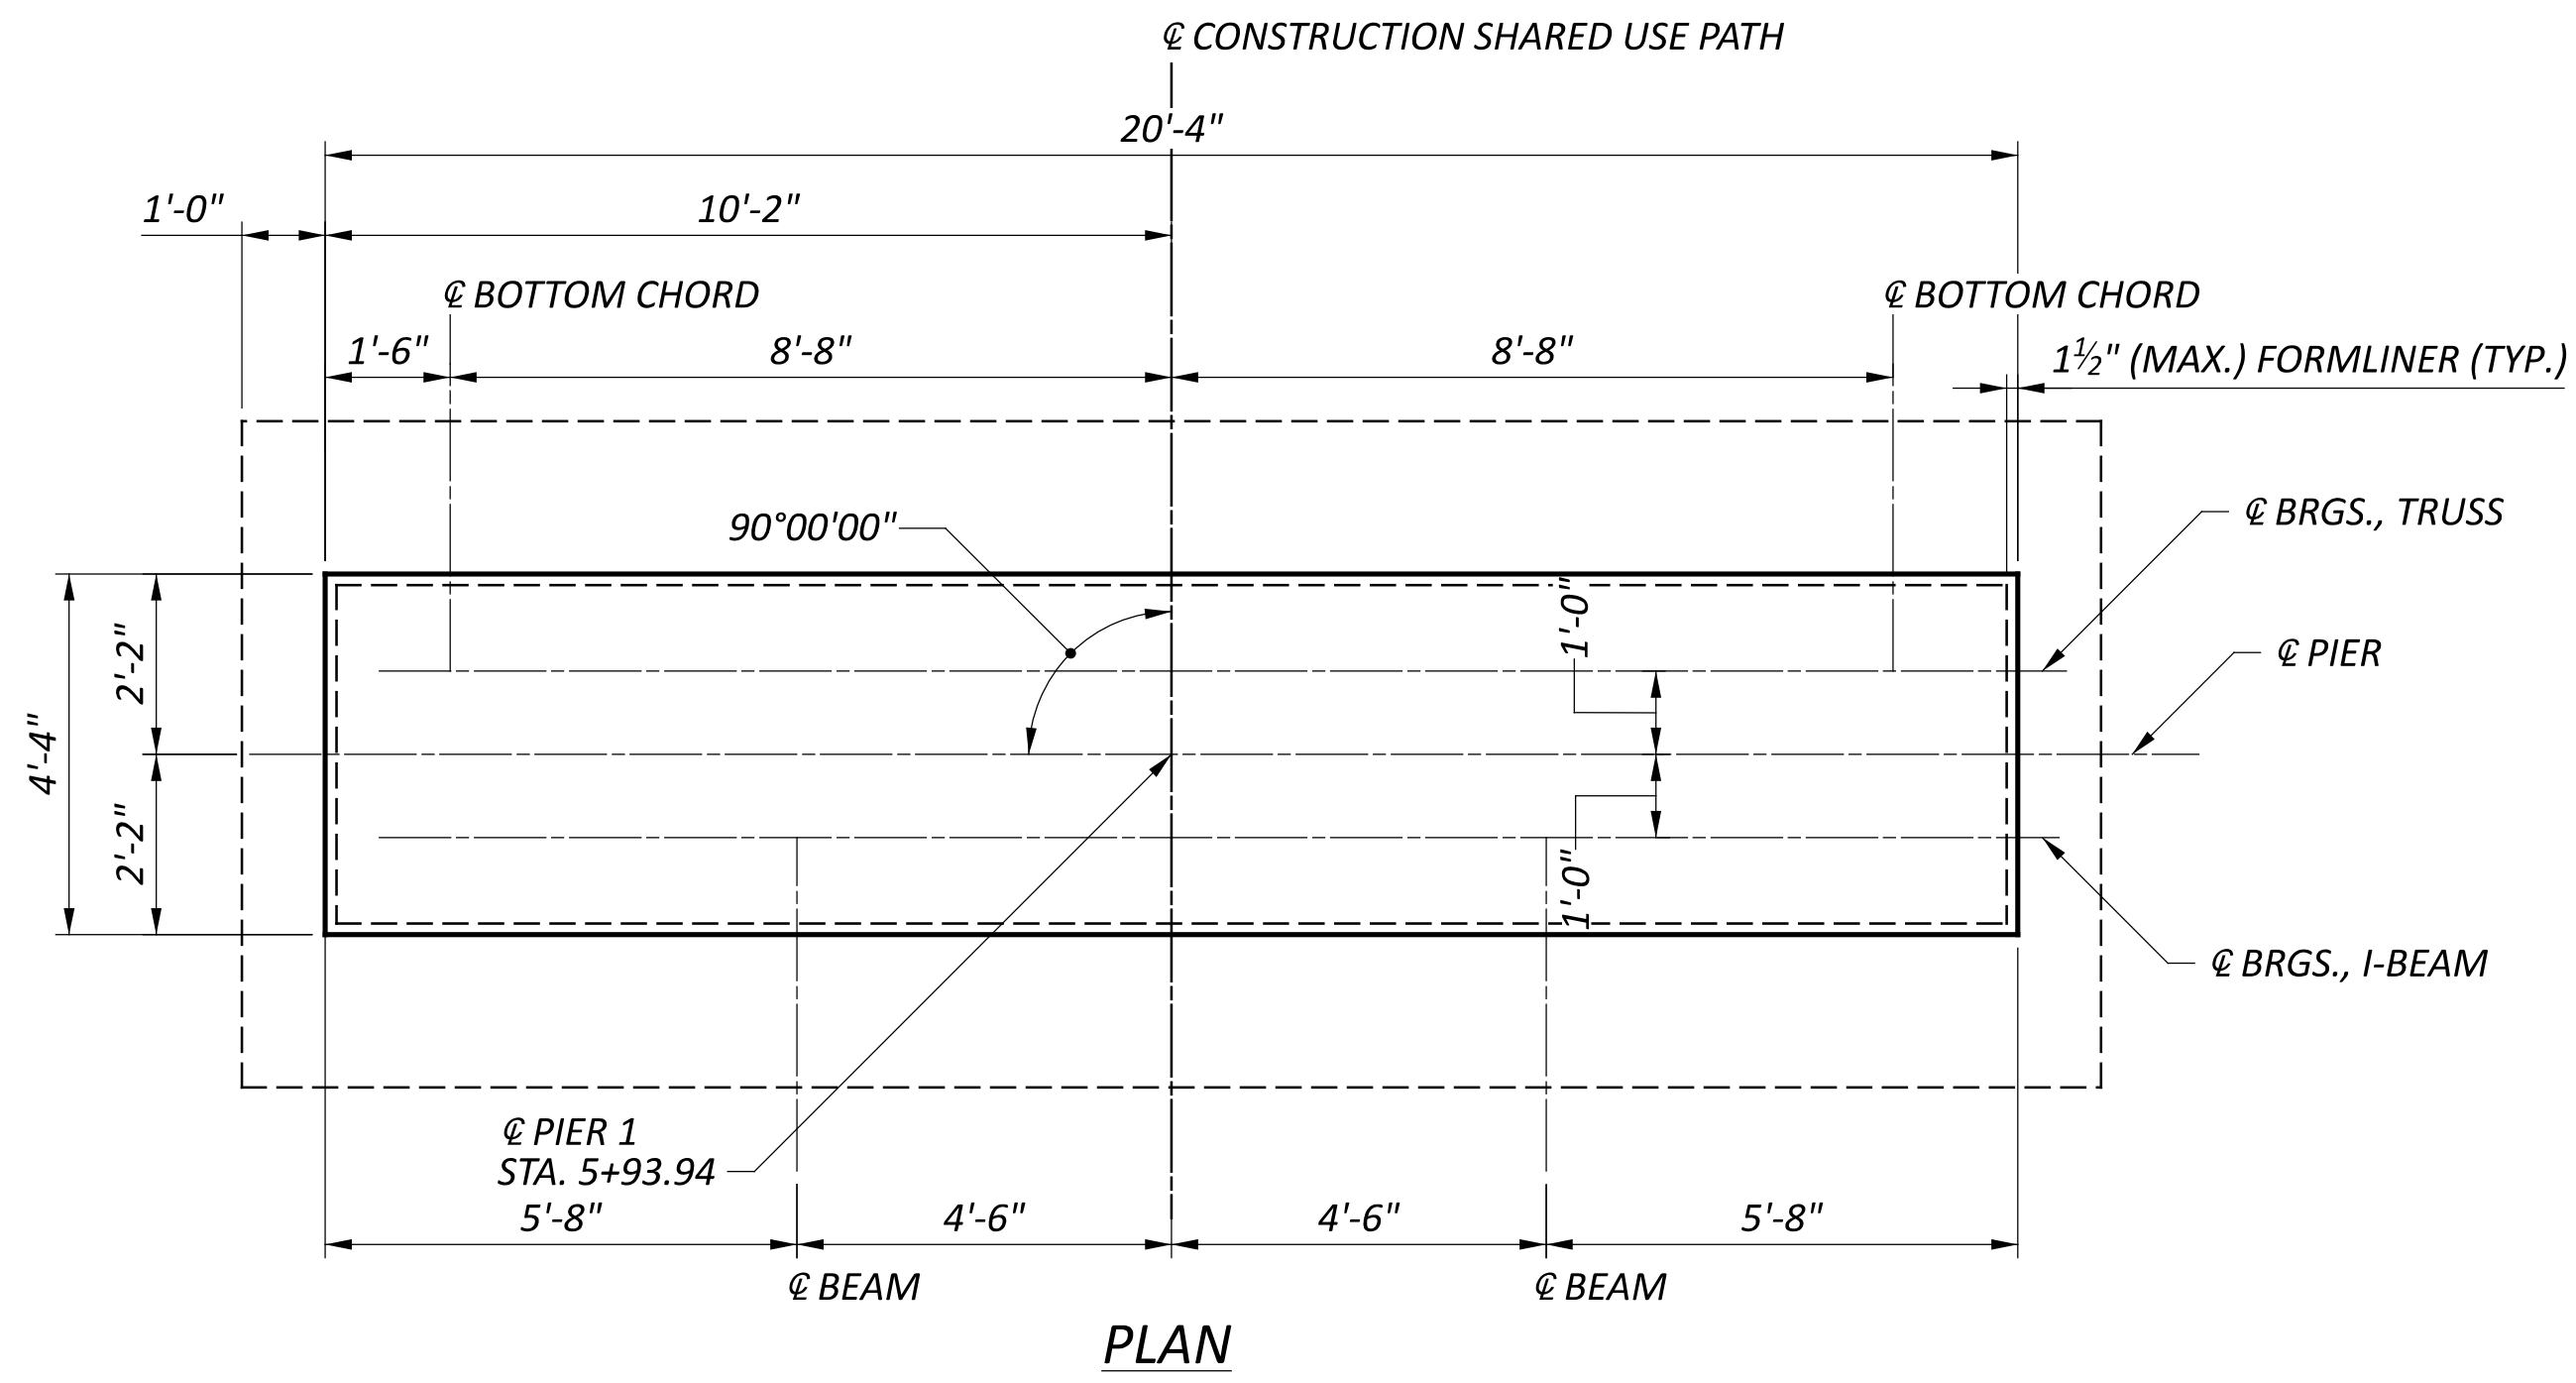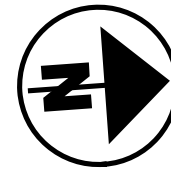


PLAN

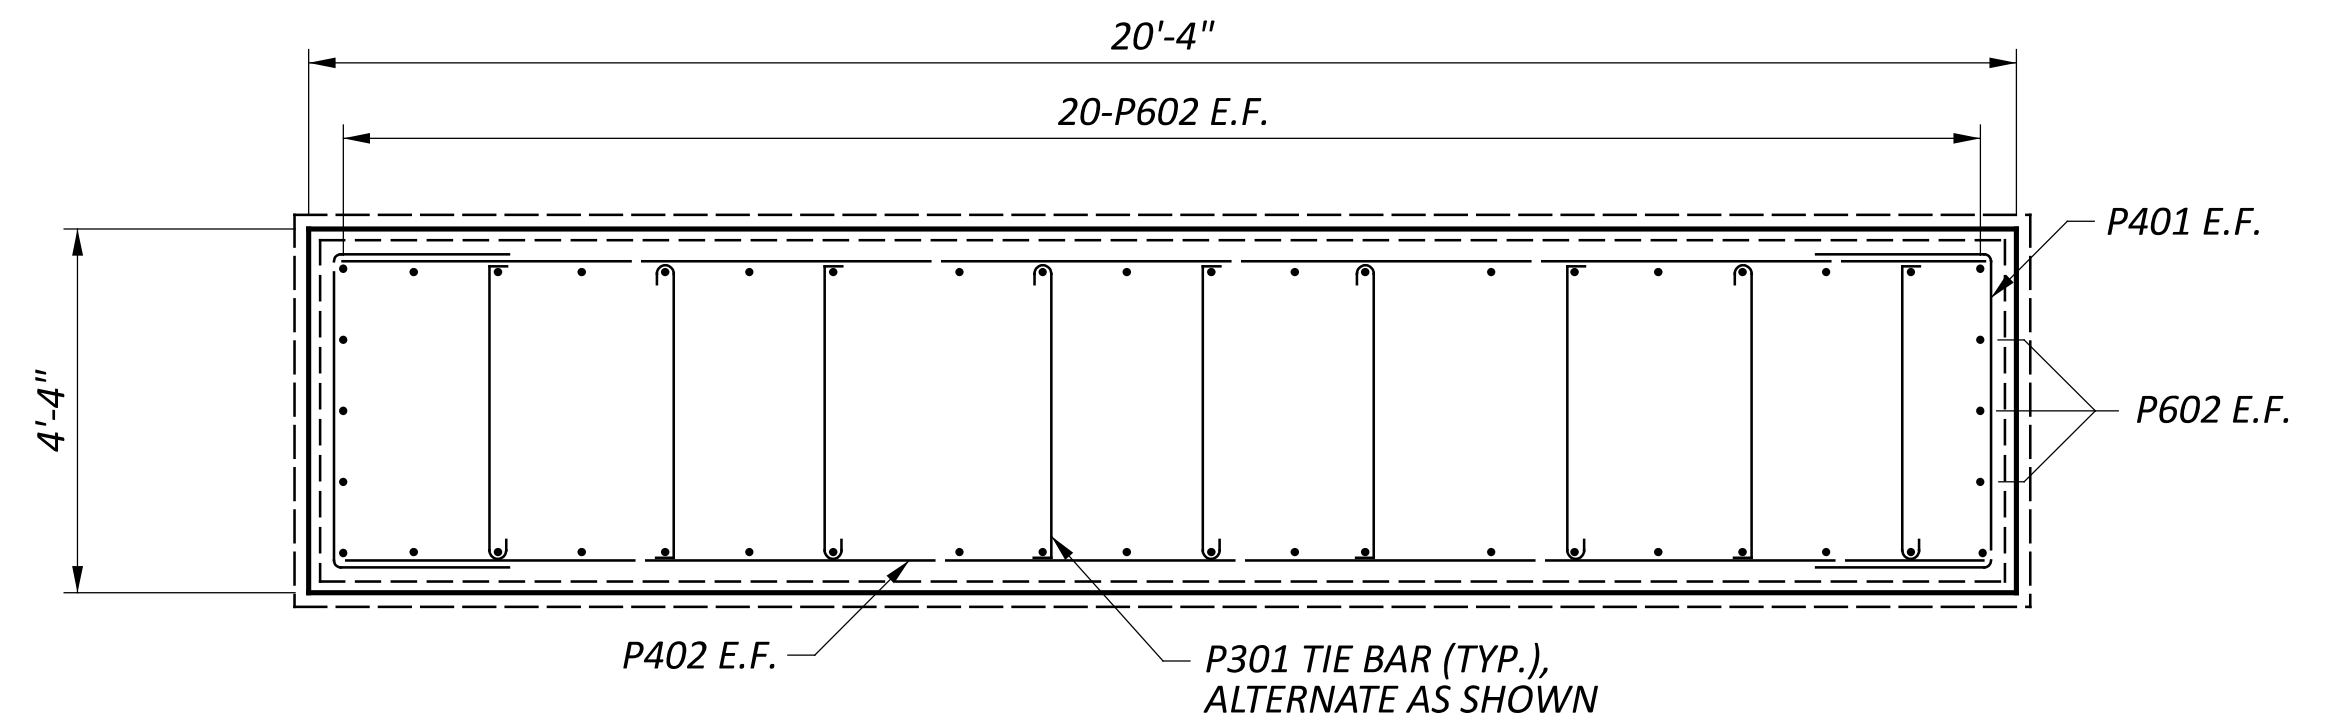

E SECTION  
9

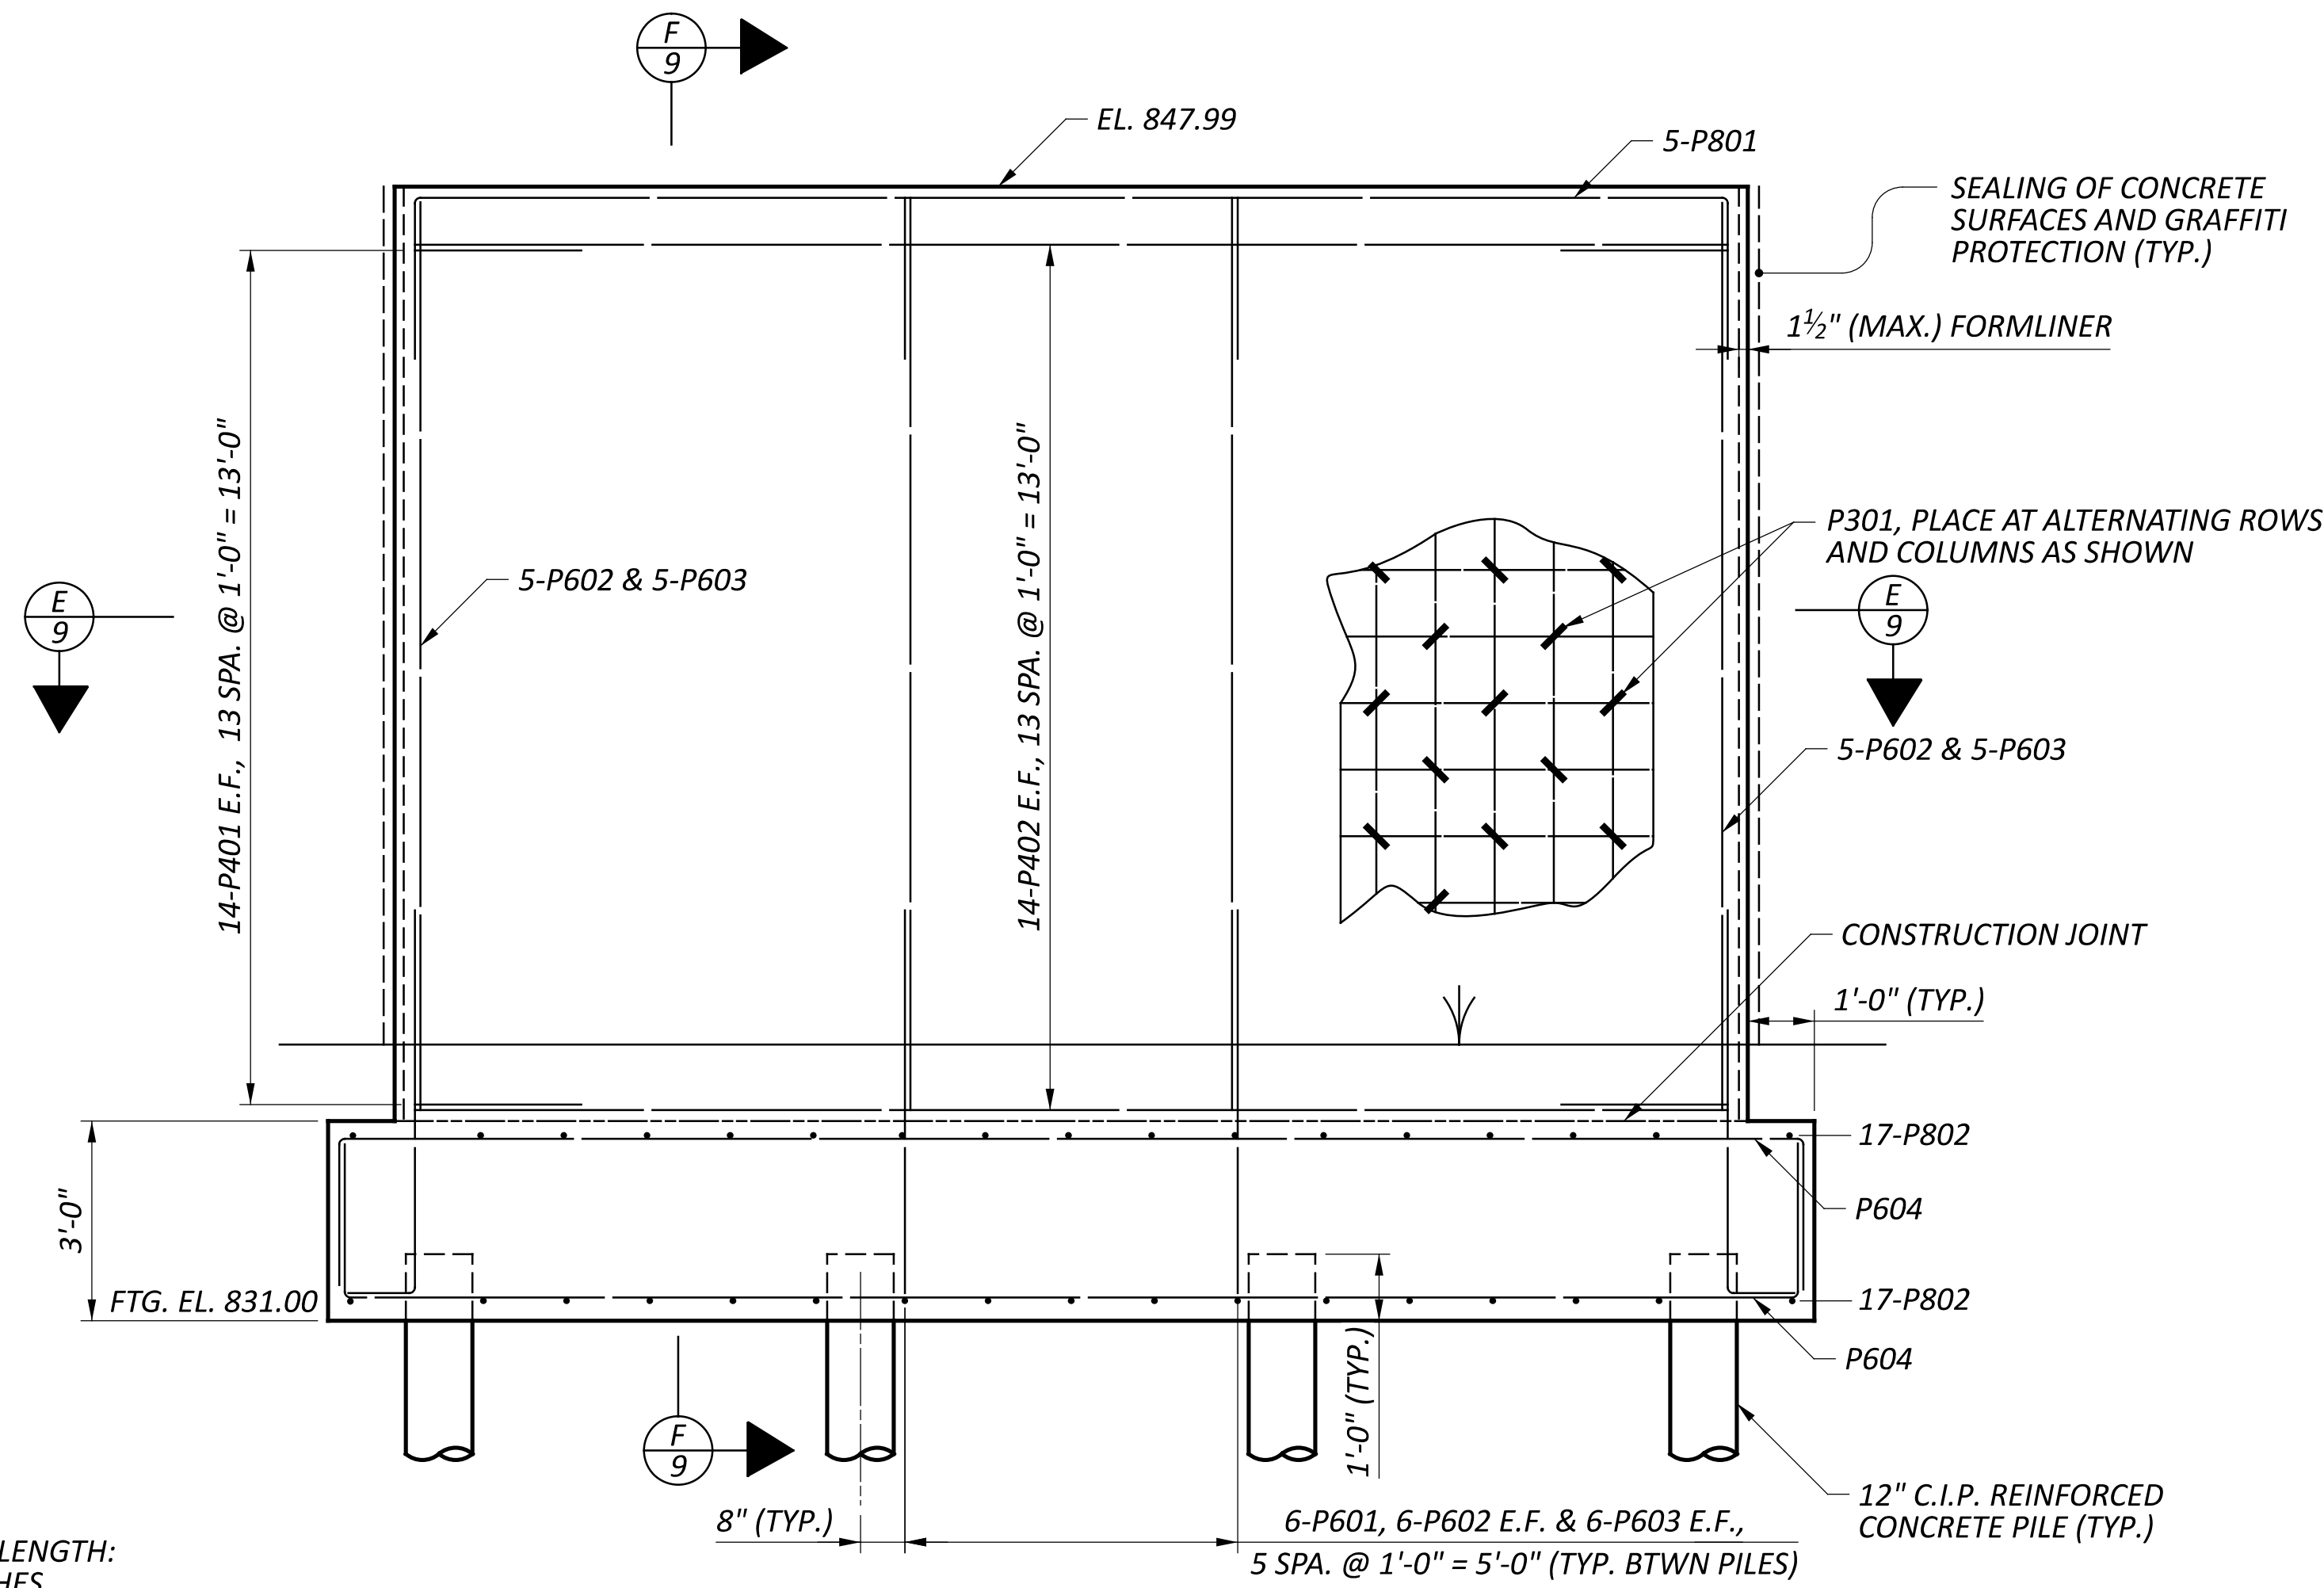

ELEVATION


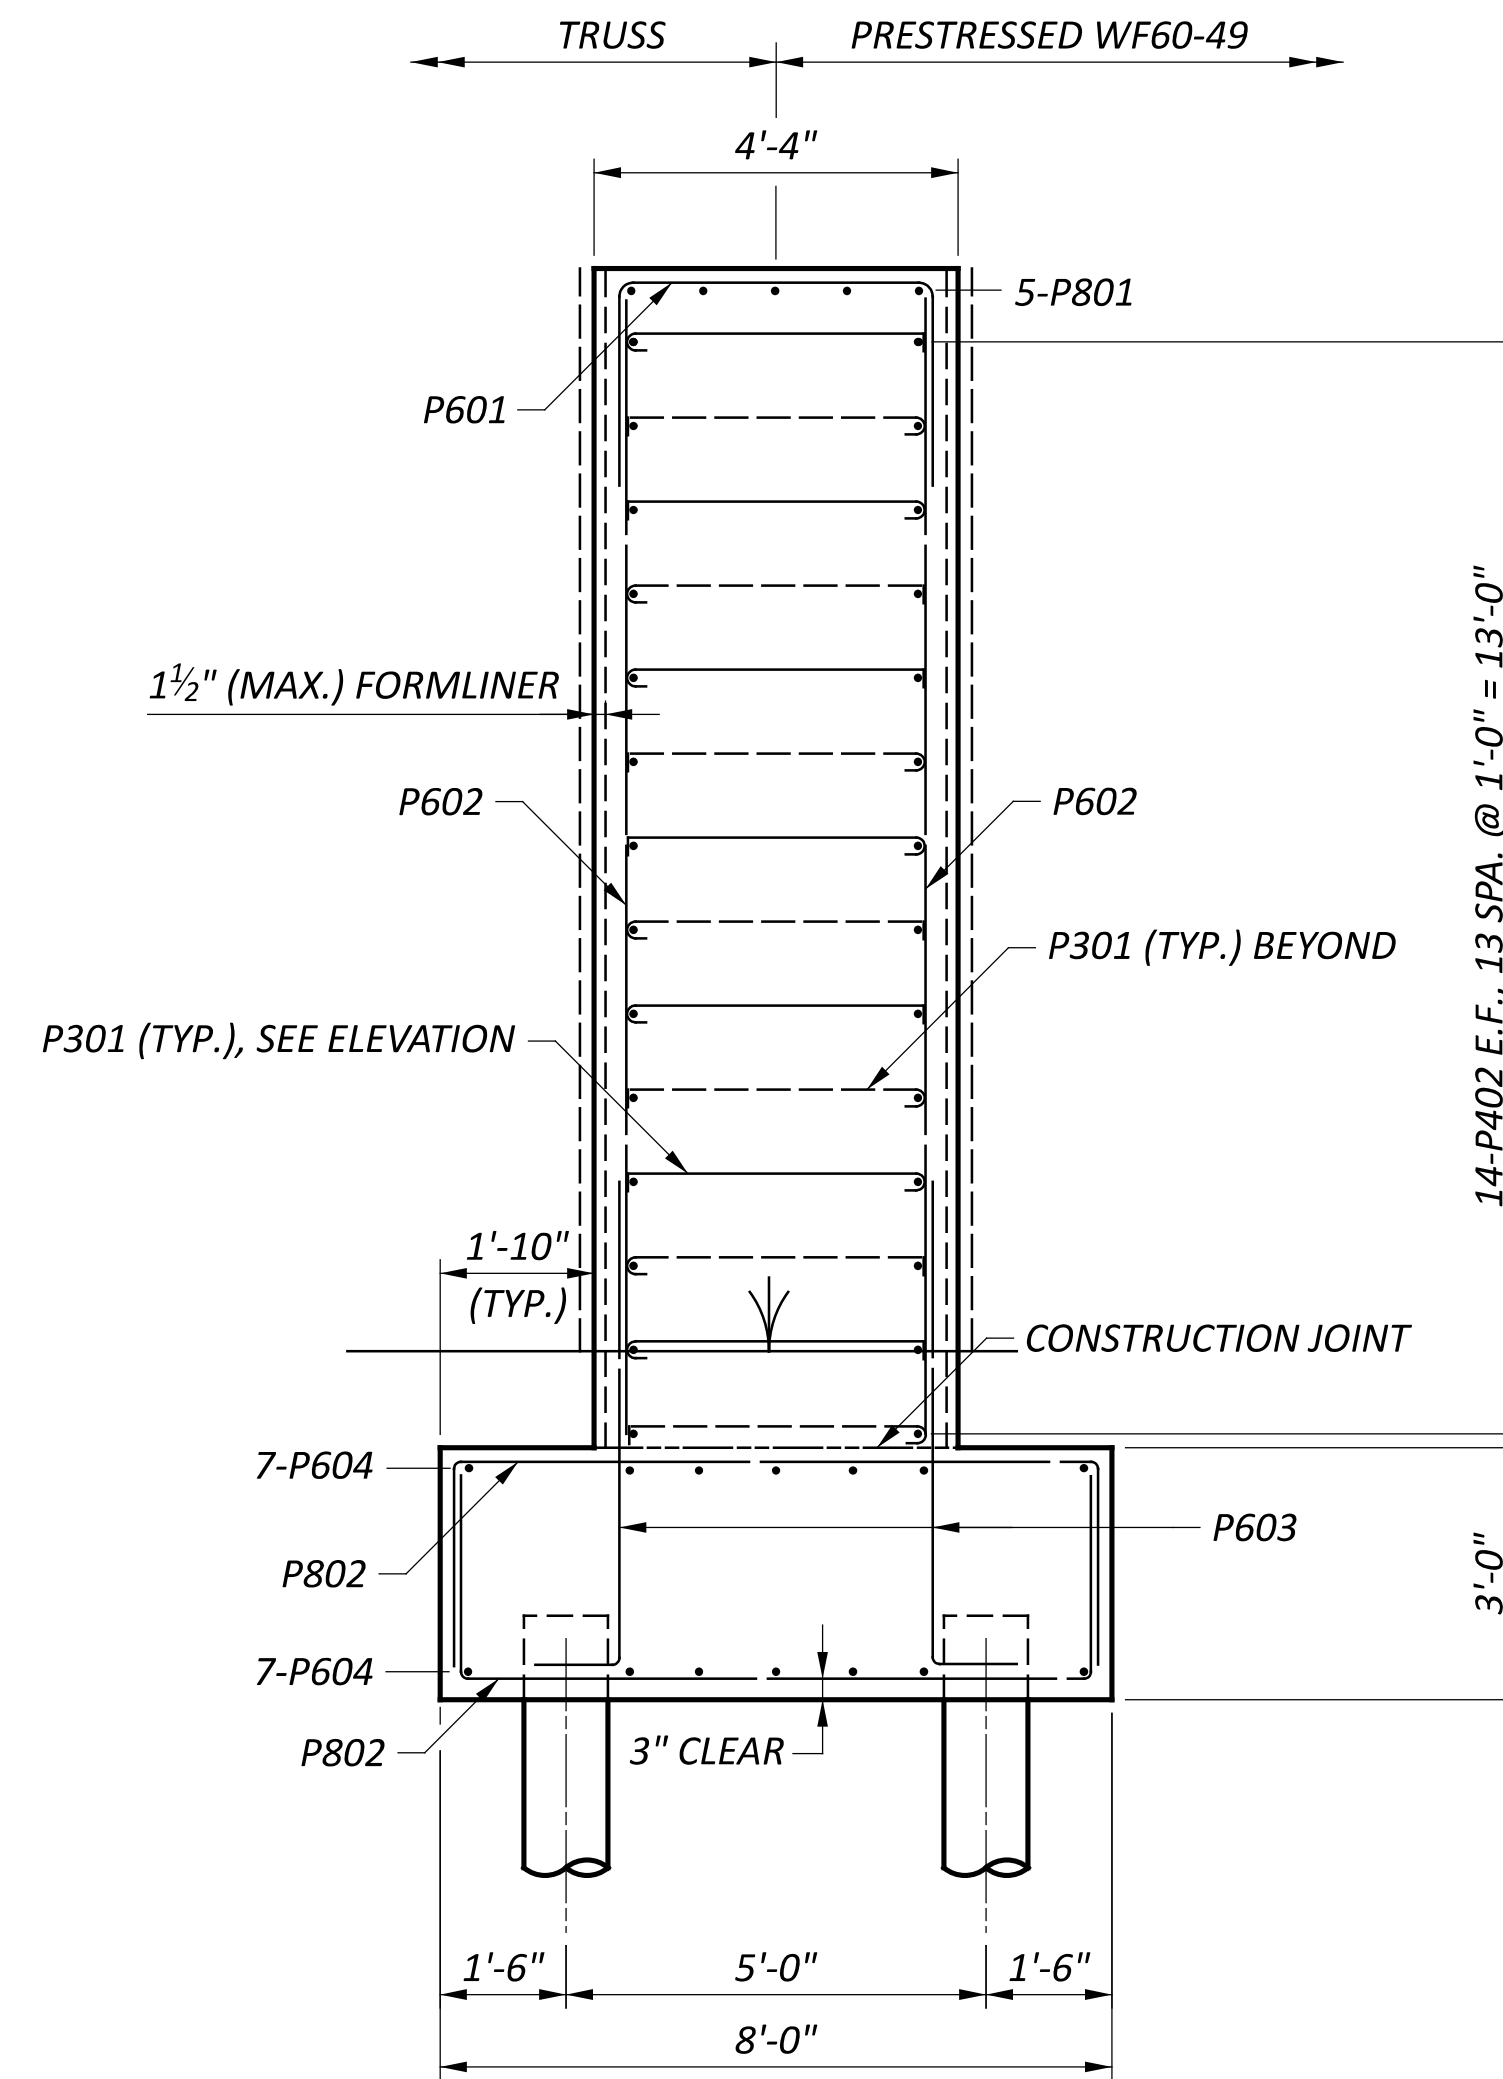


F SECTION  
9


**NOTE**  
 MINIMUM LAP SPLICE LENGTH:  
 #6 BAR = 36 INCHES

**LEGEND**  
 E.F. - EACH FACE


SFN	2926107
DESIGN AGENCY	CARPENTER MARTY
DESIGNER	CHECKER
JZ	AMR
REVIEWER	
GDJ	02/10/25
PROJECT ID	115388
SUBSET	TOTAL
9	27
SHEET	TOTAL
P.55	P.107

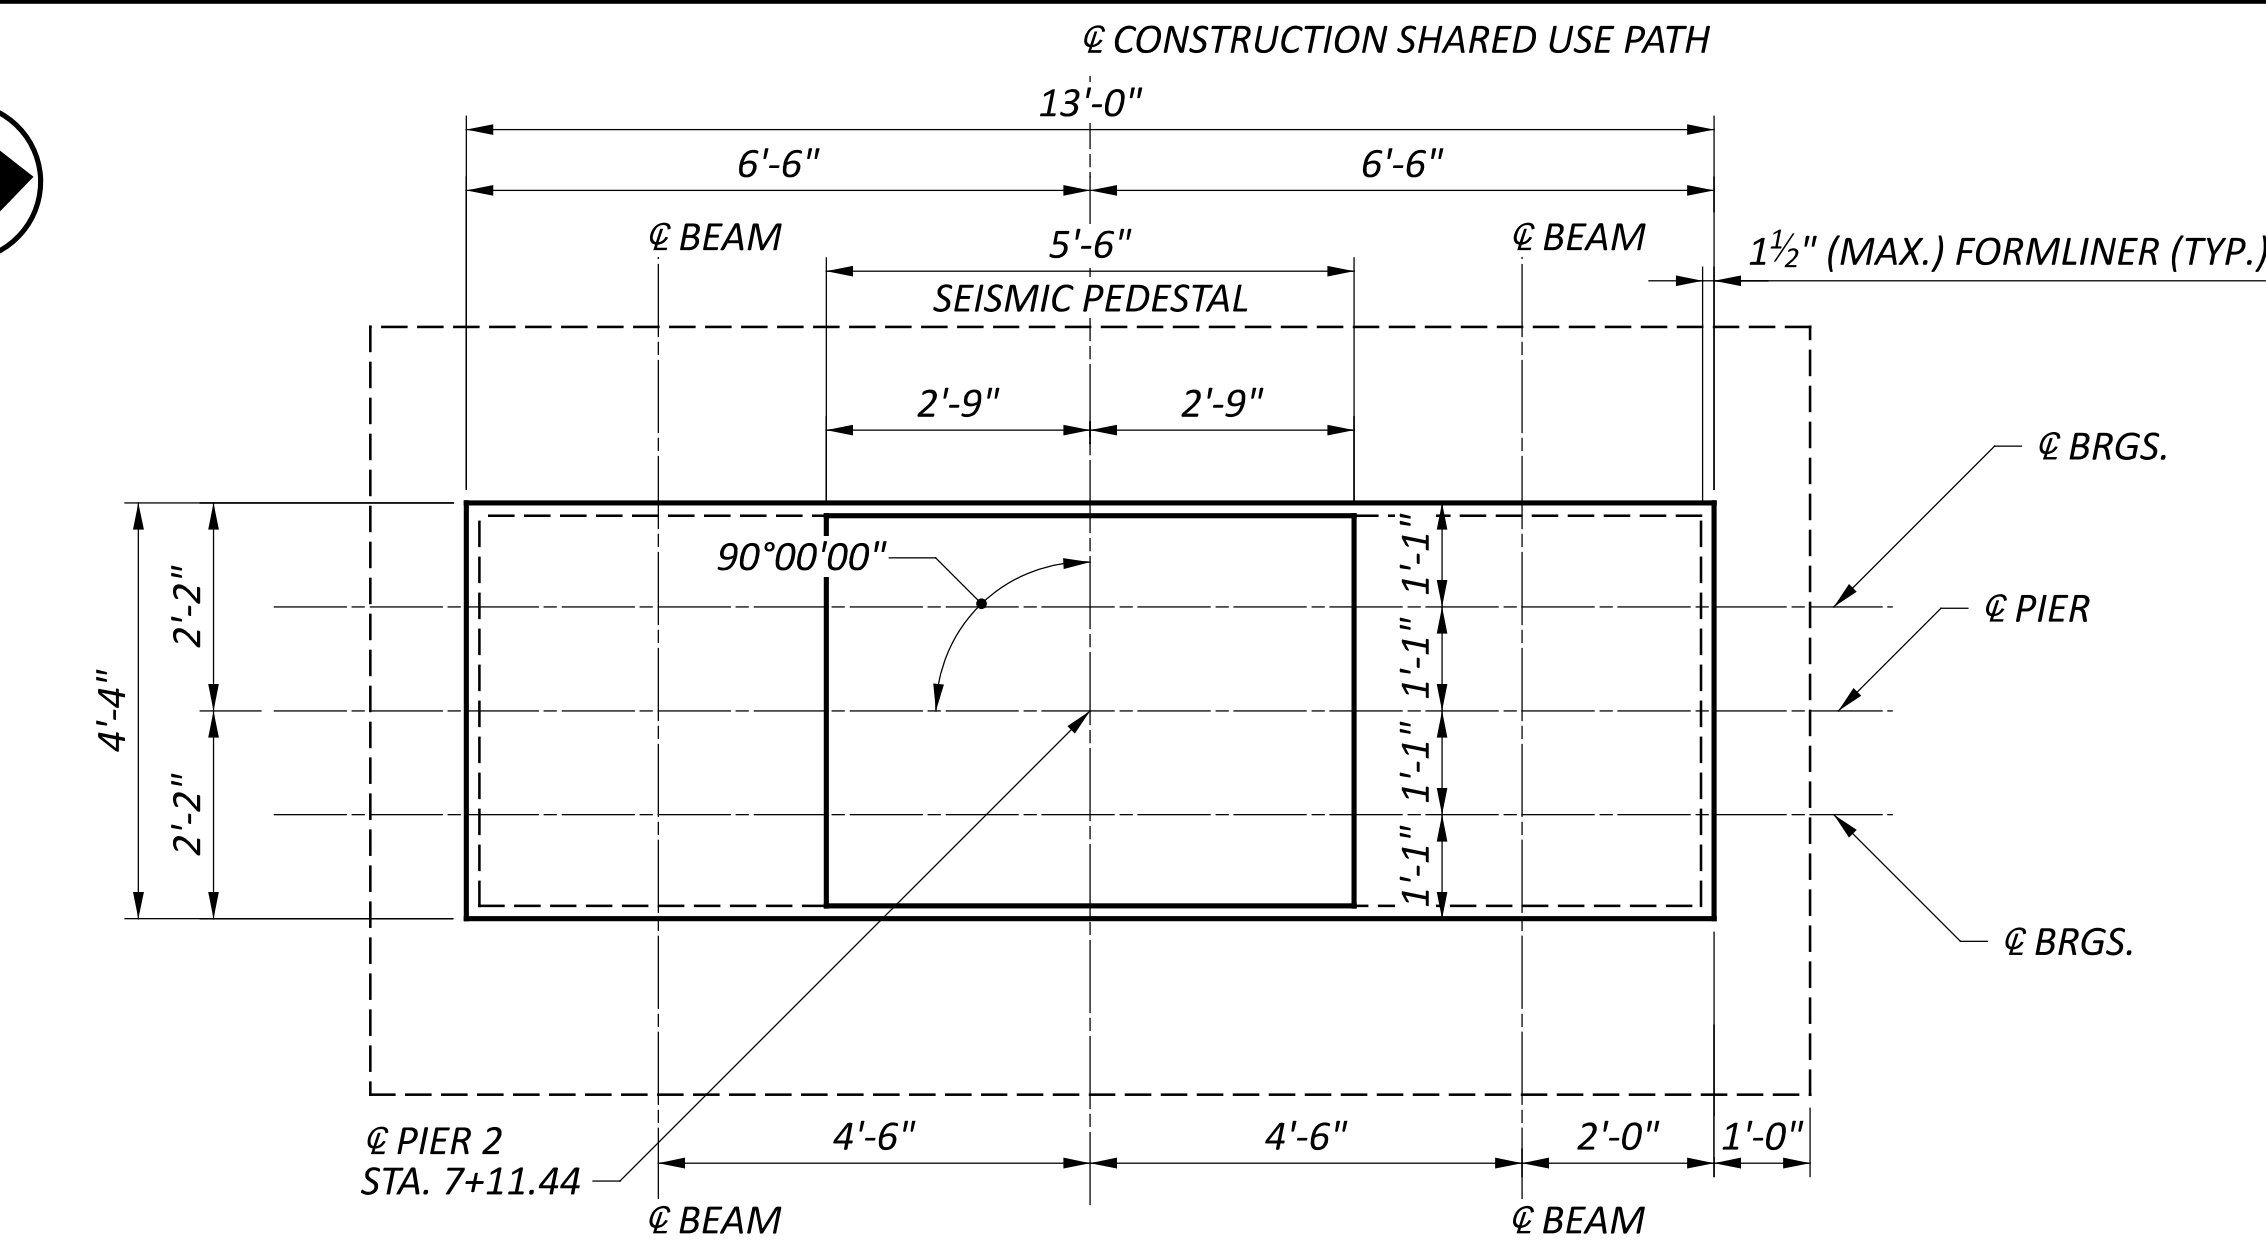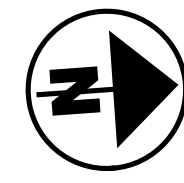


PLAN

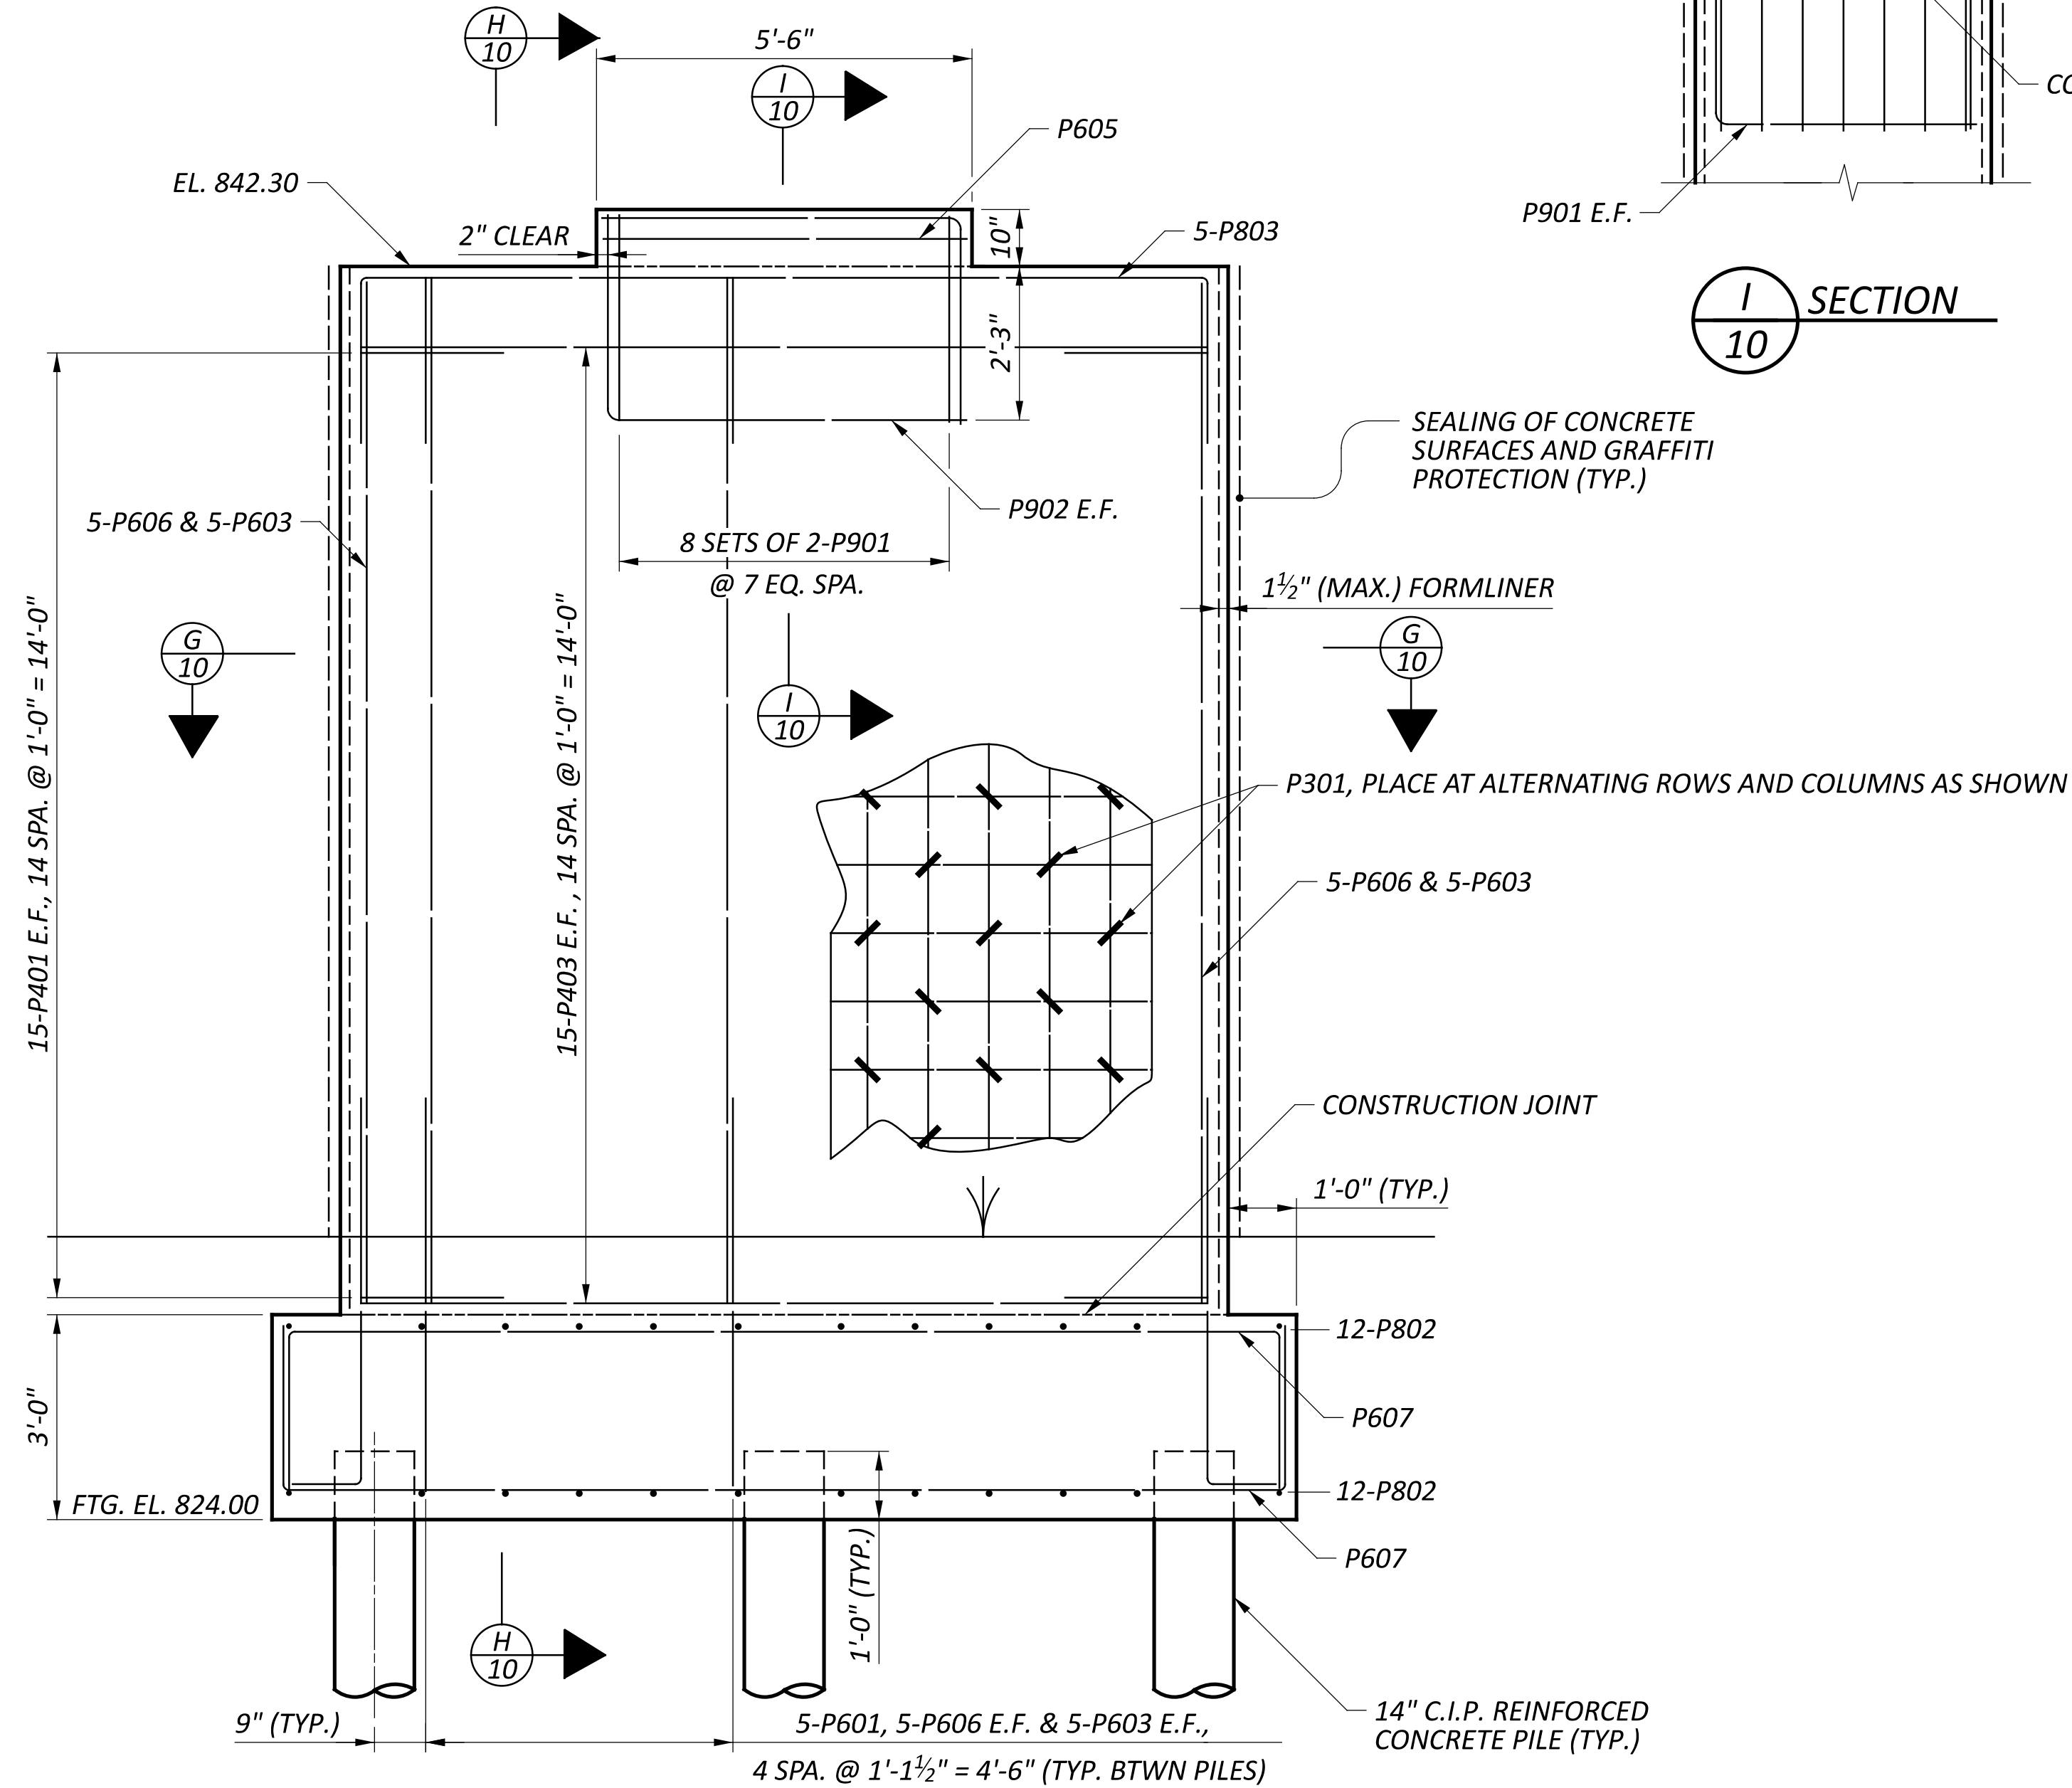


ELEVATION

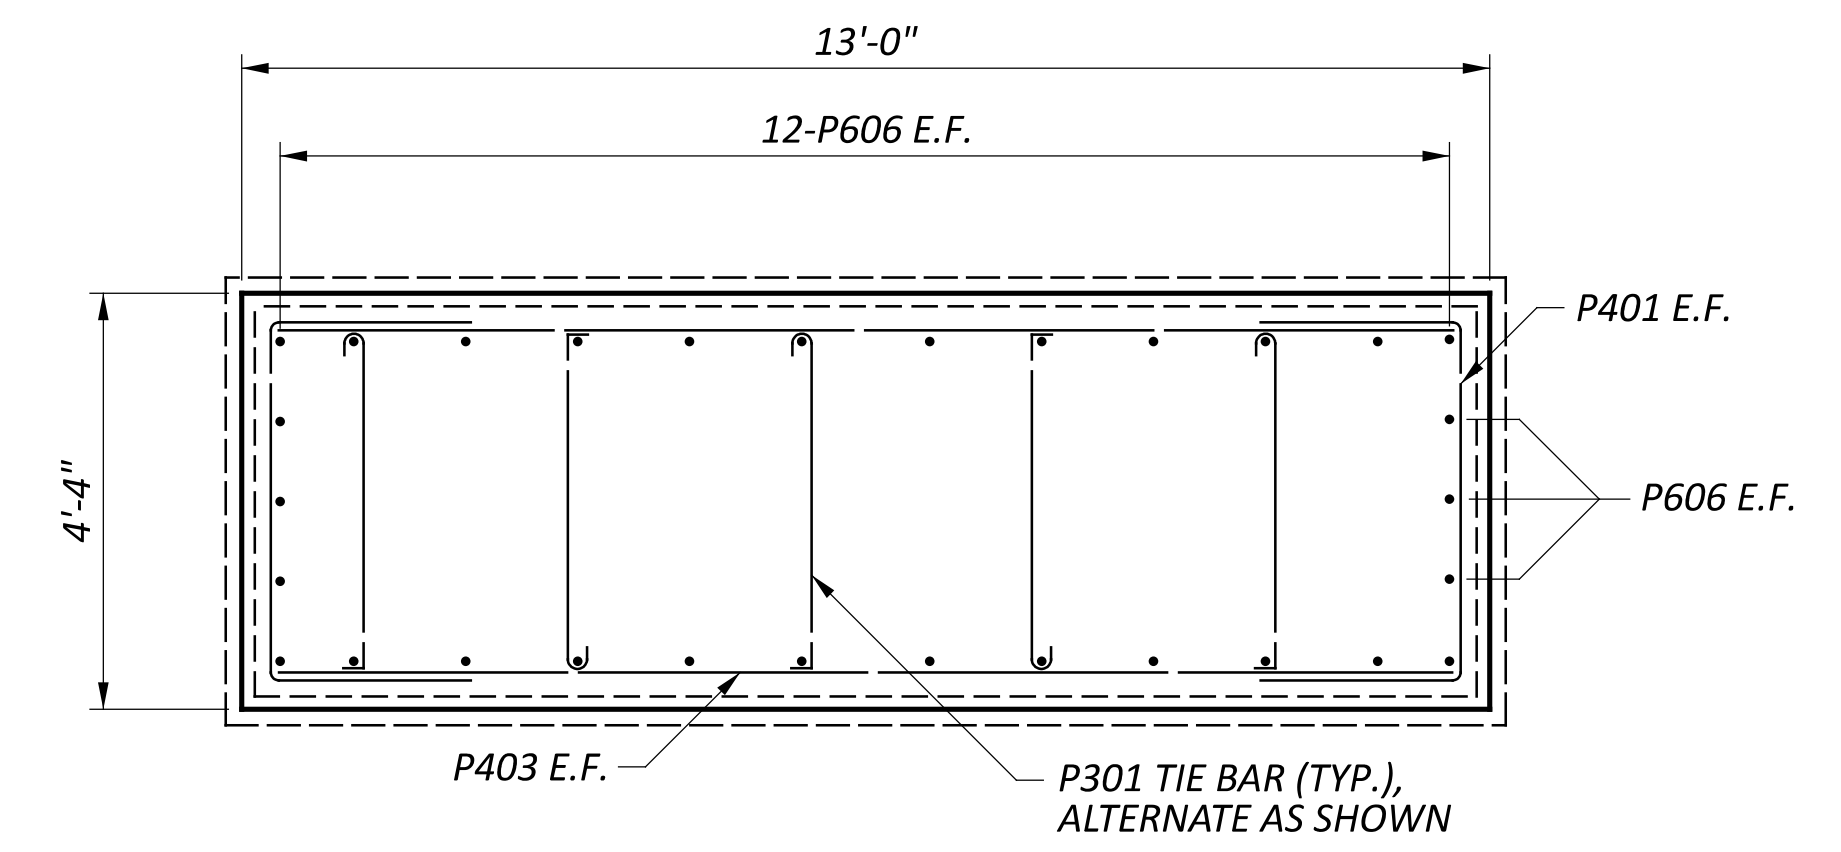

G SECTION  
10

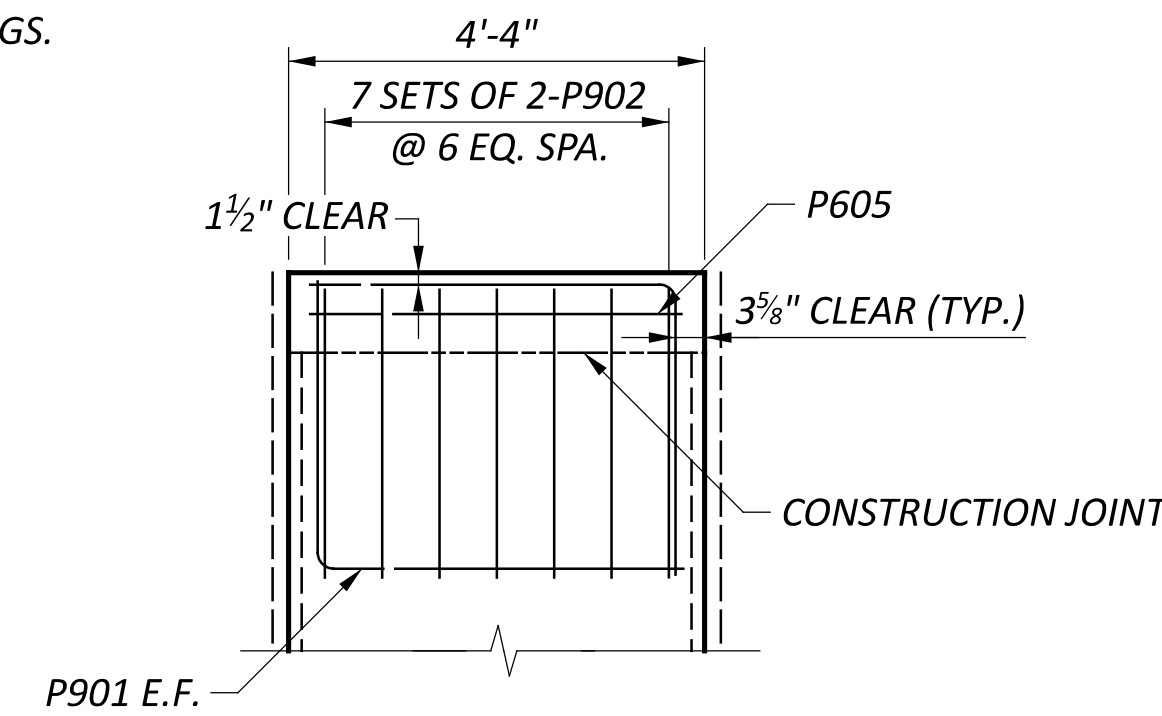

I SECTION  
10

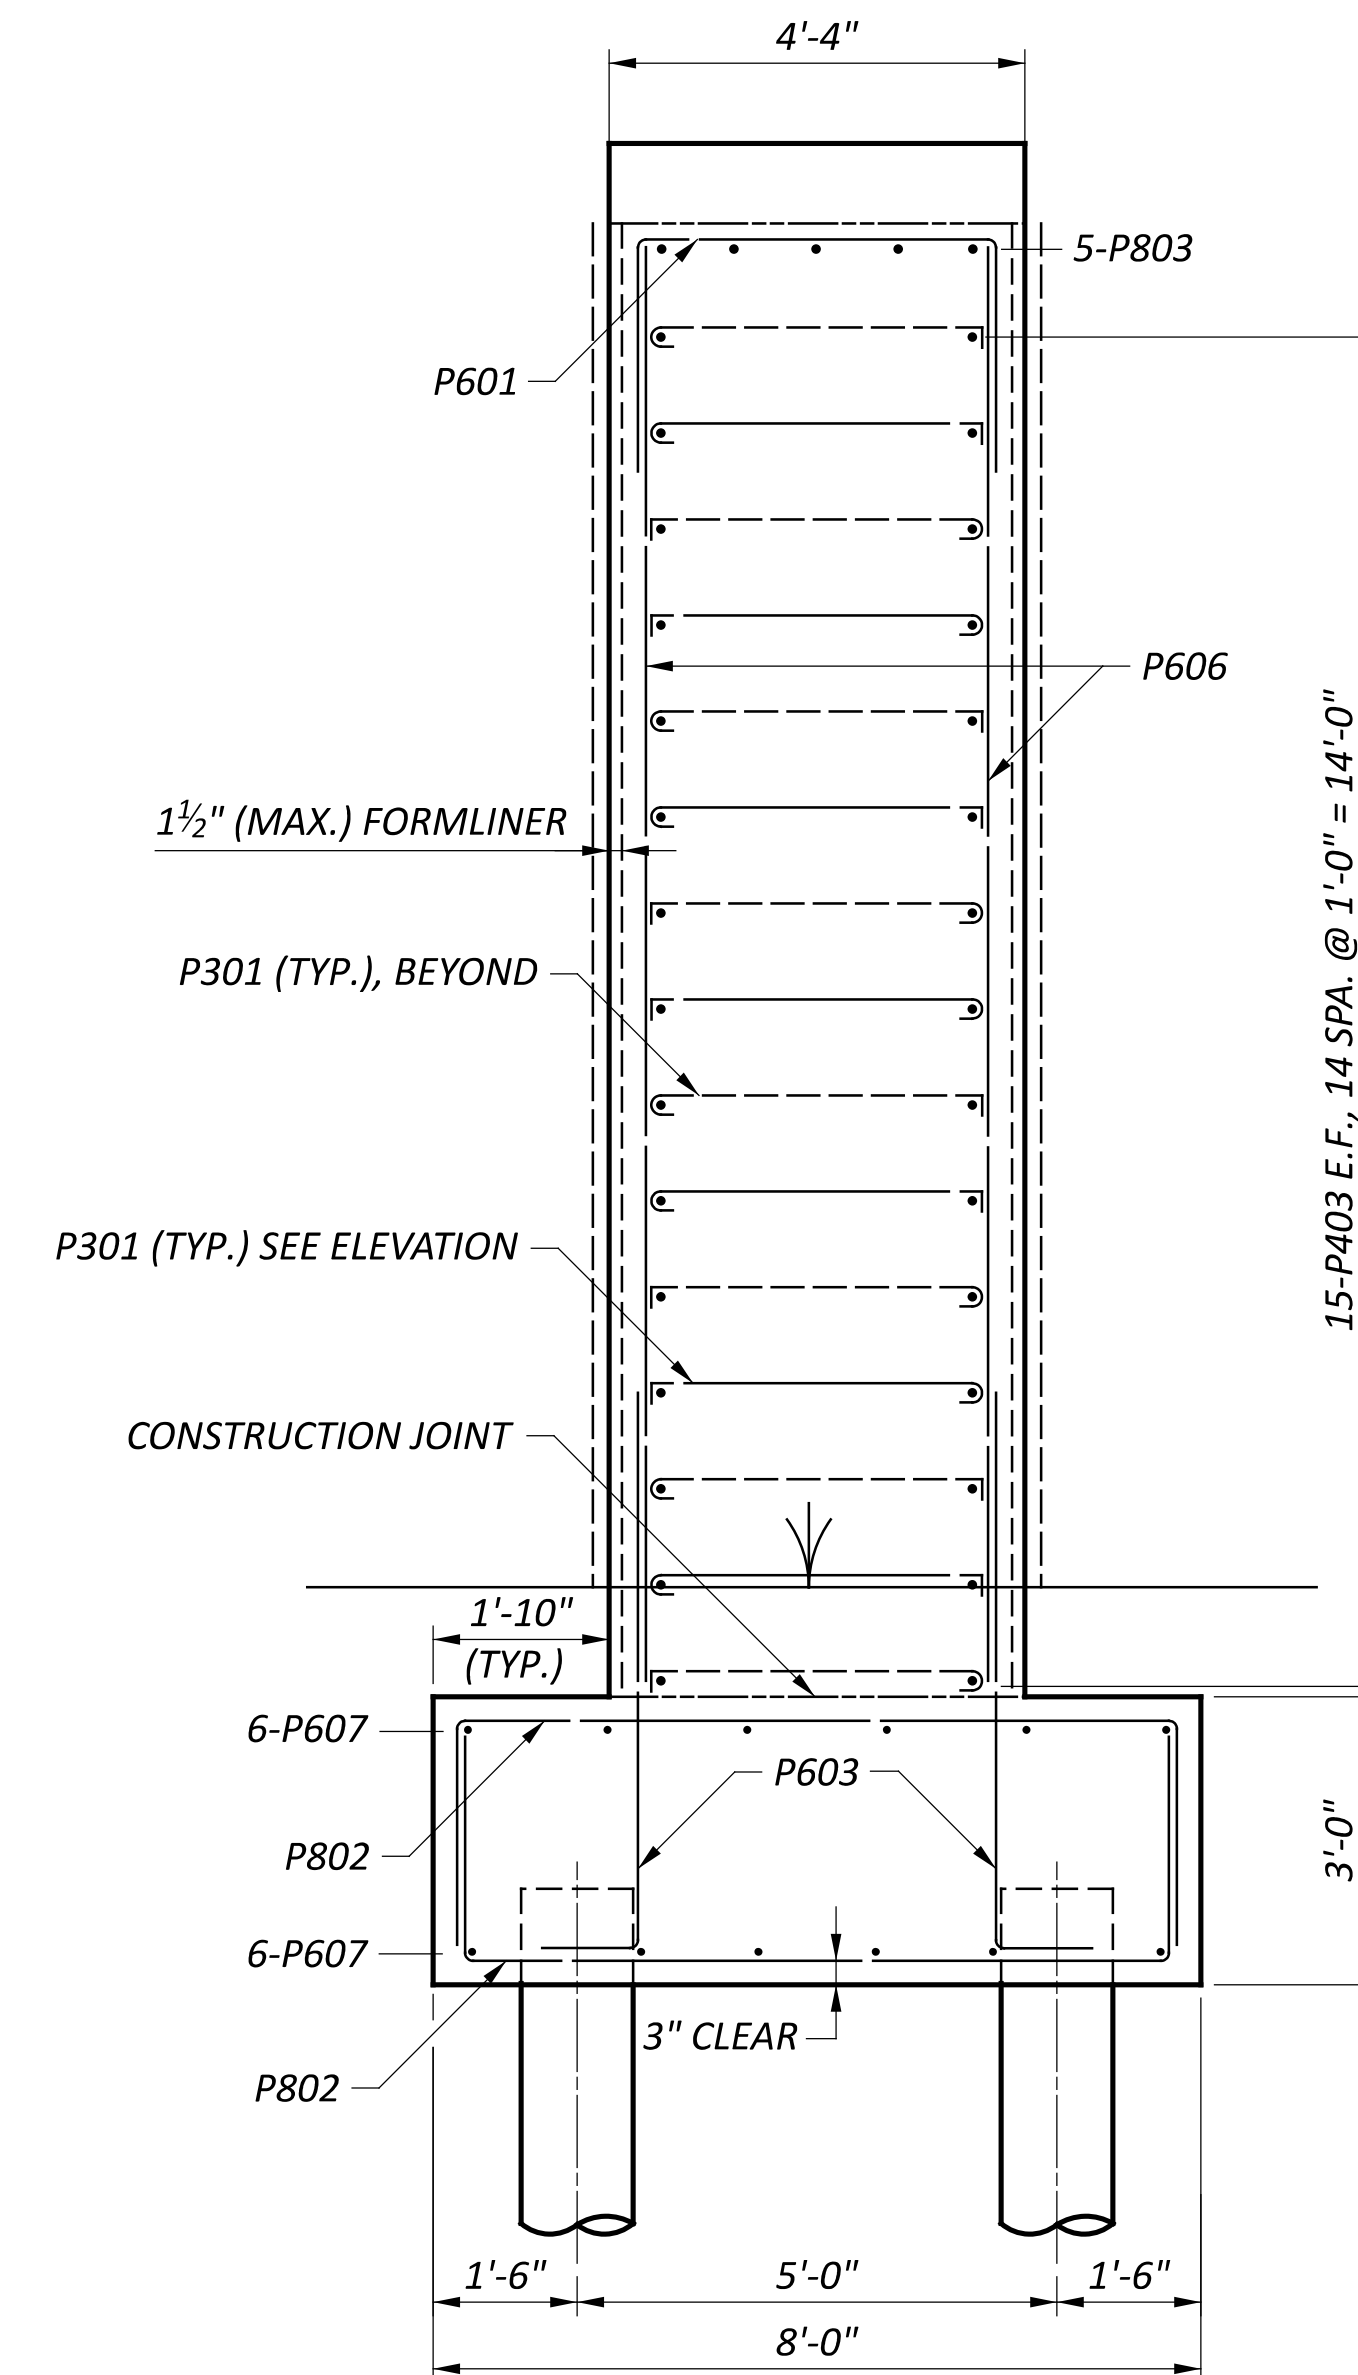



H SECTION  
10

**NOTE**  
 MINIMUM LAP SPLICE LENGTH:  
 #6 BAR = 36 INCHES


**LEGEND**  
 E.F. - EACH FACE

SFN	2926107
DESIGN AGENCY	CARPENTER MARTY
DESIGNER	CHECKER
SMH	AMR
REVIEWER	
PROJECT ID	115388
SUBSET	TOTAL
10	27
SHEET	TOTAL
P.56	P.107




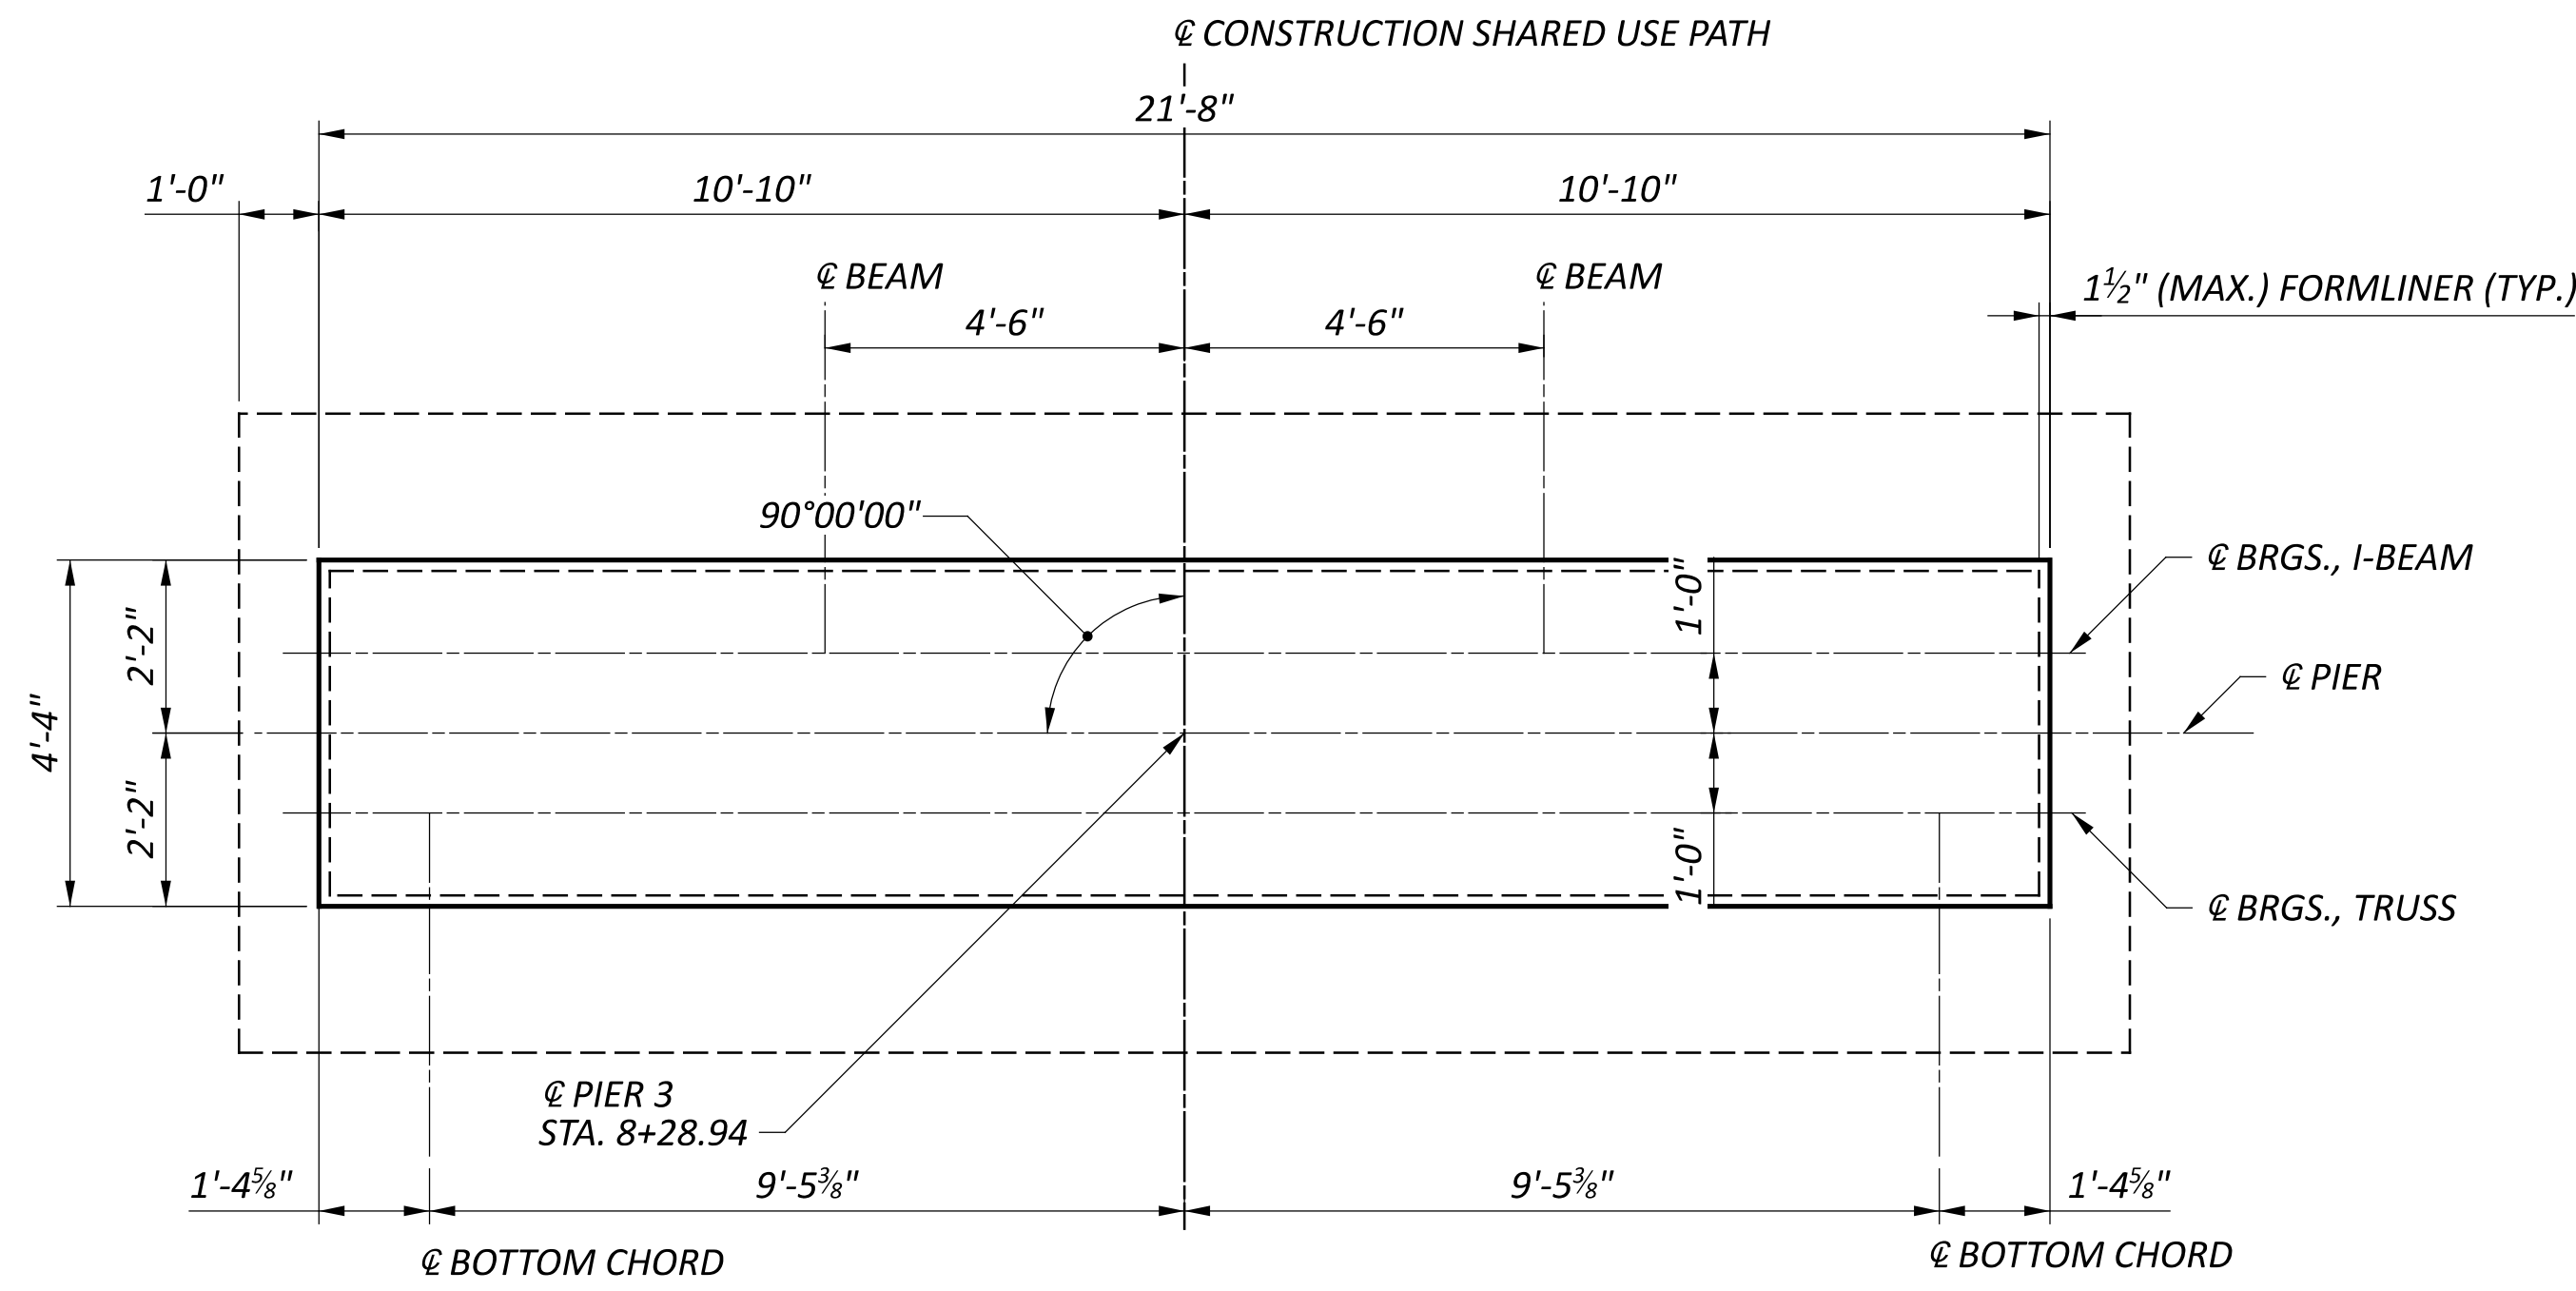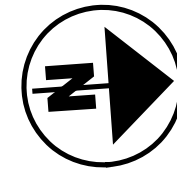


PLAN

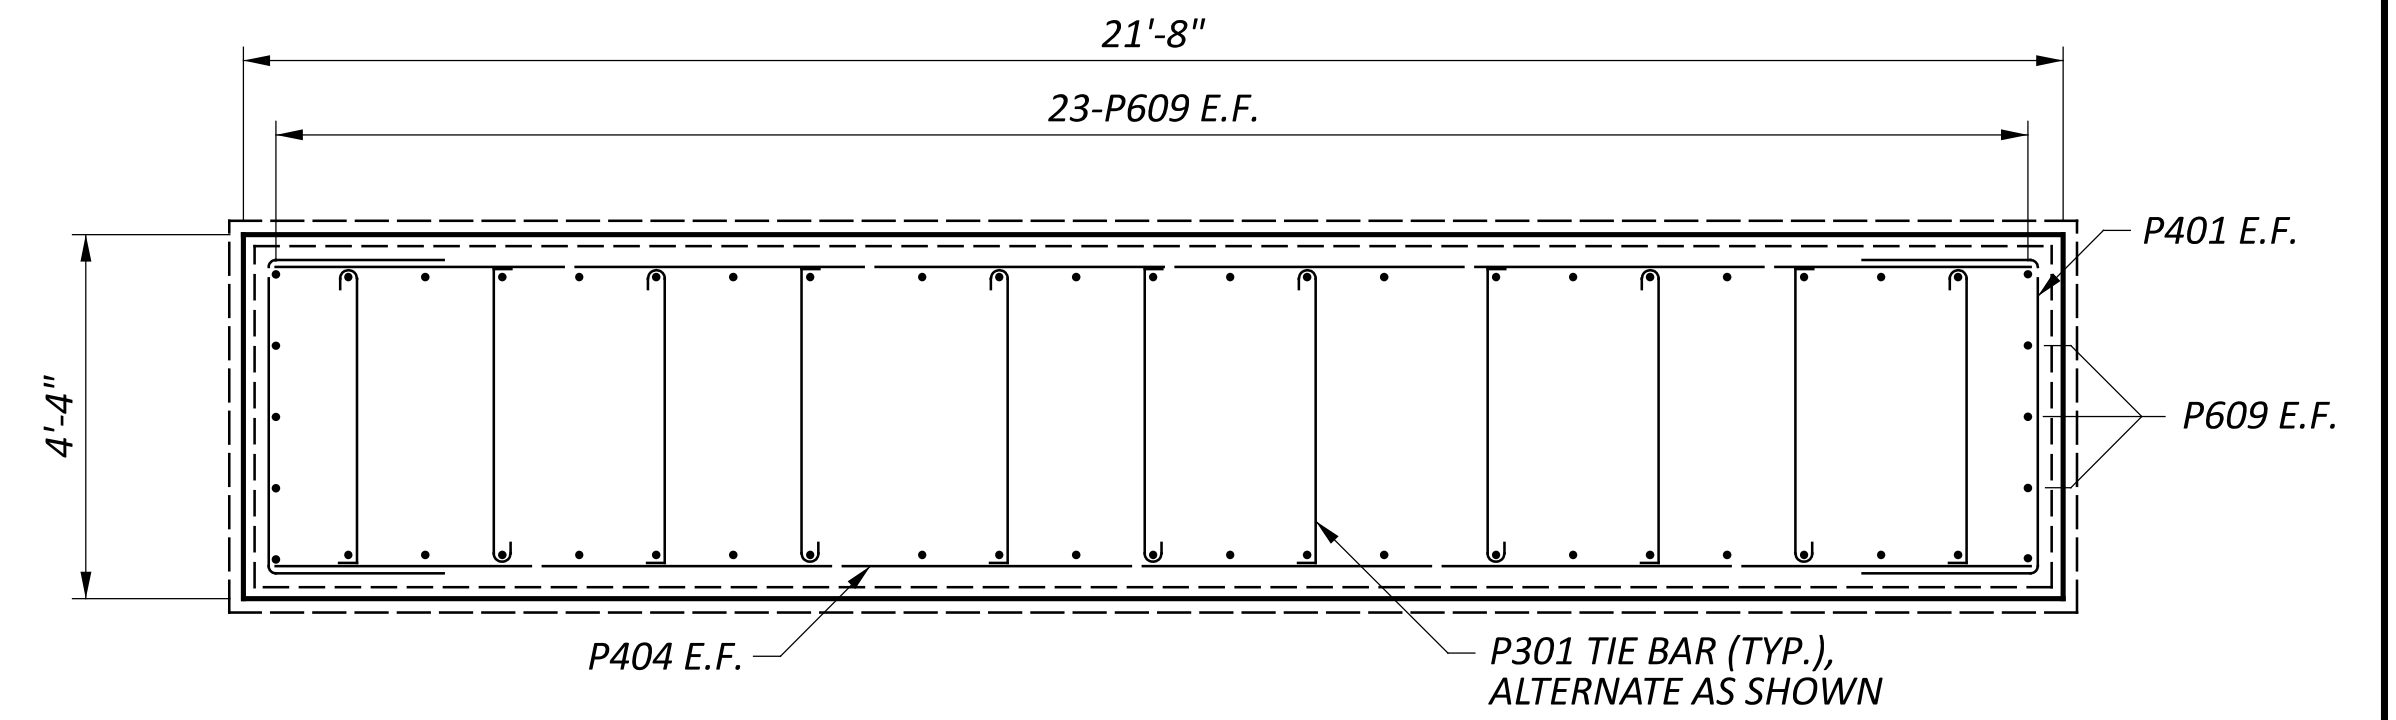

J SECTION  
 11

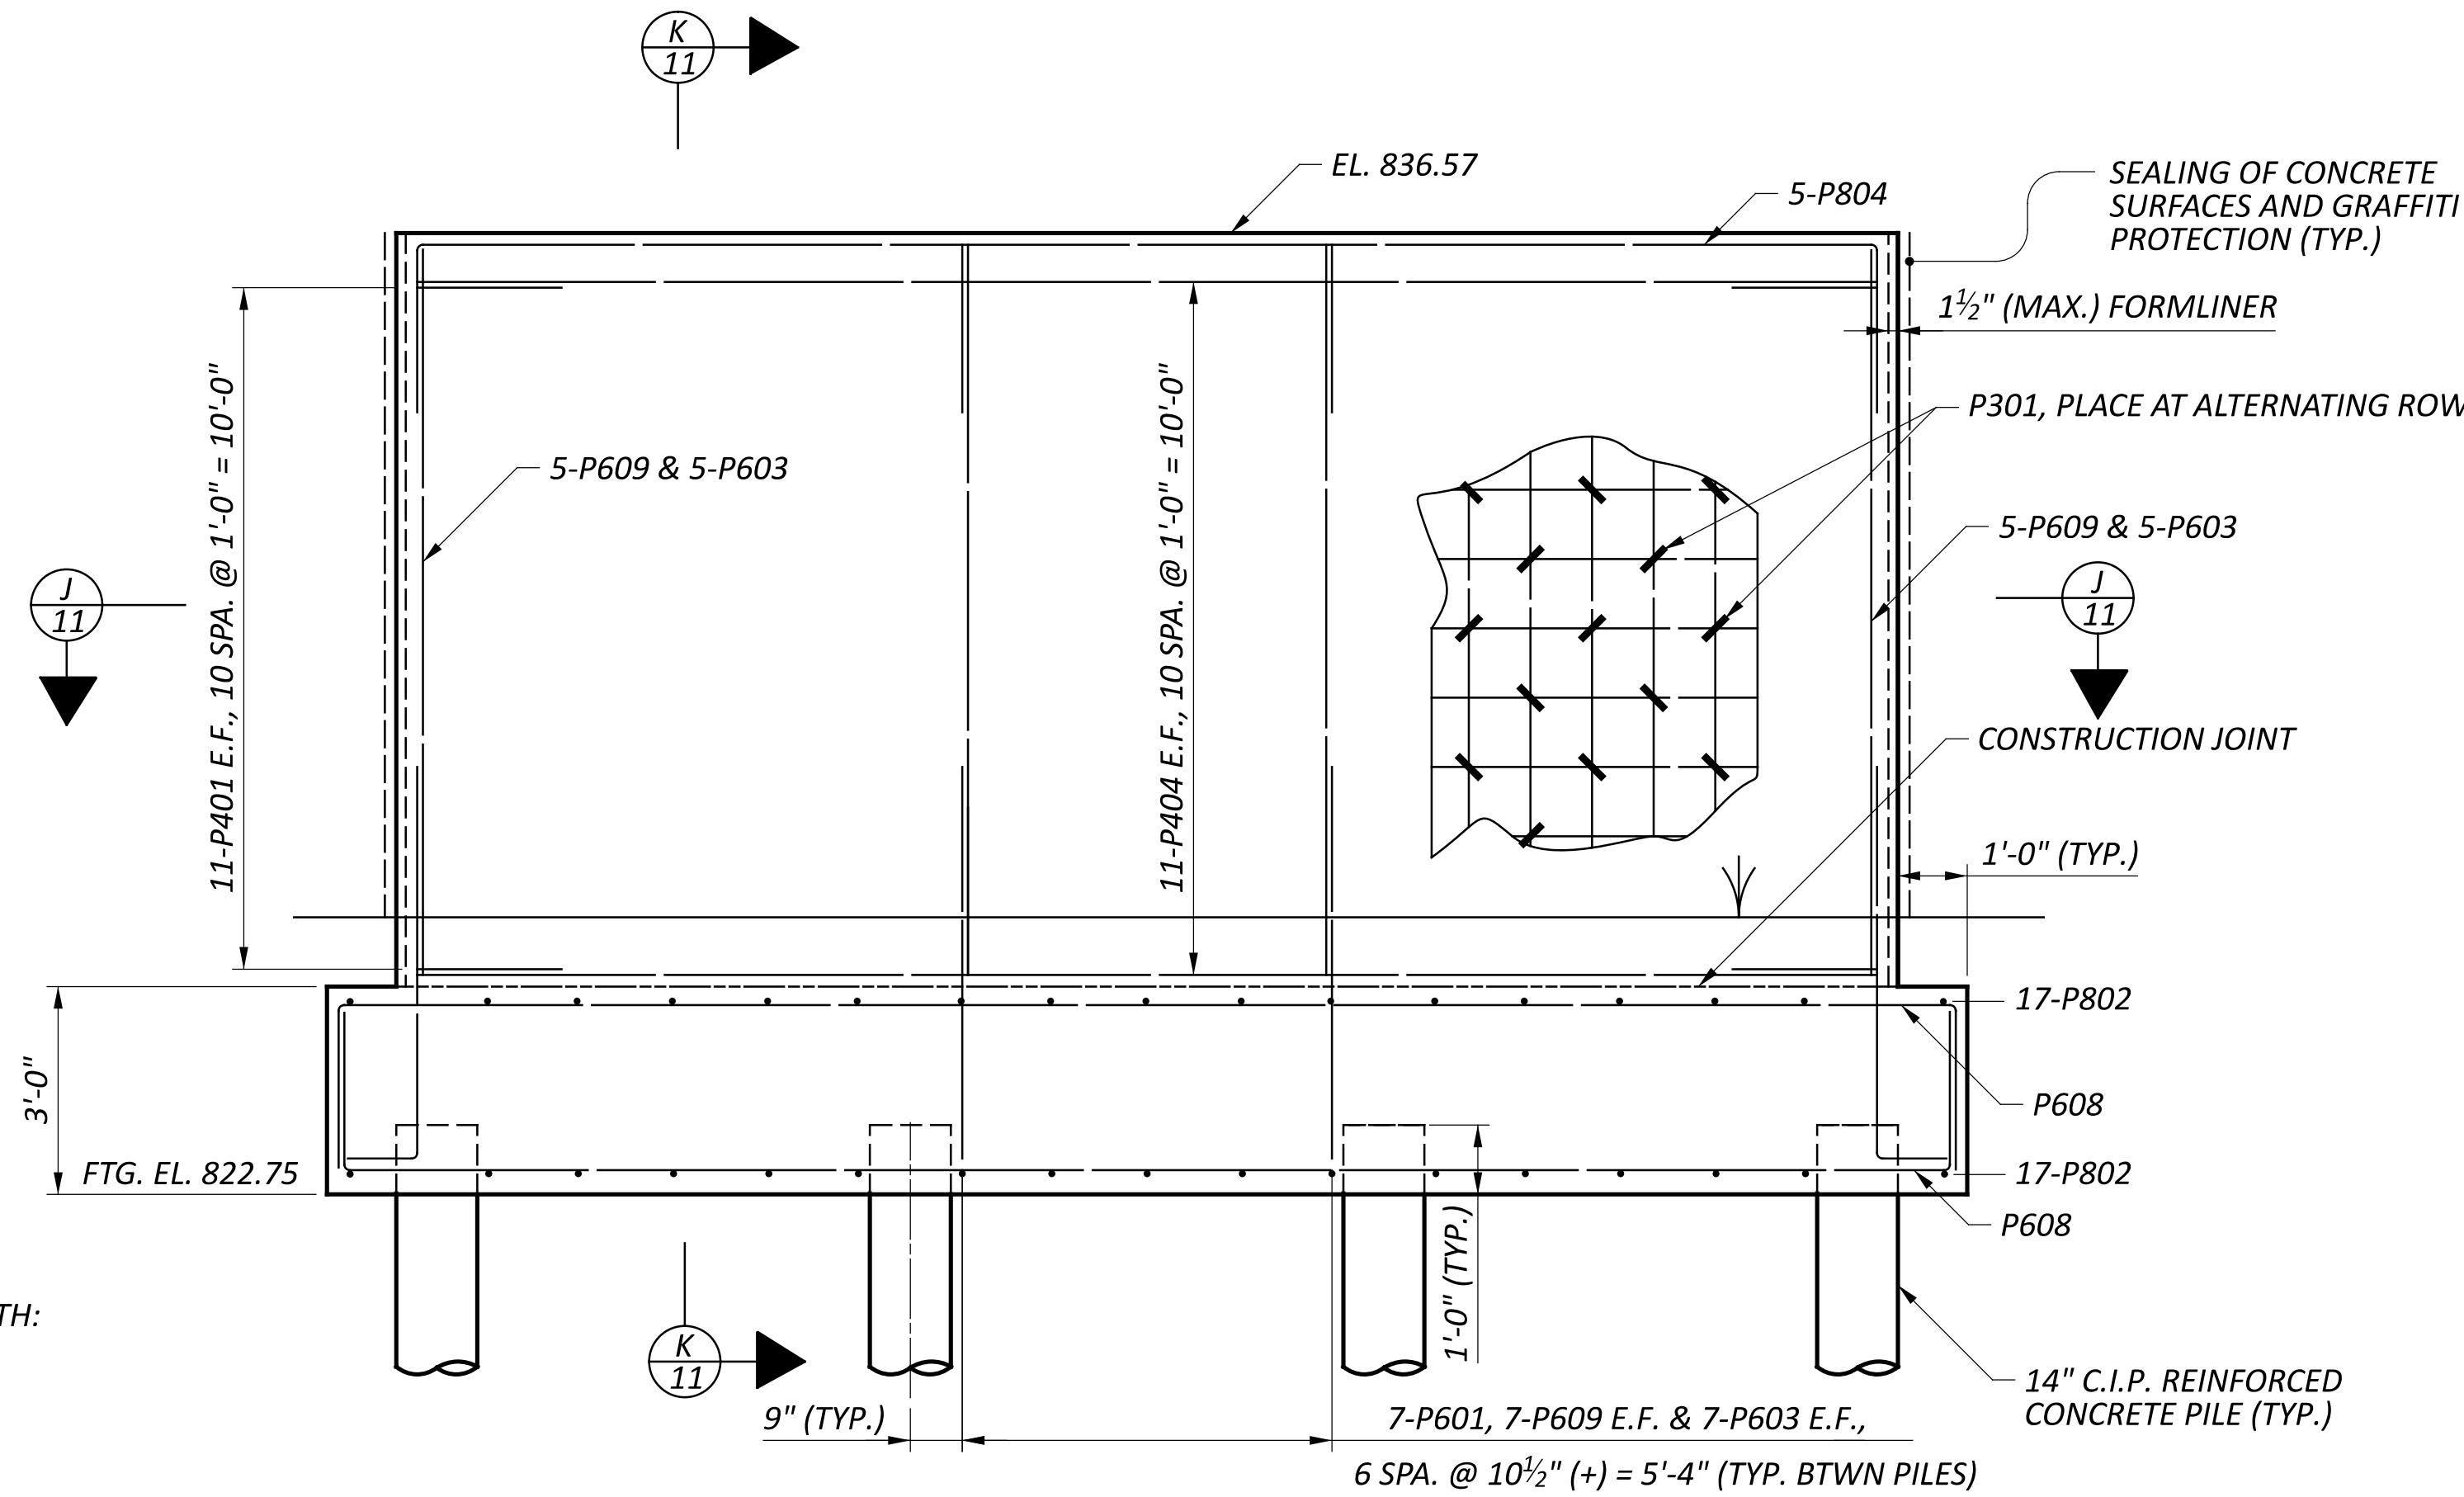

ELEVATION

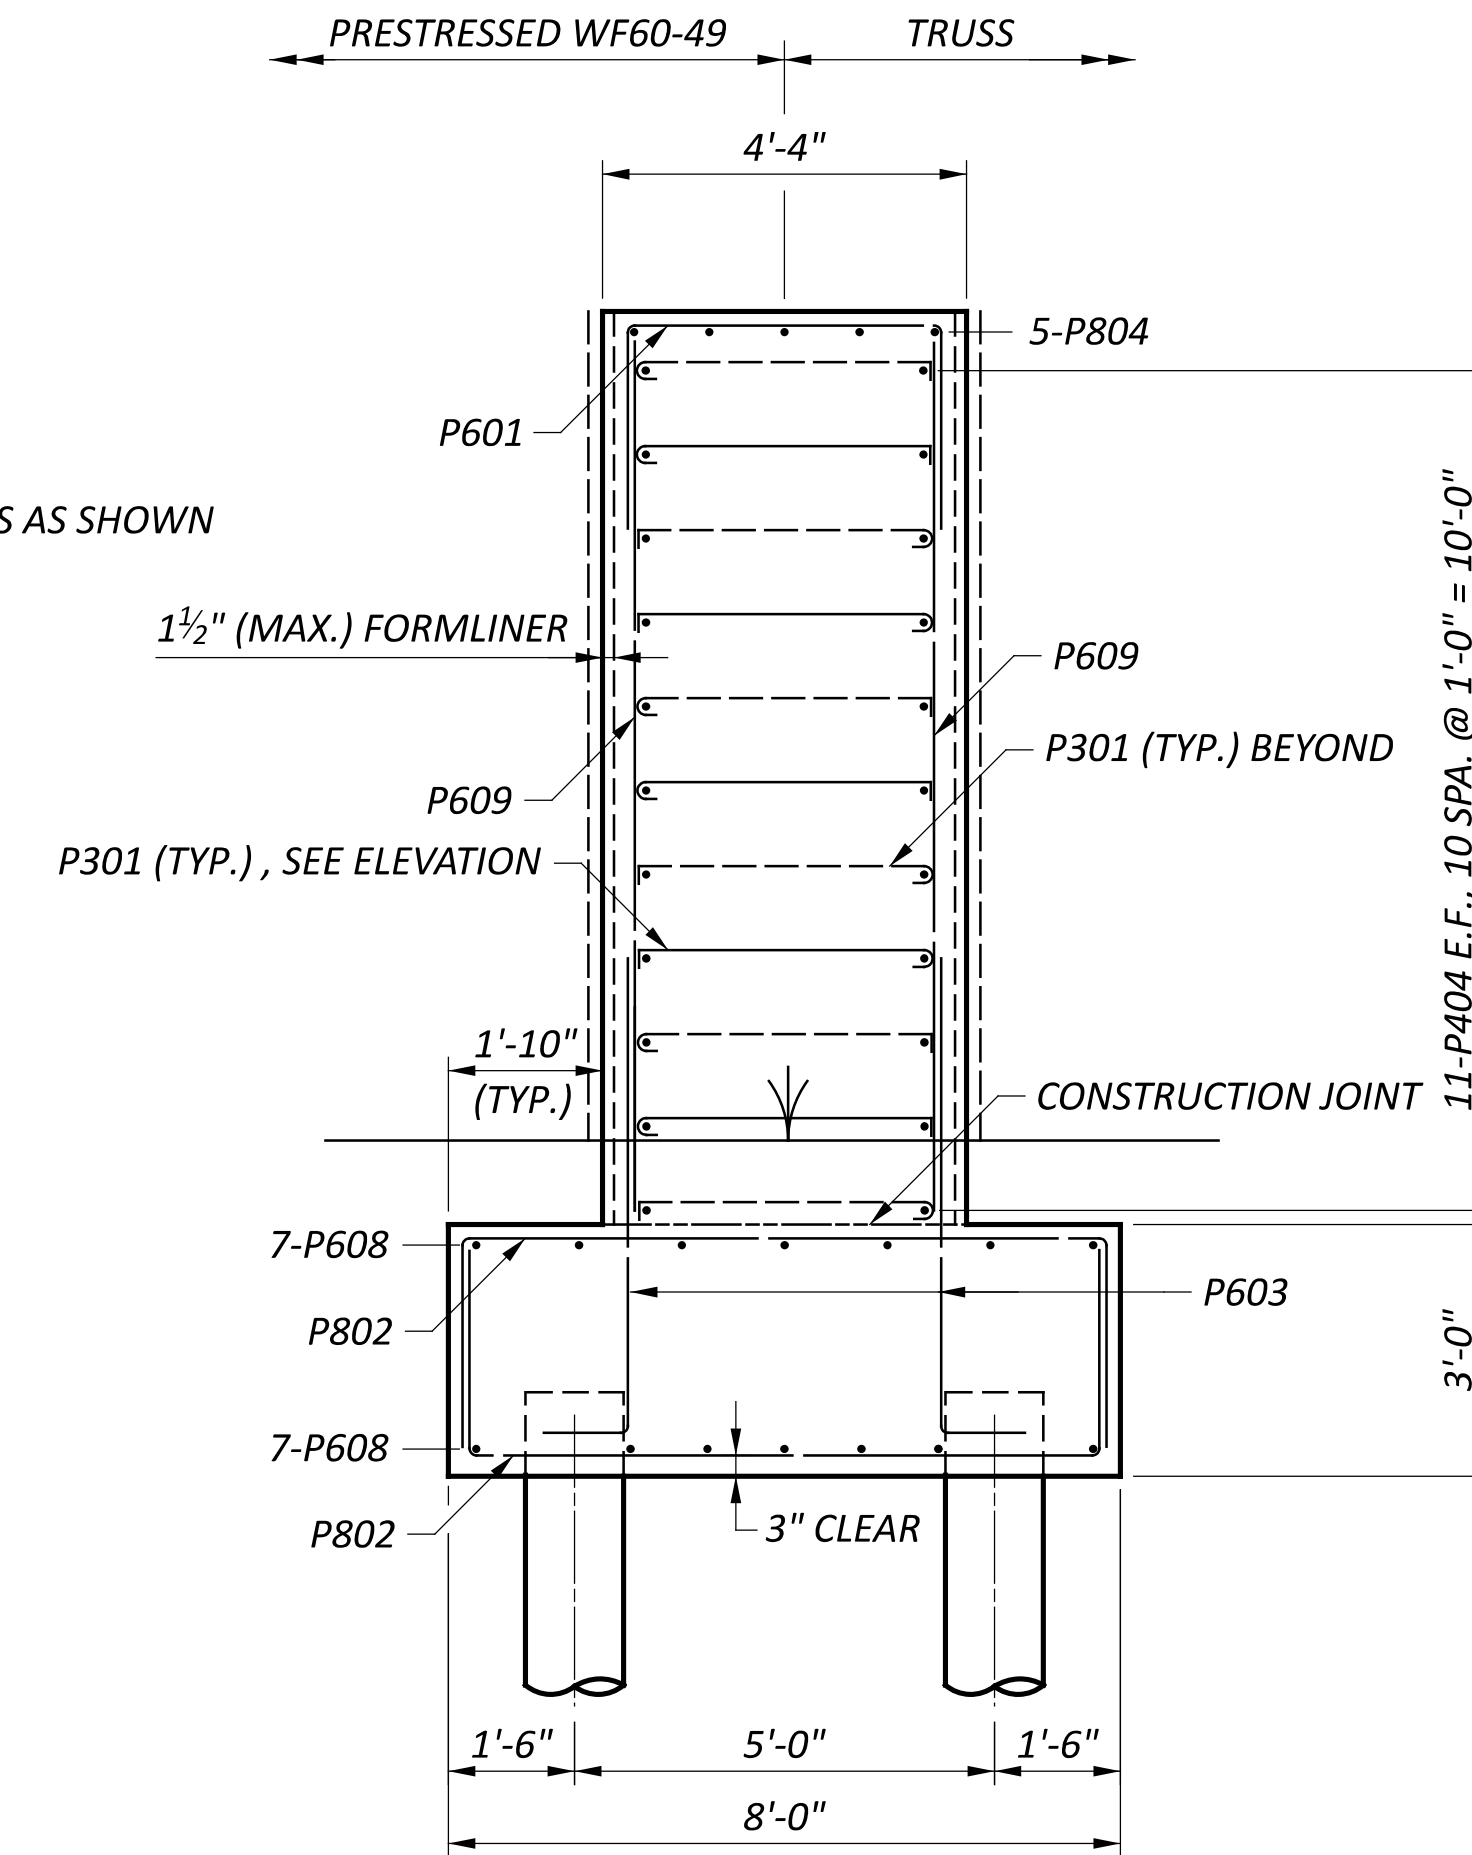


K SECTION  
 11


NOTE  
 MINIMUM LAP SPLICE LENGTH:  
 #6 BAR = 36 INCHES

LEGEND  
 E.F. - EACH FACE


SFN	2926107
DESIGN AGENCY	CARPENTER MARTY
DESIGNER	CHECKER
JZ	AMR
REVIEWER	
PROJECT ID	115388
SUBSET	TOTAL
11	27
SHEET	TOTAL
P.57	P.107

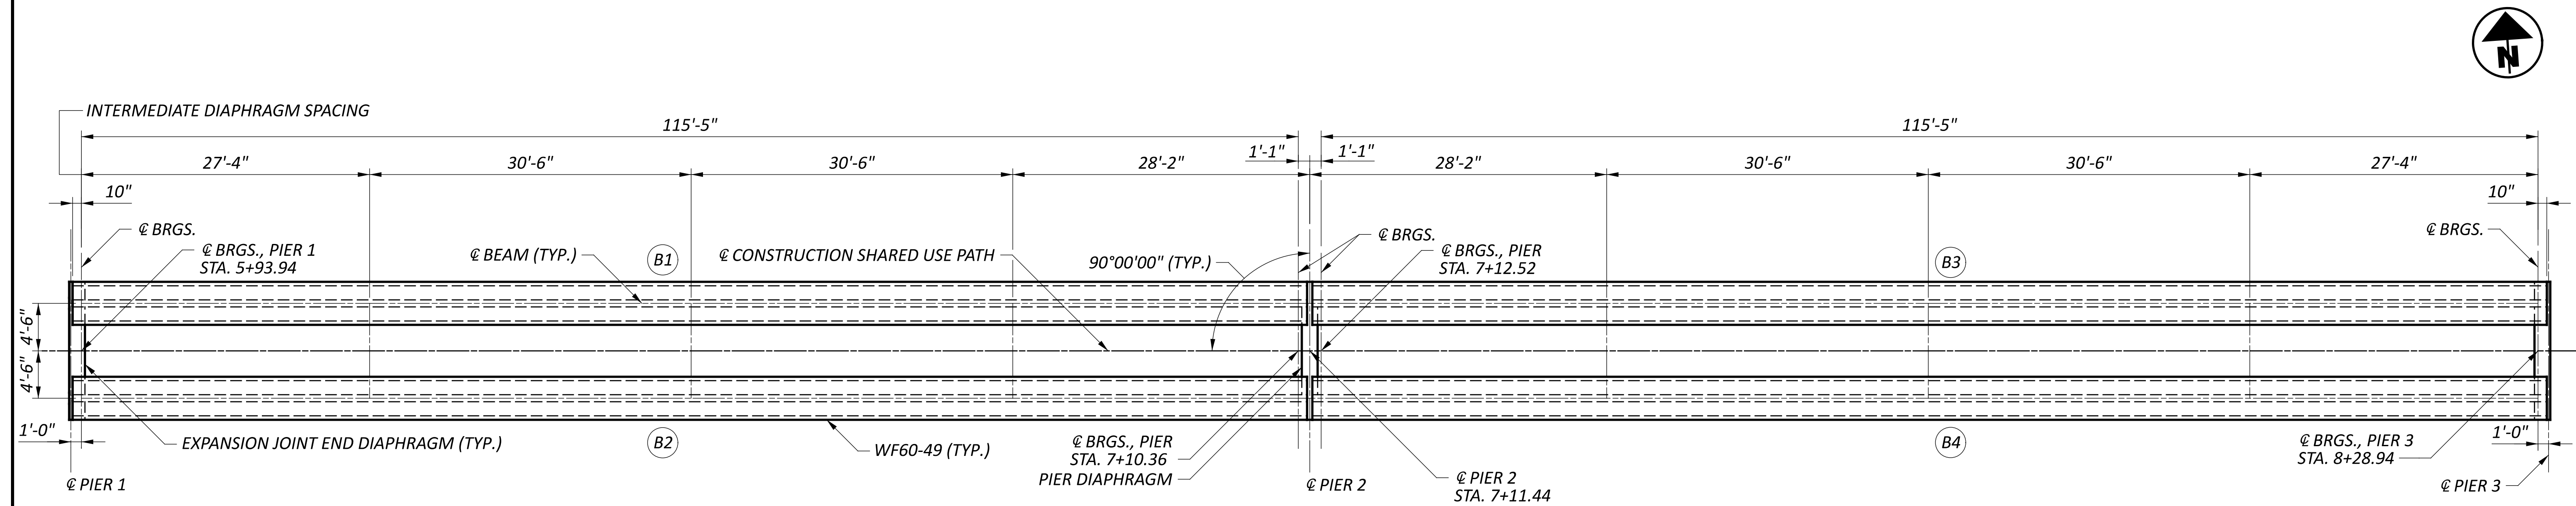


FRAMING PLAN

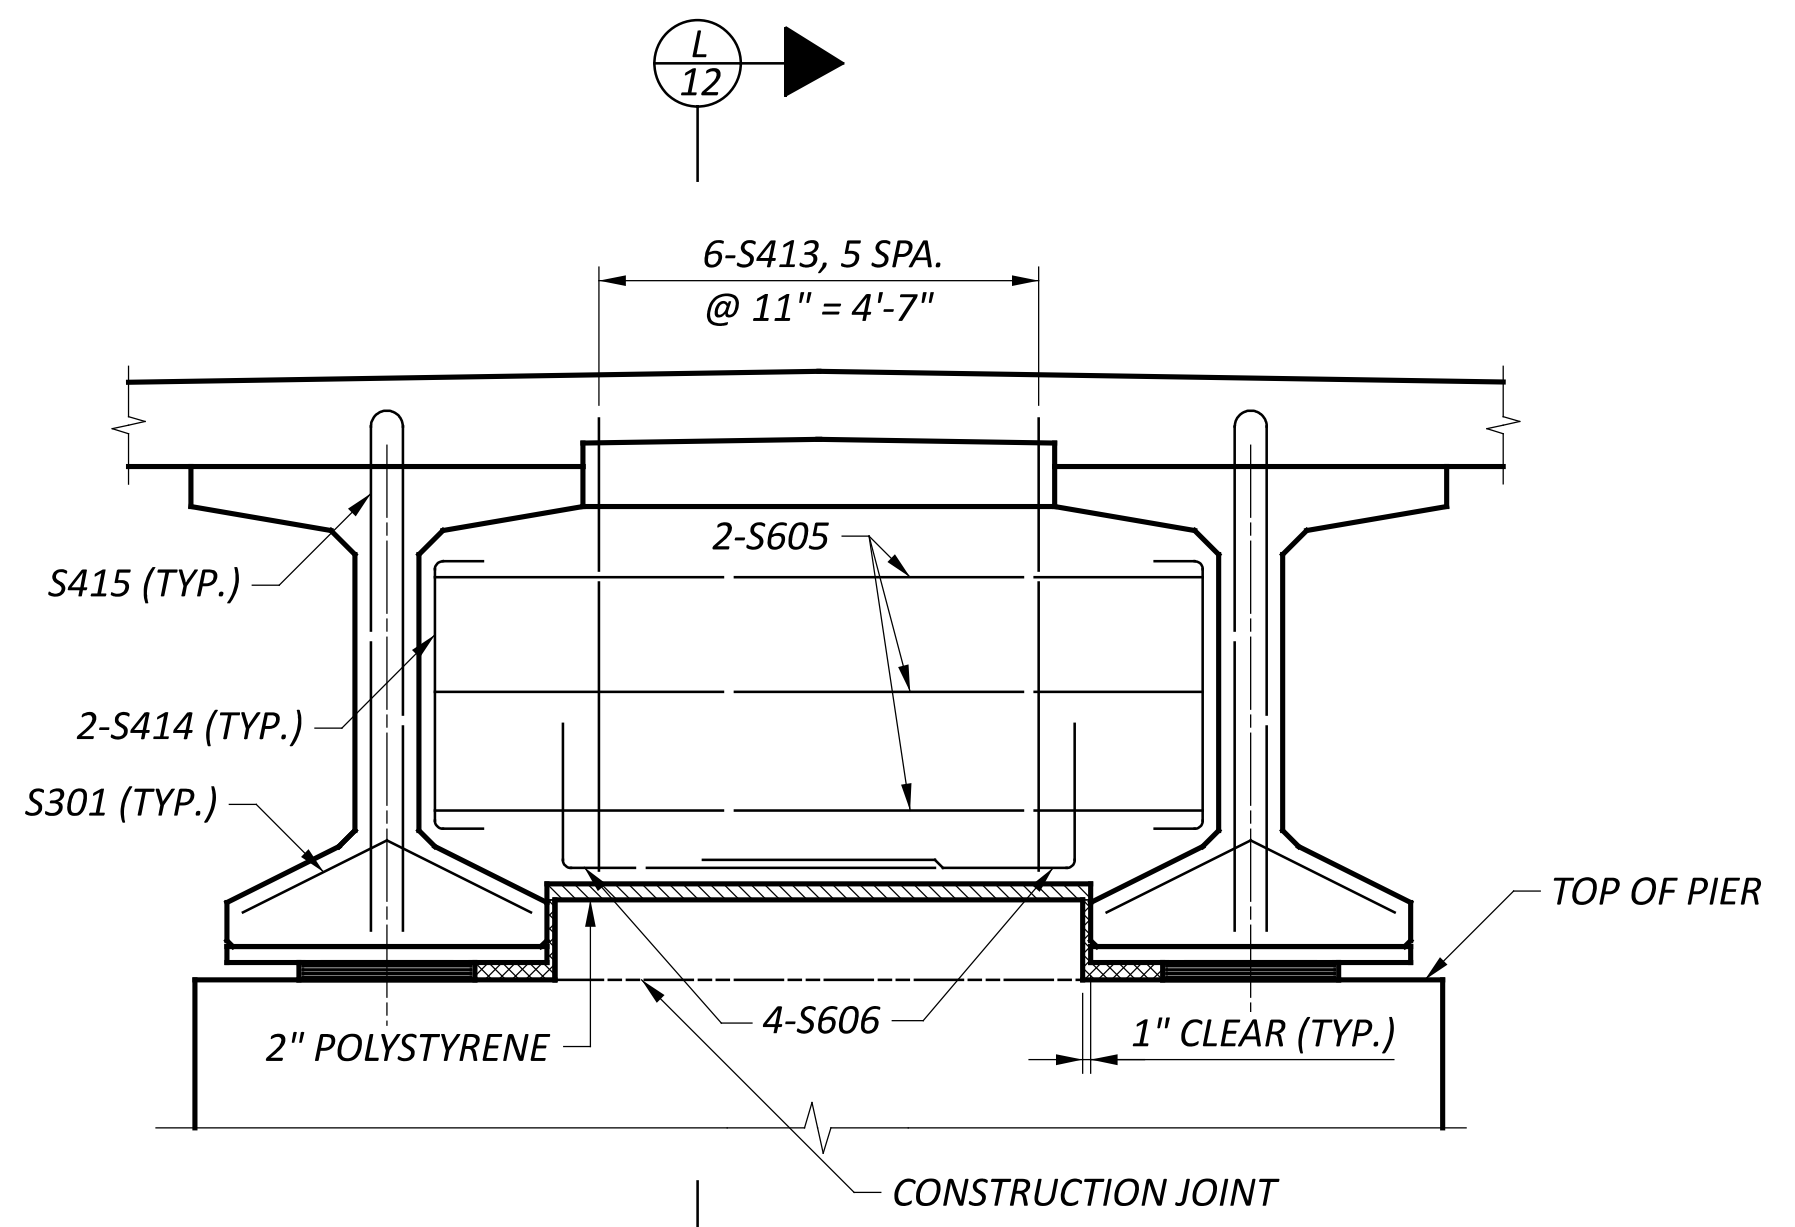

PIER 2 DIAPHRAGM ELEVATION

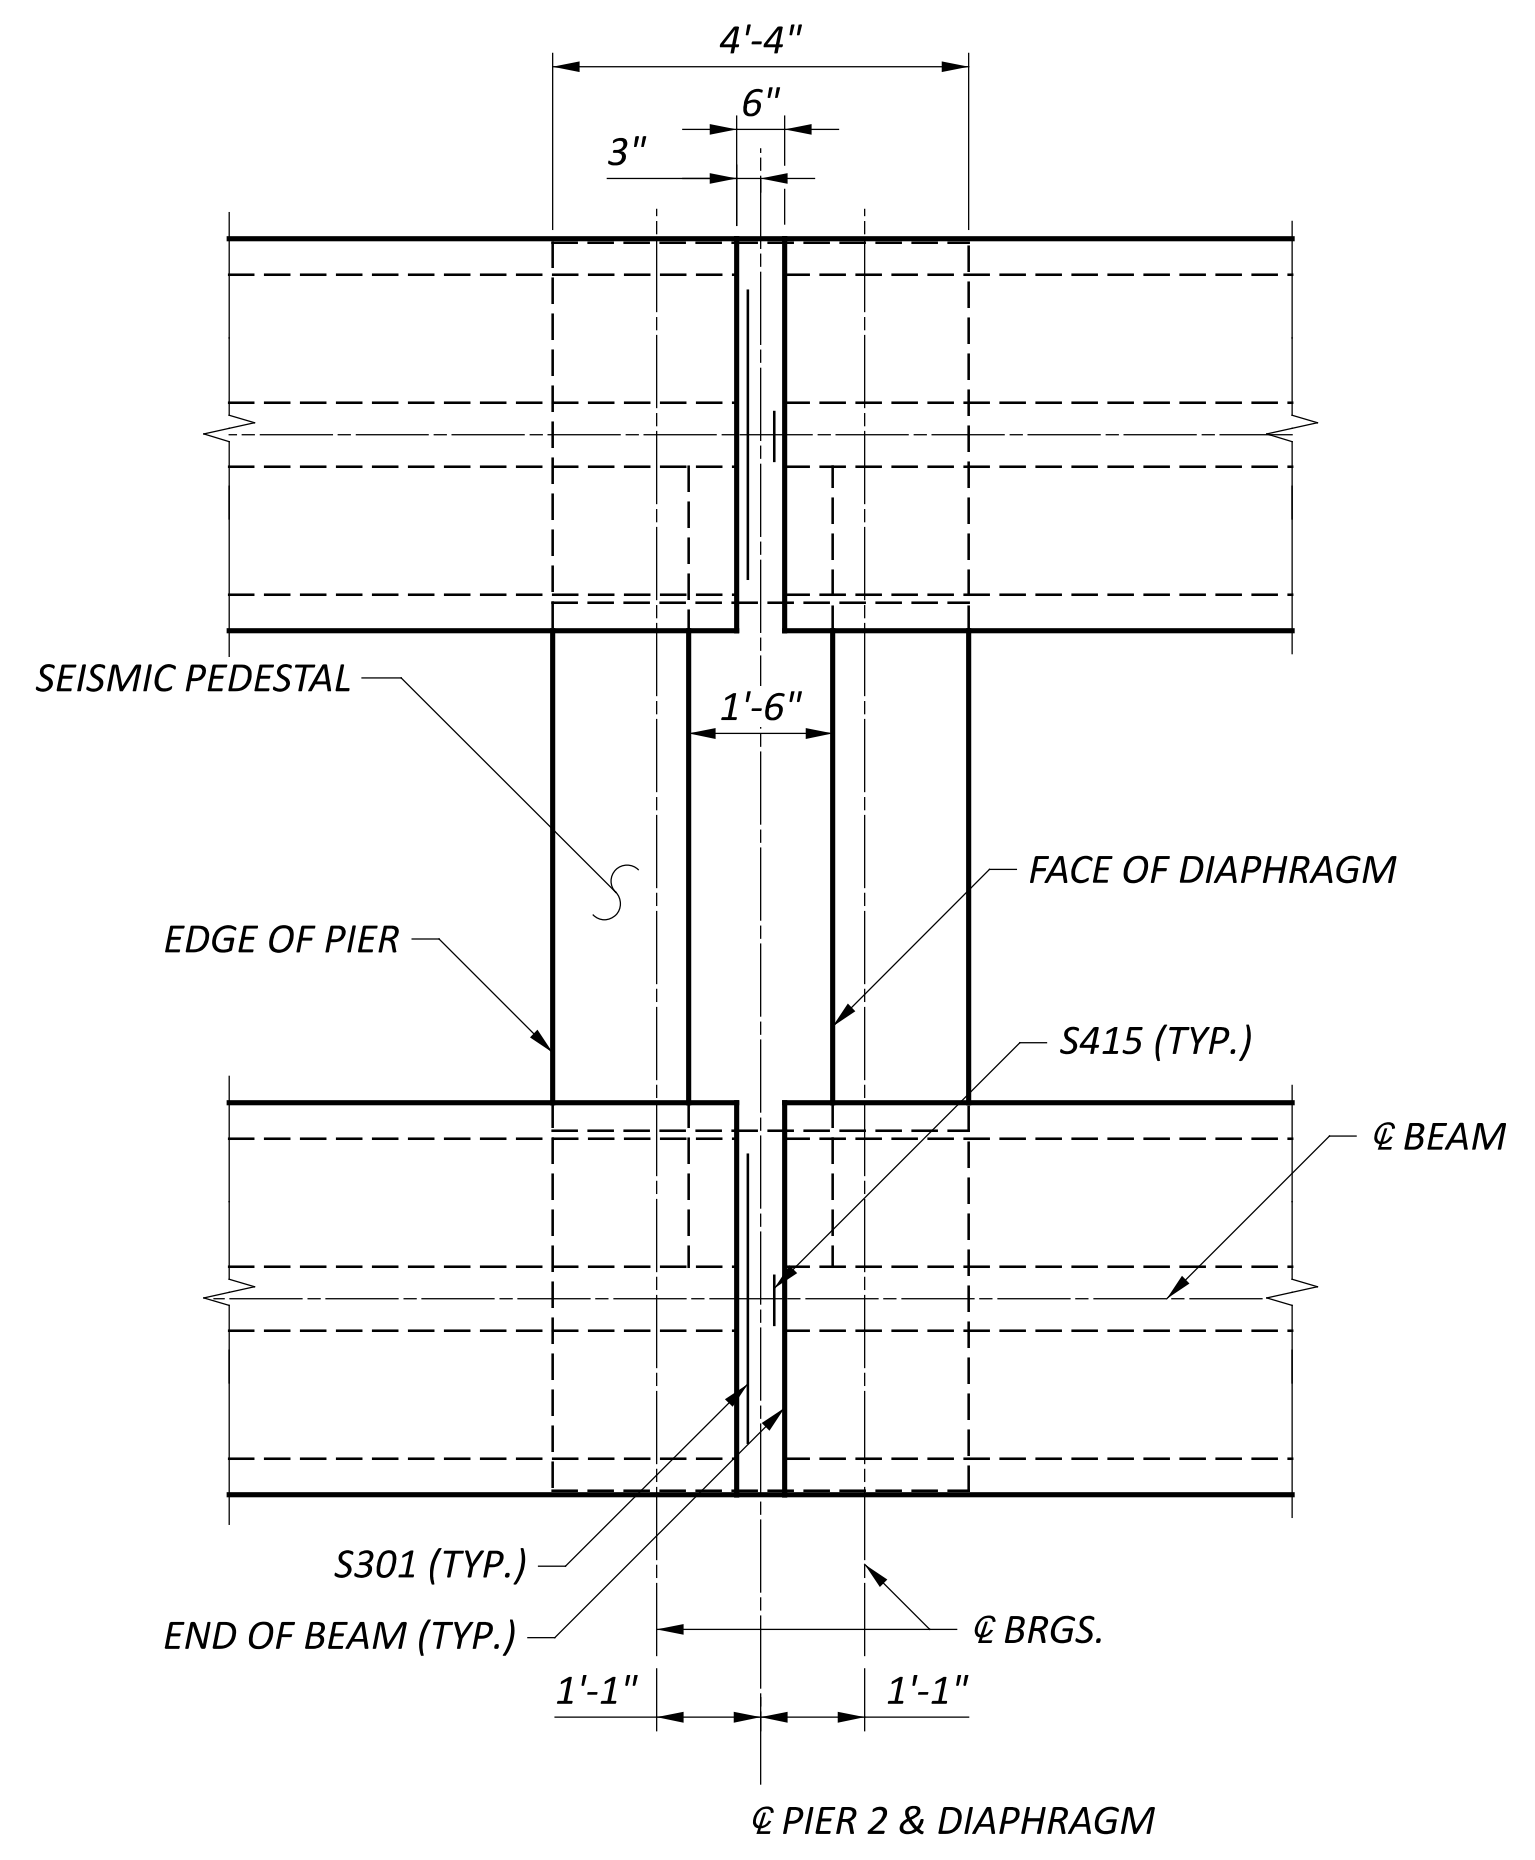

PIER 2 PLAN

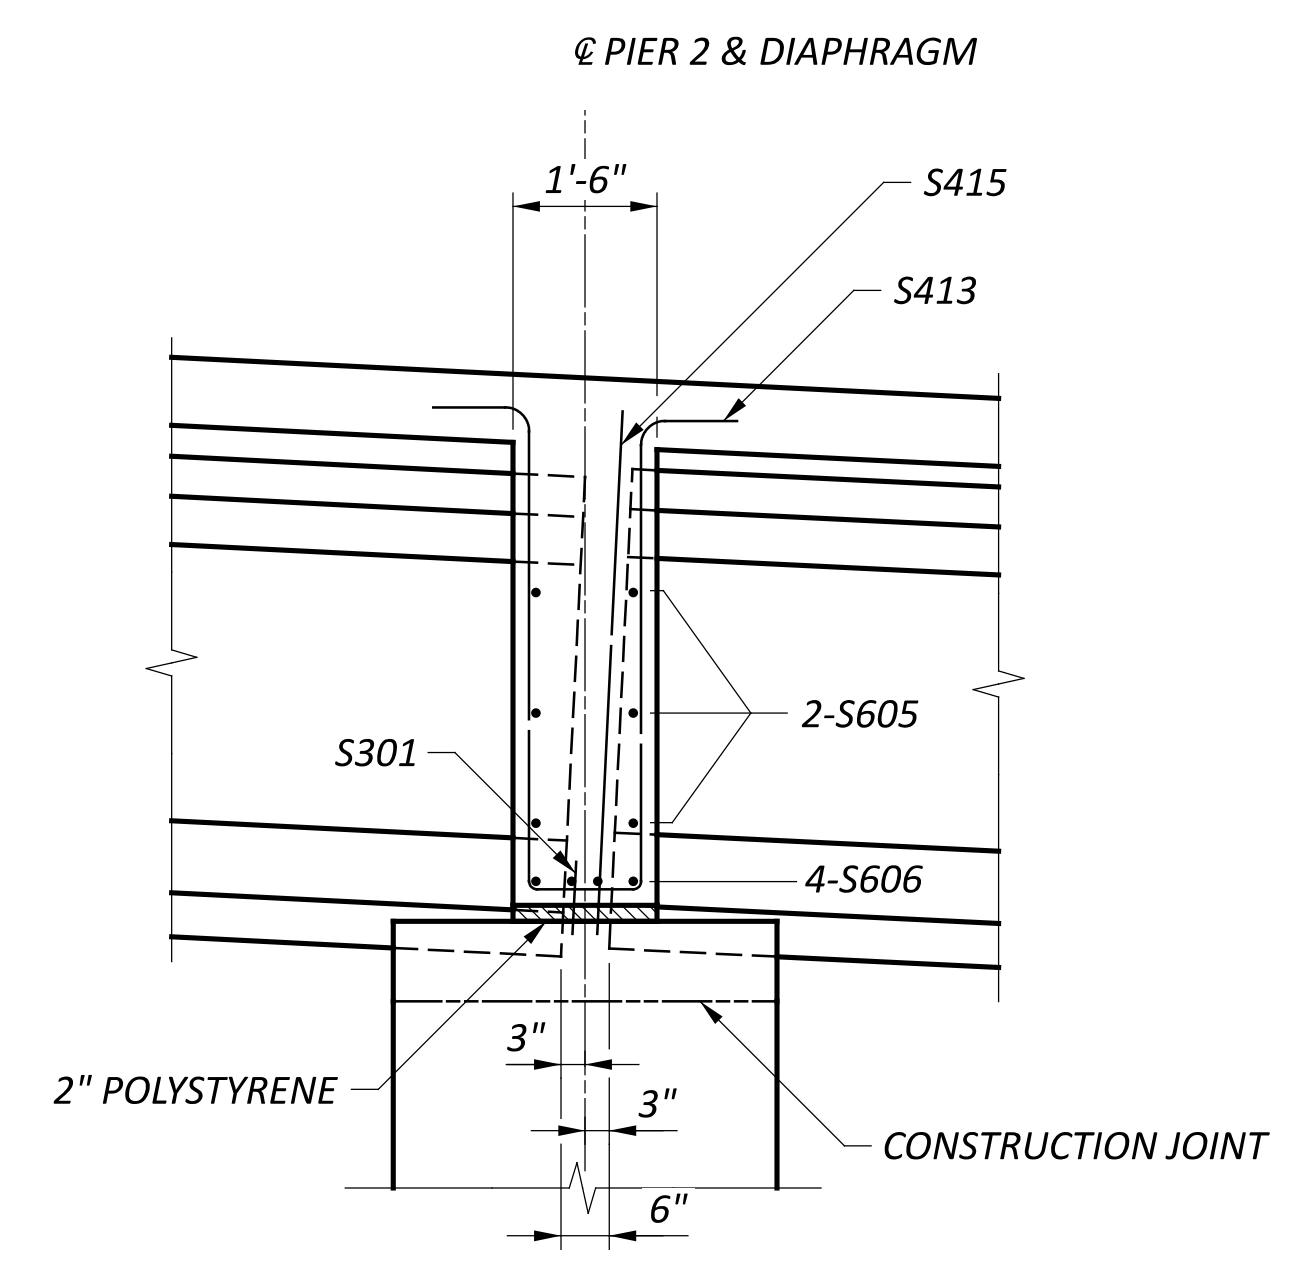

SECTION


**LEGEND**  
 (B#) - BEAM NUMBER

**NOTES**  
 1. REFER TO STD. DWG. PSID-1-13 FOR ADDITIONAL NOTES AND DETAILS.  
 2. REFER TO SHEET 13/27 FOR BEAM SECTION AND STRAND LAYOUT.



FRAMING PLAN (SPANS 2 & 3) AND PIER 2 DIAPHRAGM DETAILS  
 BRIDGE NO. GRE-BK80020-00.492  
 PEDESTRIAN BRIDGE OVER US 68 AND OLDTOWN CREEK


SFN 2926107	
DESIGN AGENCY	
CARPENTER MARTY	
DESIGNER JZ	CHECKER AMR
REVIEWER GDJ 03/28/25	
PROJECT ID 115388	
SUBSET 12	TOTAL 27
SHEET P.58	TOTAL P.107

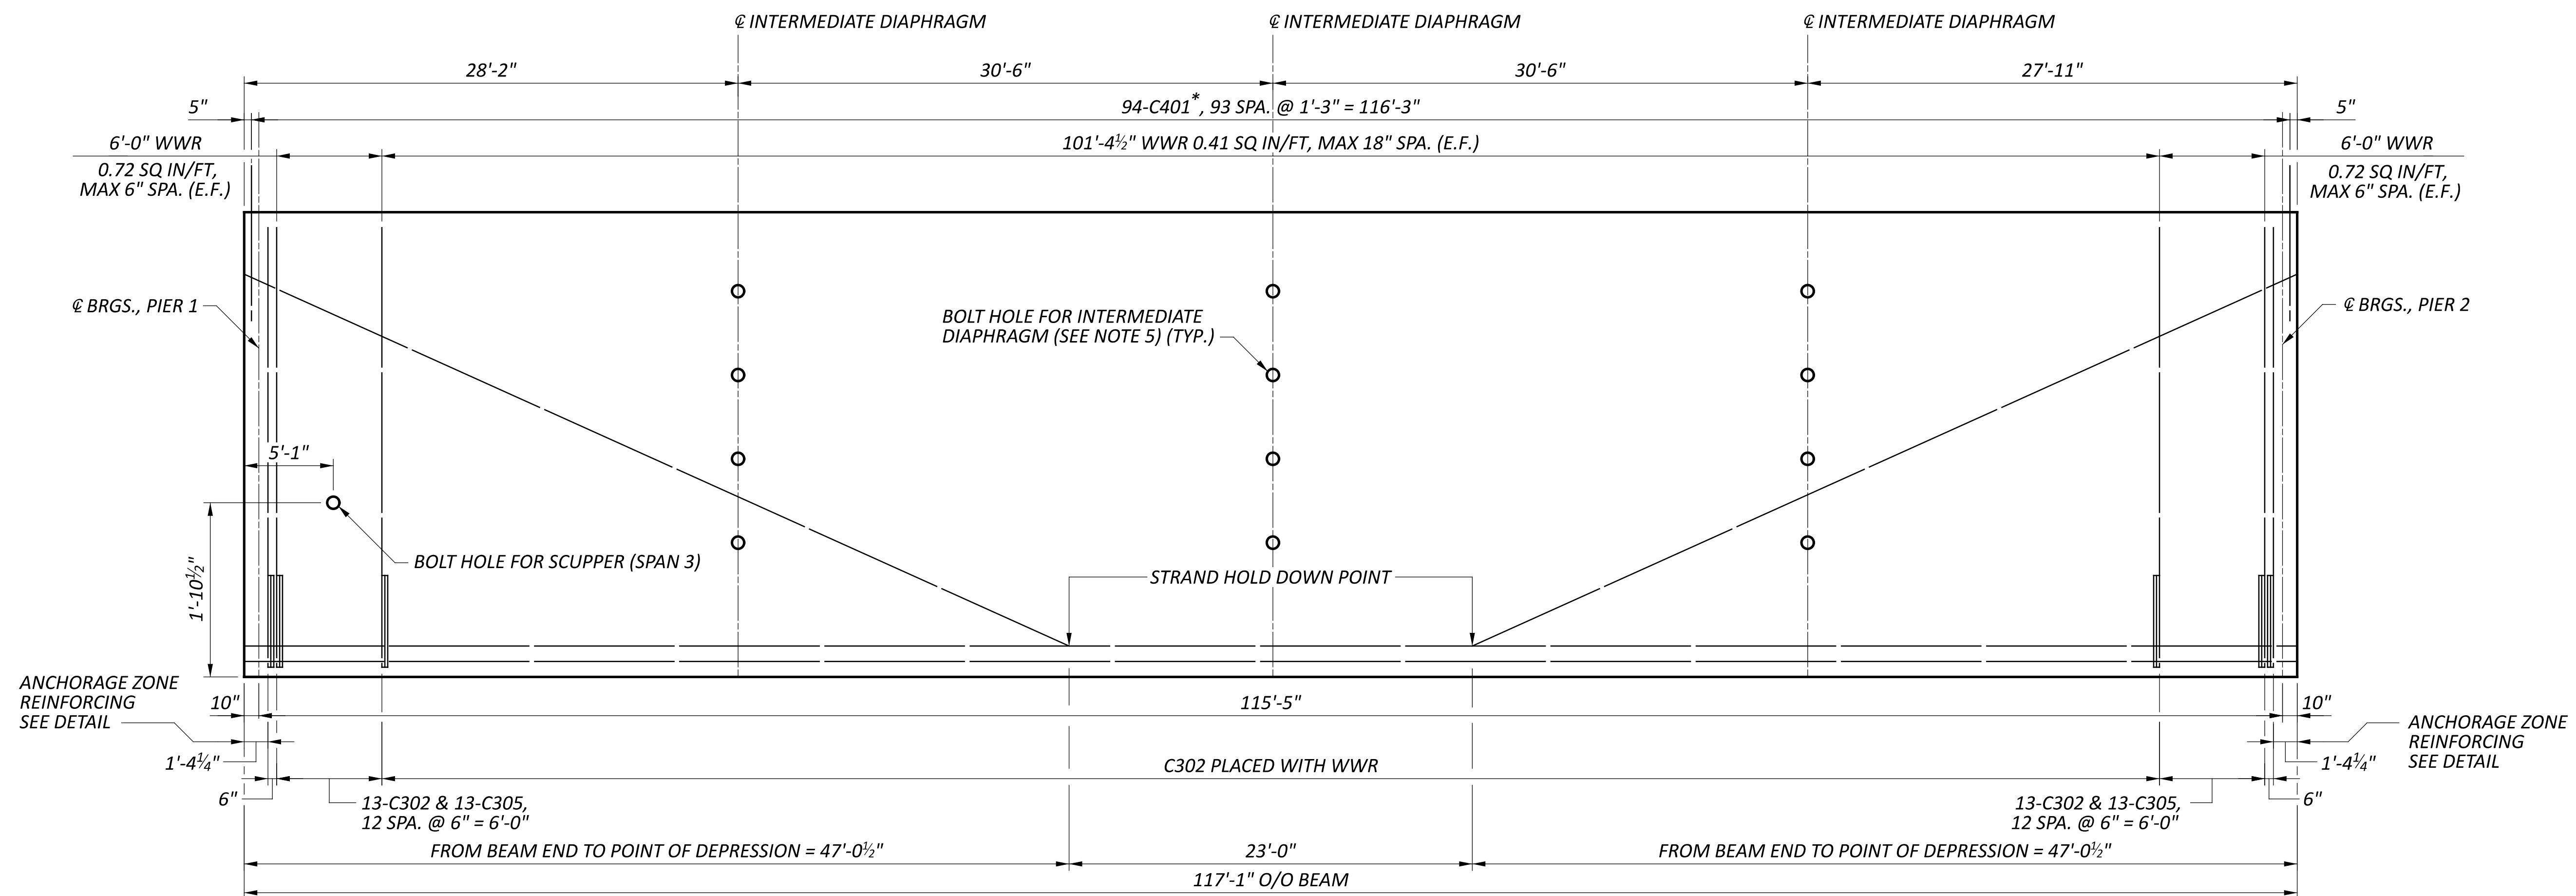


TYPICAL BEAM ELEVATION  
 VERTICAL SCALE EXAGGERATED  
 SPAN 2 SHOWN, SPAN 3 OPPOSITE HAND

SECTION	NUMBER OF STRANDS PER ROW			TOTAL	CONCRETE STRENGTHS (KSI)		C305 REQ'D	C401* REQ'D
	①	②	③		f'ci	f'cf		
END	15	12	1	28	f'ci	f'cf		
MID	15	12	1	28	5.0	7.0	38	94


\* - TO BE GALVANIZED

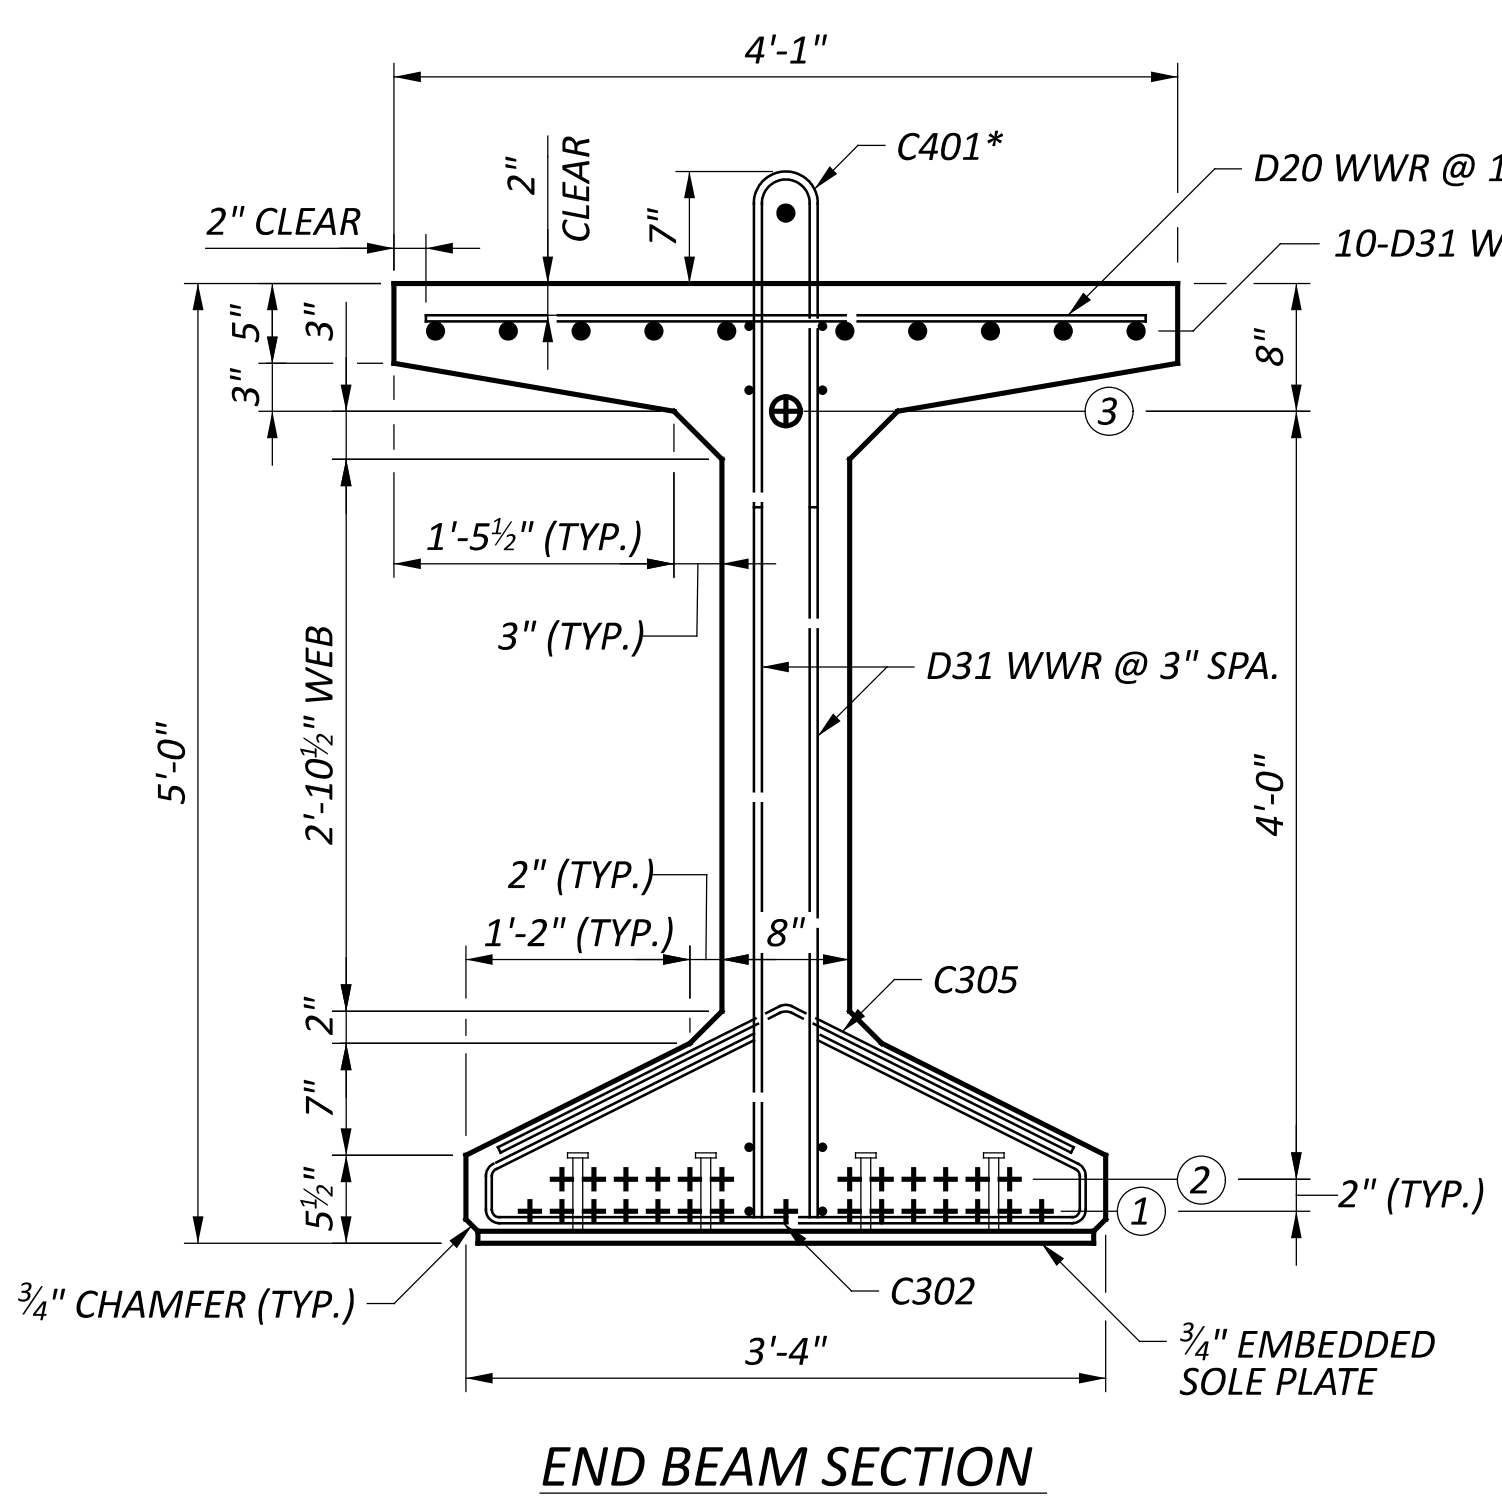

END BEAM SECTION

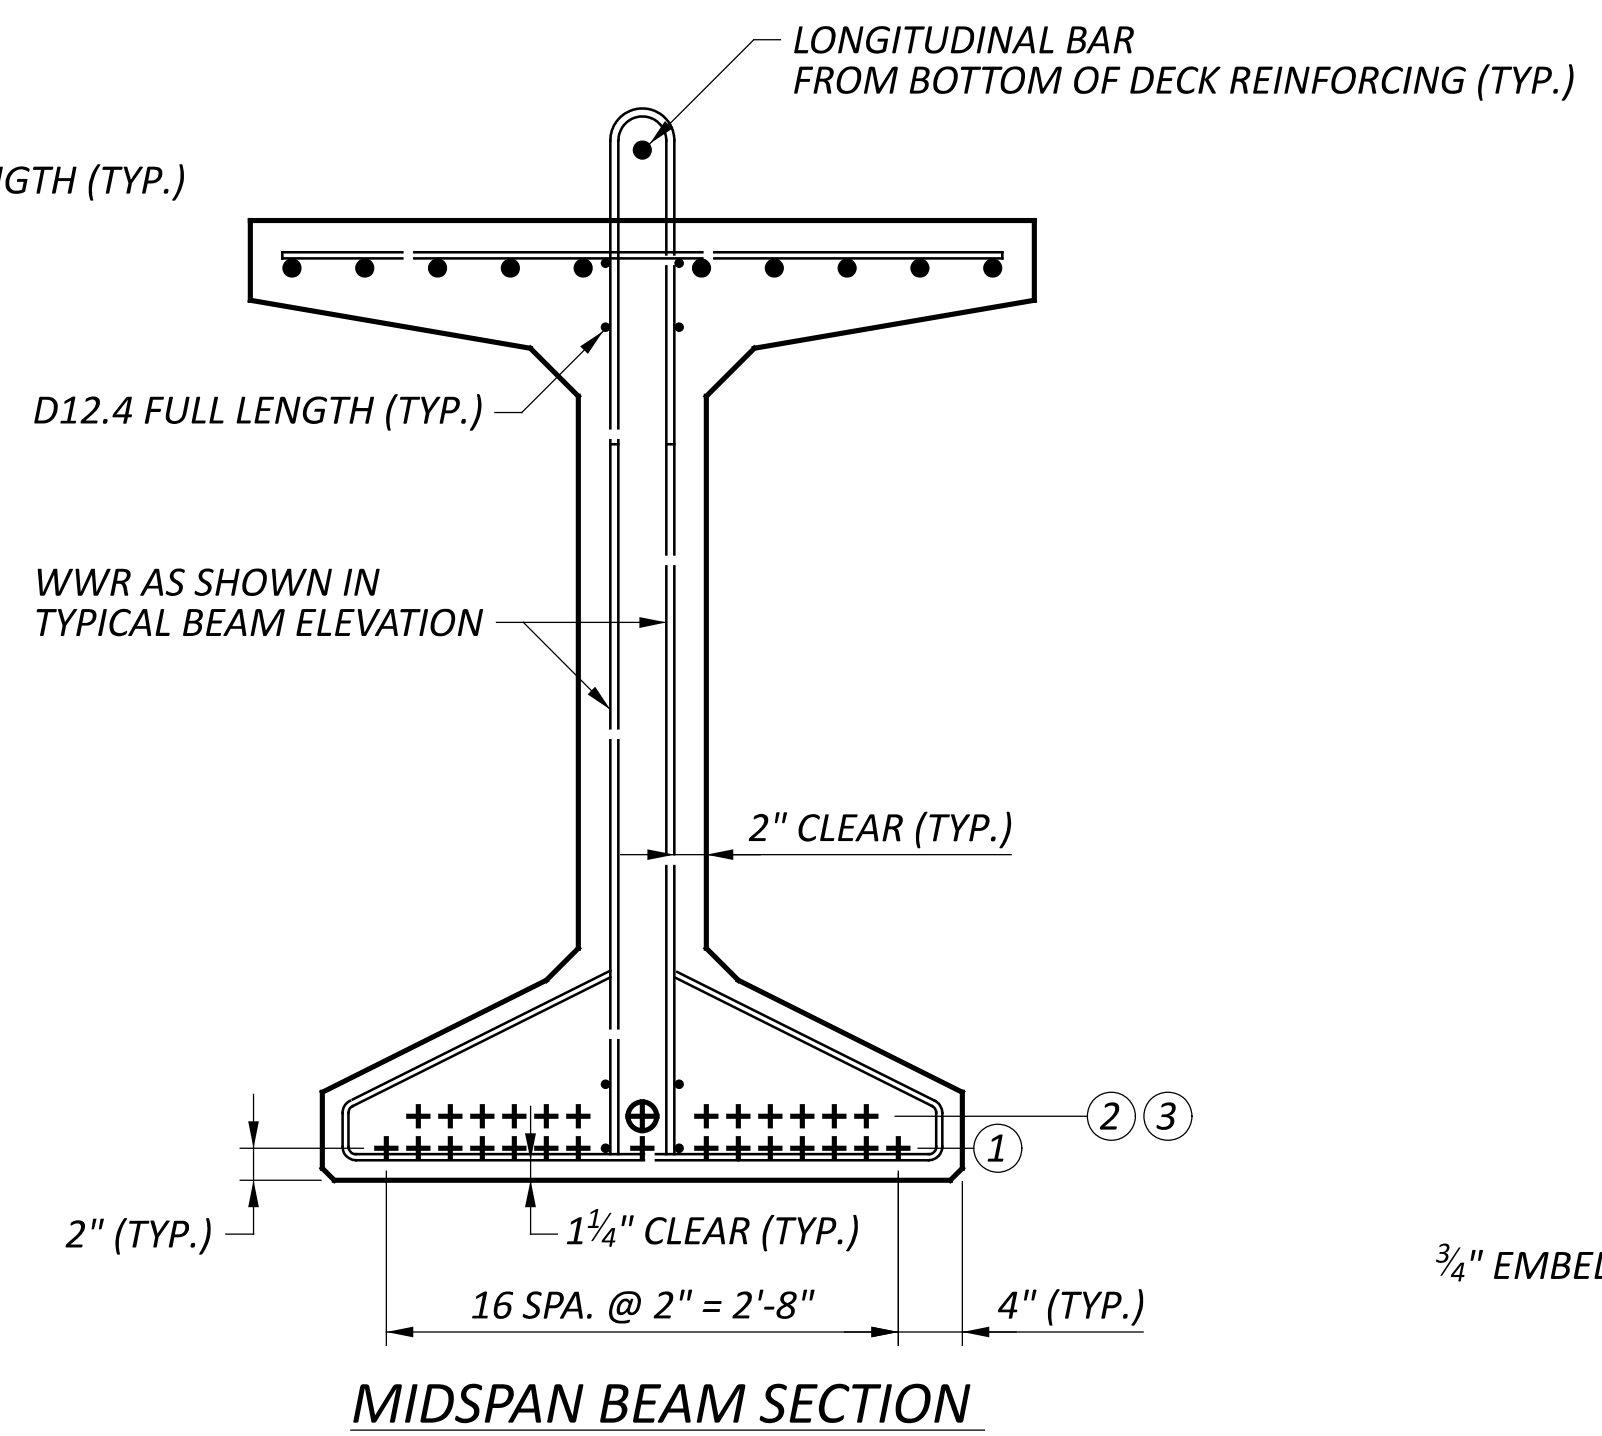

MIDSPAN BEAM SECTION

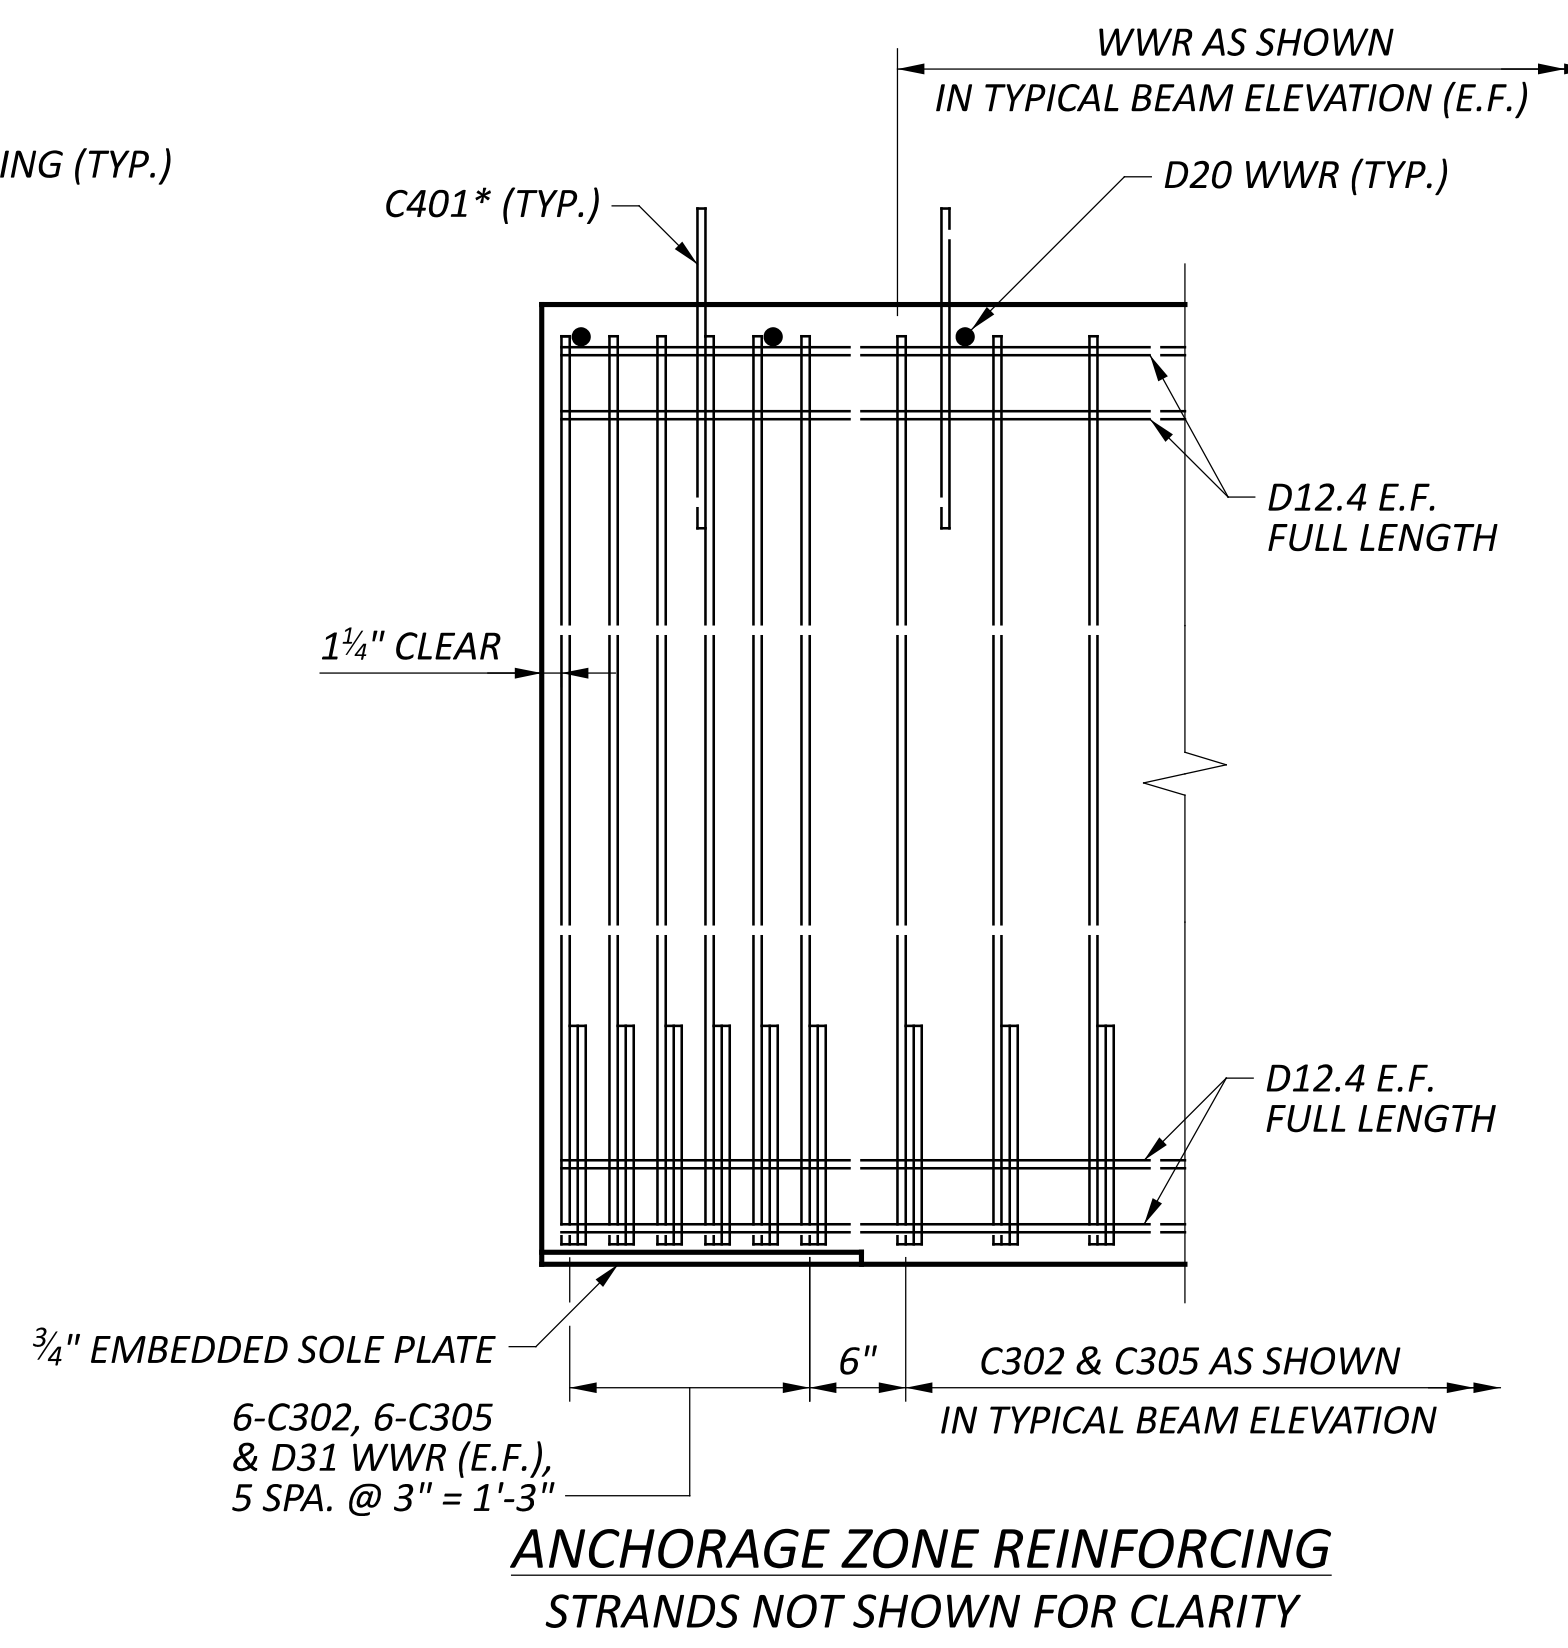

ANCHORAGE ZONE REINFORCING  
 STRANDS NOT SHOWN FOR CLARITY


LEGEND

- ⊕ - DRAPED STRAND
- E.F. - EACH FACE


NOTES

- WWR DENOTES WELDED WIRE REINFORCEMENT.
- REFER TO STD. DWG. PSID-1-13 FOR ADDITIONAL NOTES AND DETAILS.
- STRANDS ARE TO BE LOW-RELAXATION, 0.6 INCH DIAMETER (A = 0.217 SQ. IN.) SEVEN WIRE UNCOATED, ASTM A416, GRADE 270.
- VERTICAL UPLIFT FORCE AT HOLD DOWN POINT = 4.16 K
- APPROXIMATE LOCATIONS OF BOLT HOLES SHOWN FOR STEEL INTERMEDIATE DIAPHRAGMS.
- SHIPPING STRANDS SHALL BE CUT FOLLOWING DELIVERY.

SFN	2926107
DESIGN AGENCY	CARPENTER MARTY
DESIGNER	CHECKER
JZ	AMR
REVIEWER	
GDJ	03/28/25
PROJECT ID	115388
SUBSET	TOTAL
13	27
SHEET	TOTAL
P.59	P.107

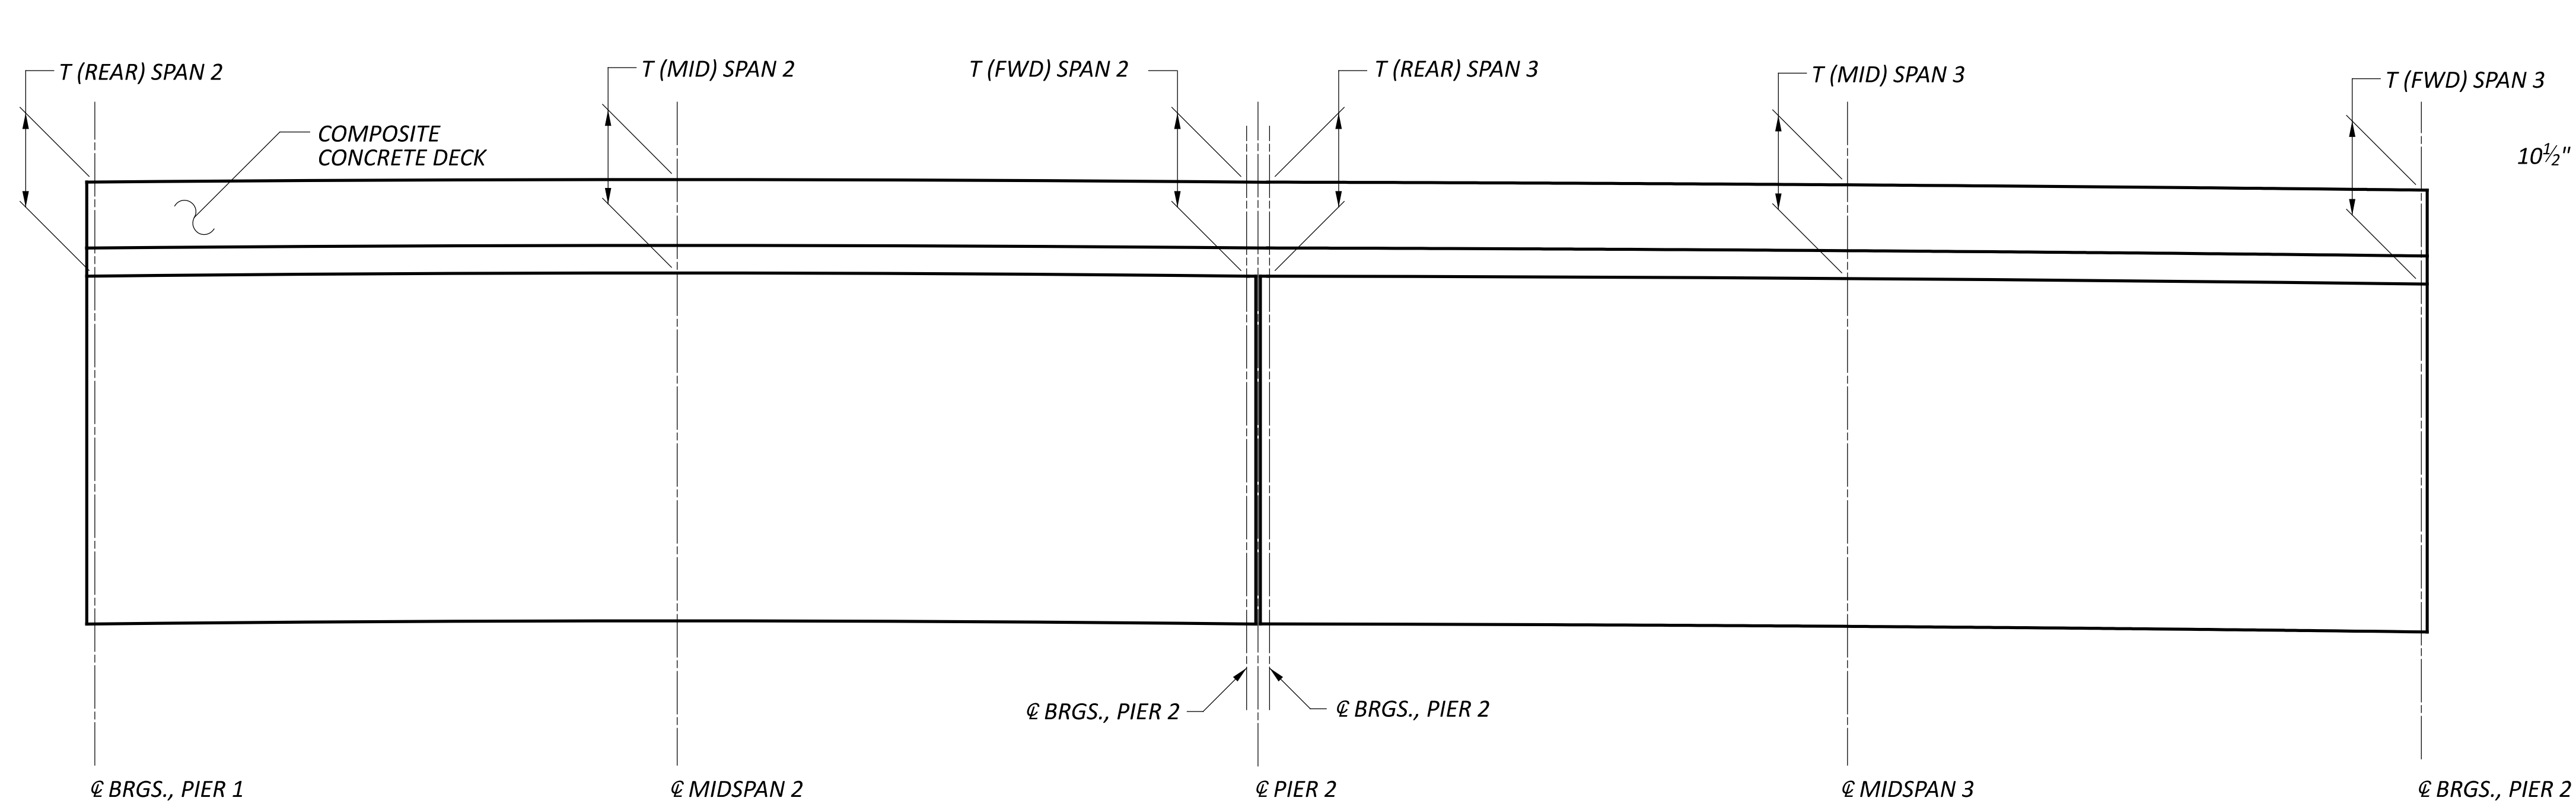

TOPPING DIAGRAM

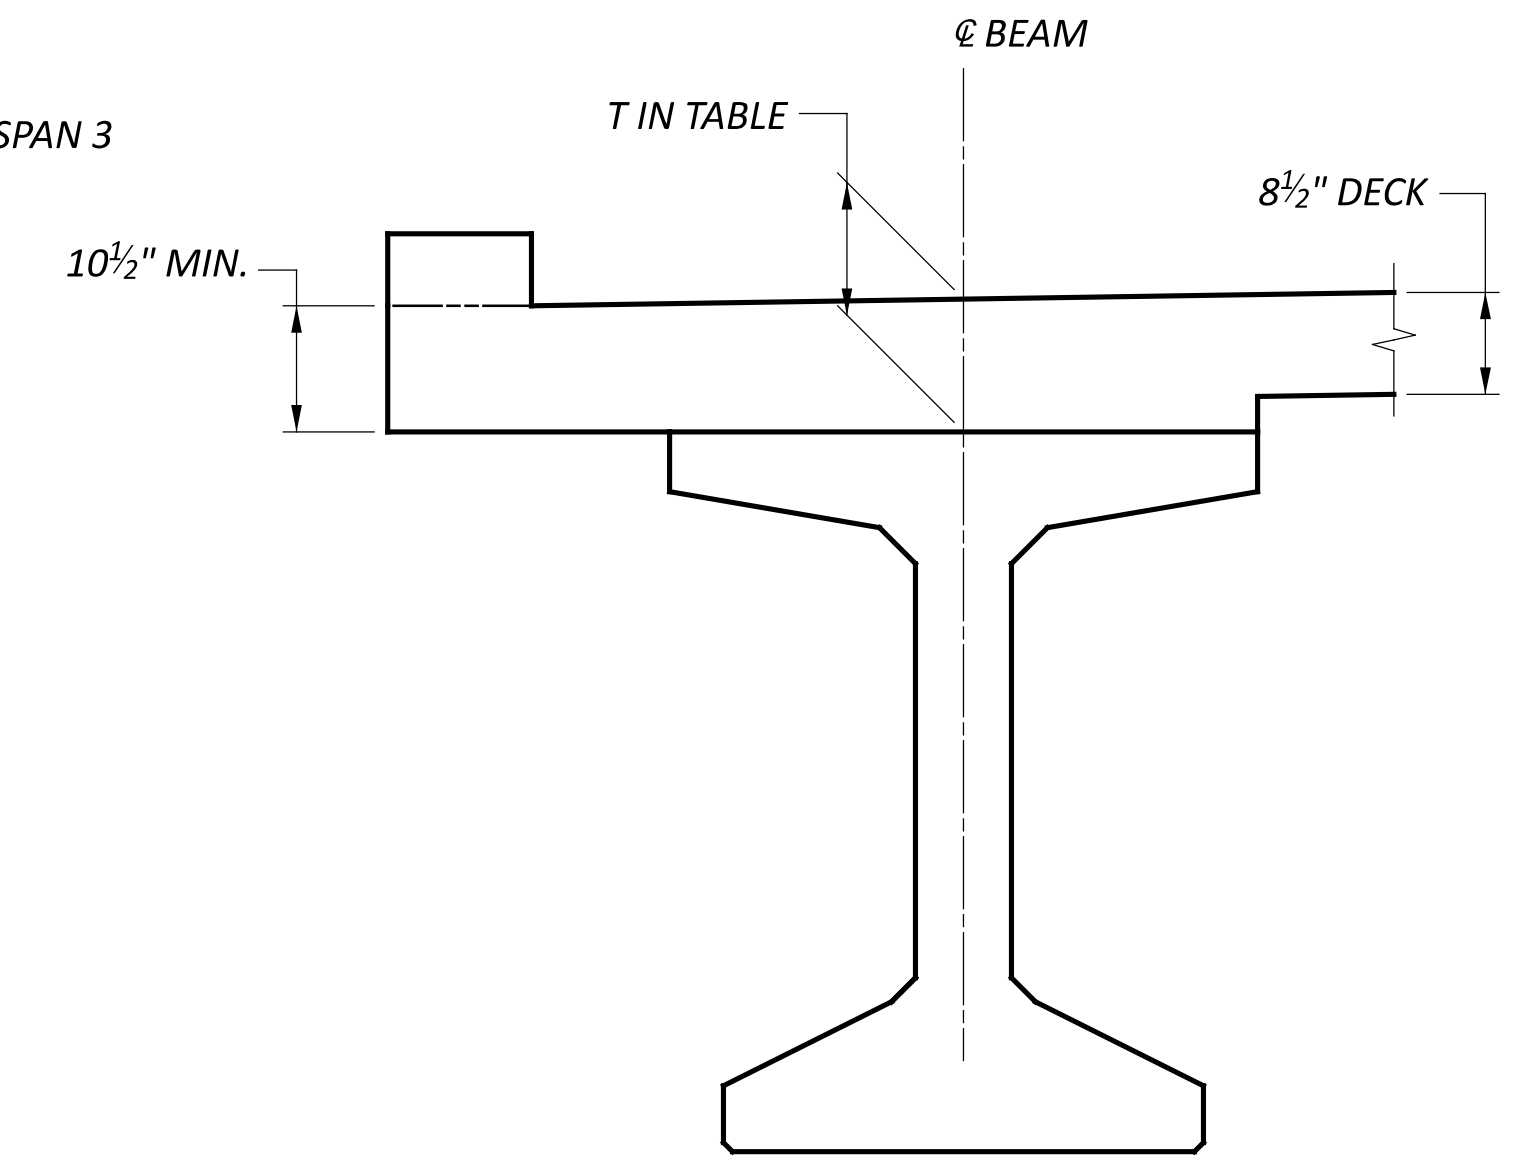

TOPPING THICKNESS DETAIL

TOPPING THICKNESSES (T) AT Ø OF BEAM							
LOCATION	SPAN 2			LOCATION	SPAN 3		
	T (REAR)	T (MID)	T (FWD)		T (REAR)	T (MID)	T (FWD)
BEAM 1	10 3/4"	12 1/4"	12 3/8"	BEAM 3	11 1/8"	10 3/4"	11 1/8"
BEAM 2	10 3/4"	12 1/4"	12 3/8"	BEAM 4	11 1/8"	10 3/4"	11 1/8"

**NOTE**





DECK SLAB THICKNESS FOR CONCRETE QUANTITY: THE ESTIMATED QUANTITY OF DECK CONCRETE IS MEASURED ACCORDING TO C&MS 511. IN ADDITION TO THE DESIGN SLAB THICKNESS, THE QUANTITY INCLUDES A VARIABLE HAUNCH THICKNESS THAT PROVIDES AN ALLOWANCE FOR: VERTICAL GRADE ADJUSTMENT, BEAM CAMBER AND ADDITIONAL SACRIFICIAL HAUNCH THICKNESS.

CAMBER: SPAN 2 & SPAN 3

ESTIMATED CAMBER AT DAY 0 (D0) IS 1 1/4 INCHES.  
 ESTIMATED CAMBER AT DAY 30 (D30) IS 2 INCHES.

DEFLECTION DUE TO REMAINING DEAD LOAD (E.G. CONCRETE DECK, CROSS FRAMES, DIAPHRAGMS, BRIDGE RAILING, ETC) IS 1 3/4 INCHES.

THE BEAM SEAT ELEVATIONS ASSUME ESTIMATED CAMBER D30 WITH A SACRIFICIAL HAUNCH THICKNESS AS SHOWN.

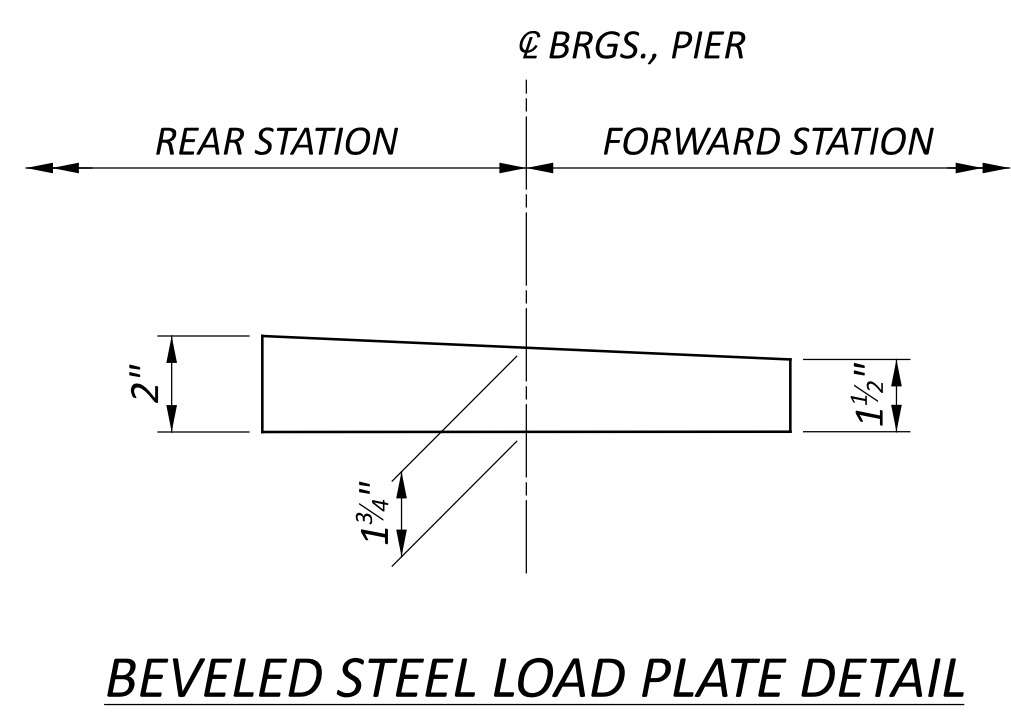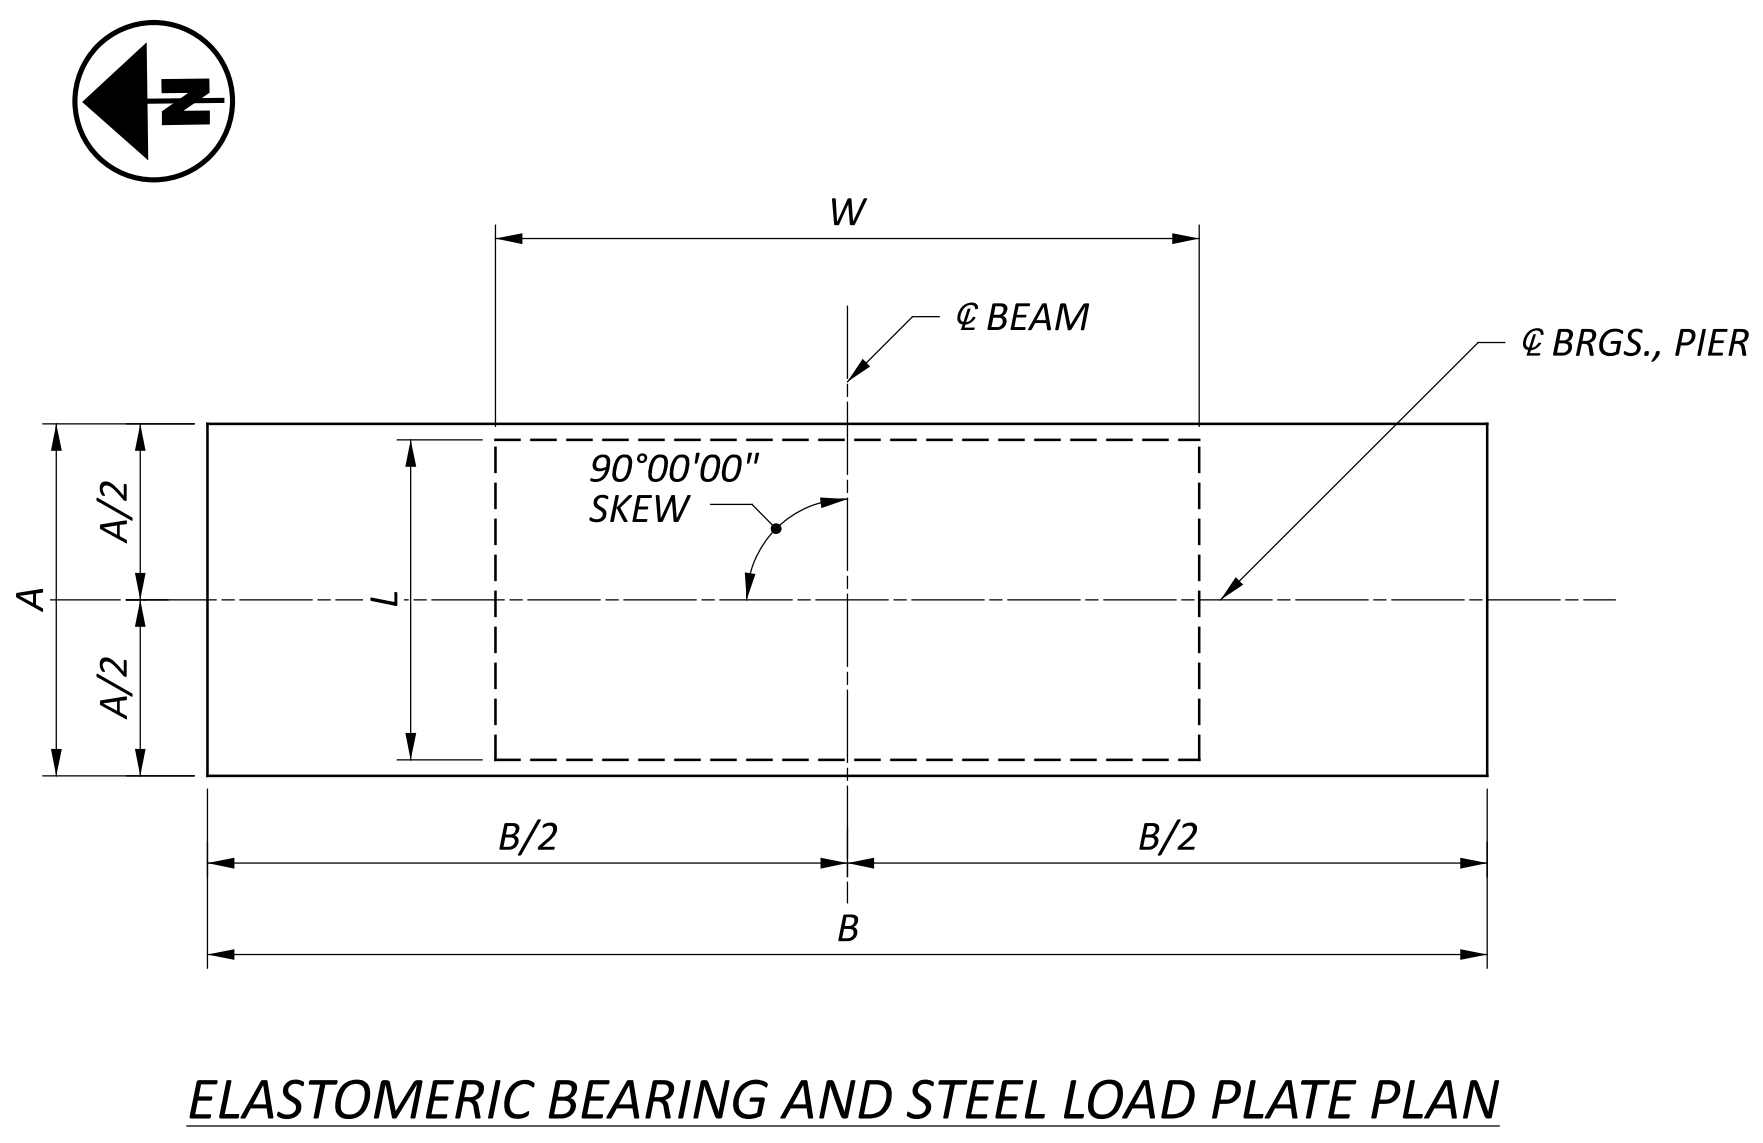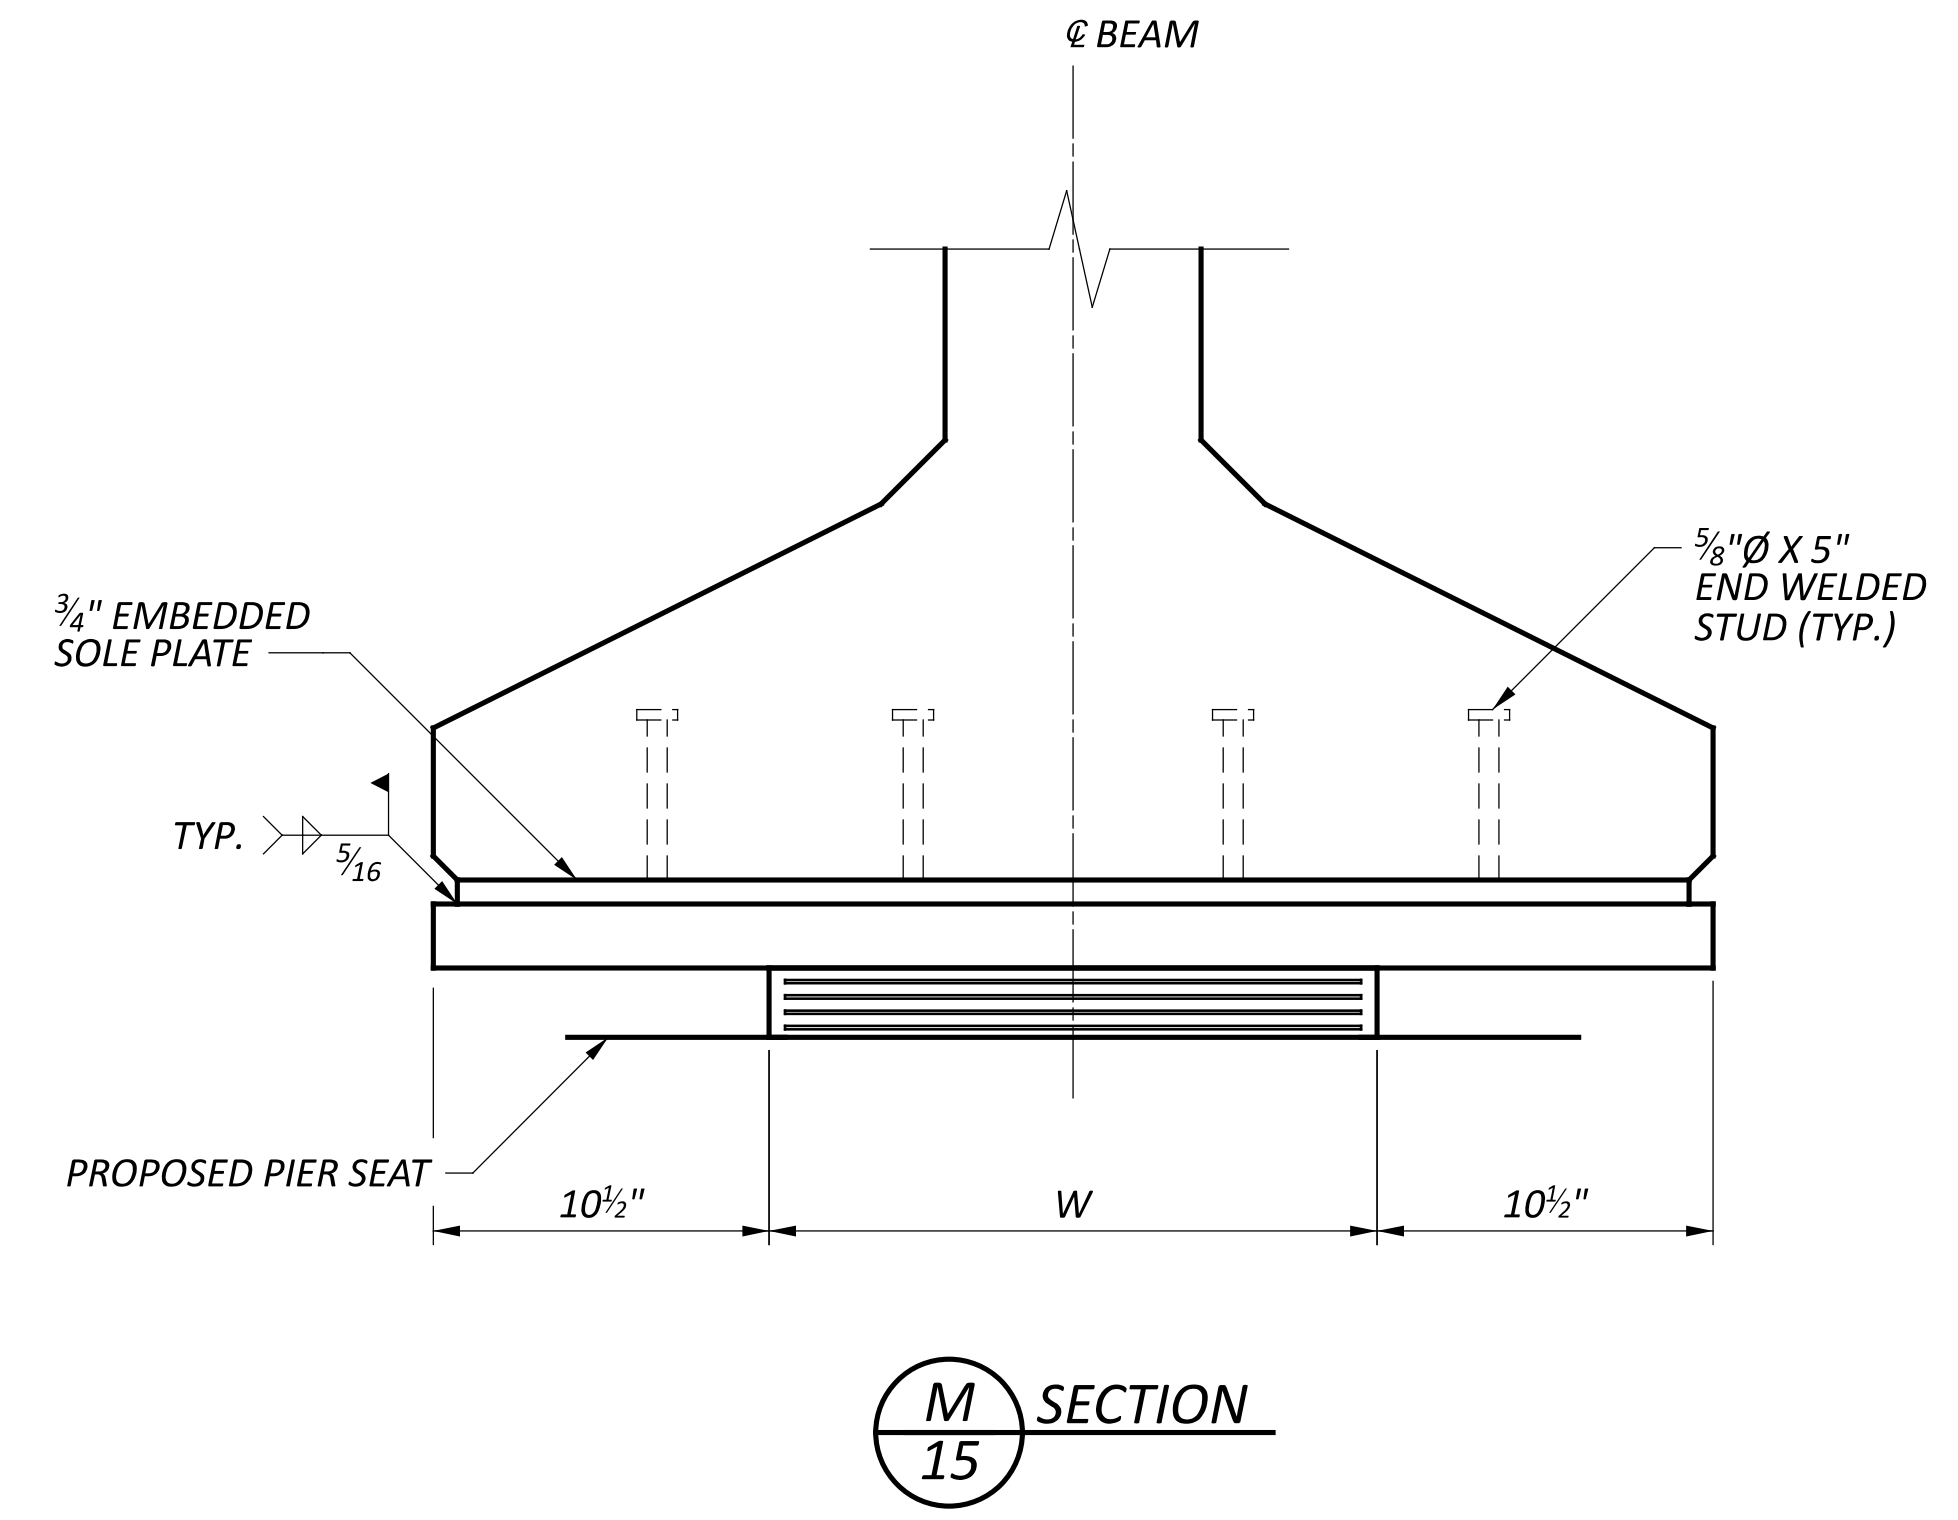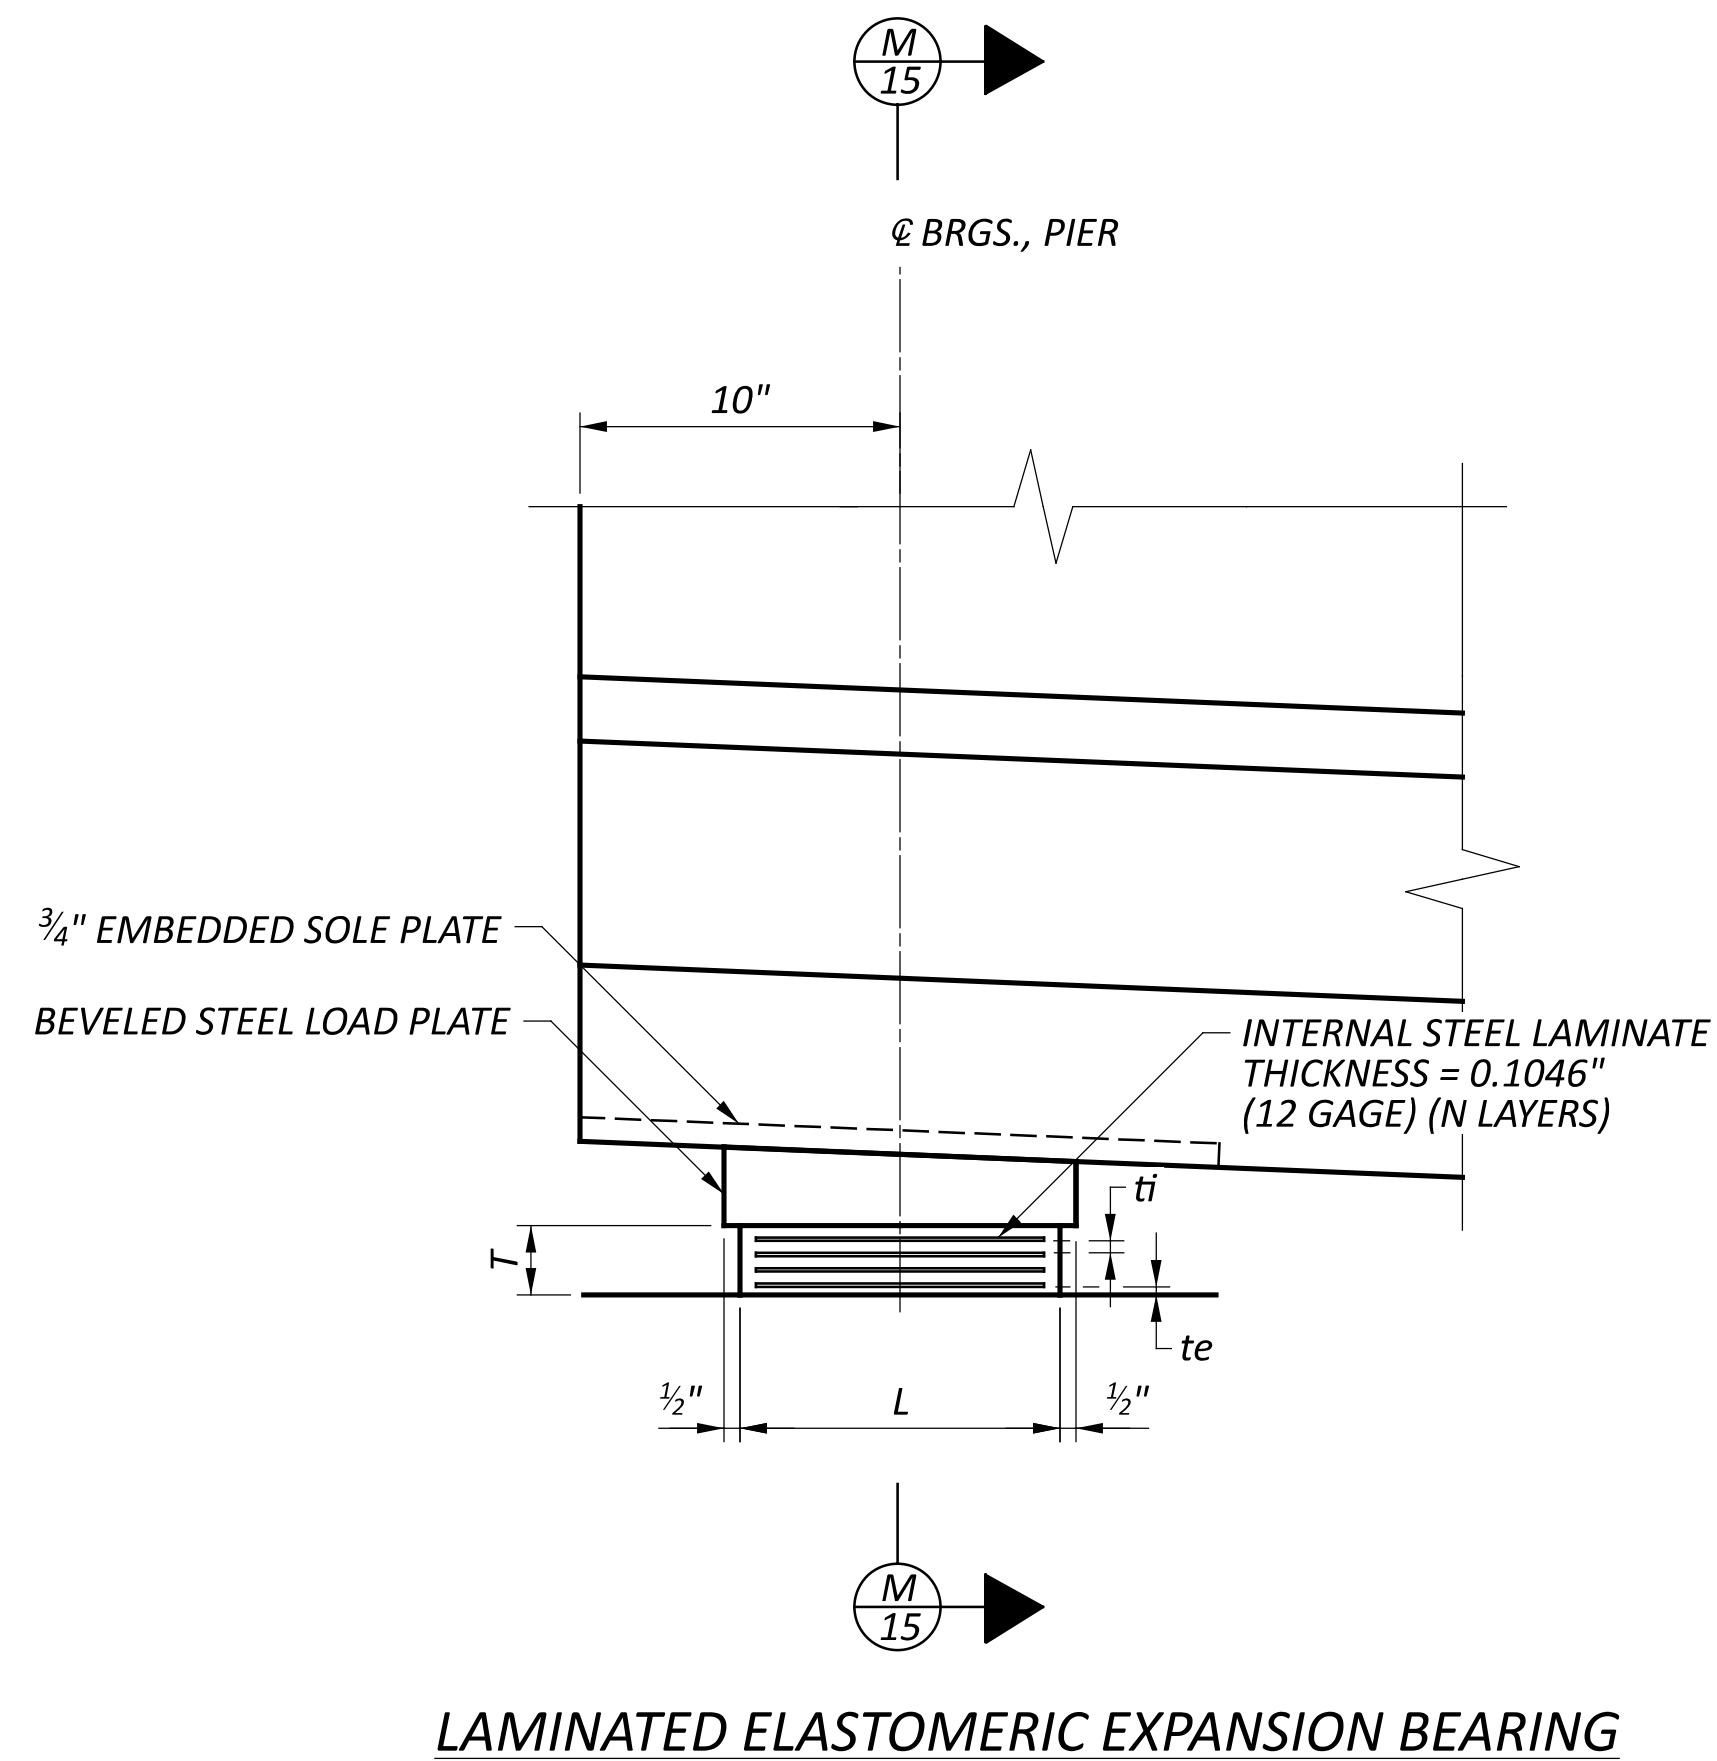

**LEGEND**

- ti = THICKNESS OF INTERNAL LAYERS
- te = THICKNESS OF EXTERNAL LAYER
- T = TOTAL THICKNESS OF ELASTOMERIC BEARINGS
- N = NUMBER OF STEEL LAMINATES & INTERNAL LAYERS

**NOTES**

1. REFER TO STD. DWG. PSID-1-13 FOR ADDITIONAL NOTES AND DETAILS.
2. ELASTOMERIC BEARINGS: THE ELASTOMER SHALL HAVE A HARDNESS OF 50 DUROMETER. THE BEARINGS WERE DESIGNED IN ACCORDANCE WITH SECTION 14.7.6 (METHOD A) OF THE AASHTO LRFD BRIDGE DESIGN SPECIFICATIONS. THE LONG TERM COMPRESSION PROOF LOAD TEST (AASHTO STANDARD SPECIFICATIONS FOR HIGHWAY BRIDGES, DIVISION II, SECTION 18.7.2.6) IS NOT REQUIRED.
3. STEEL LOAD PLATES SHALL BE BONDED BY VULCANIZATION TO THE ELASTOMER DURING THE MOLDING PROCESS. THE STEEL PLATES SHALL BE ASTM A709 GRADE 50.
4. PER C&MS 516.03, GALVANIZE STEEL COMPONENTS OF BEARING ASSEMBLIES.

ELASTOMERIC BEARING											
LOCATION	BEARING DIMENSIONS						STEEL LOAD PLATE		SERVICE REACTIONS		MAXIMUM TOTAL LOAD
	L	W	ti	te	T	N	A	B	DL	LL	
ALL PIERS	10"	19"	0.375"	0.25"	2.168"	4	11"	40"	146 K	39 K	185 K

SFN 2926107

DESIGN AGENCY

DESIGNER: JZ CHECKER: AMR



REVIEWER: GDJ 03/28/25

PROJECT ID: 115388


SUBSET: 15 TOTAL: 27

SHEET: P.61 TOTAL: P.107



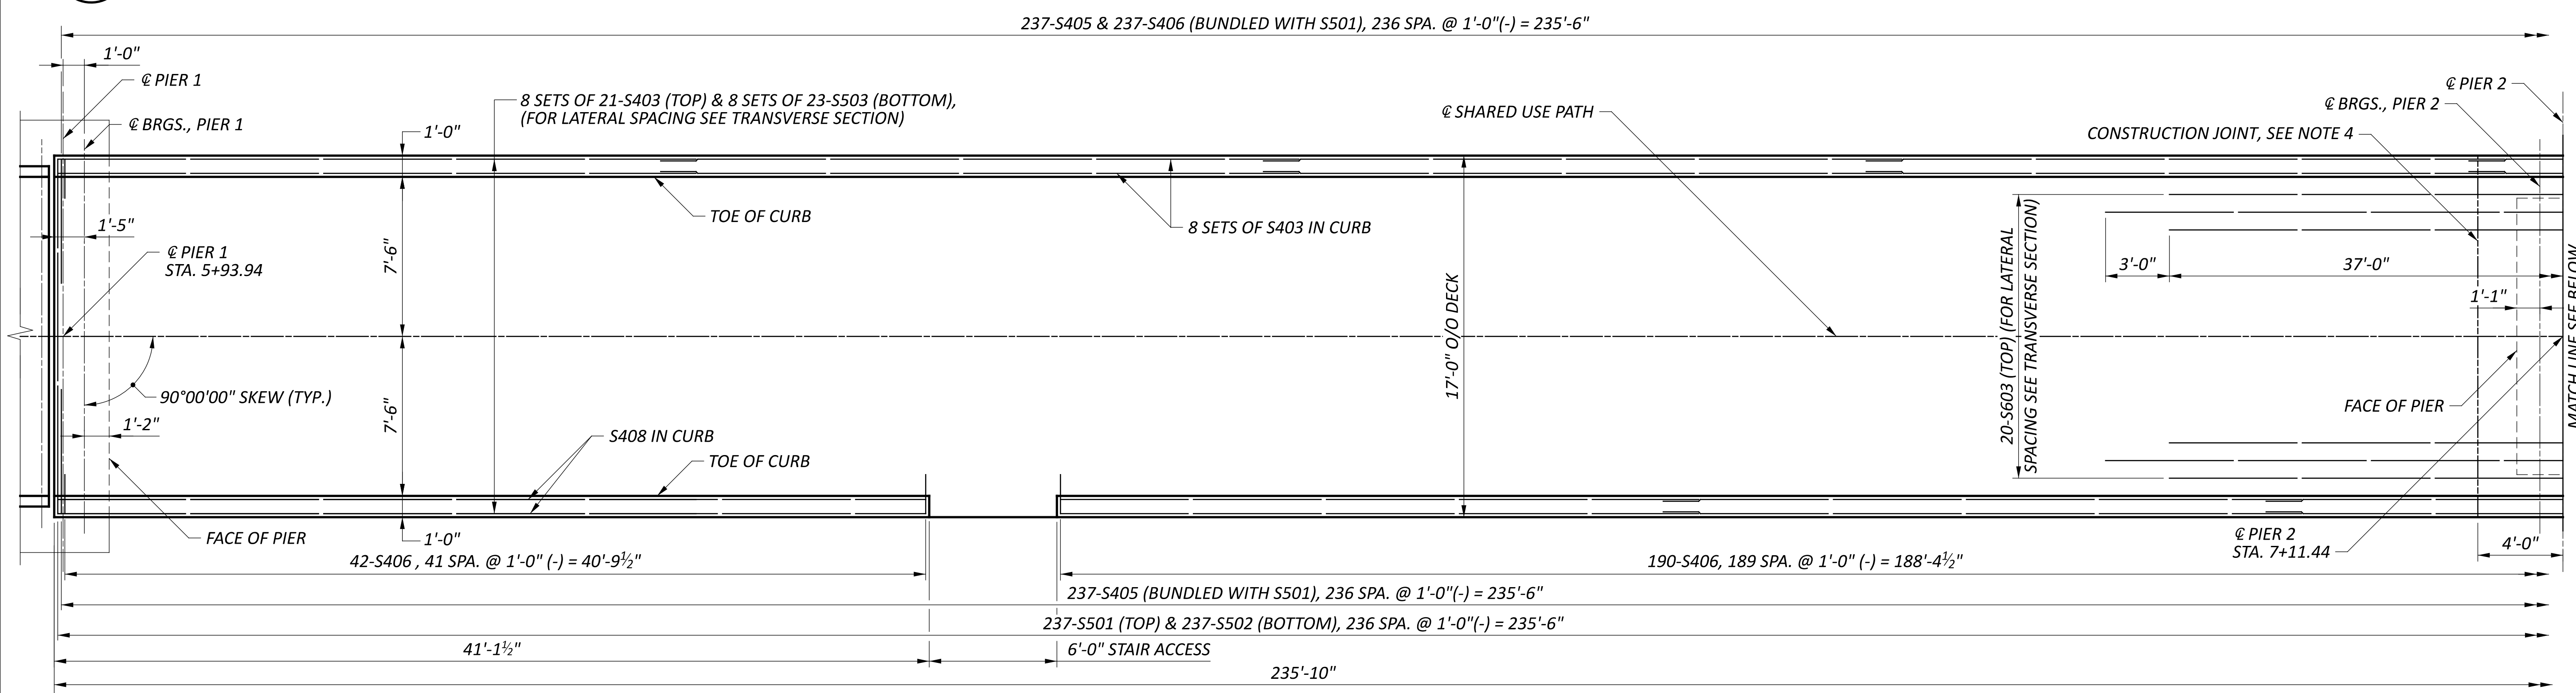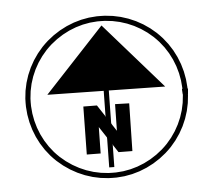

DECK PLAN - SPAN 2

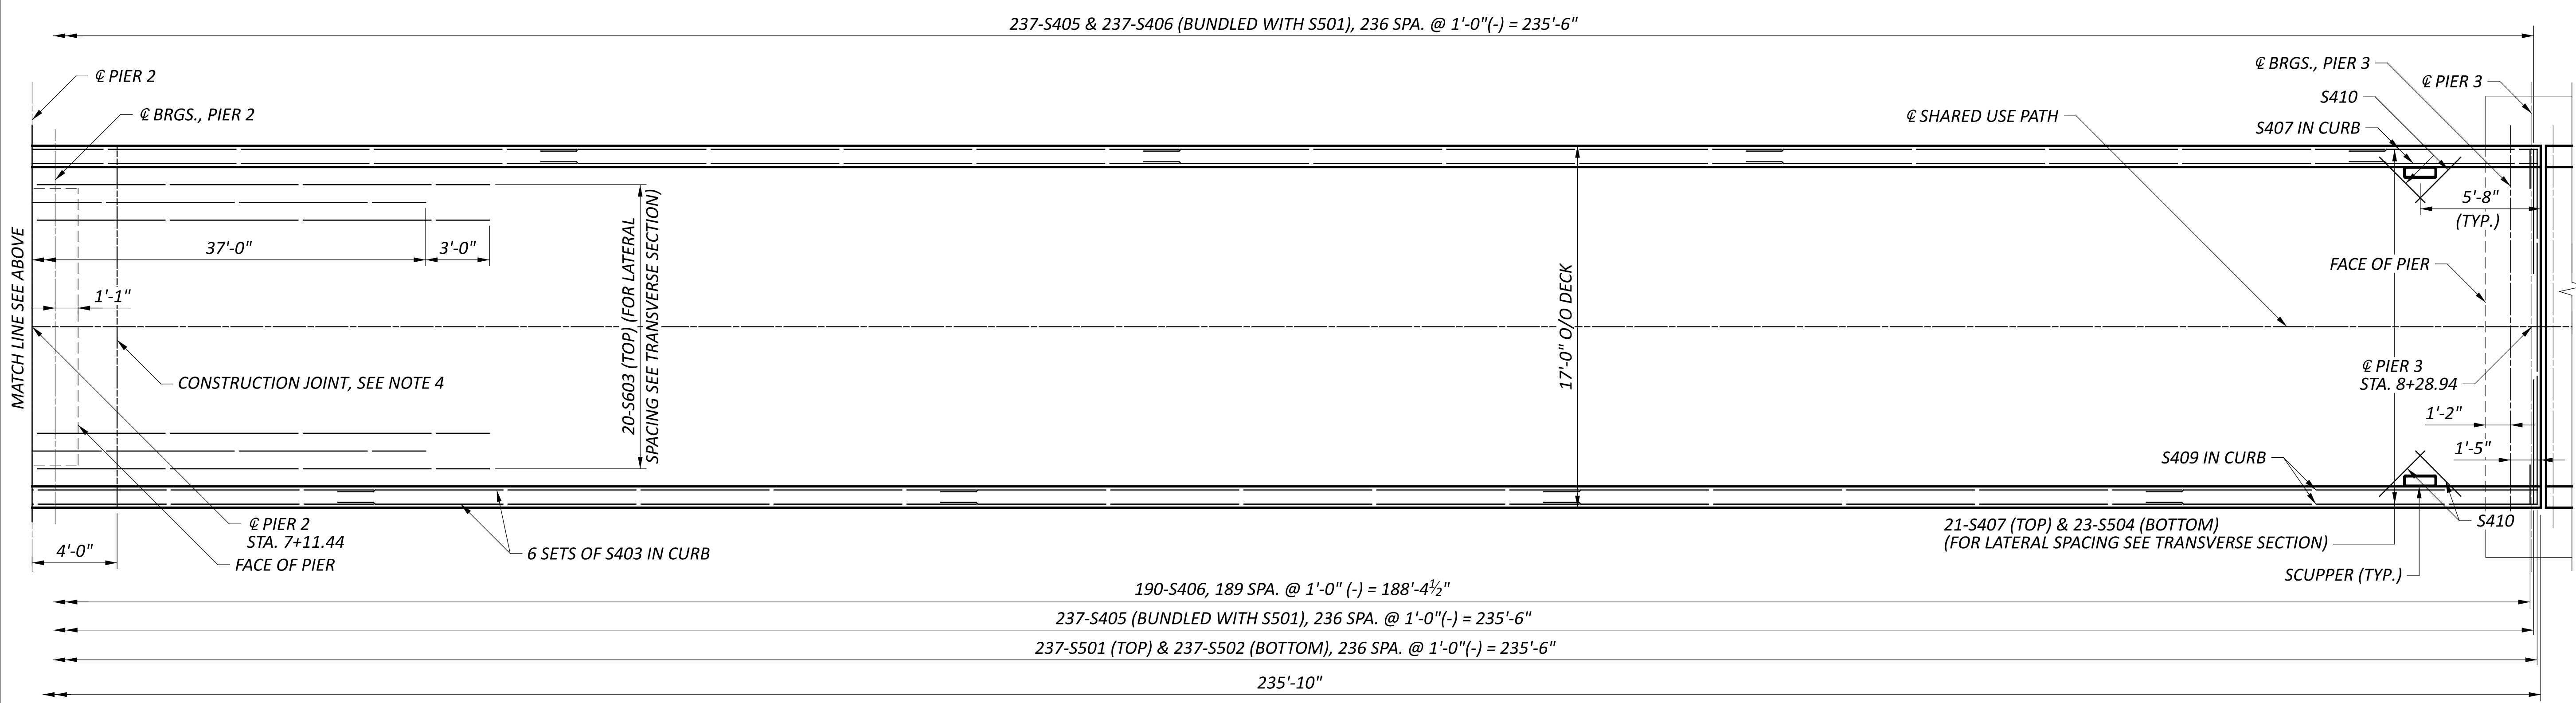

DECK PLAN - SPAN 3

- NOTES**
1. MINIMUM LAP SPLICE LENGTHS:  
 #4 BARS = 20 INCHES  
 #5 BARS = 24 INCHES
  2. REFER TO SHEET 22/27 FOR TRANSVERSE SECTION
  3. REFER TO SHEET 2/27 FOR DECK POUR SEQUENCE
  4. SEAL JOINT WITH 2'-0" WIDE HMWM


MATCH LINE SEE BELOW

SFN 2926107	
DESIGN AGENCY	
DESIGNER	CHECKER
SMH	AMR
REVIEWER	
GDJ 03/28/25	
PROJECT ID	
115388	
SUBSET	TOTAL
17	27
SHEET	TOTAL
P.63	P.107


DECK PLAN - SPANS 2 AND 3  
 BRIDGE NO. GRE-BK80020-00.492  
 PEDESTRIAN BRIDGE OVER US 68 AND OLD TOWN CREEK

**NOTES**

1. MINIMUM LAP SPLICE LENGTHS:  
 #4 BARS = 20 INCHES  
 #6 BARS = 29 INCHES
2. REFER TO SHEET 23/27 FOR TRANSVERSE SECTION.

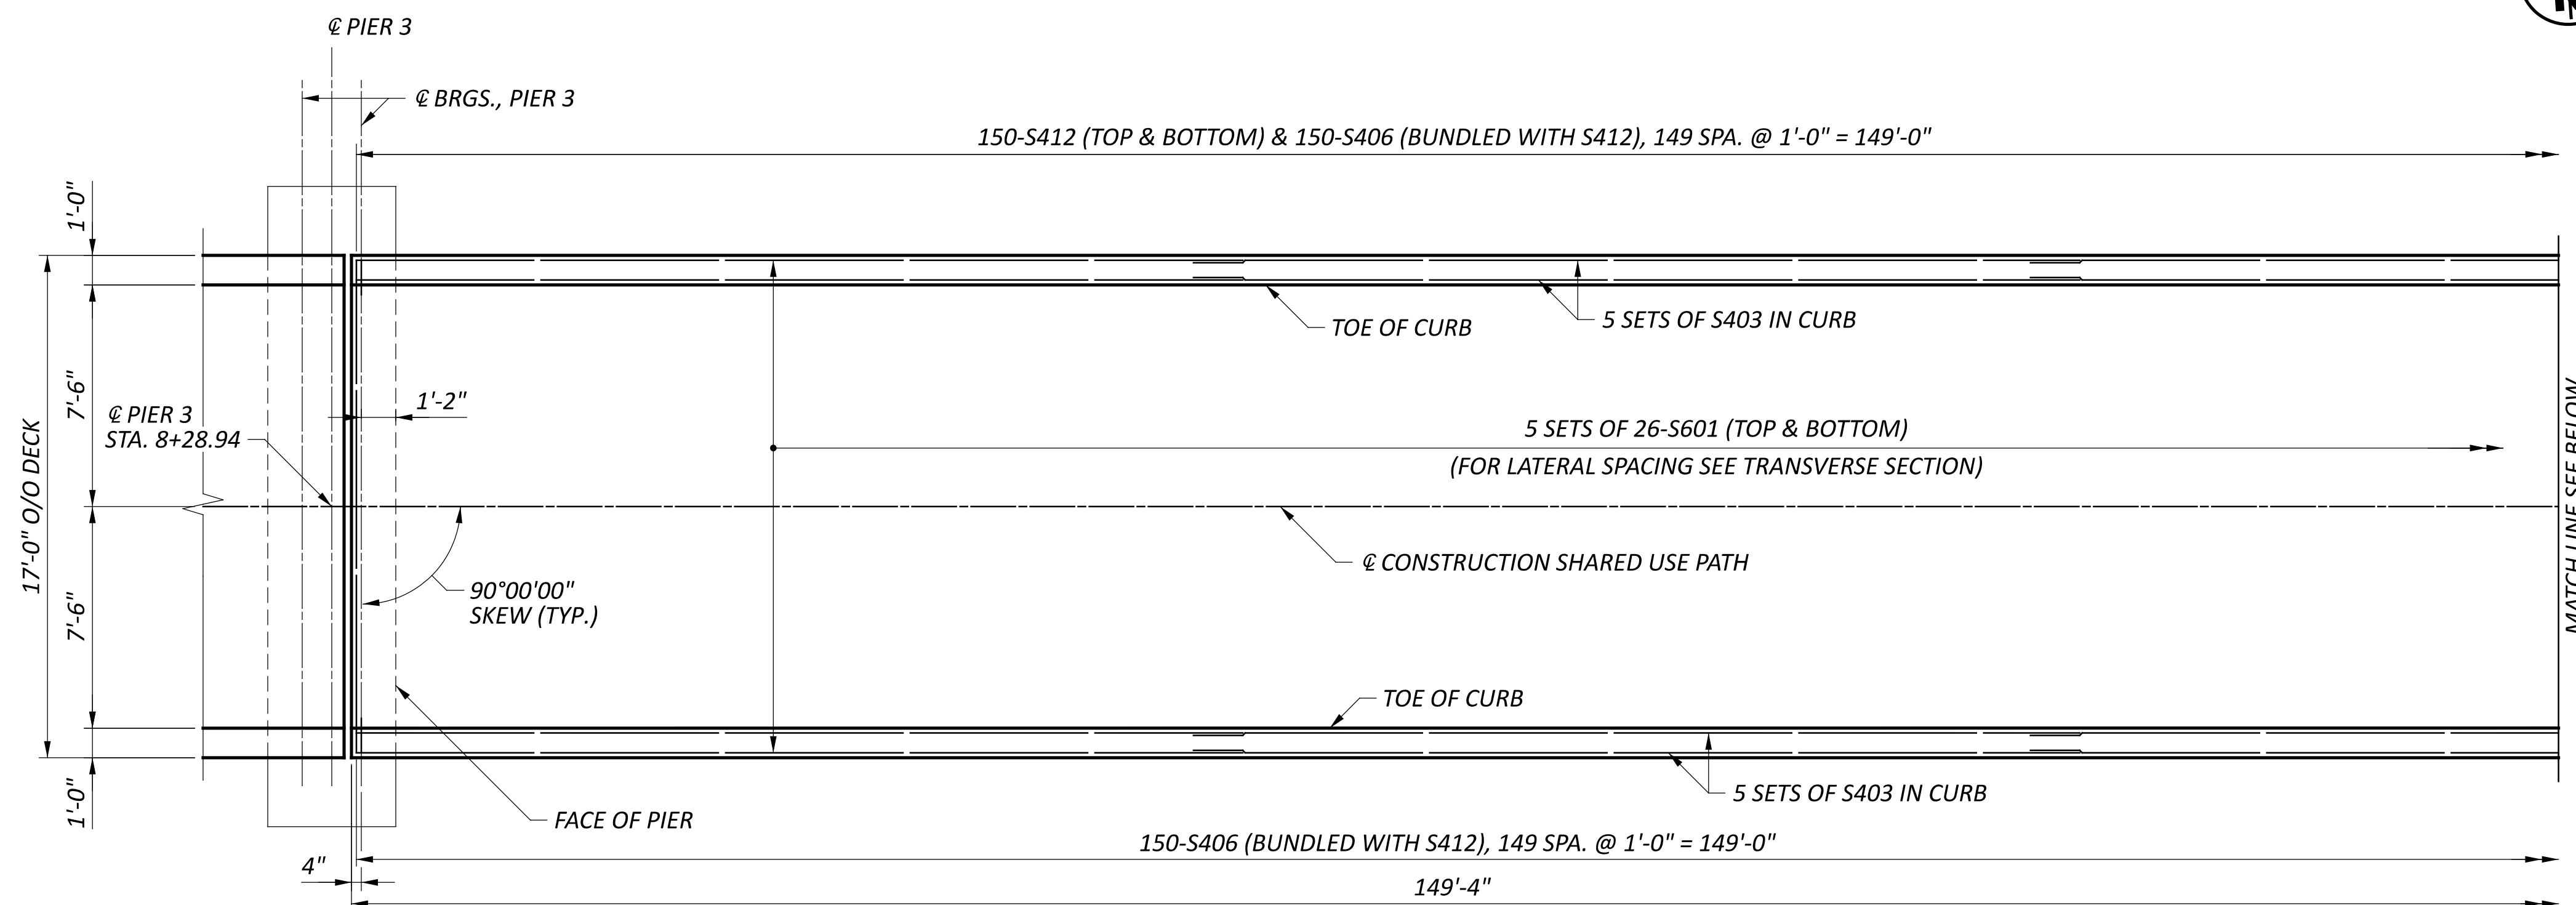

PARTIAL DECK PLAN - SPAN 4

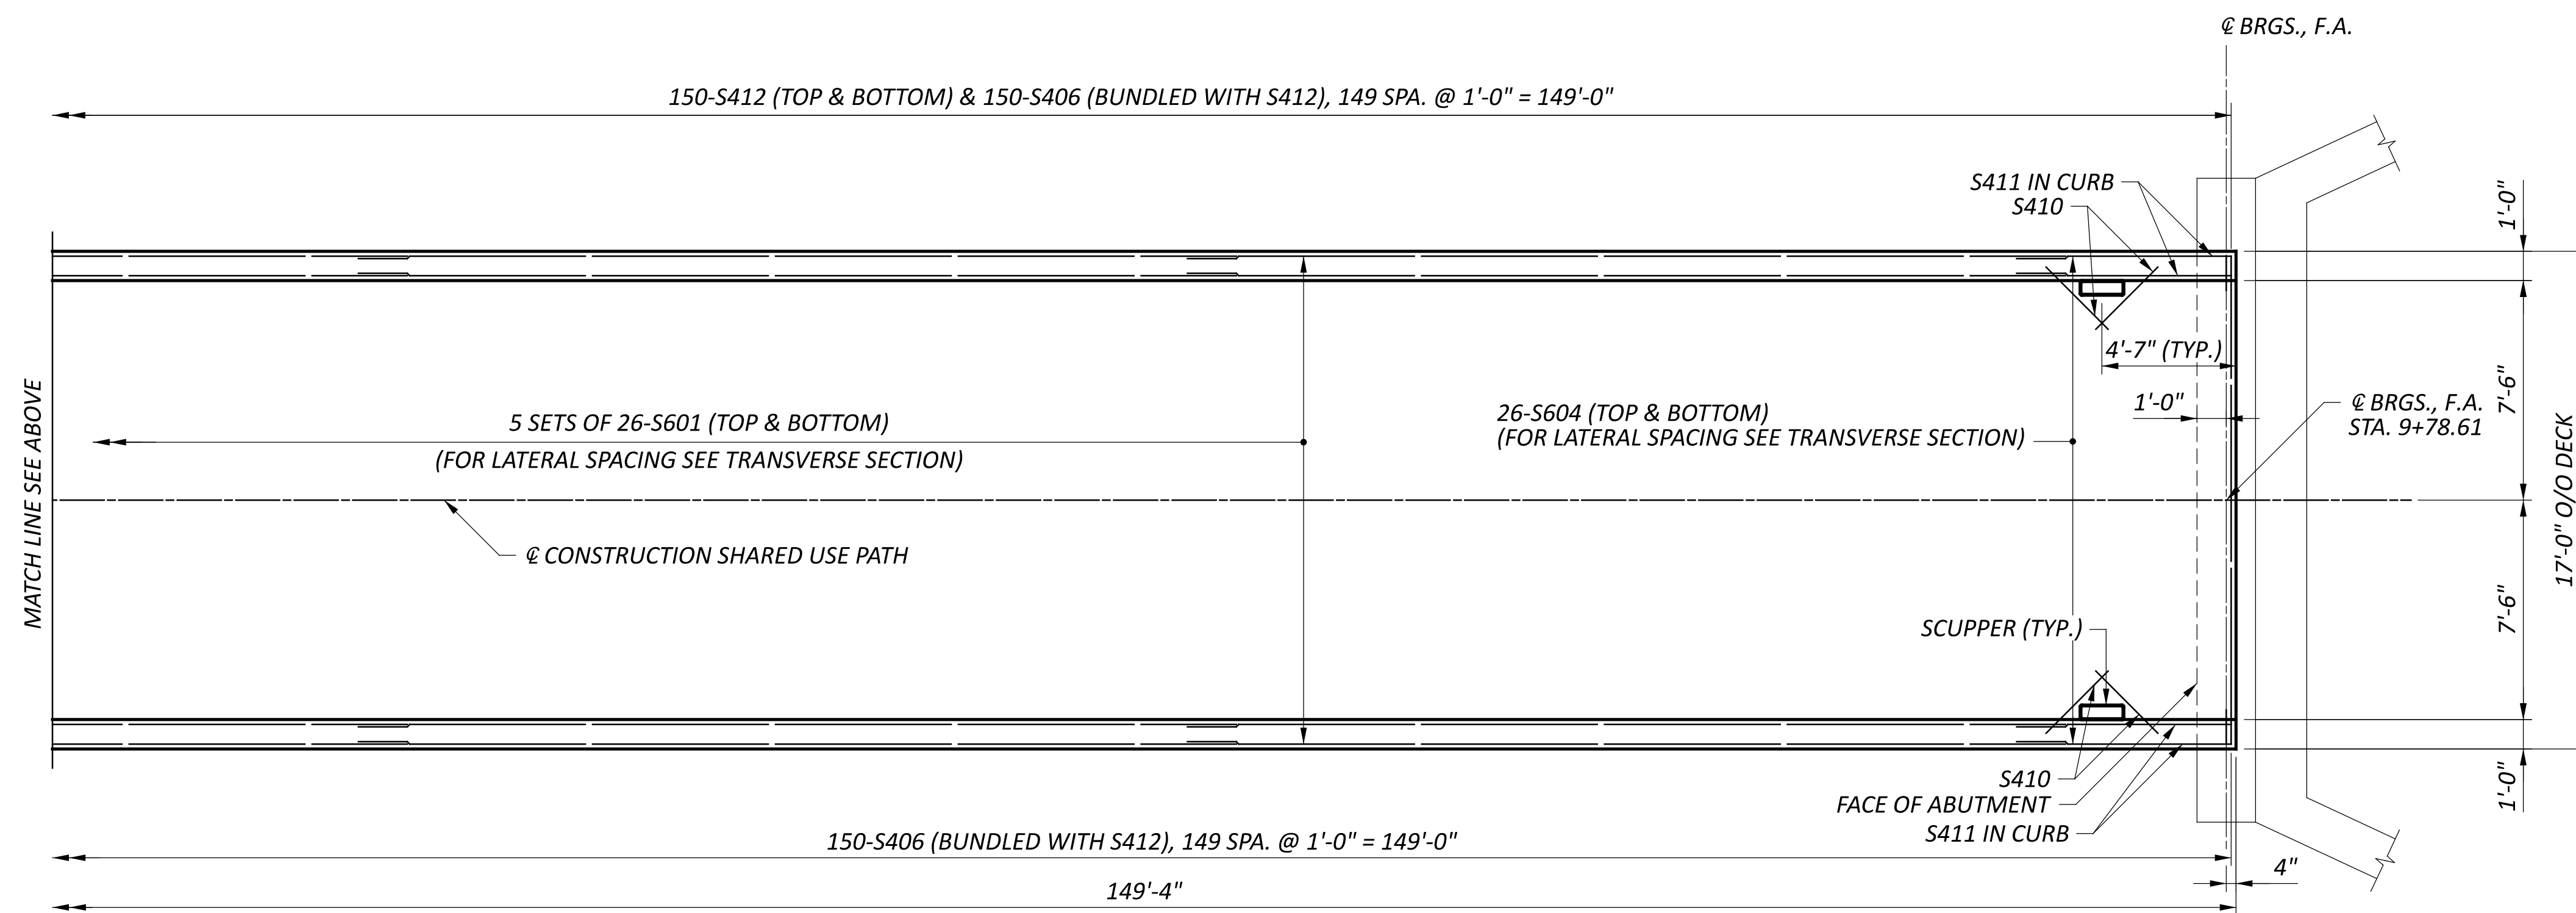





PARTIAL DECK PLAN - SPAN 4



SFN 2926107	
DESIGN AGENCY	
DESIGNER	CHECKER
JZ	AMR
REVIEWER	
GDJ 03/28/25	
PROJECT ID	
115388	
SUBSET	TOTAL
18	27
SHEET	TOTAL
P.64	P.107



FINAL DECK SURFACE ELEVATIONS TABLE (FT.) (SPAN 1 & SPAN 4)															
LOCATION		A	1/4	1/2	3/4	B	G	5/8	1/2	3/8	1/2	5/8	3/4	7/8	H
LEFT TOE OF CURB	STATION	4+98.27	5+21.94	5+45.61	5+69.27	5+92.94	8+29.94	8+48.52	8+67.11	8+85.69	9+04.27	9+22.86	9+41.44	9+60.02	9+78.61
	FINAL ELEVATION	854.66	855.09	855.17	854.89	854.26	842.70	841.78	840.86	839.93	839.01	838.09	837.17	836.25	835.33
@ CONSTRUCTION SHARED USE PATH, CROWN, & PROFILE GRADE	STATION	4+98.27	5+21.94	5+45.61	5+69.27	5+92.94	8+29.94	8+48.52	8+67.11	8+85.69	9+04.27	9+22.86	9+41.44	9+60.02	9+78.61
	FINAL ELEVATION	854.73	855.16	855.24	854.97	854.34	842.78	841.85	840.93	840.01	839.09	838.17	837.24	836.32	835.40
RIGHT TOE OF CURB	STATION	4+98.27	5+21.94	5+45.61	5+69.27	5+92.94	8+29.94	8+48.52	8+67.11	8+85.69	9+04.27	9+22.86	9+41.44	9+60.02	9+78.61
	FINAL ELEVATION	854.66	855.09	855.17	854.89	854.26	842.70	841.78	840.86	839.93	839.01	838.09	837.17	836.25	835.33

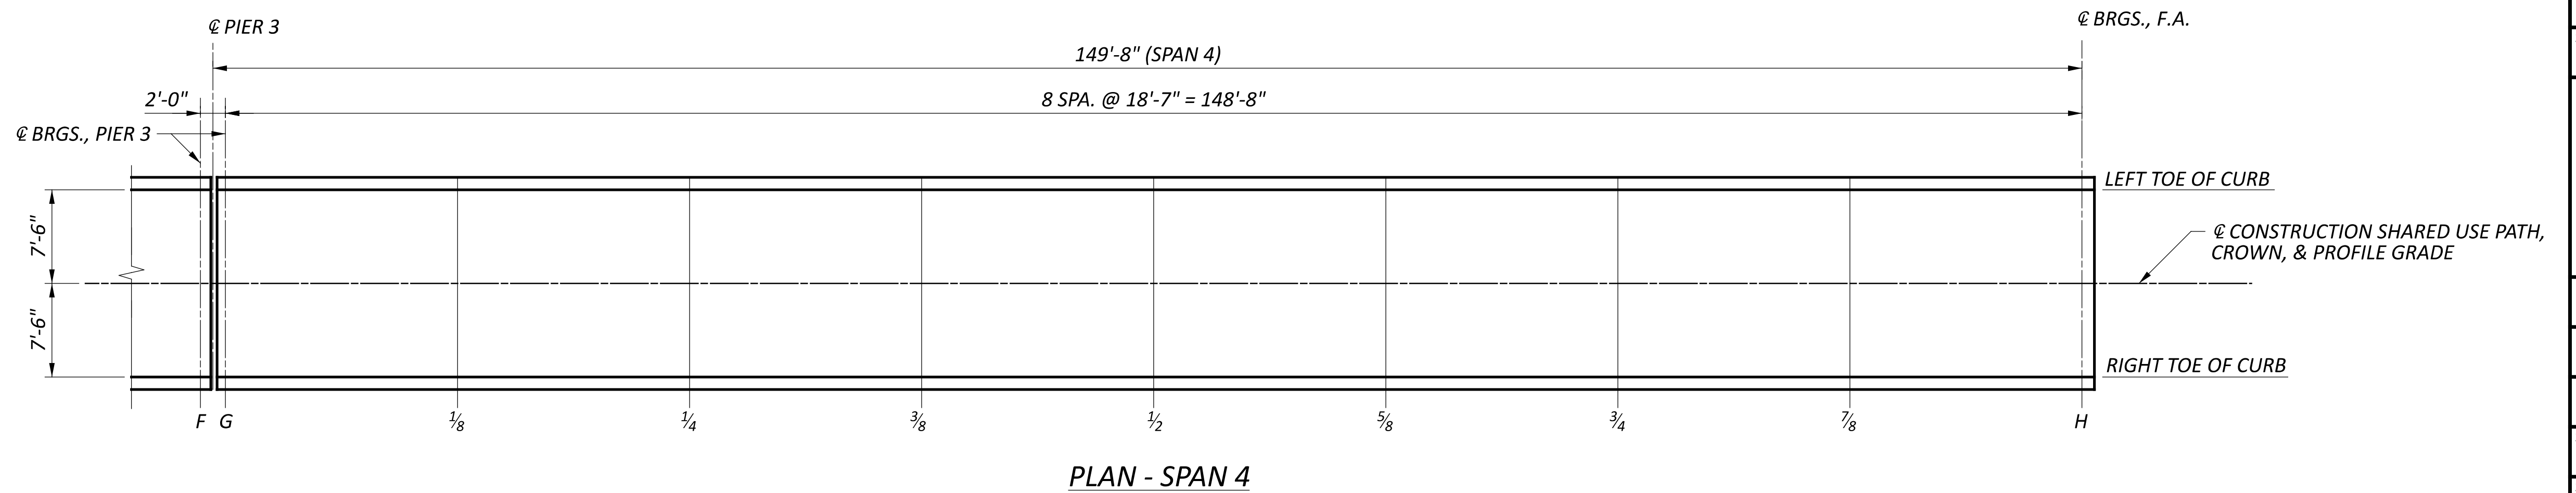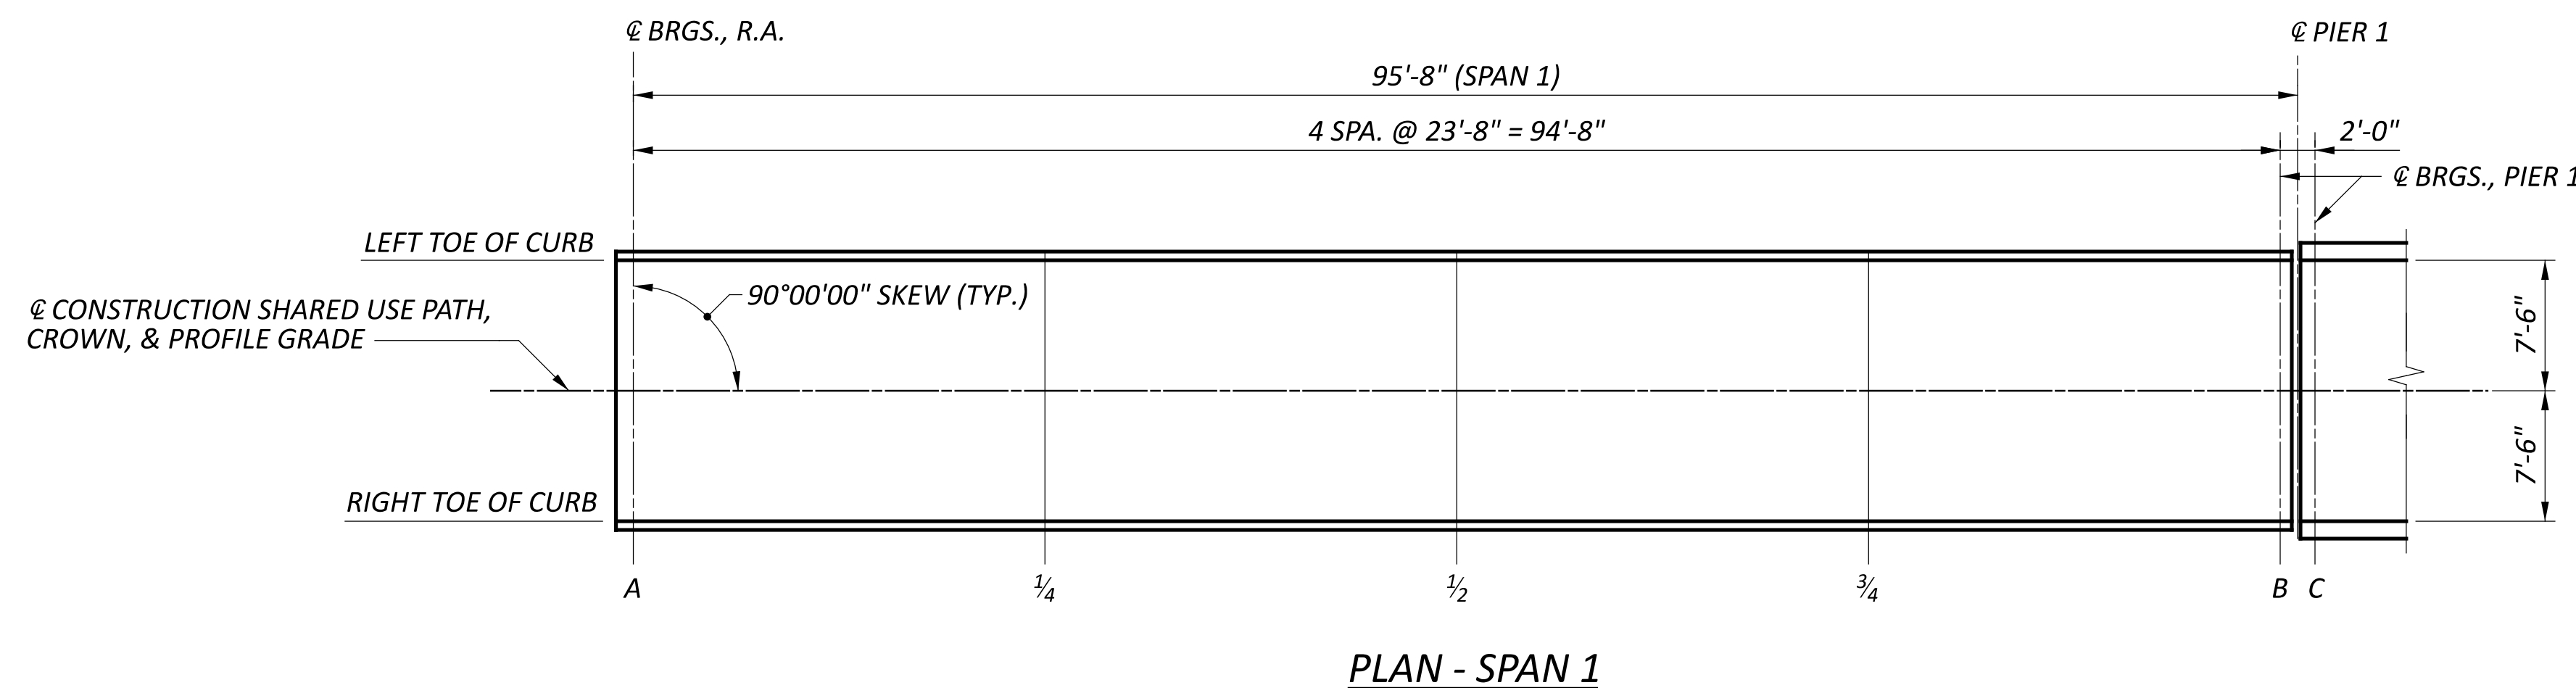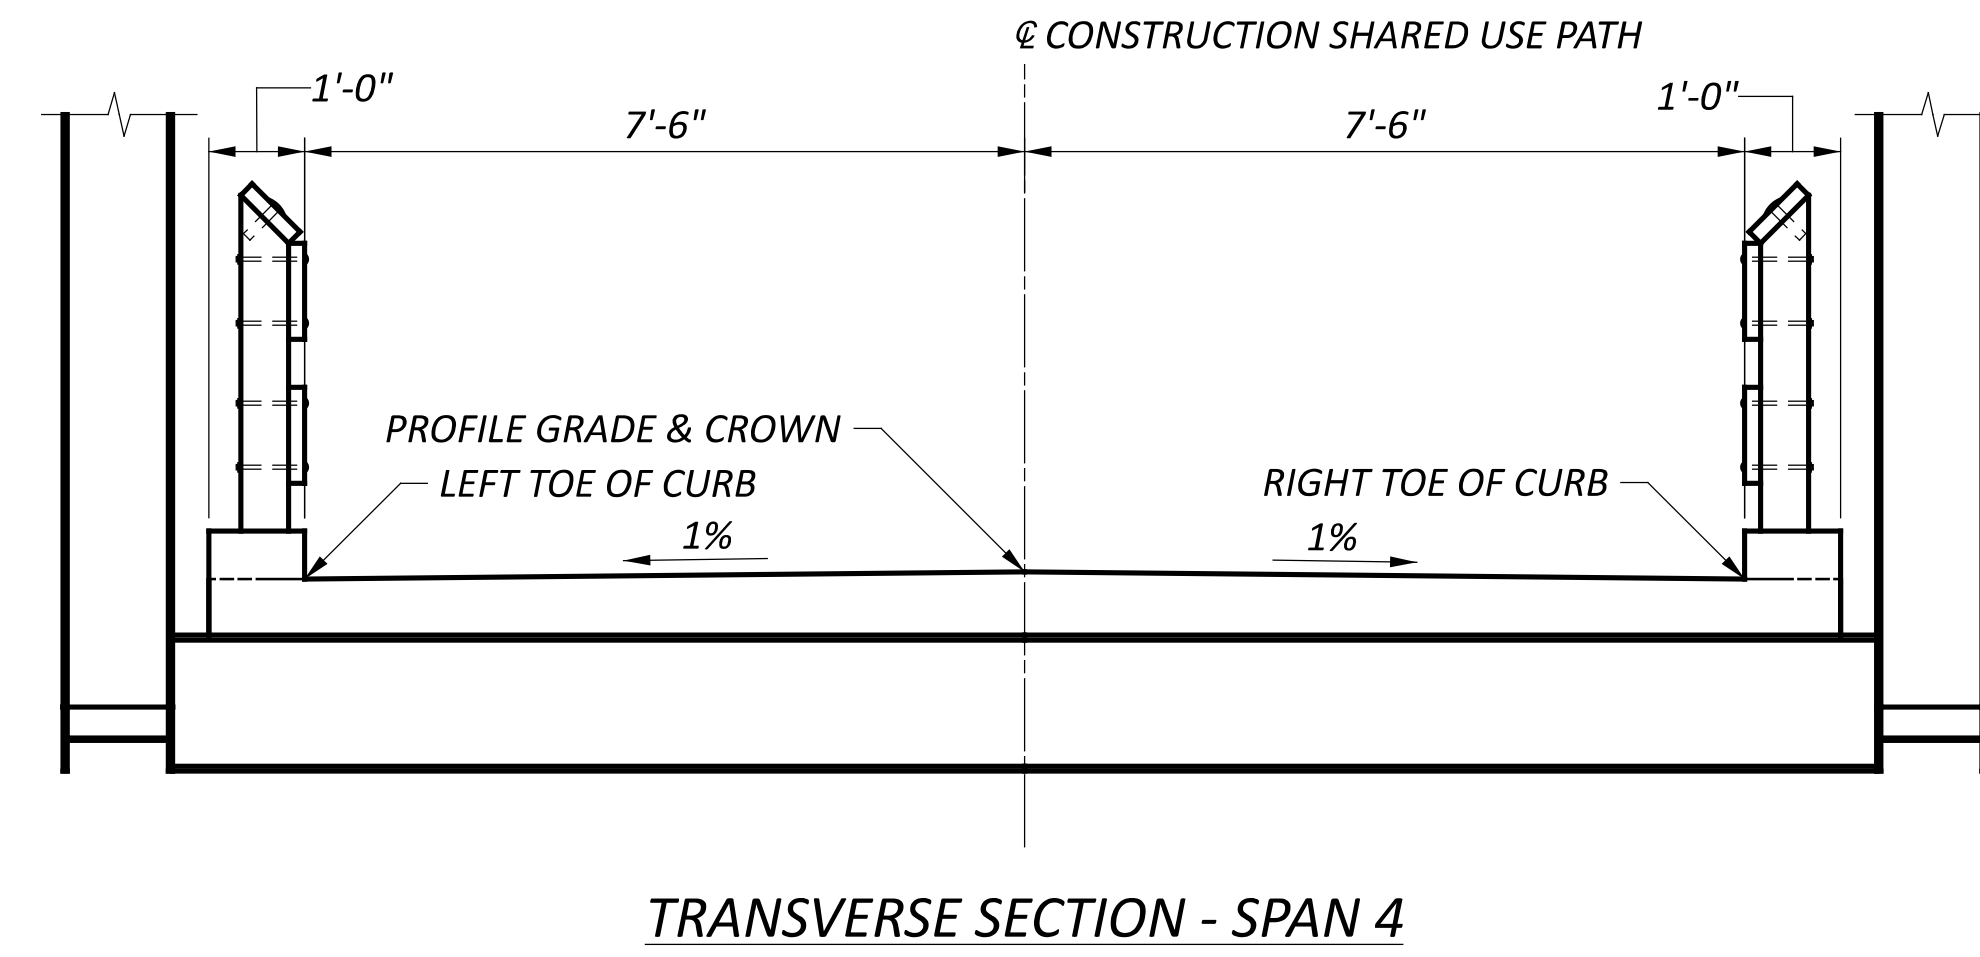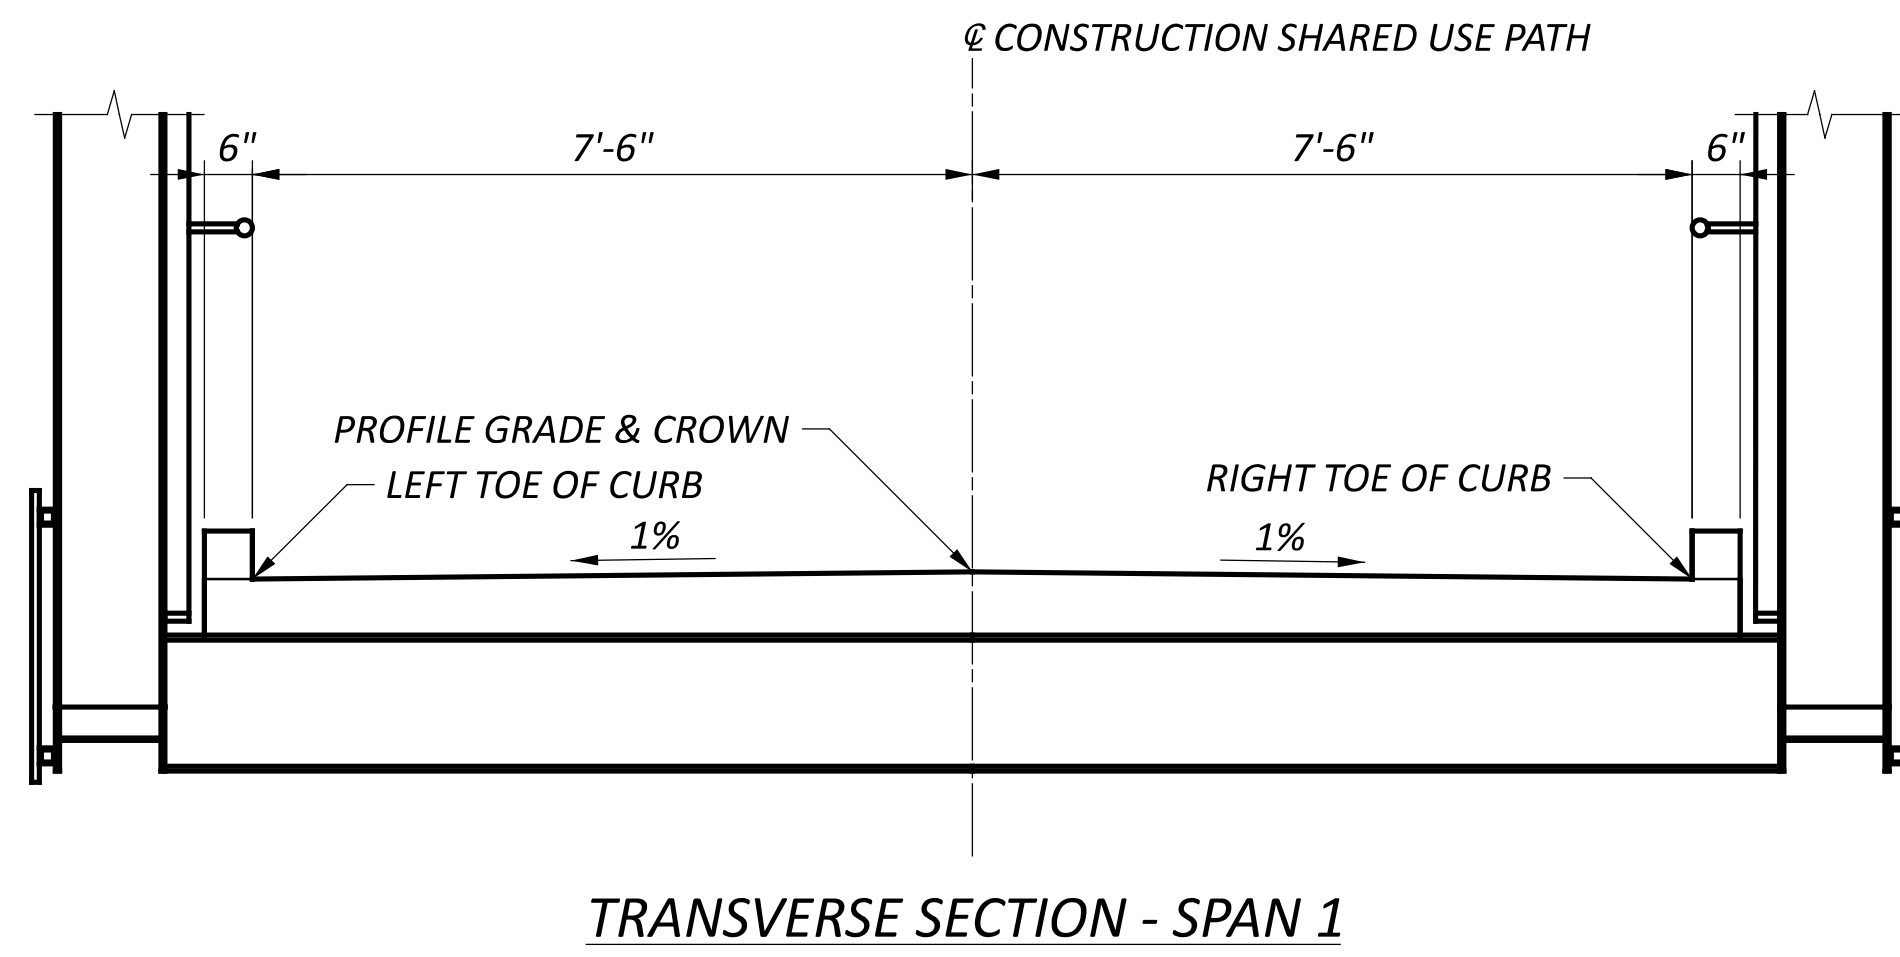

**NOTES**

1. FINAL DECK SURFACE ELEVATIONS SHOWN REPRESENT THE DECK SURFACE LOCATION AFTER ALL ANTICIPATED DEAD LOAD DEFLECTIONS HAVE OCCURRED.
2. SEE SHEET 20/27 FOR SPANS 2 & 3 FINAL DECK SURFACE ELEVATIONS



GRE-68-12.65

MODEL: Sheet\_SurvFt\_PAPER: 34x22 (in.) DATE: 3/31/2025 TIME: 4:30:16 PM USER: wshannon P:\DBP\LAG\0003\_GRE-68-12.65\115388\400-Engineering\Structures\SFN\_2926107\Sheets\115388\_SF1\_2926107\_55006.dgn

FINAL DECK SURFACE ELEVATIONS (SPAN 1 & SPAN 4)  
BRIDGE NO. GRE-BK80020-00.492  
PEDESTRIAN BRIDGE OVER US 68 AND OLD TOWN CREEK




SFN	2926107
DESIGN AGENCY	CARPENTER MARTY
DESIGNER	CHECKER
JZ	AMR
REVIEWER	
GDJ	03/28/25
PROJECT ID	115388
SUBSET	TOTAL
19	27
SHEET	TOTAL
P.65	P.107

SCREED, TOP OF HAUNCH, AND FINAL DECK SURFACE ELEVATIONS TABLE (FT.) (SPAN 2 & SPAN 3)

LOCATION		C	1/8	1/4	3/8	1/2	5/8	3/4	7/8	D	E	1/8	1/4	3/8	1/2	5/8	3/4	7/8	F
LEFT TOE OF CURB	STATION	5+94.94	6+09.37	6+23.79	6+38.22	6+52.65	6+67.07	6+81.50	6+95.93	7+10.36	7+12.52	7+26.95	7+41.38	7+55.80	7+70.23	7+84.66	7+99.08	8+13.51	8+27.94
	FINAL ELEVATION	854.19	853.62	852.92	852.21	851.49	850.78	850.06	849.35	848.63	848.52	847.81	847.09	846.38	845.66	844.95	844.23	843.51	842.80
	SCREED ELEVATION	854.19	853.67	853.03	852.34	851.64	850.91	850.16	849.40	848.63	848.52	847.86	847.19	846.51	845.80	845.08	844.33	843.57	842.80
@ BEAM 1 & BEAM 3	STATION	5+94.94	6+09.37	6+23.79	6+38.22	6+52.65	6+67.07	6+81.50	6+95.93	7+10.36	7+12.52	7+26.95	7+41.38	7+55.80	7+70.23	7+84.66	7+99.08	8+13.51	8+27.94
	FINAL ELEVATION	854.22	853.65	852.95	852.24	851.52	850.81	850.09	849.38	848.66	848.55	847.84	847.12	846.41	845.69	844.98	844.26	843.54	842.83
	TOP OF HAUNCH ELEVATION	853.52	853.00	852.35	851.66	850.96	850.23	849.48	848.72	847.95	847.85	847.18	846.51	845.83	845.13	844.40	843.65	842.89	842.12
@ CONSTRUCTION SHARED USE PATH, CROWN, & PROFILE GRADE	STATION	5+94.94	6+09.37	6+23.79	6+38.22	6+52.65	6+67.07	6+81.50	6+95.93	7+10.36	7+12.52	7+26.95	7+41.38	7+55.80	7+70.23	7+84.66	7+99.08	8+13.51	8+27.94
	FINAL ELEVATION	854.27	853.69	853.00	852.28	851.57	850.85	850.14	849.42	848.71	848.60	847.88	847.17	846.45	845.74	845.02	844.31	843.59	842.87
	SCREED ELEVATION	854.27	853.75	853.10	852.42	851.71	850.98	850.24	849.48	848.71	848.60	847.94	847.27	846.58	845.88	845.15	844.41	843.64	842.87
@ BEAM 2 & BEAM 4	STATION	5+94.94	6+09.37	6+23.79	6+38.22	6+52.65	6+67.07	6+81.50	6+95.93	7+10.36	7+12.52	7+26.95	7+41.38	7+55.80	7+70.23	7+84.66	7+99.08	8+13.51	8+27.94
	FINAL ELEVATION	854.22	853.65	852.95	852.24	851.52	850.81	850.09	849.38	848.66	848.55	847.84	847.12	846.41	845.69	844.98	844.26	843.54	842.83
	TOP OF HAUNCH ELEVATION	853.52	853.00	852.35	851.66	850.96	850.23	849.48	848.72	847.95	847.85	847.18	846.51	845.83	845.13	844.40	843.65	842.89	842.12
RIGHT TOE OF CURB	STATION	5+94.94	6+09.37	6+23.79	6+38.22	6+52.65	6+67.07	6+81.50	6+95.93	7+10.36	7+12.52	7+26.95	7+41.38	7+55.80	7+70.23	7+84.66	7+99.08	8+13.51	8+27.94
	FINAL ELEVATION	854.19	853.62	852.92	852.21	851.49	850.78	850.06	849.35	848.63	848.52	847.81	847.09	846.38	845.66	844.95	844.23	843.51	842.80
	SCREED ELEVATION	854.19	853.67	853.03	852.34	851.64	850.91	850.16	849.40	848.63	848.52	847.86	847.19	846.51	845.80	845.08	844.33	843.57	842.80


NOTES

1. SCREED ELEVATIONS SHOWN REPRESENT THE THEORETICAL DECK SURFACE LOCATION PRIOR TO DEFLECTIONS CAUSED BY DECK PLACEMENT AND OTHER ANTICIPATED DEAD LOADS.
2. TOP OF HAUNCH ELEVATIONS SHOWN REPRESENT THE THEORETICAL LOCATION OF THE BOTTOM OF THE DECK ABOVE THE BEAM HAUNCH PRIOR TO DEFLECTIONS CAUSED BY DECK PLACEMENT AND OTHER ANTICIPATED DEAD LOADS.
3. FINAL DECK SURFACE ELEVATIONS SHOWN REPRESENT THE DECK SURFACE LOCATION AFTER ALL ANTICIPATED DEAD LOAD DEFLECTIONS HAVE OCCURRED.

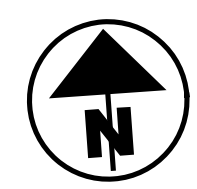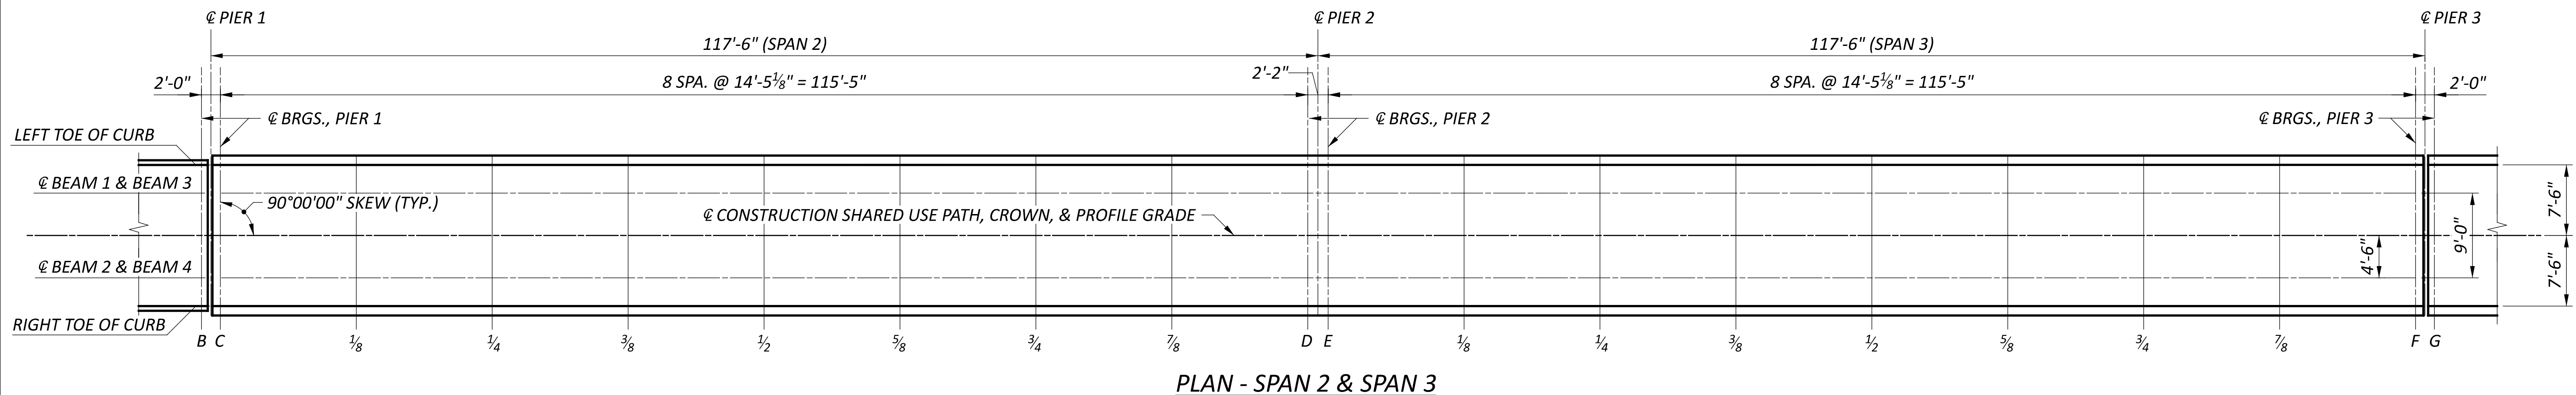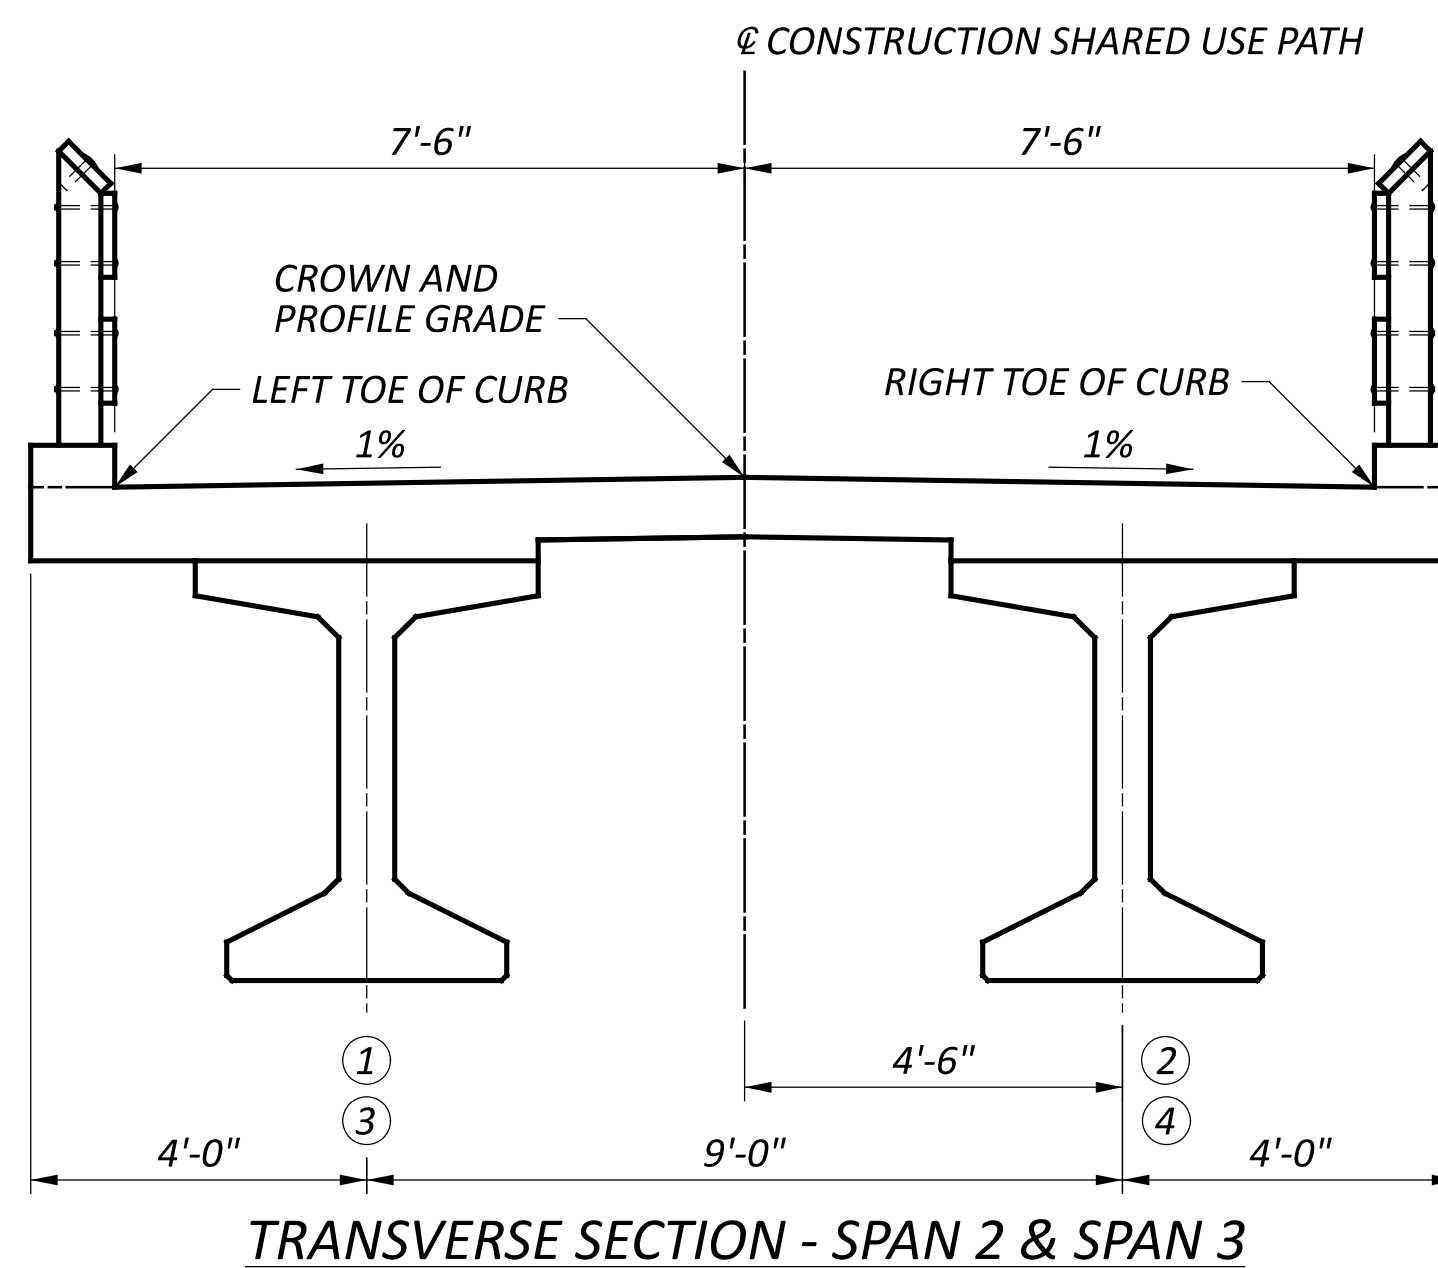


SCREED, TOP OF HAUNCH, AND FINAL DECK SURFACE ELEVATIONS (SPAN 2 & SPAN 3)  
 BRIDGE NO. GRE-BK80020-00.492  
 PEDESTRIAN BRIDGE OVER US 68 AND OLD TOWN CREEK


SFN	2926107
DESIGN AGENCY	CARPENTER MARTY
DESIGNER	CHECKER
JZ	AMR
REVIEWER	
GDJ	03/28/25
PROJECT ID	115388
SUBSET	TOTAL
20	27
SHEET	TOTAL
P.66	P.107

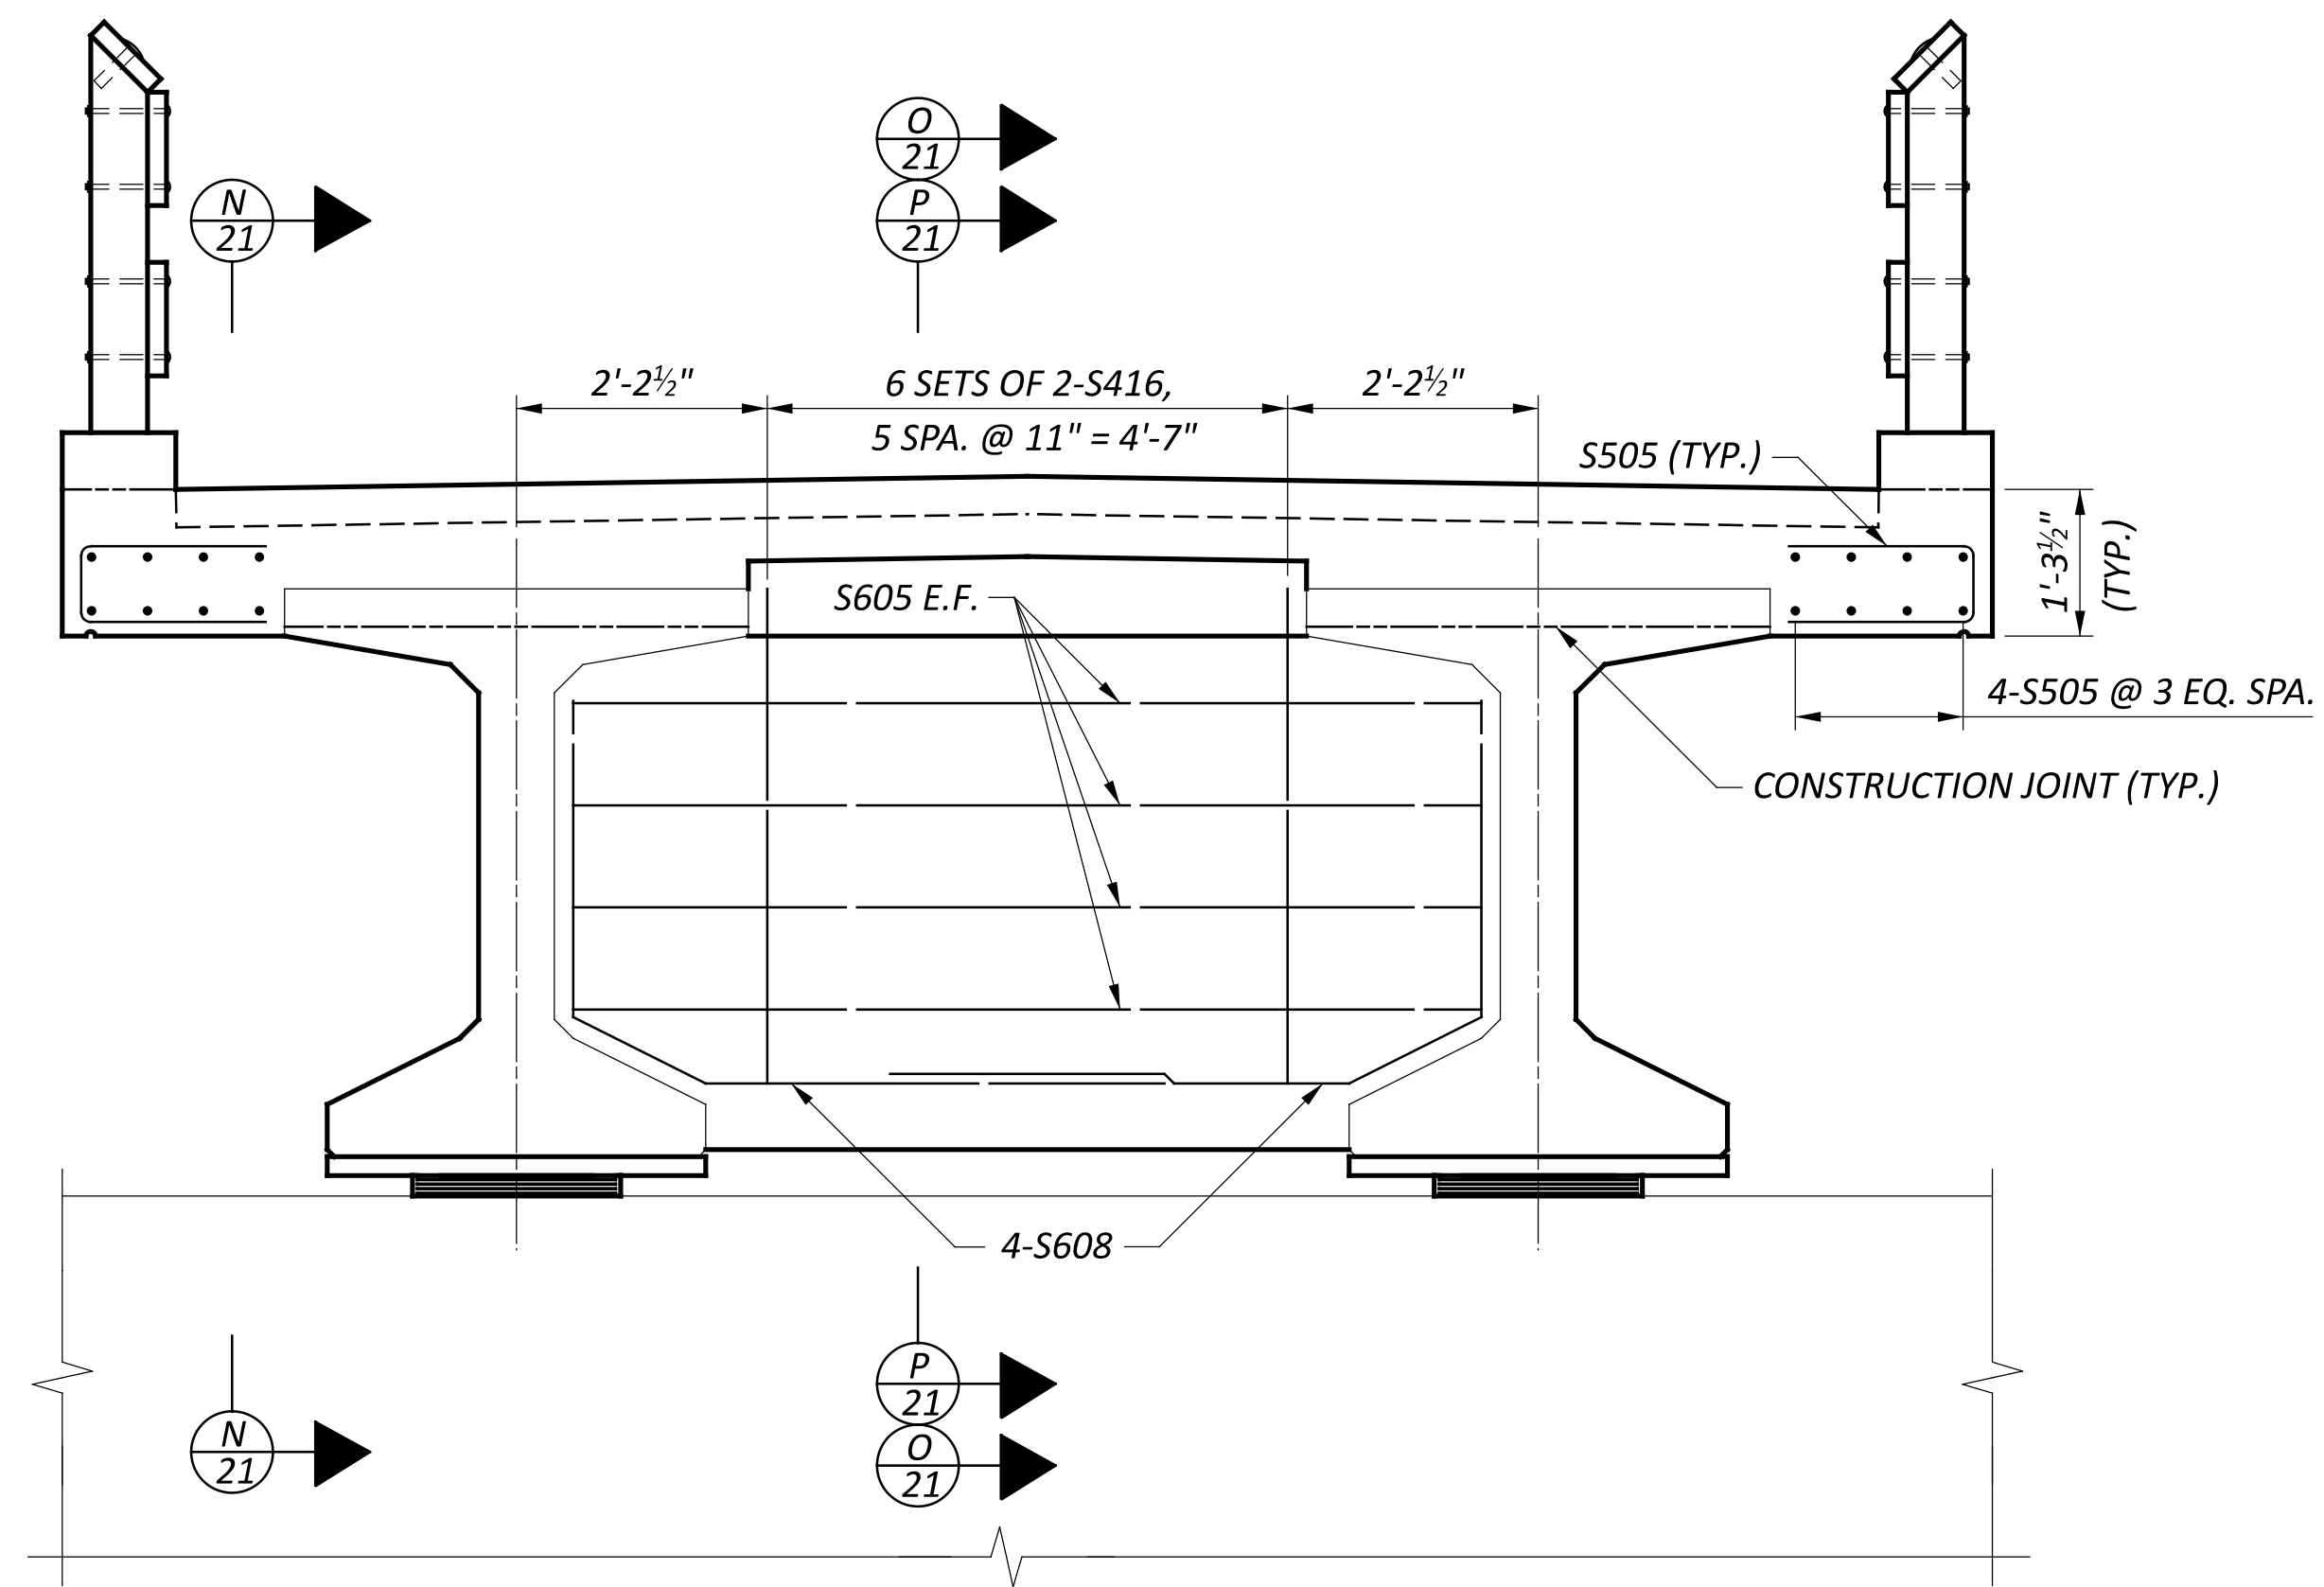


PIER 1 & PIER 3 DIAPHRAGM ELEVATION

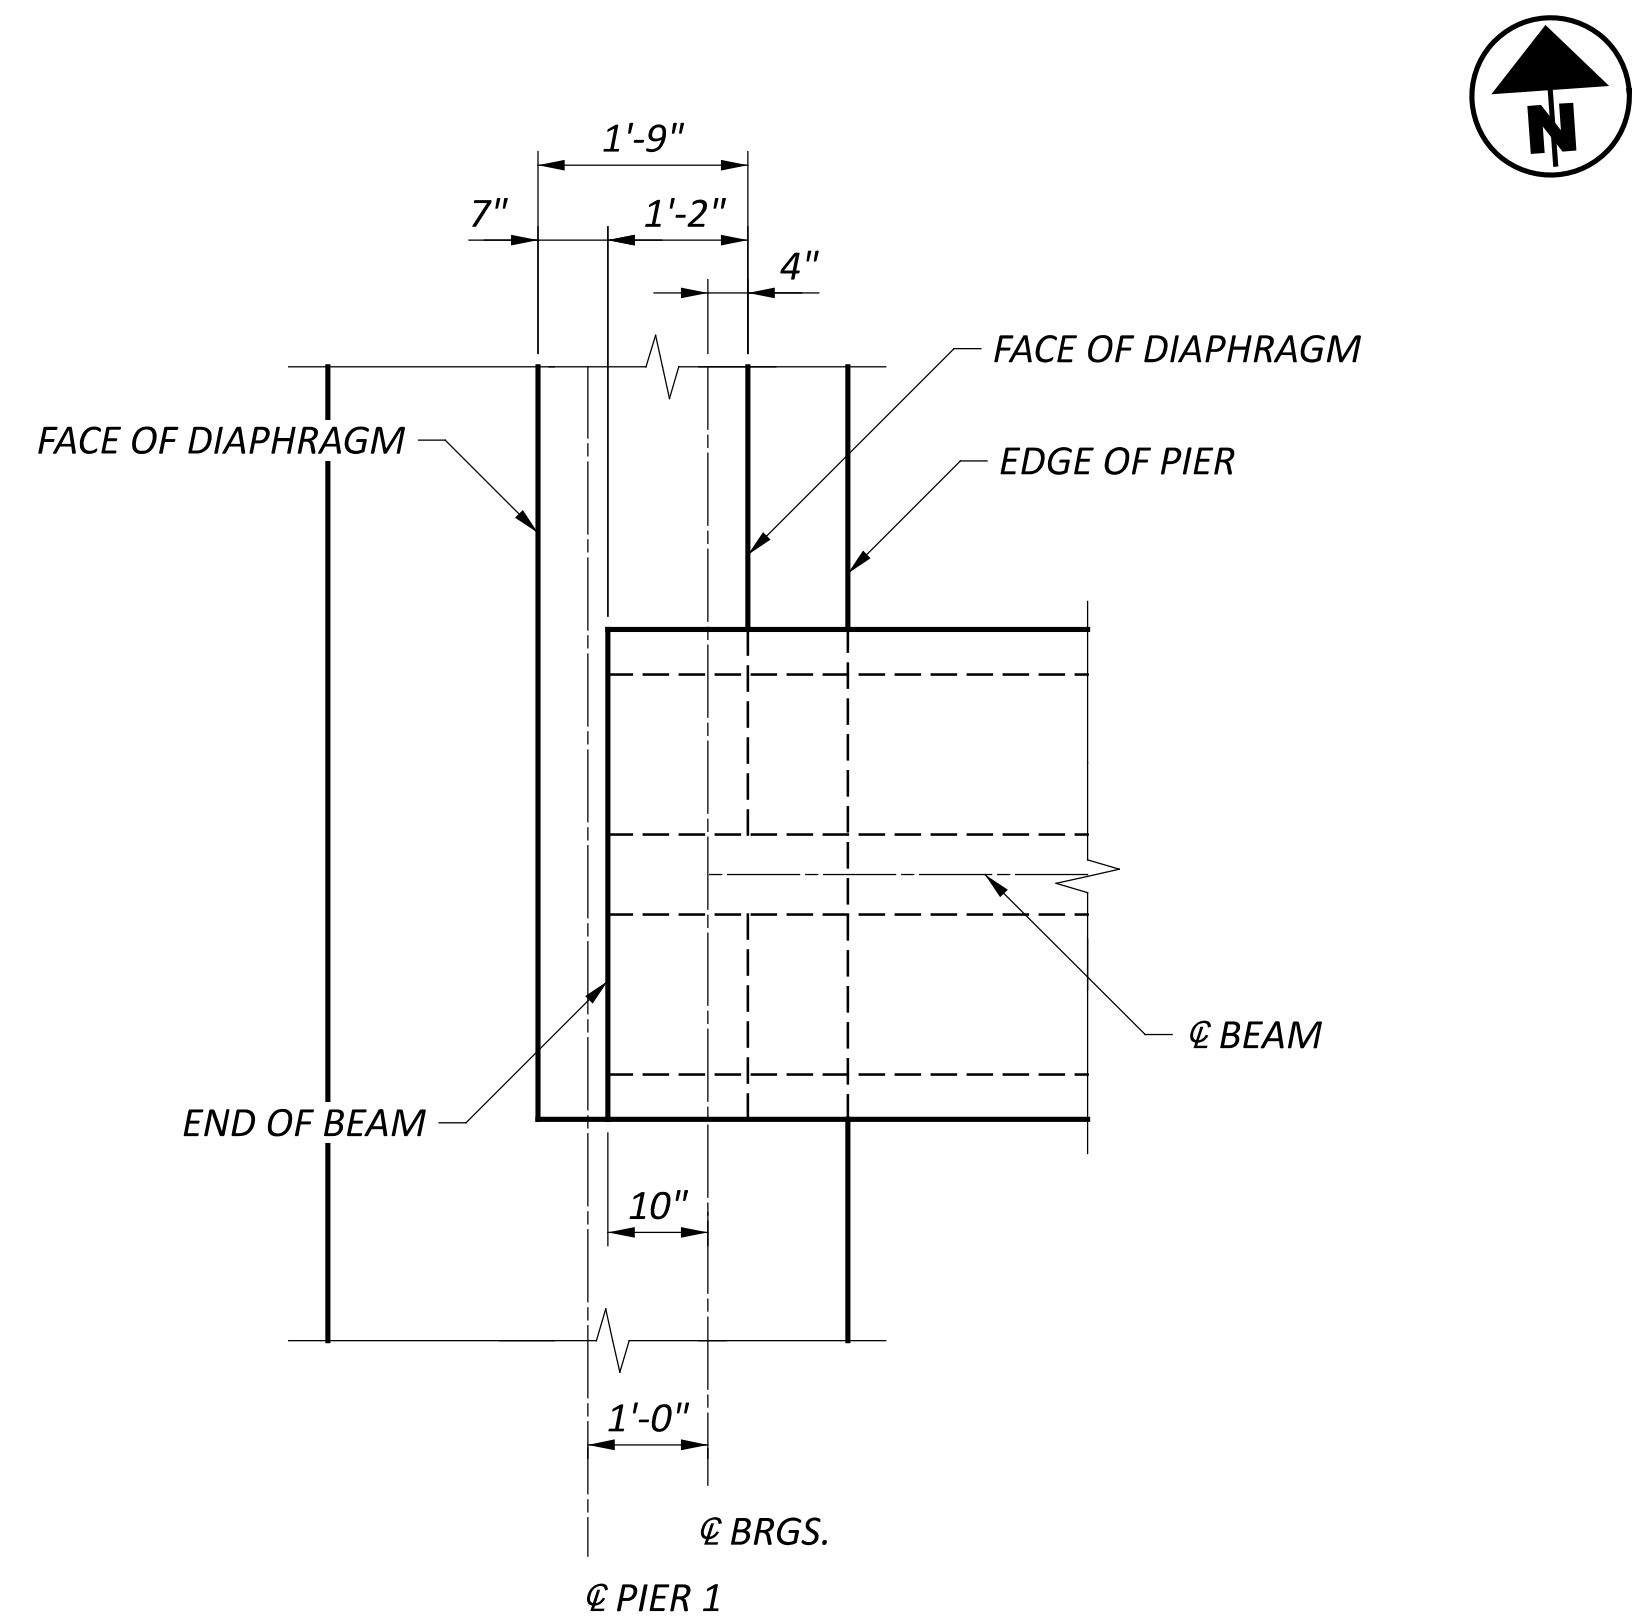


PIER 1 PARTIAL PLAN

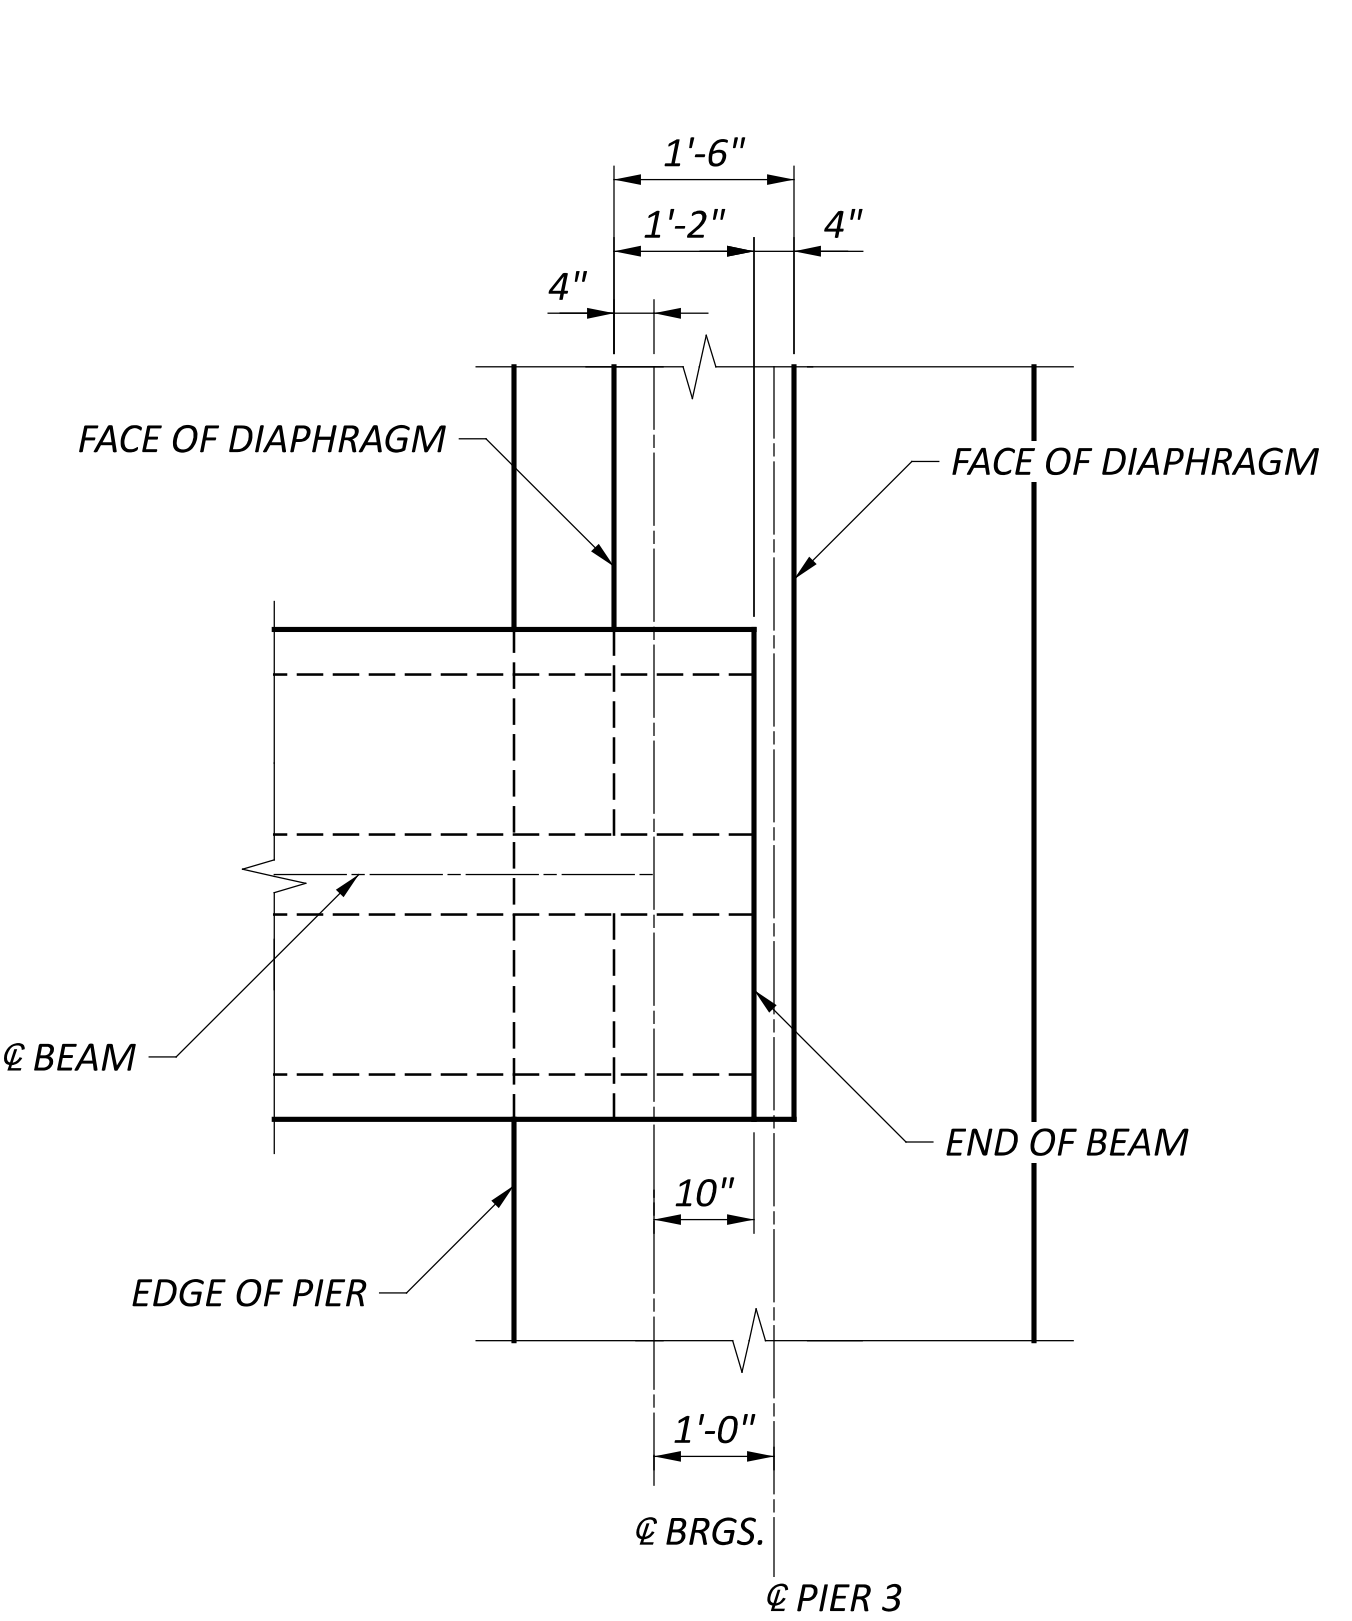


PIER 3 PARTIAL PLAN

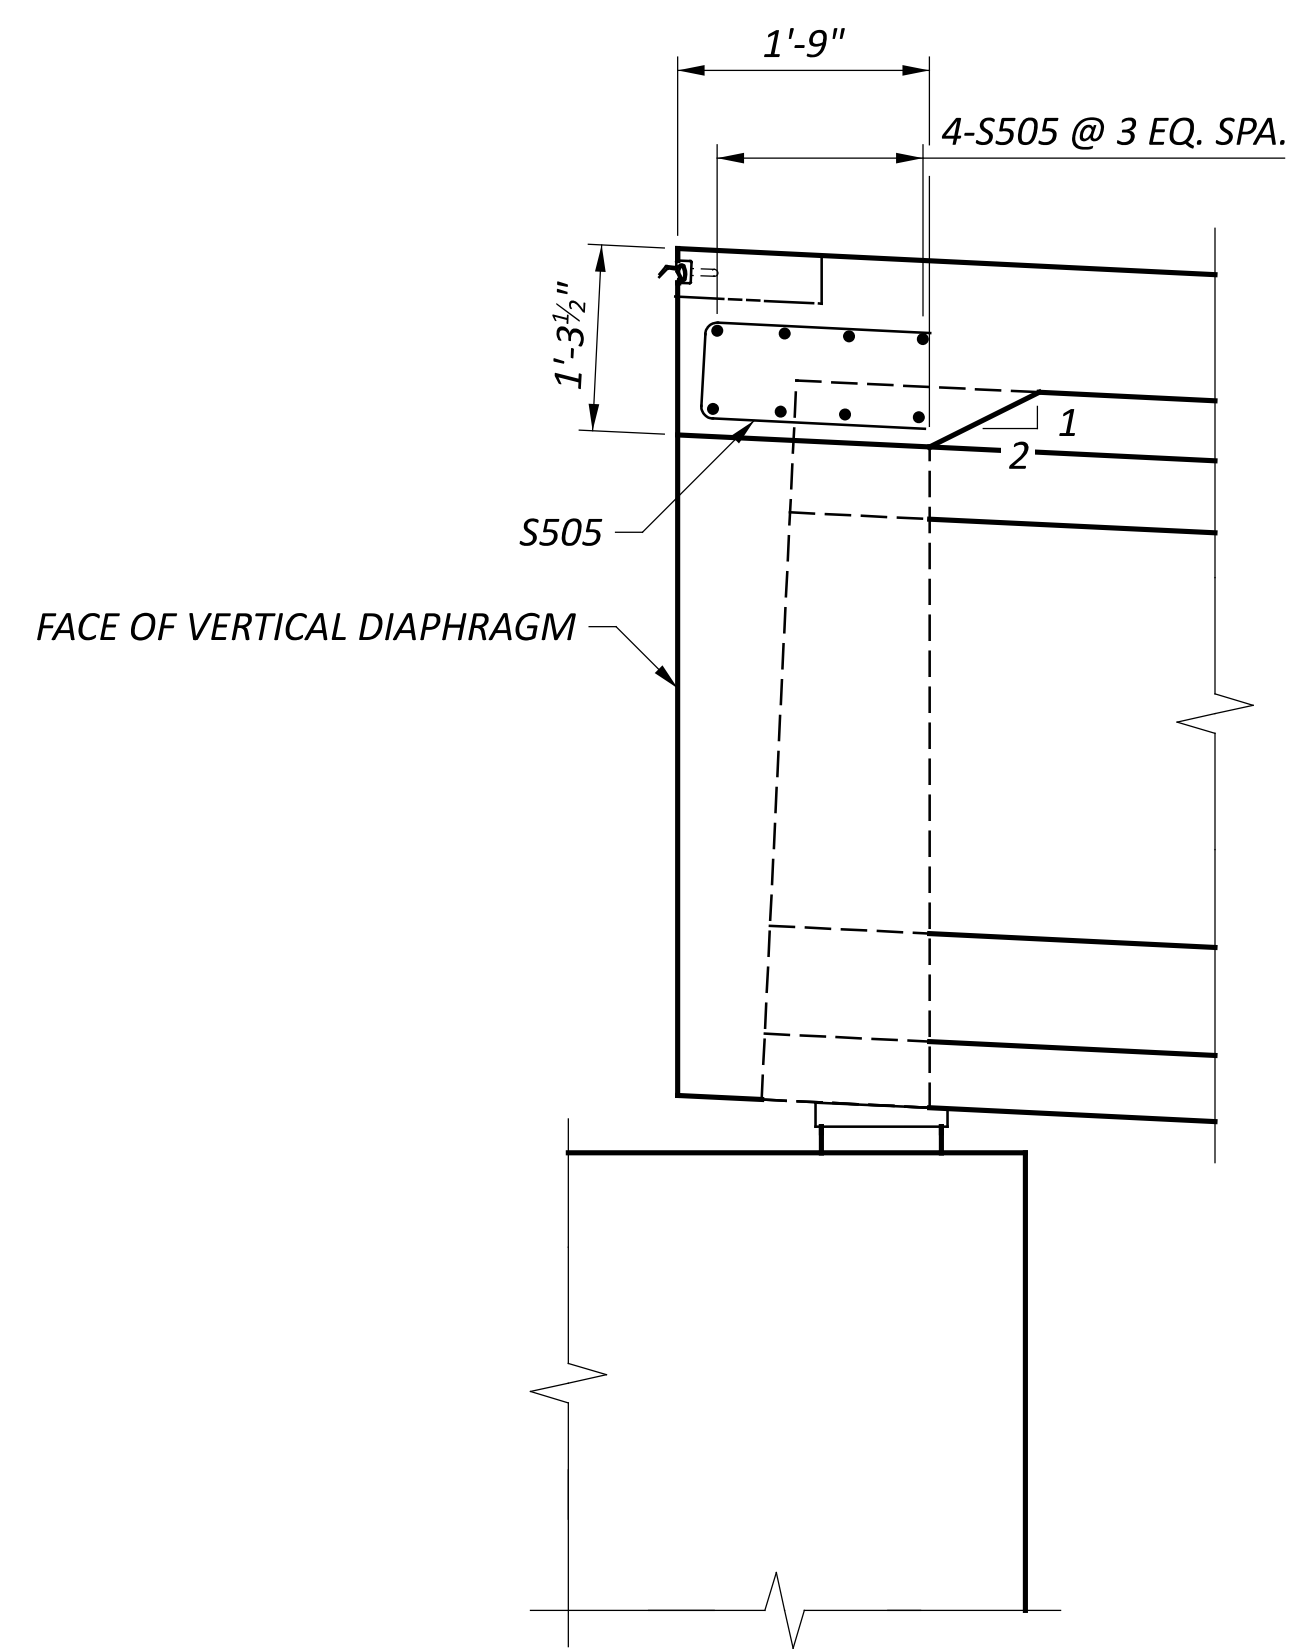

N SECTION  
 21 PIER 1 SHOWN, PIER 3 OPPOSITE HAND

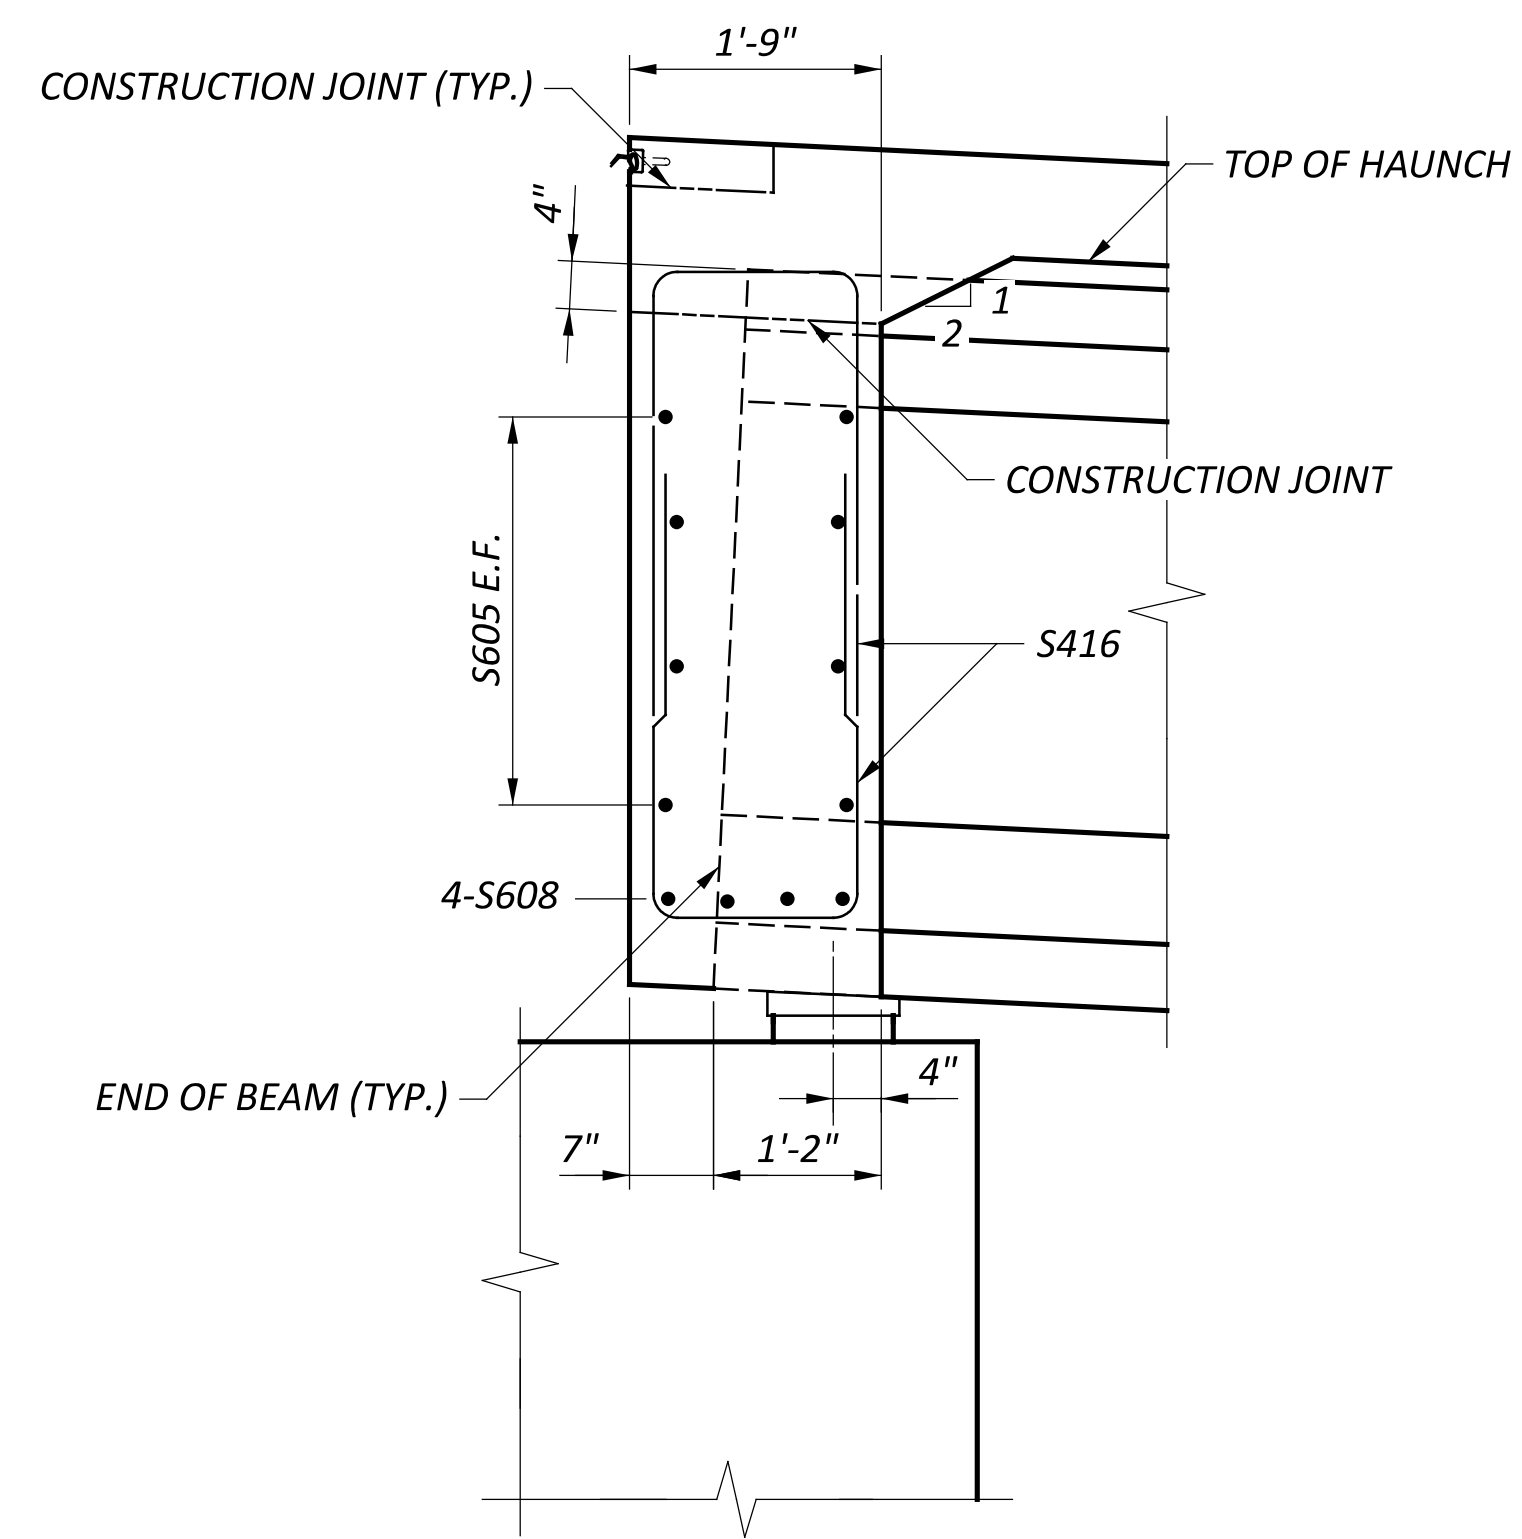

O SECTION  
 21 PIER 1 SHOWN

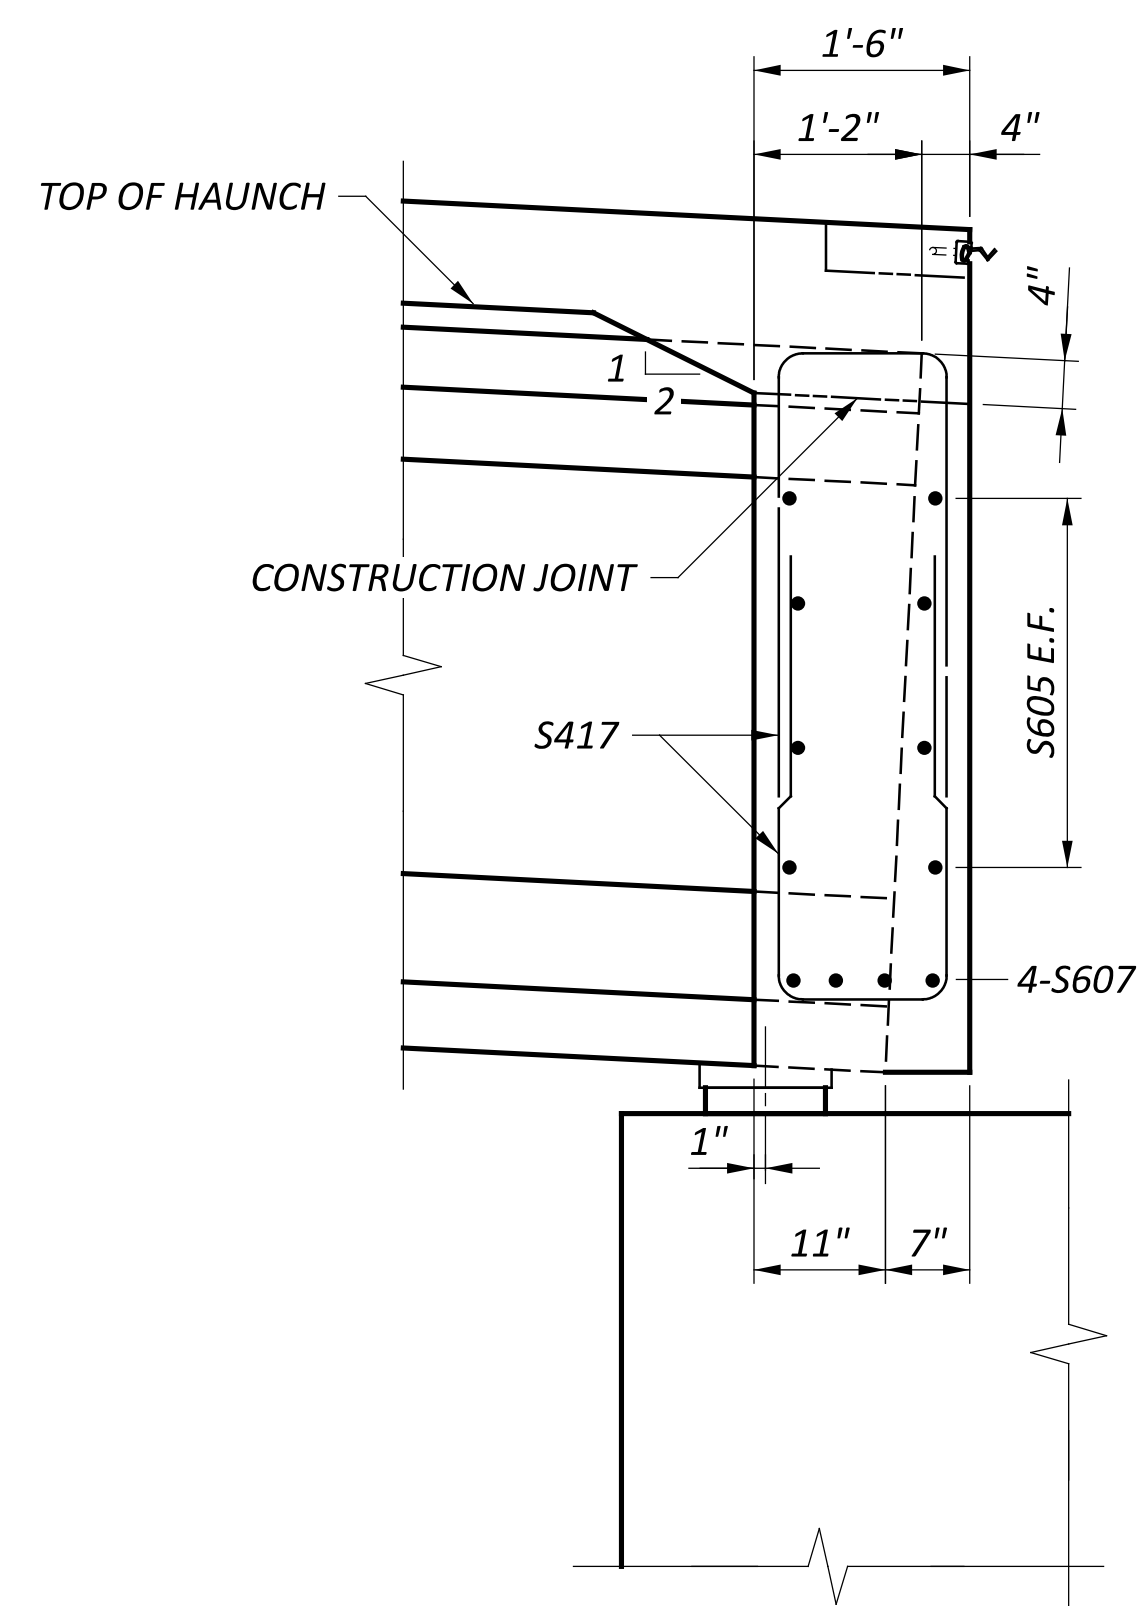

P SECTION  
 21 PIER 3 SHOWN

**LEGEND**  
 E.F. - EACH FACE







**NOTES**  
 1. REFER TO STD. DWGS. PSID-1-13 & EXJ-6-17 FOR ADDITIONAL NOTES AND DETAILS.  
 2. SEE TRANSVERSE SECTION FOR ADDITIONAL REINFORCING.

SFN 2926107	
DESIGN AGENCY	
DESIGNER JZ	CHECKER AMR
REVIEWER GDJ 03/28/25	
PROJECT ID 115388	
SUBSET 21	TOTAL 27
SHEET P.67	TOTAL P.107




**NOTES**

1. TRIM DECK REINFORCEMENT IN CONFLICT WITH SCUPPERS AND ADDITIONAL SCUPPER REINFORCEMENT.
2. STEEL YIELD STRENGTH = 36 KSI (POST SLEEVES AND SCUPPERS)
3. POST SLEEVE TO BE GALVANIZED AND PAINTED "BROWN" - AMS - STD 10076

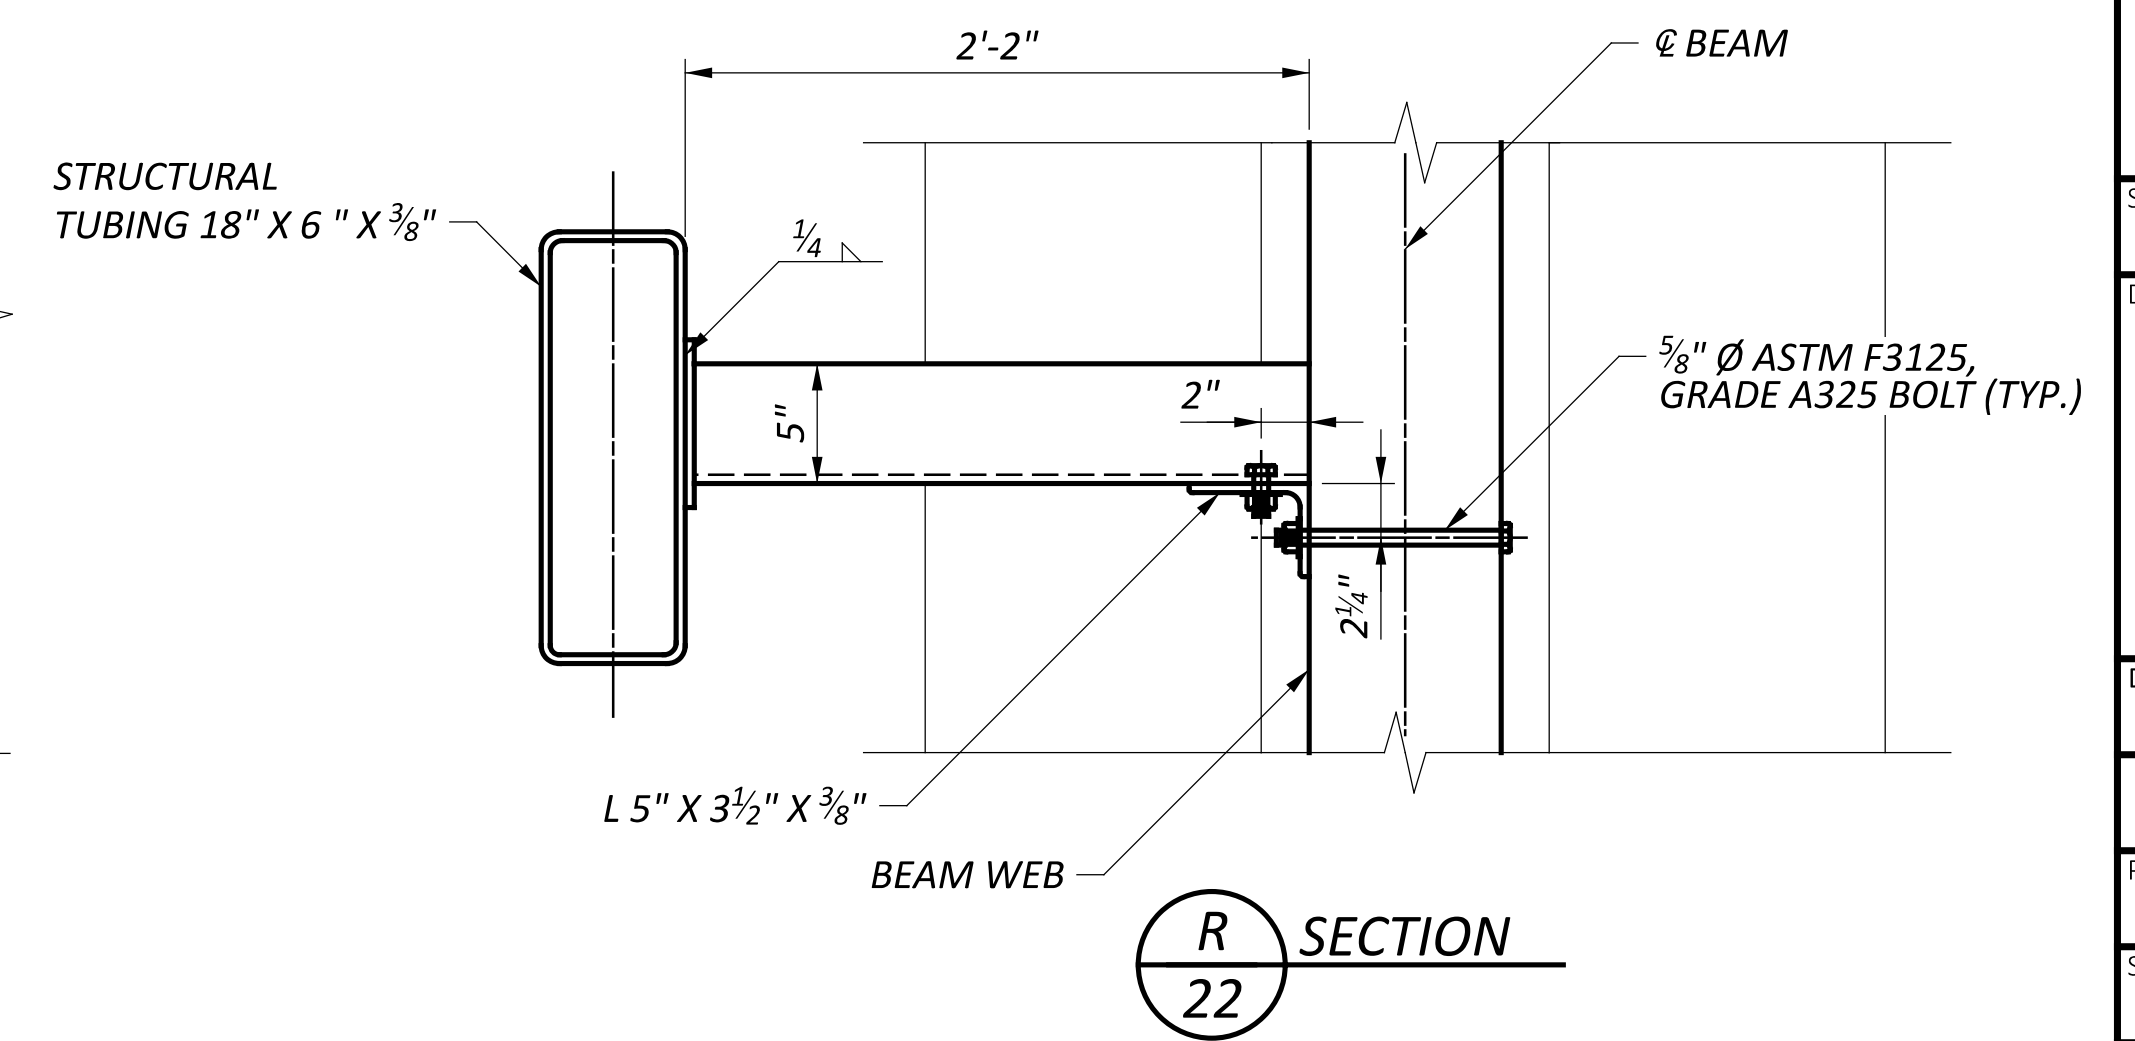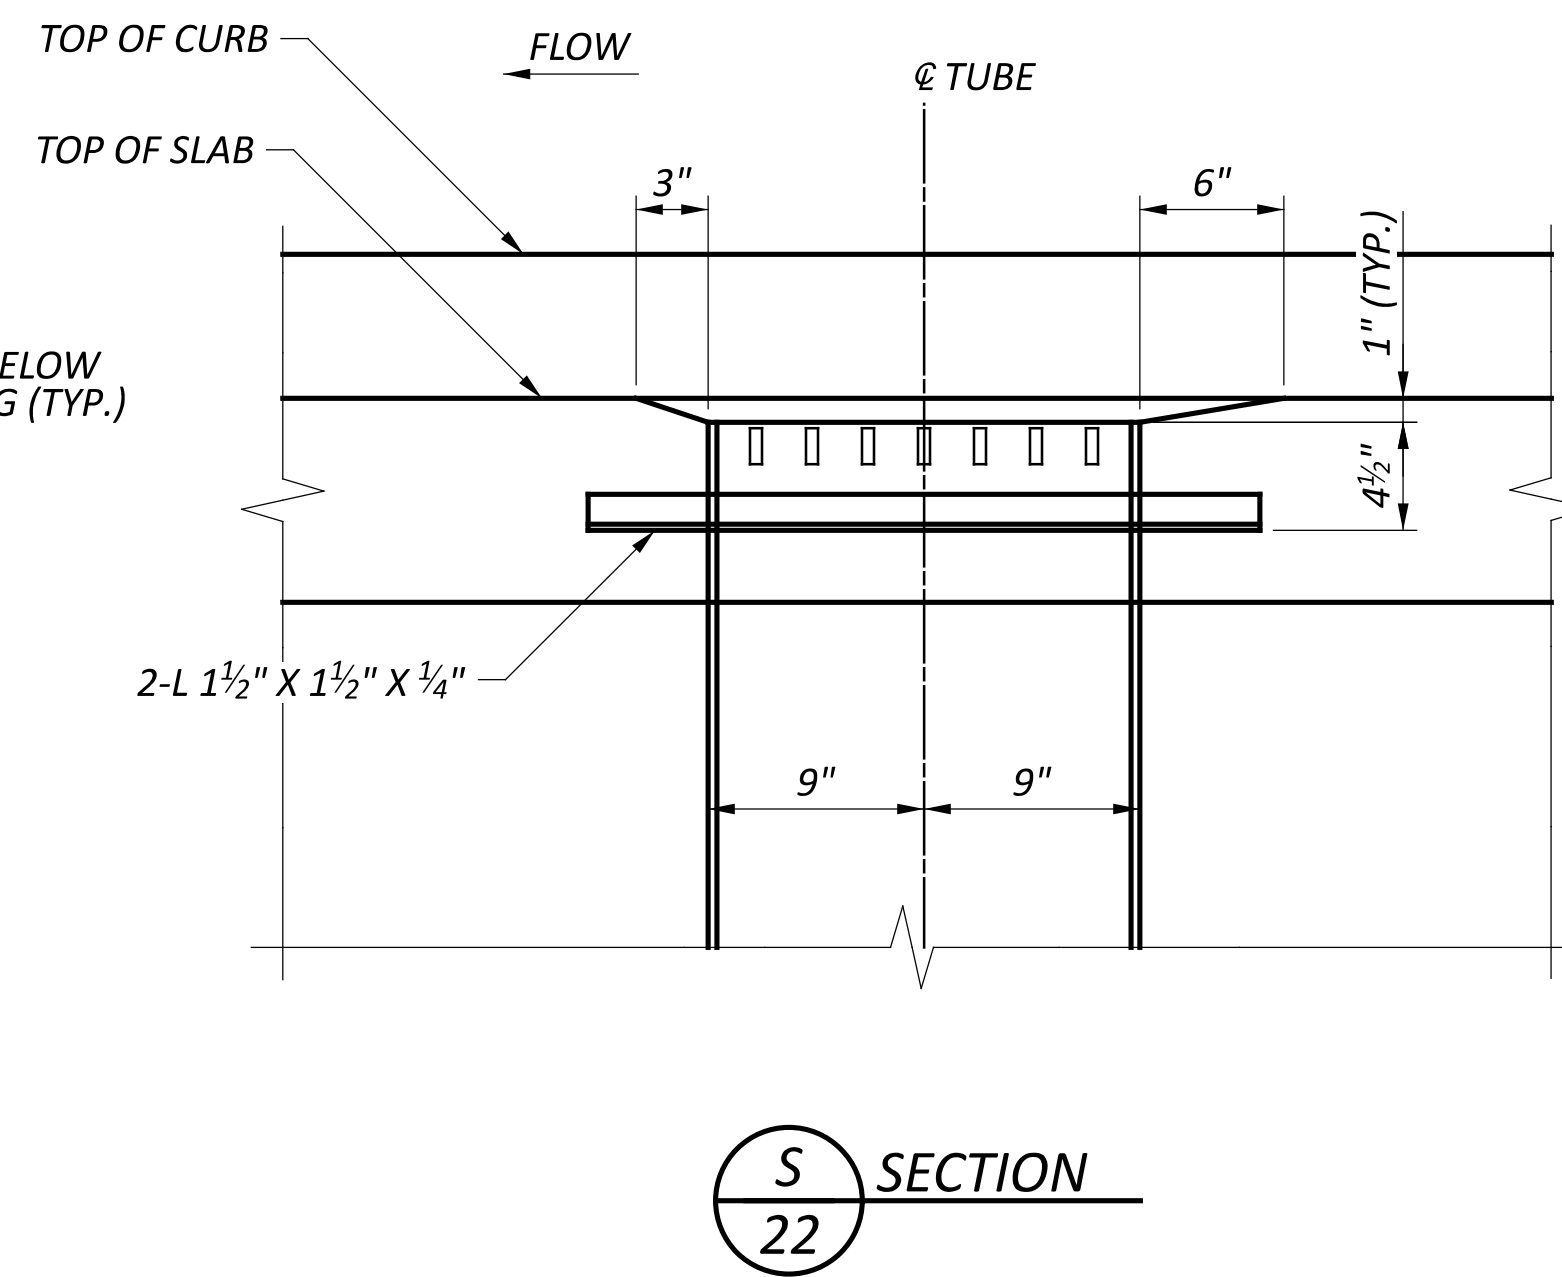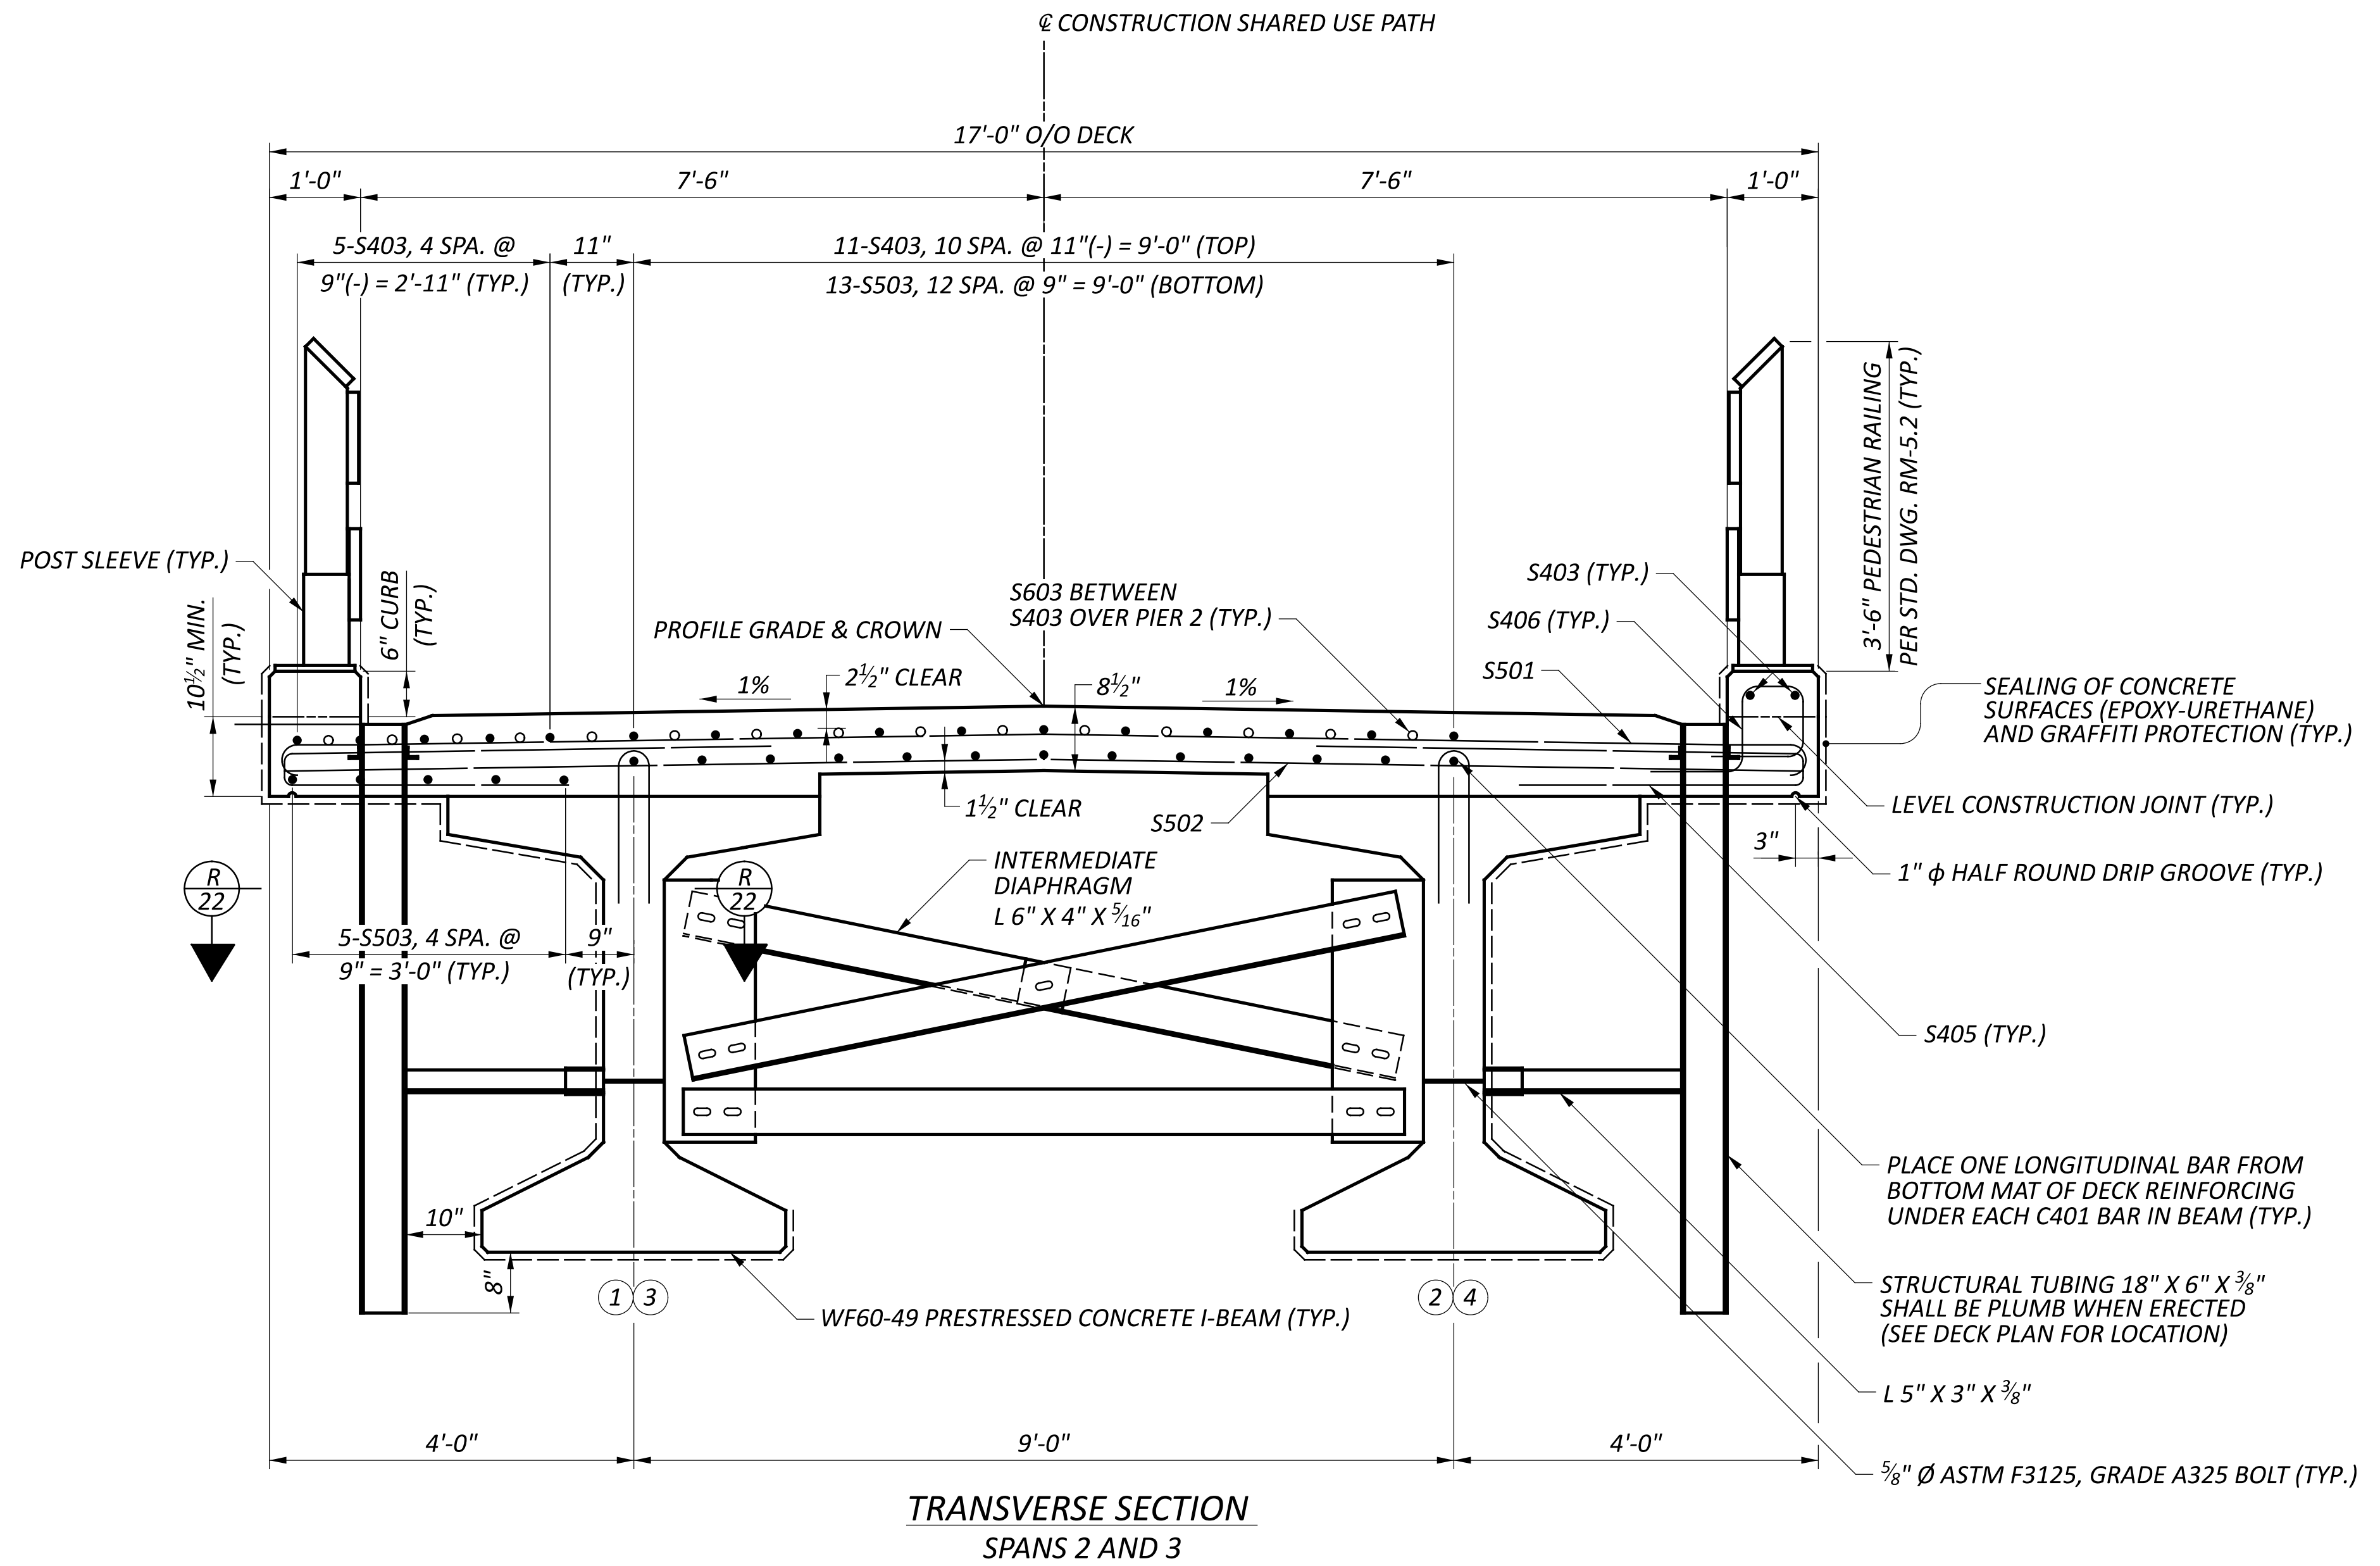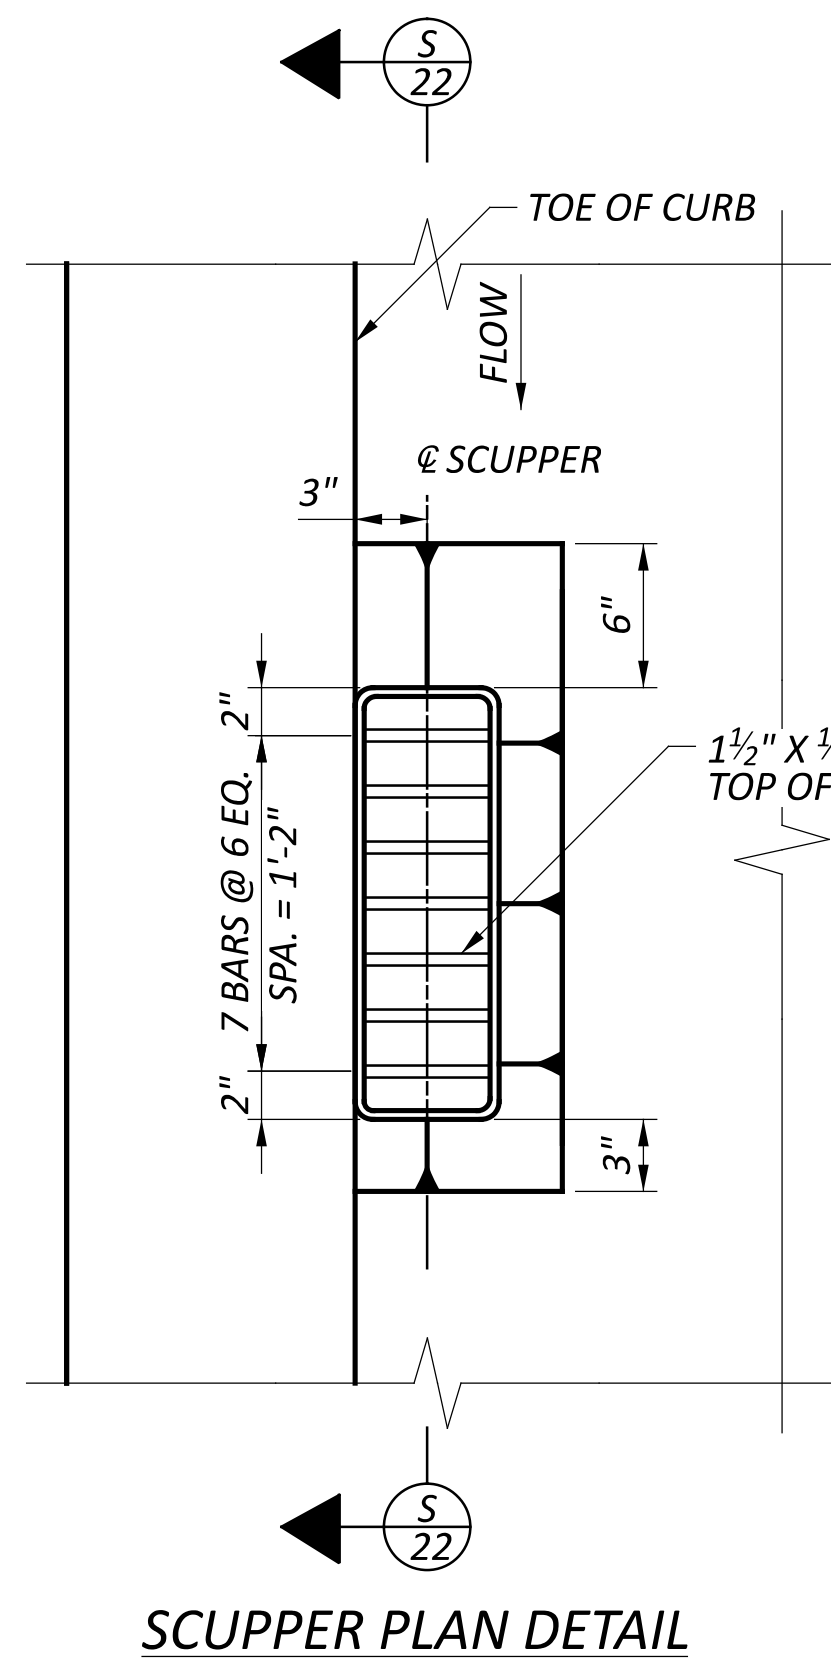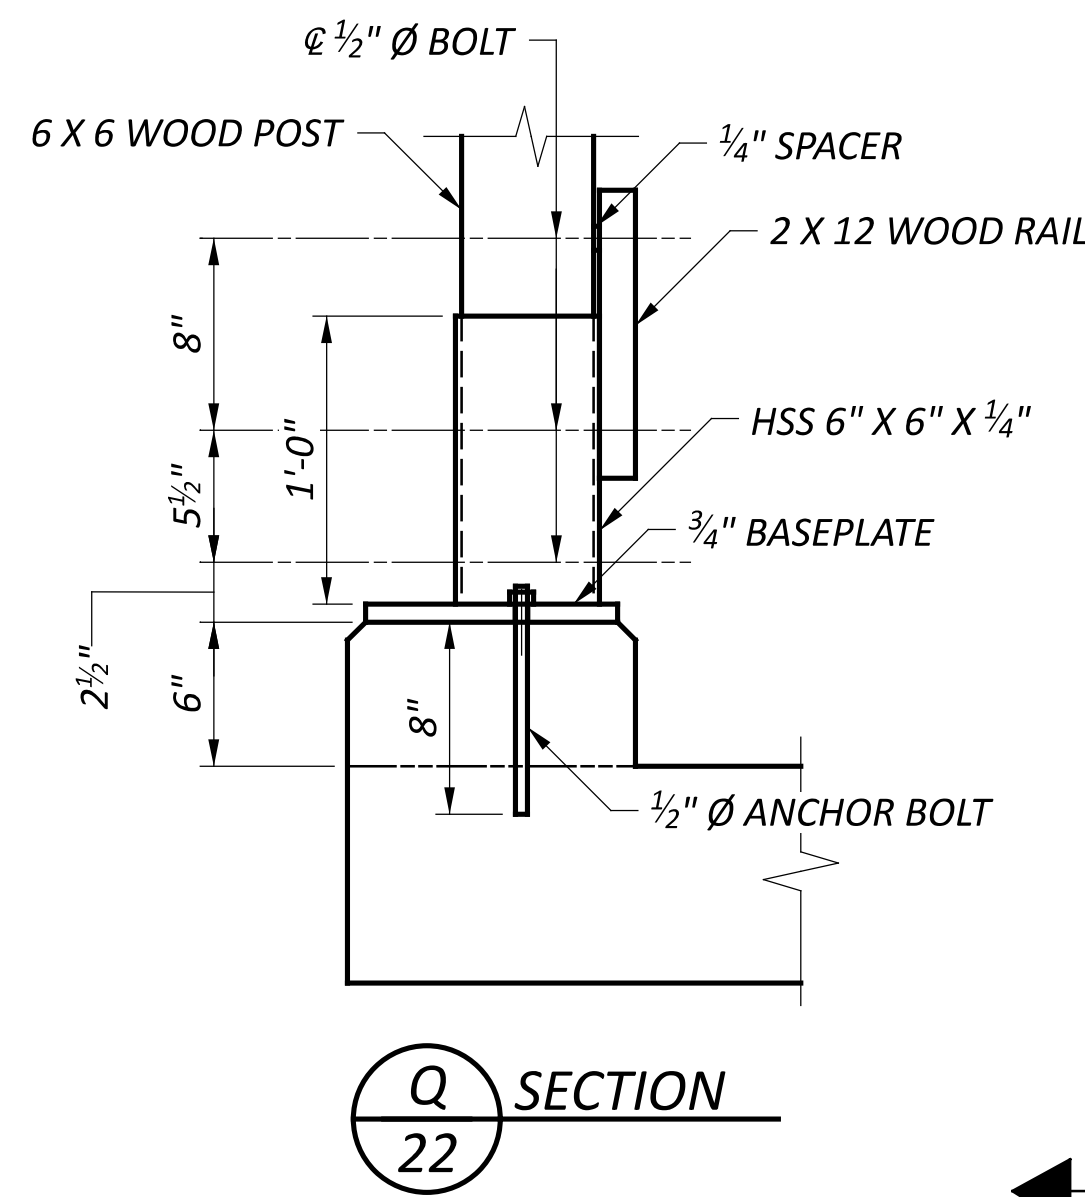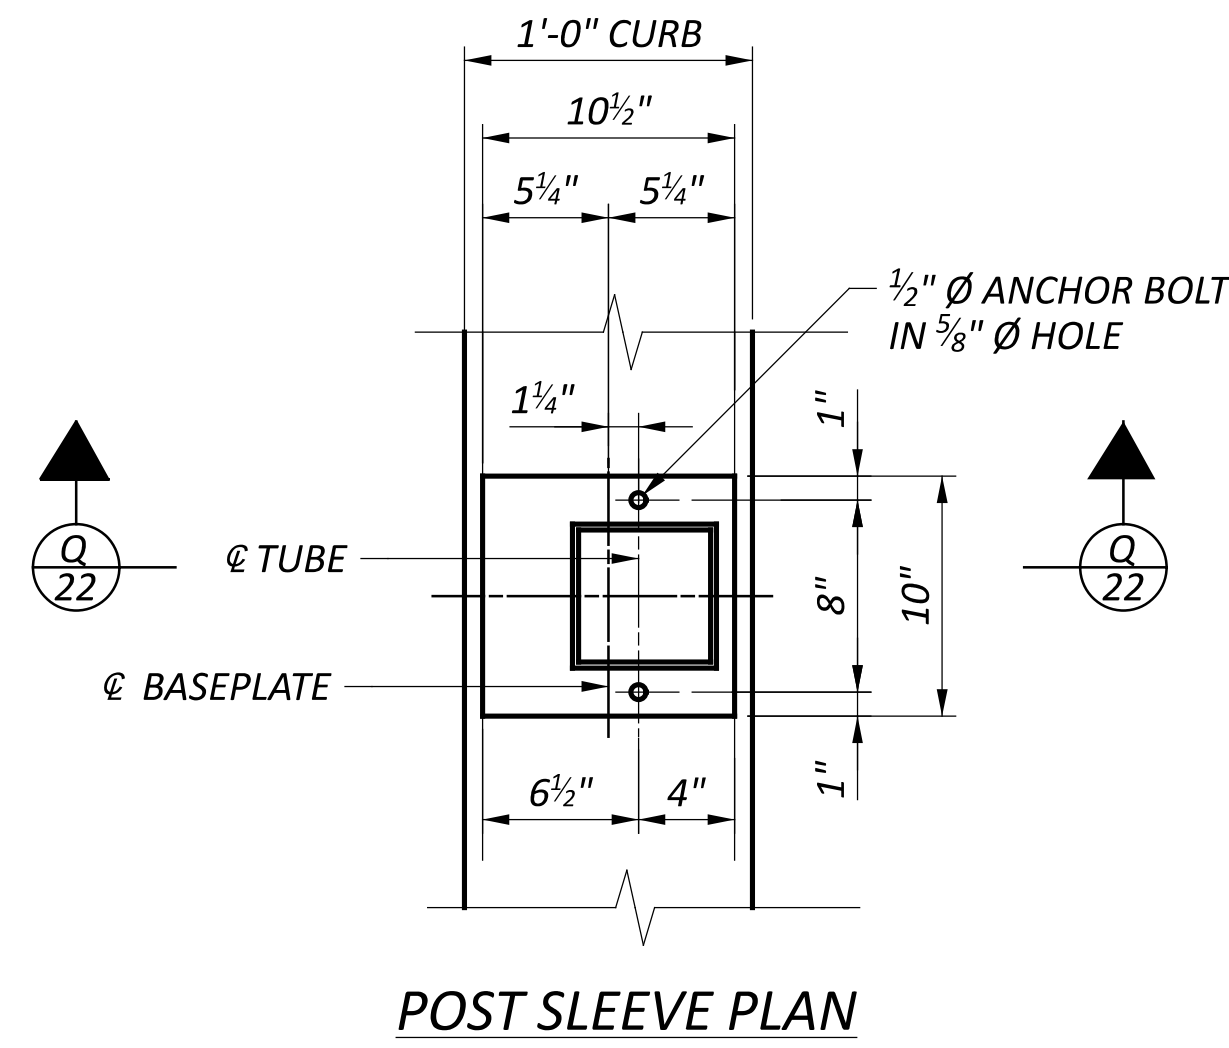

SFN	2926107
DESIGN AGENCY	CARPENTER MARTY
DESIGNER	CHECKER
JZ	AMR
REVIEWER	
GDJ	03/28/25
PROJECT ID	115388
SUBSET	TOTAL
22	27
SHEET	TOTAL
P.68	P.107

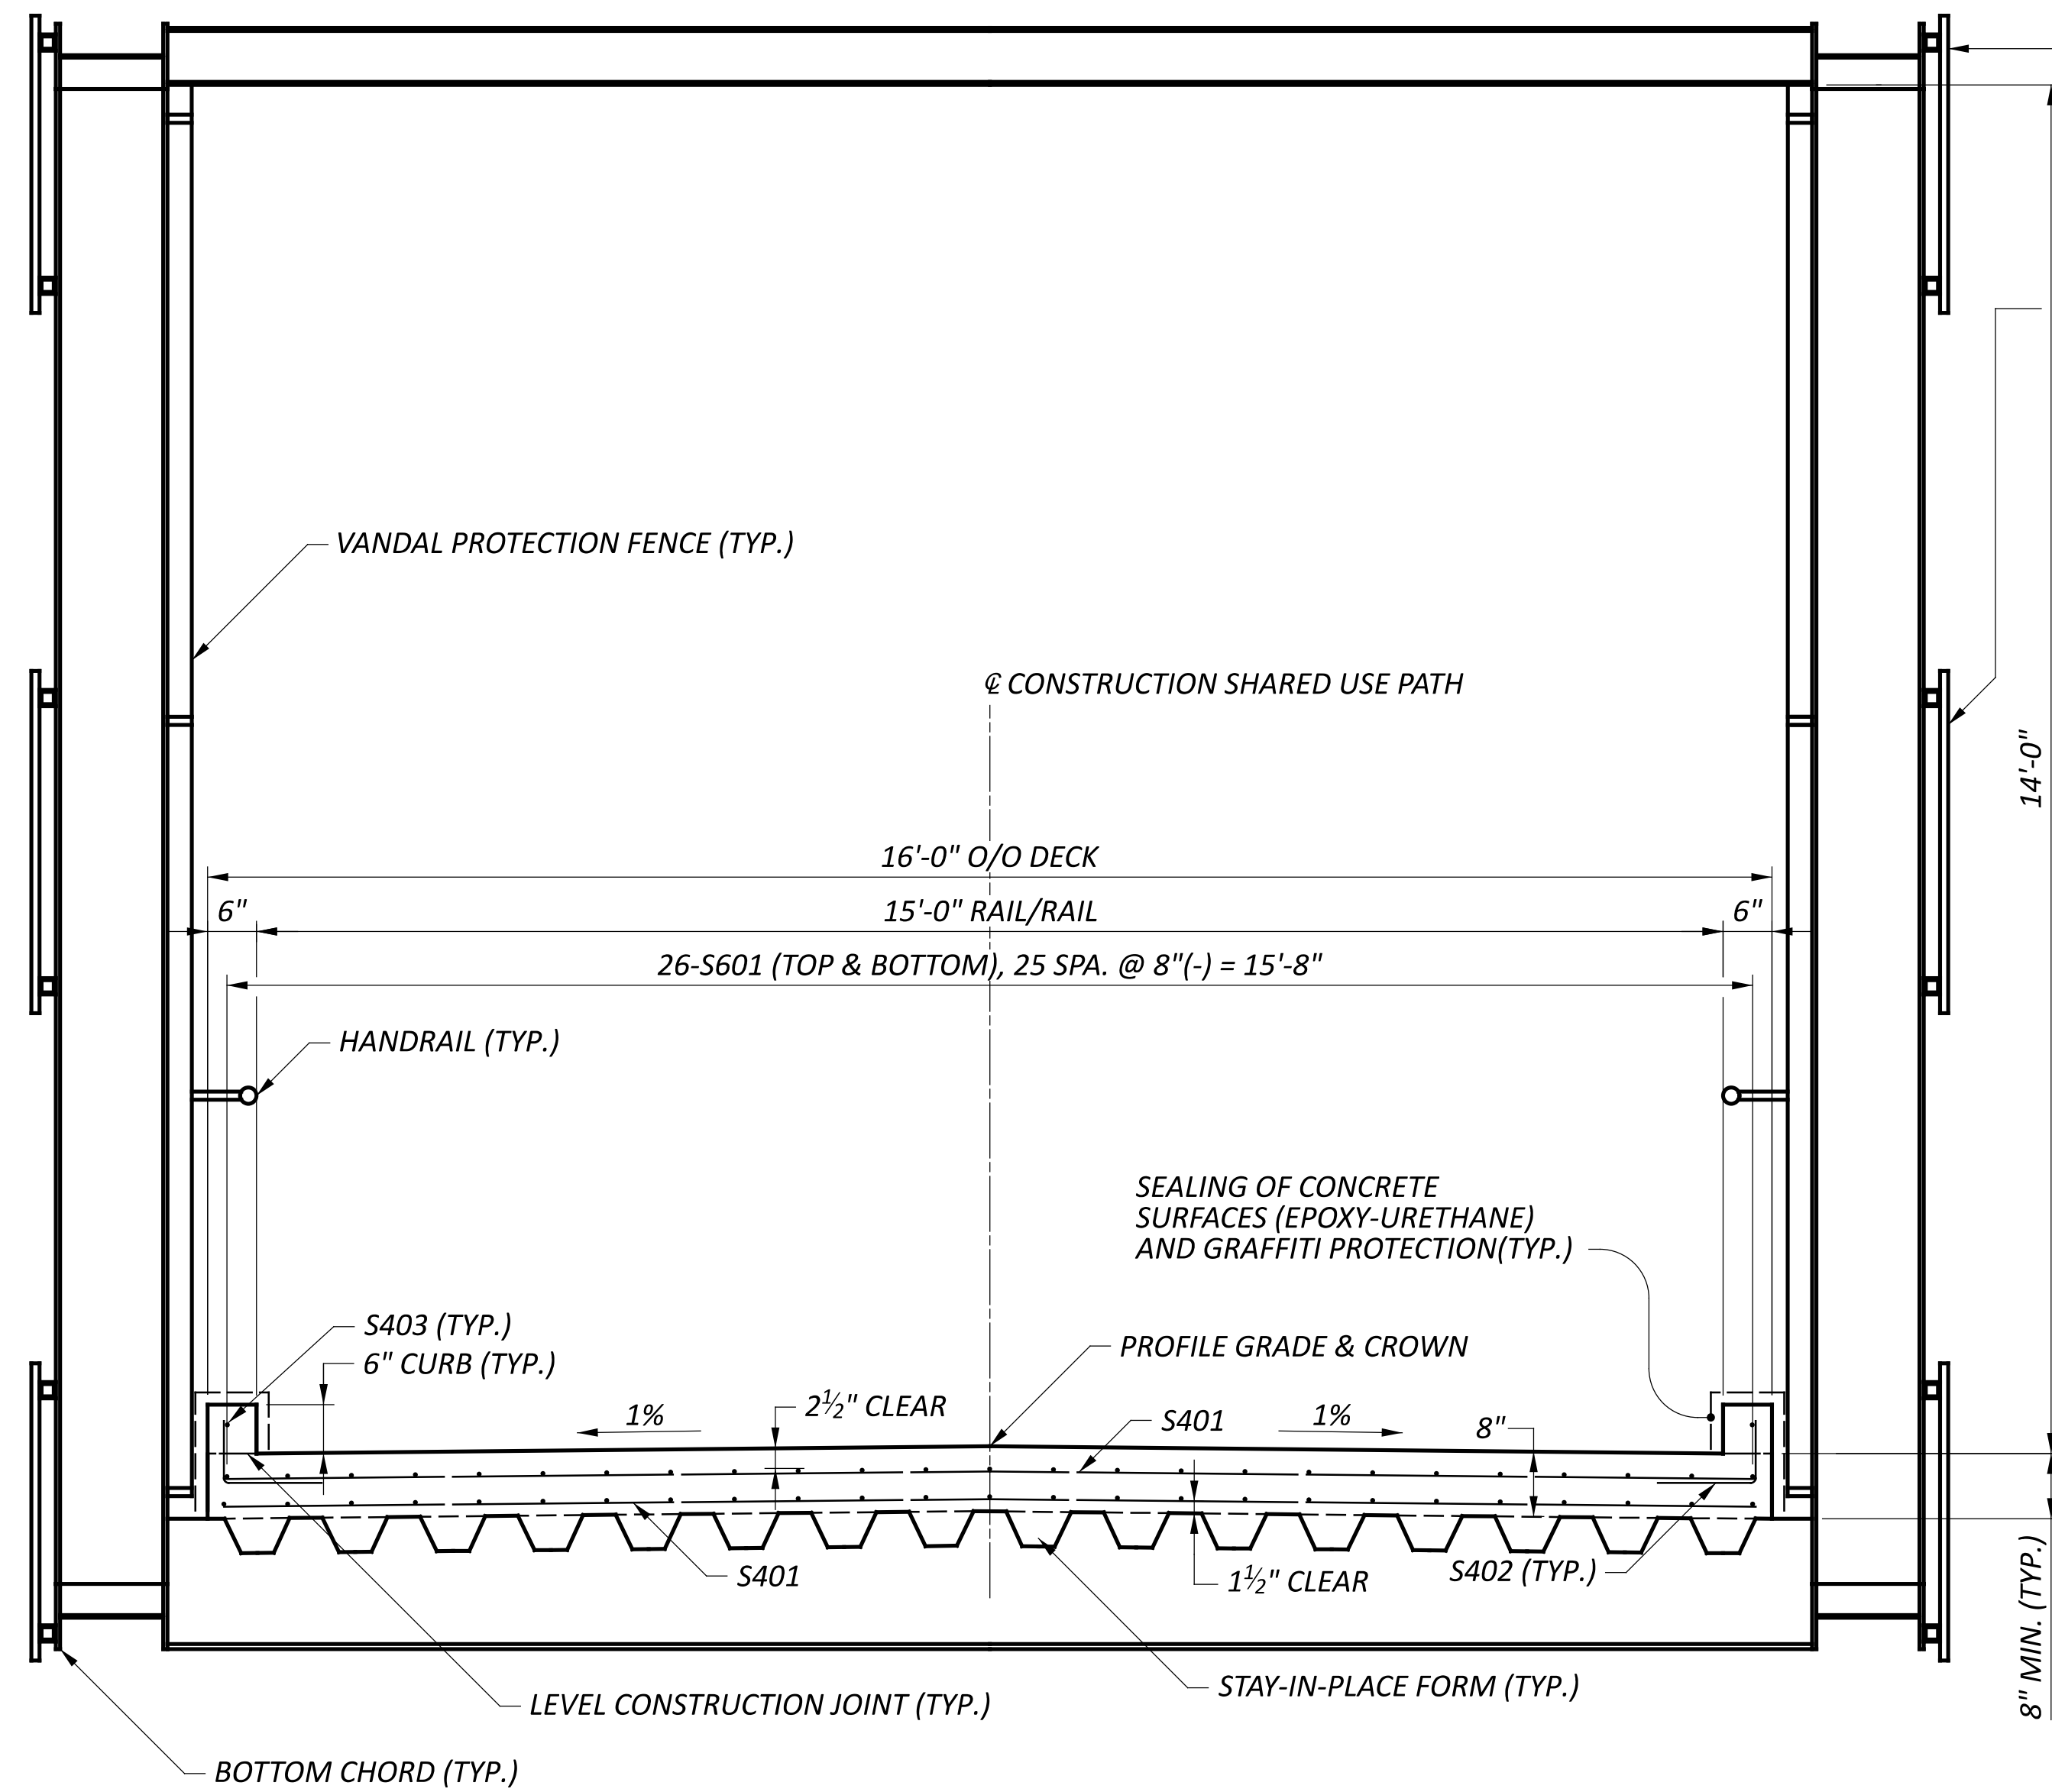

**TRANSVERSE SECTION**  
SPAN 1

GUILLOCHE PATTERN ALONG TOP AND BOTTOM CHORD OF TRUSS (TYP.) (SEE DETAIL THIS SHEET)

LETTERING AND MEDALLIONS (TYP.)

VANDAL PROTECTION FENCE (TYP.)

@ CONSTRUCTION SHARED USE PATH

16'-0" O/O DECK

15'-0" RAIL/RAIL

26-S601 (TOP & BOTTOM), 25 SPA. @ 8"(-) = 15'-8"

HANDRAIL (TYP.)

S403 (TYP.)

6" CURB (TYP.)

PROFILE GRADE & CROWN

S401

1 1/2" CLEAR

S402 (TYP.)


STAY-IN-PLACE FORM (TYP.)

LEVEL CONSTRUCTION JOINT (TYP.)

BOTTOM CHORD (TYP.)

14'-0"

8" MIN. (TYP.)

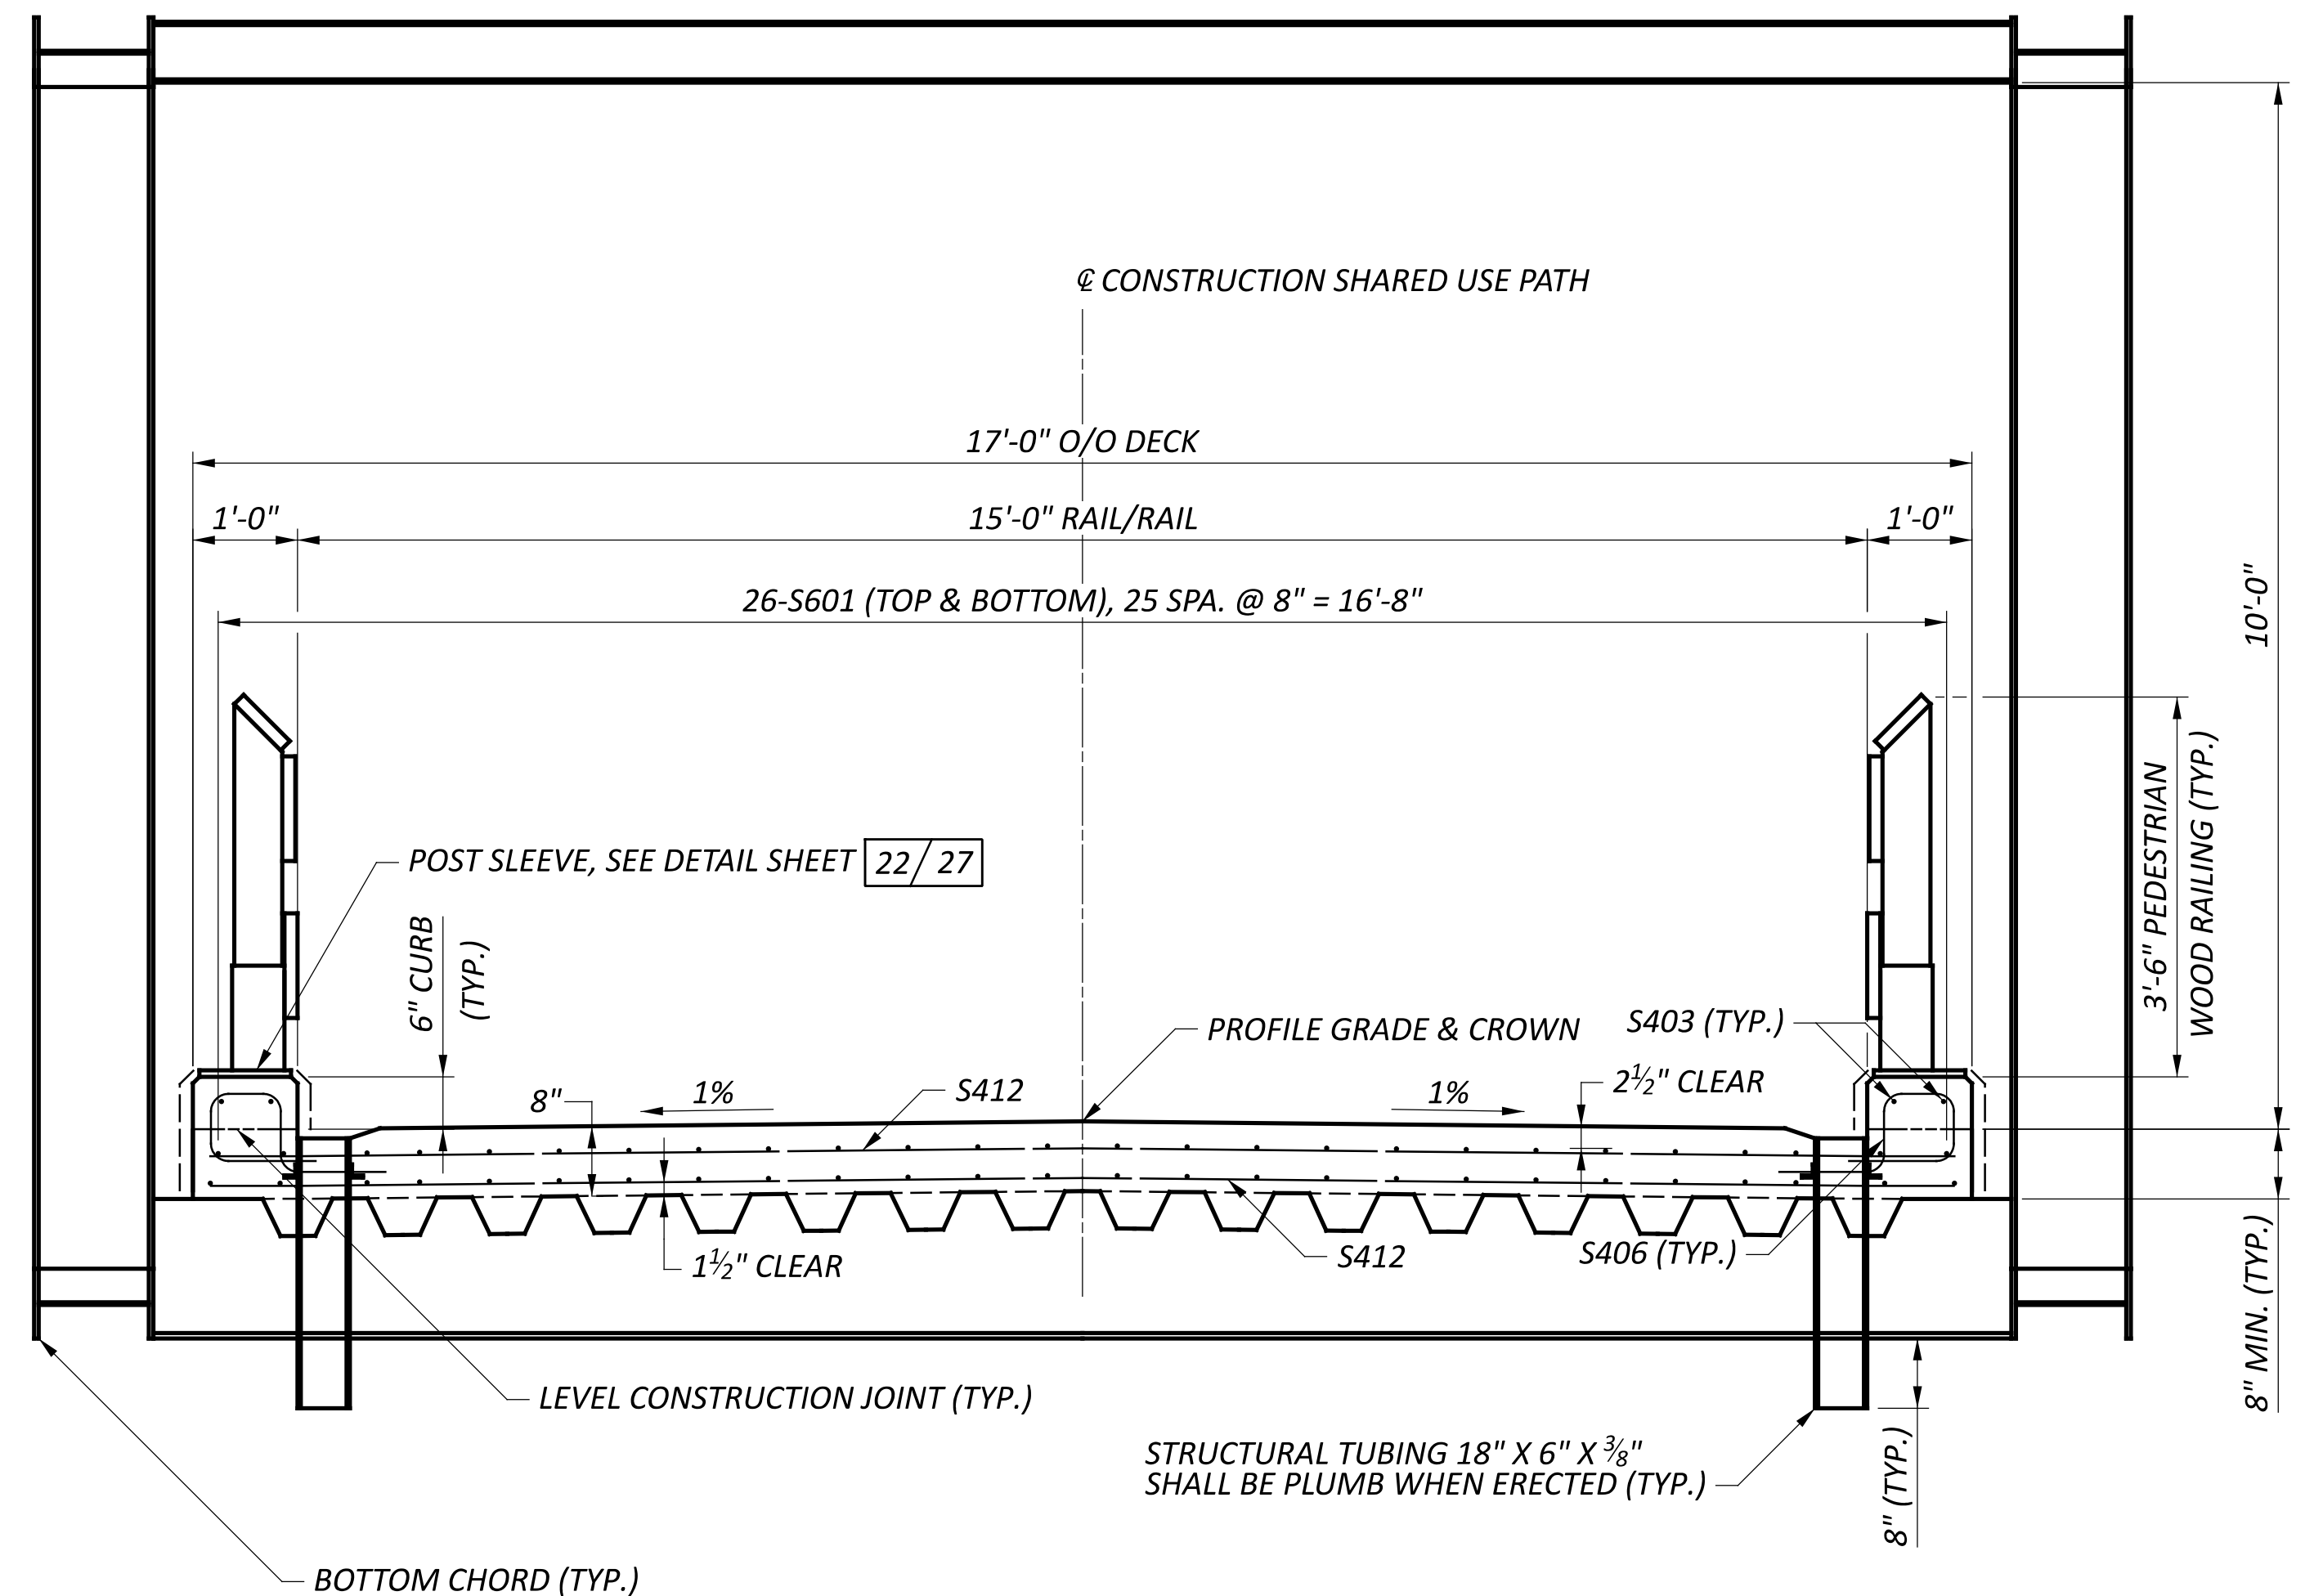

**TRANSVERSE SECTION**  
SPAN 4

GUILLOCHE PATTERN ALONG TOP AND BOTTOM CHORD OF TRUSS (TYP.) (SEE DETAIL THIS SHEET)

LETTERING AND MEDALLIONS (TYP.)

VANDAL PROTECTION FENCE (TYP.)

@ CONSTRUCTION SHARED USE PATH

17'-0" O/O DECK

15'-0" RAIL/RAIL

26-S601 (TOP & BOTTOM), 25 SPA. @ 8" = 16'-8"

POST SLEEVE, SEE DETAIL SHEET 22/27

S412

6" CURB (TYP.)

PROFILE GRADE & CROWN

S412

1 1/2" CLEAR

S406 (TYP.)

LEVEL CONSTRUCTION JOINT (TYP.)

BOTTOM CHORD (TYP.)


STRUCTURAL TUBING 18" X 6" X 3/8" SHALL BE PLUMB WHEN ERECTED (TYP.)

10'-0"


8" MIN. (TYP.)

3'-6" PEDESTRIAN WOOD RAILING (TYP.)


SFN	2926107
DESIGN AGENCY	CARPENTER MARTY
DESIGNER	CHECKER
SMH	AMR
REVIEWER	
GDJ	03/28/25
PROJECT ID	115388
SUBSET	TOTAL
23	27
SHEET	TOTAL
P.69	P.107

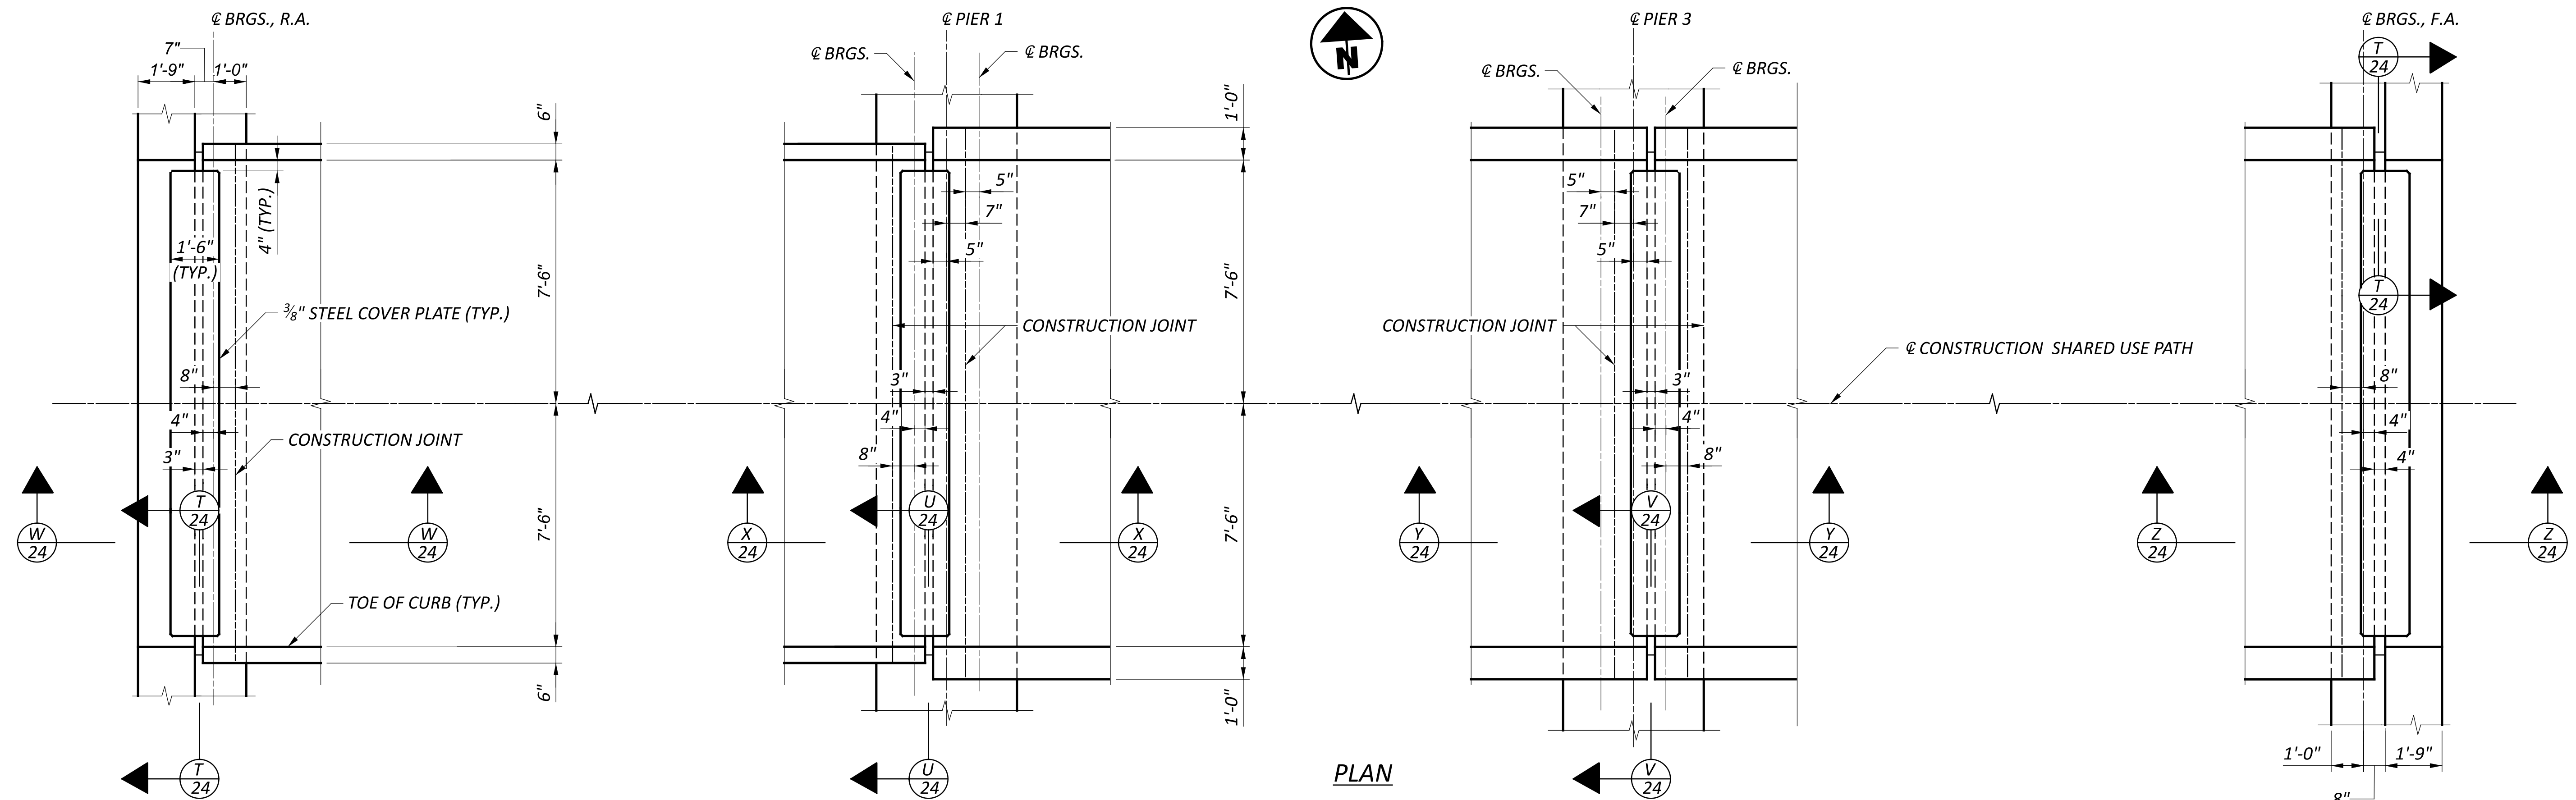


PLAN

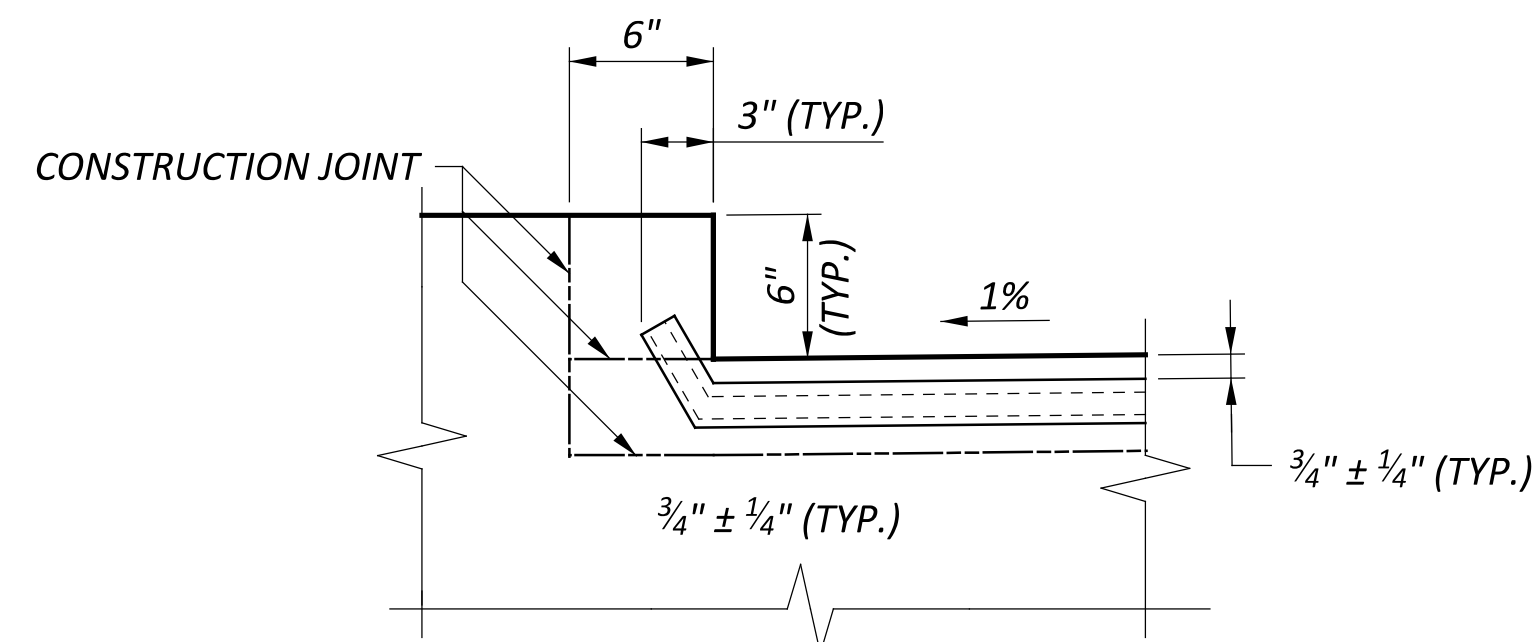

T SECTION  
24

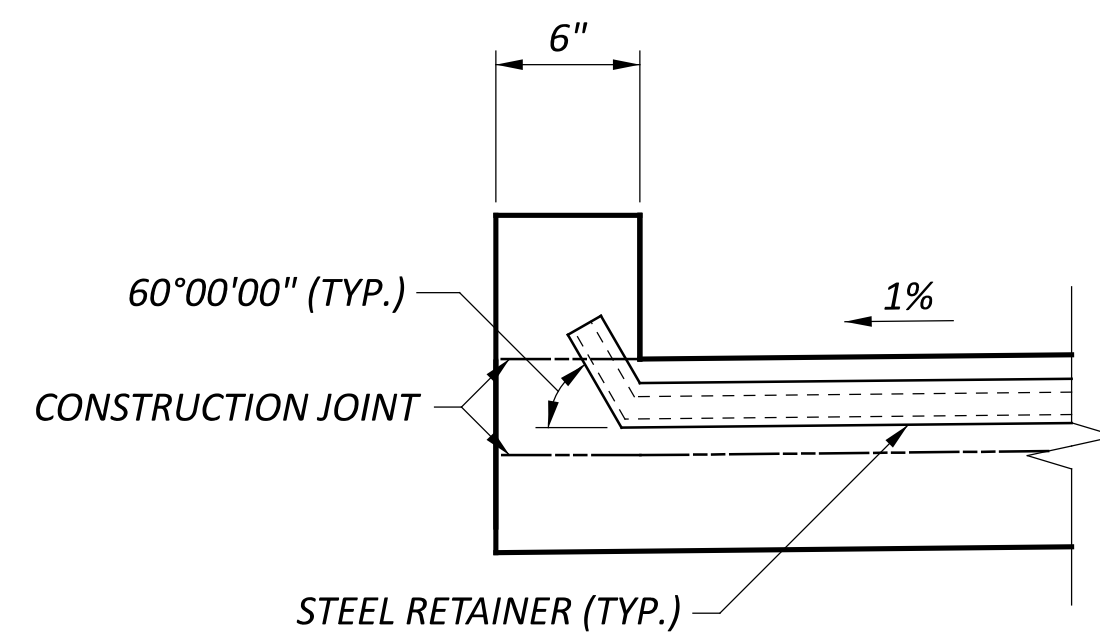


U SECTION  
24

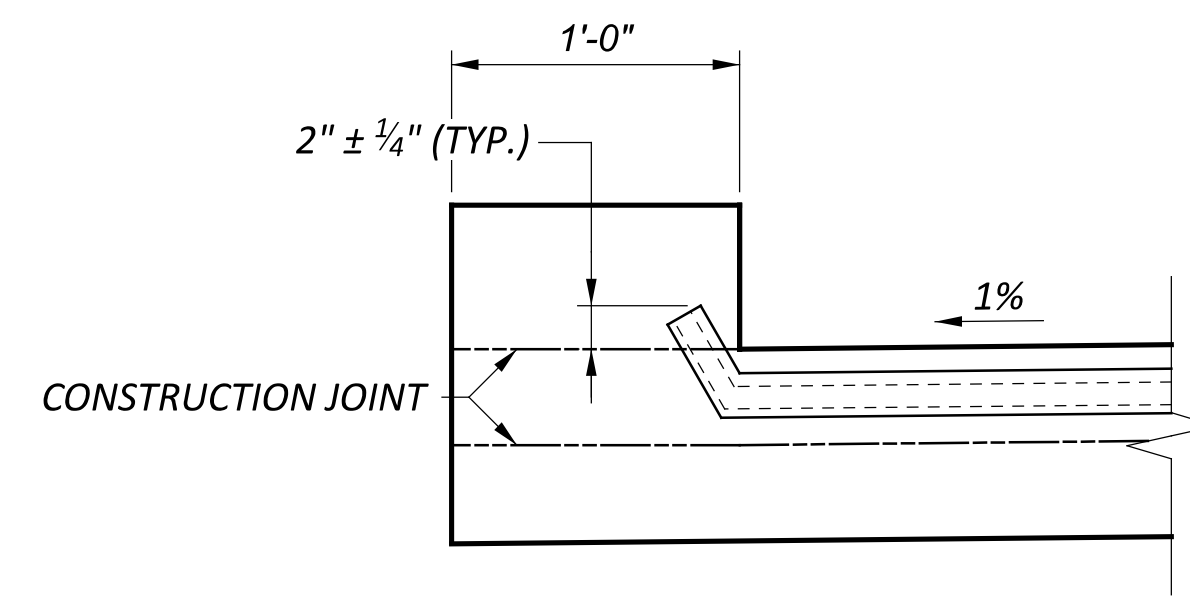


V SECTION  
24

**NOTES**


1. UTILIZE WABO STRIP SEAL MODEL CRETE SE-400 WITH SINUSOIDAL ANCHORAGE AT ALL LOCATIONS.
2. REFER TO STD. DWG. EXJ-6-17 FOR ADDITIONAL NOTES AND DETAILS.
3. STEEL RETAINERS AND COVER PLATES SHALL BE FABRICATED TO MATCH CROSS-SLOPE OF DECK.

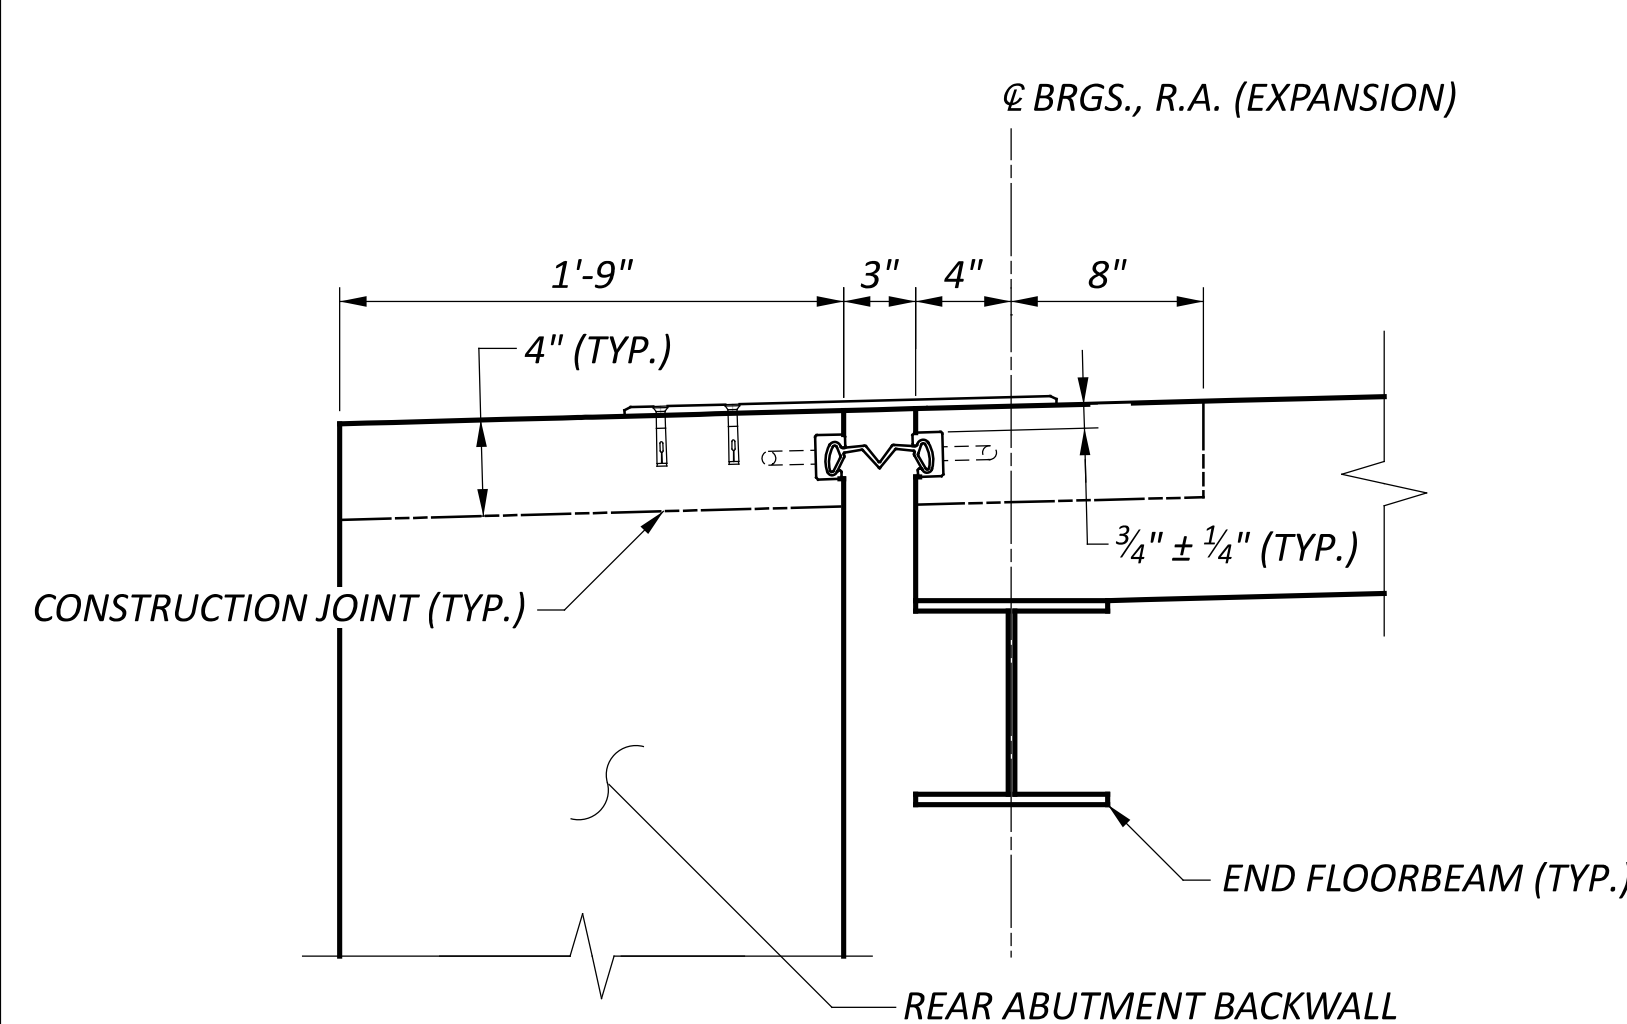


W SECTION  
24

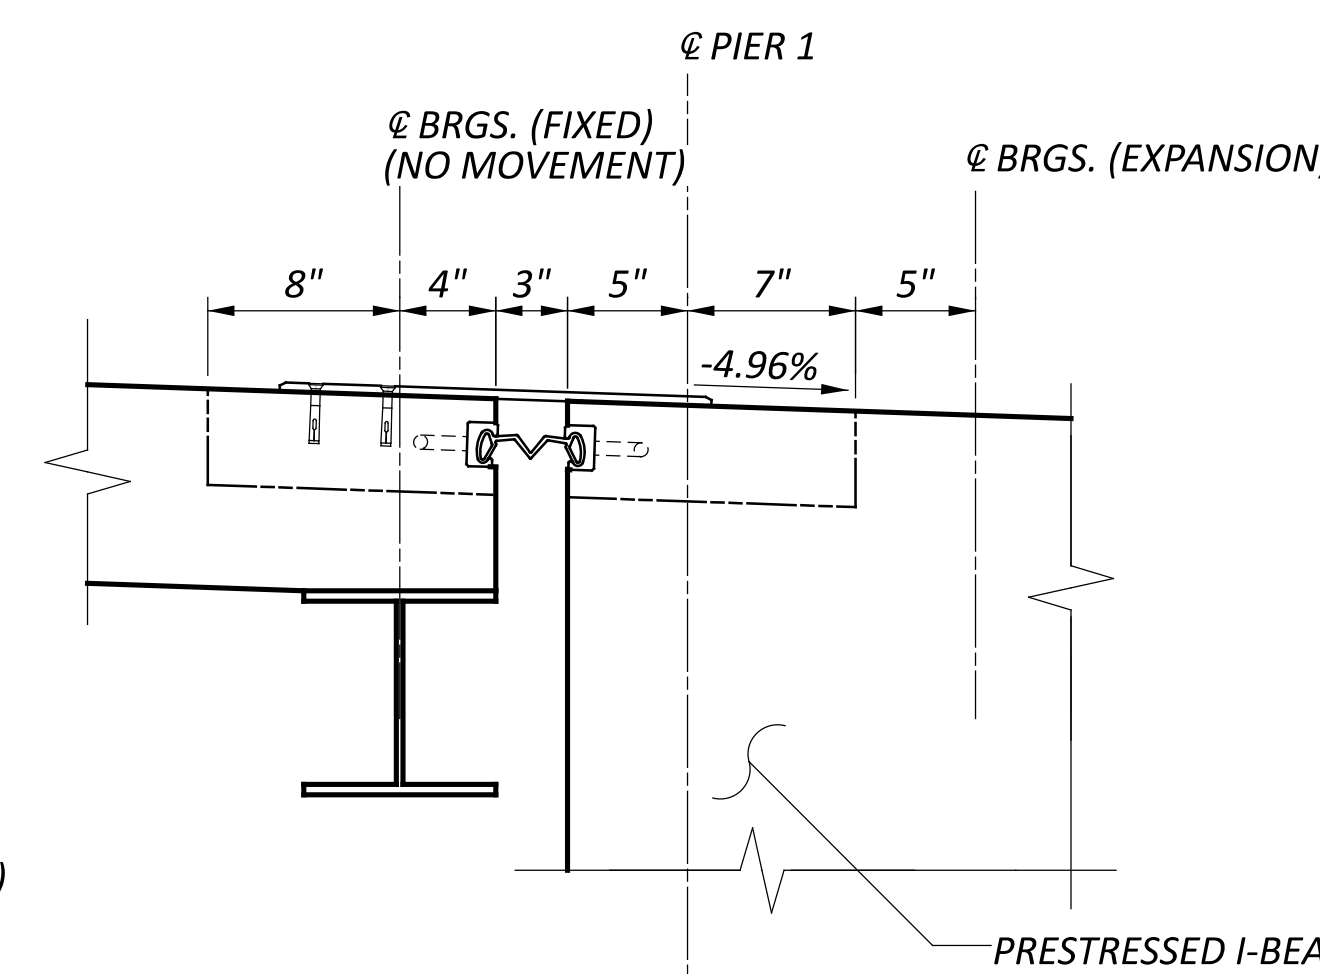

X SECTION  
24

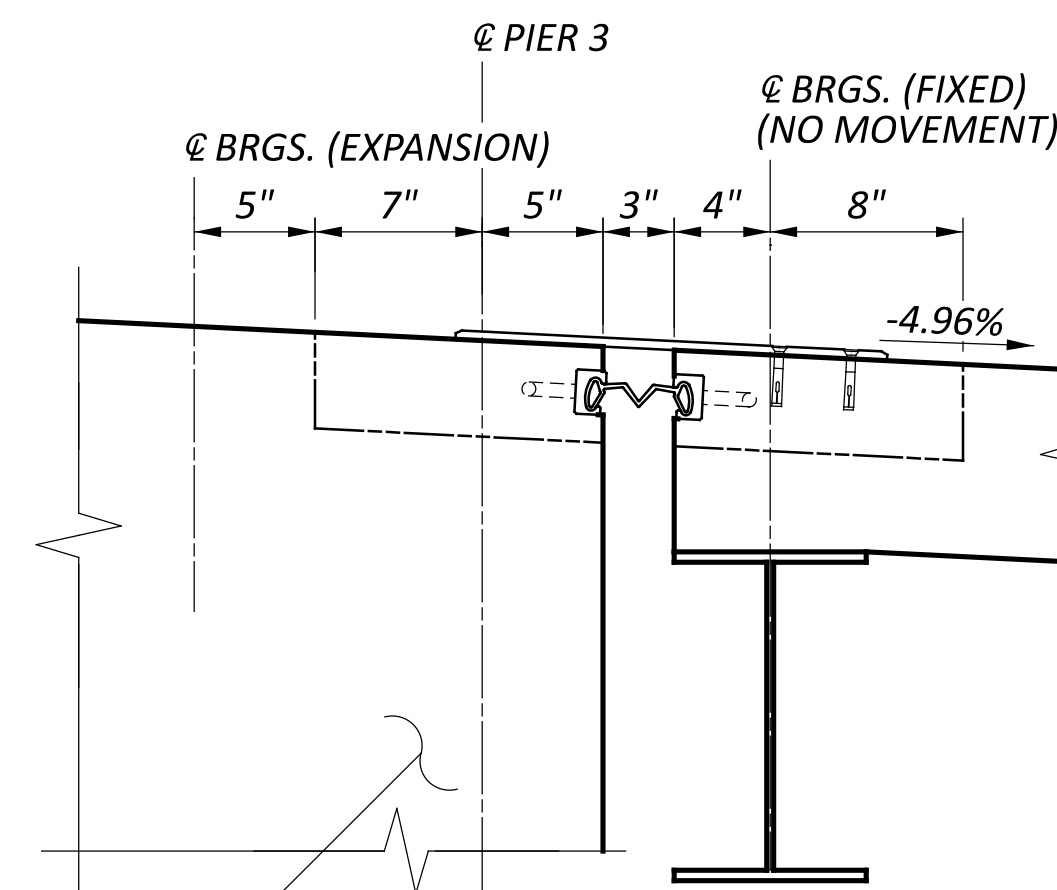

Y SECTION  
24

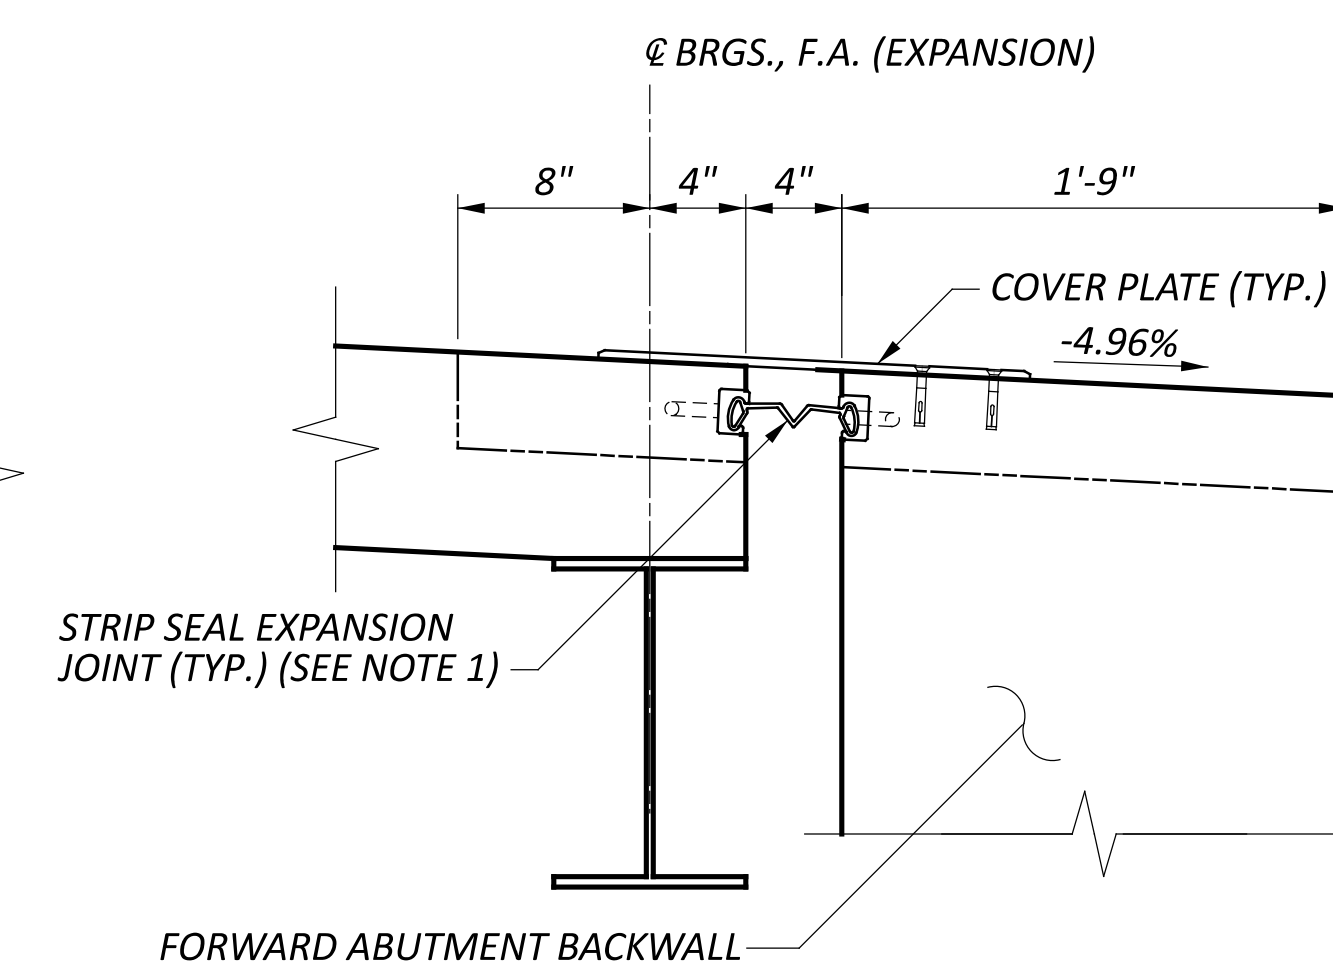


Z SECTION  
24

SFN	2926107
DESIGN AGENCY	CARPENTER MARTY
DESIGNER	CHECKER
AMR	SMH
REVIEWER	
GDJ	03/28/25
PROJECT ID	115388
SUBSET	TOTAL
24	27
SHEET	TOTAL
P.70	P.107


**LEGEND**

! - ELEVATION TAKEN AT TOP OF SLAB


# - 4-S406, 3 SPA. @ 1'-1" = 3'-3"

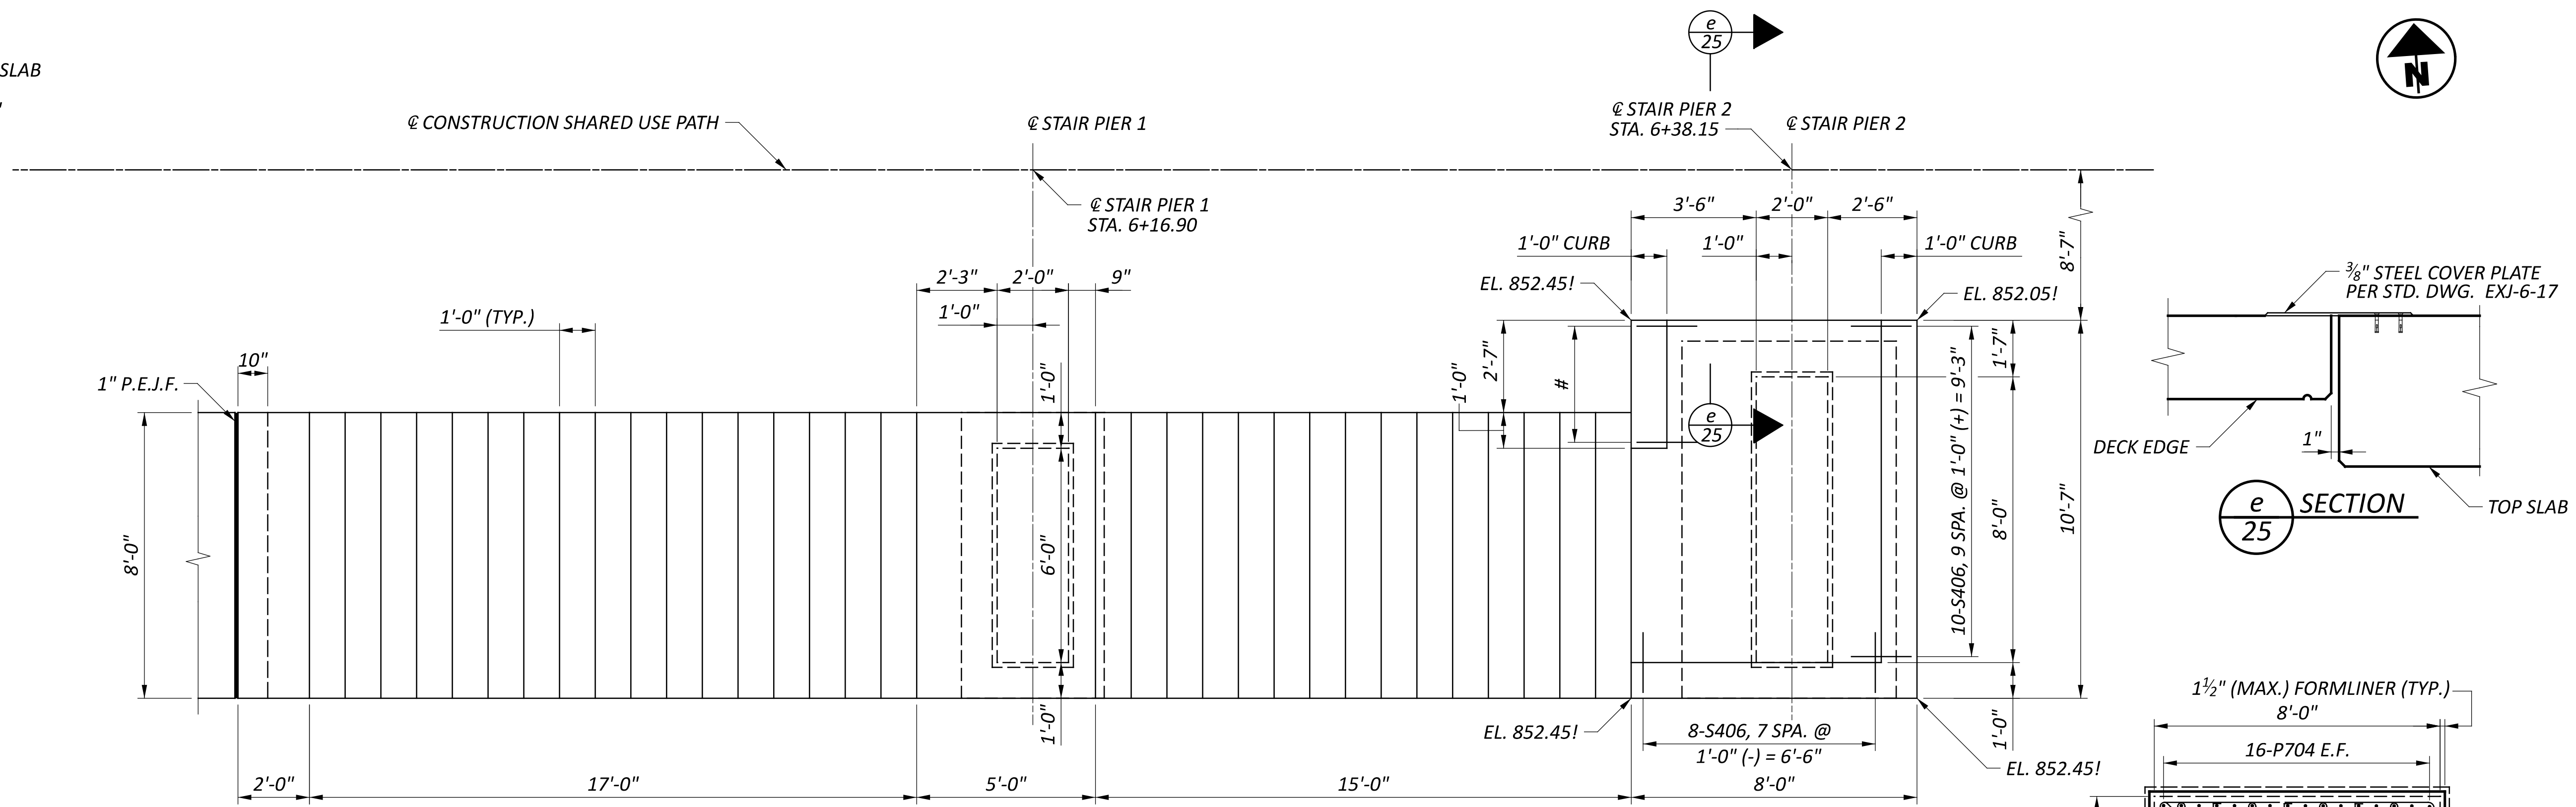


**PLAN**

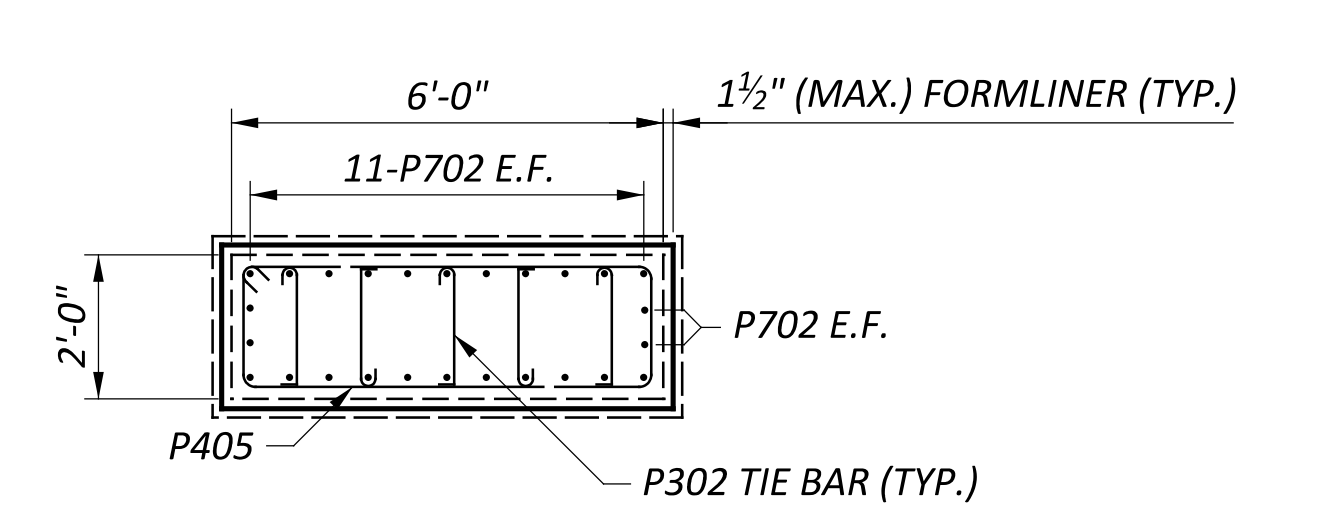


**c** SECTION  
25

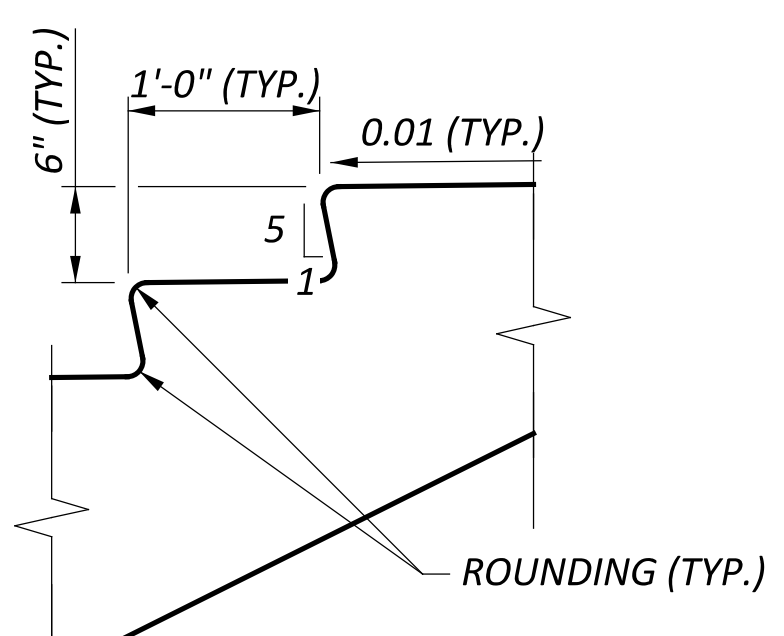


**NOSING DETAIL**

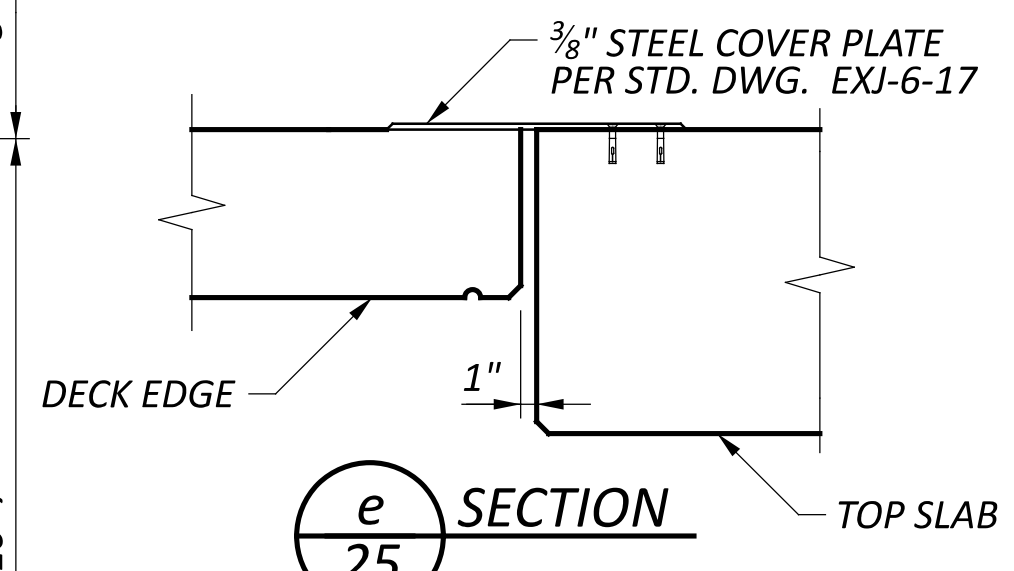


**e** SECTION  
25

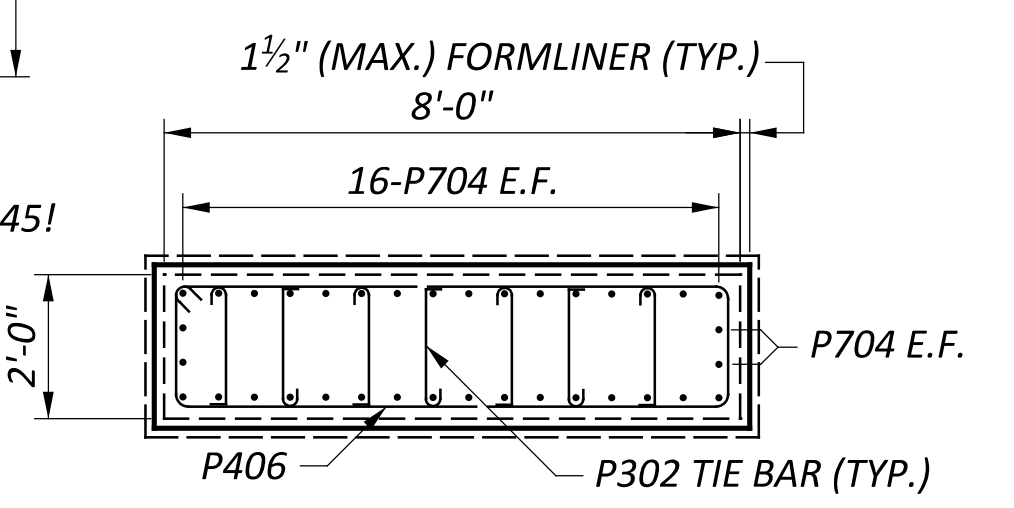


**d** SECTION  
25

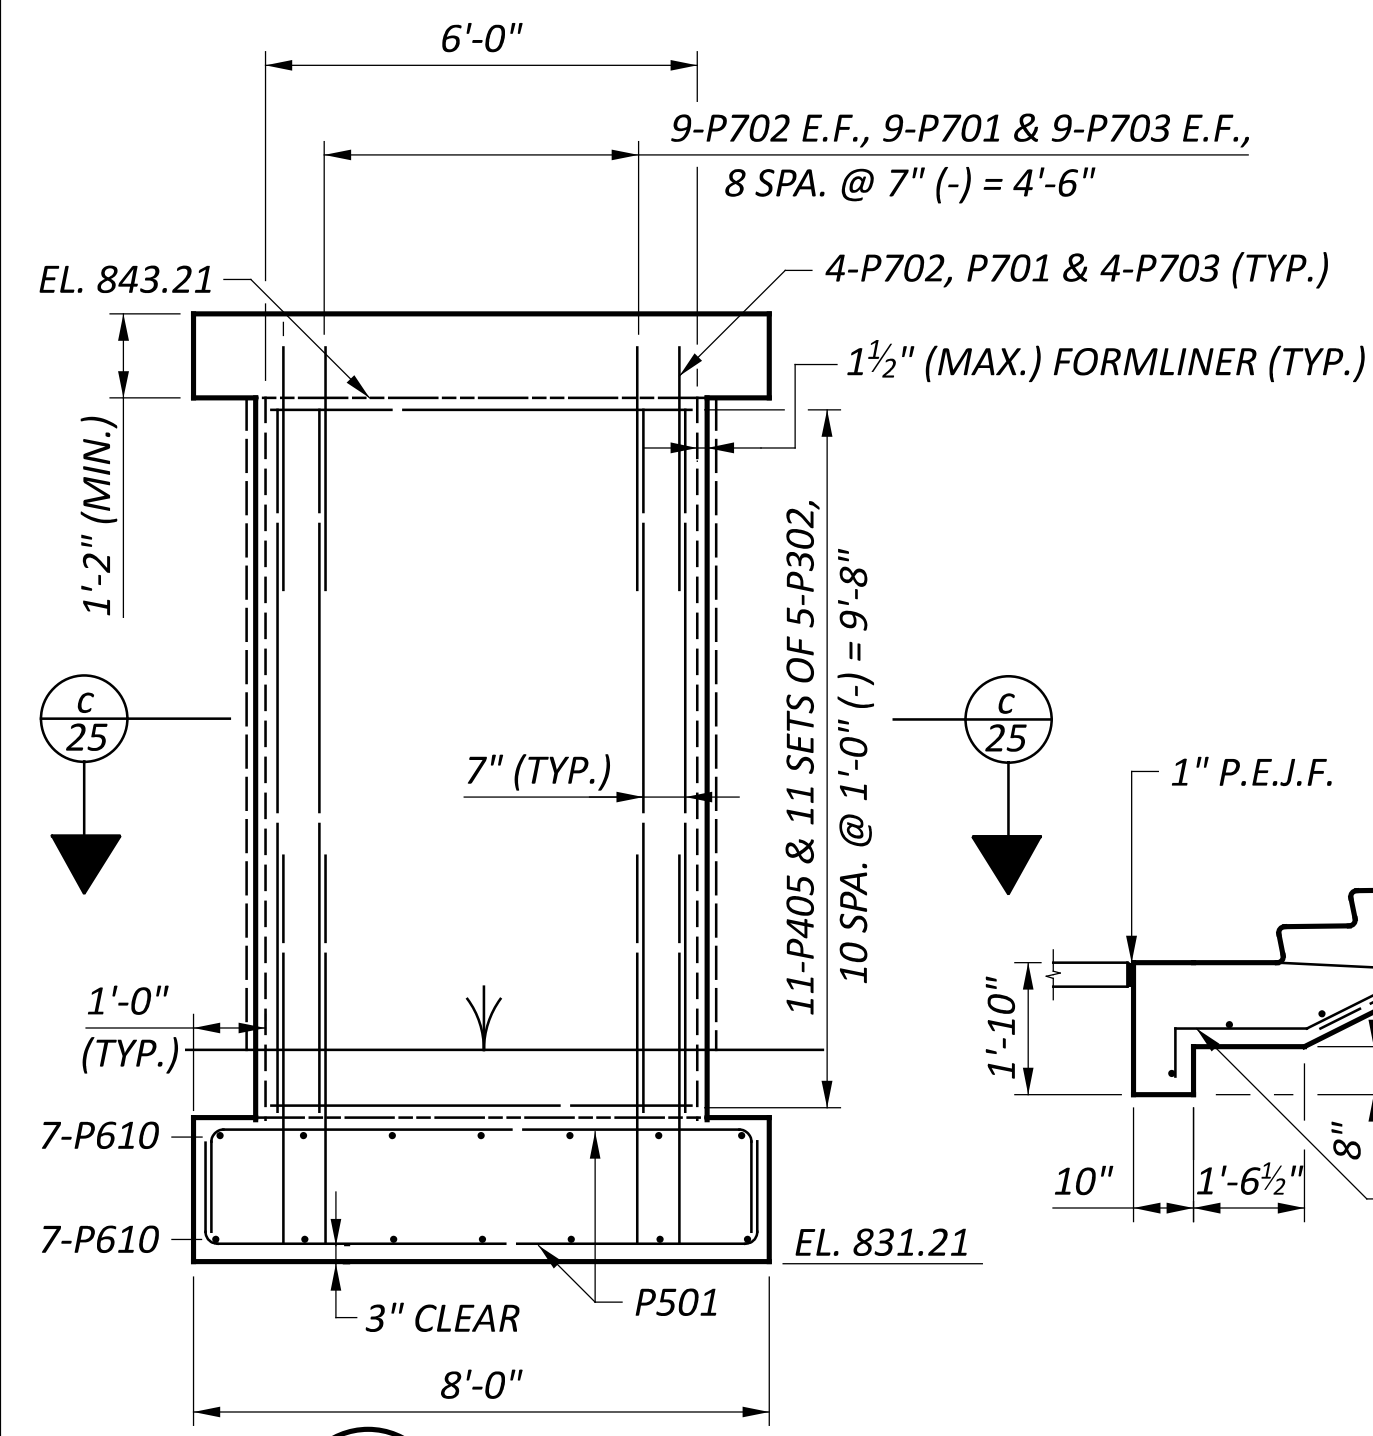


**a** SECTION  
25

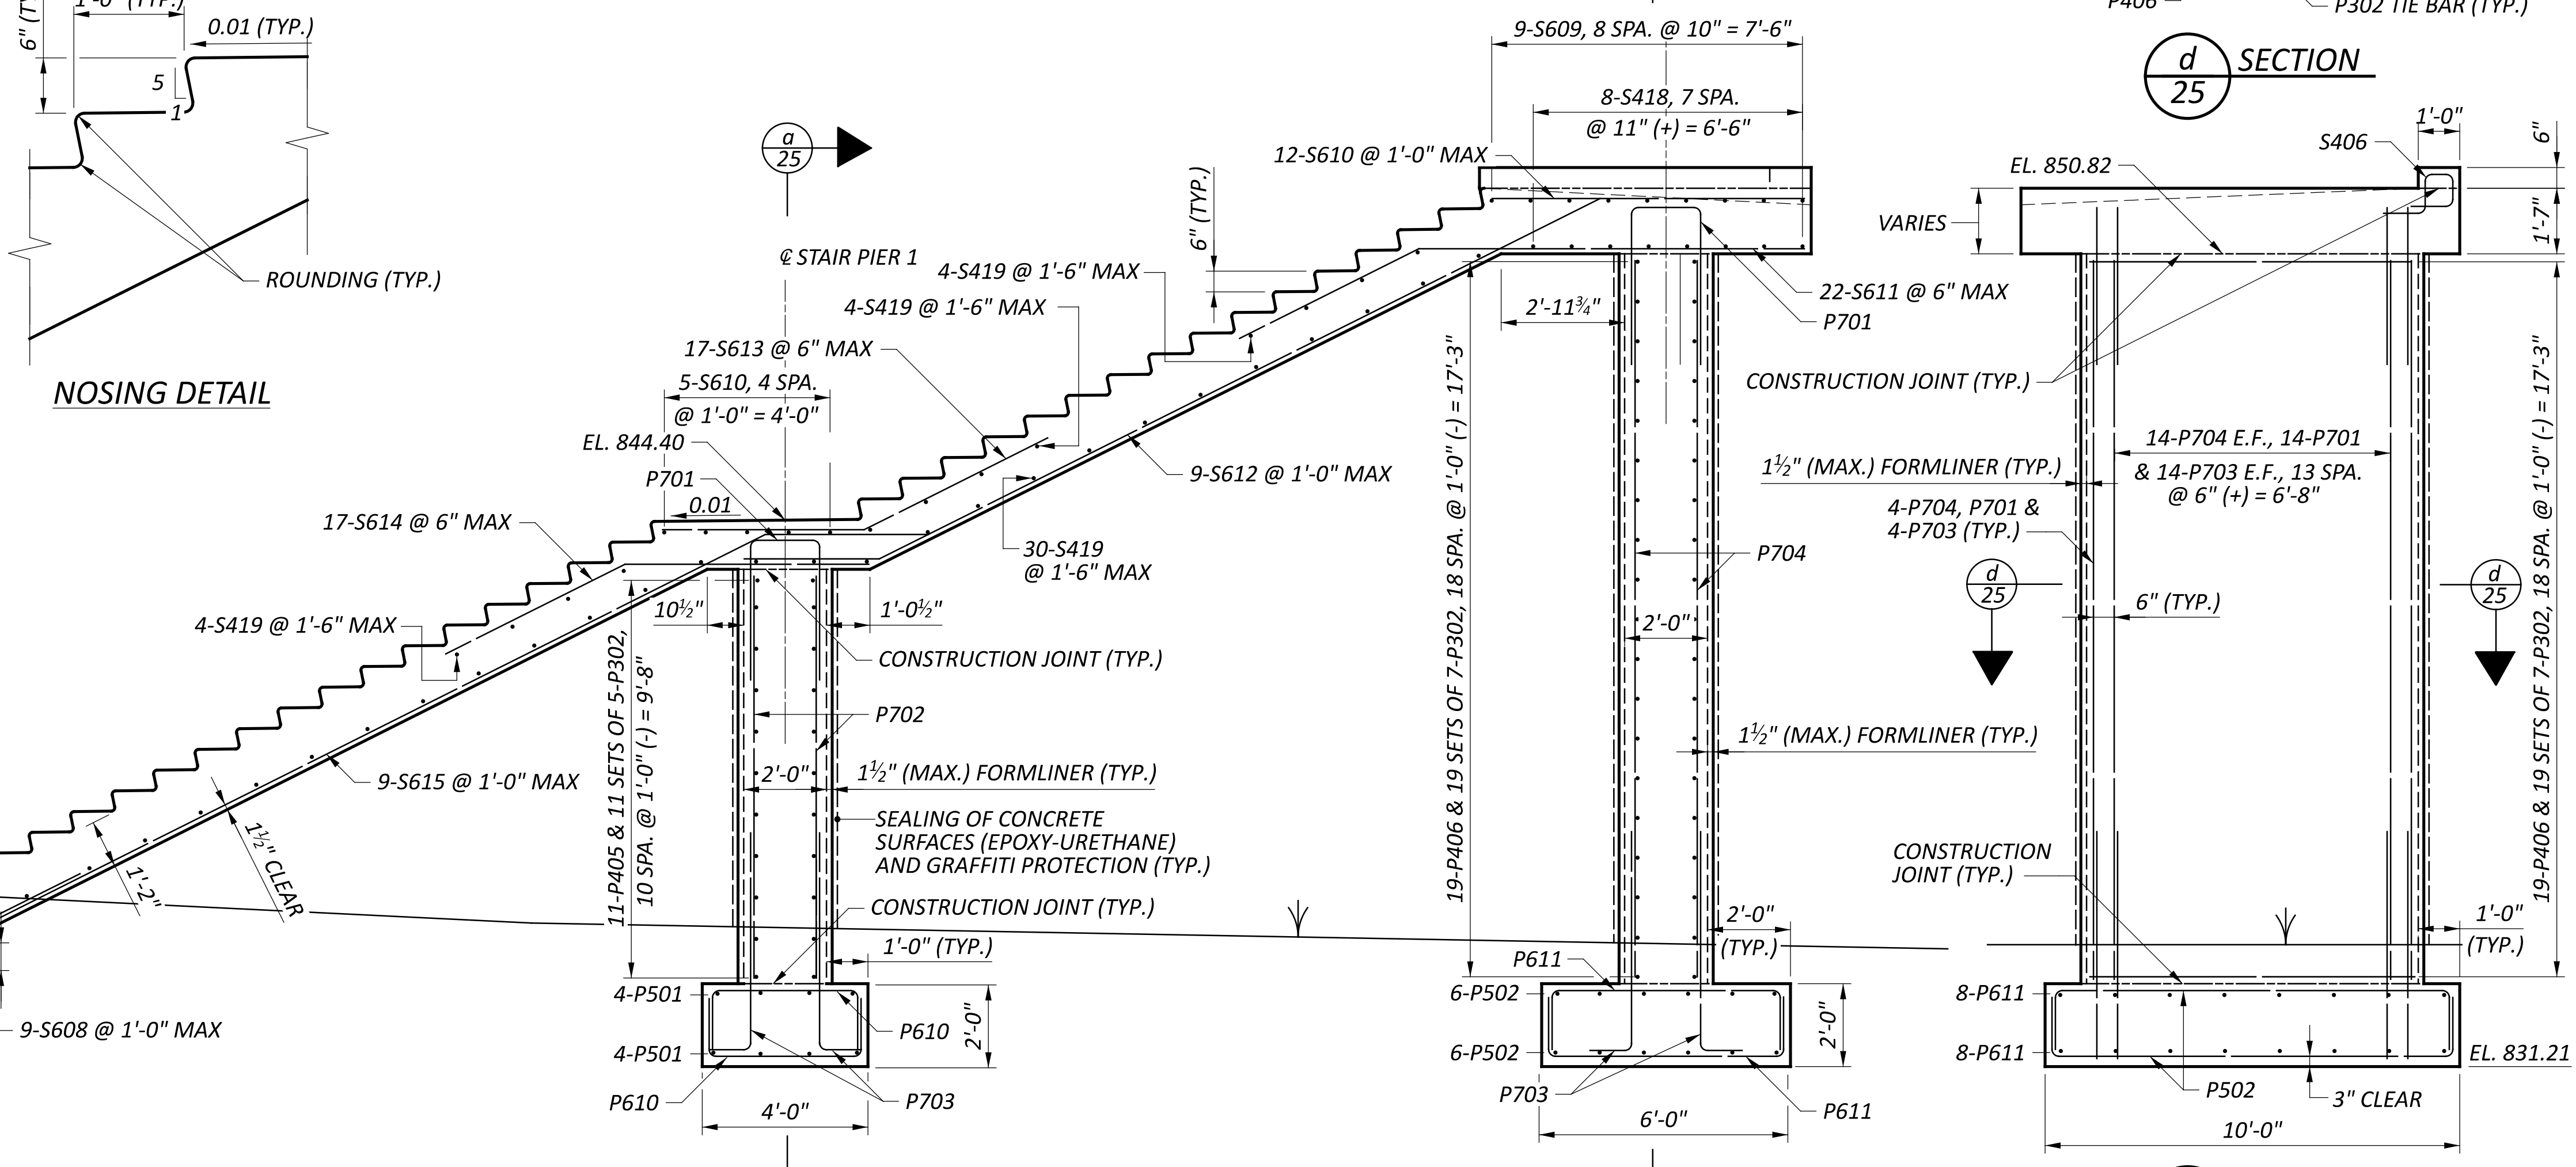

**ELEVATION**

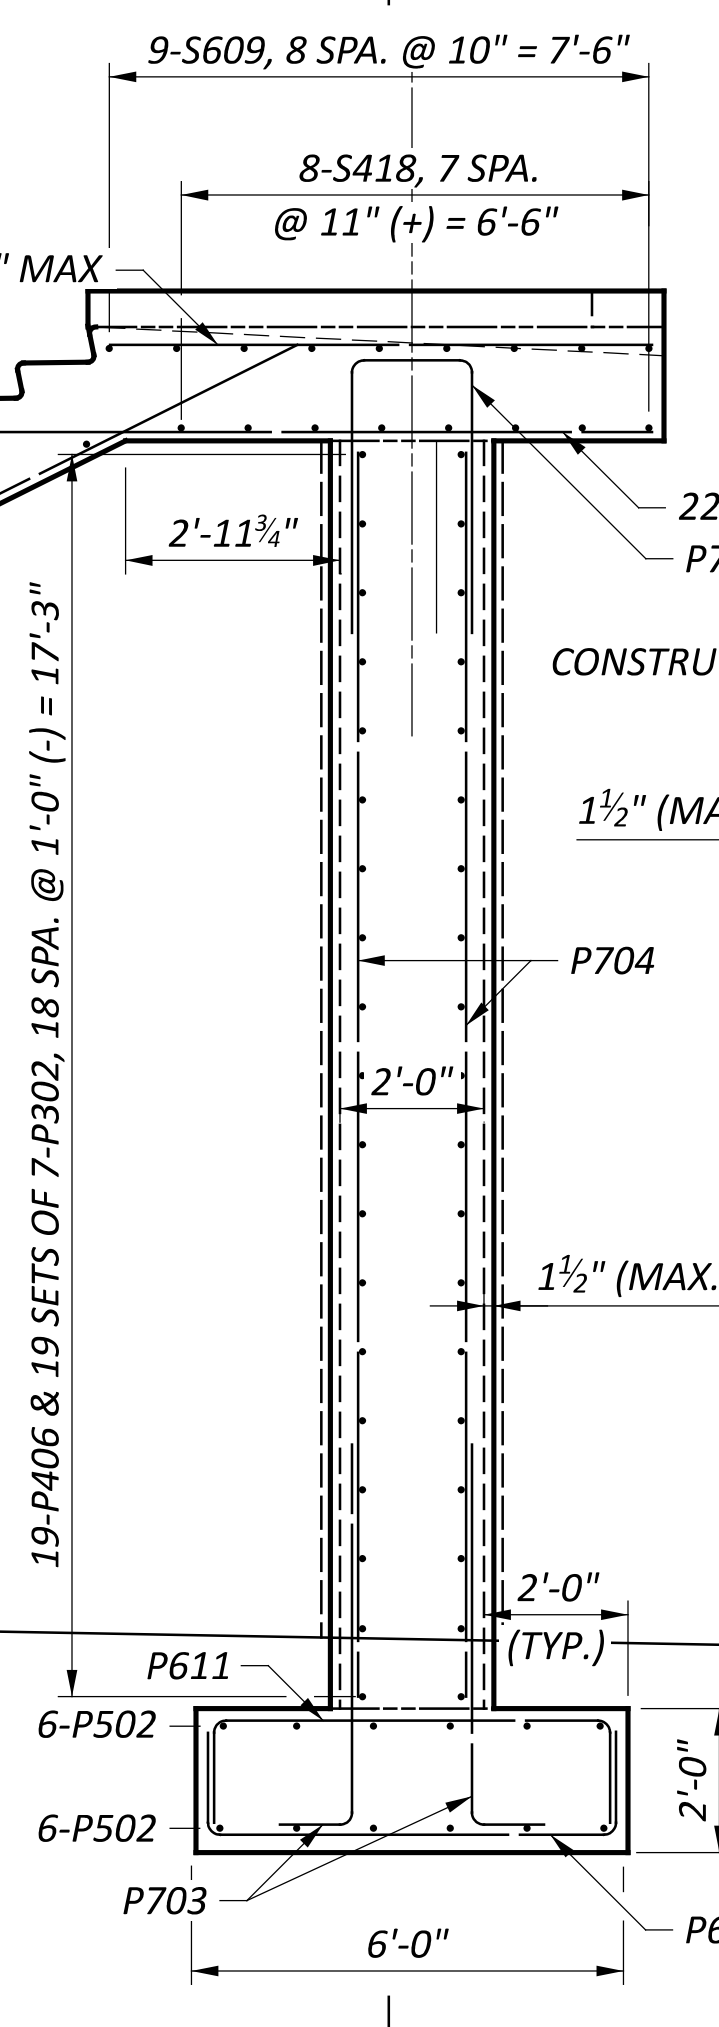

**b** SECTION  
25

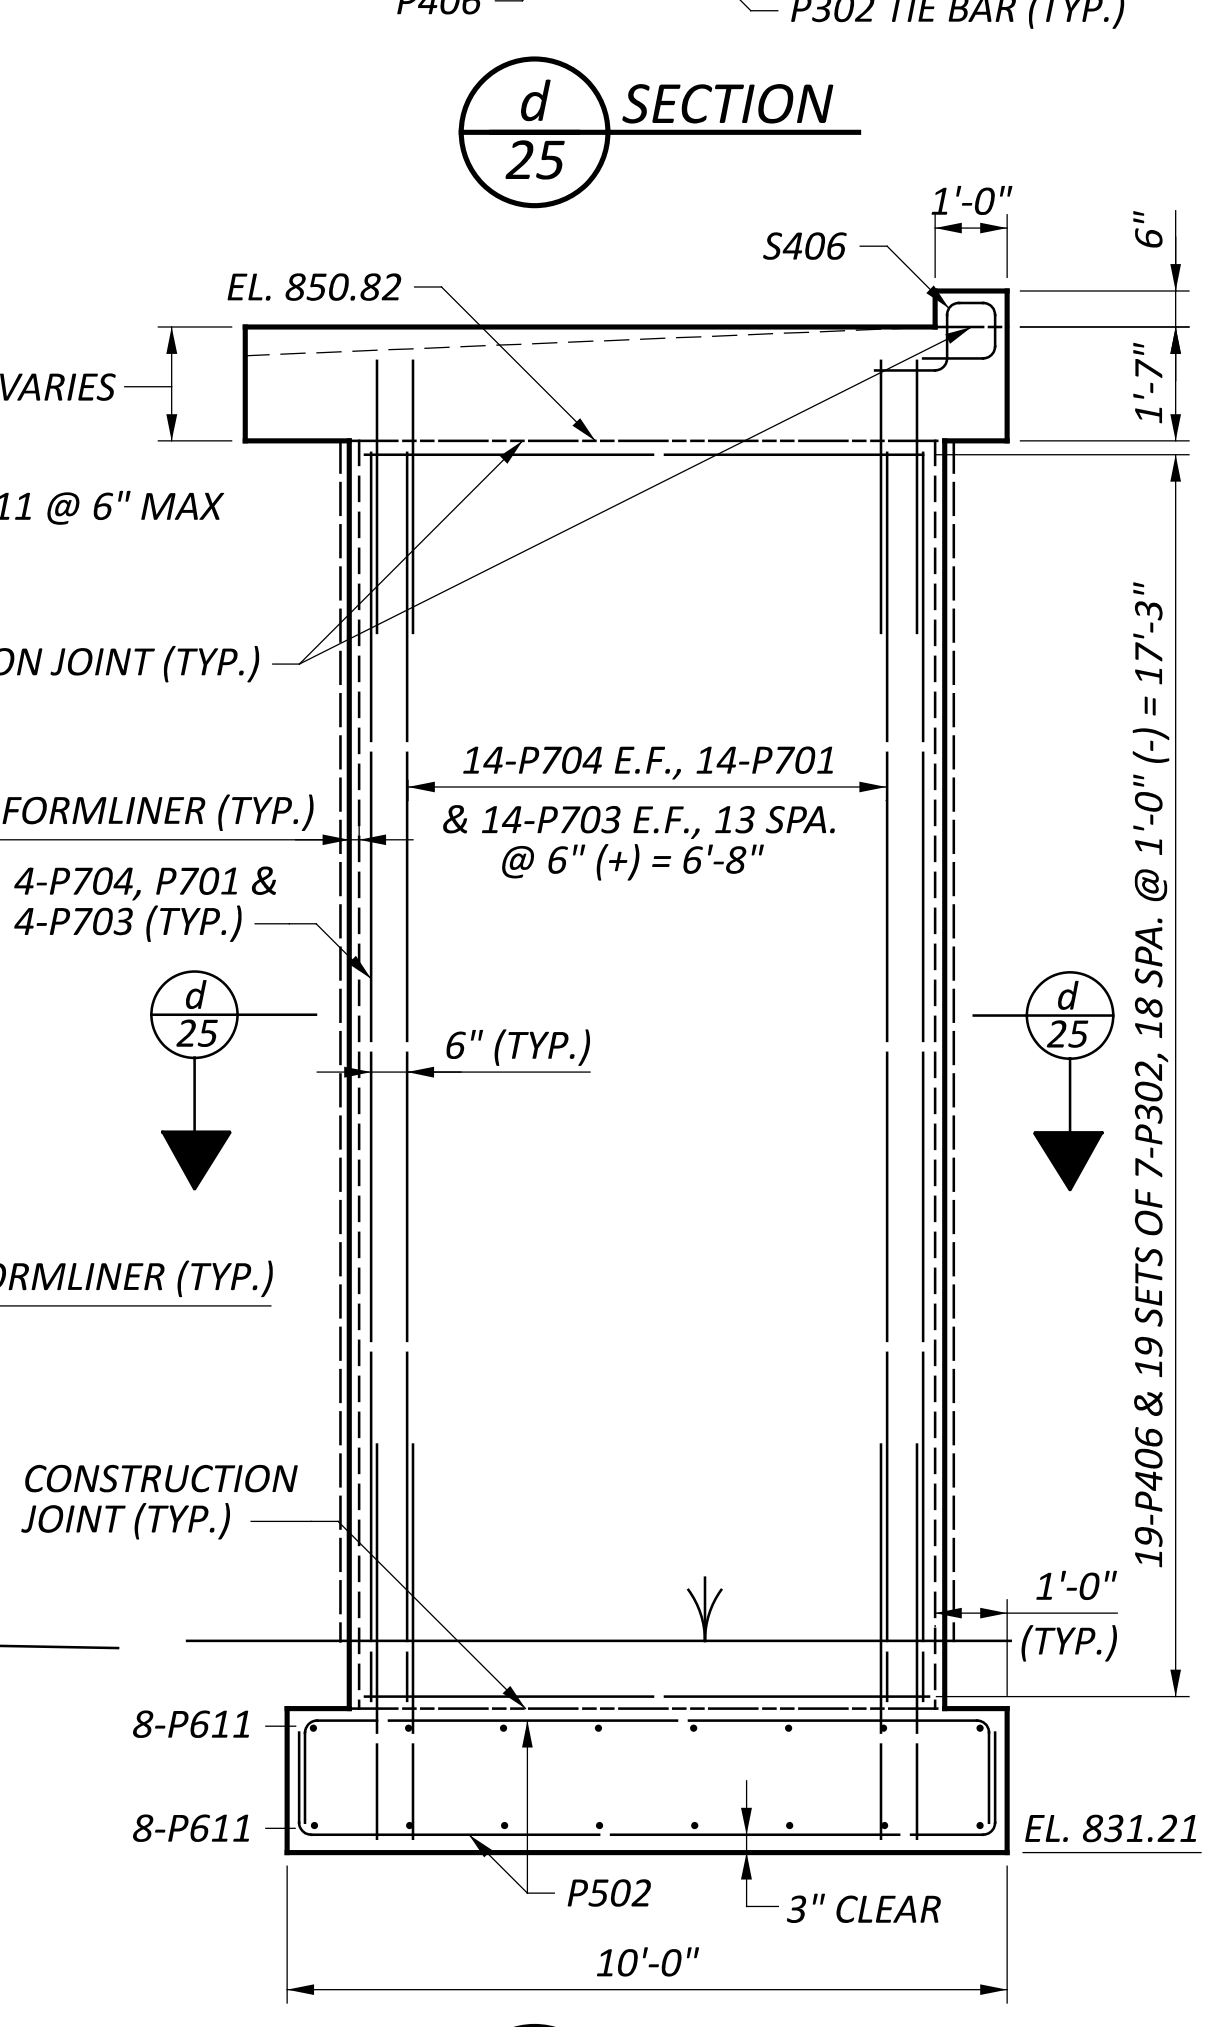

**d** SECTION  
25

GRE-68-12.65

MODEL SHEET PAPER SIZE: 34x22 (in.) DATE: 3/31/2025 TIME: 4:30:22 PM USER: wshannon  
P:\DBP\LAG\0003\_GRE-68-12.65\115388\400-Engineering\Structures\SFN\_2926107\Sheets\115388\_SF\_N\_2926107\_SV0001.dgn

BRIDGE STAIRWAY  
BRIDGE NO. GRE-BK80020-00.492  
PEDESTRIAN BRIDGE OVER US 68 AND OLD TOWN CREEK

DESIGNER	CHECKER
JZ	AMR
REVIEWER	
PROJECT ID	115388
SUBSET	TOTAL
25	27
SHEET	TOTAL
P.71	P.107


BAR MARK	MATERIAL TYPE	TOTAL	LENGTH	WEIGHT	TYPE	DIMENSIONS				
						A	B	C	D	R
<b>SUPERSTRUCTURE (GALVANIZED STEEL REINFORCEMENT - GSR)</b>										
S301	GSR	2	3'-4"	3	19	1'-8"	1'-0"	1'-4"		
S401	GSR	192	15'-8"	2010	STR					
S402	GSR	192	1'-6"	193	1	7"	1'-0"			
S403	GSR	222	30'-0"	4449	STR					
S404	GSR	2	10'-0"	14	STR					
S405	GSR	474	8'-8"	2745	2	5'-4"	6"	3'-1"		
S406	GSR	791	3'-9"	1982	30	1'-0"	8"	11"	7"	
S407	GSR	23	8'-10"	136	STR					
S408	GSR	2	40'-10"	55	STR					
S409	GSR	2	18'-5"	25	STR					
S410	GSR	8	3'-0"	17	STR					
S411	GSR	4	7'-4"	20	STR					
S412	GSR	300	16'-8"	3340	STR					
S413	GSR	6	12'-11"	52	6	1'-4"	5'-0"	1'-0"		
S414	GSR	4	3'-6"	10	2	6"	2'-9"	6"		
S415	GSR	2	11'-4"	16	24	4"	5'-5"			2"
S416	GSR	12	7'-4"	59	2	3'-1"	1'-5"	3'-1"		
S417	GSR	12	7'-1"	57	2	3'-1"	1'-2"	3'-1"		
S418	GSR	8	10'-3"	55	STR					
S419	GSR	42	7'-8"	216	STR					
S501	GSR	237	17'-10"	4409	17	16'-8"				
S502	GSR	237	16'-8"	4120	STR					
S503	GSR	184	30'-0"	5758	STR					
S504	GSR	23	11'-6"	276	STR					
S505	GSR	32	3'-7"	120	2	1'-7"	8"	1'-7"		
S601	GSR	416	30'-0"	18745	STR					
S602	GSR	52	12'-3"	957	STR					
S603	GSR	20	40'-0"	1202	STR					
S604	GSR	52	11'-1"	866	STR					
S605	GSR	22	8'-0"	265	STR					
S606	GSR	8	5'-3"	64	1	1'-6"	3'-11"			
S607	GSR	16	8'-1"	195	13	2'-9"	7"	1'-2"	4'-1"	
S608	GSR	9	5'-6"	75	39	8"	2'-0"	2'-8"	1'-4"	
S609	GSR	9	10'-3"	139	STR					
S610	GSR	17	7'-8"	196	STR					
S611	GSR	22	14'-1"	466	19	9'-3"	4'-4"	2'-2"		
S612	GSR	9	22'-8"	307	19	19'-9"	2'-8"	1'-4"		
S613	GSR	17	9'-9"	249	19	4'-11"	4'-4"	2'-2"		
S614	GSR	17	10'-9"	275	19	5'-11"	4'-4"	2'-2"		
S615	GSR	9	25'-7"	346	19	21'-8"	3'-6"	1'-9"		
<b>SUPERSTRUCTURE GSR SUBTOTAL</b>				<b>54484</b>						

**NOTES**

1. THE NUMBER IS SPECIFIED ON THE PLANS IN THE BAR MARK COLUMN. THE FIRST DIGIT INDICATES THE BAR SIZE NUMBER. FOR EXAMPLE, A501 IS A NO. 5 BAR. BAR DIMENSIONS ARE OUT-TO-OUT, UNLESS OTHERWISE NOTED.
2. REFER TO SHEET 27/27 FOR BENDING DIAGRAM.

BAR MARK	MATERIAL TYPE	NUMBER			LENGTH	WEIGHT	TYPE	DIMENSIONS				
		REAR	FWD	TOTAL				A	B	C	D	INC
<b>ABUTMENTS (GALVANIZED STEEL REINFORCEMENT - GSR)</b>												
A501	GSR	1 SERIES OF 11		1 SERIES OF 11	20'-6" TO 24'-4"	258	STR					5" (+)
A502	GSR	2		2	8'-11"	19	1	2'-8"	6'-5"			3" (-)
A503	GSR	2 SERIES OF 11		2 SERIES OF 11	9'-1" TO 11'-0"	232	1	2'-8"	6'-7" TO 8'-6"			
A504	GSR	1 SERIES OF 3		1 SERIES OF 3	29'-4" TO 29'-9"	93	2	5'-0"	19'-7" TO 20'-0"	5'-0"		3" (-)
A505	GSR	2		2	4'-11"	11	1	1'-6"	3'-7"			
A506	GSR	2		2	7'-0"	15	1	2'-2"	5'-0"			
A507	GSR	14		14	25'-3"	369	2	3'-7"	18'-4"	3'-7"		
A508	GSR		4	4	14'-5"	61	STR					
A509	GSR		8	8	21'-8"	181	STR					
A510	GSR		8	8	20'-6"	172	STR					
A511	GSR		2	2	4'-2"	9	19	3'-3"	5"	10"		
A512	GSR		2	2	2'-6"	6	STR					
A513	GSR		10	10	8'-6"	89	19	5'-10"	1'-2"	2'-5"		
A514	GSR		14	14	5'-7"	82	19	2'-11"	1'-2"	2'-5"		
A515	GSR	2 SERIES OF 6		2 SERIES OF 6	10'-0" TO 14'-4"	153	3	1'-2"	3'-6" TO 5'-8"			11" (-)
A516	GSR		4	4	6'-8"	28	19	4'-0"	1'-2"	2'-5"		
A517	GSR		2	2	25'-6"	54	STR					
A518	GSR		6	6	25'-5"	160	STR					
A519	GSR		8	8	22'-5"	188	STR					
A520	GSR		2	2	25'-8"	54	19	17'-11"	7'-6"	2'-1"		
A521	GSR		4	4	17'-5"	73	STR					
A522	GSR		2	2	22'-6"	47	STR					
A523	GSR		2	2	19'-5"	41	STR					
A524	GSR		2	2	22'-8"	48	19	14'-11"	7'-6"	2'-1"		
A601	GSR		14	14	10'-1"	213	2	4'-6"	1'-5"	4'-6"		
A602	GSR		4	4	9'-11"	60	2	4'-5"	1'-5"	4'-5"		
A603	GSR		40	40	16'-3"	977	STR					
A604	GSR		19	19	6'-8"	191	10	3"	2'-0"	2'-11"	2'-0"	
A605	GSR		19	19	7'-3"	207	1	1'-6"	5'-11"			
A606	GSR		21	21	7'-1"	224	11	9"	5'-9"	1'-6"		
A607	GSR		2	2	14'-4"	44	STR					
A608	GSR		50	50	14'-6"	1089	2	2'-7"	9'-8"	2'-7"		
A609	GSR		18	18	24'-8"	667	STR					
A610	GSR		2	2	16'-6"	50	STR					
A611	GSR		2	2	6'-5"	20	STR					
A612	GSR		10	10	19'-1"	287	STR					
A613	GSR		6	6	7'-4"	67	10	3'-7"	6"	2'-4"	1'-6"	
A614	GSR		6	6	7'-1"	64	2	3'-0"	1'-5"	3'-0"		
A615	GSR		20	20	8'-1"	243	2	3'-6"	1'-5"	3'-6"		
A616	GSR		14	14	5'-11"	125	2	2'-3"	1'-5"	2'-3"		
A617	GSR		21	21	24'-6"	773	3	3'-1"	8'-9"			
A618	GSR		4	4	23'-8"	143	2	11'-5"	1'-2"	11'-5"	2'(-)	
A619	GSR		4	4	24'-2"	146	2	11'-8"	1'-2"	11'-8"	2"	
A620	GSR		24	24	5'-4"	193	2	2'-3"	1'-2"	2'-3"		
A621	GSR		15	15	17'-10"	402	3	5'-11"	2'-7"			
A622	GSR		26	26	12'-4"	482	3	3'-2"	2'-7"			
A623	GSR		5	5	24'-6"	184	2	11'-10"	1'-2"	11'-10"		
A624	GSR		5	5	23'-10"	179	2	11'-6"	1'-2"	11'-6"		
A625	GSR		1	1	23'-6"	36	2	11'-4"	1'-2"	11'-4"		
A626	GSR		1	1	23'-8"	36	2	11'-5"	1'-2"	11'-5"		
A627	GSR		2	2	22'-0"	67	3	2'-9"	7'-10"			
A628	GSR		4	4	24'-10"	150	2	12'-0"	1'-2"	12'-0"		
A629	GSR		4	4	12'-8"	77	3	3'-4"	2'-7"			
A801	GSR		4	4	20'-2"	216	STR					
A802	GSR		6	6	19'-0"	305	STR					
A803	GSR		6	6	8'-2"	131	1	1'-6"	6'-11"			
A804	GSR		5	5	21'-8"	290	STR					
A805	GSR		5	5	23'-8"	316	STR					
A806	GSR		4	4	8'-11"	96	19	4'-6"	1'-11"	4'-1"		
A807	GSR		2	2	10'-4"	56	19	5'-11"	1'-11"	4'-1"		
A808	GSR		2	2	12'-5"	67	19	8'-0"	1'-11"	4'-1"		
A809	GSR		8	8	18'-3"	390	STR					
A810	GSR		8	8	15'-3"	326	STR					
A811	GSR		2	2	19'-2"	103	STR					
<b>ABUTMENT GSR SUBTOTAL</b>						<b>12135</b>						


**CONCRETE REINFORCEMENT**  
**BRIDGE NO. GRE-BK80020-00.492**  
**PEDESTRIAN BRIDGE OVER US 68 AND OLD TOWN CREEK**

SFN  
2926107  
DESIGN AGENCY  
  
 DESIGNER: JZ  
 CHECKER: AMR  
 REVIEWER: GDJ 03/28/25  
 PROJECT ID: 115388  
 SUBSET: 26 / TOTAL: 27  
 SHEET: P.72 / TOTAL: P.107




BAR MARK	MATERIAL TYPE	NUMBER						LENGTH	WEIGHT						TYPE	DIMENSIONS		
		PIER 1	PIER 2	PIER 3	STAIR PIER 1	STAIR PIER 2	TOTAL		PIER 1	PIER 2	PIER 3	STAIR PIER 1	STAIR PIER 2	TOTAL		A	B	C
<b>PIERS (GALVANIZED STEEL REINFORCEMENT - GSR)</b>																		
P301	GSR	126	75	116			317	4'-5"	210	125	193			528	38	3'-9"	4"	
P302	GSR				55	133	188	2'-4"				49	117	166	38	1'-8"	4"	
P401	GSR	28	30	22			80	8'-6"	159	171	125			455	2	2'-6"	3'-9"	2'-6"
P402	GSR	28					28	19'-9"	370					370	STR			
P403	GSR		30				30	12'-5"		249				249	STR			
P404	GSR			22			22	21'-1"			310			310	STR			
P405	GSR				11		11	15'-1"				111		111	3	5'-8"	1'-8"	
P406	GSR					19	19	19'-1"					243	243	3	7'-8"	1'-8"	
P501	GSR				8		8	10'-7"				89		89	2	1'-7"	7'-8"	1'-7"
P502	GSR					12	12	12'-7"					158	158	2	1'-7"	9'-8"	1'-7"
P601	GSR	18	10	21			49	8'-3"	224	124	261			609	2	2'-5"	3'-9"	2'-5"
P602	GSR	46					46	13'-8"	945					945	STR			
P603	GSR	46	30	52			128	6'-9"	467	305	528			1300	1	1'-0"	5'-11"	
P604	GSR	14					14	26'-8"	561					561	2	2'-6"	22'-0"	2'-6"
P605	GSR		1				1	19'-2"		29				29	3	5'-2"	4'-0"	
P606	GSR		30				30	15'-0"		676				676	STR			
P607	GSR		12				12	19'-4"		349				349	2	2'-6"	14'-8"	2'-6"
P608	GSR			14			14	28'-0"			589			589	2	2'-6"	23'-4"	2'-6"
P609	GSR			52			52	10'-6"			821			821	STR			
P610	GSR				14		14	6'-6"				137		137	2	1'-7"	3'-8"	1'-7"
P611	GSR					16	16	8'-6"					205	205	2	1'-7"	5'-8"	1'-7"
P701	GSR				11	16	27	8'-5"				190	276	466	2	3'-7"	1'-8"	3'-7"
P702	GSR				26		26	9'-8"				514		514	STR			
P703	GSR				26	36	62	6'-3"				333	460	793	1	1'-0"	5'-5"	
P704	GSR					36	36	17'-3"					1270	1270	2	3'-9"	1'-8"	3'-9"
P801	GSR	5					5	24'-2"	323					323	2	2'-5"	19'-9"	2'-5"
P802	GSR	34	24	34			92	12'-6"	1135	801	1135			3071	2	2'-6"	7'-8"	2'-6"
P803	GSR		5				5	16'-10"		225				225	2	2'-5"	12'-5"	2'-5"
P804	GSR			5			5	25'-6"			341			341	2	2'-5"	21'-1"	2'-5"
P901	GSR		16				16	6'-6"		354				354	1	3'-9"	3'-0"	
P902	GSR		14				14	7'-11"		377				377	1	5'-2"	3'-0"	
<b>PIER GSR SUBTOTAL</b>									<b>4394</b>	<b>3785</b>	<b>4303</b>	<b>1423</b>	<b>2729</b>	<b>16634</b>				

**BENDING DIAGRAM**

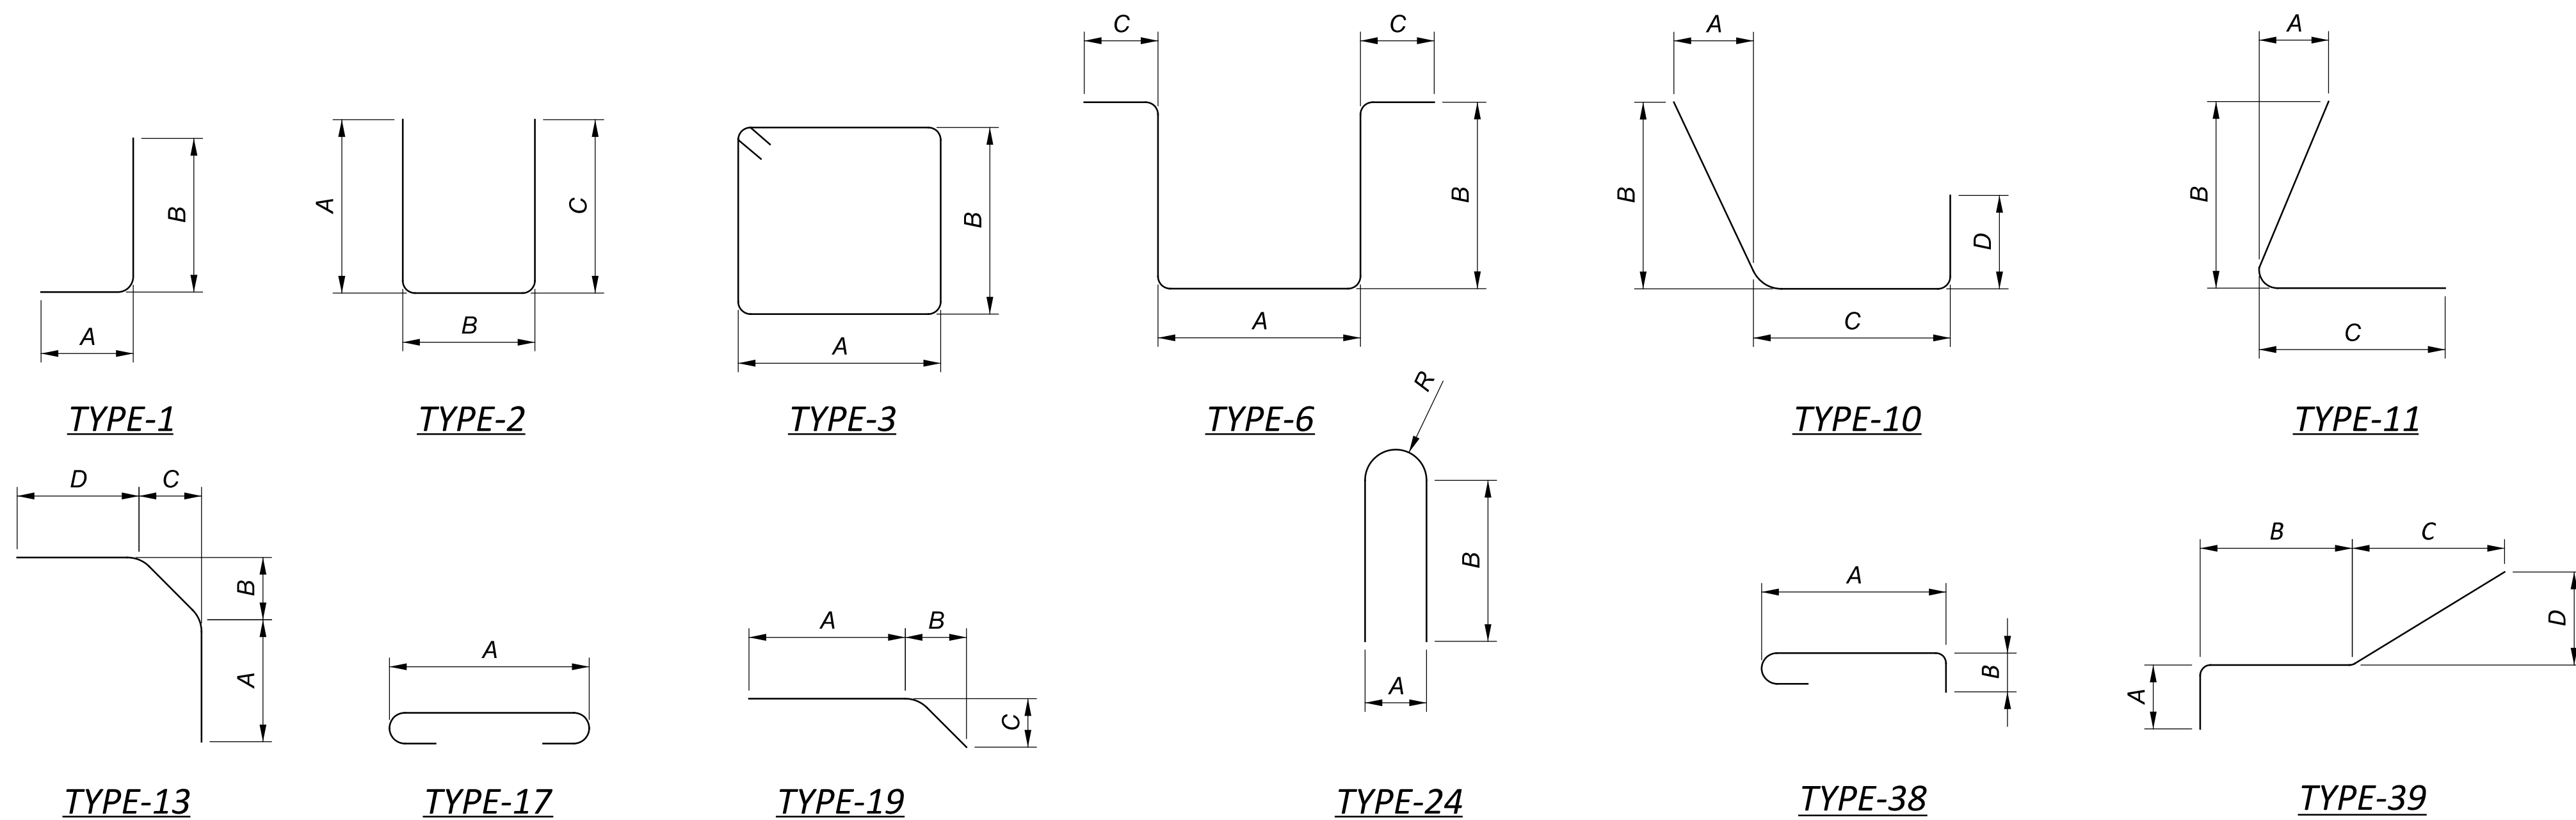

**NOTE**

THE BAR NUMBER IS SPECIFIED ON THE PLANS IN THE BAR MARK COLUMN. THE FIRST DIGIT INDICATES THE BAR SIZE NUMBER. FOR EXAMPLE, P301 IS A NO. 3 BAR. BAR DIMENSIONS ARE OUT-TO-OUT, UNLESS OTHERWISE NOTED.

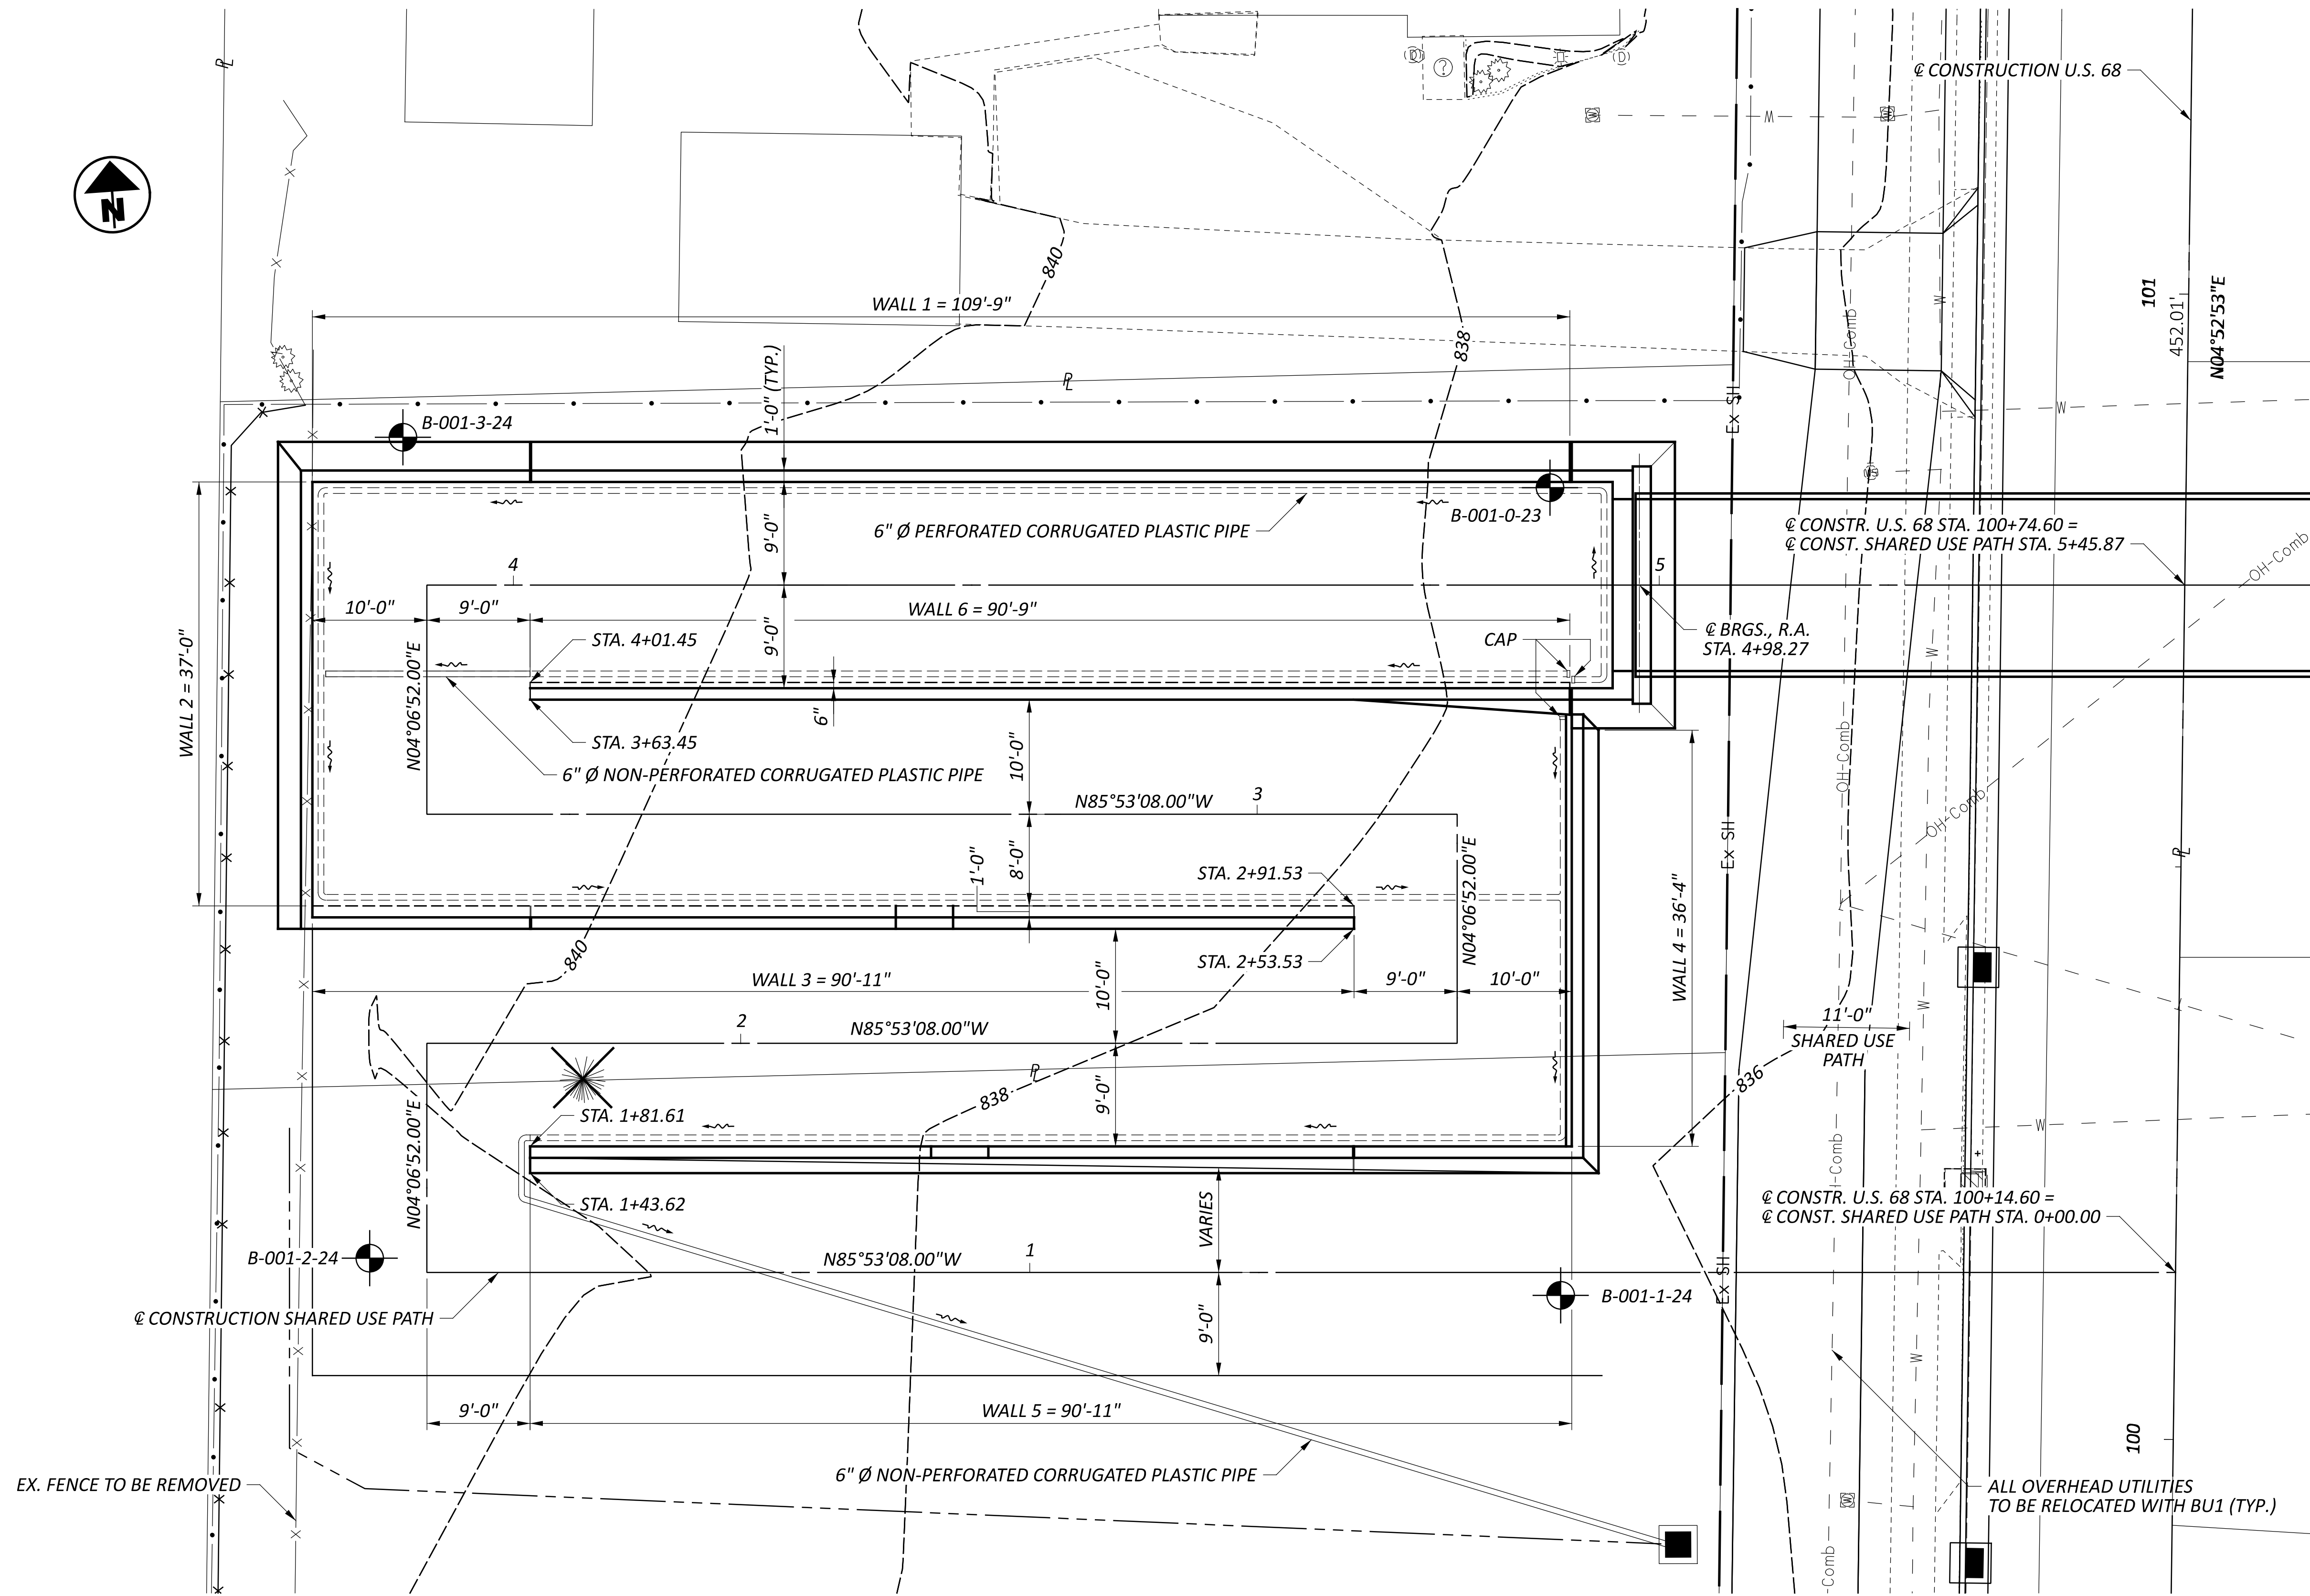

PLAN

RAMP RETAINING WALL PLAN  
 BRIDGE NO. GRE-BK80020-00.492  
 PEDESTRIAN BRIDGE OVER US 68 AND OLD TOWN CREEK

DESIGN AGENCY	
DESIGNER	CHECKER
SMH	AMR
REVIEWER	
GDJ 03/28/25	
PROJECT ID	
115388	
SUBSET	TOTAL
1	12
SHEET	
P.74	P.107

ALL OVERHEAD UTILITIES TO BE RELOCATED WITH BU1 (TYP.)

REFER TO THE FOLLOWING STANDARD CONSTRUCTION DRAWING:

RM - 5.2 REVISED 07-21-2023

**DESIGN SPECIFICATIONS**

THIS STRUCTURE CONFORMS TO THE 9th EDITION OF THE "LRFD BRIDGE DESIGN SPECIFICATIONS" ADOPTED BY THE AMERICAN ASSOCIATION OF STATE HIGHWAY AND TRANSPORTATION OFFICIALS, 2020, AND THE ODOT BRIDGE DESIGN MANUAL, 2020.

**OPERATIONAL IMPORTANCE:**

A LOAD MODIFIER OF 1.0 HAS BEEN ASSUMED FOR THE DESIGN OF THIS STRUCTURE IN ACCORDANCE WITH THE AASHTO LRFD BRIDGE DESIGN SPECIFICATIONS, ARTICLE 1.3.5 AND THE ODOT BRIDGE DESIGN MANUAL.

**DESIGN DATA**

CONCRETE CLASS QC1 WITH QC/QA - COMPRESSIVE STRENGTH 4.0 KSI (SUBSTRUCTURE)

CONCRETE REINFORCEMENT:

GALVANIZED STEEL REINFORCEMENT - MINIMUM YIELD STRENGTH 60 KSI (SUBSTRUCTURE)

**AESTHETIC TREATMENT (CONCRETE FORMLINER)**


ONE FULL SCALE PATTERNED PRECONSTRUCTION TEST PANEL SHALL BE PROVIDED FOR APPROVAL BY THE DISTRICT 8 BRIDGE SECTION. IF THE TEST PANEL DOES NOT MEET THE APPROVAL OF THE DISTRICT 8 BRIDGE SECTION, THE RESULT WILL BE GROUNDS TO REJECT THE PROPOSED PANEL SURFACE CHOSEN. THE TEST PANEL WILL BE PROVIDED REPEATEDLY, AS NECESSARY, UNTIL APPROVAL IS GRANTED. THE MOCK-UP SHALL HAVE THE SAME ARCHITECTURAL RELIEF, THICKNESS AND PATTERN INTENDED TO BE USED ON THE PROJECT. THE PANEL SHALL USE THE SAME CEMENT AND AGGREGATE SOURCE THAT WILL BE USED TO CONSTRUCT THE PROJECT. AFTER APPROVAL, THE CONCRETE TEST PANEL SHALL BE REMOVED AND DISPOSED OF BY THE CONTRACTOR.

**FOUNDATION BEARING RESISTANCE:**

WALL FOOTINGS, AS DESIGNED, PRODUCE A MAXIMUM SERVICE LIMIT STATE BEARING PRESSURE OF 1.6 KIPS PER SQUARE FOOT AND A MAXIMUM STRENGTH LIMIT STATE BEARING PRESSURE OF 2.9 KIPS PER SQUARE FOOT. THE FACTORED BEARING RESISTANCE IS 4.1 KIPS PER SQUARE FOOT.

**SEALING OF CONCRETE SURFACES, AS PER PLAN, (PERMANENT GRAFFITI PROTECTION):**

APPLY A PERMANENT GRAFFITI COATING QUALIFIED ACCORDING TO S1083 THAT IS COMPATIBLE WITH THE CONCRETE SEALER OVER WHICH IT IS APPLIED. APPLY THE GRAFFITI COATING IN ACCORDANCE WITH THE MANUFACTURER'S PRINTED INSTRUCTIONS.

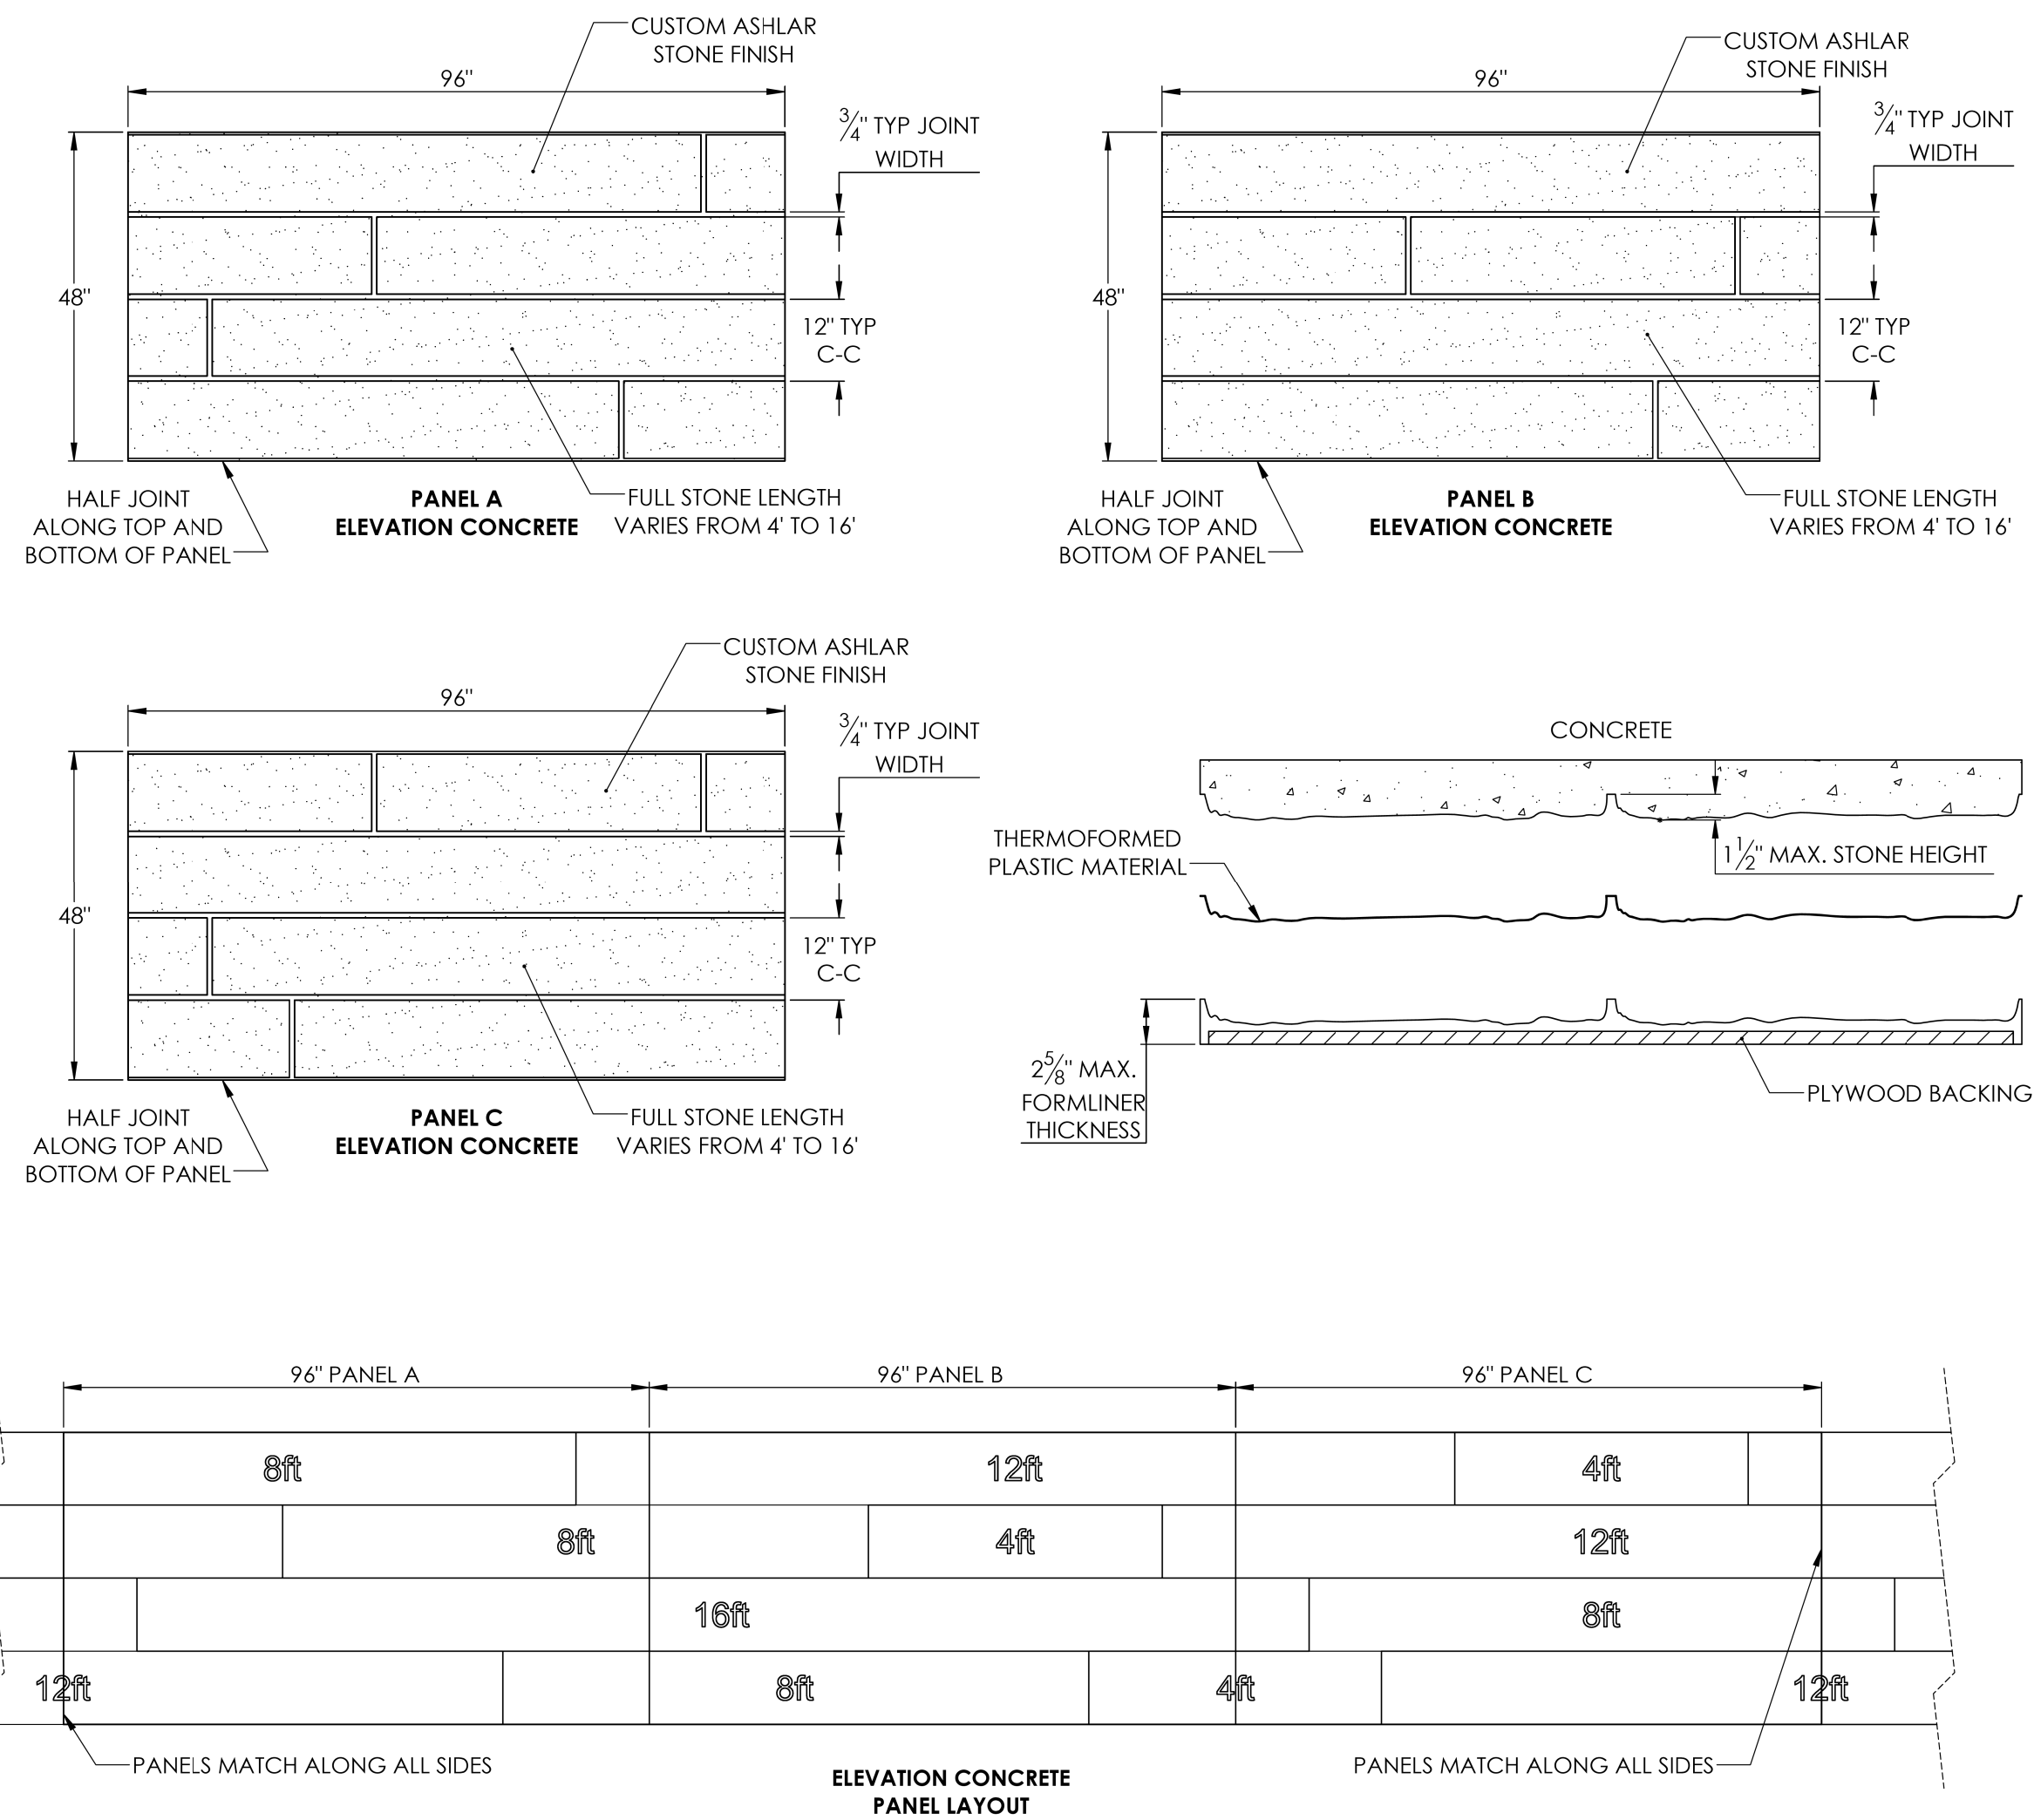


**CONCRETE FORMLINER DETAIL**

GRE-68-12.65

MODEL: Sheet\_SurvFt\_PAPER SIZE: 34x22 (in.) DATE: 3/31/2025 TIME: 4:30:38 PM USER: wshannon P:\DBP\IAG\0003\_GRE-68-12.65\115388\400-Engineering\Wall\Sheets\115388\_Wall\_WN001.dgn

RETAINING WALLS GENERAL NOTES  
 BRIDGE NO. GRE-BK80020-00.492  
 PEDESTRIAN BRIDGE OVER US 68 AND OLDTOWN CREEK



DESIGN AGENCY	
DESIGNER	CHECKER
JZ	AMR
REVIEWER	
GDJ 03/28/25	
PROJECT ID	
115388	
SUBSET	TOTAL
2	12
SHEET	TOTAL
P.75	P.107

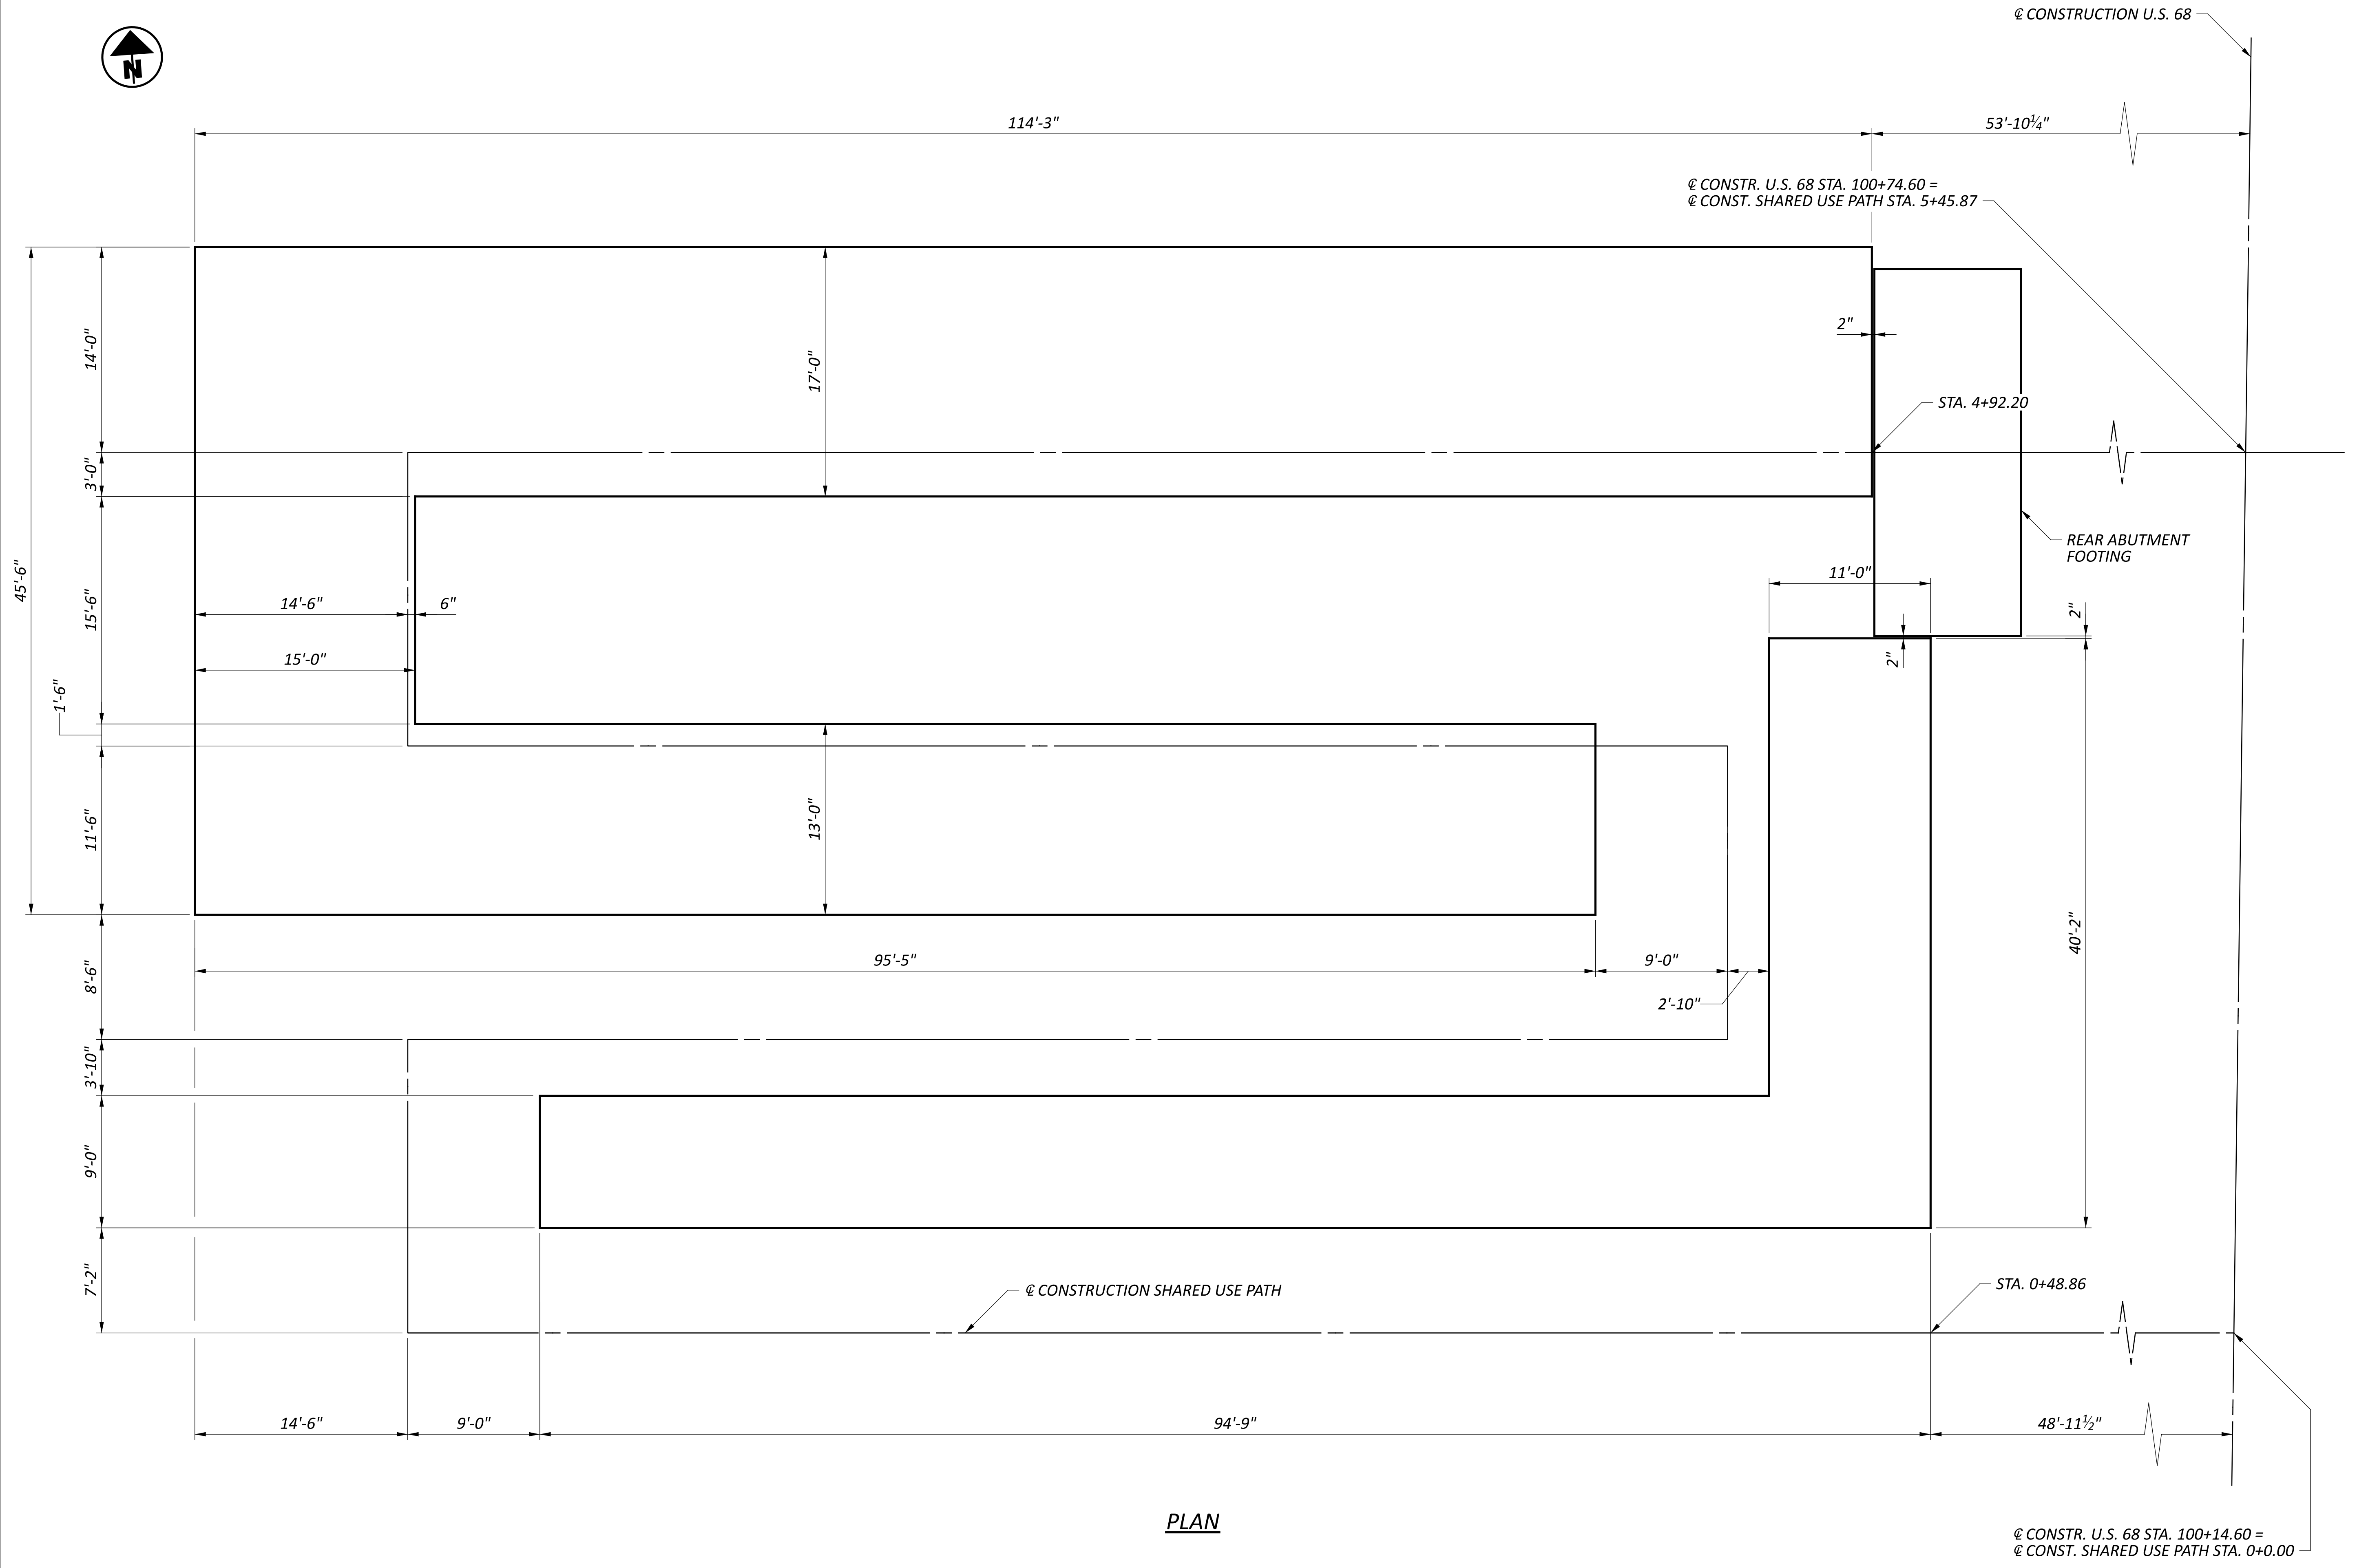

PLAN

RAMP RETAINING WALL FOUNDATION PLAN WALLS 1-5  
 BRIDGE NO. GRE-BK80020.00.492  
 PEDESTRIAN BRIDGE OVER US 68 AND OLDTOWN CREEK

DESIGN AGENCY	
DESIGNER	CHECKER
MME	AMR
REVIEWER	
GDJ 03/28/25	
PROJECT ID	
115388	
SUBSET	TOTAL
3	12
SHEET	TOTAL
P.76	P.107

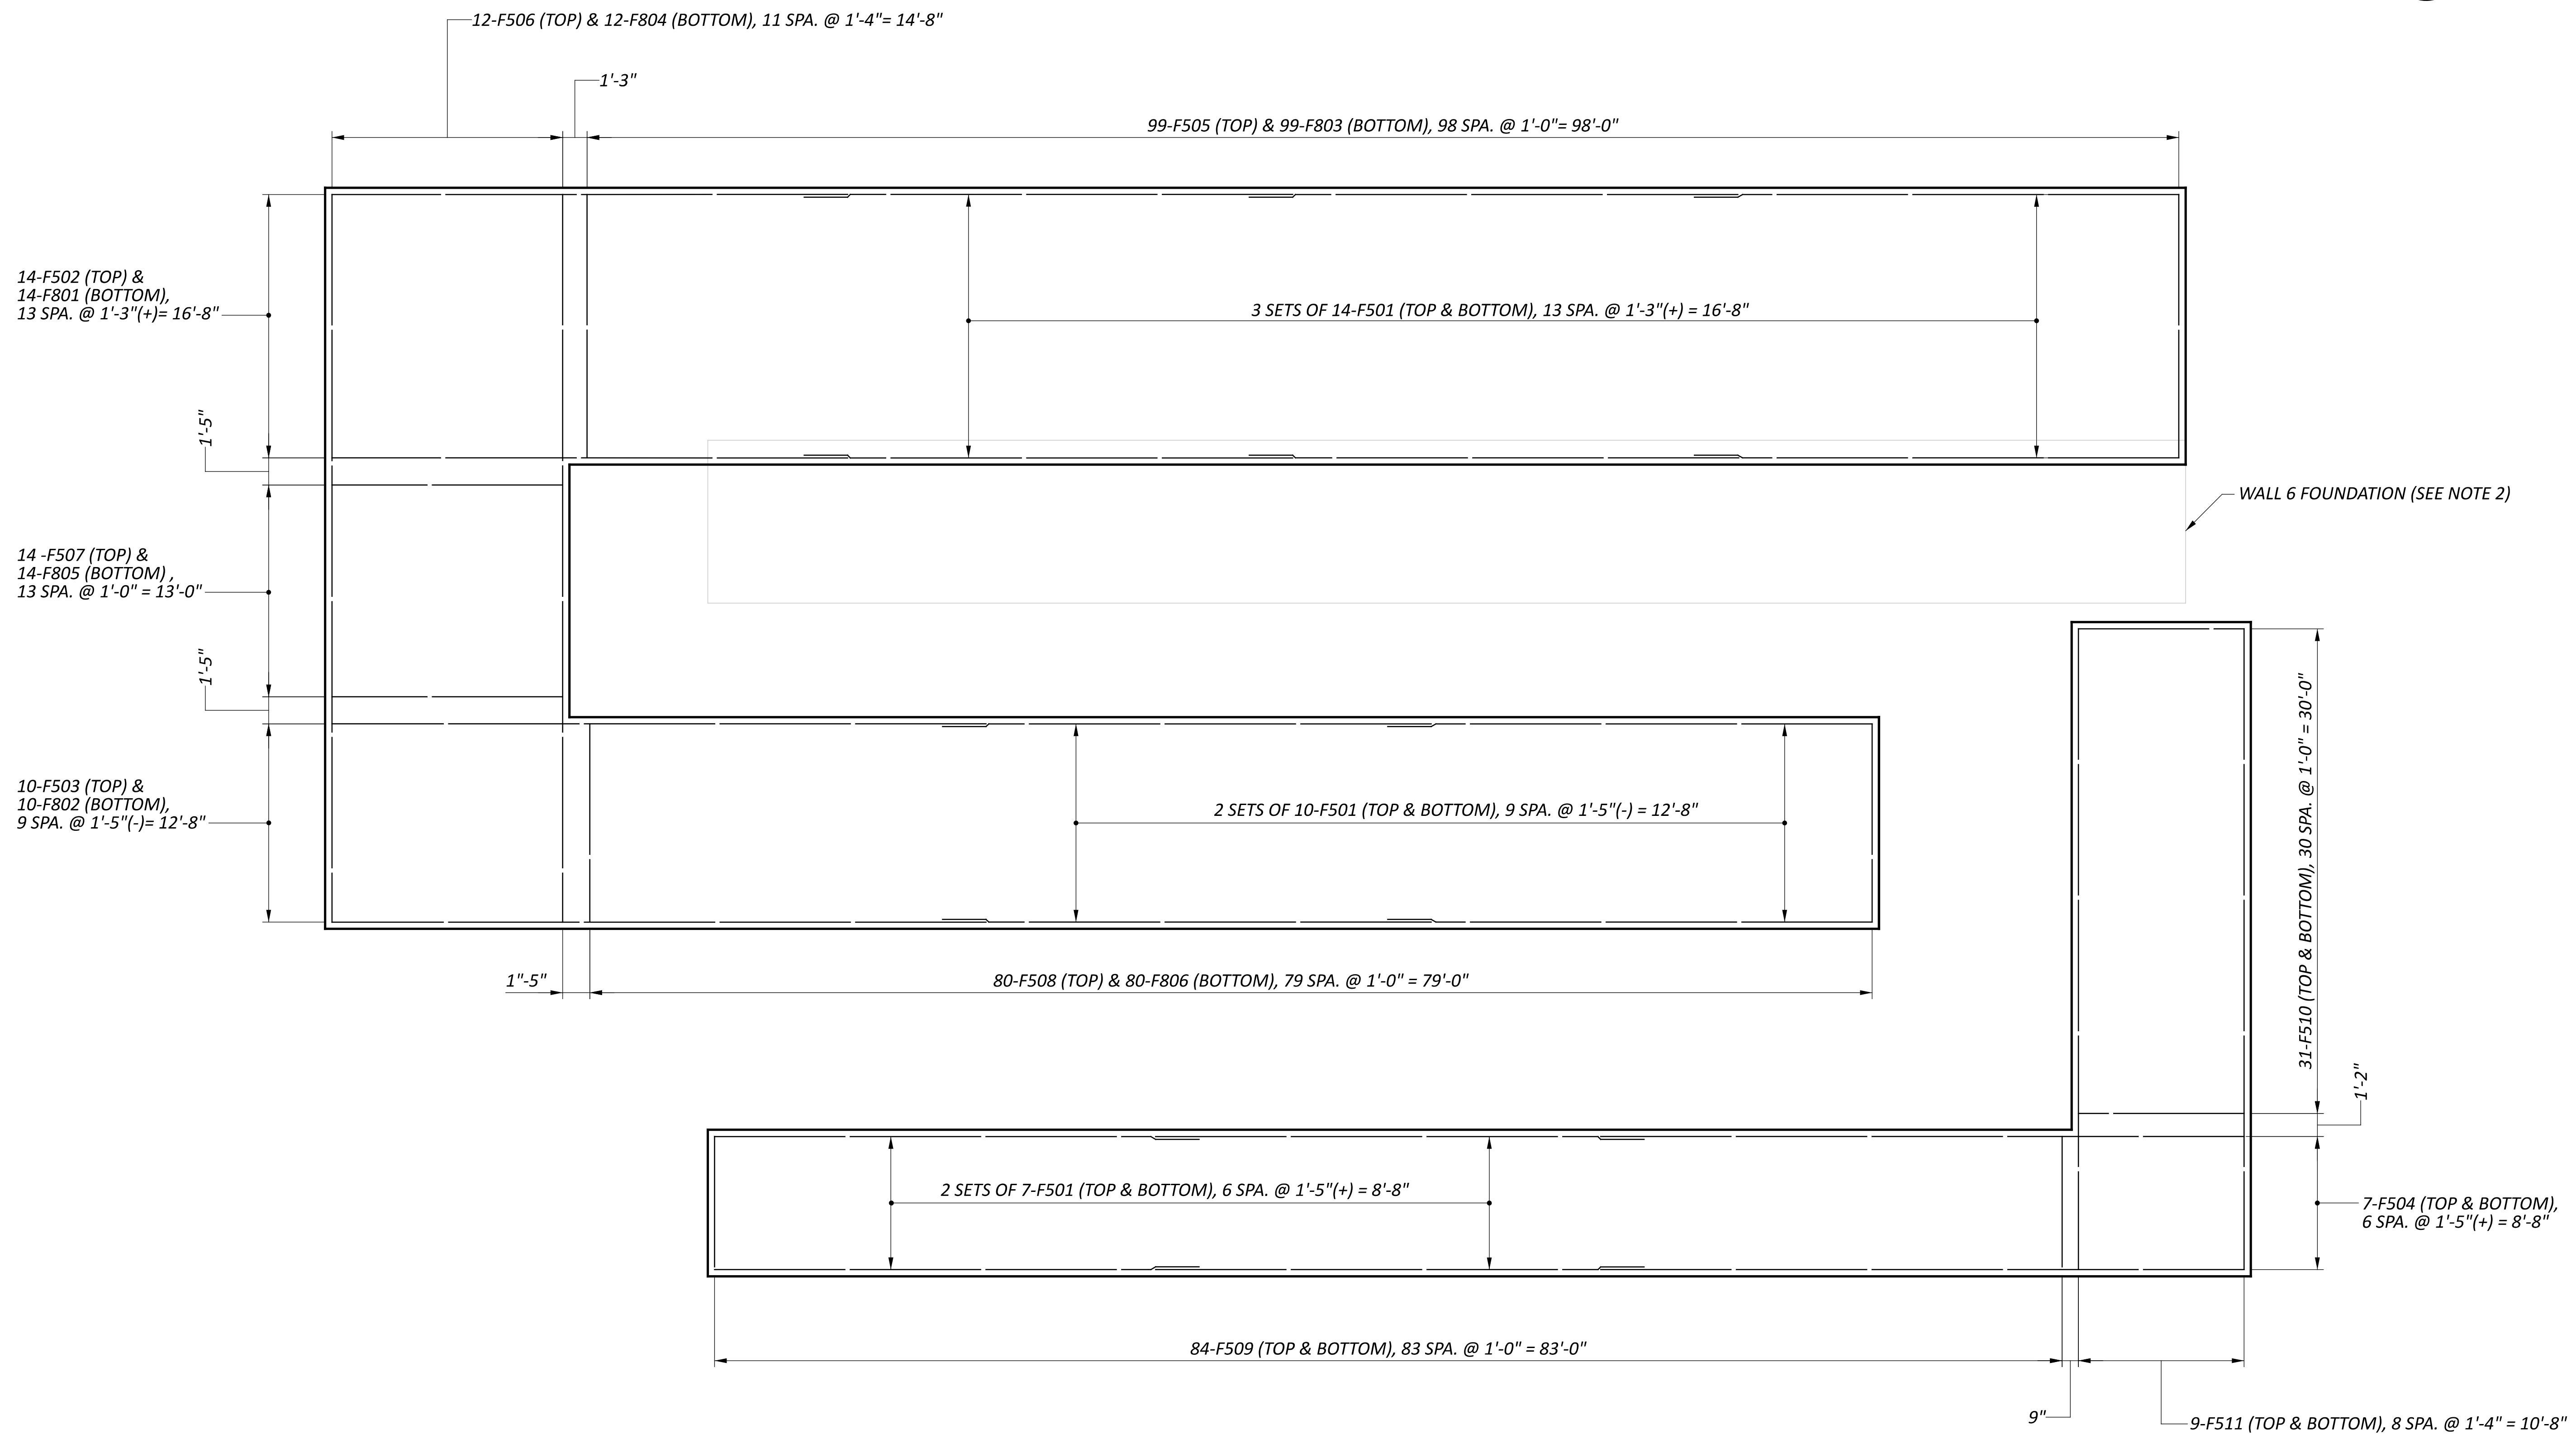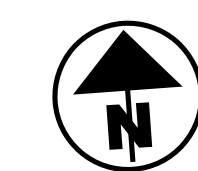


PLAN

**NOTES**

1. MINIMUM LAP SPLICE LENGTH:  
 #5 BARS = 32 INCHES  
 #8 BARS = 38 INCHES
2. REFER TO SHEET 5 / 12 FOR WALL 6 FOUNDATION DETAILS.

RAMP RETAINING WALL FOUNDATION REINFORCEMENT DETAIL WALLS 1-5  
 BRIDGE NO. GRE-BK80020.00.492  
 PEDESTRIAN BRIDGE OVER US 68 AND OLD TOWN CREEK

DESIGN AGENCY	
DESIGNER	CHECKER
MME	AMR
REVIEWER	
GDJ 02/10/25	
PROJECT ID	
115388	
SUBSET	TOTAL
4	12
SHEET	TOTAL
P.77	P.107

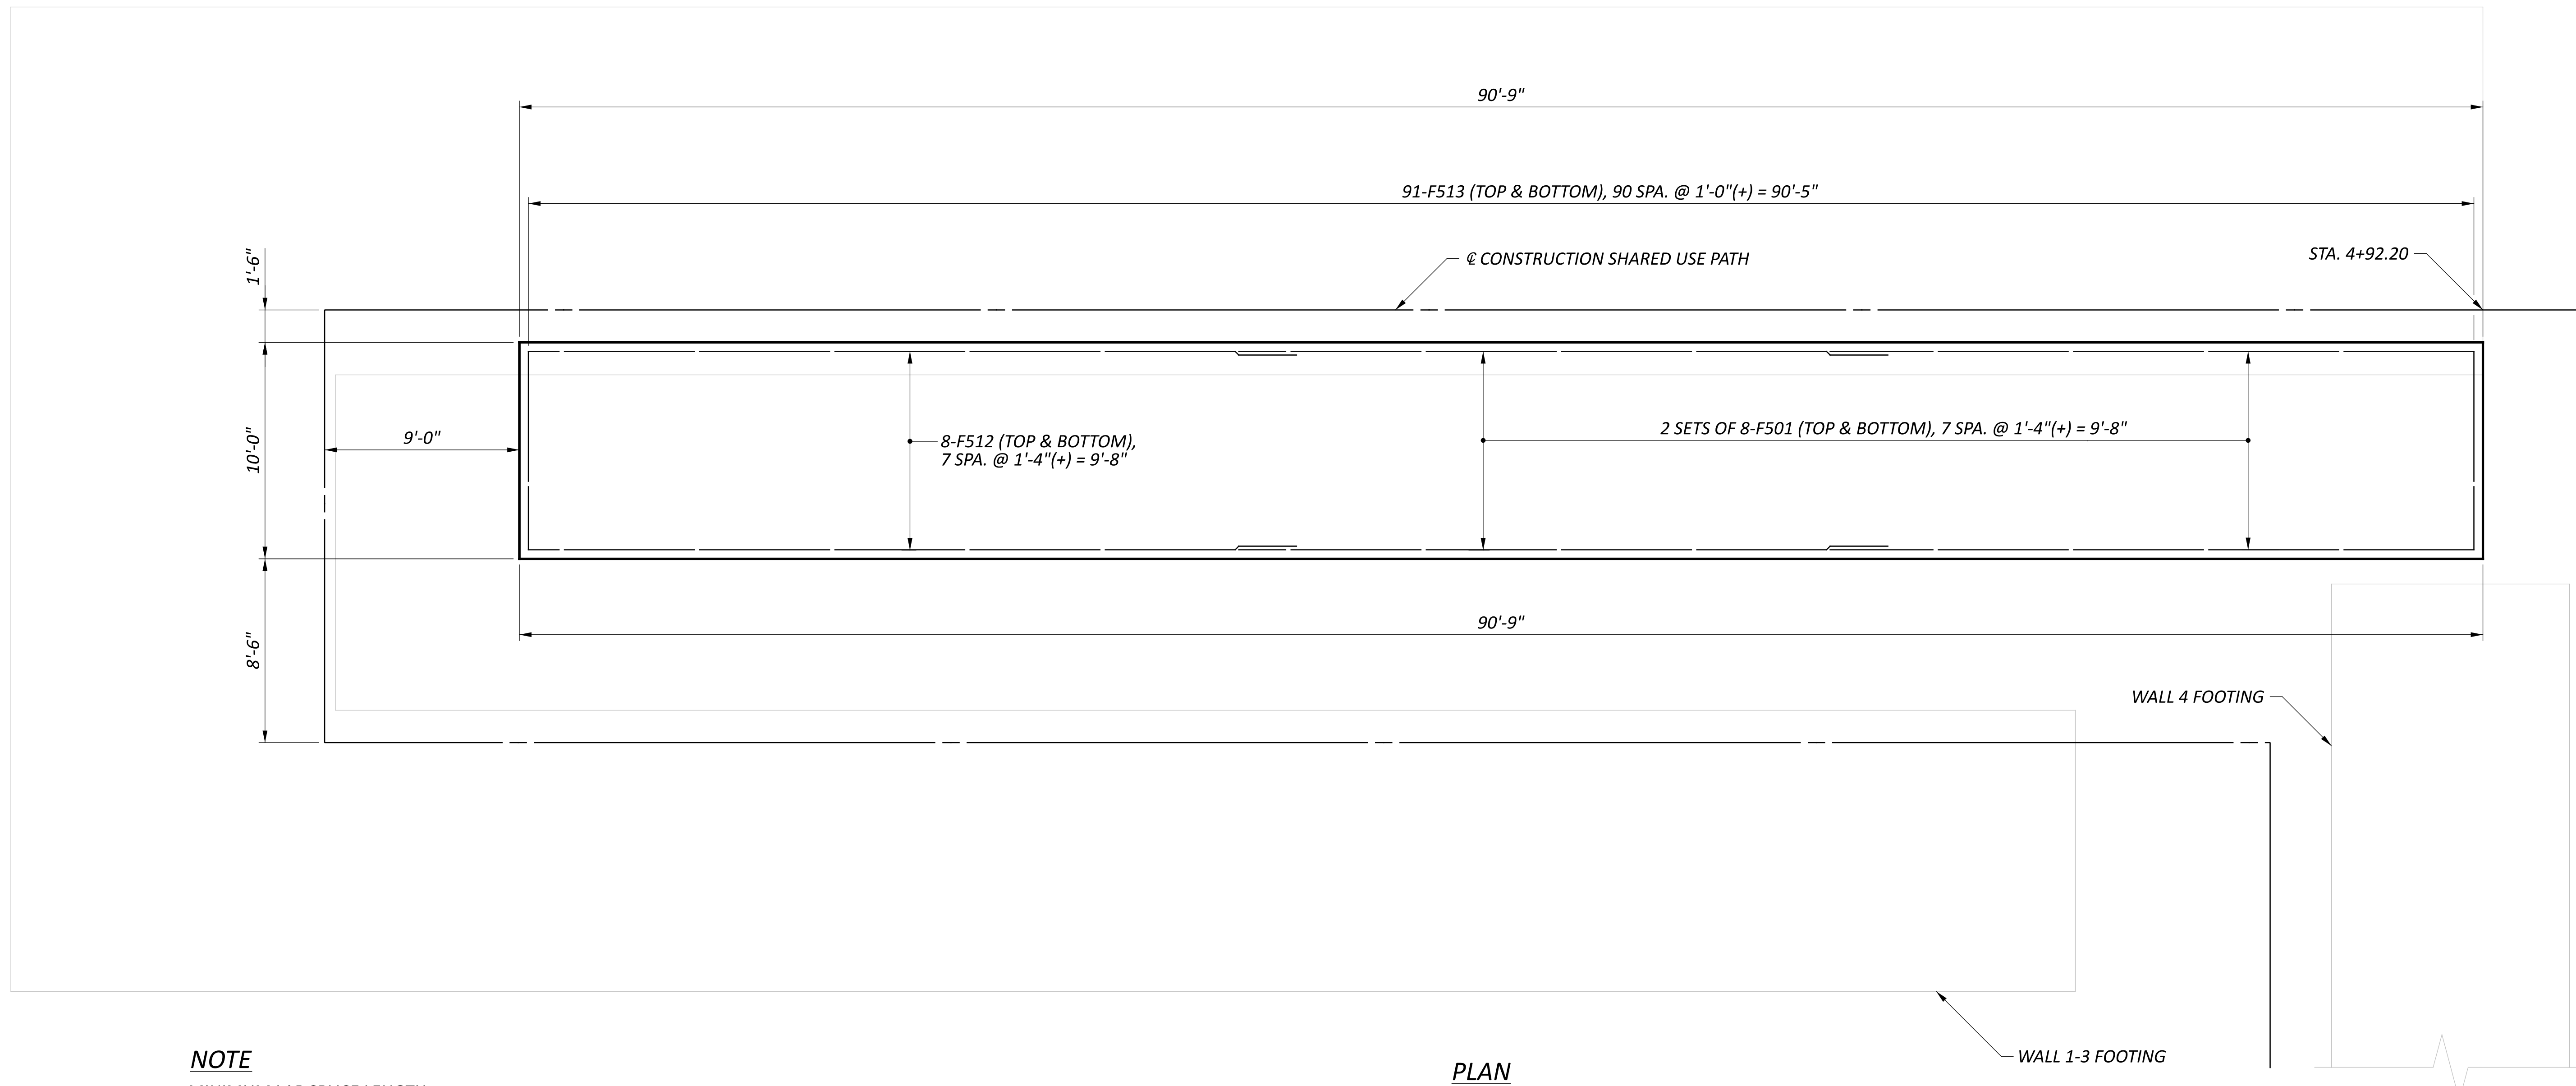

**NOTE**  
 MINIMUM LAP SPLICE LENGTH  
 #5 BAR= 32 INCHES


PLAN

DESIGN AGENCY	
DESIGNER	CHECKER
MME	AMR
REVIEWER	
GDJ 03/28/25	
PROJECT ID	
115388	
SUBSET	TOTAL
5	12
SHEET	TOTAL
P.78	P.107









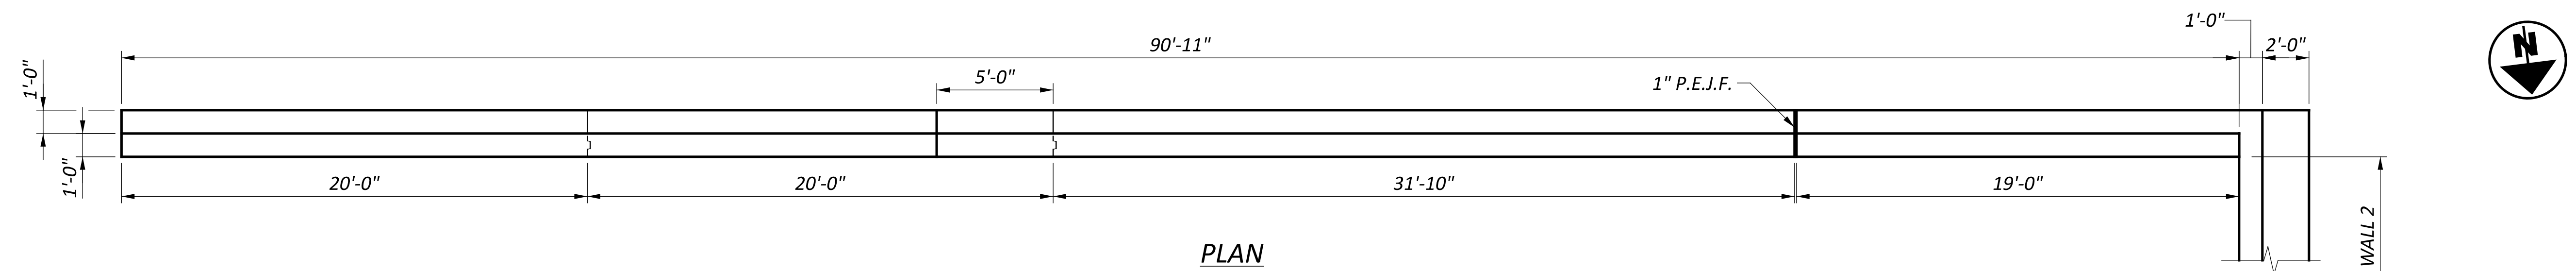

PLAN

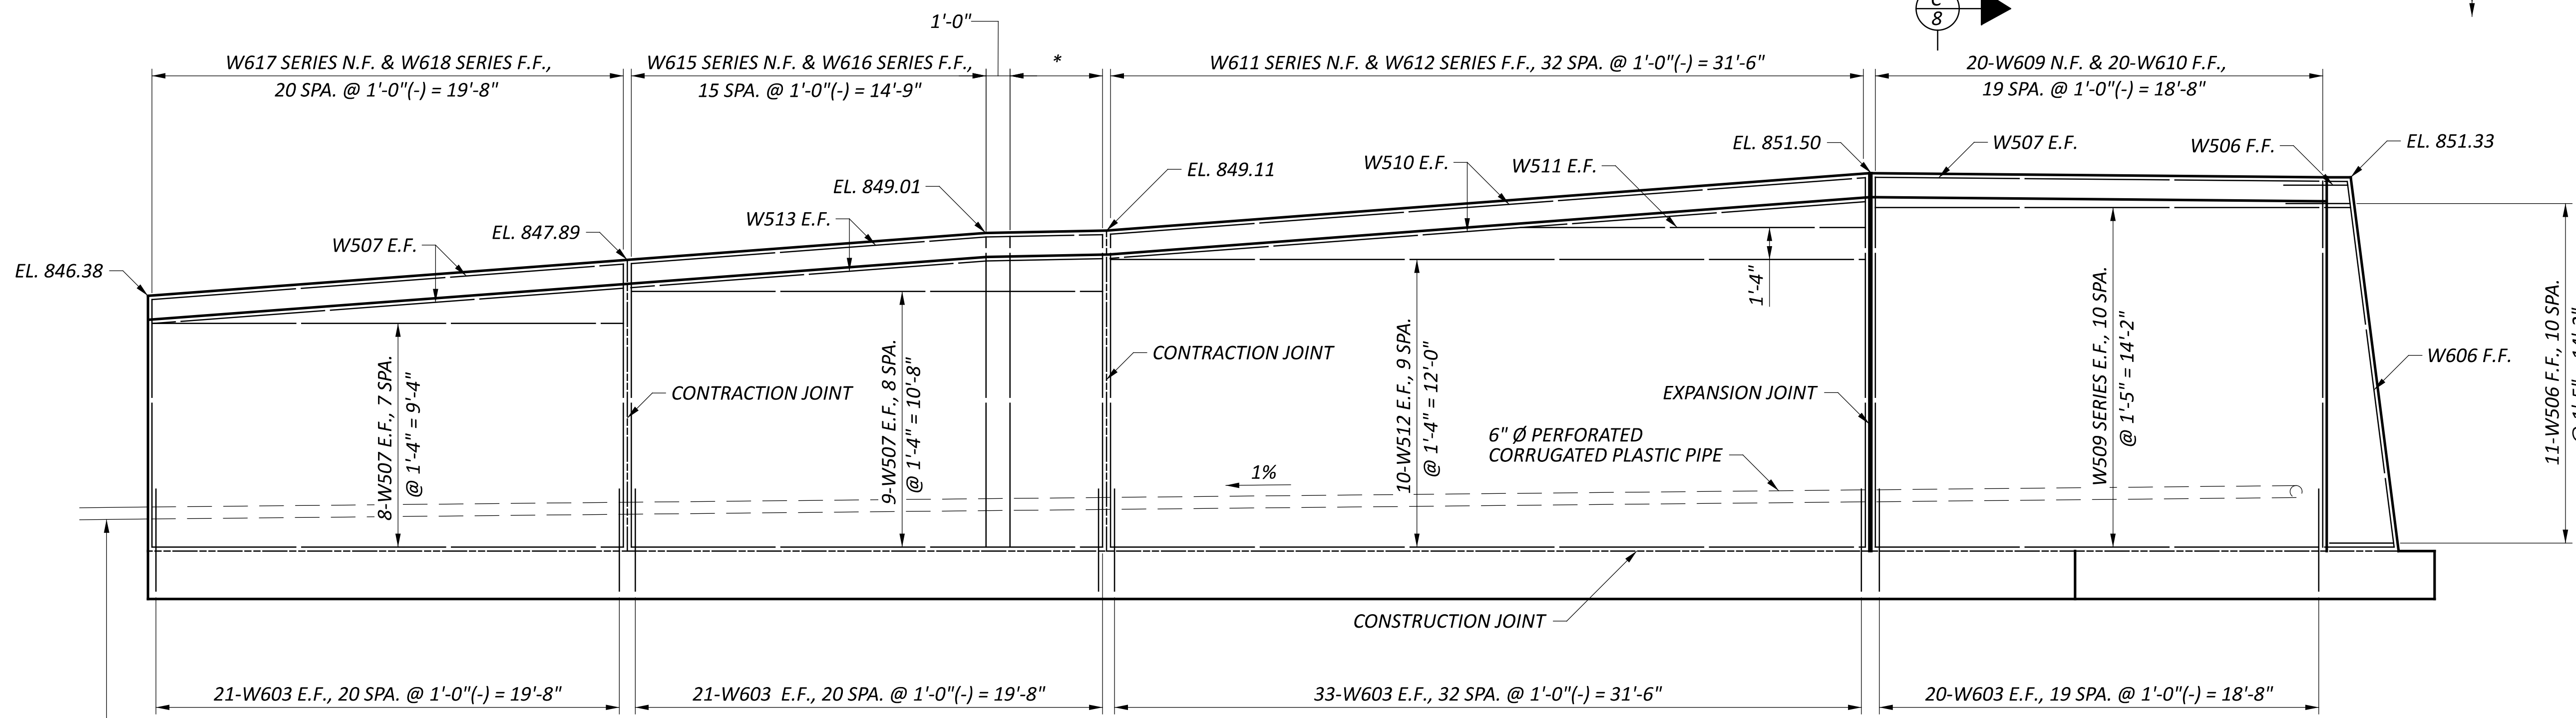

ELEVATION  
VIEWED ALONG BACK FACE

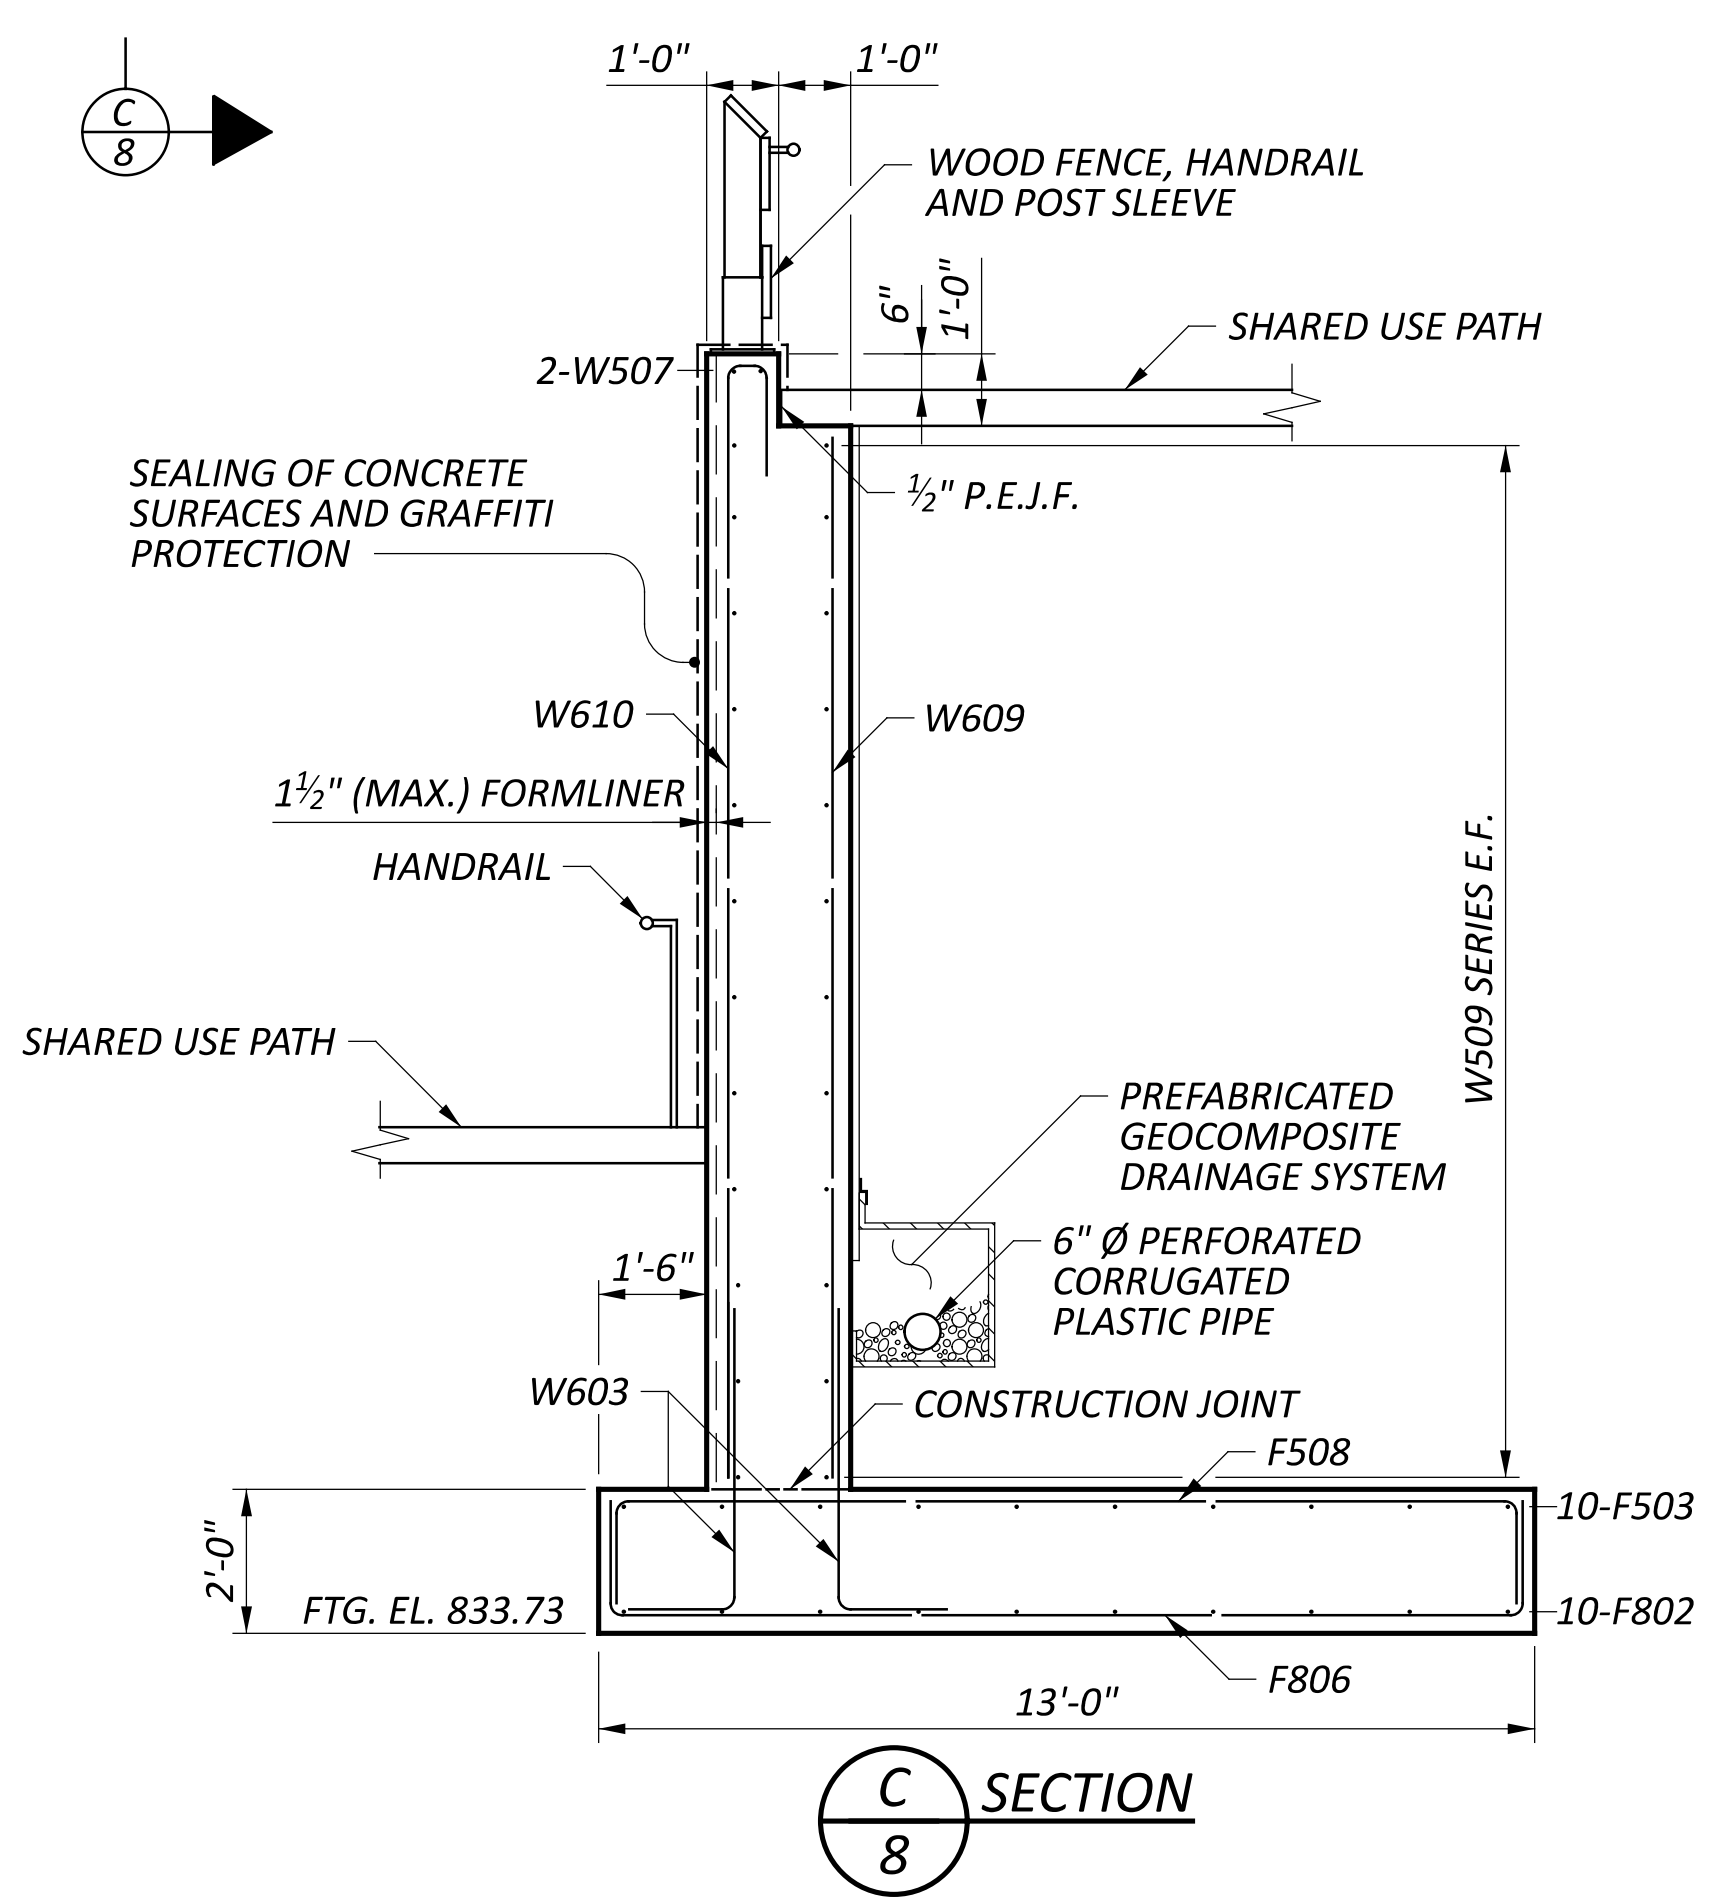

SECTION  
C  
8

NOTES



- REFER TO SHEET **6/12** FOR CONTRACTION JOINT DETAIL.
- REFER TO SHEET **P.68/P.107** FOR POST SLEEVE DETAILS.

LEGENED



- \* - 5-W613 N.F. & 5-W614 F.F., 4 SPA. @ 1'-0" = 4'-0"
- E.F. - EACH FACE
- N.F. - NEAR FACE
- F.F. - FAR FACE

WALL 3 DETAILS  
 BRIDGE NO. GRE-BK80020-00.492  
 PEDESTRIAN BRIDGE OVER US 68 AND OLD TOWN CREEK

DESIGN AGENCY	
DESIGNER	CHECKER
SMH	AMR
REVIEWER	
GDJ 03/28/25	
PROJECT ID	
115388	
SUBSET	TOTAL
8	12
SHEET	TOTAL
P.81	P.107

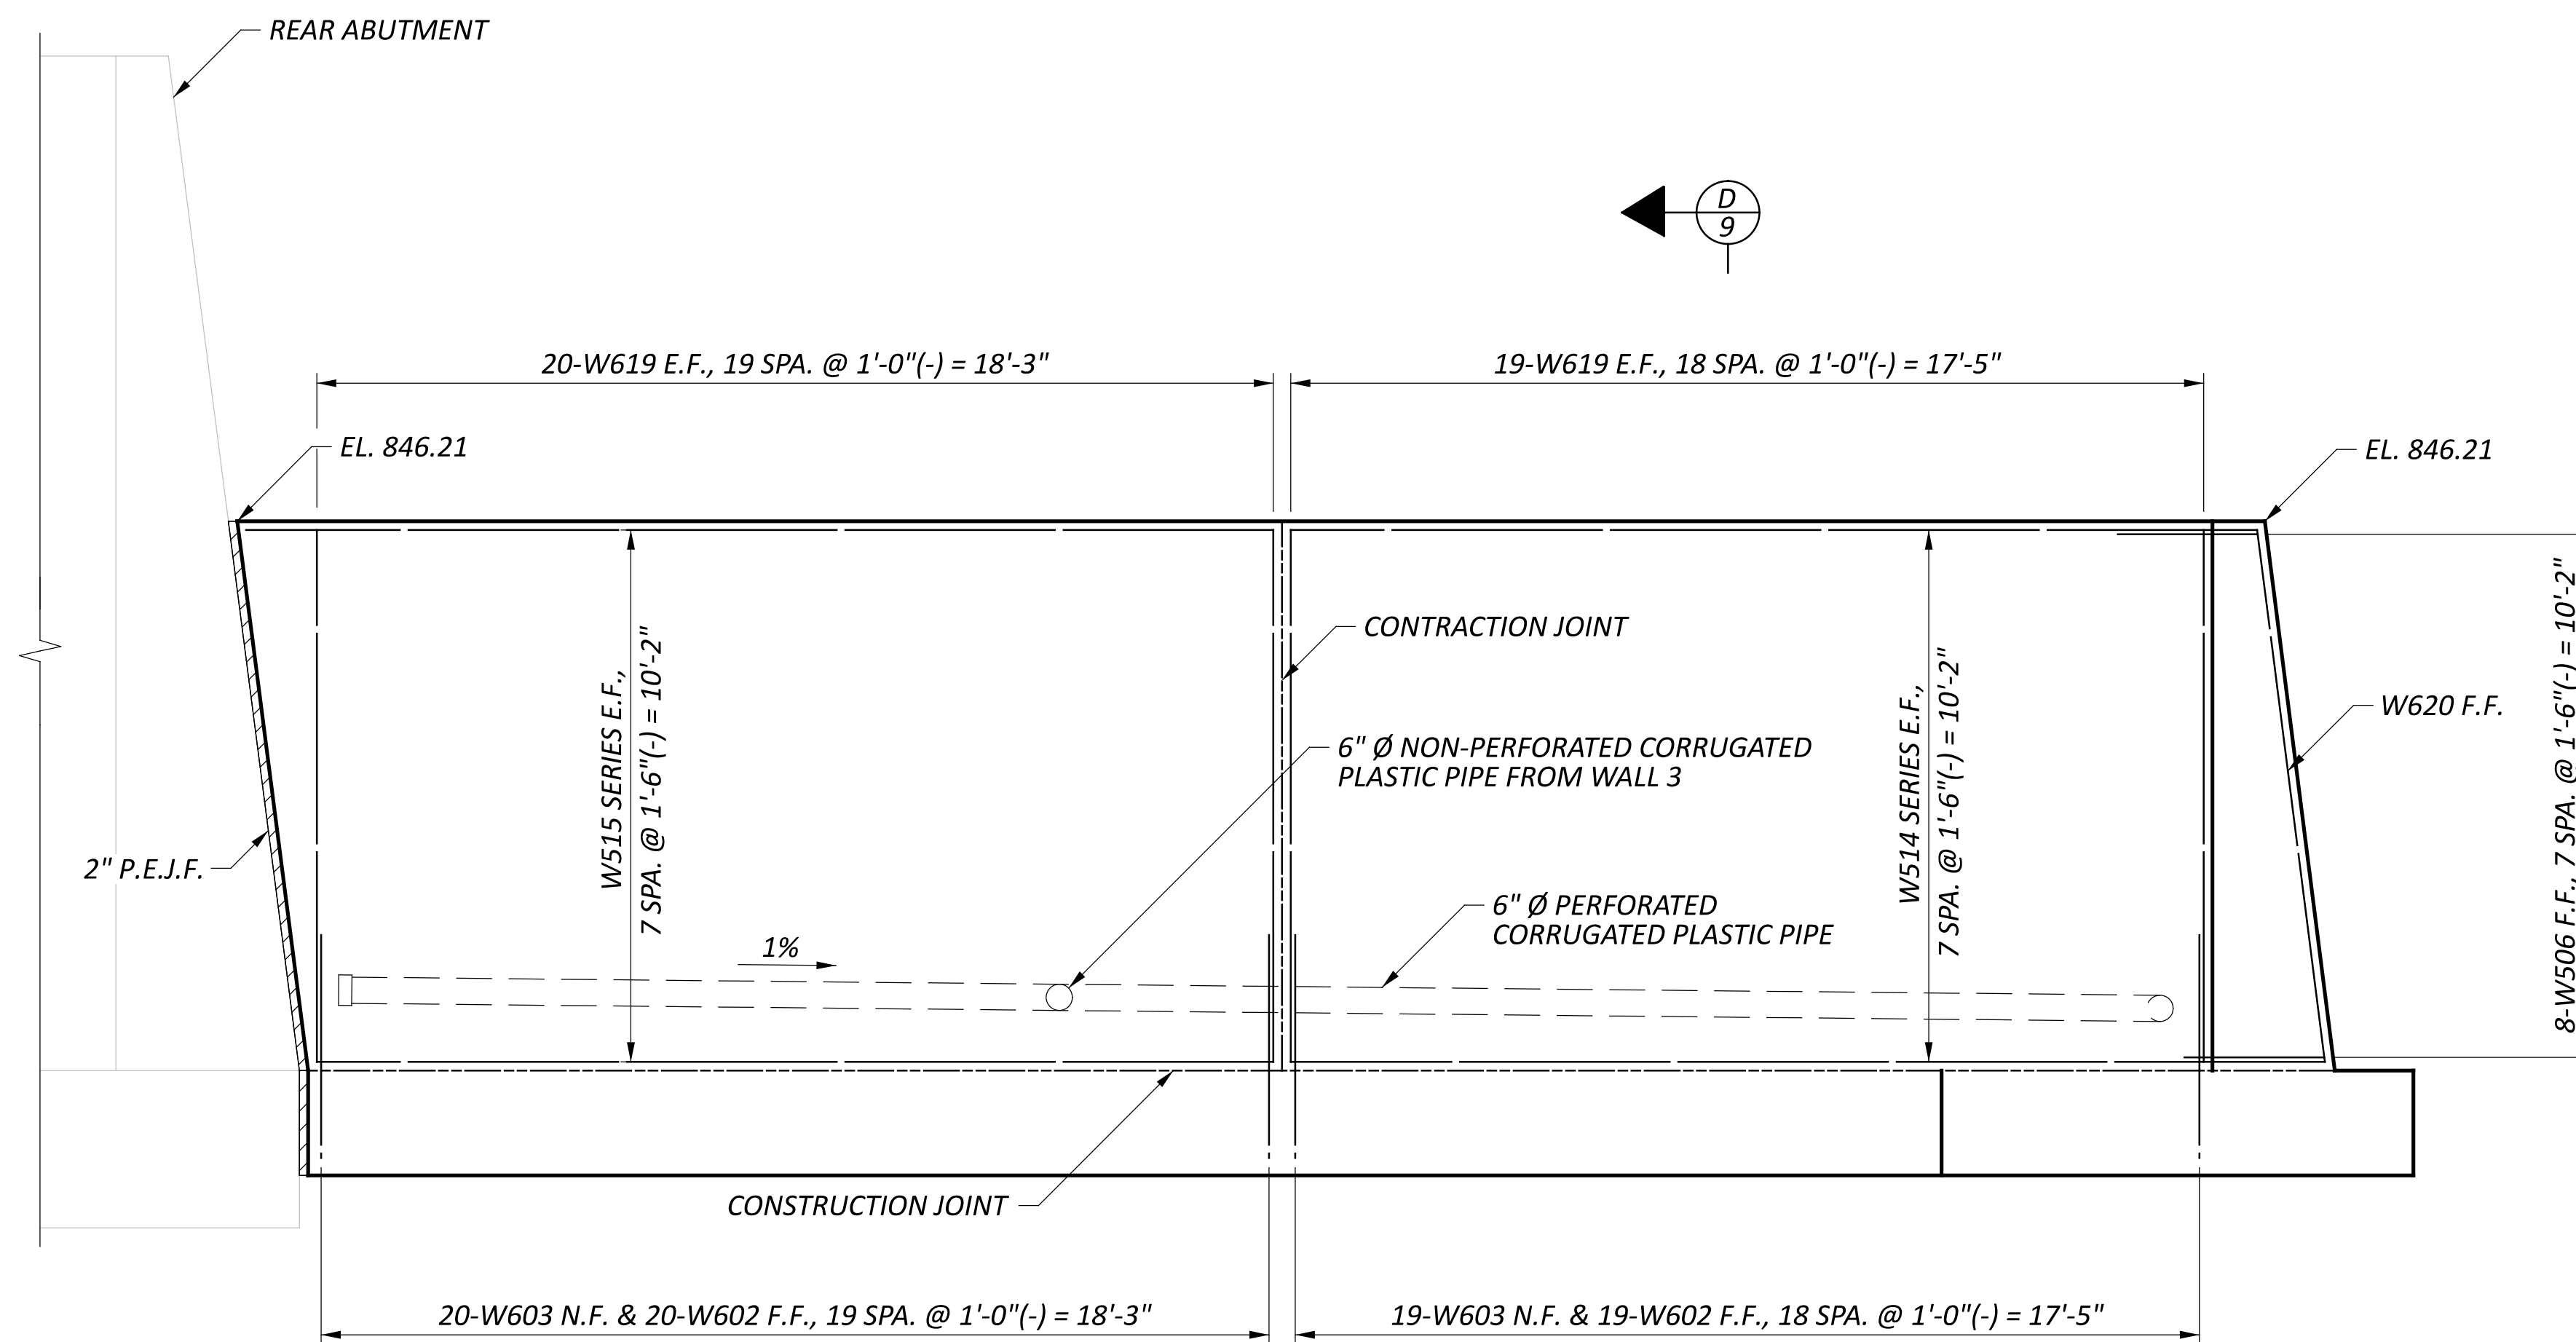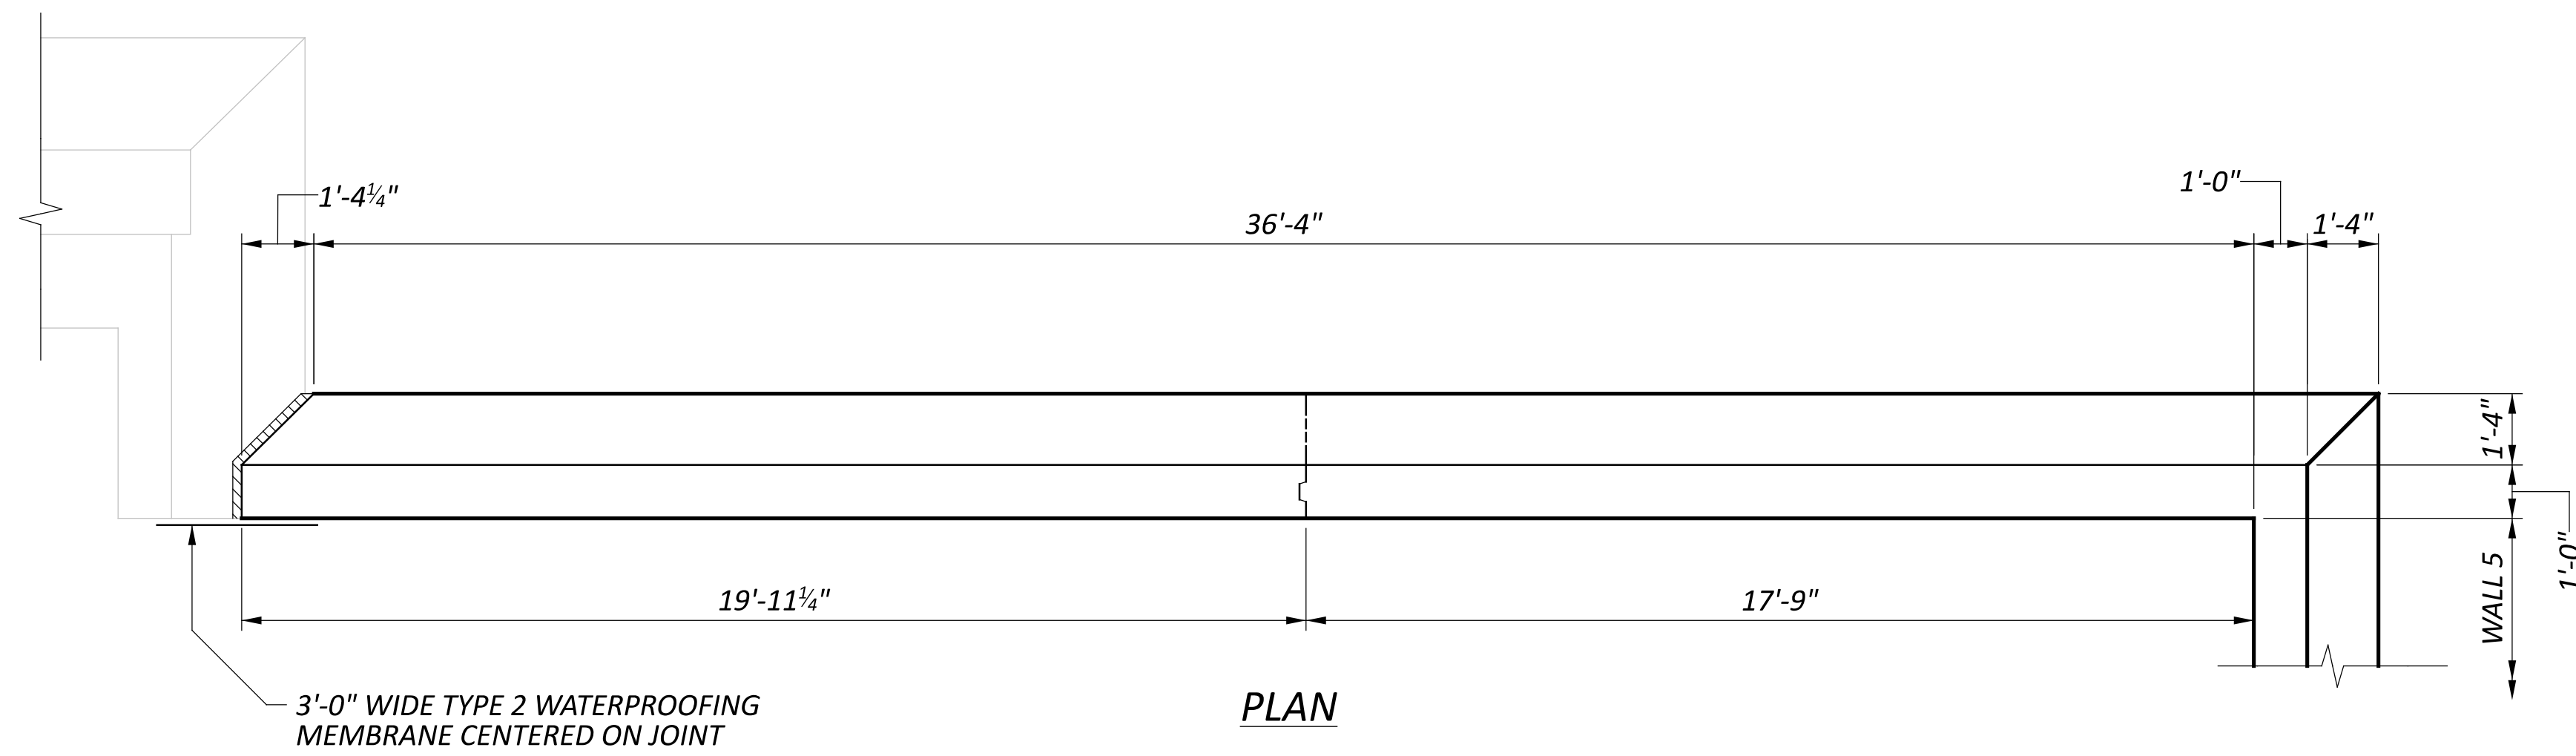

ELEVATION  
VIEWED ALONG BACK FACE

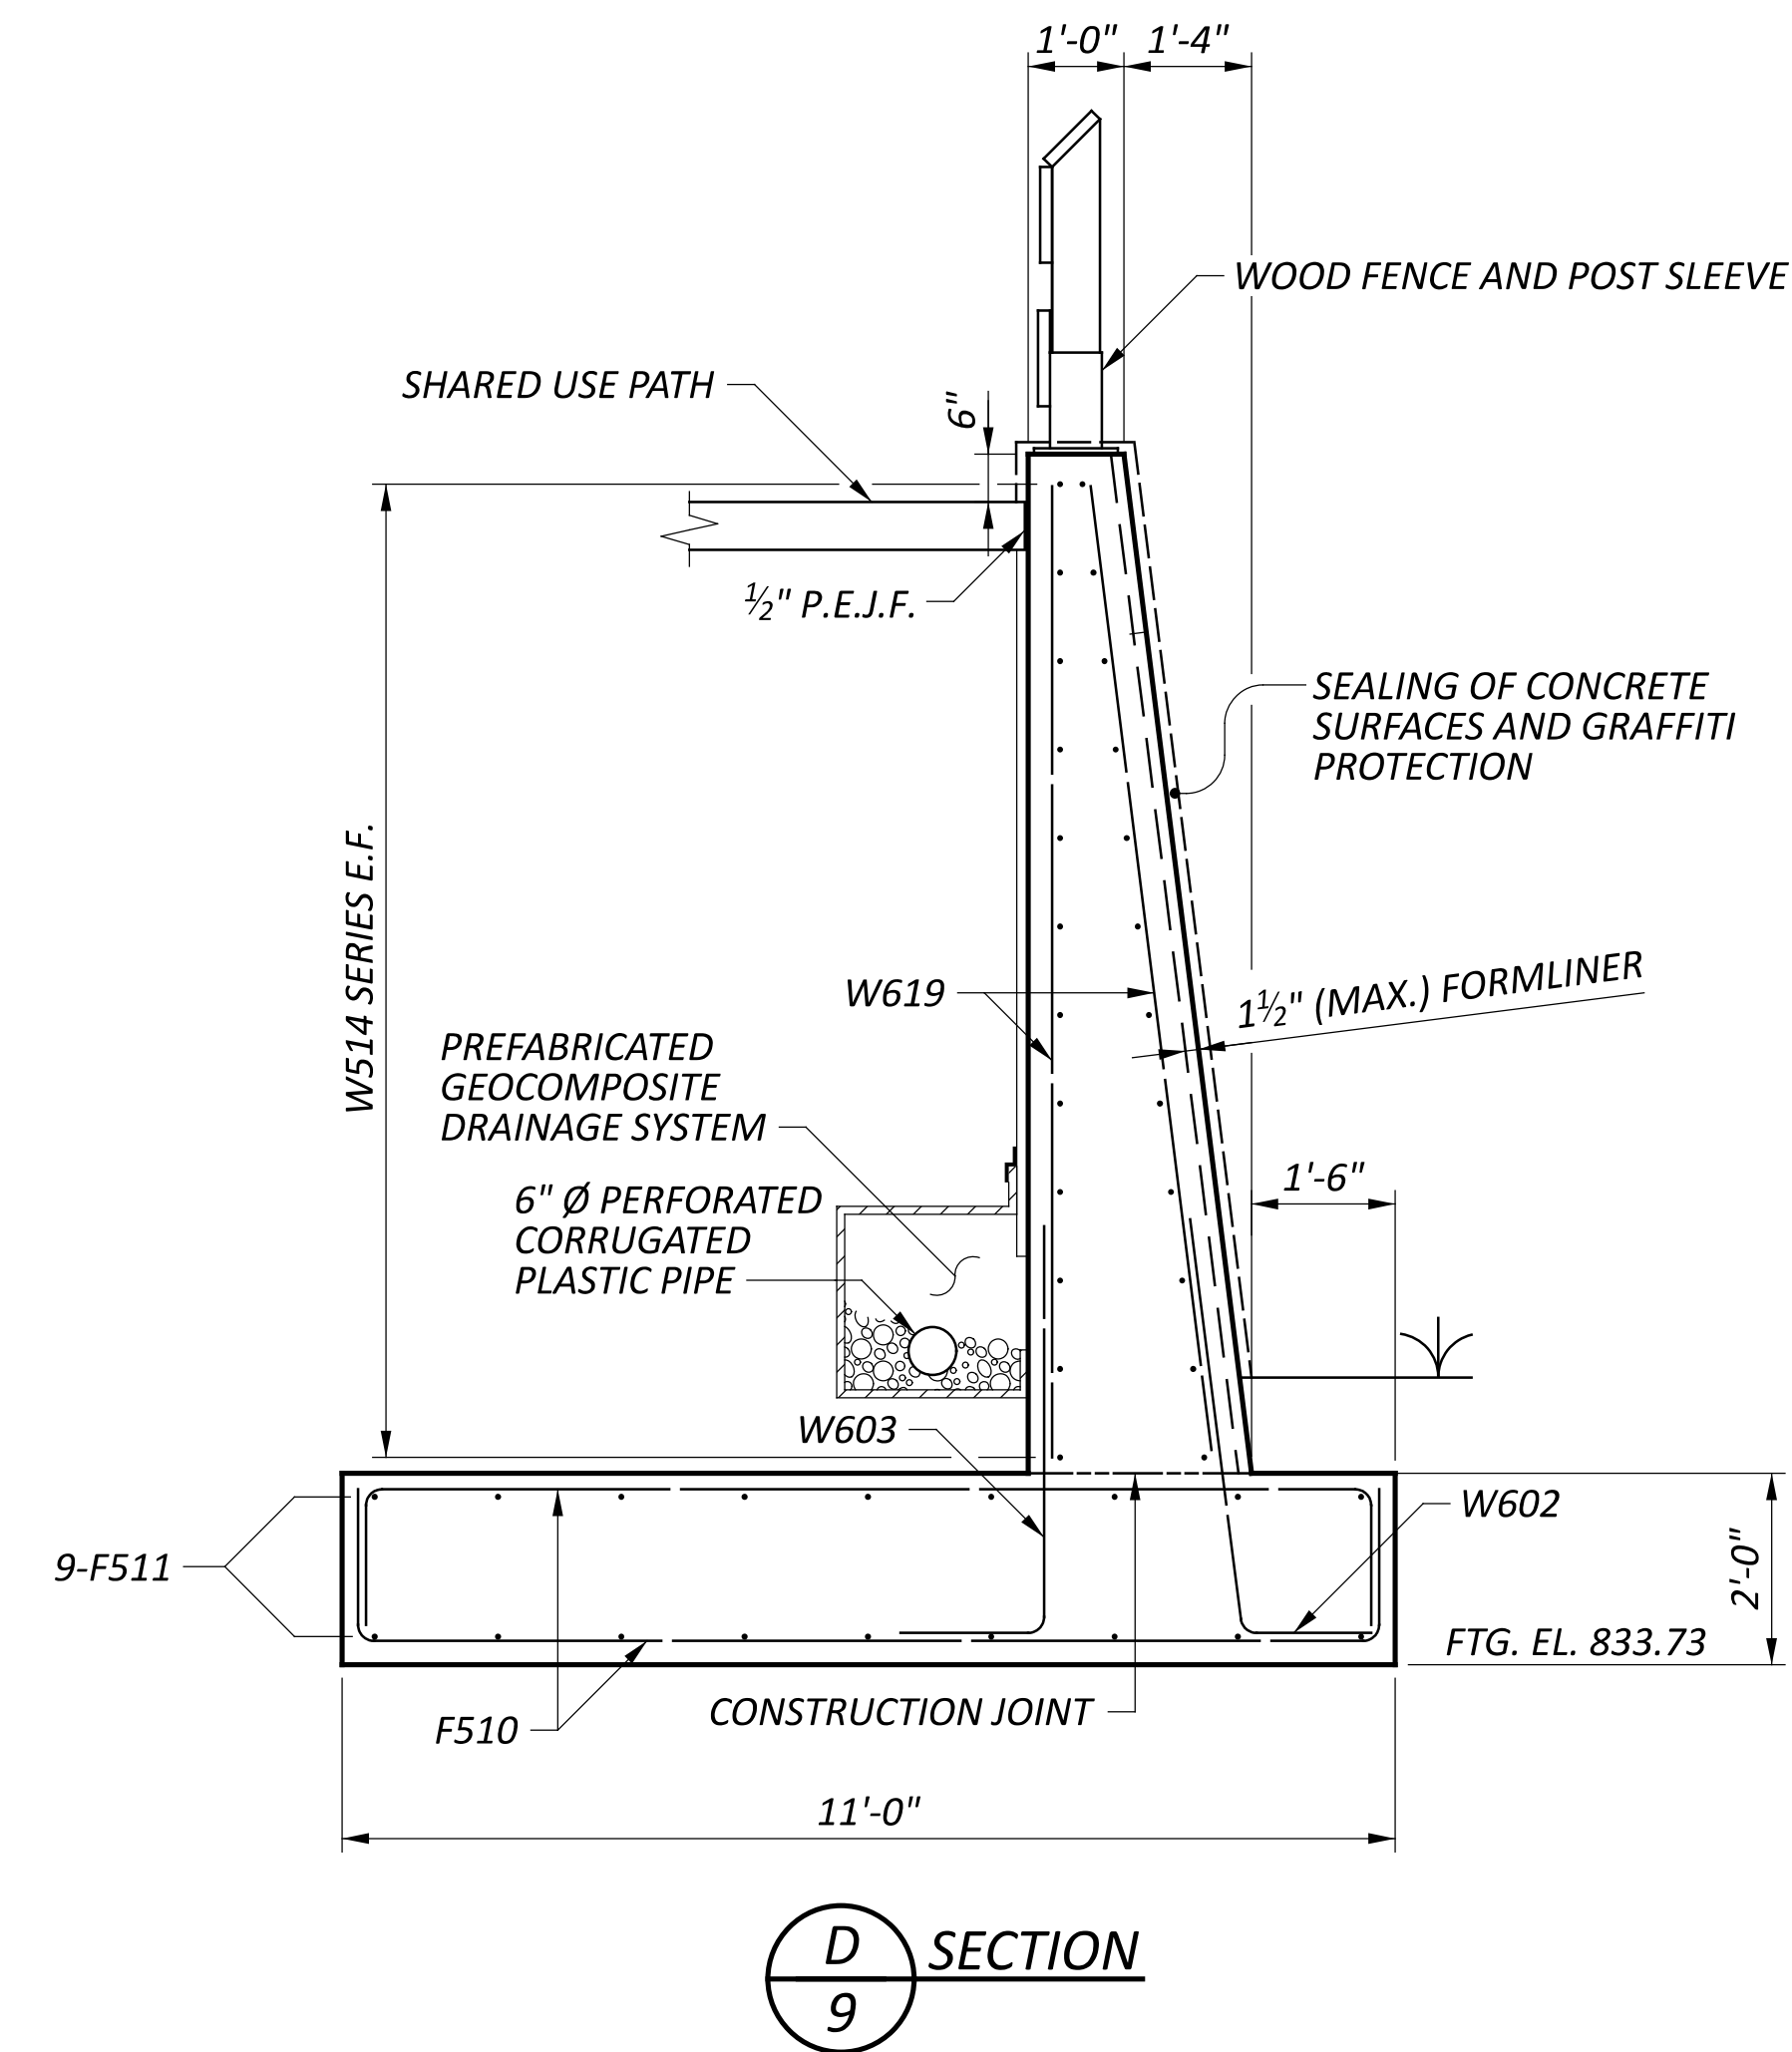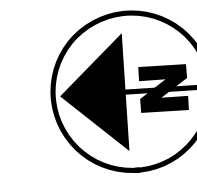

SECTION

NOTES

- REFER TO SHEET **6/12** FOR CONTRACTION JOINT DETAIL.
- REFER TO SHEET **P.68/P.107** FOR POST SLEEVE DETAILS.

LEGEND

- E.F. - EACH FACE
- N.F. - NEAR FACE
- F.F. - FAR FACE

DESIGN AGENCY



DESIGNER: SMH  
 CHECKER: AMR

REVIEWER: GDJ  
 DATE: 03/28/25

PROJECT ID: 115388

SUBSET: 9  
 TOTAL: 12


SHEET: P.82  
 TOTAL: P.107

**NOTES**


1. REFER TO SHEET **6/12** FOR EXPANSION AND CONTRACTION JOINT DETAILS.
2. PIPE CONNECTS TO CATCH BASIN (D27), INVERT EL. 833.50
3. REFER TO SHEET **P.68/P.107** FOR POST SLEEVE DETAILS.

**LEGEND**


- Δ - 5-W622 E.F., 4 SPA. @ 1'-0" = 4'-0"
- # - 4-W507 E.F., 3 SPA. @ 1'-6" = 4'-6"
- ! - 5-W507 E.F., 4 SPA. @ 1'-6" = 6'-0"
- E.F. - EACH FACE
- N.F. - NEAR FACE
- F.F. - FAR FACE

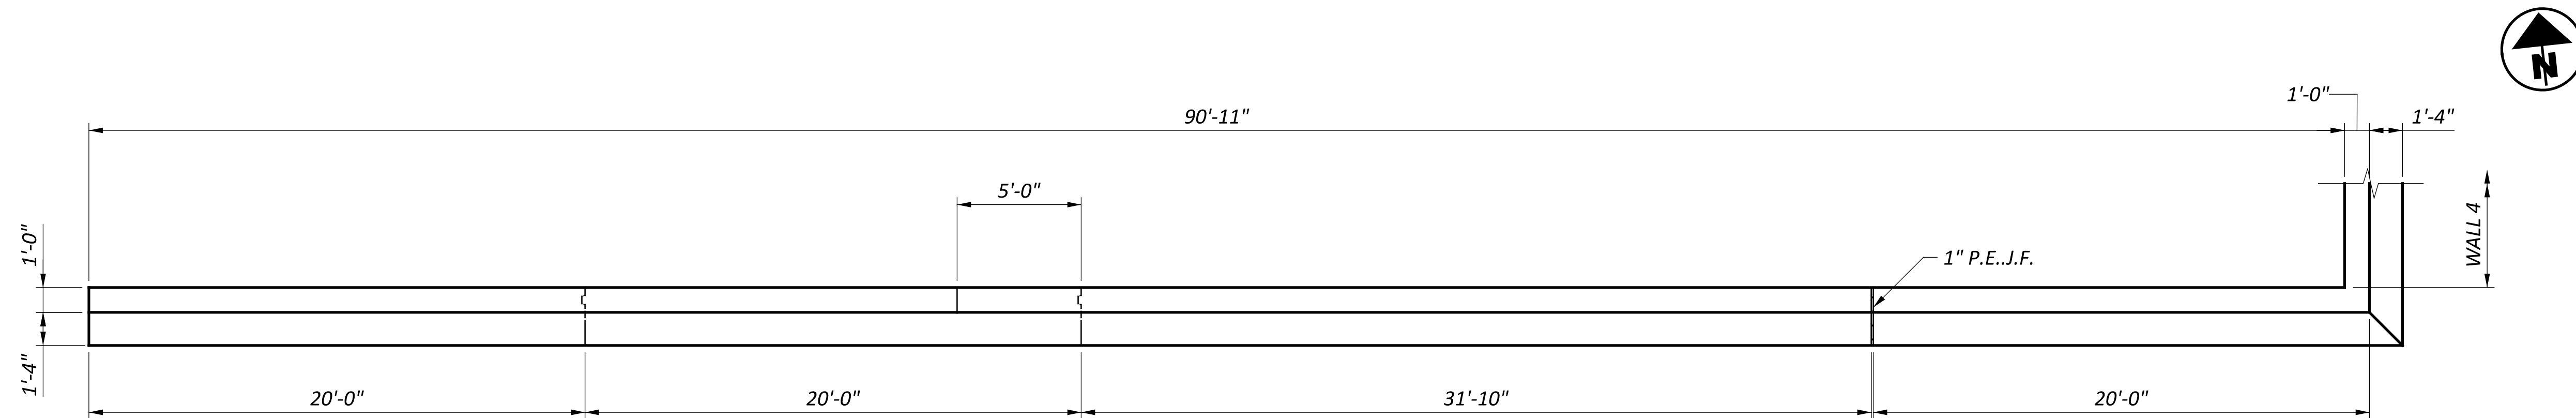

PLAN

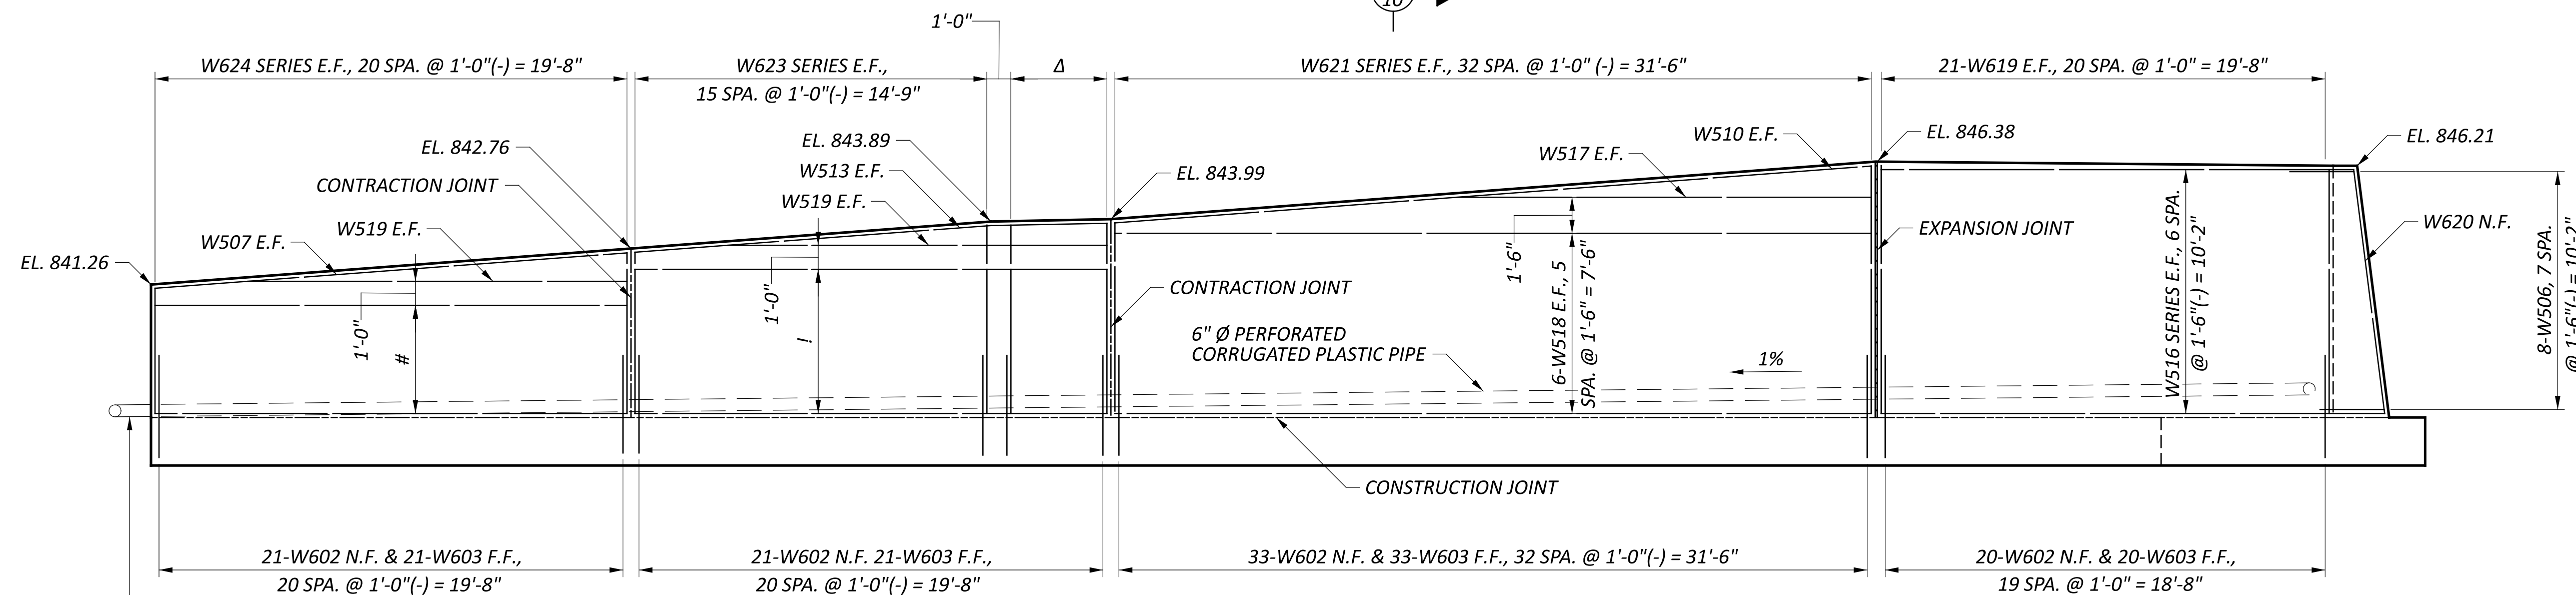

ELEVATION  
VIEWED ALONG FRONT FACE

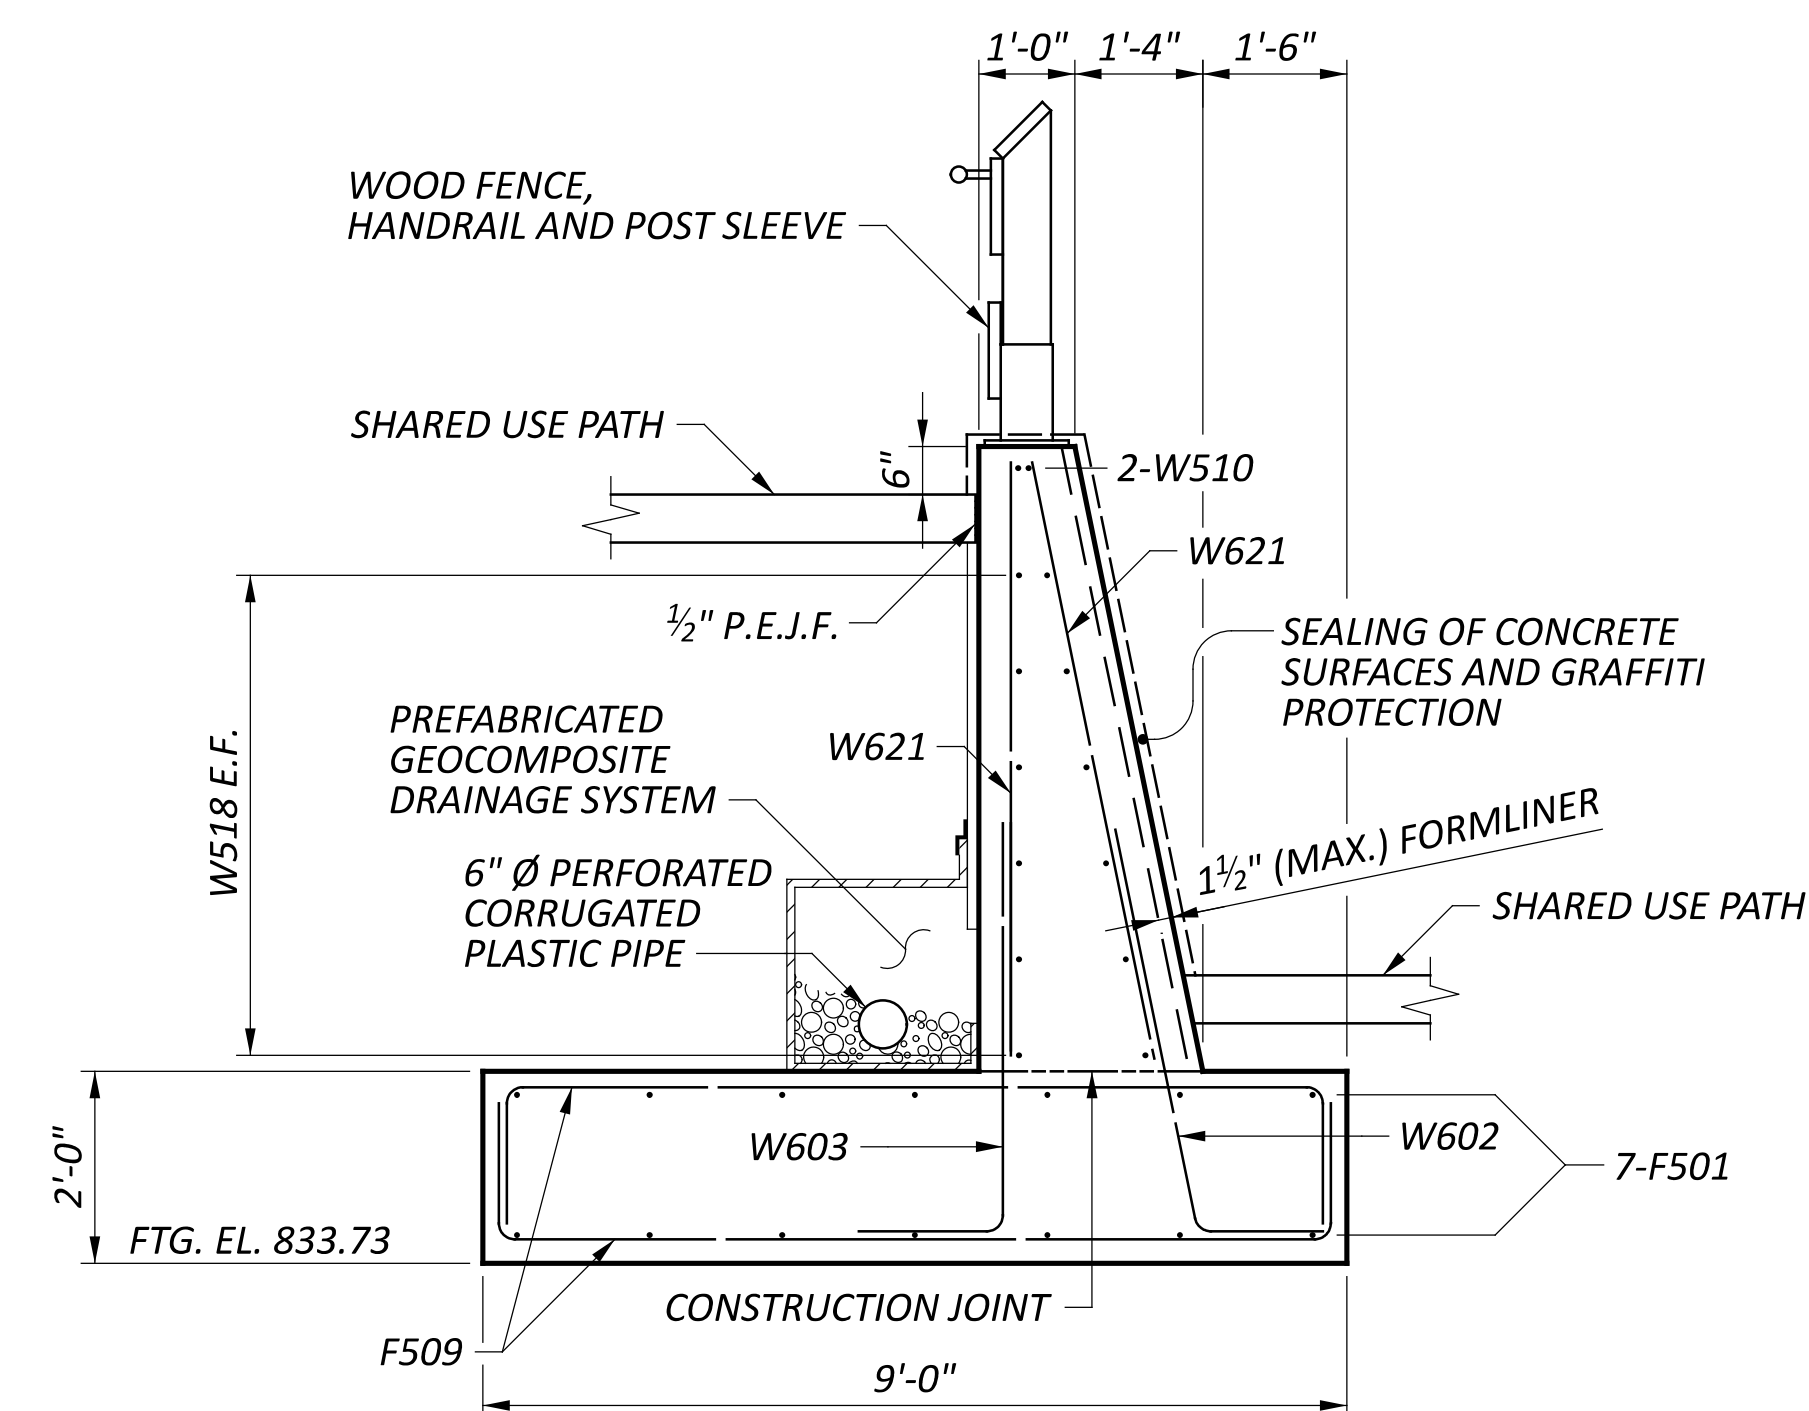

SECTION  
E 10

DESIGN AGENCY





DESIGNER: SMH  
CHECKER: AMR

REVIEWER: GDJ  
DATE: 03/28/25


PROJECT ID: 115388

SUBSET: 10  
TOTAL: 12


SHEET: P.83  
TOTAL: P.107

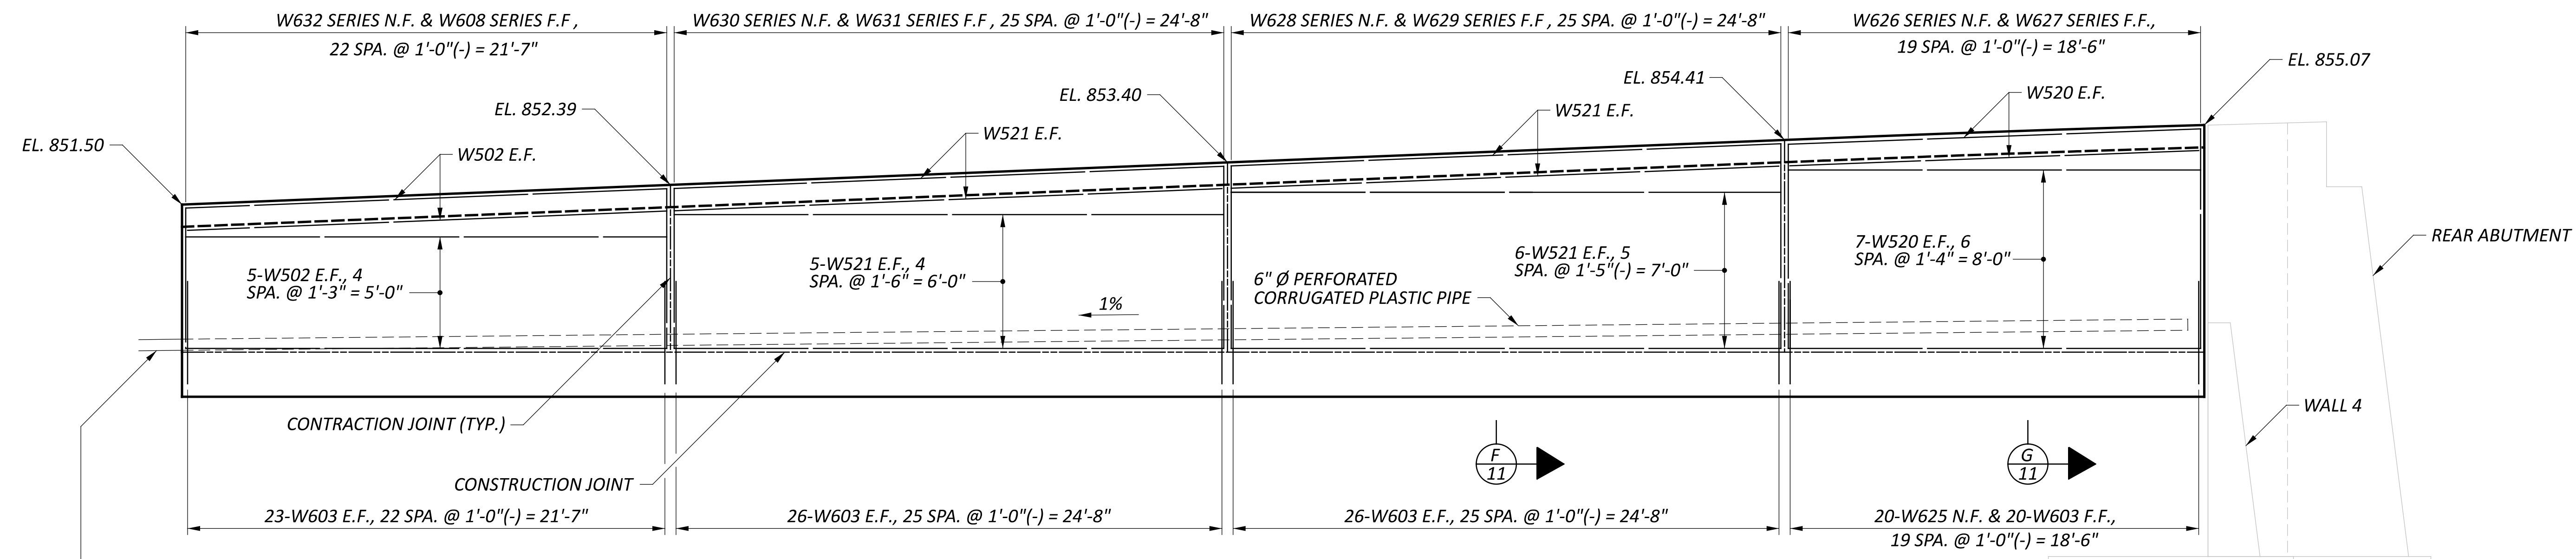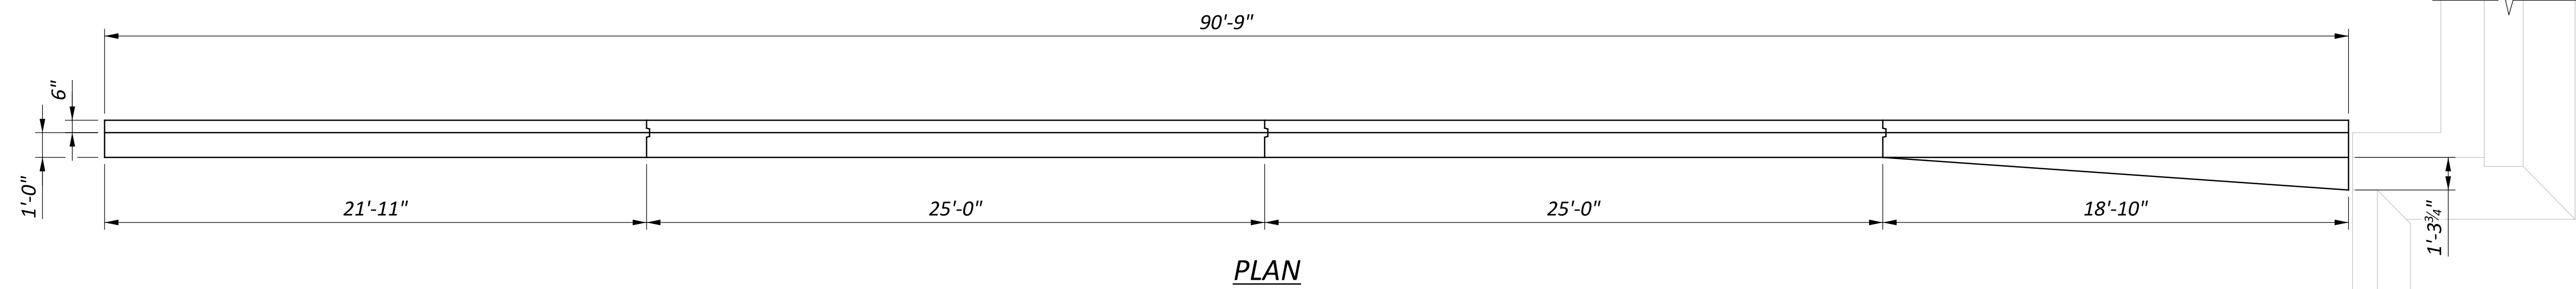

ELEVATION  
VIEWED ALONG FRONT FACE

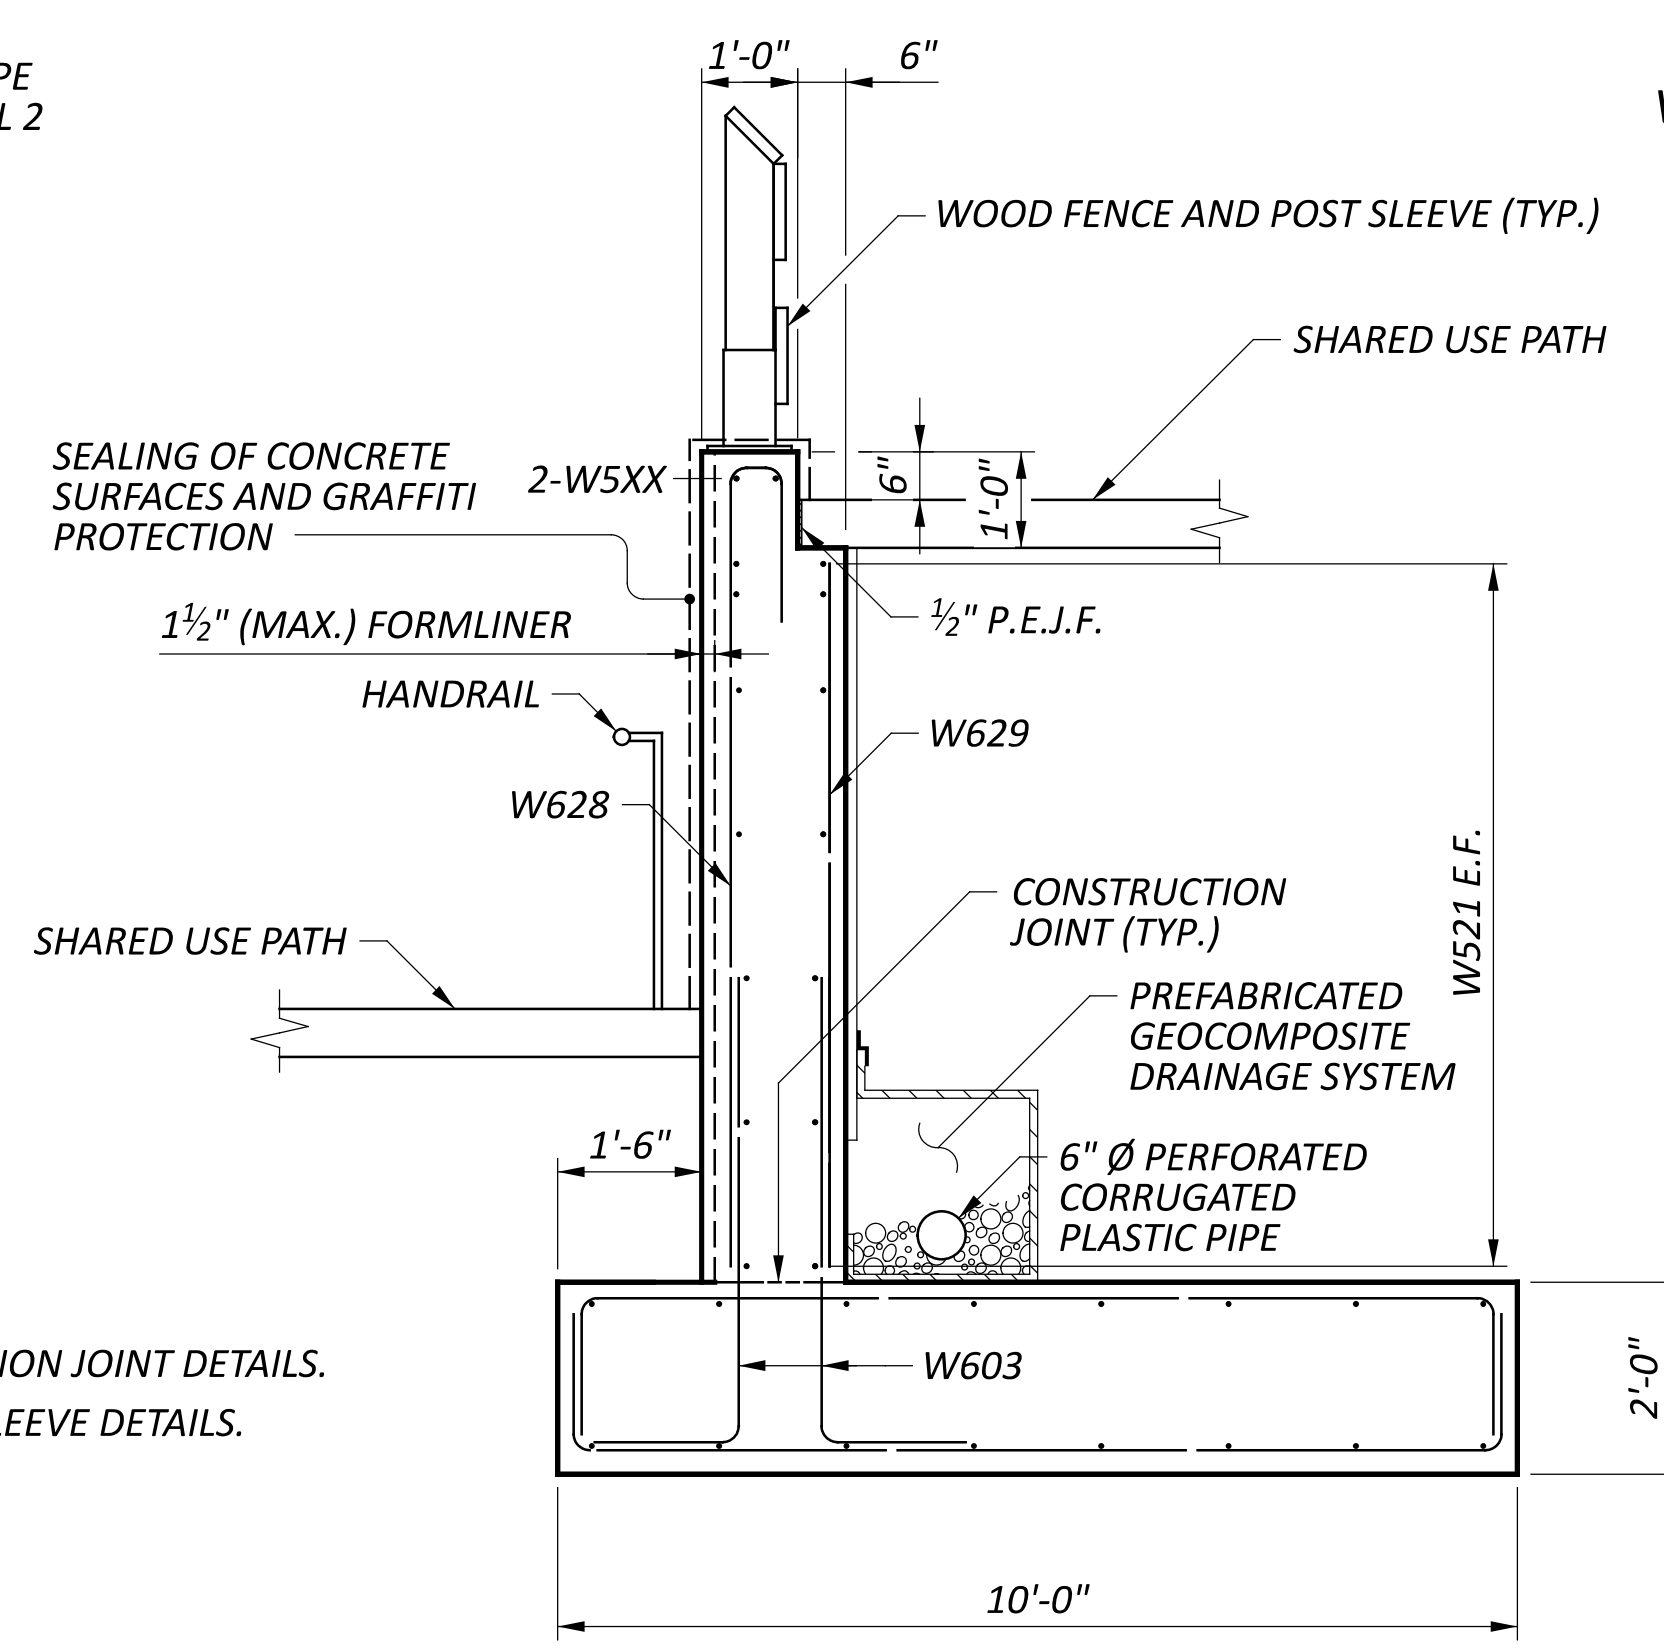

F SECTION  
11

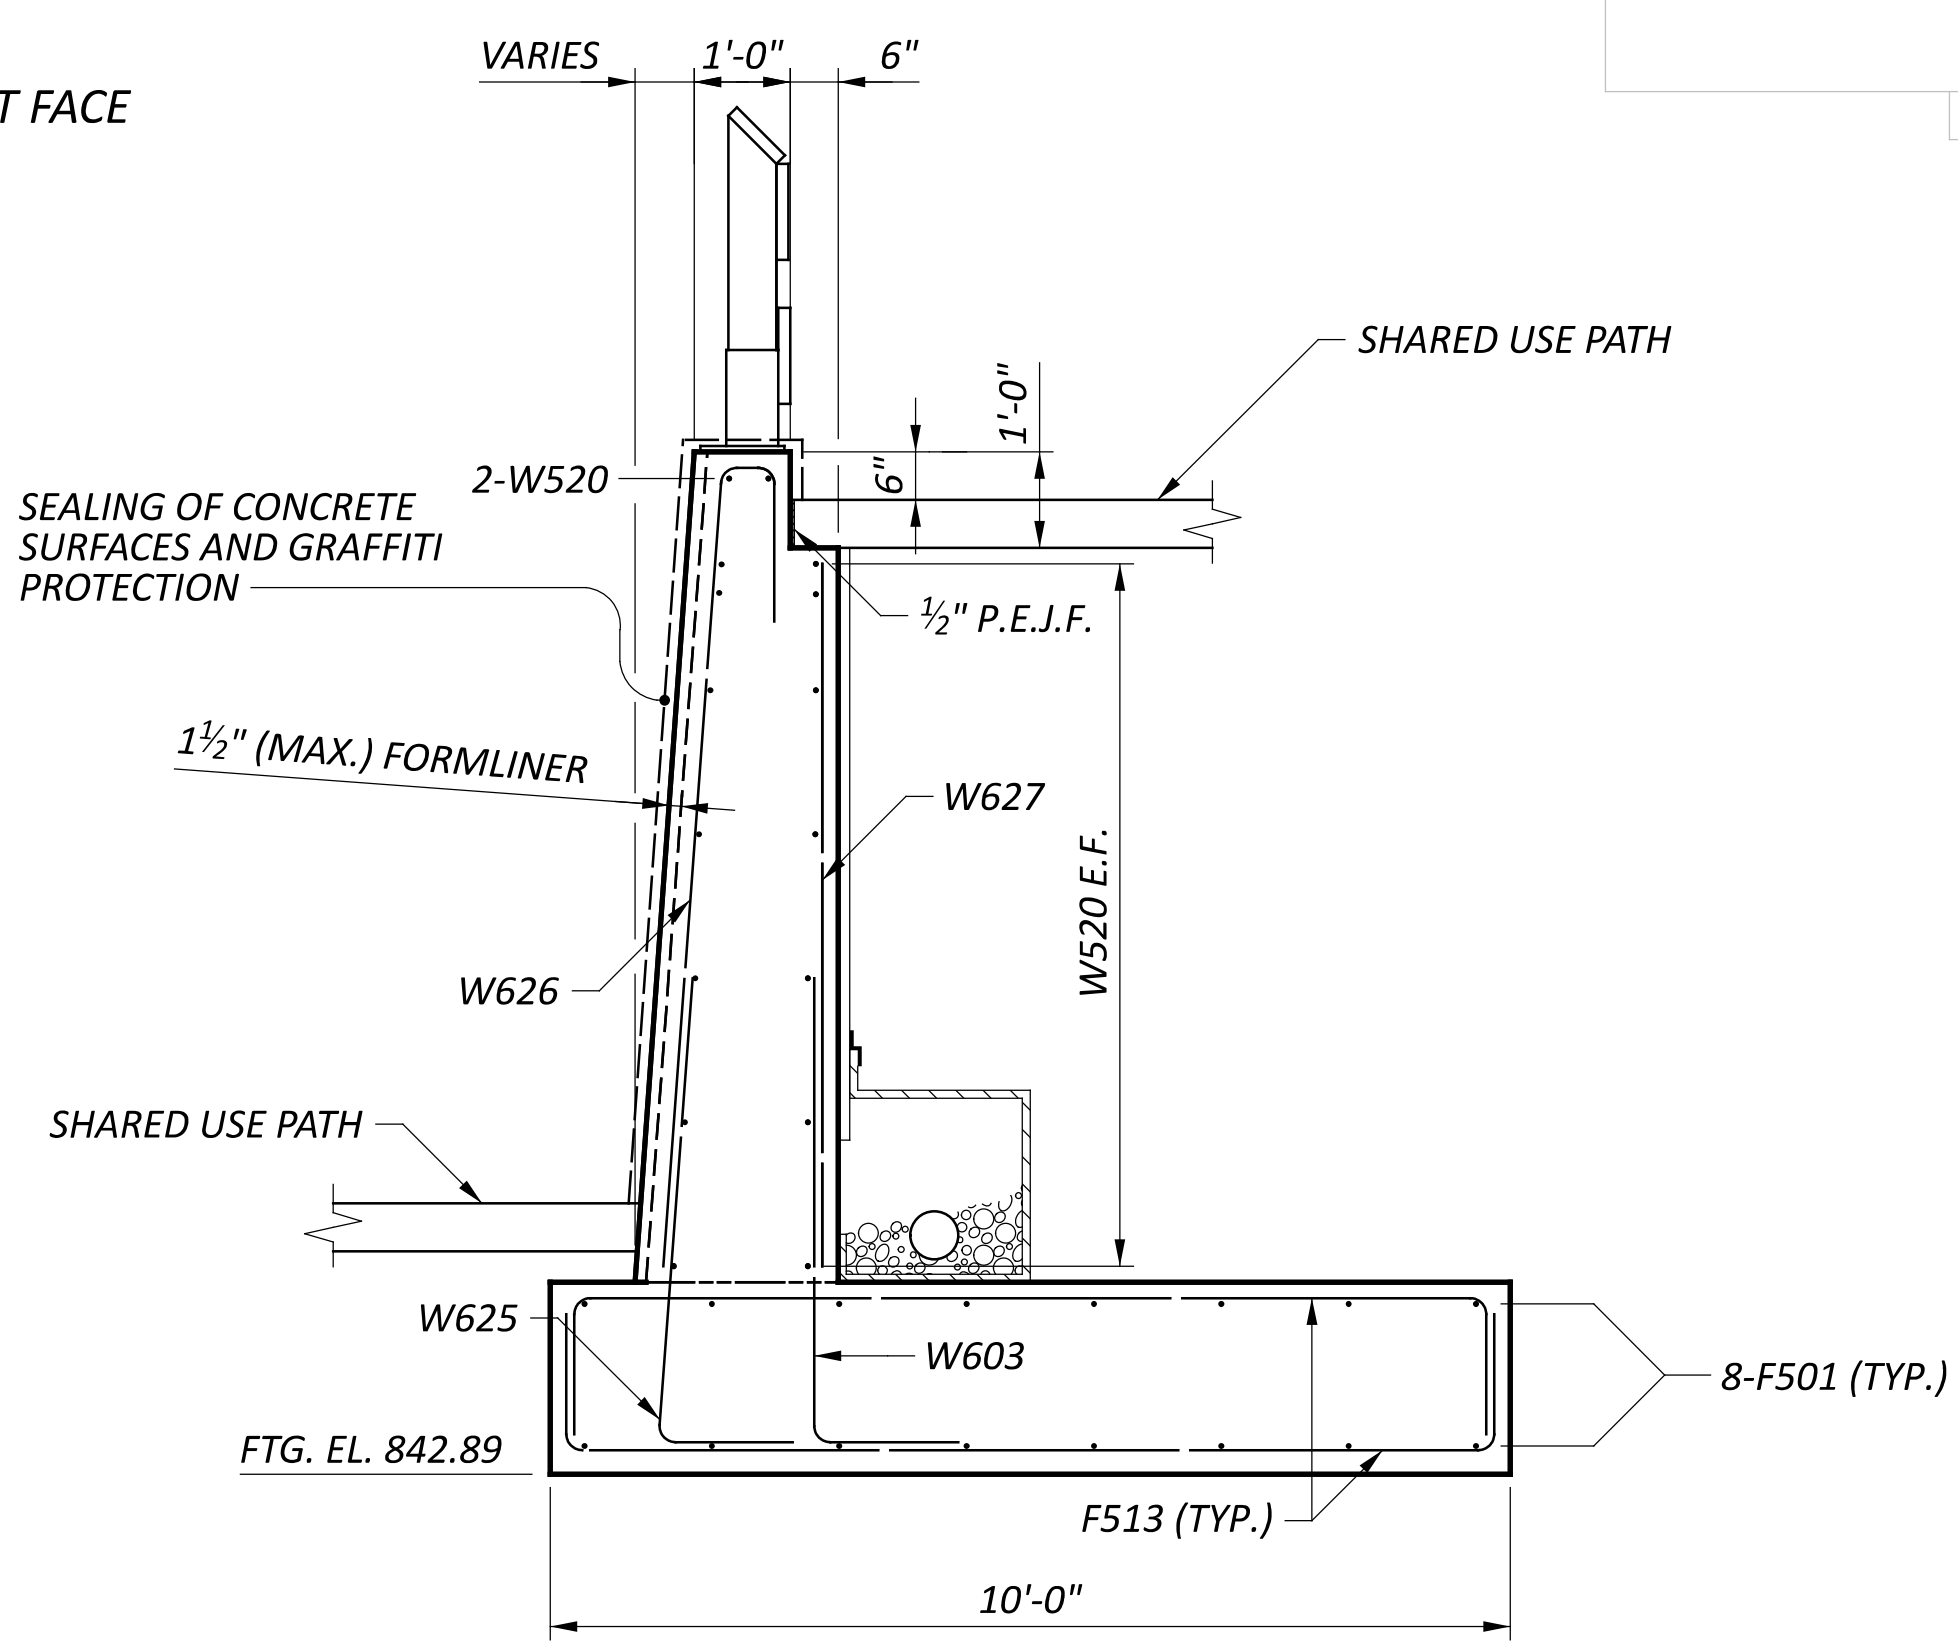

G SECTION  
11

- NOTES**
1. REFER TO SHEET **6/12** FOR CONTRACTION JOINT DETAILS.
  2. REFER TO SHEET **P.68/P.107** FOR POST SLEEVE DETAILS.

- LEGEND**
- E.F. - EACH FACE
  - N.F. - NEAR FACE
  - F.F. - FAR FACE


**WALL 6 DETAILS**  
**BRIDGE NO. GRE-BK80020.00.492**  
**PEDESTRIAN BRIDGE OVER US 68 AND OLDTOWN CREEK**

DESIGN AGENCY	
DESIGNER	CHECKER
MME	AMR
REVIEWER	
GDJ 03/28/25	
PROJECT ID	
115388	
SUBSET	TOTAL
11	12
SHEET	TOTAL
P.84	P.107

BAR MARK	MATERIAL TYPE	TOTAL	LENGTH	WEIGHT	TYPE	DIMENSIONS		
						A	B	C
<b>RETAINING WALL FOUNDATION (GALVANIZED STEEL REINFORCEMENT - GSR)</b>								
F501	GSR	184	30'-0"	5758	STR			
F502	GSR	14	31'-11"	467	STR			
F503	GSR	10	40'-5"	422	STR			
F504	GSR	14	39'-9"	581	STR			
F505	GSR	99	19'-7"	2023	2	1'-7"	16'-8"	1'-7"
F506	GSR	12	45'-2"	566	STR			
F507	GSR	14	17'-7"	257	2	1'-7"	14'-8"	1'-7"
F508	GSR	80	15'-7"	1301	2	1'-7"	12'-8"	1'-7"
F509	GSR	168	11'-7"	2030	2	1'-7"	8'-8"	1'-7"
F510	GSR	62	13'-7"	879	2	1'-7"	10'-8"	1'-7"
F511	GSR	18	39'-10"	748	STR			
F512	GSR	16	35'-9"	597	STR			
F513	GSR	182	12'-7"	2389	2	1'-7"	9'-8"	1'-7"
F801	GSR	14	32'-5"	1212	STR			
F802	GSR	10	40'-11"	1093	STR			
F803	GSR	99	19'-5"	5133	2	1'-7"	16'-8"	1'-7"
F804	GSR	12	45'-2"	1448	STR			
F805	GSR	14	17'-5"	652	2	1'-7"	14'-8"	1'-7"
F806	GSR	80	15'-5"	3294	2	1'-7"	12'-8"	1'-7"
<b>RETAINING WALL FOUNDATION GSR SUBTOTAL</b>				<b>30850</b>				





**NOTE**  
 THE BAR NUMBER IS SPECIFIED ON THE PLANS IN THE BAR MARK COLUMN. THE FIRST DIGIT INDICATES THE BAR SIZE NUMBER. FOR EXAMPLE, W501 IS A NO. 5 BAR. BAR DIMENSIONS ARE OUT-TO-OUT, UNLESS OTHERWISE NOTED.

**BENDING DIAGRAM**

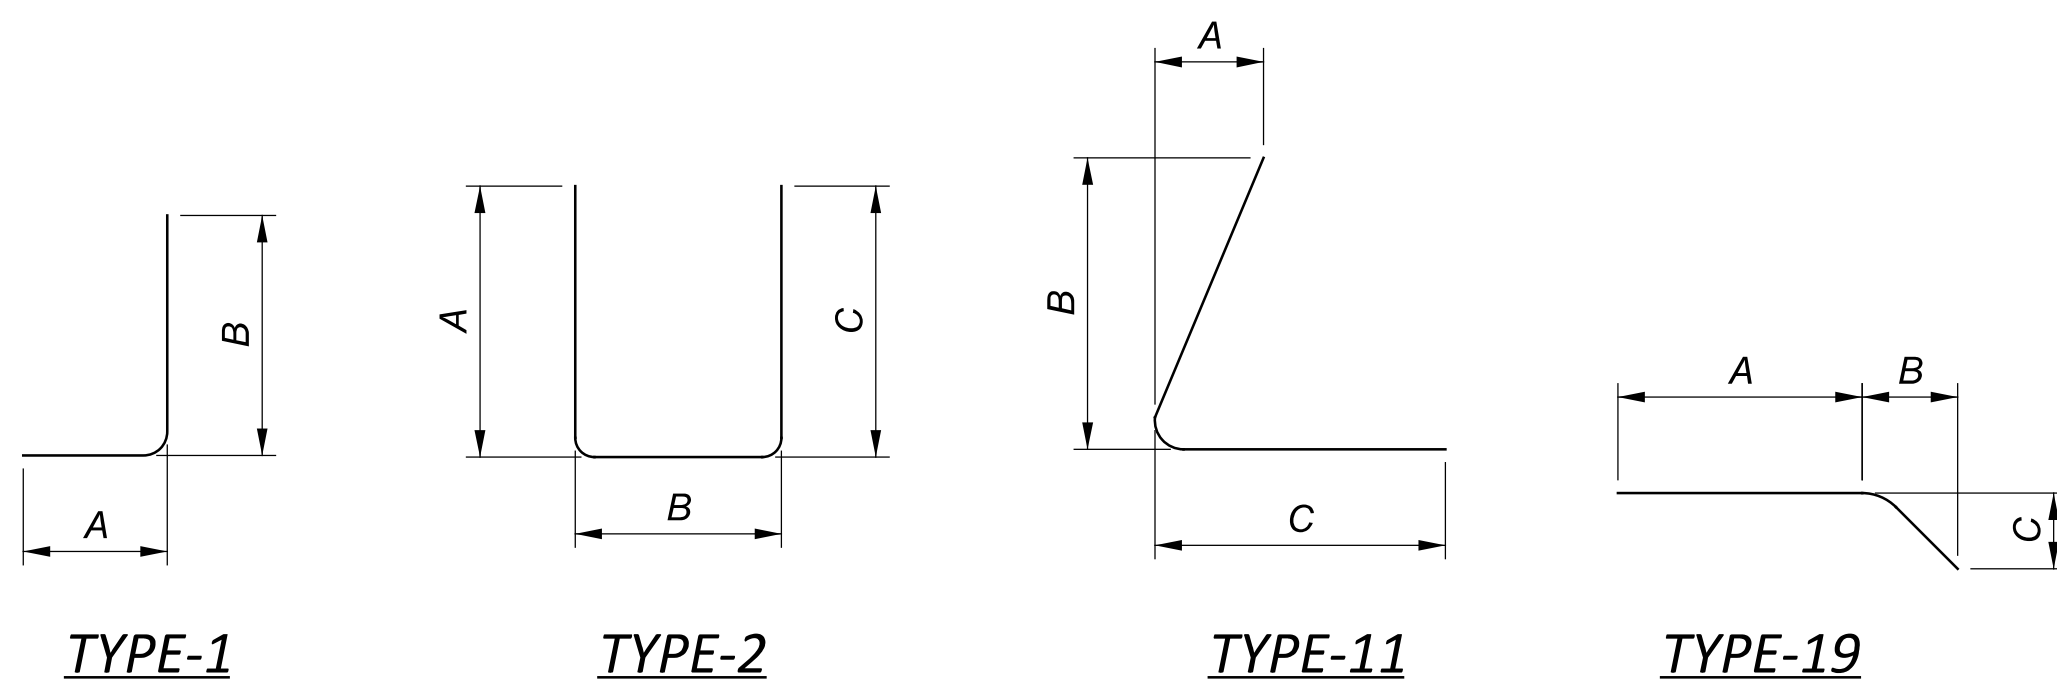


BAR MARK	MATERIAL TYPE	TOTAL	LENGTH	WEIGHT	TYPE	DIMENSIONS			
						A	B	C	INC
<b>RETAINING WALL (GALVANIZED STEEL REINFORCEMENT - GSR)</b>									
W501	GSR	28	30'-5"	889	STR				
W502	GSR	14	21'-7"	316	STR				
W503	GSR	50	29'-8"	1548	STR				
W504	GSR	2	19'-7"	41	STR				
W505	GSR	2 SERIES OF 11	19'-9" TO 21'-7"	475	STR				2"(+)
W506	GSR	32	5'-2"	173	1	2'-8"	2'-8"		
W507	GSR	86	19'-8"	1765	STR				
W508	GSR	2 SERIES OF 11	19'-11" TO 22'-2"	484	STR				3"(-)
W509	GSR	2 SERIES OF 11	19'-10" TO 21'-8"	477	STR				2"(+)
W510	GSR	6	31'-7"	198	STR				
W511	GSR	2	14'-5"	31	STR				
W512	GSR	20	31'-6"	658	STR				
W513	GSR	6	19'-9"	124	19	14'-11"	4'-10"	3"	
W514	GSR	2 SERIES OF 8	18'-5" TO 19'-9"	319	STR				2"(+)
W515	GSR	2 SERIES OF 8	18'-3" TO 19'-7"	316	STR				3"(-)
W516	GSR	2 SERIES OF 7	19'-8" TO 21'-0"	297	STR				3"(-)
W517	GSR	2	17'-3"	36	STR				
W518	GSR	12	31'-6"	395	STR				
W519	GSR	4	15'-10"	67	STR				
W520	GSR	18	18'-6"	348	STR				
W521	GSR	30	24'-8"	772	STR				
W601	GSR	2 SERIES OF 32	17'-10" TO 19'-0"	1771	STR				1" (-)
W602	GSR	287	6'-1"	2623	19	5'-0"	2"	1'-2"	
W603	GSR	647	6'-3"	6074	1	1'-6"	4'-11"		
W604	GSR	2 SERIES OF 31	16'-8" TO 17'-10"	1659	STR				1" (-)
W605	GSR	2 SERIES OF 31	15'-5" TO 16'-8"	1543	STR				1" (-)
W606	GSR	119	15'-3"	2726	STR				
W607	GSR	1	15'-5"	24	STR				
W608	GSR	1 SERIES OF 23	5'-4" TO 6'-2"	199	STR				1" (-)
W609	GSR	20	14'-3"	429	STR				
W610	GSR	20	17'-0"	511	2	15'-4"	6"	1'-6"	
W611	GSR	1 SERIES OF 33	12'-1" TO 14'-5"	657	STR				1" (-)
W612	GSR	1 SERIES OF 33	14'-9" TO 17'-1"	789	2	13'-1" TO 15'-5"	6"	1'-6"	1" (-)
W613	GSR	5	12'-0"	91	STR				
W614	GSR	5	14'-8"	111	2	13'-0"	6"	1'-6"	
W615	GSR	1 SERIES OF 16	10'-10" TO 11'-11"	274	STR				1" (-)
W616	GSR	1 SERIES OF 16	13'-6" TO 14'-7"	339	2	11'-10" TO 12'-11"	6"	1'-6"	1" (-)
W617	GSR	1 SERIES OF 21	9'-4" TO 10'-10"	319	STR				1" (-)
W618	GSR	1 SERIES OF 21	12'-0" TO 13'-6"	403	2	10'-4" TO 11'-10"	6"	1'-6"	1" (-)
W619	GSR	120	10'-2"	1833	STR				
W620	GSR	1	10'-4"	16	STR				
W621	GSR	2 SERIES OF 33	7'-11" TO 10'-4"	905	STR				1" (-)
W622	GSR	10	7'-10"	118	STR				
W623	GSR	2 SERIES OF 16	6'-9" TO 7'-10"	351	STR				1" (-)
W624	GSR	2 SERIES OF 21	5'-3" TO 6'-8"	376	STR				1" (-)
W625	GSR	20	6'-3"	188	11	8"	4'-11"	1'-6"	
W626	GSR	1 SERIES OF 20	10'-10" TO 11'-7"	338	2	9'-2" TO 9'-11"	6"	1'-6"	1" (-)
W627	GSR	1 SERIES OF 20	8'-2" TO 8'-11"	257	STR				1" (-)
W628	GSR	1 SERIES OF 26	9'-10" TO 10'-10"	404	2	8'-2" TO 9'-2"	6"	1'-6"	1" (-)
W629	GSR	1 SERIES OF 26	7'-2" TO 8'-2"	300	STR				1" (-)
W630	GSR	1 SERIES OF 26	8'-10" TO 9'-10"	365	2	7'-2" TO 8'-2"	6"	1'-6"	1" (-)
W631	GSR	1 SERIES OF 26	6'-2" TO 7'-2"	261	STR				1" (-)
W632	GSR	1 SERIES OF 23	8'-0" TO 8'-10"	291	2	6'-4" TO 7'-2"	6"	1'-6"	1" (-)
<b>RETAINING WALL GSR SUBTOTAL</b>				<b>36274</b>					



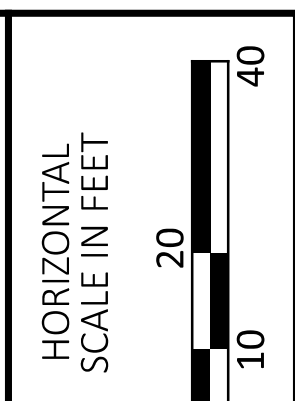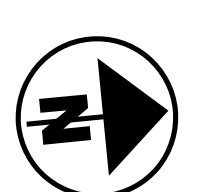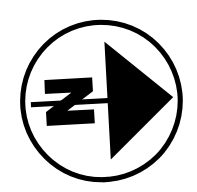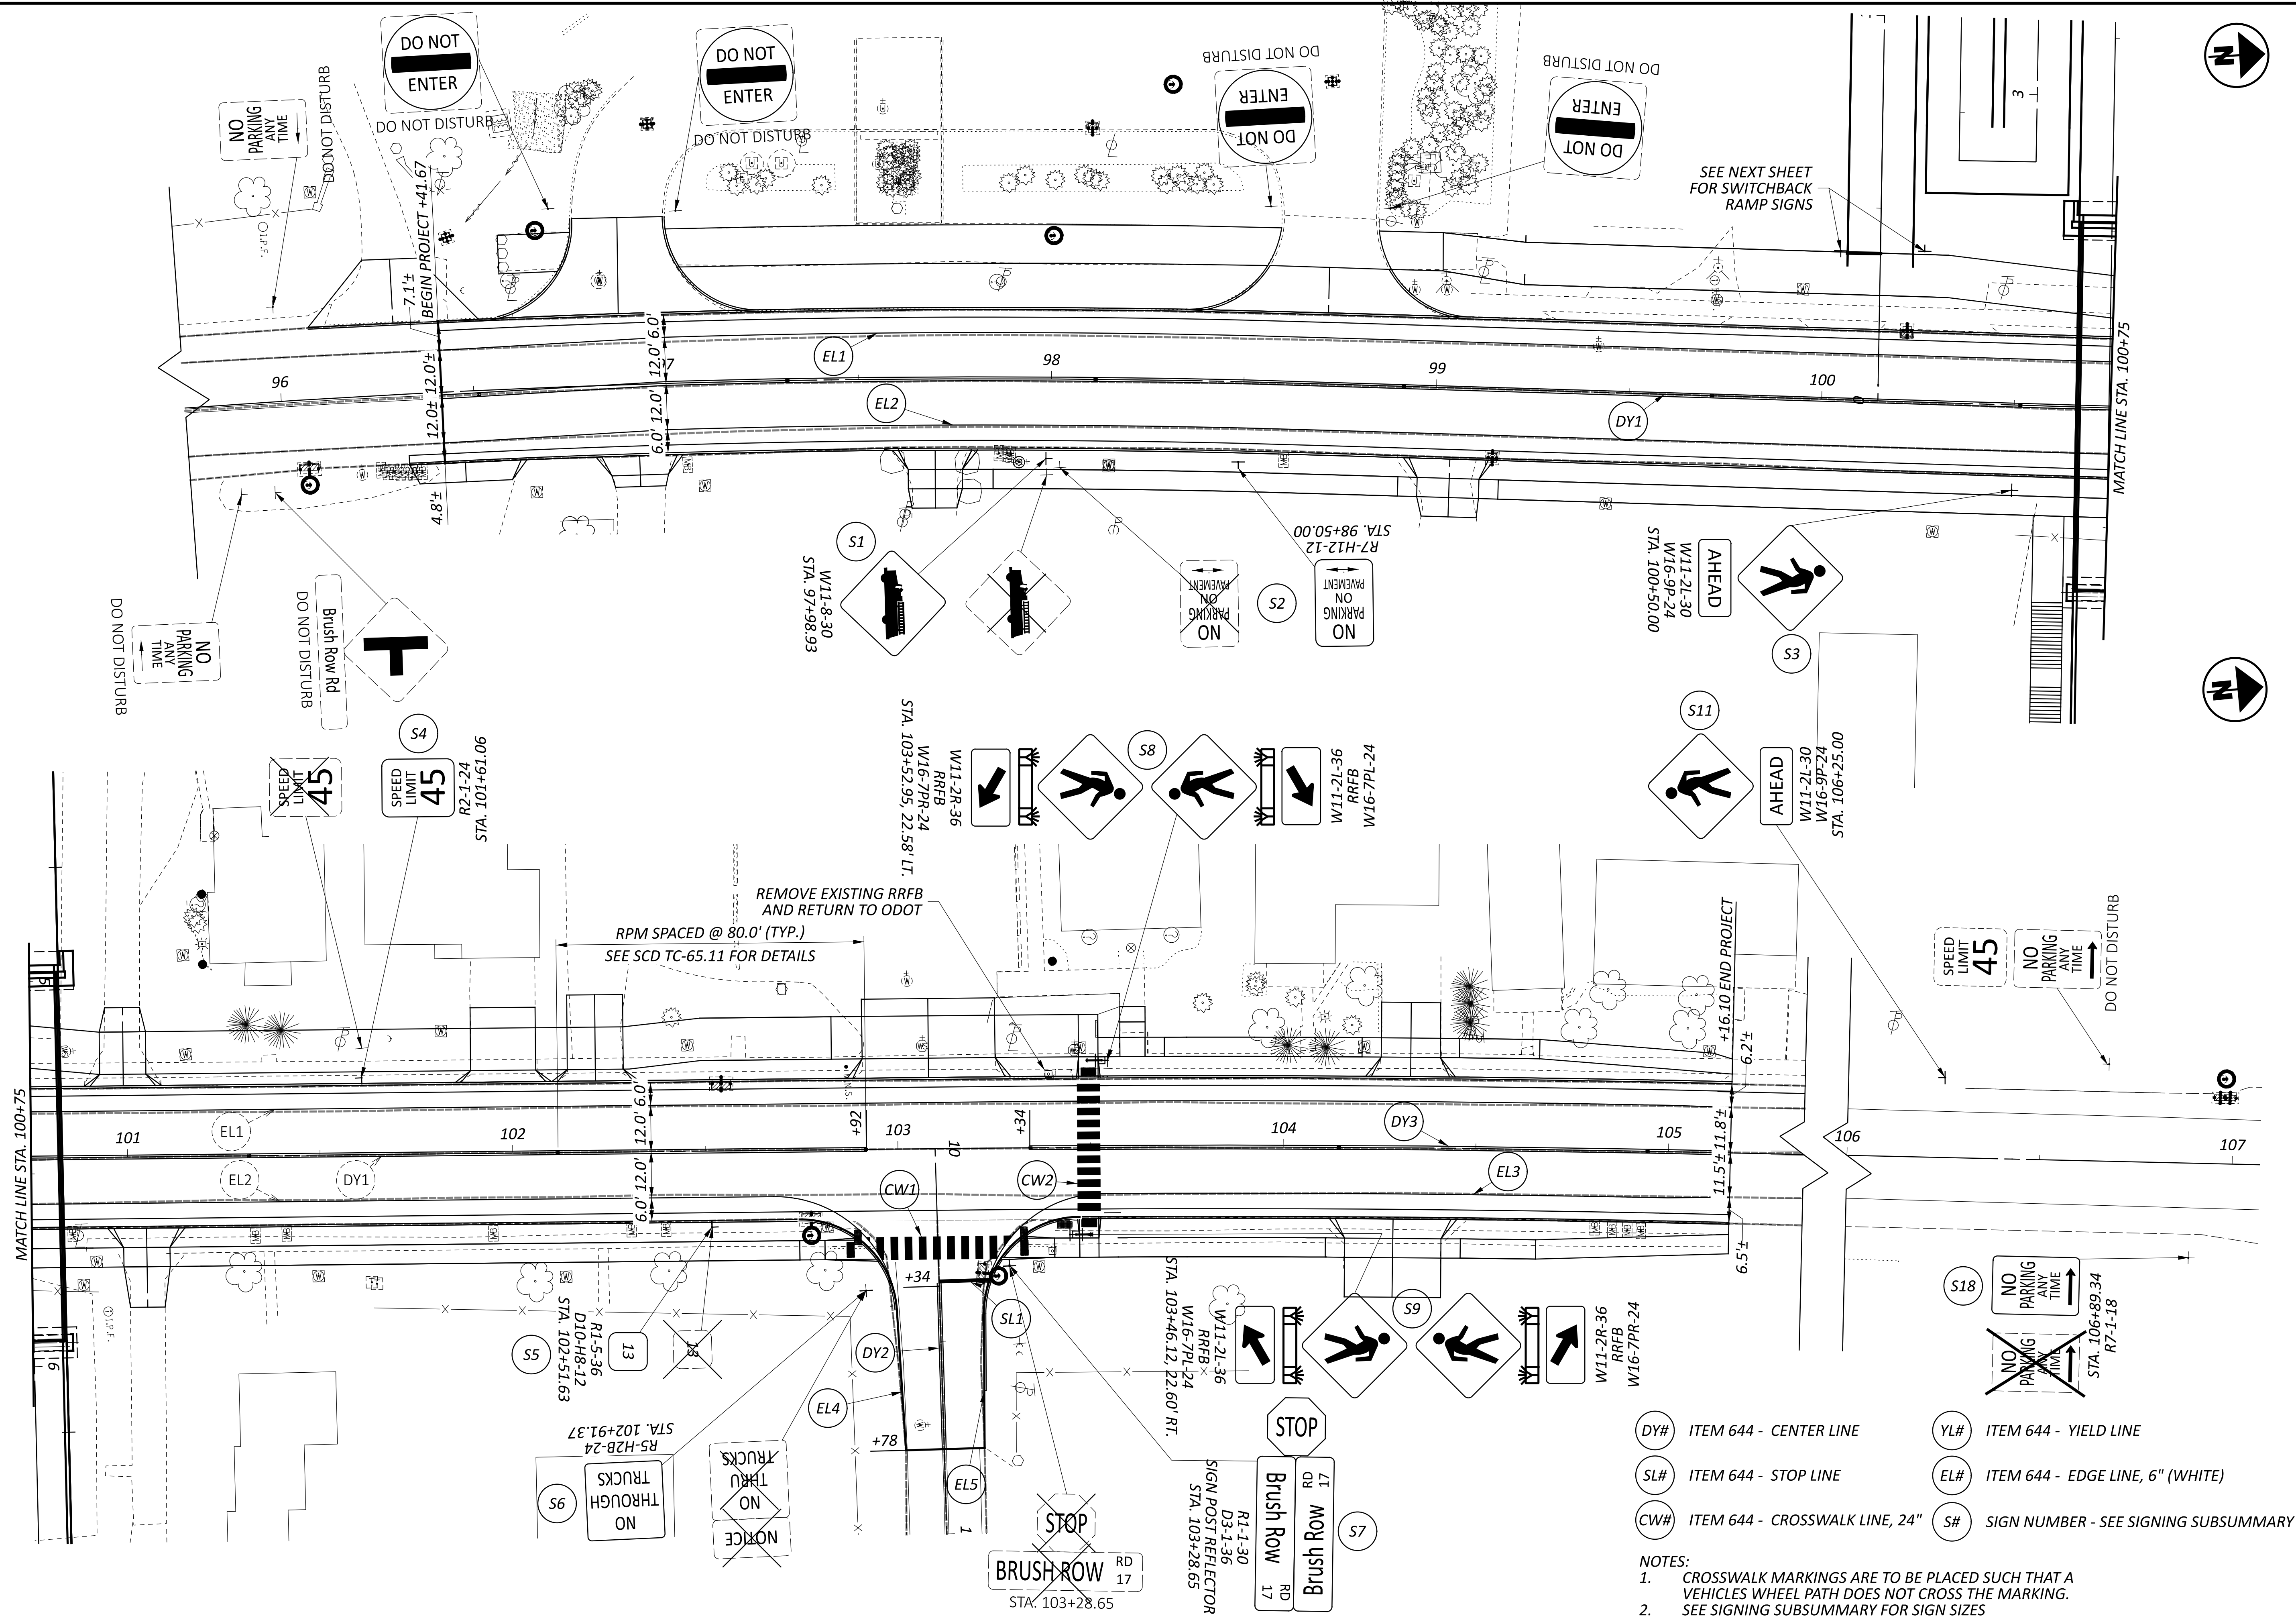


TRAFFIC CONTROL PLANS - U.S. 68  
 STA. 95+75.00 TO STA. 105+75.00

DESIGN AGENCY	
CARPENTER MARTY	
DESIGNER	WCS
REVIEWER	BAA 03/28/25
PROJECT ID	115388
SHEET	TOTAL
P.87	P.107

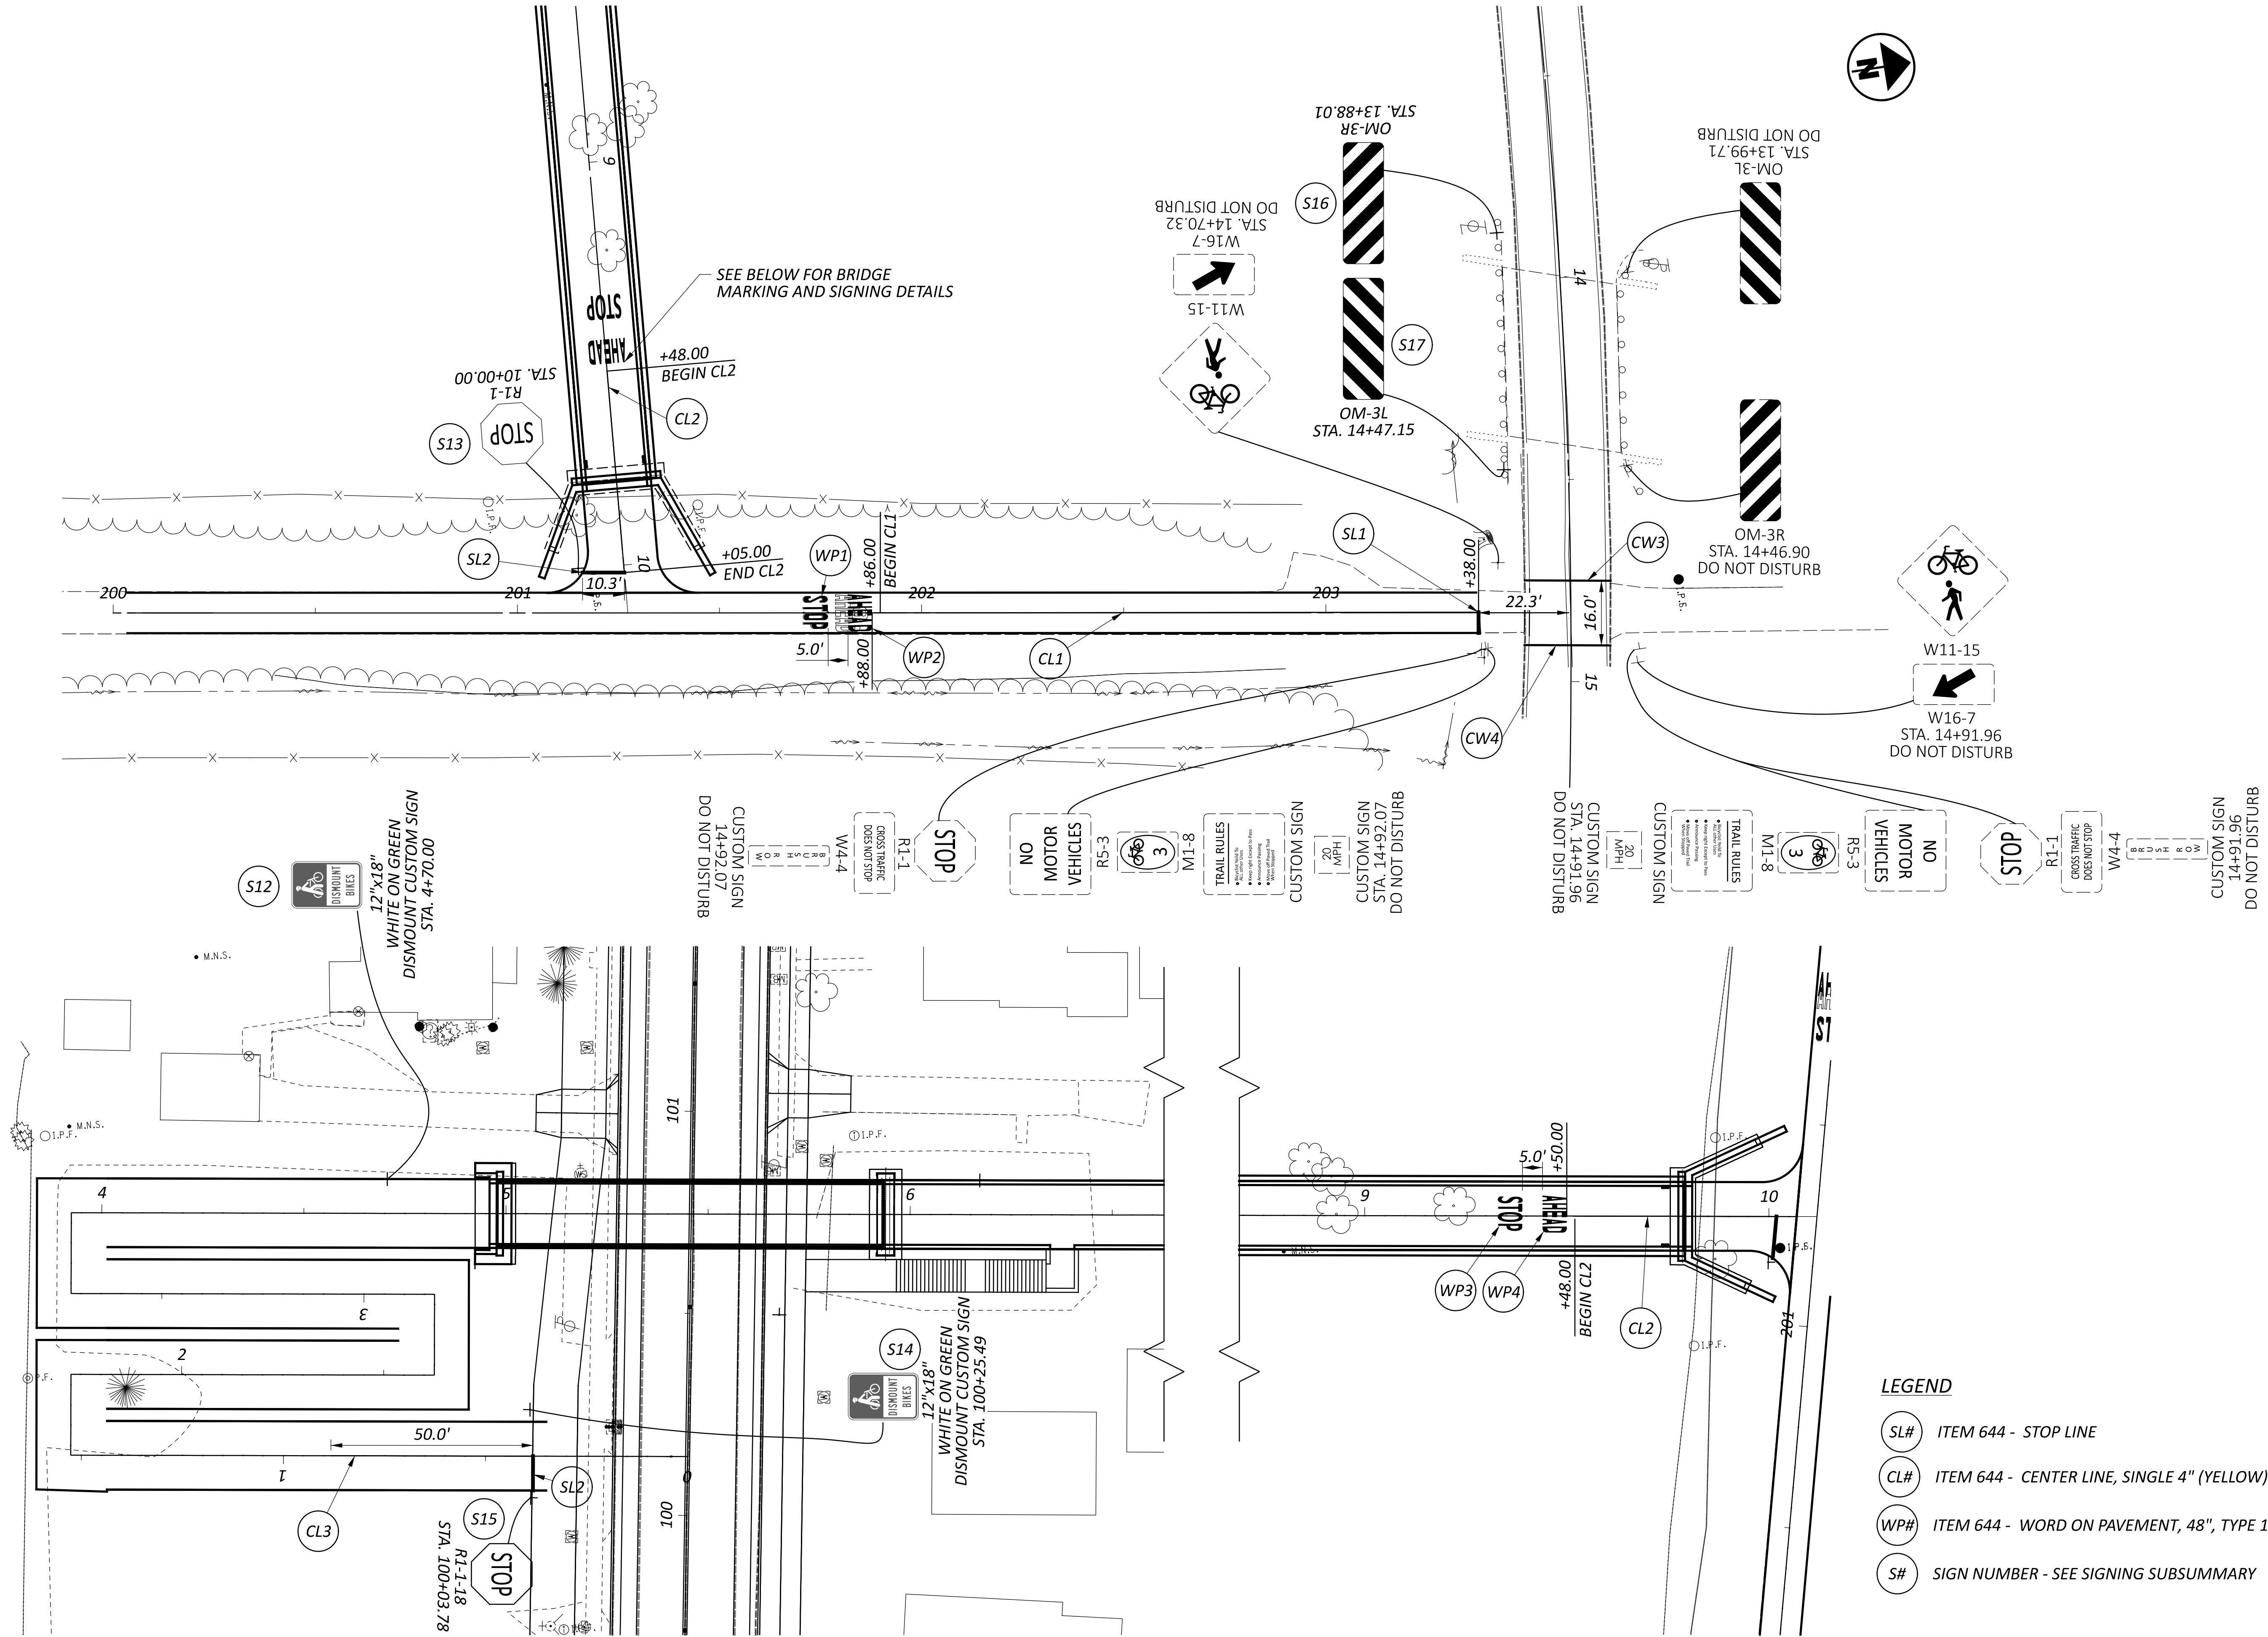


TRAFFIC CONTROL PLANS  
 LITTLE MIAMI SCENIC TRAIL AND NEW BRIDGE TRAIL

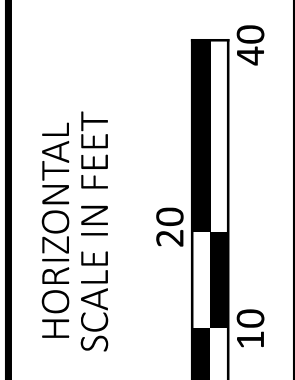


- LEGEND**
- (SL#) ITEM 644 - STOP LINE
  - (CL#) ITEM 644 - CENTER LINE, SINGLE 4" (YELLOW)
  - (WP#) ITEM 644 - WORD ON PAVEMENT, 48", TYPE 1
  - (S#) SIGN NUMBER - SEE SIGNING SUBSUMMARY

DESIGN AGENCY	CARPENTER MARTY
DESIGNER	WCS
REVIEWER	BAA
PROJECT ID	03/28/25
SHEET	115388
TOTAL	P.107
P.88	




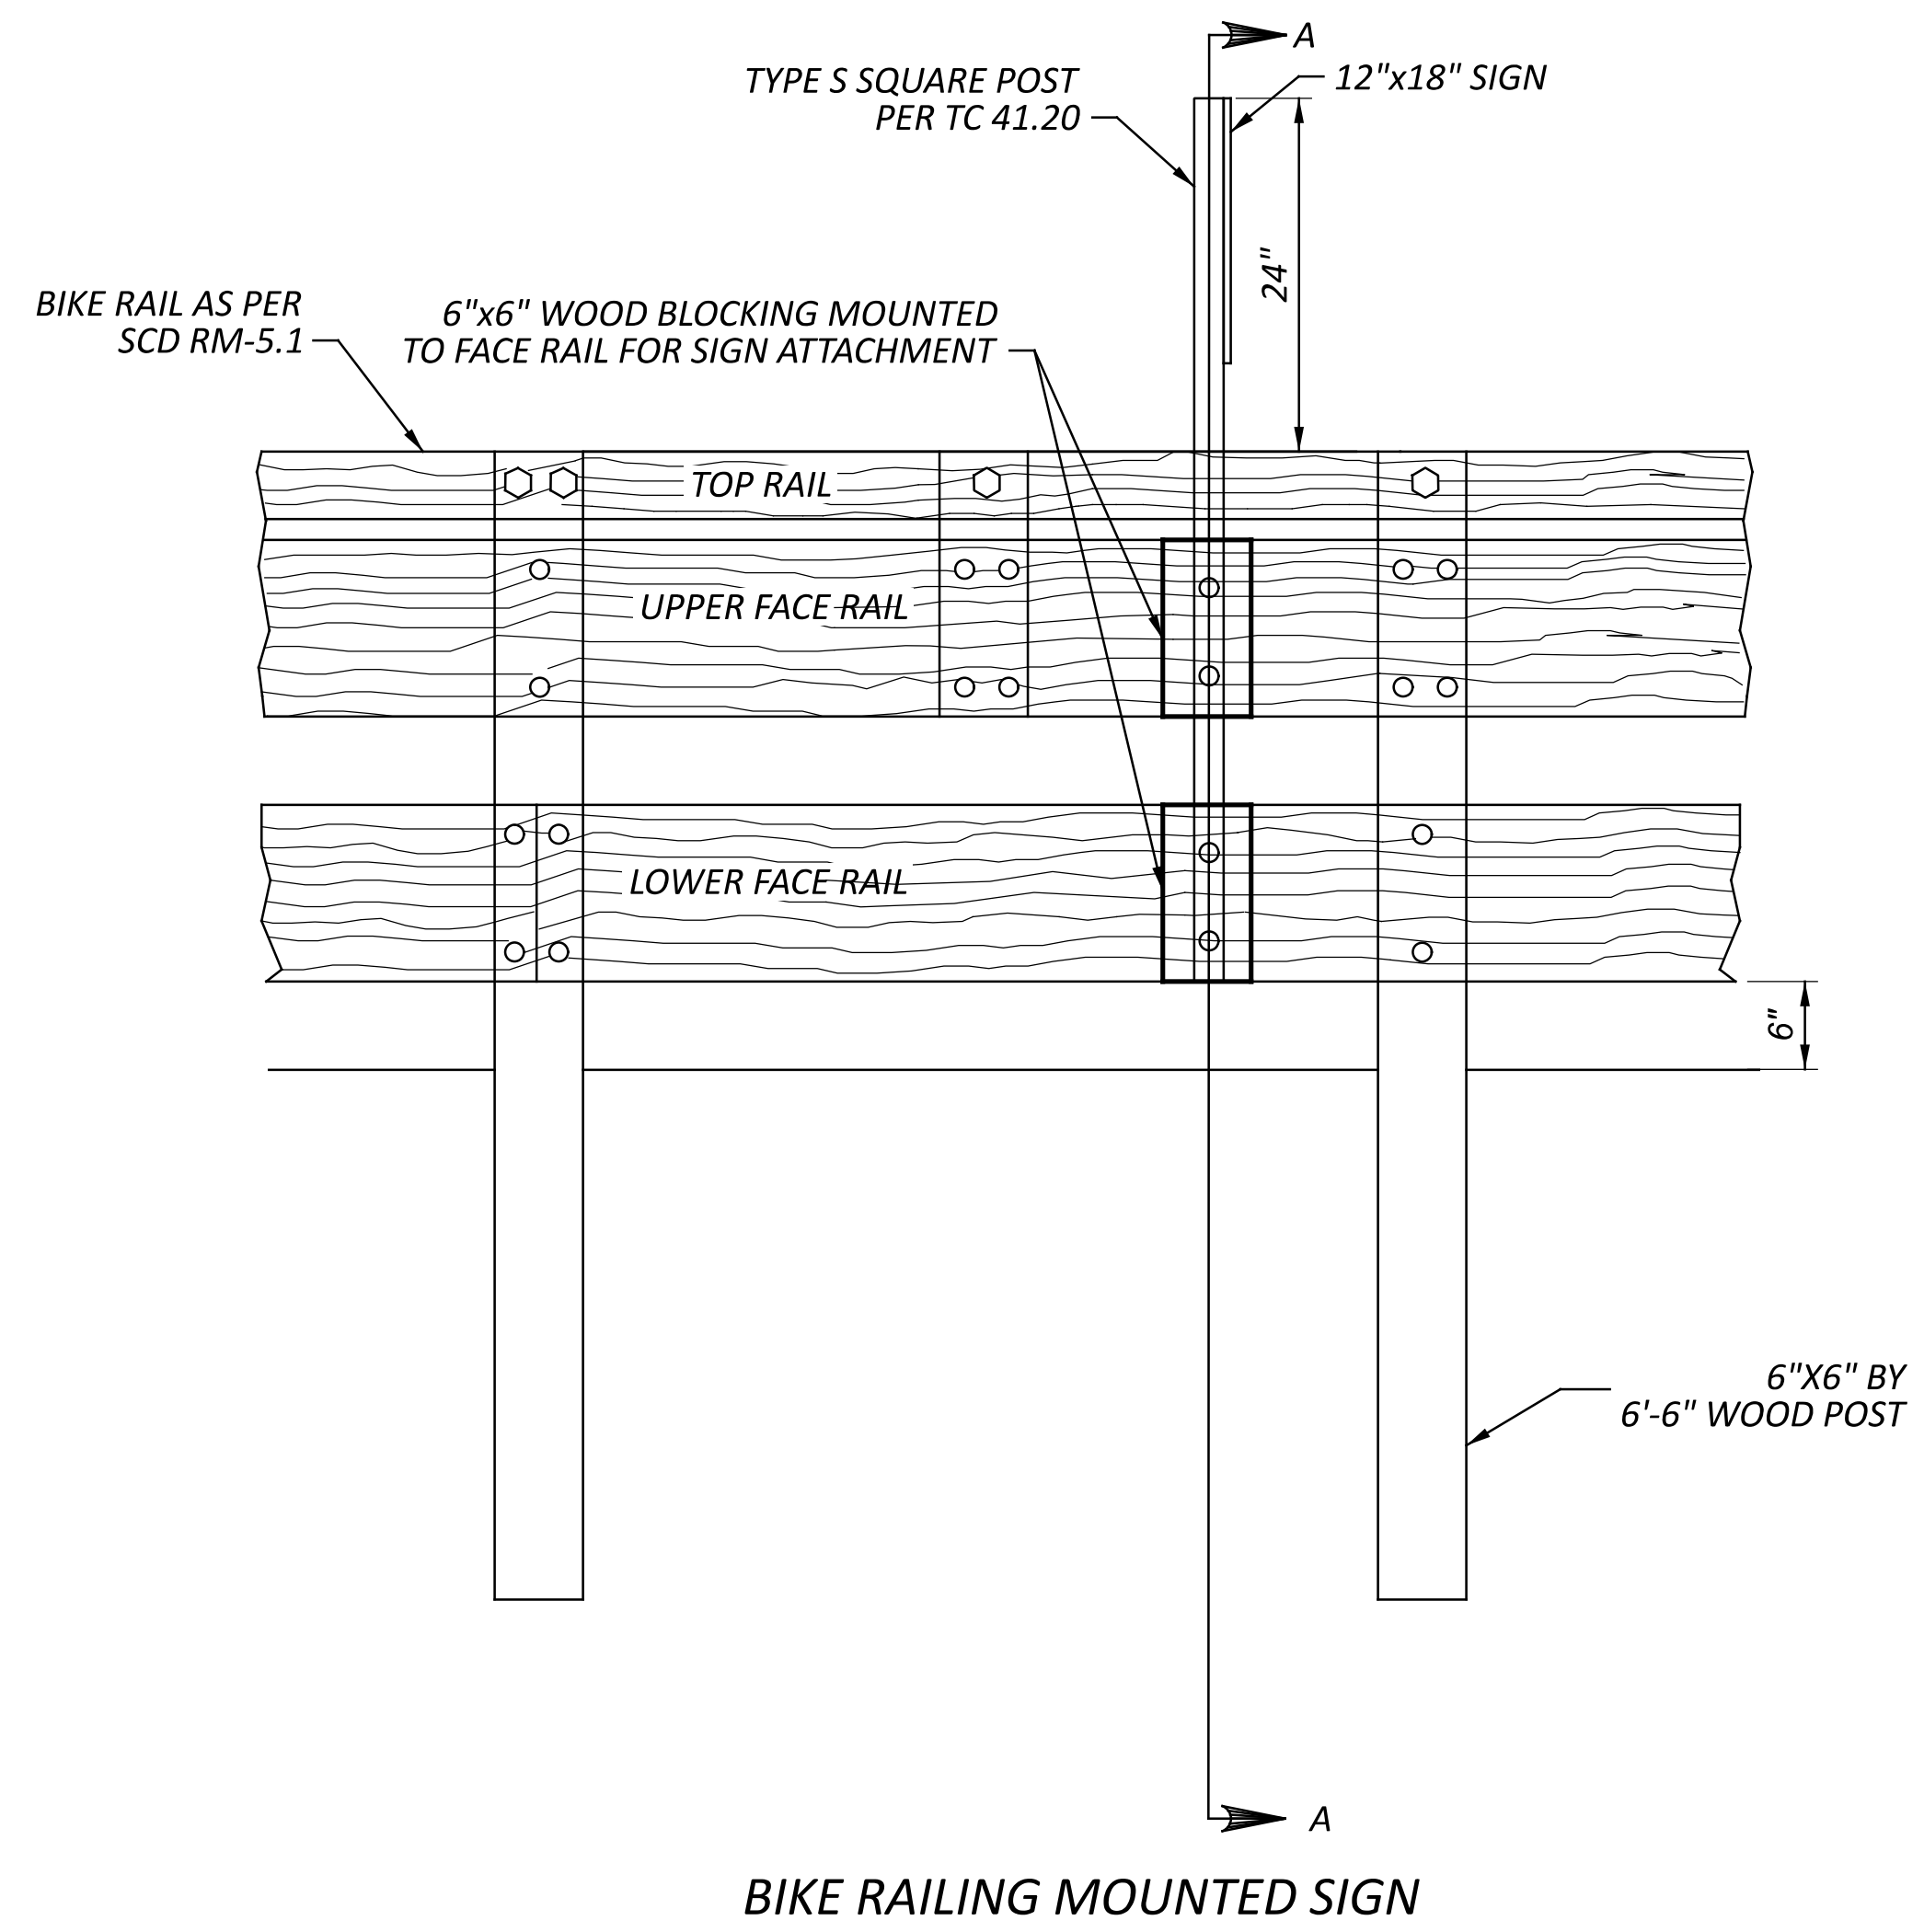

BIKE RAILING MOUNTED SIGN

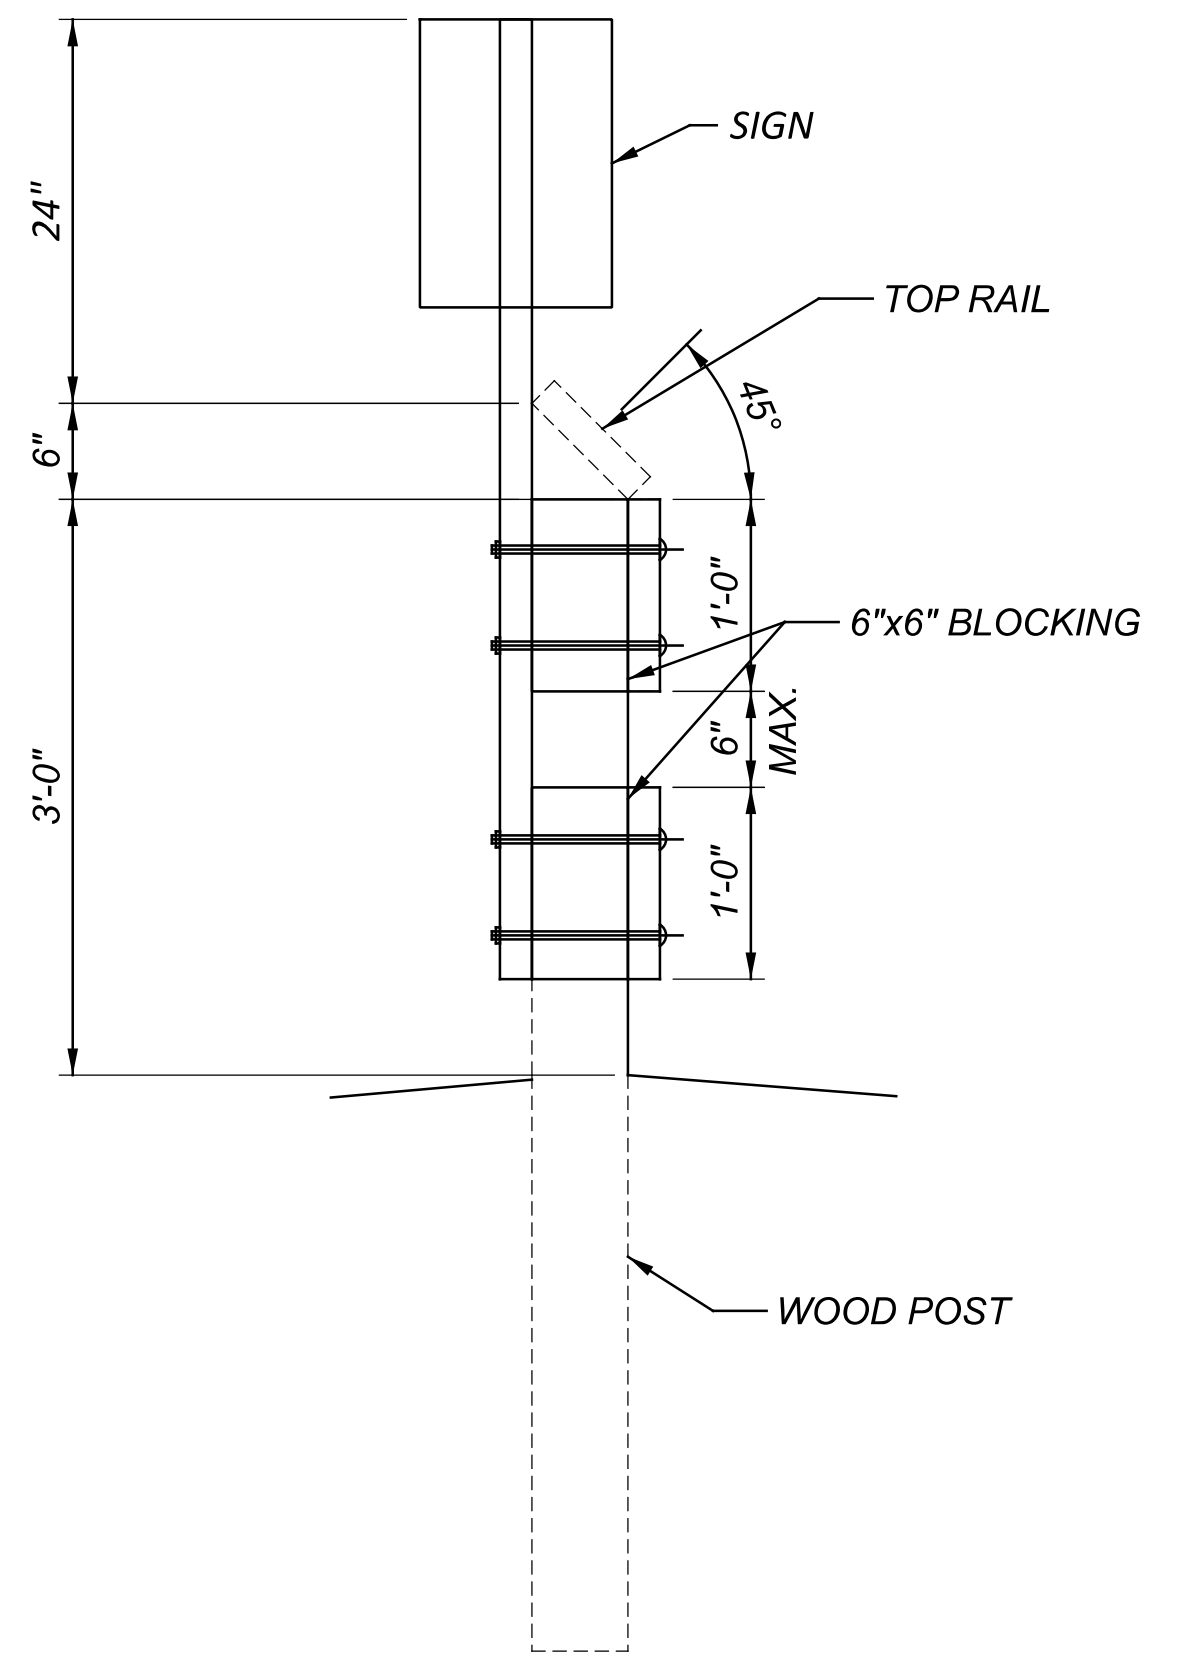

SECTION A-A

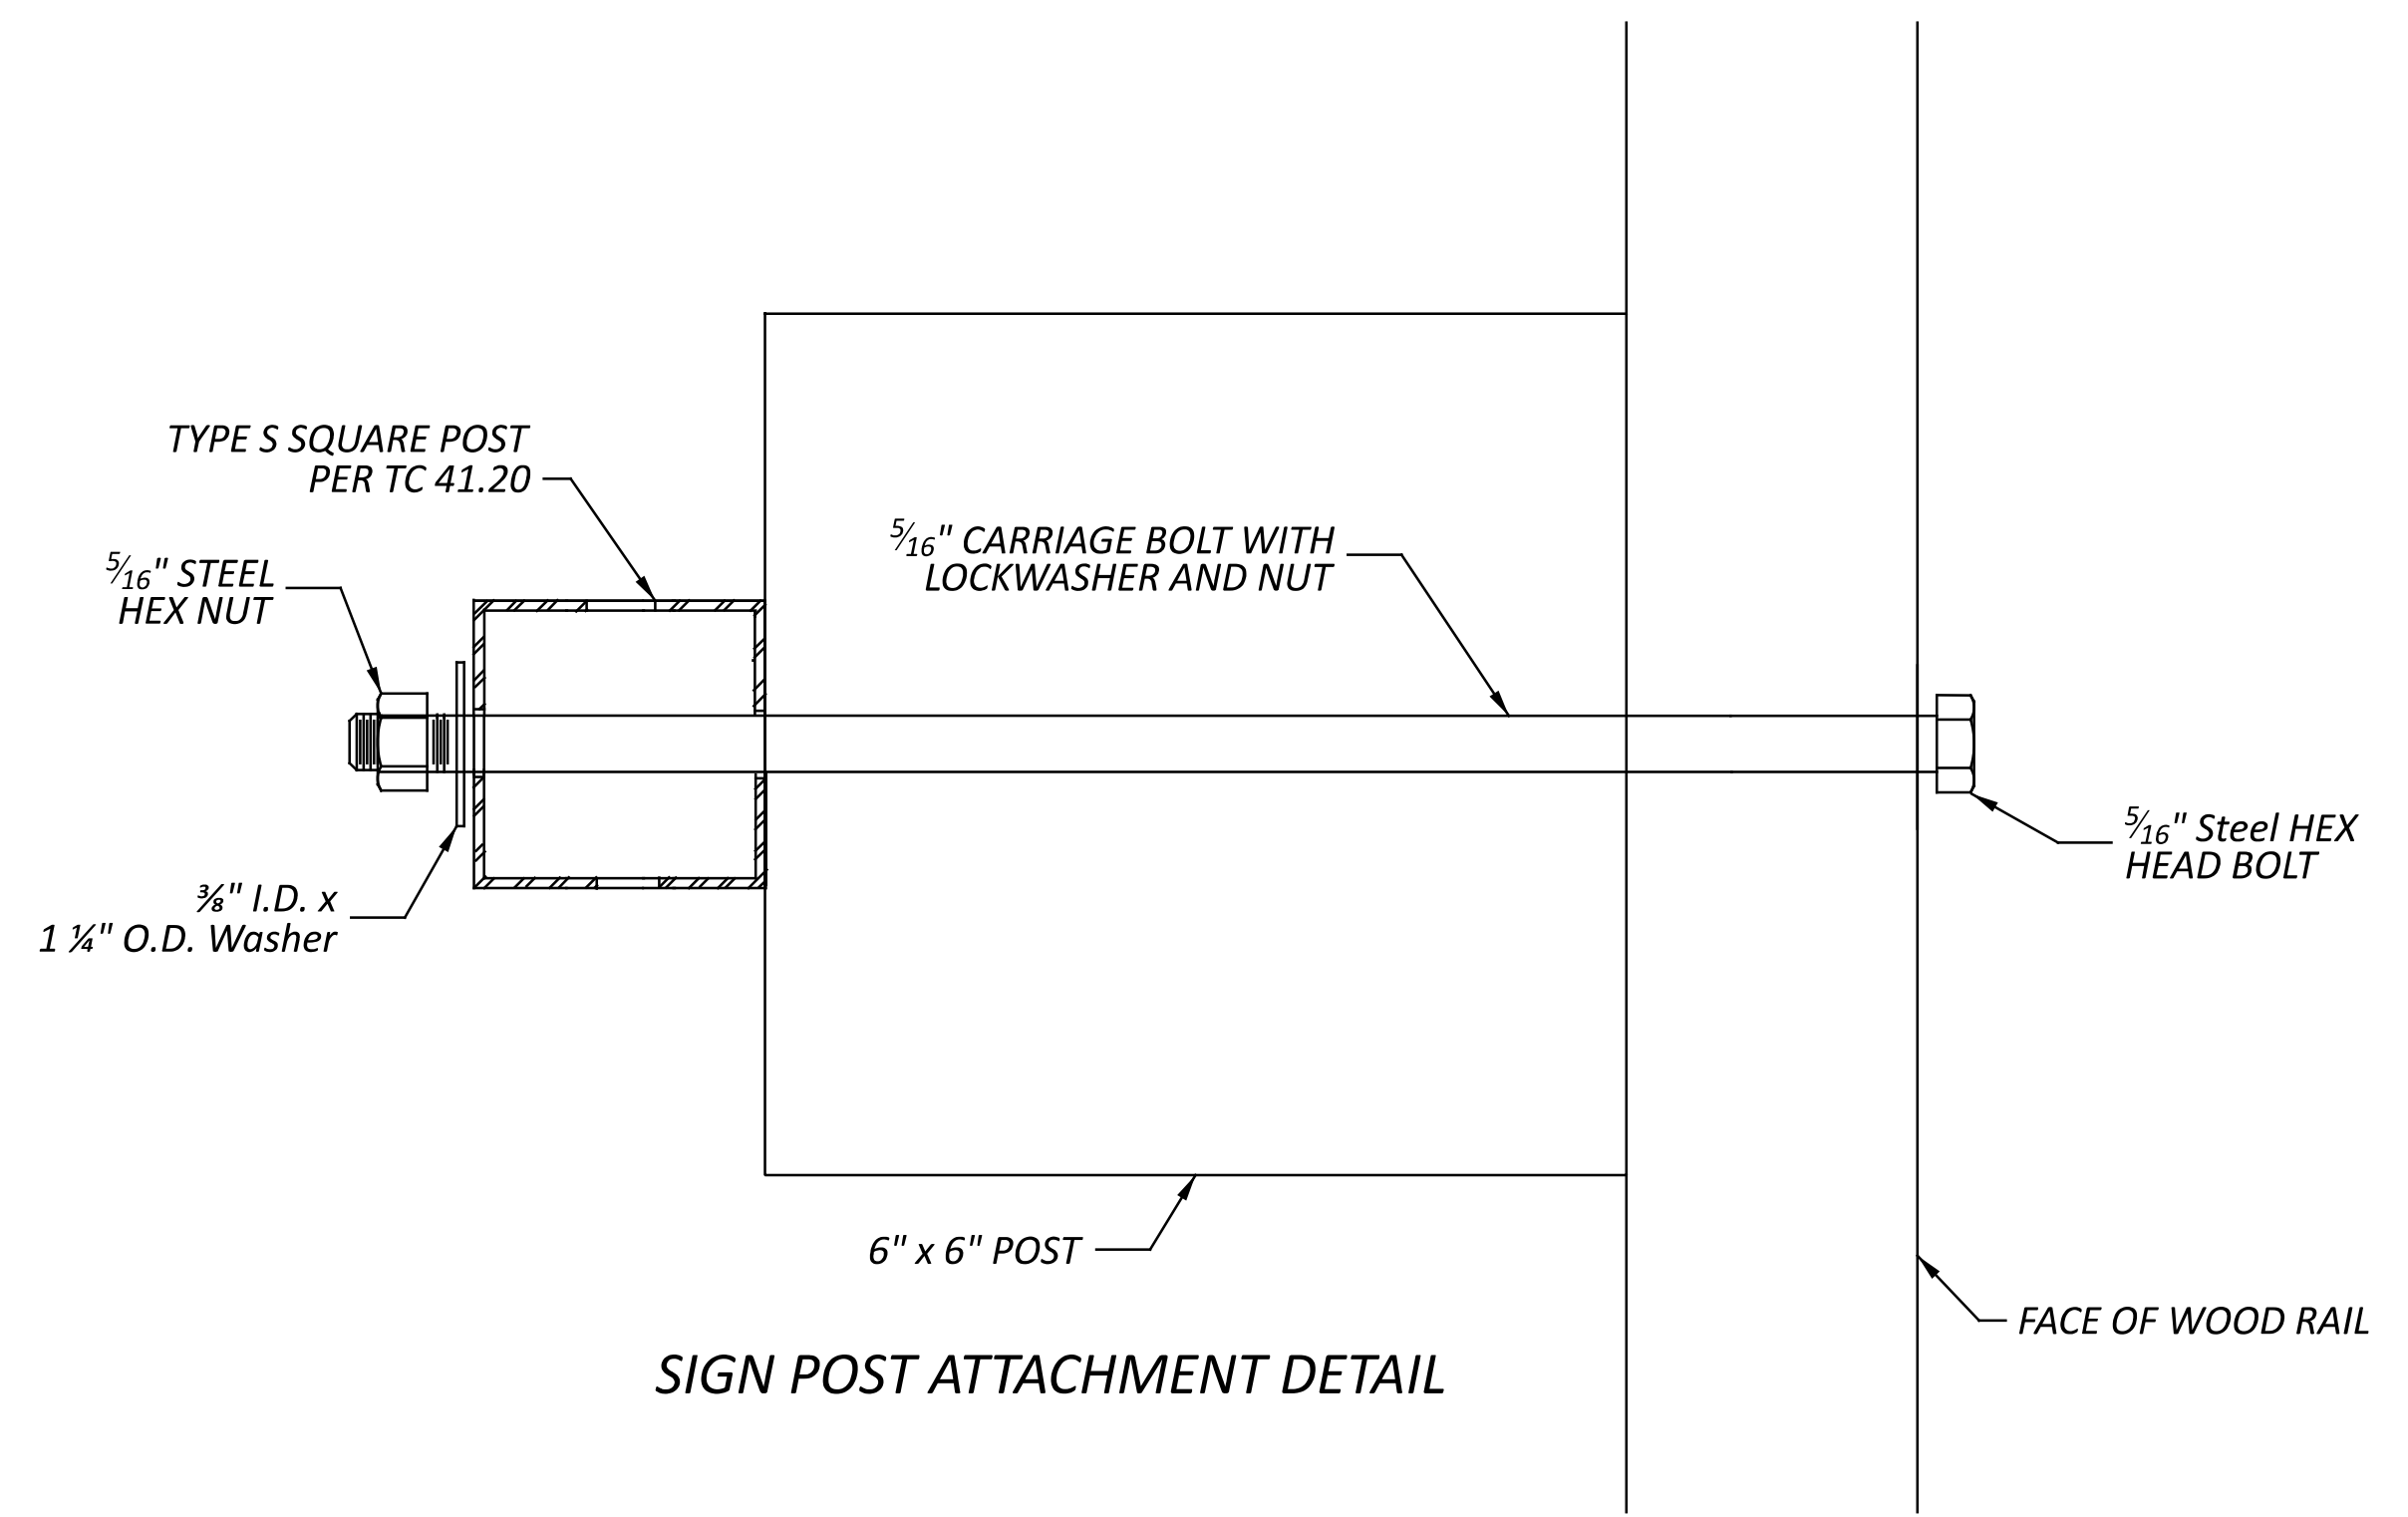

SIGN POST ATTACHMENT DETAIL

**ITEM 625, POWER SERVICE, AS PER PLAN**

IN ADDITION TO THE REQUIREMENTS OF THE SPECIFICATIONS, THE FOLLOWING IS ADDED.

THE POWER SUPPLYING AGENCY FOR THIS PROJECT IS:

AES OHIO  
 1900 DRYDEN ROAD  
 DAYTON, OH 45439  
 937-554-9063  
 ATTN: WILLIAM WARD  
 WILLIAM.WARD@AES.COM

THE ENGINEER SHALL ENSURE THAT EACH POWER SERVICE ELECTRICAL ENERGY ACCOUNT IS IN THE NAME OF AND THAT THE BILLING ADDRESS IS TO THE MAINTAINING AGENCY NOTED IN THE PLANS. THIS SHALL BE DONE NOT ONLY FOR EACH NEW POWER SERVICE ESTABLISHED BY THIS PROJECT BUT ALSO FOR EACH EXISTING POWER SERVICE, SINCE THERE MAY BE A REASSIGNMENT OF THE RESPONSIBILITY FOR AN EXISTING SERVICE AS A RESULT OF THE WORK PERFORMED BY THIS PROJECT.

**PADLOCKS AND KEYS**

PADLOCKS FURNISHED SHALL BE EITHER BRASS OR BRONZE, EQUAL TO MASTER NO. 4BKA OR WILSON BOHANNAN 660A, AND SHALL BE KEYED IN ACCORDANCE WITH C&MS 631.06. PAYMENT SHALL BE INCLUDED IN THE BID FOR THE ITEM(S) BEING LOCKED.

**ITEM 625, LUMINAIRE, MISC.: LUMINAIRE, FLOODLIGHT (LED)**

IN ADDITION TO THE REQUIREMENTS OF SUPPLEMENTAL SPECIFICATIONS 813 AND 913:

1. LUMINAIRES FOR FLOODLIGHT LIGHTING UNITS SHALL BE 240 VOLT WITH LED LAMPS.

2. SHALL BE MANUFACTURED BY:

- SIGNIFY, STONCO SERIES,  
 MODEL NUMBER: SF60-SCT-S-G2-10-BZ

3. LUMINAIRES SUPPLIED SHALL INCLUDE ALL NECESSARY ADAPTERS TO FIT THE PROPOSED LIGHTING MOUNTING BRACKETS.

4. THIS ITEM SHALL INCLUDE PROVIDING AND INSTALLING A STEEL MOUNTING BRACKET WITH EACH LUMINAIRE. THE MOUNTING BRACKET SHALL BE A GARDCO, SBRKT-RA-L1-14-WA AS MANUFACTURED BY SIGNIFY. THE BRACKET SHALL BE PAINTED TO MATCH THE PEDESTRIAN BRIDGE.

**ITEM 625, CONDUIT, 2", 725.051, AS PER PLAN**

IN ADDITION TO THE REQUIREMENTS OF ODOT C&MS, ALL EXTERIOR CONDUIT SHALL BE PAINTED TO MATCH PEDESTRIAN BRIDGE. THIS ALSO INCLUDES ANY EXTERIOR HARDWARE NECESSARY TO ATTACH CONDUIT TO BRIDGE.

**ITEM 625, JUNCTION BOX, AS PER PLAN**

IN ADDITION TO THE REQUIREMENTS OF ODOT C&MS, BRIDGE MOUNTED JUNCTION BOXES SHALL BE PAINTED TO MATCH THE PEDESTRIAN BRIDGE.

**ITEM 625, ARC FLASH CALCULATIONS AND LABEL**

THE CONTRACTOR SHALL SATISFY THE REQUIREMENTS OF ODOT SUPPLEMENTAL SPECIFICATION 825 FOR THE CONTROL CENTERS. THE CONTRACTOR MAY BE ABLE TO OBTAIN LABELS FOR THE ODOT MAINTAINED INSTALLATIONS FROM THE ODOT SIGN SHOP, 1606 WEST BROAD ST., COLUMBUS, OH 43223, FOR NON-ODOT MAINTAINED INSTALLATIONS THE CONTRACTOR IS RESPONSIBLE FOR OBTAINING THE LABEL MADE FROM "ENGINEER GRADE" SIGN SHEETING OR AN EQUIVALENT LABEL MATERIAL.

THE ODOT OFFICE OF ROADWAY ENGINEERING AND THE DISTRICT OFFICE HAVE AN EXCEL SPREADSHEET AVAILABLE UPON REQUEST, TO ASSIST WITH MAKING AND DOCUMENTING THE REQUIRED CALCULATIONS.

METHOD OF MEASUREMENT SHALL BE AS PER 825.06. THE FOLLOWING QUANTITIES HAVE BEEN CARRIED TO THE GENERAL SUMMARY.

ITEM 625, ARC FLASH CALCULATION AND LABEL,  
 (PS-A) 1 EACH

**CONDUIT EXPANSION AND DEFLECTION**

EXPANSION FITTINGS SHALL BE OZ TYPE AX, CROUSE HINDS TYPE XJG, OR EQUAL APPROVED BY THE ENGINEER. EACH EXPANSION FITTING SHALL PROVIDE EITHER 4 OR 8 INCHES TOTAL MOVEMENT AS SPECIFIED BY THE PLAN DETAILS AND SHALL HAVE AN EXTERNAL COPPER BONDING JUMPER, UNLESS SPECIFIED OTHERWISE BY THE PLAN DETAILS.

DEFLECTION COUPLINGS SHALL BE OZ TYPE DX, CROUSE HINDS TYPE XD, OR EQUAL APPROVED BY THE ENGINEER. EACH DEFLECTION COUPLING SHALL HAVE AN EXTERNAL COPPER BONDING JUMPER, UNLESS SPECIFIED OTHERWISE BY THE PLAN DETAILS. MINIMUM DEFLECTION CAPABILITY: 25°.

EXPANSION AND DEFLECTION FITTINGS FULLY OR PARTIALLY EMBEDDED IN CONCRETE, SOIL, OR SIMILAR MATERIAL SHALL BE COMPLETELY WRAPPED IN A NEOPRENE SLEEVE OR SHEET OF 1/2-INCH MINIMUM THICKNESS.

SECURE NEOPRENE WRAP WITH TIE-WRAPS PRIOR TO EMBEDMENT OF THE FITTING.



**STRUCTURE GROUNDING**

THE PROPOSED PEDESTRIAN BRIDGE OVER US-68 AND THE PROPOSED BRIDGE OVER OLDTOWN CREEK SHALL HAVE A STRUCTURE GROUNDING SYSTEM PROVIDED AS PER SCD HL-50.21.



DESIGN AGENCY	
DESIGNER	CTF
REVIEWER	NAU 03/28/25
PROJECT ID	115388
SHEET	TOTAL
P.90	P.107

CONTROL CENTER DATA									
CONTROL CENTER DESIGNATION	LINE VOLTS	CONNECTED LOAD (KVA)	SERVICE ENTRANCE CONDUCTOR SIZE - AWG	ENCLOSURE RATING (AMPS)	CIRCUIT NO.	CIRCUIT LOAD AMPS	CIRCUIT FUSE SIZE AMPS	CIRCUIT CABLE SIZE AWG	MAINTAINING AGENCY
PS-A	240	0.7	4	60	A	3.00	15	10	ODOT
					-	-	-	-	
					-	-	-	-	

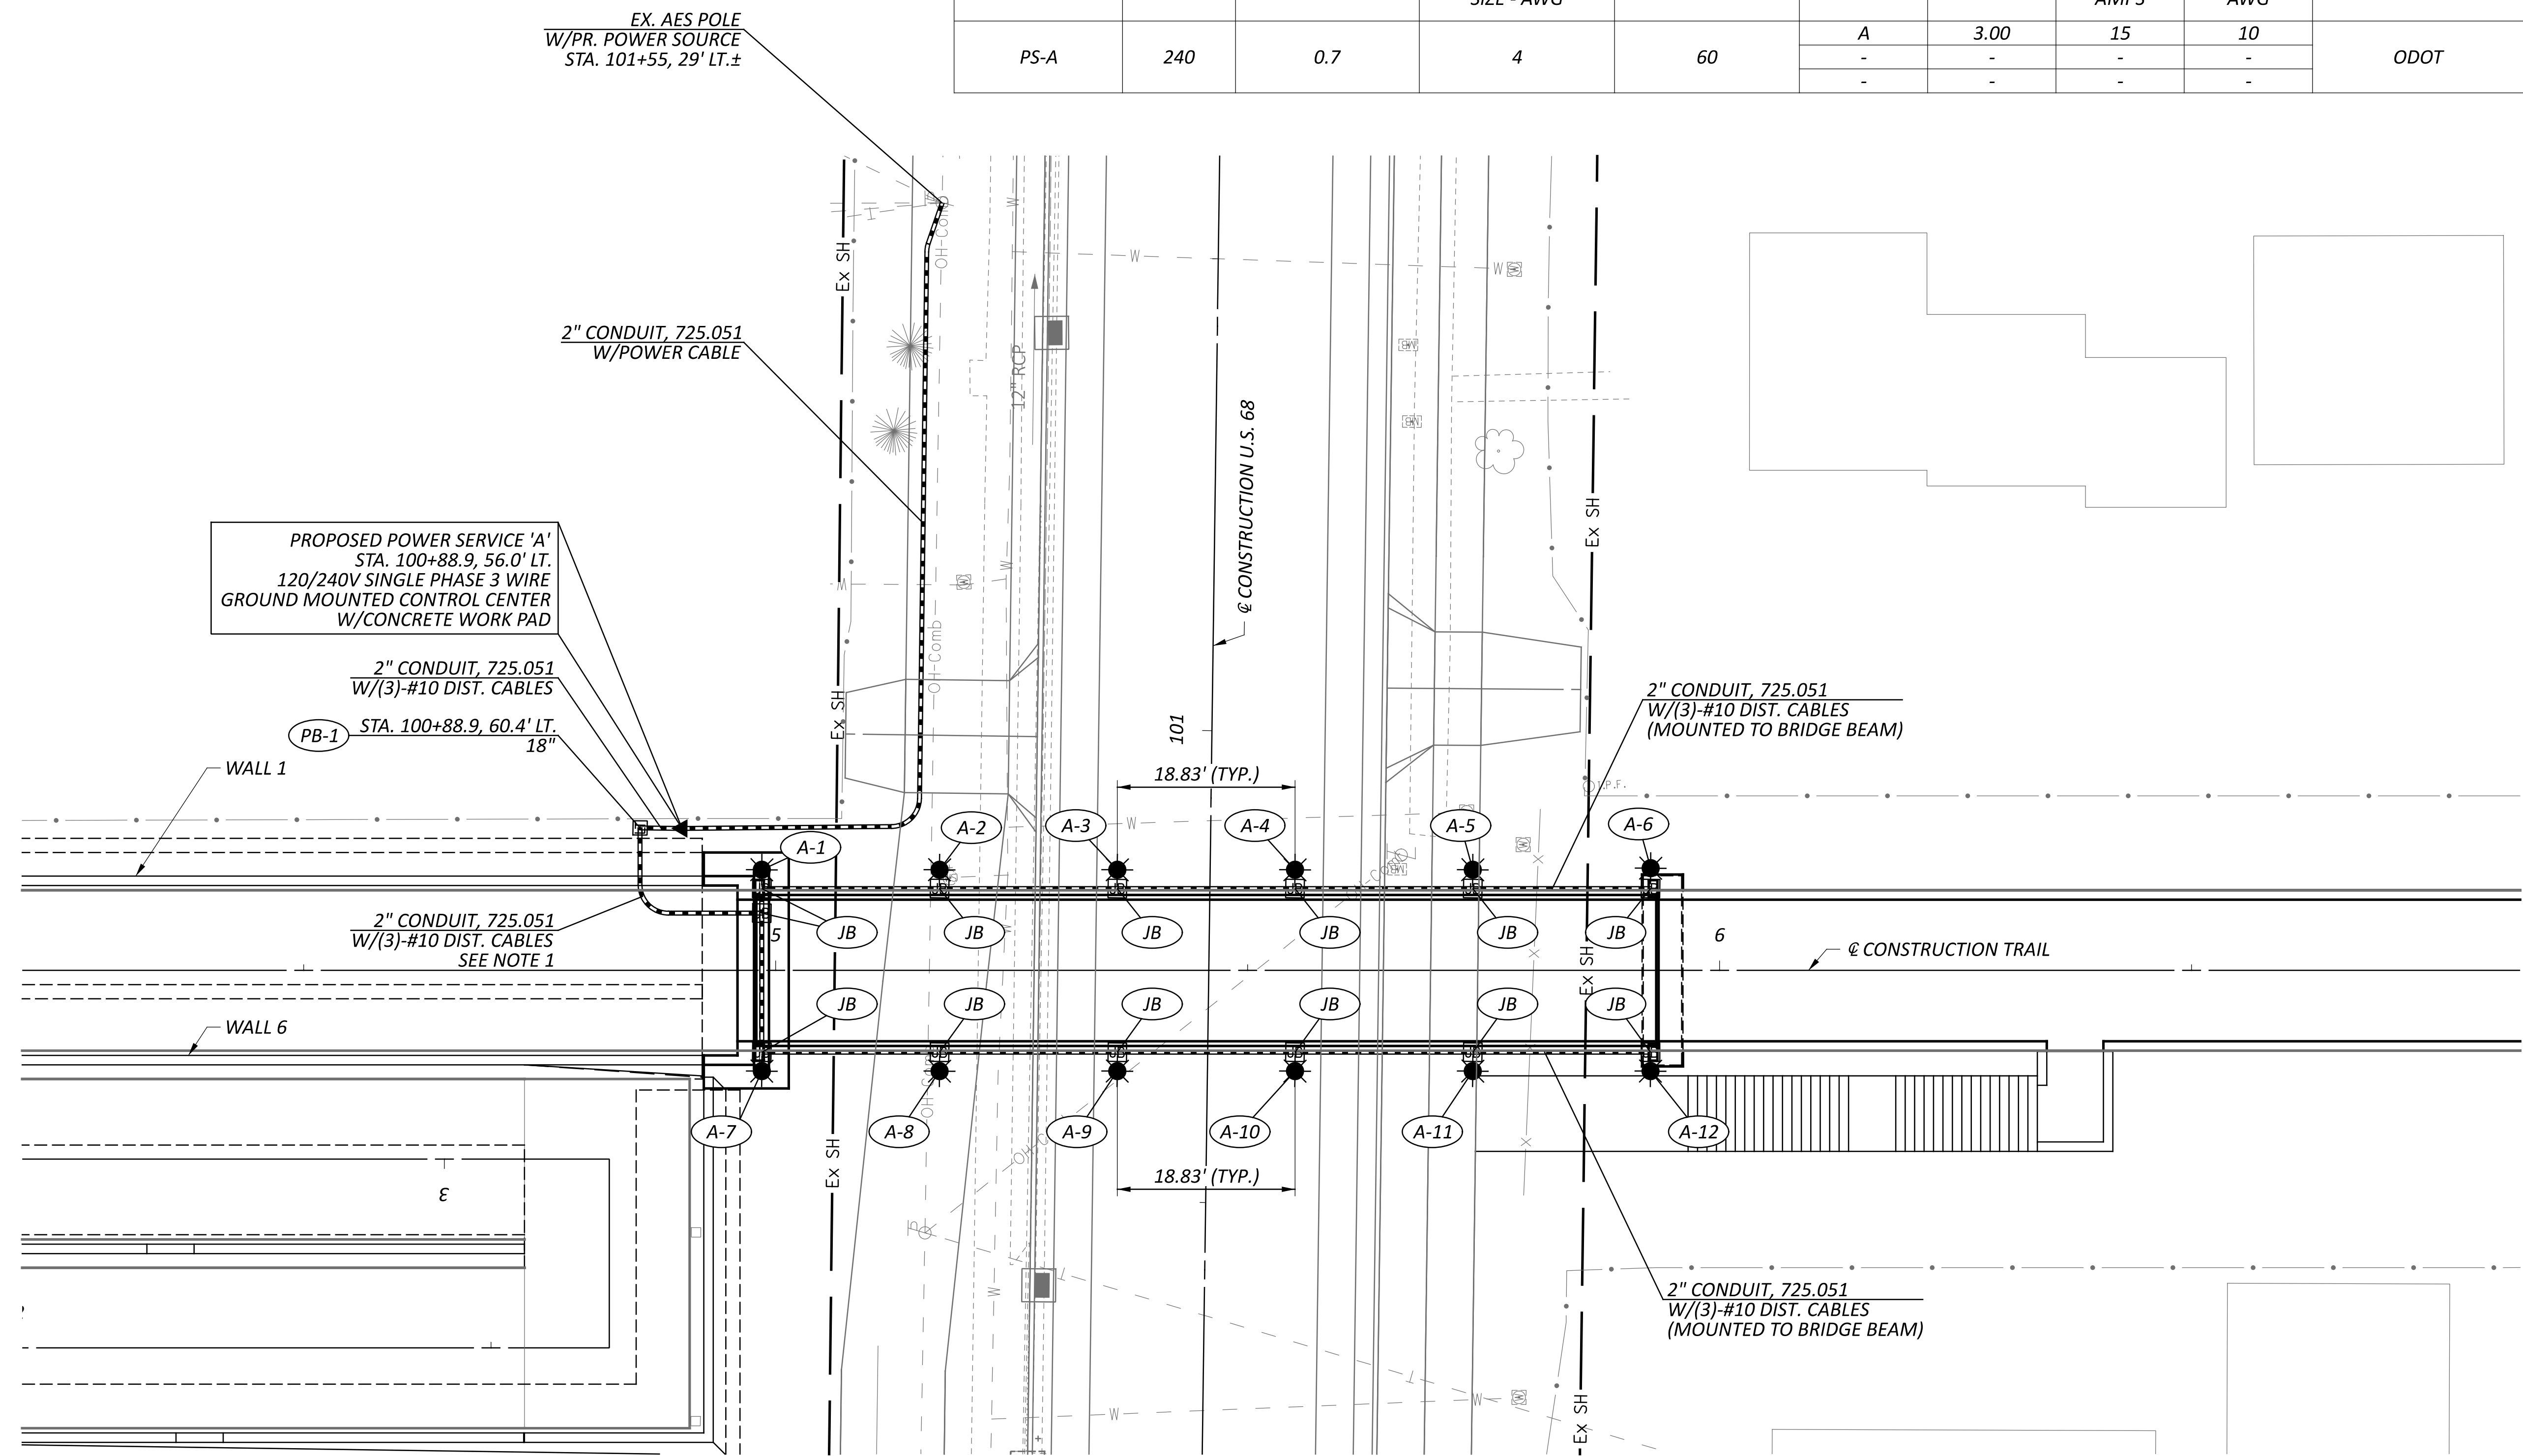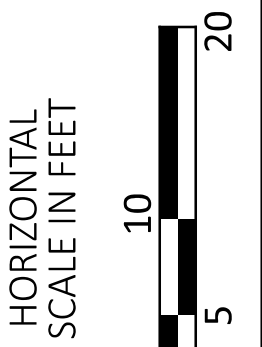


**NOTES:**  
 1. THE 2" CONDUIT BETWEEN THE 18" PULL BOX AND BRIDGE MOUNTED JUNCTION BOX SHALL PASS THROUGH RETAINING WALL 1. A 3" DIAMETER CONDUIT SLEEVE SHALL BE PROVIDED THROUGH THE WALL FOR INSTALLATION OF LIGHTING CONDUIT. AFTER INSTALLATION OF THE 2" CONDUIT, ANY GAP BETWEEN THE SLEEVE AND CONDUIT SHALL BE FULLY SEALED BY CONTRACTOR.  
 2. FOR BRIDGE MOUNTED LIGHTING DETAILS, SEE SHEET P.92.

LEGEND	
	BRIDGE MOUNTED LUMINAIRE, FLOODLIGHT
	2" CONDUIT (725.051)
	PULL BOX (725.08), IDENTIFICATION NO.
	BRIDGE JUNCTION BOX (PVC)
	POWER SERVICE


LIGHTING PLAN  
PEDESTRIAN BRIDGE OVER U.S. 68

DESIGN AGENCY  
  
 DESIGNER  
 CTF  
 REVIEWER  
 NAU 03/28/25  
 PROJECT ID  
 115388  
 SHEET TOTAL  
 P.91 P.107

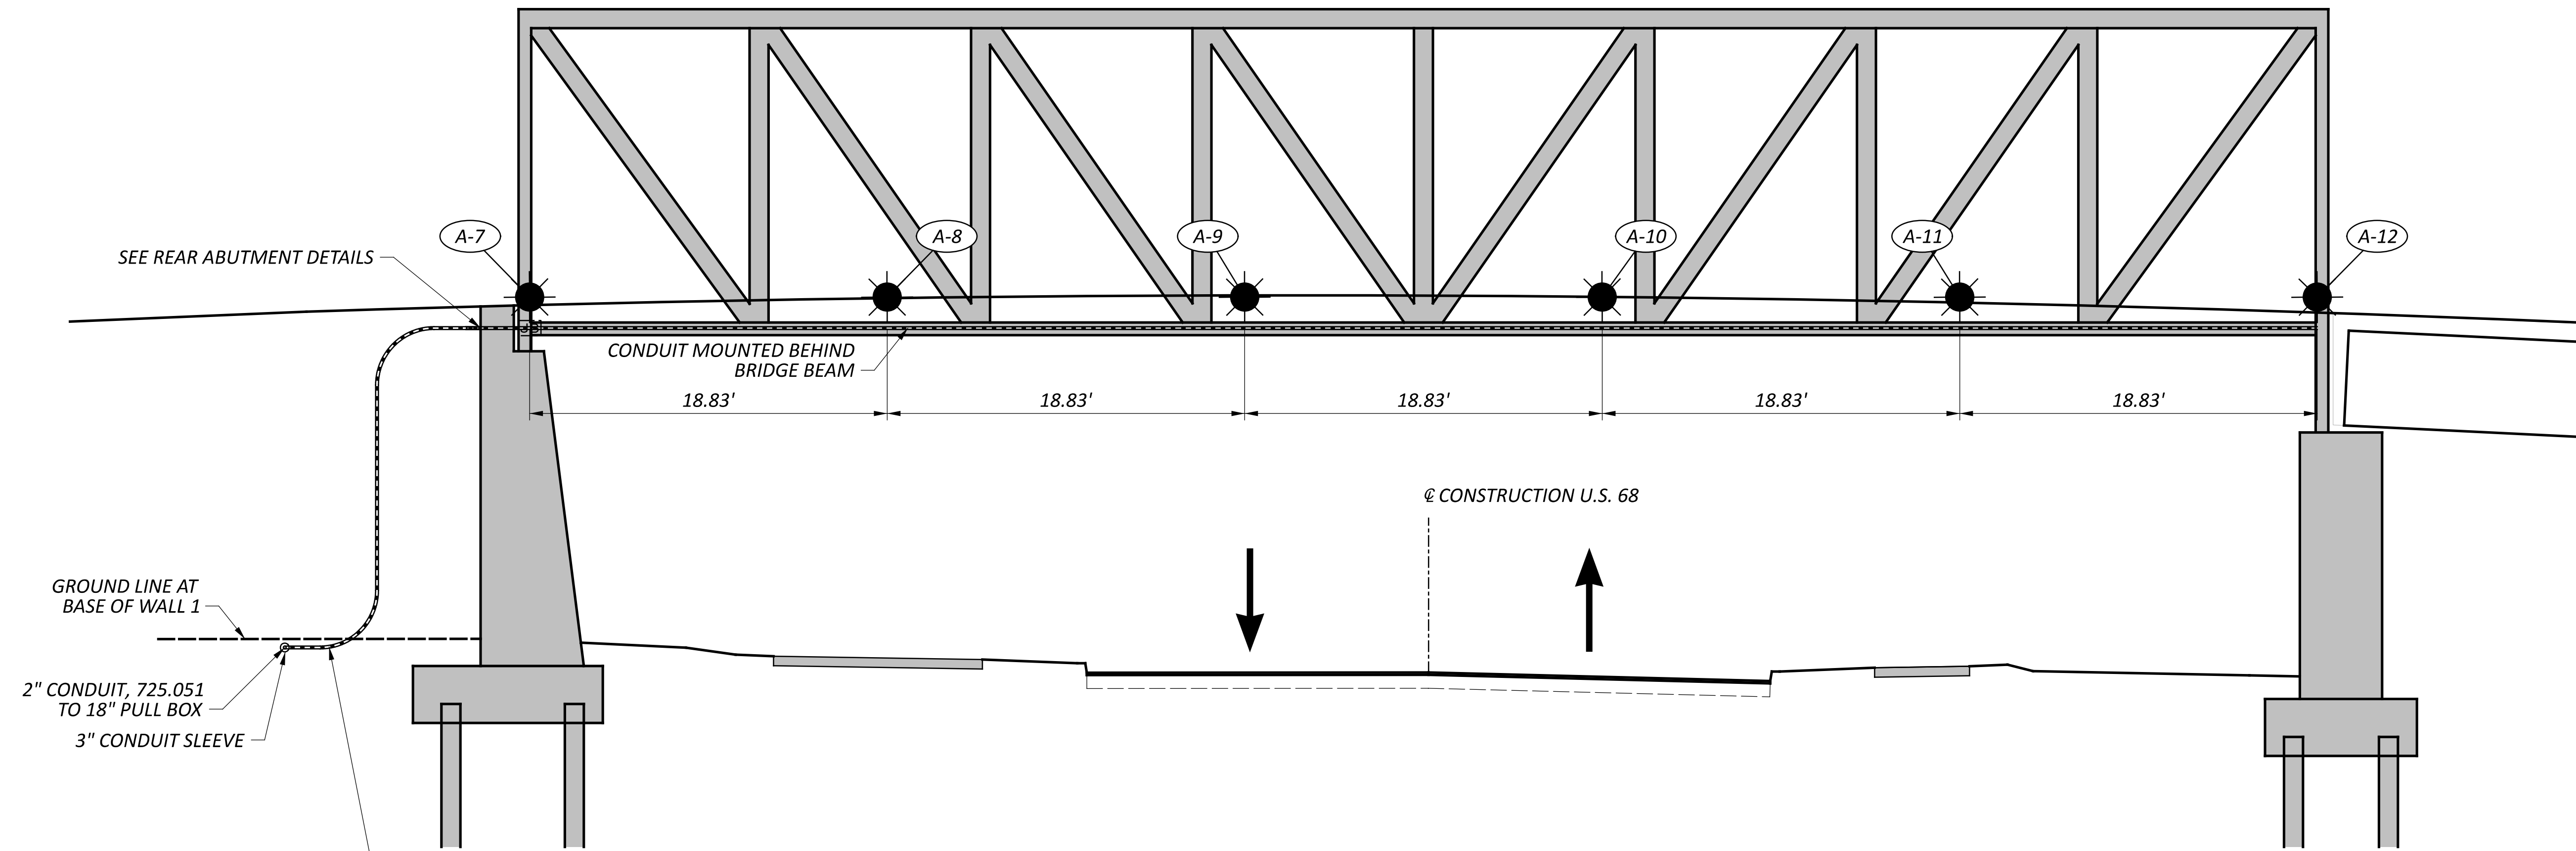

ELEVATION VIEW  
(LOOKING NORTH)


REVIEWER NOTE: FINAL SPACING AND MOUNTING DETAILS OF DECORATIVE LIGHTING TO BE DETERMINED DURING BRIDGE SHOP DRAWING REVIEW PROCESS

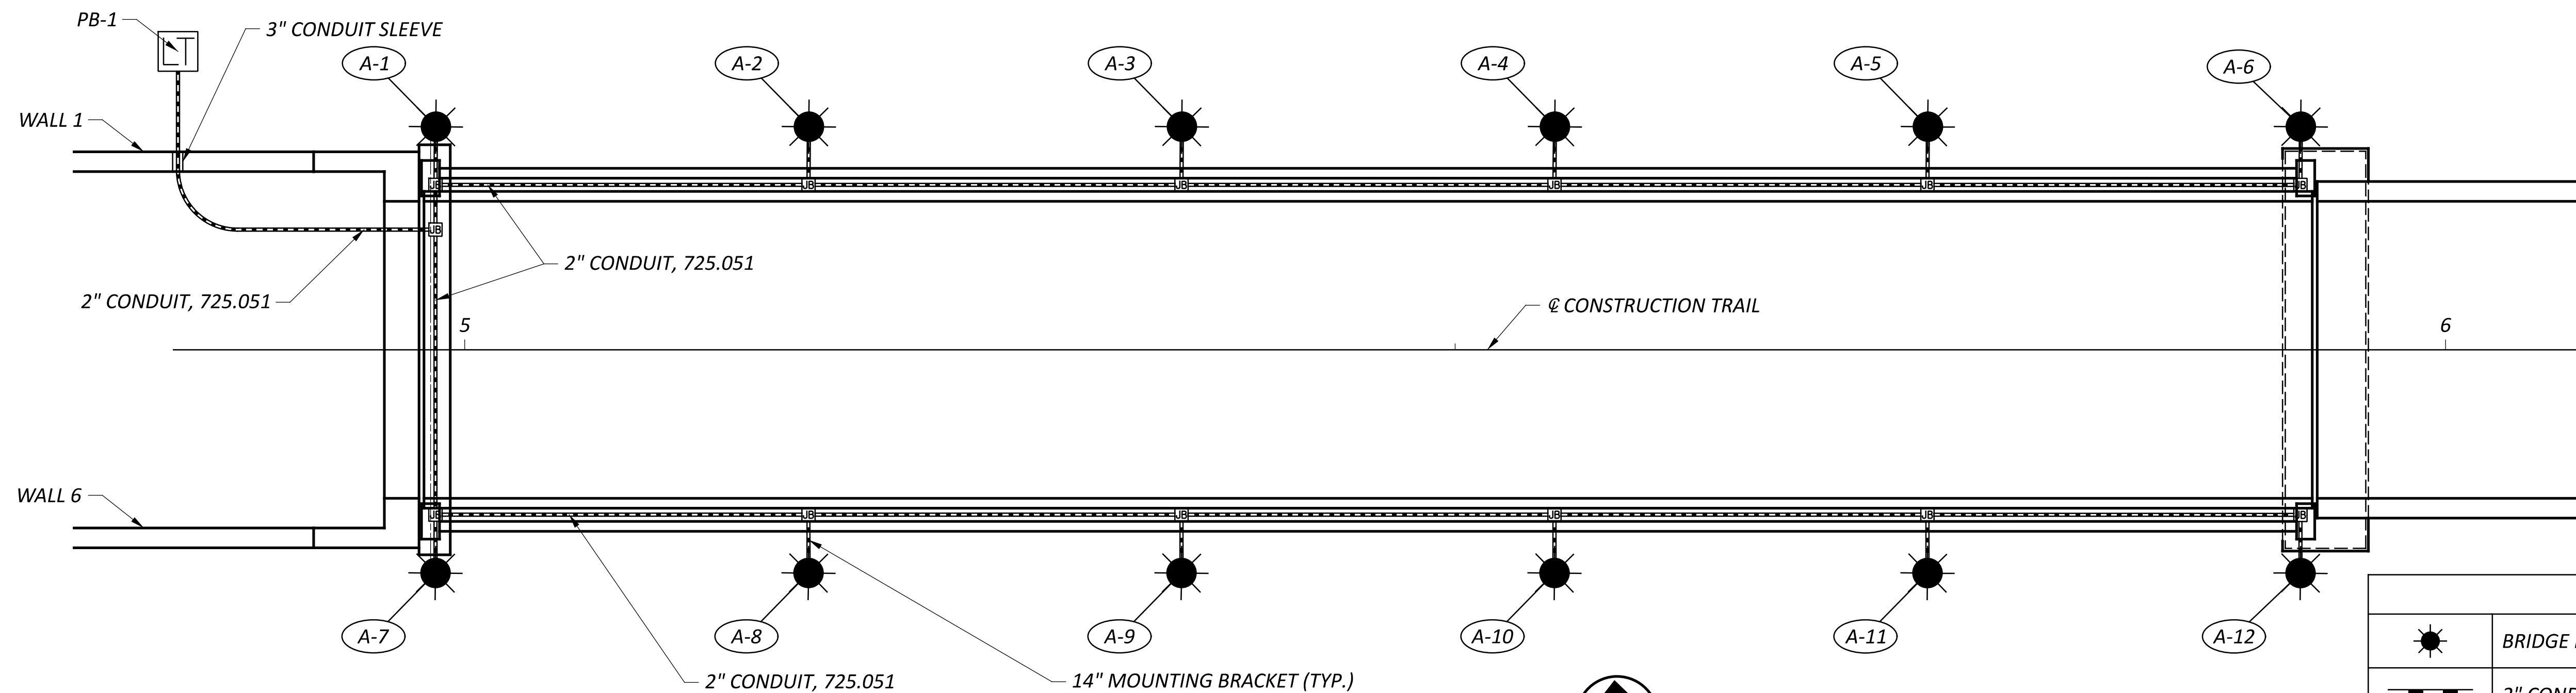

PLAN VIEW

NOTES:  
 1. BRIDGE JUNCTION BOXES SHALL BE PVC JUNCTION BOXES 6P RATED AND SHALL BE SIZE 6" X 6" X 4".

LEGEND	
	BRIDGE MOUNTED LUMINAIRE, FLOODLIGHT
	2" CONDUIT (725.051)
	PULL BOX (725.08)
	BRIDGE JUNCTION BOX (PVC)

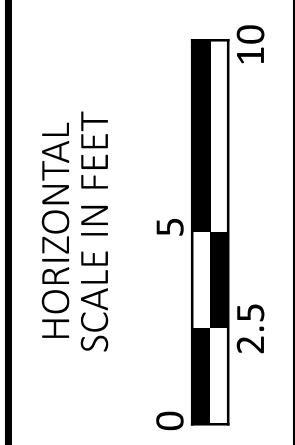

LIGHTING DETAILS  
 PEDESTRIAN BRIDGE OVER U.S. 68

DESIGN AGENCY  
  
 DESIGNER  
 CTF  
 REVIEWER  
 NAU 03/28/25  
 PROJECT ID  
 115388  
 SHEET TOTAL  
 P.92 P.107

**PROJECT DESCRIPTION**

THE PROPOSED PROJECT IS INTENDED TO PROVIDE A SAFE ACCESS PATH FROM THE LITTLE MIAMI SCENIC TRAIL TO THE FACILITIES AT THE GREAT COUNCIL STATE PARK AND SHAWNEE INTERPRETIVE CENTER LOCATED AT 1575 U.S. ROUTE 68 (US-68), WITHIN OLDTOWN, OHIO. INCLUDES THE CONSTRUCTION OF A NEW PEDESTRIAN BRIDGE STRUCTURE TO DIRECT PEDESTRIAN AND BIKE TRAFFIC OVER OLDTOWN CREEK AND US-68, AND SIX (6) NEW RETAINING WALLS (RW-1 THROUGH RW-6) IN THE VICINITY OF THE REAR ABUTMENT OF THE BRIDGE TO PROVIDE GRADE SEPARATION BETWEEN THE PROPOSED PEDESTRIAN PATH AND THE SURROUNDING AREA AS IT DESCENDS FROM THE BRIDGE TO THE EXISTING SIDEWALK GRADE.

**HISTORIC RECORDS**

AS PART OF THE INITIAL PHASES OF THE PROJECT, ODOT CONTRACTED STANTEC CONSULTING SERVICES INC. (STANTEC) AND SUBSEQUENTLY UES (FORMERLY GEOTECHNOLOGY) TO CONDUCT AN INITIAL EXPLORATION OF THE PROJECT AREA. THE INITIAL EXPLORATION FOR THIS PROJECT WAS CONDUCTED BY UES BETWEEN JANUARY 2 AND JANUARY 4, 2024 AND INCLUDED 4 BORINGS DRILLED TO A DEPTH OF 51.5 FT BGS. THE PERTINENT INFORMATION REGARDING THE SUBSURFACE INVESTIGATION CAN BE FOUND IN THE DOCUMENT TITLED "GEOTECHNICAL EXPLORATION LOGS, GRE-68-12.65, PID 115388, GREEN COUNTY, OHIO" PROVIDED BY STANTEC DATED JANUARY 29, 2024.

A HISTORIC RECORD SEARCH WAS PERFORMED THROUGH ODOT'S TRANSPORTATION INFORMATION MAPPING SYSTEM (TIMS), HOWEVER, NO HISTORICAL INFORMATION WAS FOUND WITHIN THE PROJECT AREA.

**GEOLOGY**

THE PROJECT SITE IS LOCATED WITHIN THE SOUTHERN OHIO LOAMY TILL PLAIN, WHICH IS CHARACTERIZED AS END AND RESSIONAL MORAINES, COMMONLY ASSOCIATED WITH BOULDER BELTS, BETWEEN RELATIVELY FLAT-LYING GROUND MORAINE, CUT BY STEEP-VALLEYED LARGE STREAMS WITH SURFACE SOILS CONSISTING OF LOAMY TILL. BURIED VALLEYS ARE COMMON AND ARE GENERALLY FILLED WITH OUTWASH AND ALTERNATE BETWEEN BROAD FLOODPLAINS AND NARROWS. THE GEOLOGY WITHIN THIS REGION IS DESCRIBED AS LOAMY, HIGH-LIME WISCONSINIAN-AGE TILL, OUTWASH AND LOESS OVER LOWER PALEOZOIC-AGE CARBONE ROCKS, AND IN THE EAST, SHALES.

**RECONNAISSANCE**

A FIELD RECONNAISSANCE VISIT FOR THE OVERALL PROJECT AREA WAS CONDUCTED BY NEAS ON NOVEMBER 15, 2024, WITHIN THE PROJECT LIMITS. SITE CONDITIONS, INCLUDING THE EXISTING LAND CONDITIONS AND PAVEMENT CONDITIONS, WERE NOTED DURING THE VISIT. DURING RECONNAISSANCE, NO GEOHAZARDS WERE OBSERVED WITHIN THE PROJECT LIMITS. THE LAND USE OF THE PROJECT AREA MOSTLY CONSISTS OF ODOT RIGHT-OF-WAY (ROW), FARMLAND/AGRICULTURAL/VACANT LAND, SINGLE-FAMILY HOMES, AND COMMERCIAL PROPERTIES. THE PROJECT AREA CONSISTS OF A GRAVEL PARKING LOT LOCATED TO THE WEST OF US-68 WITH PAVEMENT AND AGRICULTURAL/VACANT LAND TO THE EAST. THE EXISTING AGRICULTURAL/VACANT LAND IS VEGETATED WITH A MIX OF SMALL TO LARGE TREES WITH SOME BUSHES.

AT THE TIME OF RECONNAISSANCE, THE PAVEMENT CONDITIONS WITHIN THE PROJECT AREA WERE OBSERVED TO BE IN GOOD CONDITION WITH SOME SIGNS OF WEATHERING AND SURFACE WEAR. NO EVIDENCE OF STANDING WATER WAS NOTED IN THE PROJECT AREA. NO SIGNS OF GEOTECHNICAL INSTABILITY WERE OBSERVED AT THE TIME OF RECONNAISSANCE.

**SUBSURFACE EXPLORATION**

FIVE (5) BORINGS WERE COMPLETED AS PART OF THE SUBSURFACE EXPLORATION CONDUCTED BY NEAS BETWEEN NOVEMBER 25, 2024, AND DECEMBER 6, 2024. THE BORINGS WERE DRILLED USING A CME 55TB TRACK-MOUNTED DRILLING RIG UTILIZING 3.25-INCH I.D. HOLLOW STEM AUGERS. SOIL SAMPLES WERE GENERALLY RECOVERED USING A SPLIT SPOON SAMPLER (AASHTO T-206) AT INTERVALS OF 2.5-FT TO A DEPTH OF 35 FT BGS AND AT 5-FT INTERVALS THEREAFTER UNTIL BORING TERMINATION. THE SOIL SAMPLES OBTAINED FROM THE EXPLORATION PROGRAM WERE VISUALLY OBSERVED IN THE FIELD BY THE NEAS FIELD REPRESENTATIVE AND PRESERVED FOR REVIEW BY A GEOLOGIST AND POSSIBLE LABORATORY TESTING. STANDARD PENETRATION TESTS WERE CONDUCTED USING CME AUTO HAMMERS THAT HAVE BEEN CALIBRATED TO 89% EFFICIENCY AS INDICATED ON THE BORING LOGS.

**EXPLORATION FINDINGS**

RW-1 THROUGH RW-6

AT THE PROPOSED SITE OF THE RETAINING WALLS, THE MATERIALS ENCOUNTERED BELOW THE EXISTING TOPSOIL OR GROUND SURFACE WERE GENERALLY "MAN-MADE" FILL / POTENTIAL FILL SOILS OR NATURAL GLACIAL TILL SOILS. FILL / POTENTIAL FILL SOILS WERE ENCOUNTERED IN EACH OF THE BORINGS PERFORMED EXTENDING TO DEPTHS RANGING FROM 2.8 TO 9.5-FT BGS AND WERE CLASSIFIED AS EITHER COHESIVE SANDY SILT (A-4a), SILT AND CLAY (A-6a), SILTY CLAY (A-6b), AND CLAY (A-7-6). NATURALLY DEPOSITED GLACIAL TILL SOILS WERE ENCOUNTERED UNDERLYING THE FILL / POTENTIAL FILL SOILS IN EACH OF THE BORINGS PERFORMED. IN GENERAL, THE TILL ENCOUNTERED CONSISTED OF COARSE-GRAINED, NON-COHESIVE SOILS CLASSIFIED AS GRAVEL AND / OR STONE FRAGMENTS (A-1-a), GRAVEL AND / OR STONE FRAGMENTS WITH SAND (A-1-b), GRAVEL WITH SAND AND SILT (A-2-4), AND COARSE AND FINE SAND (A-3a). BEDROCK WAS NOT ENCOUNTERED WITHIN THE BORINGS PERFORMED.

GROUNDWATER WAS OBSERVED DURING AND / OR UPON COMPLETION OF DRILLING IN EACH OF THE BORINGS PERFORMED. GROUNDWATER WAS RECORDED TO BE ENCOUNTERED AT DEPTHS RANGING FROM 21.0 TO 25.0-FT BGS.

LEGEND		ODOT CLASS	CLASSIFIED MECH./VISUAL	
DESCRIPTION				
	GRAVEL	A-1a	10	15
	GRAVEL WITH SAND	A-1b	12	23
	GRAVEL WITH SAND AND SILT	A-2-4	3	9
	COARSE AND FINE SAND	A-3a	1	3
	SANDY SILT	A-4a	11	16
	SILT	A-4b	3	1
	SILT AND CLAY	A-6a	5	1
	SILTY CLAY	A-6b	3	4
	CLAY	A-7-6	5	4
		TOTAL	53	76
	PAVEMENT OR BASE = X = APPROXIMATE THICKNESS	VISUAL		
	SOD AND TOPSOIL = X = APPROXIMATE THICKNESS	VISUAL		
	BORING LOCATION - PLAN VIEW.			
	DRIVE SAMPLE AND/OR ROCK CORE BORING PLOTTED TO VERTICAL SCALE ONLY. HORIZONTAL BAR INDICATES A CHANGE IN STRATIGRAPHY.			
WC	INDICATES WATER CONTENT IN PERCENT.			
N <sub>60</sub>	INDICATES STANDARD PENETRATION RESISTANCE NORMALIZED TO 60% DRILL ROD ENERGY RATIO.			
W	INDICATES FREE WATER ELEVATION.			
●	INDICATES A PLASTIC MATERIAL WITH A MOISTURE CONTENT EQUAL TO OR GREATER THAN THE LIQUID LIMIT MINUS 3.			
ST	INDICATES A SHELBY TUBE SAMPLE.			
X/Y/D"	NUMBER OF BLOWS FOR STANDARD PENETRATION TEST (SPT) X = NUMBER OF BLOWS FOR 6 INCHES (UNCORRECTED) Y/D" = NUMBER OF BLOWS (UNCORRECTED) FOR D" OF PENETRATION AT REFUSAL.			

**EXPLORATION FINDINGS, (CONT.)**

PEDESTRIAN BRIDGE OVER OLDTOWN CREEK AND US-68

AT THE PROPOSED BRIDGE SITE, THE MATERIALS ENCOUNTERED BELOW THE EXISTING TOPSOIL OR GROUND SURFACE WERE GENERALLY "MAN-MADE" FILL / POTENTIAL FILL SOILS OR NATURAL GLACIAL TILL SOILS. FILL / POTENTIAL FILL SOILS WERE ENCOUNTERED IN EACH OF THE BORINGS PERFORMED AND WERE CLASSIFIED AS EITHER COHESIVE SILT AND CLAY (A-6a), SILTY CLAY (A-6b), OR CLAY (A-7-6). NATURALLY DEPOSITED GLACIAL TILL SOILS WERE ENCOUNTERED UNDERLYING THE FILL / POTENTIAL FILL SOILS IN EACH OF THE BORINGS PERFORMED. IN GENERAL, THE TILL ENCOUNTERED CAN BE DIVDED INTO AN UPPER AND LOWER STRATUM BASED ON CHARACTERISTICS. THE UPPER TILL STRATUM GENERALLY CONSISTED OF COARSE- AND FINE-GRAINED, NON COHESIVE SOILS CLASSIFIED AS EITHER GRAVEL AND STONE FRAGMENTS (A-1-a), GRAVEL AND STONE FRAGMENTS WITH SAND (A-1-b), GRAVEL AND / OR STONE FRAGMENTS WITH SAND AND SILT (A-2-4), AND NON-COHESIVE SILT (A-4b). THE LOWER TILL STRATUM GENERALLY CONSISTED OF FINE-GRAINED, COHESIVE SOILS CLASSIFIED AS COHESIVE SANDY SILT (A-4a), COHESIVE SILT (A-4b), AND CLAY (A-7-6). BEDROCK WAS NOT ENCOUNTERED WITHIN THE BORINGS PERFORMED.


GROUNDWATER WAS OBSERVED DURING AND / OR UPON COMPLETION OF DRILLING IN EACH OF THE BORINGS PERFORMED WITH THE EXCEPTION OF B-002-1-24. GROUNDWATER WAS RECORDED TO BE ENCOUNTERED AT DEPTHS RANGING FROM 10.5 TO 21.0-FT BGS.

**SPECIFICATIONS**

THIS GEOTECHNICAL EXPLORATION WAS PERFORMED IN ACCORDANCE WITH THE STATE OF OHIO, DEPARTMENT OF TRANSPORTATION, OFFICE OF GEOTECHNICAL ENGINEERING, SPECIFICATIONS FOR GEOTECHNICAL EXPLORATIONS, DATED JANUARY 24TH, 2025.


**AVAILABLE INFORMATION**

THE SOIL, BEDROCK, AND GROUNDWATER INFORMATION COLLECTED FOR THIS SUBSURFACE EXPLORATION THAT CAN BE CONVENIENTLY DISPLAYED ON THE GEOTECHNICAL PROFILE SHEETS HAS BEEN PRESENTED. GEOTECHNICAL REPORTS, IF PREPARED, ARE AVAILABLE FOR REVIEW ON THE OFFICE OF CONTRACT SALES WEBSITE.

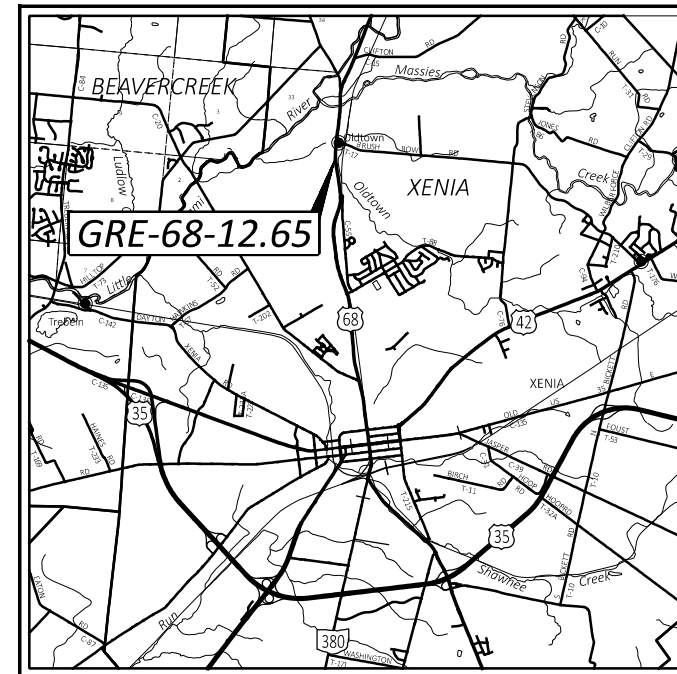


LOCATION MAP

 SCALE IN MILES



**PARTICLE SIZE DEFINITIONS**

 

SCOUR SAMPLES				
BORING ID	SAMPLE ID	SAMPLE DEPTH (ft)	SAMPLE ELEVATION	D50 VALUE (mm)
B-002-1-24	SS-1	2.5 - 4.0	825.7 - 824.3	0.148
	SS-2	5.0 - 6.5	823.3 - 821.8	0.081
	SS-3	7.5 - 9.0	820.8 - 819.3	0.931
	SS-5	12.5 - 14.0	815.8 - 814.3	0.050
	SS-7	17.5 - 19.0	810.8 - 809.3	0.064
B-003-1-24	SS-1	1.0 - 2.5	825.7 - 824.2	0.021
	SS-2	2.5 - 4.0	824.2 - 822.7	0.073
	SS-3	4.0 - 5.5	822.7 - 821.2	0.024
	SS-5	7.0 - 8.5	819.7 - 818.2	0.435

RECON. - MA, 11/15/2024  
 DRILLING - TG, JS, 01/02/2024 - 01/03/2024  
 JL, 11/25/2024 - 11/29/2024  
 DRAWN - AS, RS  
 REVIEWED - KA, BPA, 03/31/25

DESIGN AGENCY  
**NEAS**  
 2800 CORPORATE EXCHANGE DR, SUITE 240 COLUMBUS, OH, 43231  
 TEL: 614.714.0299  
 WWW.NEASINC.COM

DESIGNER	AS
REVIEWER	BPA 03/31/25
PROJECT ID	115388
SUBSET	TOTAL
1	15
SHEET	TOTAL
P.93	107



5710 Westbourne Avenue  
 Columbus, OH 43213  
 614.892.0162

### Consolidation Test


Project Name: GRE-68-12.65 Prepared by: LR  
 Source: B-001-3-24 ST-2 (2.6'-2.7'). Offset resampled ST-2 Checked by: ZM  
 Description: Stiff to very stiff, brown, CLAY, some silt, some sand, little gravel, damp. Date: 12/27/2024

Test Specification: ASTM D 2435  
 Initial Void Ratio: 0.707 Initial Bulk Unit Weight (lb/ft<sup>3</sup>): 124  
 In-situ Vertical Effective Stress (psf): 322 Dry Unit Weight (lb/ft<sup>3</sup>): 99


#### Compression and Swelling Index



Compression Index ( $C_c$ ): 0.166 Preconsolidation Pressure ( $\sigma_c'$ )(psf): 2000  
 Recompression Index ( $C_r$ ): 0.013 Over-Consolidation Ratio (OCR): 6.22

#### Consolidation Curve

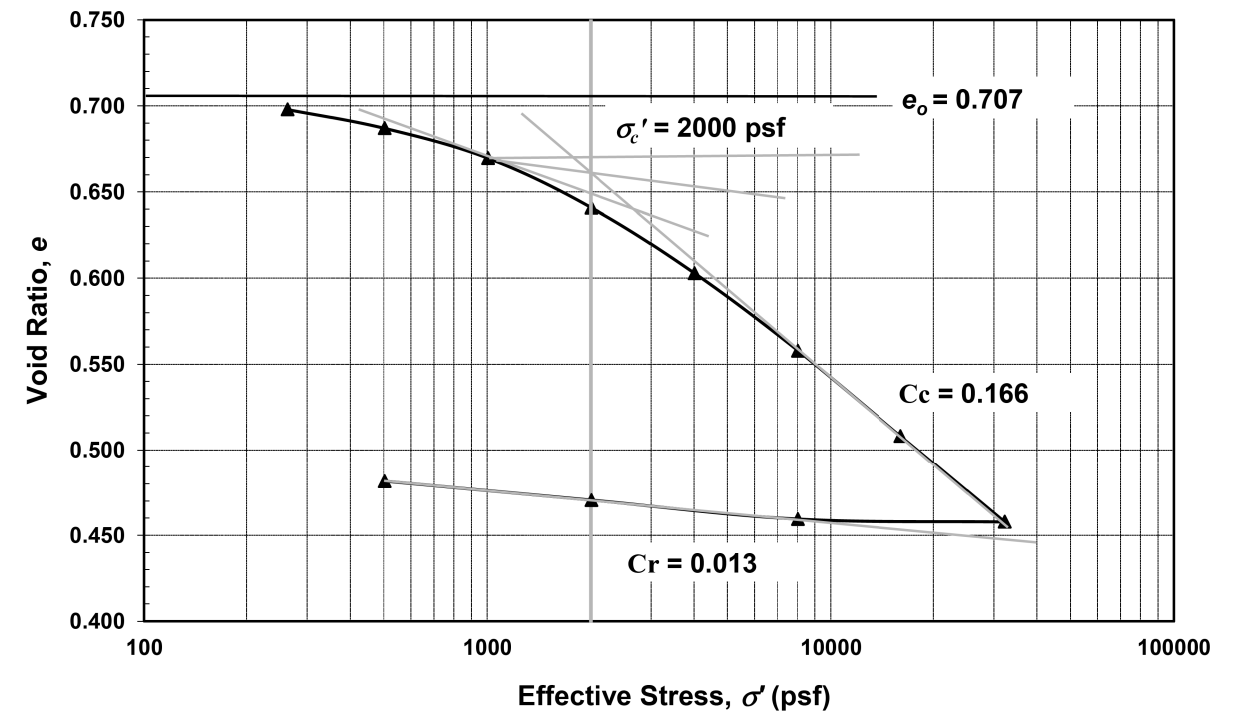




#### Loading

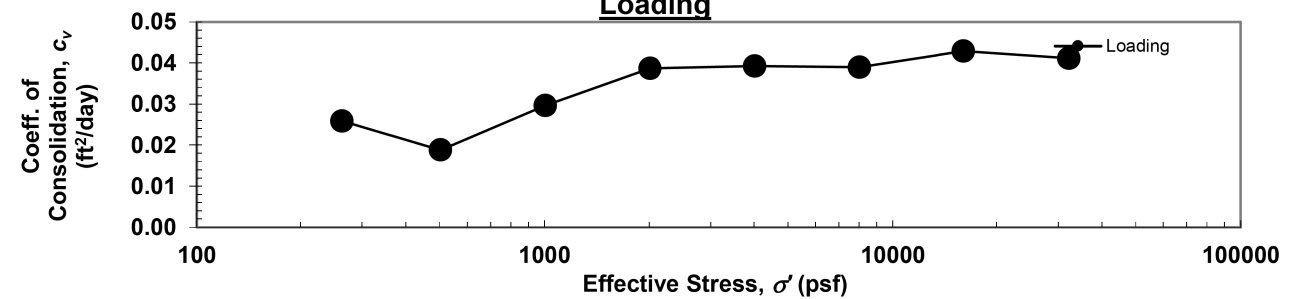

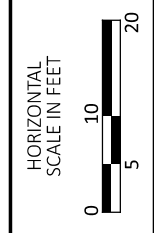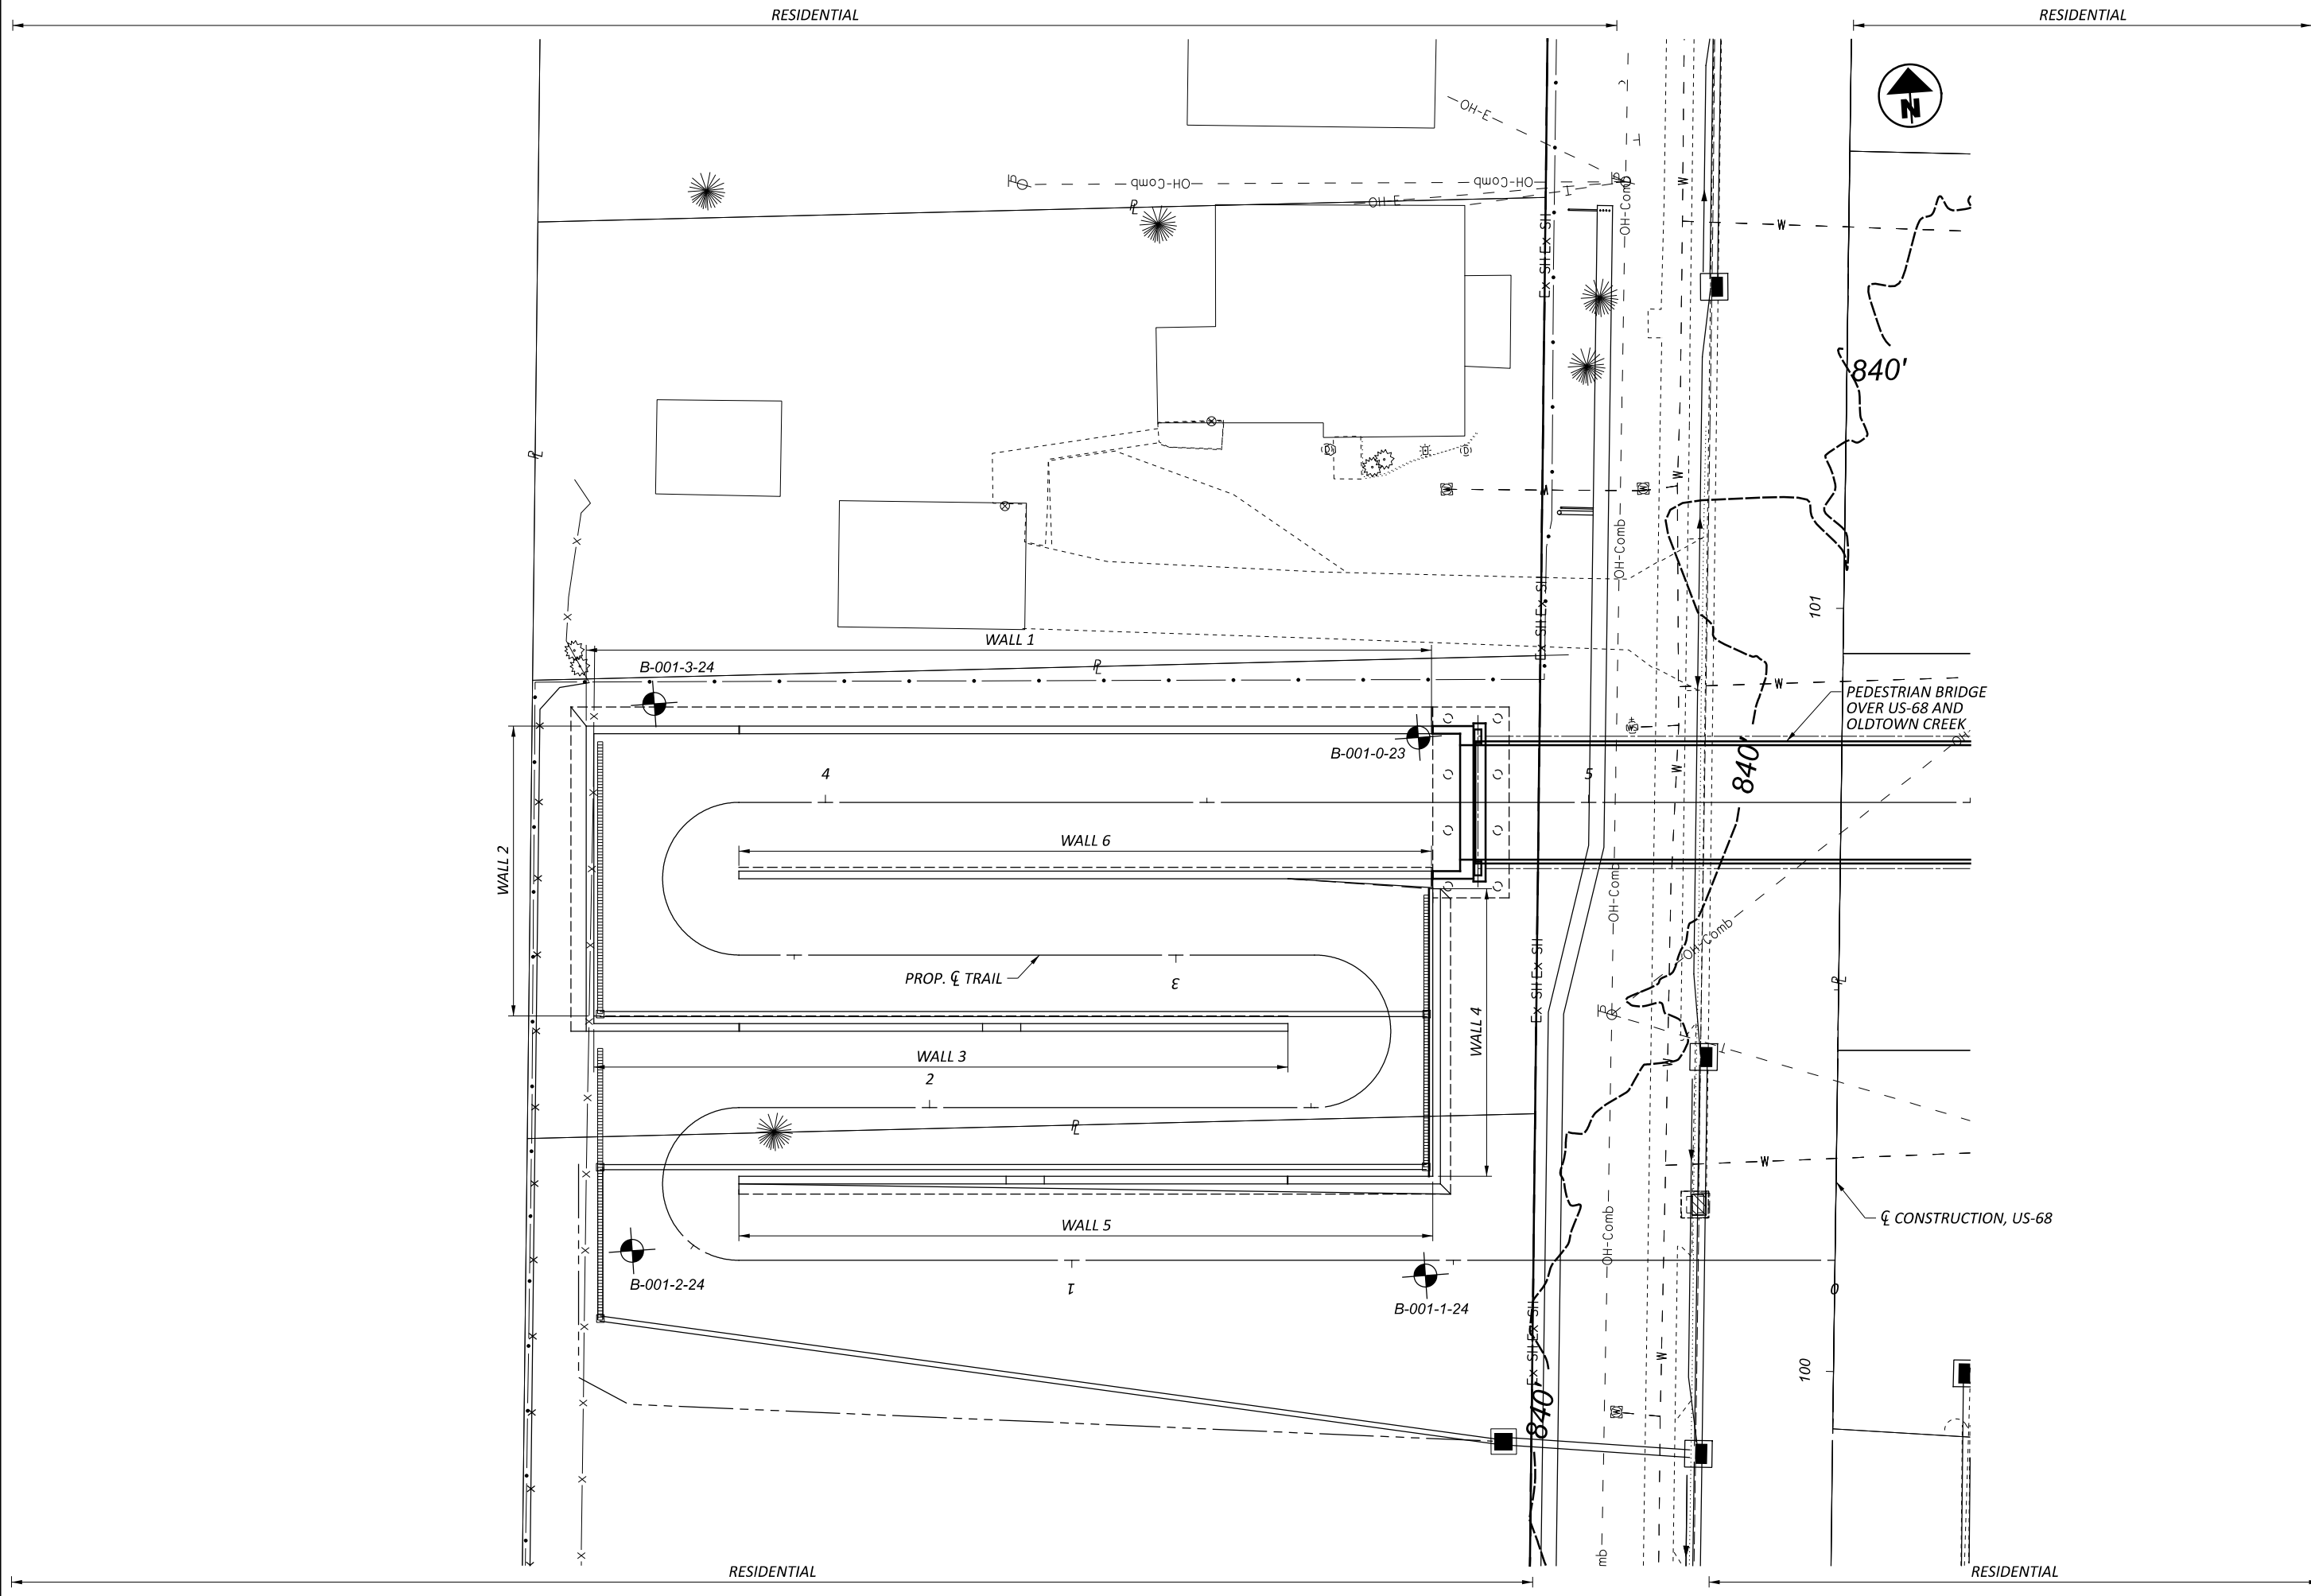

**GEOTECHNICAL PROFILE - BRIDGE**  
**PEDESTRIAN BRIDGE OVER US 68 AND OLDTOWN CREEK**

DESIGN AGENCY	
<b>NEAS</b>	
2800 CORPORATE EXCHANGE DR, SUITE 240 COLUMBUS, OH, 43231 TEL: 614.714.0299 WWW.NEASINC.COM	
DESIGNER	RS
REVIEWER	BPA 03/31/25
PROJECT ID	115388
SUBSET	TOTAL
3	15
SHEET	TOTAL
P.95	107

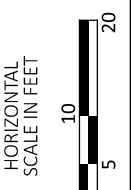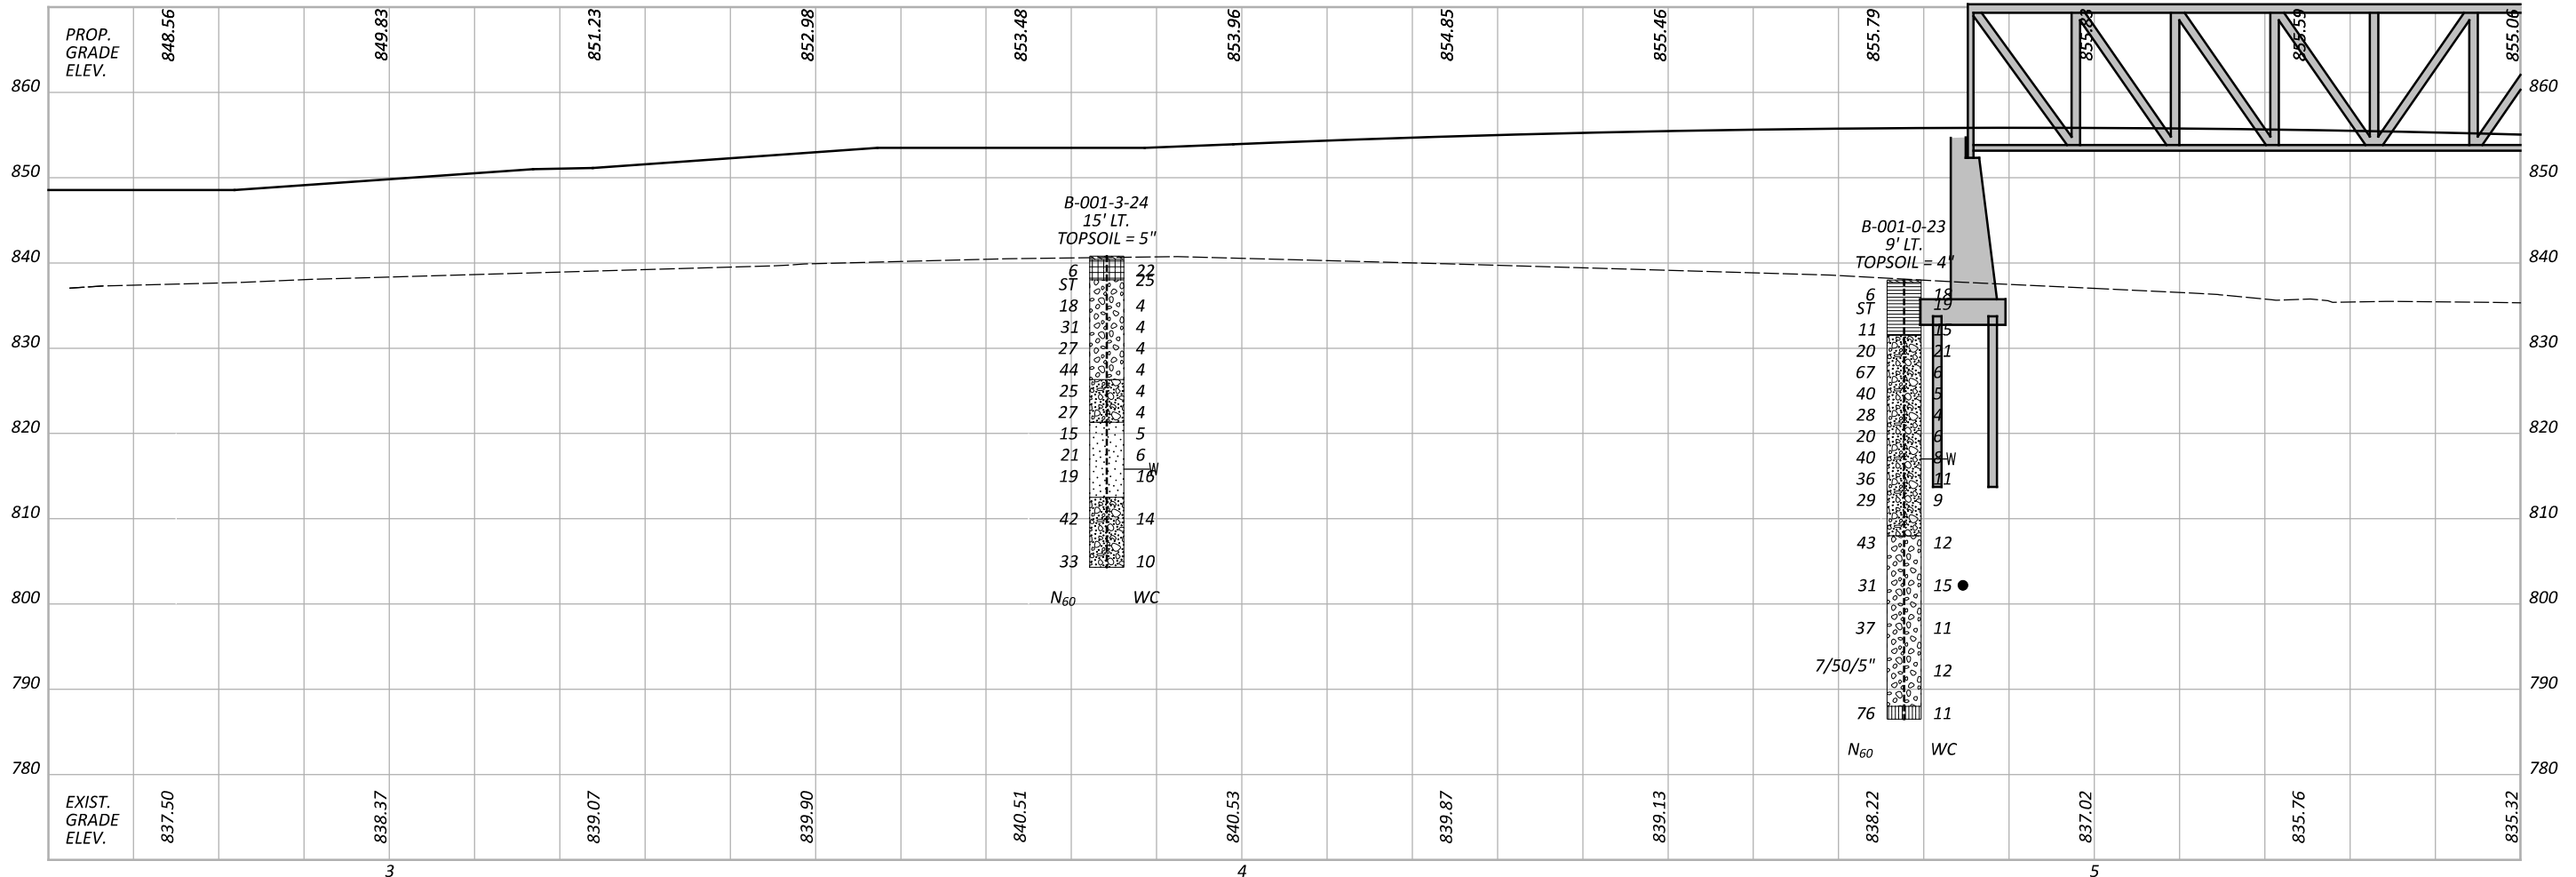
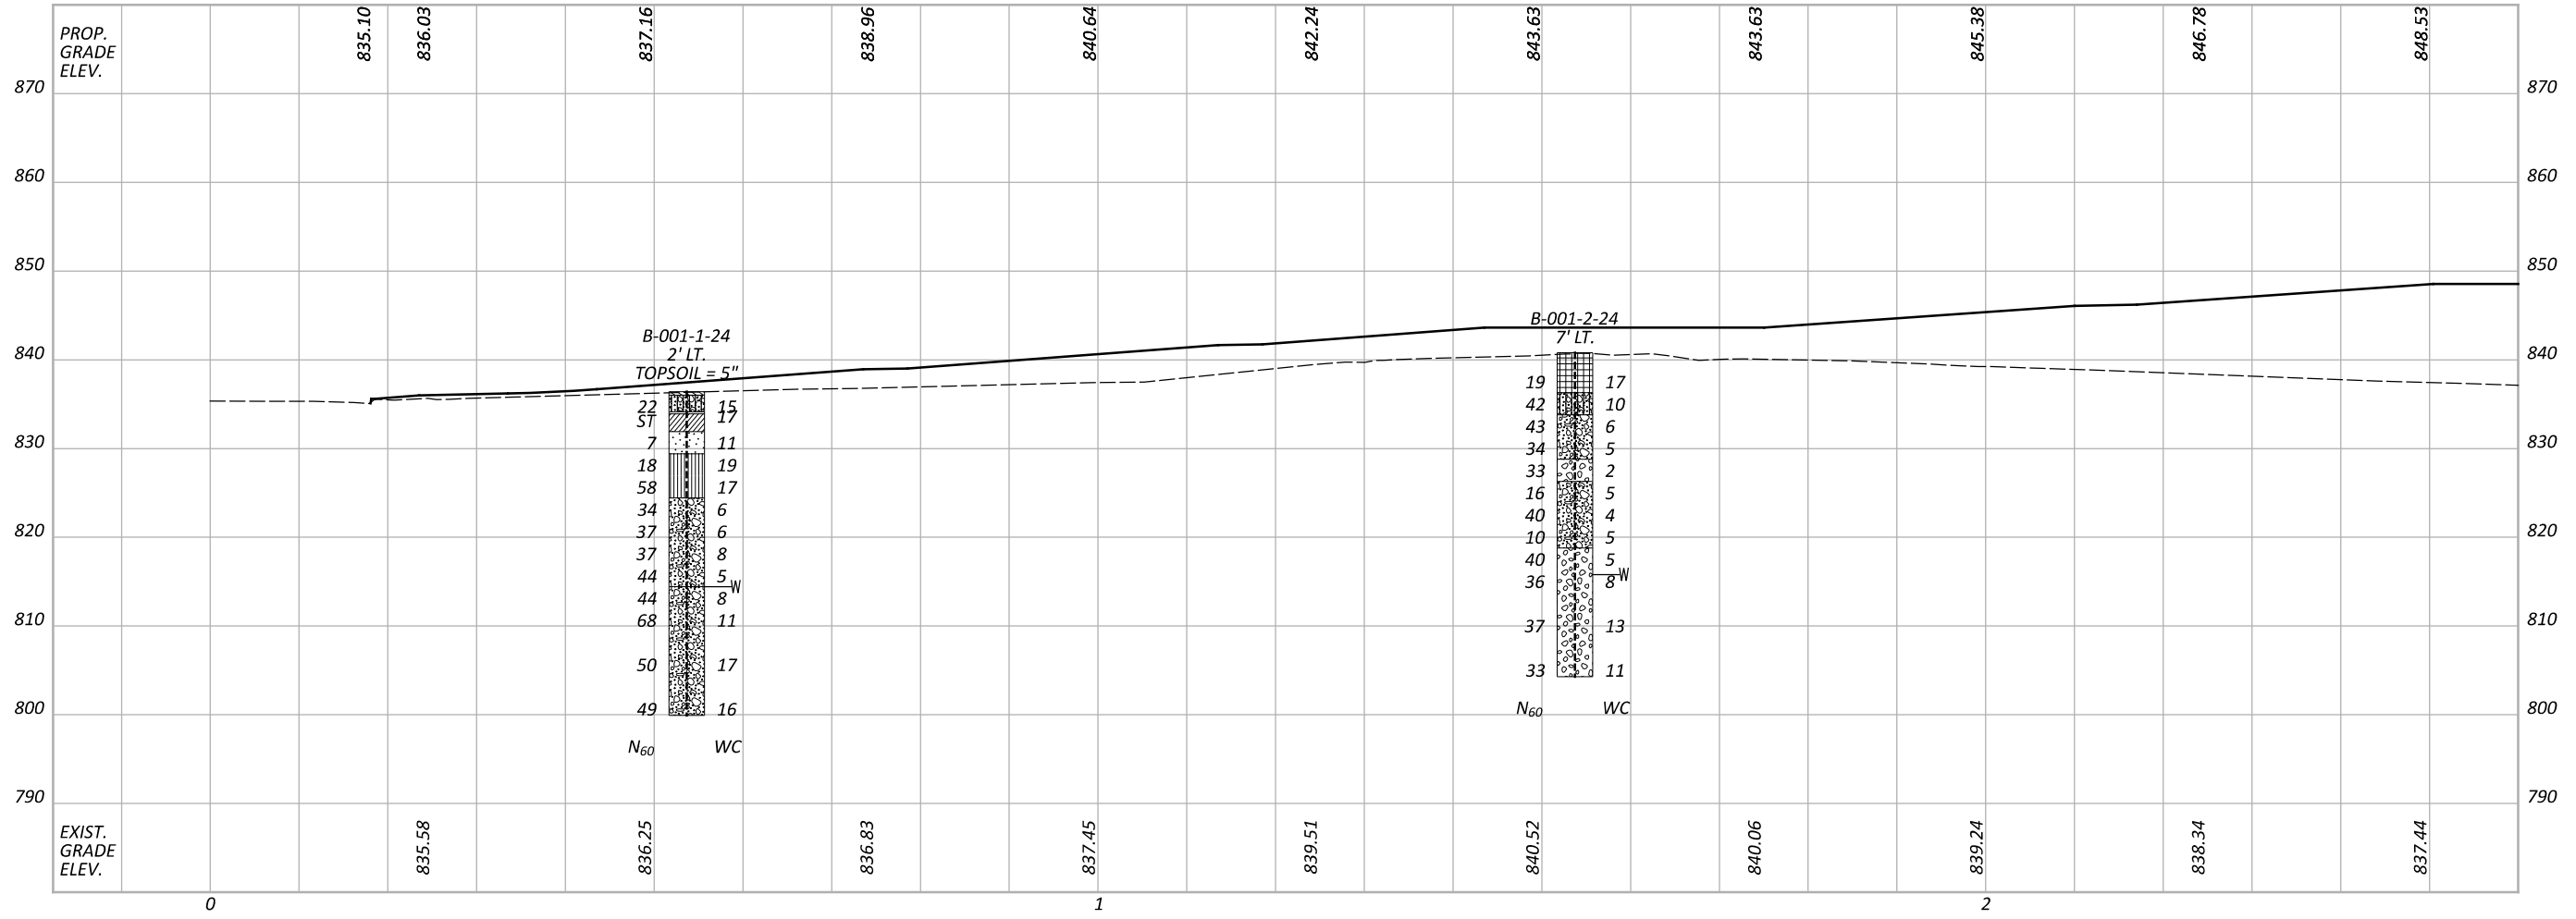


**GEOTECHNICAL PROFILE - BRIDGE  
 PEDESTRIAN BRIDGE OVER US 68 AND OLD TOWN CREEK**

DESIGN AGENCY  
**NEAS**  
 2800 CORPORATE EXCHANGE DR, SUITE 240, COLUMBUS, OH, 43231  
 TEL: 614.714.0299, WWW.NEASINC.COM

DESIGNER: RS  
 REVIEWER: BPA 03/31/25  
 PROJECT ID: 115388  
 SUBSET TOTAL: 4 / 15  
 SHEET TOTAL: P.96 / 107



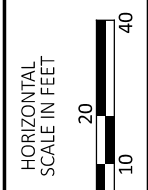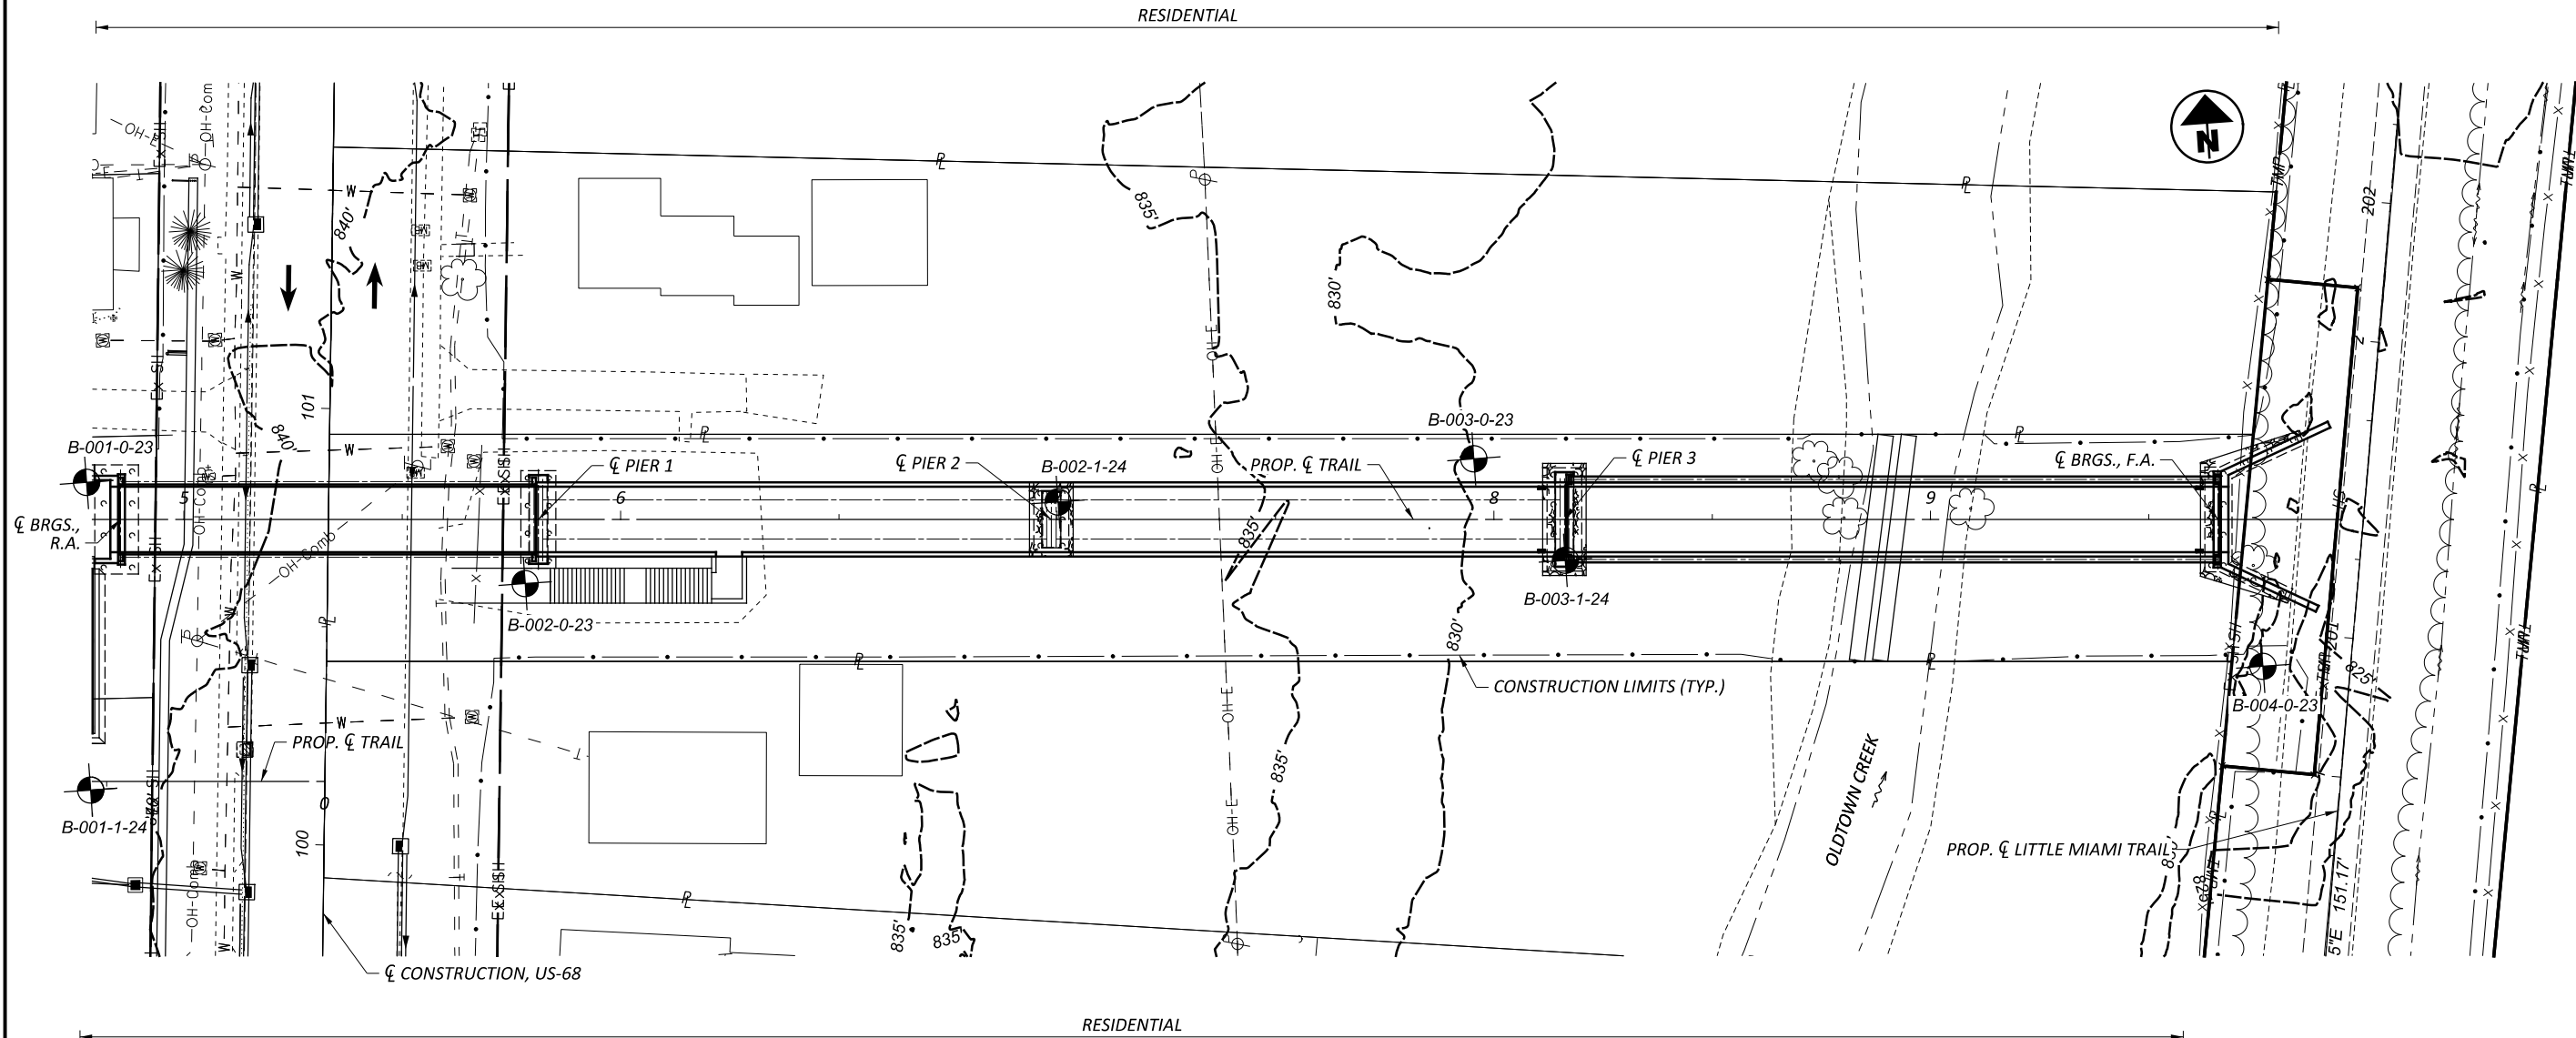

GEOTECHNICAL PROFILE - BRIDGE  
 PEDESTRIAN BRIDGE OVER US 68 AND OLDTOWN CREEK

DESIGN AGENCY	
<b>NEAS</b>	
2800 CORPORATE EXCHANGE DR., SUITE 240, COLUMBUS, OH, 43231 TEL: 614.714.0299 WWW.NEASINC.COM	
DESIGNER	
RS	
REVIEWER	
BPA 03/31/25	
PROJECT ID	
115388	
SUBSET	TOTAL
5	15
SHEET	TOTAL
P.97	107



**GRE-68-12.65**

MODEL SHEET PAPER SIZE: 17x11 (in.) DATE: 3/31/2025 TIME: 2:50:30 PM USER: Rsoffhancs P:\OHDOT\_v3\Worksheets\115388\000-Engineering\Geotechnical\Sheets\115388\_ZL001.dgn

PROJECT: GRE-68-12.65		DRILLING FIRM / OPERATOR: UES / TG		DRILL RIG: UES CME 55		STATION / OFFSET: TBD		EXPLORATION ID							
TYPE: STRUCTURE FOUNDATION		SAMPLING FIRM / LOGGER: STANTEC / JS		HAMMER: CME AUTOMATIC		ALIGNMENT: US 68		B-001-0-23							
PID: 115388 SFN: N/A		DRILLING METHOD: 3.25" HSA		CALIBRATION DATE: 7/17/23		ELEVATION: 838.0 (MSL) EOB: 51.5 ft.		PAGE							
START: 1/2/24 END: 1/3/23		SAMPLING METHOD: SPT / ST		ENERGY RATIO (%): 90*		LAT / LONG: 39.729686, -83.936960		1 OF 2							
<b>MATERIAL DESCRIPTION AND NOTES</b>															
DARK BROWN, TOPSOIL, 4 INCHES															
MEDIUM STIFF TO STIFF, LIGHT BROWN TO BROWN, SILTY CLAY, SOME SAND, DAMP TO MOIST															
QU = 4,280 PSF FROM 2.0 TO 4.0 FT.															
MEDIUM DENSE TO DENSE, BROWN TO LIGHT GRAY, GRAVEL AND STONE FRAGMENTS WITH SAND, LITTLE SILT, TRACE CLAY, MOIST TO WET															
VERY DENSE AT SS-4															
ELEV. 838.0		DEPTHS		SPT/ RQD		REC SAMPLE (%)		HP (tsf)		GRADATION (%)		ATTENBERG		HOLE SEALED	
837.7		1		2		67		1.25		-		-		18	
		2				100		4.50		0		4		17	
		3								41		33		17	
		4								-		-		-	
		5								-		-		-	
831.5		6		4		83		2.00		-		-		15	
		7								-		-		-	
		8		4		20		94		-		-		21	
		9								-		-		-	
		10								22		10		14	
		11		16		65		67		49		22		10	
		12								-		-		-	
		13		9		11		39		72		10		14	
		14								-		-		-	
		15		7		8		27		61		-		-	
		16								-		-		4	
		17								-		-		-	
		18		6		6		20		78		-		-	
		19								-		-		6	
		20								-		-		-	
817.0		21		8		11		39		83		-		-	
		22								-		-		8	
		23		8		11		35		83		-		-	
		24								-		-		11	
		25								-		-		-	
		26		8		9		29		78		-		-	
		27								-		-		9	

PROJECT: N/A		PROJECT: GRE-68-12.65		STATION / OFFSET: TBD		START: 1/2/24		END: 1/3/23		PG 2 OF 2		B-001-0-23	
PID: 115388 SFN: N/A		ELEV. 811.5		SPT/ RQD		REC SAMPLE (%)		HP (tsf)		GRADATION (%)		HOLE SEALED	
808.0		27								-		-	
		28								-		-	
		29								-		-	
		30		8		42		83		53		27	
		31								8		4	
		32								-		-	
		33								-		-	
		34								-		-	
		35		9		9		30		78		53	
		36								8		4	
		37								-		-	
		38								-		-	
		39								-		-	
		40		7		9		36		72		-	
		41								-		-	
		42								-		-	
		43								-		-	
		44								-		-	
		45		7		50/5"		-		100		-	
		46								-		-	
		47								-		-	
		48								-		-	
		49								-		-	
788.0		50		13		21		74		100		4.50	
		51								-		-	
786.5		EOB								-		-	

COBBLES ENCOUNTERED FROM 46.0 TO 47.0 FEET

HARD, GRAY, SANDY SILT, TRACE TO LITTLE GRAVEL, SOME CLAY, GLACIAL TILL, DAMP

NOTES: GPS COORDINATES DETERMINED BY CELL PHONE. ELEVATION ESTIMATED USING GPS COORDINATES AND GOOGLE EARTH TOPOGRAPHIC DATA. ABANDONMENT METHODS, MATERIALS, QUANTITIES: BENTONITE; AUGER CUTTINGS MIXED WITH BENTONITE POWDER

DESIGN AGENCY  
**NEAS**  
 2800 CORPORATE EXCHANGE DR, SUITE 240 COLUMBUS, OH, 43231  
 TEL: 614.714.0299 WWW.NEASINC.COM

DESIGNER: AS  
 REVIEWER: BPA 03/31/25  
 PROJECT ID: 115388  
 SUBSET: 7 TOTAL: 15  
 SHEET: P.99 TOTAL: 107

**GEOTECHNICAL PROFILE - BRIDGE**  
**PEDESTRIAN BRIDGE OVER US 68 AND OLD TOWN CREEK**  
**BORING LOG B-001-0-23**

**GRE-68-12.65**

MODEL SHEET PAPER SIZE: 17x11 (in.) DATE: 3/31/2025 TIME: 2:50:40 PM USER: Rsoffhancs P:\OHDOT\_v3\Worksheets\115388\000-Engineering\Geotechnical\Sheets\115388\_ZL002.dgn

PROJECT: GRE-68-12.65		DRILLING FIRM / OPERATOR: UES / TG		STATION / OFFSET: TBD		EXPLORATION ID												
TYPE: STRUCTURE FOUNDATION		HAMMER: CME AUTOMATIC		ALIGNMENT: US 68		B-002-0-23												
PID: 115388 SFN: N/A		DRILLING METHOD: 3.25" HSA		ELEVATION: 835.0 (MSL) EOB: 51.5 ft.		PAGE												
START: 1/3/23 END: 1/3/23		SAMPLING METHOD: SPT / ST		LAT / LONG: 39.729607, -83.936608		1 OF 2												
MATERIAL DESCRIPTION AND NOTES																		
GRAY, GRAVEL, 2 INCHES STIFF, LIGHT BROWN TO BROWN, SILT AND CLAY, TRACE GRAVEL, SOME SAND, DAMP TO MOIST	1	3	9	72	SS-1	1.25	1	8	24	41	26	35	20	15	25	A-6a (8)		
	2	3	4	15	56	SS-2	2.75	1	8	24	41	26	35	20	15	20	A-6a (8)	
	3	4	6	100	ST-1	-	42	20	10	18	10	23	22	1	13	A-2-4 (0)		
	4	12	20	57	33	SS-3	-	-	-	-	-	-	-	-	3	A-2-4 (V)		
	5	18	9	7	23	67	SS-4	-	-	-	-	-	-	-	7	A-2-4 (V)		
	6	11	14	41	78	SS-5	-	-	-	-	-	-	-	-	4	A-2-4 (V)		
	7	6	10	24	78	SS-6	-	-	-	-	-	-	-	-	5	A-2-4 (V)		
	8	11	12	33	72	SS-7	-	-	-	-	-	-	-	-	8	A-2-4 (V)		
	9	15	28	84	94	SS-8	-	-	-	-	-	-	-	-	5	A-1-a (V)		
	10	18	16	47	78	SS-9	-	61	22	6	8	3	18	18	NP	12	A-1-a (0)	
	11	21	9	11	41	100	SS-10	-	61	22	6	8	3	18	18	NP	16	A-1-a (0)
	12	22	4	5	24	100	SS-11	-	-	-	-	-	-	-	-	13	A-1-a (V)	
	13	26	11	26	81	100	SS-16	4.50	-	-	-	-	-	-	-	13	A-4b (V)	

STANDARD ODOT SOIL BORING LOG (6.5 X 11) - OH DOT GDT - 1/29/24 08:49 - \US0268-PFSS01\SHARED PROJECTS\1755785\61\TECHNICAL PRODUCTION\FIELD DATA\LOGS\GRE-68-12.65

PROJECT: N/A		DRILLING FIRM / OPERATOR: GRE-68-12.65		STATION / OFFSET: TBD		EXPLORATION ID												
TYPE: N/A		HAMMER: GRE-68-12.65		ALIGNMENT: US 68		B-002-0-23												
PID: 115388 SFN: N/A		DRILLING METHOD: SPT / ST		ELEVATION: 808.5		PAGE												
START: 1/3/23 END: 1/3/23		SAMPLING METHOD: SPT / ST		LAT / LONG: 39.729607, -83.936608		1 OF 2												
MATERIAL DESCRIPTION AND NOTES																		
MEDIUM DENSE TO DENSE, GRAY, GRAVEL AND STONE FRAGMENTS, SOME SAND, TRACE SILT, TRACE CLAY, MOIST TO WET VERY DENSE AT SS-8	27	19	27	99	100	SS-12	4.50	11	21	22	20	26	21	13	8	A-4a (2)		
	28	30	39	99	100	SS-13	4.50	11	21	22	20	26	21	13	8	A-4a (2)		
	29	15	30	99	100	SS-13	4.50	11	21	22	20	26	21	13	8	A-4a (2)		
	30	8	18	57	100	SS-14	-	0	1	32	60	7	20	20	NP	25	A-4b (6)	
	31	10	19	74	100	SS-15	-	0	1	32	60	7	20	20	NP	17	A-4b (6)	
	32	9	26	81	100	SS-16	4.50	-	-	-	-	-	-	-	-	13	A-4b (V)	
	33	28	4	5	24	100	SS-11	-	-	-	-	-	-	-	-	13	A-1-a (V)	
	34	11	14	41	78	SS-5	-	-	-	-	-	-	-	-	4	A-2-4 (V)		
	35	6	10	24	78	SS-6	-	-	-	-	-	-	-	-	5	A-2-4 (V)		
	36	11	12	33	72	SS-7	-	-	-	-	-	-	-	-	8	A-2-4 (V)		
	37	15	28	84	94	SS-8	-	-	-	-	-	-	-	-	5	A-1-a (V)		
	38	18	16	47	78	SS-9	-	61	22	6	8	3	18	18	NP	12	A-1-a (0)	
	39	21	9	11	41	100	SS-10	-	61	22	6	8	3	18	18	NP	16	A-1-a (0)
	40	22	4	5	24	100	SS-11	-	-	-	-	-	-	-	-	13	A-1-a (V)	
	41	26	11	26	81	100	SS-16	4.50	-	-	-	-	-	-	-	13	A-4b (V)	

STANDARD ODOT SOIL BORING LOG (6.5 X 11) - OH DOT GDT - 1/29/24 08:49 - \US0268-PFSS01\SHARED PROJECTS\1755785\61\TECHNICAL PRODUCTION\FIELD DATA\LOGS\GRE-68-12.65

NOTES: GPS COORDINATES DETERMINED BY CELL PHONE. ELEVATION ESTIMATED USING GPS COORDINATES AND GOOGLE EARTH TOPOGRAPHIC DATA. ABANDONMENT METHODS, MATERIALS, QUANTITIES: BENTONITE; AUGER CUTTINGS MIXED WITH BENTONITE POWDER

DESIGN AGENCY  
**NEAS**  
 2800 CORPORATE EXCHANGE DR, SUITE 240 COLUMBUS, OH, 43231  
 TEL: 614.714.0299 WWW.NEASINC.COM

DESIGNER: AS  
 REVIEWER: BPA 03/31/25  
 PROJECT ID: 115388  
 SUBSET: 8 TOTAL: 15  
 SHEET: P.100 TOTAL: 107

**GEOTECHNICAL PROFILE - BRIDGE**  
**PEDESTRIAN BRIDGE OVER US 68 AND OLDTOWN CREEK**  
**BORING LOG B-002-0-23**



**GRE-68-12.65**

MODEL SHEET PAPER SIZE: 17x11 (in.) DATE: 3/31/2025 TIME: 2:50:59 PM USER: Rsofflancs  
 P:\OHDOT\_v3\Worksheets\115388\000-Engineering\Geotechnical\Sheets\115388\_ZL004.dgn

STANDARD ODOT SOIL BORING LOG (6.5 X 11) - OH DOT GDT - 1/29/24 08:49 - \WS0268-PFSS01\SHARED PROJECTS\175785\61\TECHNICAL PRODUCTION\FIELD DATA\LOGS\GRE-68-12.65

PROJECT: GRE-68-12.65		DRILLING FIRM / OPERATOR: UES / TG		STATION / OFFSET: TBD		EXPLORATION ID										
TYPE: STRUCTURE FOUNDATION		HAMMER: CME AUTOMATIC		ALIGNMENT: US 68		B-004-0-23										
PID: 115388 SFN: N/A		DRILLING METHOD: 3.25" HSA		ELEVATION: 831.0 (MSL) EOB: 51.5 ft.		PAGE										
START: 1/2/24 END: 1/2/24		SAMPLING METHOD: SPT		LAT / LONG: 39.729494, -83.935199		1 OF 2										
MATERIAL DESCRIPTION AND NOTES																
DARK BROWN, TOPSOIL, 4 INCHES STIFF TO VERY STIFF, DARK BROWN TO BROWN, CLAY, TRACE GRAVEL, LITTLE TO SOME SAND, "AND" SILT, DAMP TO MOIST  DENSE BROWN TO GRAY, GRAVEL AND STONE FRAGMENTS WITH SAND, TRACE SILT, TRACE CLAY, MOIST TO WET  DENSE TO VERY DENSE, GRAY, GRAVEL AND STONE FRAGMENTS, TRACE SILT, TRACE CLAY, WET	ELEV. 831.0	DEPTHS	SPT/ RQD	REC SAMPLE (%)	HP (tsf)	GRADATION (%)	ATTERBERG									
	830.7	1	3	11	3.00	-	-									
		2														
		3	11	56	1.50	2	4	12	39	43	52	28	24	27	A-7-6 (16)	
		4														
		5	6	21	72	2.00	2	4	12	39	43	52	28	24	26	A-7-6 (16)
		6	8	8	78	4.50	-	-	-	-	-	-	-	-	17	A-7-6 (V)
		7														
		8	5	15	56	-	2	4	18	48	28	41	23	18	6	A-7-6 (11)
		9	6	4												
		10	12	30	72	-	2	4	18	48	28	41	23	18	8	A-7-6 (11)
		11	13	39	72	-	49	22	13	9	7	18	16	2	11	A-1-b (0)
		12	13													
		13	9	38	61	-	49	22	13	9	7	18	16	2	12	A-1-b (0)
		14	16	47	100	-	50	23	13	8	6	17	16	1	14	A-1-a (0)
		15	17	19												
		16	10	45	100	-	50	23	13	8	6	17	16	1	12	A-1-a (0)
		17	14													
		18	20	53	100	-	-	-	-	-	-	-	-	-	10	A-1-a (V)
		19	21													
		20	16													
		21	20													
		22														
		23	5	33	67	-	-	-	-	-	-	-	-	-	10	A-1-a (V)
		24	9													
		25	26	38	100	-	69	14	7	8	2	18	17	1	8	A-1-a (0)
	26	14														
	27	11														

STANDARD ODOT SOIL BORING LOG (6.5 X 11) - OH DOT GDT - 1/29/24 08:49 - \WS0268-PFSS01\SHARED PROJECTS\175785\61\TECHNICAL PRODUCTION\FIELD DATA\LOGS\GRE-68-12.65

PROJECT: N/A		DRILLING FIRM / OPERATOR: TBD		STATION / OFFSET: TBD		EXPLORATION ID										
TYPE: N/A		HAMMER: UES CME 55		ALIGNMENT: US 68		B-004-0-23										
PID: 115388 SFN: N/A		DRILLING METHOD: 3.25" HSA		ELEVATION: 804.5 (MSL) EOB: 51.5 ft.		PAGE										
START: 1/2/24 END: 1/2/24		SAMPLING METHOD: SPT		LAT / LONG: 39.729494, -83.935199		1 OF 2										
MATERIAL DESCRIPTION AND NOTES																
DENSE TO VERY DENSE, GRAY, GRAVEL AND STONE FRAGMENTS, TRACE SILT, TRACE CLAY, WET  DENSE TO VERY DENSE, GRAY, GRAVEL AND STONE FRAGMENTS, TRACE SILT, TRACE CLAY, WET  DENSE TO VERY DENSE, GRAY, GRAVEL AND STONE FRAGMENTS, TRACE SILT, TRACE CLAY, WET  HARD, GRAY, SANDY SILT, TRACE TO LITTLE GRAVEL, SOME CLAY, GLACIAL TILL, DAMP VERY DENSE, GRAY, GRAVEL AND STONE FRAGMENTS, TRACE SILT, TRACE CLAY, GLACIAL TILL, WET  HARD, GRAY, SANDY SILT, TRACE TO LITTLE GRAVEL, SOME CLAY, GLACIAL TILL, DAMP	ELEV. 804.5	DEPTHS	SPT/ RQD	REC SAMPLE (%)	HP (tsf)	GRADATION (%)	ATTERBERG									
	804.5	27														
		28														
		29														
		30	14	47	72	-	69	14	7	8	2	18	17	1	15	A-1-a (0)
		31	17													
		32	14													
		33														
		34														
		35	15	101	100	4.50	-	-	-	-	-	-	-	-	14	A-4a (V)
		36	25													
		37	42													
		38														
		39														
		40	18	119	100	-	-	-	-	-	-	-	-	-	12	A-1-a (V)
		41	29													
		42	50													
		43														
		44														
		45	15	65	100	-	-	-	-	-	-	-	-	-	11	A-1-a (V)
		46	21													
		47	22													
		48														
		49														
		50	11	63	100	2.25	-	-	-	-	-	-	-	-	18	A-4a (V)
		51	16													
	EOB	26														

NOTES: GPS COORDINATES DETERMINED BY CELL PHONE. ELEVATION ESTIMATED USING GPS COORDINATES AND GOOGLE EARTH TOPOGRAPHIC DATA.  
 ABANDONMENT METHODS, MATERIALS, QUANTITIES: BENTONITE; AUGER CUTTINGS MIXED WITH BENTONITE POWDER

DESIGN AGENCY  
**NEAS**  
 2800 CORPORATE EXCHANGE DR, SUITE 240, COLUMBUS, OH, 43231  
 TEL: 614.714.0299 WWW.NEASINC.COM

DESIGNER: AS  
 REVIEWER: BPA 03/31/25  
 PROJECT ID: 115388  
 SUBSET: 10 TOTAL: 15  
 SHEET: P.102 TOTAL: 107

**GEOTECHNICAL PROFILE - BRIDGE**  
**PEDESTRIAN BRIDGE OVER US 68 AND OLDTOWN CREEK**  
**BORING LOG B-004-0-23**



**GRE-68-12.65**

MODEL SHEET PAPER SIZE: 17x11 (in.) DATE: 3/31/2025 TIME: 2:51:19 PM USER: Rsofflancs  
 P:\OHDOT\_v3\Worksets\115388\400-Engineering\Geotechnical\Sheets\115388\_ZL006.dgn

PROJECT: GRE-68-12.65 TYPE: RETAINING WALL	DRILLING FIRM / OPERATOR: NEAS INC. / J/L SAMPLING FIRM / LOGGER: NEAS INC. / J/L DRILLING METHOD: 3.25" HSA SAMPLING METHOD: SPT	DRILL RIG: CME 55TB HAMMER: CME AUTOMATIC CALIBRATION DATE: 7/30/24 ENERGY RATIO (%): 89	STATION / OFFSET: 1+54.5' LT. ALIGNMENT: SHARED USE PATH ELEVATION: 840.7 (MSL) EOB: 36.5 ft. LAT / LONG: 39.729517, -83.937339										EXPLORATION ID B-001-2-24				
			GR	CS	FS	SI	CL	LL	PL	PI	WC	ODOT CLASS (G)					
MATERIAL DESCRIPTION AND NOTES		SPT/ RQD	N <sub>60</sub>	REC SAMPLE (%)	HP (tsf)	GR	CS	FS	SI	CL	LL	PL	PI	WC	ODOT CLASS (G)		
HARD, BROWN, CLAY, SOME SAND, SOME GRAVEL, LITTLE SILT, CONTAINS ROOTS, MODERATELY ORGANIC, DAMP (FILL)	ELEV. 840.7	1															
		2															
		3	6	19	61	4.50	24	13	12	16	35	60	24	36	17	A-7-6 (12)	
		4	7														
		5															
		6	7	4	42	22										10	A-2-4 (V)
		7	24														
		8	12	14	43	17										6	A-1-b (V)
		9	15														
		10	13	8	34	33										5	A-1-b (V)
		11	15														
		DENSE, BROWN, GRAVEL AND STONE FRAGMENTS LITTLE SAND, TRACE SILT, TRACE CLAY, DAMP	ELEV. 828.7	12	12	33	22										2
13	11			11													
14																	
15																	
16	4			5	16	50										5	A-1-b (V)
17																	
18	6			8	40	72			35	29	7	2	NP	NP	NP	4	A-1-b (0)
19	19																
20																	
21	3			4	10	61										5	A-1-b (V)
DENSE, BROWN, GRAVEL, SOME SAND, TRACE SILT, TRACE CLAY, MOIST TO WET	ELEV. 818.7	22															
		23	7	16	40	50									5	A-1-a (V)	
		24	11														
		25	11	12	36	33			20	11	7	2	NP	NP	NP	8	A-1-a (0)
		26	12														
		27															
		28															
		29															
		30	7	16	37	72										13	A-1-a (V)
		31	9														
DENSE, BROWN, GRAVEL, SOME SAND, TRACE SILT, TRACE CLAY, DAMP	ELEV. 804.2	32															
		33															
		34															
		35	10	14	33	67										11	A-1-a (V)
		36	8														
		EOB															

STANDARD ODOT SOIL BORING LOG (1' X 17') - OH DOT.GDT - 3/28/25 15:40 - X:\ACTIVE PROJECTS\ACTIVE SOIL PROJECTS\GRE-68-12.65\GINT FILES\GRE-68-12.65.GPJ

NOTES: GROUNDWATER ENCOUNTERED AT 25.0' DURING DRILLING. HOLE DID NOT GAVE. DRILLED AS STAKED.  
 ABANDONMENT METHODS, MATERIALS, QUANTITIES: POURED 1.0 BAG HOLE PLUG; SHOVELED SOIL CUTTINGS



DESIGNER	AS
REVIEWER	BPA 03/31/25
PROJECT ID	115388
SUBSET	TOTAL
12	15
SHEET	TOTAL
P.104	107

**GEOTECHNICAL PROFILE - BRIDGE  
 PEDESTRIAN BRIDGE OVER US 68 AND OLDTOWN CREEK  
 BORING LOG B-001-2-24**




**GRE-68-12.65**

MODEL SHEET PAPER SIZE: 17x11 (in.) DATE: 3/31/2025 TIME: 2:51:29 PM USER: Rsofflancs  
 P:\OHDOT\_v3\Worksheets\115388\000-Engineering\Geotechnical\Sheets\115388\_ZL007.dgn

PROJECT: GRE-68-12.65 TYPE: RETAINING WALL	DRILLING FIRM / OPERATOR: NEAS INC. / J/L SAMPLING FIRM / LOGGER: NEAS INC. / J/L DRILLING METHOD: 3.25" HSA SAMPLING METHOD: SPT / ST	DRILL RIG: CME 55TB HAMMER: CME AUTOMATIC CALIBRATION DATE: 7/30/24 ENERGY RATIO (%): 89	STATION / OFFSET: 3+92, 13' LT. ALIGNMENT: SHARED USE PATH ELEVATION: 840.8 (MSL) EOB: 36.5 ft. LAT / LONG: 39.729713, -83.937315										EXPLORATION ID B-001-3-24			
			GR	CS	FS	SI	CL	LL	PL	PL	WC	ODOT CLASS (G)				
MATERIAL DESCRIPTION AND NOTES		SPT / RQD	N <sub>60</sub>	REC SAMPLE (%)	HP (tsf)	GR	CS	FS	SI	CL	LL	PL	PL	WC	ODOT CLASS (G)	
5.0" TOPSOIL (DRILLERS DESCRIPTION) STIFF TO VERY STIFF, BROWN AND DARK BROWN, CLAY, SOME SILT, LITTLE SAND, TRACE GRAVEL, CONTAINS ROOTS, SLIGHTLY ORGANIC, DAMP (FILL) @2.0'-4.0': AN ADDITIONAL ST-2 WAS COLLECTED FROM AN OFFSET BORING TO PERFORM CONSOLIDATION TESTING. FULL CLASSIFICATION RESULTS PROVIDED IN THE CONSOLIDATION REPORT ARE FROM THE OFFSET ST-2.		2	2	6	44	1.50	-	-	-	-	-	-	-	-	22	A-7-6 (V)
		3			65	2.75	-	-	-	-	-	-	-	-	25	A-7-6 (V)
MEDIUM DENSE TO DENSE, BROWN, GRAVEL AND STONE FRAGMENTS SOME SAND, TRACE SILT, TRACE CLAY, DAMP		8	6	18	28	-	66	18	5	9	2	NP	NP	4	A-1-a (0)	
		11	9	31	44	-	-	-	-	-	-	-	-	4	A-1-a (V)	
MEDIUM DENSE, BROWN, GRAVEL WITH SAND TRACE SILT, TRACE CLAY, DAMP		9	15	45	44	-	-	-	-	-	-	-	-	4	A-1-a (V)	
		16	8	25	56	-	41	27	23	8	1	NP	NP	4	A-1-b (0)	
MEDIUM DENSE, BROWN, COARSE AND FINE SAND LITTLE GRAVEL, TRACE SILT, TRACE CLAY, DAMP		6	10	27	61	-	-	-	-	-	-	-	-	4	A-1-b (V)	
		5	6	15	61	-	-	-	-	-	-	-	-	5	A-3a (V)	
SS-11 BECOMES WET		5	6	21	72	-	11	32	44	10	3	NP	NP	6	A-3a (0)	
		6	7	19	67	-	-	-	-	-	-	-	-	16	A-3a (V)	
DENSE, BROWN, GRAVEL WITH SAND TRACE SILT, TRACE CLAY, WET		8	16	42	67	-	-	-	-	-	-	-	-	14	A-1-b (V)	
		6	9	33	78	-	-	-	-	-	-	-	-	10	A-1-b (V)	

STANDARD ODOT SOIL BORING LOG (1' X 17') - OH DOT.GDT - 3/28/25 15:40 - X:\ACTIVE PROJECTS\ACTIVE SOIL PROJECTS\GRE-68-12.65\GINT FILES\GRE-68-12.65.GPJ

NOTES: GROUNDWATER ENCOUNTERED AT 25.0' DURING DRILLING. HOLE DID NOT CAVE. DRILLED AS STAKED.  
 ABANDONMENT METHODS, MATERIALS, QUANTITIES: POURED 1.0 BAG HOLE PLUG; SHOVELED SOIL CUTTINGS

DESIGN AGENCY  
  
 2800 CORPORATE EXCHANGE DR, SUITE 240 COLUMBUS, OH, 43231  
 TEL: 614.714.0299 WWW.NEASINC.COM

DESIGNER: AS  
 REVIEWER: BPA 03/31/25

PROJECT ID: 115388  
 SUBSET: 13 TOTAL: 15  
 SHEET: P.105 TOTAL: 107

**GEOTECHNICAL PROFILE - BRIDGE  
 PEDESTRIAN BRIDGE OVER US 68 AND OLDTOWN CREEK  
 BORING LOG B-001-3-24**




**GRE-68-12.65**

MODEL SHEET PAPER SIZE: 17x11 (in.) DATE: 3/31/2025 TIME: 2:51:50 PM USER: Rsofflknacs  
 P:\OHDOT\_v3\Worksets\115388\400-Engineering\Geotechnical\Sheets\115388\_ZL009.dgn

PROJECT: GRE-68-12.65	DRILLING FIRM / OPERATOR: NEAS INC. / J/L	STATION / OFFSET: 8+29.9' RT.	EXPLORATION ID
TYPE: SCOUR	SAMPLING FIRM / LOGGER: NEAS INC. / J/L	ALIGNMENT: SHARED USE PATH	B-003-1-24
PID: 115388_SFN:	DRILLING METHOD: 3.25" HSA	ELEVATION: 826.7 (MSL) EOB: 10.0 ft.	PAGE
START: 11/25/24 END: 11/25/24	SAMPLING METHOD: SPT	LAT / LONG: 39.729585, -83.935761	1 OF 1
DRILL RIG: CME 55TB HAMMER: CME AUTOMATIC CALIBRATION DATE: 7/30/24 ENERGY RATIO (%): 89		GRADATION (%) GR CS FS SI CL LL PL WC	
MATERIAL DESCRIPTION AND NOTES		SPT / RQD N <sub>60</sub> REC SAMPLE ID HP (tsf) GR	
5.0" TOPSOIL (DRILLERS DESCRIPTION) STIFF DARK BROWN, SILT AND CLAY, SOME SAND, TRACE GRAVEL, MOIST (FILL)		SPT / RQD N <sub>60</sub> REC SAMPLE ID HP (tsf) GR	
HARD BROWN SILT AND CLAY, "AND" SAND, LITTLE GRAVEL, DAMP (FILL)		SPT / RQD N <sub>60</sub> REC SAMPLE ID HP (tsf) GR	
STIFF DARK BROWN, SILT AND CLAY, SOME SAND, TRACE GRAVEL, CONTAINS TRACE COAL FRAGMENTS, DAMP (FILL)		SPT / RQD N <sub>60</sub> REC SAMPLE ID HP (tsf) GR	
VERY STIFF BROWN, SANDY SILT, SOME CLAY, TRACE GRAVEL, DAMP		SPT / RQD N <sub>60</sub> REC SAMPLE ID HP (tsf) GR	
DENSE BROWN, GRAVEL WITH SAND AND SILT, TRACE CLAY, DAMP		SPT / RQD N <sub>60</sub> REC SAMPLE ID HP (tsf) GR	

ELEV.	DEPTHS	SPT / RQD	N <sub>60</sub>	REC SAMPLE ID	HP (tsf)	GR	CS	FS	SI	CL	LL	PL	WC	ODOT CLASS (G)	BACK FILL
826.7	1	3	9	SS-1	1.50	2	3	18	53	24	36	22	14	25	A-6a (10)
824.2	2	4	16	SS-2	4.50	12	13	25	29	21	35	20	15	14	A-6a (5)
822.7	3	4	30	SS-3	1.50	4	8	20	44	24	36	21	15	21	A-6a (9)
821.2	4	4	49	SS-4	3.00	-	-	-	-	-	-	-	-	18	A-4a (V)
819.7	5	5	42	SS-5	-	31	19	16	25	9	NP	NP	NP	11	A-2-4 (0)
816.7	6	13	40	SS-6	-	-	-	-	-	-	-	-	-	9	A-2-4 (V)
	7	14													
	8	18													
	9	14													
	10	14													
	EOB														

NOTES: GROUNDWATER NOT ENCOUNTERED DURING DRILLING. HOLE DID NOT CAVE. DRILLED AS STAKED.  
 ABANDONMENT METHODS, MATERIALS, QUANTITIES: SHOVELED SOIL CUTTINGS

DESIGN AGENCY  
  
 2800 CORPORATE EXCHANGE DR, SUITE 240 COLUMBUS, OH, 43231  
 TEL: 614.714.0299 WWW.NEASINC.COM

DESIGNER: AS  
 REVIEWER: BPA 03/31/25  
 PROJECT ID: 115388  
 SUBSET TOTAL: 15 / 15  
 SHEET TOTAL: P.107 / 107

GEOTECHNICAL PROFILE - BRIDGE  
 PEDESTRIAN BRIDGE OVER US 68 AND OLDTOWN CREEK  
 BORING LOG B-003-1-24