


SLM 11.12, 48"  
 SEE SHEET 287  
 AND 288

SLM 11.13, 48"  
 SEE SHEET 288

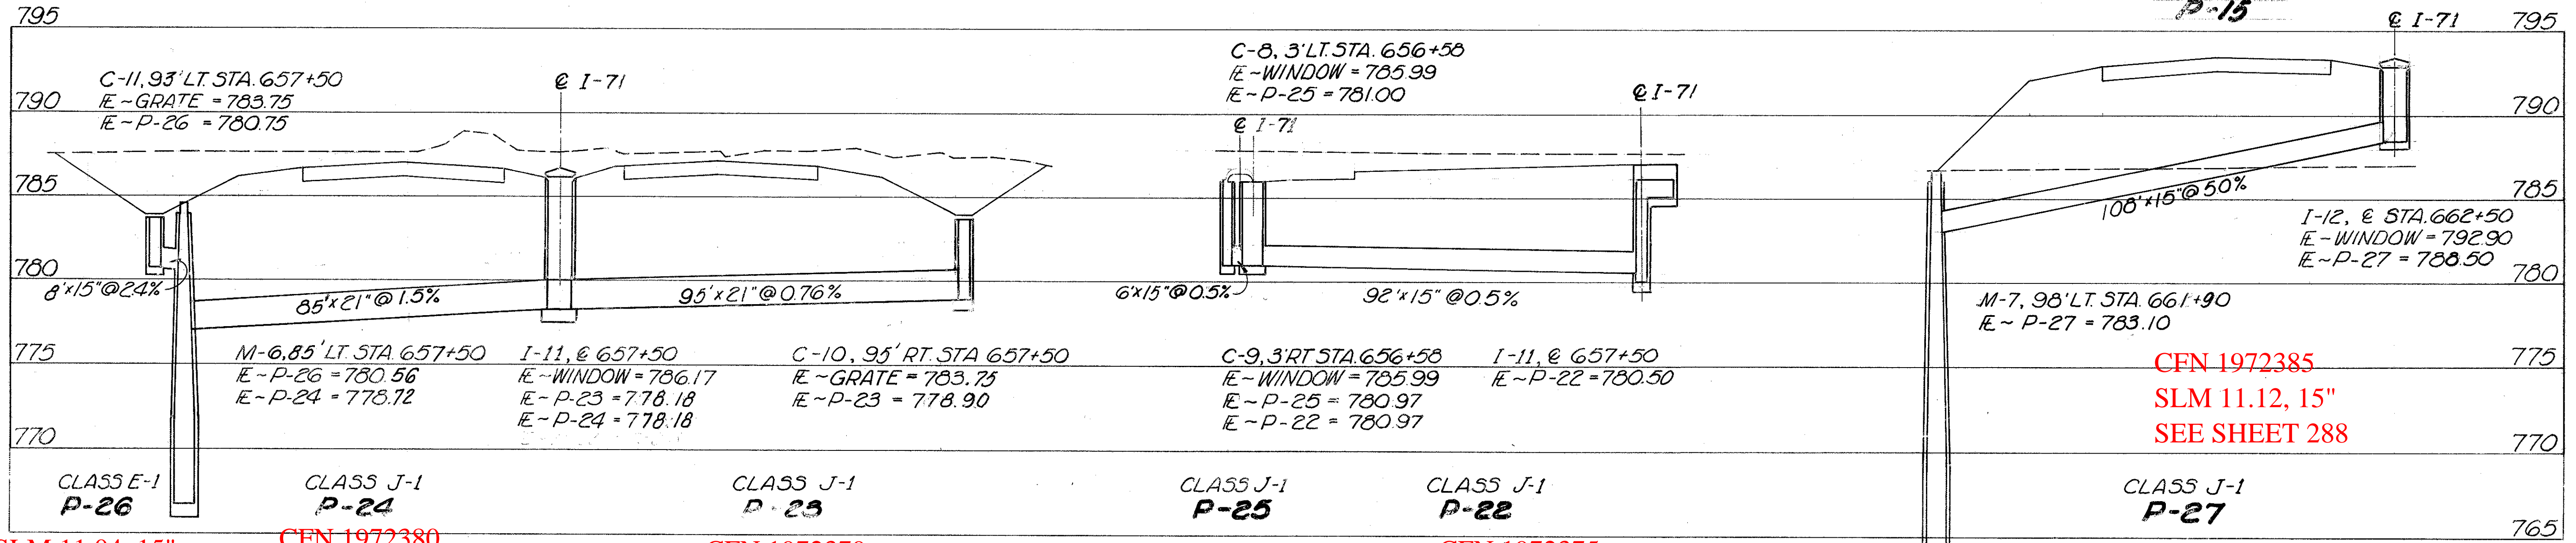

SLM 11.04, 15"  
 SEE SHEET 287

CFN 1972380  
 SLM 11.04, 21"  
 SEE SHEET 287

CFN 1972379  
 SLM 11.04, 21"  
 SEE SHEET 287

SLM 11.04, 15"  
 SEE SHEET 287

CFN 1972375  
 SLM 11.04, 15"  
 SEE SHEET 287

PIPE REFERENCE	STRUCTURES INCLUDED	ESTIMATED QUANTITIES										SEE SHEET NO.		
		CLASS E-1		CLASS J-1		CLASS J-1		CLASS J-1		CLASS J-1				
		15"	48"	15"	21"	15"	21"	15"	21"	15"	21"			
P-14	M-6		440											
P-15	M-7		70											
P-22	C-9				92									
P-23	C-10				95									
P-24	I-11				85									
P-25	C-8				6									
P-26	C-11	8												
P-27	I-12				108									
TOTALS		8	510	206	180			2	2	1	1	2		

FOR DRAINAGE PLAN-  
 SEE SHEET NOS 287 & 288