

CONVENTIONAL SIGNS

UTILITY POLES	Ø
CENTERLINE	—
FENCE	—
GUARD RAIL (EXISTING)	—
GUARD RAIL (PROPOSED)	—
RAILROAD	—
TREES & STUMPS (TO BE REMOVED)	⊗
TREES & STUMPS (EXISTING & TO REMAIN)	⊙
PROPERTY LINE	—
PROPERTY LINE—SAME OWNER	—
CONTIGUOUS PARCELS OF LAND	—
EXISTING RIGHT OF WAY	EXIST R/W
LIMITED ACCESS RIGHT OF WAY ONLY	LA
RIGHT OF WAY ONLY	R/W
SUBDIVISION LINE	—
ORIGINAL LOT LINE	—

INDEX

TITLE PAGE	1	WOOSTER ROAD PAVEMENT DETAILS	29
SCHEMATIC PLAN	2	WOOSTER ROAD RUNAROUND	29A
CENTERLINE LOCATION PLAN & GEOMETRIC LAYOUT	3, 4	ROAD "Q" PROFILE & PAV'T DETAILS	30
TYPICAL SECTIONS	5, 6	PLAN & PROFILE & DETAILS	31-33
MISC. TYPICAL DETAILS	7	60" DIA. TUNNEL SEWER	31-33
GUARD RAIL DETAILS	7A-7B	SEWER PROFILES	34-39
GENERAL NOTES	8-10	DRAINAGE DETAILS	40-42
QUANTITY SUMMARY & CALCULATIONS	11	GRADING, DRAINAGE & CROSS SECTION KEY PLAN	43
GENERAL SUMMARY	12-14	NORTHWEST CROSS SECTIONS	44-55
HILLIARD BLVD. PLAN	15	RAMP "A" CROSS SECTIONS	56-57
NORTHWEST PLAN & PROFILE & DRAINAGE QUANTITIES	16, 17	RAMP "B" CROSS SECTIONS	58
NORTHWEST PLAN & PROFILE & DRAINAGE QUANTITIES	18, 19	HILLIARD BLVD. CROSS SECTIONS	59
NORTHWEST PLAN & PROFILE	20-22	ROAD "Q" CROSS SECTIONS	60
WOOSTER ROAD PLAN & PROFILE	23	WATERWORK PLANS	61-73, 73A, 74-78
RAMP "A" & "B" PROFILE	24	RETAINING WALLS	79-90
HILLIARD BLVD. PAVEMENT DETAILS	25	STRUCTURE NO. 1 90-0675	91-101
HILLIARD BLVD. WESTWAY DRIVE RAMP "A" & "B" PAV'T DETAILS	26	STRUCTURE NO. 1 90-0696	102-112
RAMP "A" PAVEMENT DETAILS	27	LIGHTING PLANS	113-120, 120A
RAMP "B" PAVEMENT DETAILS	28	DELETED NUMBERS	121-135
		RIGHT OF WAY PLANS & EXISTING UTILITIES	136-146

DESIGN DESIGNATION

CURRENT A.D.T.	50,000
DESIGN YEAR A.D.T.	95,196
D.H.V. TWO-WAY	6,378
D. (DIRECTIONAL DISTRIBUTION)	67%
T. (PERCENTAGE BUSES OR TRUCKS)	10%
V. (DESIGN SPEED)	40 MPH


STATE OF OHIO
DEPARTMENT OF HIGHWAYS

CUY-90-6.62

CITY OF ROCKY RIVER


CUYAHOGA COUNTY

CUY-90-6.80 RIGHT OF WAY ONLY

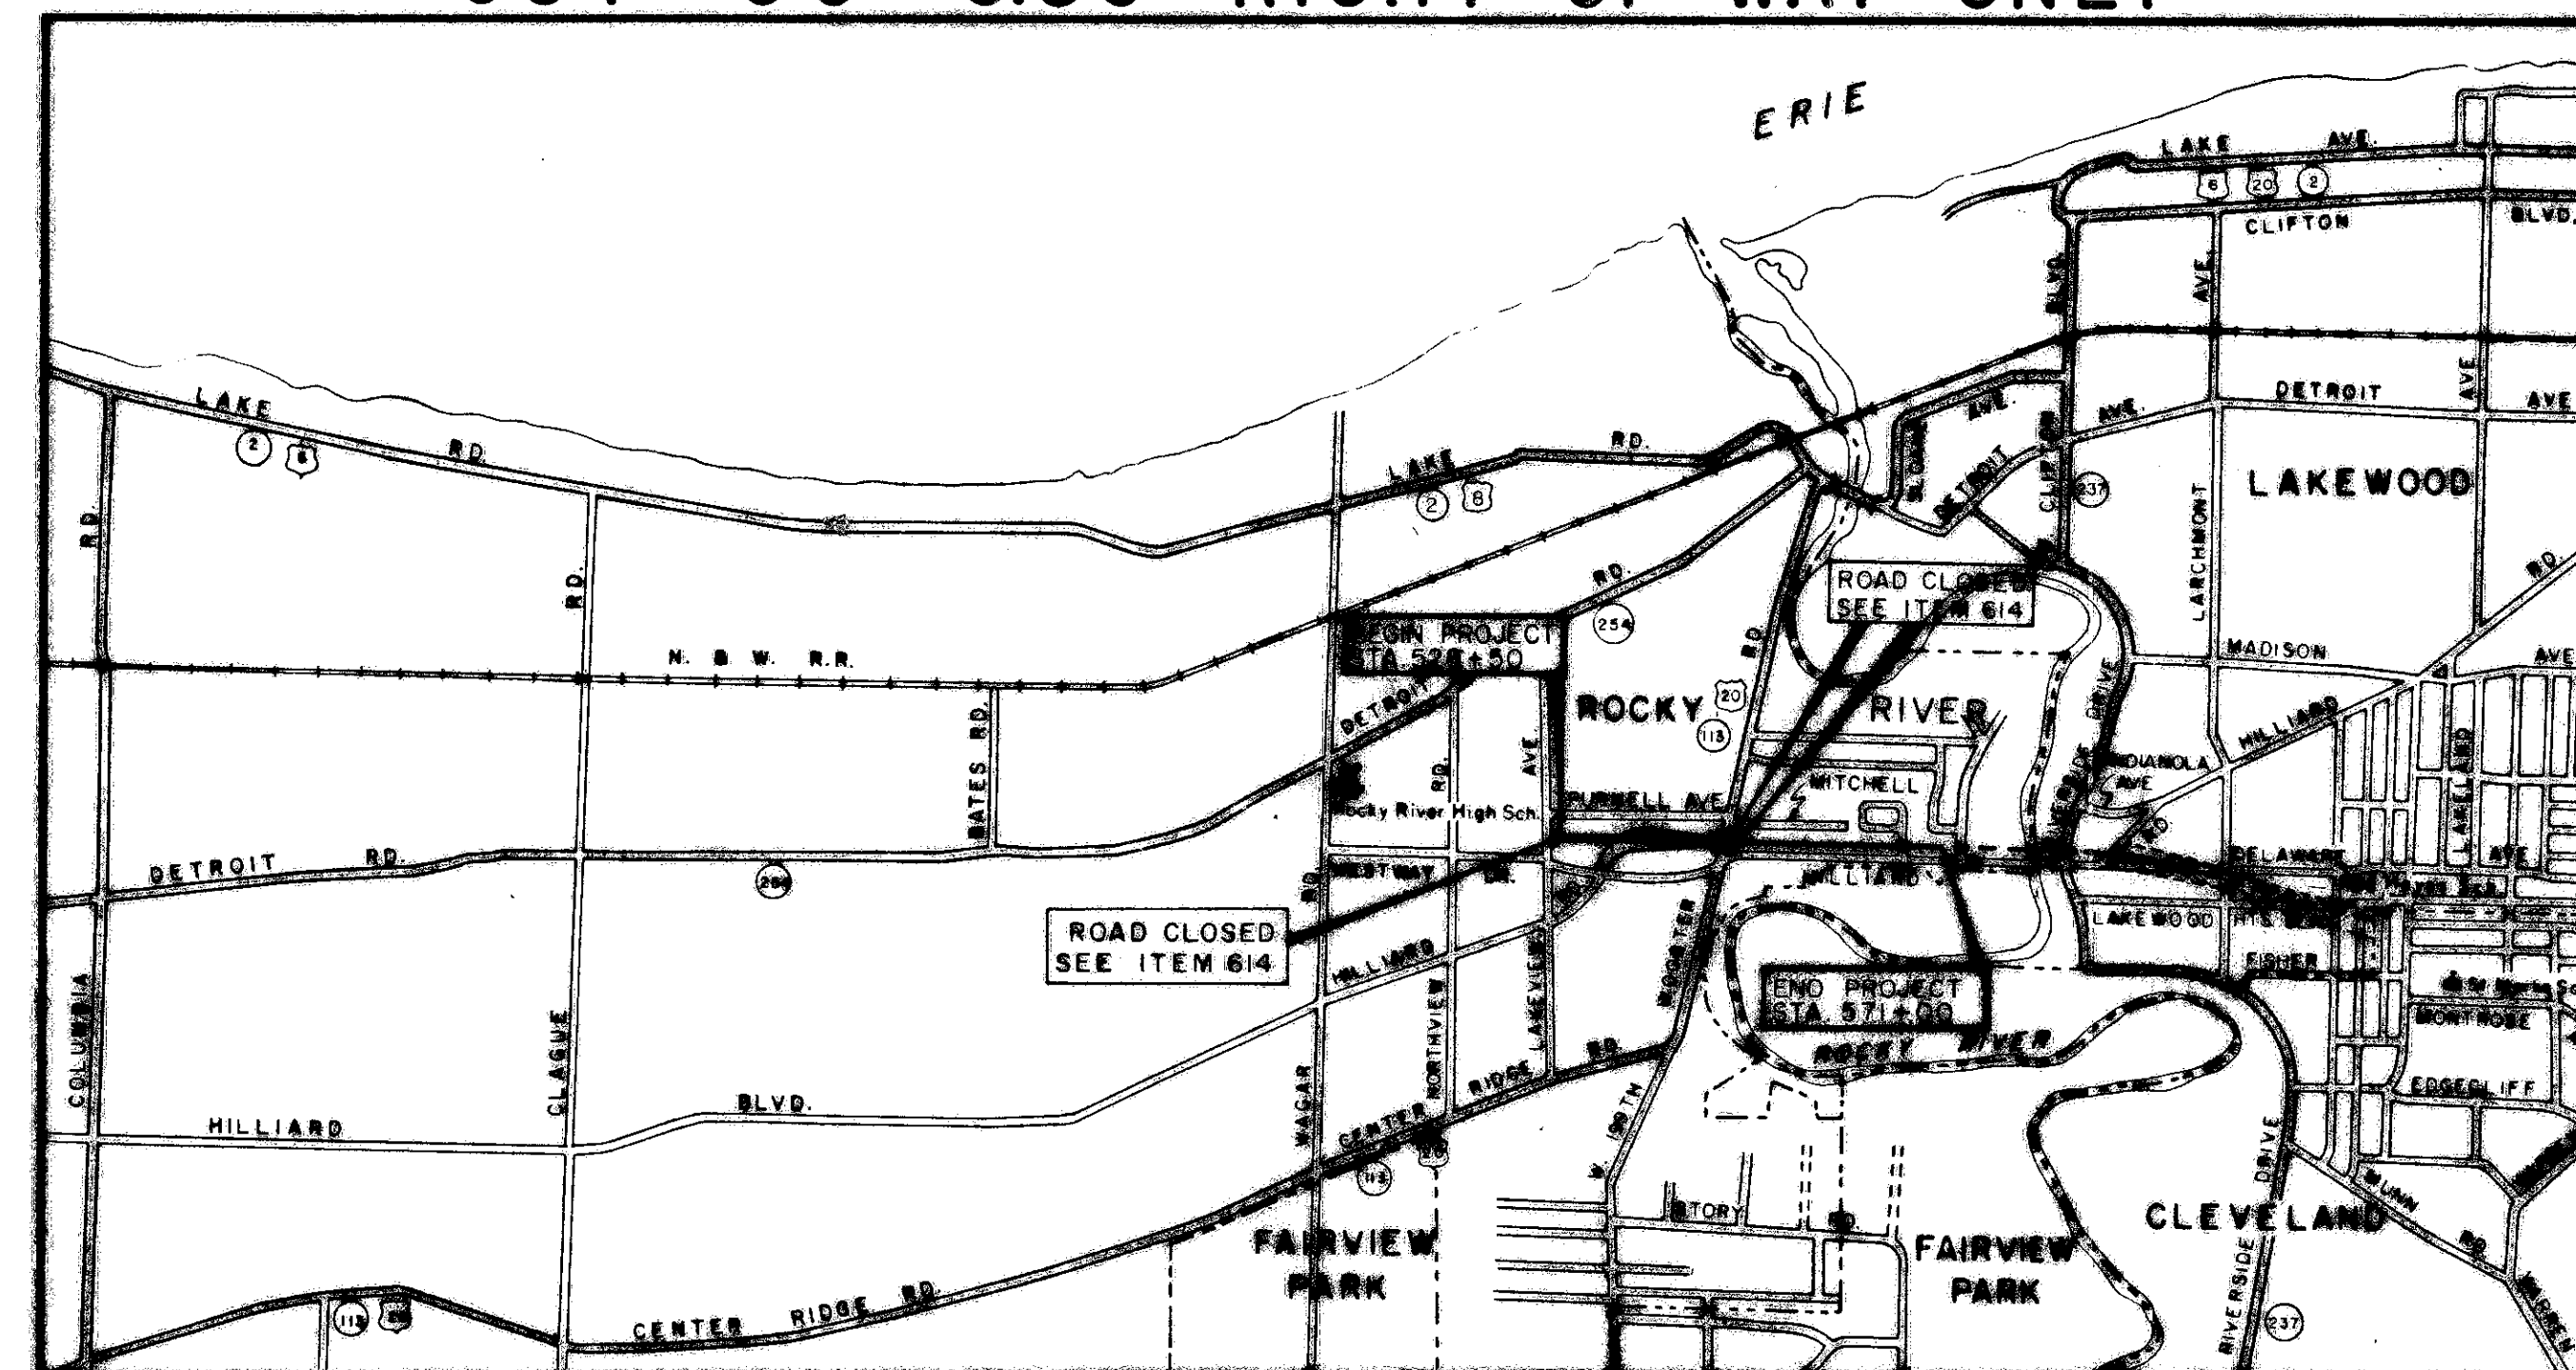

LOCATION MAP

Portion to be improved
Federal Roads
State Roads
Other Roads & Streets

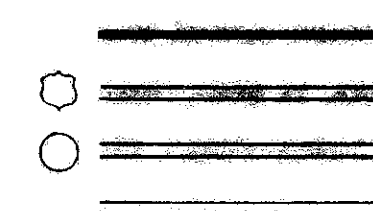

SCALE

Plan	1" = 50'	
Profile: Horizontal	1" = 50'	Unless
Profile: Vertical	1" = 10'	Noted
Cross Sections	1" = 10'	
Others	As Noted	

FED. DIVISION	STATE	PROJECT	
2	OHIO	I-90-1(70)16	

CUYAHOGA COUNTY
CUY-90-6.62
CUY-90-6.80 R/W ONLY
I-90-1(47) R/W ONLY

136
146

Plans prepared by:

TRYGVE HOFF & ASSOCIATES

1922 EAST 107TH STREET ENGINEERS CLEVELAND, OHIO

PRESIDENT CHIEF ENGINEER

PROJECT ENGINEER

1967 SPECIFICATIONS

LIMITED ACCESS

This improvement is especially designed for through traffic and has been declared a limited access highway or freeway by action of the Director of Highways in accordance with the provisions of Section 5511.02 of the Revised Code of Ohio.

The standard specifications of the State of Ohio, Department of Highways, including changes and supplemental specifications listed in the proposal shall govern this improvement.

The right of way for this improvement will be provided by the State of Ohio.

I hereby approve these plans and declare that the making of this improvement will not require the closing of the highway to traffic, and that provisions for the maintenance and safety of traffic will be as set forth on the plans and estimates.


File No.	CUYAHOGA COUNTY	CUY-90-6.62
Date of Letting		19
Contract No.		

FED. RD. DIVISION	STATE	PROJECT	
2	OHIO	1-90-(70)16	

139
146

CUYAHOGA COUNTY
CUY-90-6.62
1-90-1(47) R/W ONLY
CUY-90-6.80 R/W ONLY

1
8

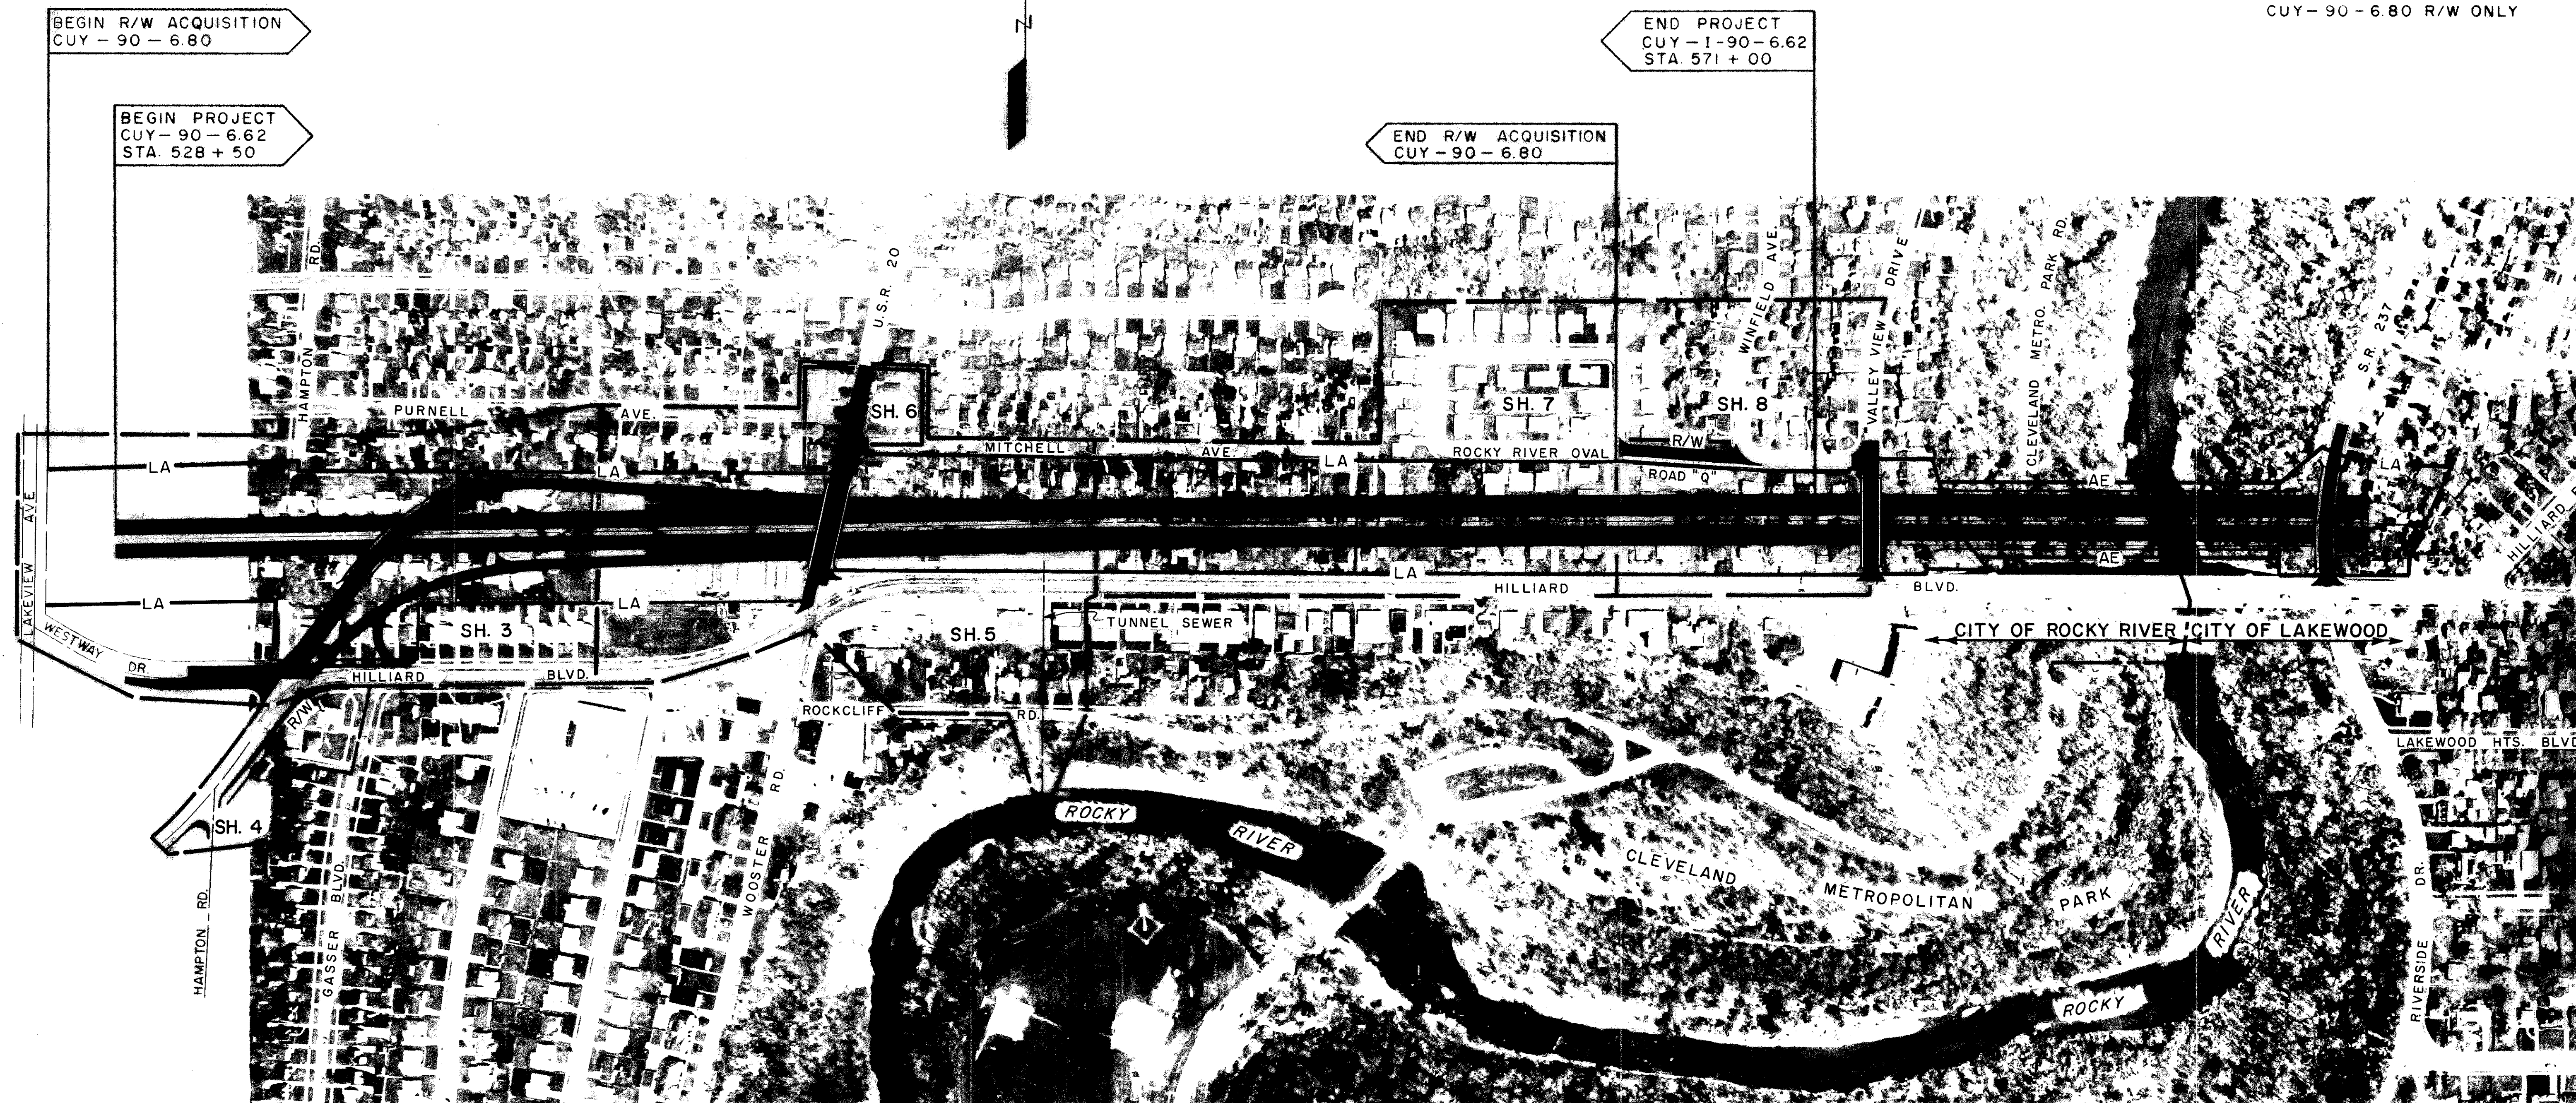

AERIAL PHOTOGRAPHY DATE MAY-1963

200 100 0 200 400 600 800 FEET

SCALE: 1" = 200'

TRYGVE HOFF & ASSOCIATES ENGINEERS 1922 EAST 107TH STREET CLEVELAND, OHIO 44106					
NORTHWEST FREEWAY SCHEMATIC PLAN					
ROCKY RIVER CUYAHOGA COUNTY - OHIO					
SCALE 1" = 200'			DATE		
DESIGNED	DRAWN	TRACED	CHECKED	REVIEWED	DATE
R.L.H.	L.K.H.		FT	T.L.L.	3/11/68

1029

SUMMARY OF ADDITIONAL RIGHT OF WAY REQUIRED

TOTAL NUMBER OF OWNERS 112

TOTAL NUMBER OF OWNERS W/STRUCTURES TO BE REMOVED 89

FED. RD. DIVISION	STATE	PROJECT
2	OHIO	I-90-1(70)16

140
146CUYAHOGA COUNTY
CUY- I-90-6.62
I-90-1(47) RIGHT OF WAY ONLY
CUY-90-6.80 R/W ONLY2
8

PARCEL NO.	OWNER	TYPE FUNDS	DEED RECORD TO BE ACQUIRED				SHEET NO	TOTAL	RESIDUE		REMARKS
			BOOK NO.	PAGE NO.	LAND SQ. FT.	BLDG.		AREA Sq. Ft.	Left of & Sq. Ft.	Right of & Sq. Ft.	
2000 WL	MILDRED C. HOLLIDAY	Inter-state	9762	163	8,458	YES	3	8,458	NO	NO	
2001 WL	ALBERT C. & BETTY S. BONDS	"	8267	341	8,500	"	"	8,500	"	"	
2002 WL	RUTH G. HOOD	"	6487	485	8,500	"	"	8,500	"	"	
2003 WL	CARL A. & M. E. REUSSER	Inter-state & State	9959	119	10,476	"	"	10,476	"	"	Interstate Fund 8830 S.F. State 1646 SF
2004 WL	JOHN T. & MARY C. JUNG	"	8807	261	10,770	"	"	10,770	"	"	" 9184 S.F. " 1586 SF
2005 WL	JAMES C. & IDA G. MORRIS	"	10700	247	10,972	"	"	10,972	"	"	" 9206 S.F. " 1586 SF
2006 WL	WILLARD E. & M. J. ANDERSON	"	10335	512	11,174	"	"	11,174	"	"	" 9588 S.F. " 1586 SF
2007 WL	RUSSEL L. & D. J. FAIST	"	8636	612	11,376	"	"	11,376	"	"	" 9790 S.F. " 1586 SF
2008 WL	LILLIAN R. PAMPUSH	"	8880	361	11,578	"	"	11,578	"	"	" 9992 S.F. " 1586 SF
2009 WL	MILDRED N. COOK	Inter-state	10152	303	11,450	"	"	11,450	"	"	
2010 WL	JACK J. & E. B. ROWE	"	10613	601	10,062	"	"	10,062	"	"	
2011 WL	FRANK C. & M. B. LYNCH, JR.	"	8856	396	10,041	"	"	10,041	"	"	
2012 WL	HELEN A. GNANDT	"	8839	182	10,019	"	"	10,019	"	"	
2013 WL	WM. J. & M. N. BADER	"	6895	543	9,998	"	"	9,998	"	"	
2014 WL	WM. J. FERRY	"	8605	37	9,976	"	"	9,976	"	"	
2015 WL	JEAN M. & F. W. SIMMELINK	"	9701	74	9,955	"	"	9,955	"	"	
2016 WL	FRANK & E. J. GIBBONS	"	9767	440	9,081	"	"	9,081	"	"	
2017 WL	WM. J. & MELBA M. GUIST	"	8808	567	11,672	"	"	11,672	"	"	
2018 WL	LENNART J. & D. E. CARLSON	"	10190	679	19,601	"	"	19,601	"	"	
2019 WL	M. M. McFADDEN	"	9784	283	19,704	"	"	19,704	"	"	
2020 WL	ALEX J. JR. & P. N. GILLESPIE	"	9051	634	11,461	"	"	11,461	"	"	
2021 WL	RUSSELL F. & D. J. PIERCE	"	9754	643	9,004	"	"	9,004	"	"	
2022 WL	WILLIAM R. & M. M. LAMPE	"	9021	411	9,892	"	"	9,892	"	"	
2023 WL	GEO. C. & L. K. WEAVER	"	8824	401	9,928	"	"	9,928	"	"	
2024 WL	EDW. G. JR. & M. D. LAWLOR	"	8673	721	9,965	"	"	9,965	"	"	
2025 WL	EUGENE & A. M. MYERS	"	8637	126	10,001	"	"	10,001	"	"	
2026 WL	RALPH T. & J. P. HANDY	"	8825	371	10,037	"	"	10,037	"	"	
2027 WL	FRANCIS P. & M. L. G. SMITH	"	8616	416	10,073	"	"	10,073	"	"	
2028 WL	MARY M. NIEDERST	"	9409	464	10,904	"	"	10,904	"	"	
2029 WL	ANNA R. STOCKHAUSEN	"	10671	247	9,352	"	"	9,352	"	"	
2030 WL	NORA E. CONNELLY	"	9761	499	9,566	"	"	9,566	"	"	
2031 WL	CHAS. B. & D. G. BALLOV	"	8656	705	9,779	"	"	9,779	"	"	
2032 WL	EARL L. & R. P. ARMSTRONG	"	8817	155	9,993	"	"	9,993	"	"	
2033 WL	WM. T. & V. P. CLAWSON	"	8674	331	9,912	"	"	9,912	"	"	
2034 WL	ROBERT L. & M. J. PRENDERGAST	"	10105	560	9,398	"	"	9,398	"	"	
2035 WL	HELEN E. & E. A. SOMMER	"	7811	677	8,500	"	"	8,500	"	"	
2036 WL	RAYMOND E. & J. H. DAUBER	"	10163	278	8,500	"	"	8,500	"	"	
2037 WL	H. WEMMER	"	6492	579 & 71	8,500	"	"	8,500	"	"	
2038 WL	PAULINE W. THUMM	"	7644	299	7,895	"	"	7,895	"	"	
2039 WL	IMO V. BEAM	"	10649	721	7,000	"	"	7,000	"	"	
2040 WL	ROBERT W. JR. & L. G. FLEMING	"	10174	468	7,000	"	"	7,000	"	"	
2041 WL	BLANCH BERGEN	"	8204	348	7,000	"	"	7,000	"	"	
2042 WL	ELEANORE & EVELYN KOSMAN	"	8222	335	7,000	"	"	7,000	"	"	
2043 WL	JEAN M. MOONEY	"	8878	669	7,000	"	"	7,000	"	"	
2044 WL	MICH. N. & R. G. DANIS	"	8415	586	288	NO	"	7,000	"	6,712	
2053 LA	JANET H. SCHILDT	"	7095	177	---	"	"	7,403	"	7,403	LA Only
2070 T	HARRY A. & D. E. STAGER	"	9423	707	109	"	4	10,049	"	10,049	Grade Slope
2071 WD	MARIE MERTENS	"	7466	95	253	"	"	9,563	"	9,310	
2071 T	MARIE MERTENS	"	7466	95	699	"	"	9,563	"	---	Grade Slope
2072 WD	WM. S. & M. E. HAZZARD	"	8527	222	824	"	"	7,286	"	6,462	
2072 T	WM. S. & M. E. HAZZARD	"	"	"	1,375	"	"	7,286	"	---	Grade Slope
2073 WD	RITA M. WILBER	"	7814	37	1,289	"	"	7,070	"	5,781	
2073 T	RITA M. WILBER	"	7814	37	2,006	"	"	7,070	"	---	Grade Slope, Reshape Drive
2076 WD	S. JOHN & J. S. VAN UUM	"	9736	516	295	"	"	8,825	"	8,530	
2076 T	S. JOHN & J. S. VAN UUM	"	9736	516	1,494	"	"	---	"	---	Grade Slope, Reshape Drive
2085 T	WILBUR C. & G. L. HOLL	"	9024	365	177	"	"	6,152	"	6,152	Grade Slope
2100 WL	LAURA CHRISTENSEN	Inter-state	10925	301	185,466	YES	5	185,466	NO	NO	Exclusive of 9,878 sq. ft. P. R. O.
2101 WL	RICHARD B. & NOREEN J. COLBRUNN	"	6082	733	8,360	"	"	8,360	"	"	
2102 WL	JOSEPH J. RIETH	"	10153	205	16,363	"	"	16,363	"	"	
2103 WL	LEROY C. & J. C. RAY	"	9929	531	9,750	"	"	9,750	"	"	
2104 WL	ELLA M. JAMES	"	6697	396	8,125	"	"	8,125	"	"	Also V - 4318, P - 99
2105 WL	JOHN REBICH ET AL	"	9748	124	8,125	"	"	8,125	"	"	
2106 WL	ELIZABETH C. GAGE	"	10687	207	8,125	"	"	8,125	"	"	
2107 WL	HERBERT L. & B. A. DIRKS	"	10677	527	8,125	"	"	8,125	"	"	
2108 WL	EDW. F. & MARIE A. CAUGHLIN	"	7419	127	8,125	"	"	8,125	"	"	
2109 WL	HARRY R. REARDON	"	4804	466	8,125	"	"	8,125	"	"	
2110 WL	ORVILLE E. & E. K. PUGSLEY	"	9724	4	8,125	"	"	8,125	"	"	
2111 WL	IRWIN L. & LOIS M. CARSON	"	5284	122	8,125	"	"	8,125	"	"	
2112A WL	WM. J. & M. E. DAUGHERTY	"	9915	216	9,634	"	"	9,634	"	"	Also Owner of Parcels 2112B WL, 2216 WL
2112B WL	WM. J. & M. E. DAUGHERTY	"	9915	216	10,776	NO	"	10,776	"	"	See Parcel 2112A WL
2113 WL	THOMAS E. ALLEN	"	10363	413	15,599	YES	"	15,599	"	"	
2114 WL	MARIE DUIGNAN	"	6413	137	4,492	"	"	4,492	"	"	
2115 WL	JAS. A. SMITH	"	8045	207	3,759	"	"	3,759	"	"	
2116 WL	SUN OIL COMPANY	"	5879	563	15,010	"	"	15,010	"	"	
2117 WD *	SEE NEXT COLUMN FOR ADDITIONAL PARCELS										
2200 WL	DOROTHY W. HAKER	Inter-state	10670	675	20,373	YES	7	20,373	NO	NO	Also V - 3174, P - 67 & V - 7854 P - 477
2201 WL	DORIS RUDY & WARREN R. RUDY	"	9425	29	8,125	"	"	8,125	"	"	
2202 WL	ORLANDO P. & B. V. MARTIN	"	8055	269	8,125	"	"	8,125	"	"	
2203 WL	CLARA M. HOOPER	"	10118	15	8,125	"	"	8,125	"	"	
2204 WL	ELSIE E. LATT	"	7229	253	8,125	"	"	8,125	"	"	
2205 WL	W. W. & L. F. NELSON	"	6009	126	16,250	"	"	16,250	"	"	
2206 WL	WM. D. TIBBETTS	"	8252	644	8,125	"	"	8,125	"	"	
2207 WL	CATH F. GREEN	"	7250	124	24,375	"	"	24,375	"	"	
2208 WL	RICHARD E. & VERA P. ROYS	"	5608	65	16,250	"	"	16,250	"	"	
2209 WL	FLOYD B. & MILDRED B. INGOLD	"	4975	510	8,125	"	"	8,125	"	"	

PARCEL NO.	OWNER	TYPE FUNDS	DEED RECORD			TO BE ACQUIRED	SHEET NO	TOTAL			RESIDUE		REMARKS
			BOOK NO.	PAGE NO.	LAND SQ. FT.			BLDG.	AREA SQ. FT	Left of & Sq. Ft.	Right of & Sq. Ft.		
2215 WL	CATHERINE BILSKI	Inter-state	9958	698	5,401	YES	7	5,401	NO	NO			
2216 WL	WM. J. & M. E. DAUGHERTY	"	9915	217	5,385	NO	"	5,385	"	"			Also Owner of Parcels 2112A & 2112B
2217 WL	ANTHONY & A. I. PIAZZA	"	10601	391	5,369	YES	"	5,369	"	"			
2218 WL	WANDA H. GATES	"	10647	161	10,691	NO	"	10,691	"	"			
2219 WL	BERNICE D. & H. J. VOLDRICH	"	10634	487	13,275	YES	"	13,275	"	"			
2220 WL	THE KAMMS CORNERS RHY CO.	"	10670	675	18,419	NO	"	18,419	"	"			Also V-7854, P-477.
2221 WL	JOHN W. & F. E. CORCORAN	"	8648	654	5,225	YES	"	5,225	"	"			
2222 WL	ERIEDA BLANK	"	6475	275	5,209	"	"	5,209	"	"			
2223 WL	FREDERICK H. & M. E. LINDEN	"	10321	399	5,182	"	"	5,182	"	"			
2224 WL	KAMMS CORNERS RT. W	"	7238	686	15,545	NO	"	15,545	"	"			
2225 WL	E. R. TAYLOR	"	6897	77	1,315	NO	"	1,315	"	"			
2226 WL	AGNES HOLMQUIST	"	9043	345	10,353	YES	"	10,353	"	"			
2227 WL	COLETTA SHAUGHNESSY	"	8432	619	8,843	"	"	8,843	"	"			
2228 WL	JANICE D. McVEY	"	8404	342	9,302	"	"	9,302	"	"			
2229 WL	CLARENCE A. & E. MOHNEY	"	8294	332	9,298	"	"	9,298	"	"			
2230 WL	HERBERT R. & A. M. SIESEL	"	8414	664	9,294	"	"	9,294	"	"			
2231 WL	LILLIAN A. SHELTON & P. A. WARD	"	9746	177	9,072	"	"	9,072	"	"			
2232 WL	ISRAEL F. ROBERSON	"	8667	223	8,400	"	"	8,400	"	"			
2233 WL	SYLVESTER & J. COTTER	"	9452	521	8,314	"	"	8,314	"	"			
2234 WL	IRVING F. & ANNE C. TRUENDLAND	"	8696	65	9,170	"	"	9,170	"	"			
2235 WL	EARL T. & O. WOOD	"	9767	293	9,170	"	"	9,170	"	"			
2236 WL	RONALD C. & PAULINE N. DOANE	"	8814	303	9,206	"	"	9,206	"	"			
2237 WL	J. A. THORRAT	"	10625	37 & 38	33,120	"	"	33,120	"	"			
ADDITIONAL PARCELS													
*2117 WD	GUND REALTY COMPANY	Inter-state	10139	303	29	NO	5	8,028	NO	7,999			
2117 T	GUND REALTY COMPANY	"	10139	303	199	"	5	---	NO	---			Replacing Walk
2130 WD	MARVIN S. & Y. C. FREEMAN	"	10387	371	879	"	"	19,229	18,350	NO			
2130 T	MARVIN S. & Y. C. FREEMAN	"	10387	371	1,381	"	"	19,229	---	---			Grade Slope
2131 WD	JOHN F. & V. F. WOJS	"	10152	438	111	"	"	11,371	11,260	"			
2131 T	JOHN F. & V. F. WOJS	"	10152	438	1,402	"	"	11,371	---	---			Grade Slope
2133 WD	NELSON N. & A. B. ARD	Inter-state	6010	87	228	"	"	8,551	8,323	"			
2133 T	NELSON N. & A. B. ARD	"	6010	87	1,148	"	"	8,551	---	---			Grade Slope
2134 WD	N. JAMES MALTA, ET AL & LENA STALZER 1/2 INT.	{	9954	130	116	"	"	6,367	6,251	"			
2134 T	N. JAMES MALTA, ET AL & LENA STALZER 1/2 INT.		10335	613	790	"	"	6,367	---	---			Grade Slope, Reshape Drive
2135 WD	ELEANORE KOSMAN	"	9453	354	60	"	"	6,250	6,190	"			
2135 T	ELENORE KOSMAN	"	9453	354	692	"	"	6,250	---	---			Grade Slope, Reshape Drive
2136 WD	HENRY M. & R. G. WATKINS	"	9080	137	16	"	"	6,081	6,065	"			
2136 T	HENRY M. & R. G. WATKINS	"	9080	137	416	"	"	6,081	---	---			Grade Slope, Reshape Drive
2140 S	THE SMYTHE REALTY CO.	Inter-state	8436	149	27,880*	NO	5	16,263	NO	16,263			Underground Easement for 60" Diameter Tunnel Sewer
2141 S	RUTH D. DONNELLY	"	6093	737	43,980*	"	"	8,400	"	8,400			" " " " " "
2143 S	CLEVELAND METROPOLITAN PARK DISTRICT	"				"	"	very large	very large	very large			Easement for 60" Dia. Tunnel Sewer Owner same as #2400 In Project CITY-1-50-7-32
AUDITOR'S TAX MAP DATA:													
	Map No.	Page No.	Parcel No.										
2000 WL	301	28	67										
2001 WL	301	28	69										
2002 WL	301	28	65										
2035 WL	301	28	68										
2036 WL	301	28	66										
2037 WL	301	28	70										
2100 WL	304	18	43-46										
2224 WL	301	34	6										
2226 WL	301	34	7										
2237 WL	301	34	5,11,14										

UTILITY LEGEND
SEWER 12" S.W. 12" S.W.
GAS 12" S.W. 12" S.W.
WATER 12" S.W. 12" S.W.
CATCH BASINS 12" S.W. 12" S.W.
& CURB INLETS 12" S.W. 12" S.W.
HYDRANT 12" S.W. 12" S.W.
VALVE 12" S.W. 12" S.W.
WATER METER 12" S.W. 12" S.W.
POLES JOINTLY OWNED 12" S.W. 12" S.W.
BY C.E.I. & O.B.T. 12" S.W. 12" S.W.
POLES OWNED BY O.B.T. 12" S.W. 12" S.W.
POLES OWNED BY C.E.I. 12" S.W. 12" S.W.

ABBREVIATIONS
O.B.T. OHIO BELL TELEPHONE CO.
C.E.I. CLEVELAND ELECTRIC
ILLUMINATING CO.
S.C. SCREWED END (PIPE)
P.E. PLAIN END (PIPE)
H.P. HIGH PRESSURE
M.H. MANHOLE

LEGEND
ST. STORY
F OR FR. FRAME
BR. BRICK
BLK. CONCRETE BLOCK
DR. DRIVE
SWF. STEEL WIRE FENCE
SCL.F. STEEL CHAIN LINK FENCE
W.P.F. WOOD PICKET FENCE
W.R.F. WOOD RAIL FENCE
A.S. ASPHALT SIDING
C. CAR
G OR GAR. GARAGE - 2 C.G. (2 CAR GARAGE)
HOUSE NUMBER
CONC. CONCRETE
AL.S. ALUMINUM SIDING
W.S. WOOD SHINGLE SIDING
C.S. COMPOSITION SHINGLE SIDING
APT. APARTMENT
END POST
CORNER POST
LINE POST

NOTES
ALL CHAIN LINK FENCE GATES ARE 14' SWING TYPE.
FOR FENCE DETAILS SEE STANDARD CONSTRUCTION
DRAWING F-1.

AREA PARTICIPATION

PARCEL NO.	INTERSTATE FUND	STATE FUND	TOTAL
2003	8830 S.F.	1646 S.F.	10,476 S.F.
2004	9184 "	1586 "	10,770 "
2005	9206 "	1586 "	10,972 "
2006	9588 "	1586 "	11,174 "
2007	9790 "	1586 "	11,376 "
2008	9992 "	1586 "	11,578 "

CONVENTIONAL SIGNS
SECTION LINE
CENTER LINE OF ROAD
PROPERTY LINE
LIMITED ACCESS RIGHT OF WAY
RIGHT OF WAY LINE
FENCE LINE
SEWER EASEMENT LINE
TEMPORARY EASEMENT LINE
SLOPE LIMITS
EXISTING STREET RIGHT OF WAY
VOID PROPERTY LINE

QUANTITIES

DESCRIPTION	201 TRES REMOVED SIZE: 12"-24"	201 TRES REMOVED SIZE: 24"-36"	201 TRES REMOVED SIZE: 36"-48"	607 CHAIN LINK FENCE	607 CHAIN LINK FENCE GATE	201 STUMPS REMOVED SIZE: 12"-24"
R/W SHEET NUMBER 3	5			2412		
R/W SHEET NUMBER 4	1					
R/W SHEET NUMBER 5	31	12	3	2510		1
R/W SHEET NUMBER 7	48	6		2612	2	1
R/W SHEET NUMBER 8	4	1		963		
TOTALS	89	19	3	8497	2	2

FED. RD. DIVISION 2
STATE OHIO
PROJECT I-90-1(70)16
CUYAHOGA COUNTY
CUY-1-90-6.62
I-90-1(47) RIGHT OF WAY ONLY
ORIGINAL ROCKPORT TOWNSHIP
CITY OF ROCKY RIVER
SECTION 17


141
146
3
8

BEGIN R/W ACQUISITION
STA. 352 + 67.05
CUY-90-6.80
I-90-1(47)

BEGIN PROJECT CUY-1-90-6.62
I-90-1(70)16

MARY JANE PEASE SUBDIVISION
VOL. 39
PAGE 2
PARCEL NO. 11

SOLD
Vol. 97-03037
Pg. 15

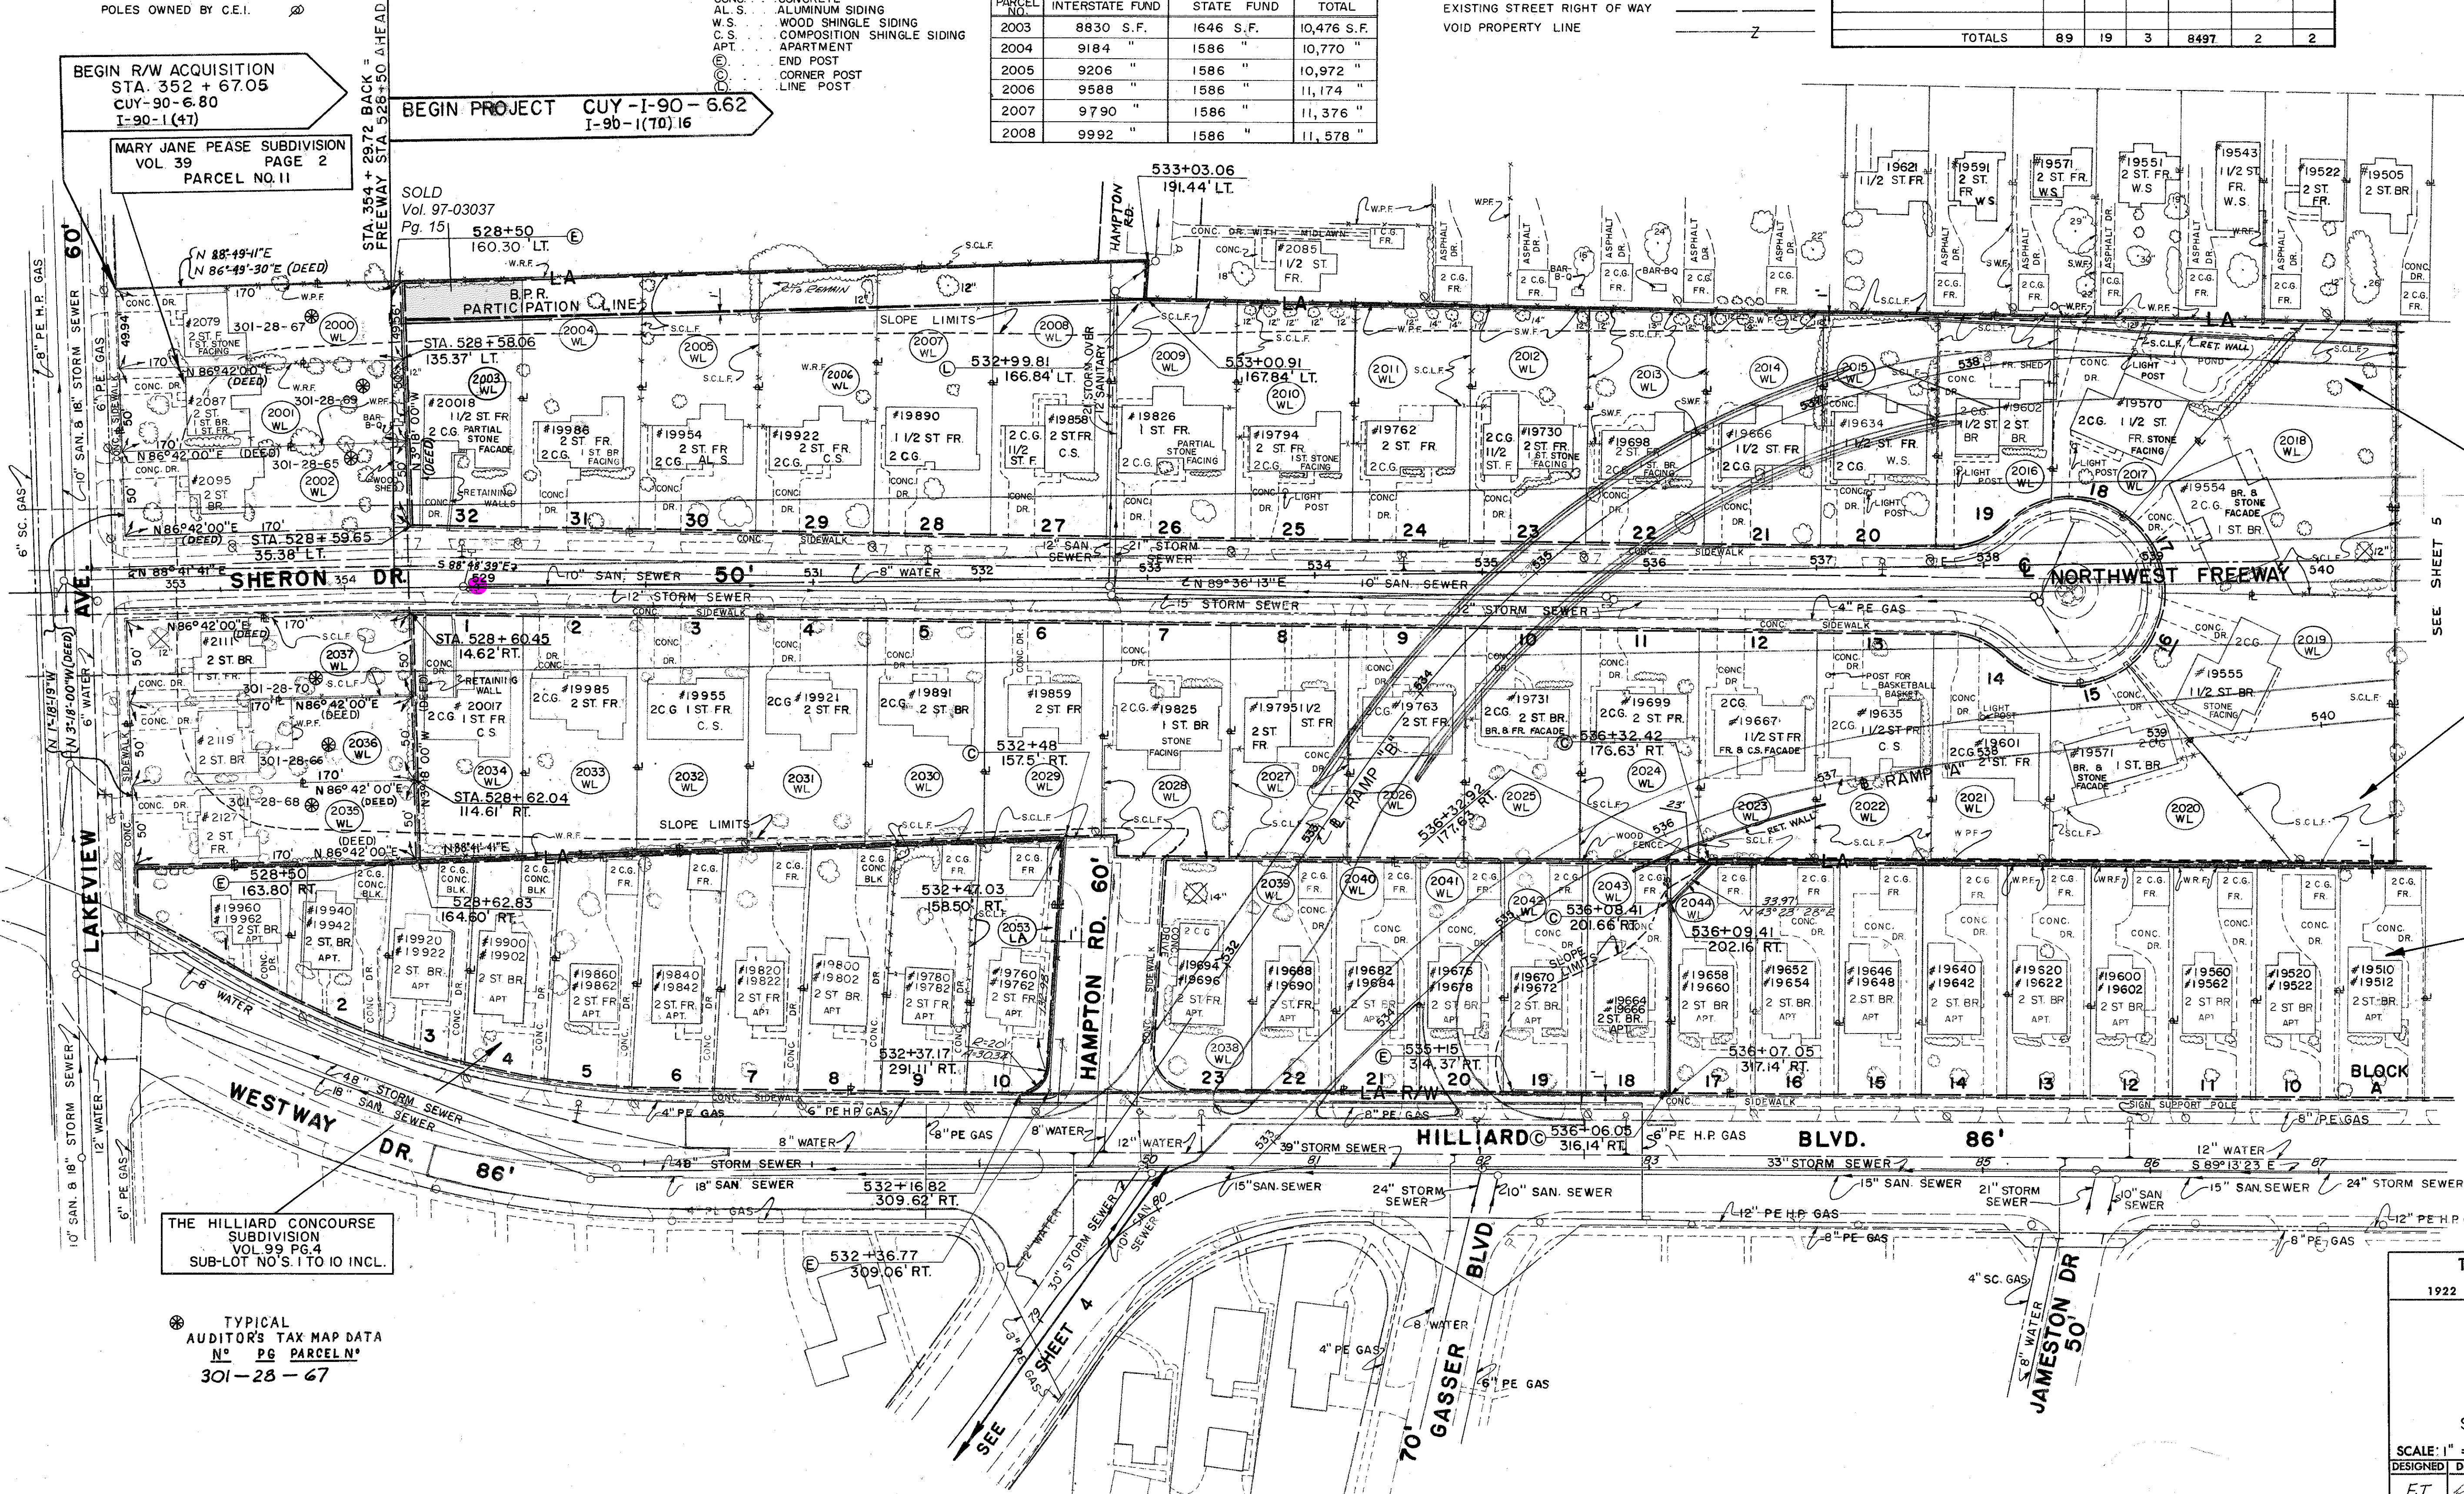

THE STRUHAR SUBDIVISION NO. 2
VOL. 160 PG. 5
SUB-LOT NO'S. 1 TO 32 INCL.

THE J. M. GASSER ESTATE
SUBDIVISION NO. 1
VOL. 97 PG. 40
SUB-LOT NO'S. 10 TO 23 INCL.
BLOCK A

THE HILLIARD CONCOURSE
SUBDIVISION
VOL. 99 PG. 4
SUB-LOT NO'S. 1 TO 10 INCL.

TYPICAL
AUDITOR'S TAX MAP DATA
N° PG PARCEL N°
301-28-67

TRYGVE HOFF & ASSOCIATES
ENGINEERS
1922 EAST 107TH STREET CLEVELAND, OHIO

R/W PLAN
PARCEL NUMBERS
SERIES 2000 - 2053
STA 528+50 TO STA. 540+50±

SCALE: 1" = 50'
DATE
DESIGNED DRAWN TRACED CHECKED REVIEWED DATE REVISED
F.T. J.H. J.H. F.T. J.H. 2-22-68

CONT. NO. 63032 SHEET ACCT. NO. 6100

THE RIVER-WOOD-PARK
SUBDIVISION
VOL. 83 PG. 38
SUB-LOT NO'S. 150 TO 163 INCL.

FED. RD. DIVISION	STATE	PROJECT
2	OHIO	I-90-1(70)16

143
146

CUYAHOGA COUNTY
CUY-1-90-6.62
I-90-1(47) RIGHT OF WAY ONLY
ORIGINAL ROCKPORT TOWNSHIP
CITY OF ROCKY RIVER
SECTION 17

5
8

NOTE:
FOR 20 SCALE DETAILS
OF PARCELS 2130, 2131
AND 2133 TO 2136 INCL.
SEE R/W SHEET 6.

THE MARK MITCHELL
WOOSTER ROAD SUBDIVISION
VOL. 33 PG. 22
SUB-LOT NO'S. 40 TO 51 INCL.
& NO'S. 1 TO 3 INCL.

PROPOSED BUSINESS PROPERTY
OF HILLIARD BLVD. FROM
WOOSTER ROAD EAST
VOL. 105 PG. 25
SUB-LOT NO'S. 1 TO 11 INCL.

THE J.M. GASSER ESTATES
SUBDIVISION NO. 1
VOL. 97 PG. 40
SUB-LOT NO'S. 1 TO 9 INCL.

NOTE:
FOR 20 SCALE DETAIL
OF PARCEL 2117 SEE
R/W SH. 6

STEIN-KENNEY ALLOTMENT
VOL. 73
PG. 13
SUB-LOT NO'S. 8 TO 10 INCL.

HILLIARD ROAD SUBDIVISION
OF GOLD COLONY REALTY CO.
VOL. 93 PG. 14
SUB-LOT NO'S. 42 TO 45 INCL.

ITEM 201 TREES & STUMPS REMOVED		
SIZE	NO. OF TREES	NO. OF STUMPS
12" - 24"	31	1
24" - 36"	12	3
TOTALS	43	4

NOTES

FOR FENCE CONNECTION TO BRIDGE SEE
"FENCE DETAIL" AND SECTION A-A, DWG. 29
TOTAL 2510 L.F. CHAIN LINK FENCE ON
THIS SHEET

FOR LEGENDS SEE SHEET 3

SEE "GENERAL NOTES", SHEET 8/146 FOR
NOTE - WORK WITHIN TEMPORARY
RIGHT OF WAY.

TRYGVE HOFF & ASSOCIATES
ENGINEERS
1922 EAST 107TH STREET CLEVELAND, OHIO

R/W PLAN
PARCEL NUMBERS
SERIES 2100 - 2143
STA. 540+50± TO STA. 553+20±

SCALE: 1" = 50'	DATE
DESIGNED	DATE
DRAWN	DATE
TRACED	DATE
CHECKED	DATE
REVIEWED	DATE
FT.	FT.

CONT. NO. 63032 SHEET ACCT. NO. 6101

FENCE DETAIL 'A'
(END POST ANCHOR ON ABUTMENT WALL)

TYPICAL AUDITOR'S TAX MAP
DATA
No. Pg. Parcel No.
304 - 18 - 46




1 NOV 21 1987 2 NOV 25 1988 123

THE RIVER- WOOD- PARK
SUBDIVISION
VOL. 83 PG. 38
SUBLOT NOS. 150 TO 154 INCL.

THE MARK MITCHELL
WOOSTER ROAD SUBDIVISION
VOL. 33 PG. 22
SUBLOT NOS. 1 TO 3 INCL.


THE J. M. GASSER ESTATES
SUBDIVISION No. 1
VOL. 97 PG. 40
SUBLOT NOS. 1 & 2

CUYAHOGA COUNTY
CUY- I-90-6.62
I-90-1(47) RIGHT OF WAY ONLY
ORIGINAL ROCKPORT TOWNSHIP
CITY OF ROCKY RIVER
SECTION 17

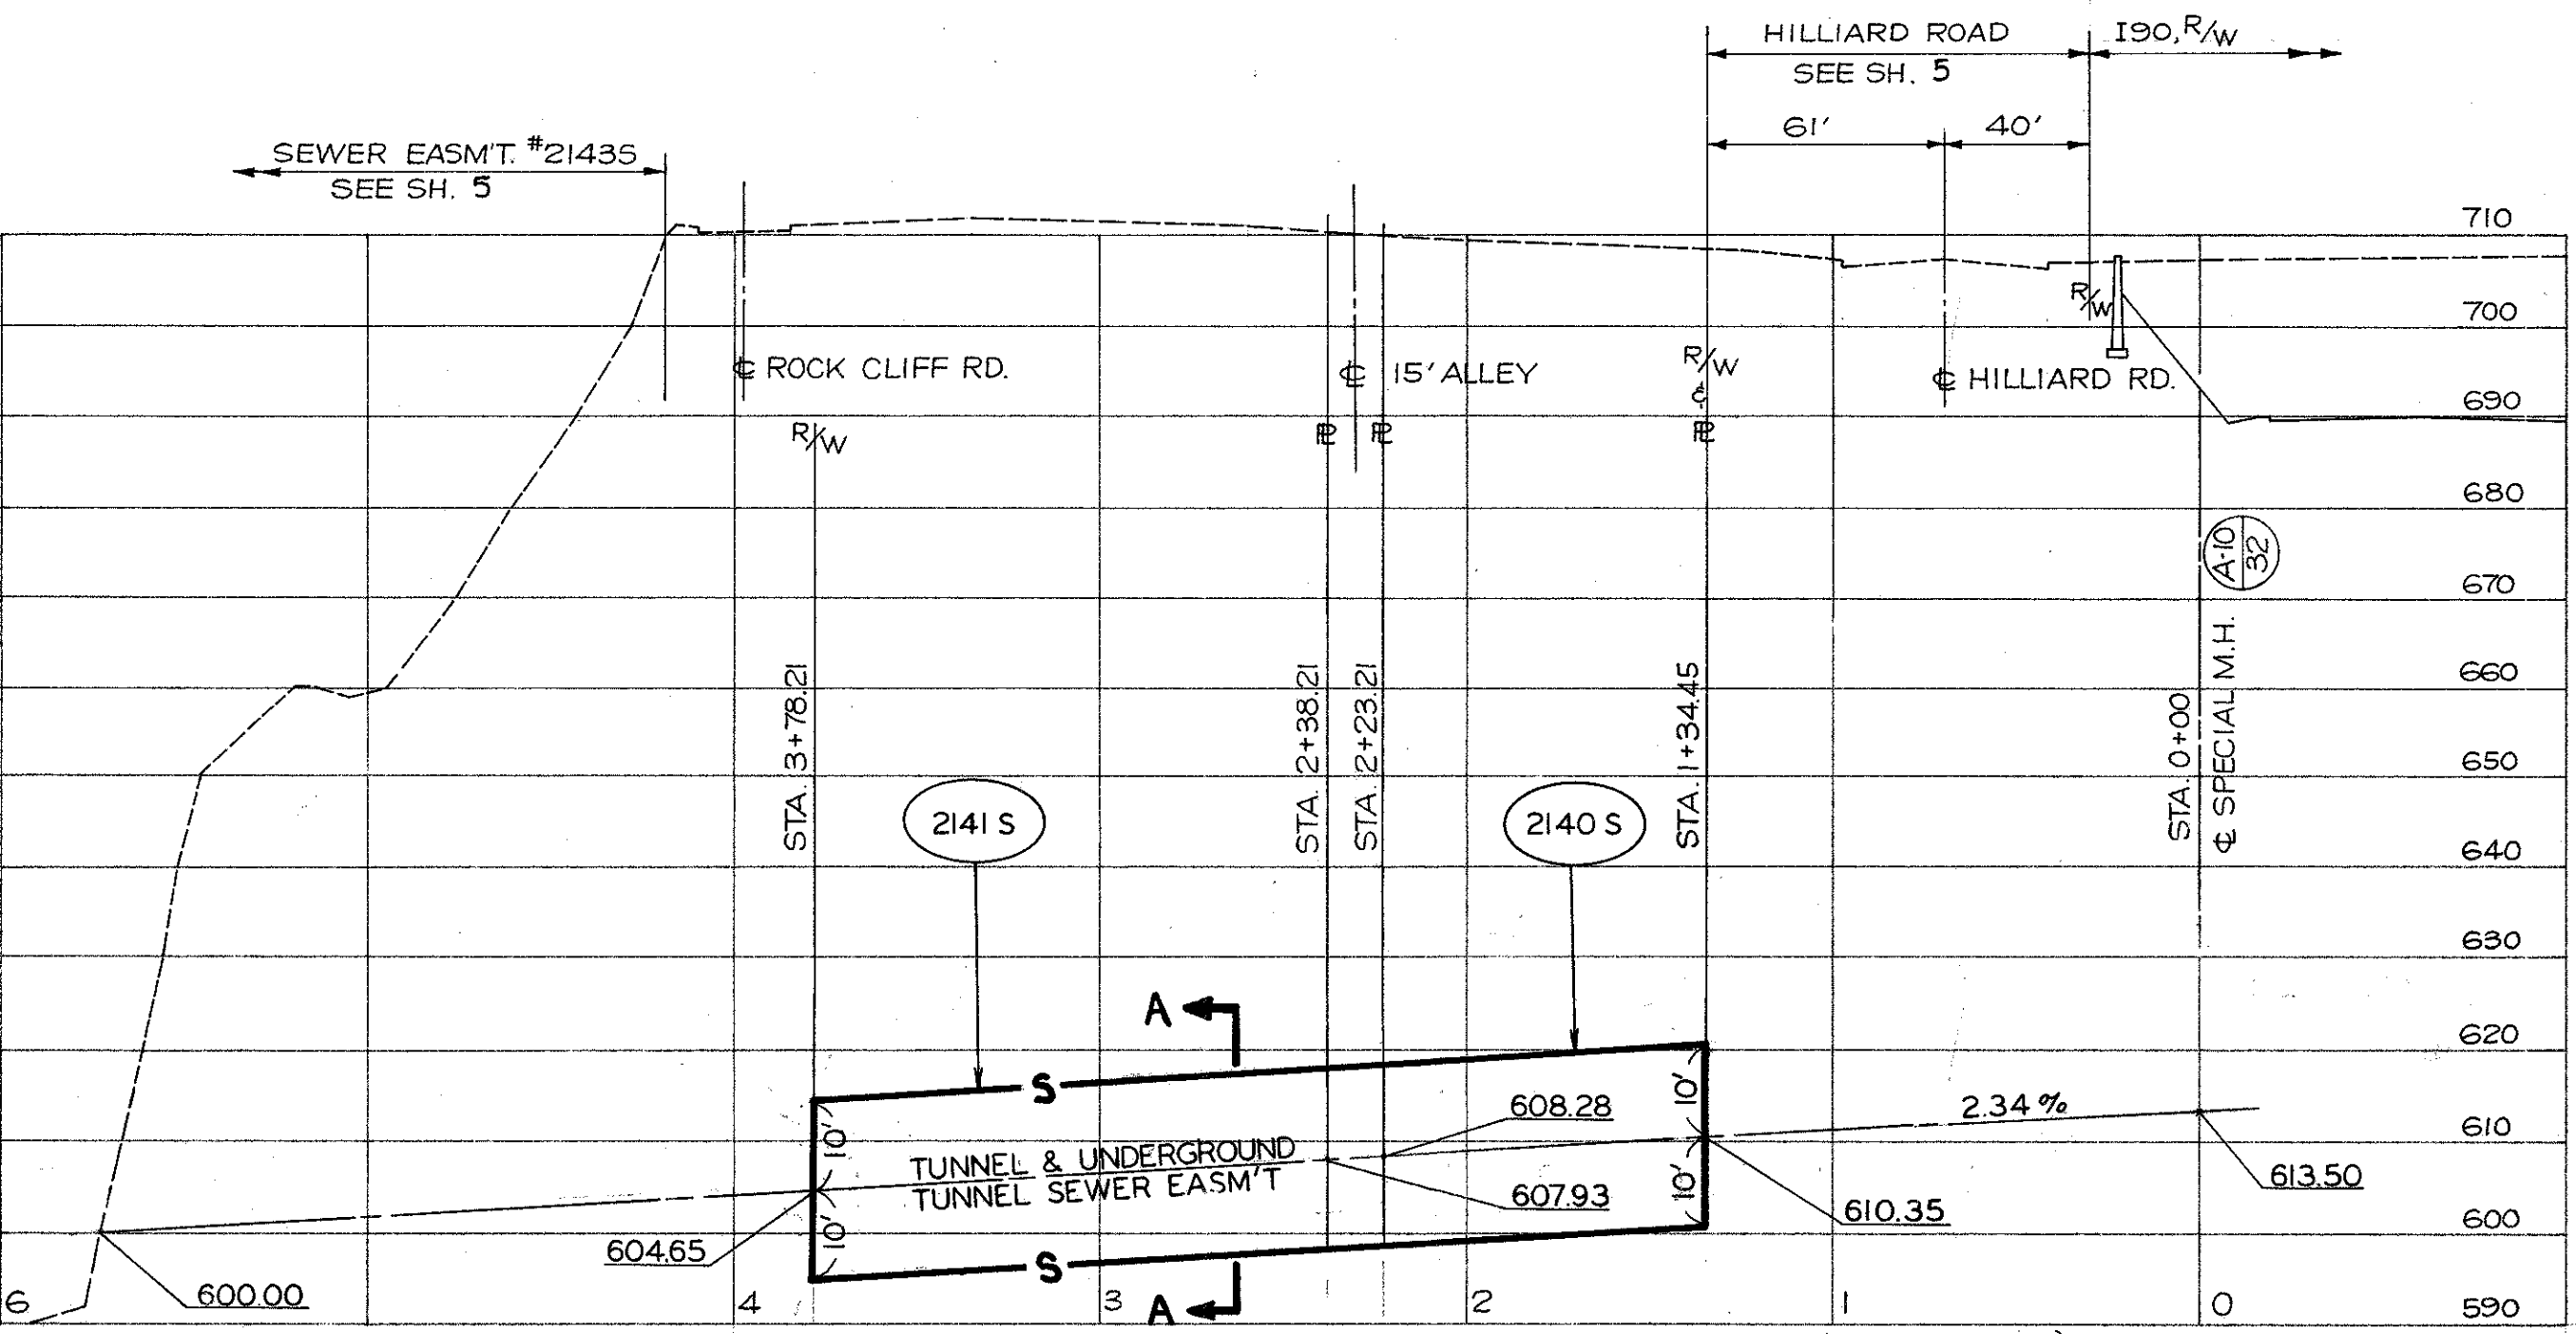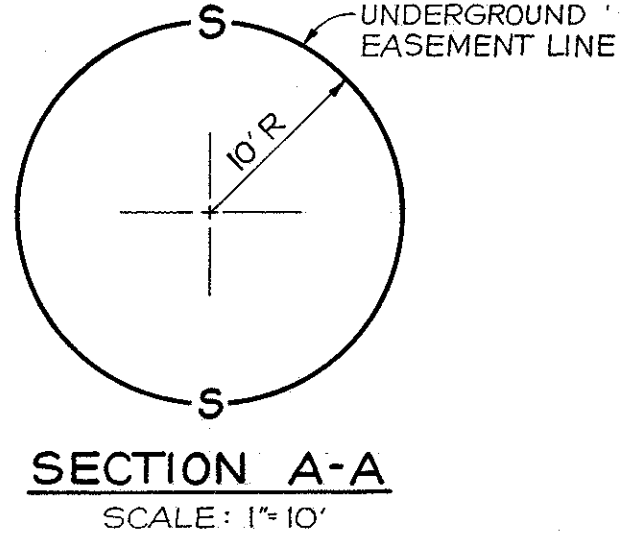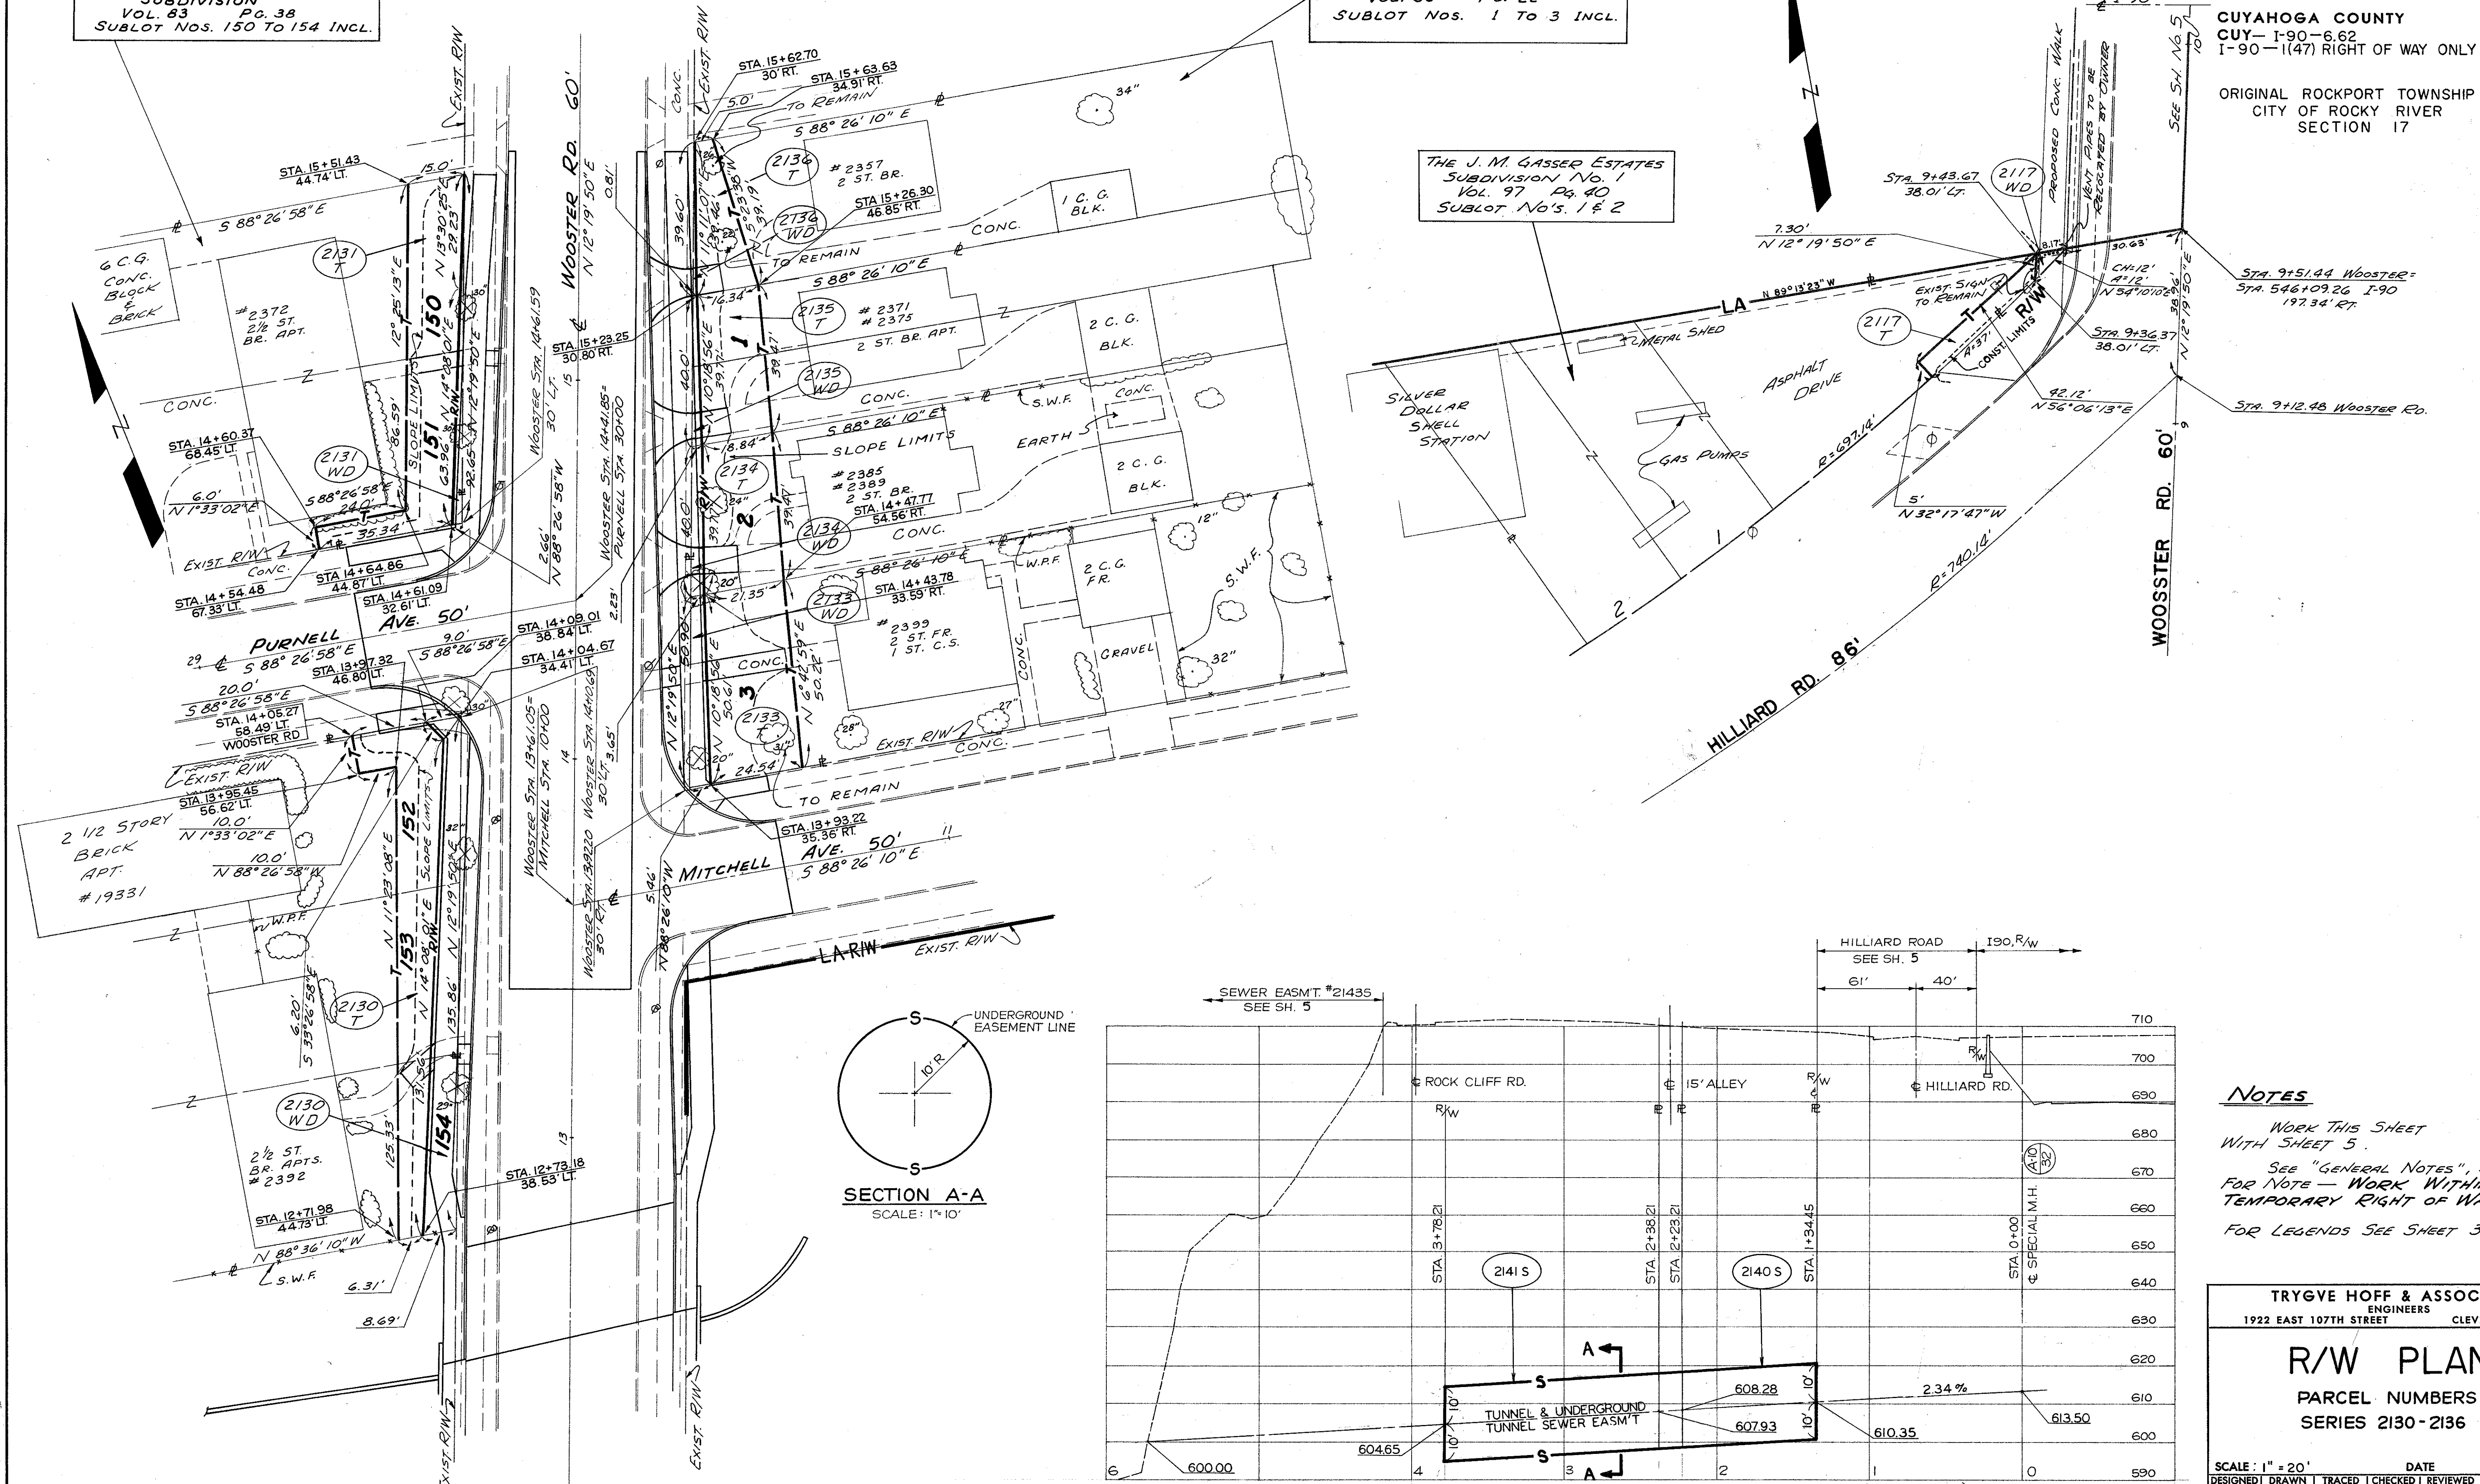

NOTES
WORK THIS SHEET
WITH SHEET 5.
SEE "GENERAL NOTES", SHEET 8/
FOR NOTE - WORK WITHIN
TEMPORARY RIGHT OF WAY.
FOR LEGENDS SEE SHEET 3.

TRYGVE HOFF & ASSOCIATES ENGINEERS 1922 EAST 107TH STREET CLEVELAND, OHIO					
R/W PLAN					
PARCEL NUMBERS SERIES 2130-2136					
SCALE: 1" = 20'	DATE				
DESIGNED	DRAWN	TRACED	CHECKED	REVIEWED	DATE
FT.	AK.	AK.	FT.	J.L.L.	2-22-68

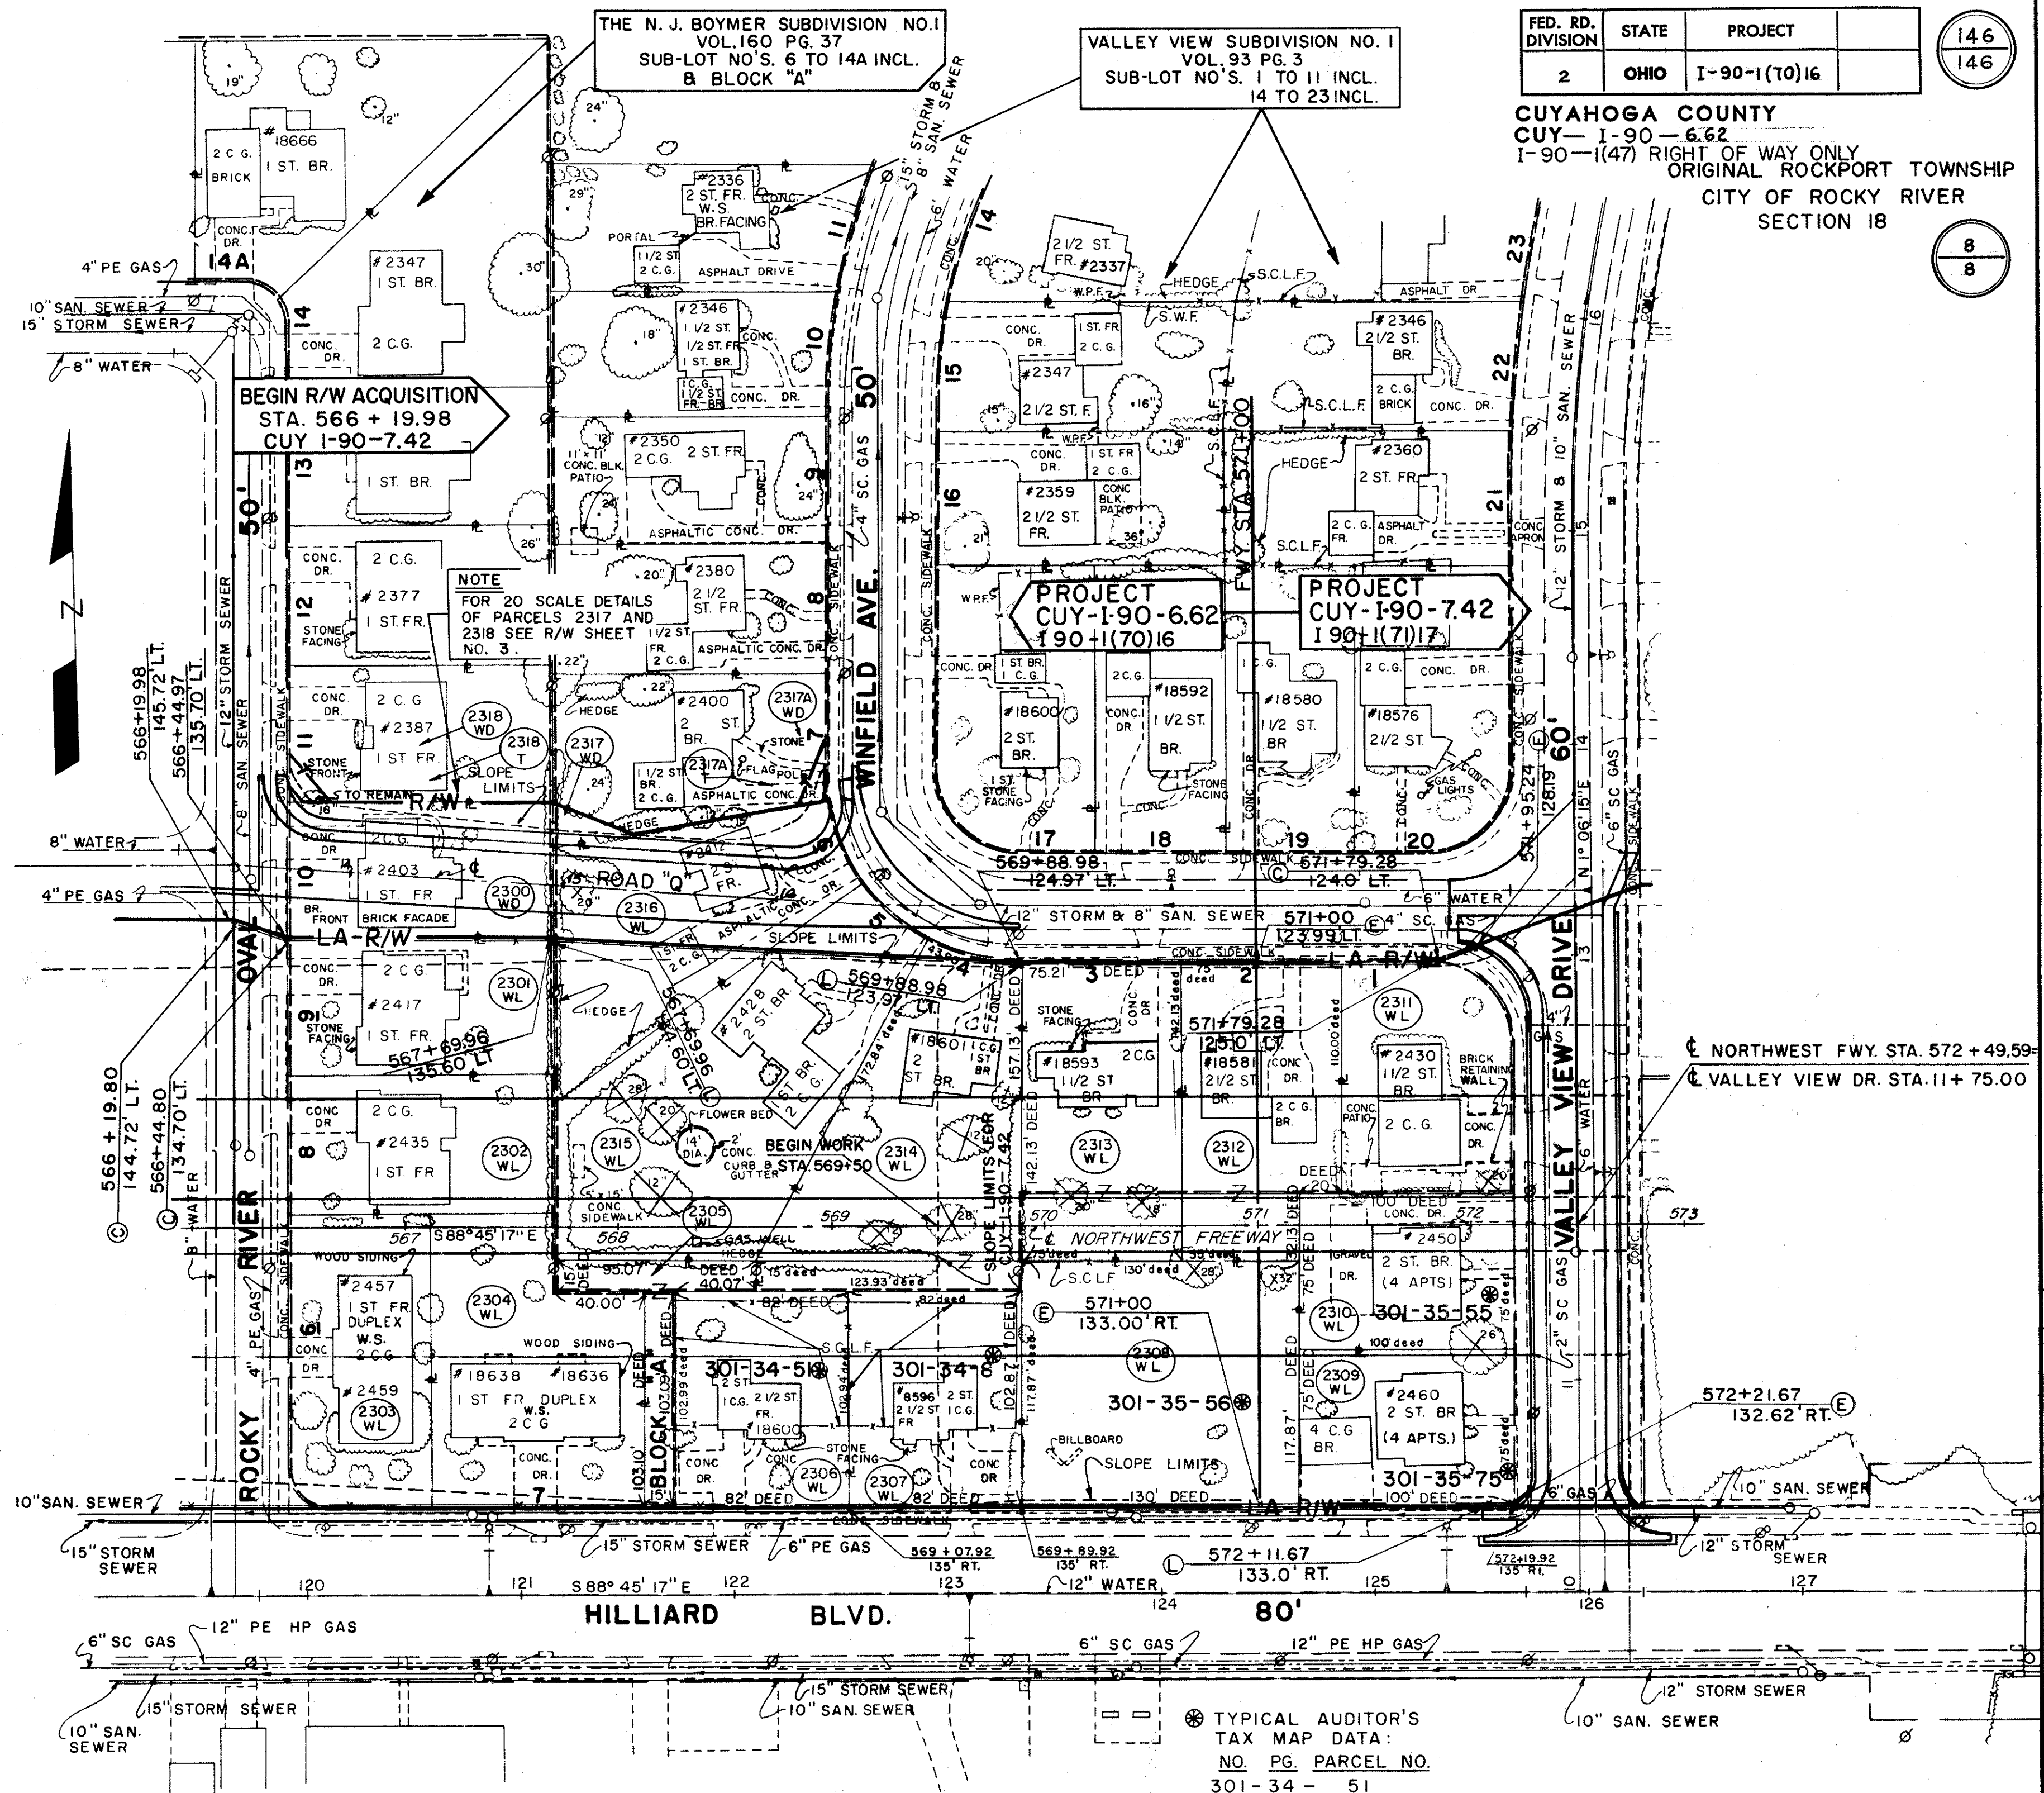

TRYGVE HOFF & ASSOCIATES
ENGINEERS
1922 EAST 107TH STREET CLEVELAND, OHIO


R/W PLAN
STA. 566+19.98 TO STA. 572+49.59
PARCEL NUMBERS
SERIES 2300 - 2318

SCALE: 1" = 50' DATE
DESIGNED DRAWN TRACED CHECKED REVIEWED DATE REVISED
F.T. D.K. F.T. J.R. 2/22/68

This Improvement Has Been Declared A Limited Access Highway From Sta. 528 Plus 50.00 To Sta. 617 Plus 6.62 By Action Of The Director Of Highways & Recorded In Volume 48, Page 25 Of The Director's Journal Pursuant To Law.

CENTER LINE SURVEY PLAT NORTHWEST FREEWAY

CITY OF ROCKY RIVER, CUYAHOGA COUNTY, OHIO
ROCKPORT TWP. R14W, T7N, SEC. 5, 17 & 18

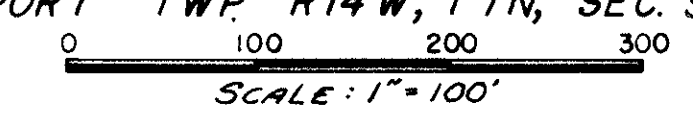

RECEIVED _____ 19____
RECORDED _____ 19____
BOOK _____ PAGE _____
County Recorder _____


FED. RD. DIVISION	STATE	PROJECT
2	OHIO	

CUYAHOGA COUNTY
CUY-1-90-6.62
CUY-1-90-7.42
CUY-1-90-7.69
I-90-1(47) RIGHT OF WAY ONLY

137
146

1
2

SIGNED Charles M. Zupnik
DATE 3-8-68 DIVISION DEPUTY DIRECTOR
OHIO DEPT. OF HIGHWAYS

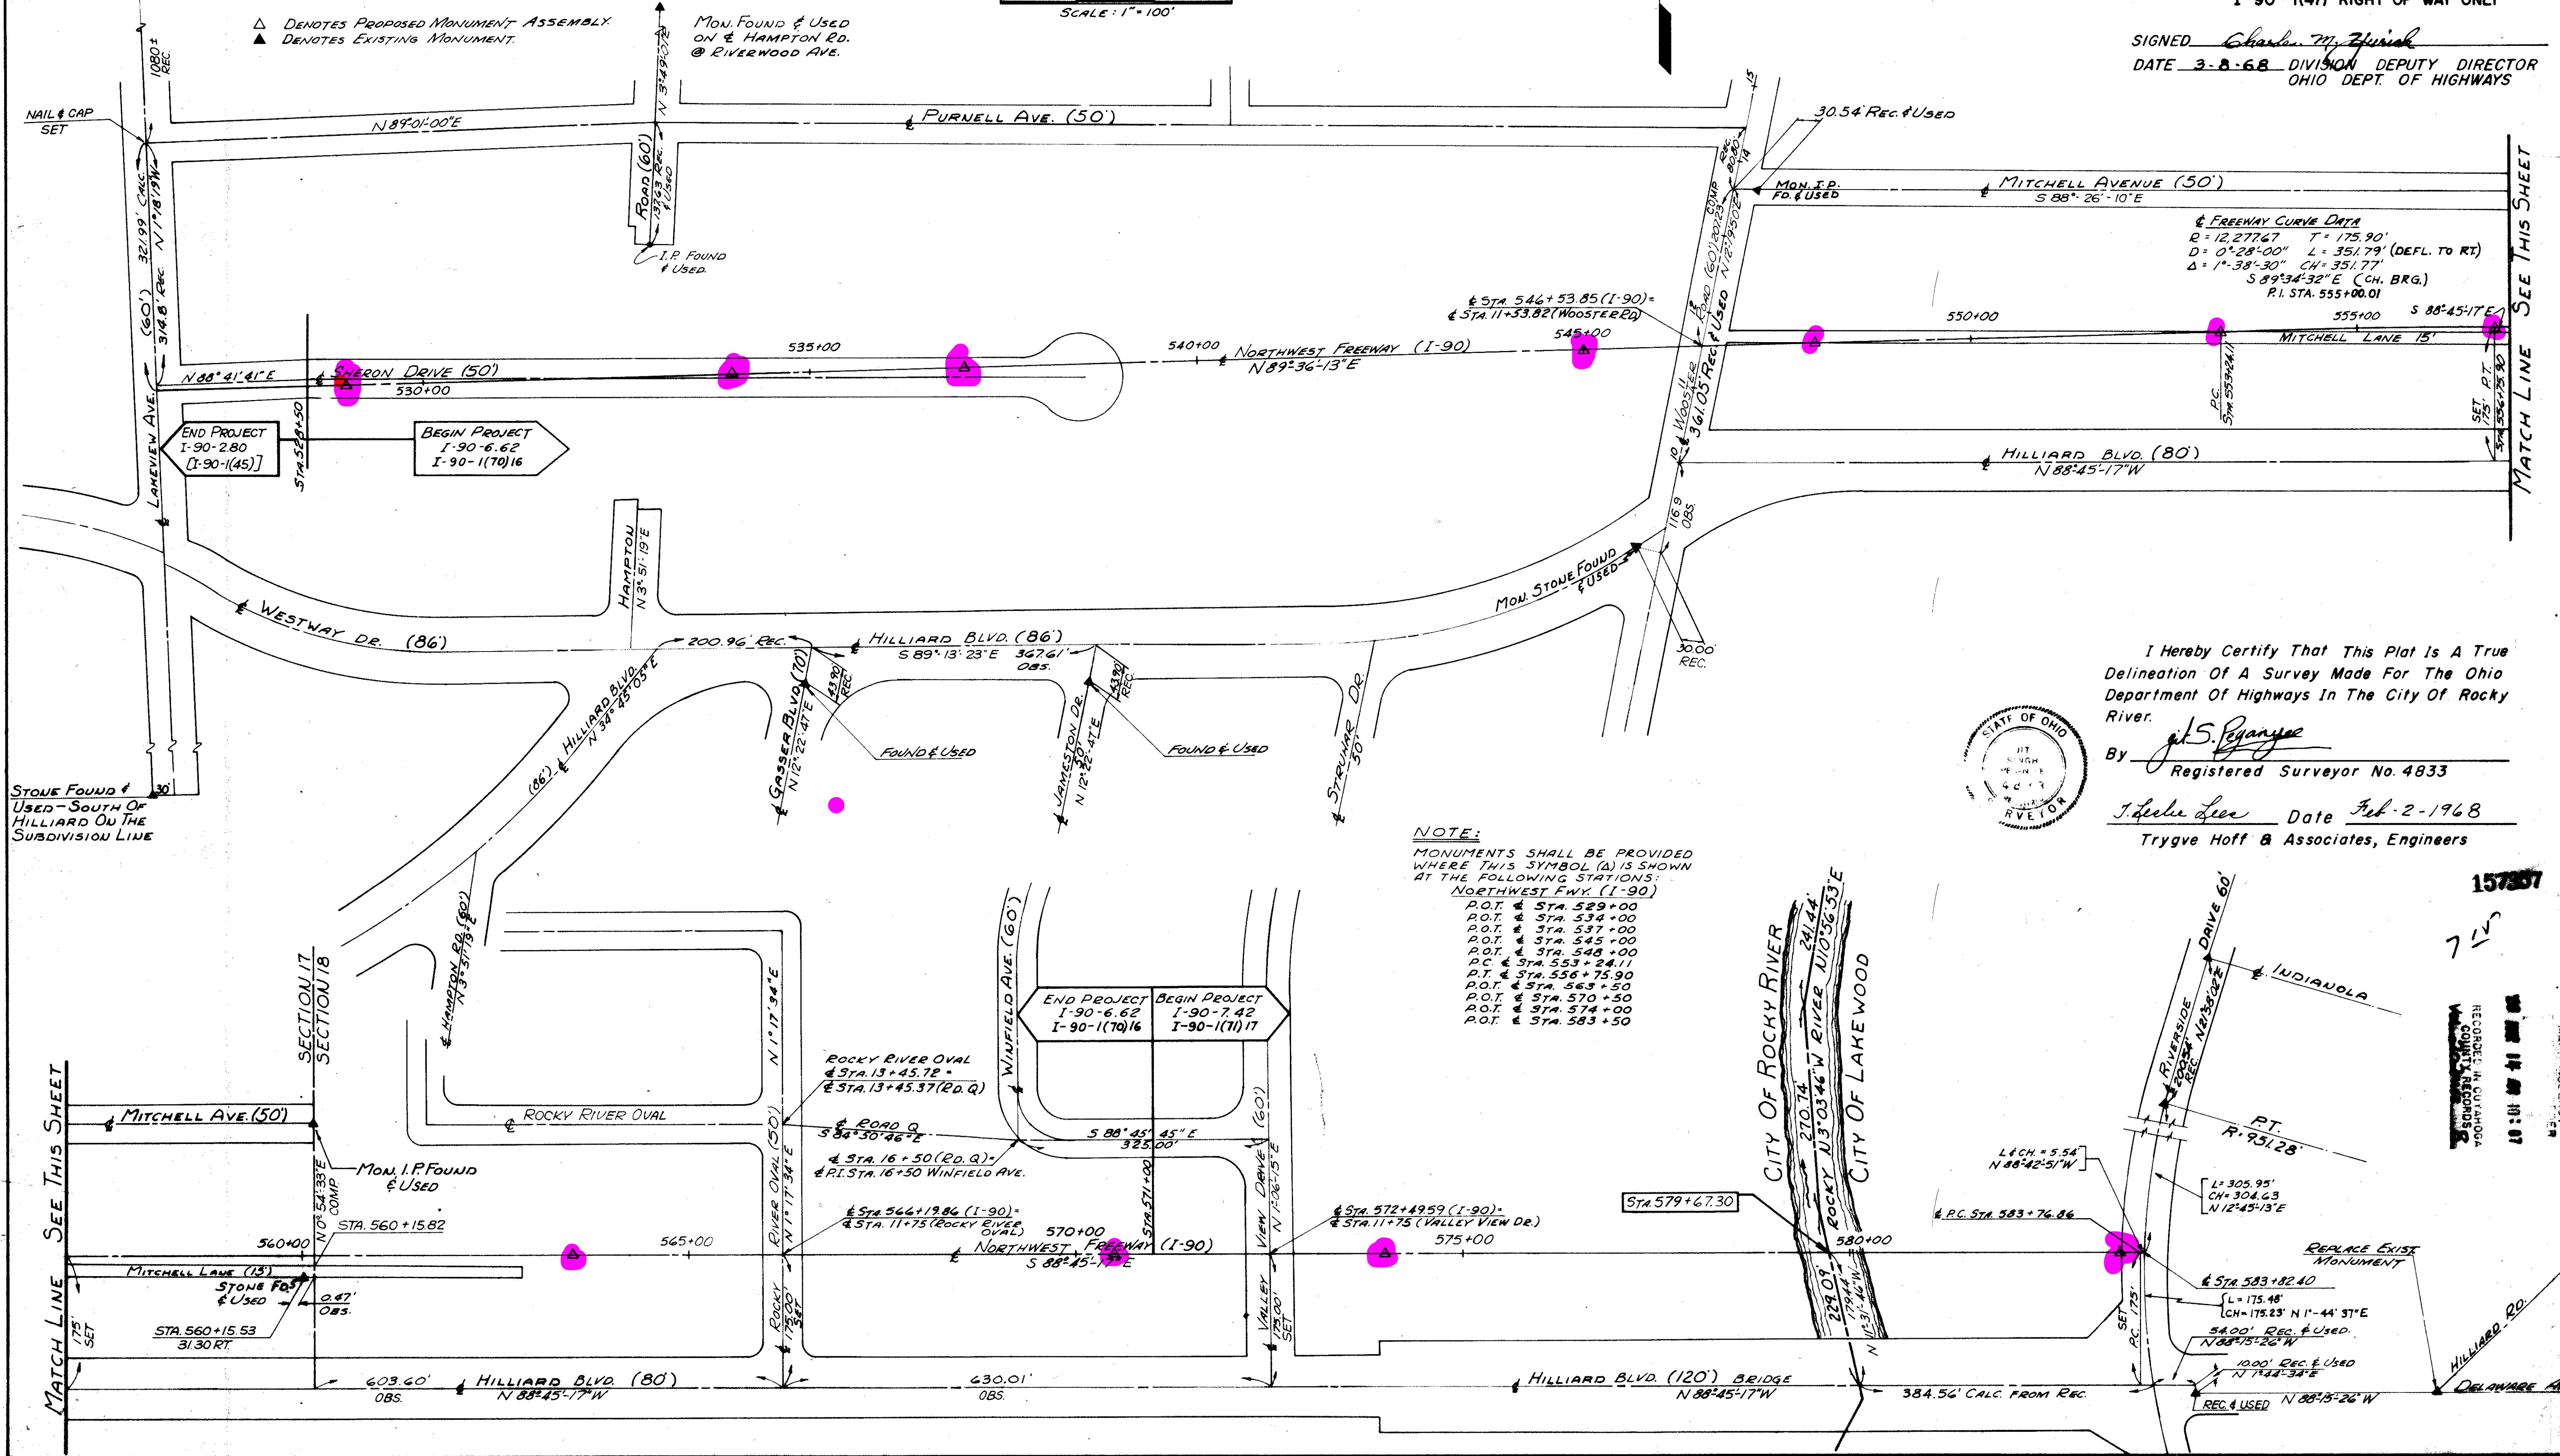


FREEWAY CURVE DATA
R=12,277.67 T=175.90'
D=0°28'00" L=351.79' (DEFL. TO RT)
Δ=1°38'30" CH=351.77'
S 89°34'32" E (CH. BRG.)
P.I. STA. 555+00.01

I Herby Certify That This Plat Is A True Delineation Of A Survey Made For The Ohio Department Of Highways In The City Of Rocky River.

By J. S. Ryanyee
Registered Surveyor No. 4833

J. Leche Lee Date Feb. 2-1968
Trygve Hoff & Associates, Engineers

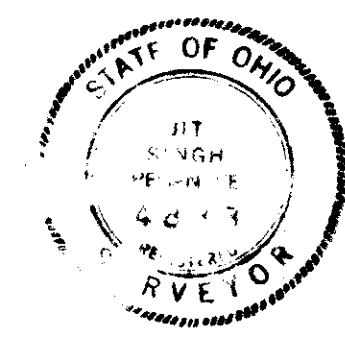

- NOTE:
MONUMENTS SHALL BE PROVIDED WHERE THIS SYMBOL (A) IS SHOWN AT THE FOLLOWING STATIONS:
NORTHWEST FWY. (I-90)
P.O.T. & STA. 529+00
P.O.T. & STA. 534+00
P.O.T. & STA. 537+00
P.O.T. & STA. 545+00
P.O.T. & STA. 548+00
P.C. & STA. 553+24.11
P.T. & STA. 556+75.90
P.O.T. & STA. 563+50
P.O.T. & STA. 570+50
P.O.T. & STA. 574+00
P.O.T. & STA. 583+50

15737

FILED
MAY 14 1968
RECORDED IN CUYAHOGA COUNTY RECORDS

6095

CONT. No. 63032

PLAT NO. 63032 SHEET ACCT. NO. 6096

This Improvement Has Been Declared A Limited Access Highway From Sta. 528 Plus 50.00 To Sta. 617 Plus 61.82 By Action Of The Director Of Highways And Recorded In Volume 48, Page 25 Of The Director's Journal Pursuant To Law.

CENTER LINE SURVEY PLAT NORTHWEST FREEWAY

CITY OF LAKEWOOD, CUYAHOGA COUNTY, OHIO
ROCKPORT TWP. R14W, T7N, SEC.'S 18 & 19

RECEIVED	19
RECORDED	19
BOOK	PAGE
County Recorder	

FED. RD. DIVISION	STATE	PROJECT
2	OHIO	

CUYAHOGA COUNTY
CUY-1-90-6.62
CUY-1-90-7.42
CUY-1-90-7.69
I-90-11(47) RIGHT OF WAY ONLY

138
146
2
2

Δ DENOTES PROPOSED MONUMENT ASSEMBLY
▲ DENOTES EXISTING MONUMENT

SCALE 1" = 100'

SIGNED Charles M. Zupnik
DATE 3-8-68 DIVISION DEPUTY DIRECTOR
OHIO DEPT. OF HIGHWAYS

NOTE:
MONUMENTS SHALL BE PROVIDED WHERE THIS SYMBOL (Δ) IS SHOWN AT THE FOLLOWING STATIONS:

NORTHWEST FREEWAY (I-90)
R.O.C. & STA. 584+50
R.O.C. & STA. 585+00
P.T. & STA. 585+47.81
P.O.T. & STA. 601+00
P.O.T. & STA. 603+00
P.C. & STA. 608+95.40
R.O.C. & STA. 615+50

ROAD M
P.C. & STA. 1+00
R.O.C. & STA. 6+05.96
P.T. & STA. 6+58.78
P.O.T. & STA. 9+41.49
P.O.T. & STA. 16+27.78
P.O.T. & STA. 18+75.44
P.T. & STA. 25+30.02
P.O.T. & STA. 27+80.16



ROAD N
P.T. & STA. 10+76.87
P.C. & STA. 19+93.18
P.T. & STA. 21+57.01
P.O.T. & STA. 27+45.37
P.O.T. & STA. 30+64.60
P.T. & STA. 34+33.48
P.O.T. & STA. 40+17.92

HILLIARD ROAD
F.TAN. STA. 141+02.04
MCKINLEY AVE.
R.O.T. & STA. 8+02.75
P.O.T. & STA. 10+00.00
P.O.T. & STA. 13+95.81

I Hereby Certify That This Plat Is A True Delineation Of A Survey Made For The Ohio Department Of Highways In The City Of Lakewood.

By J. Spangler
Registered Surveyor No. 4833

J. Leslie Lee Date Feb-2-1968
Trygve Hoff & Associates, Engineers

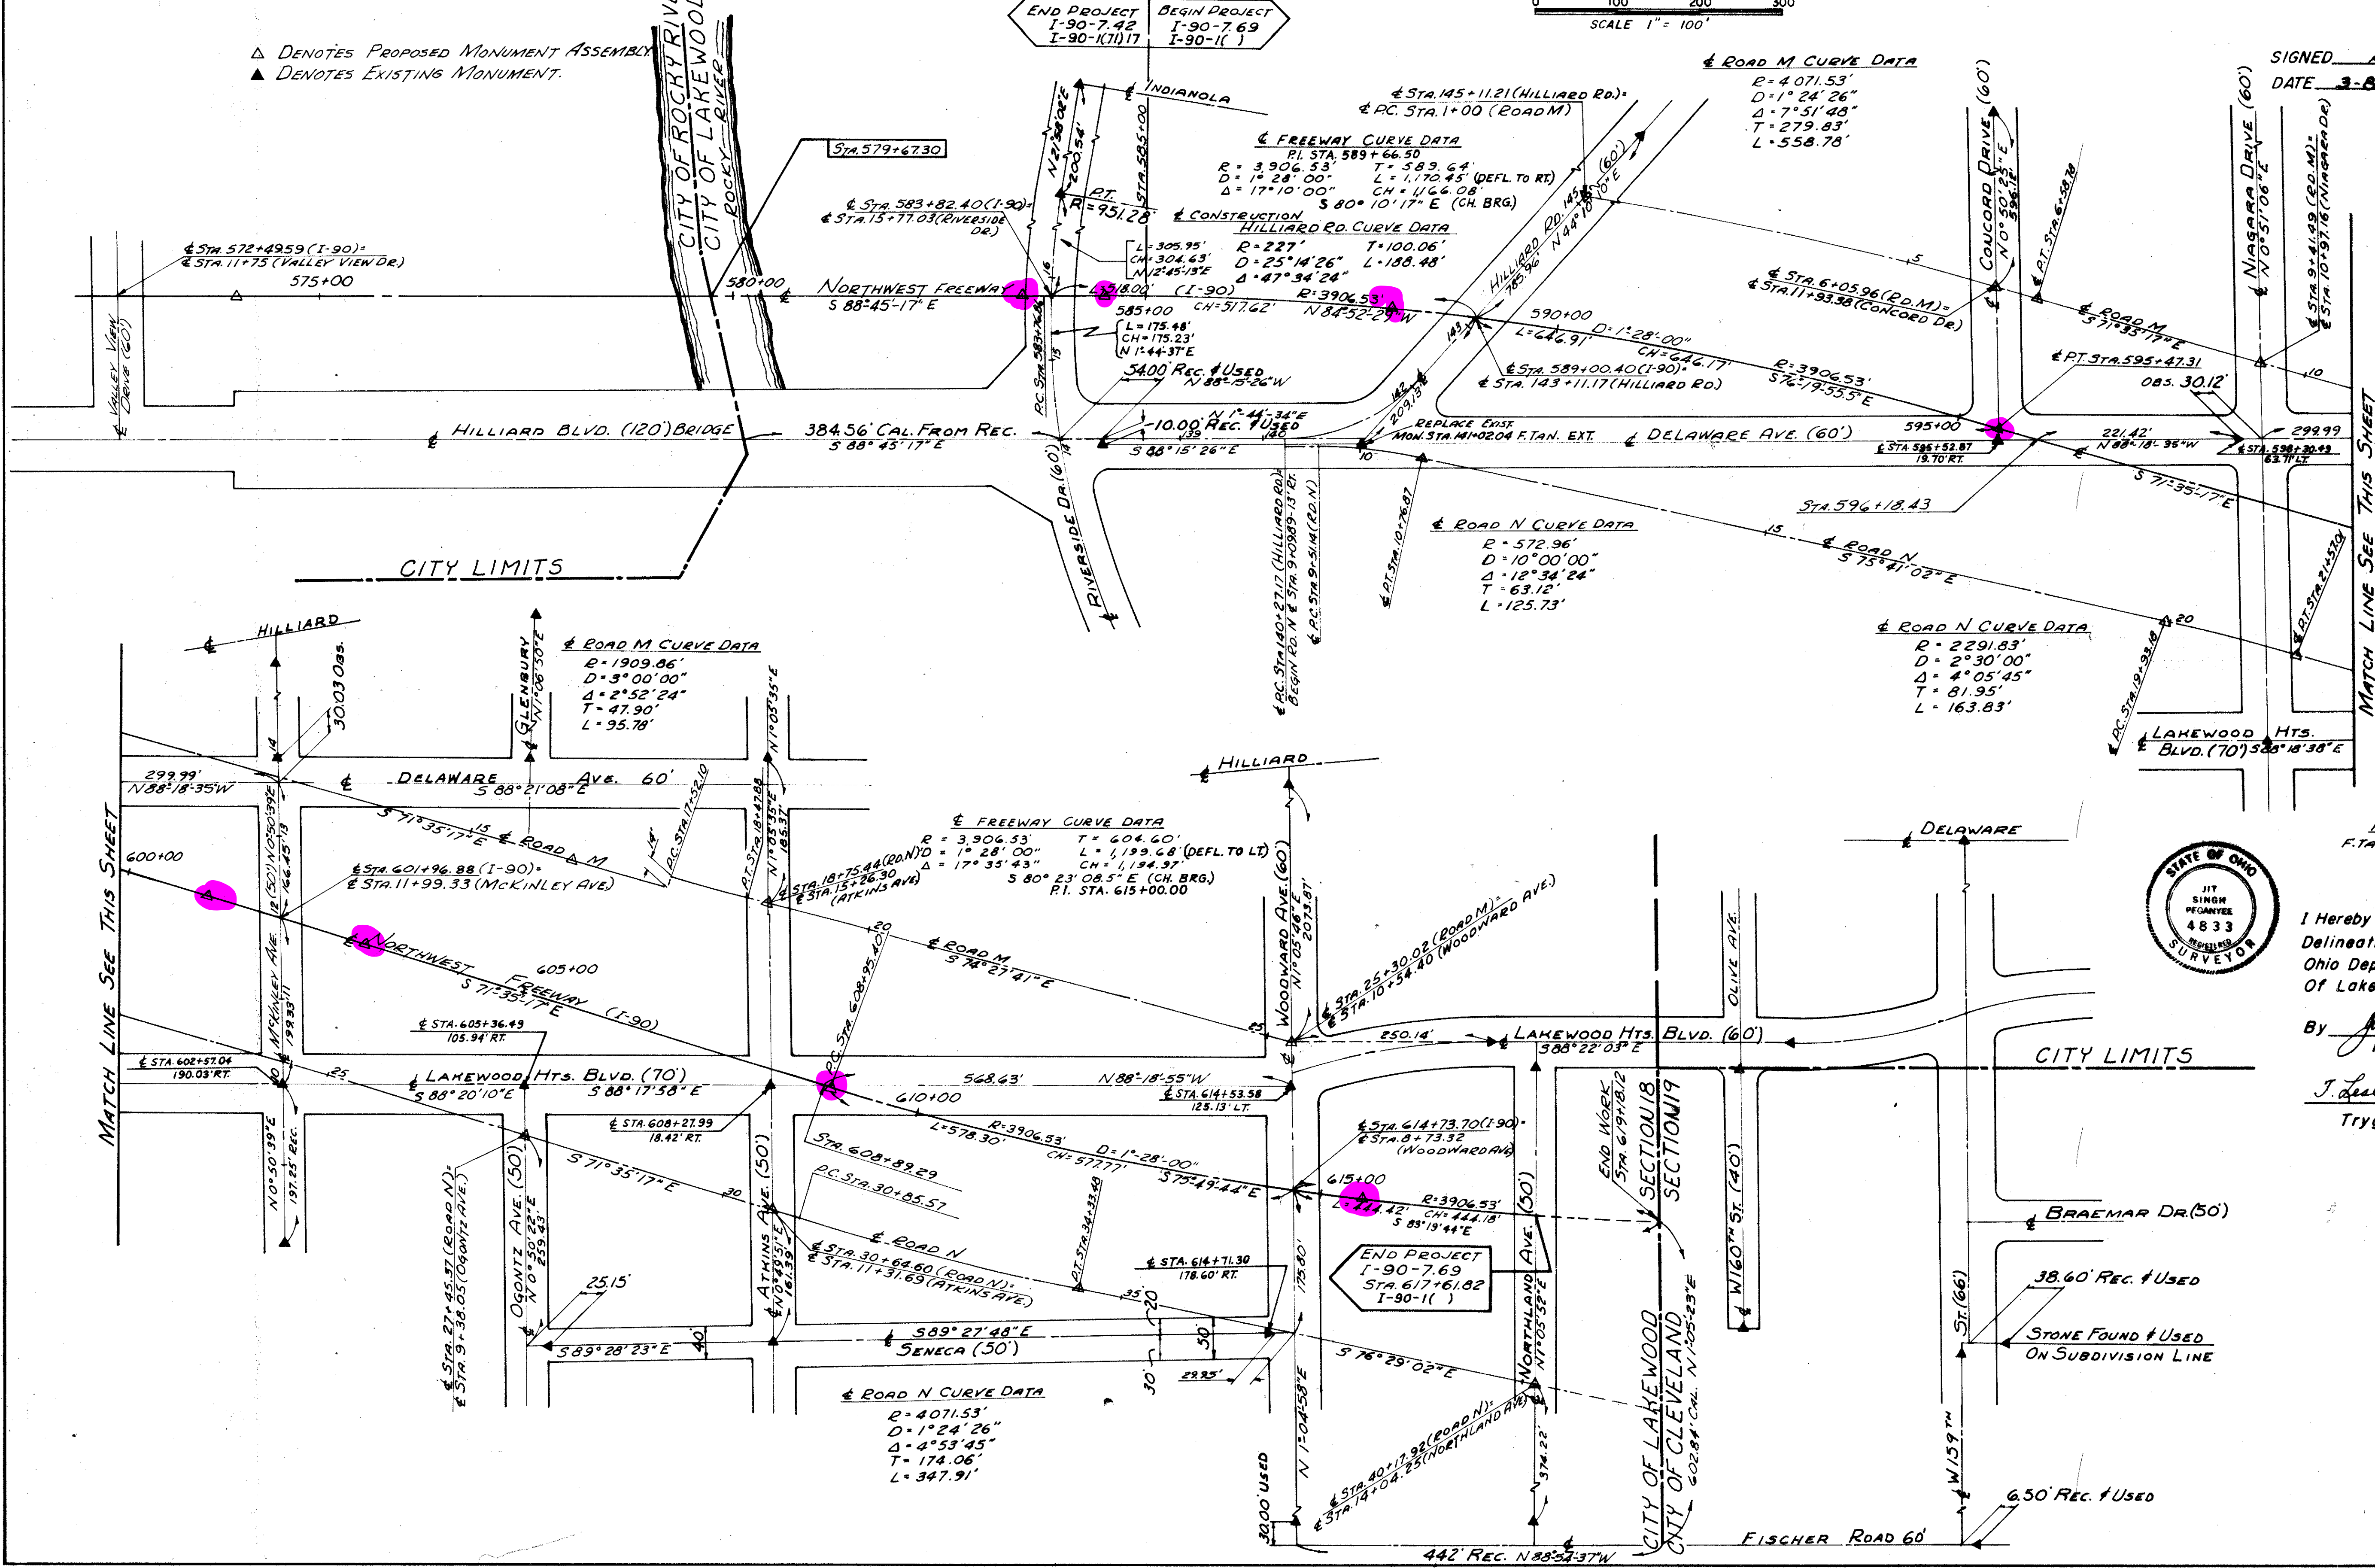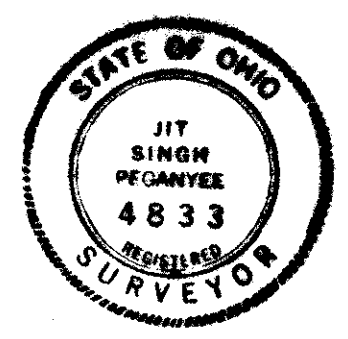

157358

RECORDED IN CUYAHOGA COUNTY RECORD NO. 10:07