

# PROP. U.S.R.-33 and MOULTON-Ft. AMANDA RD. INTERCHANGE 1987 ADT.



## LIGHTING PLAN

FED. RD. DIVISION	STATE	PROJECT
2	OHIO	

536  
621

AUGLAIZE COUNTY  
AUG. - 33 - 6.25

100 0 100 200  
scale 1"=100' feet

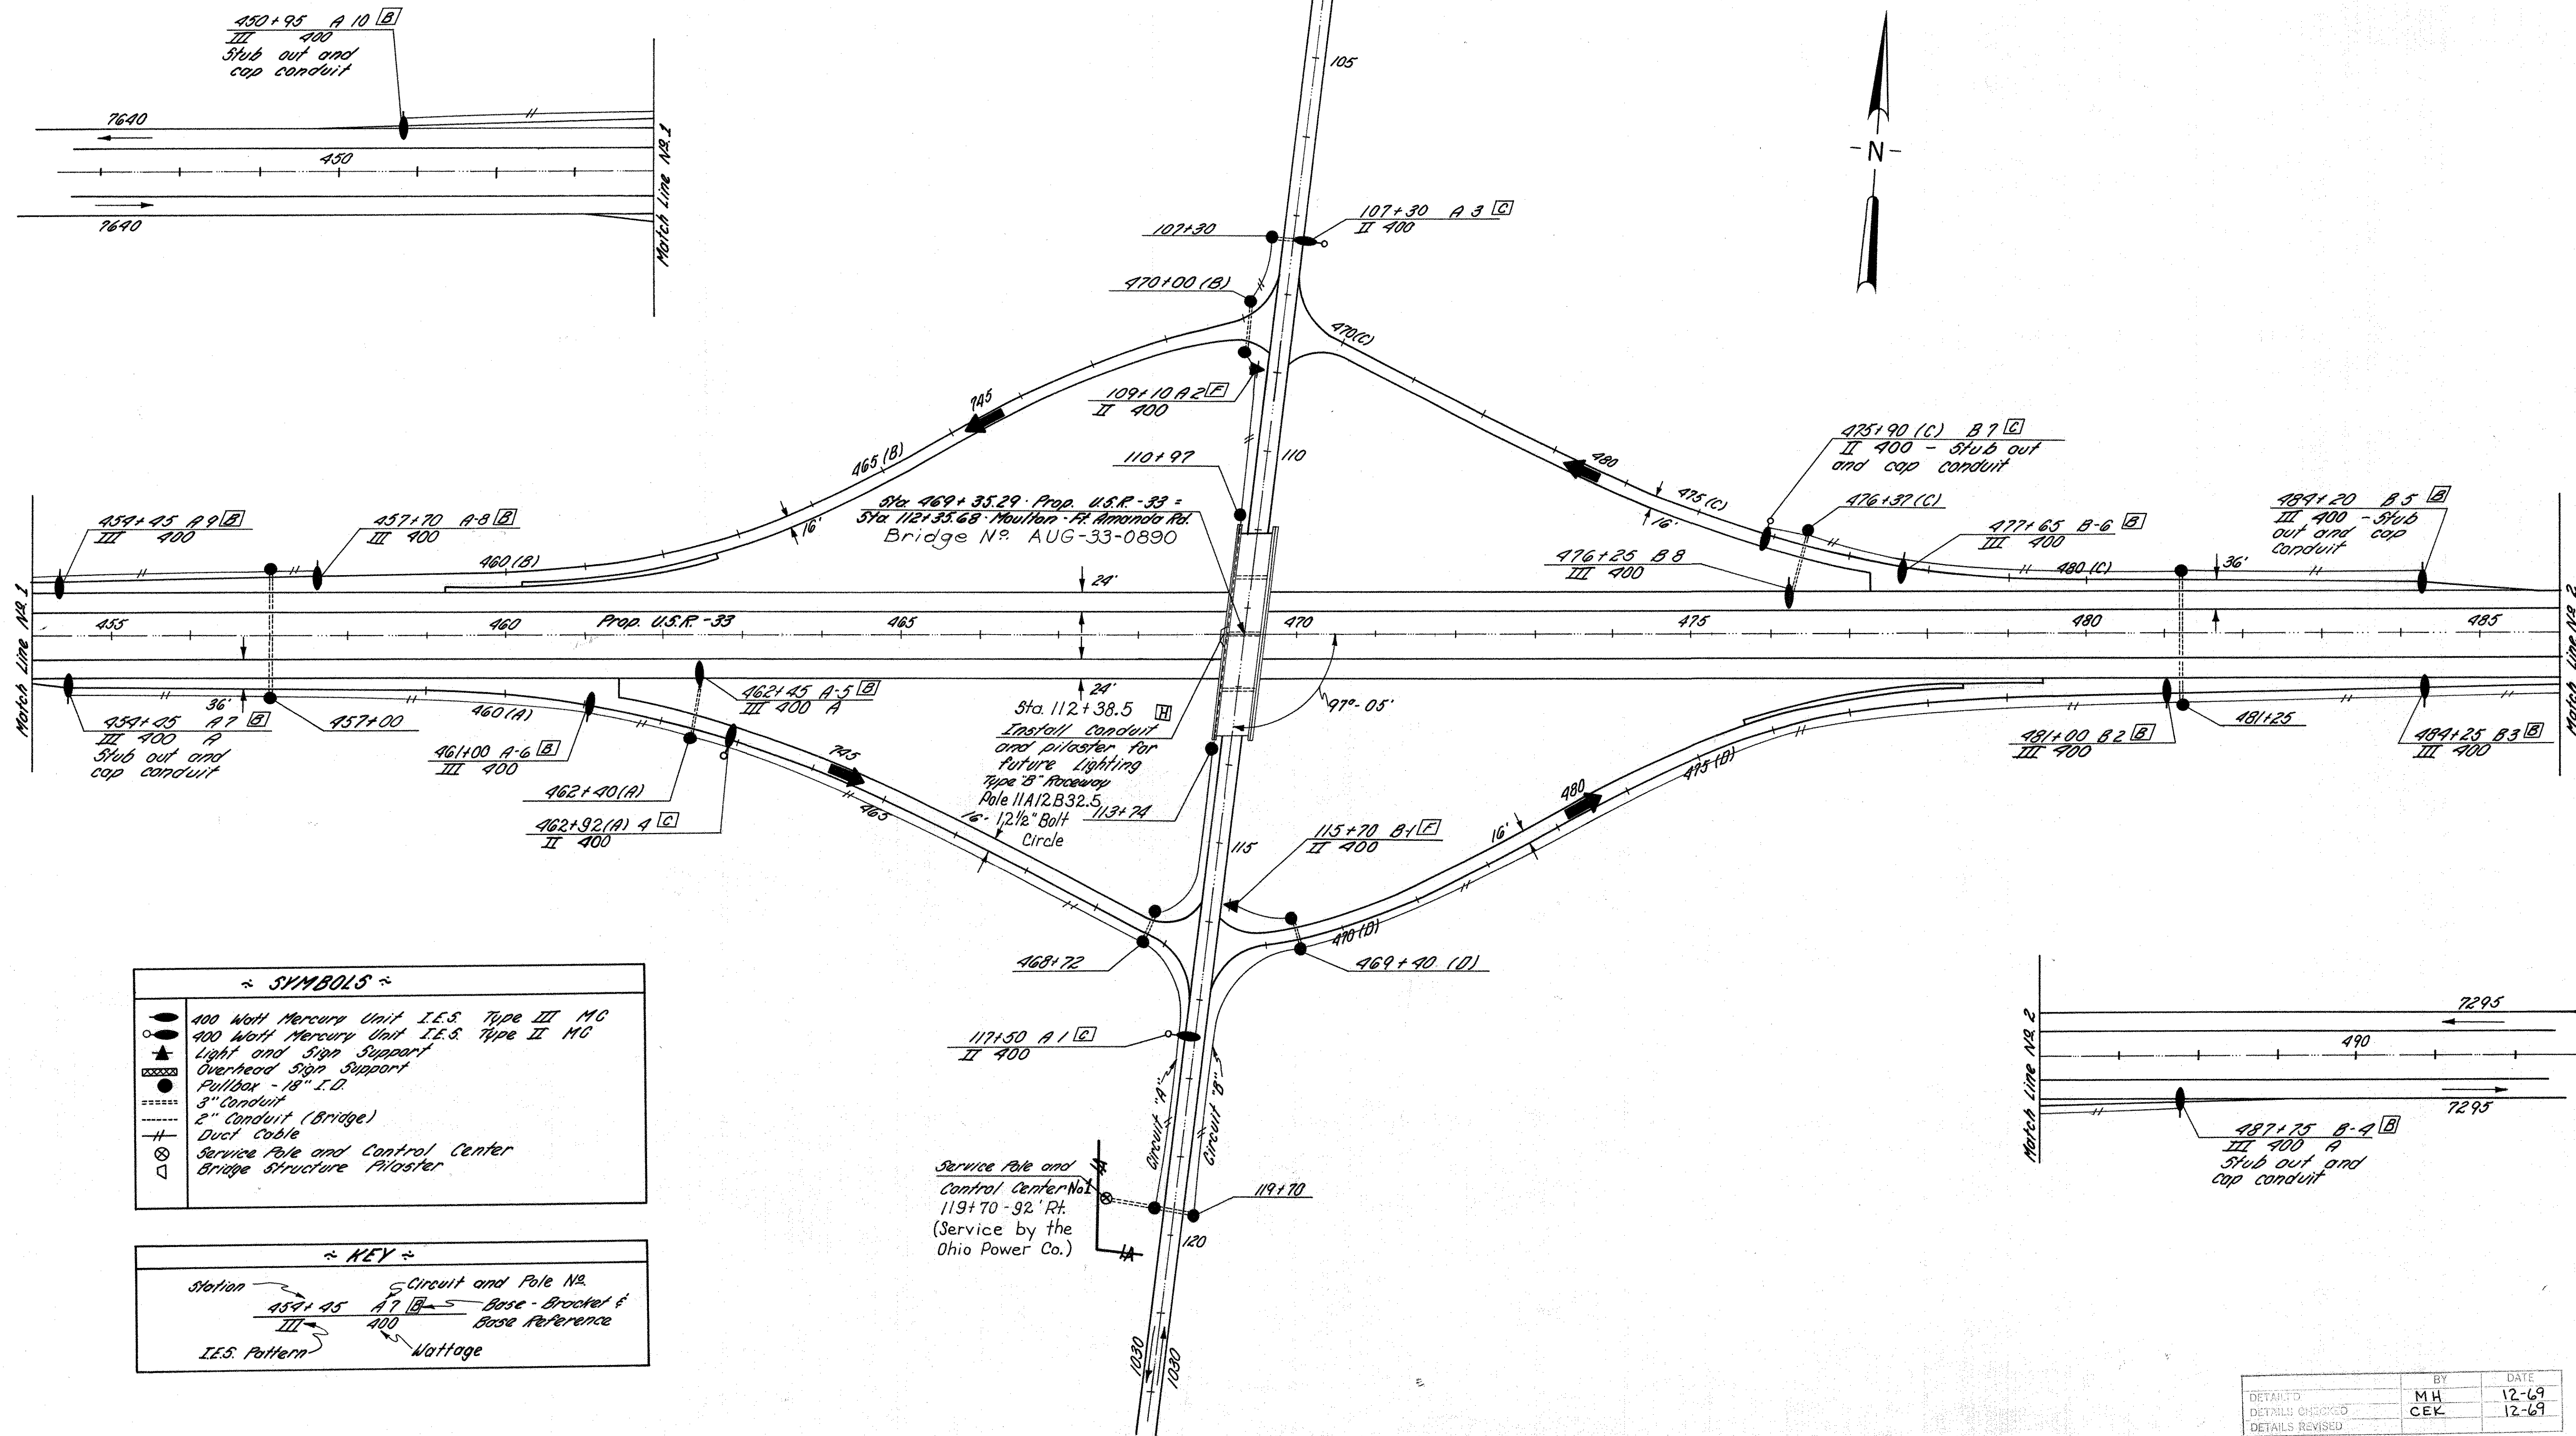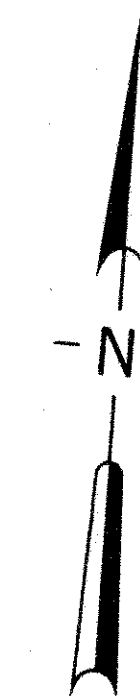

SYMBOLS	
	400 Watt Mercury Unit I.E.S. Type III MC
	400 Watt Mercury Unit I.E.S. Type II MC
	Light and Sign Support
	Overhead Sign Support
	Pullbox - 18" I.D.
	3" Conduit
	2" Conduit (Bridge)
	Duct Cable
	Service Pole and Control Center
	Bridge Structure Pilaster

KEY	
Station	Circuit and Pole No.
454+45 A 9 [B]	Base - Bracket & Base Reference
III 400	Wattage

DATE	BY
12-69	MH
DETAILS CHECKED	CEK
12-69	
DETAILS REVISED	

LIGHTING ~ PROP. U.S.R.-33 & MOULTON-Ft. AMANDA RD. INTERCHANGE ~