
 

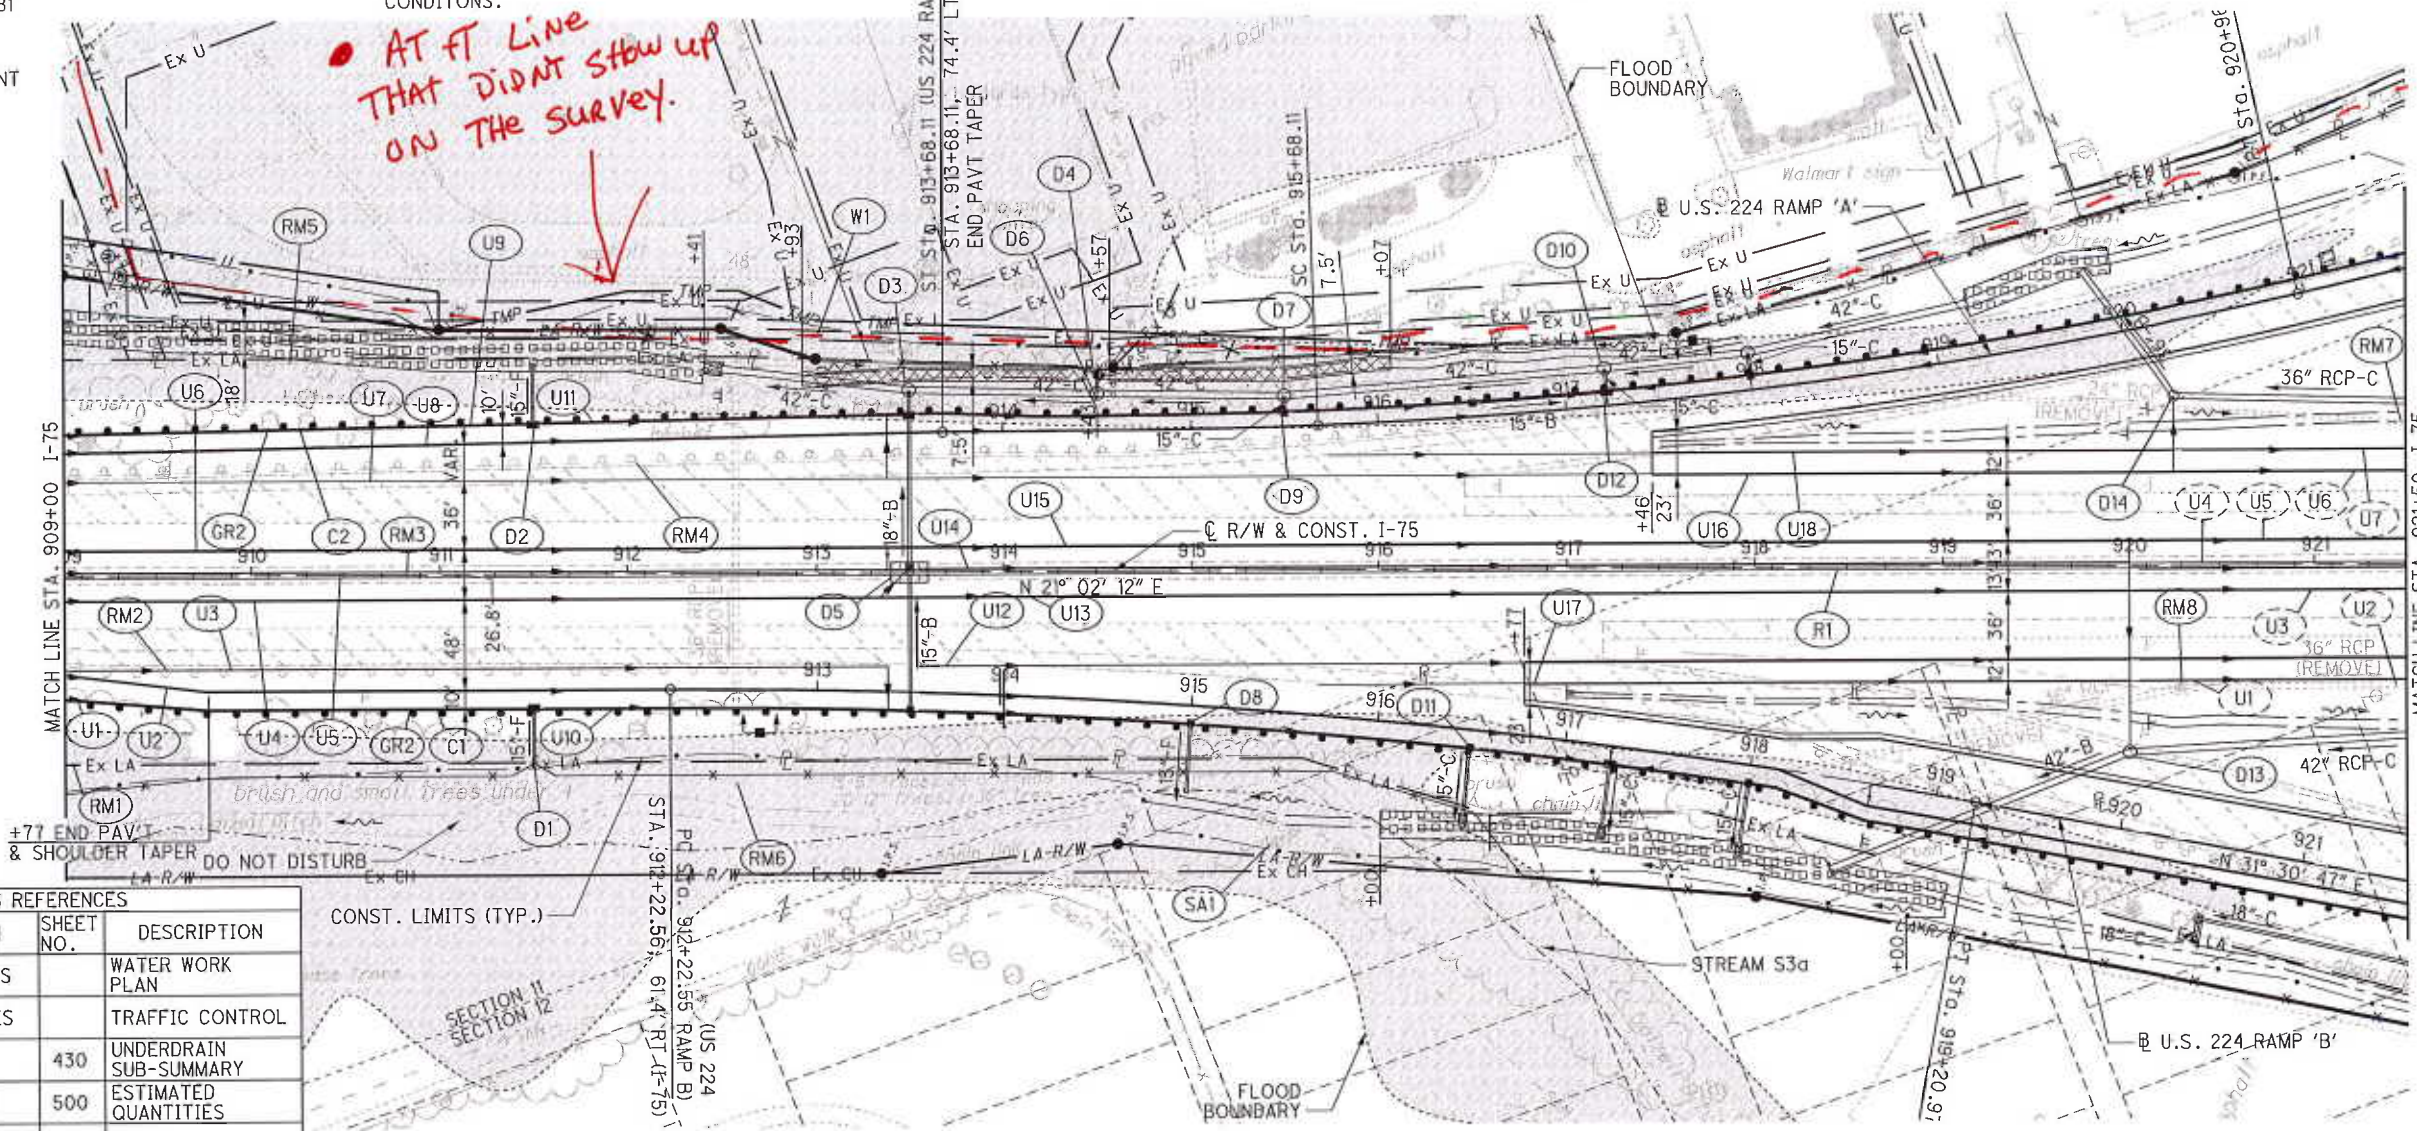


**LEGEND**

-  DEP MAT TYPE A
-  HAN-224-11.81 PROJECT LIMITS
-  SEE ADJACENT SHEET

**NOTE:**  
 EXISTING TOPO WITHIN THE LIMITS OF THE HAN-224-11.81 PROJECT (PID 84557) SHOWN ARE BASED ON BID PLANS. CONTRACTOR TO VERIFY AS BUILT CONDITIONS.


*AT FT Line THAT DIDNT SHOW UP ON THE SURVEY.*



CROSS REFERENCES			
SHEET NO.	DESCRIPTION	SHEET NO.	DESCRIPTION
	CROSS SECTIONS		WATER WORK PLAN
	STORM PROFILES		TRAFFIC CONTROL
	INTERCHANGE DETAILS	430	UNDERDRAIN SUB-SUMMARY
	LIGHTING PLAN	500	ESTIMATED QUANTITIES
	US 224 RAMP A PLAN & PROFILE		
	US 224 RAMP B PLAN & PROFILE		

CONST. LIMITS (TYP.)

**NOTE:**  
 -SEE FENCE PLAN SHEET

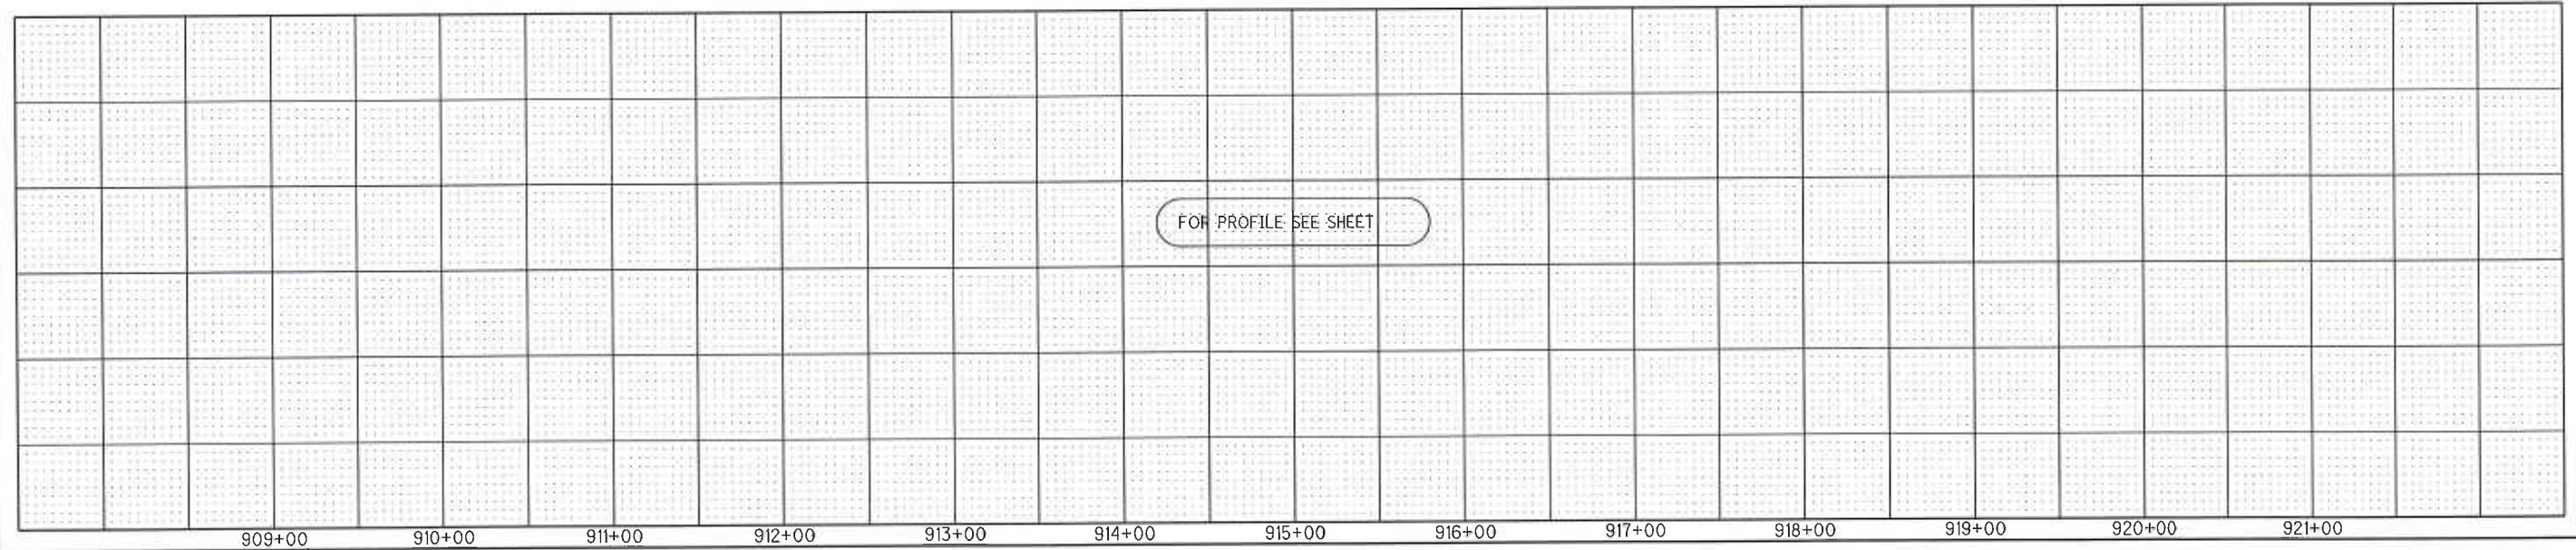

**PLAN AND PROFILE - I-75**  
**STA. 909+00 TO STA. 921+50**



**HAN-75-14.39**

498  
 2034

T:\Projects\HAN\87005\roadway\sheet\87005GP015.dgn 21-AUG-2014 2:10AM redderj

CROSS REFERENCES	
SHEET NO.	DESCRIPTION
	CROSS SECTIONS
	STORM PROFILES
	INTERCHANGE DETAILS
	US 224 RAMP C PLAN & PROFILE
	US 224 RAMP D PLAN & PROFILE
	TRAFFIC CONTROL
430	UNDERDRAIN SUB-SUMMARY
504	ESTIMATED QUANTITIES

LEGEND	
	DITCH EROSION PROTECTION
	HAN-224-11.81 PROJECT LIMITS
	SEE ADJACENT SHEET

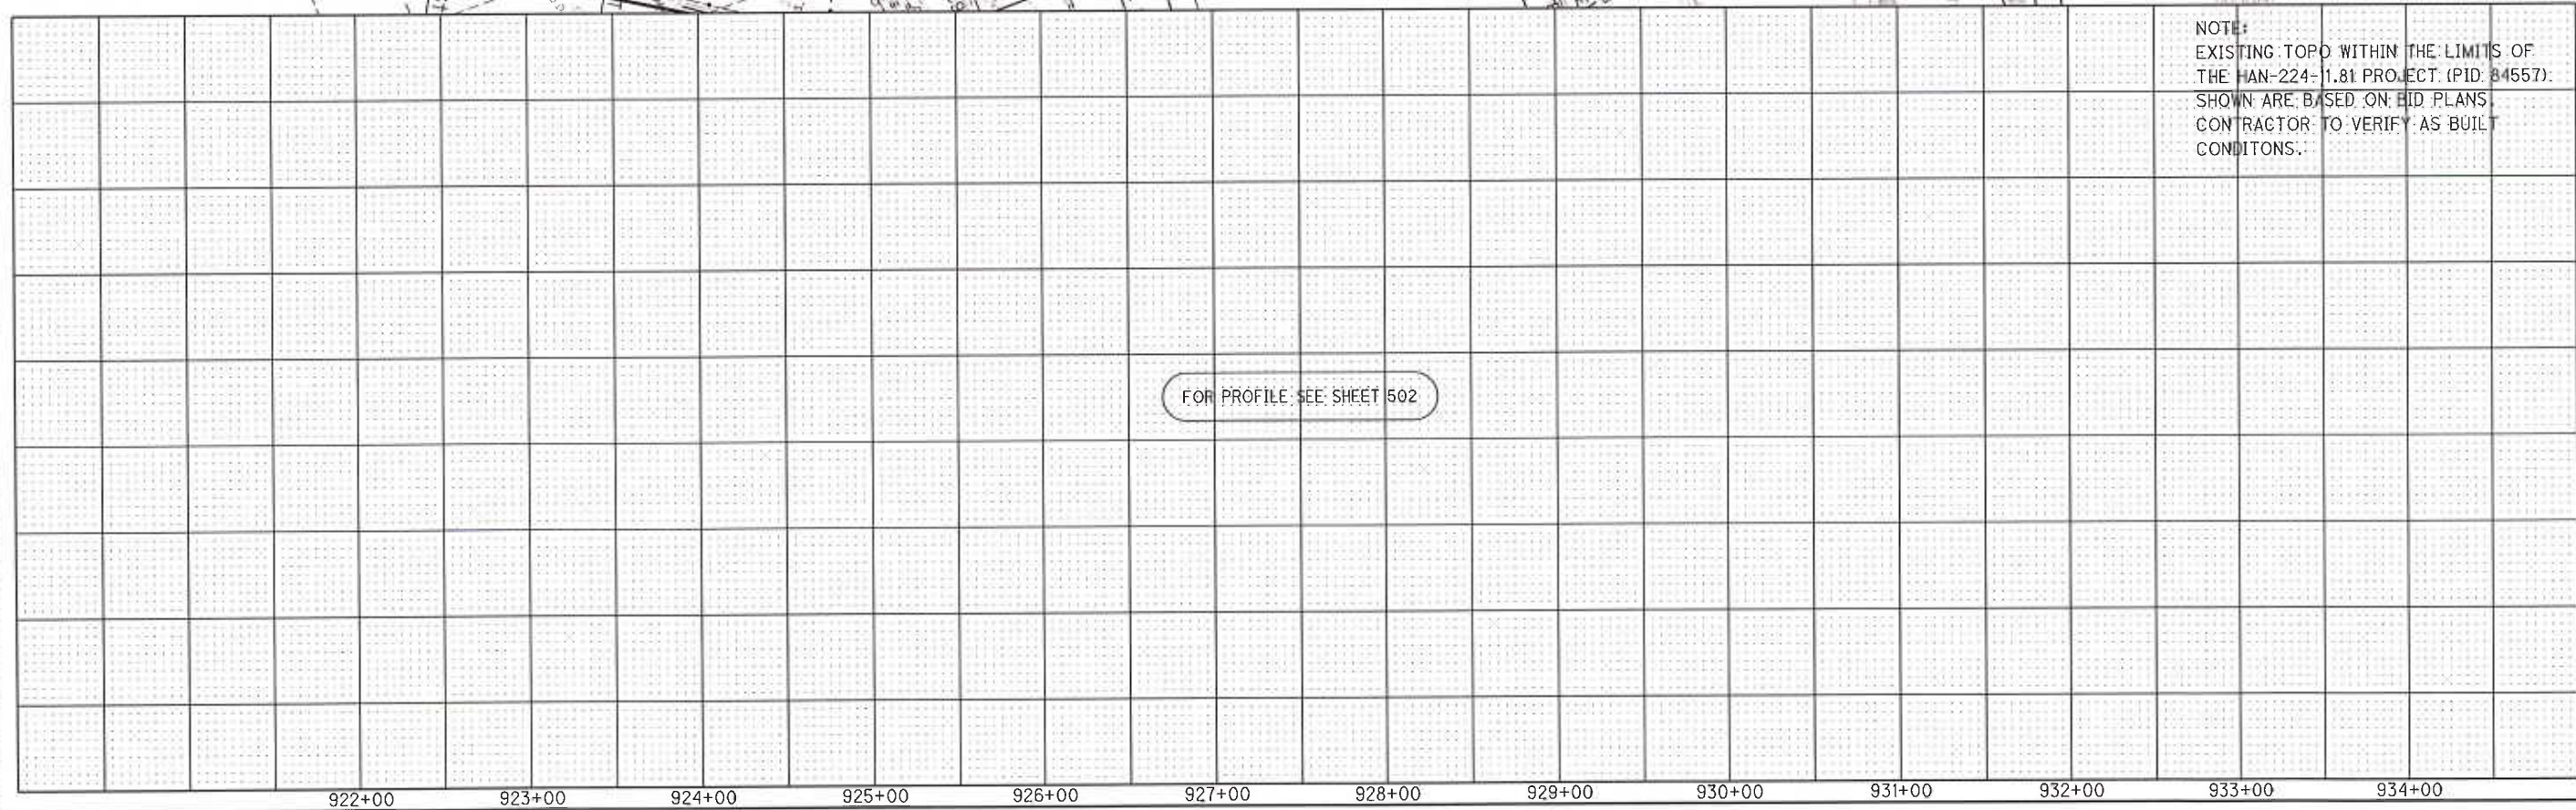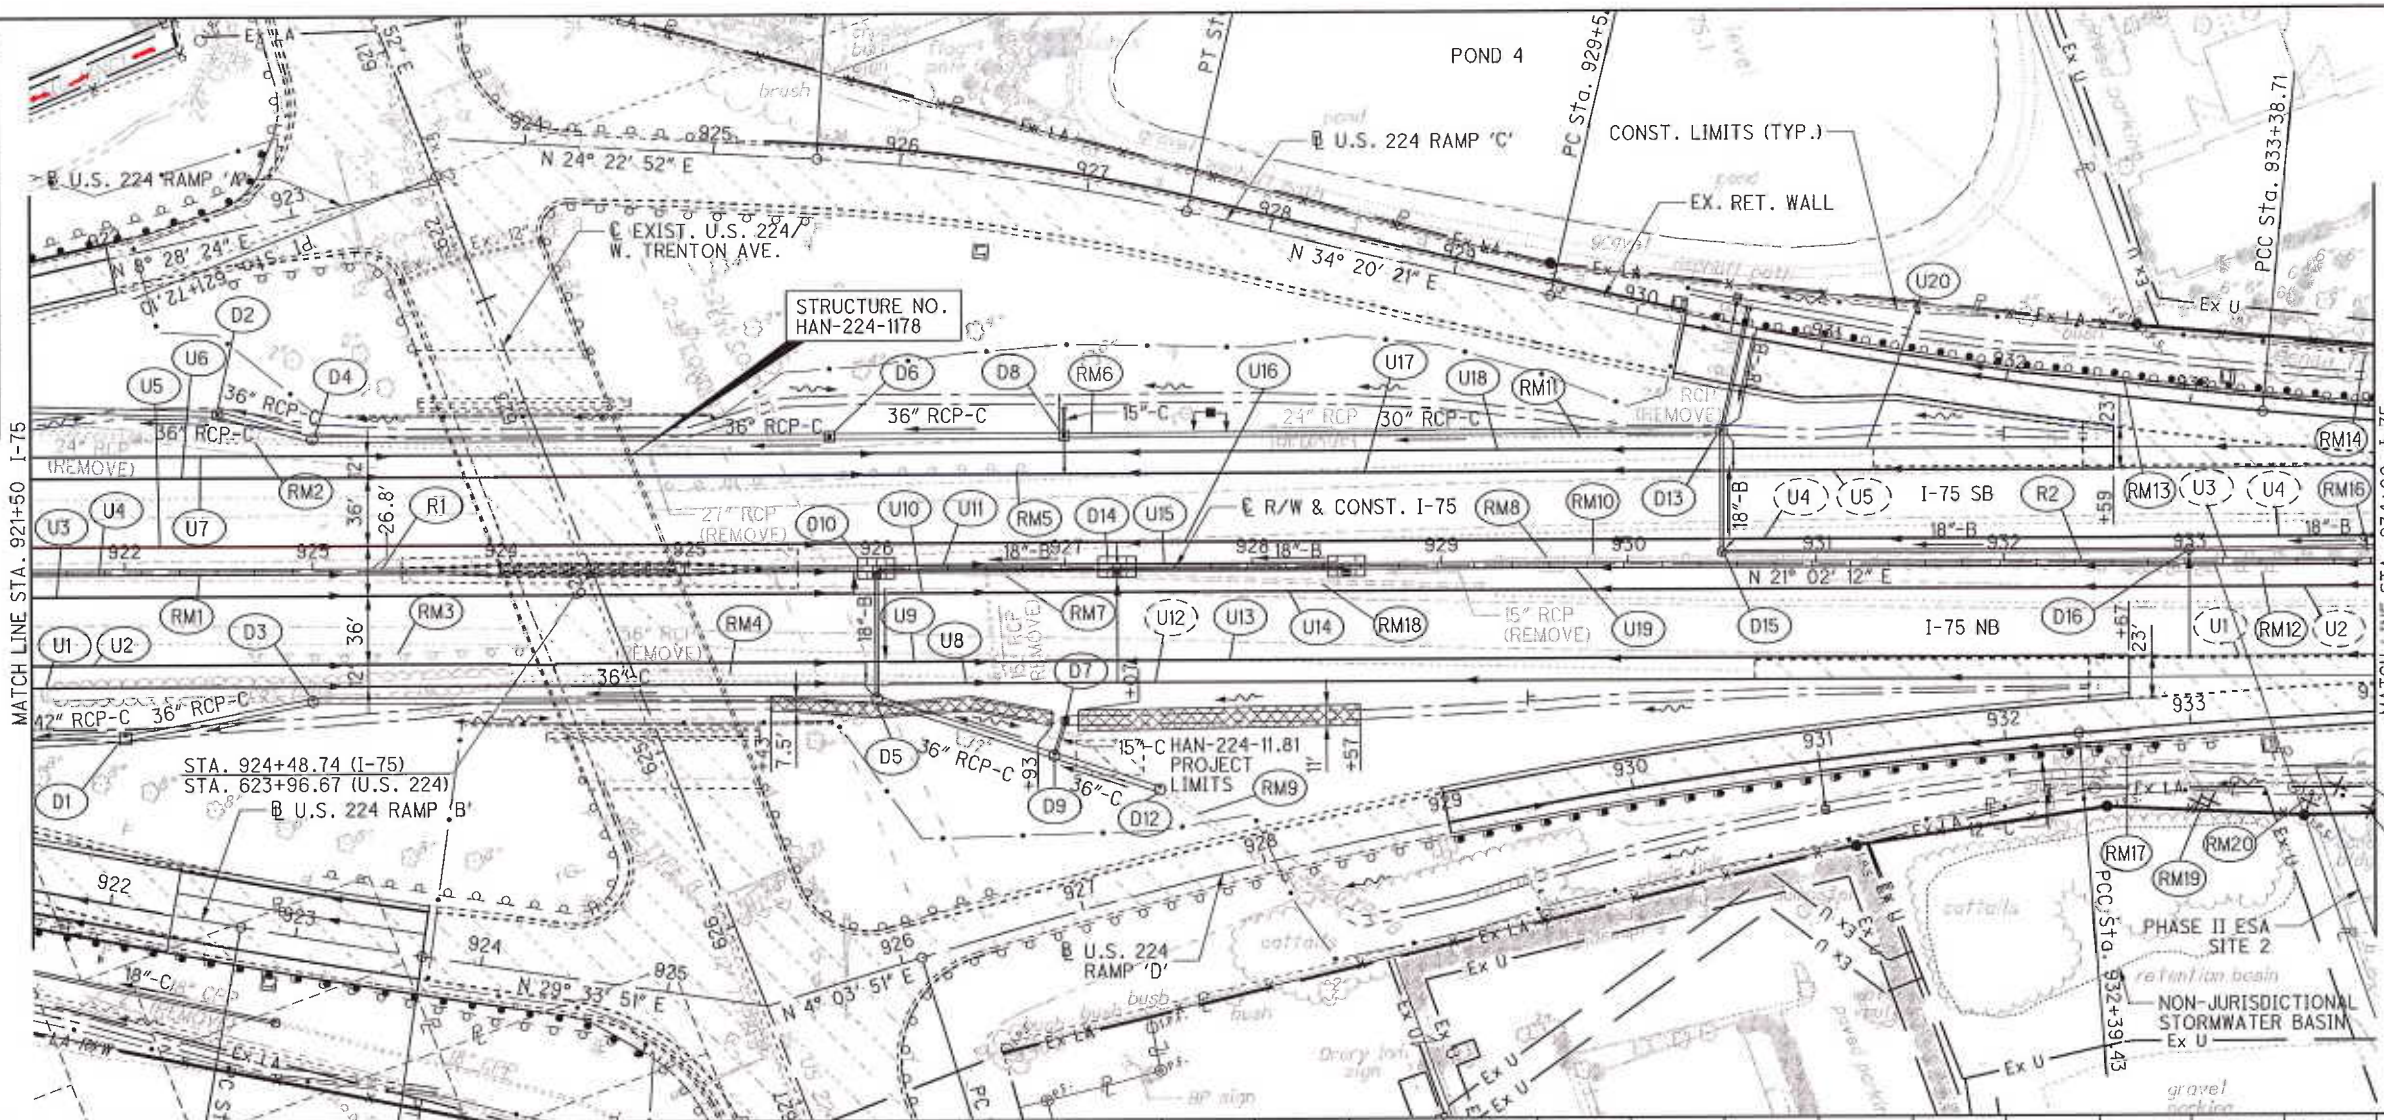

NOTE:  
 EXISTING TOPD WITHIN THE LIMITS OF THE HAN-224-11.81 PROJECT (PID: 84557): SHOWN ARE BASED ON BID PLANS CONTRACTOR TO VERIFY AS BUILT CONDITONS.



PLAN AND PROFILE - I-75  
 STA. 921+50 TO STA. 934+00

HAN-75-14.39

501  
 2034

T:\Projects\HAN\87005\roadway\sheet\87005GF016.dgn 21-AUG-2014 2:10AM redderj