



DATE: 19-Nov-09 10:49
 FILE: J:\B\Job\6087 MAH-170-4.80B\Plan_Sheets\Microstation_DGN\6087_CPA.dgn
 SCALE: 1" = 20'

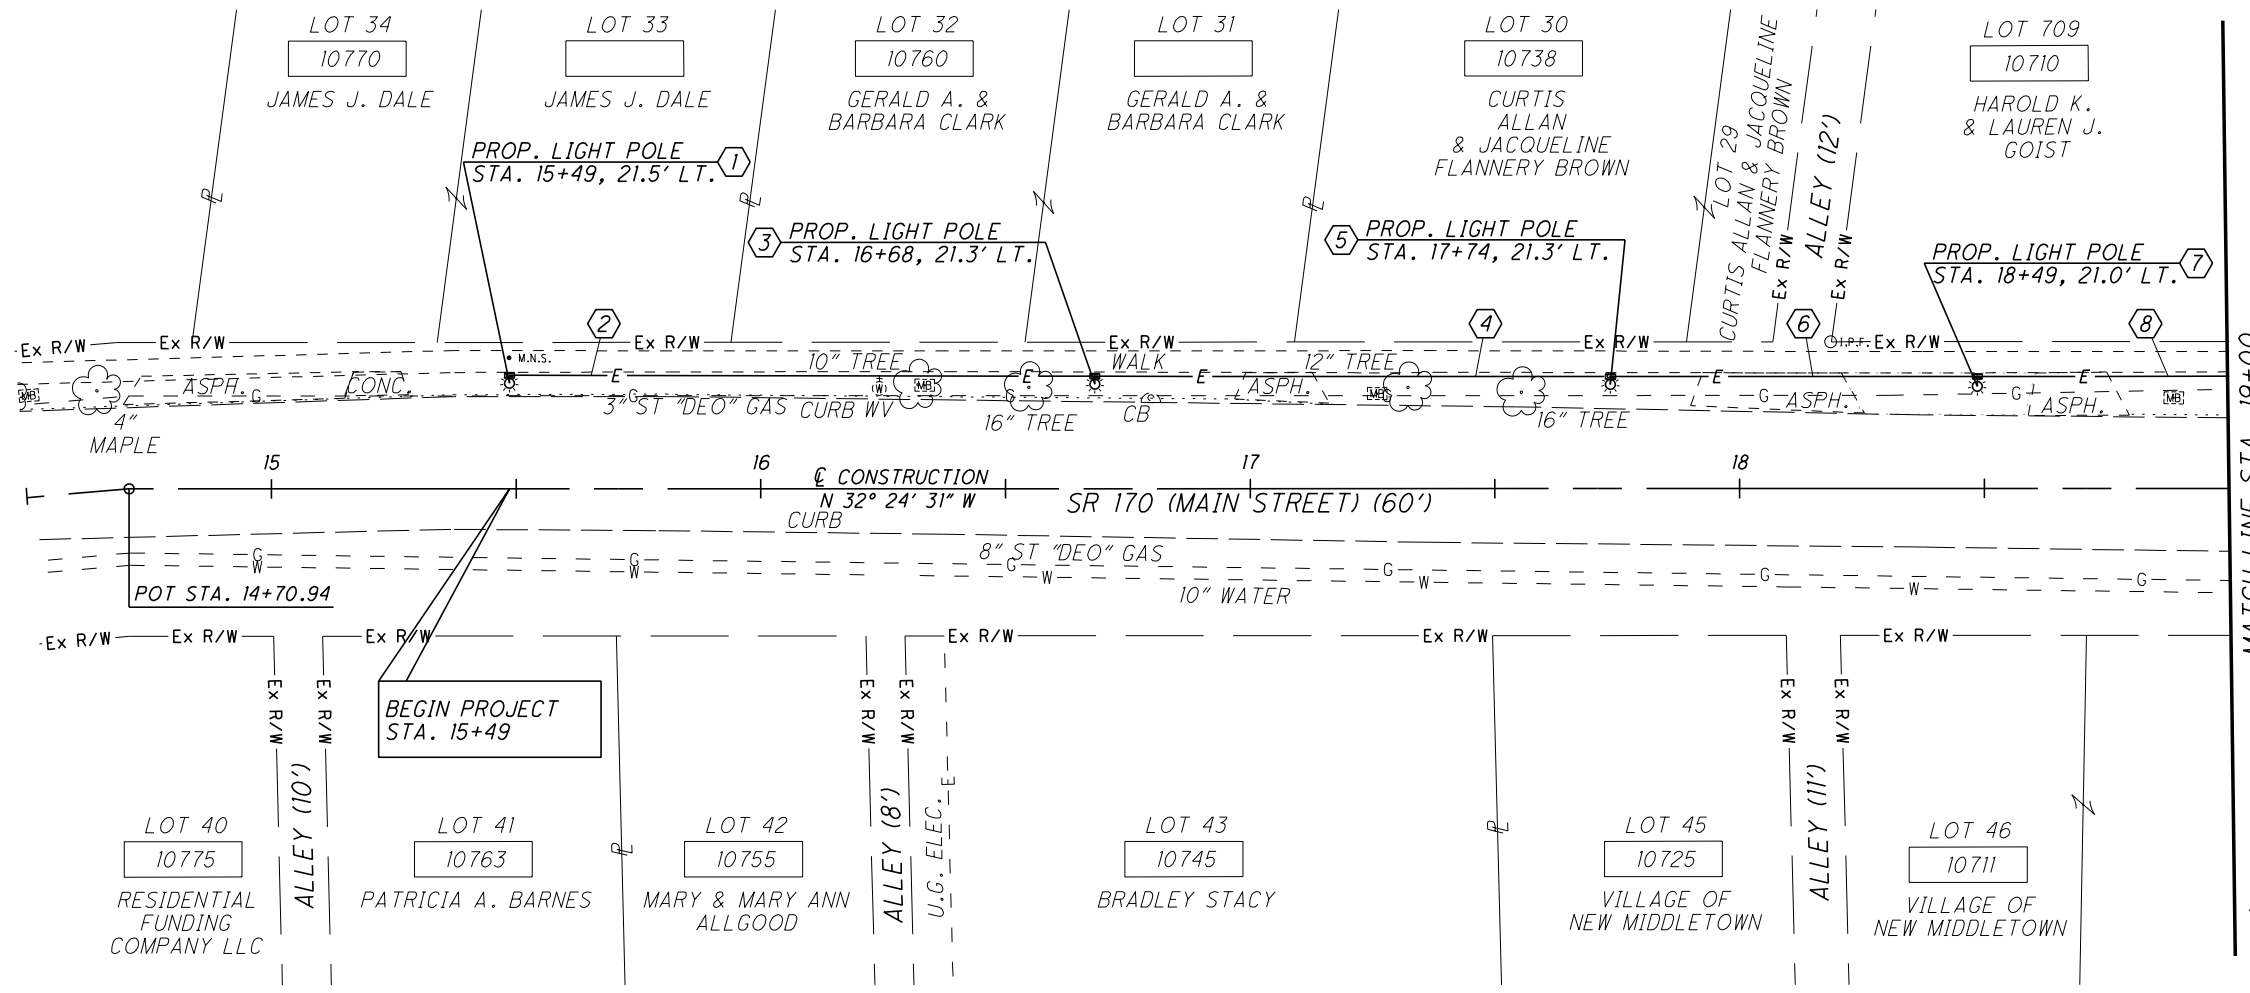

MATCH LINE STA. 19+00

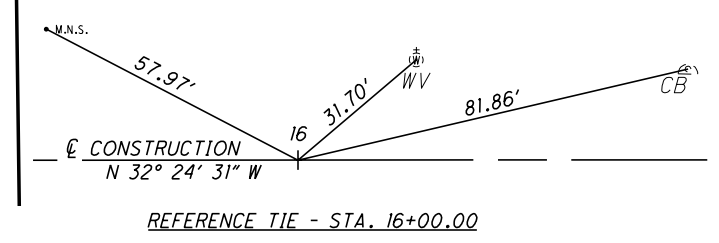

LEGEND

PROPOSED LIGHT POLE

PROPOSED JUNCTION BOX


PROPOSED CONDUIT

CROSS REFERENCES

SHEET NO.	DESCRIPTION
4	SUB-SUMMARY
9	LIGHTING DETAILS





LIGHTING PLAN
 STA. 14+50 TO STA. 23+50

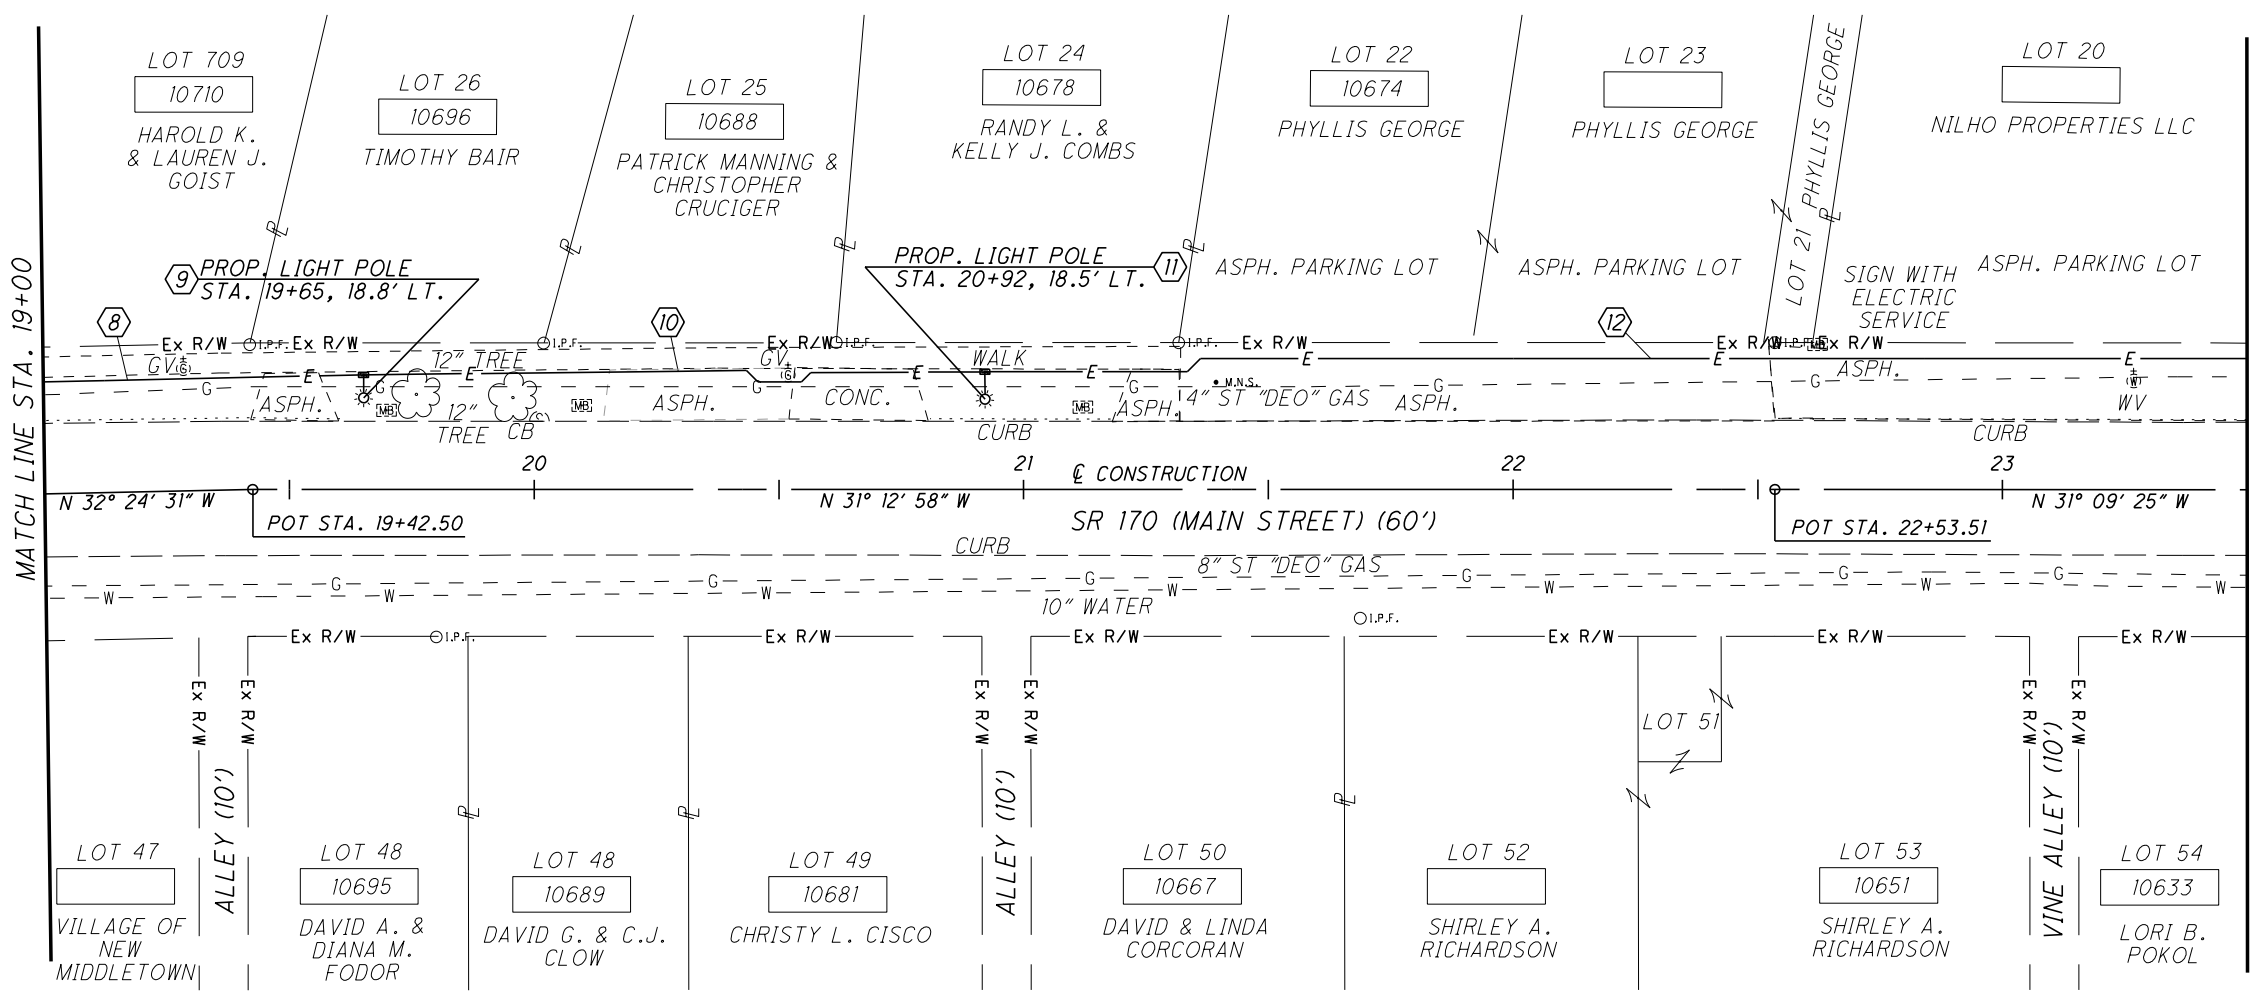

MATCH LINE STA. 19+00

MATCH LINE STA. 23+50

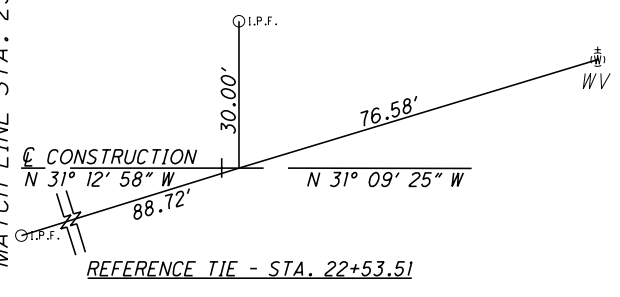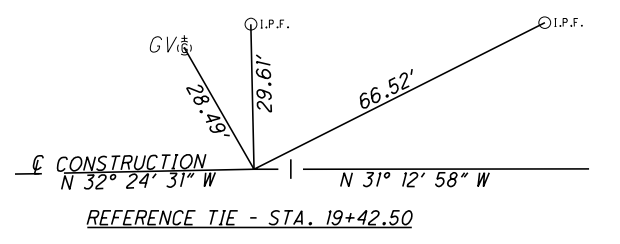

MAH-170-4.80