


Luminaire Schedule									
Symbol	Qty	Label	Arrangement	LLF	Description	Tag	Lum. Watts		
⊙	11	E	GROUP	0.950	1A-1914LED-RLM431-1L40T3-MDL06-A (6' ARM 16.5' MH)/1AM-1912-XRLED-9L35T5-MDL14-A3 (2' ARM 18' MH) POLEN.A.				


Calculation Summary									
Label	Description	CalcType	Units	Avg	Max	Min	Avg/Min	Max/Min	
CalcPts_1		Illuminance	Fc	1.13	4.82	0.11	10.27	43.82	

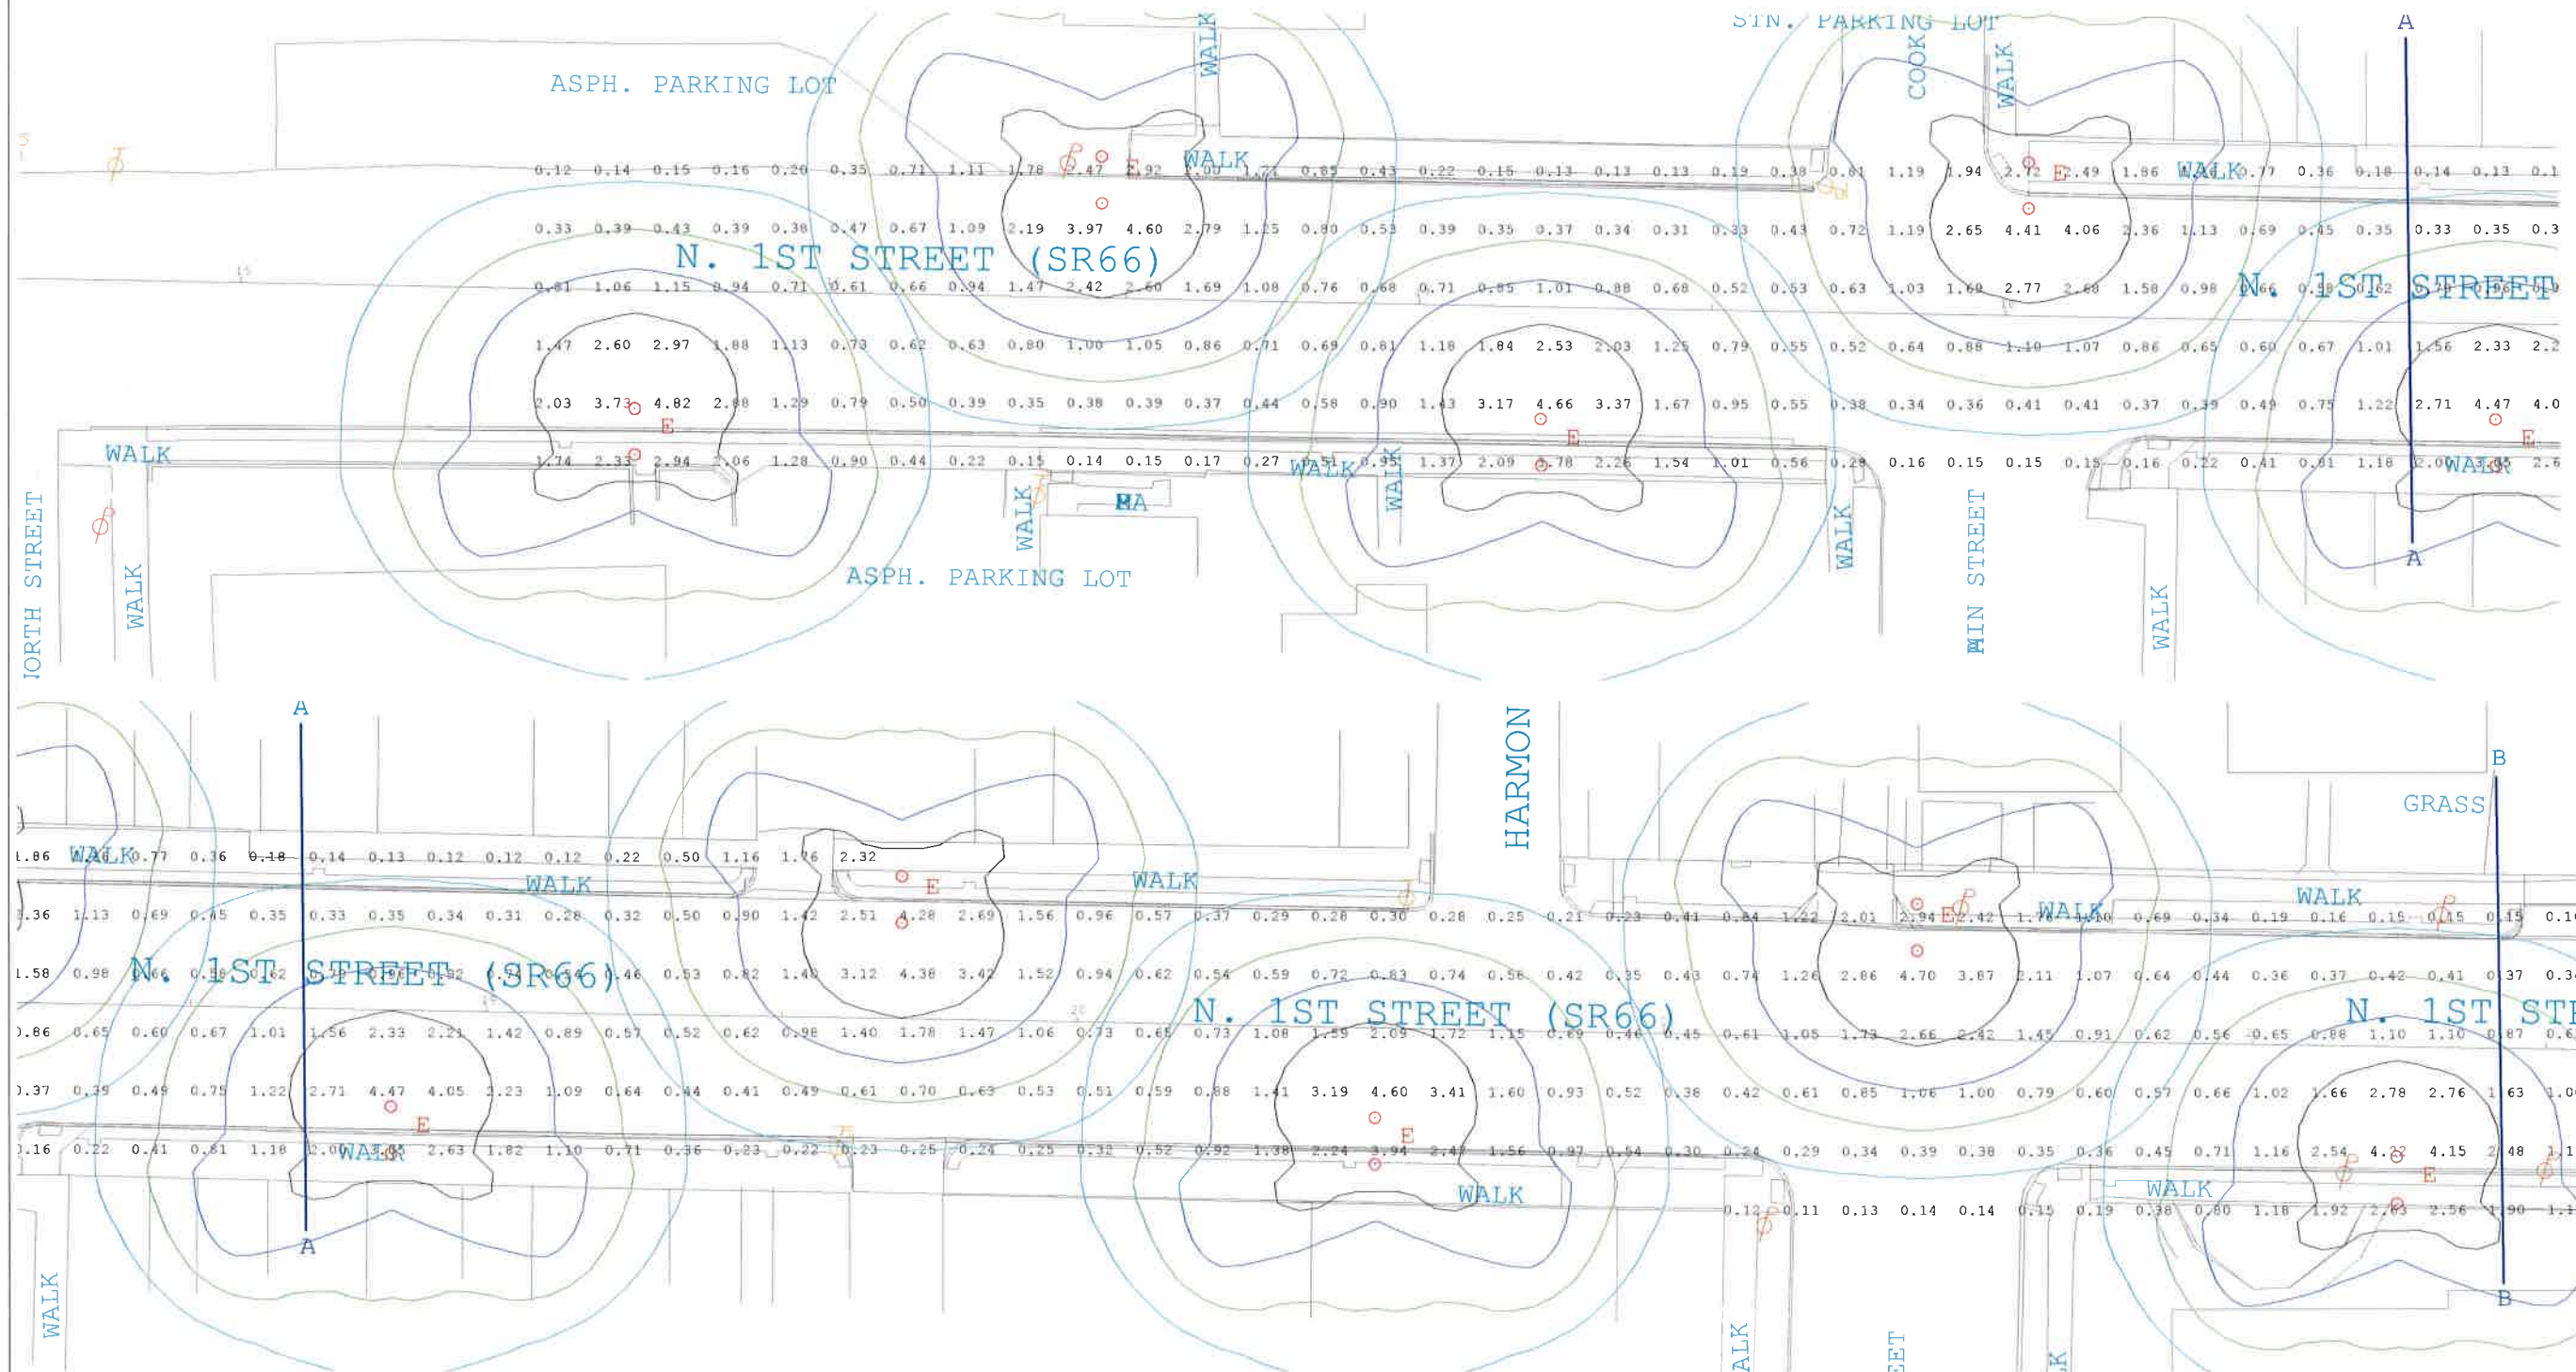

#	Date	Comments
B	01/03/20	CHANGED MATTAGE OF 1914

Drawn By: MR
Drawing #: 3788
Date: 4/3/2020
Scale: 1=30

OAKWOOD STREETSCAPE
OAKWOOD, OH

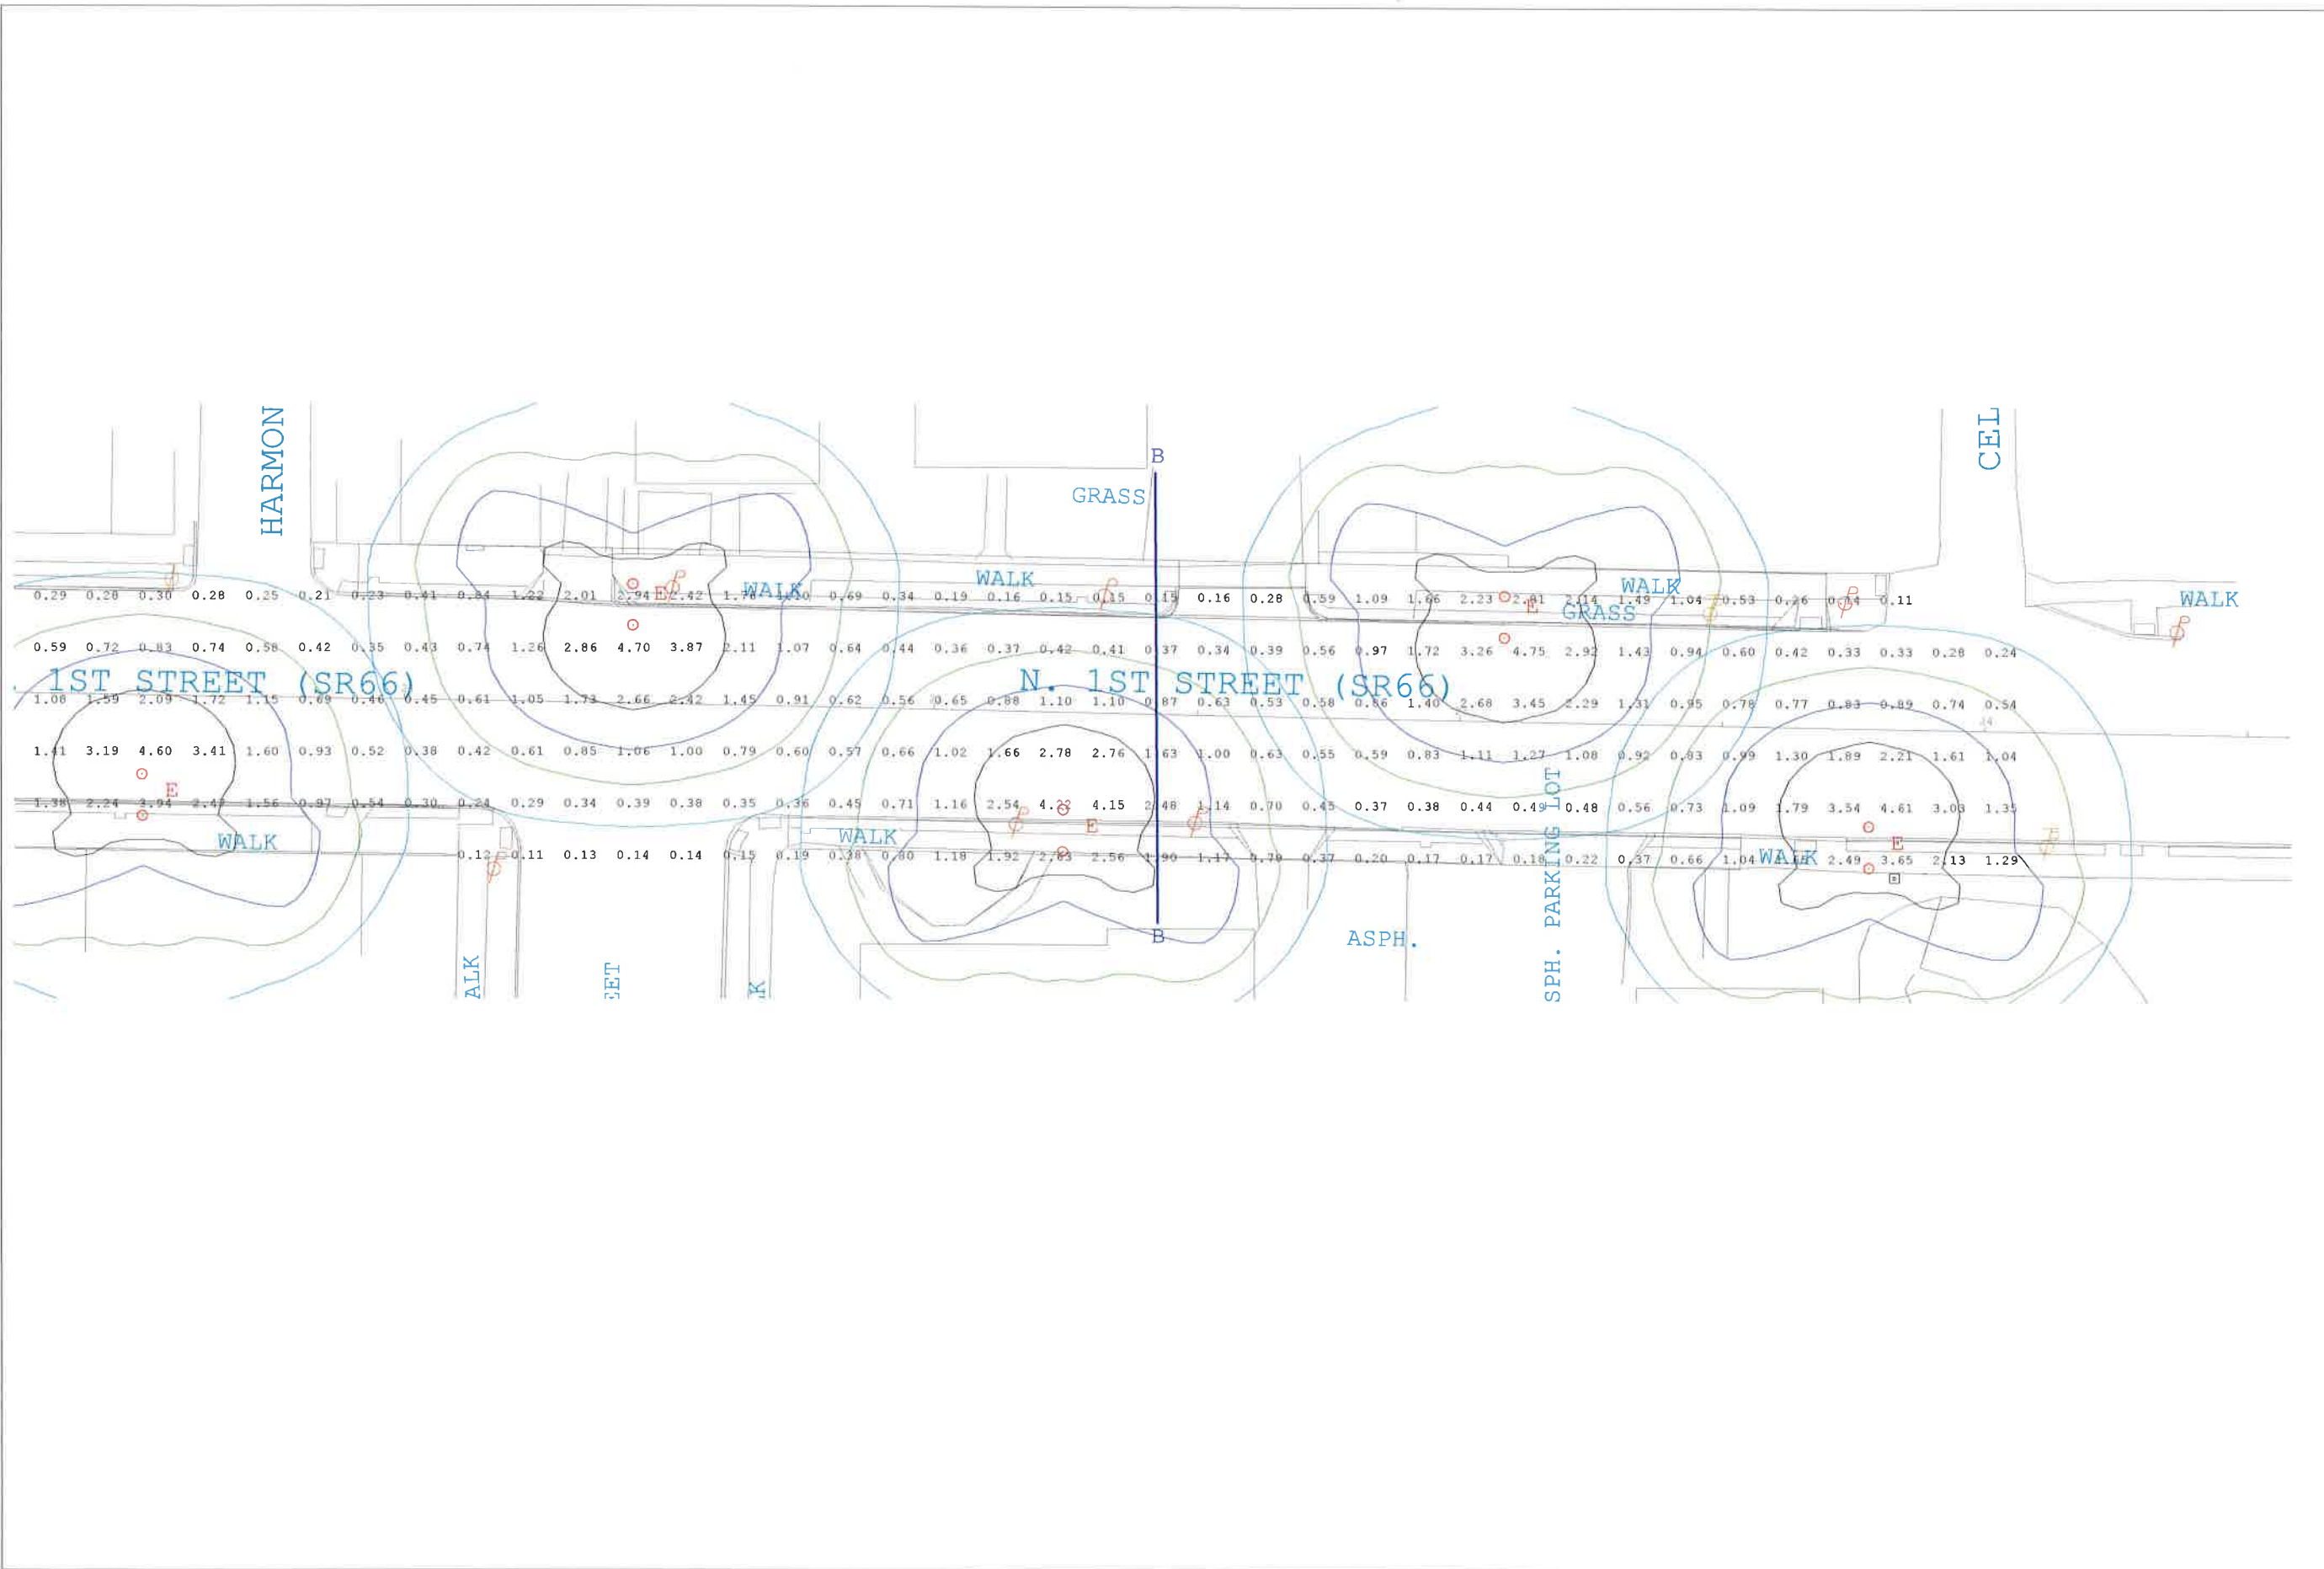

#	Date	Comments
B	04/03/20	CHANGED WATTAGE OF 1914

Revisions

Drawn By: MR  
Drawing #: 3788  
Date: 4/3/2020  
Scale: 1=30