


61-7

FED. RD. DIVISION	STATE	PROJECT
2	OHIO	

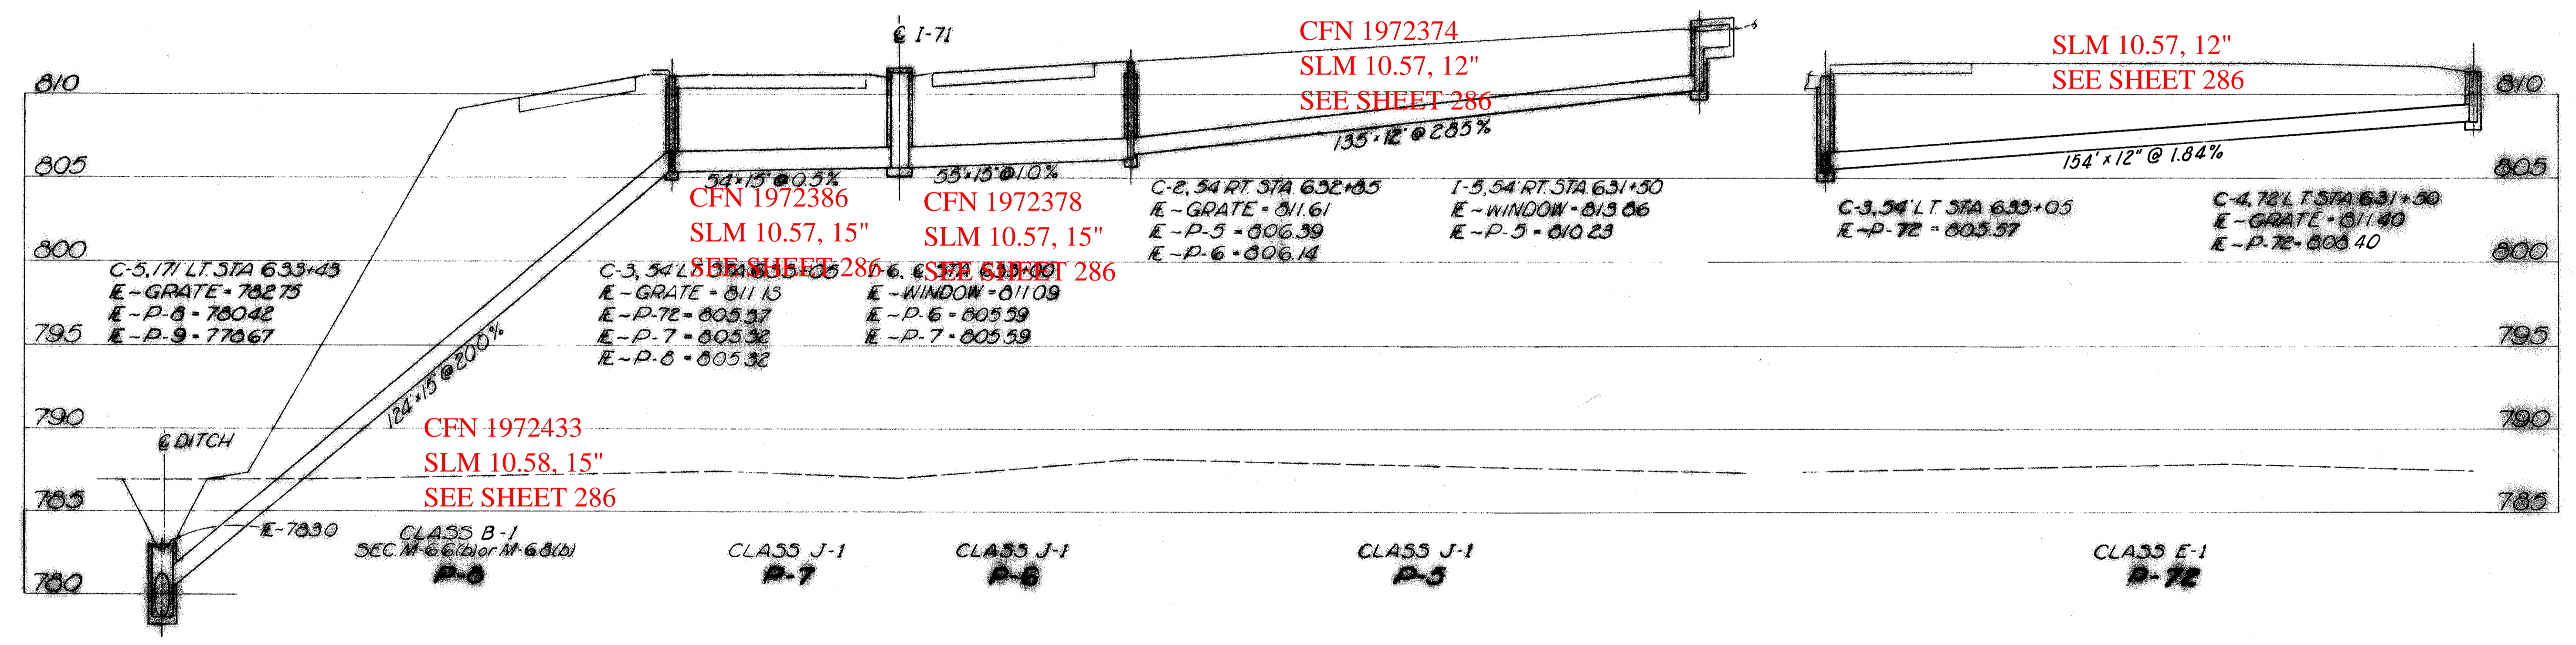

		ESTIMATED QUANTITIES										
PIPE REFERENCE	STRUCTURES INCLUDED	CLASS E-1 12"	I-1			CLASS B-1 Sec. M-6(b) or M-6(b) 15"	I-B				SEE SHEET NO.	
			CLASS J-1		CATCH BASINS		INLETS		SPECIAL			
			12"	15"	STANDARD		STANDARD	STANDARD		SPECIAL		
P-5	I-5			135					1			
P-6	C-2			55				1				
P-7	I-6			54							1	
P-8	C-3							1				
P-7E	C-4	154			124							
TOTALS		154		135	109	124	1	2	1		1	

FOR DRAINAGE PLAN -
SEE SHEET NO. 286.