


CLASS E-1
P-9
 SLM 10.60, 36"
 SEE SHEET 286

CLASS E-1
P-10
 SLM 10.71, 36"
 SEE SHEET 286

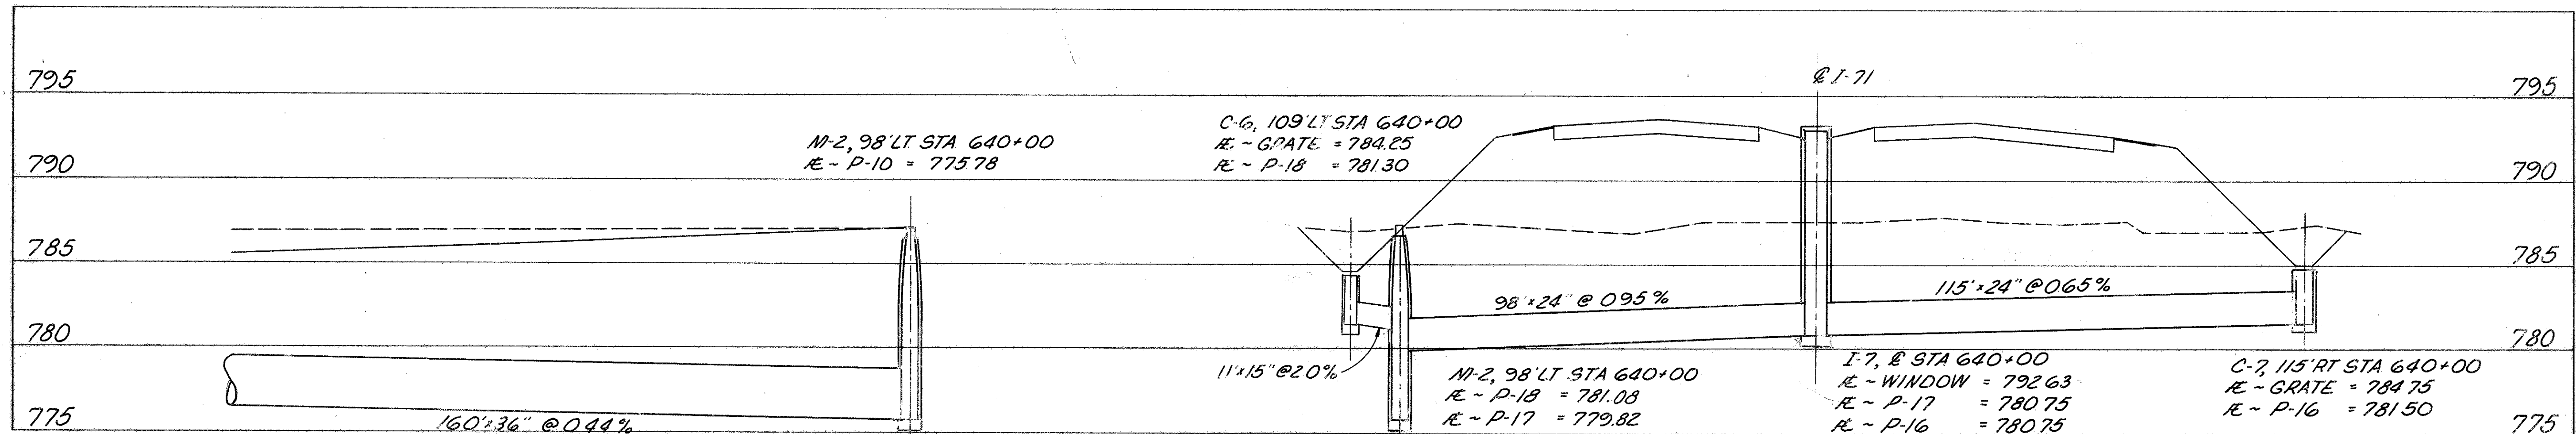

CLASS E-1
P-10
 SLM 10.71, 36"
 SEE SHEET 286

CLASS E-1
P-18
 SLM 10.71, 15"
 SEE SHEET 286

CLASS J-1
 SEC M-6 G(b) or M-6 B(b)
P-17
 CFN 1972389
 SLM 10.71, 24"
 SEE SHEET 286

CLASS J-1
 SEC M-6 G(b) or M-6 B(b)
P-16
 CFN 1972383
 SLM 10.71, 24"
 SEE SHEET 286

FOR DRAINAGE PLAN -
 SEE SHEET NO. 286.

		ESTIMATED QUANTITIES							SEE SHEET NO.
PIPE REFERENCE	STRUCTURES INCLUDED	I-1		I-2			MANHOLES STANDARD		
		CLASS E-1		CATCH BASINS STANDARD		INLETS SPECIAL			
		15"	36"	Nº	Nº	Nº			
P-9	C-5		136						
P-10	M-1		320						
P-16	C-7				1				
P-17	I-7					1			
P-18	C-6				1				
TOTALS		11	656	2/3	1	2	1	1	