


SLM 11.00, 42"
 SEE SHEET 287
 550' x 42" @ 0.46 %
 CLASS B-1
 SEC. M-6.6 (b).
 P-13

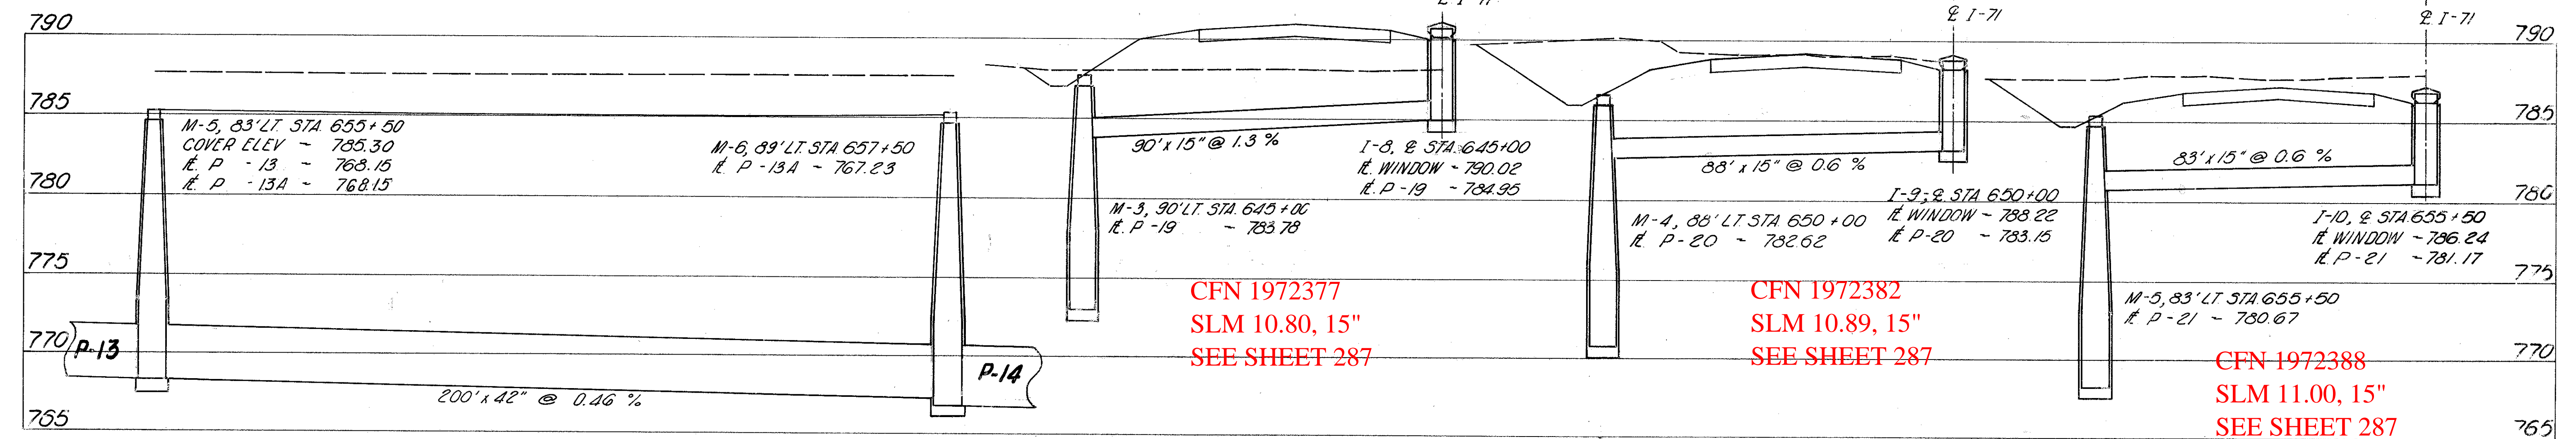

CLASS B-1
 SEC. M-6.6 (c)
 P-13A
 SLM 11.04, 42"
 SEE SHEET 287

CFN 1972377
 SLM 10.80, 15"
 SEE SHEET 287

CFN 1972382
 SLM 10.89, 15"
 SEE SHEET 287

CFN 1972388
 SLM 11.00, 15"
 SEE SHEET 287

CLASS J-1
 P-19

CLASS J-1
 P-20

CLASS J-1
 P-21

CHECKED BY: _____
 INKED BY: _____
 DATE: _____
 PLOTTED BY: _____
 DATE: _____
 DESCRIPTION: _____
 QUANTITY: _____

		ESTIMATED QUANTITIES						SEE SHEET NO.
PIPE REFERENCE	STRUCTURES INCLUDED	I - 1		I - 8		MANHOLES		
		CLASS B-1		INLETS			STD. #2	
		SEC. M-6.6A	SEC. M-6.6B	SPECIAL				
15"	42"	42"	2-6	2-8				
LIN. FT.	LIN. FT.	LIN. FT.	EACH	EACH	EACH			
P-13	M-4							
P-13A	M-5	550				1		
P-19	I-8		200			1		
P-20	I-9	90			1			
P-21	I-10	83		1				
		83						
				1				
TOTALS		261	550	200	1	2	2	

FOR DRAINAGE PLAN -
 SEE SHEET NOS 286 & 287.