


CFN 1972325
 SLM 12.27, 12"
 SEE SHEET 293

CLASS J-1
 P-102
 CFN 1972301
 SLM 12.27, 18"
 SEE SHEET 293

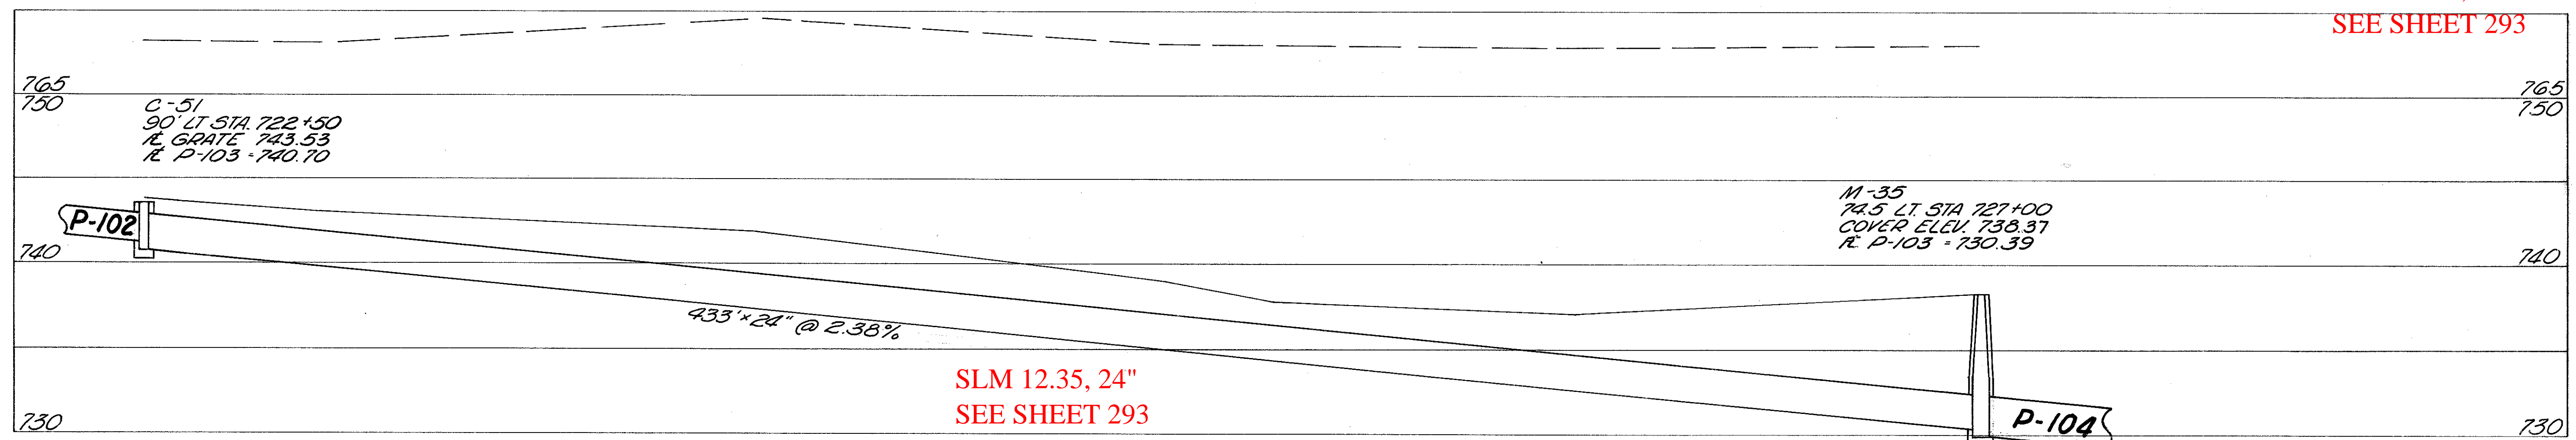

SLM 12.35, 24"
 SEE SHEET 293

CLASS B-1
 P-103

DESCRIPTION	DATE	BY	CHECKED	DATE
PLOTTED	DATE	BY	DATE	
QUANTITY				

		ESTIMATED QUANTITIES						SEE SHEET NO.
PIPE REFERENCE	STRUCTURES INCLUDED	I-1			I-B			
		CLASS B-1	CLASS J-1	CLASS J-1	SPECIAL INLETS	STD. NO. 5 C.B.		
		24"	12"	18"	Nº2-12, Nº2-14			
		L.F.	L.F.	L.F.	EACH	EACH	EACH	
P-101	I-21							
P-102	I-22		450		1			
P-103	C-51	433		90		1		
TOTALS		433	450	90	1	1	1	

FOR DRAINAGE PLAN -
 SEE SHEET NO. 293.