


P-92
 CLASS E-1
 SEC. M-6.6(c) OR M-6.8(b)

CFN 1972393
SLM 11.78, 24"
SEE SHEET 291
P-73
 CLASS B-1
 SEC. M-6.6(d)

P-74
 CLASS J-1
 SEC. M-6.6(d)

CFN 1972332
SLM 11.85, 27"
SEE SHEET 291

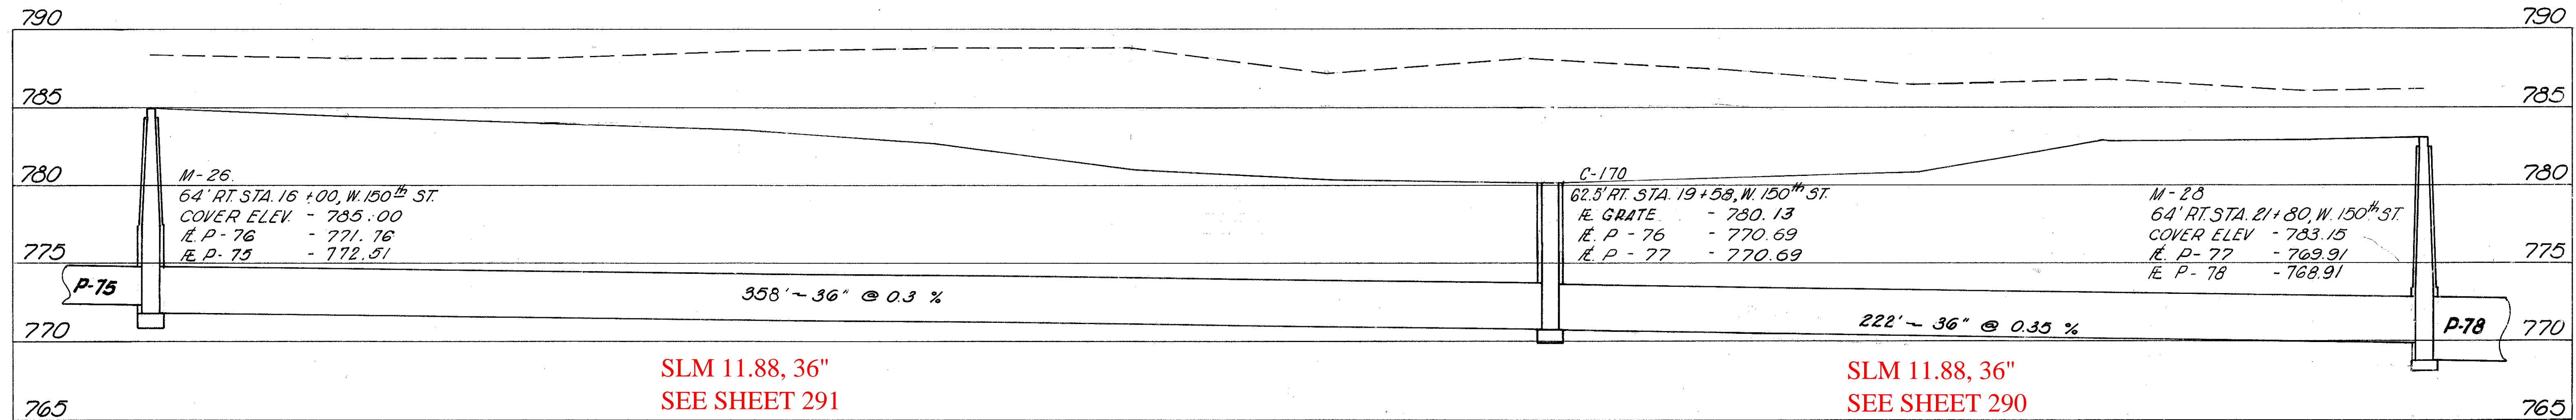

SLM 11.88, 36"
SEE SHEET 291

SLM 11.88, 36"
SEE SHEET 290

P-76
 CLASS B-1
 SEC. M-6.6(b) OR M-6.8(b)

P-77
 CLASS B-1
 SEC. M-6.6(b) OR M-6.8(b)

PIPE REFERENCE	STRUCTURES INCLUDED	ESTIMATED QUANTITIES							SEE SHEET NO.
		I-1		I-3		I-8			
		CLASS B-1	CLASS E-1	CLASS J-1	STANDARD NO.		2-4 C.B. MOD. W/O SIDE WIND		
		SEC. M-6.6(b) OR M-6.8(b)	SEC. M-6.6(c) OR M-6.8(b)	SEC. M-6.6(d)	5 CATCH BASIN	2 MANHOLE			
LIN. FT.	LIN. FT.	LIN. FT.	LIN. FT.	EACH	EACH	EACH			
P-73	C-40			140					
P-74	M-25				335				
P-76	M-26	358							
P-77	C-170	222							
P-92	C-42		114						
M-27 DELETED FROM CONTRACT									
TOTALS		580	114	140	335	2	2	1	

FOR DRAINAGE PLAN ~
 SEE SHEET NO. 290 & 291