

STATE OF OHIO
DEPARTMENT OF HIGHWAYS

FED. RD. DIVISION	STATE	PROJECT
2	OHIO	

CUYAHOGA COUNTY
CUY-71-13.68268
2791
12

RIGHT OF WAY

CUY. 71-13.68

CITY OF CLEVELAND
CUYAHOGA COUNTY

I-71-5 (18) 247

LIMITED ACCESS

This improvement is especially designed for through traffic and has been declared a limited access highway or freeway by action of the Director of Highways in accordance with the provisions of Section 5511.02 of the Revised Code of Ohio.

1963 SPECIFICATIONS

The standard specifications of the State of Ohio Department of Highways, including changes and supplemental specifications listed in the proposal shall govern this improvement.

The right of way for this improvement will be provided by the State of Ohio.

I hereby approve these plans and declare that the making of this improvement will not require the closing of the highway to traffic and that provisions for the maintenance and safety of traffic will be as set forth on these plans and estimates.

Approved _____

Date _____ Division Deputy Director

Approved _____

Date _____ Engineer of Bridges

Approved _____

Date _____ Engineer of Location and Design

Approved _____

Date _____ Deputy Director of Design and Construction

Approved _____

Date _____ Deputy Director of Right of Way

Approved _____

Date _____ Deputy Director of Planning and Programming

Approved _____

Date _____ First Assistant Director

Approved _____

Date _____ Director of Highways

Approved _____ *Louis E. Drasler*Date 10/5/64 Director of Public Service, City of Cleveland, Ohio

CONVENTIONAL SIGNS


County Line	-----
Corporation Line	-----
Center Line	-----
Township Line	-----
Section Line	-----
Fence Line	-----
Guard Rail (existing)	-----
Guard Rail (proposed)	-----
Railroad	-----
Power Poles	-----
Telephone Poles	-----
Trees or stumps (existing)	-----
Trees or stumps (to be removed)	-----
L/A	-----

INDEX SHEETS

Title Sheet	1	Bellaire Road	88-102
Schematic Plan	2	Memphis Avenue	103-116
Typical Section	3-7	Pavement Details	117-119
General Notes	8-9	Culverts	120-122
General Summary	10-13	Pipe Profiles	123-135
Quantities & Sub-Summary	14	Miscellaneous Details	136-142
Calculation Sheets	15-16	Utility Plans	142-168
Superelevation Tables	17-18	Landscaping Plans	169-175
Plan Sheets	19-24	Signing Plans	176-189
Profile Sheets	25-32	Lighting Plans	190-201
Emery Hirst	33	Structure Over 20' Span	202-267
Cross Sections	34-87	Right Of Way	268-279
		Soils Profiles	1-5

LINE DATA

Begin Project	Station 797+00
End Project	Station 870+00 E.B.
Net Length For Project	= 7300 Lin. Ft. or 1.38 Mi.
Add For Approaches	= 3970 Lin. Ft. (See Sheet 8)
Net Length Of Work	= 11,270 Lin. Ft. or 2.13 Mi.

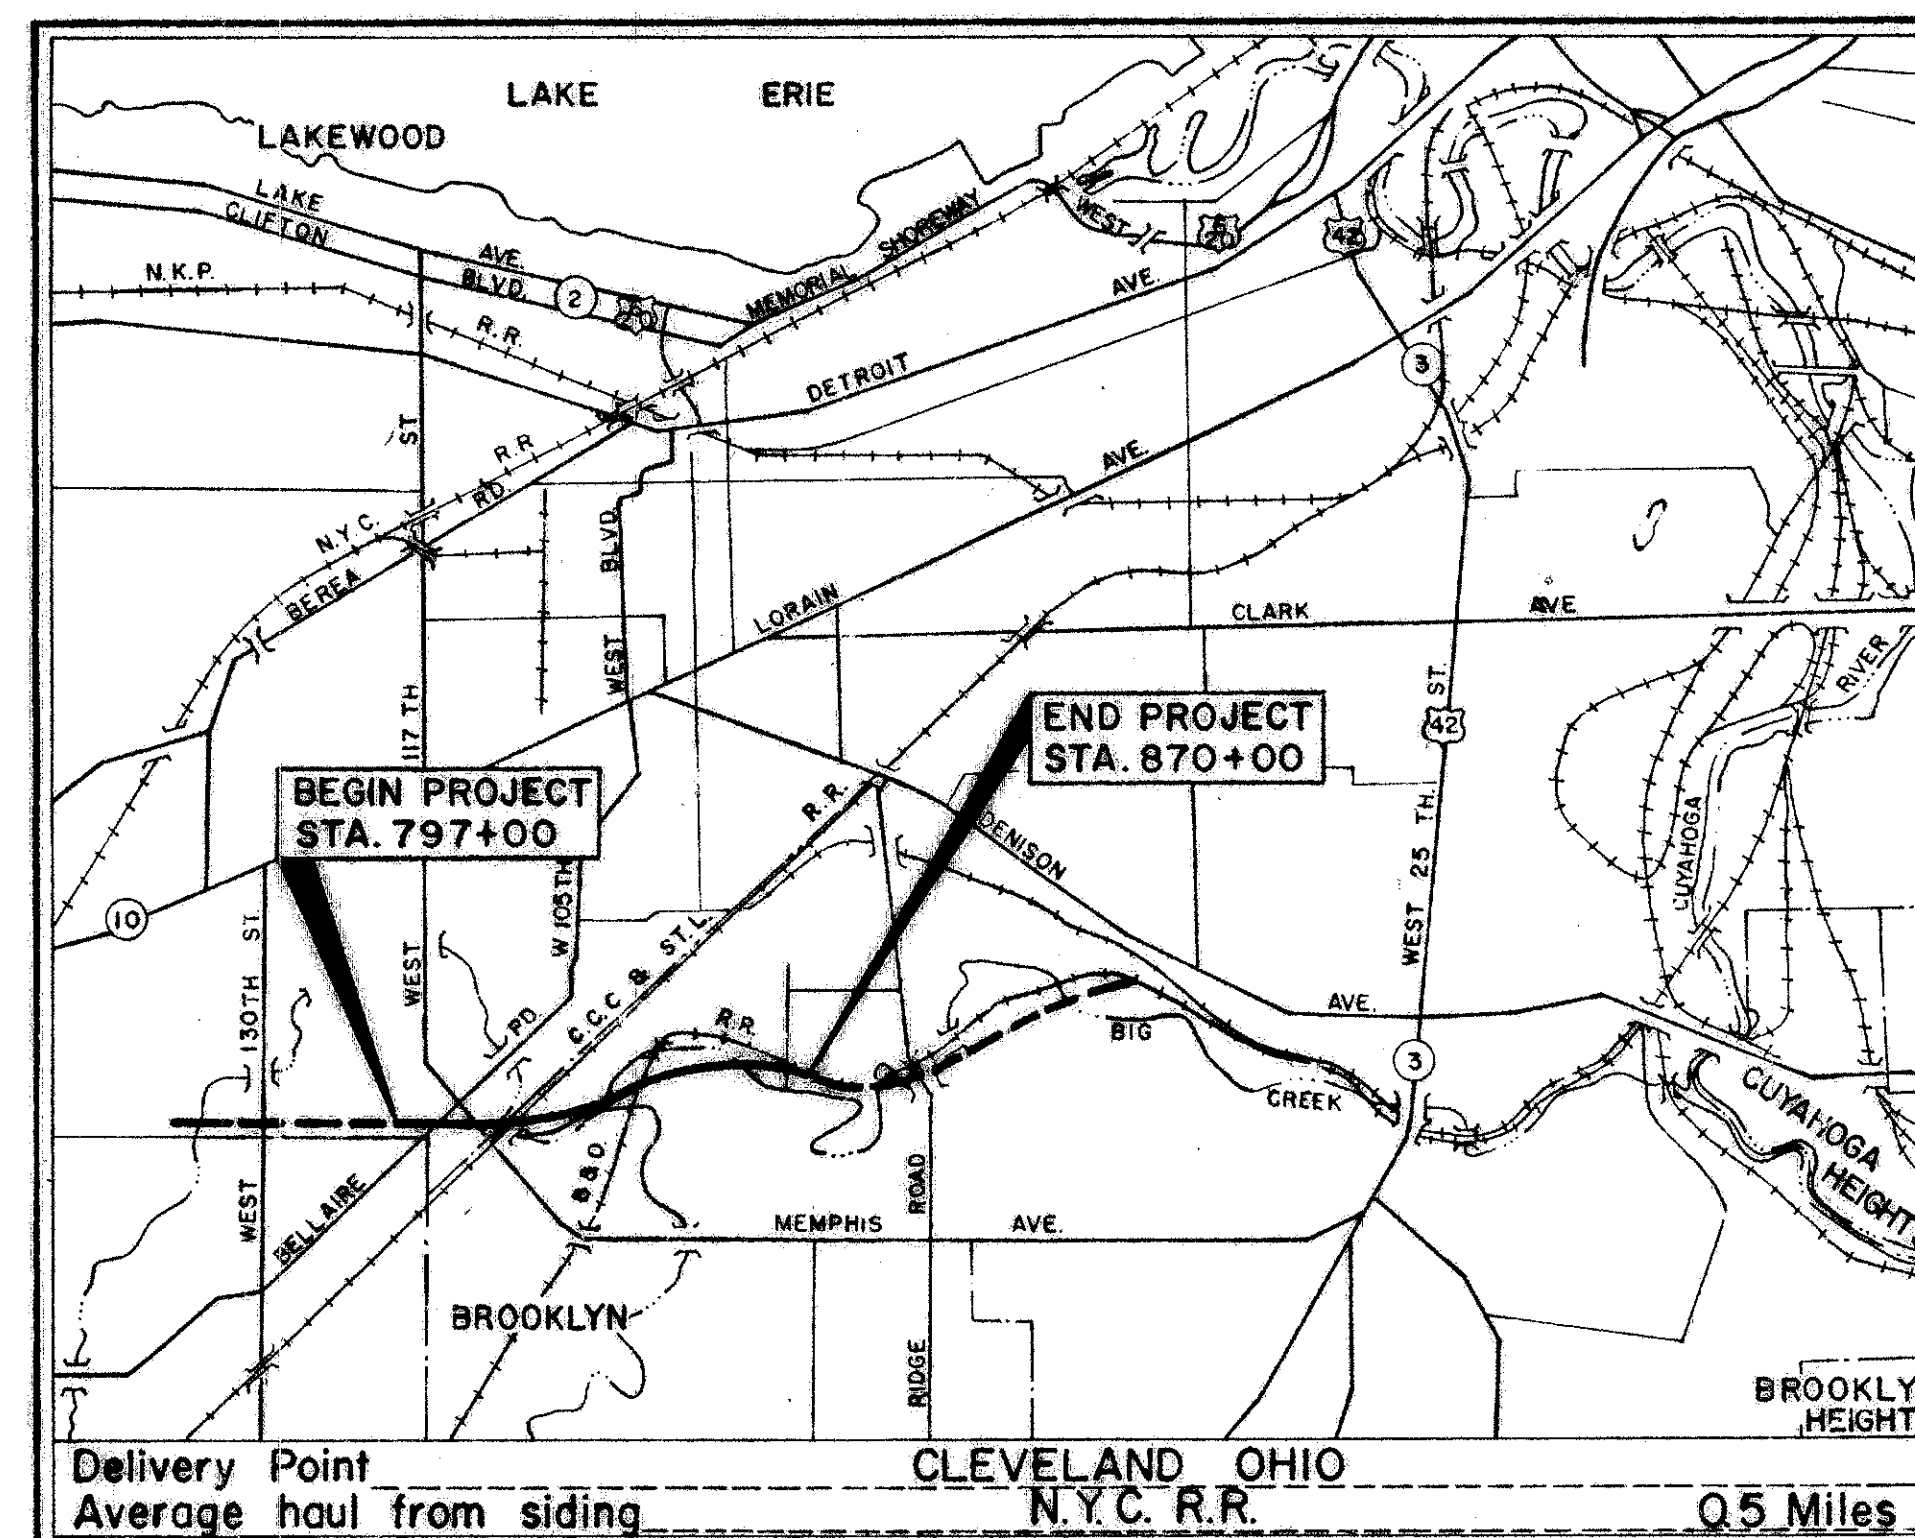

LOCATION MAP

SCALE OF MILES

Portion to be improved
Future Improvement

SCALE

Plan _____ 1"
Profile _____ 1"
X-Sections _____ 1"

Supplemental Prints of Standard Construction Drawings										Supplemental Specifications	
SD-1-63	11-12-63	F-2	2-1-63	BT-70-71	11-15-60	I-8 CB NO. 5	2-1-63	I-15 NO. 2-A	8-17-60	I-124	3-20-61
L-1	4-1-50	F-3	2-1-63	BT-71 R	3-2-53	I-8 MH NO. 1	2-1-63	I-15 NO. 6	2-1-63	CE-101.04	5-22-56
L-3	4-1-50	G-707	4-1-64	HW E	2-1-63	I-8 MH NO. 1A	2-1-63	L-JNO. 1	7-1-55	L-120	1-2-62
L-3A	4-1-50	FACI-1	2-25-64	T-J-1	9-12-60	I-8 MH NO. 2	2-1-63	I-21-23	8-1-56	I-128	7-1-59
RI-1	7-15-58	FACI-2	2-25-64	I-1	11-15-60	I-8 CB NO. 3	2-1-63			I-129	4-5-61
T-35	1-2-56	HW-2	8-1-63	I-8 CB 2-3 & 2-4	2-1-63	I-12	2-1-63				
F-1	2-1-63	HW-3	8-1-63	I-8 CB 2-5 & 2-6	2-1-63	I-15 NO. 1	11-15-60				

File No.	Date of Letting _____ 19
Contract No.	

RACKOFF ASSOCIATES

ENGINEERS
COLUMBUS, OHIO*Melvin Rackoff*
MELVIN RACKOFFDEPARTMENT OF COMMERCE
BUREAU OF PUBLIC ROADS


APPROVED:

DIVISION ENGINEER

DATE

COORDINATE GRID PLAT STA 797+00 TO STA 870+00 JAN 7 1965

PROPERTY MAP

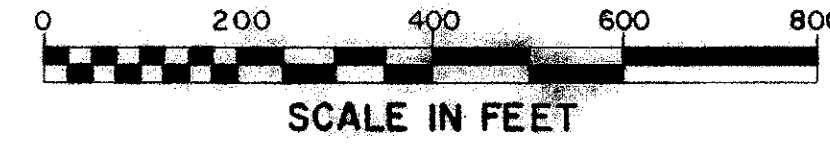

LIMITED ACCESS



FED. RD. DIVISION	STATE	PROJECT
2	OHIO	

CUYAHOGA COUNTY	
CUY-71-13.68	

270
279

3
12

BEGIN PROJECT
CUY-71-13.68
STA. 797+00

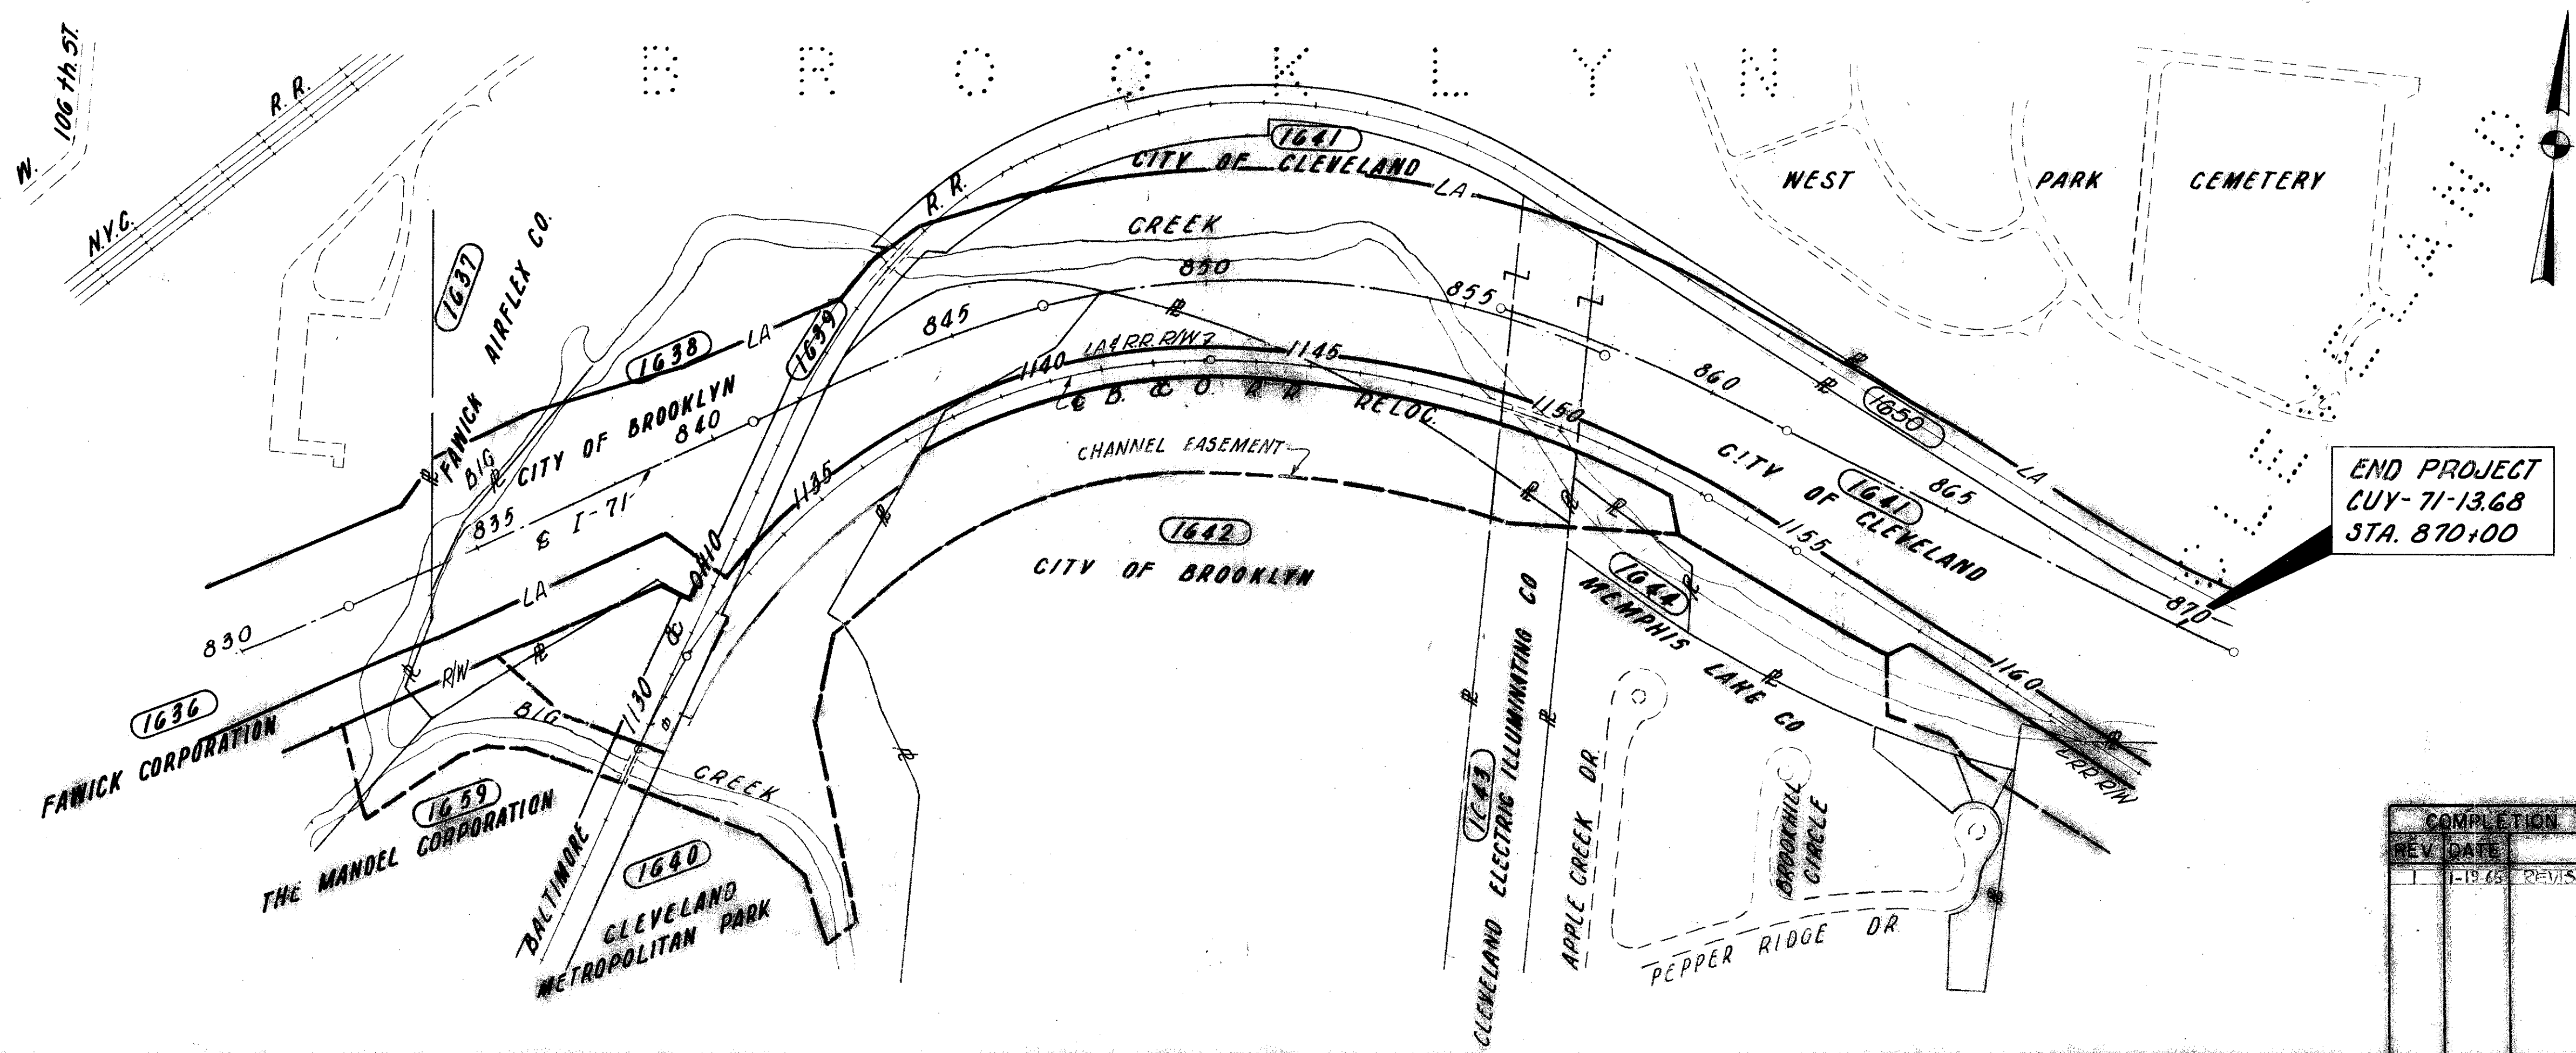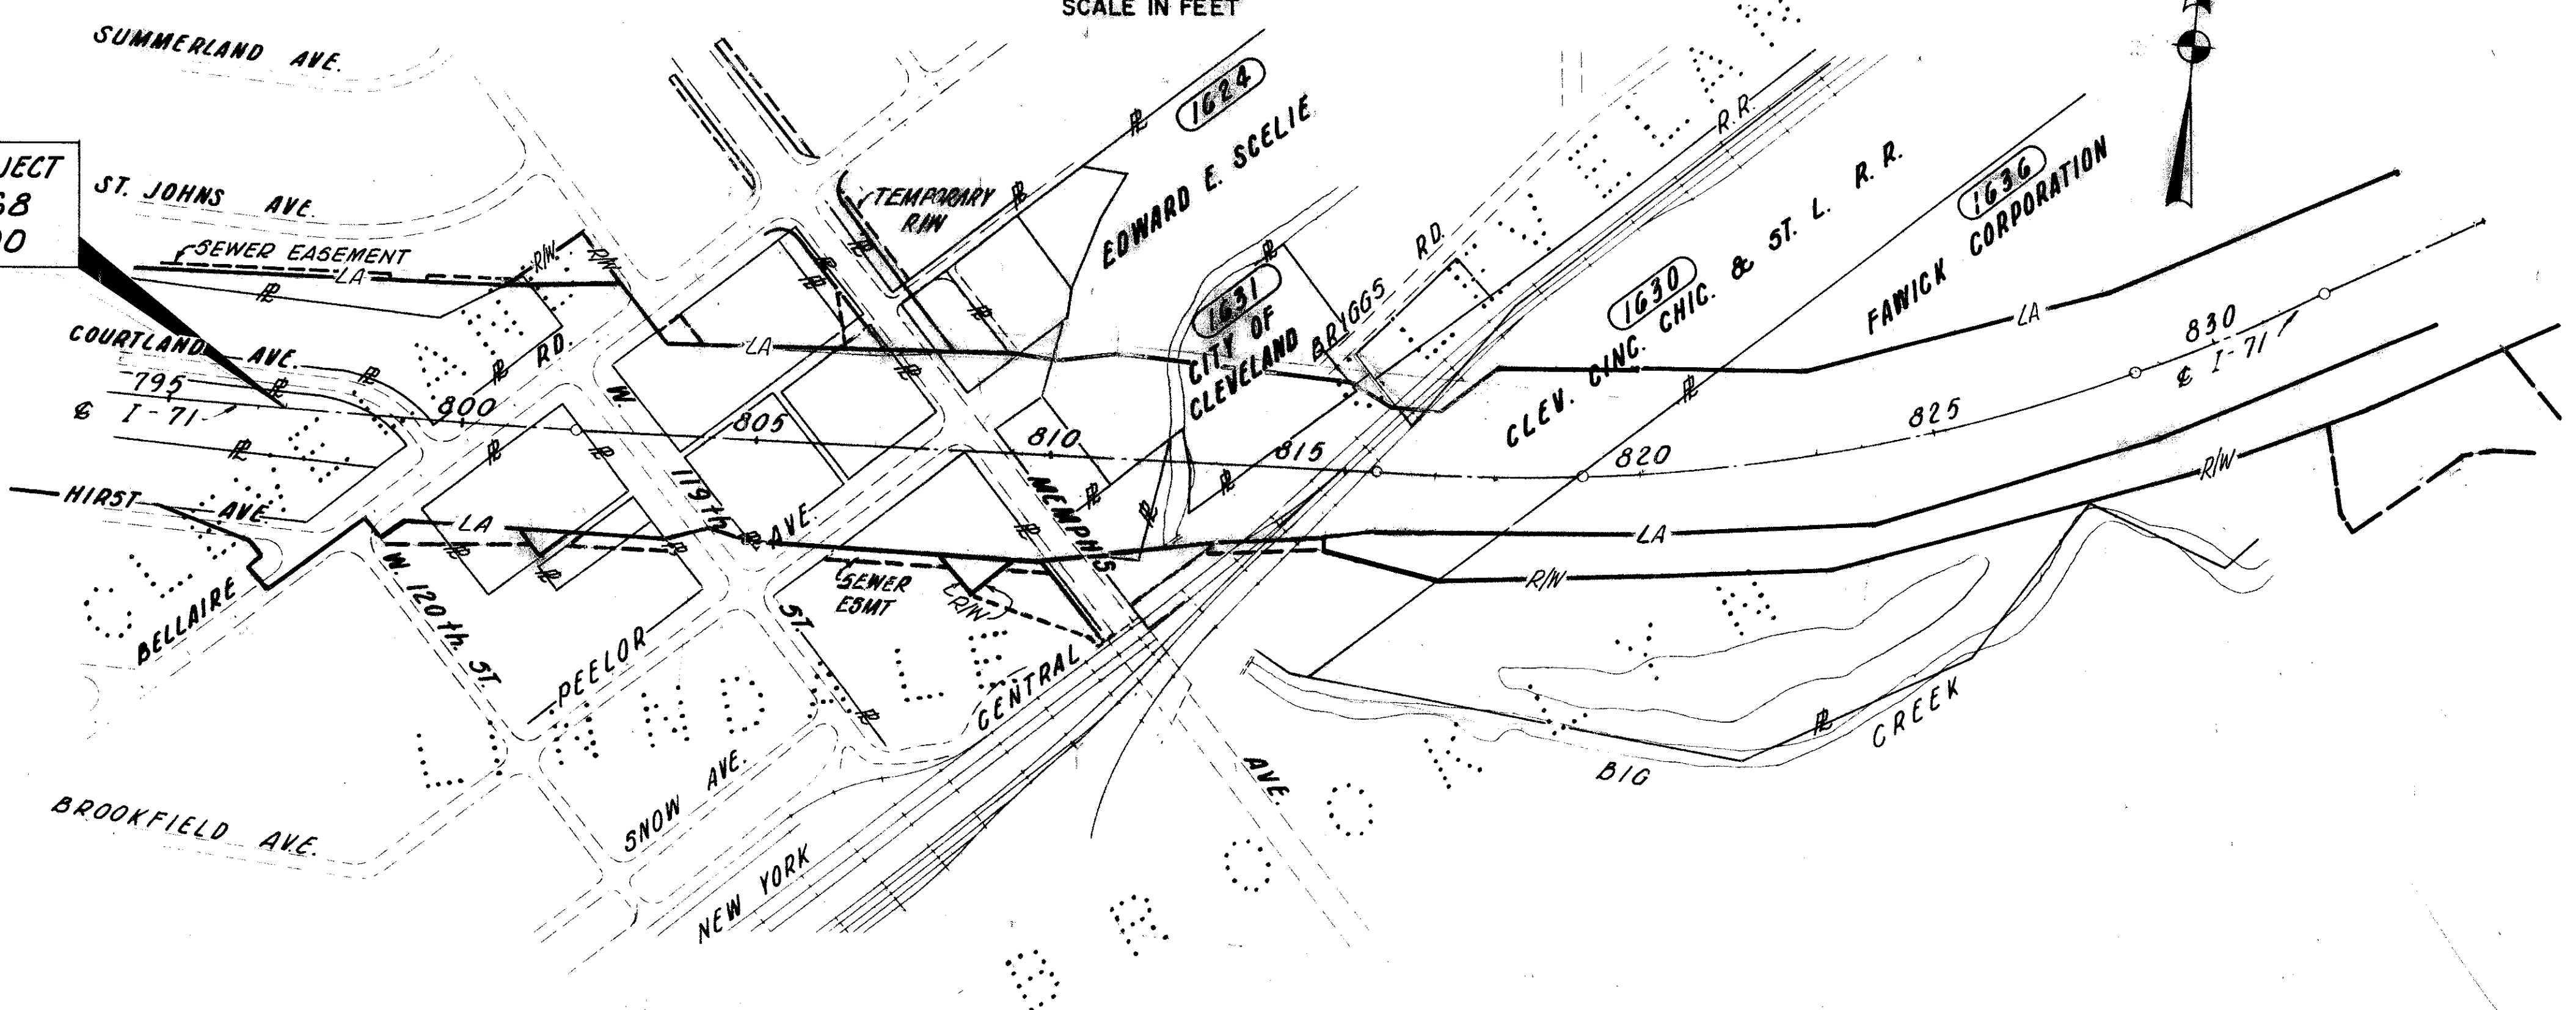

END PROJECT
CUY-71-13.68
STA. 870+00

COMPLETION DATE	12-12-64
REV. DATE	DESCRIPTION
1-19-65	REVISED P.R. R/W PARCEL 1640

FED. RD. DIVISION	STATE	PROJECT	
2	OHIO		

271

279



PARCEL NO.	OWNER	DEED RECORD		DEED AREA	TOBE ACQUIRED		NET RESIDUE		SHEET NO.	REMARKS
		BOOK	PAGE		LAND	BLDGs.	LEFT	RIGHT		
1619WL	T. D. DUTTON	9936	627	6510	6510	YES			7	TOTAL TAKE
1620WL	PASQUALE LEMBO	4705	349	13,300	13,300	YES			7	" "
1621WL	HELEN E. CEFUS	9769	737	3290	3290	YES			7	" "
1622WL	GUND REALTY CO.	10139	308	19,000	4375		12465		7	
1622WD	"				2160					
1622U	"				45					
1624WL	EDWARD E. SCELIE	9779	368	5,034	35,399		4,816		7	
1623WB	ROBERT P. & MARION O'NEIL								7	PROPERTY RIGHTS; N
1625WL	ANNA & JOSEPHINE ROGINSKY	6616	97	6000	6000	YES			7	TOTAL TAKE
1626WL	JOHN ROGINSKY	6499	331	8400	8400	YES			7	" "
1627WL	JOSEPH & FLORENCE ROGINSKY	6616	96	4600	4600	YES			7	" "
1628WL	DON & IRENE SHORT	10306	83	17,991	17,991	YES			7	" "
1630AWD	C.C.C. & ST. L. R.R.				2839				7	
1630A	C.C.C. & ST. L. R.R.				343 AC.	YES			7	768
1630B	"				0.37 AC.				7	768
1630S	"				0.09 AC.				7	768
1630D	"				1584				7	768
1630AT	"				11045				7	768
1630AS	"				841				7	768
1630E	"				0.21 AC.				7	768
1630C	"				243				7	768
1631WL	CITY OF CLEVELAND	8631	187	5,57	333 AC.		2,24 AC.		7	
1636WL	FAWICK CORP	4636	219							
1636WD	"	8435	210-212	29.78 AC.	8.82 AC.		1148 AC.	6.79 AC.	7	
1636S	"		214-216		2.69 AC.					
1636WA	"		218-219		0.13 AC.					
1636X	"	9027	282							
	"	9763	630		0.21 AC.					
	"	10169	469							
1637WL	FAWICK AIRFLEX COMPANY, INC.	6844	215	14.62 AC.	0.75 AC.		13.87 AC.		10	
1638WL	CITY OF BROOKLYN	7244	658	8,374 AC.	4.78 AC.		191 AC.	0.45 AC.	10	
1638WD	"				1.23 AC.				10	
1638X	"				0.35 AC.				9	
1638S	"				0.25 AC.				10	
1638EL	NORTHEAST OHIO REGIONAL SEWER DIST.				0.471 AC.				10	SOLD
1639AWL	CITY OF CLEVELAND	4636	220	1600	1600				10	TOTAL TAKE
1639WL	B. & O. RAILROAD CO.				1.32 AC.				10	BEING ACQUIRED ON GUY-TI-14-1
1639X	"				0.18 AC.					
1640WL	CLEVELAND METROPOLITAN PARK	3740	80	2948 AC.	236 AC.		2241 AC.		10	" "
1640WD	"				1.38 AC.				10	
1640WD	"				3.27 AC.				10	
1641WL	CITY OF CLEVELAND	4087	587	23,344 AC.	16,19 AC.		206 AC.	255 AC.	10, 11	" "
1641WD	"	1486	638		2.54 AC.				11	
1641X	"	1454	241		1.22 AC.				11	
1641X-1	"	1452	482		0.75 AC.				12	
1642WL	CITY OF BROOKLYN	7244	658	78,000 AC.	0.59 AC.		76,57 AC.		10, 11	" "
1642WD	"				0.84 AC.				10, 11	
1642X	"				4,69 AC.				10, 11	
1643X	CLEVELAND ELEC. ILLUMINATING CO.	3356	89	9,50 AC.	0.06 AC.		950 AC.		11	" " "
		3382	280							
1644X	MEMPHIS LAND CO.	9932	544,548	0.82 AC.	0.09 AC.		0.82 AC.		11	" " "
1645WD	DONALD R. & J.A. HASSINGER	10635	175	14,118	588		13,530		12	" " "
1646WD	NICHOLAS, JR., & A.P. MOLDORAN	10638	659	7096	4920	YES	2176		12	" " "
1646	"				1770				12	" " "
1647WD	BROOKLYN ACRES, ET. AL.	9932	546	2,13 AC.	0.03 AC.		210 AC.		12	" " "
1659WD	THE MANDEL CORP.			40,59 AC.	1323		40,56 AC.		10	
1659X	"				1,15 AC.					
1663SA	OLGA TOCZEK								5	*RELOCATE GAS LINE
1661WL	GEORGE NICHOLAS	10384	699	14,000	1050	YES	5950		5	
1661S	"	10667	711		3924				5	
1661WA	"								5	
1663-WL	OLGA TOCZEK	7686	354	9500	1155	YES	8345		5	
1663S	"				1693				5	
1663WA	"								5	
1664S	JOSEPH O. TOCZEK	9753	335	19,000	242		19000		5	REMOVE HOUSE
1664WA	"								5	RELOCATE WATER SERVICE LINE
1665WL	ANTONIA MANCINI	1634	50	19,000	342		12,624		7	RELOCATE WATER SERVICE LINE
1665S	"				1152				7	
1665WD	"				2034				7	
1665T	"				735				7	
1667WL	K.WAZEIVICH ETAL	8269	690	4000	1631	YES	796		7	
1667WD	"	5820	606		1573					
1667T	"				461				7	
1667S	"				1048				7	
1667A-T	MARLAND HARTMAN ET. AL.			9520	76		9500		7	
1668WL	MIKE LOACHTA, ET. AL.	10605	633	9500	4349	YES	3181		7	
1668S	"	2448	442		1306				7	
1668-WA	"								7	
1668-WD	"								7	
1668-T	"								7	
1673WD	WILLIAM KLINGER	9078	125	7600	33		5477		7	
1673T	"				1362	INTERSTATE			7	
1674-WD	K. & VASSIL SOTIR & GEO. SOTOS	4637	519	28,500	180	INTERSTATE	24477		7	
1674-T	"	4638	475		180	INTERSTATE			7	
	"	8653	472		180	INTERSTATE			7	
1675WL	VITTORIO DIASER	4782	695	3,500	3,500	YES			7	TOTAL TAKE

R/W SUMMARY JAN 7 1965

PARCEL NO.	TAX MAP NO.	LOT NO.	NAME OF OWNER	T.B.A.(SQ.FT.)
1607 WL	421-2-20	16(11)	PAULINE PIGNATARO	9500
1608 WL	421-2-19-18	15(12)	MANCINI LAND CO.	26964
1608 WA	17-16-15-14	15(10)	MANCINI LAND CO.	86
1661 WL	421-1-43-44	15(12)	GEORGE NICHOLAS	1050
1661 S	421-1-43-44	15(12)	GEORGE NICHOLAS	3924
1661 WA	421-1-43-44	15(12)	GEORGE NICHOLAS	
1663 WL	421-1-4	3(12)	OLGA TOCZEK	1155
1663 S	421-1-4	3(12)	OLGA TOCZEK	1533
1663 WA	421-1-4	3(12)	OLGA TOCZEK	
1664 S	421-1-5	2(12)	JOSEPH & O. TOCZEK	242

CURVE DATA
 P.I. STA 797+37.47
 D = 04°17'40"LT
 D = 00°28'00"
 R = 12277.67'
 T = 460.33'
 L = 920.24'
 E = 8.63'

LIMITED ACCESS
 SCALE: 1" = 50'

FED. RD. DIVISION	STATE	PROJECT
2	OHIO	

CUYAHOGA COUNTY
 CUY-71-13.68

272
279
5
12



PARCEL NO.	TAX MAP NO.	LOT NO.	NAME OF OWNER	T.B.A.(SQ.FT.)
1390 WL	19-12-111	153	ALEX FODOR	5765
1390 S	19-12-111	153	ALEX FODOR	1488
1392 WL	19-12-109	155	JAMES O. & S. L. FOUNTAINE	4215
1392 S	19-12-109	155	JAMES O. & S. L. FOUNTAINE	408
1393 WL	19-12-108	156	CATHERINE MALLOY	4689
1393 S	19-12-108	156	CATHERINE MALLOY	850
1394 WL	19-12-120	157	TOOL PRODUCERS INC.	1585
1394 X	19-12-120	157	TOOL PRODUCERS INC.	929
1400 X	19-12-49	158	PETER & P. HORDZEJCUK	47
1463 WL	19-12-829	91-92	LELLIE MAE LESTER	15,362
1464 WL	19-12-10	90	ROSE MARY & WM. CRITE	10752

PARCEL NO.	TAX MAP NO.	LOT NO.	NAME OF OWNER	T.B.A.(SQ.FT.)
1483 WL	19-15-47	79	ELMO D. WATERS	7350
1513 WL	19-12-178	82-83	CITY OF CLEVELAND	9,015
1519 WL	19-12-10	64	AUGUST FELICE	3941
1520 WL	19-12-15	85	TOOL PRODUCERS INC.	6,756
1521 WL	19-12-14	86	CITY OF CLEVELAND	5466
1522 WL	19-12-13	87	MAY S. MUNTZ	5414
1523 WL	19-12-12	88	JULIA CARTER	4,813
1524 WL	19-12-11	89	JULIA A. CARTER	4,663
1525 WL	19-15-46	79	CITY OF CLEVELAND	6500
1526 WL	19-15-45	78	BRAMSON CONSTRUCTION INC.	4998
1527 WL	19-15-4443	1&2	ST. PAUL'S A.M.E. CHURCH	17,779


PARCEL NO.	TAX MAP NO.	LOT NO.	NAME OF OWNER	T.B.A.(SQ.FT.)
1544 WL	19-12-19-20	80-81	JOSEPH & MARY FERRINGO	8868
1601 WL	421-1-45	14(12)	ALTHEA M. RONDA	3150
1601 S	421-1-45	14(12)	ALTHEA M. RONDA	1941
1602 WL	421-1-46	13(12)	F. A. GRABNEGGER	5251
1602 S	421-1-46	13(12)	F. A. GRABNEGGER	1581
1602 WA	421-1-46	13(12)	F. A. GRABNEGGER	
1604 WL	421-1-47	12(12)	TOMMY & P. ROPCZ	9500
1604 WL	421-1-48-1	910-1102	FRANK & ANGELA BARBER	21,000
1605 WL	421-1-2	910-1102	CHARLES KLEMANEK	7500
1606 WL	421-1-3	4(12)	ANNA LASHUTKA	4119
1606 S	421-1-3	4(12)	ANNA LASHUTKA	1554

ITEM	QTY.	(L.F.)
I-26	1421	

COMPLETION DATE 12-14-64

REV.	DATE	BY	DESCRIPTION
8	10/19/67	P.C.S.	ADDED PARCELS 1663 WA 1 & 1664 WA

R/W BELLAIRE ROAD JAN 7 1965

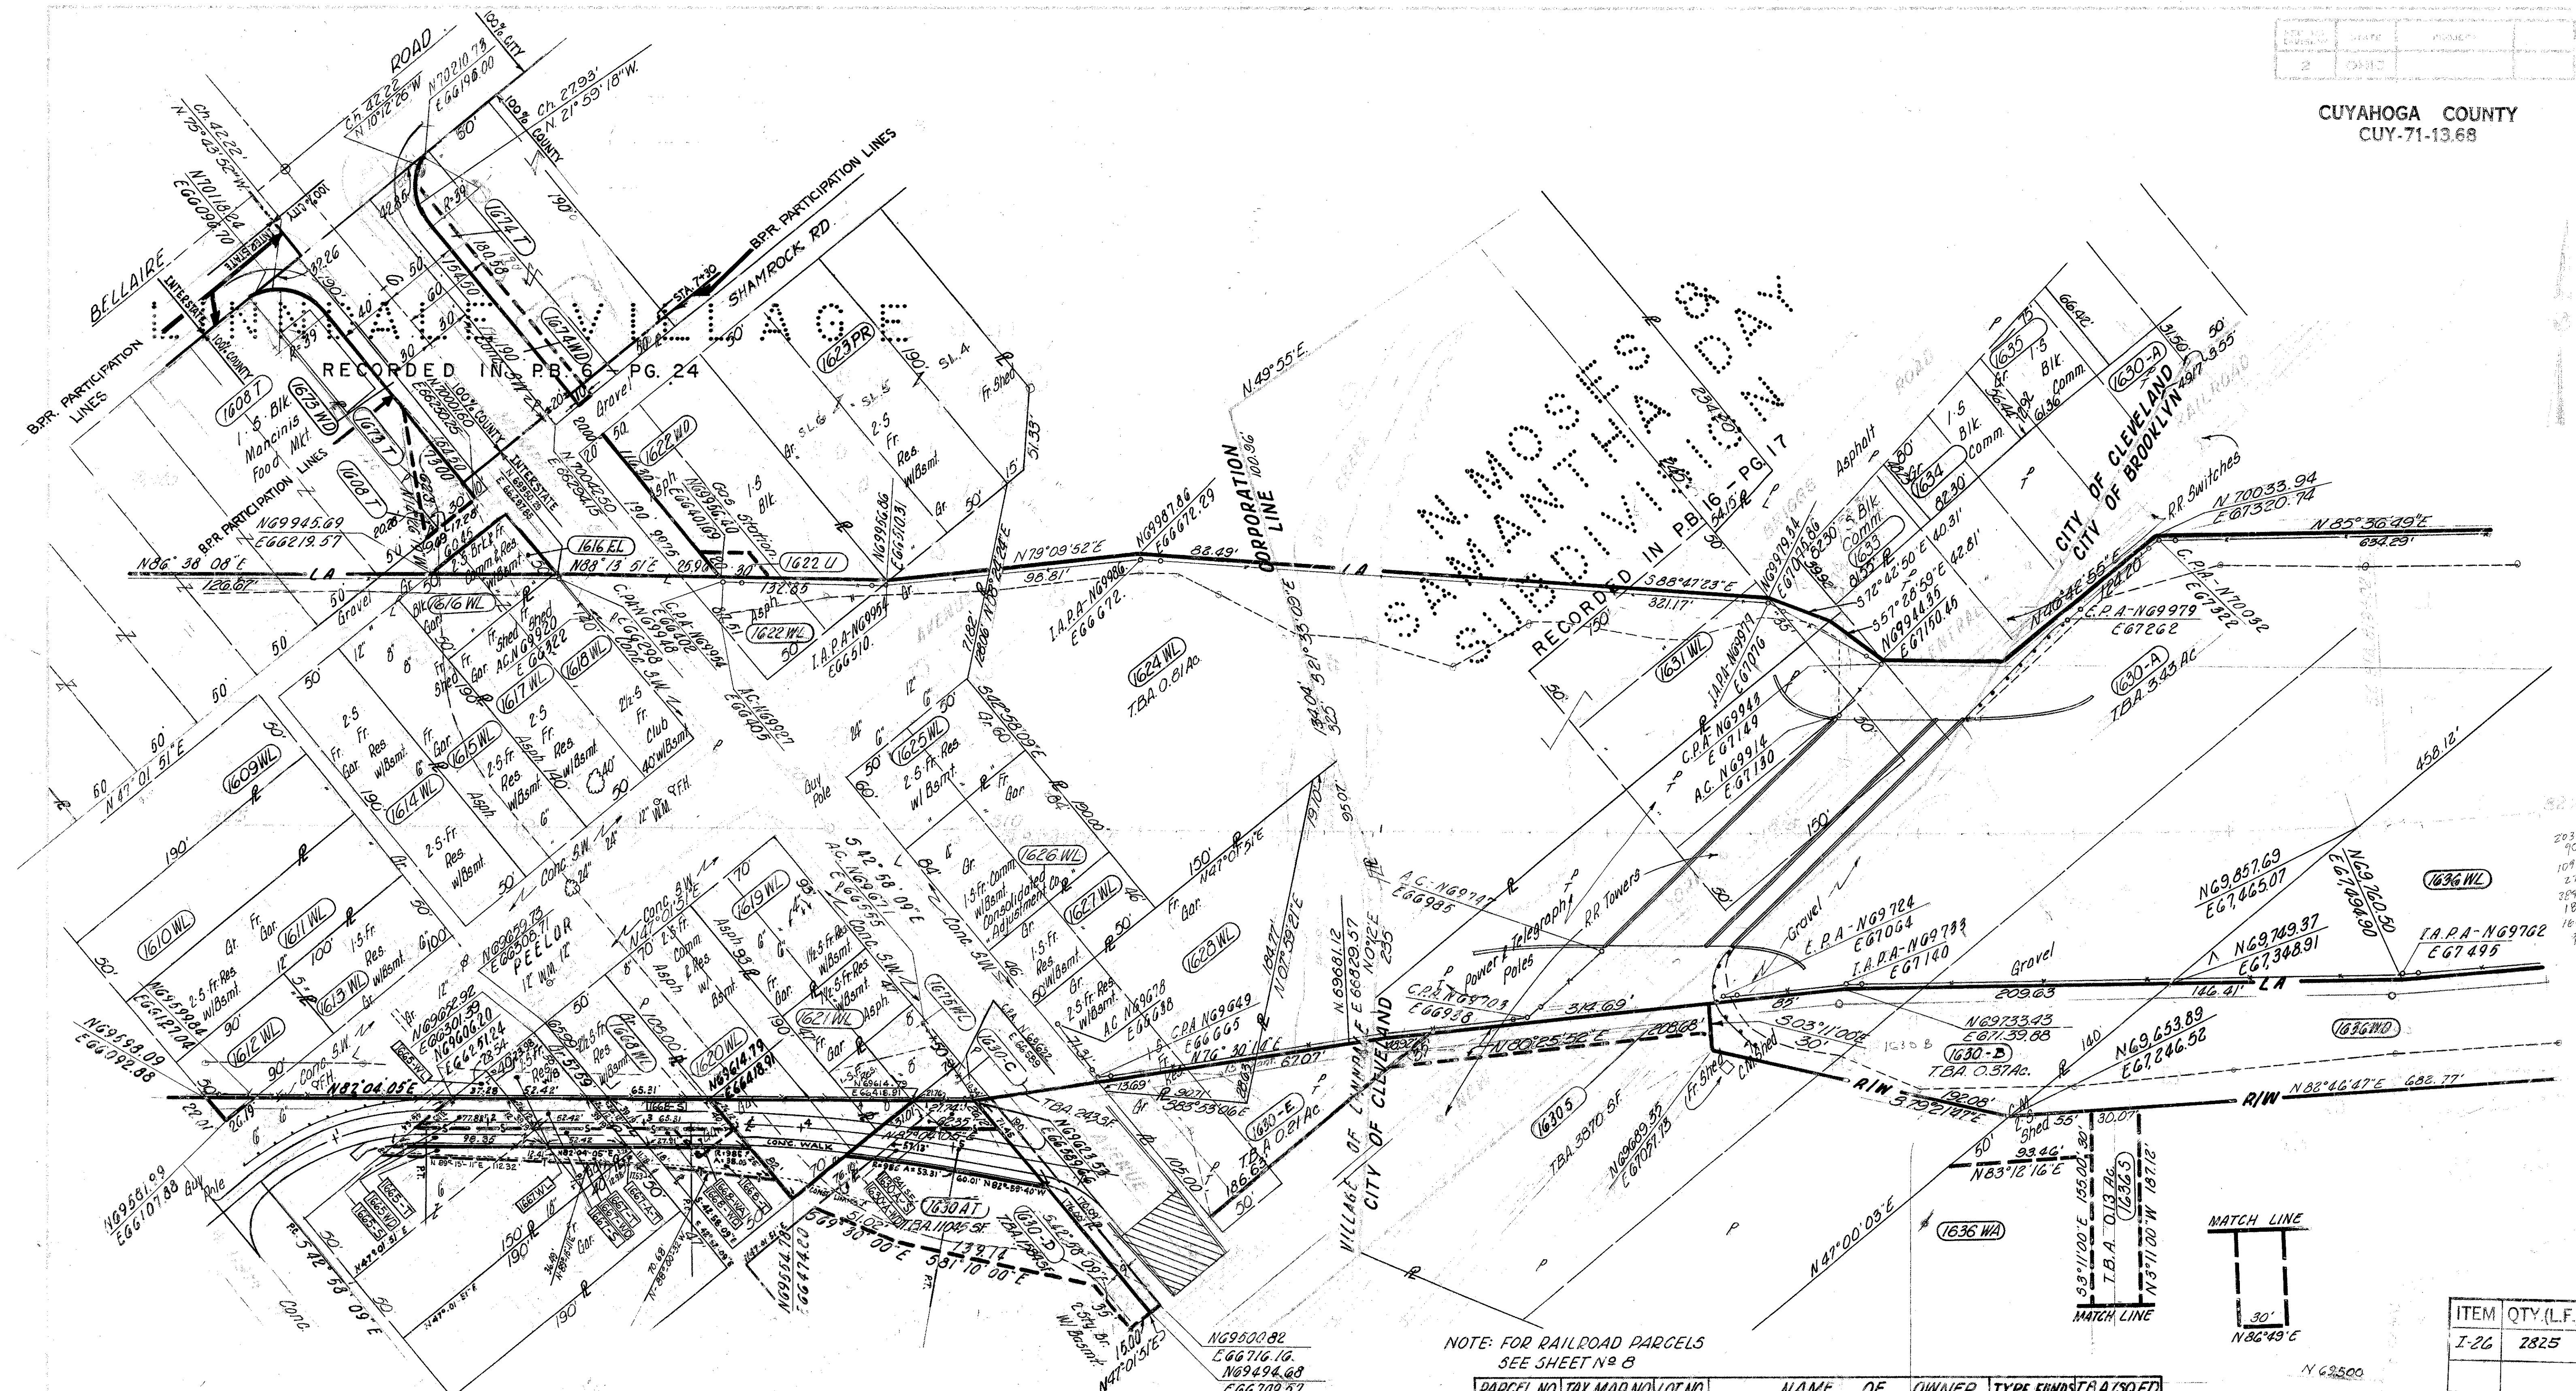

NOTE: FOR RAILROAD PARCELS
SEE SHEET NO. 8

PARCEL NO.	TAX MAP NO.	LOT NO.	NAME OF OWNER	TYPE FUNDS	T.B.A. (SQ.FT.)
1608 T	421-2-23, 19, 18, 16, 15, 14, 13	12, 11, 10, 9, 8	MANCINI LAND CO.	INTERSTATE	
1609 WL	421-2-21	8(11)	MIKE VARACKA		9500
1610 WL	421-2-22	7(11)	PATRONIA DEBASSIS		9500
1611 WL	421-2-23	6(11)	LIZETTE JAMEY ET AL.		9500
1612 WL	421-2-24	5(11)	JOSEPH MANCINI ET AL.		4500
1613 WL	421-2-8	5(11)	JOSEPH MANCINI & SAM DELUCO		5000
1614 WL	421-2-9	4(11)	FROSINA KOLAS		9500
1615 WL	421-2-10	3(11)	EARL M. & N.J. BLANKENSHIP		9500
1616 WL	421-2-1	12(11)	MIKE KUPRESANIN		4500
1623 FR	421-3-21		ROBERT P. & MARION O'NEIL	INTERSTATE	Property Rights

PARCEL NO.	TAX MAP NO.	LOT NO.	NAME OF OWNER	TYPE FUNDS	T.B.A. (SQ.FT.)
1617 WL	421-2-11	2(11)	ANNA LASHUTKA	INTERSTATE	7000
1618 WL	421-2-12	1(11)	WILLIAM KLINGER		5600
1619 WL	421-2-364	9(10)(2)	T.D. DUTTON		6510
1620 WL	421-2-5	10(11)(2)	PASQUALE LEMBO		9619
1621 WL	421-2-32	3(10)(2)	HELEN E. CEFUS		3290
1622 WL	421-3-22423	7(8)(10)	GUND REALTY CO.		4375
1622 WD	421-3-22423	7(8)(10)	GUND REALTY CO.		2160
1622 U	421-3-22423	7(8)(10)	GUND REALTY CO.		45
1625 WL	421-3-24	9(10)(1)	ANNA & JOSEPHINE ROGINSKY		6000
1626 WL	421-3-29	9(10)(1)	JOHN ROGINSKY		8400
1627 WL	421-3-25	9(10)(1)	JOSEPHINE & FLORENCE ROGINSKY	INTERSTATE	4600

PARCEL NO.	TAX MAP NO.	LOT NO.	NAME OF OWNER	TYPE FUNDS	T.B.A. (SQ.FT.)
1628 WL	421-3-26	8(11)	DOM & IRLENE SHORT	INTERSTATE	17,991
1665 WL	421-2-25426	15(16)(2)	ANTONIA MANCINI		342
1665 S	421-2-25426	15(16)(2)	ANTONIA MANCINI		1152
1667 WL	421-2-7	15(16)(2)	K. WAZEVICH ET AL.		1631
1667 S	421-2-7	15(16)(2)	K. WAZEVICH ET AL.		1048
1668 WL	421-2-6	12(2)	MIKE LOACHTA ET AL.		4349
1668 S	421-2-6	12(2)	MIKE LOACHTA ET AL.		1306
1668 WL	421-2-6	12(2)	MIKE LOACHTA ET AL.	INTERSTATE	2123
1673 WD	421-2-12	1(11)	WILLIAM KLINGER	INTERSTATE	1362
1673 T	421-2-12	1(11)	WILLIAM KLINGER	INTERSTATE	4023
1674 WD	421-2-15, 16, 17, 11, 12, 13, 14		K. VASSIL SOTIR & GEO. SOTOS	INTERSTATE	1709
1674 T	421-2-15, 16, 17, 11, 12, 13, 14		K. VASSIL SOTIR & GEO. SOTOS	INTERSTATE	

R.S.	DATE	DESCRIPTION
4-29-70	ADDED PARCEL 1676L	
COMPLETION DATE 12-14-64		
REV	DATE	DESCRIPTION
11-24-65		Parcels 1630-WL, -WD, -AWL, -AWD & BWD changed to Parcels 1630-A, -B, -C, -D & -E respect.
P.S.	3-31-66	Fence Revised & Sidewalk Added, South Side I.R. 71 between Peeler Ave. & Memphis Ave.
A.M.	6-7-66	P.C. 1623 WL changed to 1623 PR
K.T.S.	8-9-66	ADDED TYPE FUNDS COLUMN
K.T.S.	10-5-66	ADDED PARCELS 1645-WD, 1665-T, 1666-WD, 1668-T & 1680-AWD; ADDED PEELOR AVE. RELOCATION; REVISED LA FENCE & SIDEWALK BETWEEN PEELOR AVE. & MEMPHIS AVE.

COMPLETION DATE 12-14-64		
REV.	DATE	DESCRIPTION
1	11-24-65	PC's 1630-WL;WD,-AWL,-AWD & BWD changed to 1630-A,-B,-C,-D & E respect.

CURVE DATA
CURVE NO 7 SPIRAL NO 7

Δ = 26°12'39" LT
Δc = 19°12'39" LT
D = 02°00'00"
R = 2864.79'
T = 484.82'
L = 960.54'
E = 40.74'

Ls = 350.00'
θ = 03°30'00"
P = 17.9'
K = 174.98'
LT = 233.38'
ST = 116.71'
Ts = 842.34'
Es = 78.44'


CITY OF BROOKLYN

LIMITED ACCESS

SCALE: 1" = 50'

FED. RD. DIVISION	STATE	PROJECT	276
2	OHIO		279
			9
			12

CUYAHOGA COUNTY
CUY-71-13.68

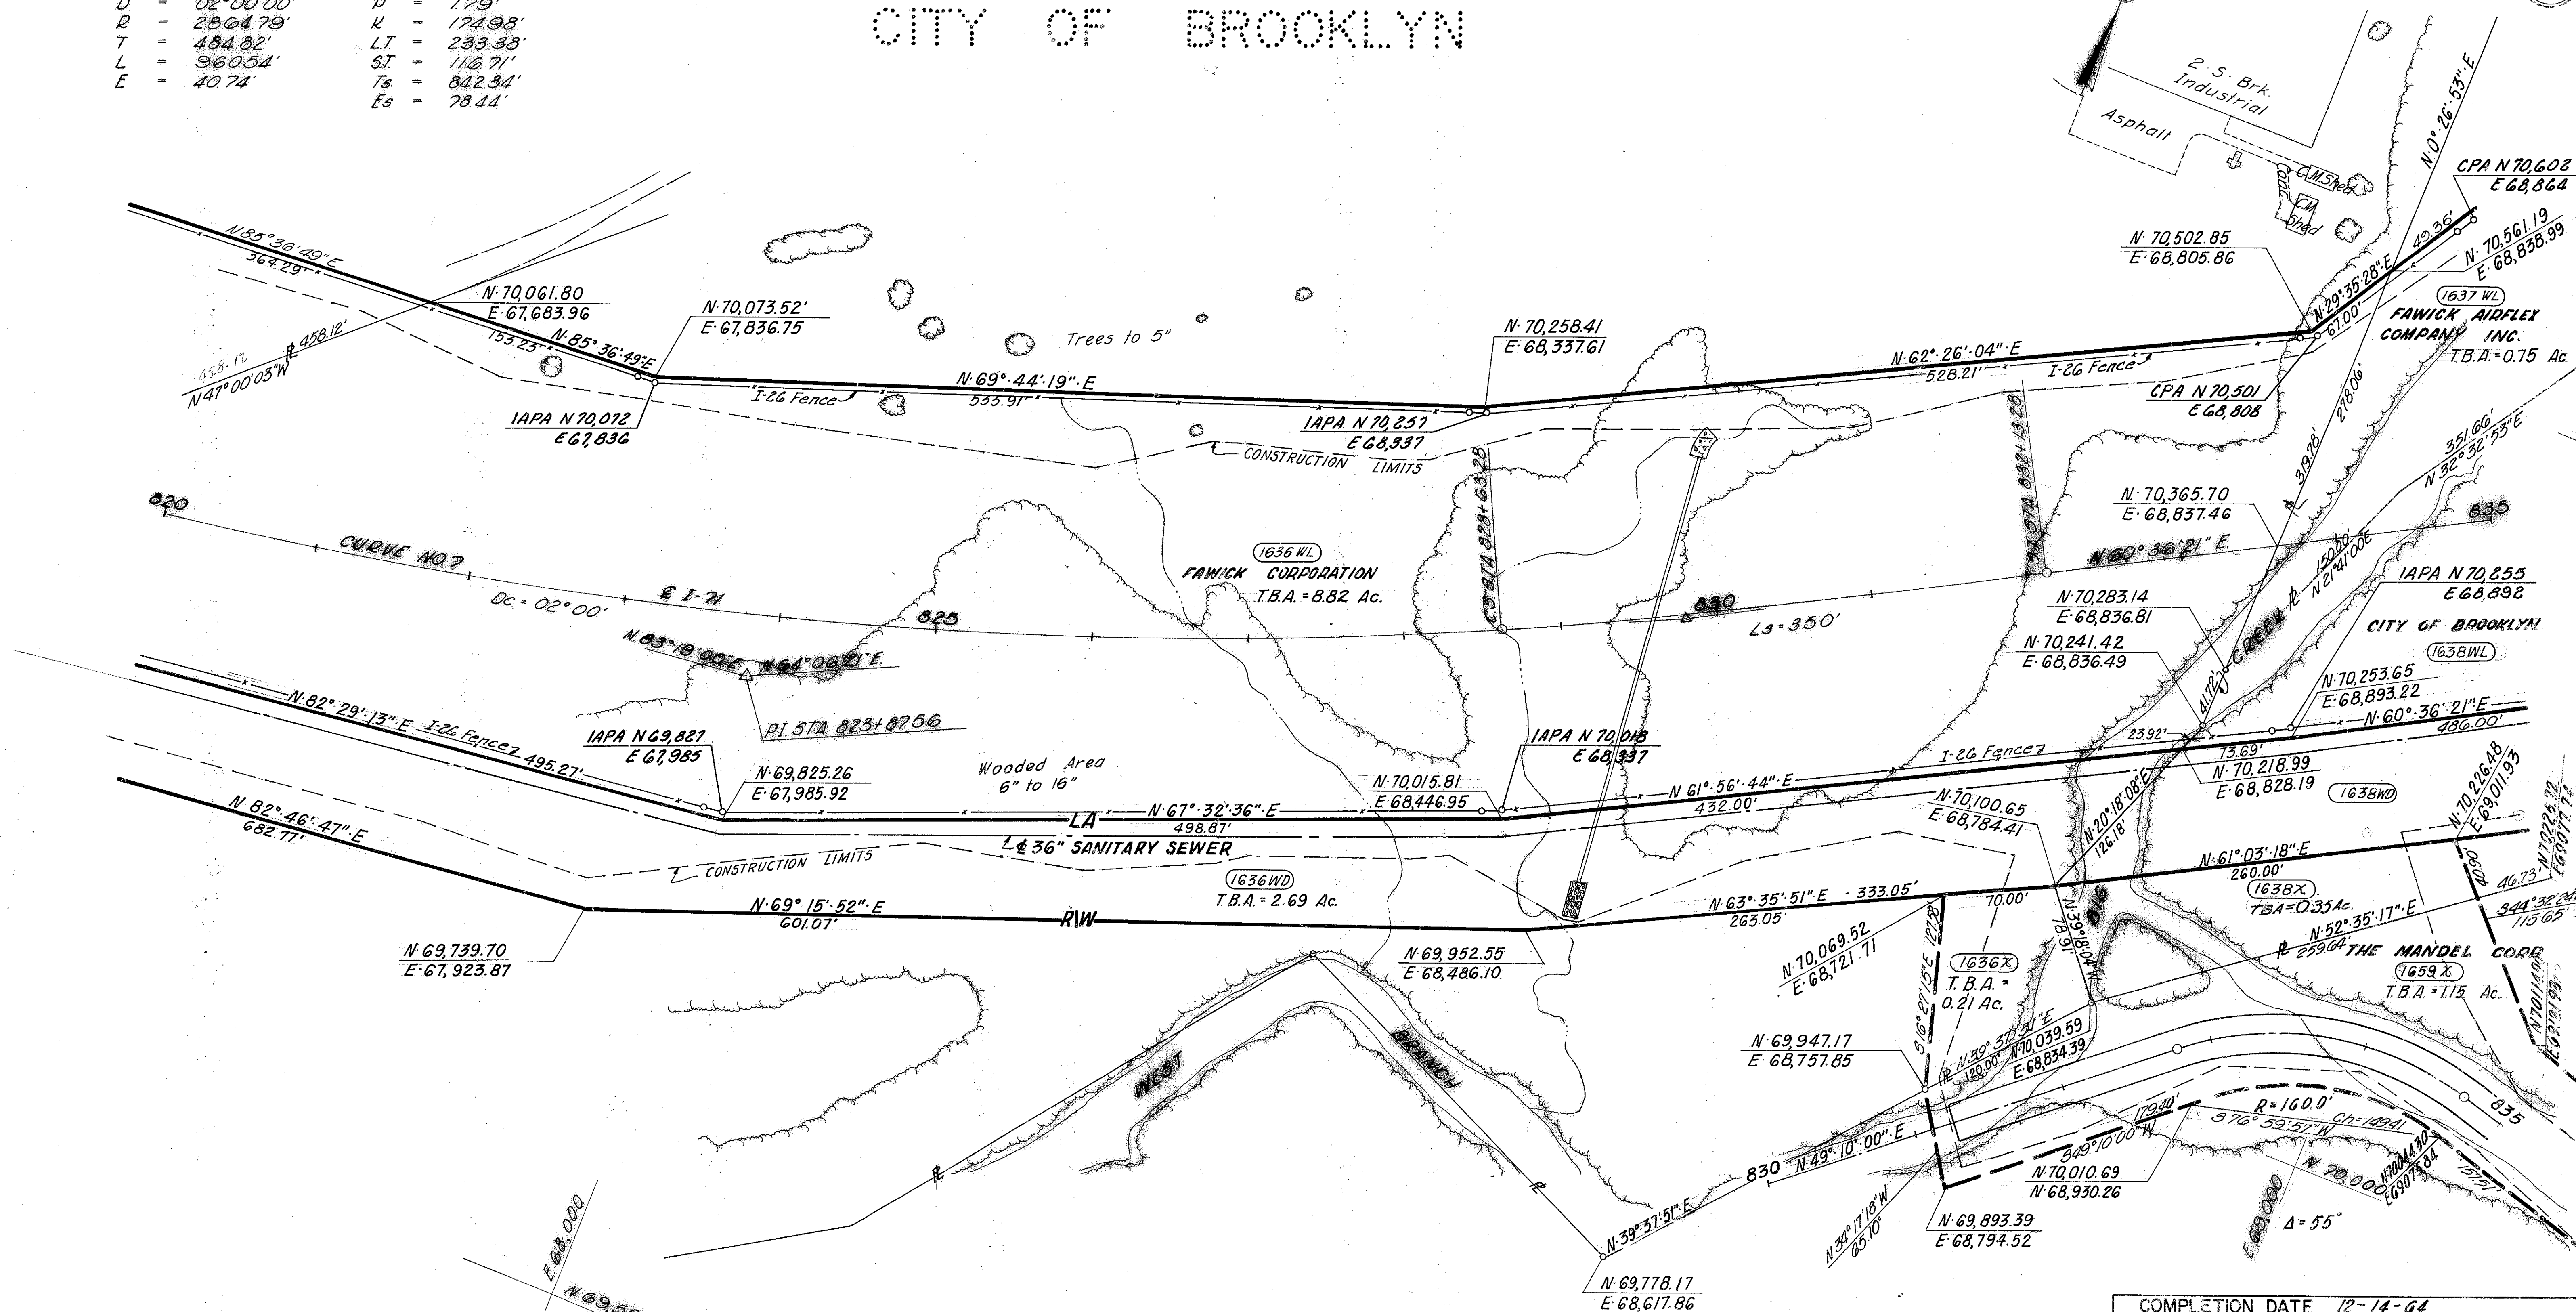

ITEM	QTY (L.F.)
I-26	3050

REV.	DATE	DESCRIPTION
1	12-14-64	COMPLETION DATE


R/W STA 820+00 TO STA 835+00

JAN 7 1965

FED. RD. DIVISION	STATE	PROJECT	
2	OHIO		1

4
4.31

CUYAHOGA COUNTY
CUY-71-13.68
R/W 9.96

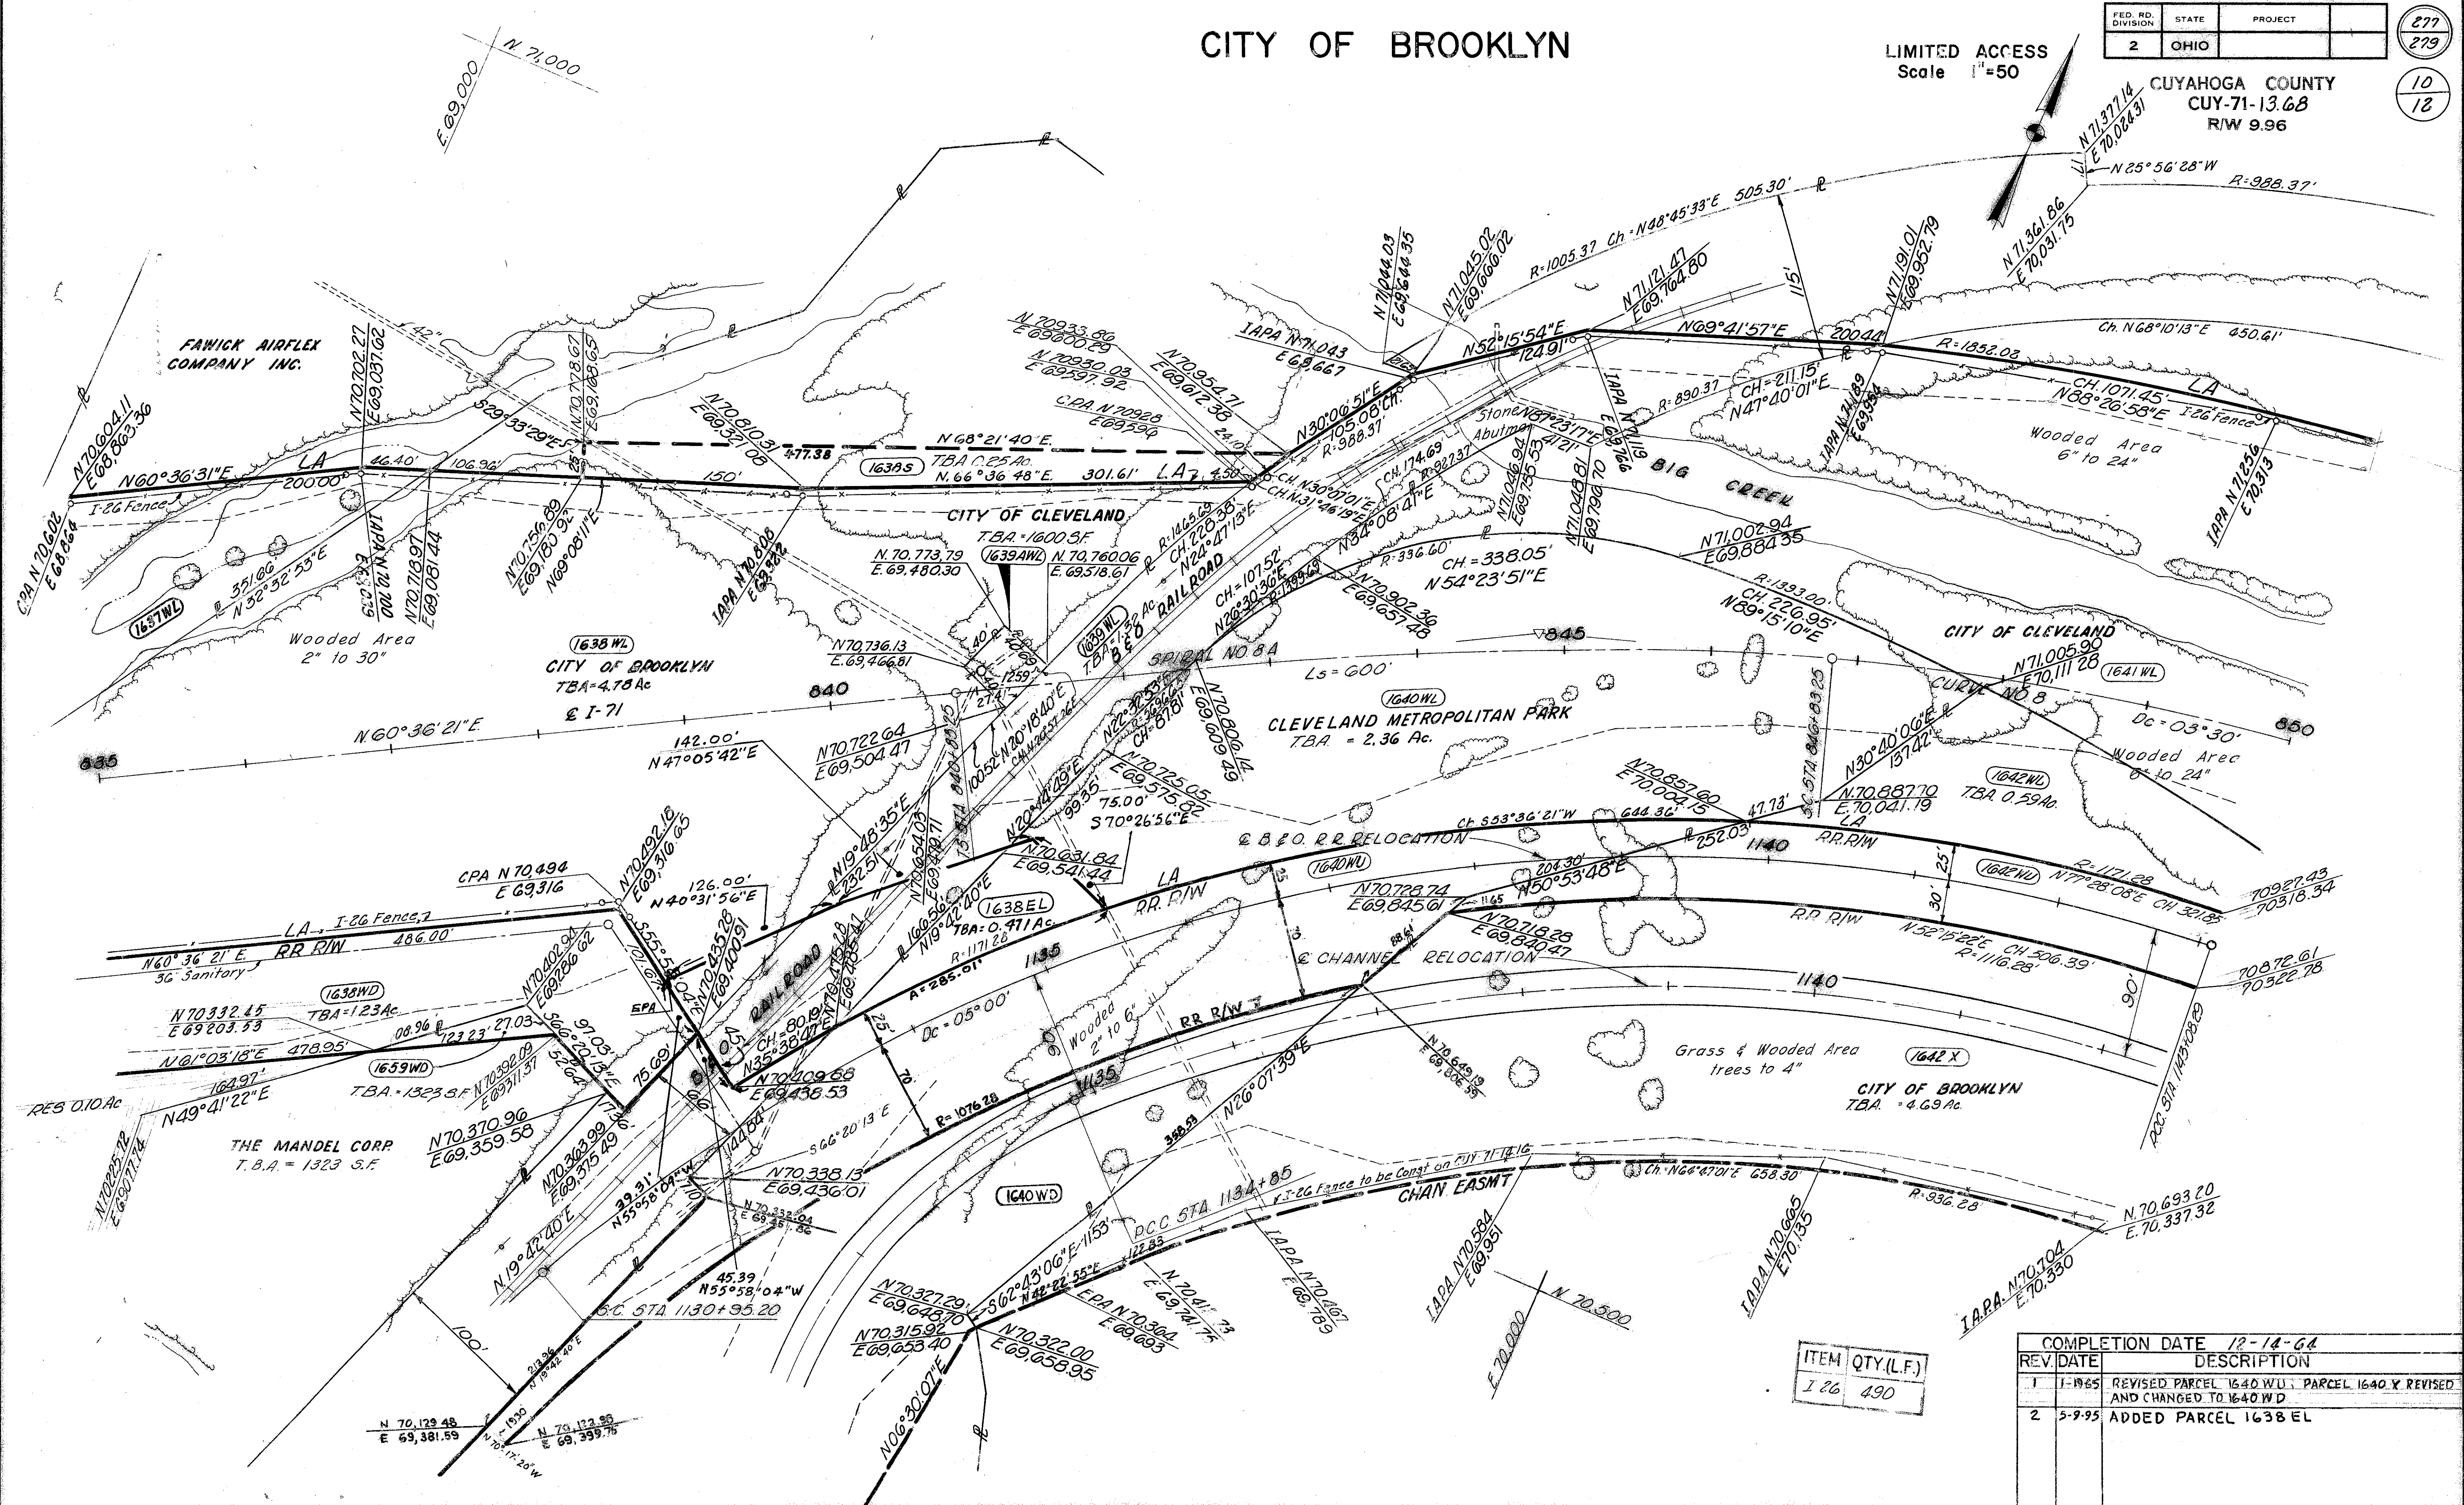

ITEM	QTY.(L.F.)
I 26	490

COMPLETION DATE 12-14-64		
REV.	DATE	DESCRIPTION
1	1-19-65	REVISED PARCEL 1640 W.D. PARCEL 1640 X REVISED AND CHANGED TO 1640 W.D.
2	5-9-95	ADDED PARCEL 1638 EL

R/W STA 835+00 TO STA 850+00

JAN 7 1986

FED. RD. DIVISION	STATE	PROJECT
2	OHIO	

CUYAHOGA COUNTY
CUY-71-13.68
R/W 9.96

LIMITED ACCESS
Scale: 1" = 50'

That portion of the existing
B&O Railroad property lying
north of the Proposed I-71
Right-of-Way to be acquired
by the City of Cleveland

CITY OF BROOKLYN

CURVE DATA

CURVE NO. 8
 $\Delta = 59^{\circ}56'39"$ RT
 $\Delta_c = 38^{\circ}32'16"$ RT
 $D = 03^{\circ}30'00"$
 $R = 1637.02'$
 $T = 572.28'$
 $L = 1101.08'$
 $E = 97.15'$

SPIRAL NO. 8-A
 $L_s = 600.00'$
 $\theta = 10^{\circ}30'00"$
 $P = 9.16'$
 $L = 299.66'$
 $LT = 400.70'$
 $ST = 200.64'$

SPIRAL NO. 8-B
 $L_s = 600.00'$
 $\theta = 10^{\circ}54'30"$
 $P = 9.51'$
 $L = 299.63'$
 $LT = 400.77'$
 $ST = 200.70'$

SPIRAL NO. 8-C
 $L_s = 600.00'$
 $\theta = 10^{\circ}25'02"$
 $P = 9.08'$
 $L = 299.67'$
 $LT = 400.77'$
 $ST = 200.63'$

CURVE DATA

CURVE NO. 2
 $\Delta = 30^{\circ}10'03"$ RT
 $\Delta_c = 03^{\circ}00'00"$
 $D = 03^{\circ}00'00"$
 $R = 1910.08'$
 $L = 1005.58'$
 $T = 514.80'$
 $E = 68.16'$

SPIRAL NO. 2-A
 $L_s = 200.00'$
 $\theta = 03^{\circ}00'00"$
 $P = 0.87'$
 $L = 99.99'$
 $LT = 133.35'$
 $ST = 66.68'$

CLEVELAND ELEC.
ILLUMINATING CO.
T.B.A. = 0.06 Ac.

ITEM	QTY (L.F.)
1-1615	

COMPLETION DATE	12-14-64
REV. DATE	
DESCRIPTION	

R/W STA 850+00 TO STA 865+00

JAN 7 1965

CITY OF CLEVELAND

CUYAHOGA COUNTY
CUY-71-13.68
R/W 9.96


LIMITED ACCESS
Scale: 1" = 50'

FED. RD. DIVISION	STATE	PROJECT
2	OHIO	

279
279
12
12

CURVE DATA

CURVE NO. 14	SPIRAL NO. 14A
PI STA 879+44.20	Ls = 600.00'
Δ = 44° 44' 19" LT	θ = 13° 30' 00"
Δc = 19° 59' 19" LT	P = 1176'
D = 04° 30' 00"	K = 299.45'
R = 1273.24'	LT = 401.17'
T = 224.38'	ST = 201.06'
L = 444.19'	Is = 828.28'
E = 19.62'	Es = 116.32'

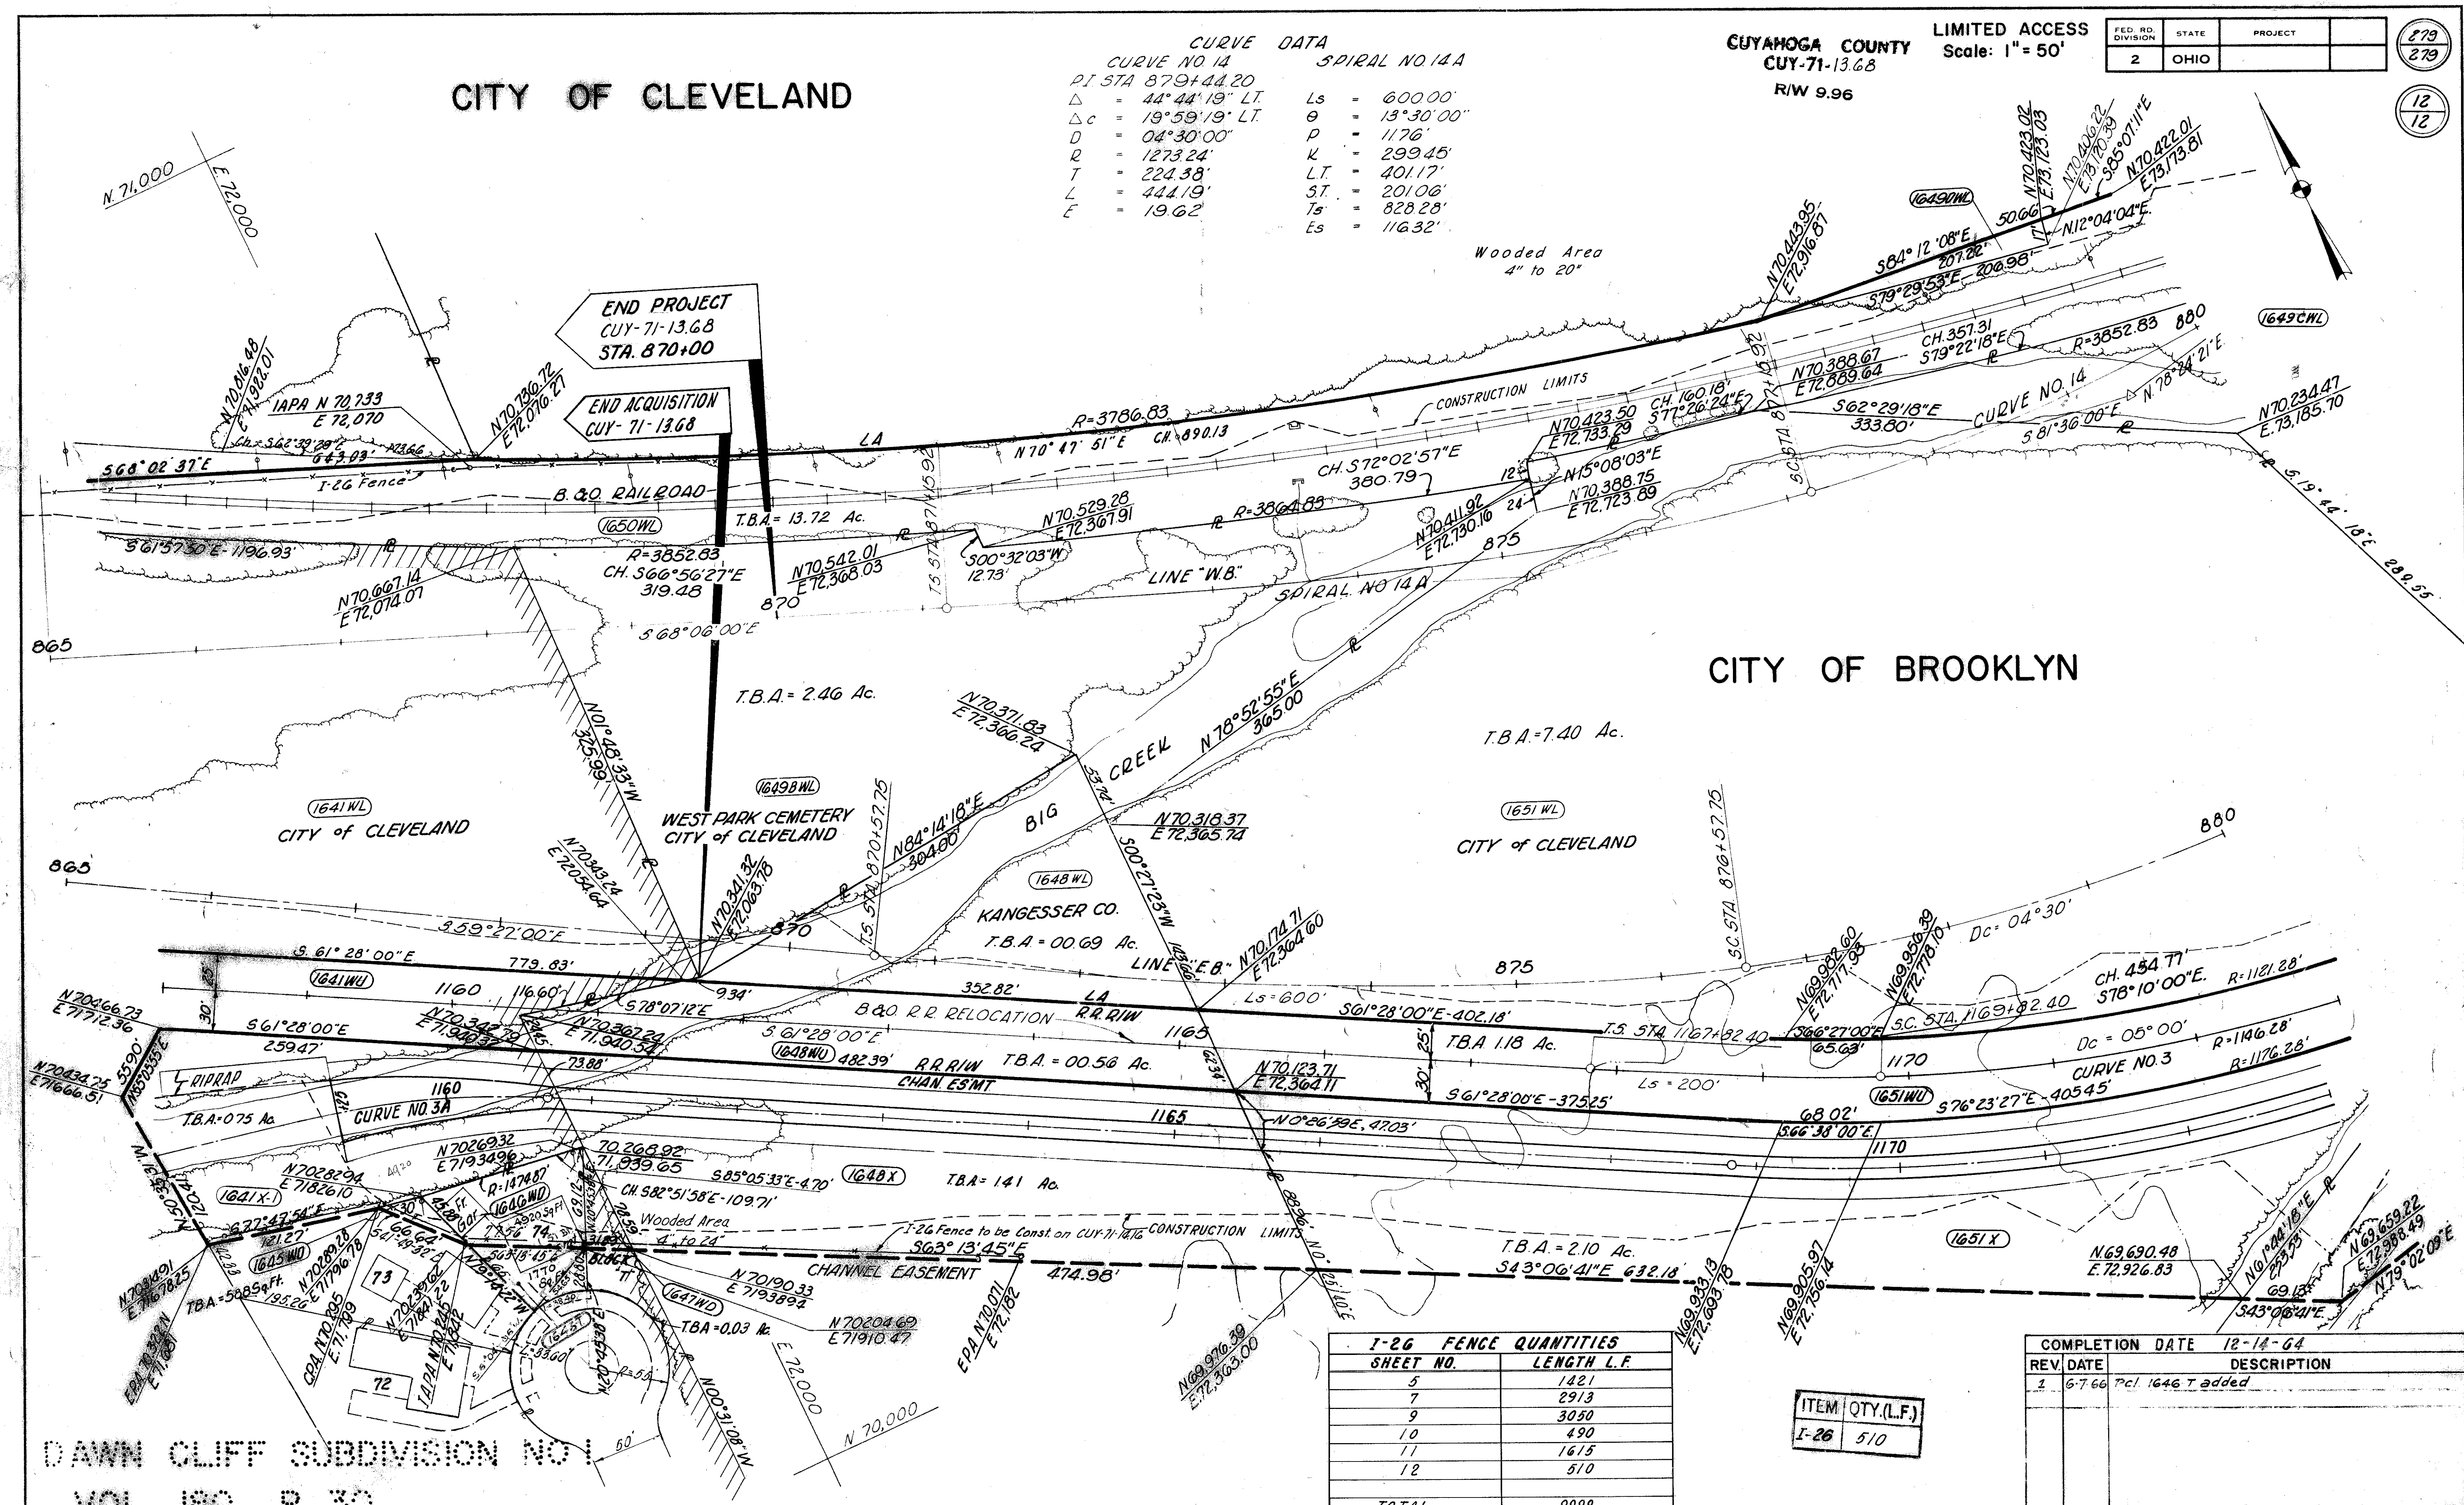

I-26 FENCE QUANTITIES

SHEET NO.	LENGTH L.F.
5	1421
7	2913
9	3050
10	490
11	1615
12	510
TOTAL	9999

ITEM	QTY.(L.F.)
I-26	510

COMPLETION DATE 12-14-64	
REV. DATE	DESCRIPTION
1 6-7-66	Pcl 1646 T added

DAWN CLIFF SUBDIVISION NO. 1
VOL. 180 P. 30

R/W STA 865+00 TO STA 880+00

JAN 7 1965