

SW


M-18

FED. RD. DIVISION	STATE	PROJECT	76 478
2	OHIO		

CUYAHOGA COUNTY
CITY OF CLEVELAND
MEDINA-CLARK INTERCHANGE
CUY- 71-18.54
CUY- 90-13.81

LEGEND

- MH → CB Proposed Storm Sewer
- → Proposed Sanitary Sewer
- - - Proposed Underdrain
- ○ - Existing Sewer to Remain in Service
- X - Existing Sewer to be Abandoned

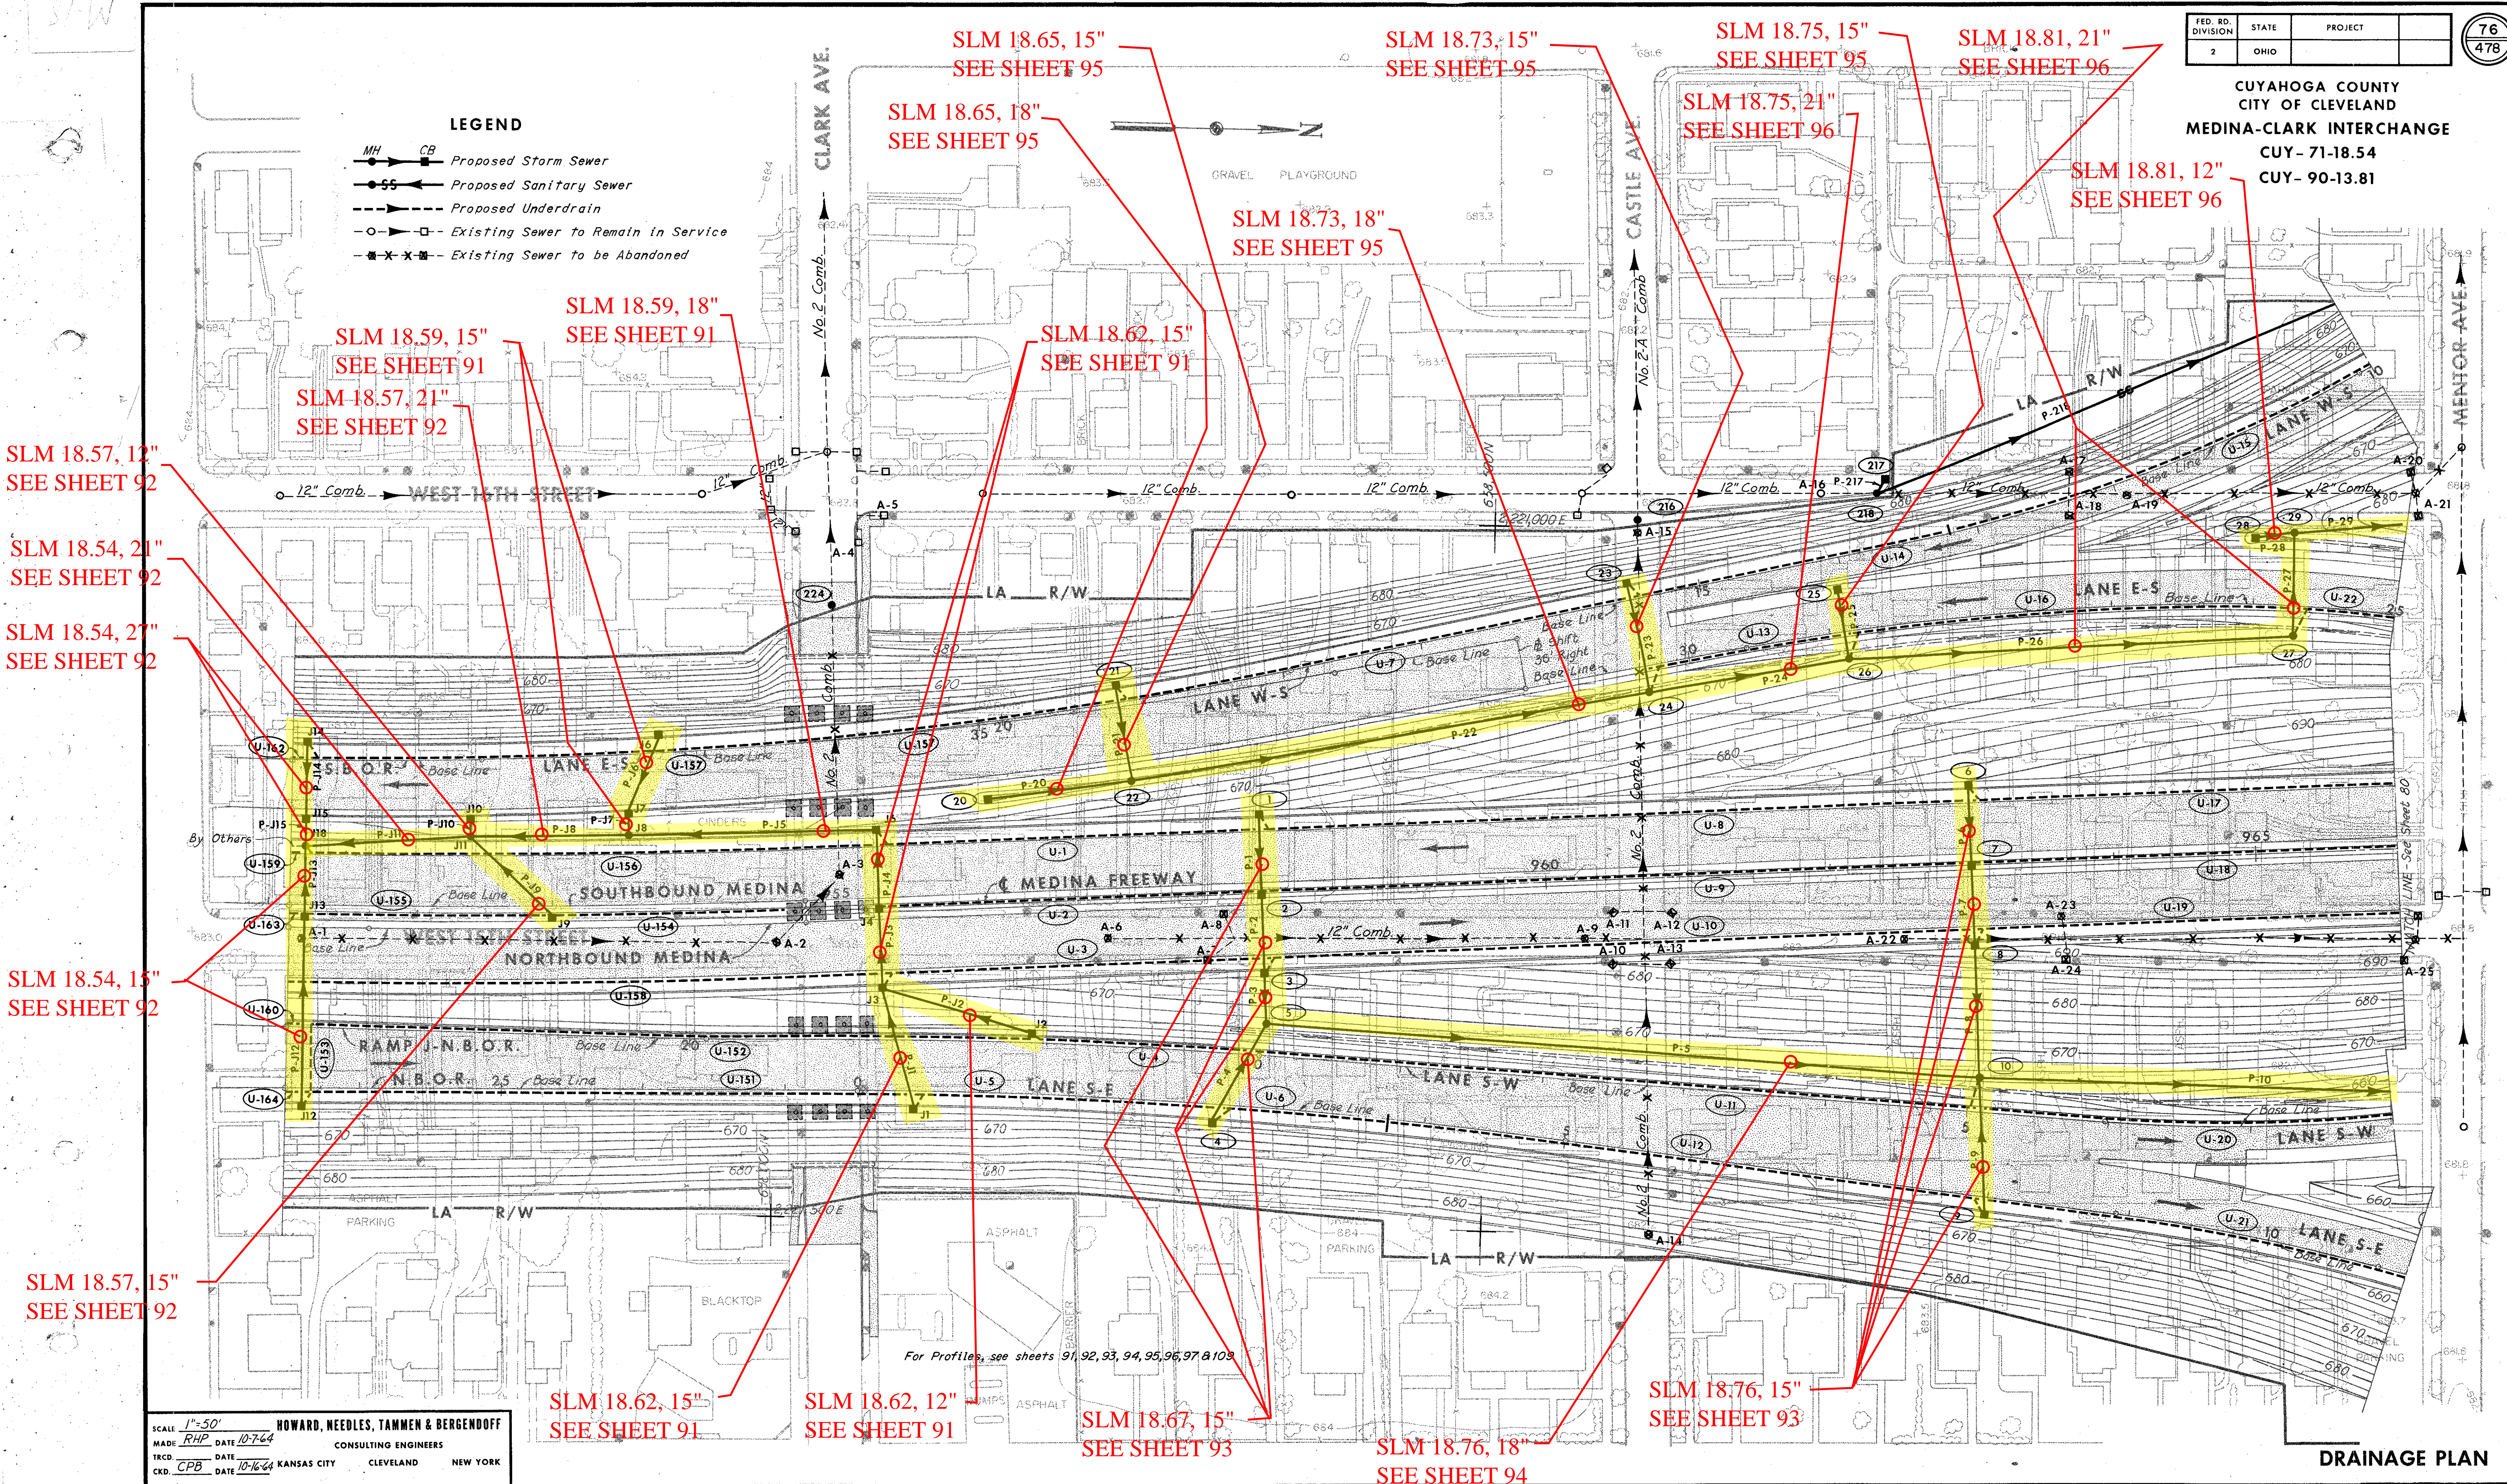

SLM 18.57, 12"
SEE SHEET 92

SLM 18.54, 21"
SEE SHEET 92

SLM 18.54, 27"
SEE SHEET 92

SLM 18.54, 15"
SEE SHEET 92

SLM 18.57, 15"
SEE SHEET 92

SLM 18.59, 15"
SEE SHEET 91

SLM 18.57, 21"
SEE SHEET 92

SLM 18.59, 18"
SEE SHEET 91

SLM 18.65, 15"
SEE SHEET 95

SLM 18.65, 18"
SEE SHEET 95

SLM 18.62, 15"
SEE SHEET 91

SLM 18.73, 18"
SEE SHEET 95

SLM 18.73, 15"
SEE SHEET 95

SLM 18.75, 15"
SEE SHEET 95

SLM 18.75, 21"
SEE SHEET 96

SLM 18.81, 21"
SEE SHEET 96

SLM 18.81, 12"
SEE SHEET 96

SLM 18.62, 15"
SEE SHEET 91

SLM 18.62, 12"
SEE SHEET 91

SLM 18.67, 15"
SEE SHEET 93

SLM 18.76, 18"
SEE SHEET 94

SLM 18.76, 15"
SEE SHEET 93

SCALE: 1"=50'
MADE: RHP DATE: 10-7-64
TRCD: CPB DATE: 10-16-64
CKD: CPB DATE: 10-16-64

HOWARD, NEEDLES, TAMMEN & BERGENDOFF
CONSULTING ENGINEERS
KANSAS CITY CLEVELAND NEW YORK

DRAINAGE PLAN