


FED. RD. DIVISION	STATE	PROJECT
2	OHIO	

77
478

CUYAHOGA COUNTY
CITY OF CLEVELAND
MEDINA-CLARK INTERCHANGE
CUY- 71-18.54
CUY- 90-13.81

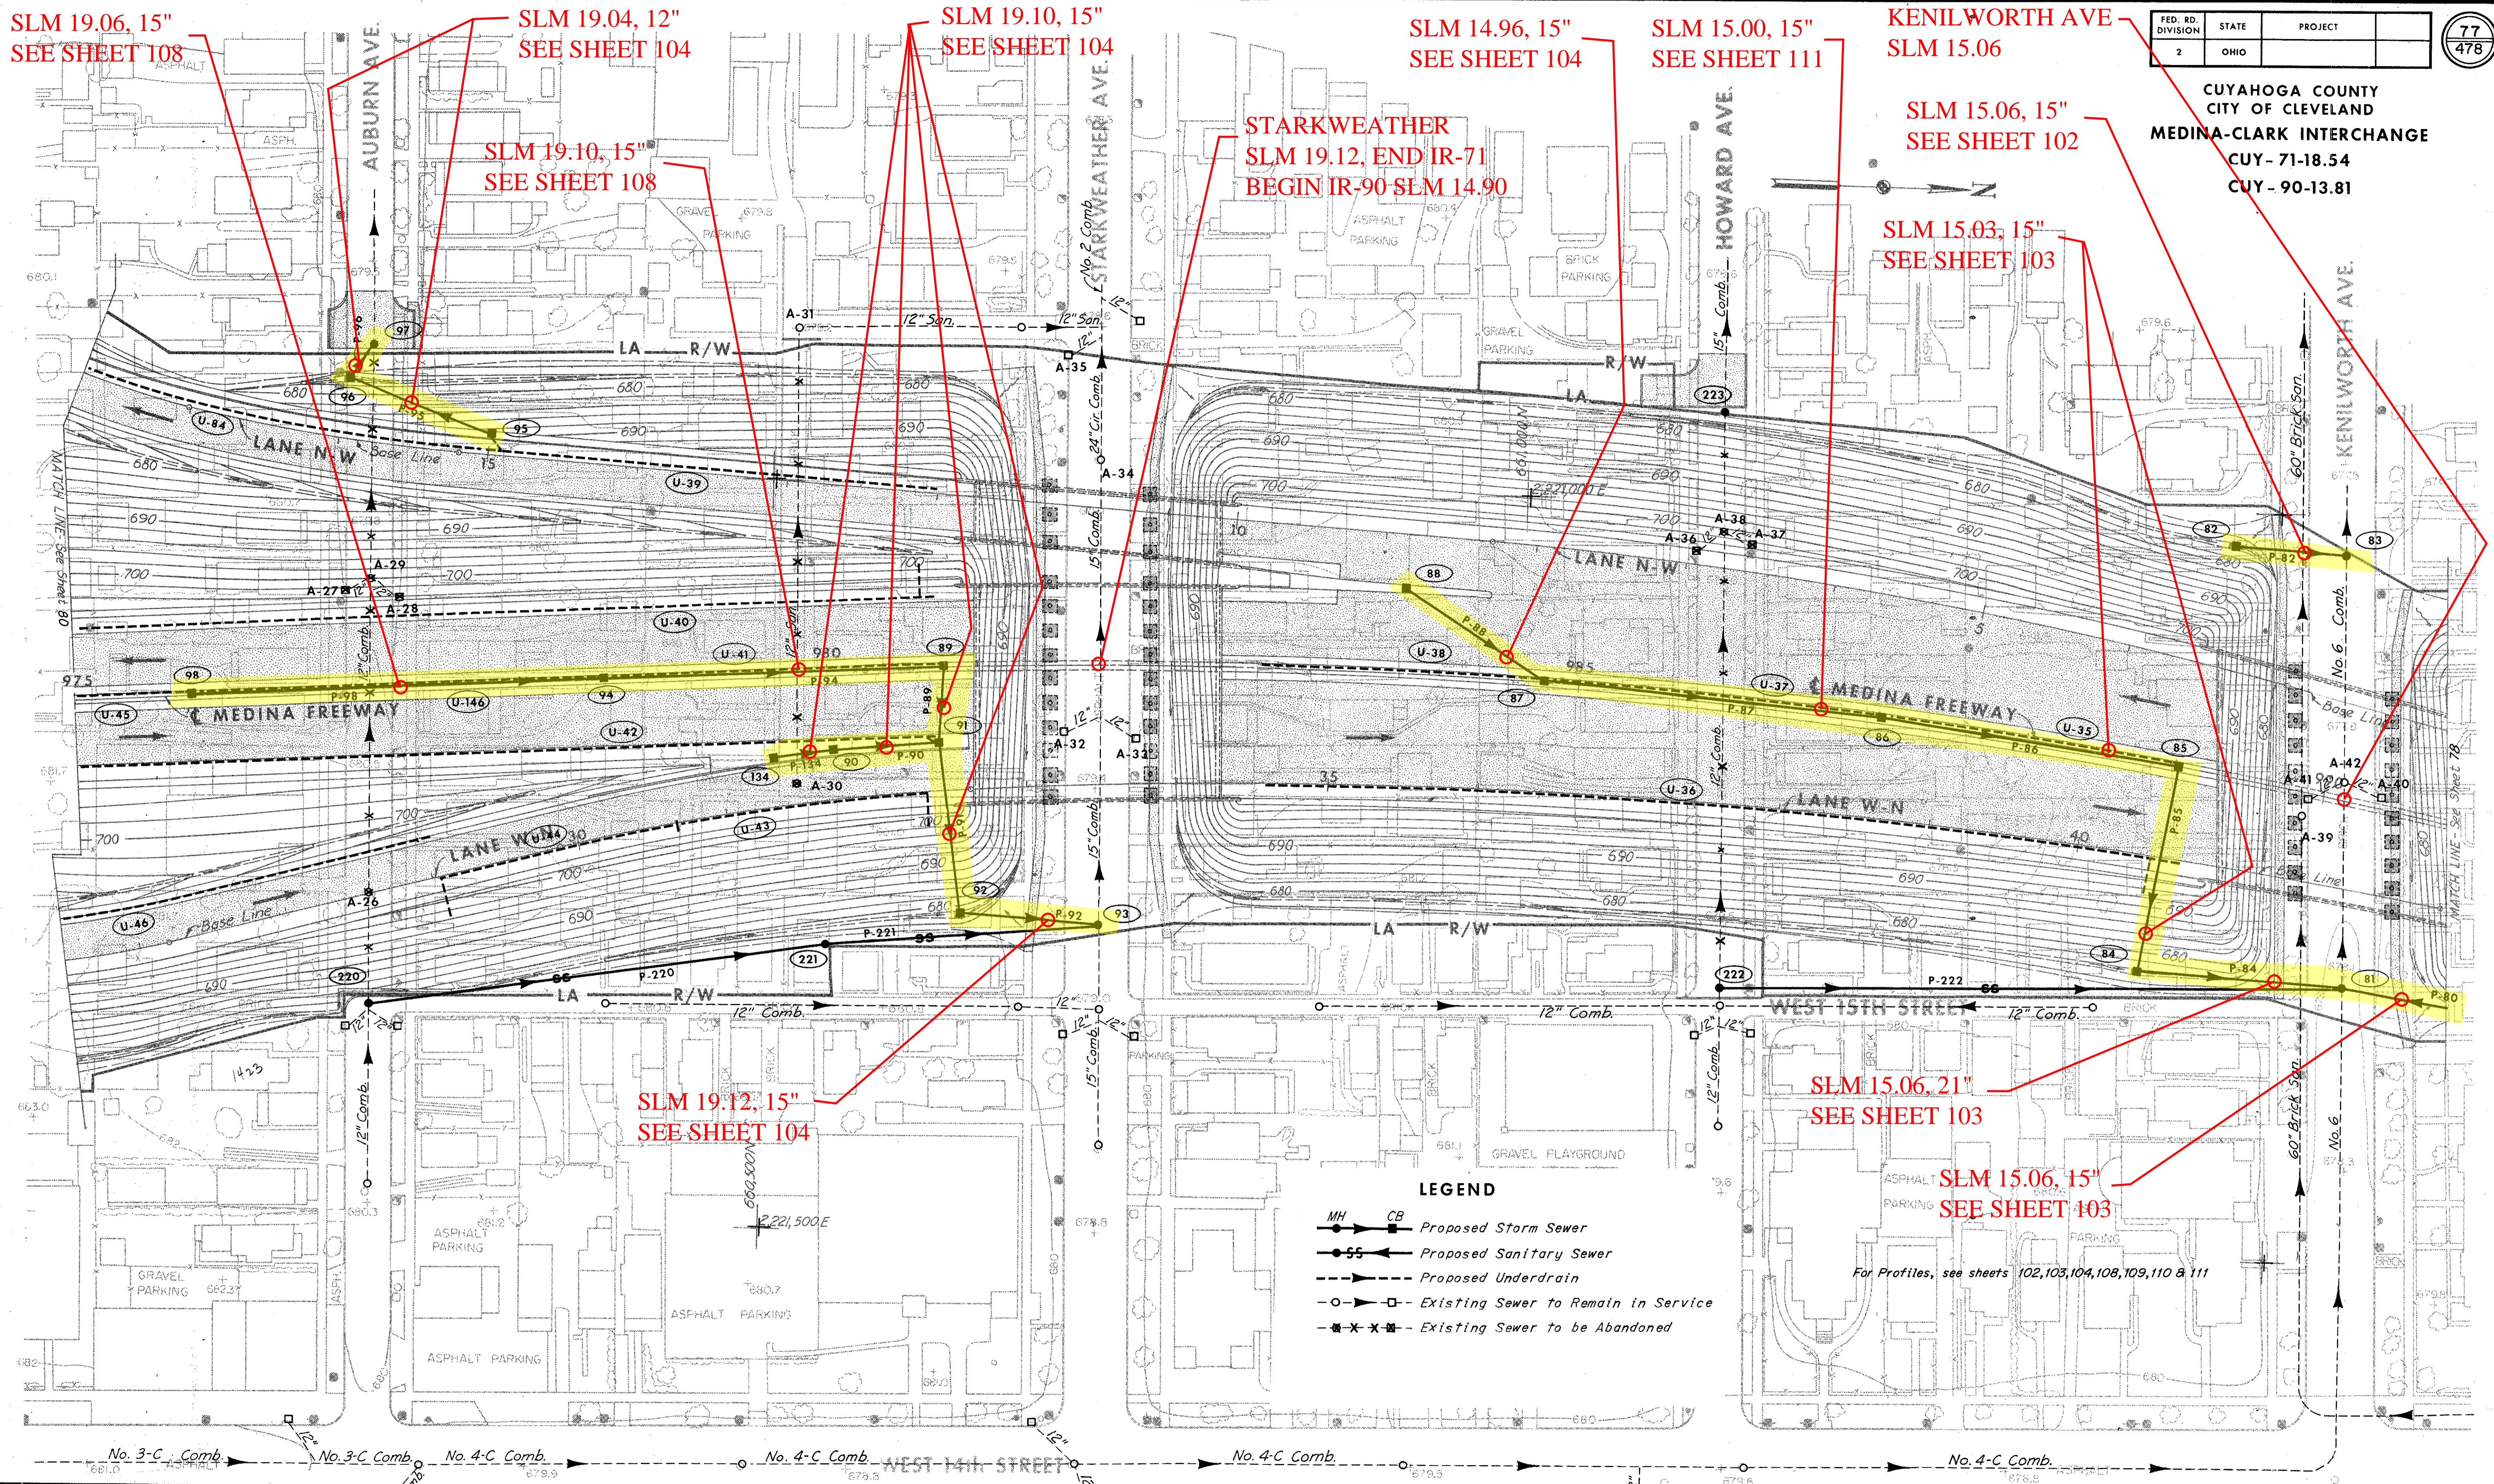

SLM 19.06, 15"
SEE SHEET 108

SLM 19.04, 12"
SEE SHEET 104

SLM 19.10, 15"
SEE SHEET 104

SLM 14.96, 15"
SEE SHEET 104

SLM 15.00, 15"
SEE SHEET 111

KENILWORTH AVE
SLM 15.06

SLM 15.06, 15"
SEE SHEET 102

SLM 15.03, 15"
SEE SHEET 103

SLM 19.10, 15"
SEE SHEET 108

STARKWEATHER
SLM 19.12, END IR-71
BEGIN IR-90 SLM 14.90

SLM 19.12, 15"
SEE SHEET 104

SLM 15.06, 21"
SEE SHEET 103

SLM 15.06, 15"
SEE SHEET 103

For Profiles, see sheets 102, 103, 104, 108, 109, 110 & 111

LEGEND

- MH CB Proposed Storm Sewer
- Proposed Sanitary Sewer
- - - Proposed Underdrain
- Existing Sewer to Remain in Service
- x-x- Existing Sewer to be Abandoned

SCALE 1"=50'
MADE RHP DATE 10/2/64
TRCD LPA DATE 10/16/64
HOWARD, NEEDLES, TAMMEN & BERGENDOFF
CONSULTING ENGINEERS
KANSAS CITY CLEVELAND NEW YORK

DRAINAGE PLAN