


FED. RD. DIVISION	STATE	PROJECT	80 478
2	OHIO		

CUYAHOGA COUNTY  
CITY OF CLEVELAND  
**MEDINA-CLARK INTERCHANGE**  
CUY-71-18.54  
CUY-90-13.81

**LEGEND**

- MH → CB Proposed Storm Sewer
- SS Proposed Sanitary Sewer
- - - Proposed Underdrain
- O - Existing Sewer to Remain in Service
- X - Existing Sewer to be Abandoned

SLM 0.13, 21"  
SEE SHEET 98

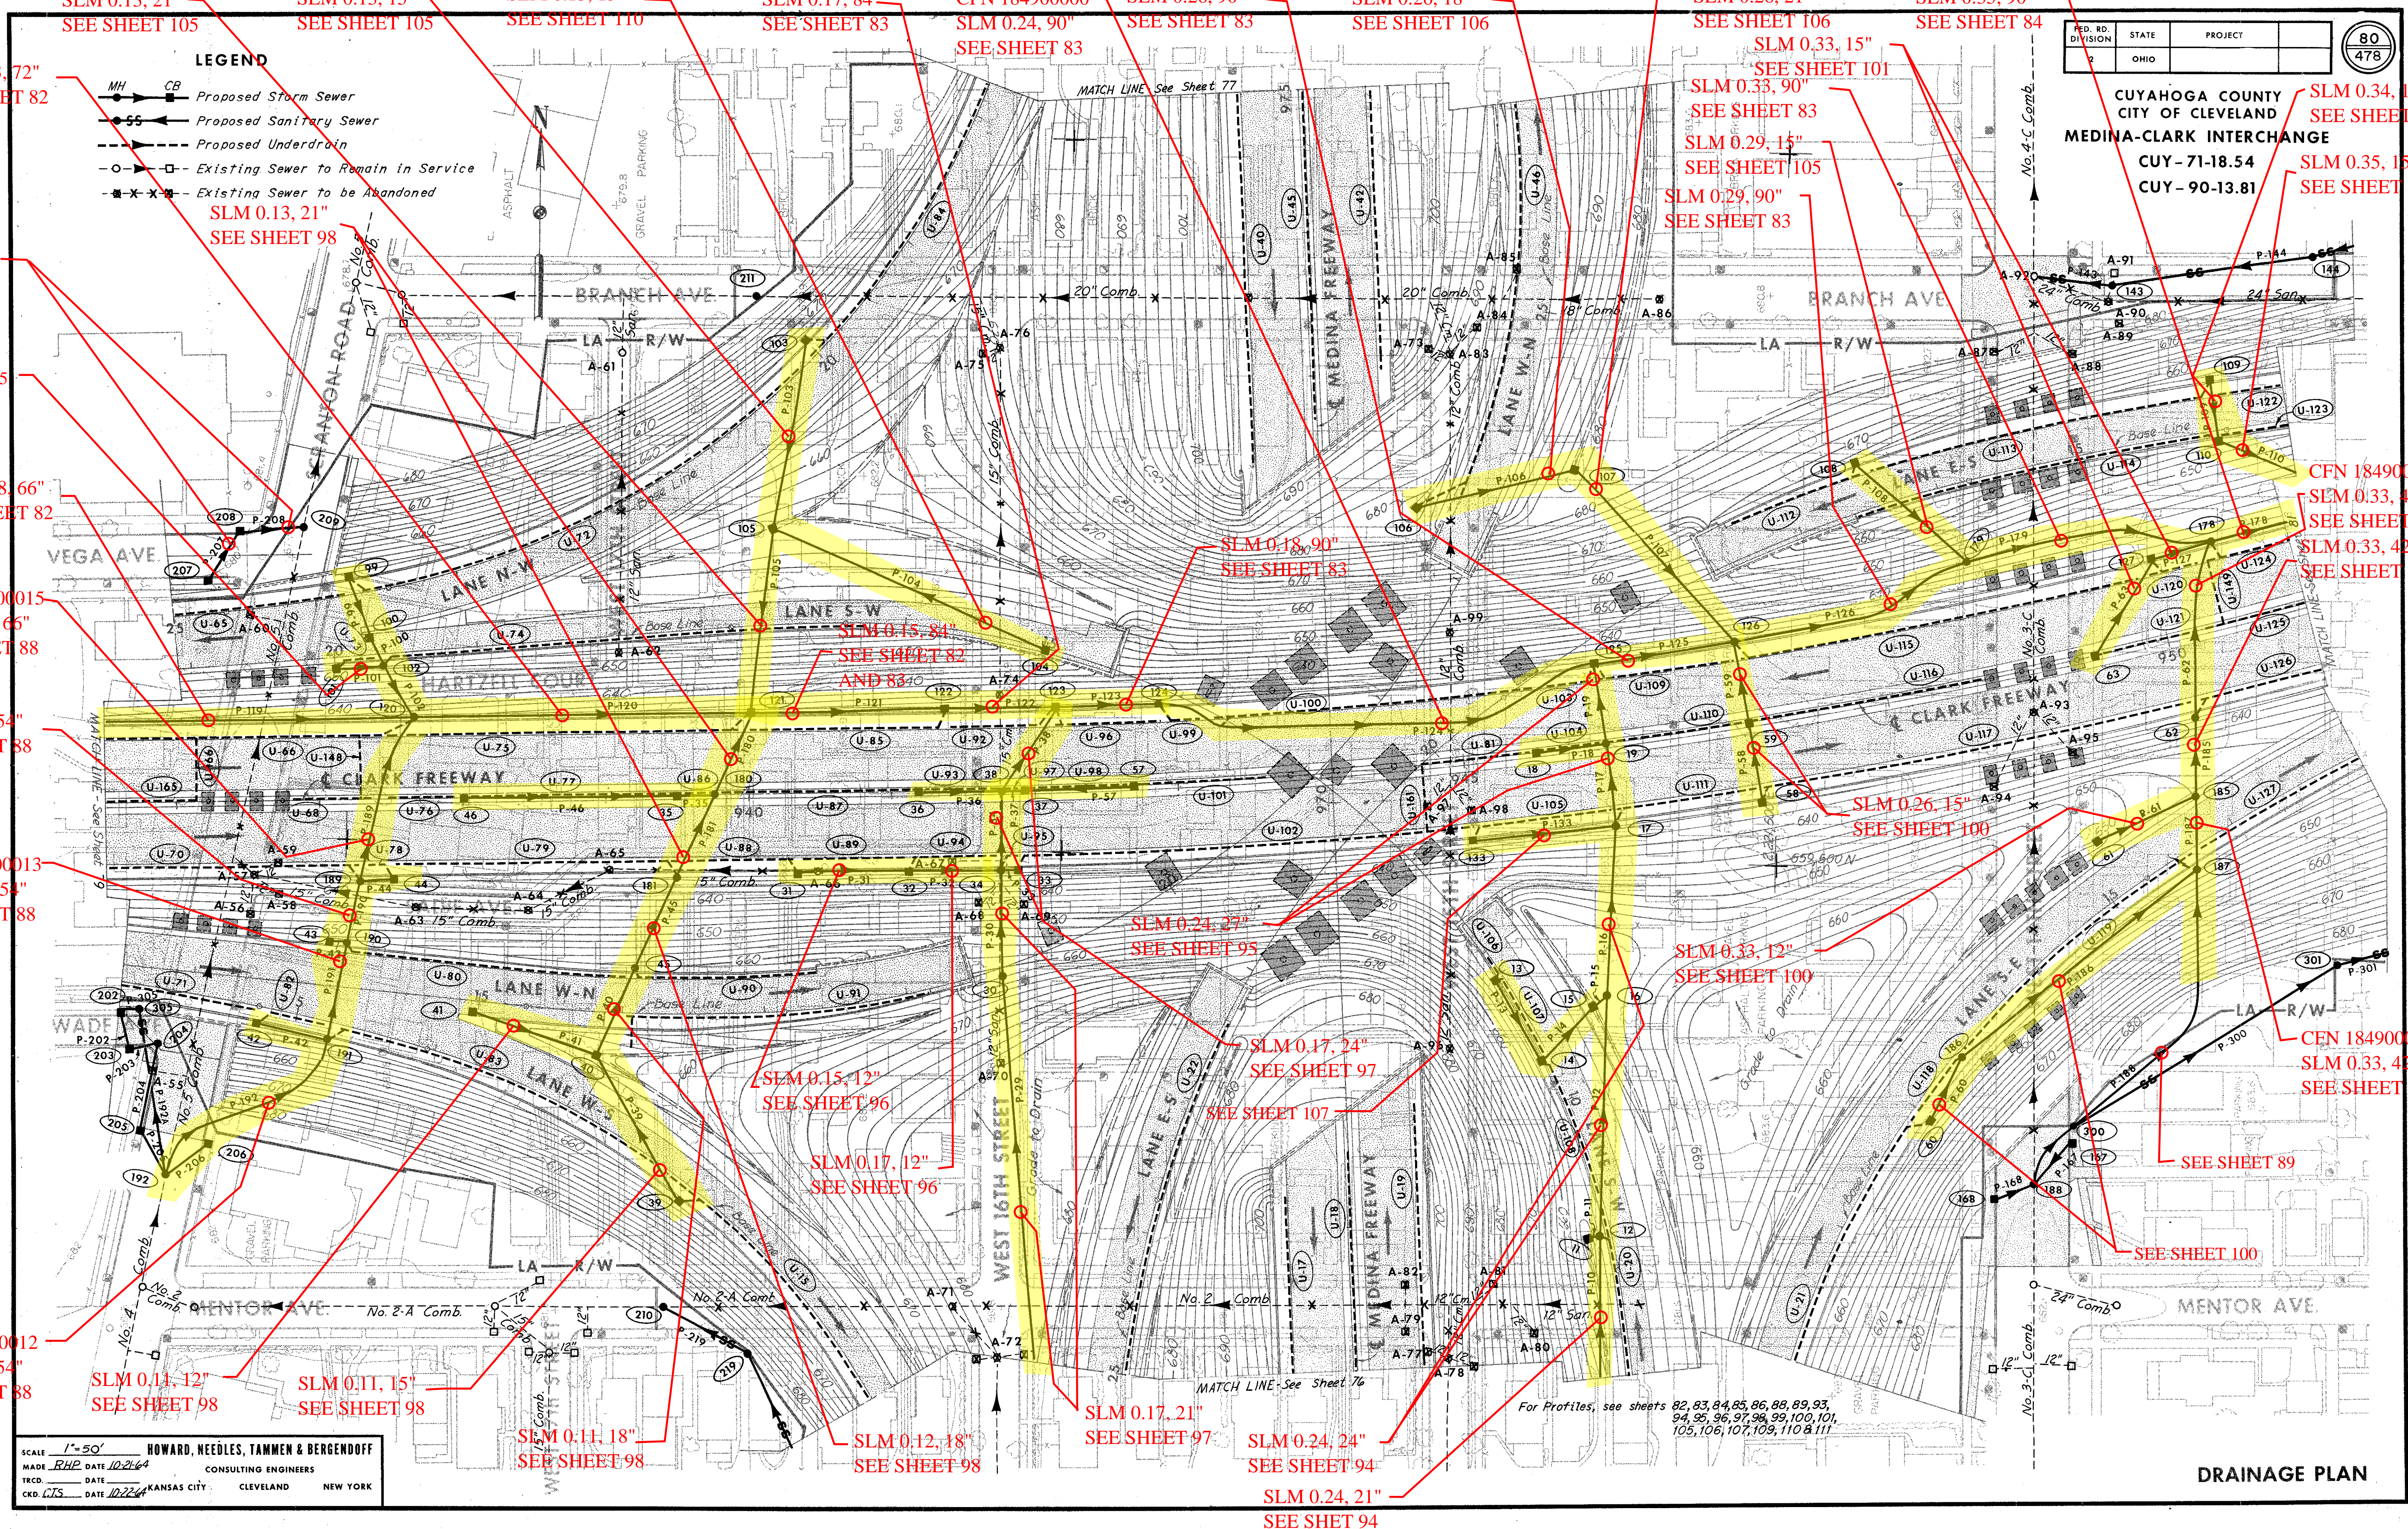

SLM 0.13, 72"  
SEE SHEET 82

SEE SHEET 88

SEE SHEET 105

SLM 0.08, 66"  
SEE SHEET 82

CFN 18490015  
SLM 0.08, 66"  
SEE SHEET 88

SLM 0.08, 54"  
SEE SHEET 88

CFN 18490013  
SLM 0.08, 54"  
SEE SHEET 88

CFN 18490012  
SLM 0.08, 54"  
SEE SHEET 88

SLM 0.13, 21"  
SEE SHEET 105

SLM 0.13, 15"  
SEE SHEET 110

SLM 0.17, 84"  
SEE SHEET 83

CFN 18490000  
SLM 0.24, 90"  
SEE SHEET 83

SLM 0.26, 90"  
SEE SHEET 83

SLM 0.26, 18"  
SEE SHEET 106

SLM 0.26, 21"  
SEE SHEET 106

SLM 0.33, 15"  
SEE SHEET 101

SLM 0.33, 90"  
SEE SHEET 83

SLM 0.29, 15"  
SEE SHEET 105

SLM 0.29, 90"  
SEE SHEET 83

SLM 0.35, 90"  
SEE SHEET 84

SLM 0.34, 15"  
SEE SHEET 106

SLM 0.35, 15"  
SEE SHEET 106

CFN 18490067  
SLM 0.33, 48"  
SEE SHEET 89

SLM 0.33, 42"  
SEE SHEET 89

CFN 18490064  
SLM 0.33, 42"  
SEE SHEET 89

SCALE 1"=50'

HOWARD, NEEDLES, TAMMEN & BERGENDOFF  
MADE RHP DATE 10/21/64  
CONSULTING ENGINEERS  
TRCD. DATE  
CKD. CTS. DATE 10/22/64 KANSAS CITY CLEVELAND NEW YORK

For Profiles, see sheets 82, 83, 84, 85, 86, 88, 89, 93, 94, 95, 96, 97, 98, 99, 100, 101, 105, 106, 107, 109, 110 & 111

**DRAINAGE PLAN**