

SHEET NUM.													PART.	ITEM	ITEM EXT	GRAND TOTAL	UNIT	DESCRIPTION	SEE SHEET NO.
						3	5	6	10	11	13	15	01/STR/ PV						
						LS							LS	201	11000	LS		ROADWAY	
										52			52	202	23000	52	SY	CLEARING AND GRUBBING	
									74	41			115	202	35100	115	FT	PAVEMENT REMOVED	
										45			45	202	75000	45	FT	PIPE REMOVED, 24" AND UNDER	
																	FT	FENCE REMOVED	
											162		162	203	10000	162	CY	EXCAVATION	
											57		57	203	20000	57	CY	EMBANKMENT	
										85			85	607	98000	85	FT	FENCE, MISC.:TEMPORARY ORANGE CONSTRUCTION FENCE (OR EQUIVALENT)	6
									2				2	SPECIAL	69050350	2	EACH	MAILBOX REMOVED AND RESET	3
										5			5	601	11001	5	SY	EROSION CONTROL	
					3.5					22			25.5	601	21050	25.5	SY	RIPRAP, TYPE D, AS PER PLAN (USING 6" REINFORCED CONCRETE SLAB)	11
										4			4	601	32200	4	CY	TIED CONCRETE BLOCK MAT WITH TYPE 1 UNDERLAYMENT	
																	CY	ROCK CHANNEL PROTECTION, TYPE C WITH FILTER	
					708								708	659	10001	708	SY	SEEDING AND MULCHING, AS PER PLAN	3A
					0.1								0.1	659	20000	0.1	TON	COMMERCIAL FERTILIZER	
					0.2								0.2	659	31000	0.2	ACRE	LIME	
					4								4	659	35000	4	MGAL	WATER	
									198				198	670	00701	198	SY	DITCH EROSION PROTECTION, AS PER PLAN	3A
													10,000	832	30001	10,000	EACH	EROSION CONTROL, AS PER PLAN	3A
										1.4			1.4	602	20000	1.4	CY	DRAINAGE	
					40								40	605	13300	40	FT	CONCRETE MASONRY	
					90								90	605	31100	90	FT	6" UNCLASSIFIED PIPE UNDERDRAINS	
																	FT	AGGREGATE DRAINS	
					50								50	611	00900	50	FT	6" CONDUIT, TYPE B	
					50								50	611	01400	50	FT	6" CONDUIT, TYPE E	
					65								65	611	01500	65	FT	6" CONDUIT, TYPE F	
									117				117	611	06400	117	FT	15" CONDUIT, TYPE D, 706.02	
									195				195	611	07600	195	FT	18" CONDUIT, TYPE C, 706.02	
										54			54	611	16400	54	FT	36" CONDUIT, TYPE B, 706.02	
										16			16	611	16600	16	FT	36" CONDUIT, TYPE C, 706.02	
									2				2	611	98470	2	EACH	CATCH BASIN, NO. 2-2B	
										1			1	611	98540	1	EACH	CATCH BASIN, NO. 2-4	
					2								2	611	99710	2	EACH	PRECAST REINFORCED CONCRETE OUTLET	
																		PAVEMENT	
					13								13	301	56000	13	CY	ASPHALT CONCRETE BASE, PG64-22, (449)	
					55								55	304	20000	55	CY	AGGREGATE BASE	
					10								10	407	20000	10	GAL	NON-TRACKING TACK COAT	
					3								3	442	22100	3	CY	ASPHALT CONCRETE SURFACE COURSE, 12.5 MM, TYPE A (449)	
					11								11	442	22120	11	CY	ASPHALT CONCRETE SURFACE COURSE, 12.5 MM, TYPE A (449) (DRIVEWAYS)	
					3								3	442	22300	3	CY	ASPHALT CONCRETE INTERMEDIATE COURSE, 12.5 MM, TYPE A (449)	
					8								8	442	22320	8	CY	ASPHALT CONCRETE INTERMEDIATE COURSE, 12.5 MM, TYPE A (449) (DRIVEWAYS)	
																		WATER WORK ALTERNATES	
												36	36	SPECIAL	63820000	36	FT	4" WATER MAIN DIP CLASS 52 MECHANICAL JOINTS AND FITTINGS	15
																		(DEL-CO WATER SPECIFICATIONS) (ALTERNATE 1)	
												12	12	SPECIAL	63820442	12	FT	10" STEEL PIPE ENCASEMENT, OPEN CUT (DEL-CO WATER SPECIFICATIONS) (ALTERNATE 1)	15
												LS	LS	SPECIAL	63898100	LS		WATER WORKS, MISC.: EX. WATER MAIN CONNECTION (BY DEL-CO WATER) (ALTERNATE 1)	
												36	36	SPECIAL	63820416	36	FT	4" WATER MAIN POLYVINYL CHLORIDE PIPE AND FITTINGS	15
																		(CLASS 200 SDR 21, DEL-CO WATER SPECIFICATIONS) (ALTERNATE 2)	
												12	12	SPECIAL	63820442	12	FT	10" STEEL PIPE ENCASEMENT, OPEN CUT (DEL-CO WATER SPECIFICATIONS) (ALTERNATE 2)	15
												LS	LS	SPECIAL	63898100	LS		WATER WORKS, MISC.: EX. WATER MAIN CONNECTION (BY DEL-CO WATER) (ALTERNATE 2)	
										0.02			0.02	644	00104	0.02	MILE	TRAFFIC CONTROL	
										0.01			0.01	644	00300	0.01	MILE	EDGE LINE, 6"	
																		CENTER LINE	
							32						32	614	11110	32	hour	MAINTENANCE OF TRAFFIC	
								LS					LS	614	12420	LS		LAW ENFORCEMENT OFFICER WITH PATROL CAR FOR ASSISTANCE	
								35					35	614	13000	35	CY	DETOUR SIGNING	
					5								5	614	18601	5	SNMT	ASPHALT CONCRETE FOR MAINTAINING TRAFFIC	
																		PORTABLE CHANGEABLE MESSAGE SIGN, AS PER PLAN	4-5
								1					1	617	25000	1	MGAL	WATER	
								0.25					0.25	642	00300	0.25	MILE	CENTER LINE, TYPE 1	
																		INCIDENTALS	
													LS	614	11000	LS		MAINTAINING TRAFFIC	
													LS	623	10000	LS		CONSTRUCTION LAYOUT STAKES AND SURVEYING	
													LS	624	10000	LS		MOBILIZATION	

GENERAL SUMMARY

DESIGN AGENCY



6350 PRESIDENTIAL GATEWAY
COLUMBUS, OHIO 43231
(614) 823-4949

DESIGNER

BBB

REVIEWER

SSK 10-17-22

PROJECT ID




108799

SHEET

P.8

TOTAL

21

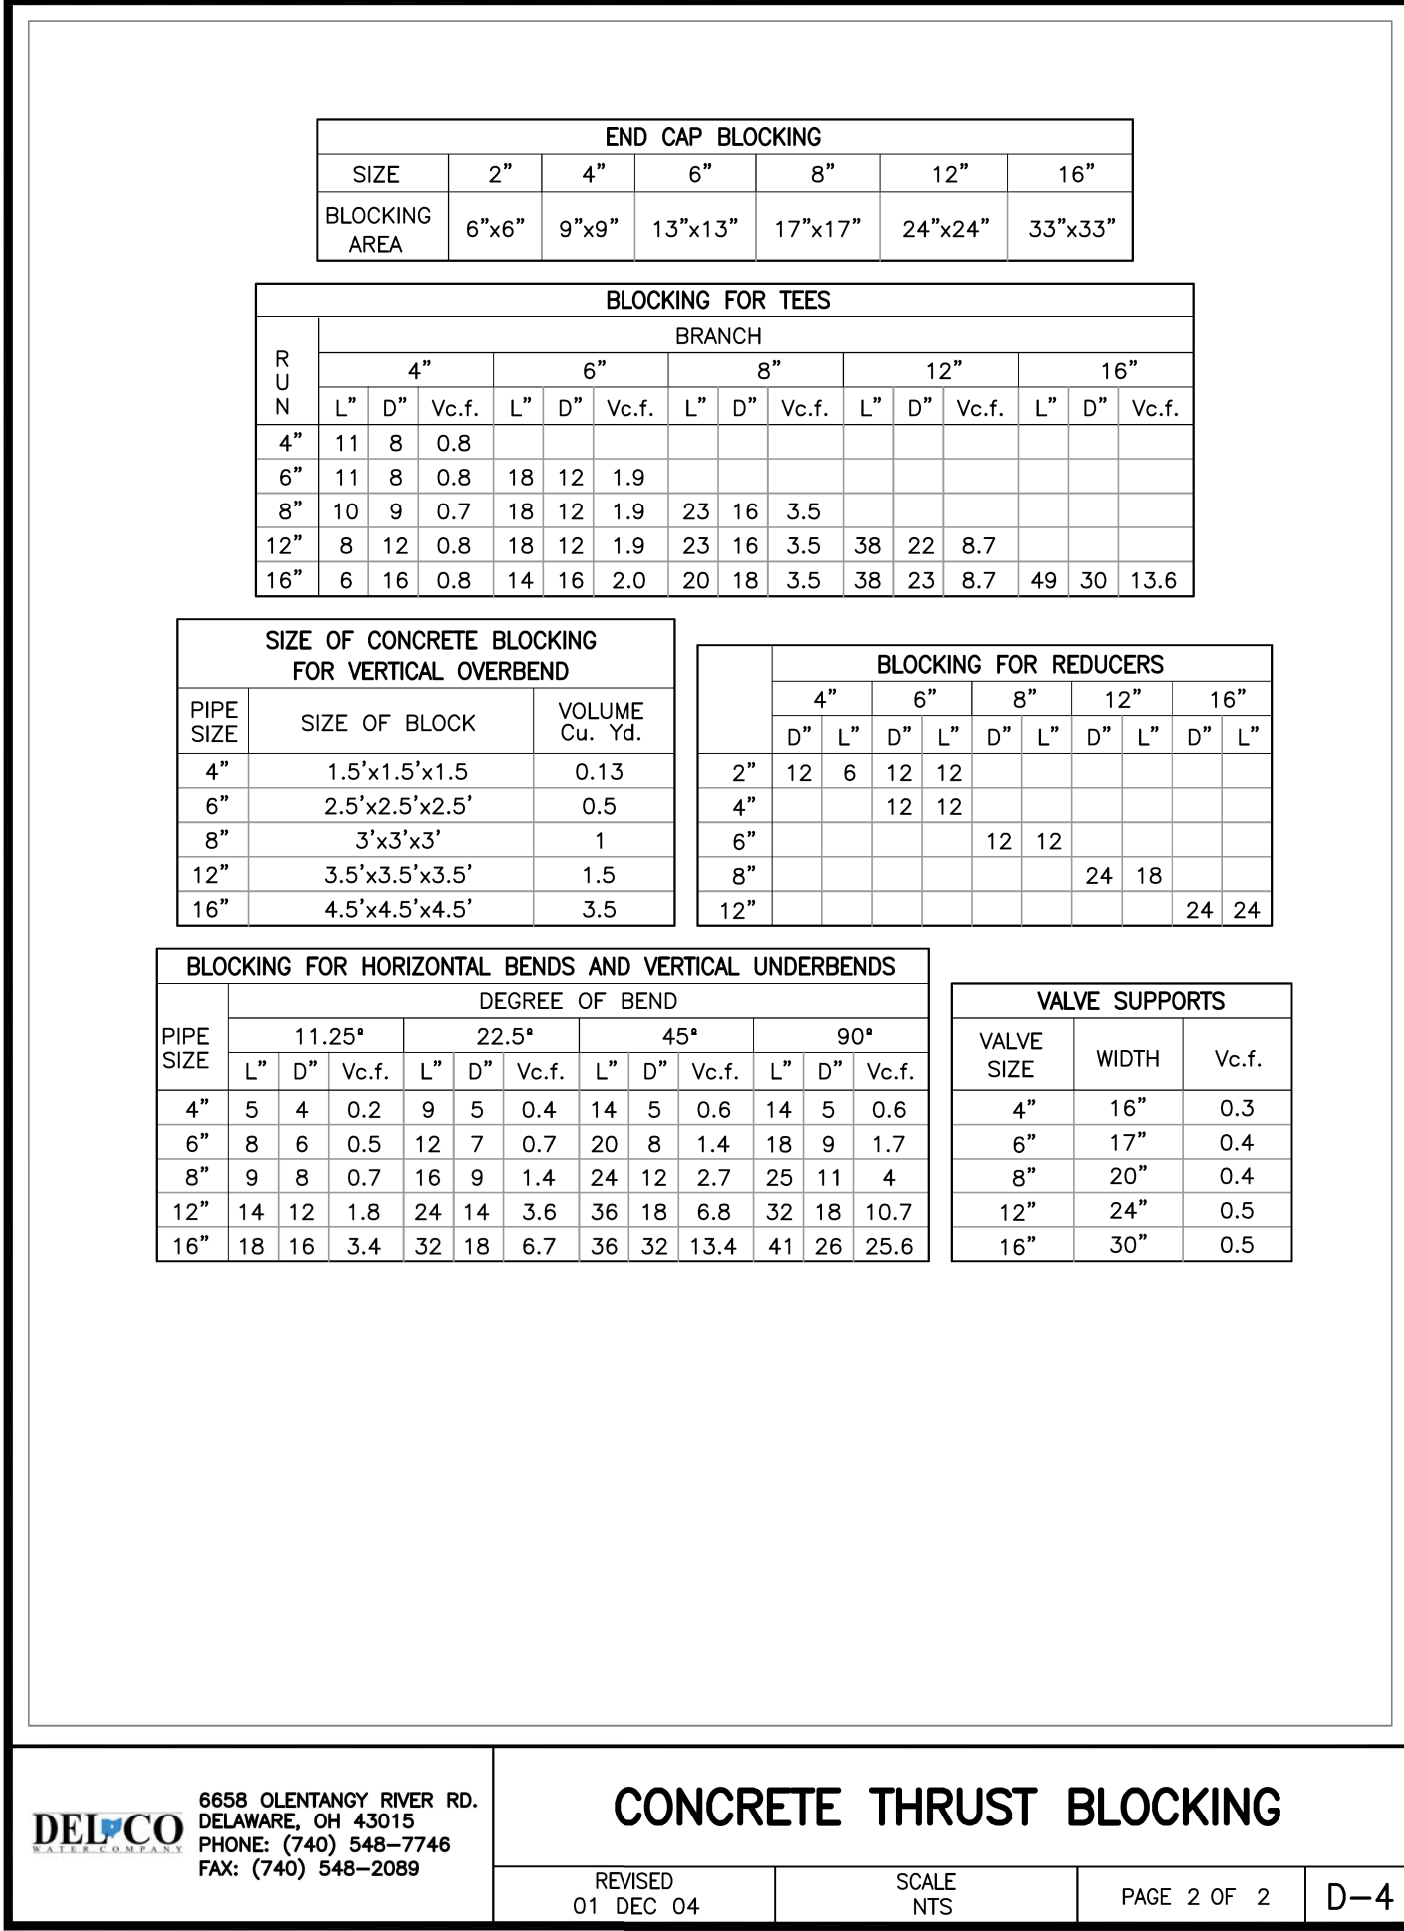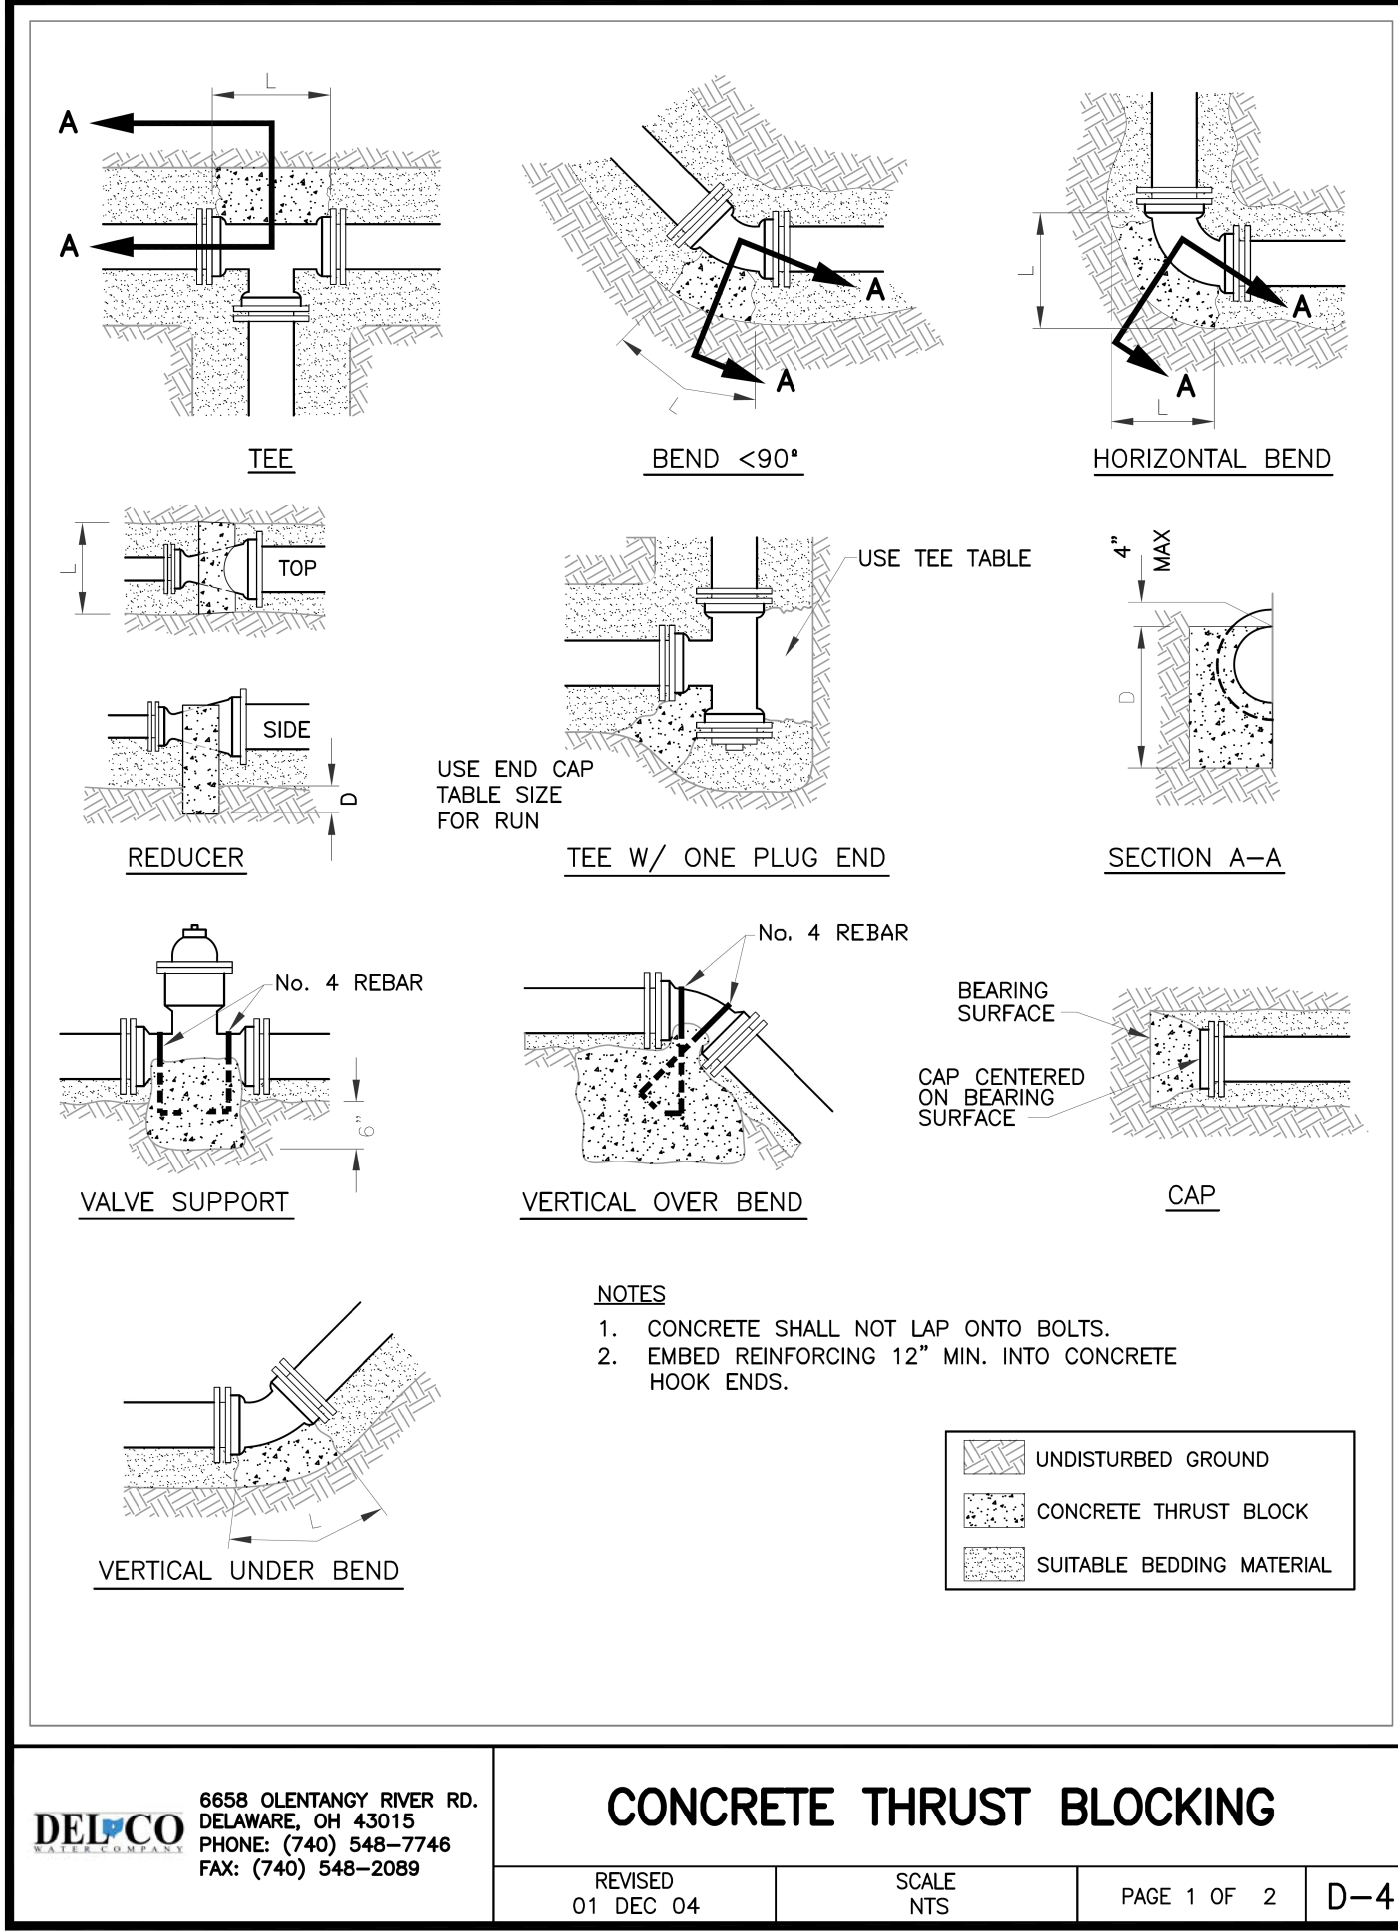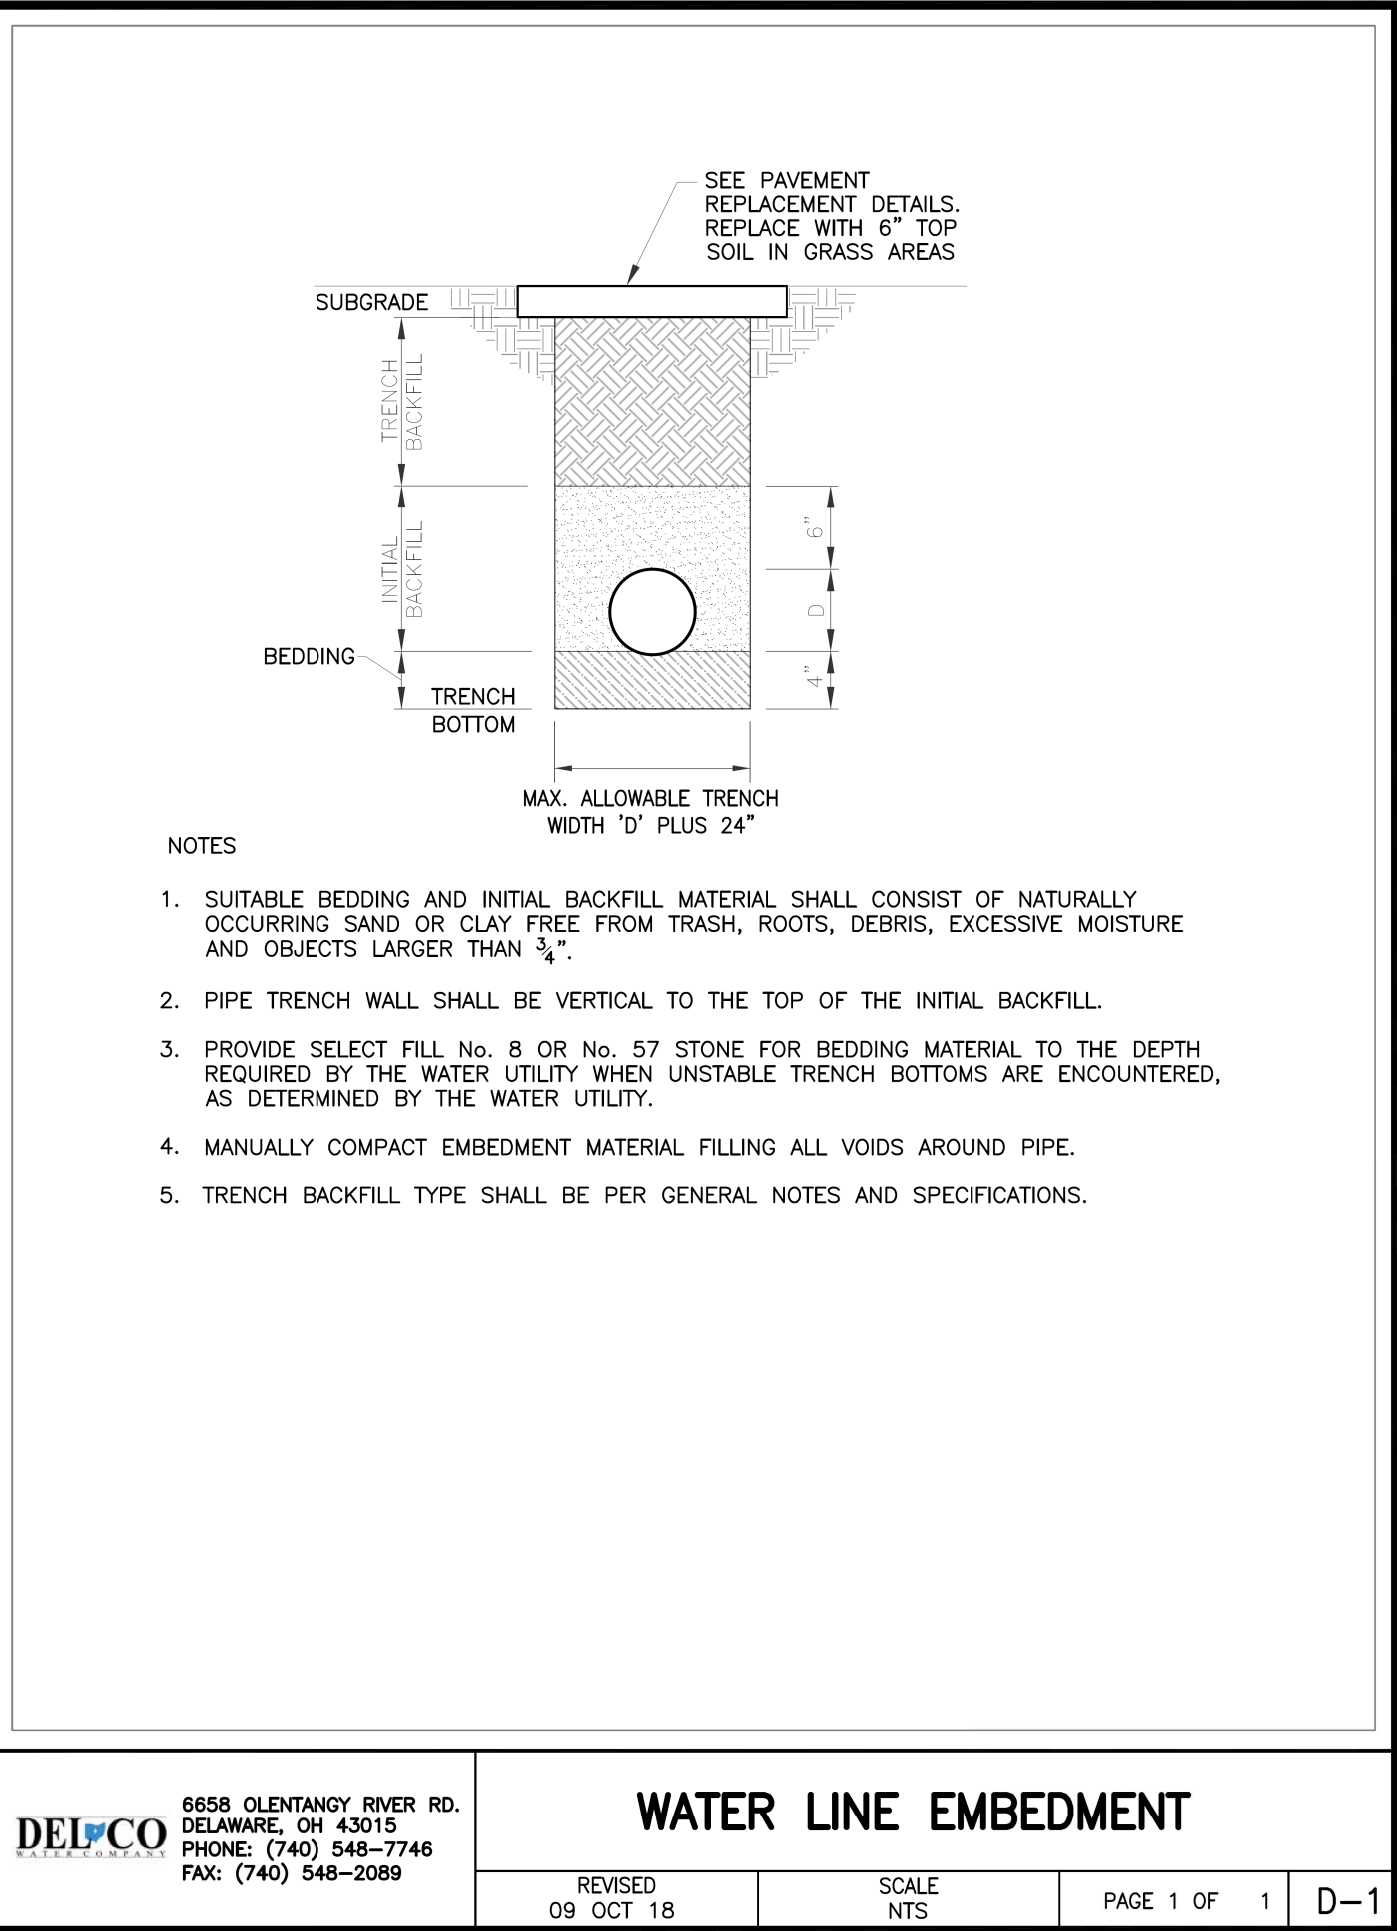

*COST FOR WORK BY DEL-CO TO CONNECT PROPOSED WORK WITH EXISTING IS ESTIMATED AT \$3,000 (BOTH CONNECTIONS).

NOTE:
DEL-CO WATER SPECIFICATIONS AND STANDARDS ARE TO BE COMPLIED WITH FOR ALL PROPOSED WATER LINE WORK.

REF NO.	STATION TO STATION	SIDE	SPECIAL	SPECIAL	SPECIAL
			SPECIAL - 4" WATER MAIN (DEL-CO WATER STANDARD)	SPECIAL - 10" STEEL PIPE ENCASEMENT, OPEN CUT (DEL-CO WATER STANDARD)	SPECIAL - WATER WORK, MISC.: EX. WATER MAIN CONNECTION (BY DEL-CO WATER)
			FT	FT	LS
W-1	112+82 TO 113+15	LT.	36	12	1
TOTALS CARRIED TO GENERAL SUMMARY			36	12	1

