



LUMINAIRE SCHEDULE						
Symbol	Label	Qty	Catalog Number	Lumens	LLF	Watts
•	A	12	K803-P4RAD-III-50(SSL)-8060	Absolute	0.98	50
●	B	12	K803-P4RAD-III-40(SSL)-8060/Walk Side	Absolute	0.98	38

STATISTICS						
Description	Symbol	Avg	Max	Min	Max/Min	Avg/Min
Street	+	1.95 fc	6.32 fc	0.35 fc	18.1:1	5.6:1
Sidewalk	+	3.4 fc	5.8 fc	1.8 fc	3.2:1	1.9:1

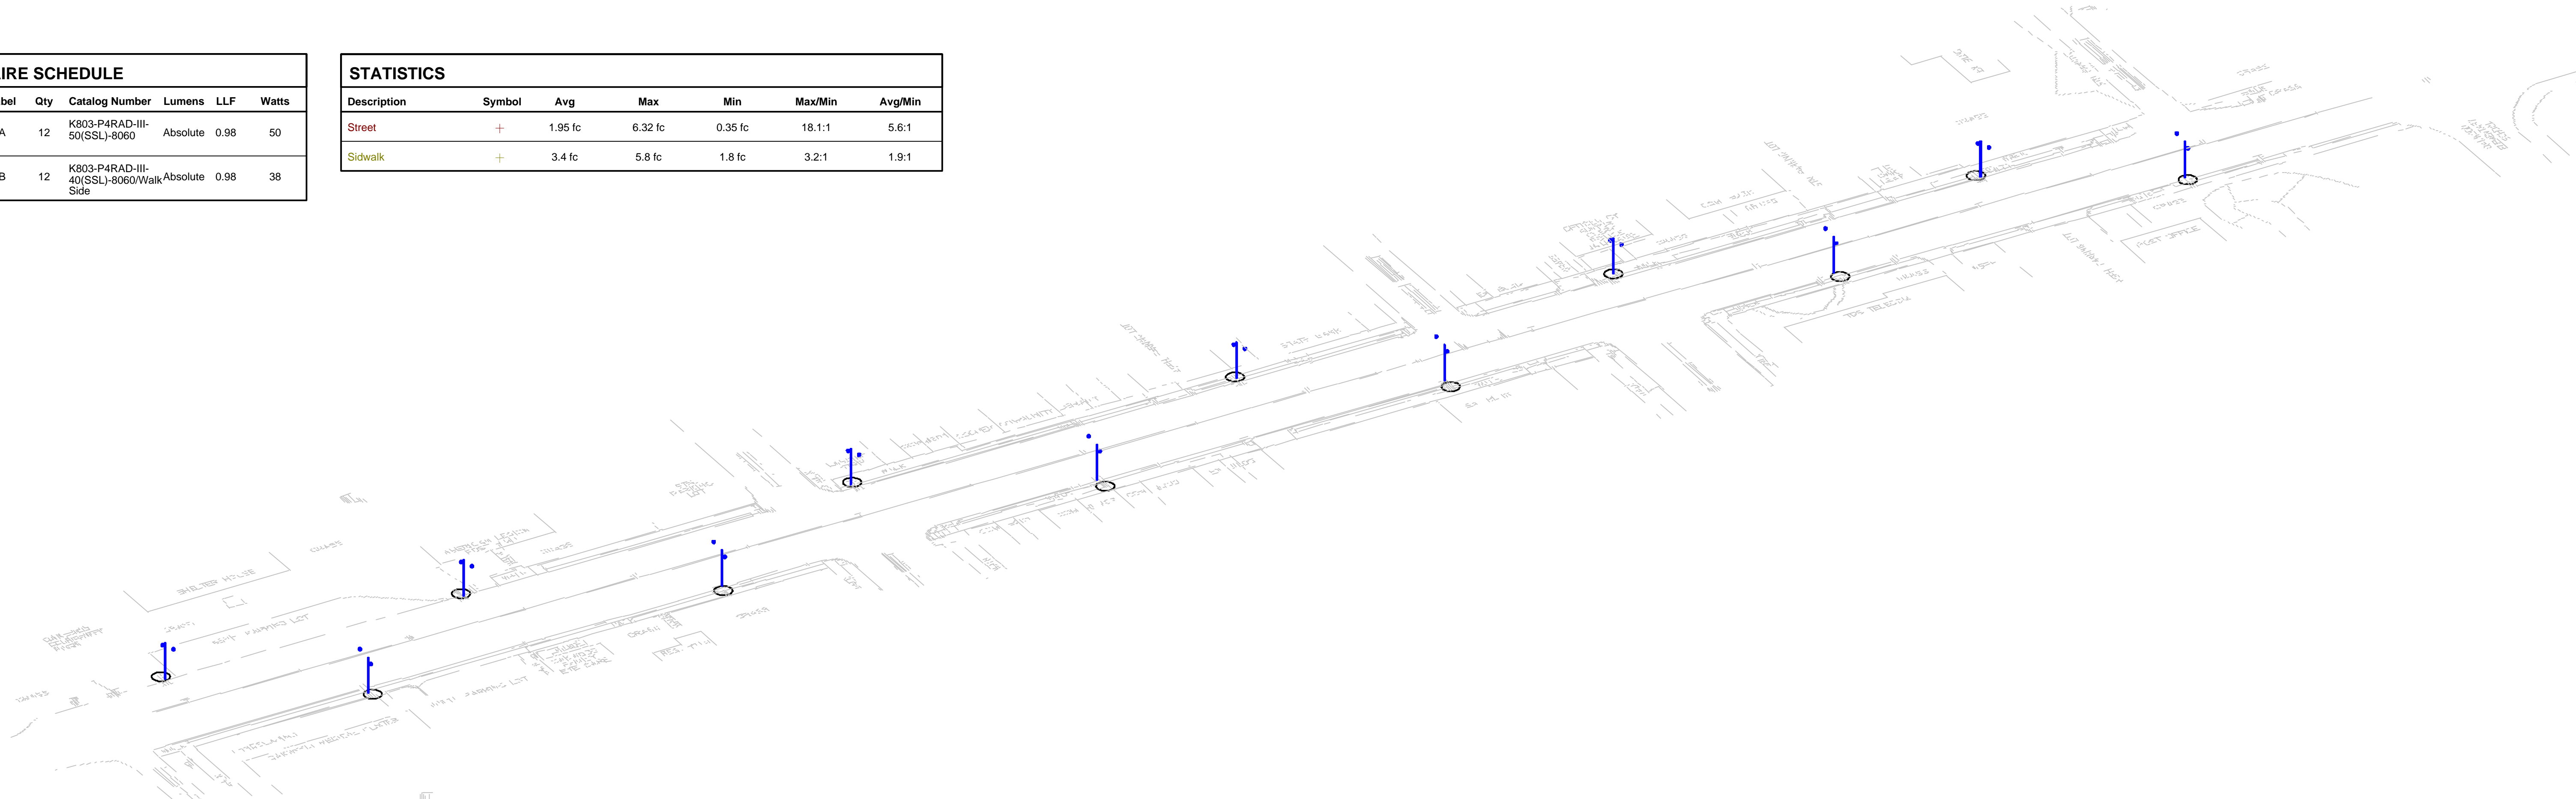

Southwest View  
Not to Scale

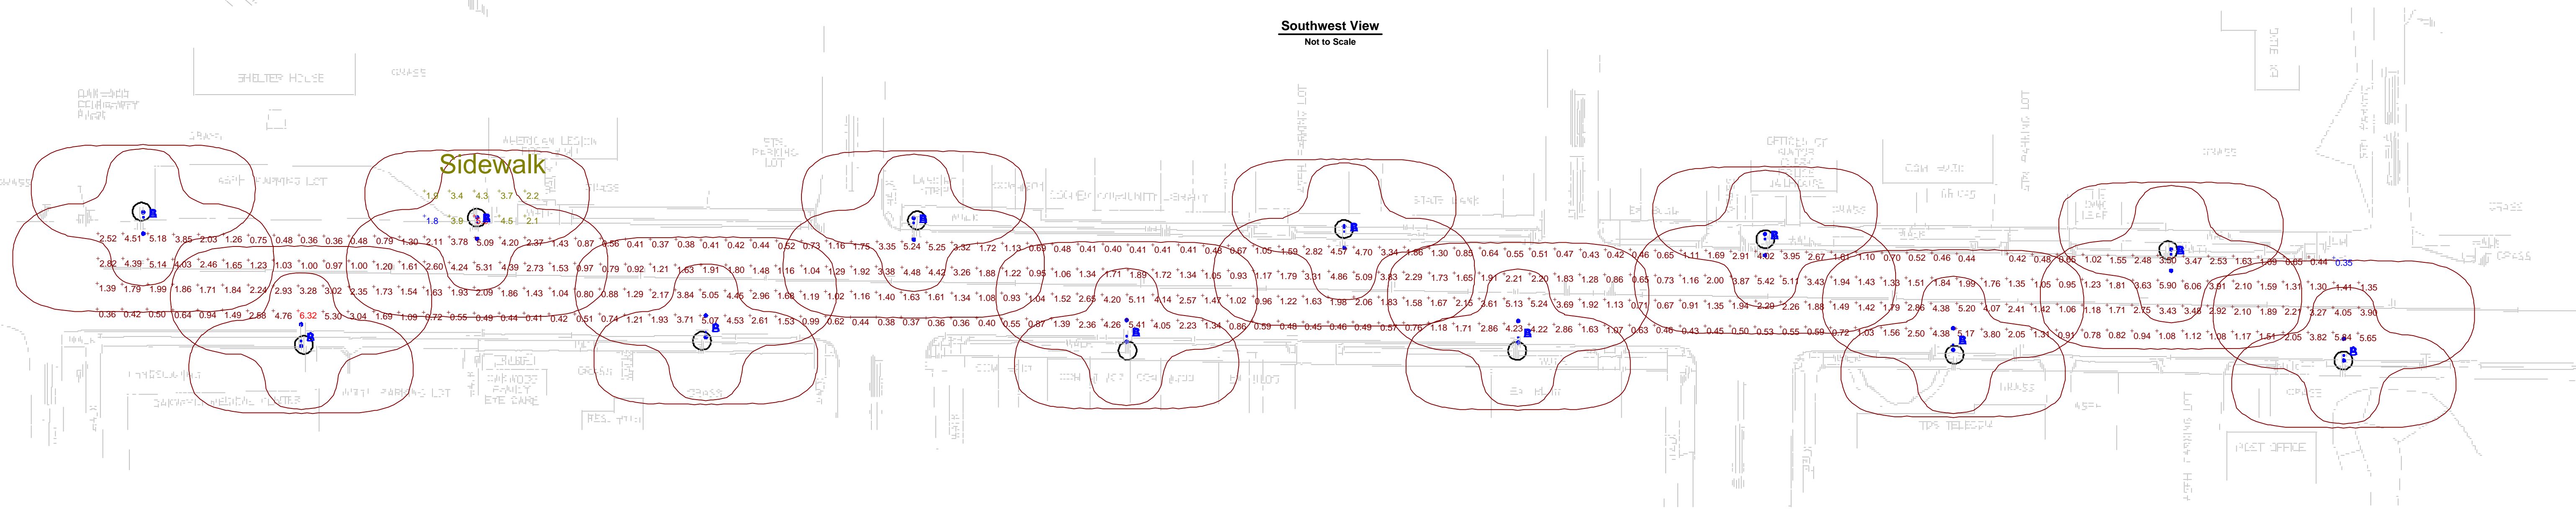

Plan View  
Scale 1" = 32'

Al Specht  
Sales/Specifications IESNA, LC  
Ohio Lighting Systems  
2146 Charlestown Ave  
Toledo, OH 43613  
Cell: 419.705.6114  
Main Office Fax: 248.542.2200  
Main Office Fax: 248.519.2700  
aspect@mts-east.com



210000-00025  
Village of Oakwood, Oh.  
St scape Lighting

Designer  
Al Specht  
Date  
Feb 10 2021  
Scale  
As Shown 24x36  
Drawing No.